



THIS DRAWING THE PROPERTY OF VALUE BUDGET HOUSING CORPORATION NO PART OF THE DRAWING MAY BE REPRODUCED IN ANY MANNER WHATSOEVER WITHOUT WRITTEN PERMISSION FROM VALUE BUDGET HOUSING CORPORATION

NOTE :
FOR ALL AC DRAINAGE DETAILS REFER DWG. NO.VBHC/BH-1/CLS/P/GFC/68


LEGEND	
SYMBOL	DESCRIPTION
EWC	WATER CLOSET
WB	WASH BASIN
WM	WASHING MACHINE
SH	SHOWER MIXER
SR	SHOWER ROSE & SHOWER ARM
AC	ANGLE COCK
HF	HEALTH FAUCET
FT	FLOOR TRAP
NT	NAHNI TRAP
KS	KITCHEN SINK
SC	SINK COCK
BV	BALL VALVE
DWS	DOMESTIC WATER SUPPLY
FWS	FLUSHING WATER SUPPLY
HWS	HOT WATER SUPPLY
WP	WASTE PIPE
DR	SOIL PIPE (DRAINAGE)
WH	WATER HEATER
H	HOT
C	COLD

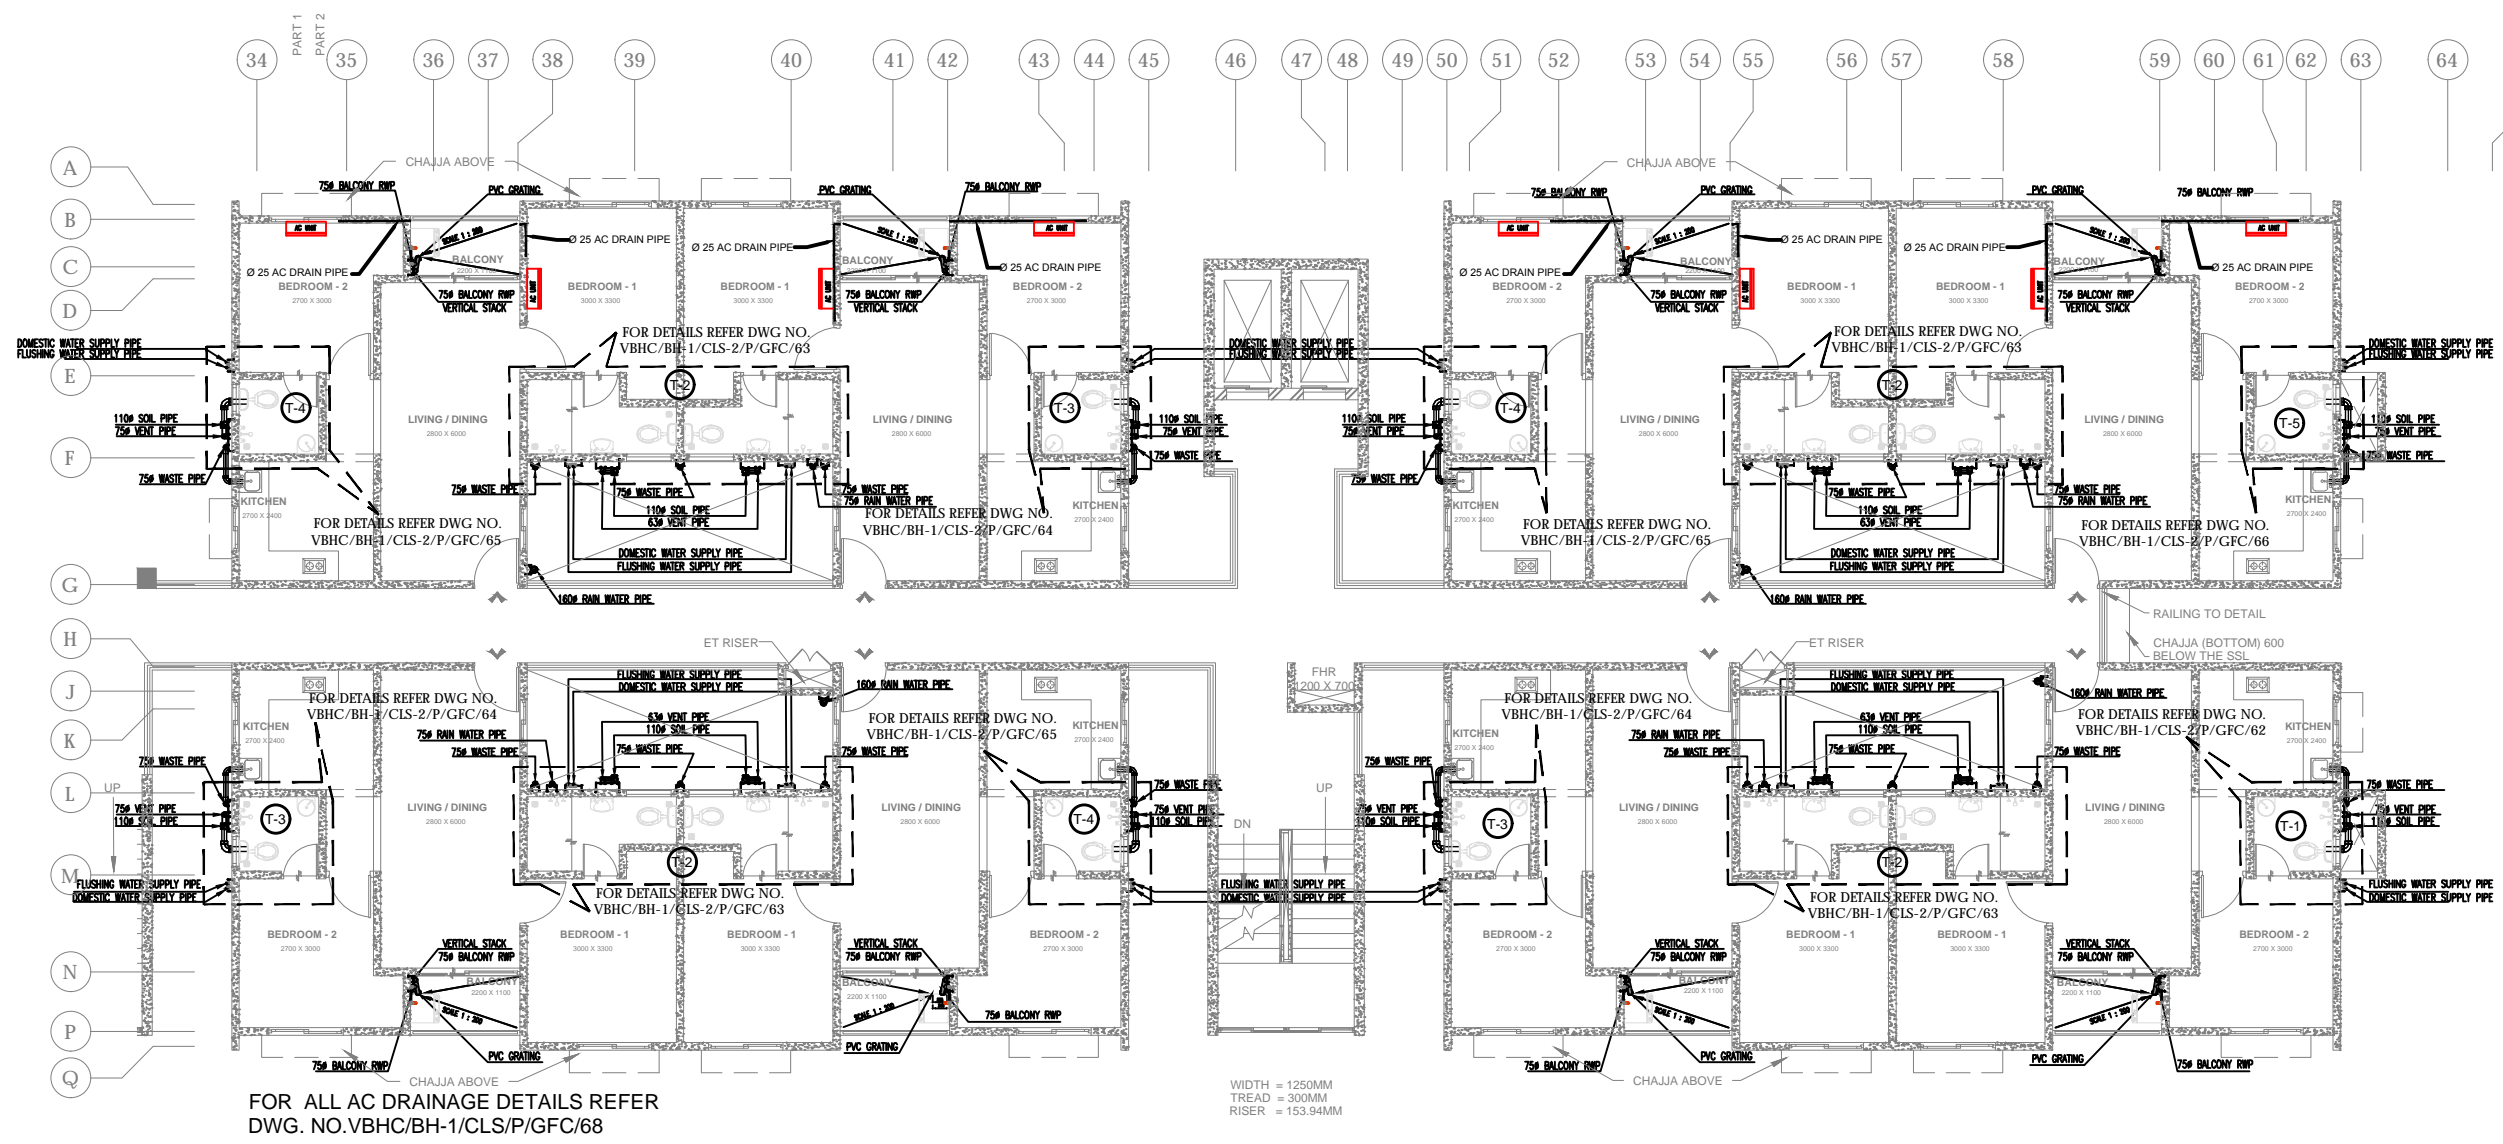


TYPICAL FLOOR PLAN (BLOCK-A)
(SCALE 1:100)

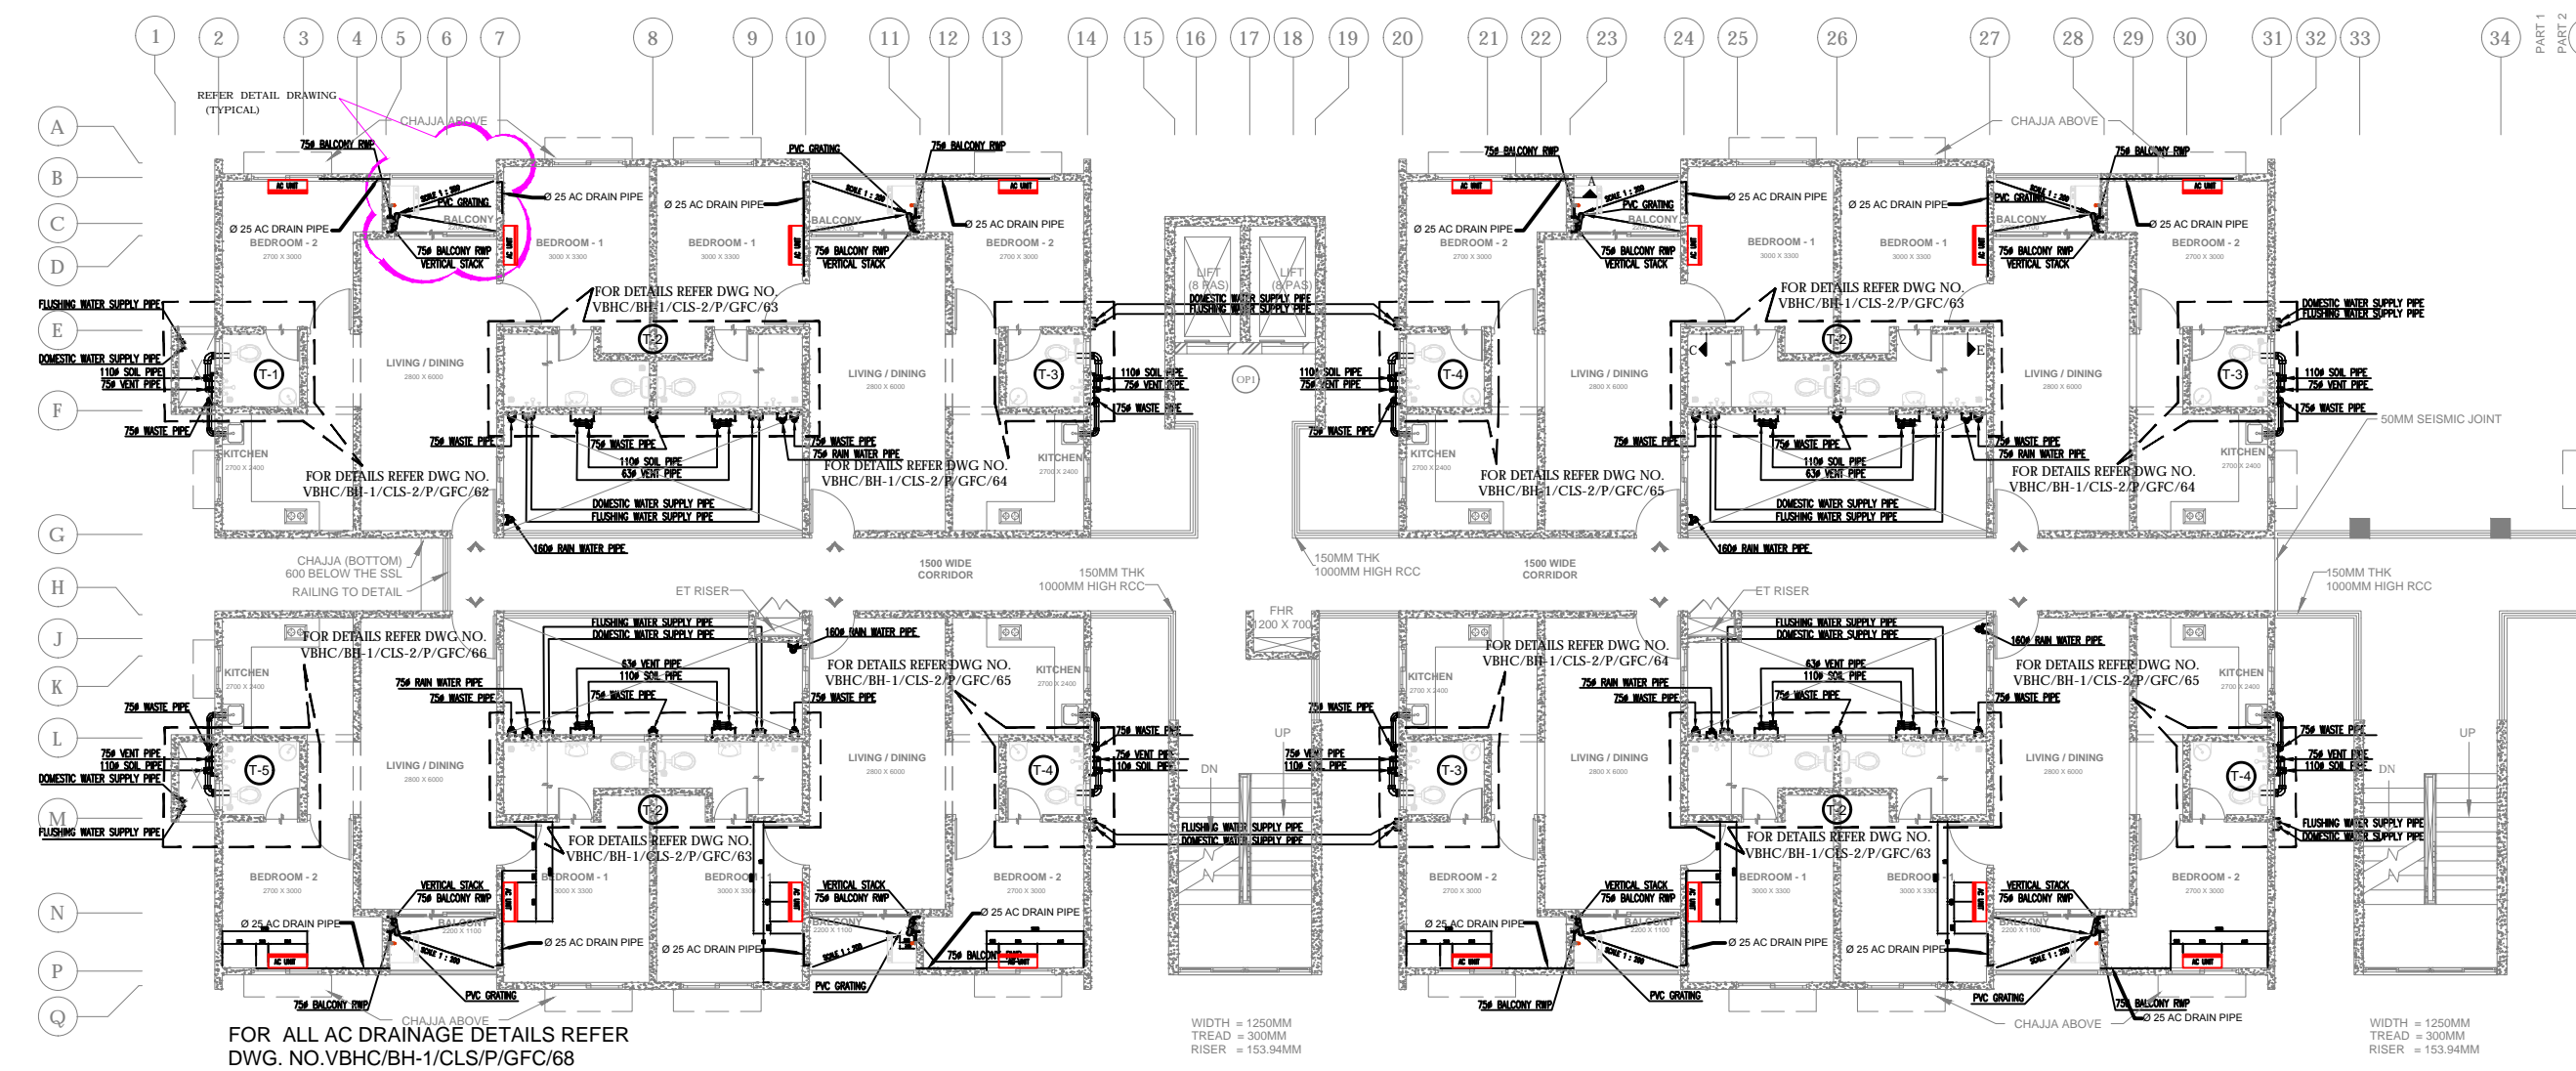

TYPICAL FLOOR PLAN (BLOCK-B)
(SCALE 1:100)

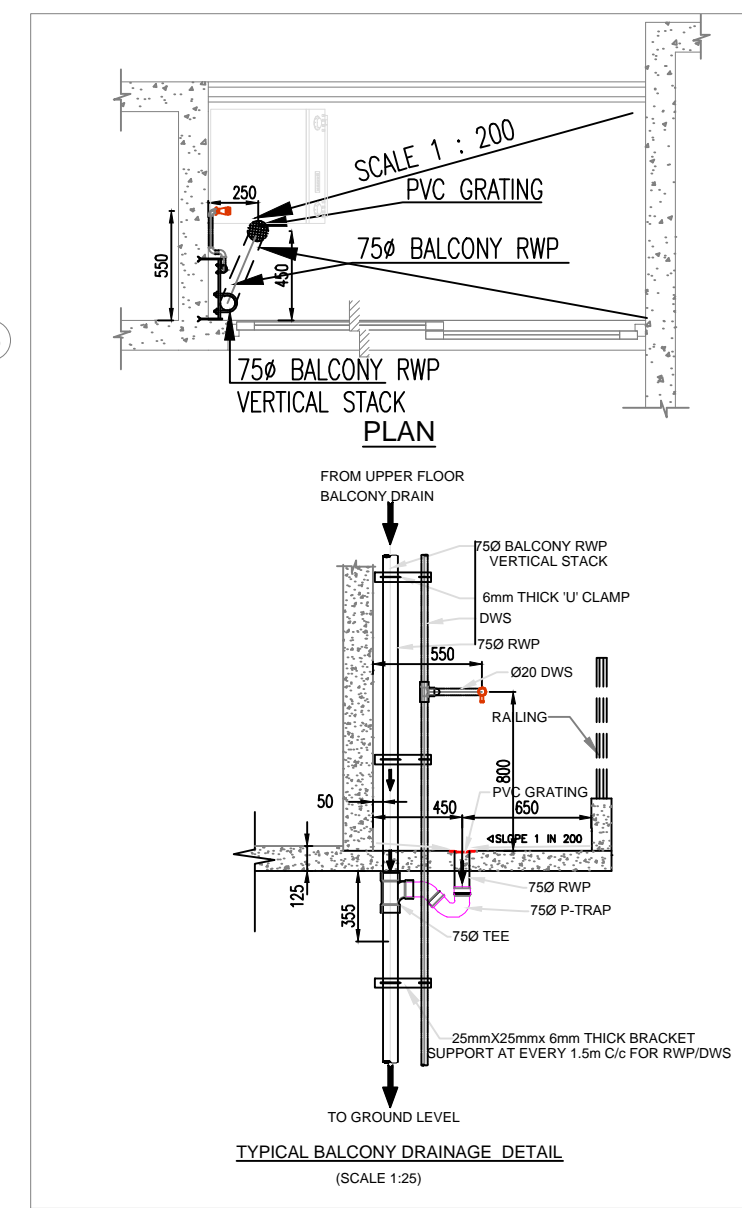

KEY PLAN

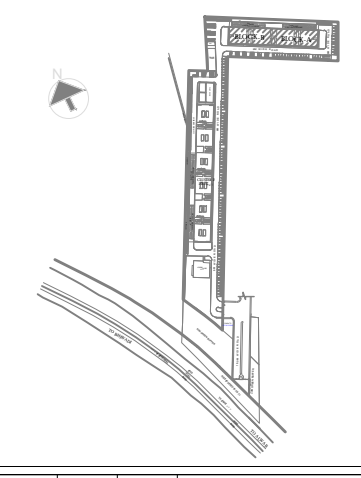

REV.	DATE	DRN.	CHK.	DESCRIPTION
RO	14-01-15	REG.	SHAILESH P	GOOD FOR CONSTRUCTION

CLIENT:
VBHC DELHI VALUE HOMES PVT. LTD.

ILD TRADE CENTRE UNIT-303, THIRD FLOOR, OPP. SECTOR-47, SOHNA ROAD, GURGAON-122001
PH: +91-124-4006265
www.vbhc.com

ARCHITECTS, MEP & LANDSCAPING CONSULTANTS:
VALUE & BUDGET HOUSING CORPORATION PVT LTD
'LAKSHMI NARAYAN' COMPLEX, 4TH FLOOR, OPP. TO MOUNT CARMEL COLLEGE, 10/1 PALACE ROAD, WASANTH NAGAR, BENGALURU 560 052
PH: +91 80 49095100
FAX: +91 80 43479502
www.vbhc.com

STRUCTURAL:
Vision Structural Design Aid
No. 72, II FLOOR, ABOVE CANARA BANK 50 FT. ROAD, HANUMANTHAGAR BENGALURU - 560018
Tel-Fax: 080-26615806
email: info@vsa.co.in
www.vsa.co.in

PROJECT NAME:
VBHC BHIWADI

DRAWING TITLE:		BLOCK
TYPICAL FLOOR PLAN PLUMBING LAYOUT		A & B
DRAWN : RAGHAVENDRA.B.G	DATE : 14-01-2015	SHEET SIZE
DESIGNED : SHAILESH.P	SCALE : AS SHOWN	A1
APPROVED : SANJEEV.KUMAR	SHEET : 1 OF 1	REV
DRAWING No :		RO
VBHC/BH-1/CLS-1/P/GFC/11		