
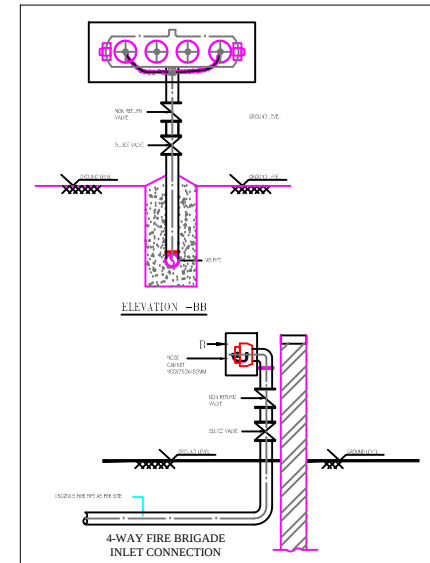
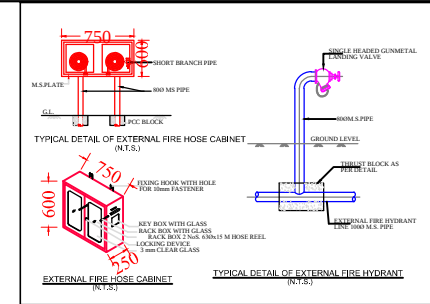


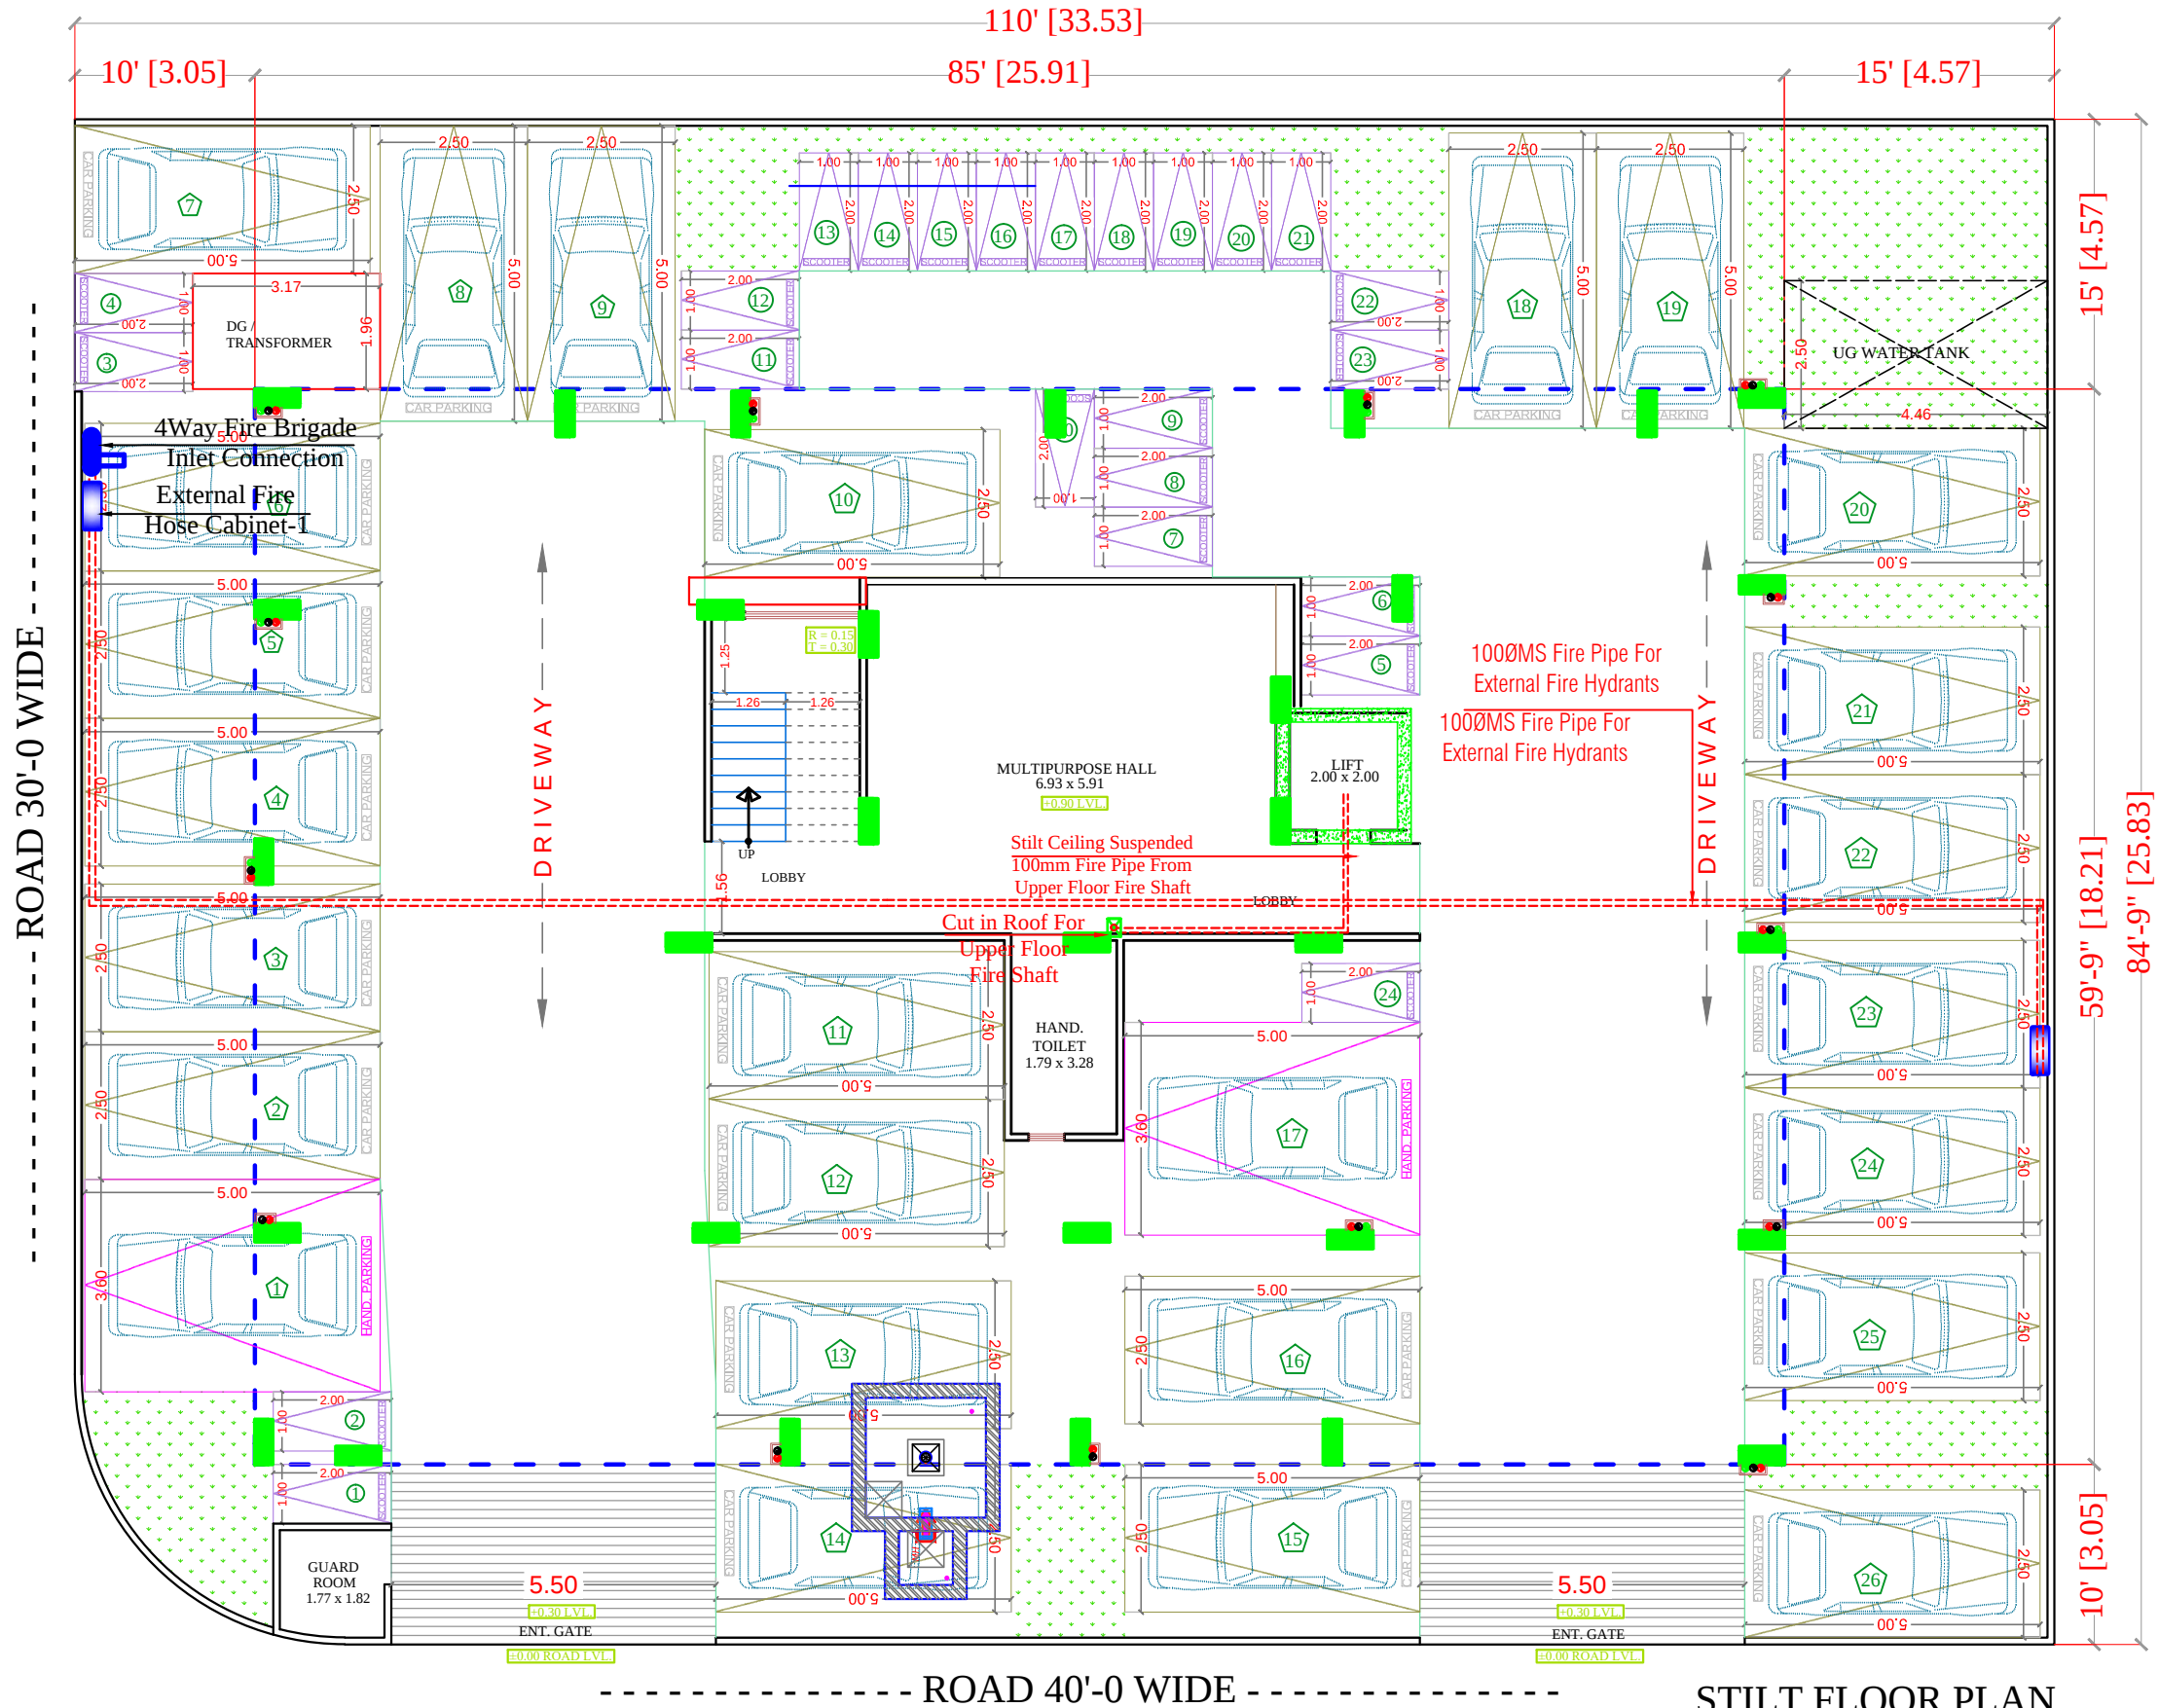

LEGEND		
SYMBOL	QTY.	DESCRIPTION
	02	EXTERNAL FIRE HOSE CABINET
	01	FIRE HOSE CABINET
		1000MS FIRE PIPE FOR EXTERNAL FIRE HYDRANTS

SEAL:-

RAMESH KUMAWAT
M.E.P. CONSULTANT
B.E. CIVIL

Shree Ram Builders and Developers
Partner

SPACE CONSULTANT

PLOT-A-173, JAGDAMBA NAGAR, HEERAPURA
POWER HOWER, JAIPUR (RAJ) 302024

ARCHITECT :-

FRANK SQUARE
ARCHITECTURE | PLANNER | DESIGNER
C-49 VIDYA APARTMENT PARAS MARG,
BAPU NAGAR JAIPUR, (RAJ.)
Email-afranksquare@gmail.com
Mobile-9461302542


PROJECT :-

**PROPOSED BUILDING AT PLOT
NO.-A-53 & A-54,
NARAYANPURI-A, JAIPUR**

BUILDING NAME
ANANDAM HEIGHTS III

DEVELOPER NAME
SHREE RAM BUILDERS & DEVELOPERS

DRAWING: STILT FLOOR
EXTERNAL FIRE HYDRANT
FOR RERA SUBMISSION PLAN

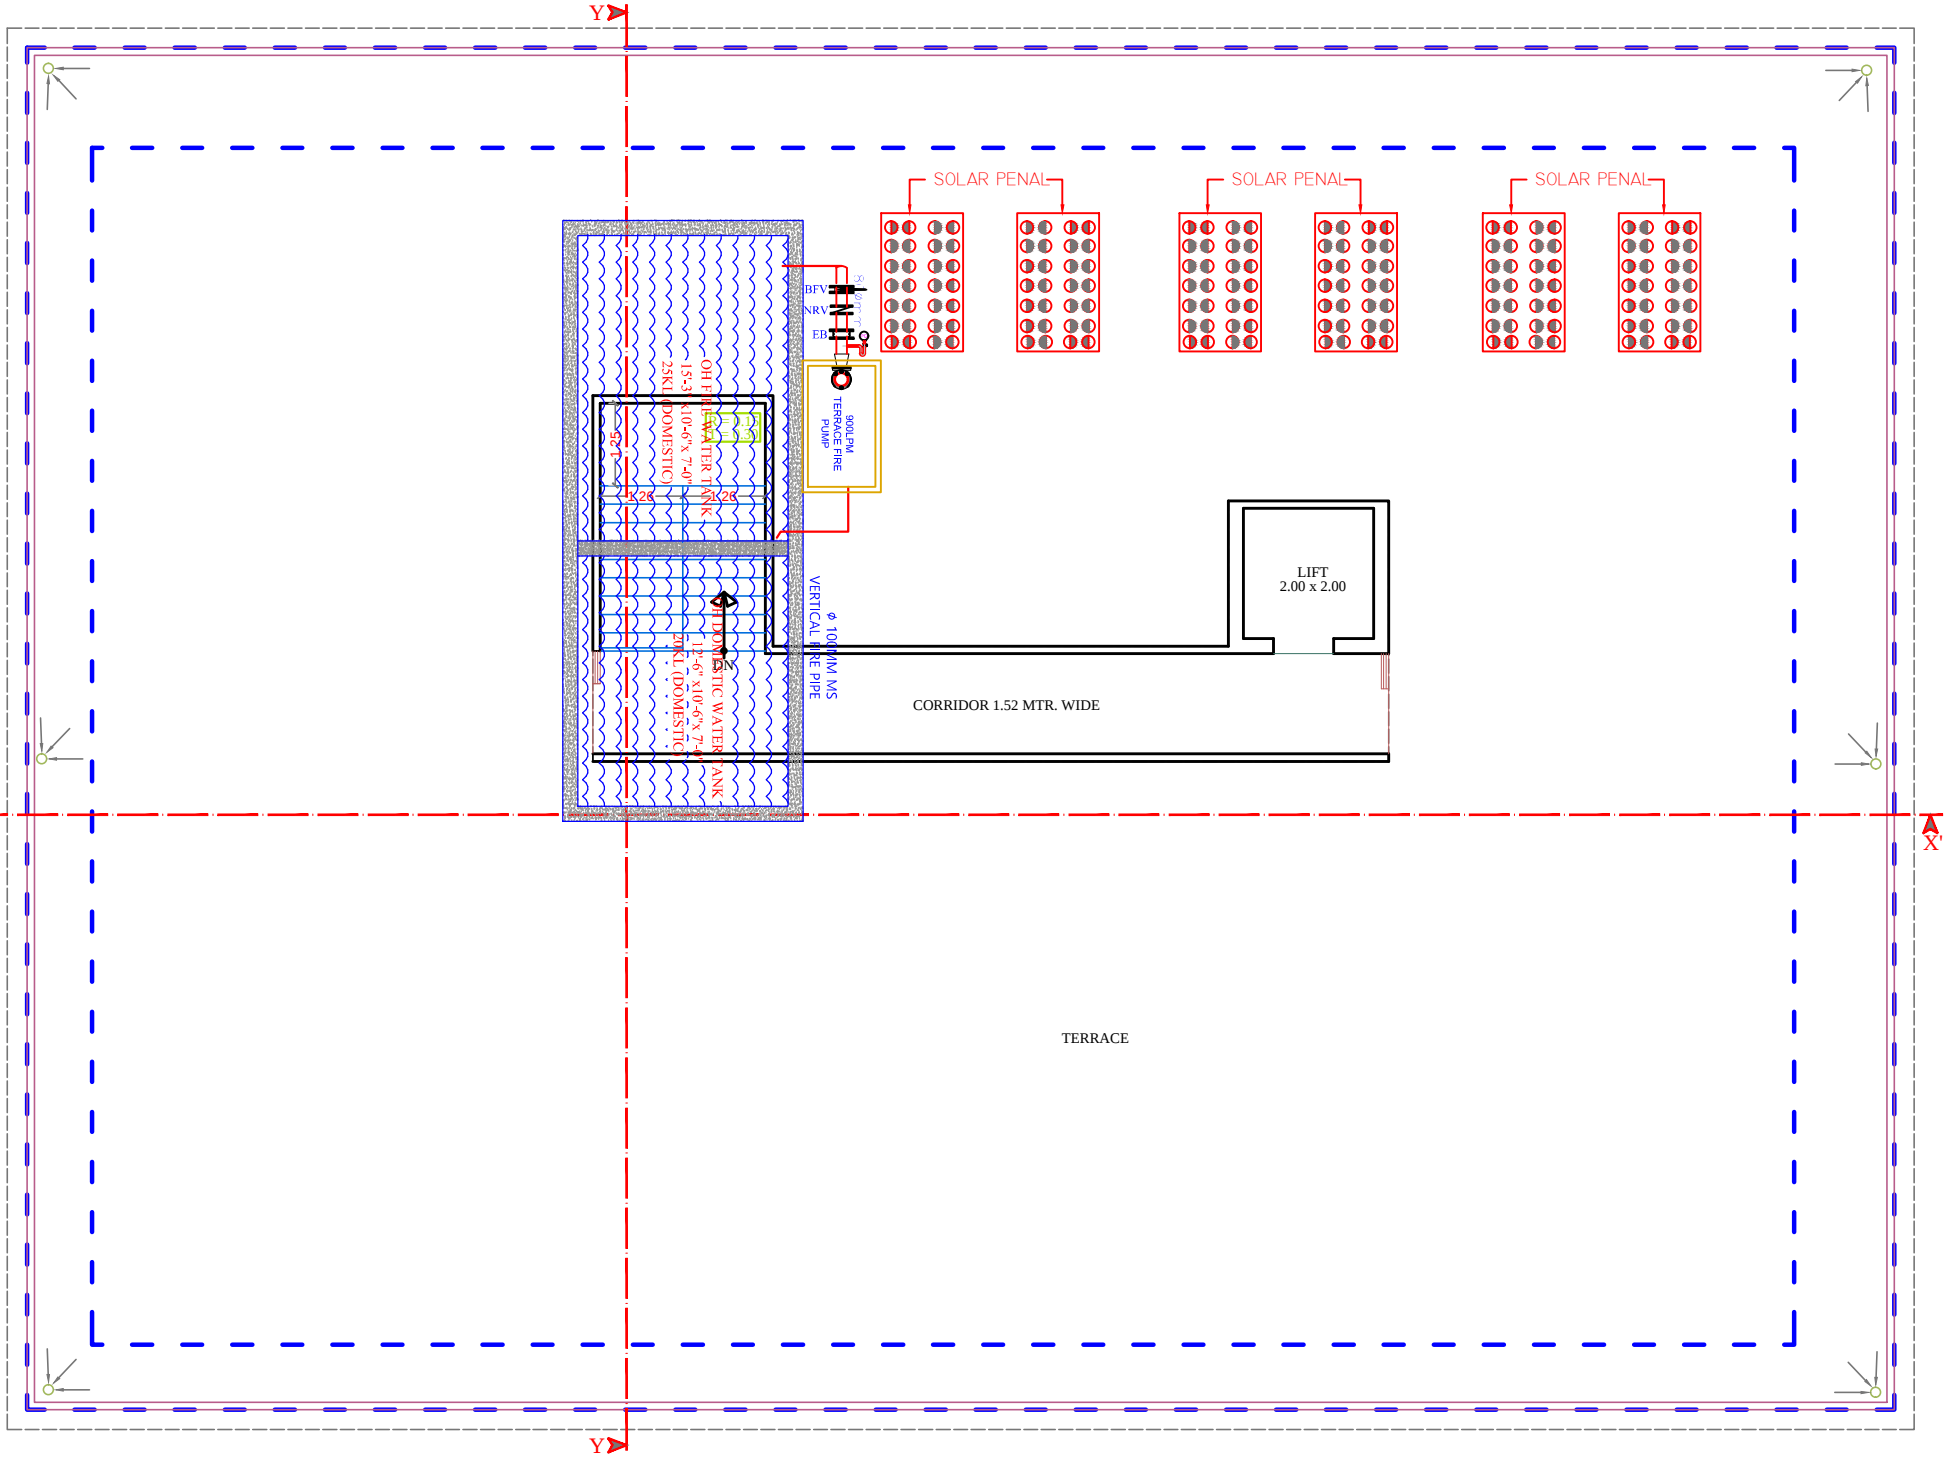


TERRACE FLOOR PLAN

Ramesh Kumawat
RAMESH KUMAWAT
M.E.P. CONSULTANT
B.E. CIVIL

Shree Ram Builders and Developers
Shree Ram Builders and Developers
Partner

LEGEND				
	Symbole	DESCRIPTION		
1.		HOSEREEL		
2.		FIRE PIPE		
3.		FIRE PIPE		
4.		FIRE EXTINGUISHER		
5.		EXTERNAL YARD HYDRANT		

PROJECT TITLE :- PROPOSED BUILDING AT PLOT NO.-A-53 & A-54, NARAYANPURI-A, JAIPUR	BUILDING NAME ANANDAM HEIGHTS III		DRAWING TITLE :- TERRACE FLOOR FIRE FIGHTING	SPACE CONSULTANT PLOT-A-173, JAGDAMBA NAGAR, HEERAPURA POWER HOWER, JAIPUR (RAJ) 302024	DRN. BY			NORTH
	DEVELOPER NAME SHREE RAM BUILDERS & DEVELOPERS					DATE		
					APPD. BY		REVISION	
					SCALE			

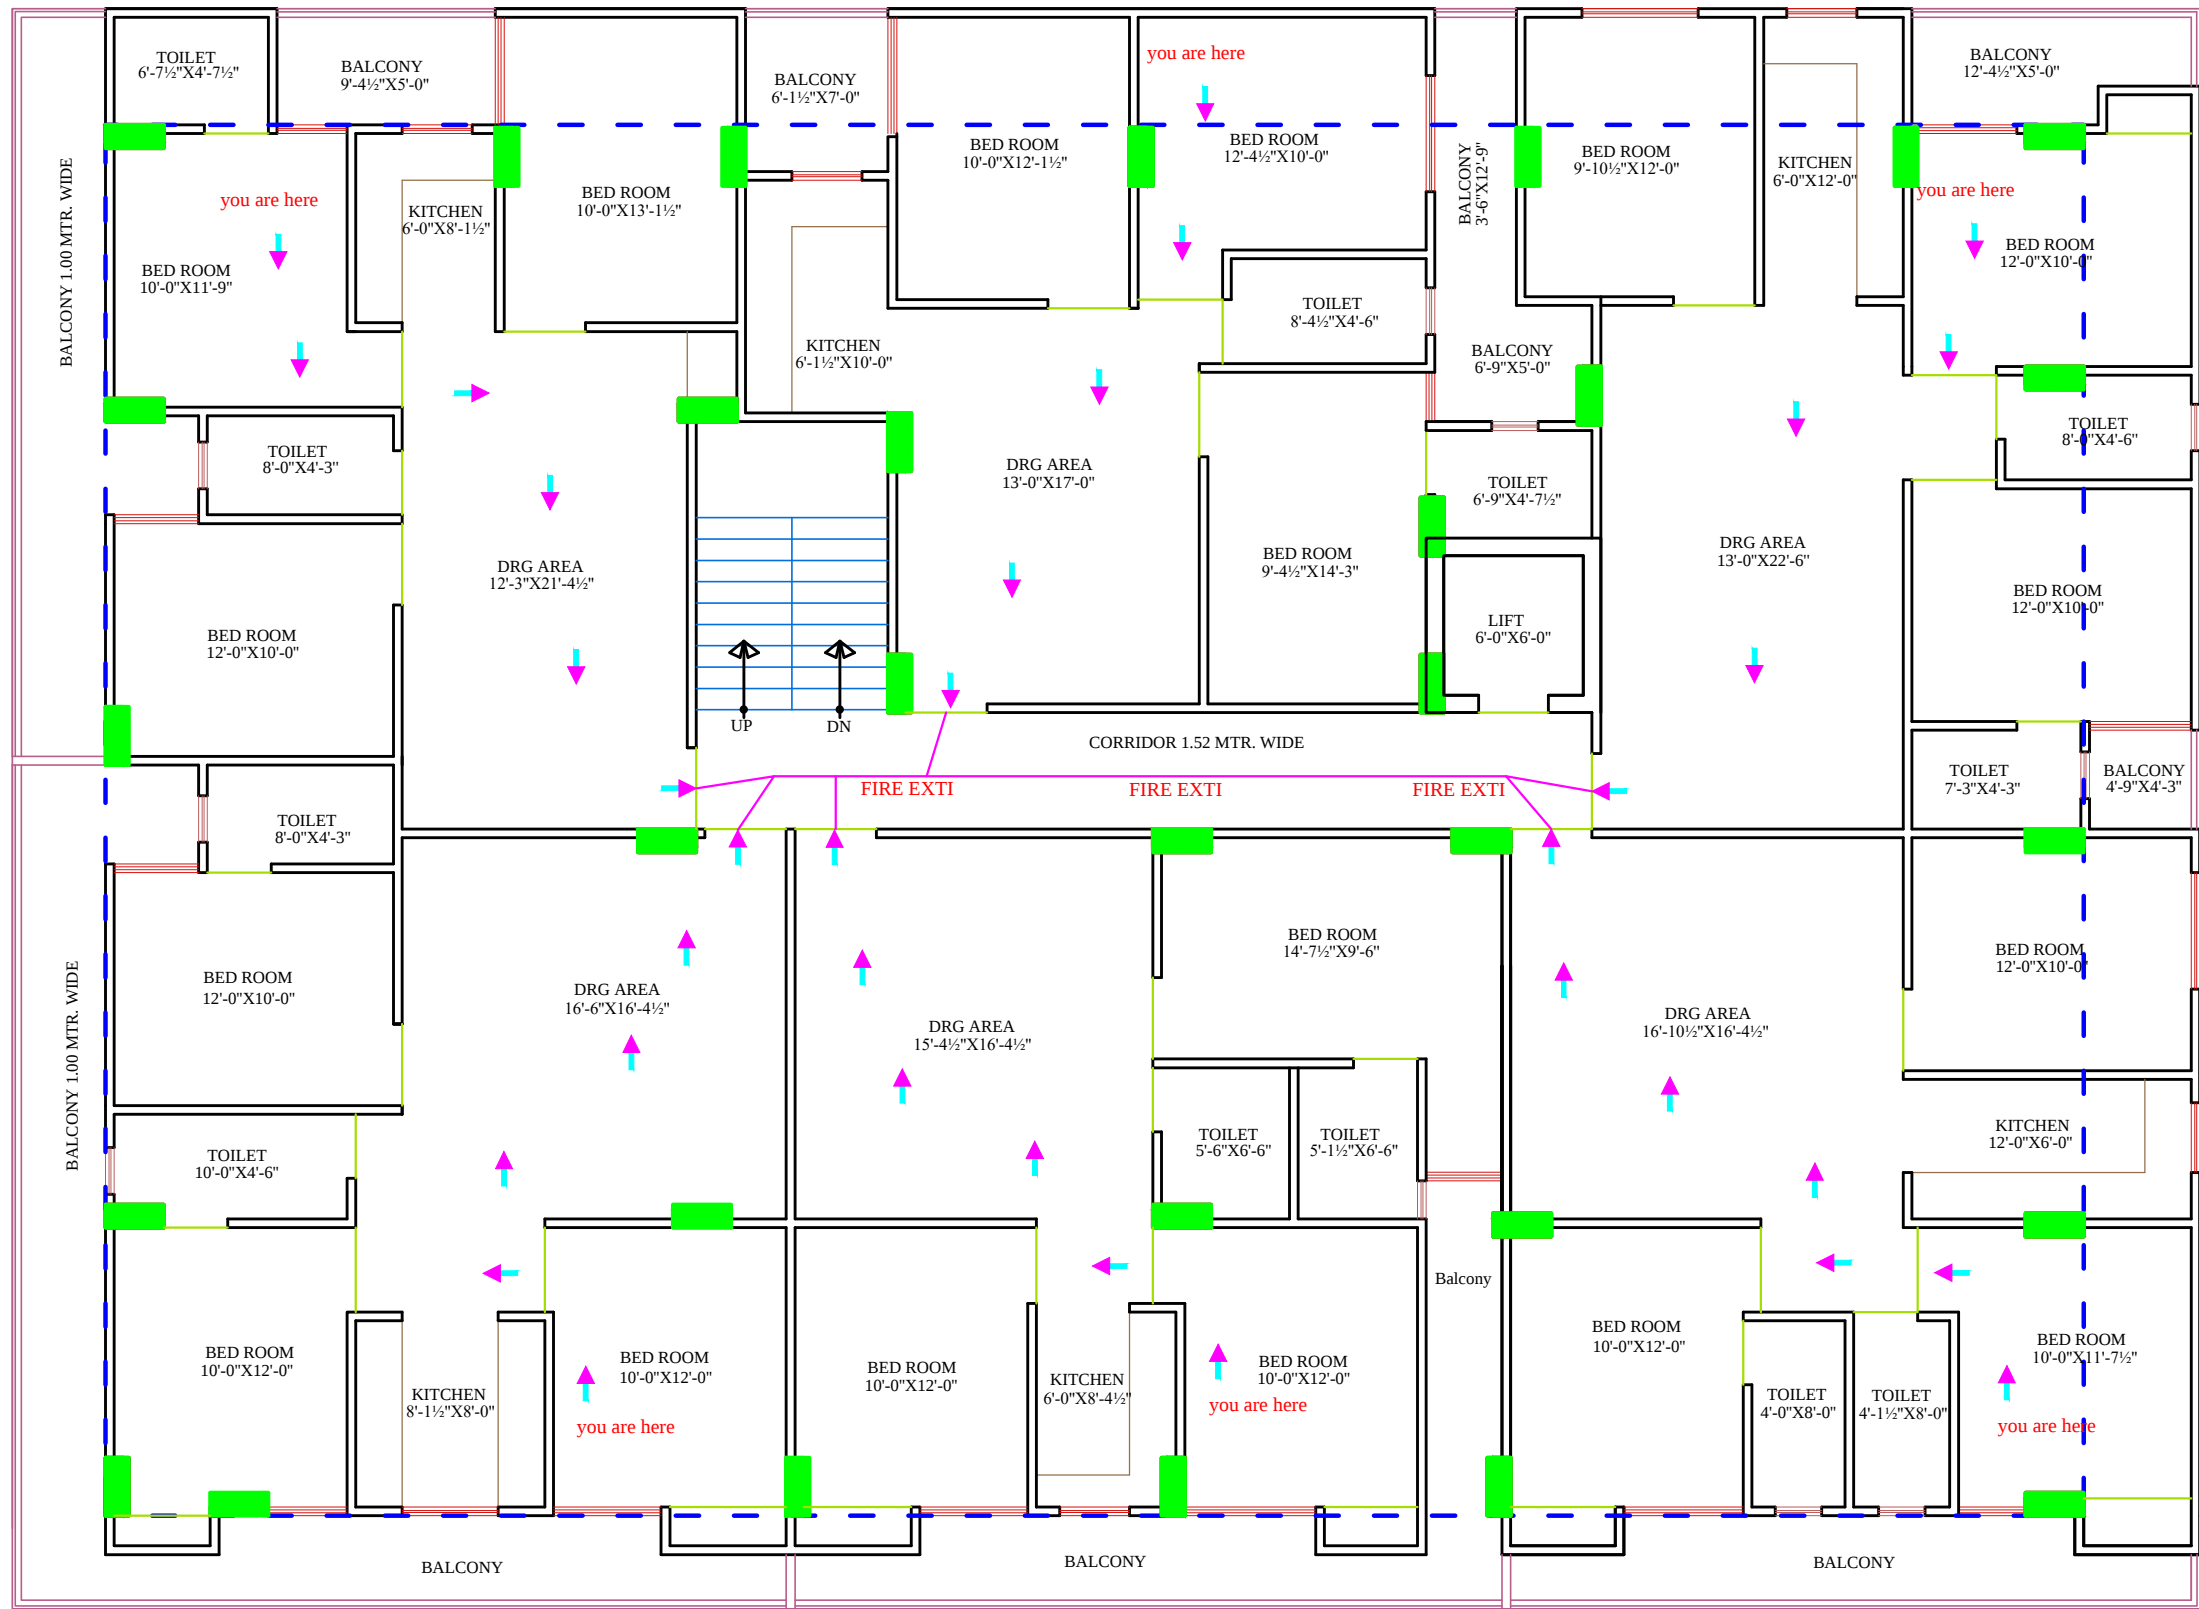

RAMESH KUMAWAT
M.E.P. CONSULTANT
B.E. CIVIL

Shree Ram Builders and Developers
Partner

PROJECT TITLE :- PROPOSED BUILDING AT PLOT NO.-A-53 & A-54, NARAYANPURI-A, JAIPUR	BUILDING NAME ANANDAM HEIGHTS III		DRAWING TITLE :- TYPICAL FLOOR FIRE FIGHTING	SPACE CONSULTANT PLOT-A-173, JAGDAMBA NAGAR, HEERAPURA POWER HOWER, JAIPUR (RAJ) 302024		DRN. BY			NORTH
							DATE		
	DEVELOPER NAME SHREE RAM BUILDERS & DEVELOPERS					APPD. BY		REVISION	
						SCALE	N.T.S		