



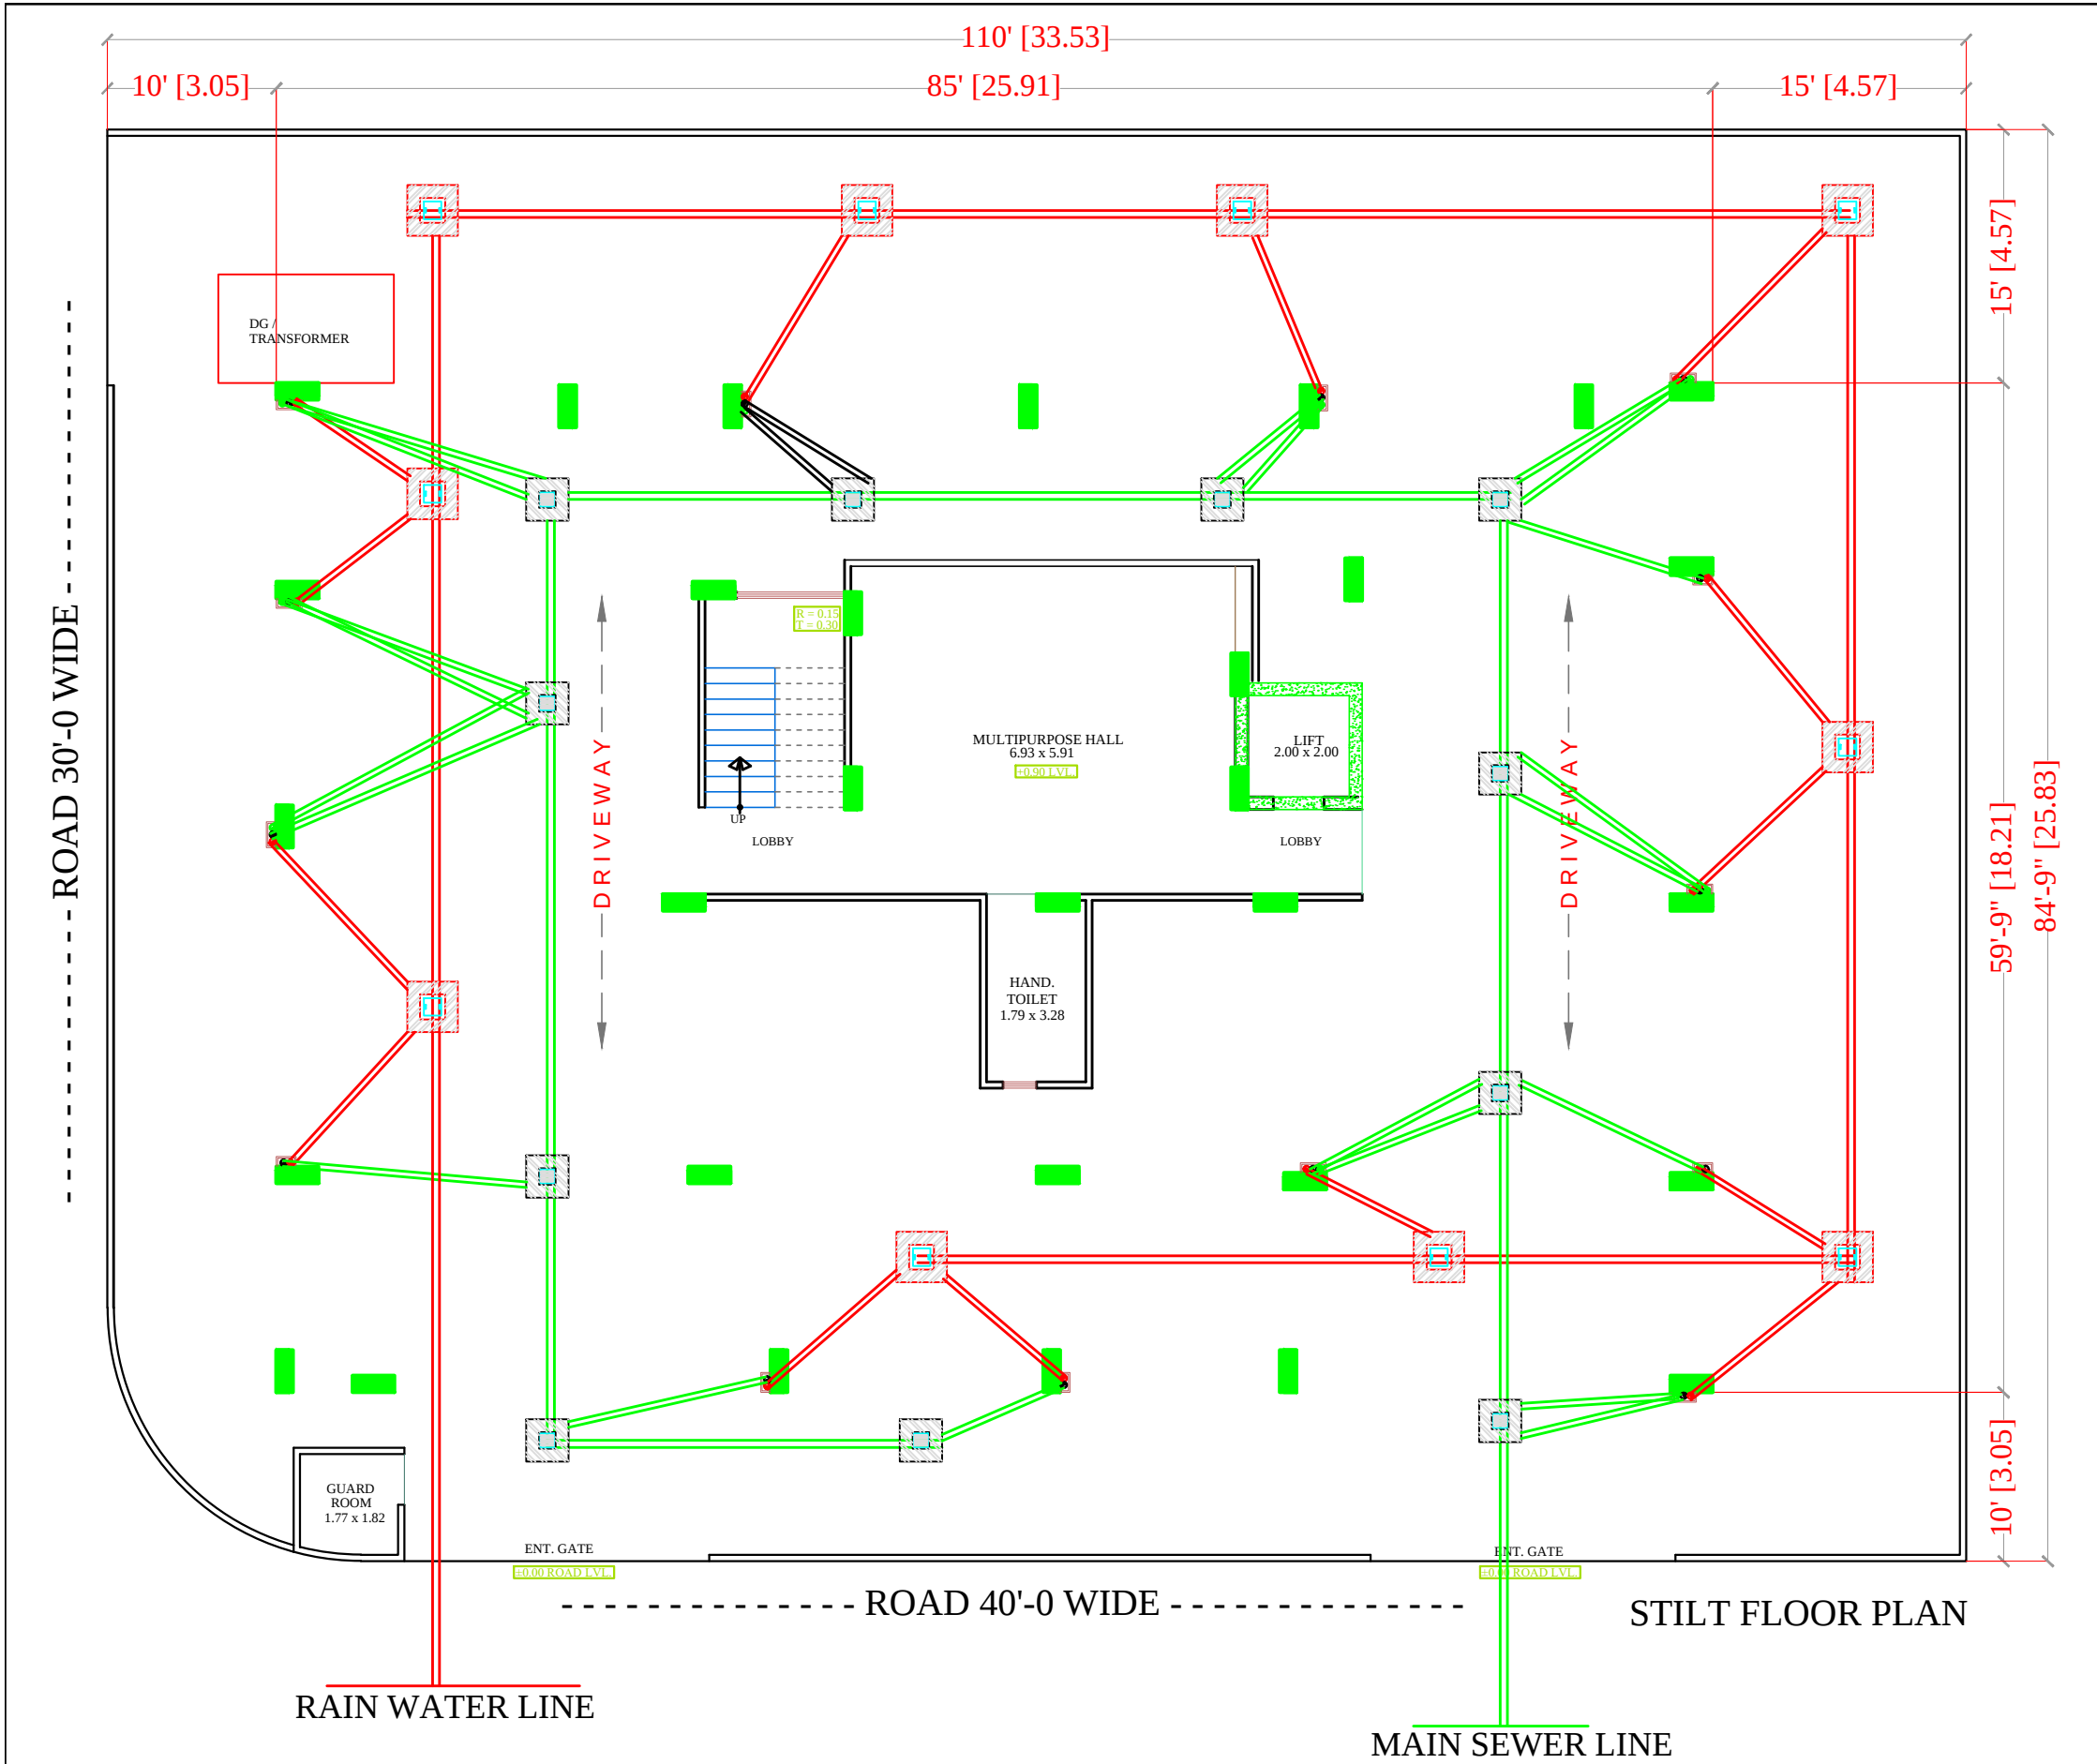

SYMBOL	DESCRIPTION
	Ø 110 mm Soil Waste Water Pipe
	Ø 110 mm Waste Water Pipe
	Ø 110 mm Rain Water Pipe
	Ø 160 mm Rain Water Pipe Slope 1:200
	Ø 110 mm Rain Water Pipe Slope 1:200
	RC-12"X12" Depth According to Slope
	RC-18"X18" Depth According to Slope
	RC-24"X24" Depth According to Slope
	Flow Direction

PROJECT TITLE :- PROPOSED BUILDING AT PLOT NO.-A-53 & A-54, NARAYANPURI-A, JAIPUR	BUILDING NAME ANANDAM HEIGHTS III	DRAWING TITLE :- STILT FLOOR WATER SUPPLY	SPACE CONSULTANT PLOT-A-173, JAGDAMBA NAGAR, HEERAPURA POWER HOWER, JAIPUR (RAJ) 302024	DRN. BY		DATE	NORTH
	DEVELOPER NAME SHREE RAM BUILDERS & DEVELOPERS			APPD. BY		REVISION	
				SCALE			

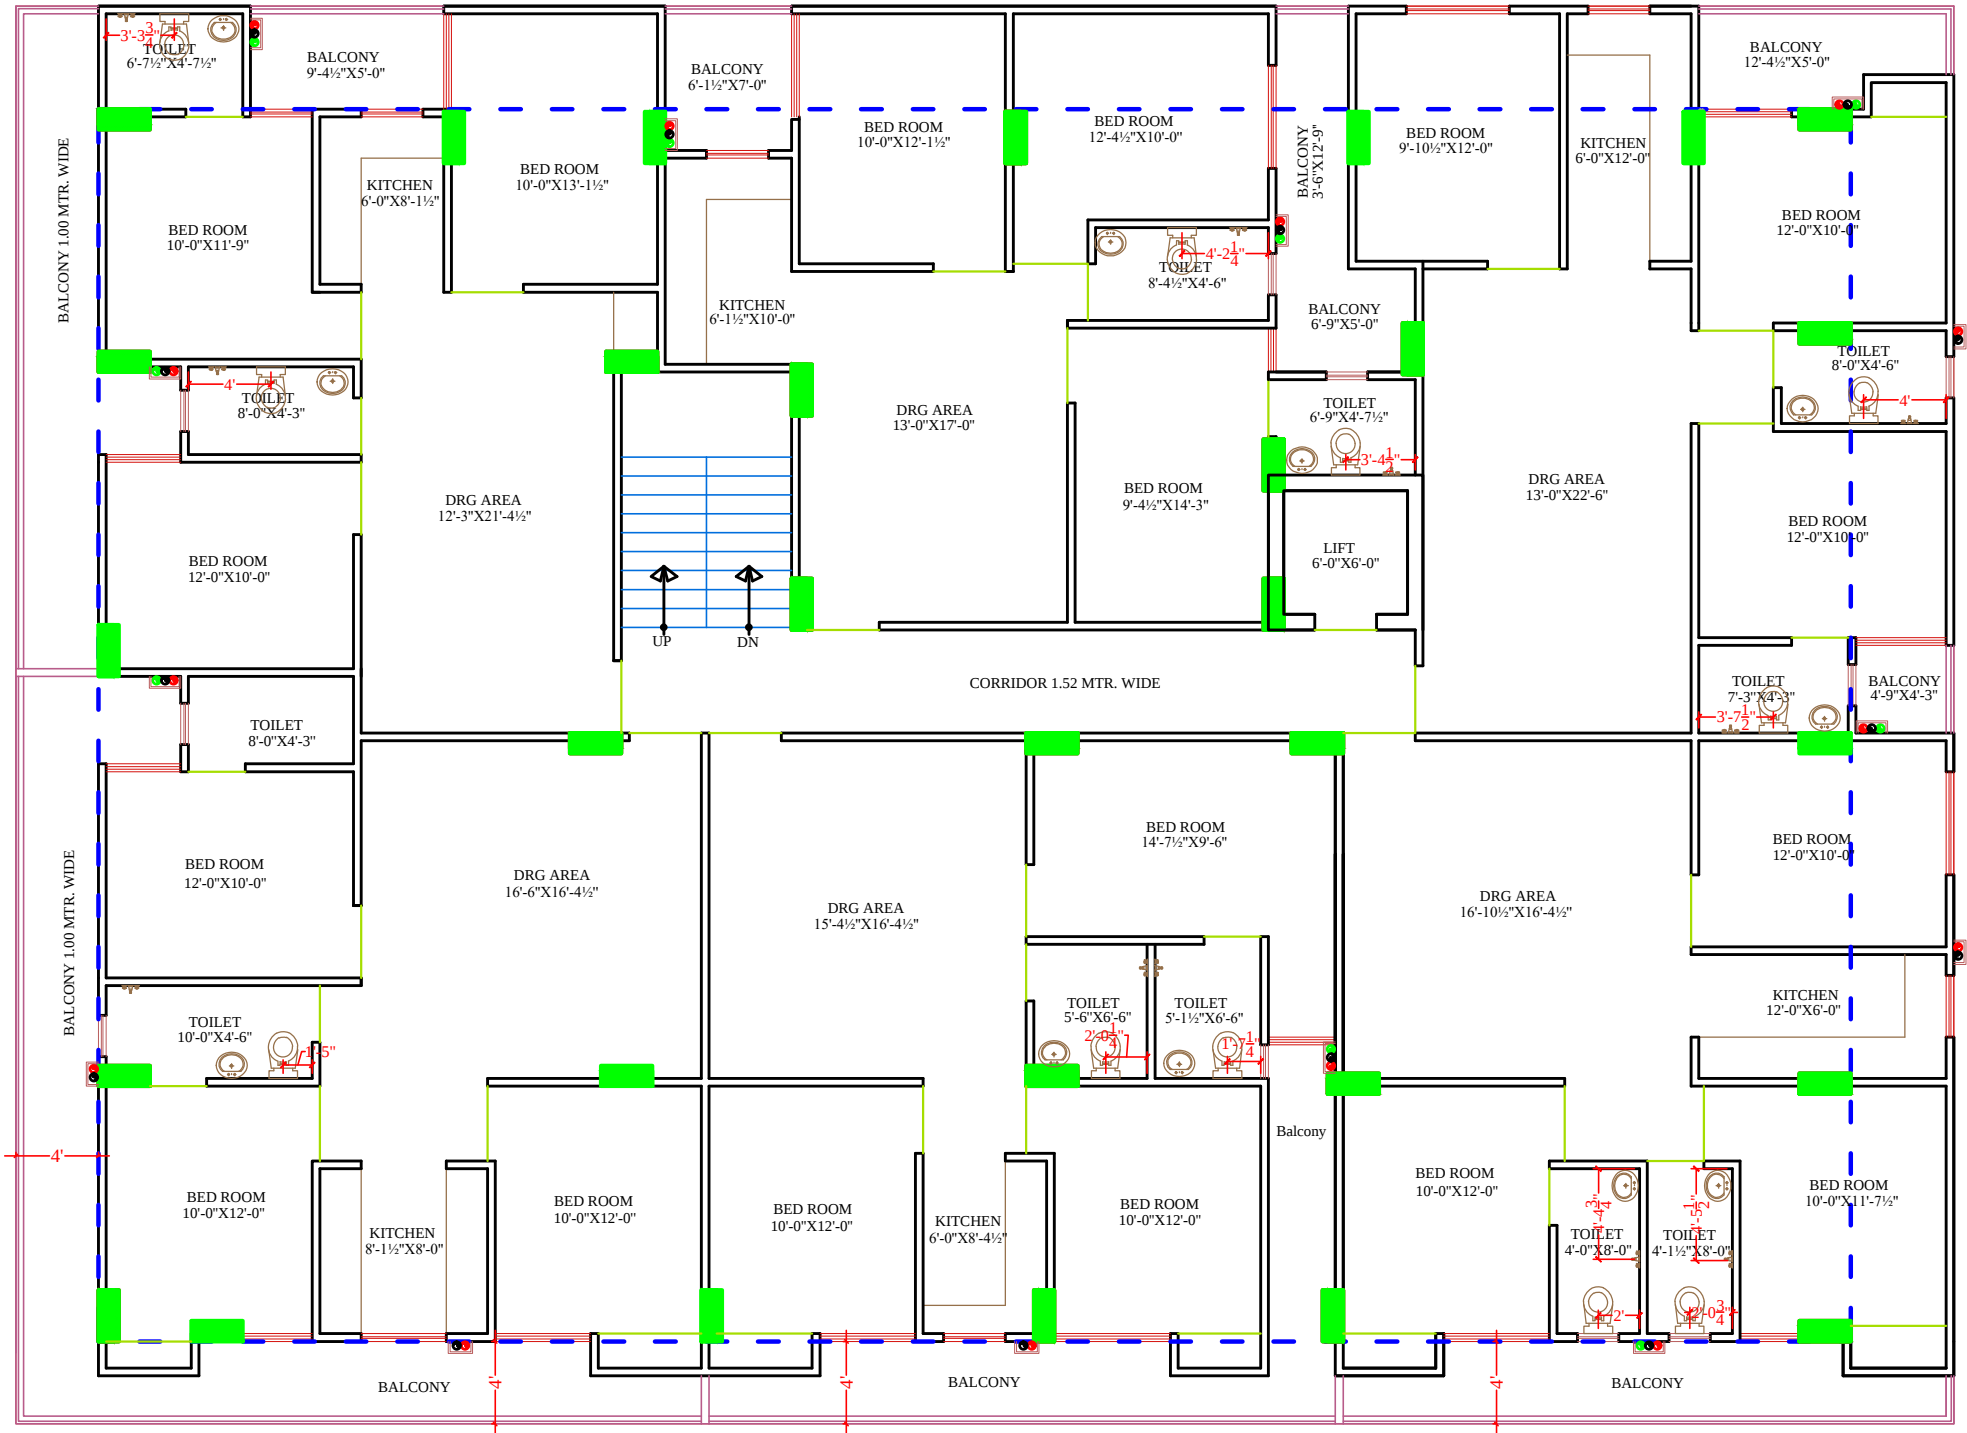

RAMESH KUMAWAT
M.E.P. CONSULTANT
B.E. CIVIL

Shree Ram Builders and Developers
Partner

All Heights For Finish Floor Lvl	SYMBOL	SYMBOL	DESCRIPTION
+1000MM			Ø 20MM CWS PIPE THRU WALL CHASE TO SINK
			Ø 20MM HWS PIPE THRU WALL CHASE TO SINK
+1950MM			Ø 20MM CWS PIPE THRU WALL CHASE TO GEYSER
			Ø 20MM HWS PIPE THRU WALL CHASE FROM GEYSER
+1500MM			Ø 20MM CWS PIPE THRU WALL CHASE TO AQUAGUARD
+450MM			Ø 20MM CWS PIPE THRU WALL CHASE TO BASIN ANGLE VALVE
+800MM			Ø 20MM HWS PIPE THRU WALL CHASE TO BASIN ANGLE VALVE
+2100MM			Ø 20MM CWS PIPE THRU WALL CHASE TO CONCELED STOP COCK
+300MM			Ø 20MM CWS PIPE THRU WALL CHASE TO FAUCET
+1000MM WALL MIXER DIVERTOR			Ø 20MM CWS PIPE THRU WALL CHASE TO WALL MIXER / DIVERTOR
+2025MM O.H.SHOWER			Ø 20MM HWS PIPE THRU WALL CHASE TO WALL MIXER / DIVERTOR
+600MM			Ø 20MM CWS PIPE THRU WALL CHASE TO TAP
+1000MM	AS PER/ARCHI.		SOAP DISH
+1500MM	AS PER/ARCHI.		TOWEL RAIL
+450MM	AS PER/ARCHI.		PAPER HOLDER
			COLD WATER SUPPLY LINE
			HOT WATER SUPPLY LINE
			FLUSHING WATER SUPPLY LINE

PROJECT TITLE :-

PROPOSED BUILDING AT PLOT NO.-A-53 & A-54, NARAYANPURI-A, JAIPUR

BUILDING NAME

ANANDAM HEIGHTS III

DEVELOPER NAME

SHREE RAM BUILDERS & DEVELOPERS

DRAWING TITLE :-

TYPICAL FLOOR PLUMBING PLAN

SERVICES CONSULTANT

DRN. BY

APPD. BY

SCALE

DATE

REVISION

NORTH

SERVICES CONSULTANT:
PLOT-A-173, JAGDAMBA NAGAR ,HEERAPURA
POWER HOWER ,JAIPUR (RAJ) 302024

ARCHITECTS:-
 **FRANK SQUARE**
ARCHITECTURE | PLANNER | DESIGNER
C-49 VIDYA APARTMENT PARAS MARG,
BAPU NAGAR JAIPUR, (RAJ.)
Email-afranksquare@gmail.com
Mobile-9461302542

Project:
PROPOSED BUILDING AT PLOT
NO.-A-53 & A-54,
NARAYANPURI-A, JAIPUR

BUILDING NAME
ANANDAM HEIGHTS III

DEVELOPER NAME
SHREE RAM BUILDERS & DEVELOPERS

Drawing: WATER SUPPLY SCHEMATIC
DIAGRAM

DRN BY : CHCKD BY :

APPRVD BY : DATE.:-

Shree Ram Builders and Developers

Partner


RAMESH KUMAWAT
M.E.P. CONSULTANT
B.E. CIVIL

WATER SUPPLY SCHEMATIC DIAGRAM

