
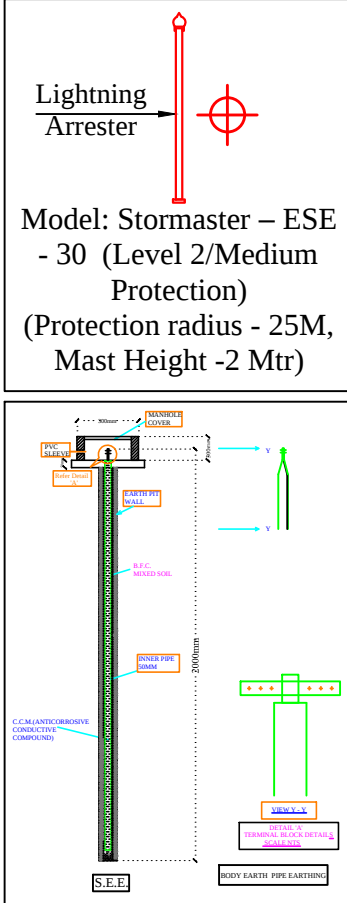


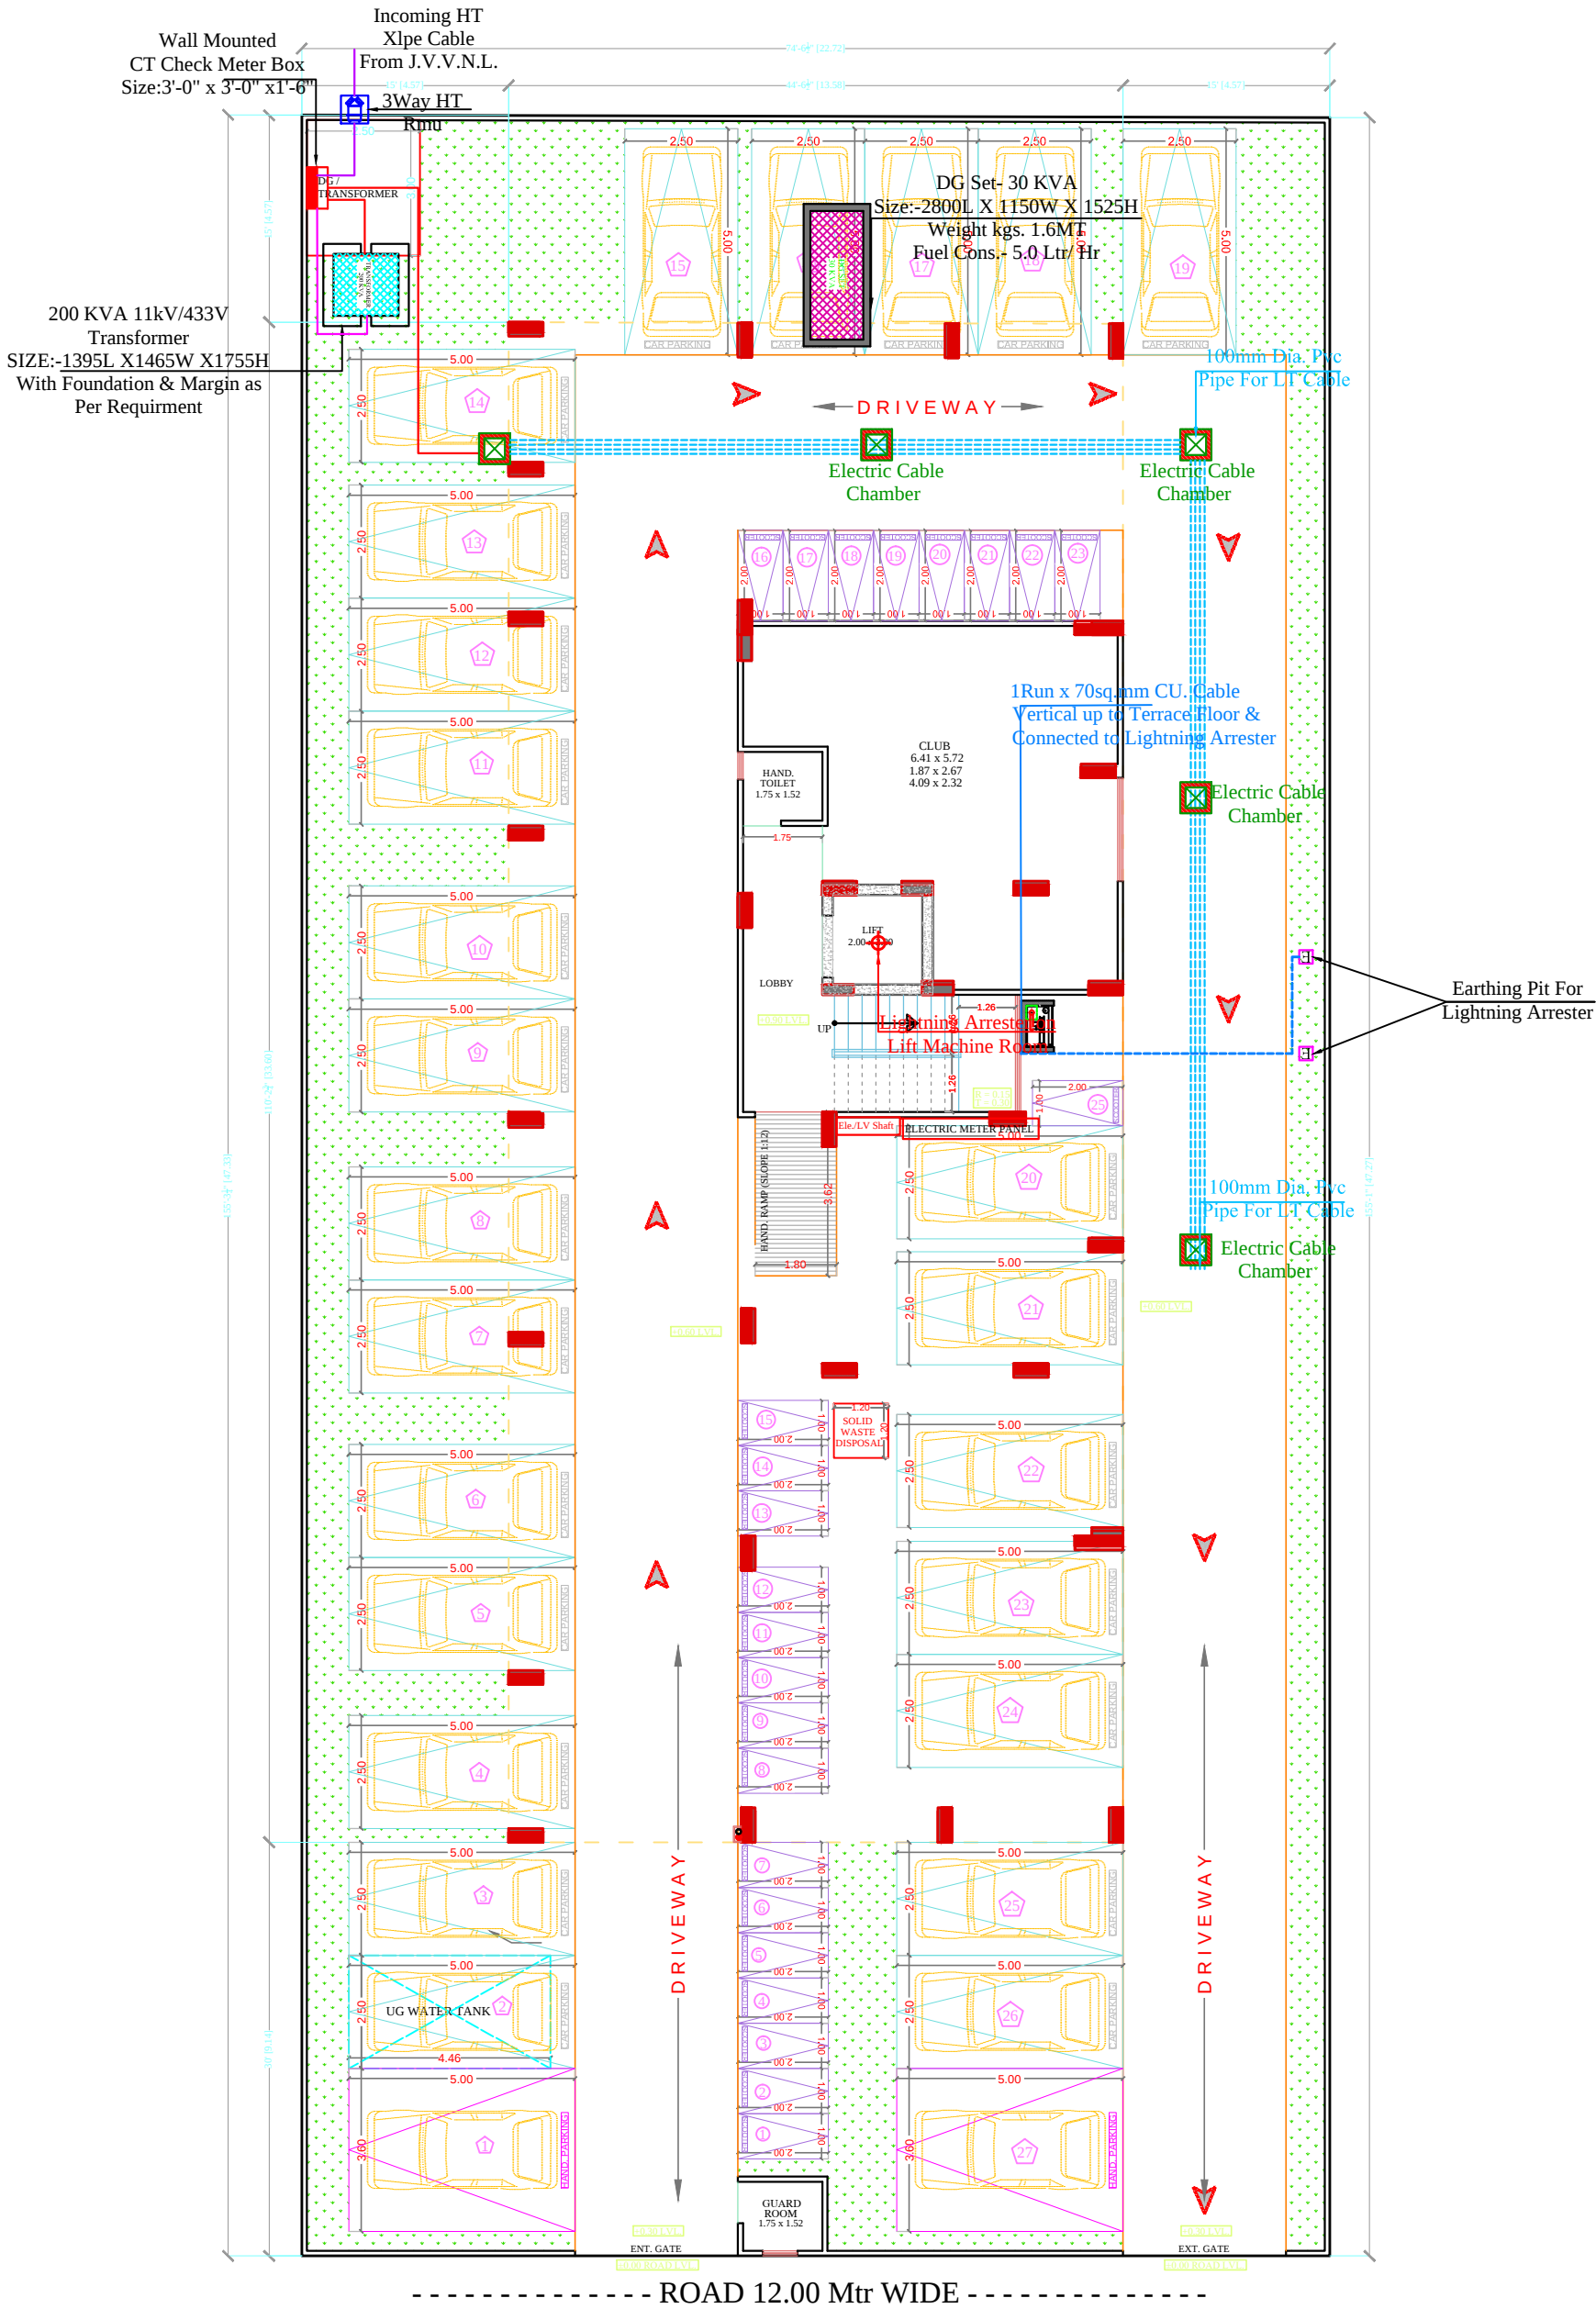

SIGN:-

SPACE CONSULTANT
PLOT-A-173, JAGDAMBA NAGAR, HEERAPURA
POWER HOWER, JAIPUR (RAJ) 302024

ARCHITECT :-
FRANK SQUARE
ARCHITECTURE | PLANNER | DESIGNER
C-49 VIDYA APARTMENT PARAS MARG,
BAPU NAGAR JAIPUR, (RAJ.)
Email-afranksquare@gmail.com
Mobile-9461302542

PROJECT :-
PROPOSED BUILDING AT PLOT
NO.-R-17-259, CHORDIA CITY,
JAIPUR


DRAWING:
STILT FLOOR
ELECTRIC SUB STATION,
CABLE ROUTE &
LIGHTNING ARRESTER FOR
RERA SUBMISSION PLAN

DATE

SCALE:-

N.T.S.

PRODUCED BY AN AUTODESK EDUCATIONAL PRODUCT

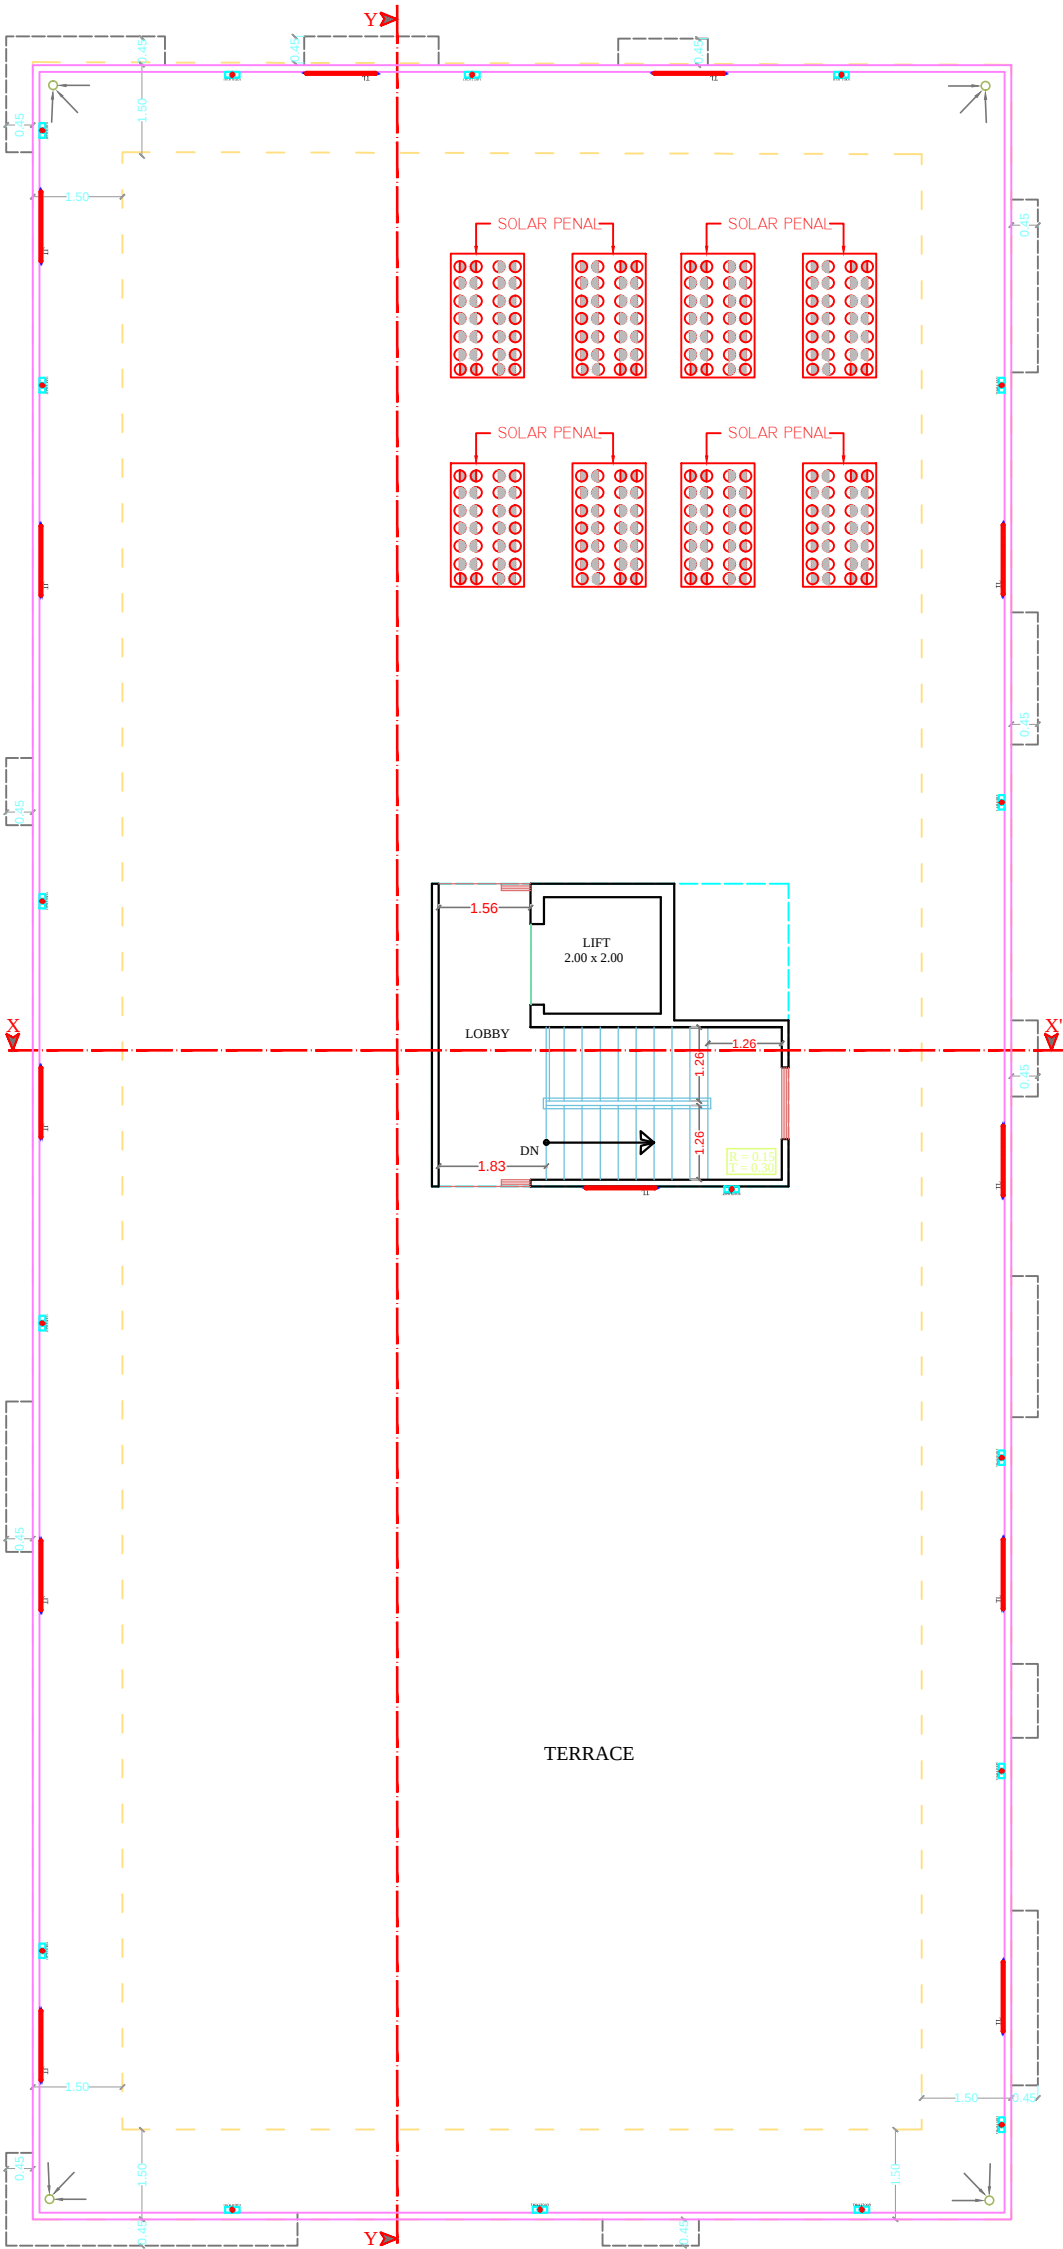


TERRACE FLOOR PLAN



LEGENDS:				
Mounting Height	No.	I D	Symbol	Description
+90"		TL/W		LED WALL TUBE LIGHT
+2"		FL		FOOT LIGHT
CEILING		DL		LED DOWN LIGHTS (SURFACE MOUNTED)
+42"				

PROJECT TITLE :- PROPOSED BUILDING AT PLOT NO.-R-17-259, CHORDIA CITY, JAIPUR	DRAWING TITLE :- TERRACE FLOOR ELECTRIC POINT	SPACE CONSULTANT PLOT-A-173, JAGDAMBA NAGAR, HEERAPURA POWER HOUSE, JAIPUR (RAJ) 302024	DRN. BY		DATE	NORTH
			APPD. BY		REVISION	
			SCALE			

PRODUCED BY AN AUTODESK EDUCATIONAL PRODUCT

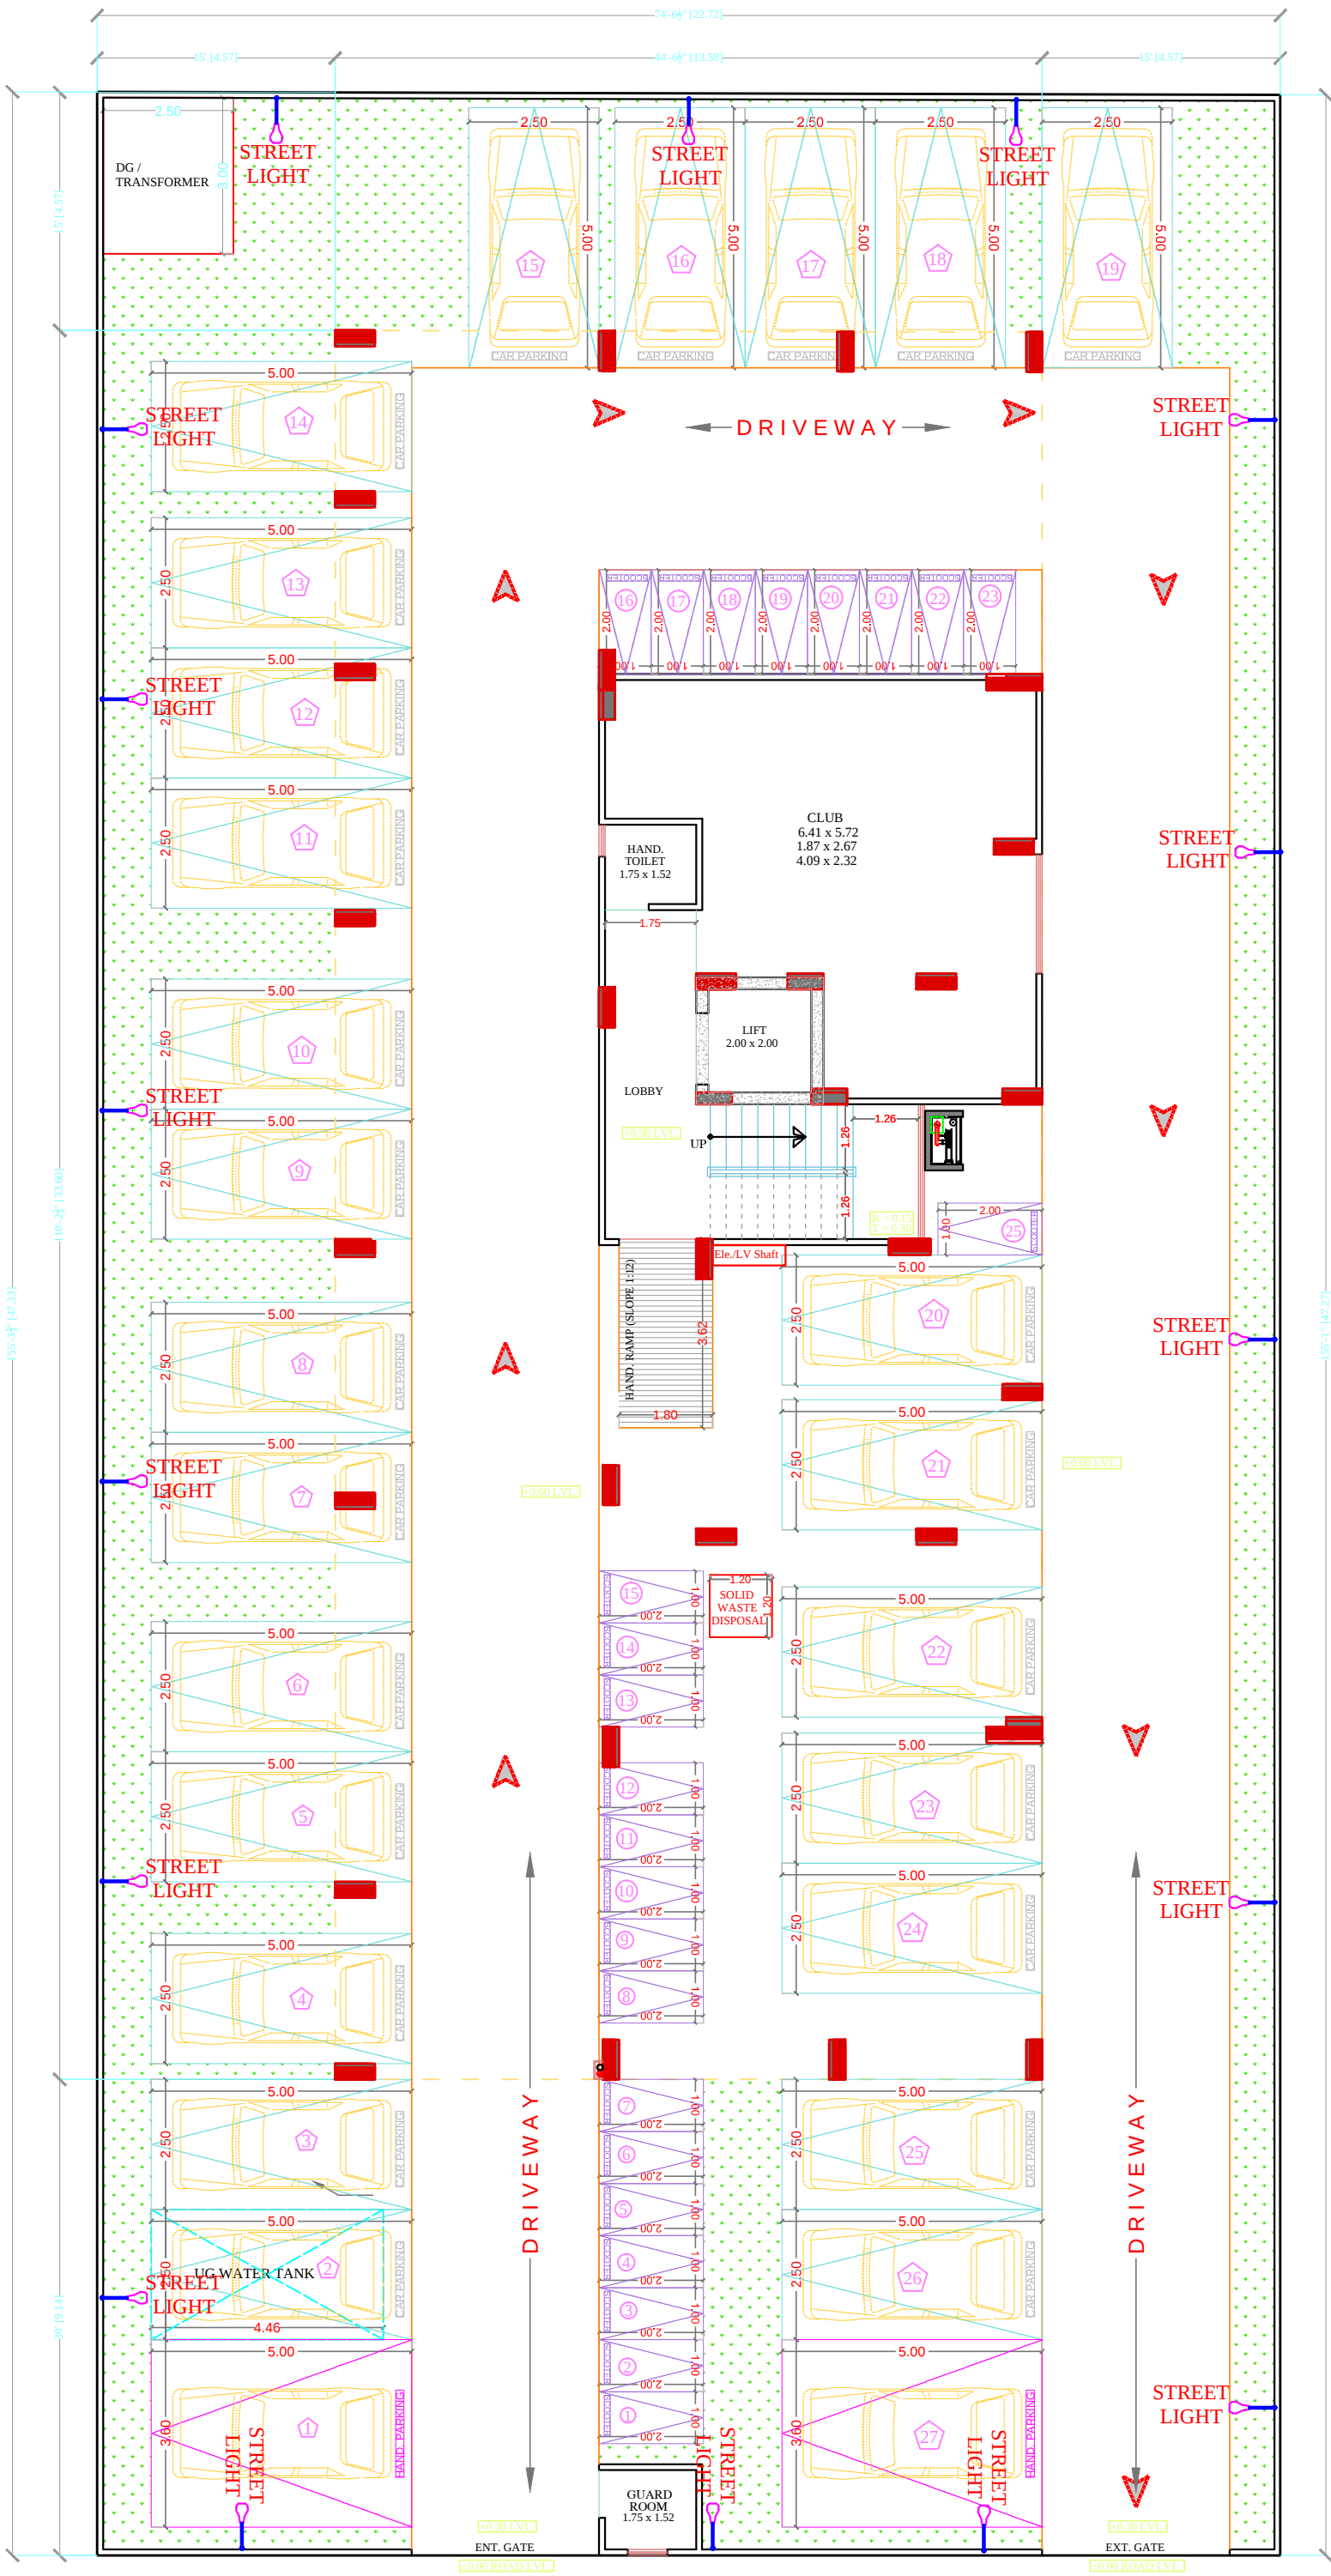

LEGENDS:

Qty.	I D	Symbol	Description
14	PL		STREET LIGHT

SIGN:-



SPACE CONSULTANT
PLOT-A-173, JAGDAMBA NAGAR, HEERAPURA
POWER HOWER, JAIPUR (RAJ) 302024

ARCHITECT :-
 **FRANK SQUARE**
ARCHITECTURE | PLANNER | DESIGNER
C-49 VIDYA APARTMENT PARAS MARG,
BAPU NAGAR JAIPUR, (RAJ.)
Email-afranksquare@gmail.com
Mobile-9461302542

PROJECT :-
PROPOSED BUILDING AT PLOT
NO.-R-17-259, CHORDIA CITY,
JAIPUR

DRAWING:
STILT FLOOR
EXTERNAL STREET LIGHT
FOR RERA SUBMISSION PLAN

DATE	
SCALE:-	N.T.S.

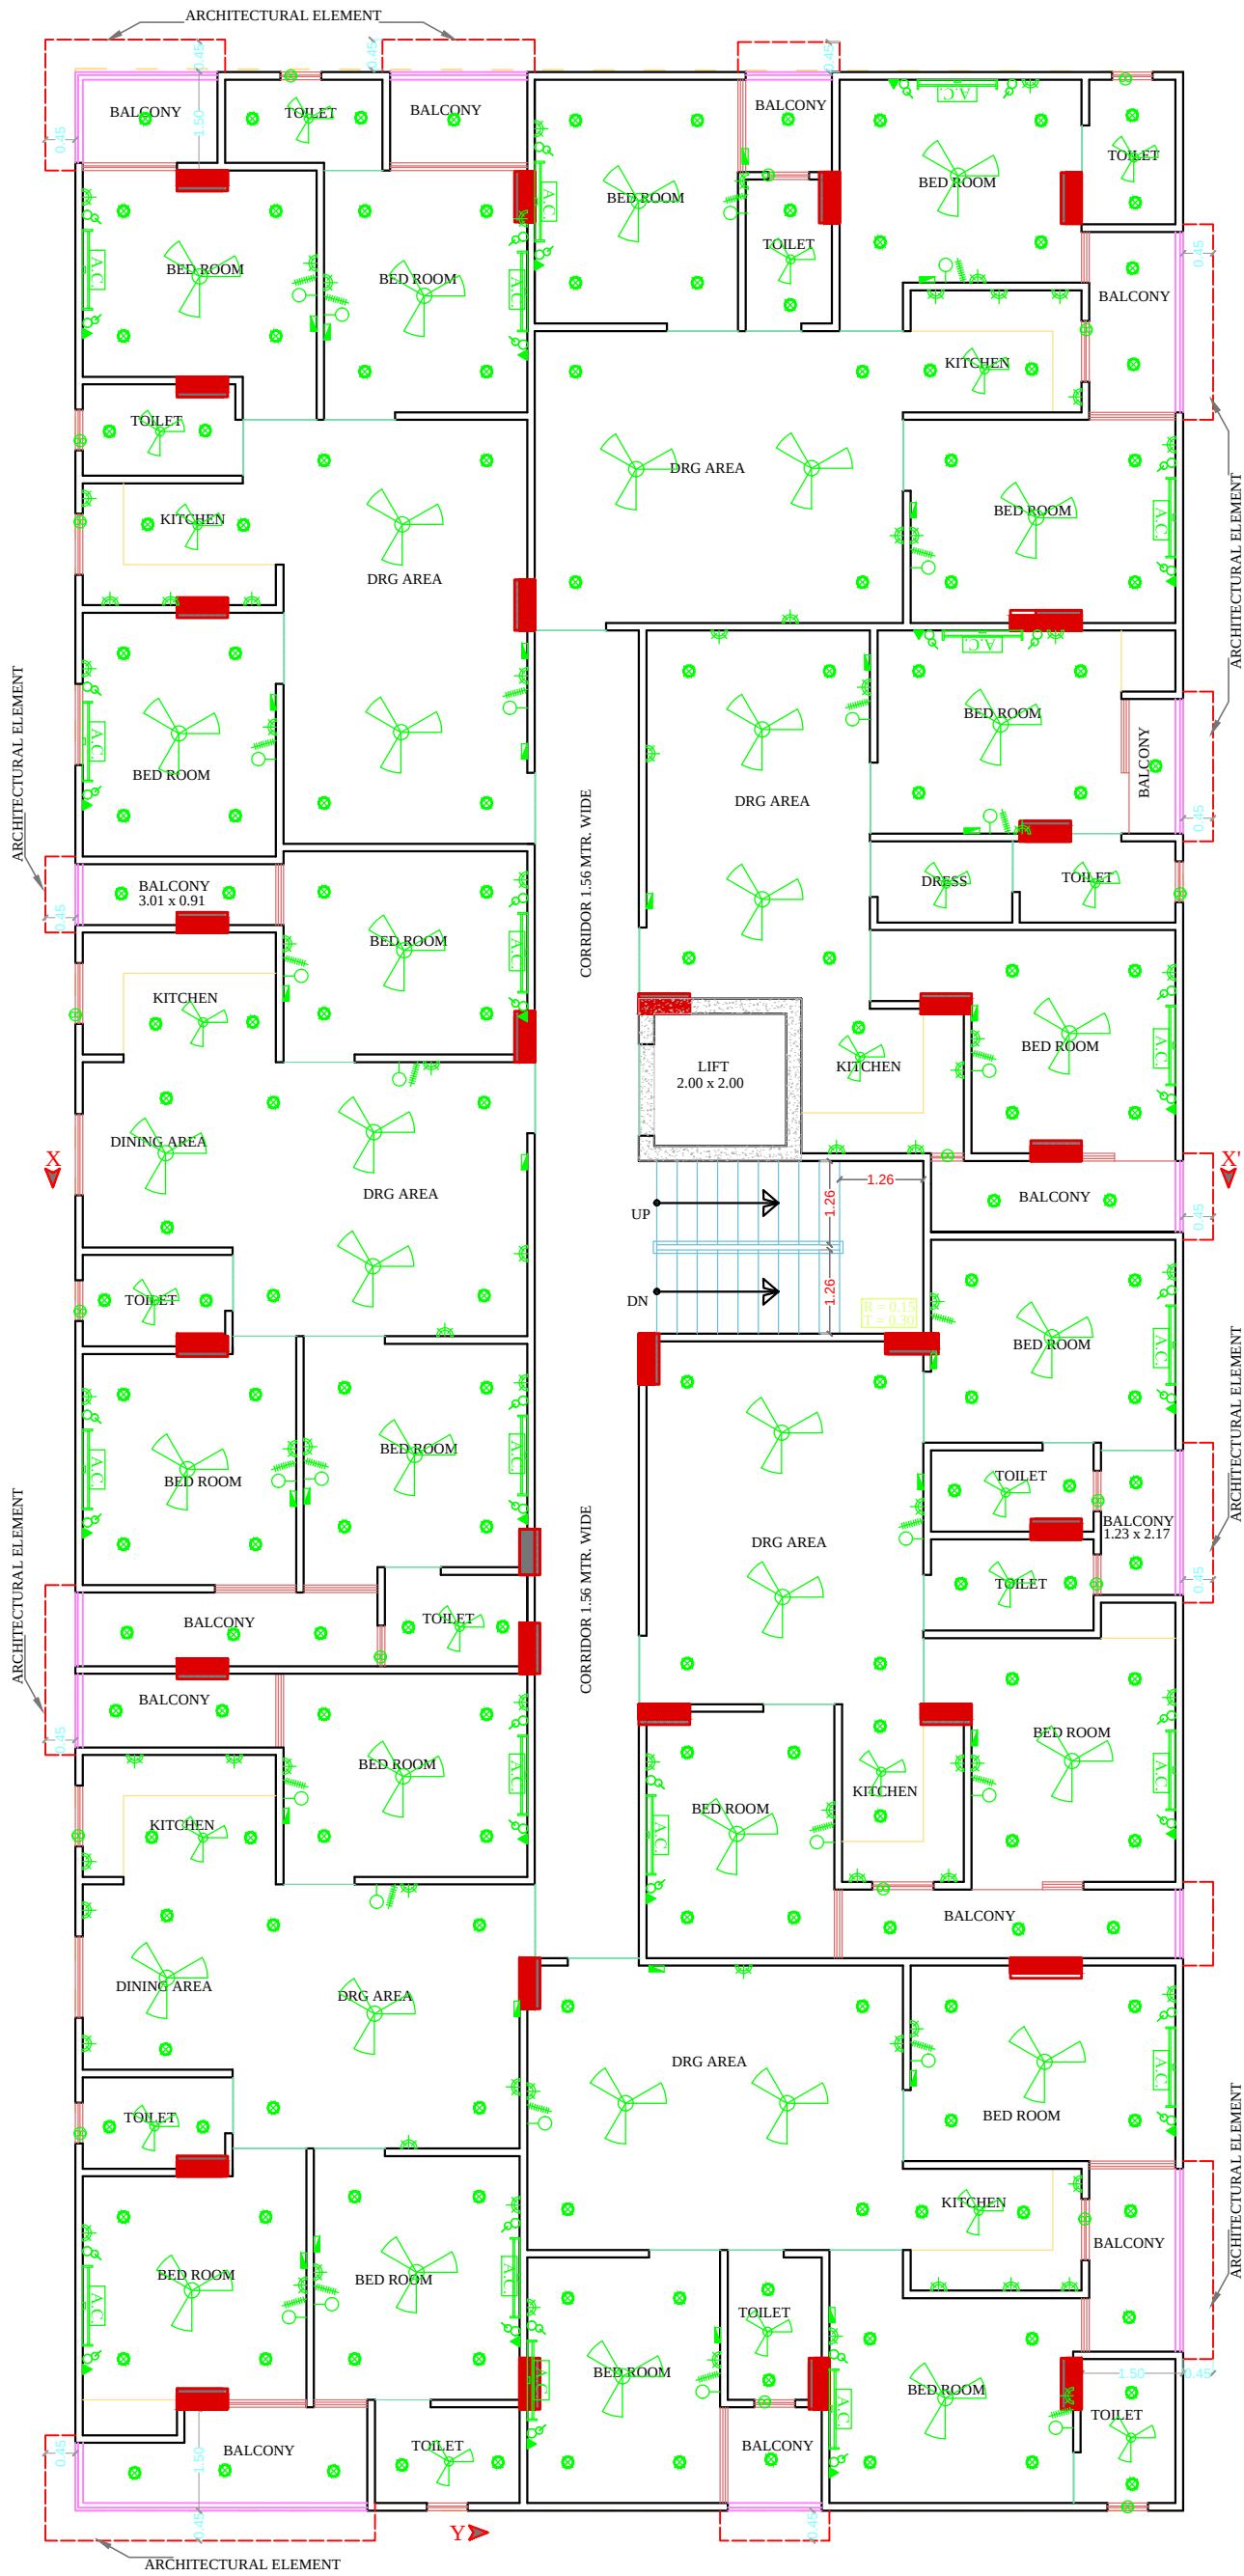

NO	ITEM	SYMBOL
1	CEILING FAN	ROOF
2	TUBE LIGHT	+8'6"
3	BULB	+8'6"
4	POWER POINT	+1'6"
5	BED POINT	+4'3"
6	CEILING LIGHT	ROOF
7	A.C.POINT	+6'6"
8	SWITCH BOARD	+4'3"
9	EXHAUST	VENT
10	TELEPHONE	+1'6"
11	GYSER	+6'0"
12	BELL POINT	+8'6"
13	T.V.	+1'6"
14	M.BOX	M.B
15	M.C.B.	M.C.B. +6'6"
16	FANCY LIGHT	+8'6"
17	HANGING LIGHT	ROOF



PROJECT TITLE :-
PROPOSED BUILDING AT PLOT
NO.-R-17-259, CHORDIA CITY,
JAIPUR

DRAWING TITLE :-
TYPICAL FLOOR
ELECTRIC PLAN

SPACE CONSULTANT
PLOT-A-173, JAGDAMBA NAGAR, HEERAPURA
POWER HOWER, JAIPUR (RAJ) 302024

DRN. BY		DATE	NORTH
APPD. BY		REVISION	
SCALE			