



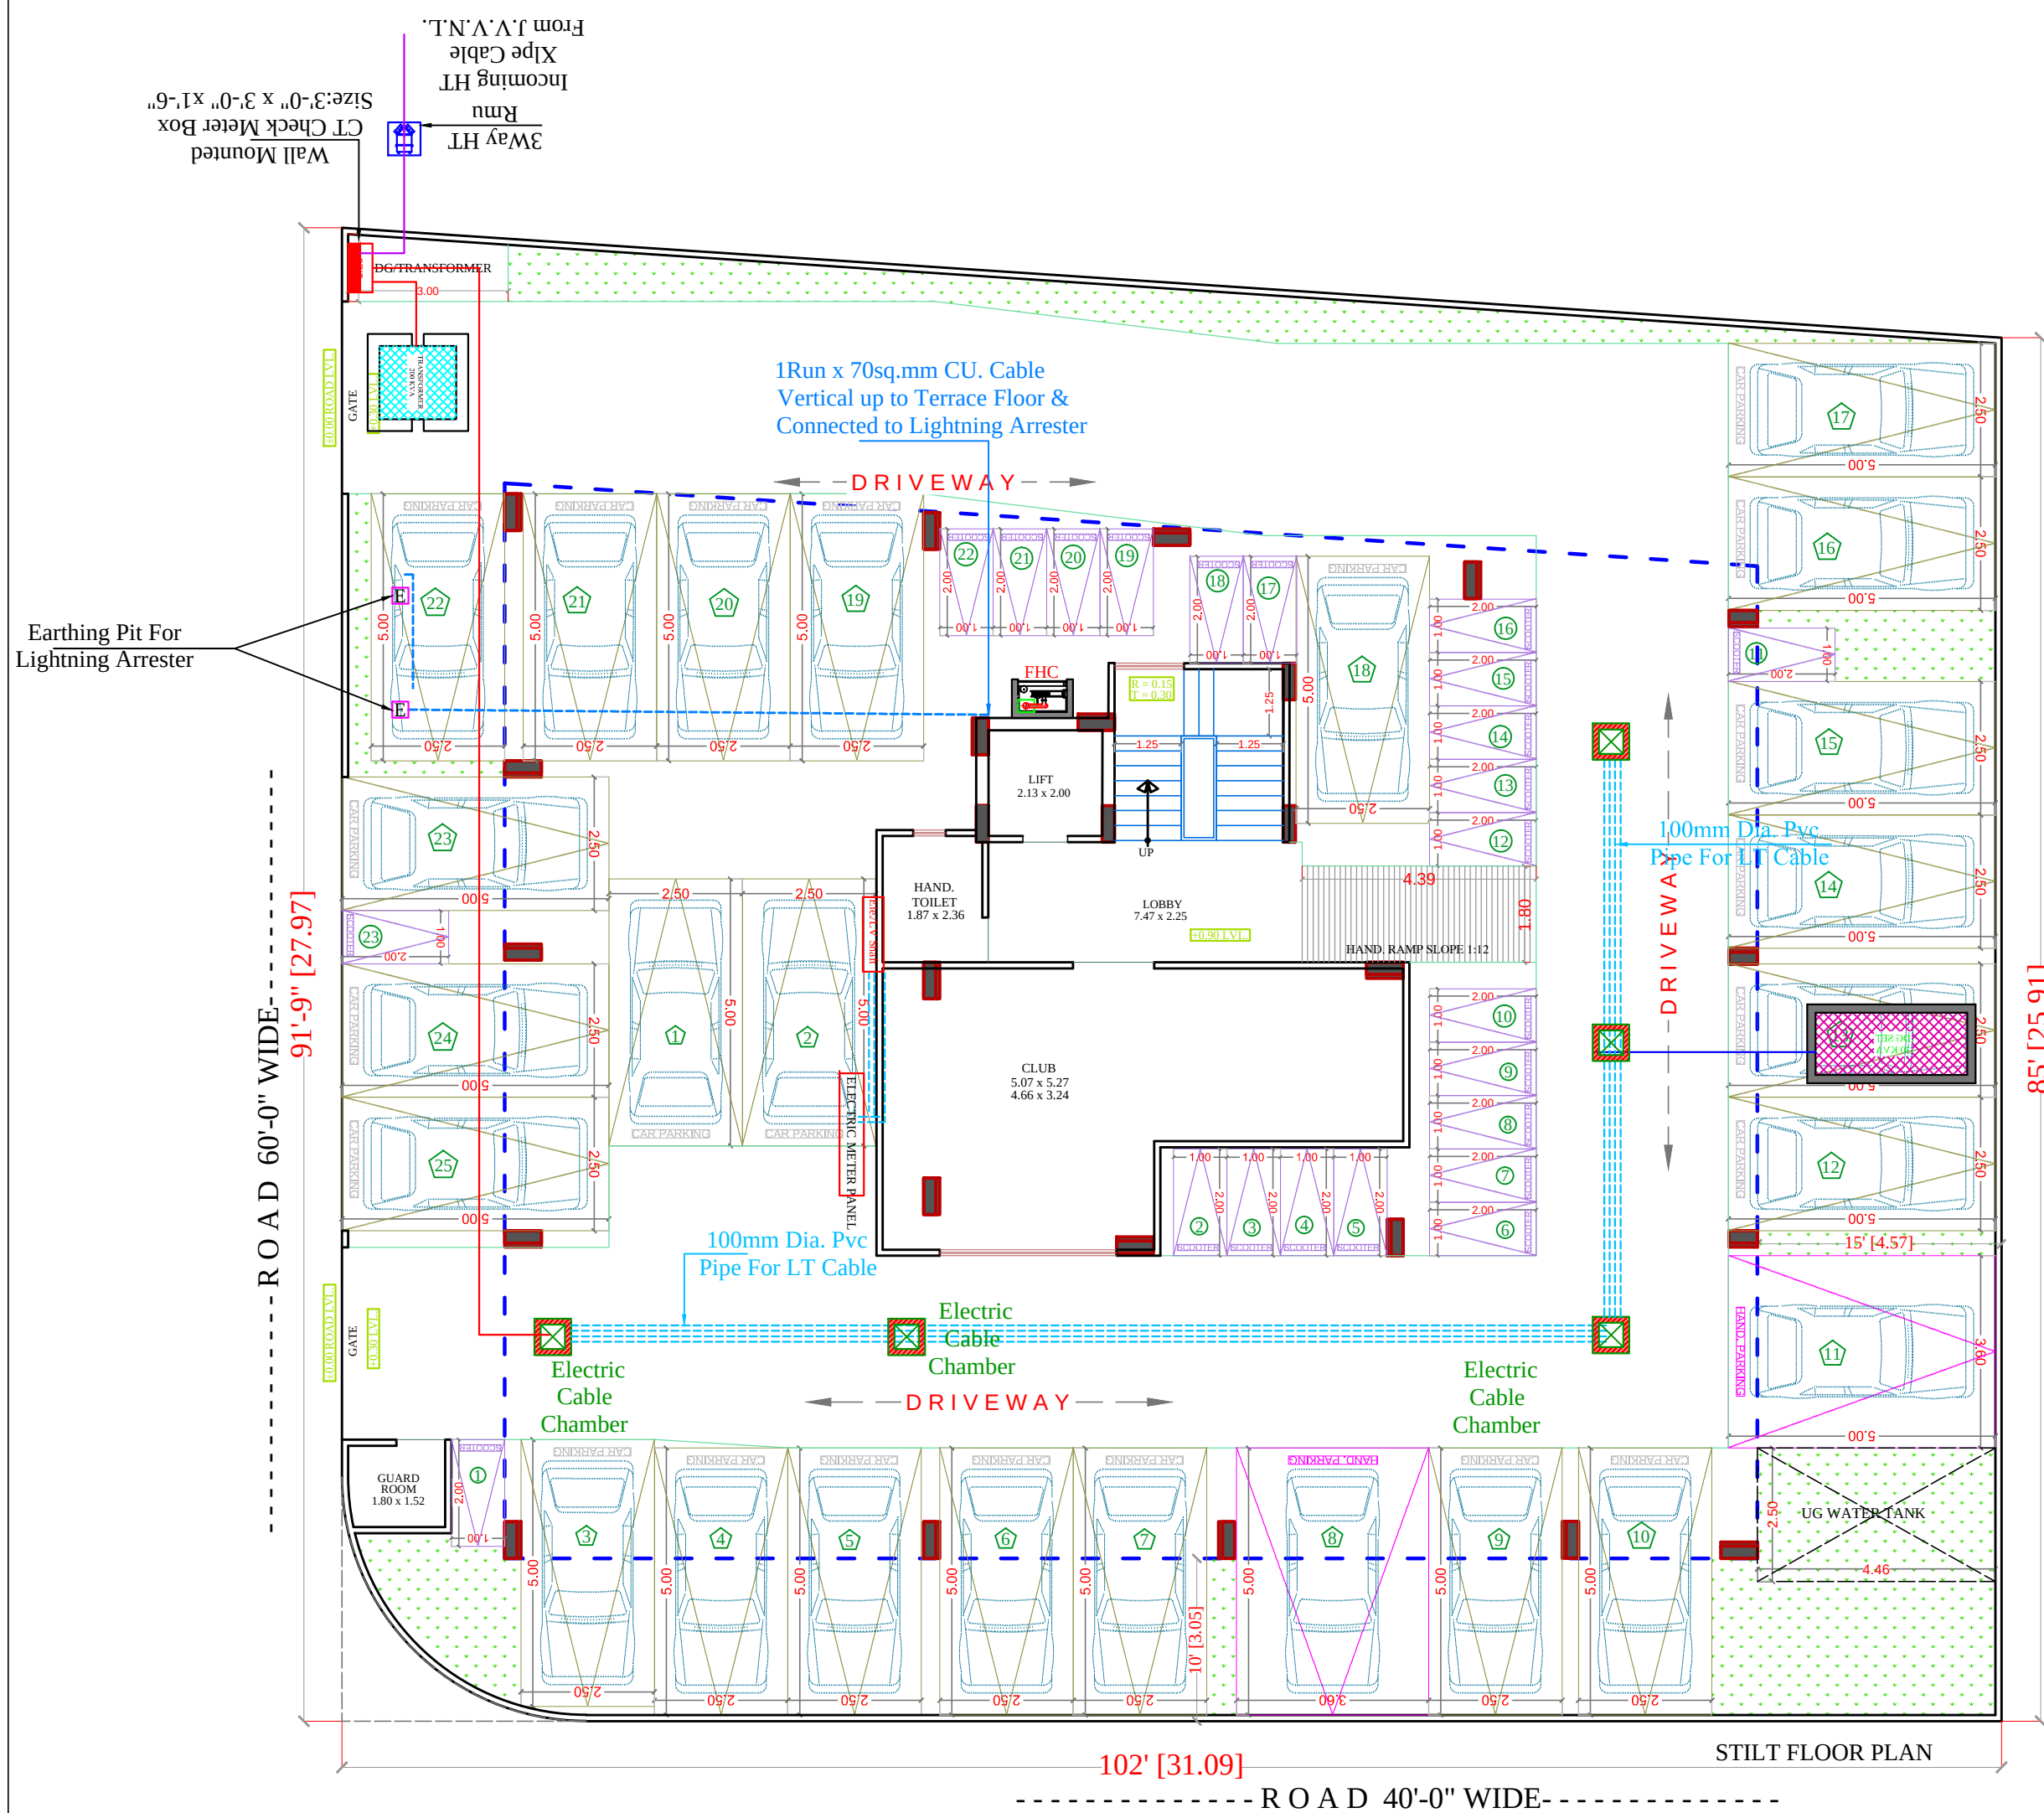

Lightning Arrester

Model: Stormaster – ESE - 30 (Level 2/Medium Protection)
(Protection radius - 25M, Mast Height -2 Mtr)

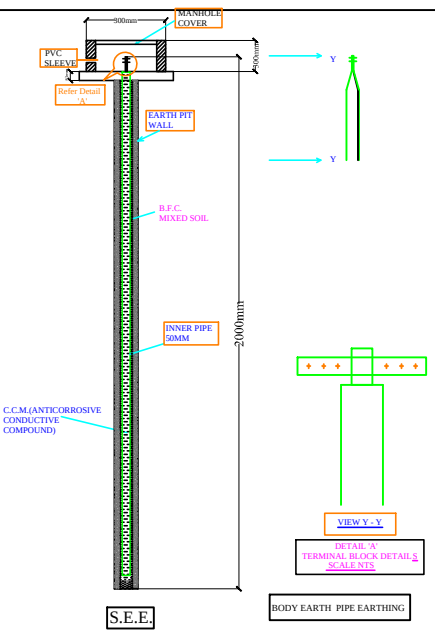


SIGN:-
SEAL:-
Space Consultant
S No 016180
B Tech (Civil)

SPACE CONSULTANT
PLOT-A-173, JAGDAMBA NAGAR, HEERAPURA
POWER HOWER, JAIPUR (RAJ) 302024

ARCHITECT :-
FRANK SQUARE
ARCHITECTURE | PLANNER | DESIGNER
C-49 VIDYA APARTMENT PARAS MARG,
BAPU NAGAR JAIPUR, (RAJ.)
Email-afranksquare@gmail.com
Mobile-9461302542

PROJECT :-
PROPOSED BUILDING AT PLOT NO.-A1 & A2, NARAYANPURI-A, JAIPUR
DRAWING:
STILT FLOOR
ELECTRIC SUB STATION,
CABLE ROUTE &
LIGHTNING ARRESTER FOR
RERA SUBMISSION PLAN

DATE
SCALE:- N.T.S.

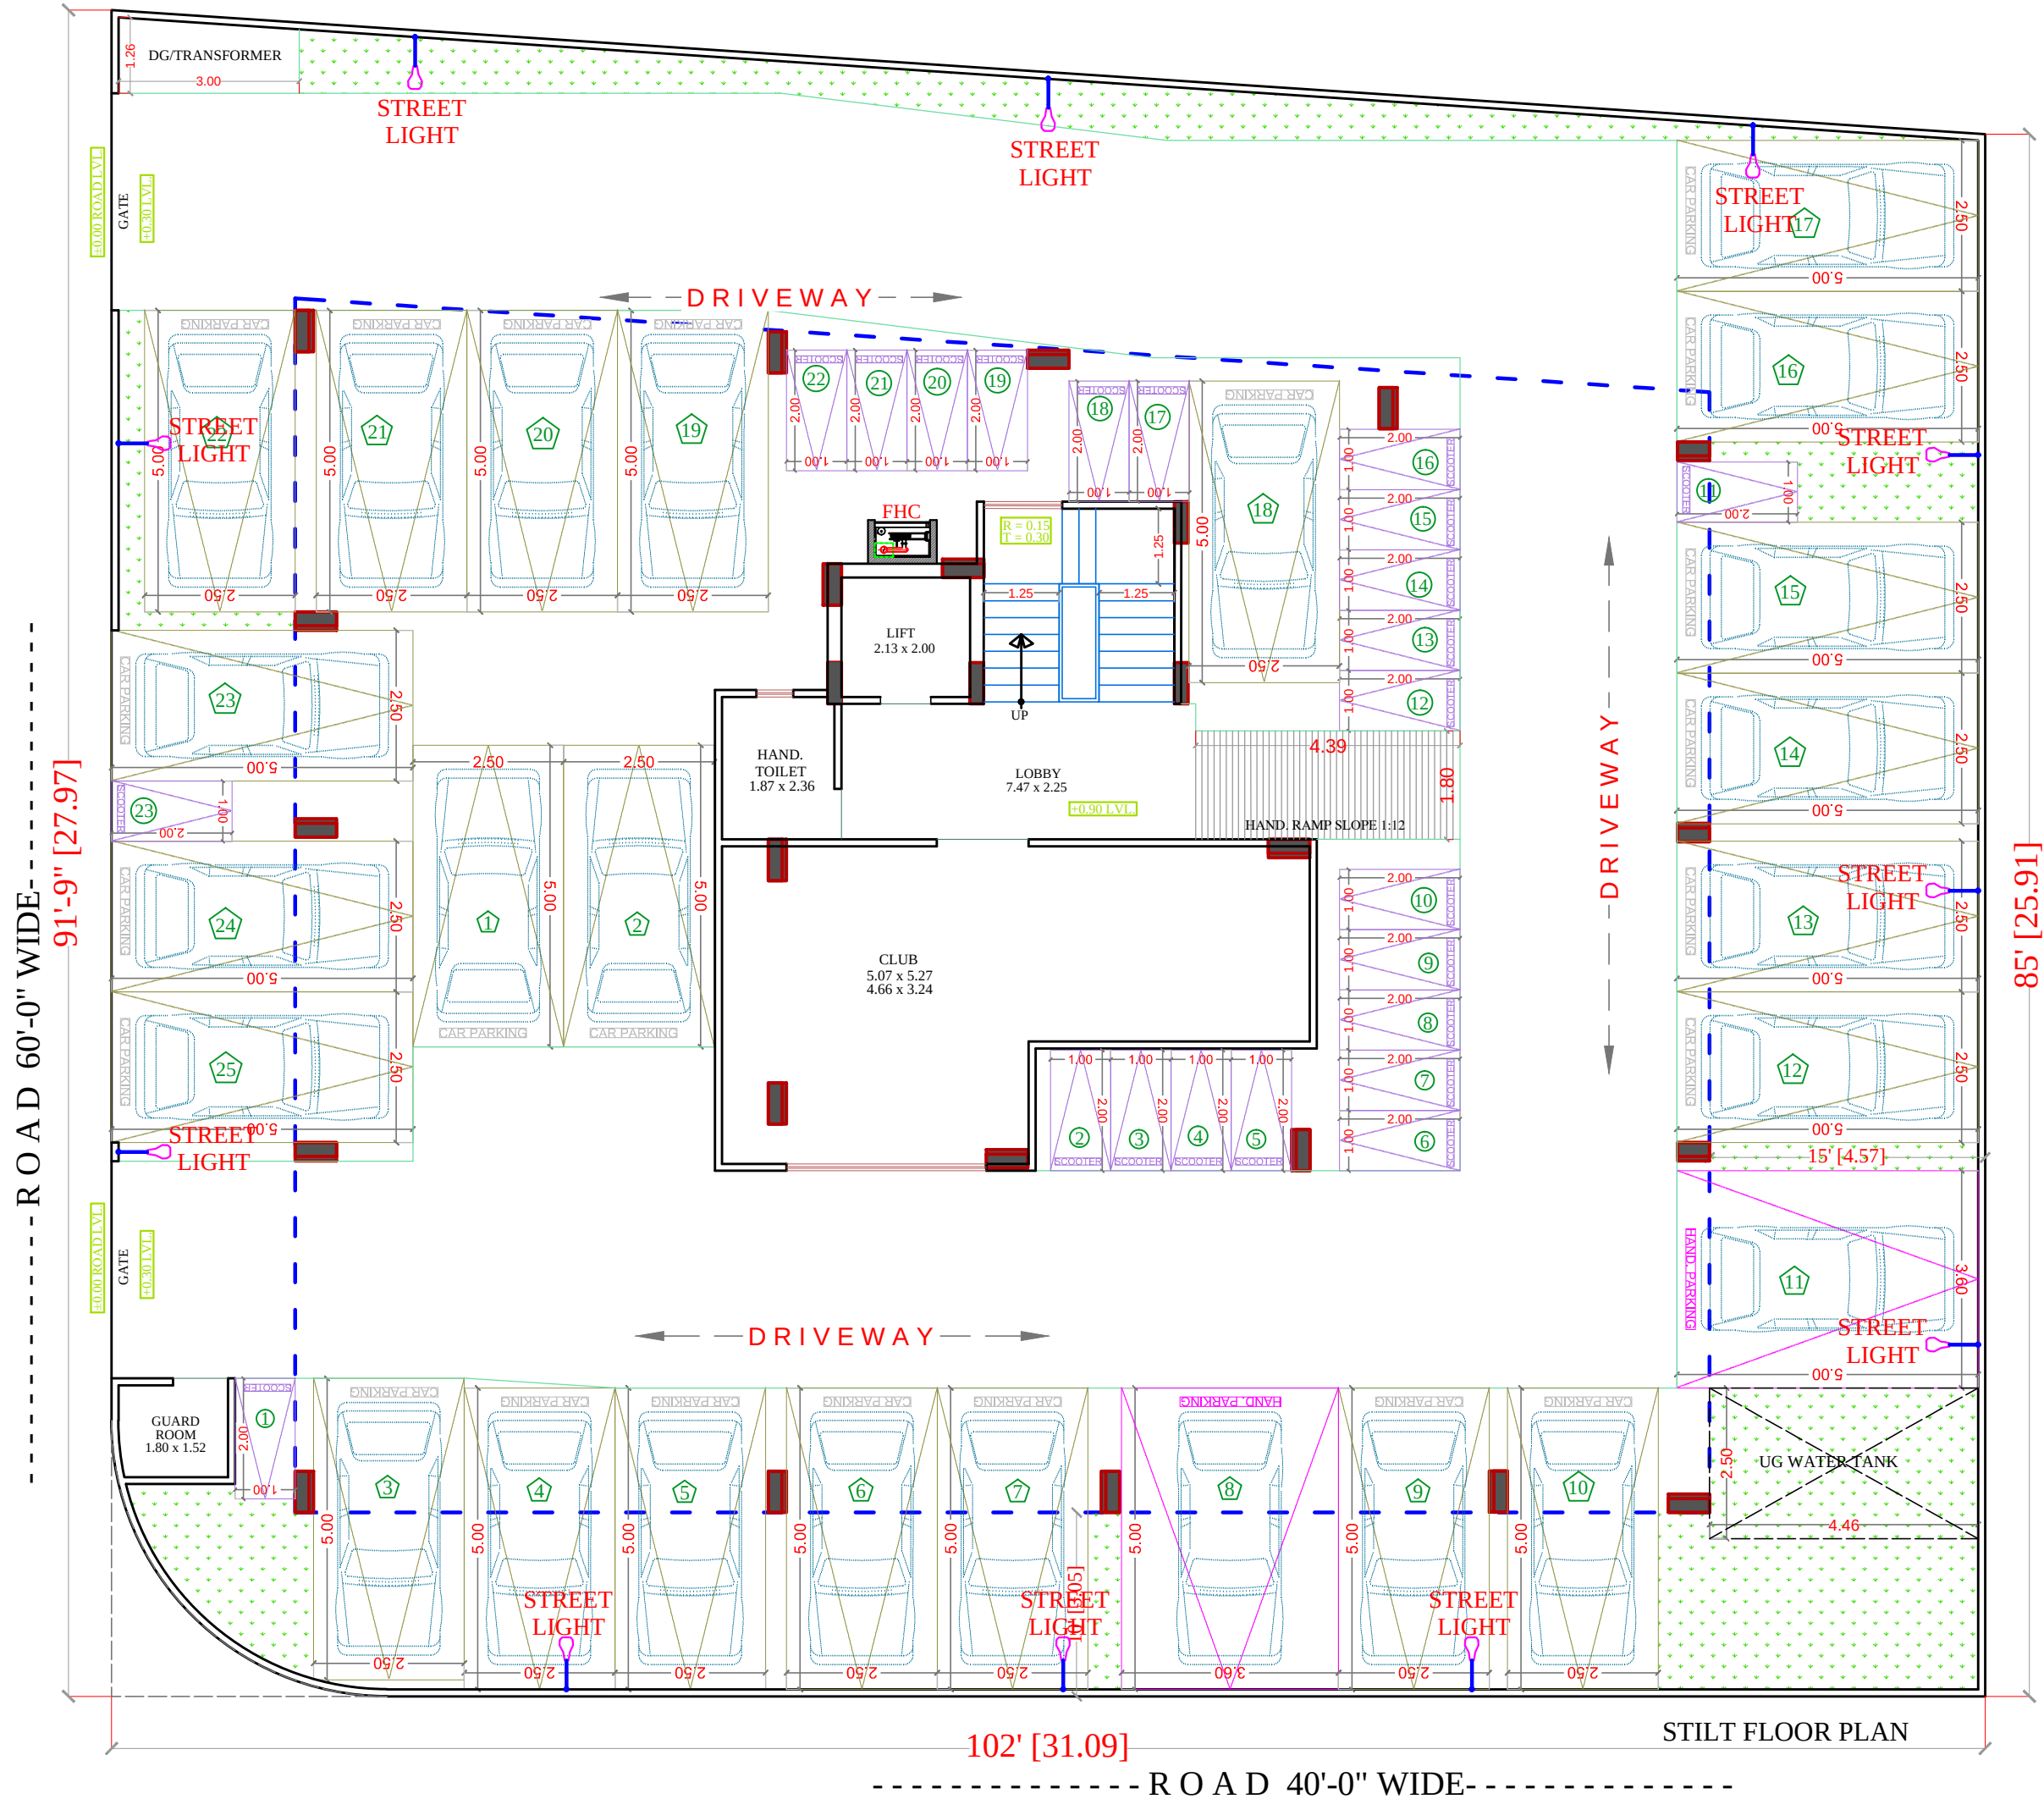

LEGENDS:

Qty.	I D	Symbol	Description
14	PL		STREET LIGHT

SIGN:- SEAL:-



SPACE CONSULTANT

PLOT-A-173, JAGDAMBA NAGAR, HEERAPURA
POWER HOWER, JAIPUR (RAJ) 302024

ARCHITECT :-

FRANK SQUARE

ARCHITECTURE | PLANNER | DESIGNER
C-49 VIDYA APARTMENT PARAS MARG,
BAPU NAGAR JAIPUR, (RAJ.)
Email-afranksquare@gmail.com
Mobile-9461302542


PROJECT :-

PROPOSED BUILDING AT PLOT
NO.-A1 & A2, NARAYANPURI-A,
JAIPUR

DRAWING:

STILT FLOOR
EXTERNAL STREET LIGHT
FOR RERA SUBMISSION PLAN

DATE	18-08-2023
SCALE:-	N.T.S.

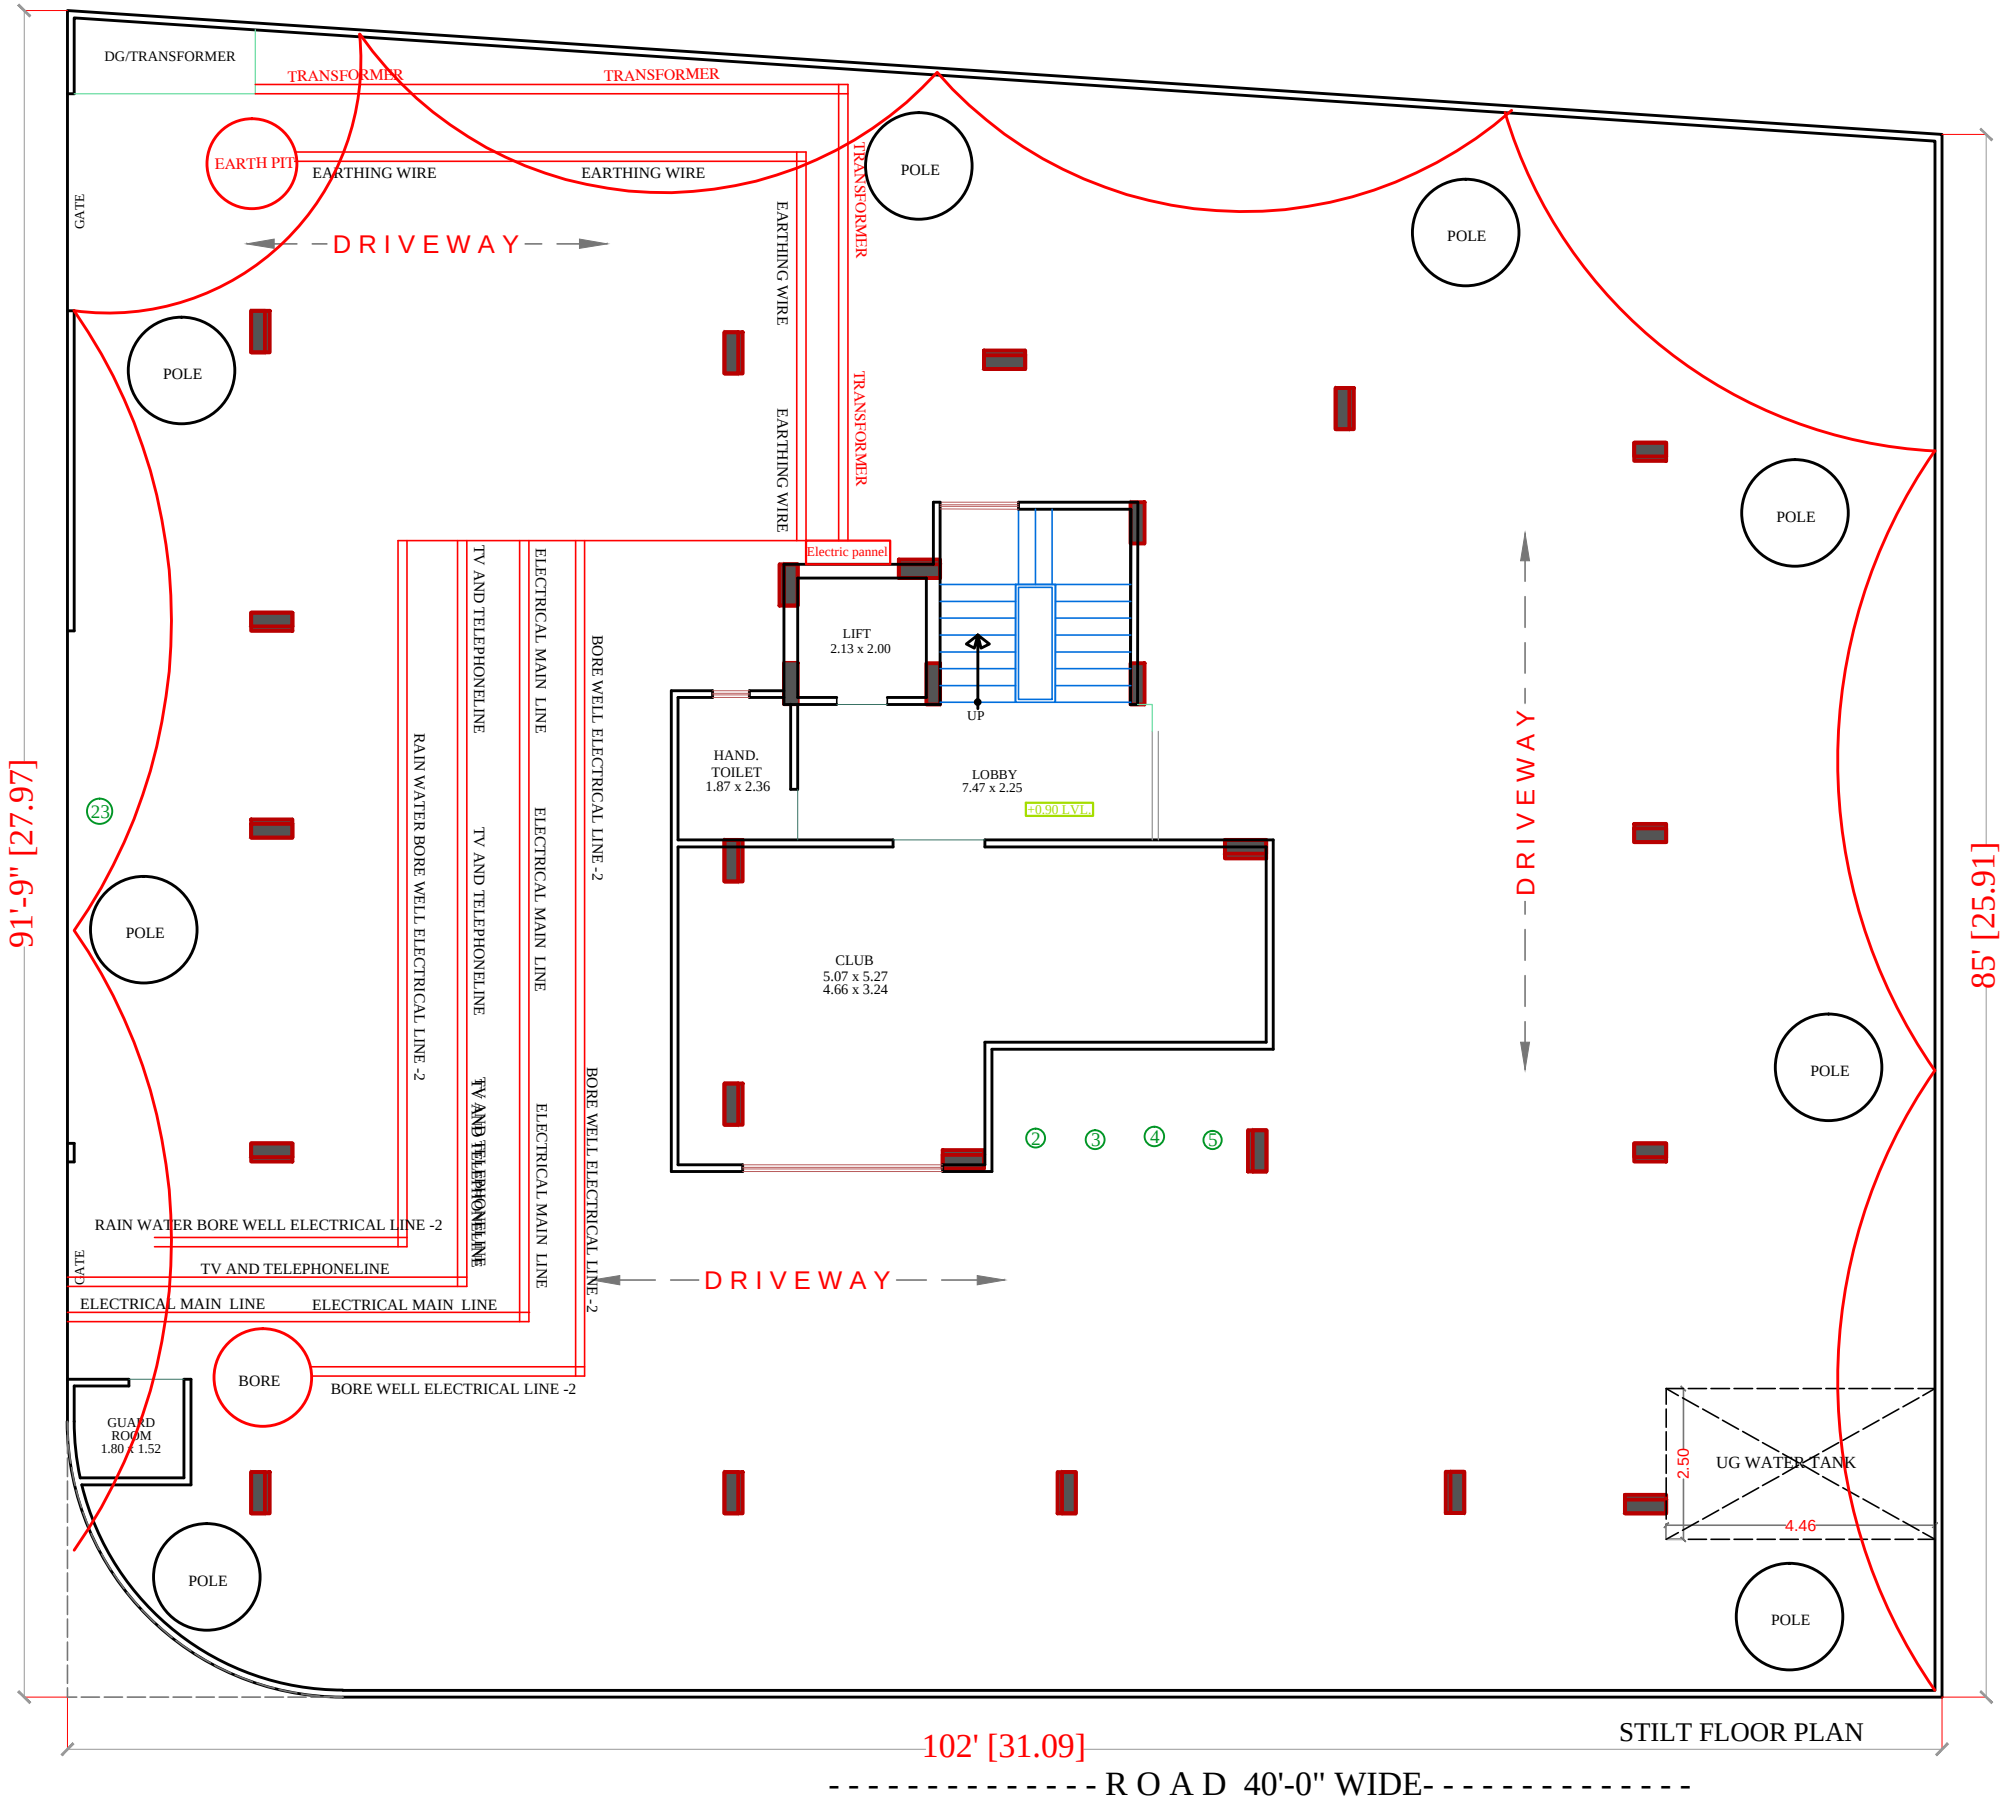

NO	ITEM	SYMBOL
1	CEILING FAN	ROOF
2	TUBE LIGHT	+8'6"
3	BULB	+8'6"
4	POWER POINT	+1'6"
5	BED POINT	+4'3"
6	CEILING LIGHT	ROOF
7	A.C.POINT	+6'6"
8	SWITCH BOARD	+4'3"
9	EXHAUST	VENT
10	TELEPHONE	+1'6"
11	GYSER	+6'0"
12	BELL POINT	+8'6"
13	T.V.	+1'6"
14	M.BOX	M.B
15	M.C.B.	M.C.B
16	FANCY LIGHT	+8'6"
17	HANGING LIGHT	ROOF

STILT (PARKING) FLOOR PLAN

PROJECT TITLE :-

PROPOSED BUILDING AT PLOT NO.-A1 & A2, NARAYANPURI-A, JAIPUR

DRAWING TITLE :-

SERVICE DRAWING SLD/DISTRIBUTION AFTER LT PANEL, EARTHING LAYOUT,EXTERNAL LIGHTING PLAN, TV & TELEPHONE RISER,LIGHTING ARRESTR, & PIT LOCATION COMMON AREA TRANSFORMER

SPACE CONSULTANT
PLOT-A-173, JAGDAMBA NAGAR, HEERAPURA
POWER HOWER, JAIPUR (RAJ) 302024

DRN. BY

APPD. BY

SCALE


DATE

REVISION

N.T.S

NORTH



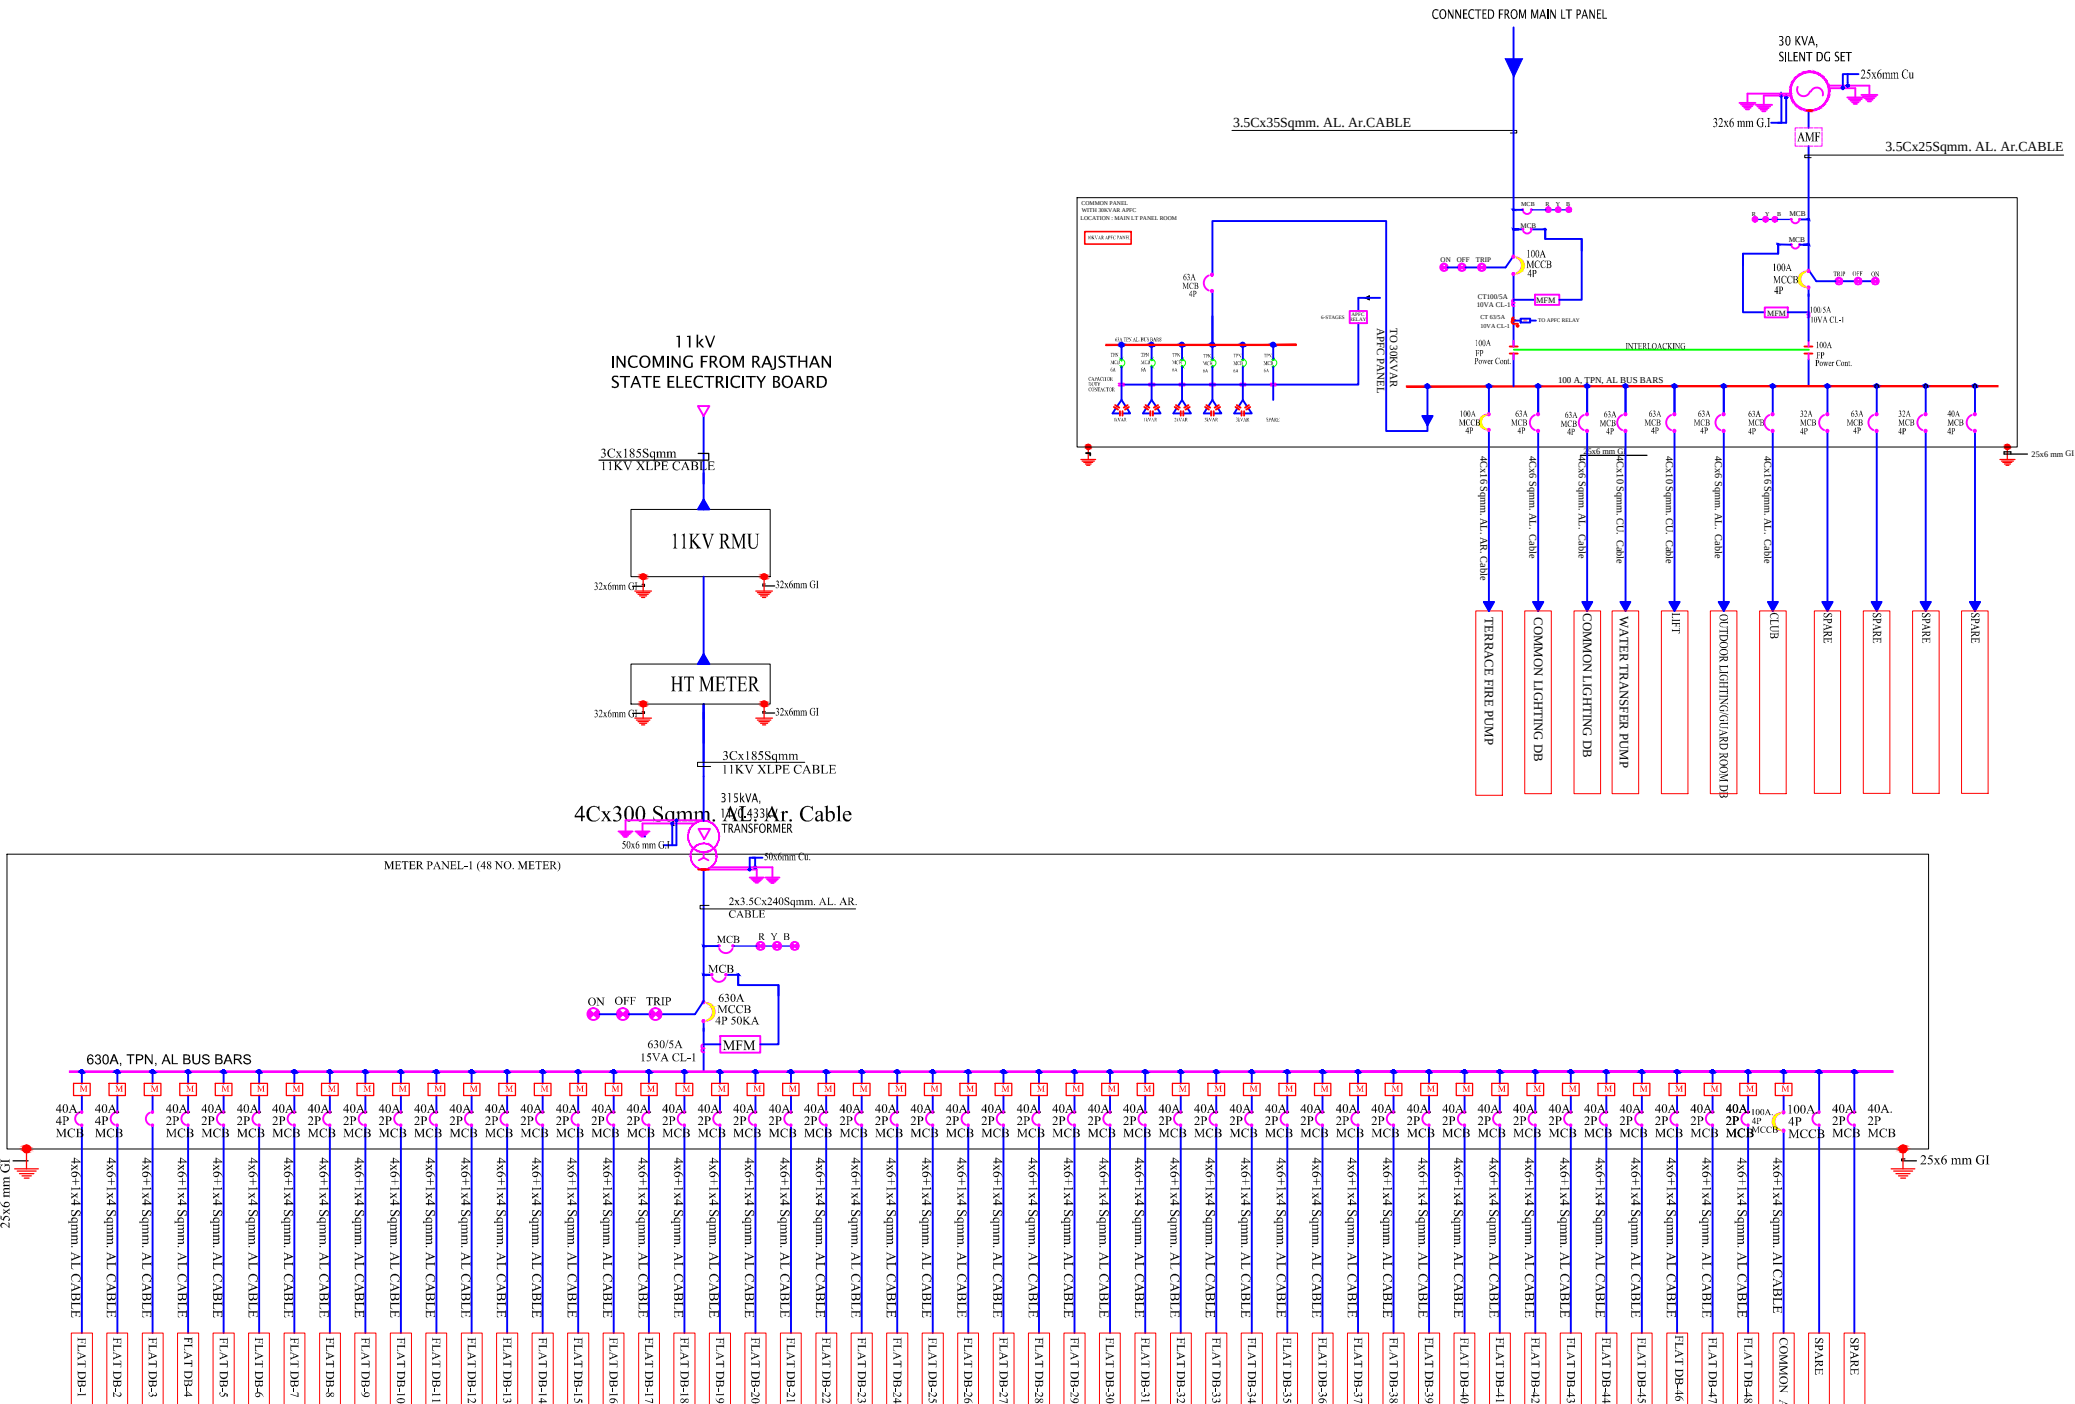

LEGEND	
SYMB.	DESCRIPTION
[A]	AMMETER
[V]	VOLT METER
[PF]	POWER FACTOR METER
[VA]	VOLTMETER, AMMETER, FREQUENCY METER
[F]	FREQUENCY METER
[KWH]	KILOWATT HOUR METER
[KW]	KILOWATT METER
[AS]	AMMETER SELECTOR SWITCH
[VS]	VOLTMETER SELECTOR SWITCH
[LR]	LOCKOUT RELAY
[STR]	SUPERVISORY TRIP RELAY
[UV]	UNDER VOLTAGE DEVICE
[OV]	OVER VOLTAGE DEVICE
[RPS]	REVERSE POWER PHASE DEVICE
[DPR]	DIFFERENTIAL PROTECTION RELAY
[OCB]	OVER CURRENT & EARTH FAULT RELAY
[MFR]	MULTI FUNCTION RELEY
[EDG]	ELECTRICAL OPERATED MANUALLY DRAWOUT
[CF]	CONTROL FUSE
[CT]	CURRENT TRANSFORMER
[TVM]	TRIVECTOR METER
[IL]	INDICATING LAMP
[OLR]	OVER LOAD RELAY
[PC]	POWER CONTACTOR
[PT]	POTENTIAL TRANSFORMER
[DSE]	DUAL SOURCE ELECTRONIC ENERGY METER
[GND]	GROUNDING
[MPR]	MICRO PROCESSOR BASED RELEASE
[MEM]	ELECTRONIC ENERGY METER
[ACB]	AIR CIRCUIT BREAKER
[VCB]	VACUUM CIRCUIT BREAKER
[MCB]	MINIATURE CIRCUIT BREAKER
[MCCB]	MOULDED CASE CIRCUIT BREAKER
[MPCB]	MOTOR PROTECTION CIRCUIT BREAKER

REVISION - 00

GENERAL NOTES :

1. ALL THE DIMENSIONS ON THE DRAWING ARE IN WRITTEN.

2. ONLY WRITTEN DIMENSIONS ARE TO BE FOLLOWED, DRAWING SHOULD NOT BE SCALED IN ANY CIRCUMSTANCES.

3. ALL MEASUREMENTS MUST BE CHECKED AND VERIFIED BY THE CONTRACTORS PRIOR TO EXECUTION OF WORK AT THE SITE.

4. THIS DRAWING IS TO BE READ IN CONJUNCTION WITH ALL RELEVANT STRUCTURAL, ARCHITECTURAL & FACILITY PLANNING DRAWINGS.

5. ANY DISCREPANCIES MUST BE BROUGHT TO THE NOTICE OF THE ENGINEER IMMEDIATELY & PRIOR TO EXECUTION AT SITE.

6. CO-ORDINATION WITH SERVICES SUCH AS HVAC, PLUMBING & ELECTRICAL, ETC. IS THE RESPONSIBILITY OF THE CONTRACTORS.

7. FOR DETAILS, REFER RELEVANT LARGE SCALE DETAIL DRGS. AS INDICATED.

LIGHTING LEGEND

SR.NO.	SYMBOL	DESCRIPTION	HEIGHT FROM FFL
1		CEILING TUBELIGHT POINT	CEILING
2		LED CEILING LIGHT POINT	CEILING
3		LED WALL BRACKET LIGHT POINT AT WALL	+7'-4"
4		6A SOCKET WITH SWITCH	+2'-0"
5		GENERAL POINT 16A SOCKET WITH SWITCH	+2'-0"
6		MDF BOX	+5'-0"
7		CEILING ROSE	+7'-0"
8		SWITCH BOARD	+4'-0"
9		EXHAUST FAN	VENT. HT.
10		LIGHT & POWER DISTRIBUTION BOARD	+5'-1"
11		Ø25MM POINT CONDUIT	CEILING
12		Ø25MM POWER CIRCUIT CONDUIT	CEILING FLOORING
13		Ø25MM LIGHT CIRCUIT CONDUIT	CEILING FLOORING
14		CEILING FAN	CEILING

ARCHITECT

ARCHITECT :-

FRANK SQUARE

ARCHITECTURE | PLANNER | DESIGNER
C-49 VIDYA APARTMENT PARAS MARG,
BAPU NAGAR JAIPUR, (RAJ.)
Email-afranksquare@gmail.com
Mobile-9461302542

PROJECT :-

PROPOSED BUILDING AT PLOT NO.-A1 & A2, NARAYANPURI-A, JAIPUR

BUILDER/DEVELOPER/CLIENT:-

DRAWING TITLE:-

MAIN PANEL SLD

SUBMITTED FOR :-


PRELIMINARY	☐	APPROVAL	☐
PROPOSAL	☐	FOR RERA	☒
DATE :-			NORTH :-
DRAWN :-			
APPROVED :-			
DRAWING NO.:-			SCALE :-

CONSULTANT

AMP INFRA SERVICES

VILLA NO 16. SHUBHASIS GEETA
JAISINGHPURA, BHANKROTA &
CHIMANPURA.JAIPUR 302026
EMAIL ID- ampinfrajpr@gmail.com
CONTACT NO. :- 9462866389

RAMESH KUMAWAT
M.E.P. CONSULTANT
B.E. CIVIL

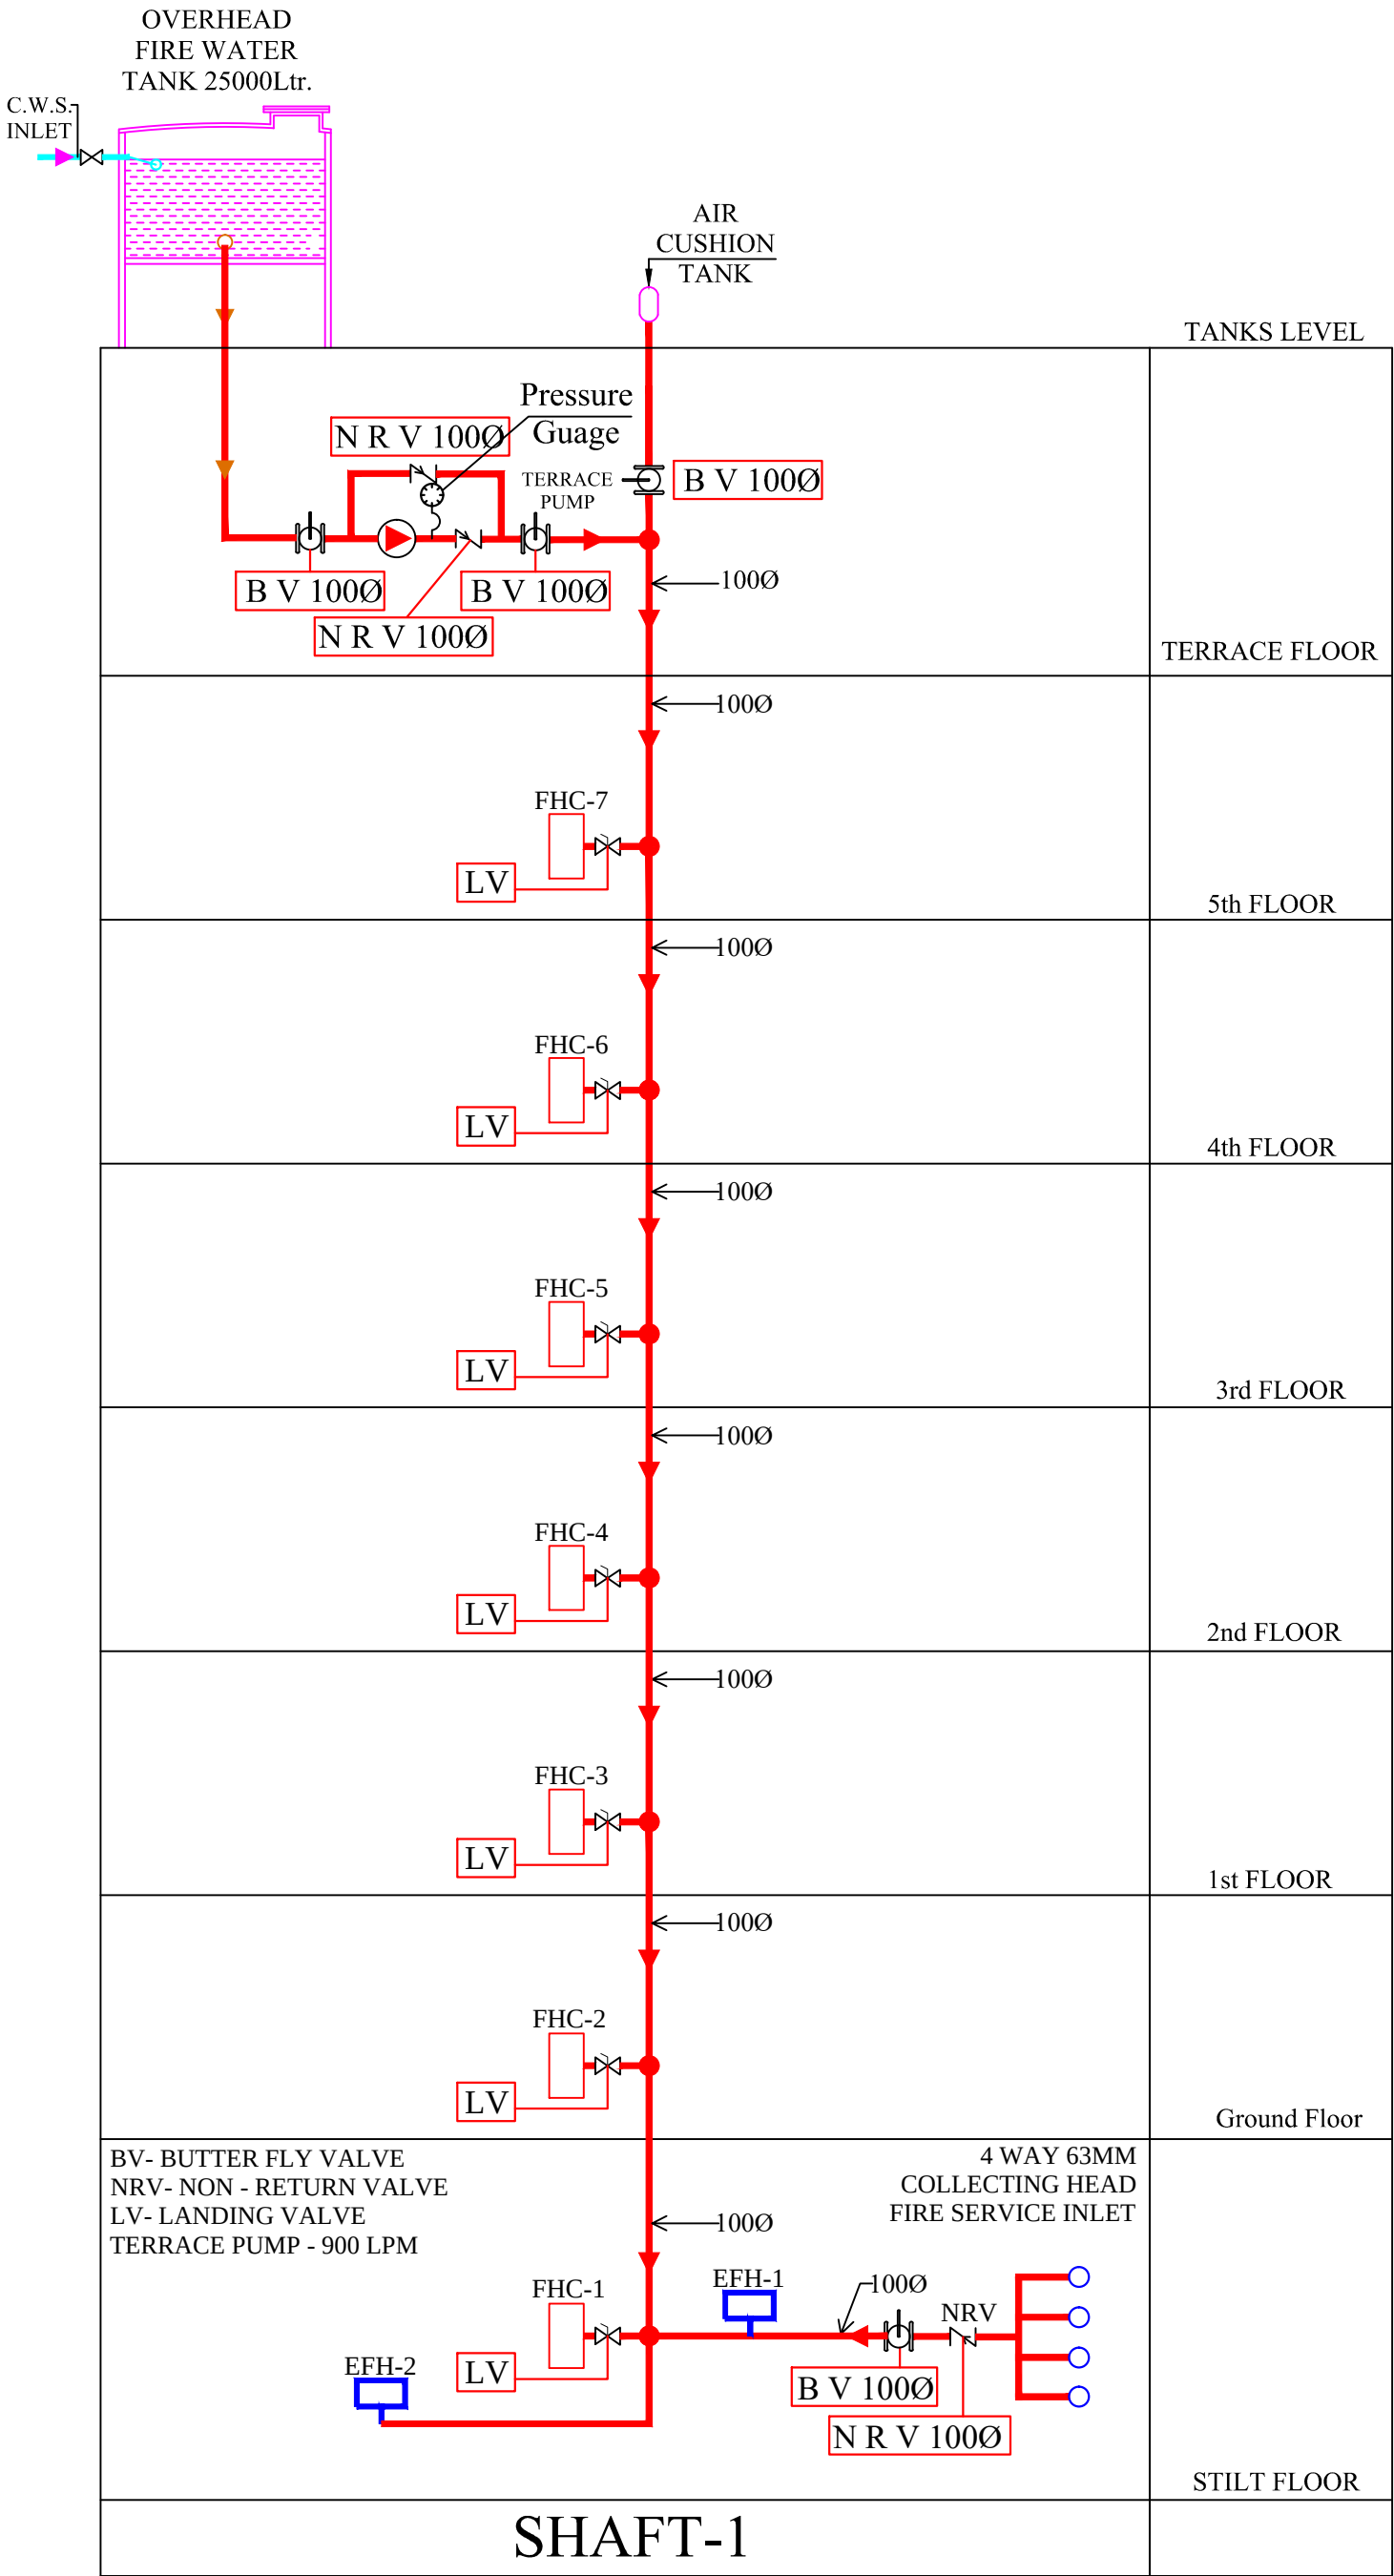

750

SHORT BRANCH PIPE

800 M.S. PIPE

M.S. PLATE

P.C.C. BLOCK

GROUND LEVEL

800 M.S. PIPE

SINGLE HEADED GUNMETAL LANDING VALVE

THURST BLOCK AS PER DETAIL

EXTERNAL FIRE HOSE CABINET (N.T.S.)

EXTERNAL FIRE HYDRANT (N.T.S.)

FIXING HOOK WITH HOLE FOR 18mm FASTENER

KEY BOX WITH GLASS

BACK BOX WITH GLASS

BACK BOX 2 Nos. 600x150 M HOSE REEL

LOCKING DEVICE

3 mm CLEAR GLASS

600

750

550

TYPICAL DETAIL OF EXTERNAL FIRE HOSE CABINET (N.T.S.)

TYPICAL DETAIL OF EXTERNAL FIRE HYDRANT (N.T.S.)

NON RETURN VALVE

SLUICE VALVE

GROUND LEVEL

ELEVATION - BB

4-WAY FIRE BRIGADE INLET CONNECTION

100MM 5 TIE PIPE AS PER SITE

ELEVATION

FRONT VIEW

DETAIL OF FIRE HYDRANT CABINET

PLAN

DRAWING:

TYPICAL DETAIL FOR FIRE HOSE CABINET-1

SCALE:-NTS

FHC-1

S.no.	Symbol	Description	Qty.	Size in mm
1.		Butter fly Valve	04	100Ø
2.		Non Return Valve	03	100Ø
3.		Landing Valve Single headed	09	63Ø
4.		Pressure Guage	01	
5.		FHC	07	
6.		External Fire Hose Cabinet	02	

SIGN:-

SEAL:-

24/21

Space Consultant

S No. 016180

P. J. B. Tech. (Civil)

SPACE CONSULTANT

PLOT-A-173, JAGDAMBA NAGAR, HEERAPURA
POWER HOWER, JAIPUR (RAJ) 302024

PROJECT :-

PROPOSED BUILDING AT PLOT
NO.-A1 & A2, NARAYANPURI-A,
JAIPUR

DRAWING:-

FIRE SCHEMATIC LAYOUT