


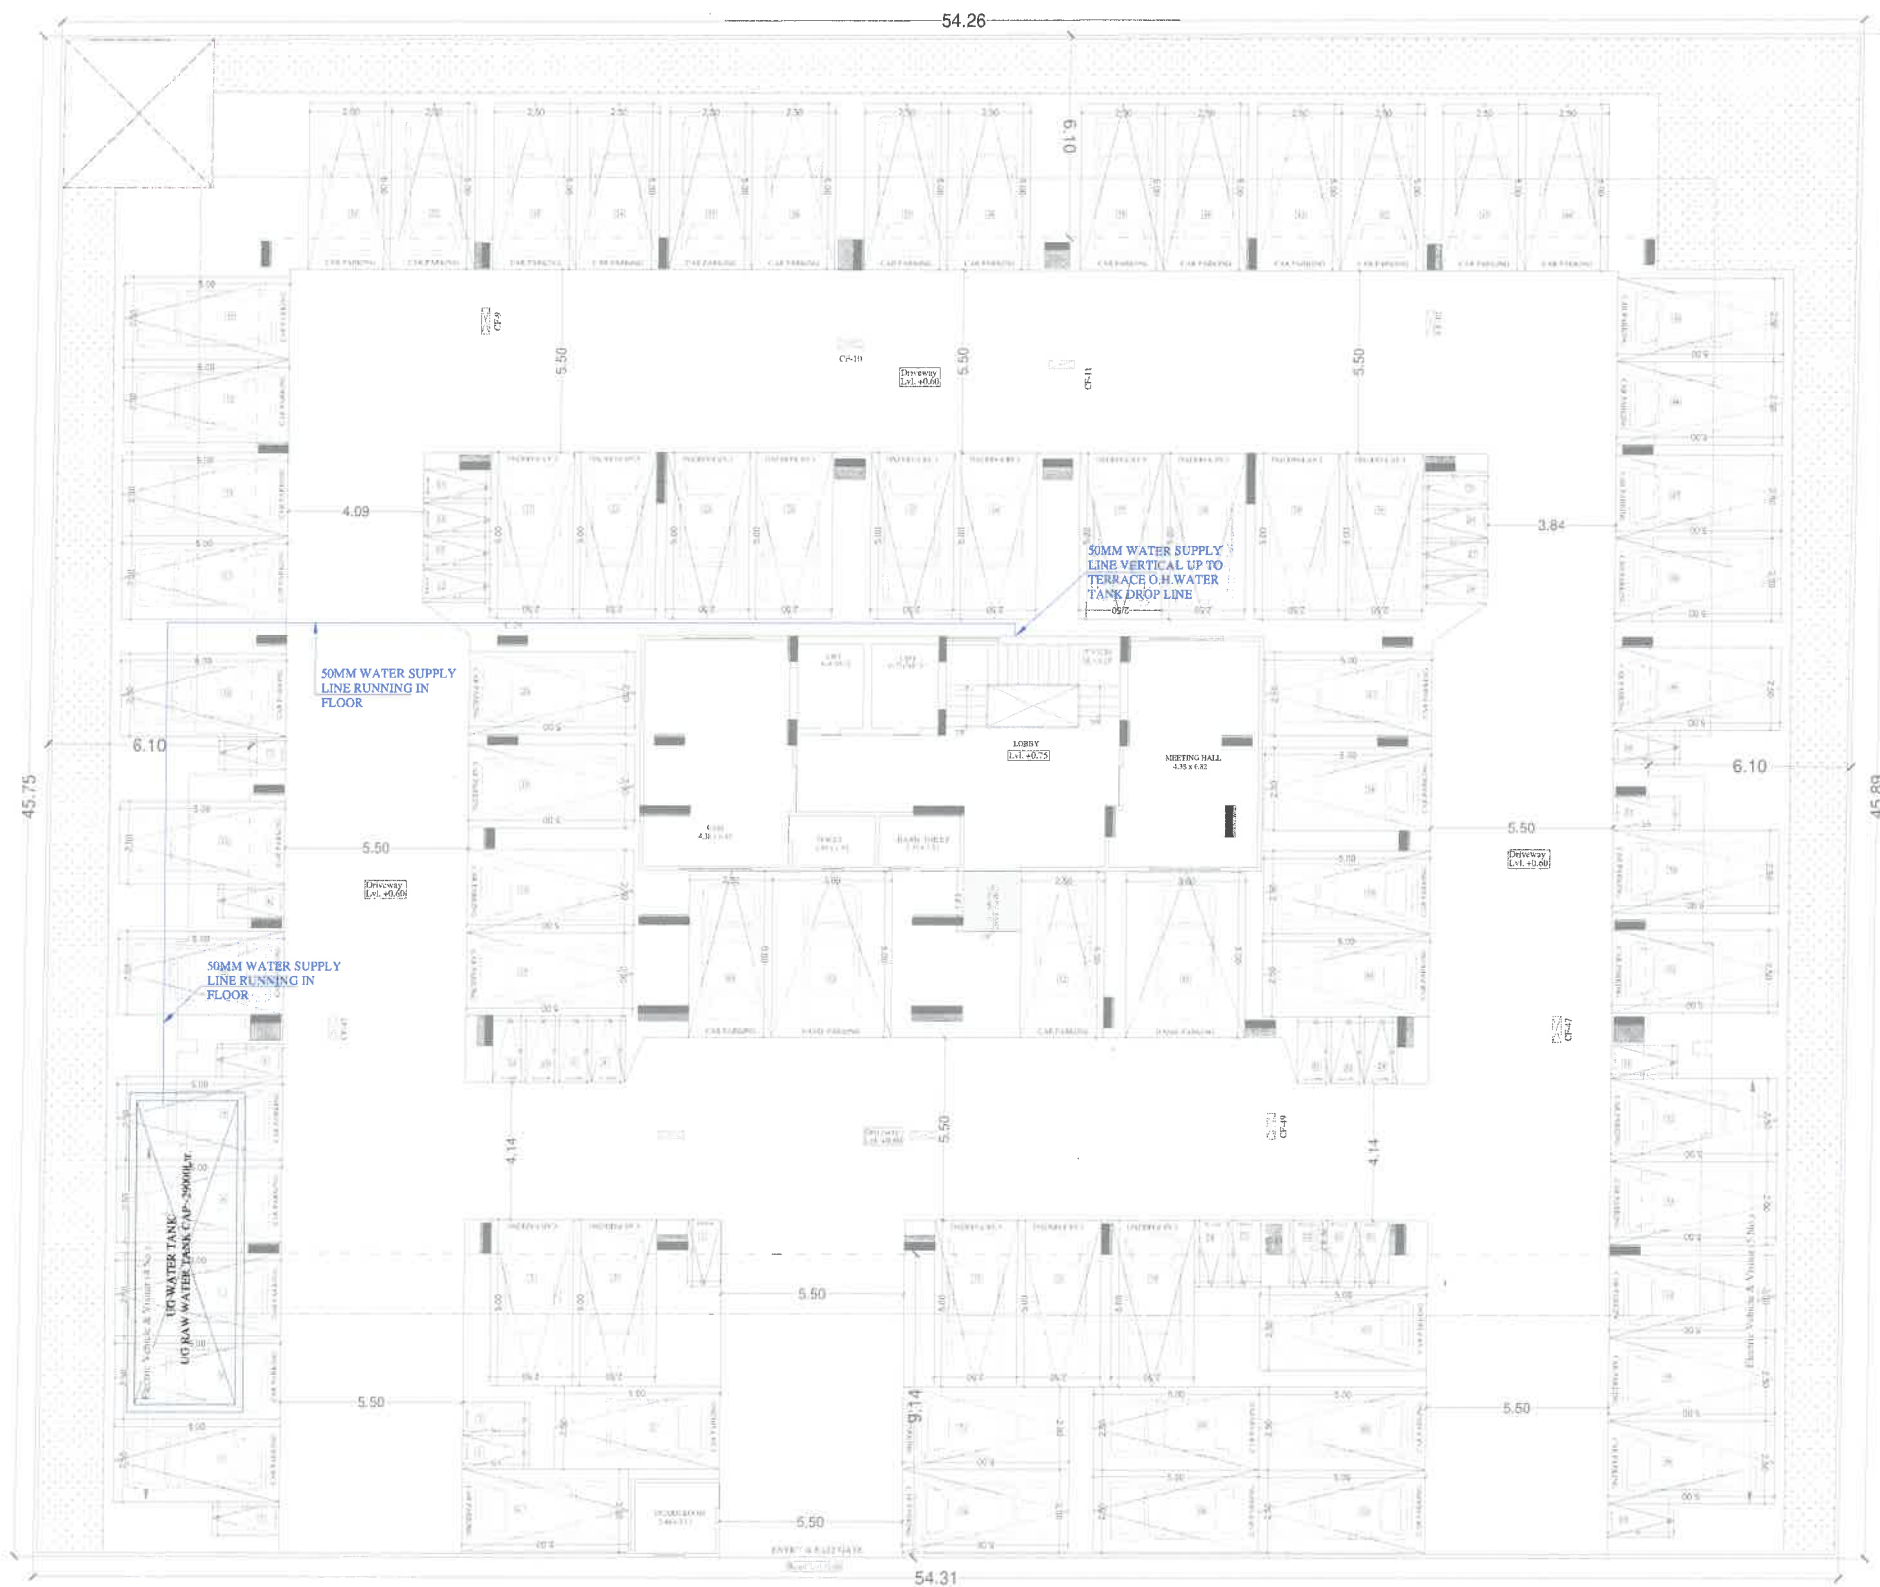

Shree Vinayak Builders
Banwala
 partners

Vipul
VIPUL AGARWAL
 M.E.P. CONSULTANT
 B.E. ELECTRICAL

SERVICE CONSULTANT

ASHI ASSOCIATES


F 9 / 440 , Keshav Marg Chitrakut Scheme, Jaipur
 PH:91-0-93146-10438 ,0141-2440946, Mail: vipul8599@yahoo.com

ARCHITECTS:

SPACE GRID

C-49, VIDYA APARTMENT, PARAS
 MARG, BAPU NAGAR, NEAR JANTA
 STORE CIRCLE, JAIPUR-302015
 PH-09314918766,0141-4005506 (O)
 Email:-info.spacegrid@gmail.com

STILT PLAN

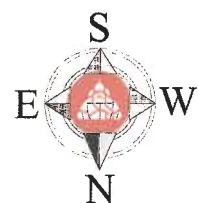

PROJECT NAME:

NAKSHATRA

PROMOTER:

SHREE VINAYAK BUILDERS

DRAWING:

UGWT TO OHT FILLING LINE ROUTE PLAN

PROJECT:

KHASRA NO. 398/10 AT VILLAGE
 MOHANPURA, TEHSIL- SANGANER, JAIPUR

DRN. BY:

vinod kumawat

SCALE:


N.T.S.

APPD. BY:


Shri Krishan Sharma

DATE:

SHRI KRISHAN
Architect
 CA/99/25451

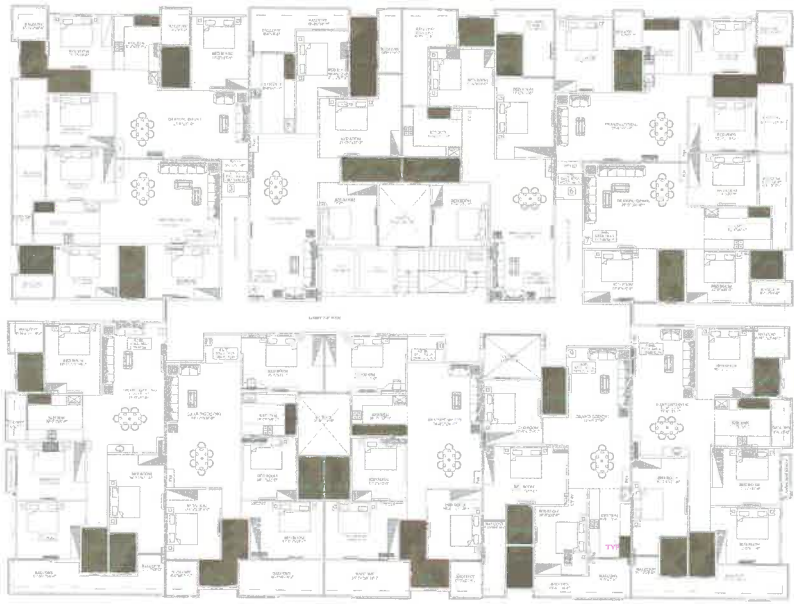

KEY PLAN

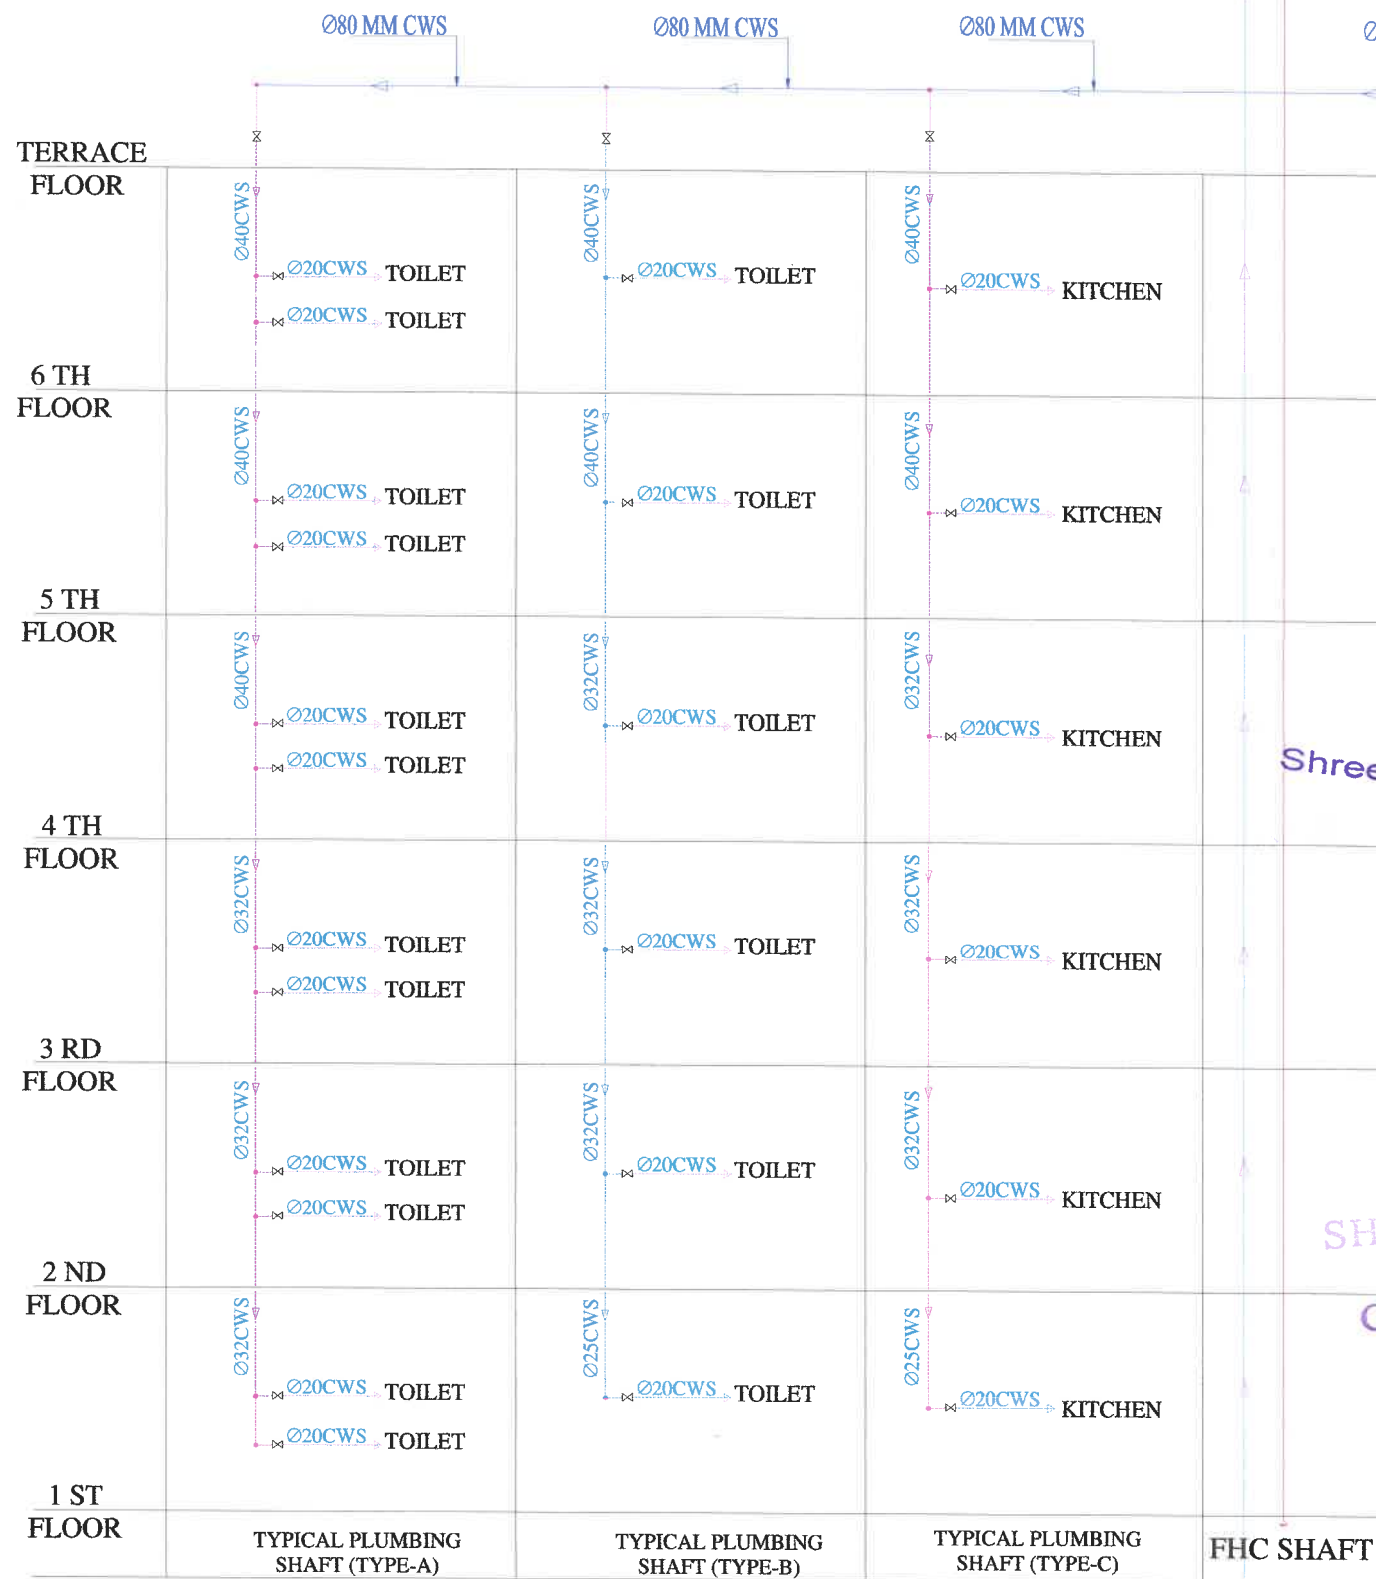

50MM DIA OVER HEAD RAW
WATER TANK FILLING LINE

AUTO.AIR
VENT

FLOAT SWITCH-2 AT 10% TANK FULL
FLOAT SWITCH-1 AT 100% TANK FULL

FIRE WATER TANK

RAW
WATER
TANK

MUMTY LVL.
25ØRAIN OUT PIPE
WITH GATE VALVE

FIRE HYDRANT PIPE WITH
GATE VALVE DROP TO FHC

80Ø GRAVITY COLD
WATER SUPPLY RING PIPE
WITH GATE VALVE

Shree Vinayak Builders
Partners

VIPUL AGARWAL
M.E.P. CONSULTANT
B.E. ELECTRICAL

SERVICES CONSULTANT:
ASHI ASSOCIATES

F 9 / 440 , Keshav Marg Chitrakut Scheme,Jaipur
PH:91-0-93146-10438 ,0141-2440946 Mail:vipul8599@yahoo.com

ARCHITECTS:-

SPACE GRID

C-19, VIDYA APARTMENT, PARAS MARG,
BAPU NAGAR, NEAR JANTA STORE
CIRCLE, JAIPUR-302015
PH-09314918766,0141-4005506 (O)
Email:-info.spacegrid@gmail.com

PROJECT NAME:

NAKSHATRA

PROMOTER:

SHREE VINAYAK BUILDERS

PROJECT

KHASRA NO. 398/10 AT VILLAGE
MOHANPURA, TEHSIL- SANGANER,
JAIPUR

DRAWING:-

WATER SUPPLY SCHEMATIC
DIAGRAM



Shree Vinayak Builders
Bhavin
Partners


Vipul
VIPUL AGARWAL
M.E.P. CONSULTANT
B.E. ELECTRICAL

All Heights For Finish Floor Lvl	SYMBOL	SYMBOL	DESCRIPTION
+1000MM			Ø 20MM CWS PIPE THRU WALL CHASE TO SINK
			Ø 20MM HWS PIPE THRU WALL CHASE TO SINK
+1950MM			Ø 20MM CWS PIPE THRU WALL CHASE TO GEYSER
			Ø 20MM HWS PIPE THRU WALL CHASE FROM GEYSER
+1500MM			Ø 20MM CWS PIPE THRU WALL CHASE TO AQUAGUARD
+800MM			Ø 20MM CWS PIPE THRU WALL CHASE TO WASH BASIN MIXER
+450MM			Ø 20MM CWS PIPE THRU WALL CHASE TO BASIN ANGLE VALVE
+450MM			Ø 20MM CWS PIPE THRU WALL CHASE TO BASIN ANGLE VALVE
+800MM			Ø 20MM HWS PIPE THRU WALL CHASE TO BASIN ANGLE VALVE
+2100MM			Ø 20MM CWS PIPE THRU WALL CHASE TO CONCEALED STOP COCK
+1000MM WALL MIXER DIVERTOR			Ø 20MM CWS PIPE THRU WALL CHASE TO WALL MIXER / DIVERTOR
+2025MM O.H. SHOWER			Ø 20MM HWS PIPE THRU WALL CHASE TO WALL MIXER / DIVERTOR
+300MM			Ø 20MM CWS PIPE THRU WALL CHASE TO FAUCET
+450MM			Ø 20MM CWS PIPE THRU WALL CHASE TO CISTERN ANGLE VALVE
+1200MM			Ø 20MM CWS PIPE THRU WALL CHASE TO URINAL ANGLE VALVE
+900MM			Ø 20MM CWS PIPE THRU WALL CHASE TO TAP FOR AUTOCLAVE
			COLD WATER SUPPLY LINE

SERVICE CONSULTANT

ASHI ASSOCIATES

F 9 / 440 , Keshav Marg Chitrakut Scheme, Jaipur
PH: 91-0-93146-10438 , 0141-2440946, Mail: vipul8599@yahoo.com

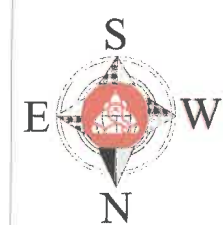


PROJECT NAME:
NAKSHATRA
PROMOTER:
SHREE VINAYAK BUILDERS

DRAWING:
1ST FLOOR INTERNAL PLUMBING PLAN
PROJECT ADDRESS :
KHASRA NO. 398/10 AT VILLAGE MOHANPURA, TEHSIL- SANGANER, JAIPUR

DRN. BY:
SNEHA
SCALE:
N.T.S.

APPD. BY:
SANJAY
DATE:
22-05-2025

ARCHITECTS:
SHR KRISHAN Architect CA/99/25451
SPACE GRID
C-49, VIDYA APARTMENT, PARAS MARG, BAPU NAGAR, NEAR JANTA STORE CIRCLE, JAIPUR-302015
PH-09314918766, 0141-4005506 (O)
Email: info.spacegrid@gmail.com

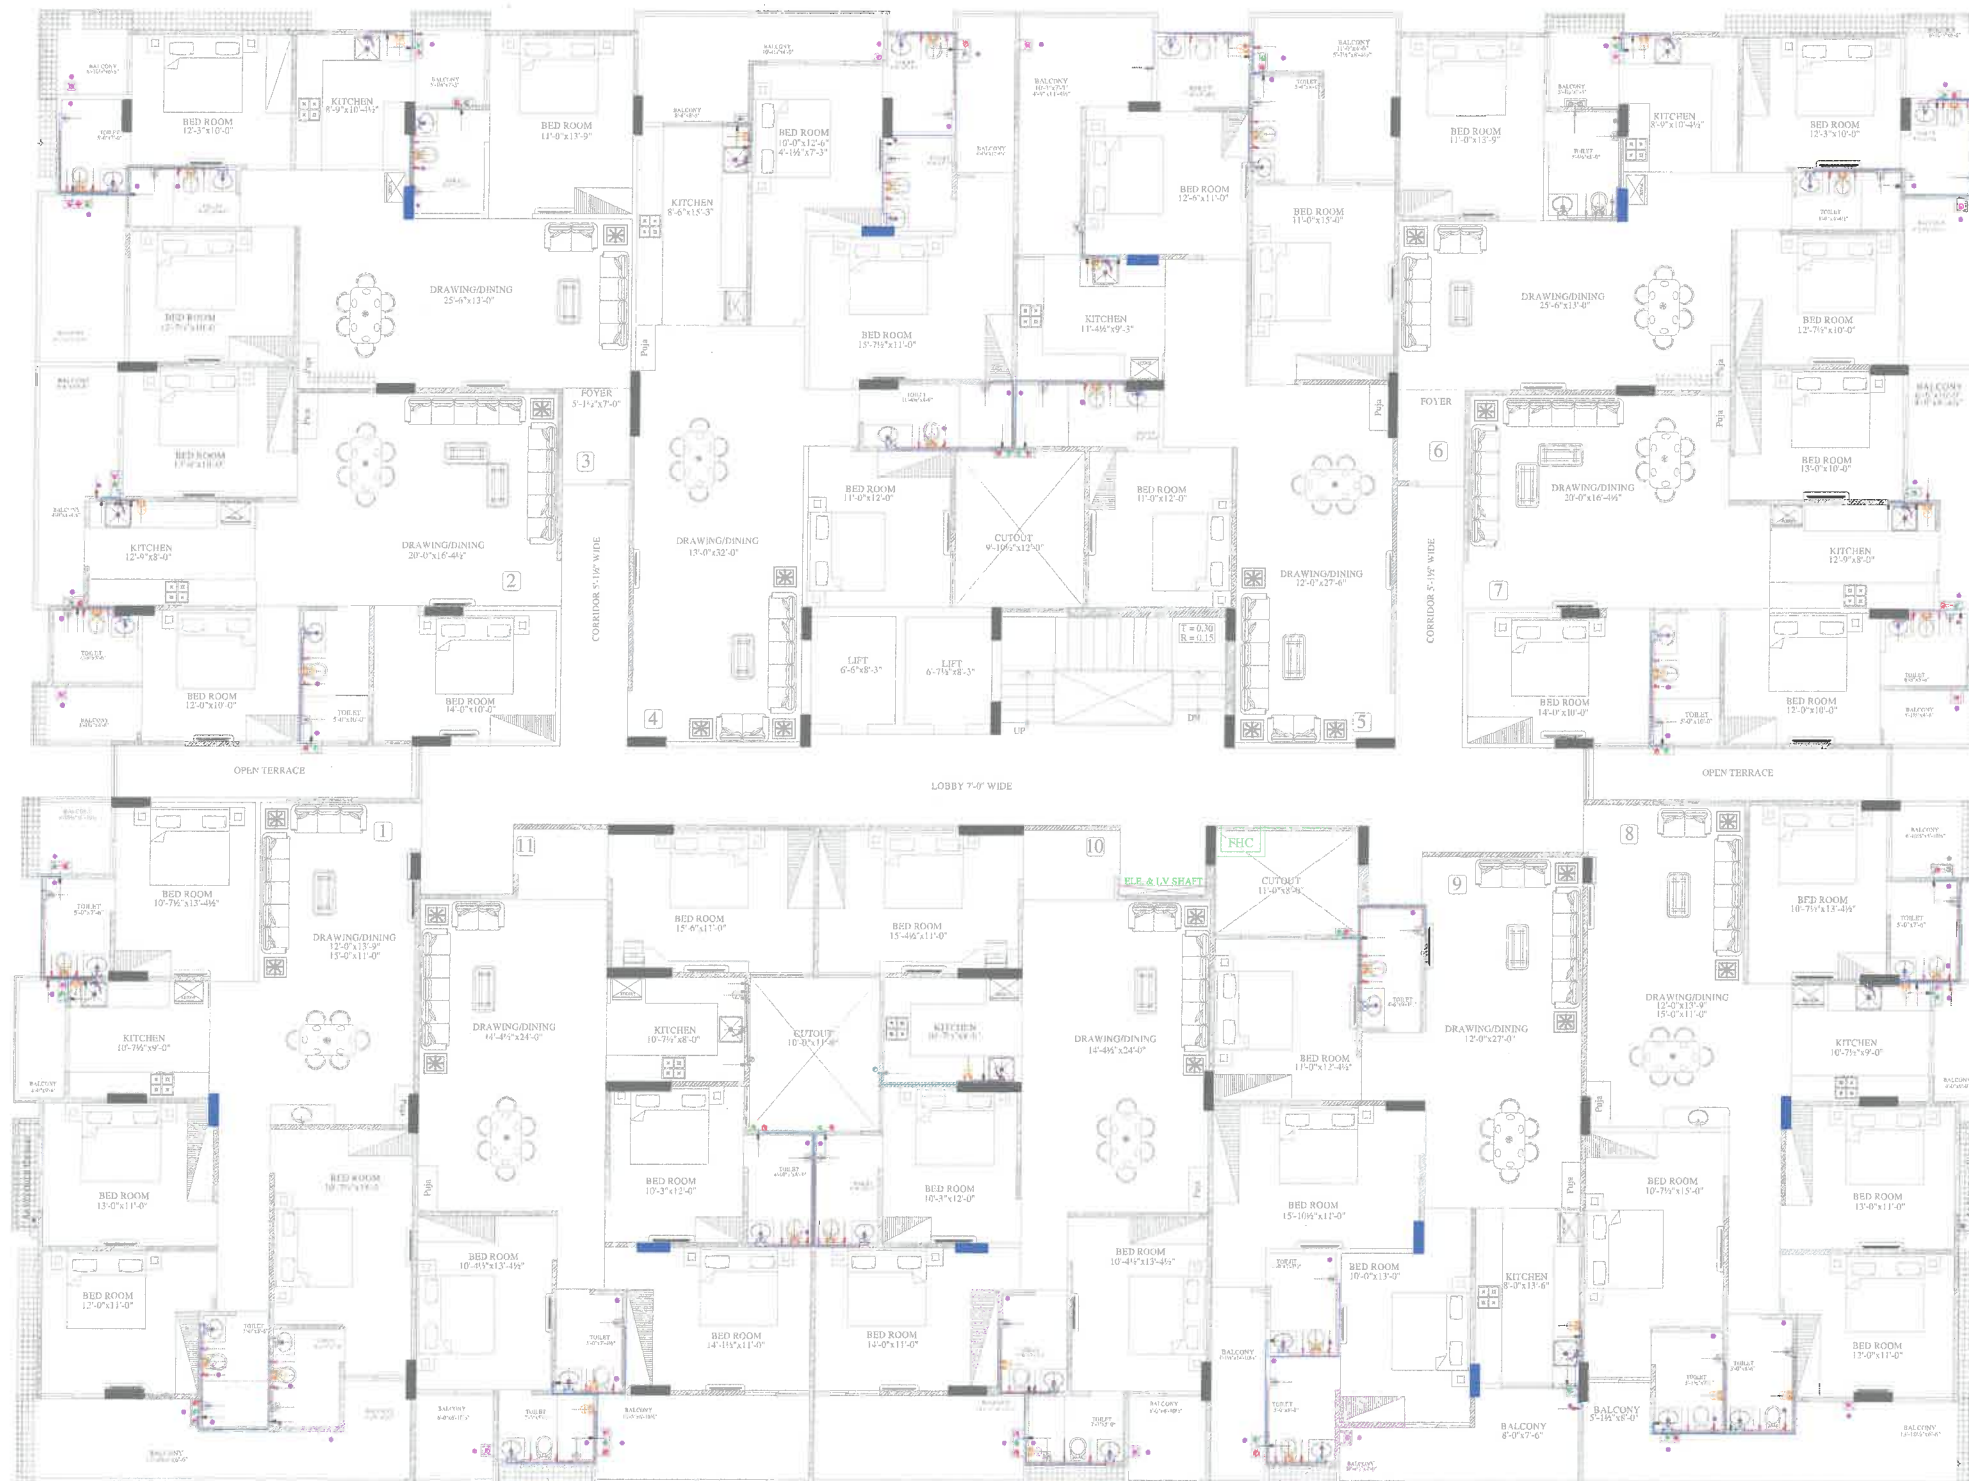

Shree Vinayak Builders
Baniwala

Vipul
VIPUL AGARWAL
M.E.P. CONSULTANT
B.E. ELECTRICAL

All Heights For Finish Floor Lvl	SYMBOL	SYMBOL	DESCRIPTION
+1000MM			Ø 20MM CWS PIPE THRU WALL CHASE TO SINK
+1950MM			Ø 20MM HWS PIPE THRU WALL CHASE TO SINK
+1500MM			Ø 20MM CWS PIPE THRU WALL CHASE TO GEYSER
+800MM			Ø 20MM HWS PIPE THRU WALL CHASE FROM GEYSER
+450MM			Ø 20MM CWS PIPE THRU WALL CHASE TO AQUAGUARD
+450MM			Ø 20MM CWS PIPE THRU WALL CHASE TO WASH BASIN MIXER
+450MM			Ø 20MM CWS PIPE THRU WALL CHASE TO BASIN ANGLE VALVE
+800MM			Ø 20MM CWS PIPE THRU WALL CHASE TO BASIN ANGLE VALVE
+2100MM			Ø 20MM HWS PIPE THRU WALL CHASE TO BASIN ANGLE VALVE
+1000MM			Ø 20MM CWS PIPE THRU WALL CHASE TO CONCEALED STOP COCK
+1000MM			Ø 20MM CWS PIPE THRU WALL CHASE TO WALL MIXER / DIVERTOR
+2025MM			Ø 20MM HWS PIPE THRU WALL CHASE TO WALL MIXER / DIVERTOR
+300MM			Ø 20MM CWS PIPE THRU WALL CHASE TO FAUCET
+450MM			Ø 20MM CWS PIPE THRU WALL CHASE TO CISTERN ANGLE VALVE
+1200MM			Ø 20MM CWS PIPE THRU WALL CHASE TO URINAL ANGLE VALVE
+900MM			Ø 20MM CWS PIPE THRU WALL CHASE TO TAP FOR AUTOCLAVE
			COLD WATER SUPPLY LINE

SERVICE CONSULTANT
ASHI ASSOCIATES
F 9 / 440 , Keshav Marg Chitrakut Scheme, Jaipur
PH:91-0-93146-10438 , 0141-2440946, Mail: vipul8599@yahoo.com

	PROJECT NAME:	DRAWING:	DRN. BY:	APPD. BY:	ARCHITECTS:
	NAKSHATRA	2ND TO 5TH FLOOR INTERNAL PLUMBING PLAN	SNEHA	SANJAY	
	PROMOTER:	PROJECT ADDRESS :	SCALE:	DATE:	
	SHREE VINAYAK BUILDERS	KHASRA NO. 398/10 AT VILLAGE MOHANPURA, TEHSIL- SANGANER, JAIPUR	N.T.S.	22-05-2025	SPACE GRID C-49, VIDYA APARTMENT, PARAS MARG, BAPU NAGAR, NEAR JANTA STORE CIRCLE, JAIPUR-302015 PH-09314918766, 0141-4005506 (O) Email:-info.spacegrid@gmail.com



----- ROAD 12 M WIDE -----

Shree Vinayak Builders
Gommineni
 Partners

Vipul
VIPUL AGARWAL
 M.E.P. CONSULTANT
 B.E. ELECTRICAL

All Heights For Finish Floor Lvl	SYMBOL	SYMBOL	DESCRIPTION
+1000MM			Ø 20MM CWS PIPE THRU WALL CHASE TO SINK
			Ø 20MM HWS PIPE THRU WALL CHASE TO SINK
+1950MM			Ø 20MM CWS PIPE THRU WALL CHASE TO GEYSER
			Ø 20MM HWS PIPE THRU WALL CHASE FROM GEYSER
+1500MM			Ø 20MM CWS PIPE THRU WALL CHASE TO AQUAGUARD
+800MM			Ø 20MM CWS PIPE THRU WALL CHASE TO WASH BASIN MIXER
+450MM			Ø 20MM CWS PIPE THRU WALL CHASE TO BASIN ANGLE VALVE
+450MM			Ø 20MM CWS PIPE THRU WALL CHASE TO BASIN ANGLE VALVE
+800MM			Ø 20MM HWS PIPE THRU WALL CHASE TO BASIN ANGLE VALVE
+2100MM			Ø 20MM CWS PIPE THRU WALL CHASE TO CONCEALED STOP COCK
+1000MM WALL MIXER DIVERTOR			Ø 20MM CWS PIPE THRU WALL CHASE TO WALL MIXER / DIVERTOR
+2025MM O.H.SHOWER			Ø 20MM HWS PIPE THRU WALL CHASE TO WALL MIXER / DIVERTOR
+300MM			Ø 20MM CWS PIPE THRU WALL CHASE TO FAUCET
+450MM			Ø 20MM CWS PIPE THRU WALL CHASE TO CISTERN ANGLE VALVE
+1200MM			Ø 20MM CWS PIPE THRU WALL CHASE TO URINAL ANGLE VALVE
+900MM			Ø 20MM CWS PIPE THRU WALL CHASE TO TAP FOR AUTOCLAVE
			COLD WATER SUPPLY LINE

SERVICE CONSULTANT

ASHI ASSOCIATES

F 9 / 440 , Keshav Marg Chitrakut Scheme,Jaipur
 PH:91-0-93146-10438 ,0141-2440946, Mail:vipul8599@yahoo.com



PROJECT NAME:
NAKSHATRA
 PROMOTER:
SHREE VINAYAK BUILDERS


DRAWING:
**6THTH FLOOR INTERNAL
 PLUMBING PLAN**
 PROJECT ADDRESS :
**KHASRA NO. 398/10 AT VILLAGE
 MOHANPURA, TEHSIL- SANGANER, JAIPUR**

DRN. BY:
 SNEHA
 SCALE:
 N.T.S.
 APPD. BY:
 SANJAY
 DATE:
 22-05-2025

ARCHITECTS:

SHRI KRISHNA
 Architect
 CA/99/25451

SPACE GRID
 C-49, VIDYA APARTMENT, PARAS
 MARG, BAPU NAGAR, NEAR JANTA
 STORE CIRCLE, JAIPUR-302015
 PH-09314918766,0141-4005506 (O)
 Email:-info.spacegrid@gmail.com

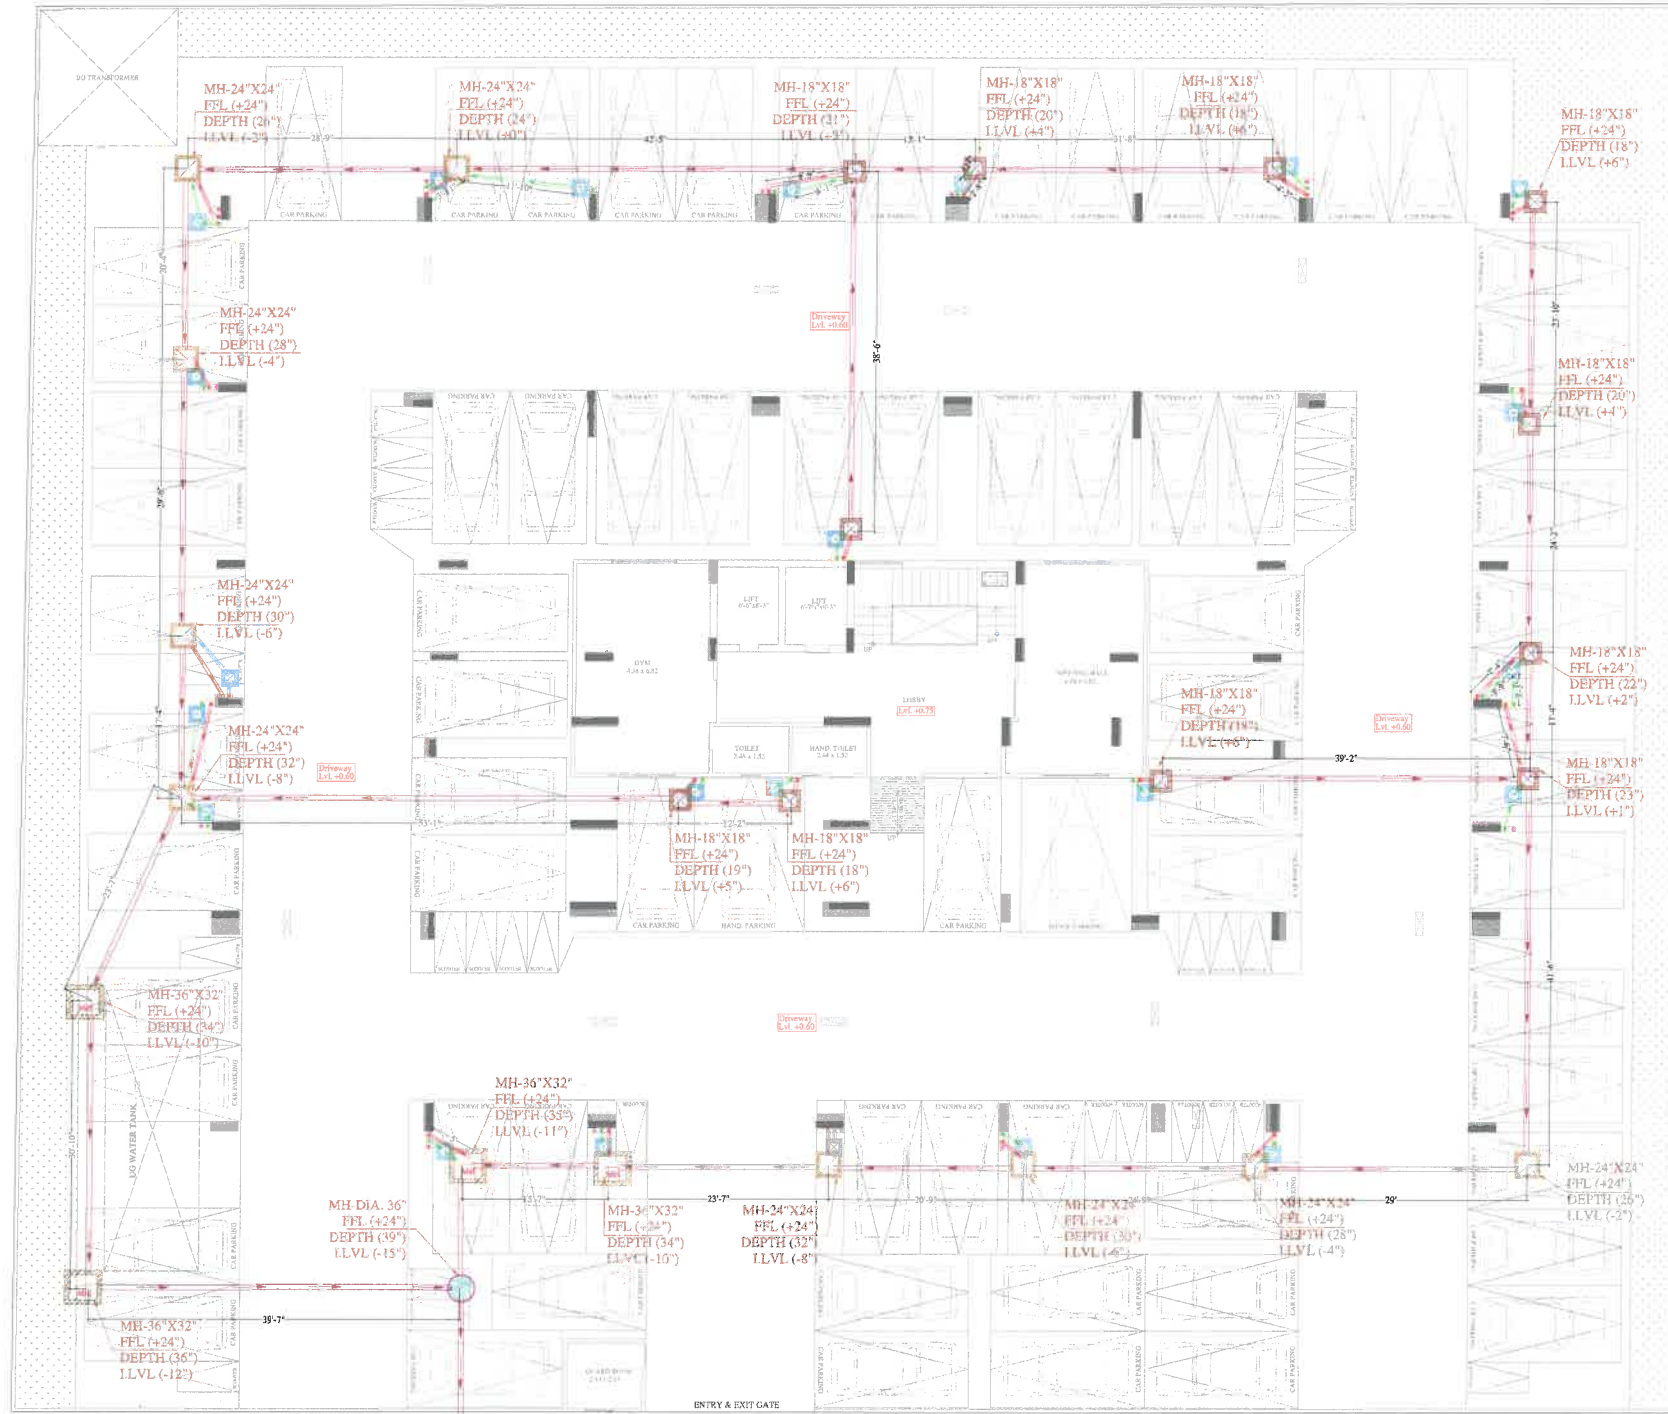

STILT PLAN

6" SWP DROP TO OUTSIDE AS PER SITE CONDITION

----- ROAD 12 M WIDE -----

Shree Vinayak Builders

Bommal

Vipul
VIPUL AGARWAL
M.E.P. CONSULTANT
B.E. ELECTRICAL

SYMBOL	DESCRIPTION
	110 mm Soil Waste Water Pipe
	110 mm Waste Water Pipe
	110 mm Rain Water Pipe
	160 mm Soil Waste Water Pipe Slope 1:200
	160 mm Rain Water Pipe Slope 1:200
	110 mm Soil Waste Water Pipe Slope 1:150
	110 mm Waste Water Pipe Slope 1:150
	110 mm Rain Water Pipe Slope 1:200
	RC-300X300mm Depth According to Slope
	RC-450X450mm Depth According to Slope
	RC-600X600mm Depth According to Slope
	RC-750X600mm Depth According to Slope
	RC-900X750mm Depth According to Slope
	Gully Trap-300X300mm Depth 300 mm
	Main Hole-450X450mm Depth According to Slope
	Main Hole-600X600mm Depth According to Slope
	Main Hole-900X800mm Depth According to Slope
	Main Hole-DIA.900mm Depth According to Slope
	Flow Direction

SERVICES CONSULTANT:
ASHI ASSOCIATES
F 9 / 440 , Keshav Marg Chitrakut Scheme,Jaipur
PH:91-93146-0438 ,0141-2440946
Mail: vipul8599@yahoo.com



PROJECT NAME:
NAKSHATRA

PROMOTER:
SHREE VINAYAK BUILDERS

DRAWING:
**EXTERNAL SEWERAGE PIPE
ROUTE PLAN**

PROJECT ADDRESS :
**KHASRA NO. 398/10 AT VILLAGE
MOHANPURA, TEHSIL- SANGANER, JAIPUR**

DRN. BY:
SNEHA


CHKD. BY:
SANJAY

SCALE:
N.T.S.

DATE:
02-10-2024

ARCHITECTS:
SPACE GRID

C-49, VIDYA APARTMENT, PARAS
MARG, BAPU NAGAR, NEAR JANTA
STORE CIRCLE, JAIPUR-302015
PH-09314918766,0141-4005506 (O)
Email: info.spacegrid@gmail.com

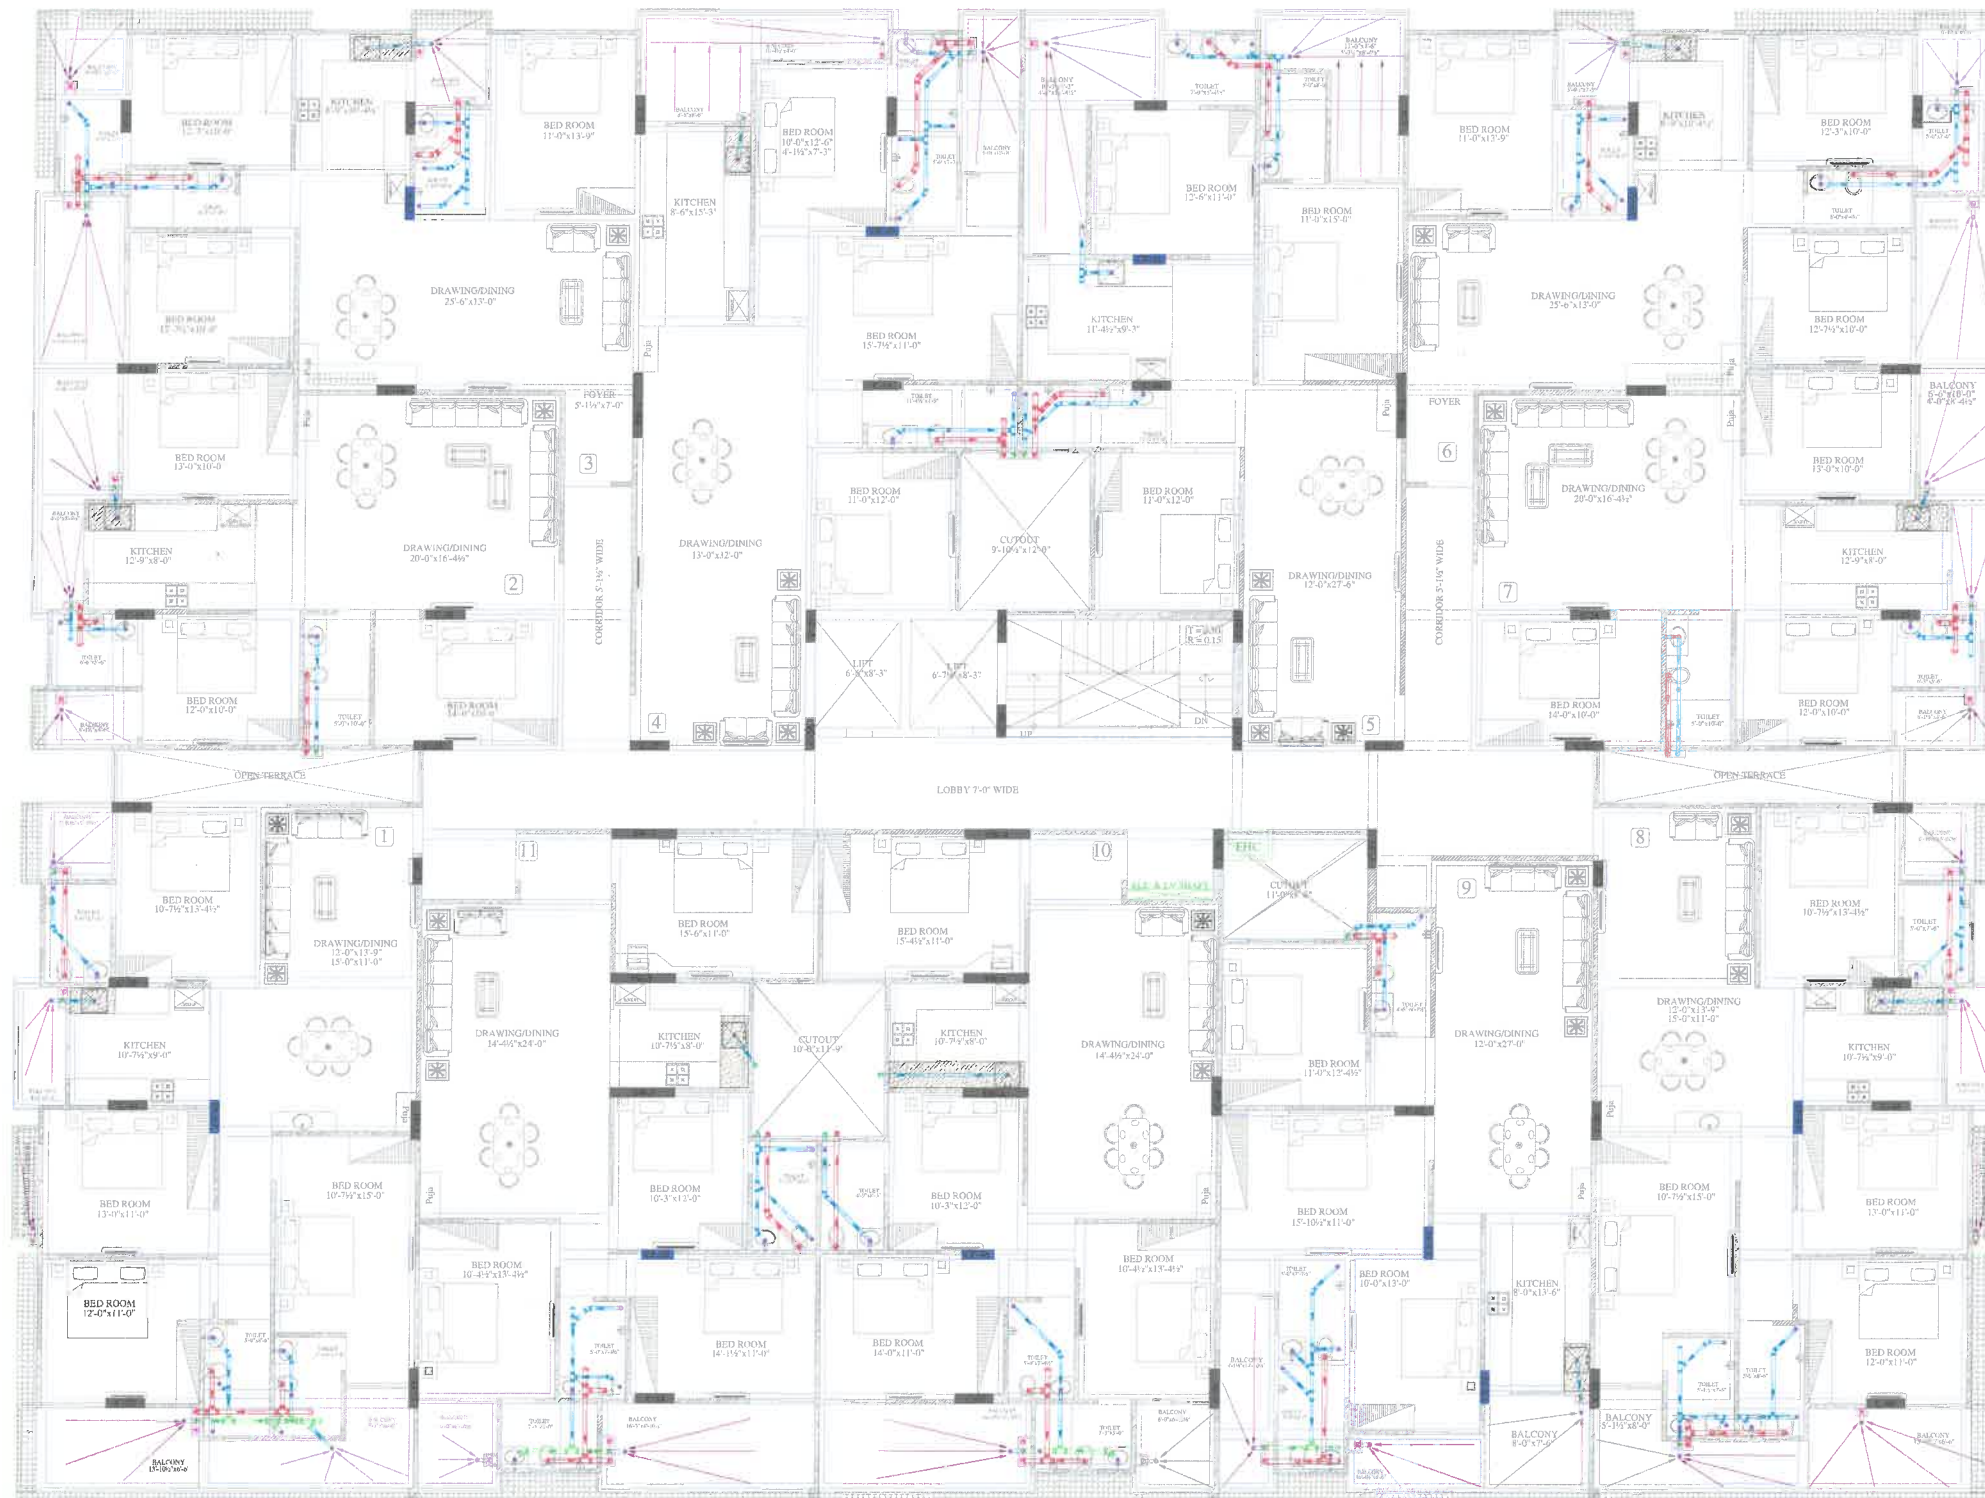

Shree Vinayak Builders
Bennish
 Partners


Vipul
VIPUL AGARWAL
 M.E.P. CONSULTANT
 B.E. ELECTRICAL

SYMBOL	DESCRIPTION
	Ø4" Soil Waste Water Pipe
	Ø4" Waste Water Pipe
	Ø4" mm Rain Water Pipe
	Ø4" Soil Waste Water Pipe Slope 1:150
	Ø4" Waste Water Pipe Slope 1:150
	Ø4" Rain Water Pipe Slope 1:200
	Ø3" Waste Water Pipe Internal Toilet Slope 1:150
	Ø3" Rain Water Pipe 1:200
	Ø2" Waste Water Pipe Bottle Trap
	Floor Trap
	Flow Direction
	6" Platform Raise

SERVICE CONSULTANT

ASHI ASSOCIATES

F 9 / 440 , Keshav Marg Chitrakut Scheme, Jaipur
 PH:91-0-93146-10438 ,0141-2440946, Mail:vipul8599@yahoo.com

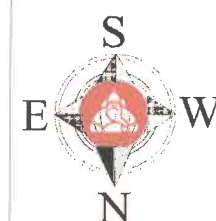

PROJECT NAME:
NAKSHATRA
 PROMOTER:
SHREE VINAYAK BUILDERS


DRAWING:
1ST FLOOR INTERNAL DRAINAGE PLAN
 PROJECT ADDRESS :
KHASRA NO. 398/10 AT VILLAGE MOHANPURA, TEHSIL- SANGANER, JAIPUR

DRN. BY:
SNEHA
 SCALE:
N.T.S.
 APPD. BY:
SANJAY
 DATE:
22-05-2025

ARCHITECTS:

Shri Krishna
SHRI KRISHNA
 Architect
 CA/99/25451

SPACE GRID
 C-49, VIDYA APARTMENT, PARAS MARG, BAPU NAGAR, NEAR JANTA STORE CIRCLE, JAIPUR-302015
 PH-09314918766,0141-4005506 (O)
 Email:-info.spacegrid@gmail.com

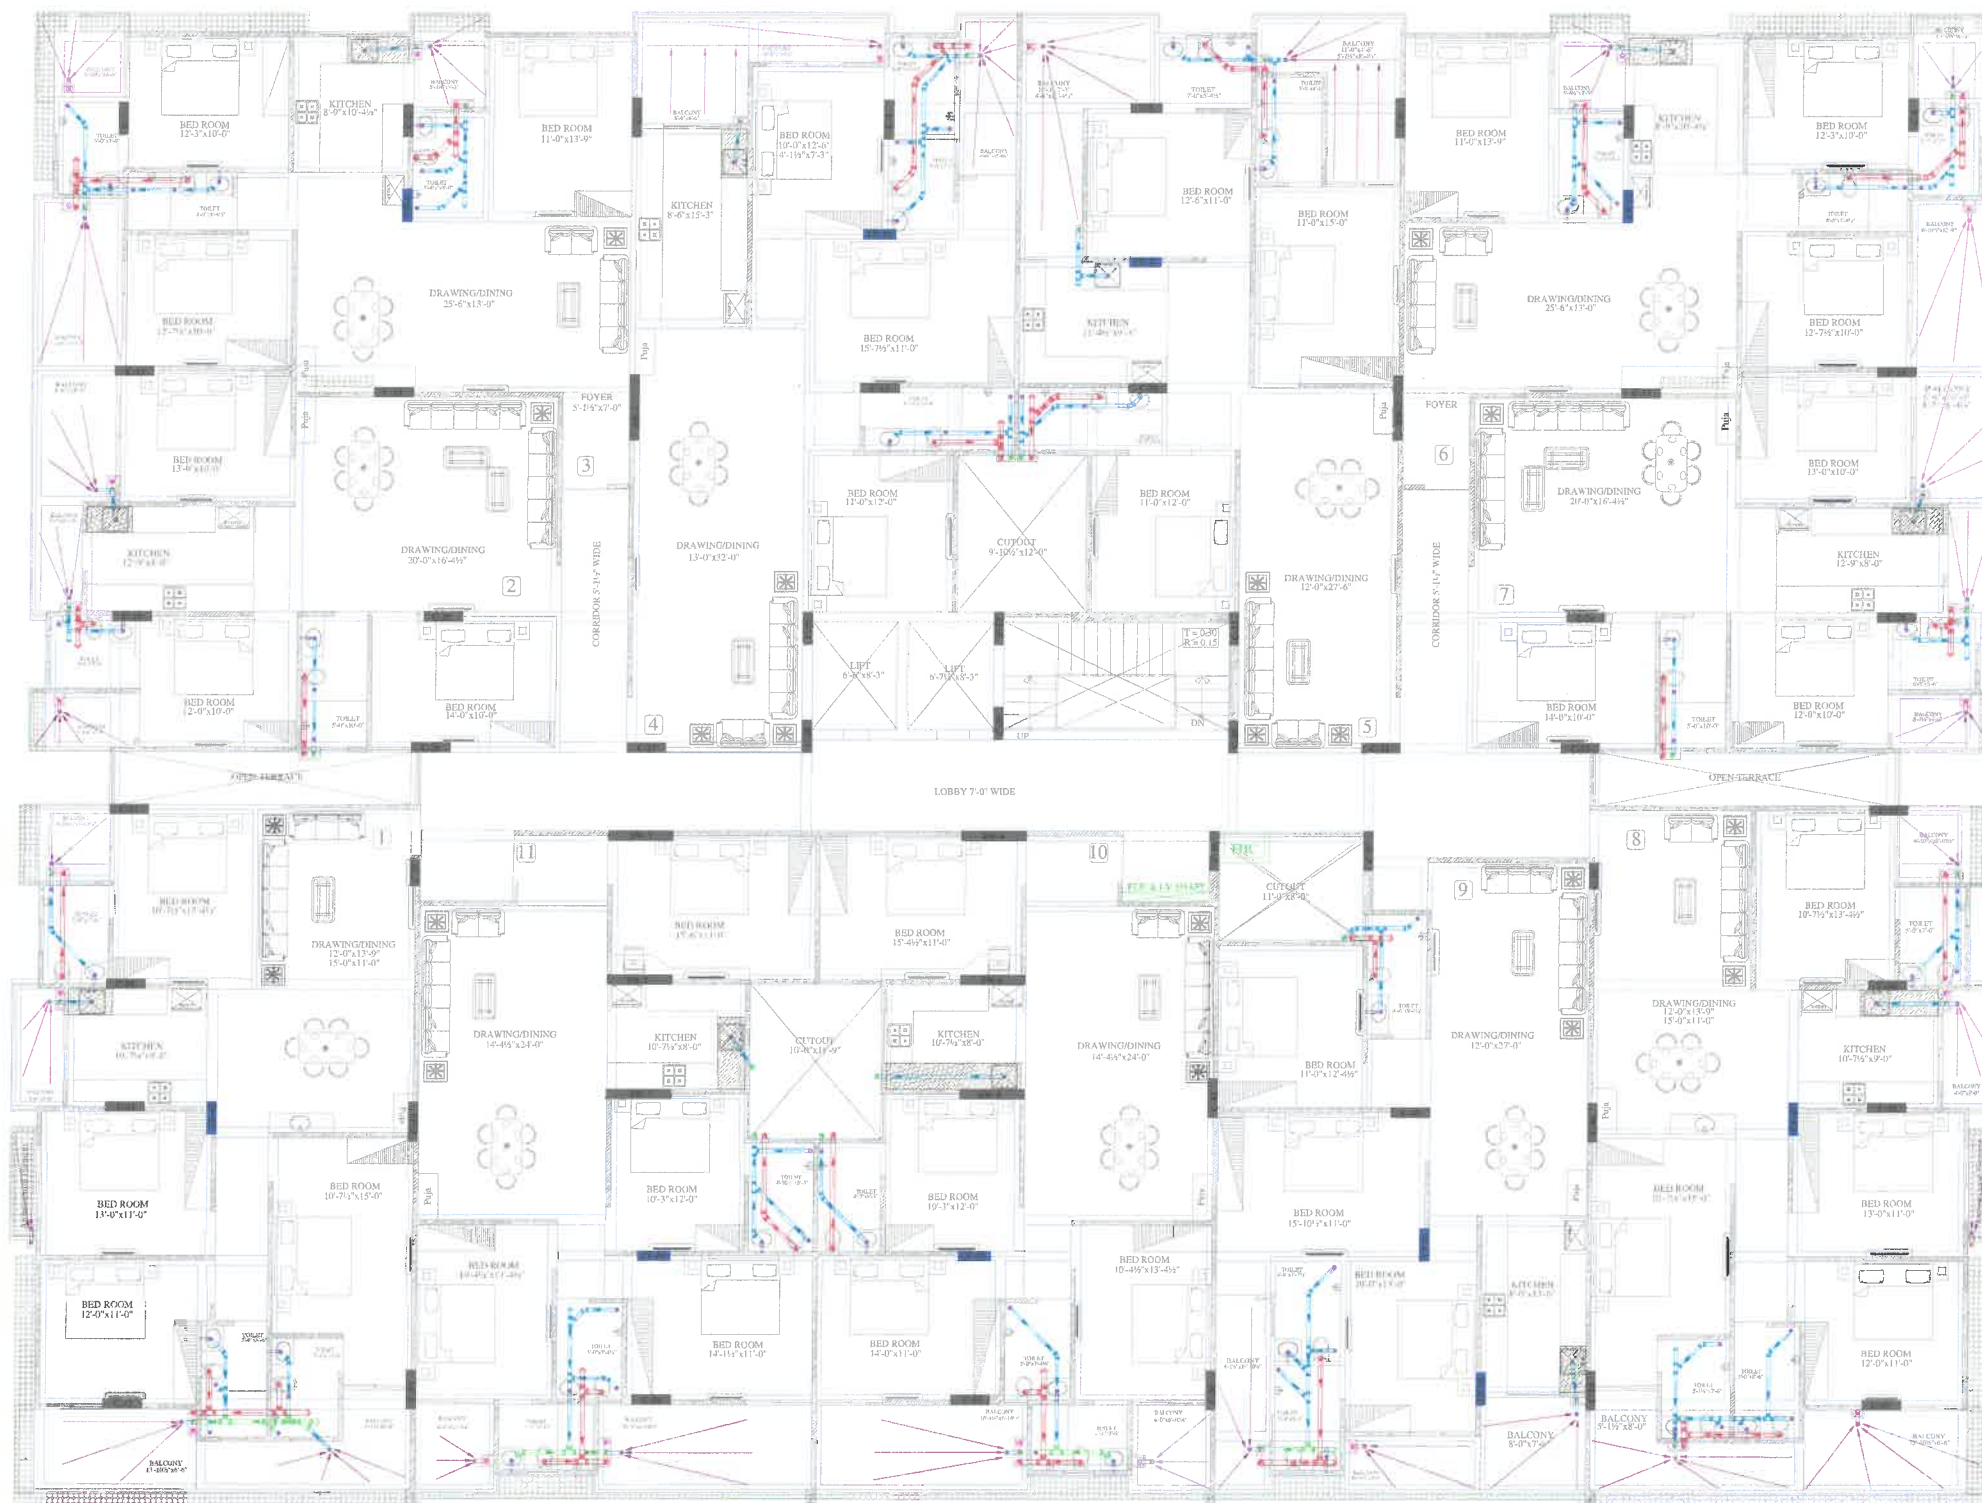

Shree Vinayak Builders
Banshi
Partners

Vipul
VIPUL AGARWAL
M.E.P. CONSULTANT
B.E. ELECTRICAL

SYMBOL	DESCRIPTION
	Ø4" Soil Waste Water Pipe
	Ø4" Waste Water Pipe
	Ø4" mm Rain Water Pipe
	Ø4" Soil Waste Water Pipe Slope 1:150
	Ø4" Waste Water Pipe Slope 1:150
	Ø4" Rain Water Pipe Slope 1:200
	Ø3" Waste Water Pipe Internal Toilet Slope 1:150
	Ø3" Rain Water Pipe 1:200
	Ø2" Waste Water Pipe Bottle Trap
	Floor Trap
	Flow Direction
	6" Platform Raise

SERVICE CONSULTANT


ASHI ASSOCIATES

F 9 / 440 , Keshav Marg Chitrakut Scheme,Jaipur
PH:91-0-93146-10438 ,0141-2440946, Mail:vipul8599@yahoo.com

Shri Krishan
Architect
CA/99/25451

SPACE GRID

C-49, VIDYA APARTMENT, PARAS
MARG, BAPU NAGAR, NEAR JANTA
STORE CIRCLE, JAIPUR-302015
PH-09314918766,0141-4005506 (O)
Email:-info.spacegrid@gmail.com

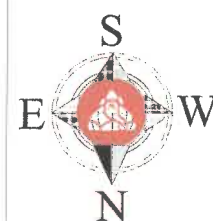


PROJECT NAME:
NAKSHATRA
PROMOTER:
SHREE VINAYAK BUILDERS

DRAWING:
2ND TO 5TH FLOOR
INTERNAL DRAINAGE PLAN
PROJECT ADDRESS :
KHASRA NO. 398/10 AT VILLAGE
MOHANPURA, TEHSIL- SANGANER, JAIPUR

DRN. BY:
SNEHA
SCALE:
N.T.S.
APPD. BY:
SANJAY
DATE:
22-05-2025


ARCHITECTS:

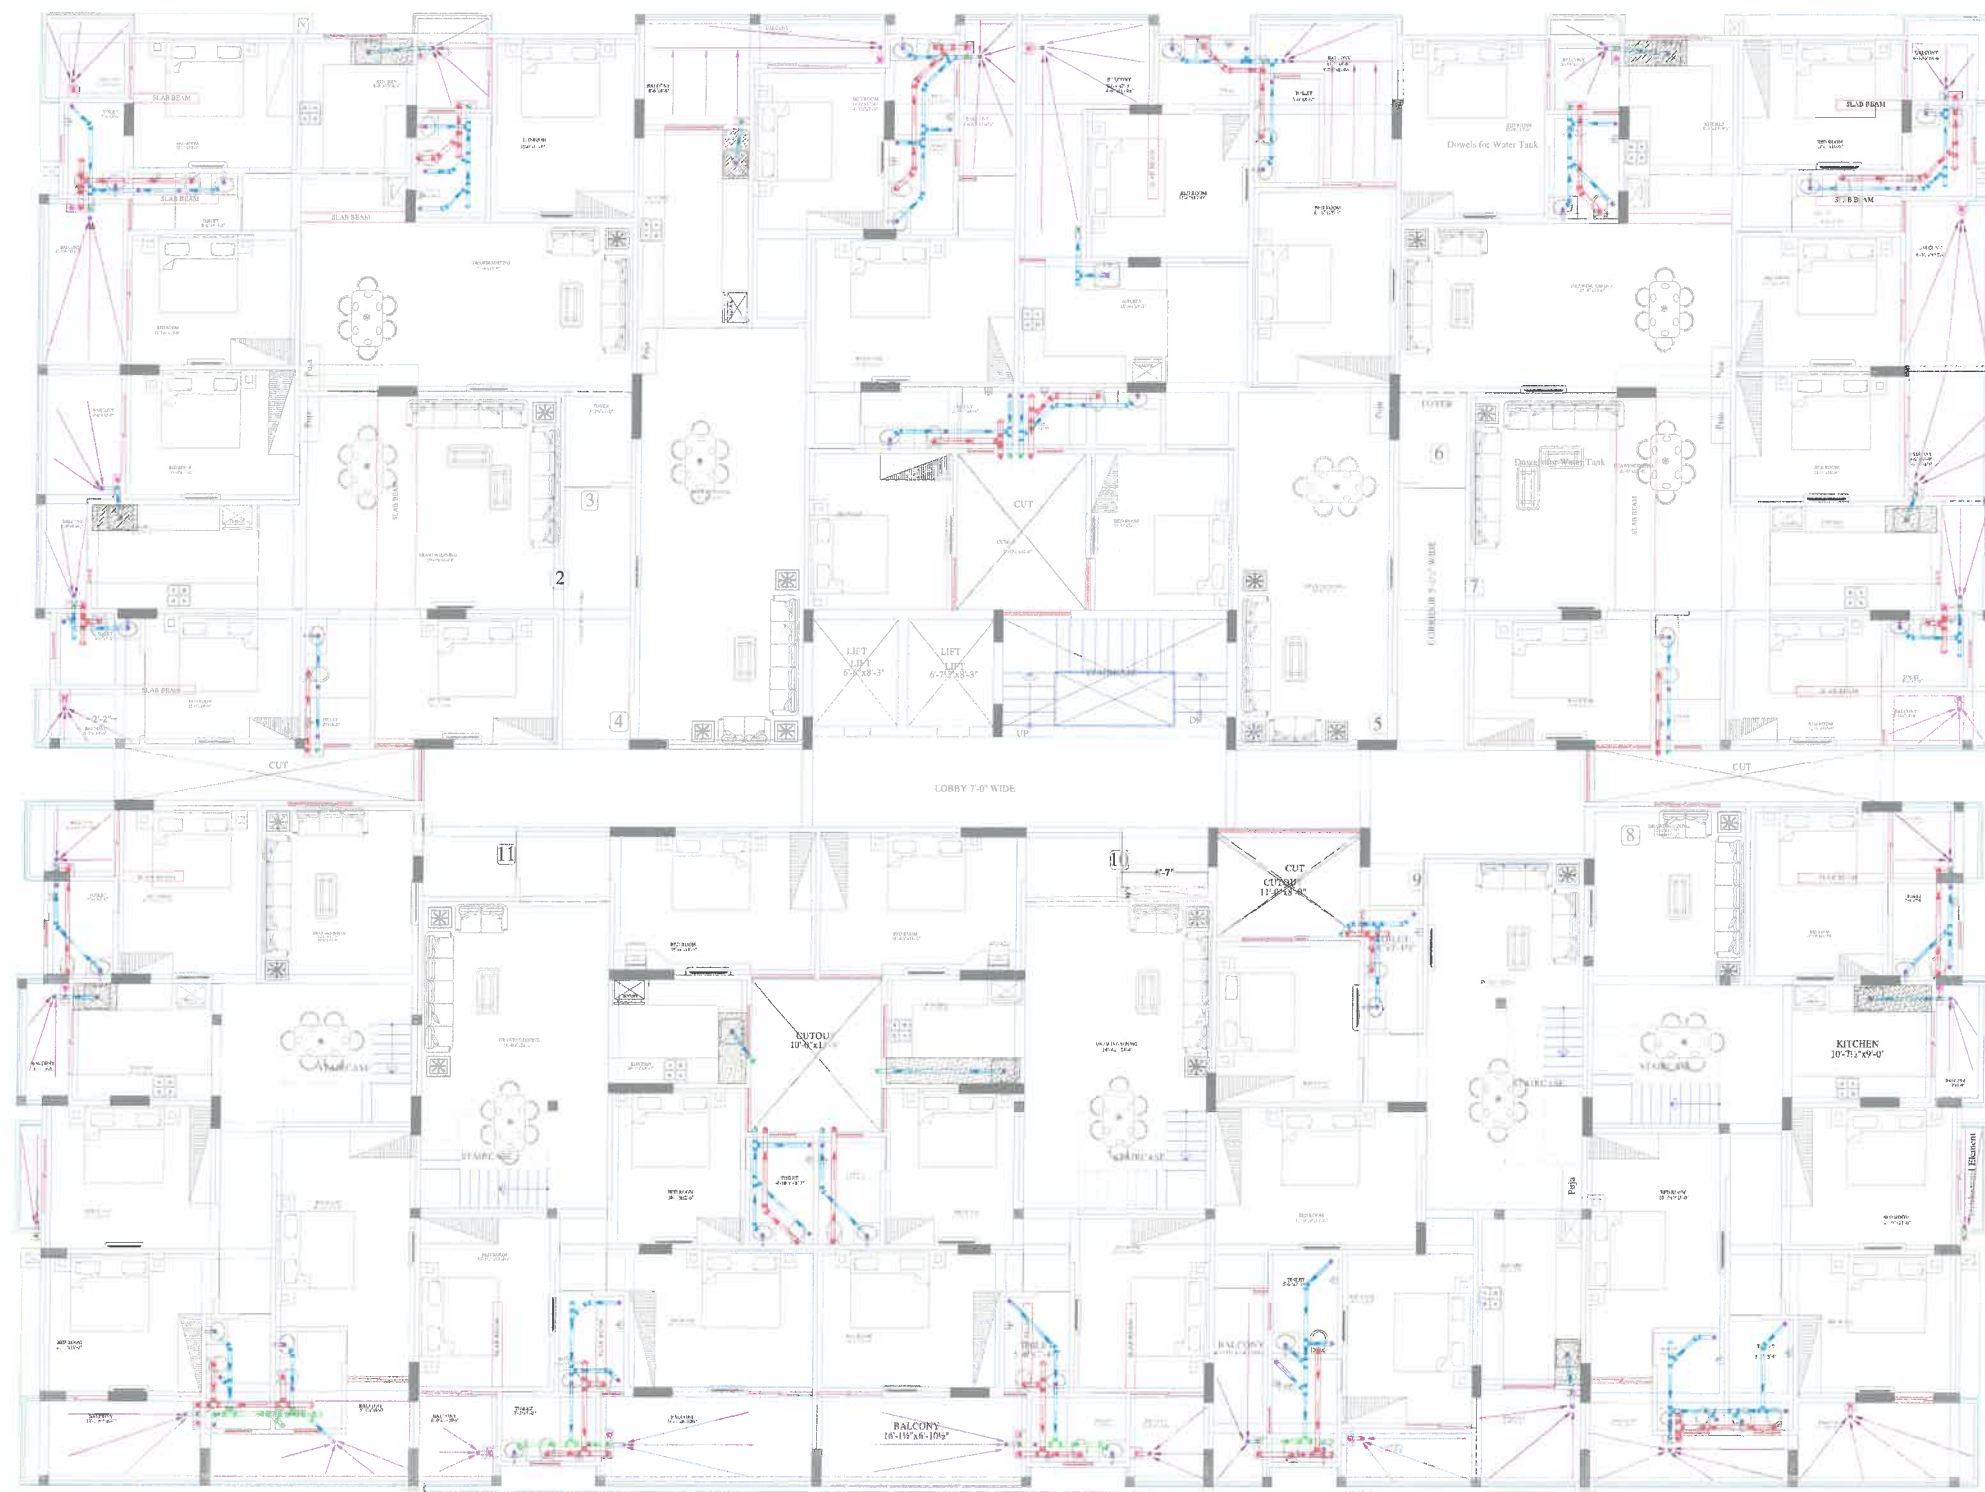

Shree Vinayak Builders
Banshi
Partners

Vipul
VIPUL AGARWAL
M.E.P. CONSULTANT
S.E. ELECTRICAL

SYMBOL	DESCRIPTION
	Ø4" Soil Waste Water Pipe
	Ø4" Waste Water Pipe
	Ø4" mm Rain Water Pipe
	Ø4" Soil Waste Water Pipe Slope 1:150
	Ø4" Waste Water Pipe Slope 1:150
	Ø4" Rain Water Pipe Slope 1:200
	Ø3" Waste Water Pipe Internal Toilet Slope 1:150
	Ø3" Rain Water Pipe 1:200
	Ø2" Waste Water Pipe Bottle Trap
	Floor Trap
	Flow Direction
	6" Platform Raise
SERVICE CONSULTANT	
ASHI ASSOCIATES	
F 9 / 440 , Keshav Marg Chitrakut Scheme,Jaipur	
PH:91-0-93146-10438 ,0141-2440946, Mail:vipul8599@yahoo.com	

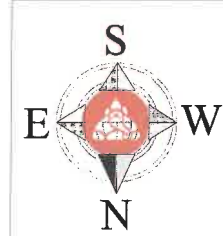

PROJECT NAME: NAKSHATRA	DRAWING: 6TH FLOOR INTERNAL DRAINAGE PLAN	DRN. BY: SNEHA	APPD. BY: SANJAY	ARCHITECTS: SPACE GRID
PROMOTER: SHREE VINAYAK BUILDERS	PROJECT ADDRESS : KHASRA NO. 398/10 AT VILLAGE MOHANPURA, TEHSIL- SANGANER, JAIPUR	SCALE: N.T.S.	DATE: 22-05-2025	C-49, VIDYA APARTMENT, PARAS MARG, BAPU NAGAR, NEAR JANTA STORE CIRCLE, JAIPUR-302015 PH-09314918766,0141-4005506 (O) Email:-info.spacegrid@gmail.com

SRIKRISHNA
Architect
CA/99/25451