

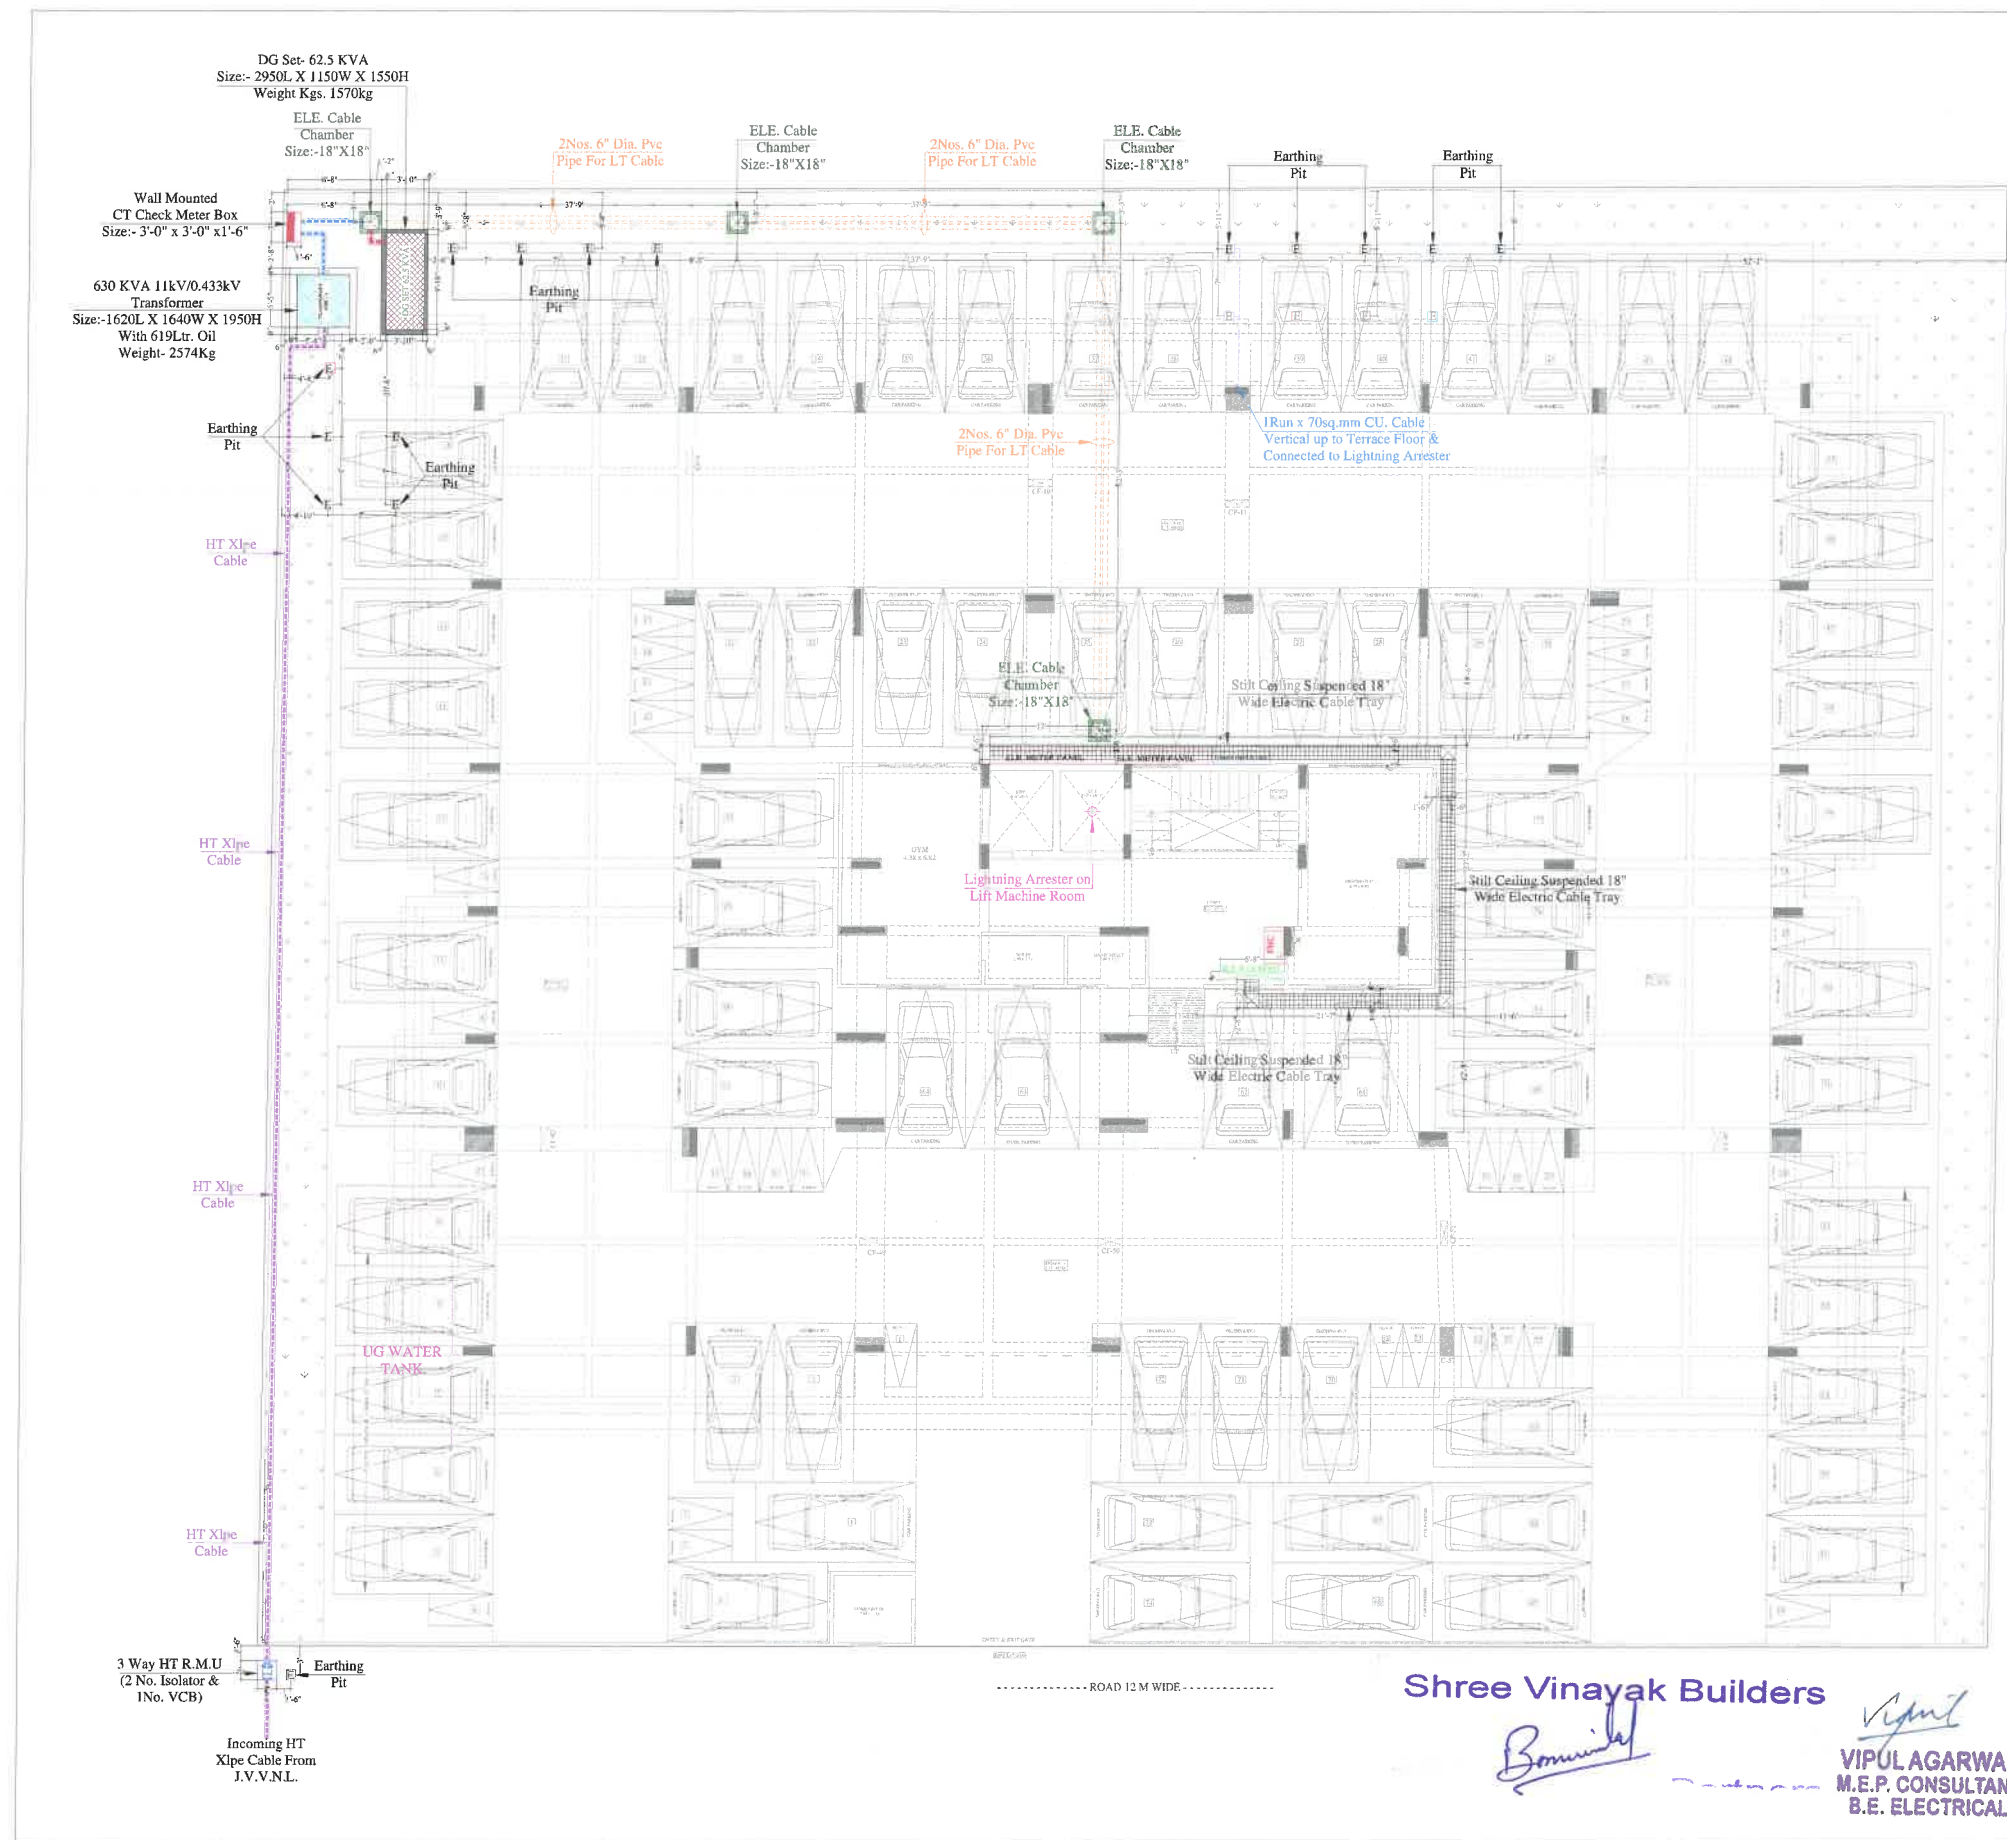


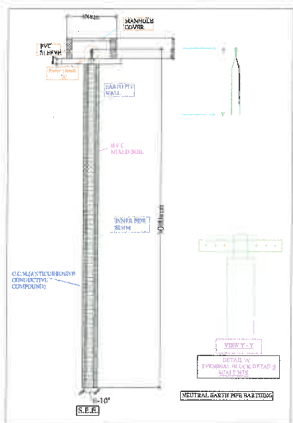


Lightning Arrester

Model: Stormaster – ESE
- 50 (Level 2/Medium Protection)
(Protection radius - 35M, Mast Height -2 Mtr)

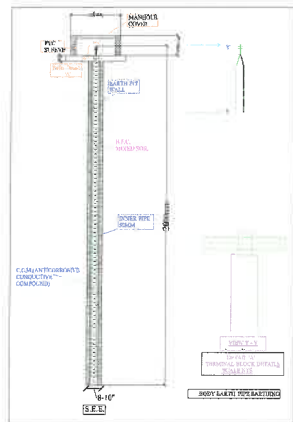

EARTHING DETAILS		
01	50MM PIPE(2METER)	3WAY HT R.M.U. BODY EARTH
01	50MM PIPE(2METER)	CT CHECK METER BOX BODY EARTH
02	50MM PIPE(2METER)	TRANSFORMER BODY EARTH
02	50MM PIPE(3METER)	TRANSFORMER NEUTRAL EARTH
02	50MM PIPE(2METER)	DG SET BODY EARTH
02	50MM PIPE(3METER)	DG SET NEUTRAL EARTH
02	50MM PIPE(2METER)	LIGHTNING ARRESTER BODY EARTH
02	50MM PIPE(2METER)	ELECTRIC PANEL BODY EARTH
01	50MM PIPE(2METER)	TELEPHONE EXCH. BODY EARTH
04	50MM PIPE(2METER)	LIFT PANEL BODY EARTH
NOTES:		
1. ALL NEUTRAL EARTHS TO BE CONNECTED 50 X 3 GI EARTH STRIP FROM EARTH PIT TO EQUIPMENT.		
2. ALL BODY EARTHS TO BE CONNECTED 25 X 3 GI EARTH STRIP FROM EARTH PIT TO EQUIPMENT.		
SERVICE CONSULTANT		
ASHI ASSOCIATES		
F 9 / 440 , Keshav Marg Chitrakut Scheme,Jaipur		
PH-91-0-93146-10438 ,0141-2440946, Mail: vipul8599@yahoo.com		

	PROJECT NAME:	PROJECT:	DRAWING:	DRN. BY:	CKD. BY:	DATE:	ARCHITECTS:
	NAKSHATRA	KHASRA NO. 398/10 AT VILLAGE MOHANPURA, TEHSIL-SANGANER, JAIPUR	STILT FLOOR ELECTRIC SUB-STATION, CABLE CHAMBER PIPE ROUTE & LIGHTNING ARRESTER PLAN	PAWAN	SANJAY	01-10-2024	SPACE GRID
	PROMOTER:			APPD. BY:		SCALE:	
	SHREE VINAYAK BUILDERS			VIPUL AGARWAL		N.T.S.	C-49, VIDYA APARTMENT, PARAS MARG, BAPU NAGAR, NEAR JANTA STORE CIRCLE, JAIPUR-302015 PH-09314918766,0141-4005506 (O) Email:-info.spacegrid@gmail.com

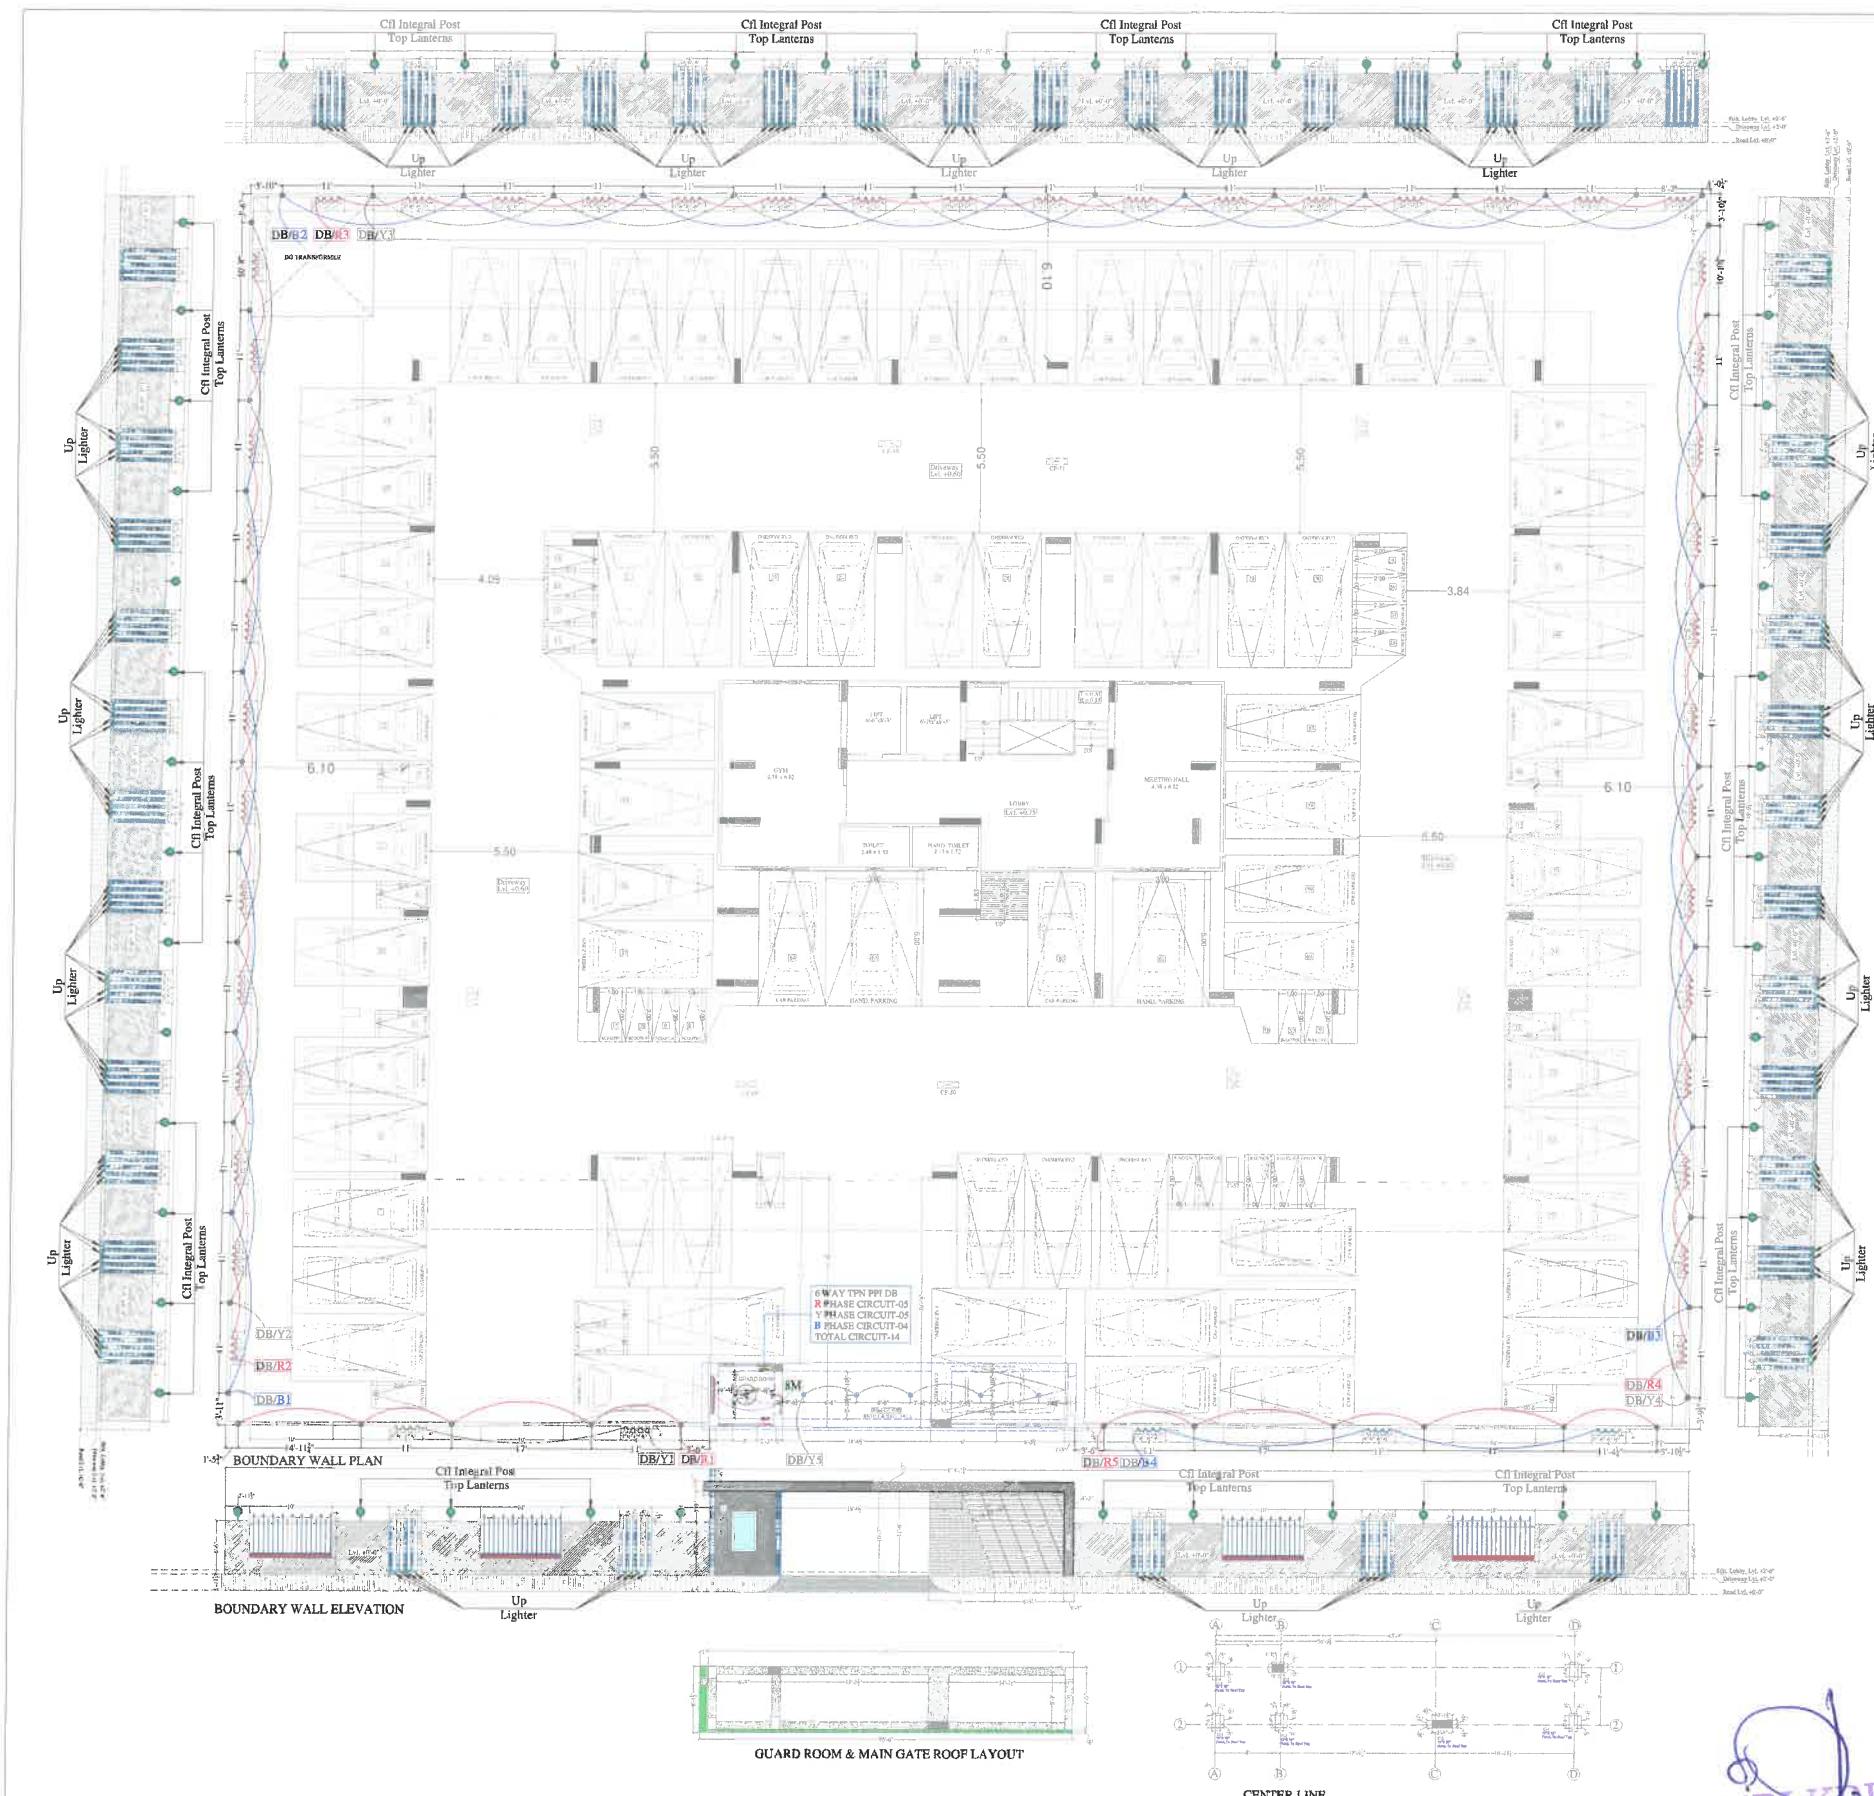


BOUNDARY WALL PLAN

BOUNDARY WALL ELEVATION



GUARD ROOM & MAIN GATE ROOF LAYOUT

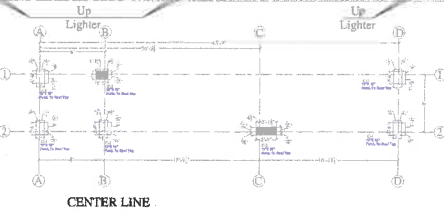

CENTER LINE

Shree Vinayak Builders

Bannu Patel

Partner

Vipul

VIPUL AGARWAL
M.E.P. CONSULTANT
B.E. ELECTRICAL

LEGENDS:

Mounting Height	No.	ID	Symbol	Description
IN CONDUIT				Control Wiring For Light Point 1.5 sqmm Red [Phase], Black [Neutral], 1.5 sqmm Green [Earth]
IN CONDUIT				R PHASE CONTROL CABLE 1Run x 4Core x 4.0 Sqmm Al. Ar. Cable
IN CONDUIT				Y PHASE CONTROL CABLE 1Run x 4Core x 4.0 Sqmm Al. Ar. Cable
IN CONDUIT				B PHASE CONTROL CABLE 1Run x 4Core x 4.0 Sqmm Al. Ar. Cable
	05		DB/R	DB/ R PHASE CIRCUIT NO.
	05		DB/Y	DB/ Y PHASE CIRCUIT NO.
	04		DB/B	DB/ B PHASE CIRCUIT NO.

LEGENDS:

Mounting Height	No.	ID	Symbol	Description
CEILING	05	DL		LED 6" DOWN LIGHTER 20W (SURFACE MOUNTED) MAKE:- SYSKA LED CAT NO.:- SCL-15W GLD 6.5K/4K
	188	UL		UP LIGHTER
	56			CFL INTEGRAL POST TOP LANTERNS, CAT NO. 110202 LUMINAIRE TYPE: INDOOR 218 O LAMP TYPE: 'D' TYPE CFL 2X18W
CEILING	01	FAN30		CEILING FAN 30"
+00"	01	TL/W		LED WALL TUBE LIGHT MAKE SYSKA LED CAT NO. SSK-T5-20W
+90"	01	BULB		LED BULB 20W MAKE SYSKA LED CAT NO. SSK-20W 5.7K/4K
+42"	01	SB		SWITCH BOARD
+38"	01	TEL		TELEPHONE POINT (1 MODULAR BOX)
+36"	01	LP		6 A PLUG POINT FOR TELEPHONE (3 MODULAR BOX)
+60"	01	MCB DB		MCB DISTRIBUTION BOARD
			M	MODULAR BOX NO.

SERVICE CONSULTANT

ASHI ASSOCIATES






F 9 / 440 , Keshav Marg Chitrakut Scheme, Jaipur
PH-91-0293146-10438, 0141-2440946, Mail: vipul8599@yahoo.com

DRAWN:-	DEALT:-	APPD:-
VJESH	SANJAY	VIPUL AGARWAL



PROJECT NAME: NAKSHATRA	DRAWING: EXTERNAL LIGHTING PLAN	DRN. BY: Vinod kumawat	APPD. BY: Shri Krishan Sharma	ARCHITECTS: SHRI KRISHAN Architect CA/99/25451
PROMOTER: SHREE VINAYAK BUILDERS	PROJECT ADDRESS : KHASRA NO. 398/10 AT VILLAGE MOHANPURA, TEHSIL- SANGANER, JAIPUR	SCALE: N.T.S.	DATE: 17-12-2024	SPACE GRID C-49, VIDYA APARTMENT, PARAS MARG, BAPU NAGAR, NEAR JANTA STORE CIRCLE, JAIPUR-302015 PH-0931 4918766, 0141-4005506 (O) Email:-info.spacegrid@gmail.com

NOTE:-
THIS SLD HAS BEEN PREPARED AS PER CONCEPT STAGE DATA AVAILABLE WITH US. KINDLY CONTACT US FOR FINAL SLD & DETAILS BEFORE PLACING ORDER FOR FABRICATION. WE SHALL NOT BE RESPONSIBLE , IF THE PANELS ARE UNDER UTILISED OR OVER LOADED AT ANY STAGE.

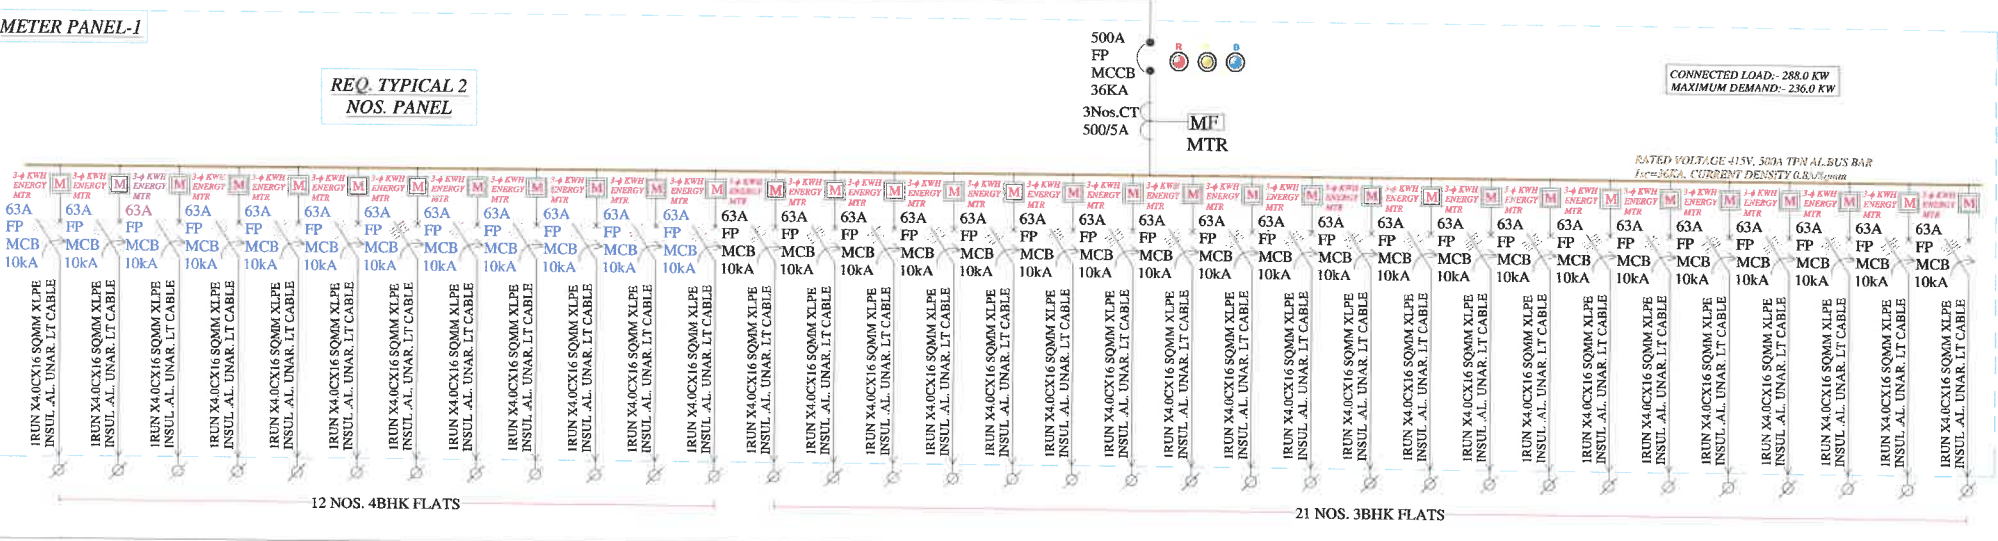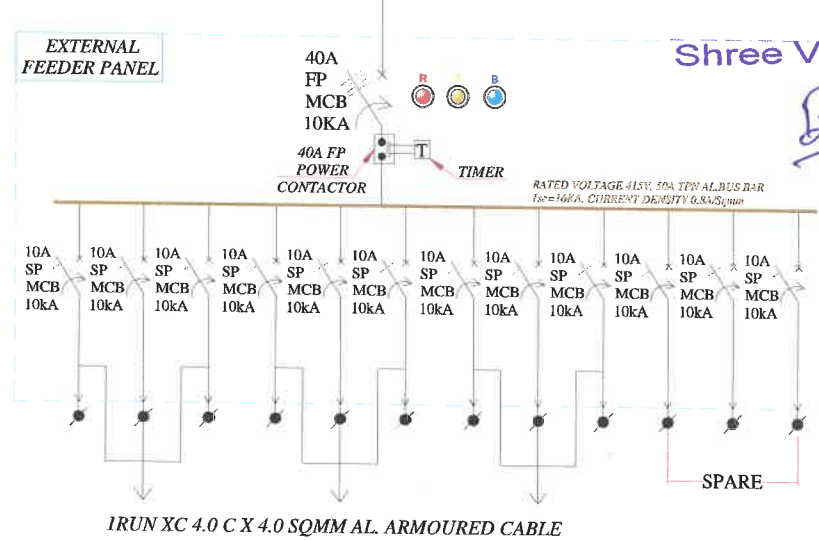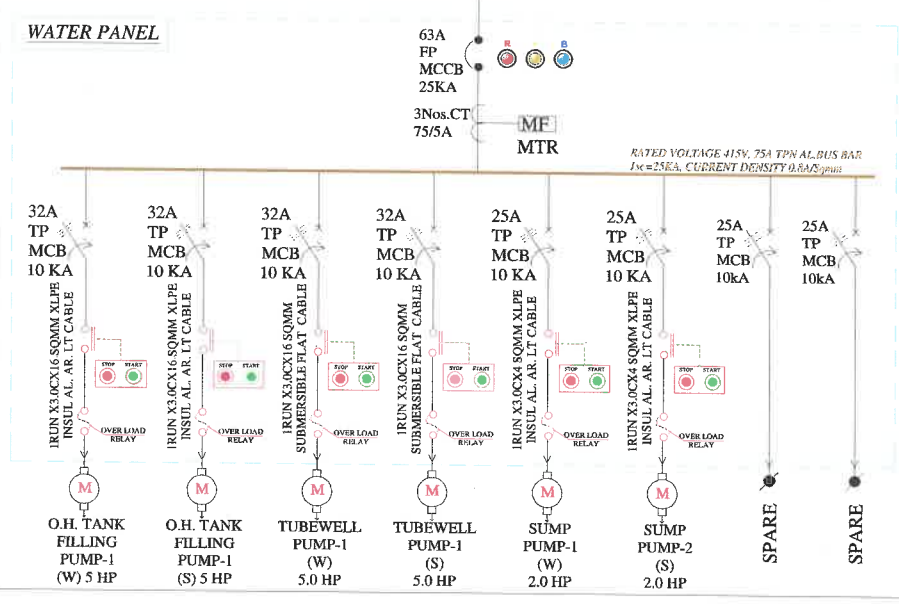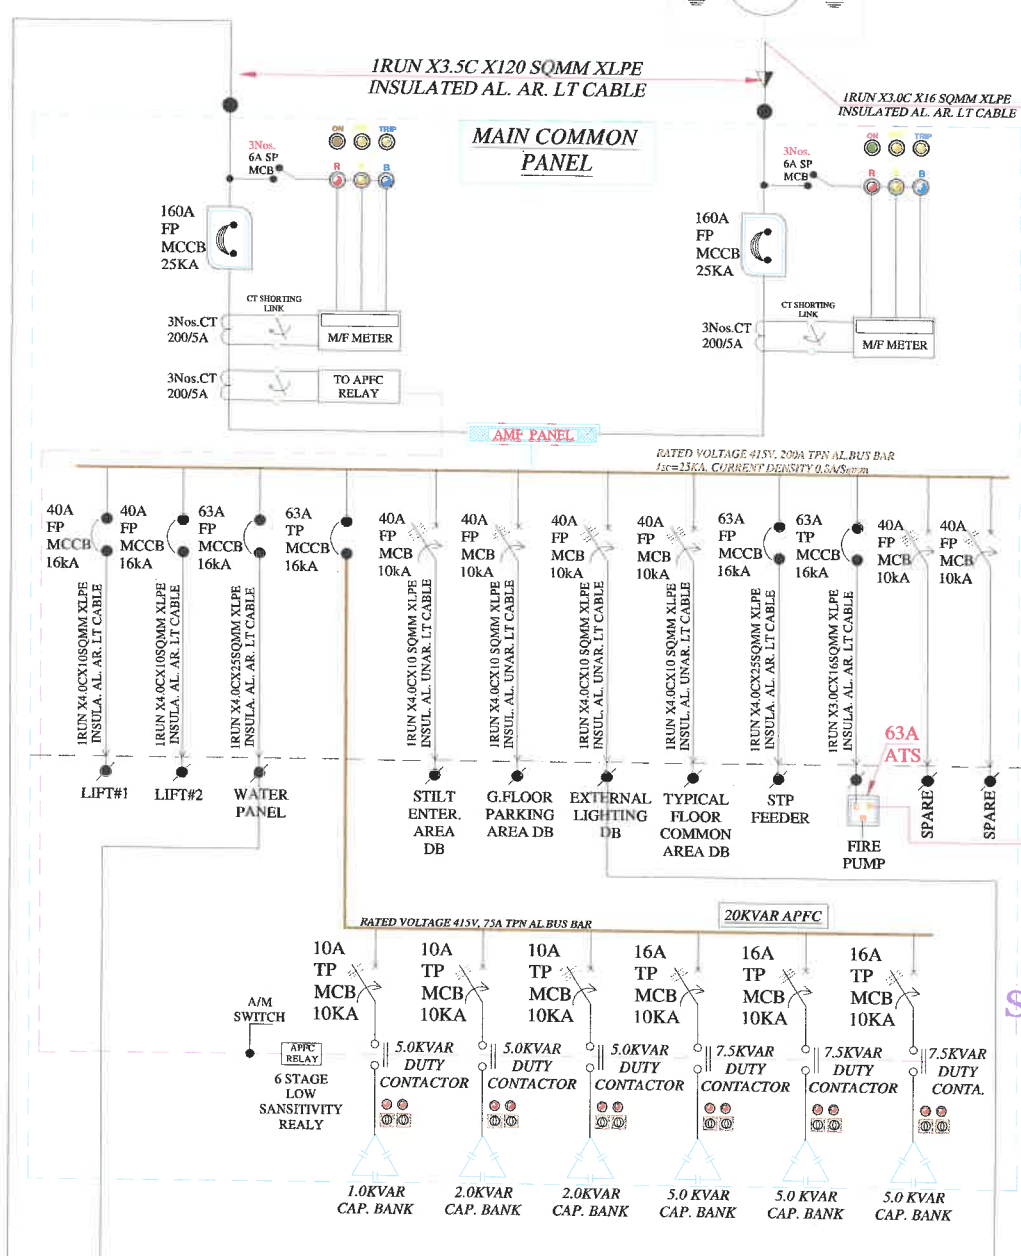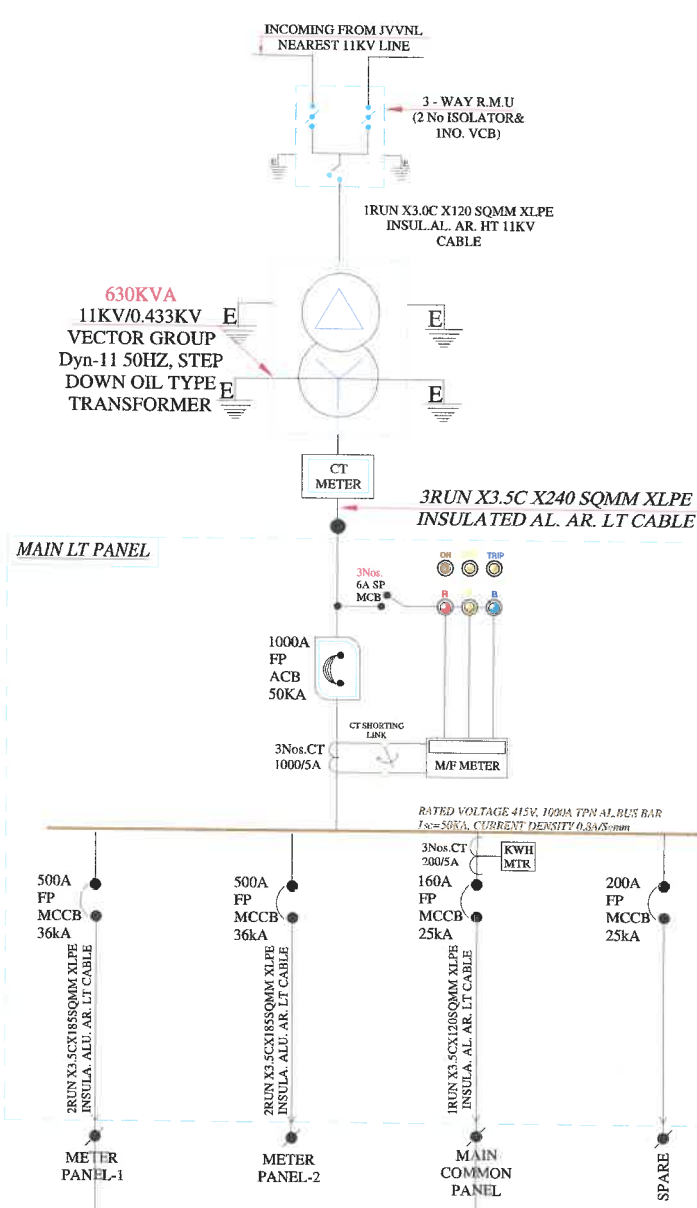

MEP CONSULTANT:
ASHI ASSOCIATES
F 9-440, KESHAV MARG,
CHITRAKUT SCHEME, JAIPUR
PH: 93146-10438, 2440946
E MAIL: vipul8599@yahoo.com

PROJECT NAME:

NAKSHATRA

PROMOTER:

SHREE VINAYAK BUILDERS

PROJECT ADDRESS :

KHASRA NO. 398/10 AT
VILLAGE MOHANPURA,
TEHSIL- SANGANER, JAIPUR

TITLE: MAIN LT PANELS

DRAWING:

SINGLE LINE DIAGRAM	
DATE:- 05-09-2024	REV:- 00

05-09-2024	00
DRAWN BY:-	

VICKY YADAV

CHECKED BY :-
VIPUL AGARWAL

VIPUL
VIPUL AGARWAL
M.E.P. CONSULTANT
B.E. ELECTRICAL

SHRI KRISHAN
Architect
CA/99/25451

Shree Vinayak Builders

Bennett Partners