


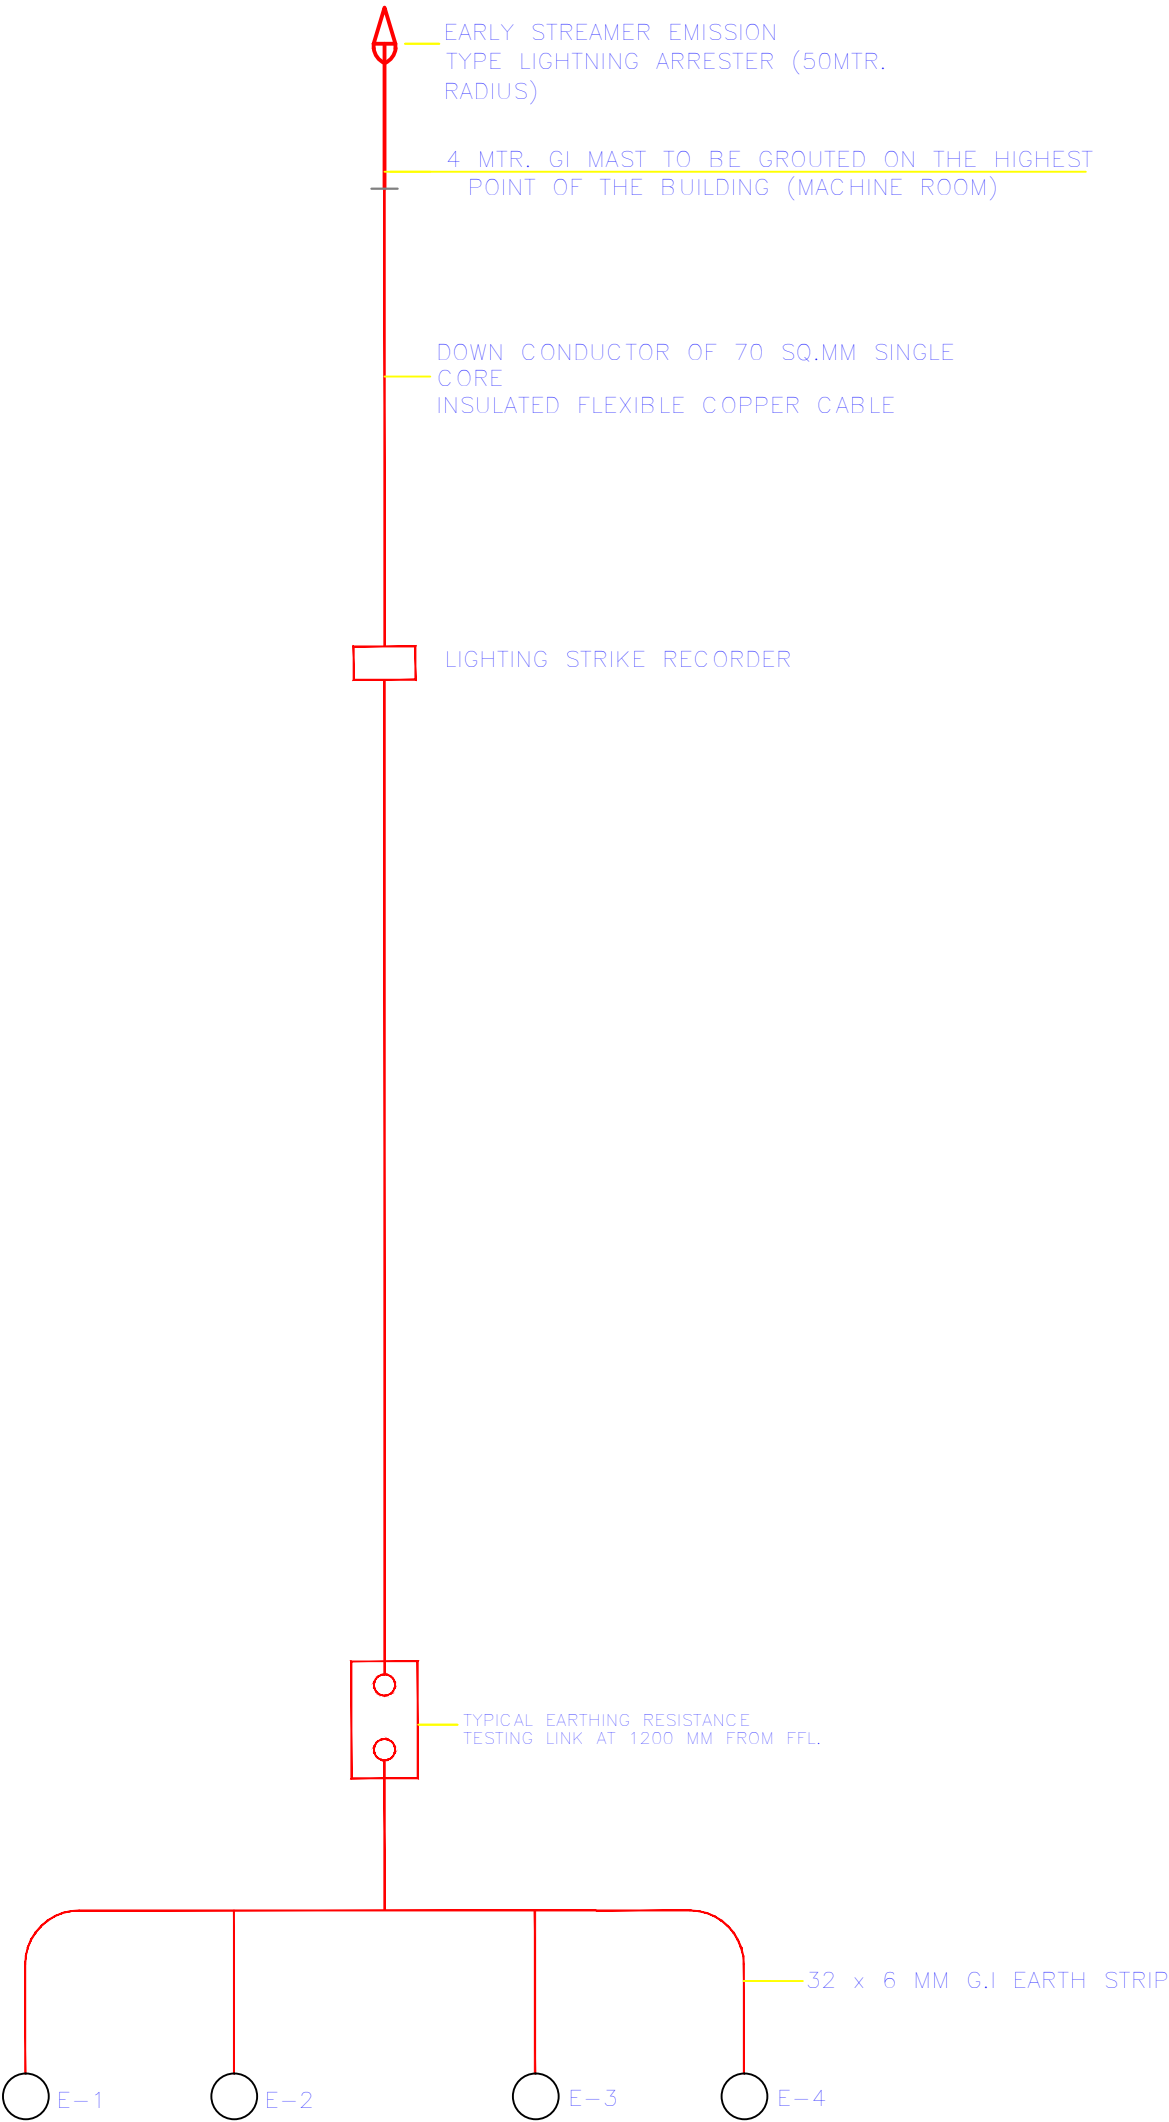

 
SCHEMATIC DIAGRAM
LIGHTNING PROTECTION SYSTEM



LIGHTENING ARRESTOR SLD




RAMESH KUMAWAT
M.E.P. CONSULTANT
B.E. CIVIL



 
Shree Ram Builders and Developers
Partner

PROJECT TITLE :- PROPOSED BUILDING AT PLOT NO.-A-53 & A-54, NARAYANPURI-A, JAIPUR	BUILDING NAME ANANDAM HEIGHTS III	DRAWING TITLE :- LIGHTENING ARRESTOR SLD	SPACE CONSULTANT PLOT-A-173, JAGDAMBA NAGAR, HEERAPURA POWER HOWER, JAIPUR (RAJ) 302024	DRN. BY			NORTH
	DEVELOPER NAME SHREE RAM BUILDERS & DEVELOPERS			APPD. BY		DATE	
				SCALE		REVISION	

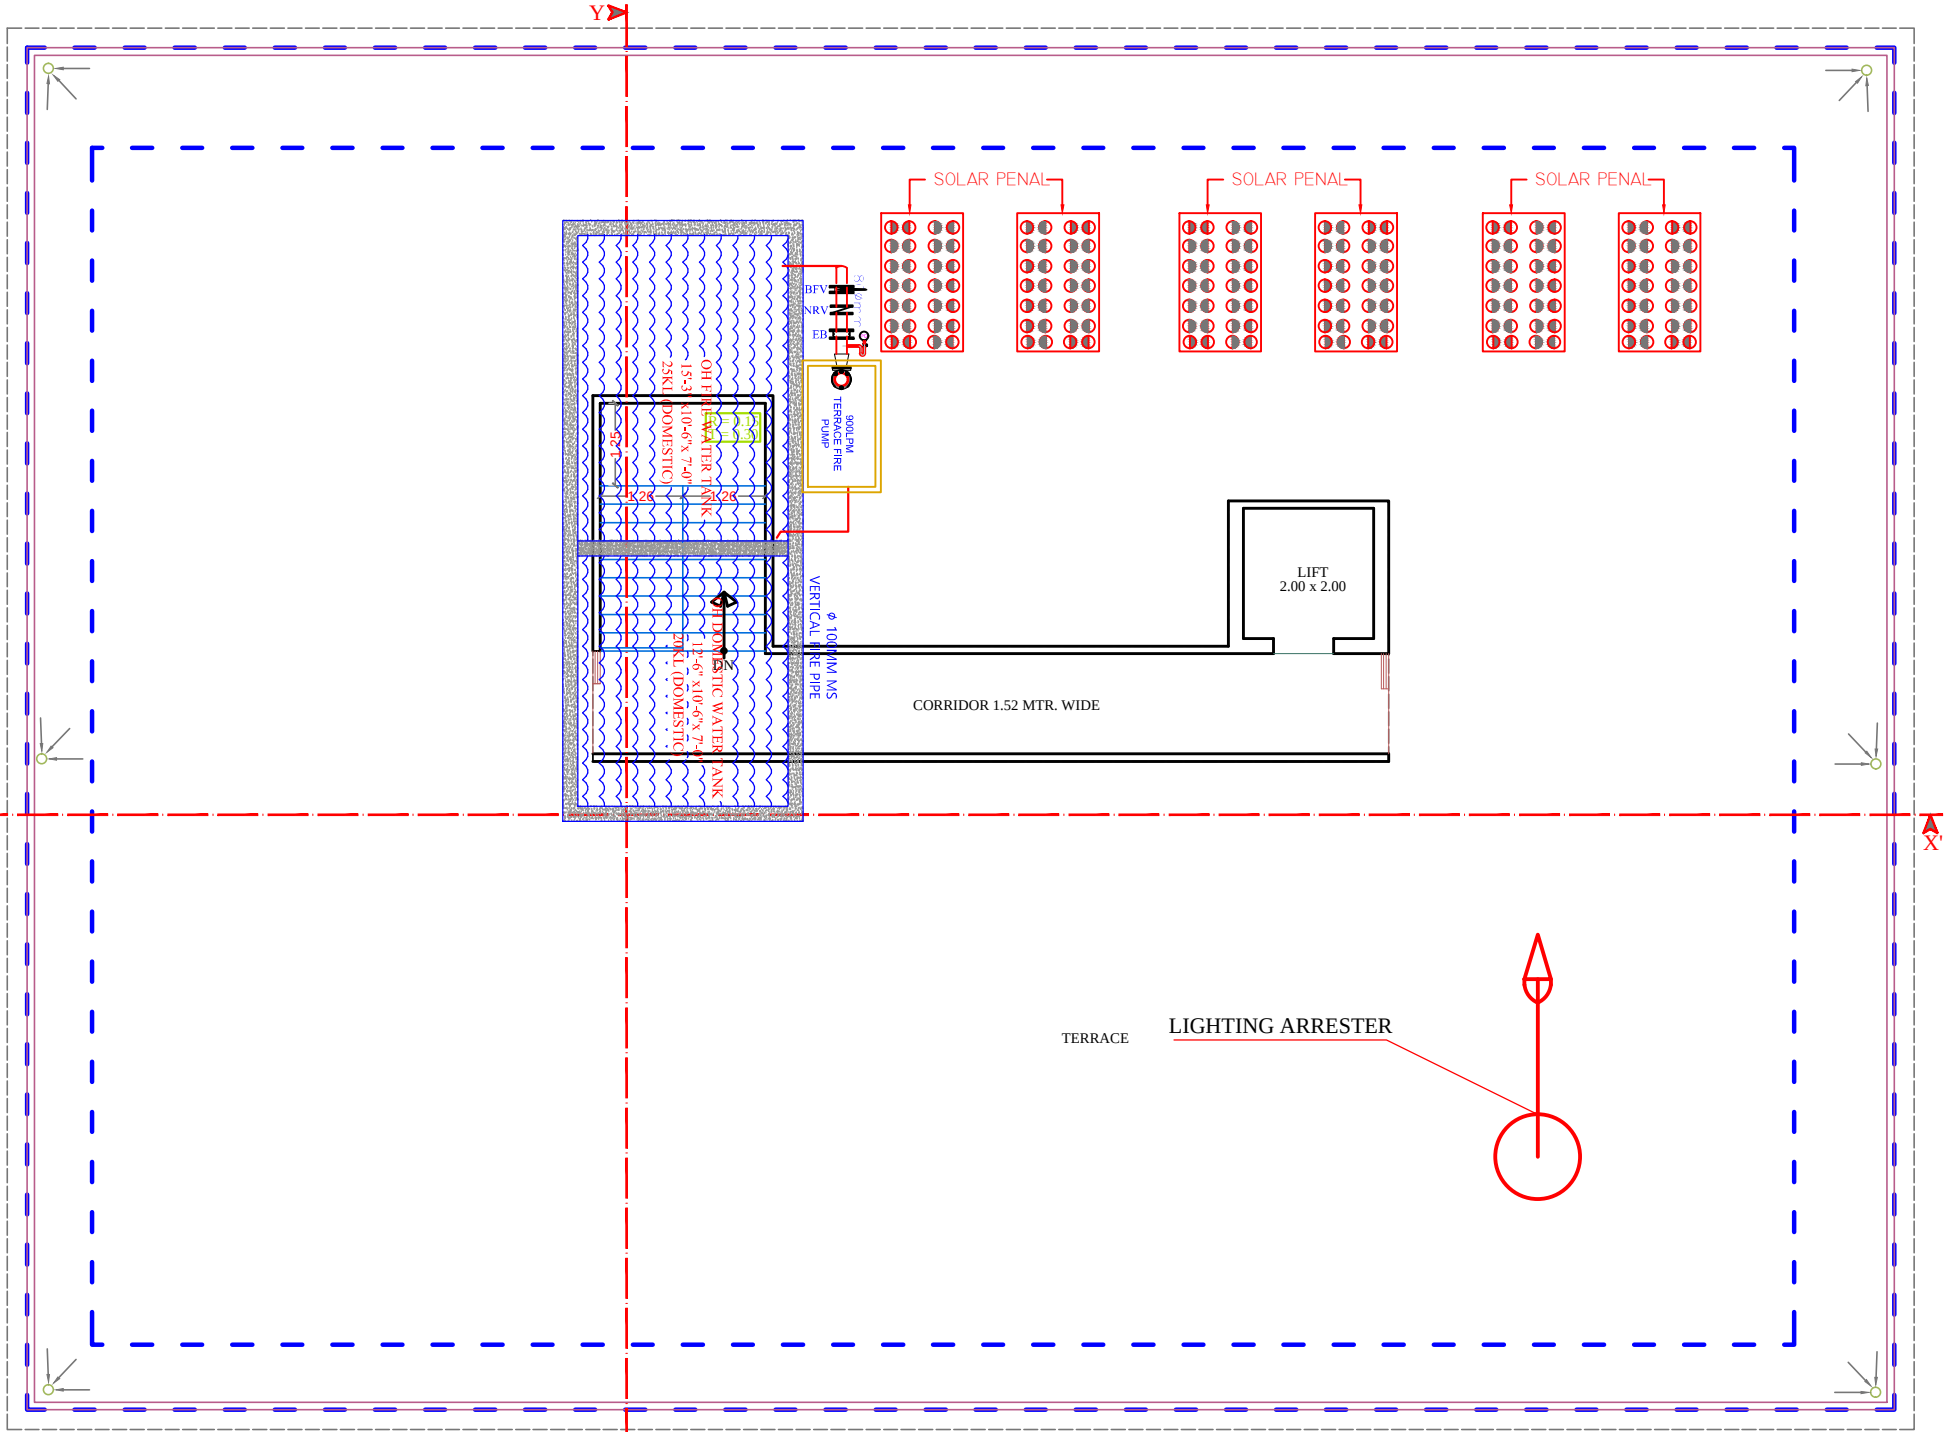

TERRACE FLOOR PLAN


RAMESH KUMAWAT
M.E.P. CONSULTANT
B.E. CIVIL

Shree Ram Builders and Developers

Partner

LEGEND				
	Symbole	DESCRIPTION		
1.		HOSEREEL		
2.		FIRE PIPE		
3.		FIRE PIPE		
4.		FIRE EXTINGUISHER		
5.		EXTERNAL YARD HYDRANT		

PROJECT TITLE :- PROPOSED BUILDING AT PLOT NO.-A-53 & A-54, NARAYANPURI-A, JAIPUR	BUILDING NAME ANANDAM HEIGHTS III		DRAWING TITLE :- TERRACE FLOOR LIGHTING ARRESTER LOCATION	SPACE CONSULTANT PLOT-A-173, JAGDAMBA NAGAR, HEERAPURA POWER HOWER, JAIPUR (RAJ) 302024	DRN. BY			NORTH
	DEVELOPER NAME SHREE RAM BUILDERS & DEVELOPERS						DATE	
							REVISION	
							SCALE	