
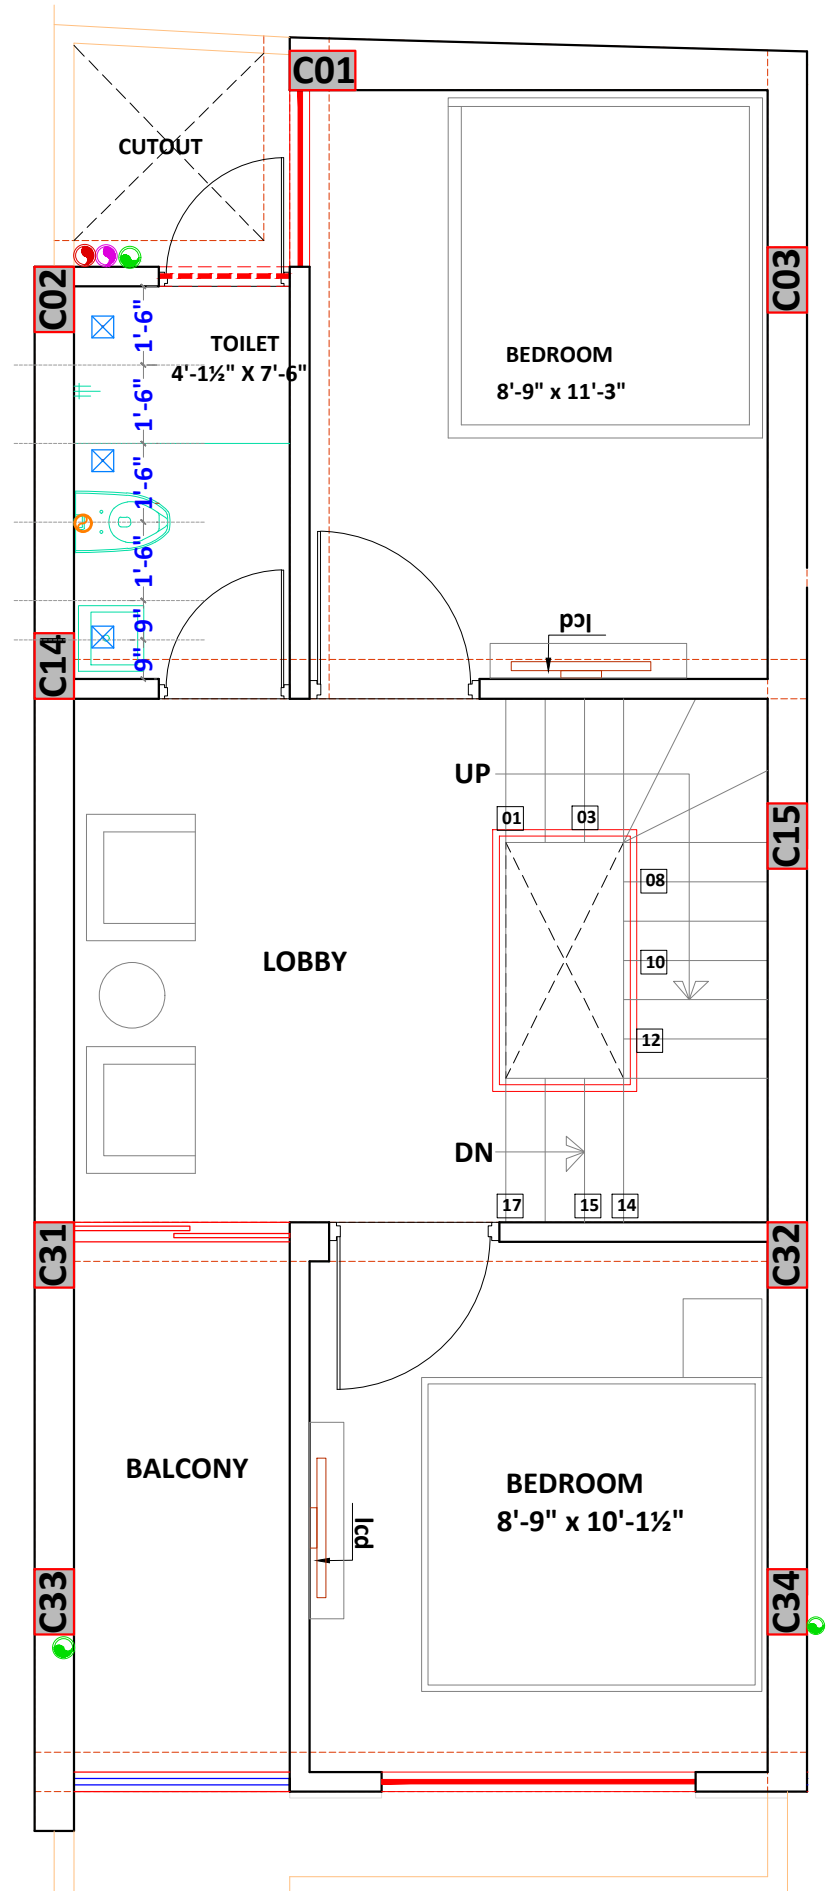


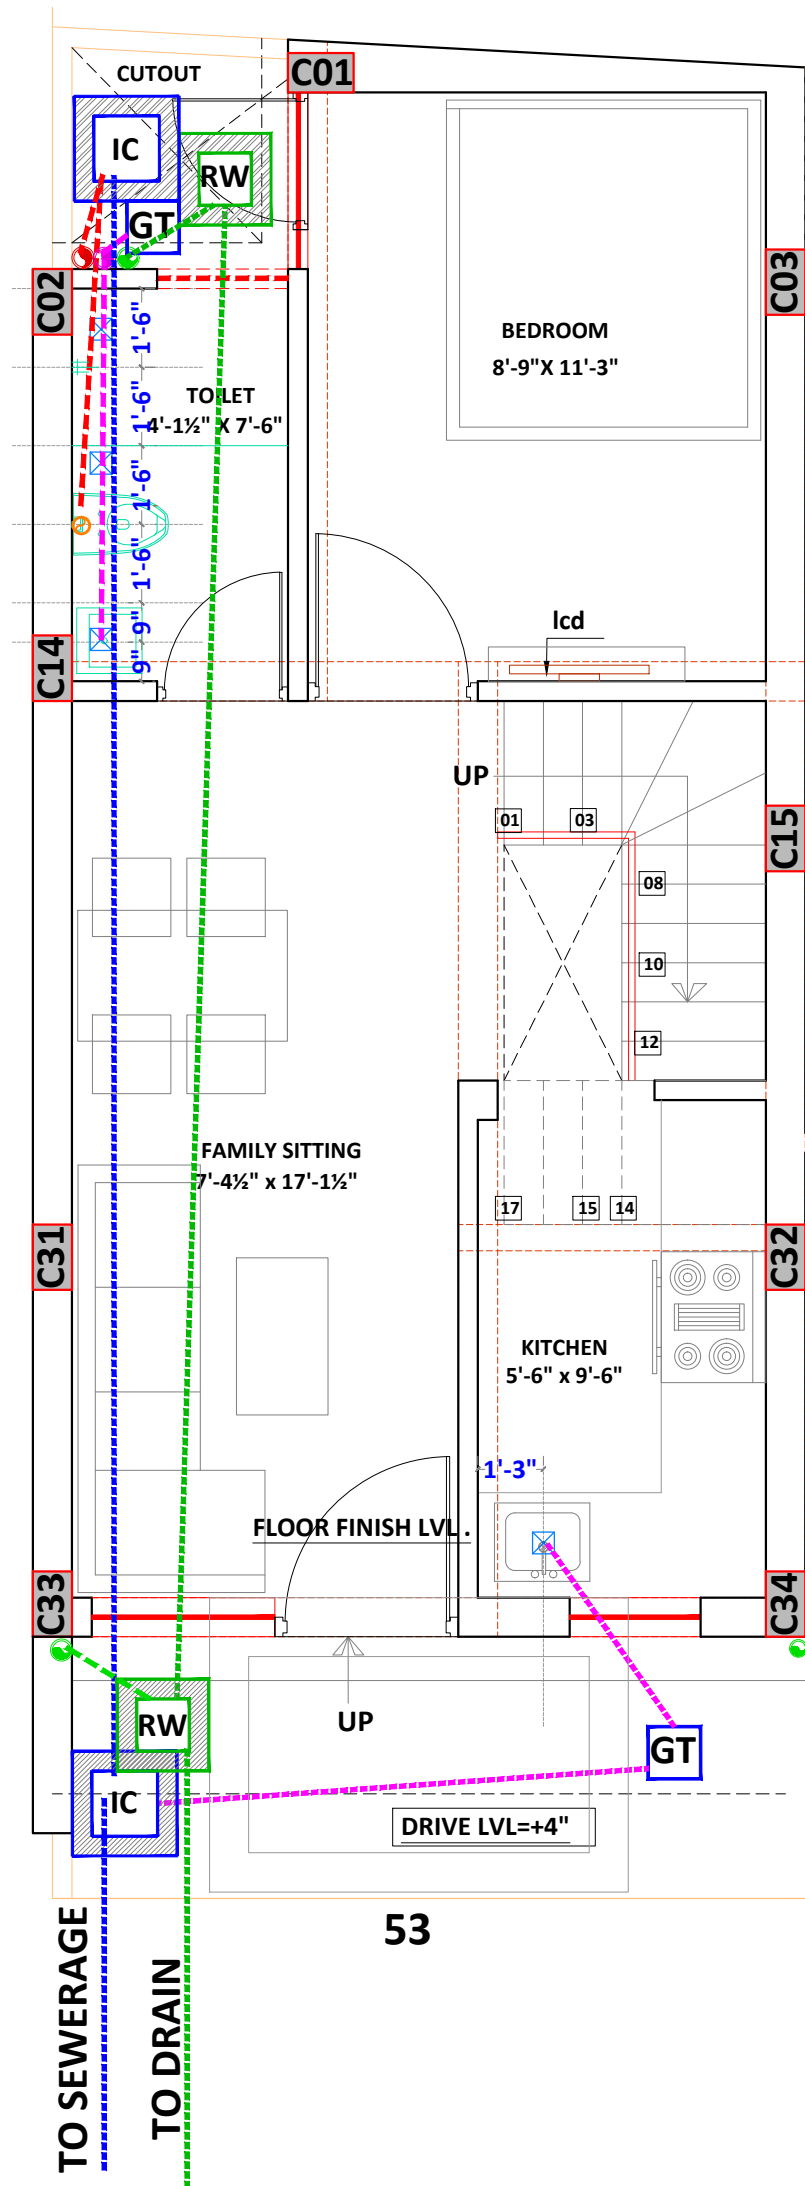

Pukhraj Jain
PUKHRAJ JAIN
Chartered Accountant (I)
AM-091/71-5
Registered Valuer (FIRV)
Car-I /F-2907

Project:
PROPOSED LAYOUT PLAN OF
CHEIF MINISTER JAN AVAS YOJNA-2015
PROVISION 3B" KHASRA NO- 231/6,
233/5 AT REVENUE- VILLAGE-KANAKPURA,
TEH.-JAIPUR, JAIPUR

Architect

Applicant:

Drawing Title:

SANITARY LAYOUT
PLOT NO. 53

Scale:



1:100

North:



SANSKRITI

Architects Interiors Engineers Valuers
26 A FRIENDS COLONY-II, LAL KOTHI
TONK ROAD, JAIPUR - 302015
p: 0141 2742294, 4036248-49
e: sanskriti.arch@gmail.com
w: www.sanskritiarchitects.com

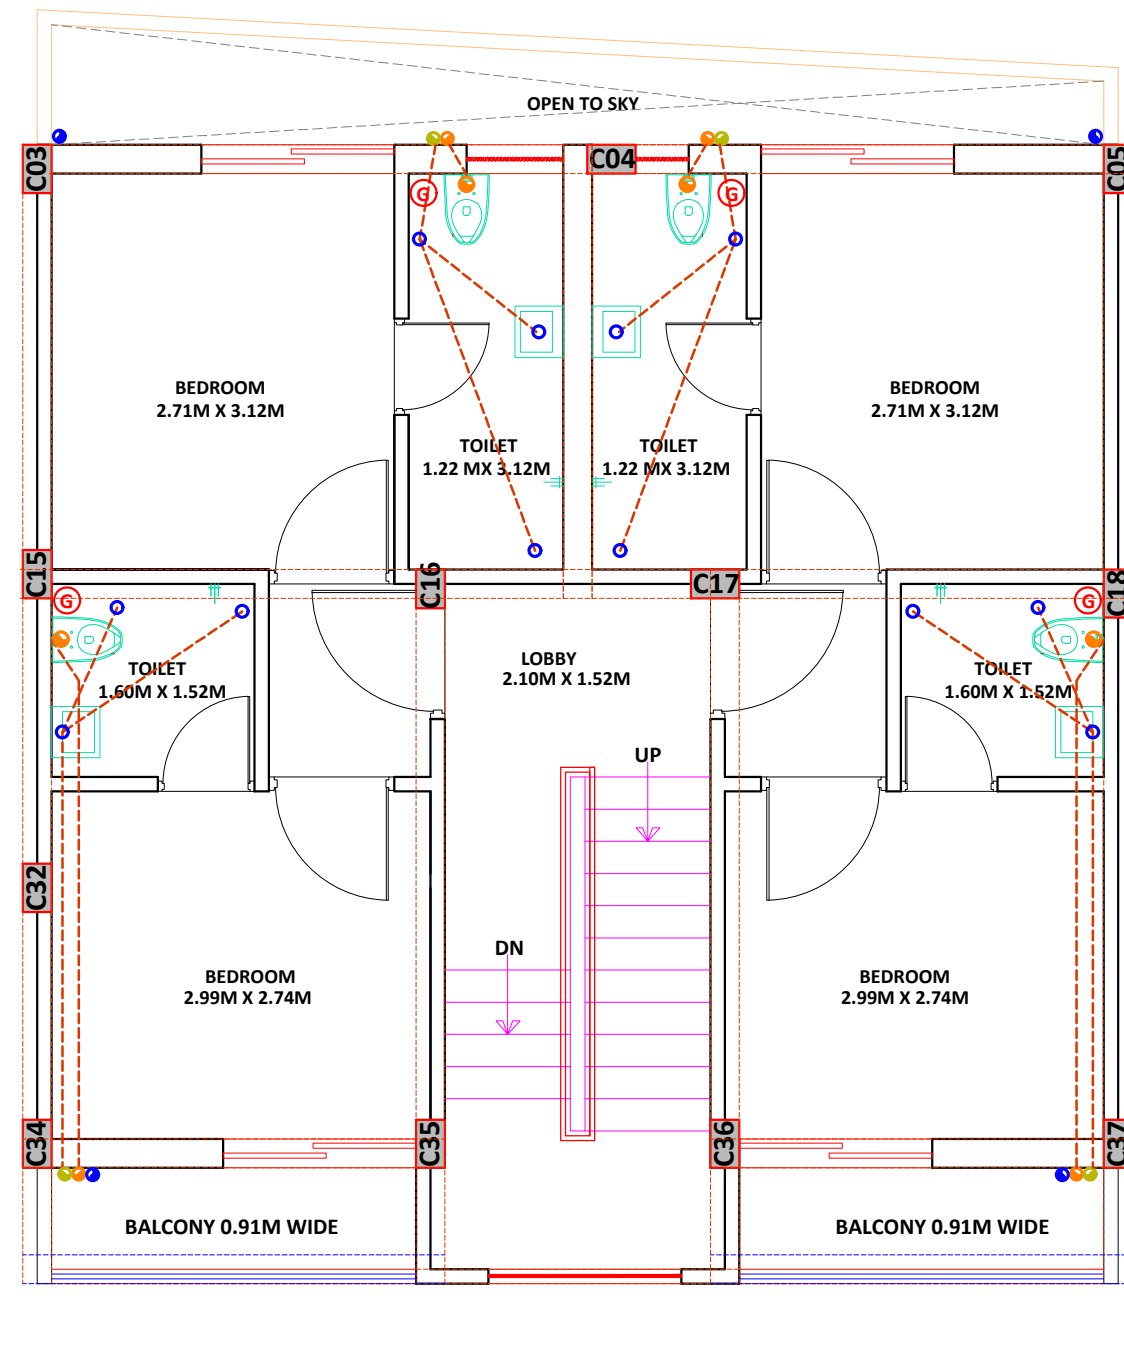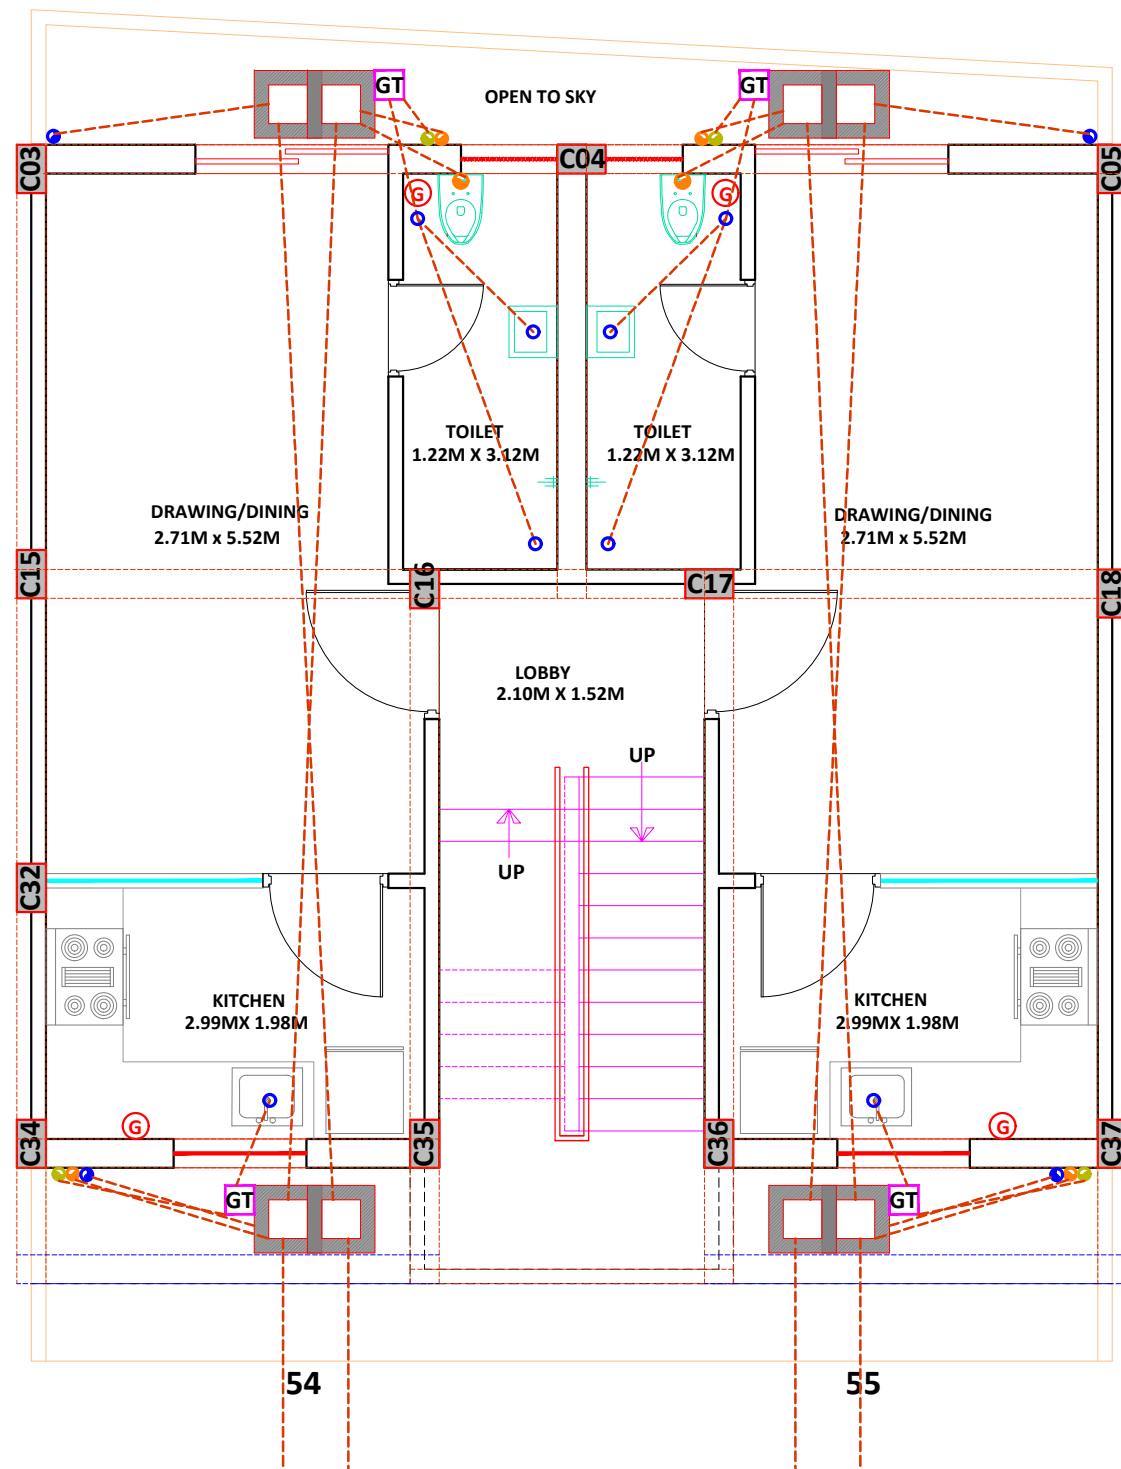

Project:

PROPOSED LAYOUT PLAN OF"
CHEIF MINISTER JAN AVAS YOJNA-2015
PROVISION 3B" KHASRA NO- 231/6,
233/5 AT REVENUE- VILLAGE-KANAKPURA,
TEH.-JAIPUR, JAIPUR

Architect

PUKHRAJ JAIN
Architect
AM-093/71-8
Registered Valuer (RVR)
Can't / F-2997

Applicant:

Drawing Title:

SANITARY LAYOUT

PLOT NO. 54 & 55

Scale:



1:100

North:



SANSKRITI

Architects Interiors Engineers Valuers
26 A FRIENDS COLONY-II, LAL KOTHI
TONK ROAD, JAIPUR - 302015
p: 0141 2742294, 4036248-49
e: sanskriti.arch@gmail.com
w: www.sanskritiarchitects.com

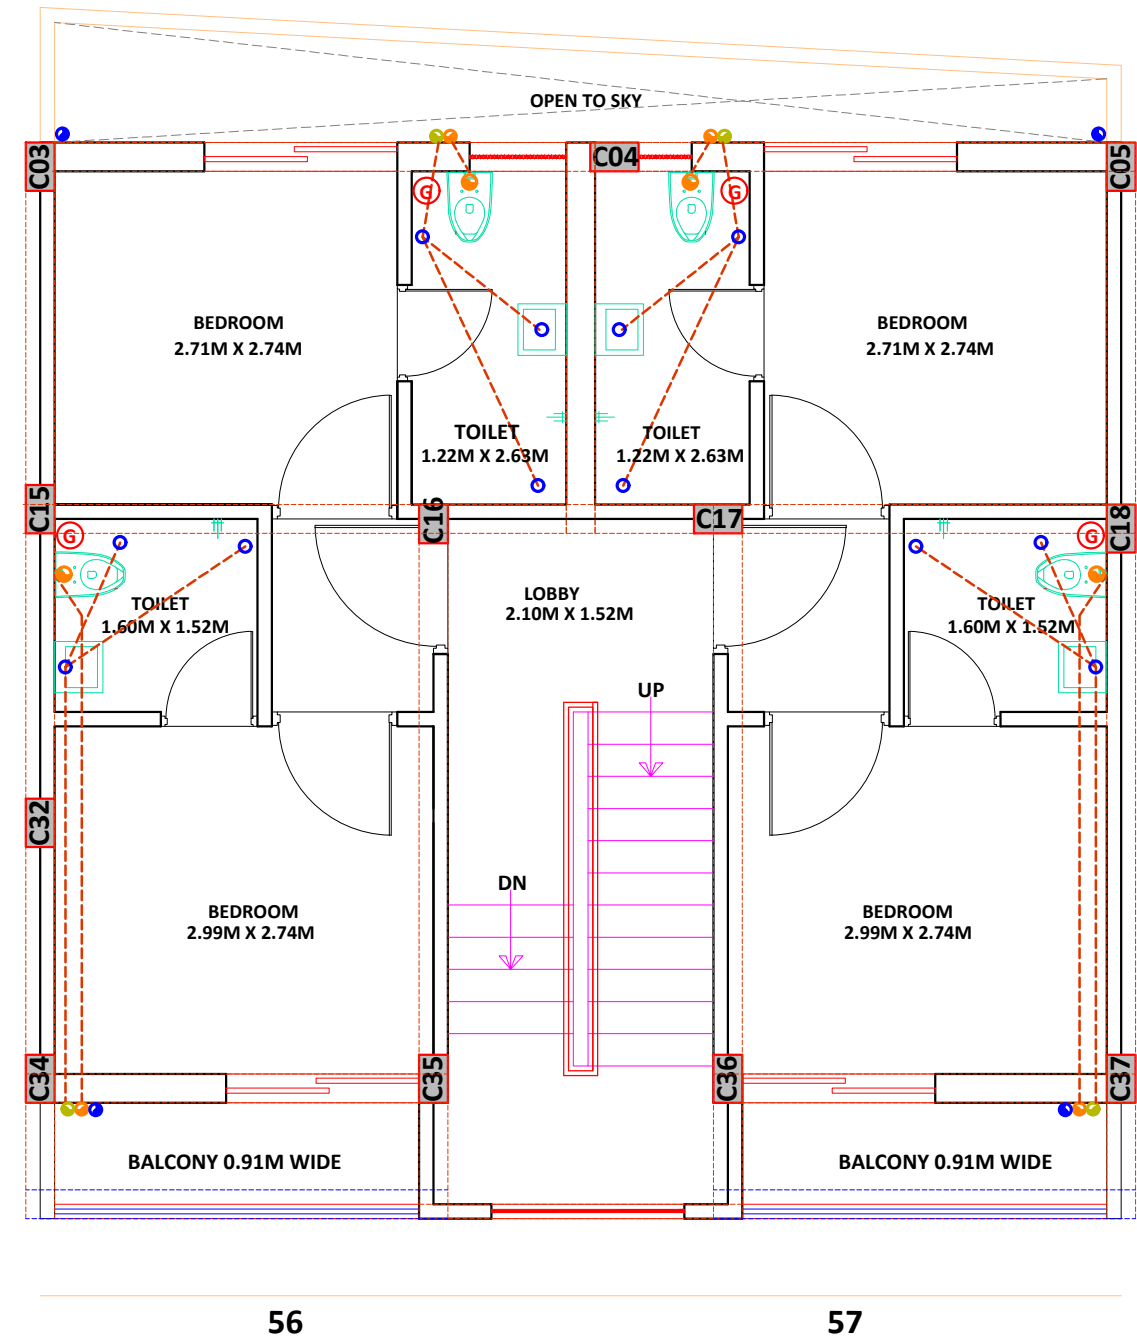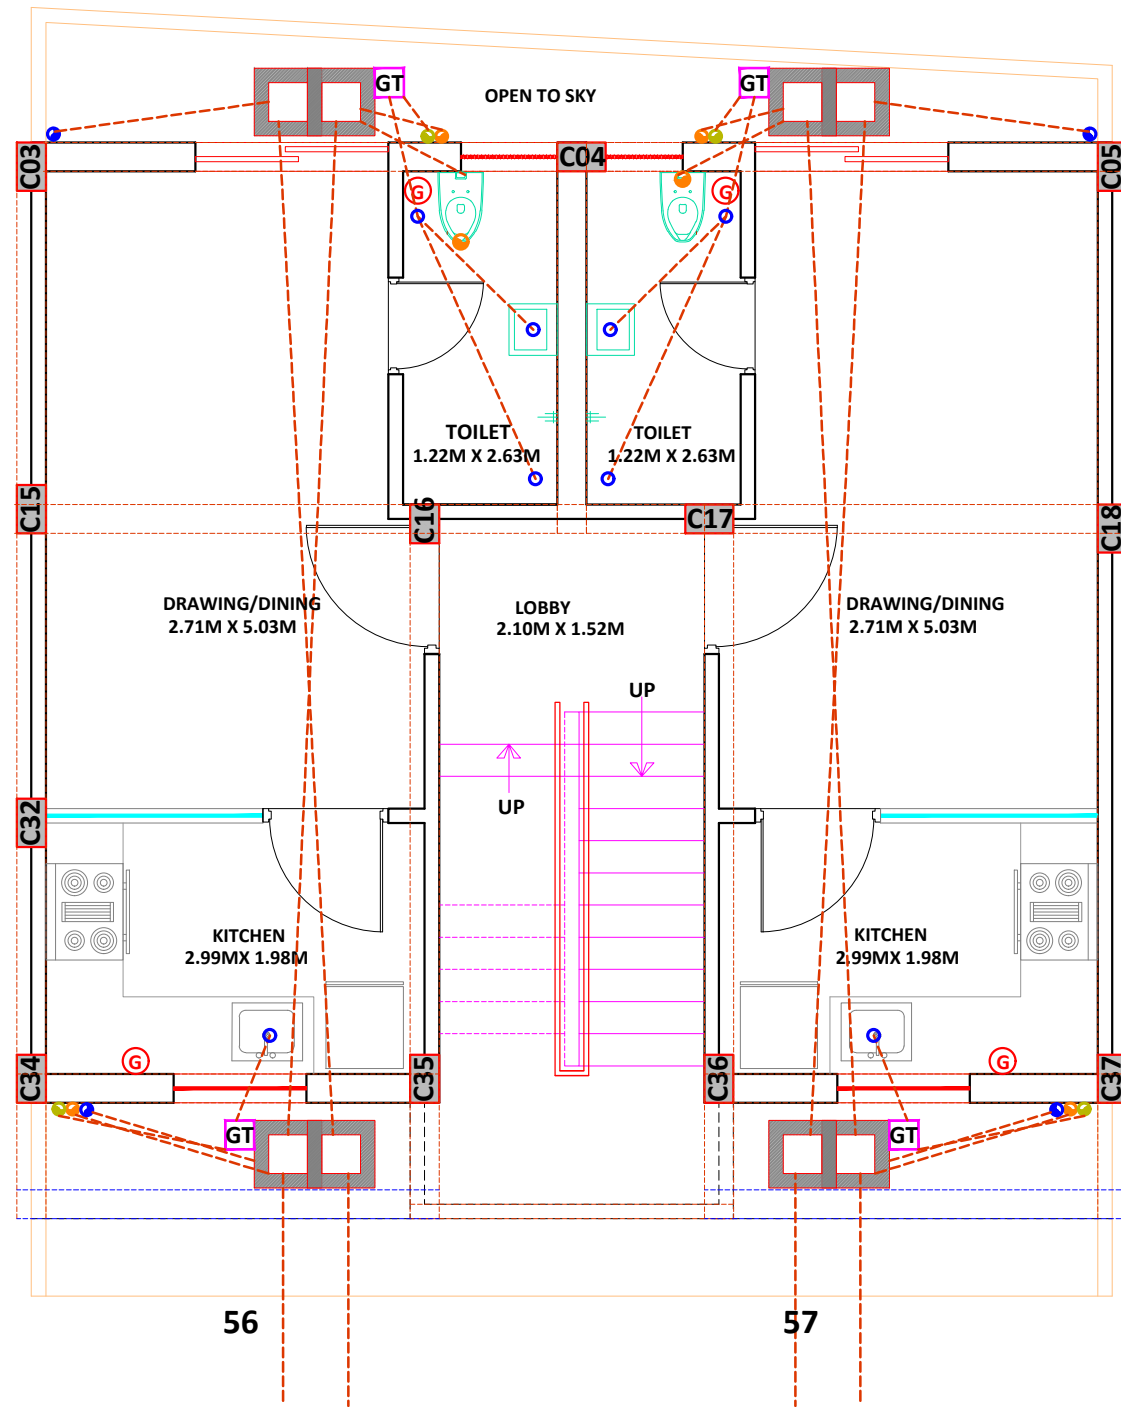

Project:

PROPOSED LAYOUT PLAN OF"
CHEIF MINISTER JAN AVAS YOJNA-2015
PROVISION 3B" KHASRA NO- 231/6,
233/5 AT REVENUE- VILLAGE-KANAKPURA,
TEH.-JAIPUR, JAIPUR

Architect

PUKHRAJ JAIN
Architect (I)
AIA-0211 (2015)
Registered Valuer (FIRV)
Car-I /F-2907

Applicant:

Drawing Title:

SANITARY LAYOUT

PLOT NO. 56 & 57

Scale:


1:100

North:




SANSKRITI

Architects Interiors Engineers Valuers
26 A FRIENDS COLONY-II, LAL KOTHI
TONK ROAD, JAIPUR - 302015
p: 0141 2742294, 4036248-49
e: sanskriti.arch@gmail.com
w: www.sanskritiarchitects.com

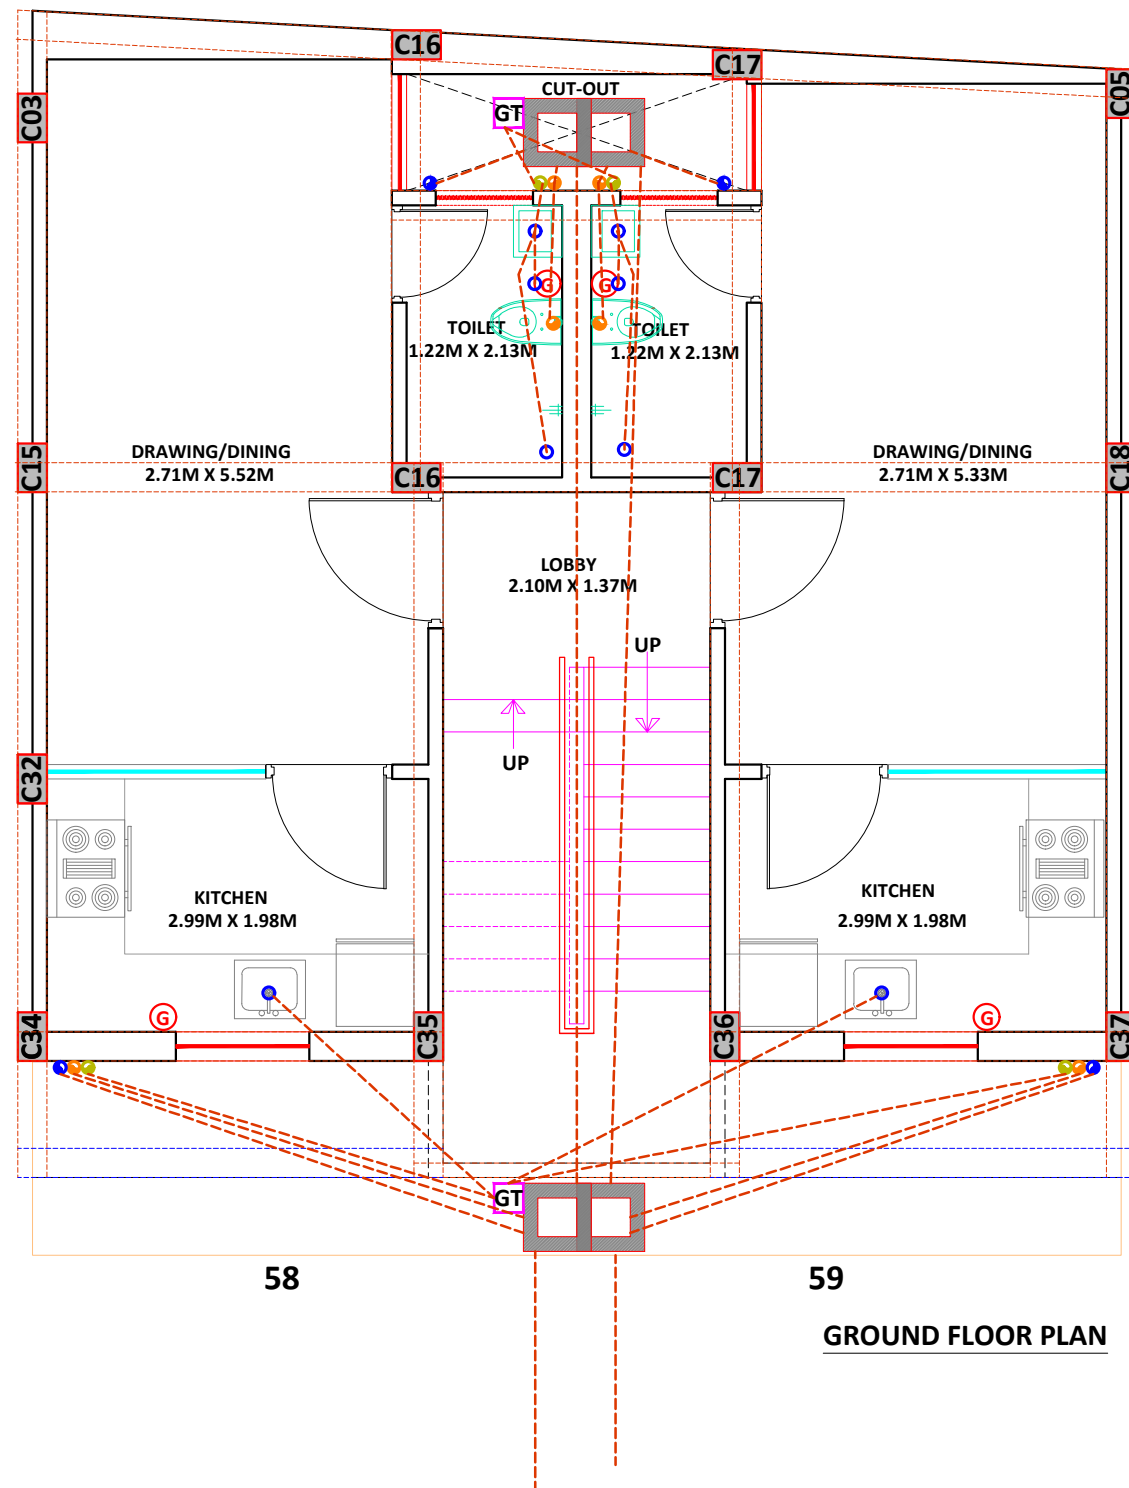

GROUND FLOOR PLAN

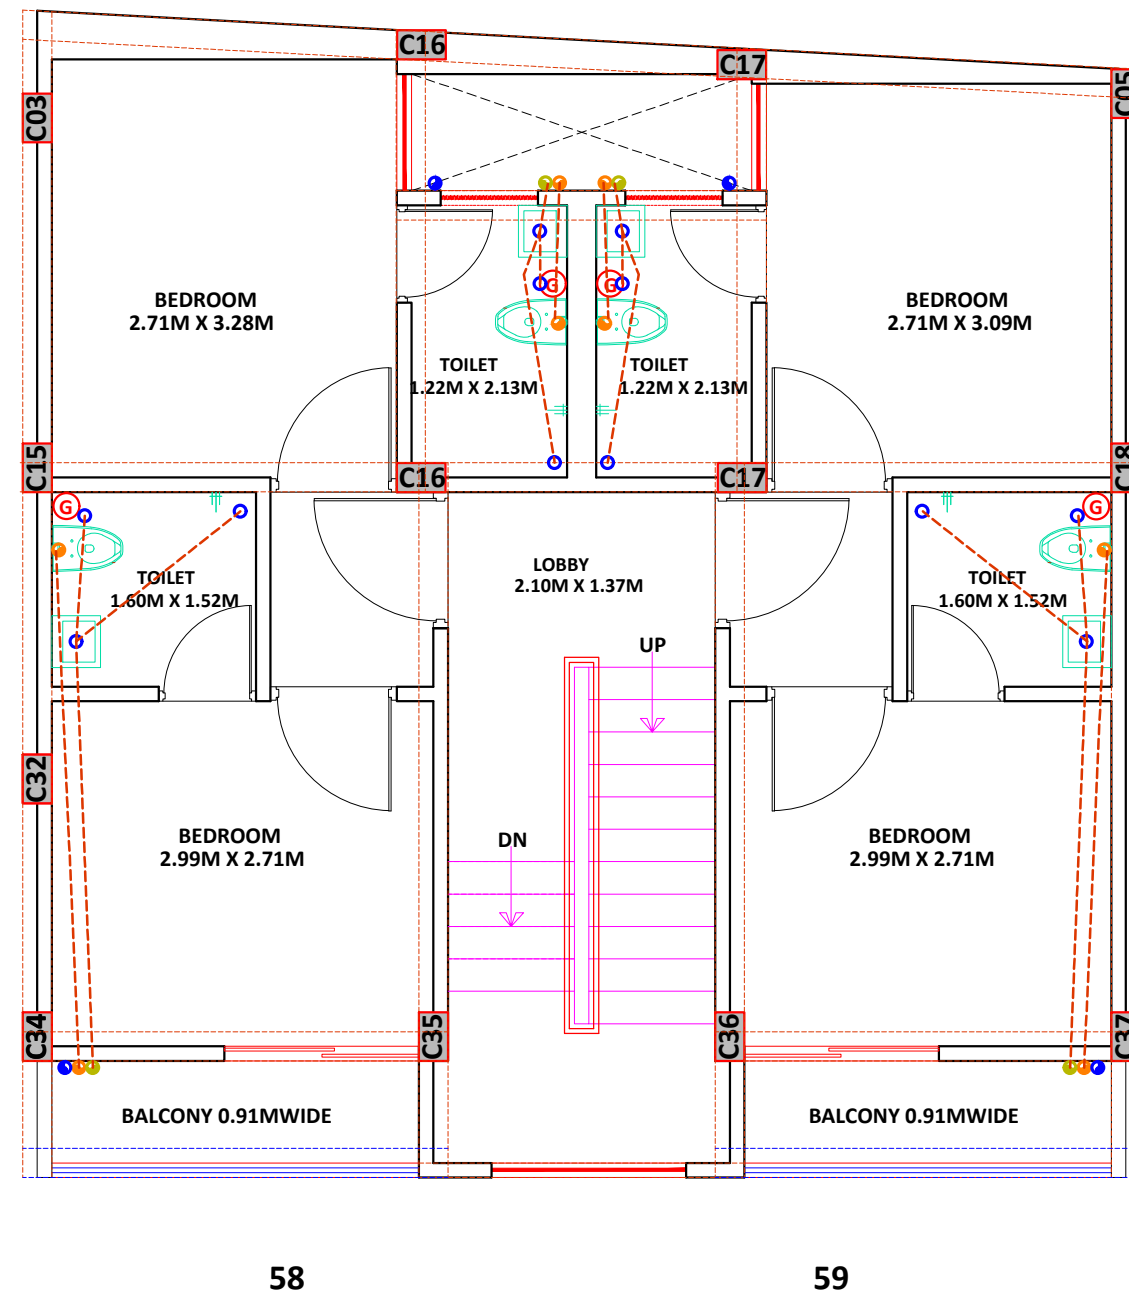

FIRST FLOOR PLAN

Project:

PROPOSED LAYOUT PLAN OF"
CHEIF MINISTER JAN AVAS YOJNA-2015
PROVISION 3B" KHASRA NO- 231/6,
233/5 AT REVENUE- VILLAGE-KANAKPURA,
TEH.-JAIPUR, JAIPUR

Architect

PUKHRAJ JAIN
Architect
AIA-09171-8
Registered Valuer (FIRV)
Car-I / F-2907

Applicant:

Drawing Title:

EWS
SANITARY LAYOUT
PLOT NO. 58 & 59

Scale:



1:100

North:



SANSKRITI

Architects Interiors Engineers Valuers
26 A FRIENDS COLONY-II, LAL KOTHI
TONK ROAD, JAIPUR - 302015
p: 0141 2742294, 4036248-49
e: sanskriti.arch@gmail.com
w: www.sanskritiarchitects.com

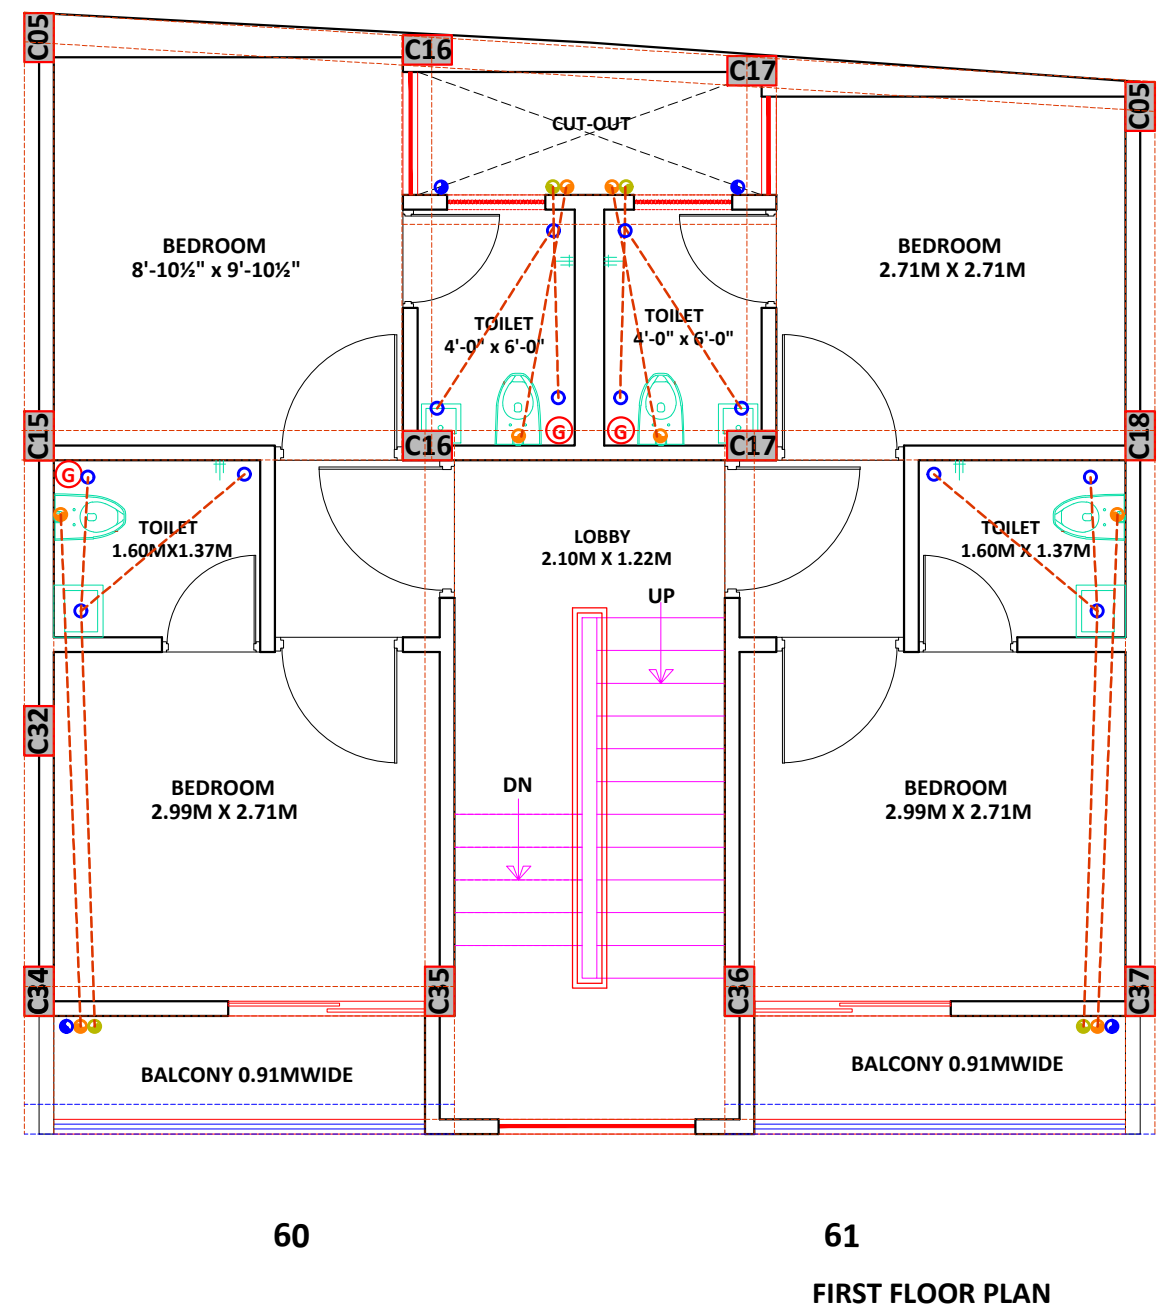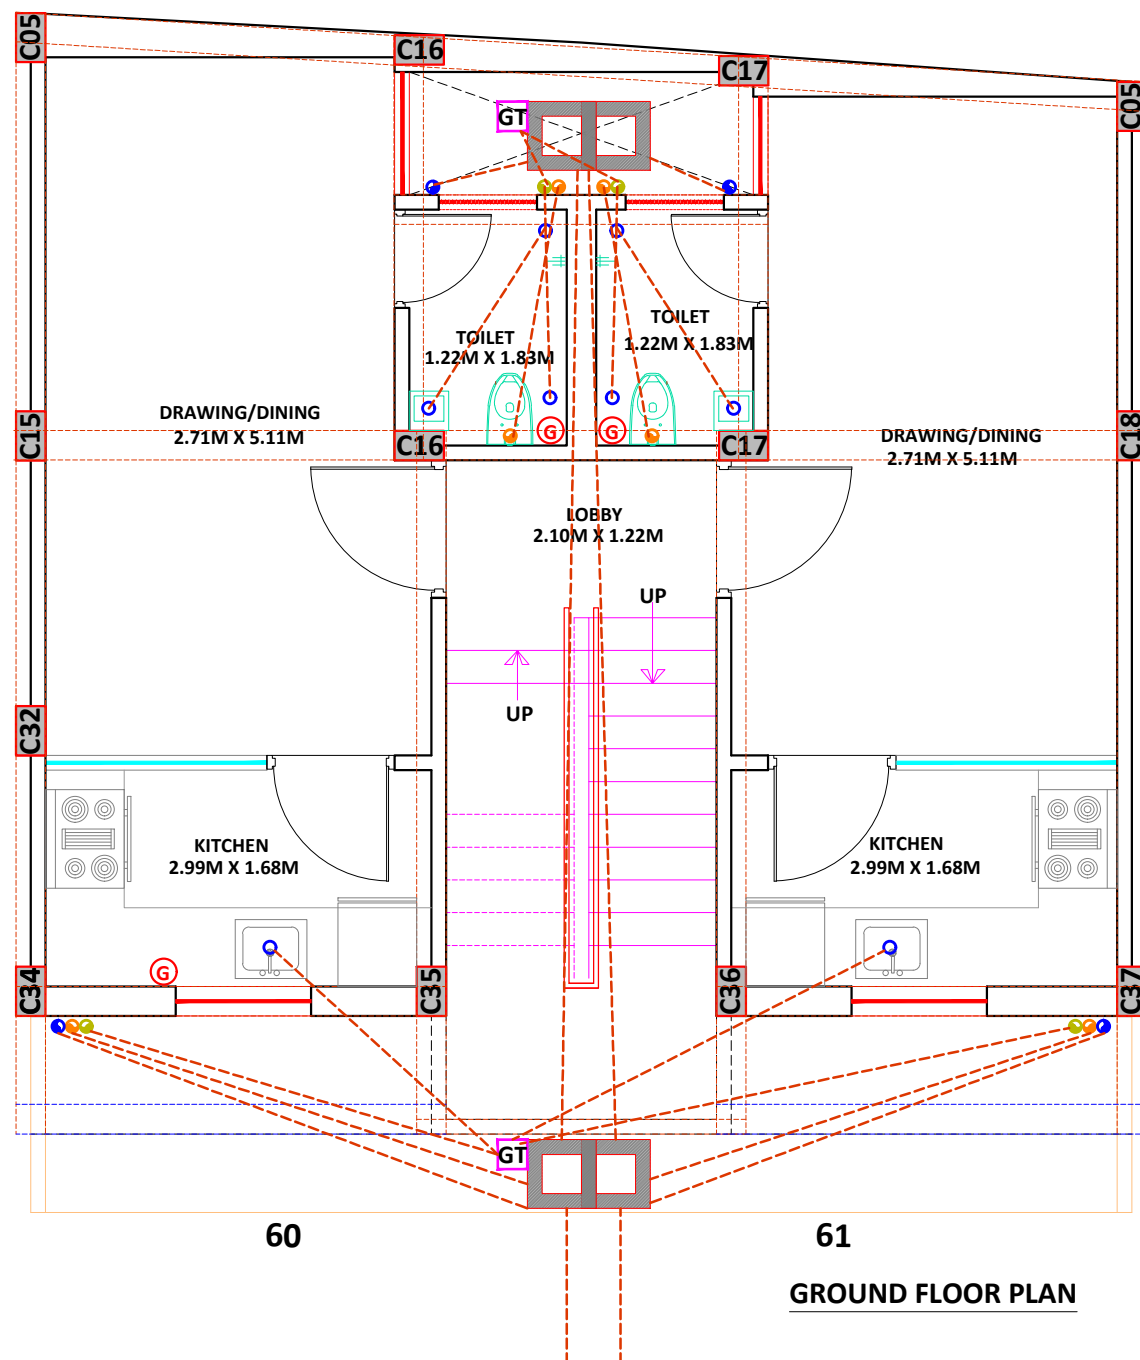

Project:

PROPOSED LAYOUT PLAN OF
CHEIF MINISTER JAN AVAS YOJNA-2015
PROVISION 3B" KHASRA NO- 231/6,
233/5 AT REVENUE- VILLAGE-KANAKPURA,
TEH.-JAIPUR, JAIPUR

Architect

PUKHRA JAIN
Architect (Rajasthan)
AM-691/71-9
(Registered Valuer (RVR))
Car-I/F-2907

Applicant:

Drawing Title:

EWS
SANITARY LAYOUT
PLOT NO. 60 & 61

Scale:


1:100

North:




SANSKRITI

Architects Interiors Engineers Valuers
26 A FRIENDS COLONY-II, LAL KOTHI
TONK ROAD, JAIPUR - 302015
p: 0141 2742294, 4036248-49
e: sanskriti.arch@gmail.com
w: www.sanskritiarchitects.com

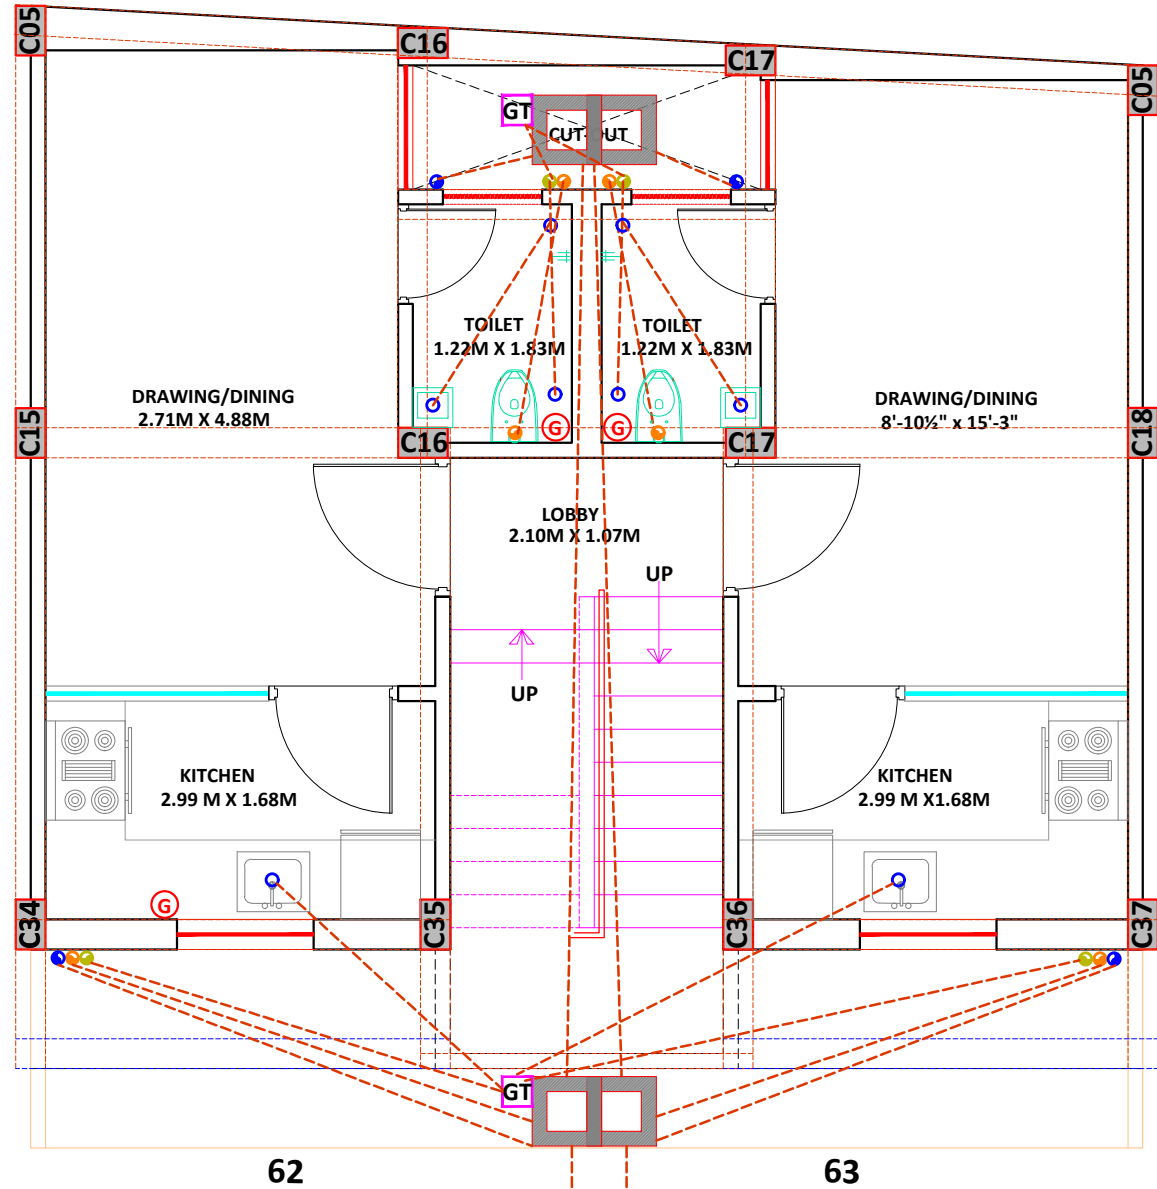

GROUND FLOOR PLAN

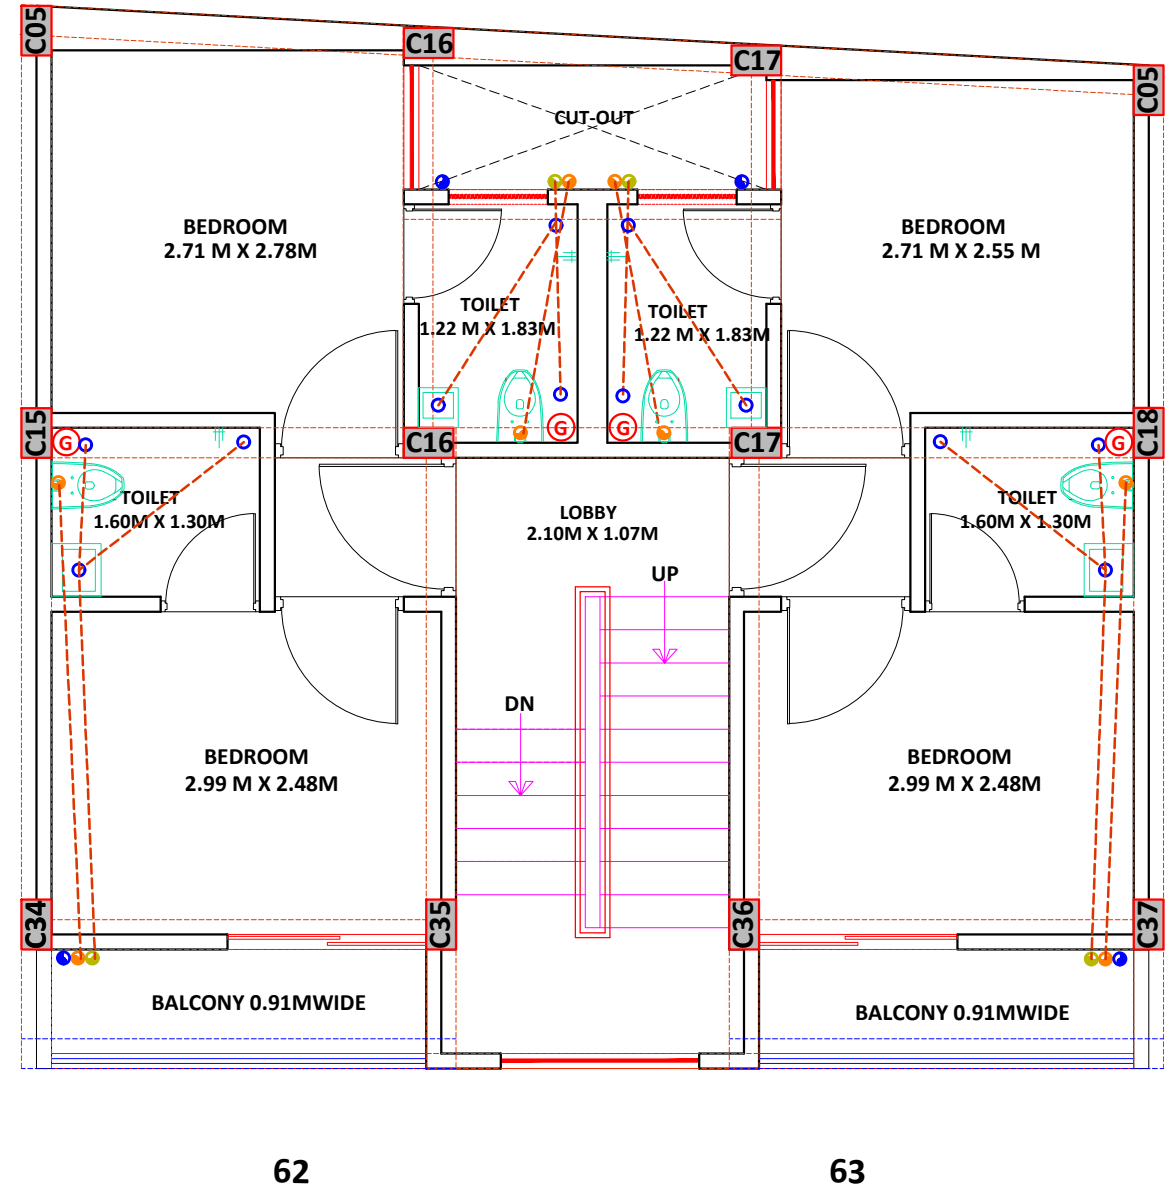

FIRST FLOOR PLAN

Project:

PROPOSED LAYOUT PLAN OF"
CHEIF MINISTER JAN AVAS YOJNA-2015
PROVISION 3B" KHASRA NO- 231/6,
233/5 AT REVENUE- VILLAGE-KANAKPURA,
TEH.-JAIPUR, JAIPUR

Architect

PUKHRAJ JAIN
Architect (I)
ATA-091111-5
Registered Valuer (FIRV)
Car-1/F-2907

Applicant:

Drawing Title:

EWS
SANITARY LAYOUT
PLOT NO. 62 & 63

Scale:


1:100

North:




SANSKRITI

Architects Interiors Engineers Valuers
26 A FRIENDS COLONY-II, LAL KOTHI
TONK ROAD, JAIPUR - 302015
p: 0141 2742294, 4036248-49
e: sanskriti.arch@gmail.com
w: www.sanskritiarchitects.com


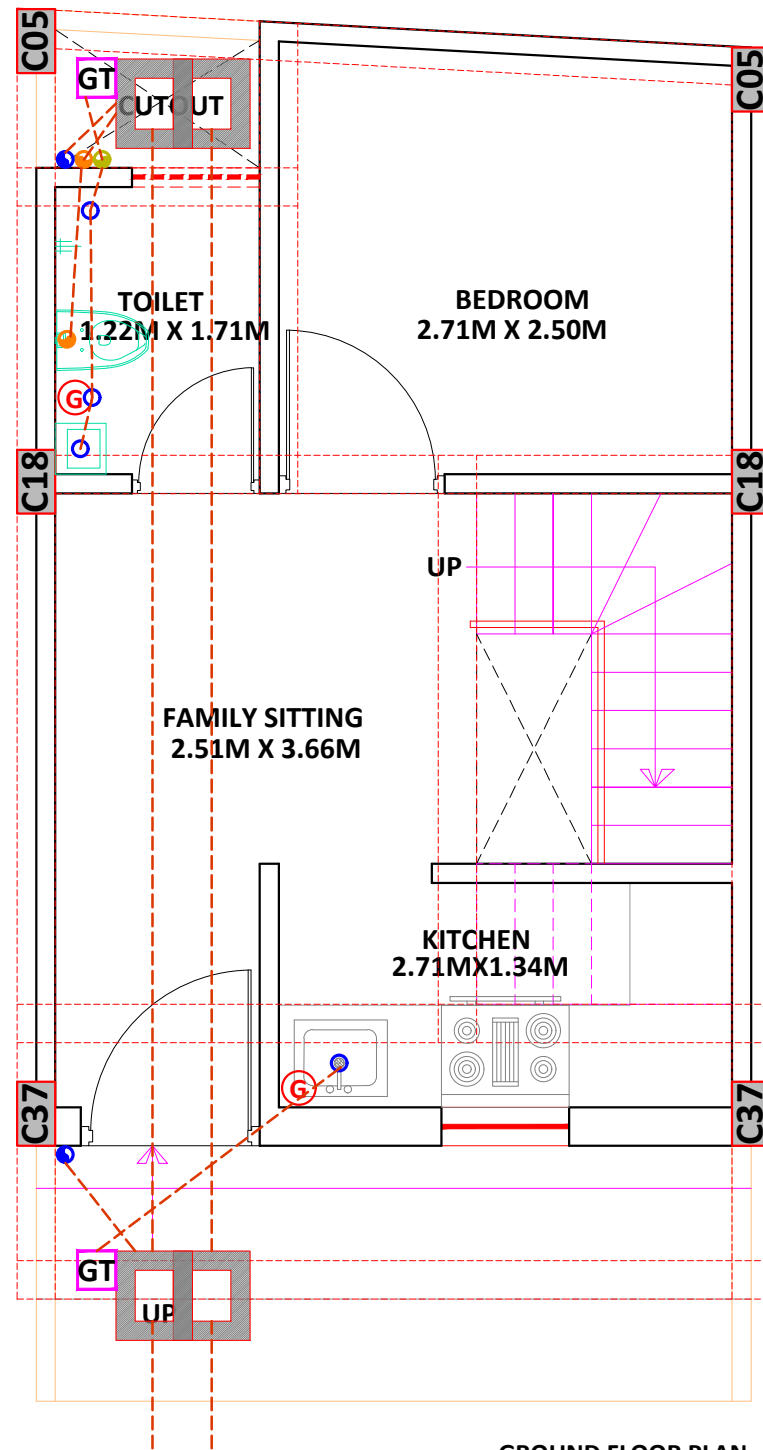


GROUND FLOOR PLAN

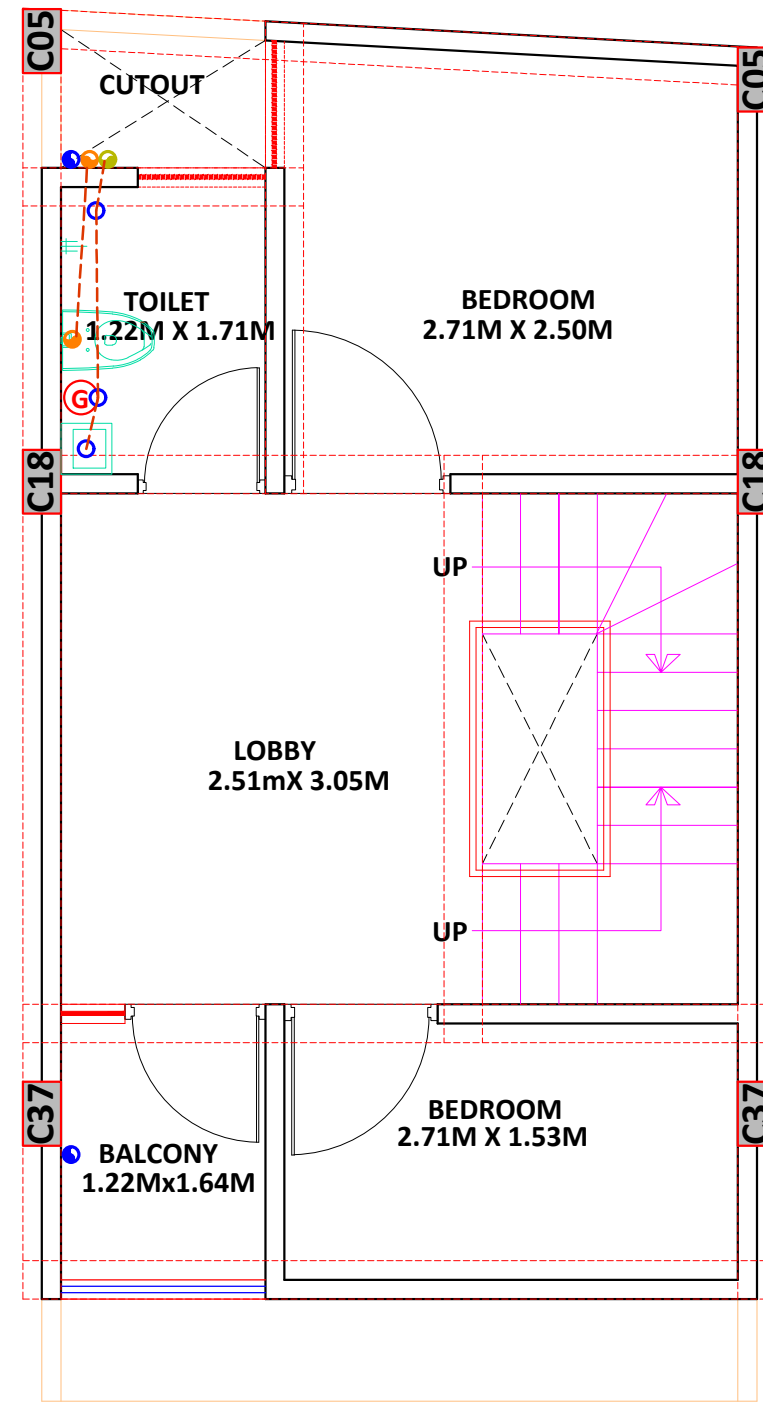

FIRST FLOOR PLAN

Project: PROPOSED LAYOUT PLAN OF" CHEIF MINISTER JAN AVAS YOJNA-2015 PROVISION 3B" KHASRA NO- 231/6, 233/5 AT REVENUE- VILLAGE-KANAKPURA, TEH.-JAIPUR, JAIPUR	Architect  PUKHRAJ JAIN Architect (I) AM-09171-5 Registered Valuer (FIRV) Car-I /F-2907	Applicant:	Drawing Title: EWS SANITARY LAYOUT PLOT NO. 64	Scale: 1:100 North:	 SANSKRITI Architects Interiors Engineers Valuers 26 A FRIENDS COLONY-II, LAL KOTHI TONK ROAD, JAIPUR - 302015 p: 0141 2742294, 4036248-49 e: sanskriti.arch@gmail.com w: www.sanskritiarchitects.com
---	--	-------------------	--	---	---

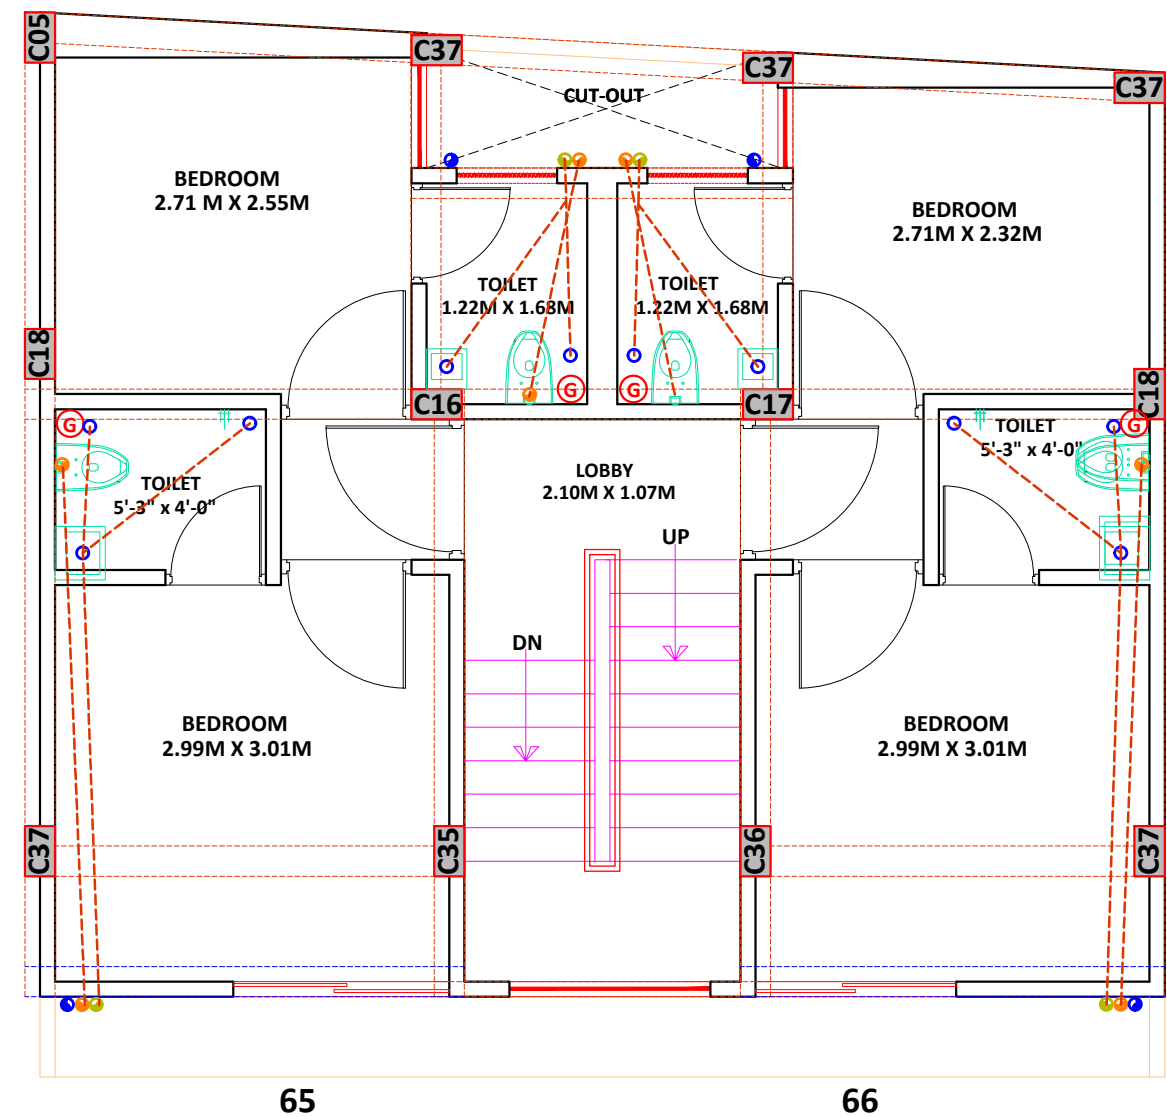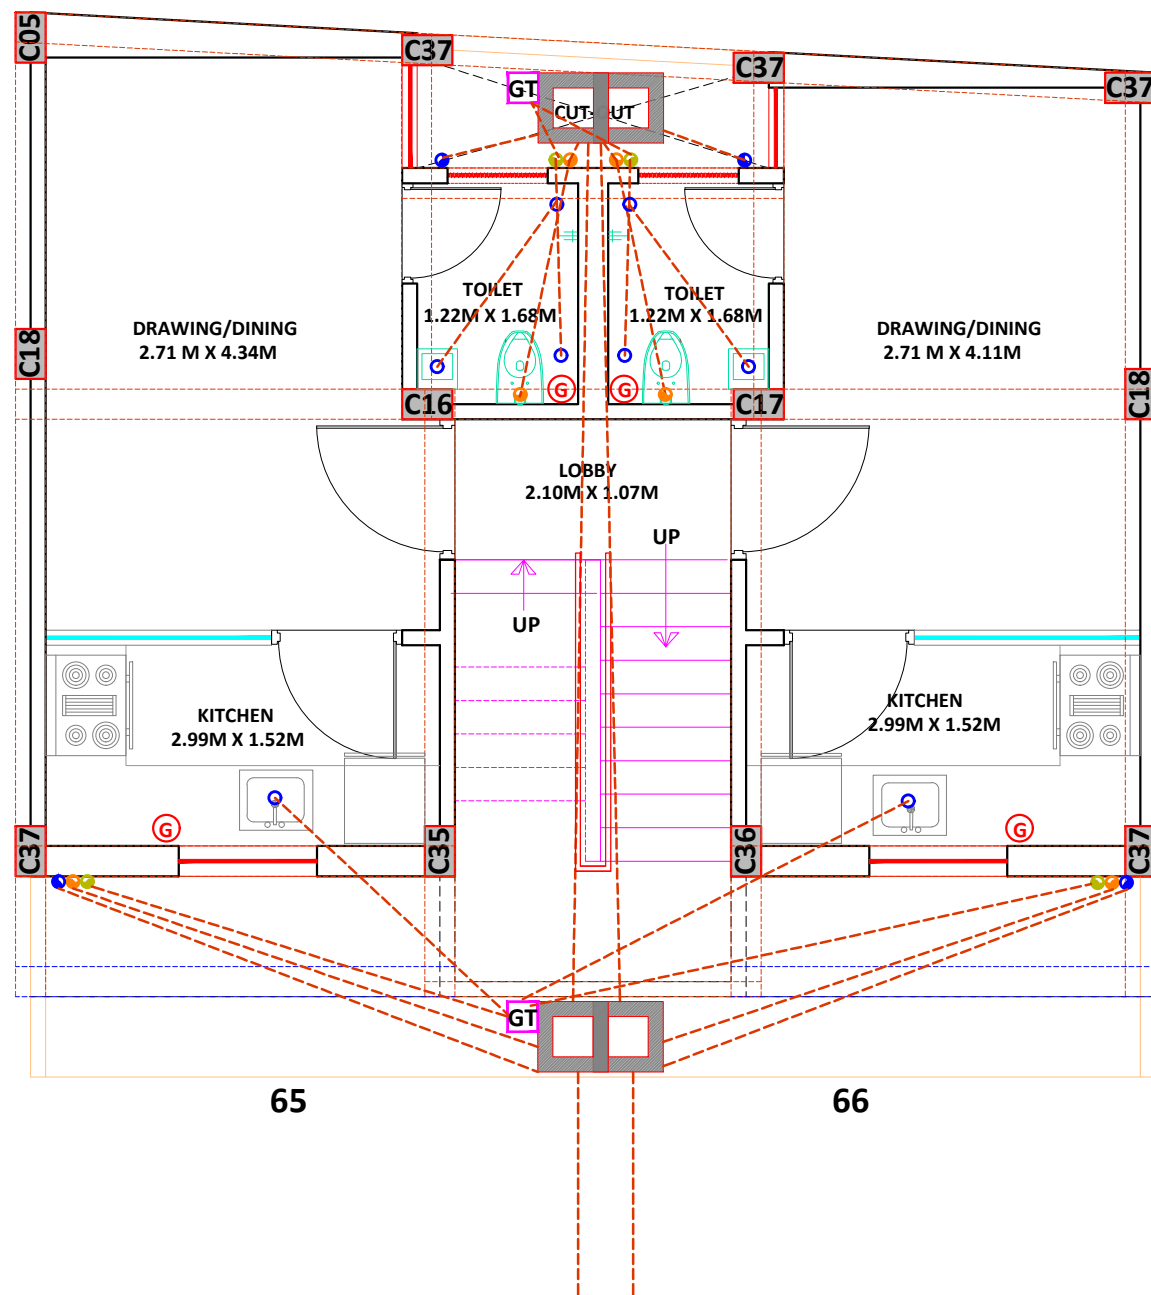

Project:

PROPOSED LAYOUT PLAN OF"
CHEIF MINISTER JAN AVAS YOJNA-2015
PROVISION 3B" KHASRA NO- 231/6,
233/5 AT REVENUE- VILLAGE-KANAKPURA,
TEH.-JAIPUR, JAIPUR

Architect

PUKHRAJ JAIN
Architect (RERA)
Registered Valuer (RVI)
Car-1/F-2997

Applicant:

Drawing Title:

EWS
SANITARY LAYOUT
PLOT NO. 65 & 66

Scale:


1:100

North:




SANSKRITI


Architects Interiors Engineers Valuers
26 A FRIENDS COLONY-II, LAL KOTHI
TONK ROAD, JAIPUR - 302015
p: 0141 2742294, 4036248-49
e: sanskriti.arch@gmail.com
w: www.sanskritiarchitects.com

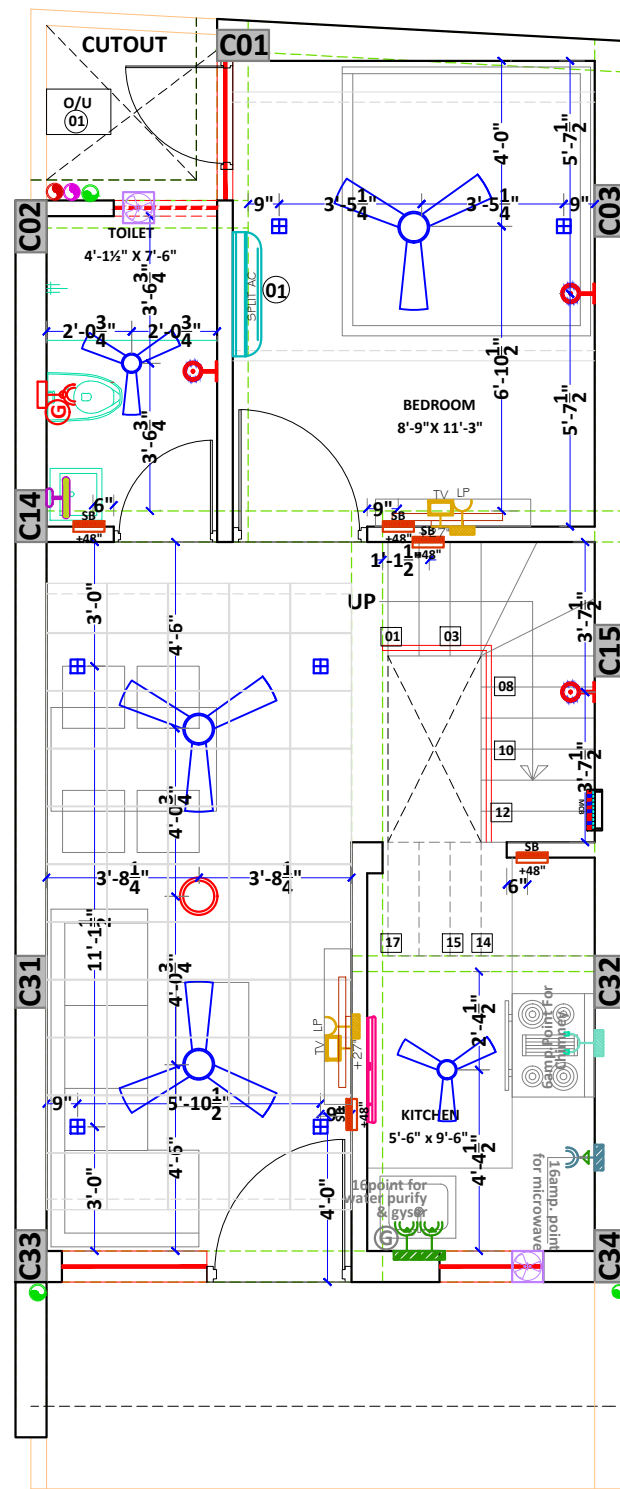

GROUND FLOOR

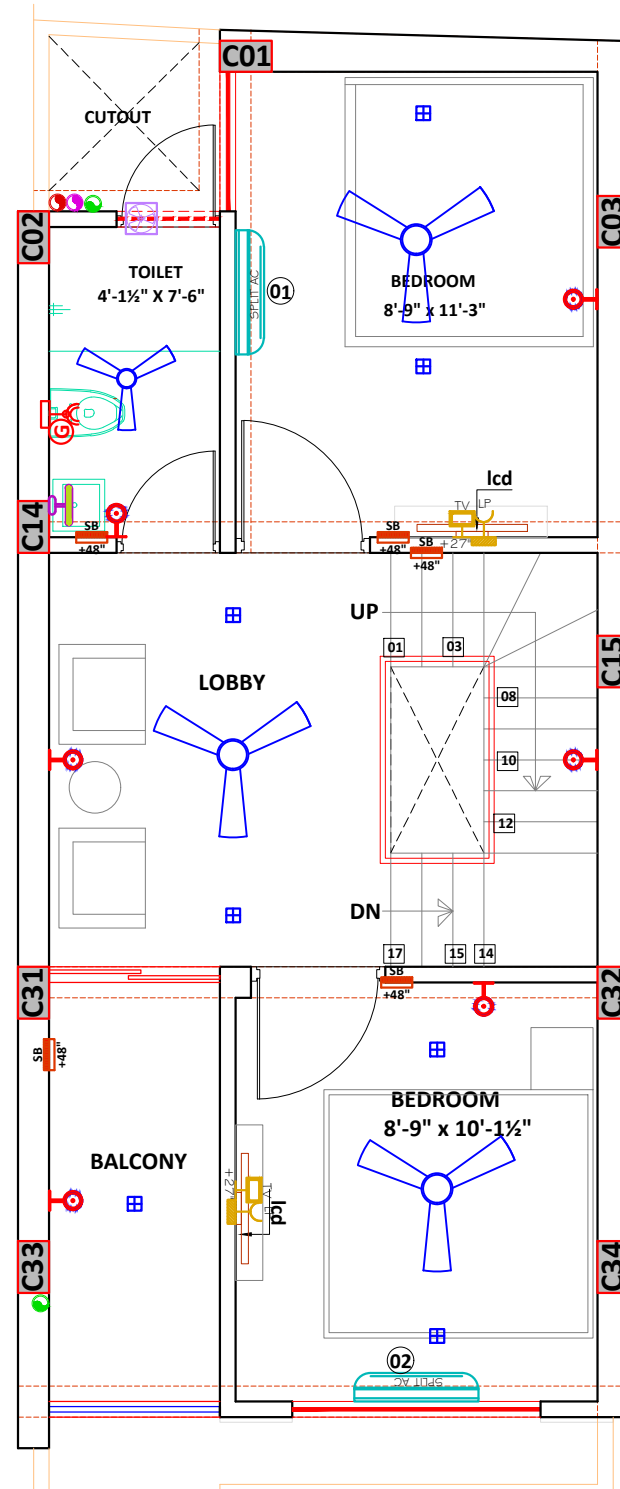

FIRST FLOOR

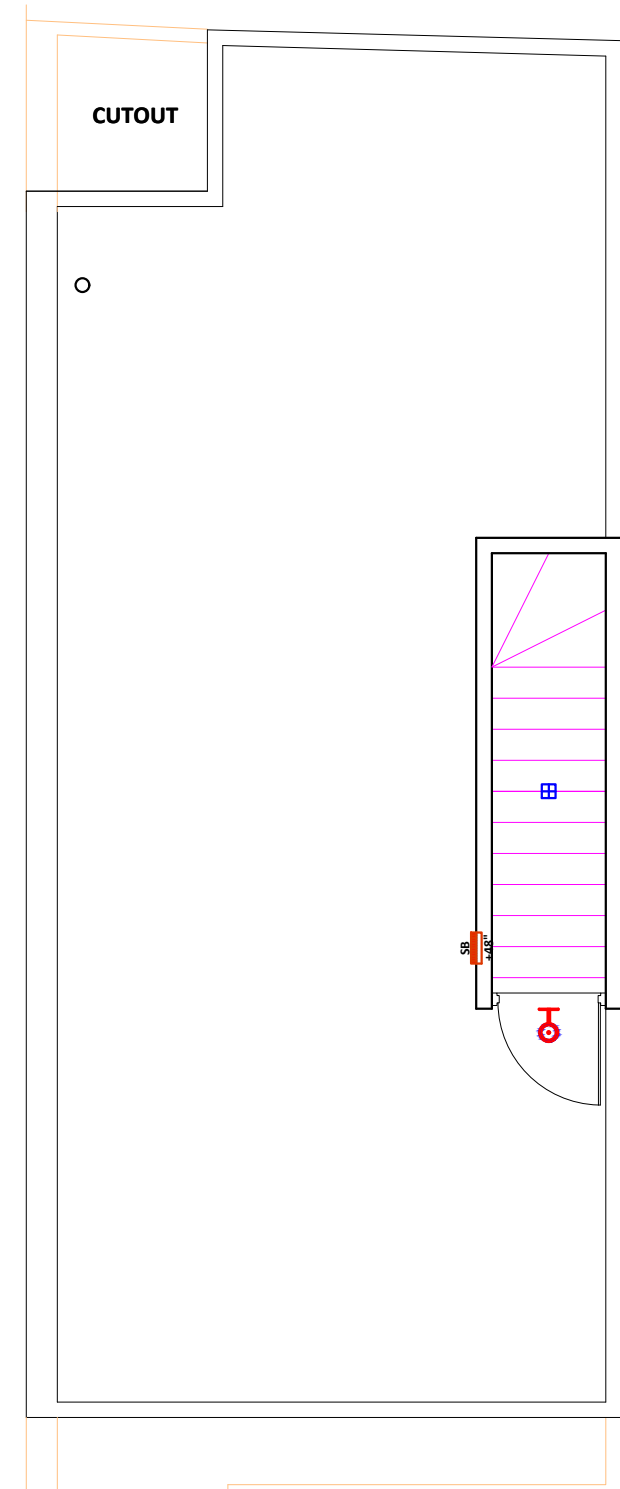

TERRACE FLOOR

Project:

PROPOSED LAYOUT PLAN OF"
CHEIF MINISTER JAN AVAS YOJNA-2015
PROVISION 3B" KHASRA NO- 231/6,
233/5 AT REVENUE- VILLAGE-KANAKPURA,
TEH.-JAIPUR, JAIPUR

Architect

PUKHRAJ JAIN
Architect (R)
AlM-093 / 11-3
Registered Valuer (FRV)
Car-I / F-2907

Applicant:

Drawing Title:

ELECTRICAL LAYOUT
PLOT NO. 53

Scale:


1:100

North:



SANSKRITI


Architects Interiors Engineers Valuers
26 A FRIENDS COLONY-II, LAL KOTHI
TONK ROAD, JAIPUR - 302015
p: 0141 2742294, 4036248-49
e: sanskriti.arch@gmail.com
w: www.sanskritiarchitects.com

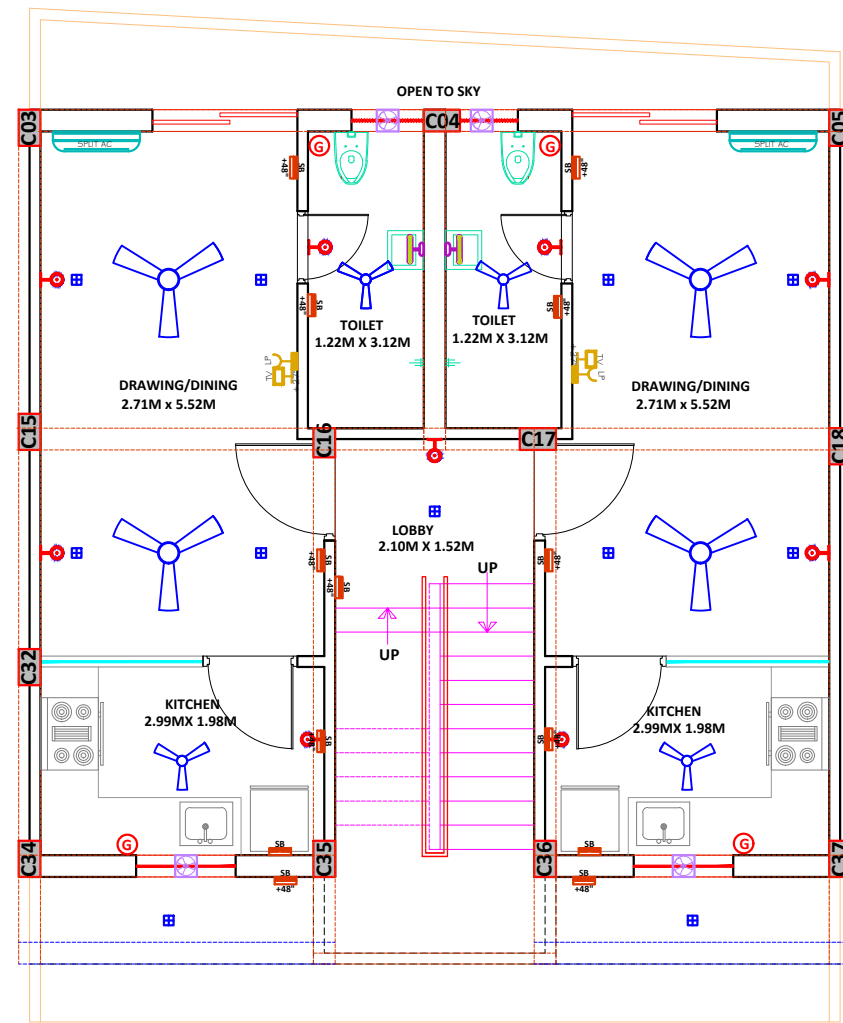

54

55


GROUND FLOOR PLAN

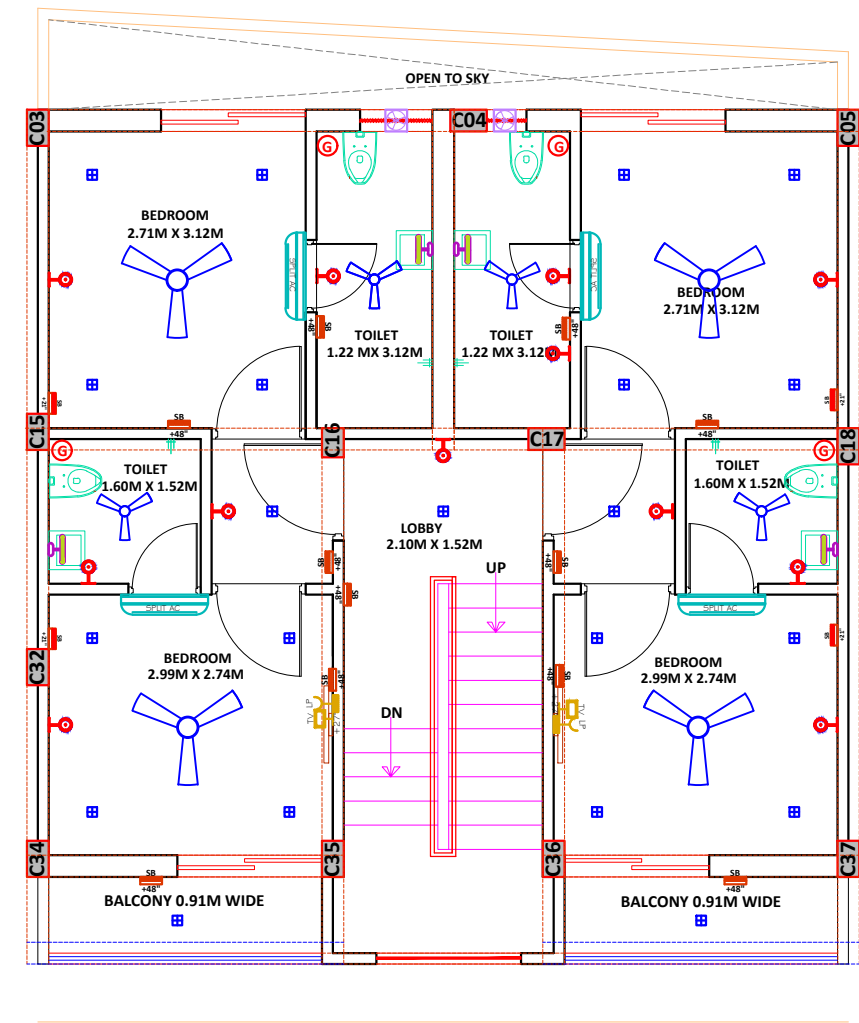

54

55

FIRST FLOOR PLAN

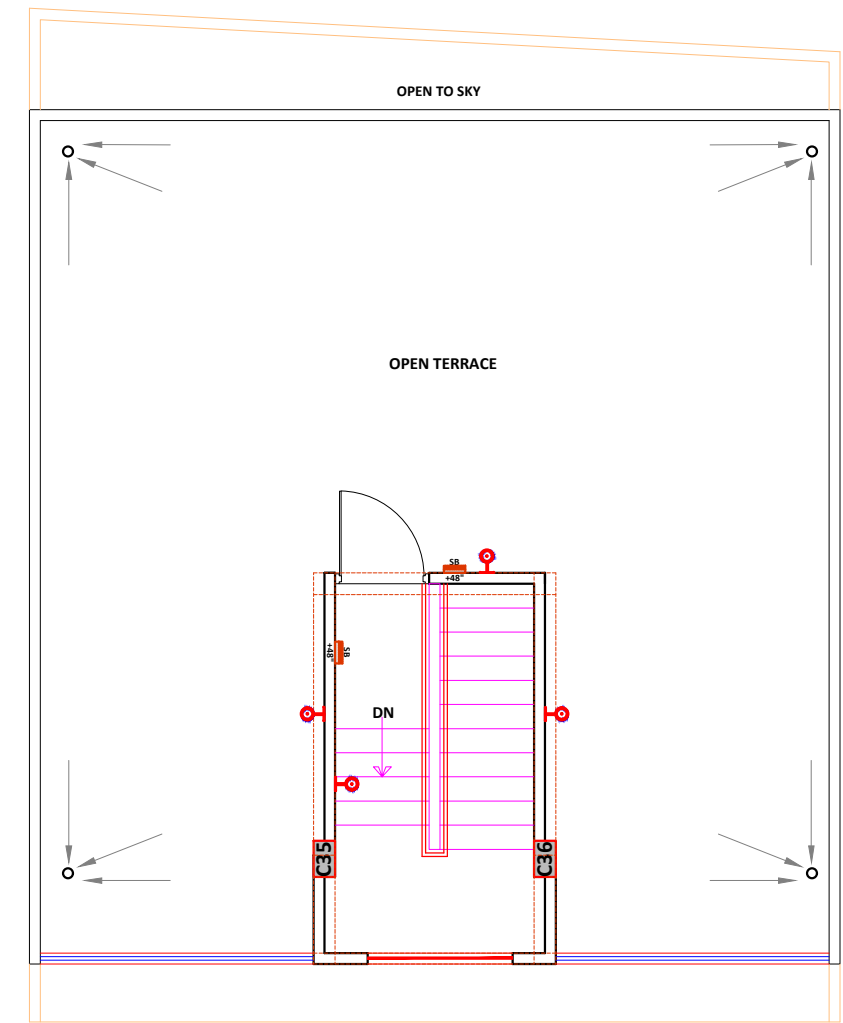

54

55

TERRACE FLOOR PLAN

Project:

PROPOSED LAYOUT PLAN OF"
CHEIF MINISTER JAN AVAS YOJNA-2015
PROVISION 3B" KHASRA NO- 231/6,
233/5 AT REVENUE- VILLAGE-KANAKPURA,
TEH.-JAIPUR, JAIPUR

Architect

PUKHRAJ JAIN
Architect
AIO-50111-3
Registered Under RERA
Car-11/2027

Applicant:

Drawing Title:

ELECTRICAL LAYOUT

PLOT NO. 54 & 55

Scale:


1:100

North:




SANSKRITI


Architects Interiors Engineers Valuers
26 A FRIENDS COLONY-II, LAL KOTHI
TONK ROAD, JAIPUR - 302015
p: 0141 2742294, 4036248-49
e: sanskriti.arch@gmail.com
w: www.sanskritiarchitects.com

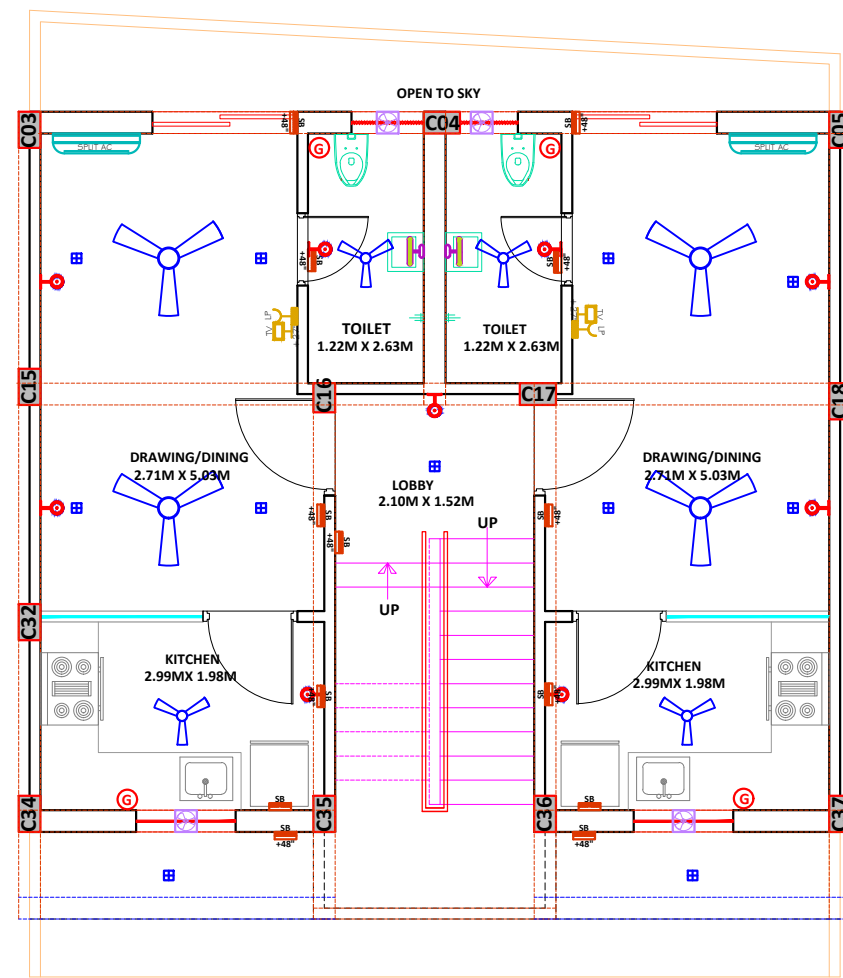

56 57
GROUND FLOOR PLAN

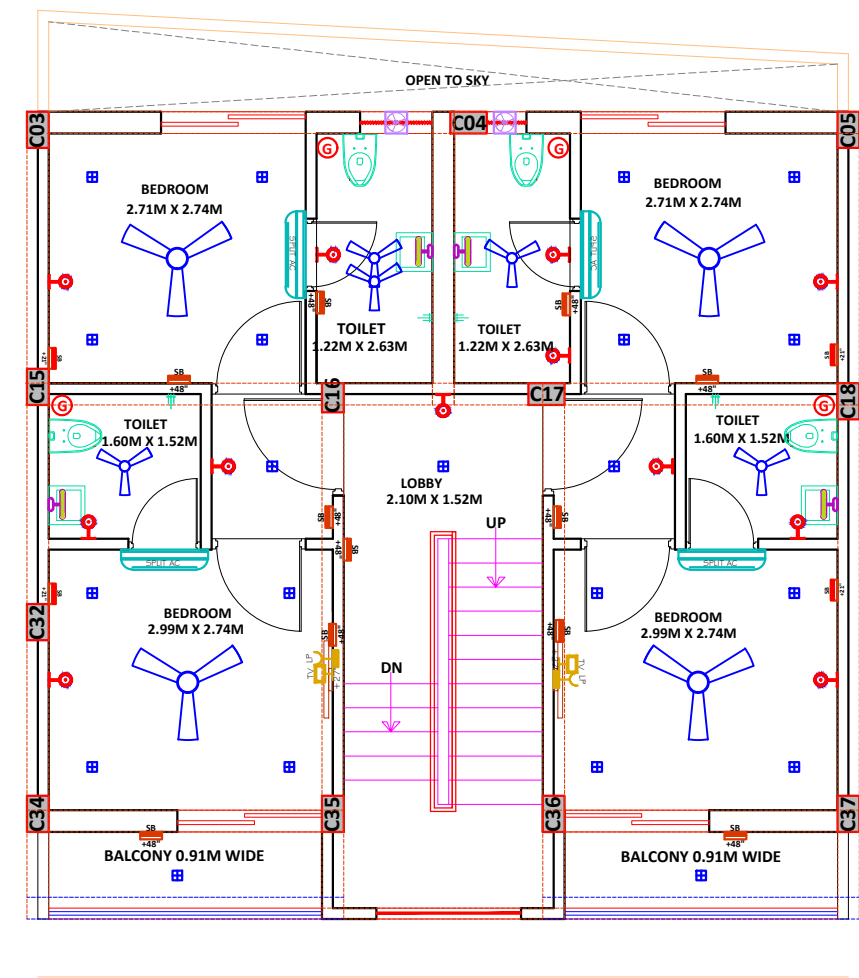

56 57
FIRST FLOOR PLAN

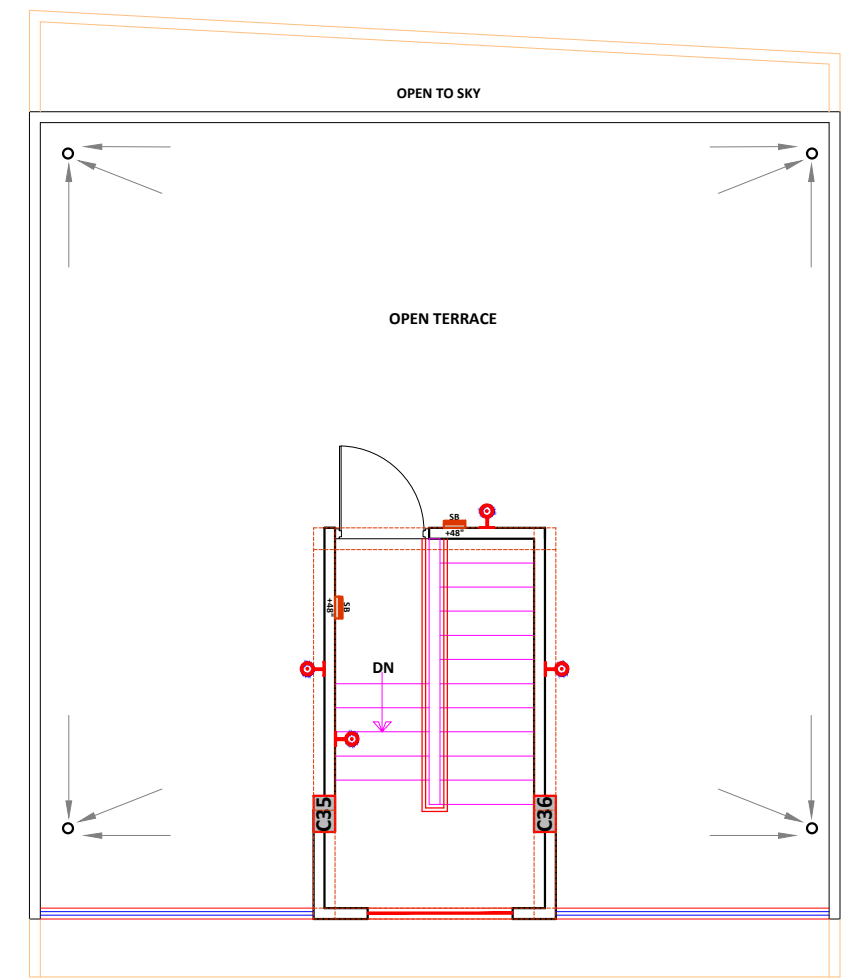

56 57
TERRACE FLOOR PLAN

Project:

PROPOSED LAYOUT PLAN OF"
CHEIF MINISTER JAN AVAS YOJNA-2015
PROVISION 3B" KHASRA NO- 231/6,
233/5 AT REVENUE- VILLAGE-KANAKPURA,
TEH.-JAIPUR, JAIPUR

Architect

PURKHRAJ JAIN
Architect
AIA-01111-1
Registered No. (R001)
Cap-1/P-2507

Applicant:

Drawing Title:

ELECTRICAL LAYOUT
PLOT NO. 56 & 57

Scale:


1:100

North:



SANSKRITI


Architects Interiors Engineers Valuers
26 A FRIENDS COLONY-II, LAL KOTHI
TONK ROAD, JAIPUR - 302015
p: 0141 2742294, 4036248-49
e: sanskriti.arch@gmail.com
w: www.sanskritiarchitects.com

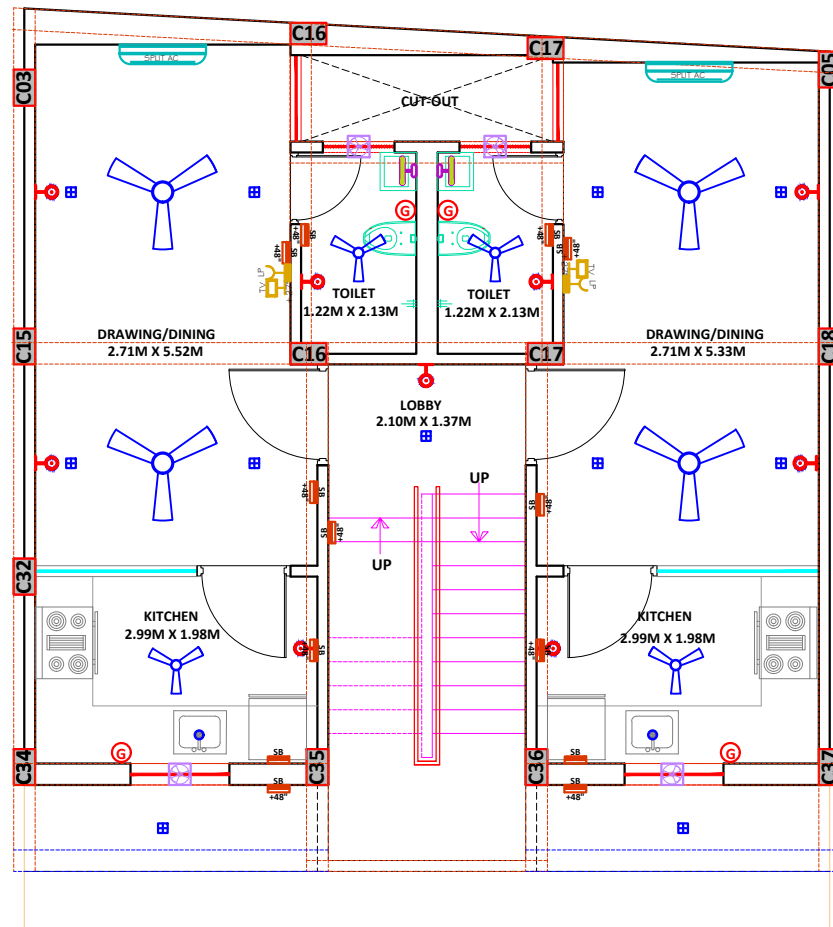

58

59


GROUND FLOOR PLAN

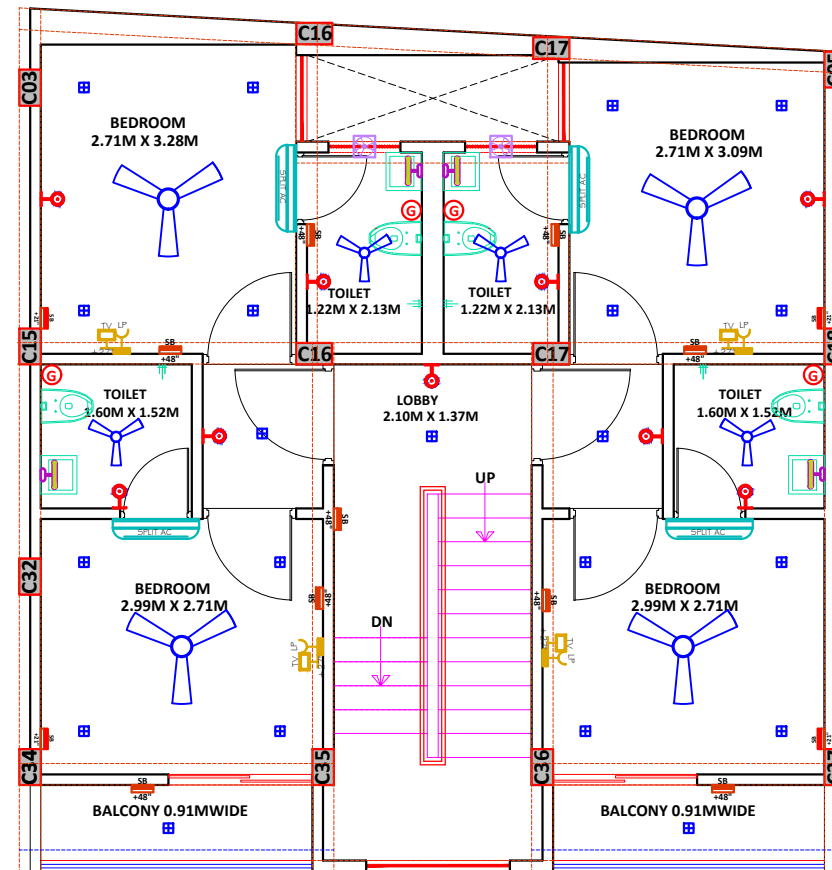

58

59

FIRST FLOOR PLAN

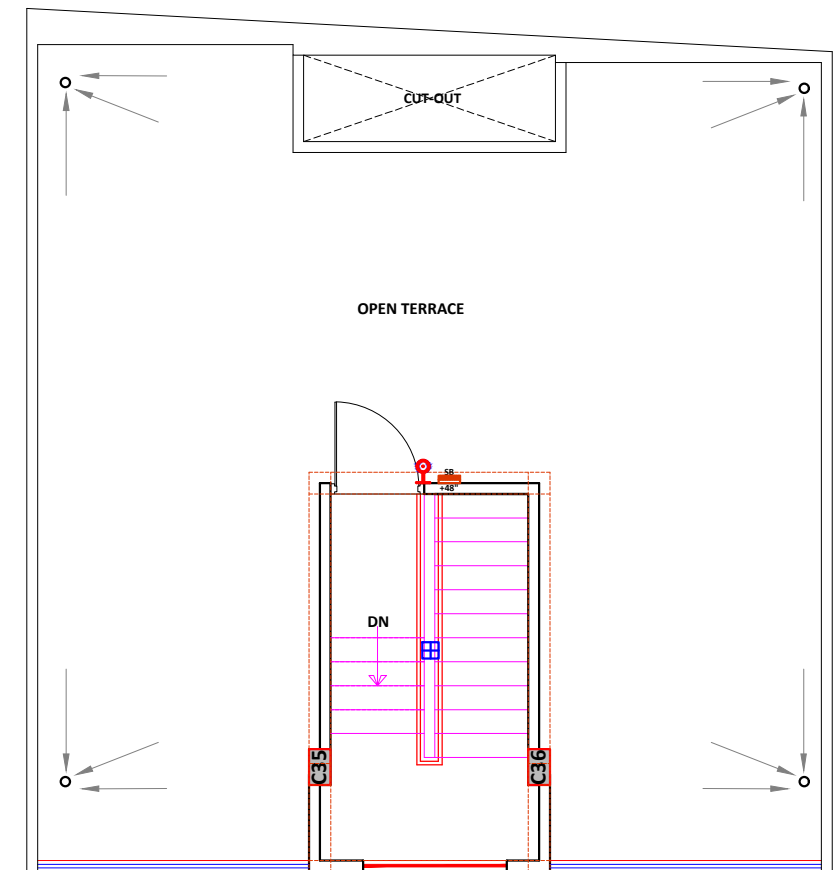

58

59

TERRACE FLOOR PLAN

Project:

PROPOSED LAYOUT PLAN OF"
CHEIF MINISTER JAN AVAS YOJNA-2015
PROVISION 3B" KHASRA NO- 231/6,
233/5 AT REVENUE- VILLAGE-KANAKPURA,
TEH.-JAIPUR, JAIPUR

Architect

PUKHRAJ JAIN
ARCHITECT
REGISTERED ARCHITECT (RAT)
GATE NO. 1/1-2007

Applicant:

Drawing Title:

EWS
ELECTRICAL LAYOUT
PLOT NO. 58 & 59

Scale:




1:100

North:



SANSKRITI

Architects Interiors Engineers Valuers
26 A FRIENDS COLONY-II, LAL KOTHI
TONK ROAD, JAIPUR - 302015
p: 0141 2742294, 4036248-49
e: sanskriti.arch@gmail.com
w: www.sanskritiarchitects.com

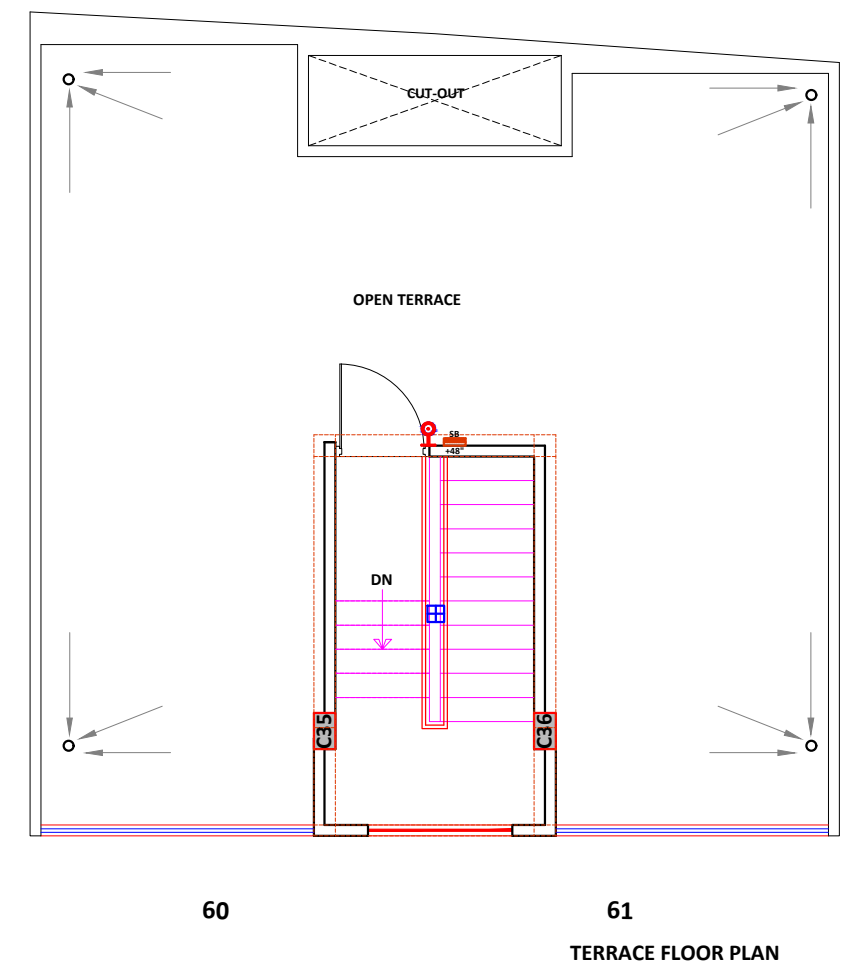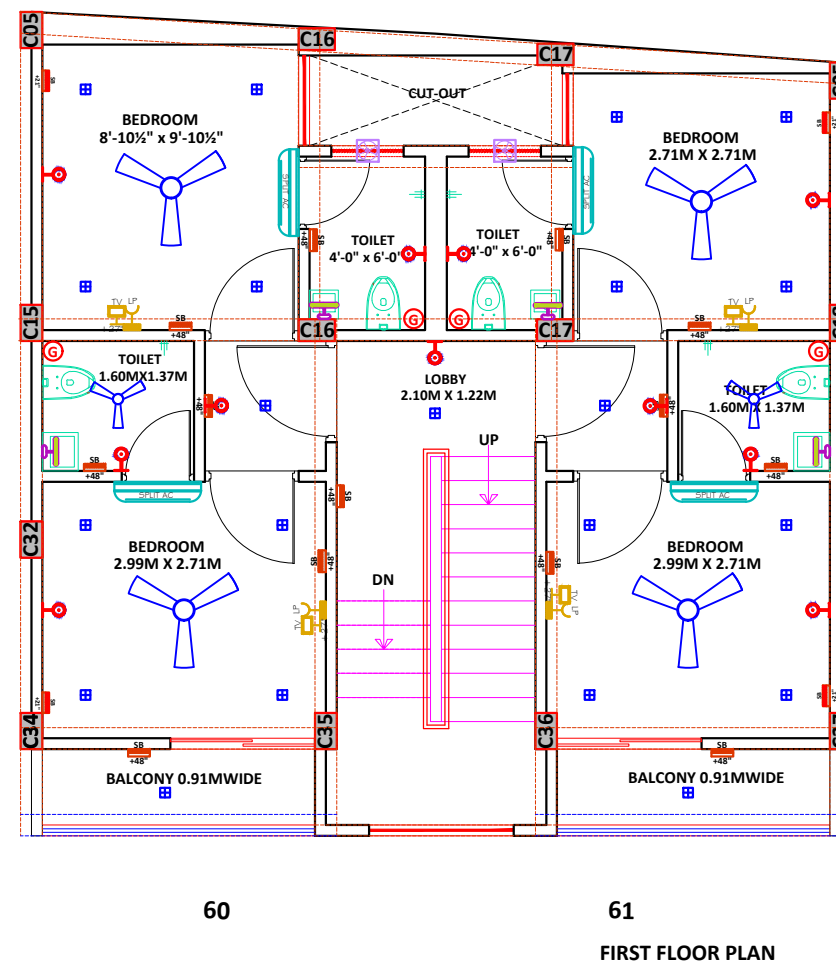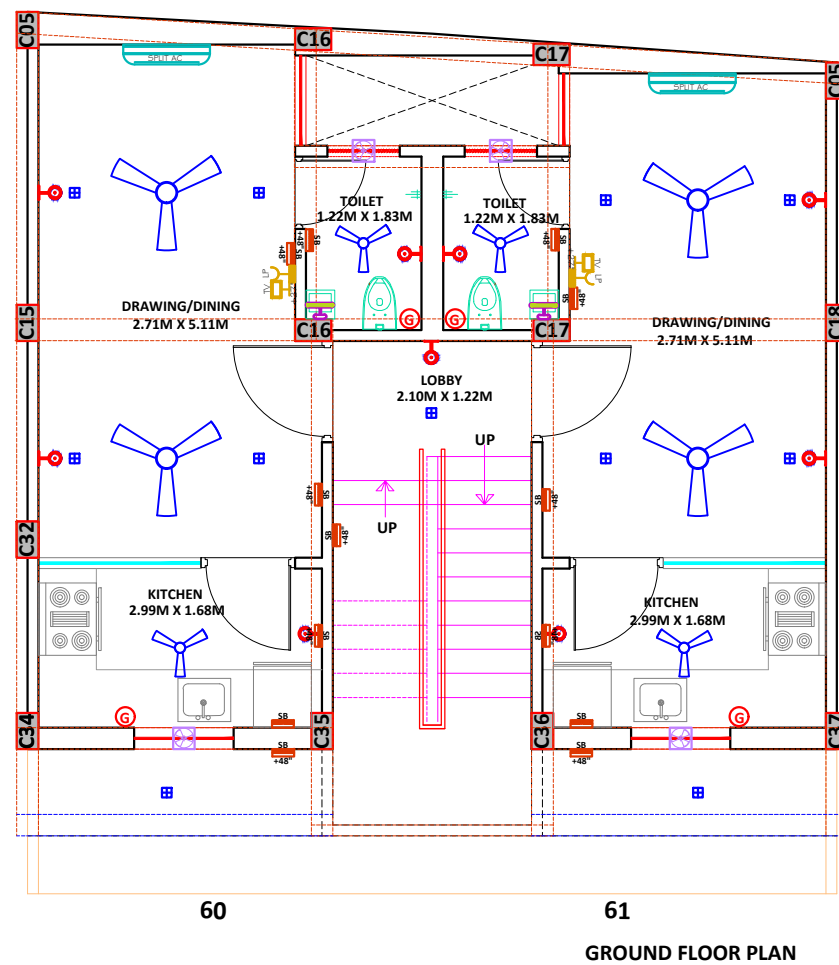

Project:

PROPOSED LAYOUT PLAN OF"
CHEIF MINISTER JAN AVAS YOJNA-2015
PROVISION 3B" KHASRA NO- 231/6,
233/5 AT REVENUE- VILLAGE-KANAKPURA,
TEH.-JAIPUR, JAIPUR

Architect

PURKHRA JAIN
Architect
A-50-60/1, 2nd Floor
Registered Office (R.O.)
Car-5/1-2537

Applicant:

Drawing Title:

EWS
ELECTRICAL LAYOUT
PLOT NO. 60 & 61

Scale:


1:100

North:



SANSKRITI


Architects Interiors Engineers Valuers
26 A FRIENDS COLONY-II, LAL KOTHI
TONK ROAD, JAIPUR - 302015
p: 0141 2742294, 4036248-49
e: sanskriti.arch@gmail.com
w: www.sanskritiarchitects.com

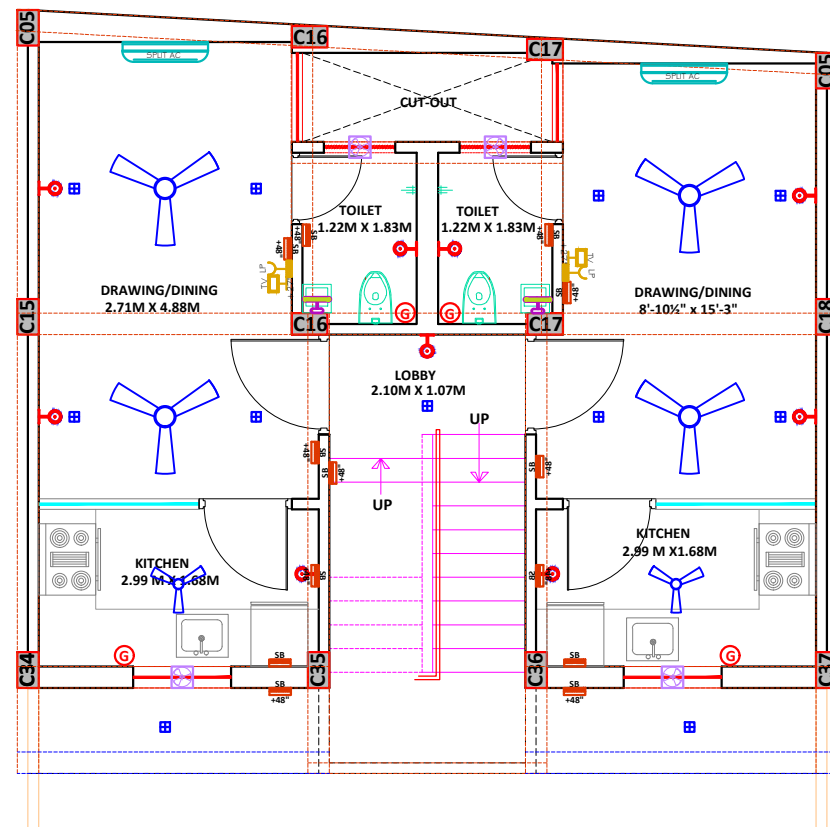

62

63


GROUND FLOOR PLAN

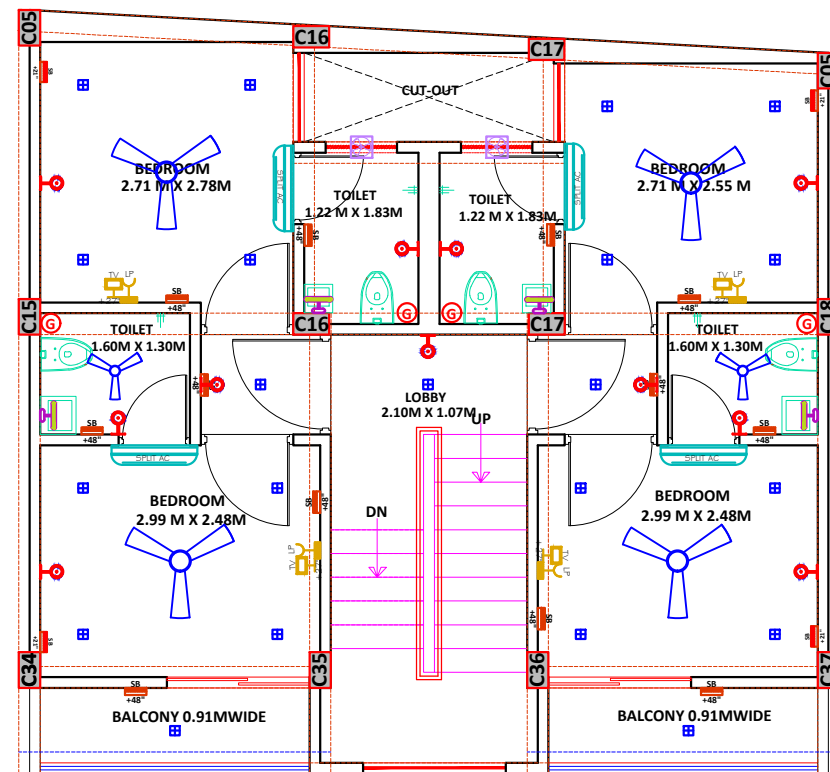

62

63

FIRST FLOOR PLAN

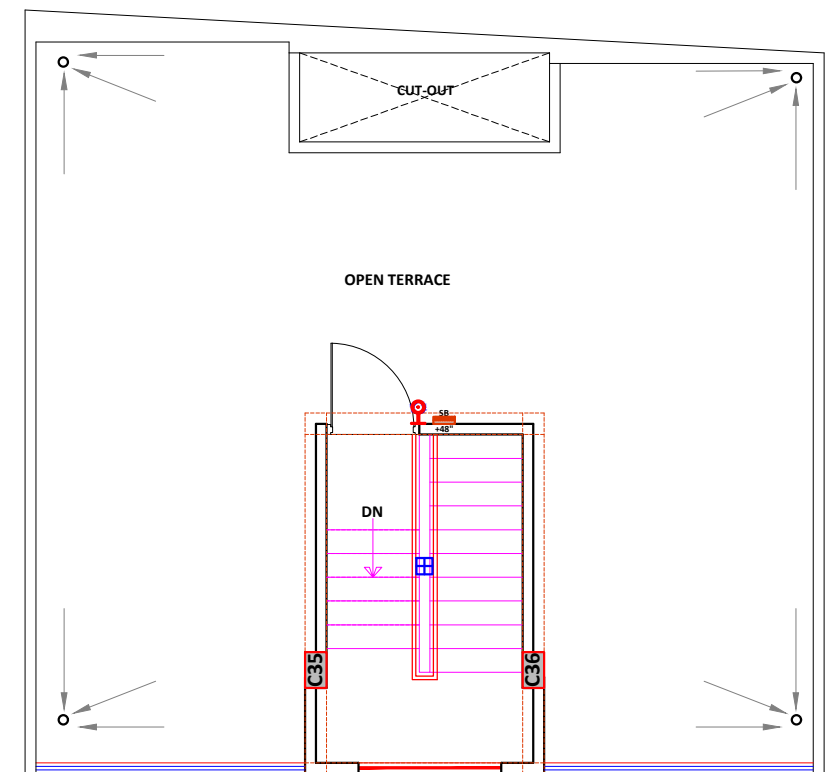

62

63

TERRACE FLOOR PLAN

Project:

PROPOSED LAYOUT PLAN OF"
CHEIF MINISTER JAN AVAS YOJNA-2015
PROVISION 3B" KHASRA NO- 231/6,
233/5 AT REVENUE- VILLAGE-KANAKPURA,
TEH.-JAIPUR, JAIPUR

Architect

PUKHRAJ JAIN
Architect
Registered Valuer (RVI)
Cact 17-0997

Applicant:

Drawing Title:

EWS
ELECTRICAL LAYOUT
PLOT NO. 62 & 63

Scale:


1:100

North:




SANSKRITI


Architects Interiors Engineers Valuers
26 A FRIENDS COLONY-II, LAL KOTHI
TONK ROAD, JAIPUR - 302015
p: 0141 2742294, 4036248-49
e: sanskriti.arch@gmail.com
w: www.sanskritiarchitects.com

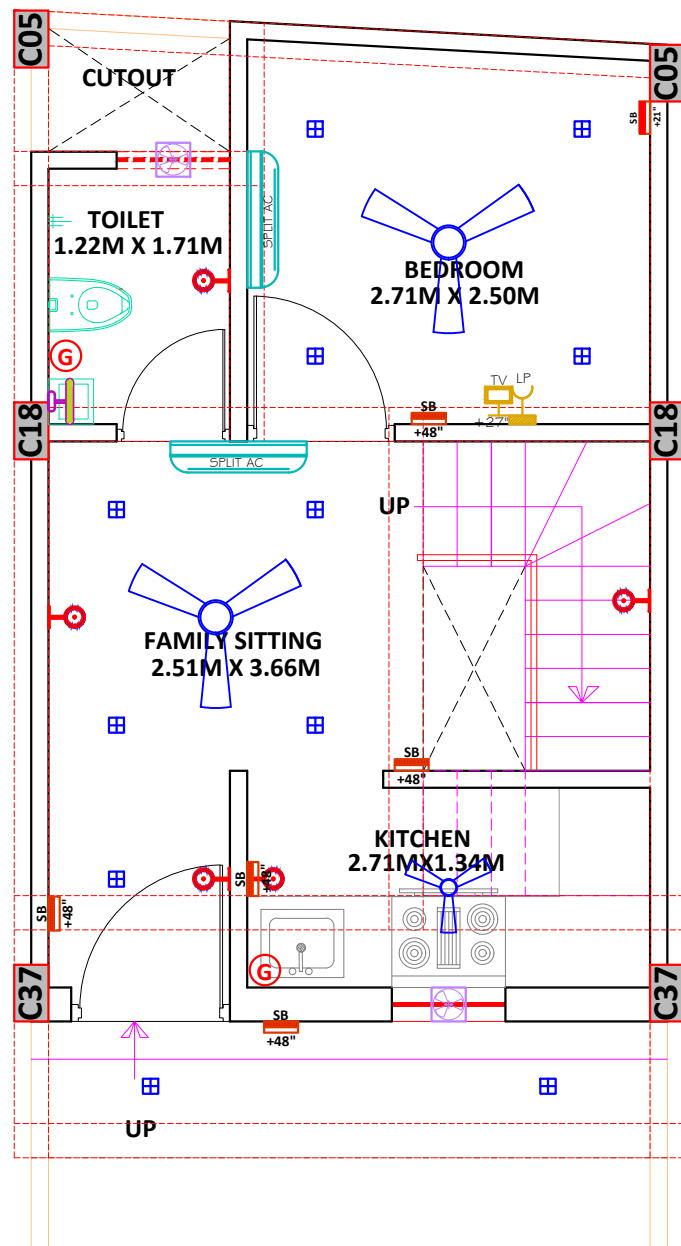

GROUND FLOOR PLAN

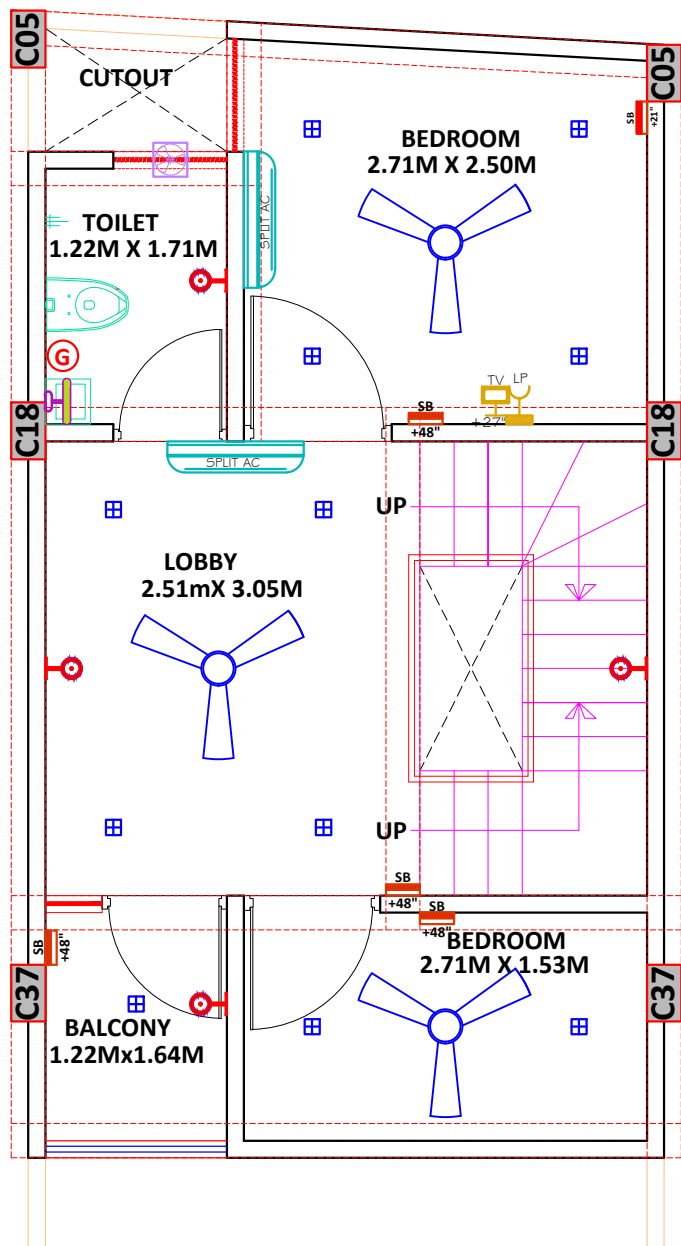

FIRST FLOOR PLAN

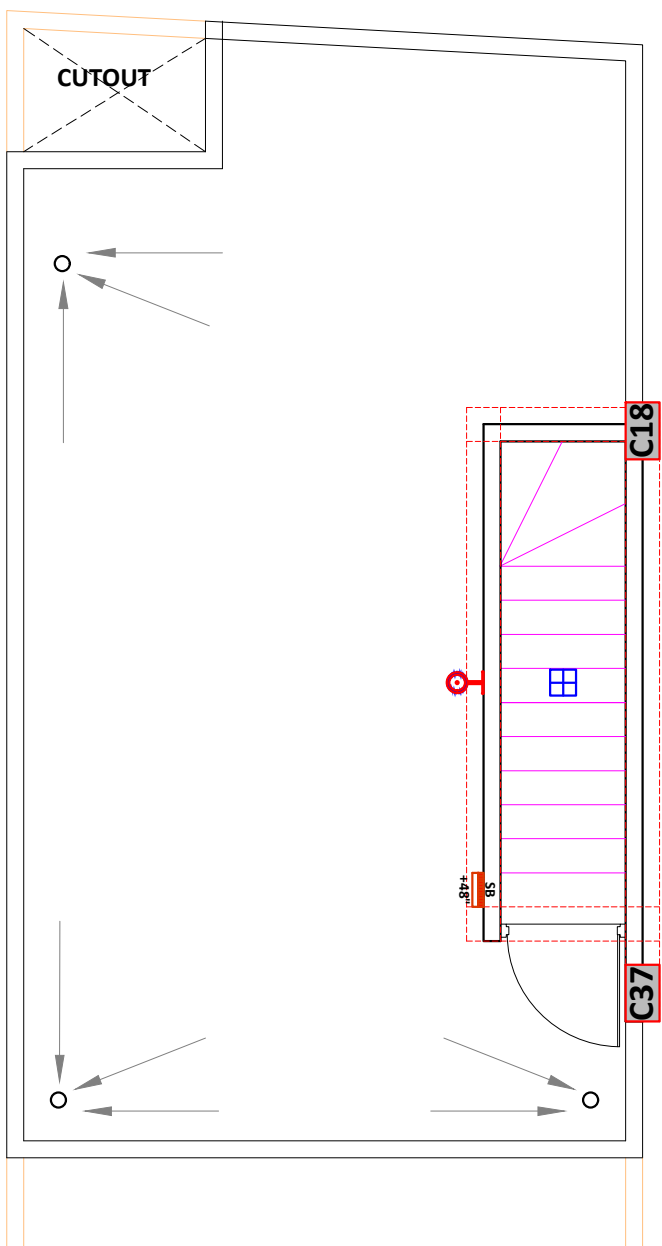

TERRACE FLOOR PLAN

Project:

PROPOSED LAYOUT PLAN OF"
CHEIF MINISTER JAN AVAS YOJNA-2015
PROVISION 3B" KHASRA NO- 231/6,
233/5 AT REVENUE- VILLAGE-KANAKPURA,
TEH.-JAIPUR, JAIPUR

Architect

PUKHRA JAIN
Architect (I)
AM-091/71-5
Registered Valuer (FIRV)
Car-I/F-2907

Applicant:

Drawing Title:

EWS
ELECTRICAL LAYOUT
PLOT NO. 64

Scale:




1:100

North:



SANSKRITI

Architects Interiors Engineers Valuers
26 A FRIENDS COLONY-II, LAL KOTHI
TONK ROAD, JAIPUR - 302015
p: 0141 2742294, 4036248-49
e: sanskriti.arch@gmail.com
w: www.sanskritiarchitects.com

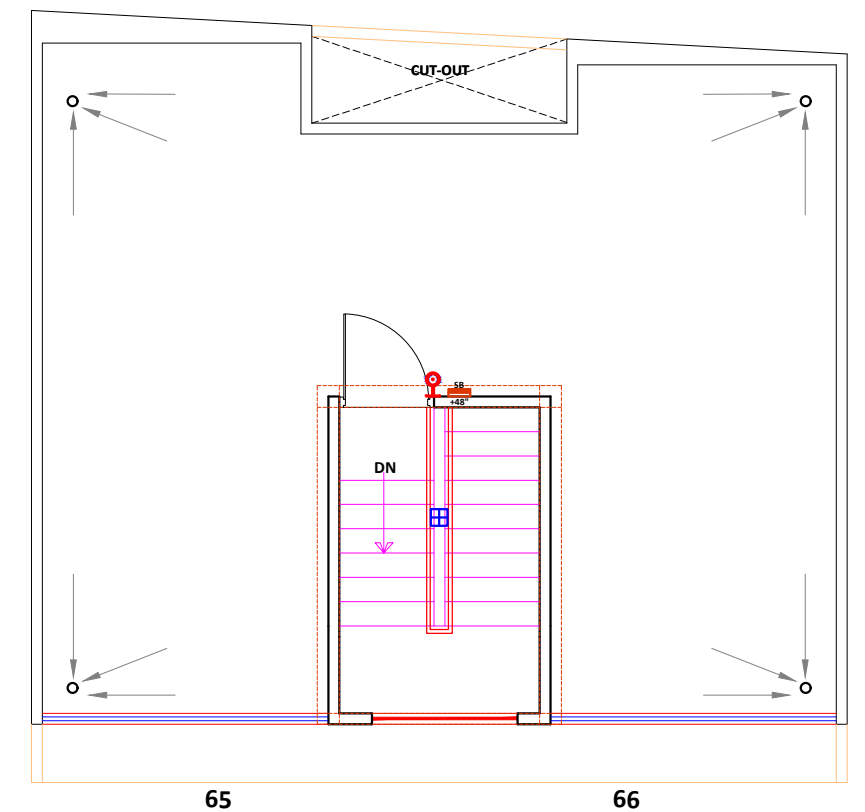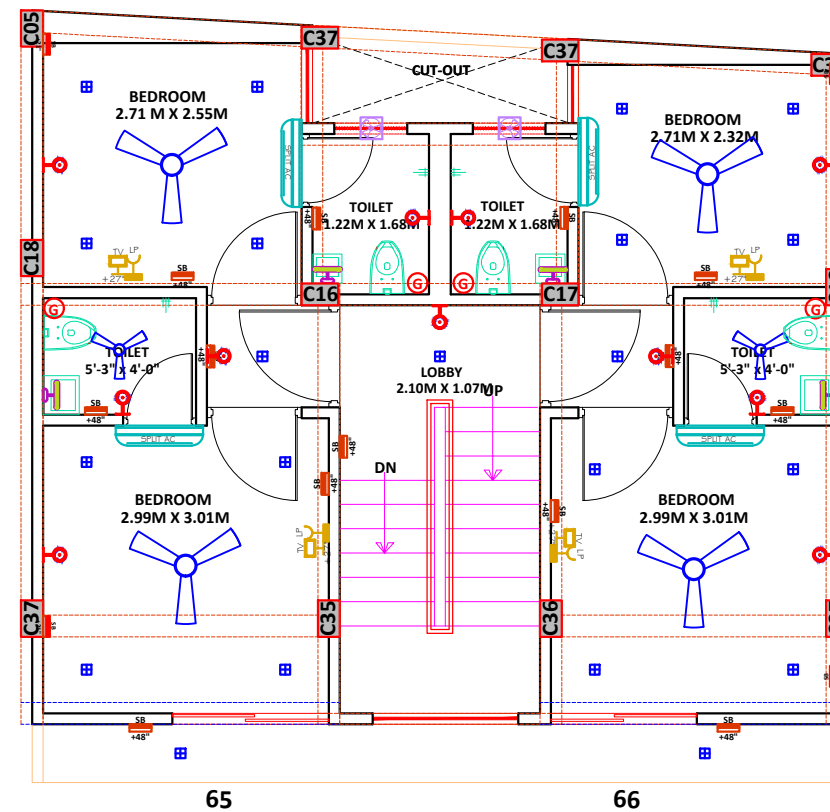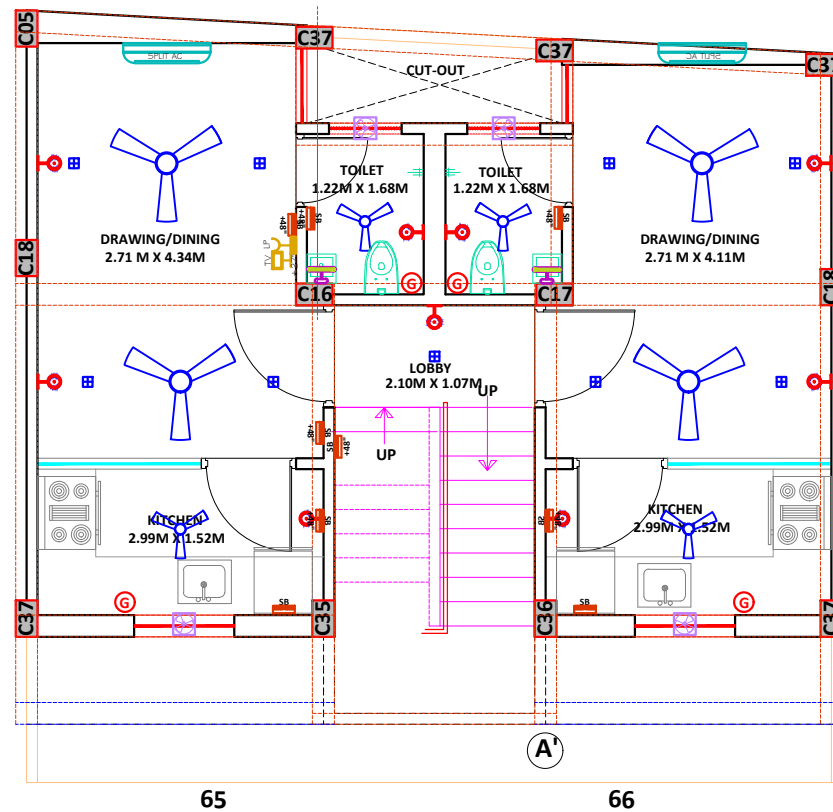

TERRACE FLOOR PLAN

Project:

PROPOSED LAYOUT PLAN OF"
CHEIF MINISTER JAN AVAS YOJNA-2015
PROVISION 3B" KHASRA NO- 231/6,
233/5 AT REVENUE- VILLAGE-KANAKPURA,
TEH.-JAIPUR, JAIPUR

Architect

PUKHRAJ JAIN
Architect
Registration No. 1197
GATE-1/2-2007

Applicant:

Drawing Title:

EWS
ELECTRICAL LAYOUT
PLOT NO. 65 & 66

Scale:

1:100

North:



SANSKRITI

Architects Interiors Engineers Valuers
26 A FRIENDS COLONY-II, LAL KOTHI
TONK ROAD, JAIPUR - 302015
p: 0141 2742294, 4036248-49
e: sanskriti.arch@gmail.com
w: www.sanskritiarchitects.com