

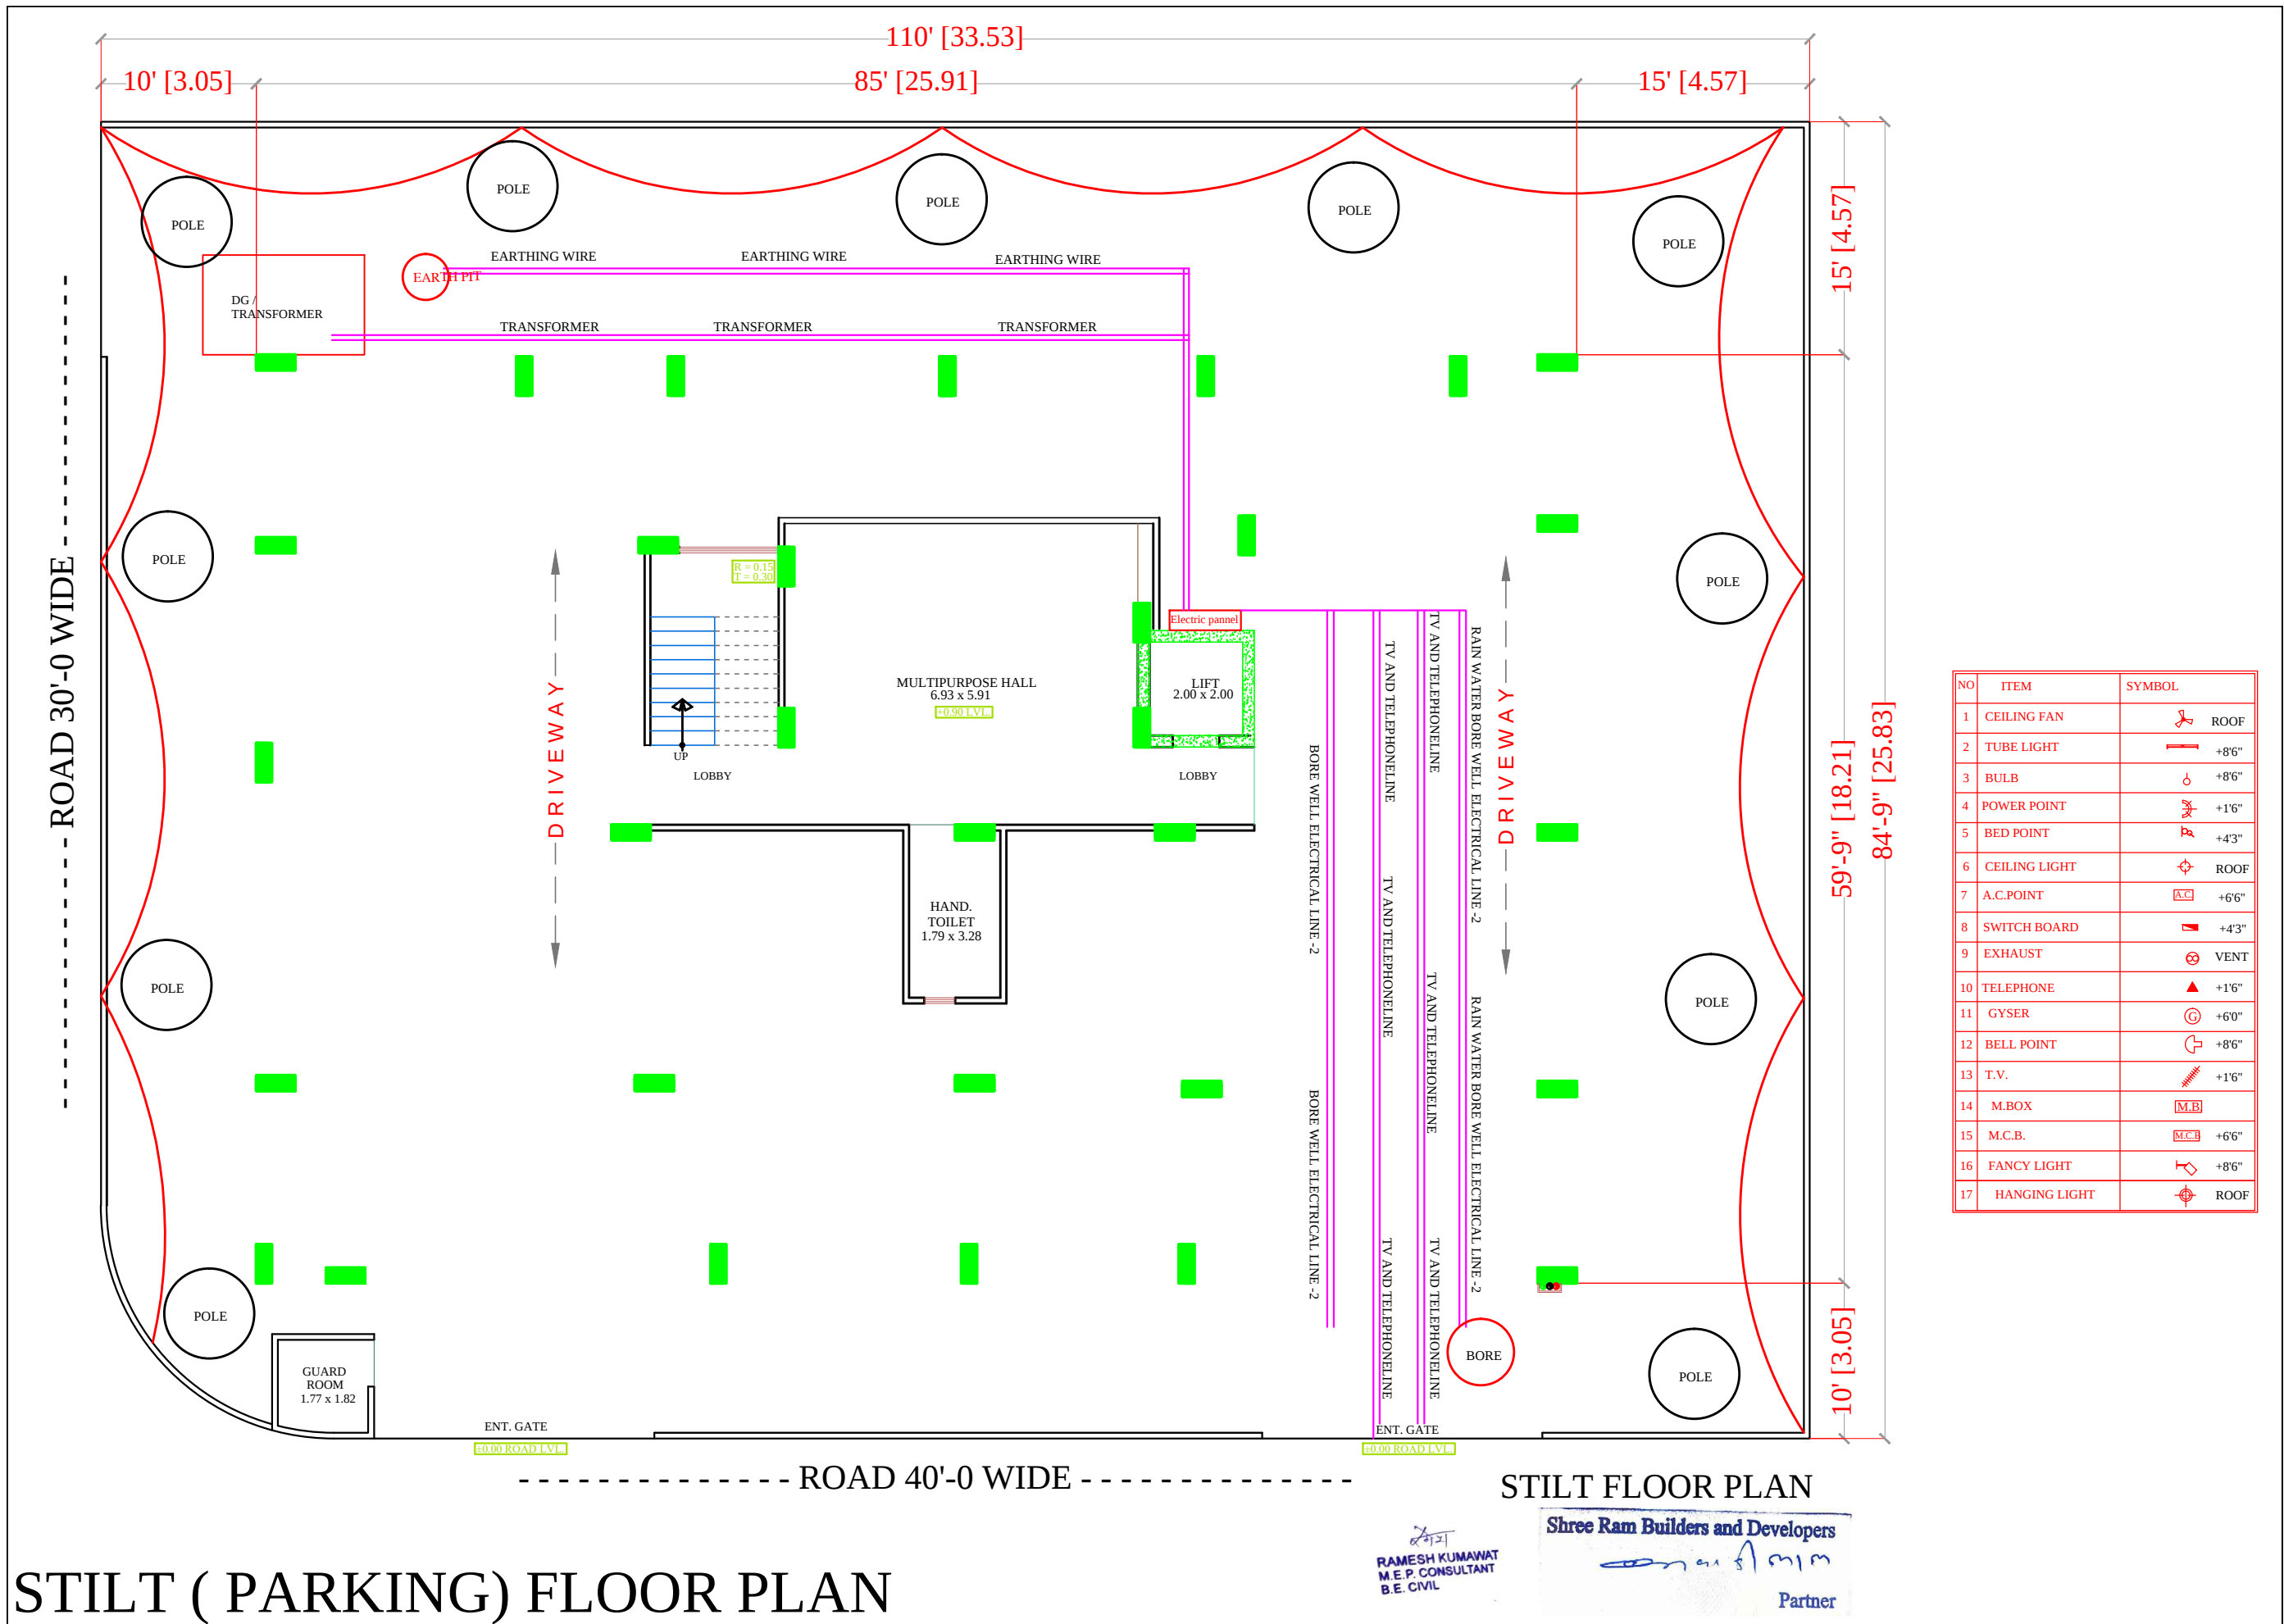


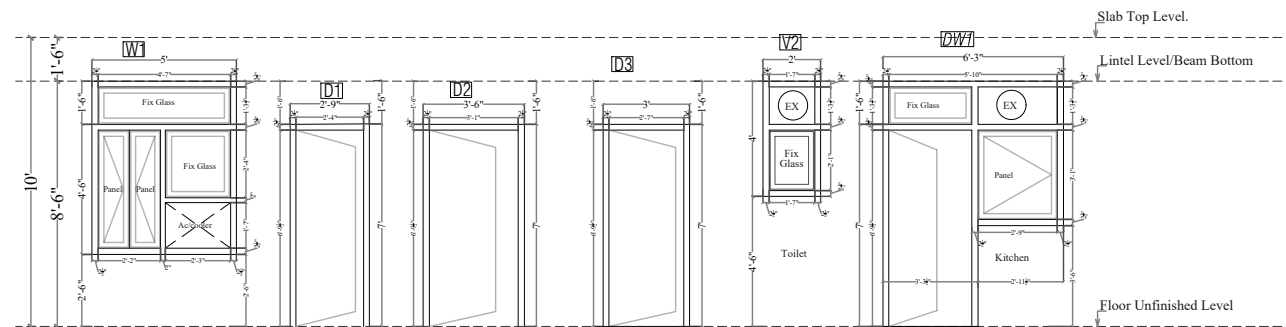


PROJECT TITLE :- PROPOSED BUILDING AT PLOT NO.-A-53 & A-54, NARAYANPURI-A, JAIPUR	BUILDING NAME ANANDAM HEIGHTS III	DRAWING TITLE :- SERVICE DRAWING SLD/DISTRIBUTION AFTER LT PANEL, EARTHING LAYOUT,EXTERNAL LIGHTING PLAN, TV & TELEPHONE RISER,LIGHTING ARRESTR, & PIT LOCATION COMMON AREA TRANSFORMER	SPACE CONSULTANT PLOT-A-173, JAGDAMBA NAGAR, HEERAPURA POWER HOWER, JAIPUR (RAJ) 302024	DRN. BY			
	DEVELOPER NAME SHREE RAM BUILDERS & DEVELOPERS			APPD. BY		DATE	
				SCALE	N.T.S	REVISION	

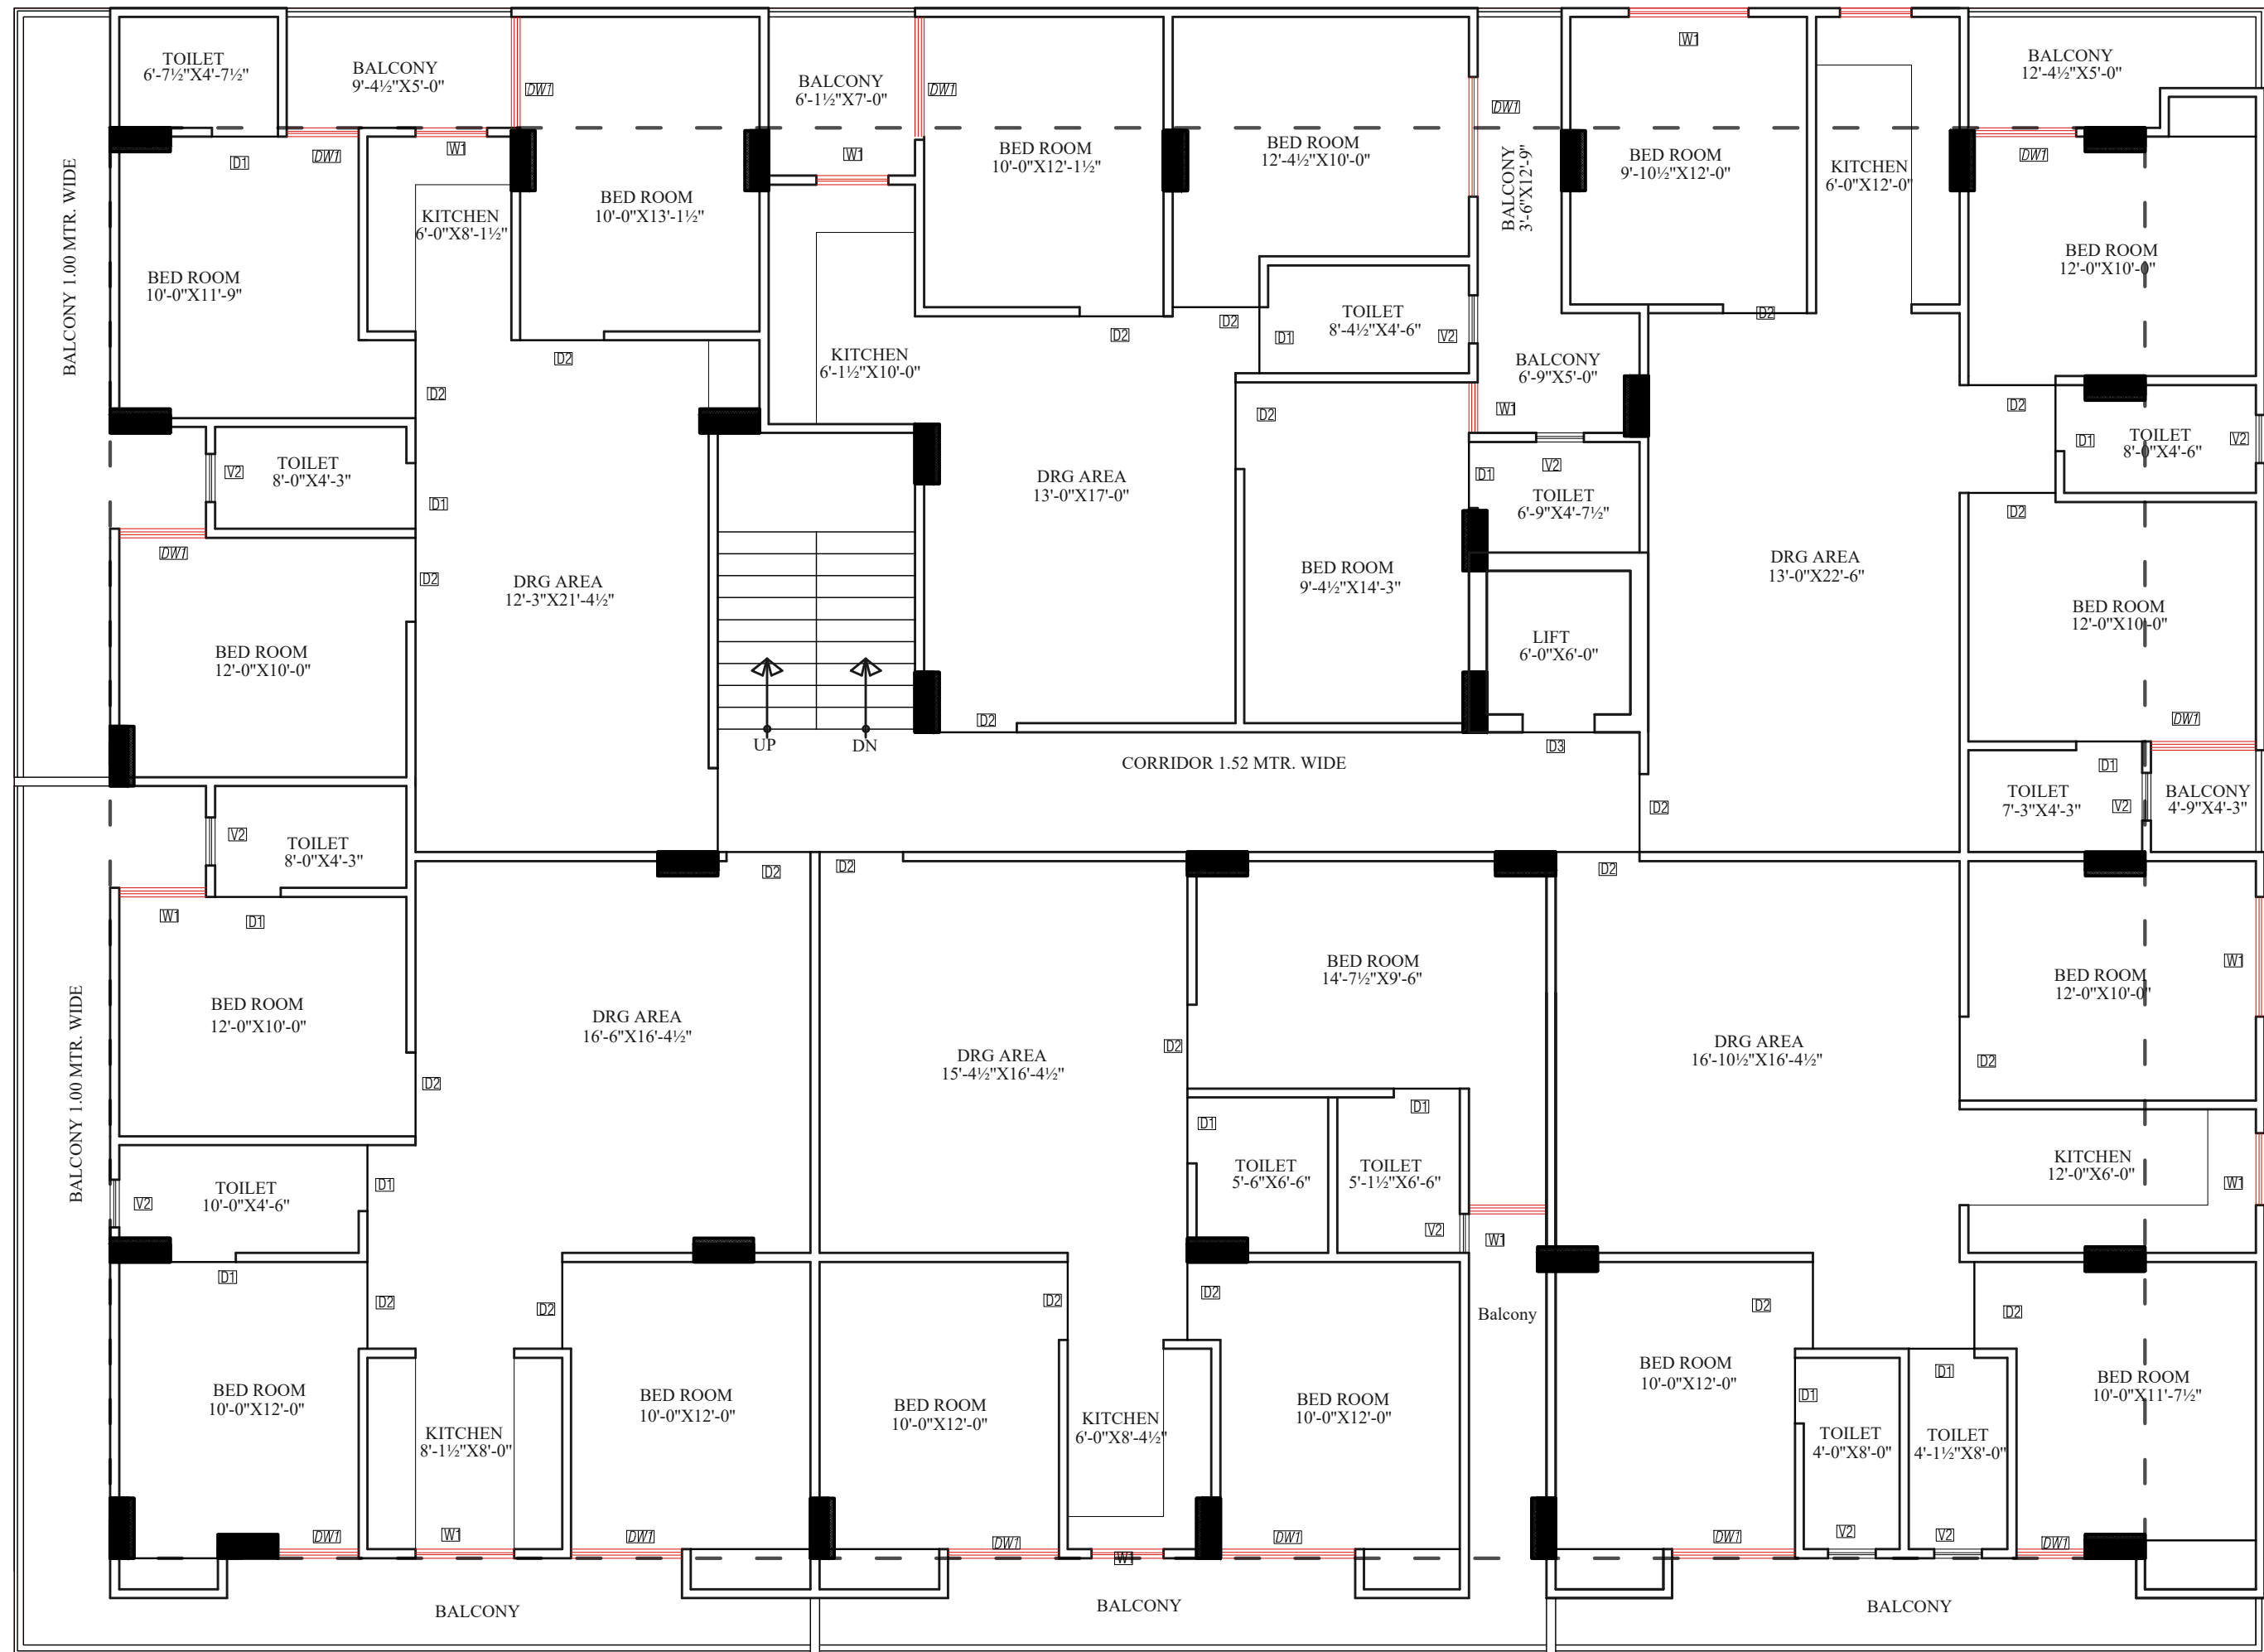

Shree Ram Builders and Developers

Signature

Partner


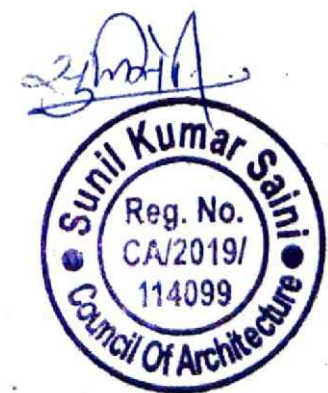


PROJECT TITLE :-
PROPOSED BUILDING AT
PLOT NO.-A-53 & A-54,
NARAYANPURI-A, JAIPUR

BUILDING NAME
ANANDAM HEIGHTS III
DEVELOPER NAME
SHREE RAM BUILDERS & DEVELOPERS

DRAWING TITLE :-
DOOR WINDOW
DETAIL

ARCHITECT :-
FRANK SQUARE
ARCHITECTURE | PLANNER | DESIGNER
C-49 VIDYA APARTMENT PARAS MARG,
BAPU NAGAR JAIPUR, (RAJ.)
Email-afranksquare@gmail.com
Mobile-9461302542

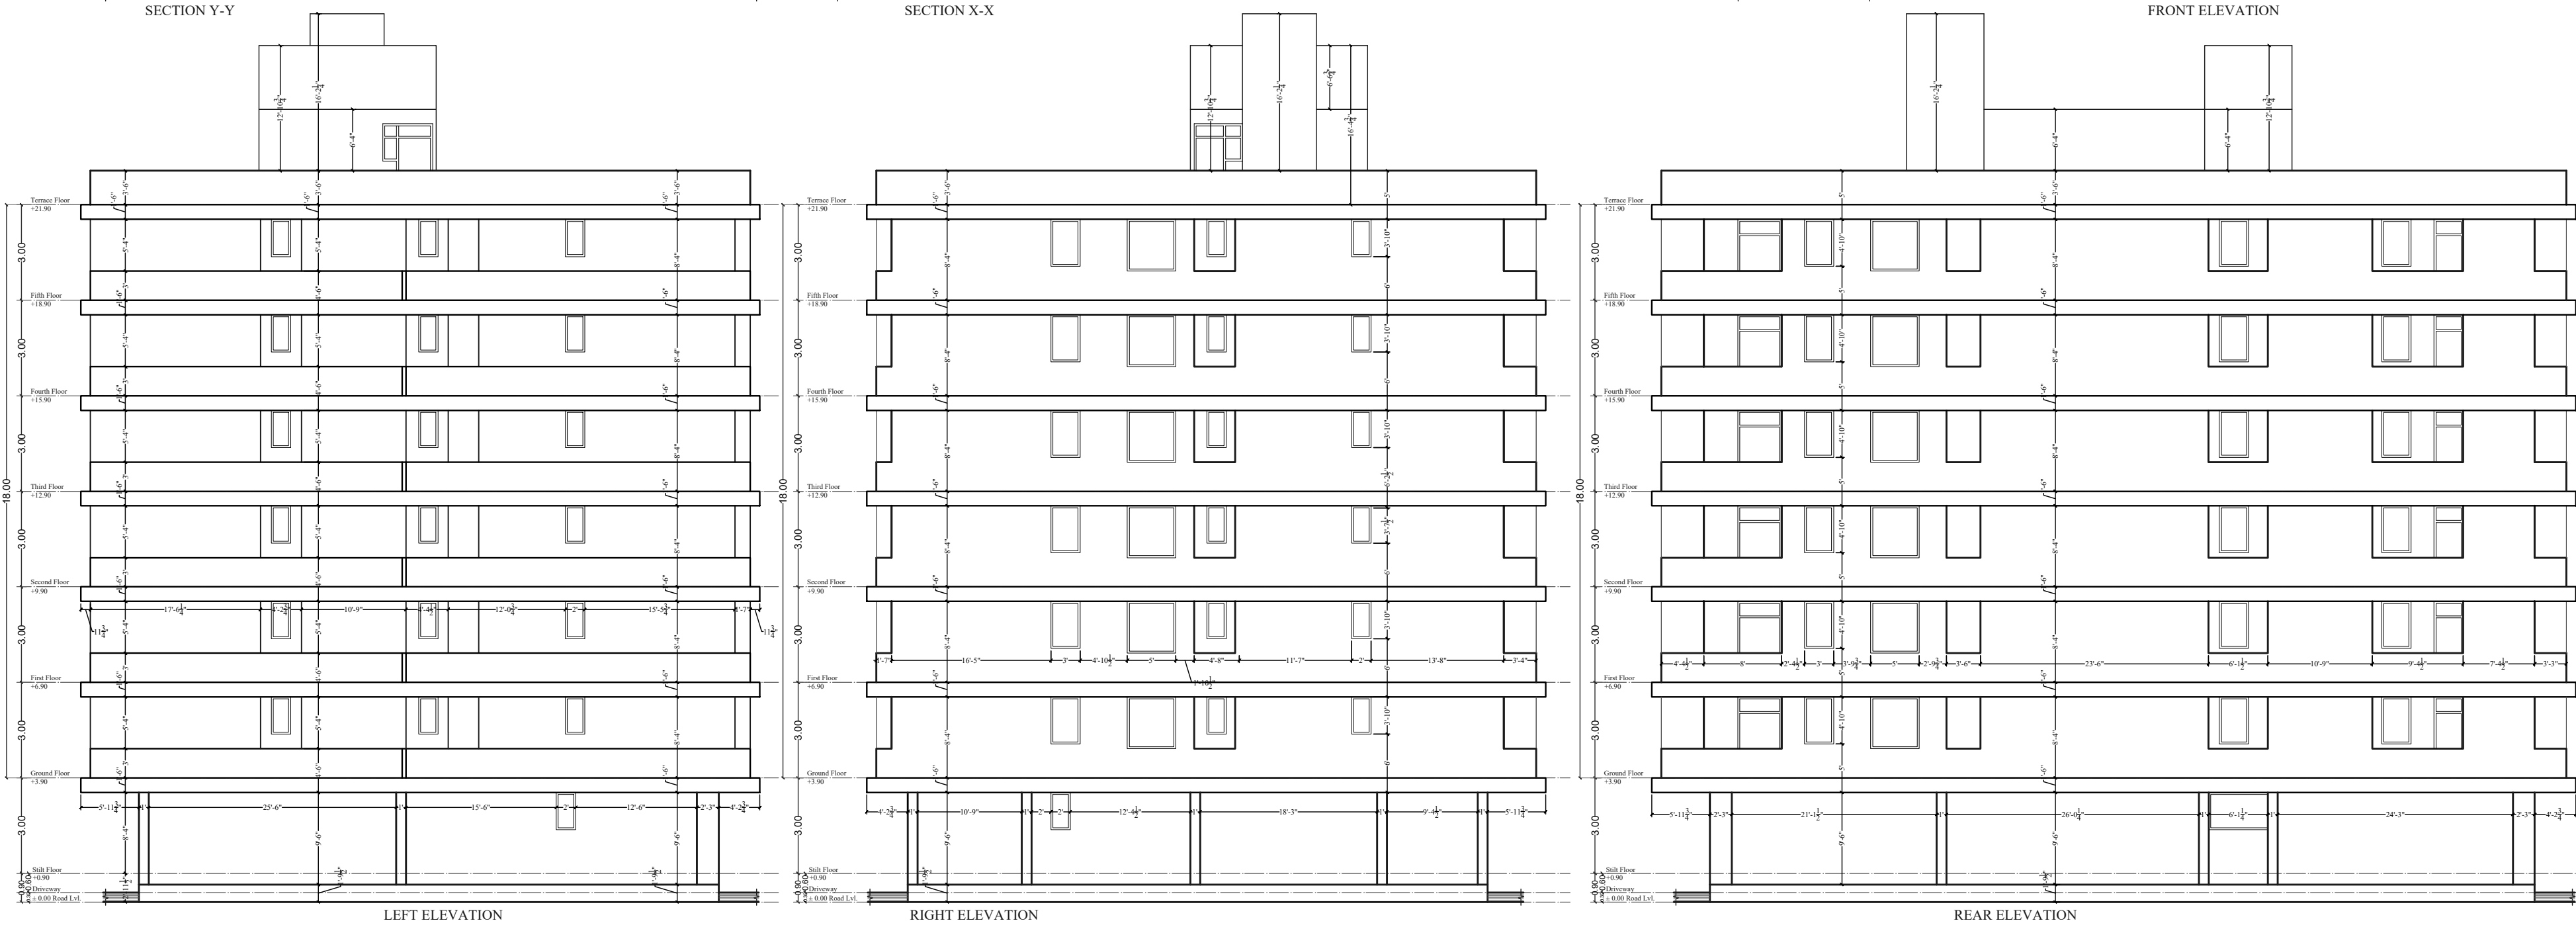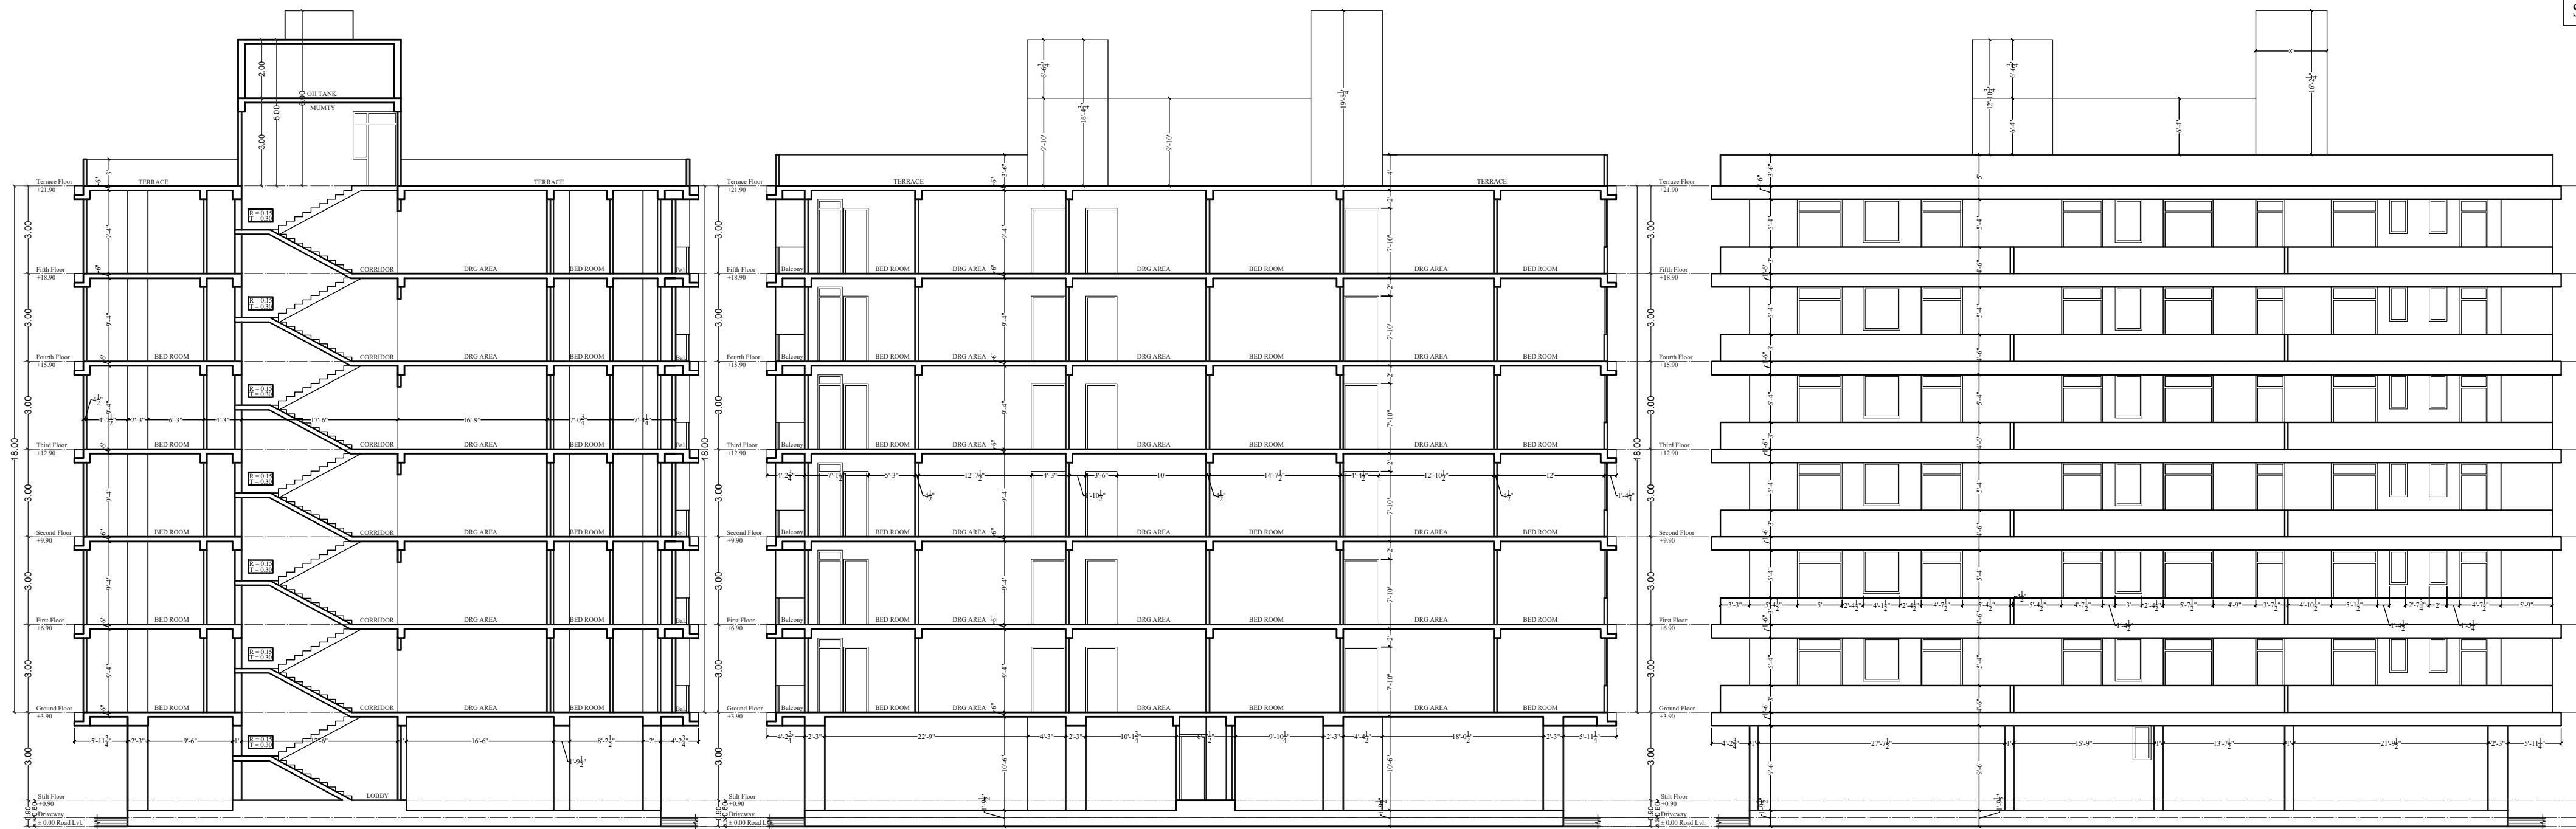

Shree Ram Builders and Developers
Partner


PROJECT :-
PROPOSED BUILDING AT PLOT
NO.-A-53 & A-54,
NARAYANPURI-A, JAIPUR

BUILDING NAME
ANANDAM HEIGHTS III

DEVELOPER NAME
SHREE RAM BUILDERS & DEVELOPERS

ARCHITECT :-
FRANK SQUARE
ARCHITECTURE | PLANNER | DESIGNER
C-49 VIDYA APARTMENT PARAS MARG,
BAPU NAGAR JAIPUR, (RAJ.)
Email-afranksquare@gmail.com
Mobile-9461302542



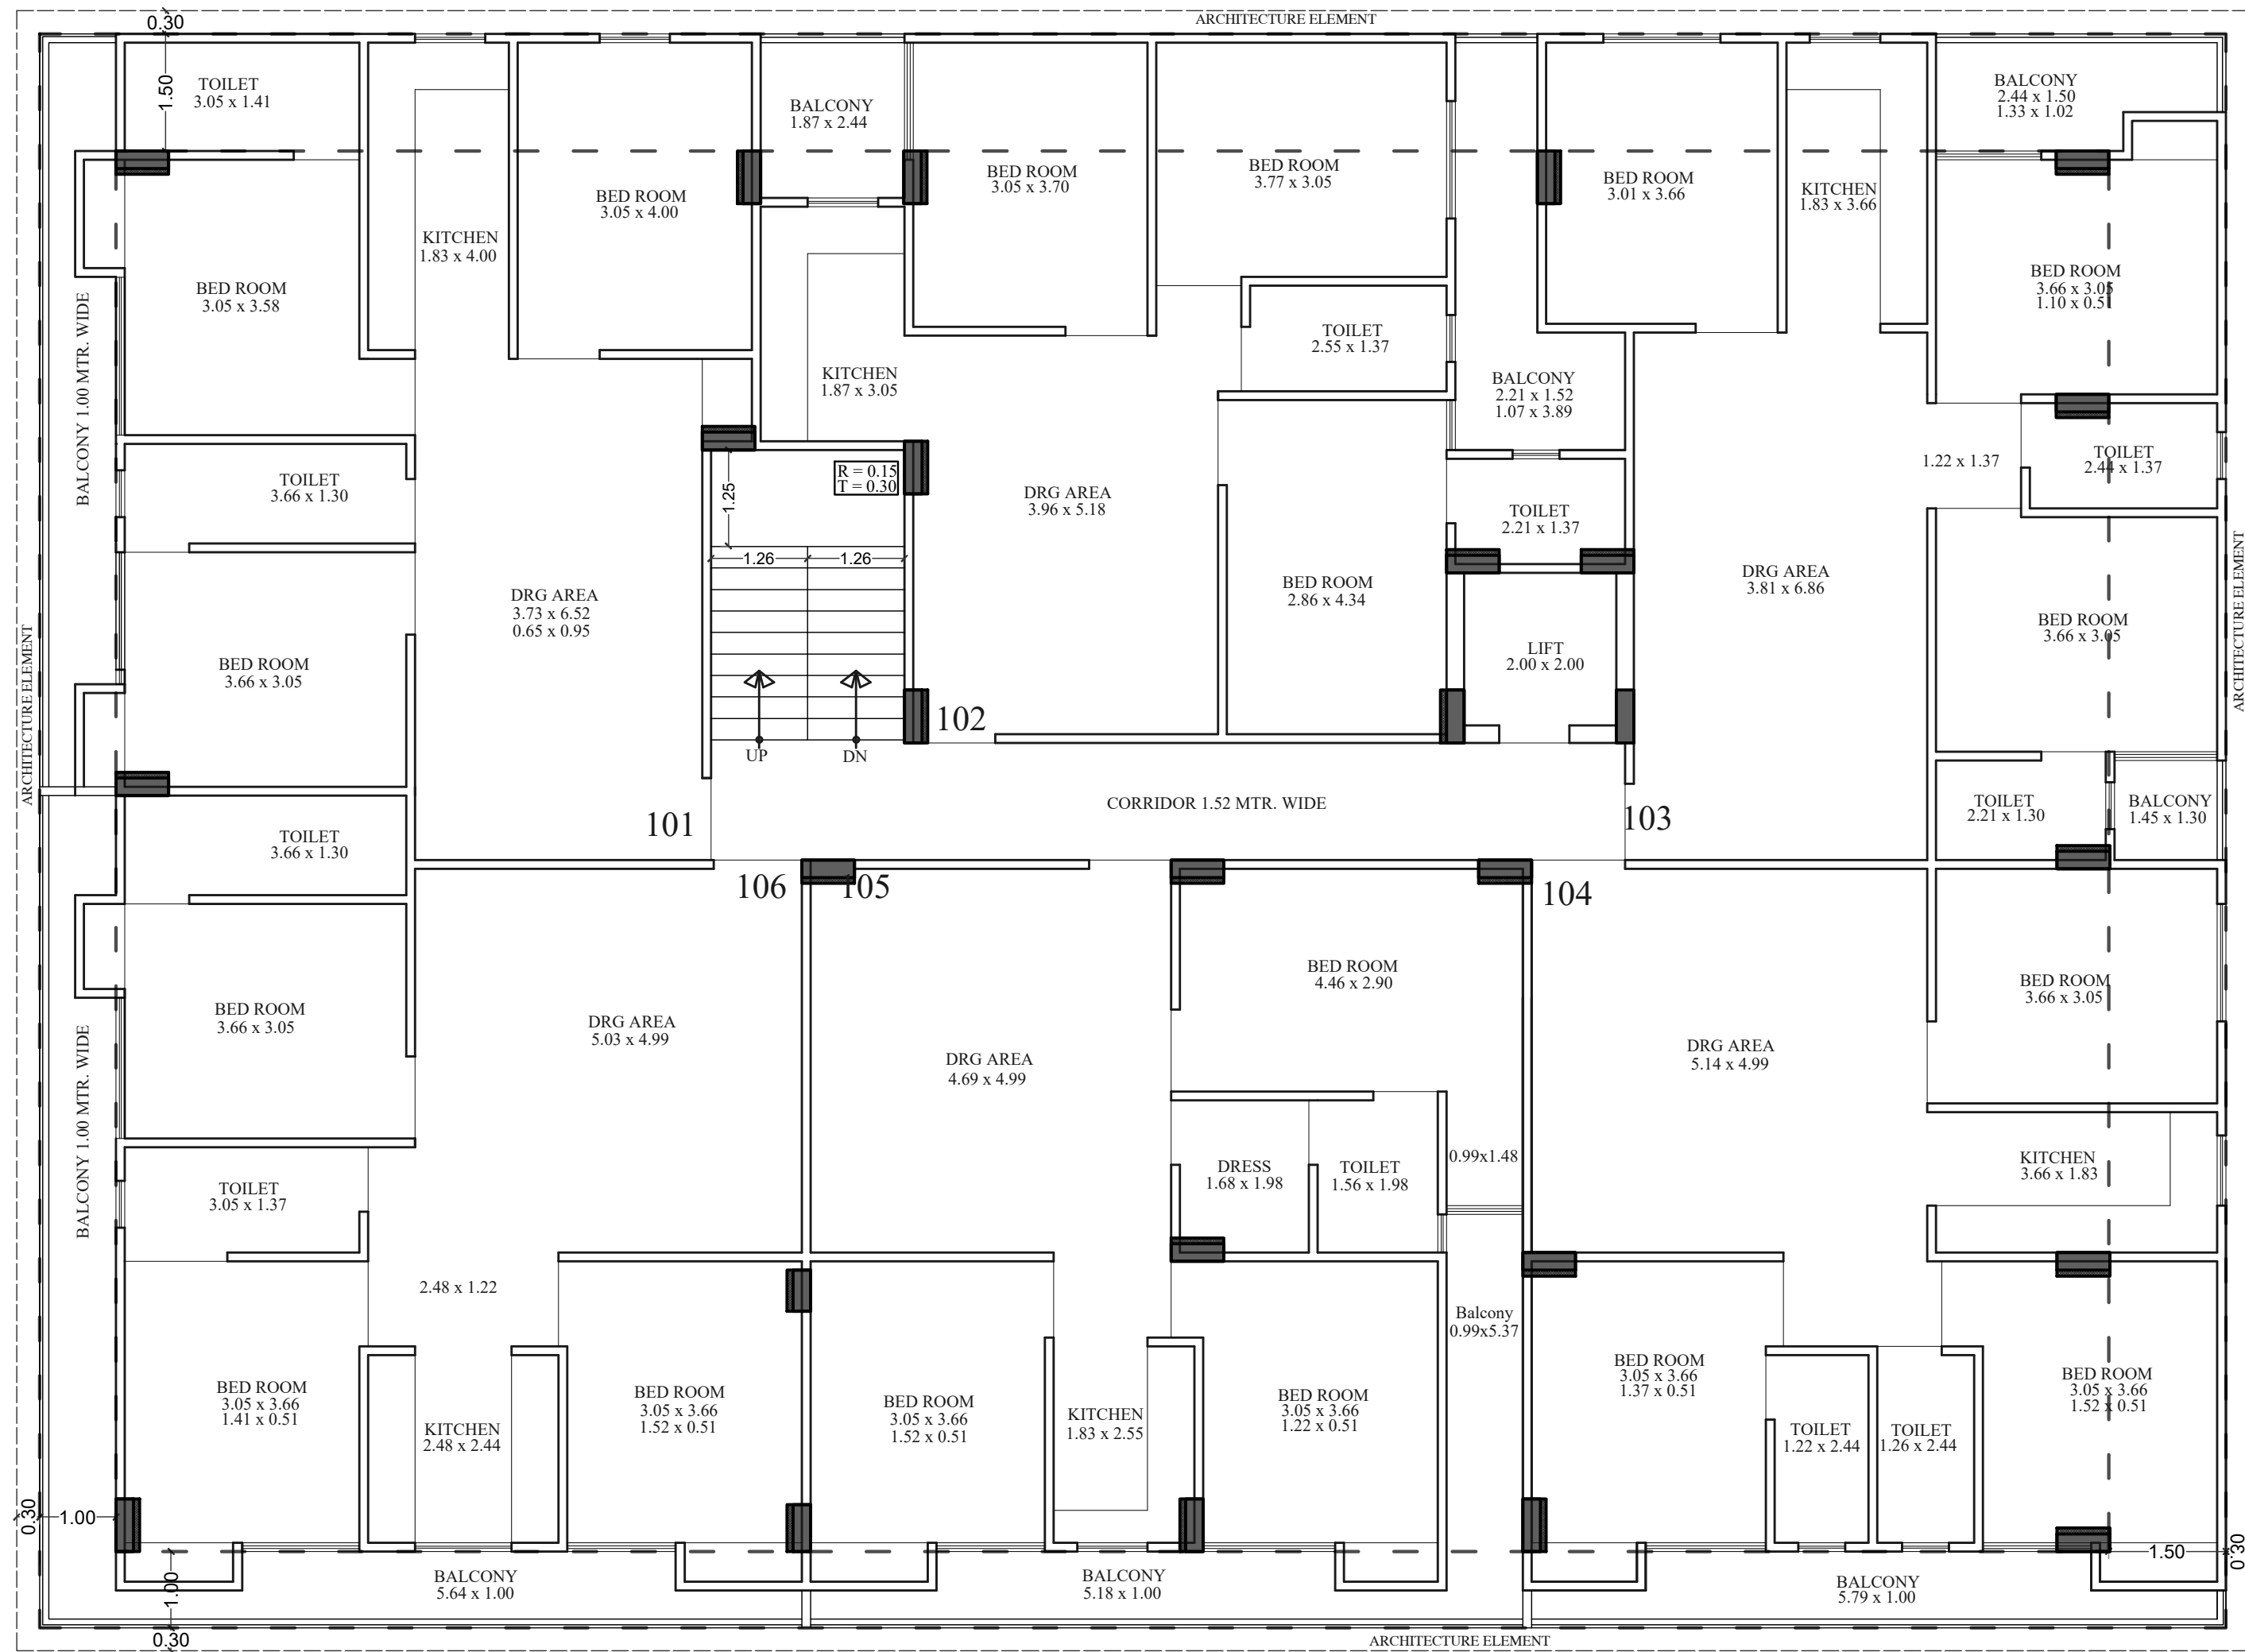


Shree Ram Builders and Developers

Partner




GROUND FLOOR AREA PLAN


AREA IN SQ.MT	FLAT NO.	101 3BHK	102 3BHK	103 3BHK	104 3BHK	105 3BHK	106 3BHK	ADDRESS :- PROPOSED BUILDING AT PLOT NO.-A53 & A54, NARAYANPURI-A, JAIPUR	
BUILTUP AREA		=91.30	= 88.05	= 89.27	= 91.06	= 95.09	=103.36	BUILDING NAME	ANANDAM HEIGHTS III
CARPET AREA		=76.13	= 71.81	= 78.71	= 79.73	= 77.90	=82.89	DEVELOPER NAME	SHREE RAM BUILDERS & DEVELOPERS
BALCONY AREA		= 10.91	= 11.26	= 6.91	= 7.82	= 13.56	= 16.87		

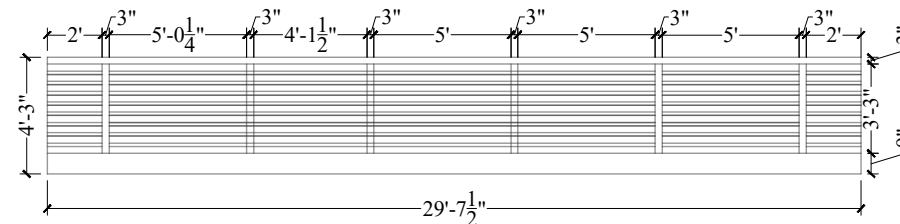

ARCHITECT :-
 **FRANK SQUARE**
 ARCHITECTURE | PLANNER | DESIGNER
 C-49 VIDYA APARTMENT PARAS MARG,
 BAPU NAGAR JAIPUR, (RAJ.)
 Email-afranksquare@gmail.com
 Mobile-9461302542

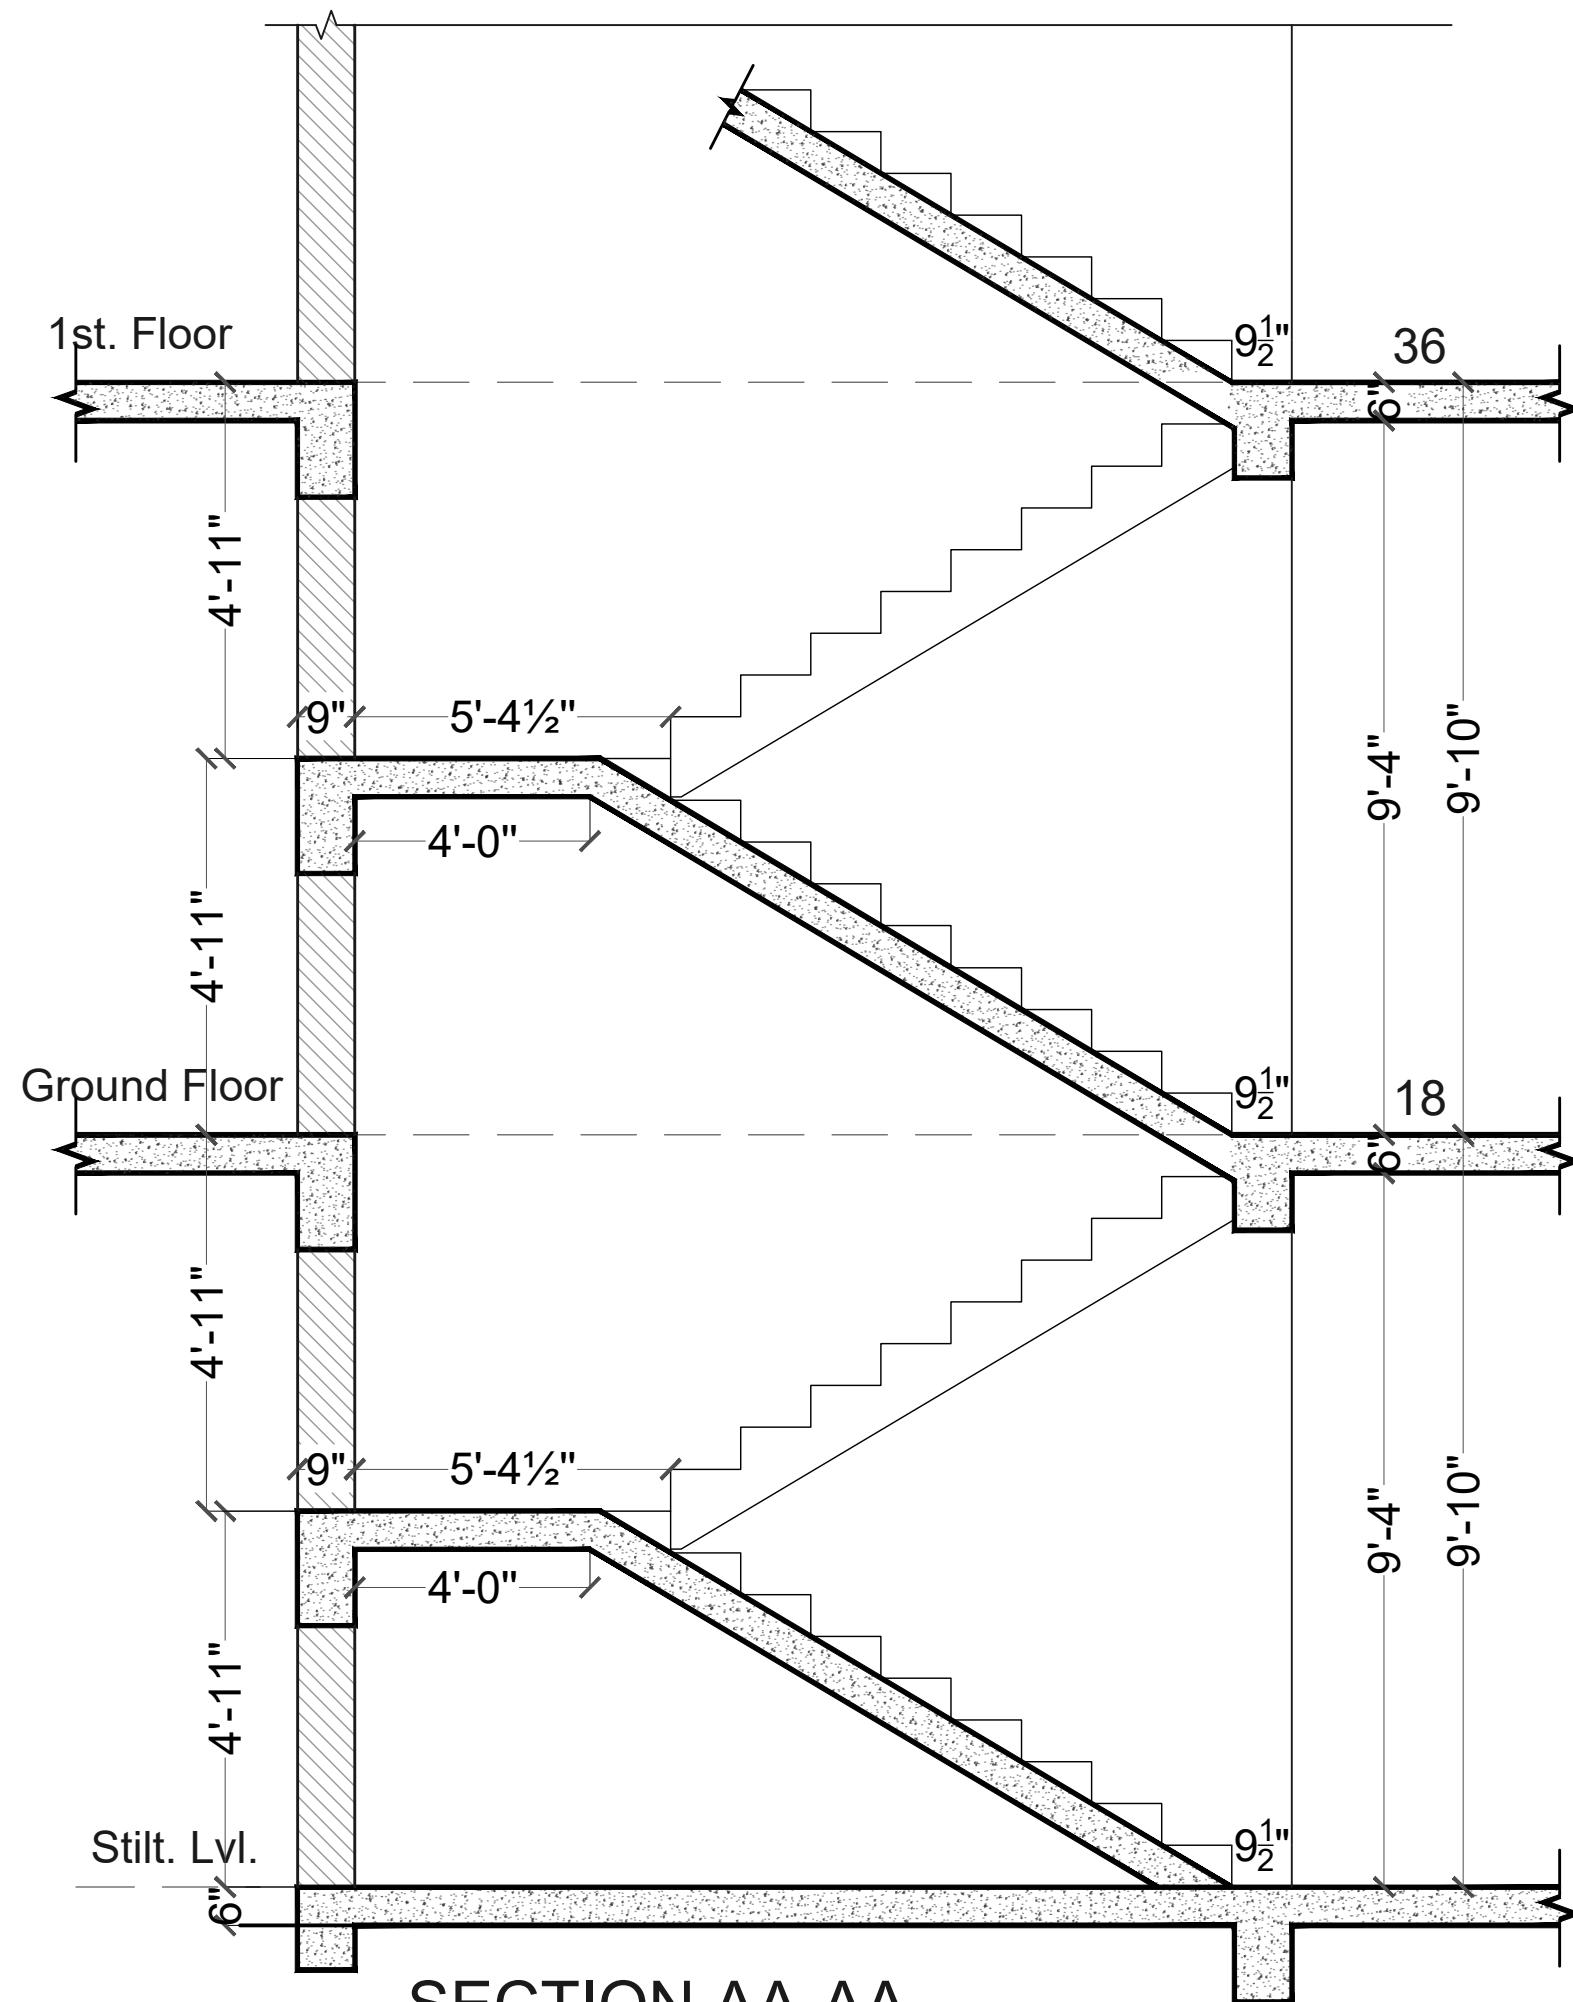

SECTION AA-AA

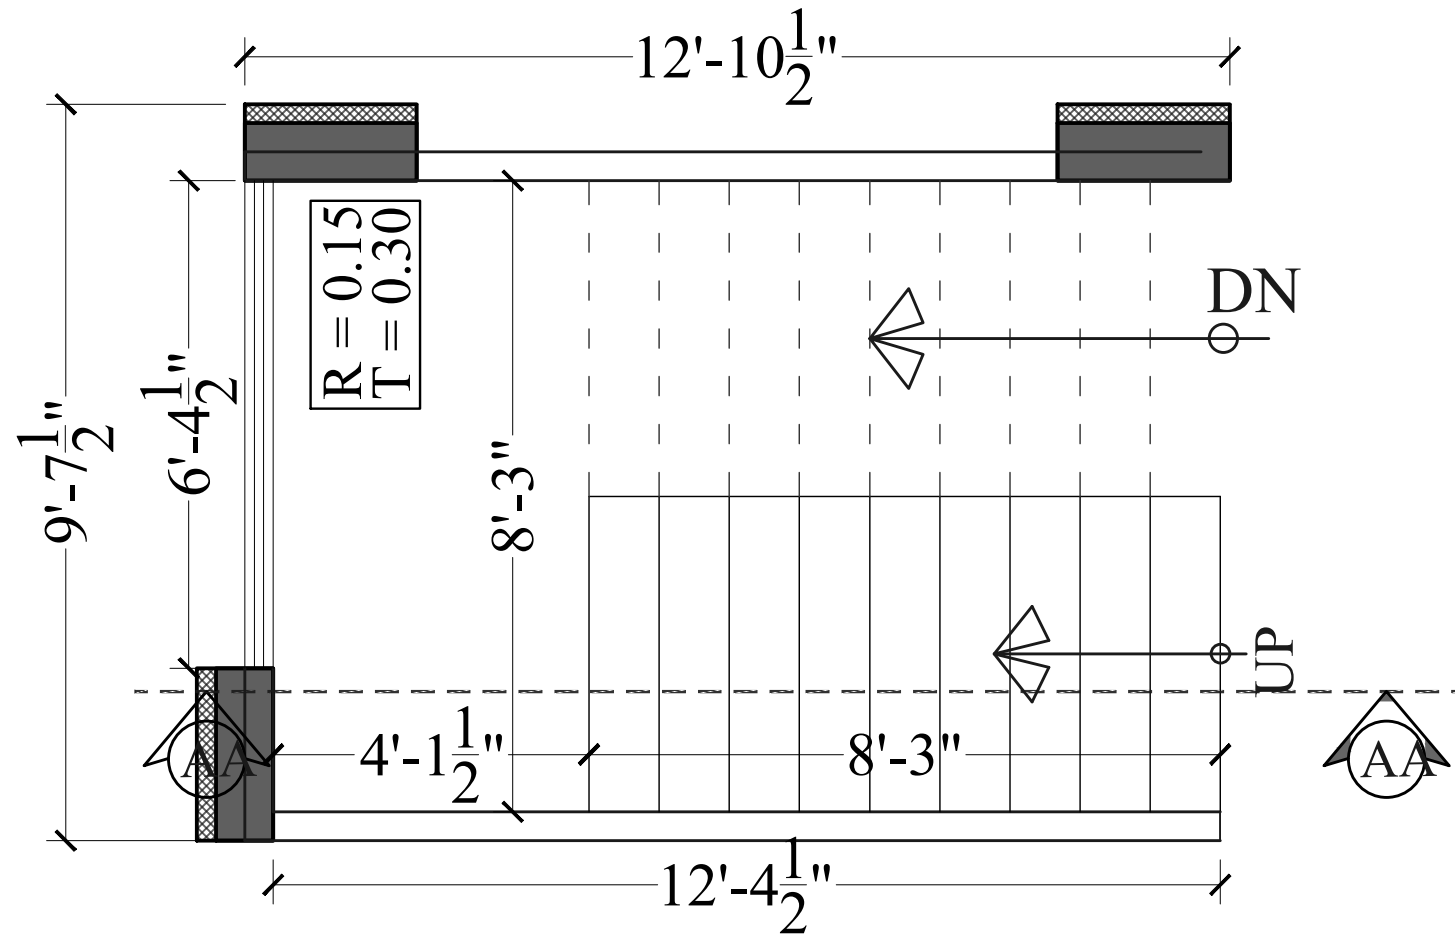

Stilt Floor To Ground Floor Stair Case Plan

Shree Ram Builders and Developers

[Signature]

Partner


PROJECT TITLE :-
PROPOSED BUILDING AT
PLOT NO.-A-53 & A-54,
NARAYANPURI-A, JAIPUR


BUILDING NAME
ANANDAM HEIGHTS III
DEVELOPER NAME
SHREE RAM BUILDERS & DEVELOPERS

DRAWING TITLE :-
STAIR CASE
SECTION DETAIL

ARCHITECT :-
FRANK SQUARE
ARCHITECTURE | PLANNER | DESIGNER
C-49 VIDYA APARTMENT PARAS MARG,
BAPU NAGAR JAIPUR, (RAJ.)
Email-afranksquare@gmail.com
Mobile-9461302542



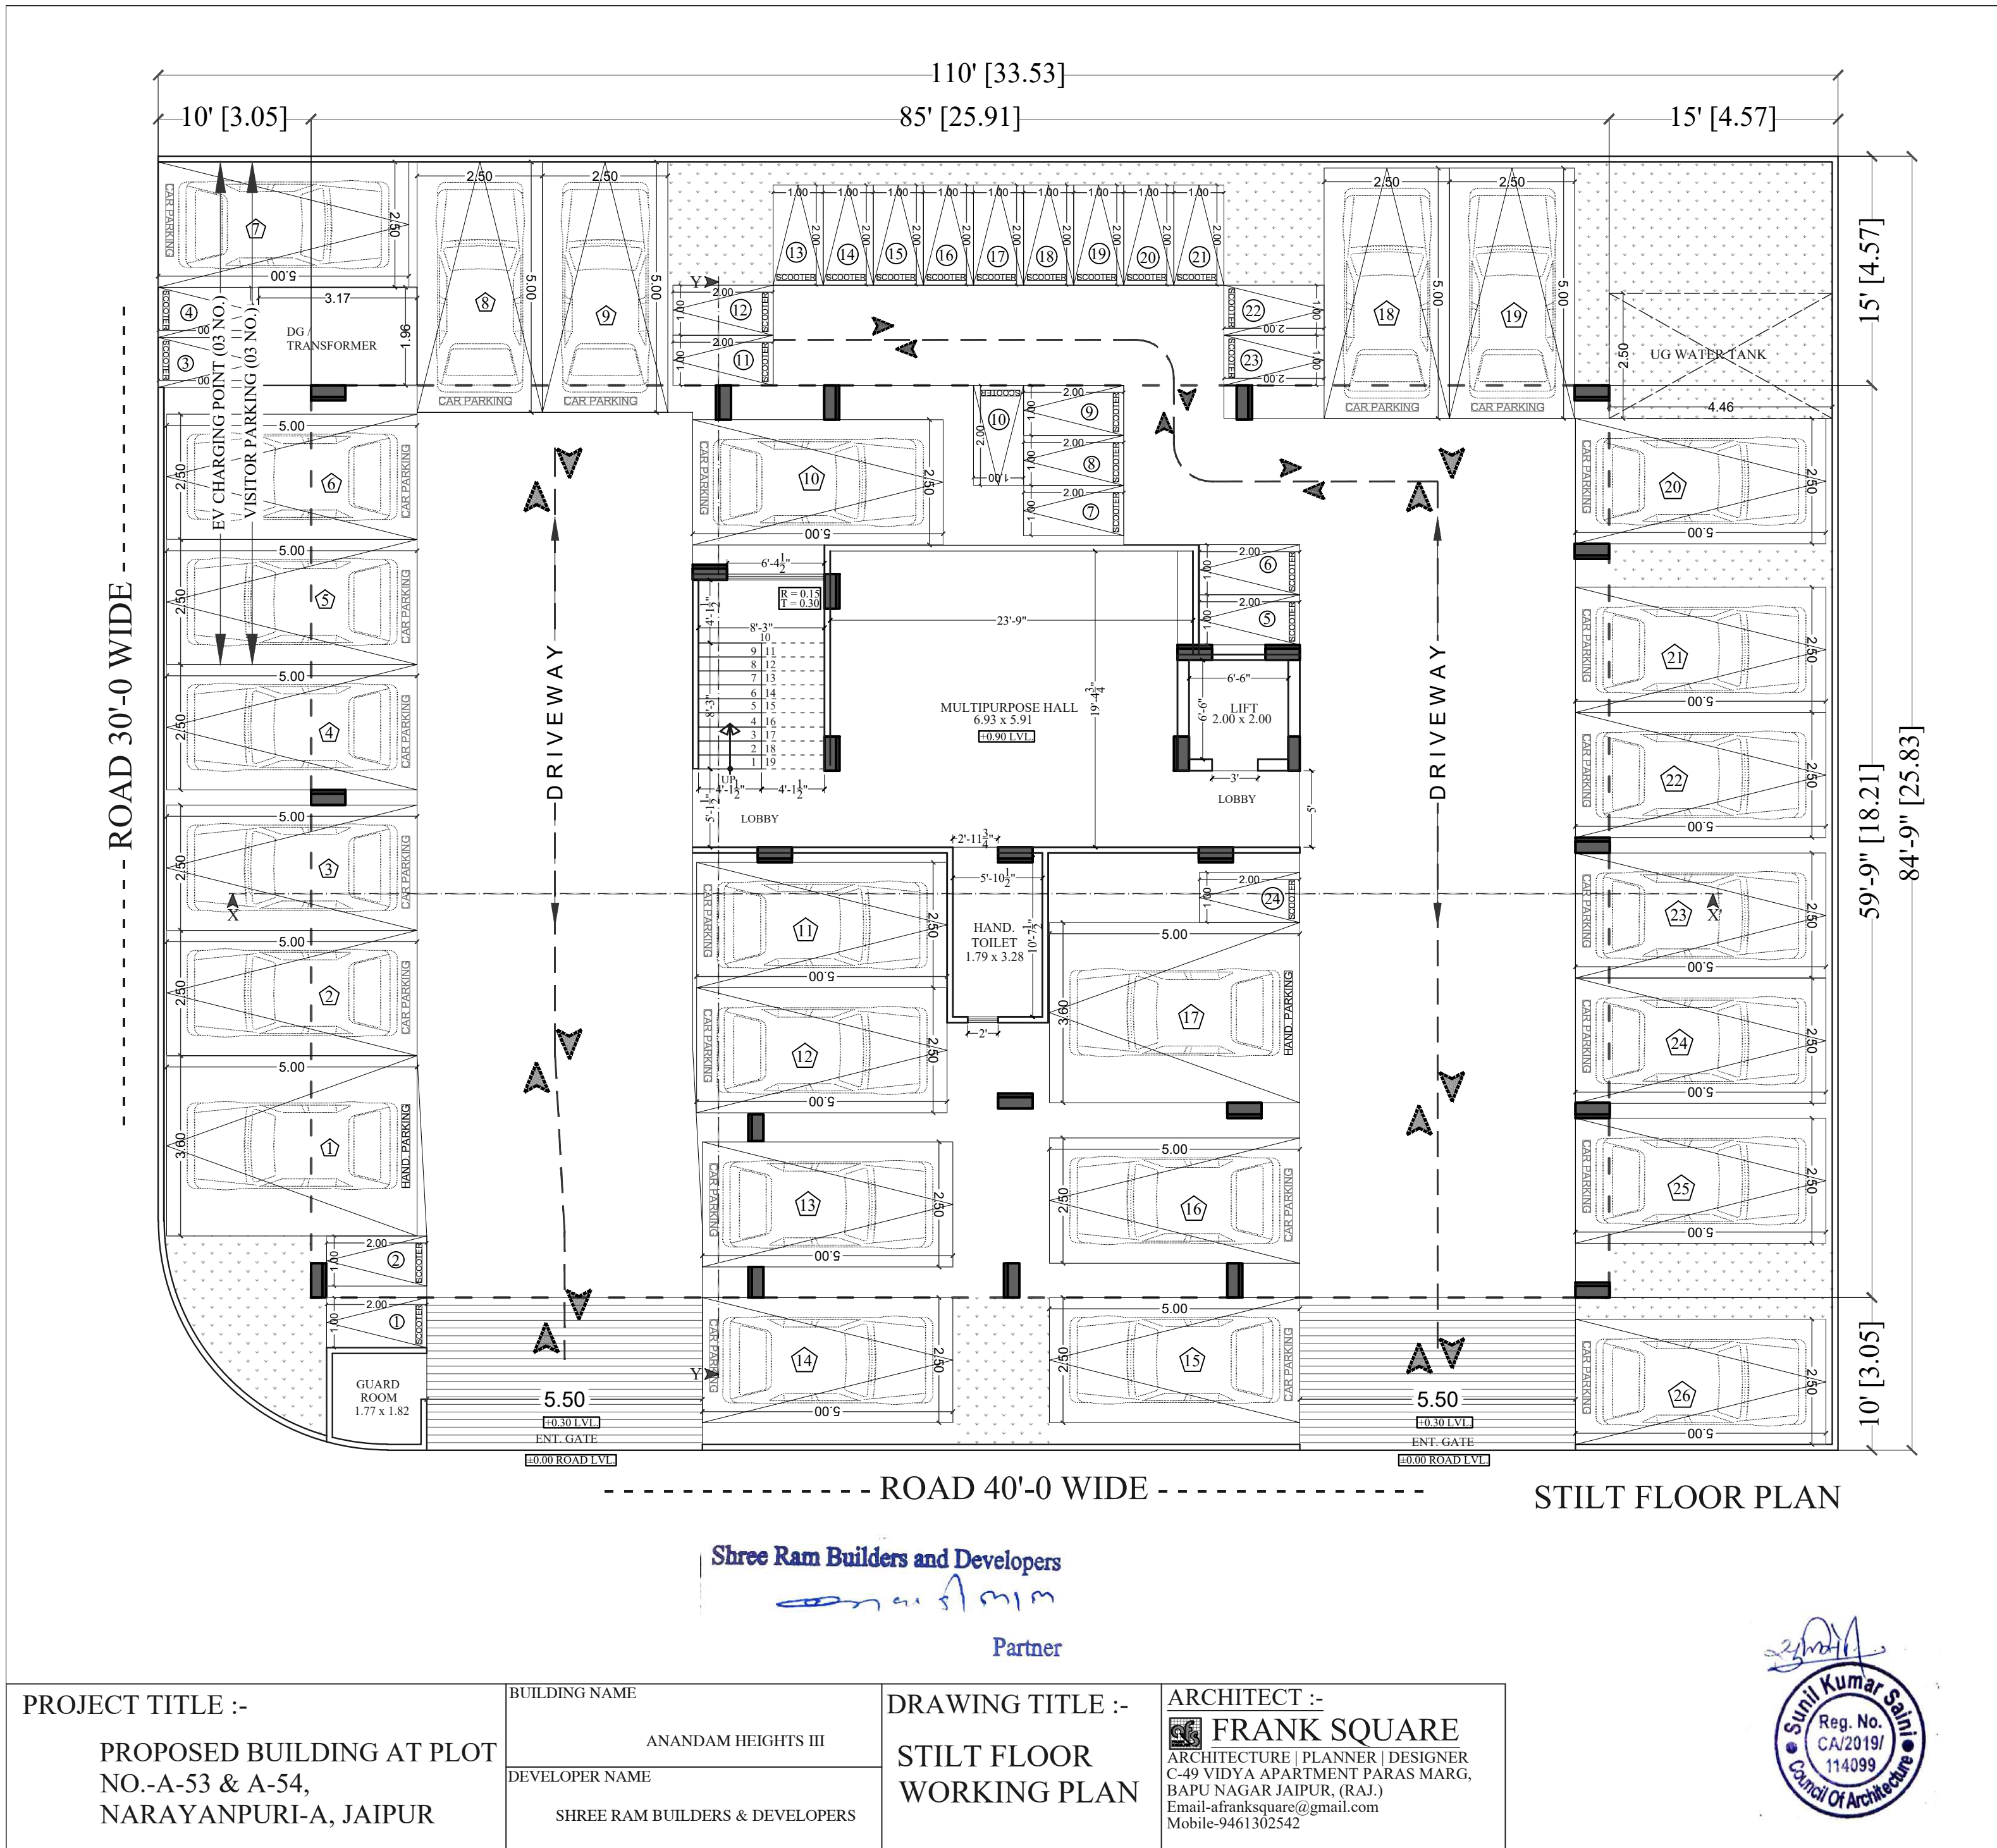

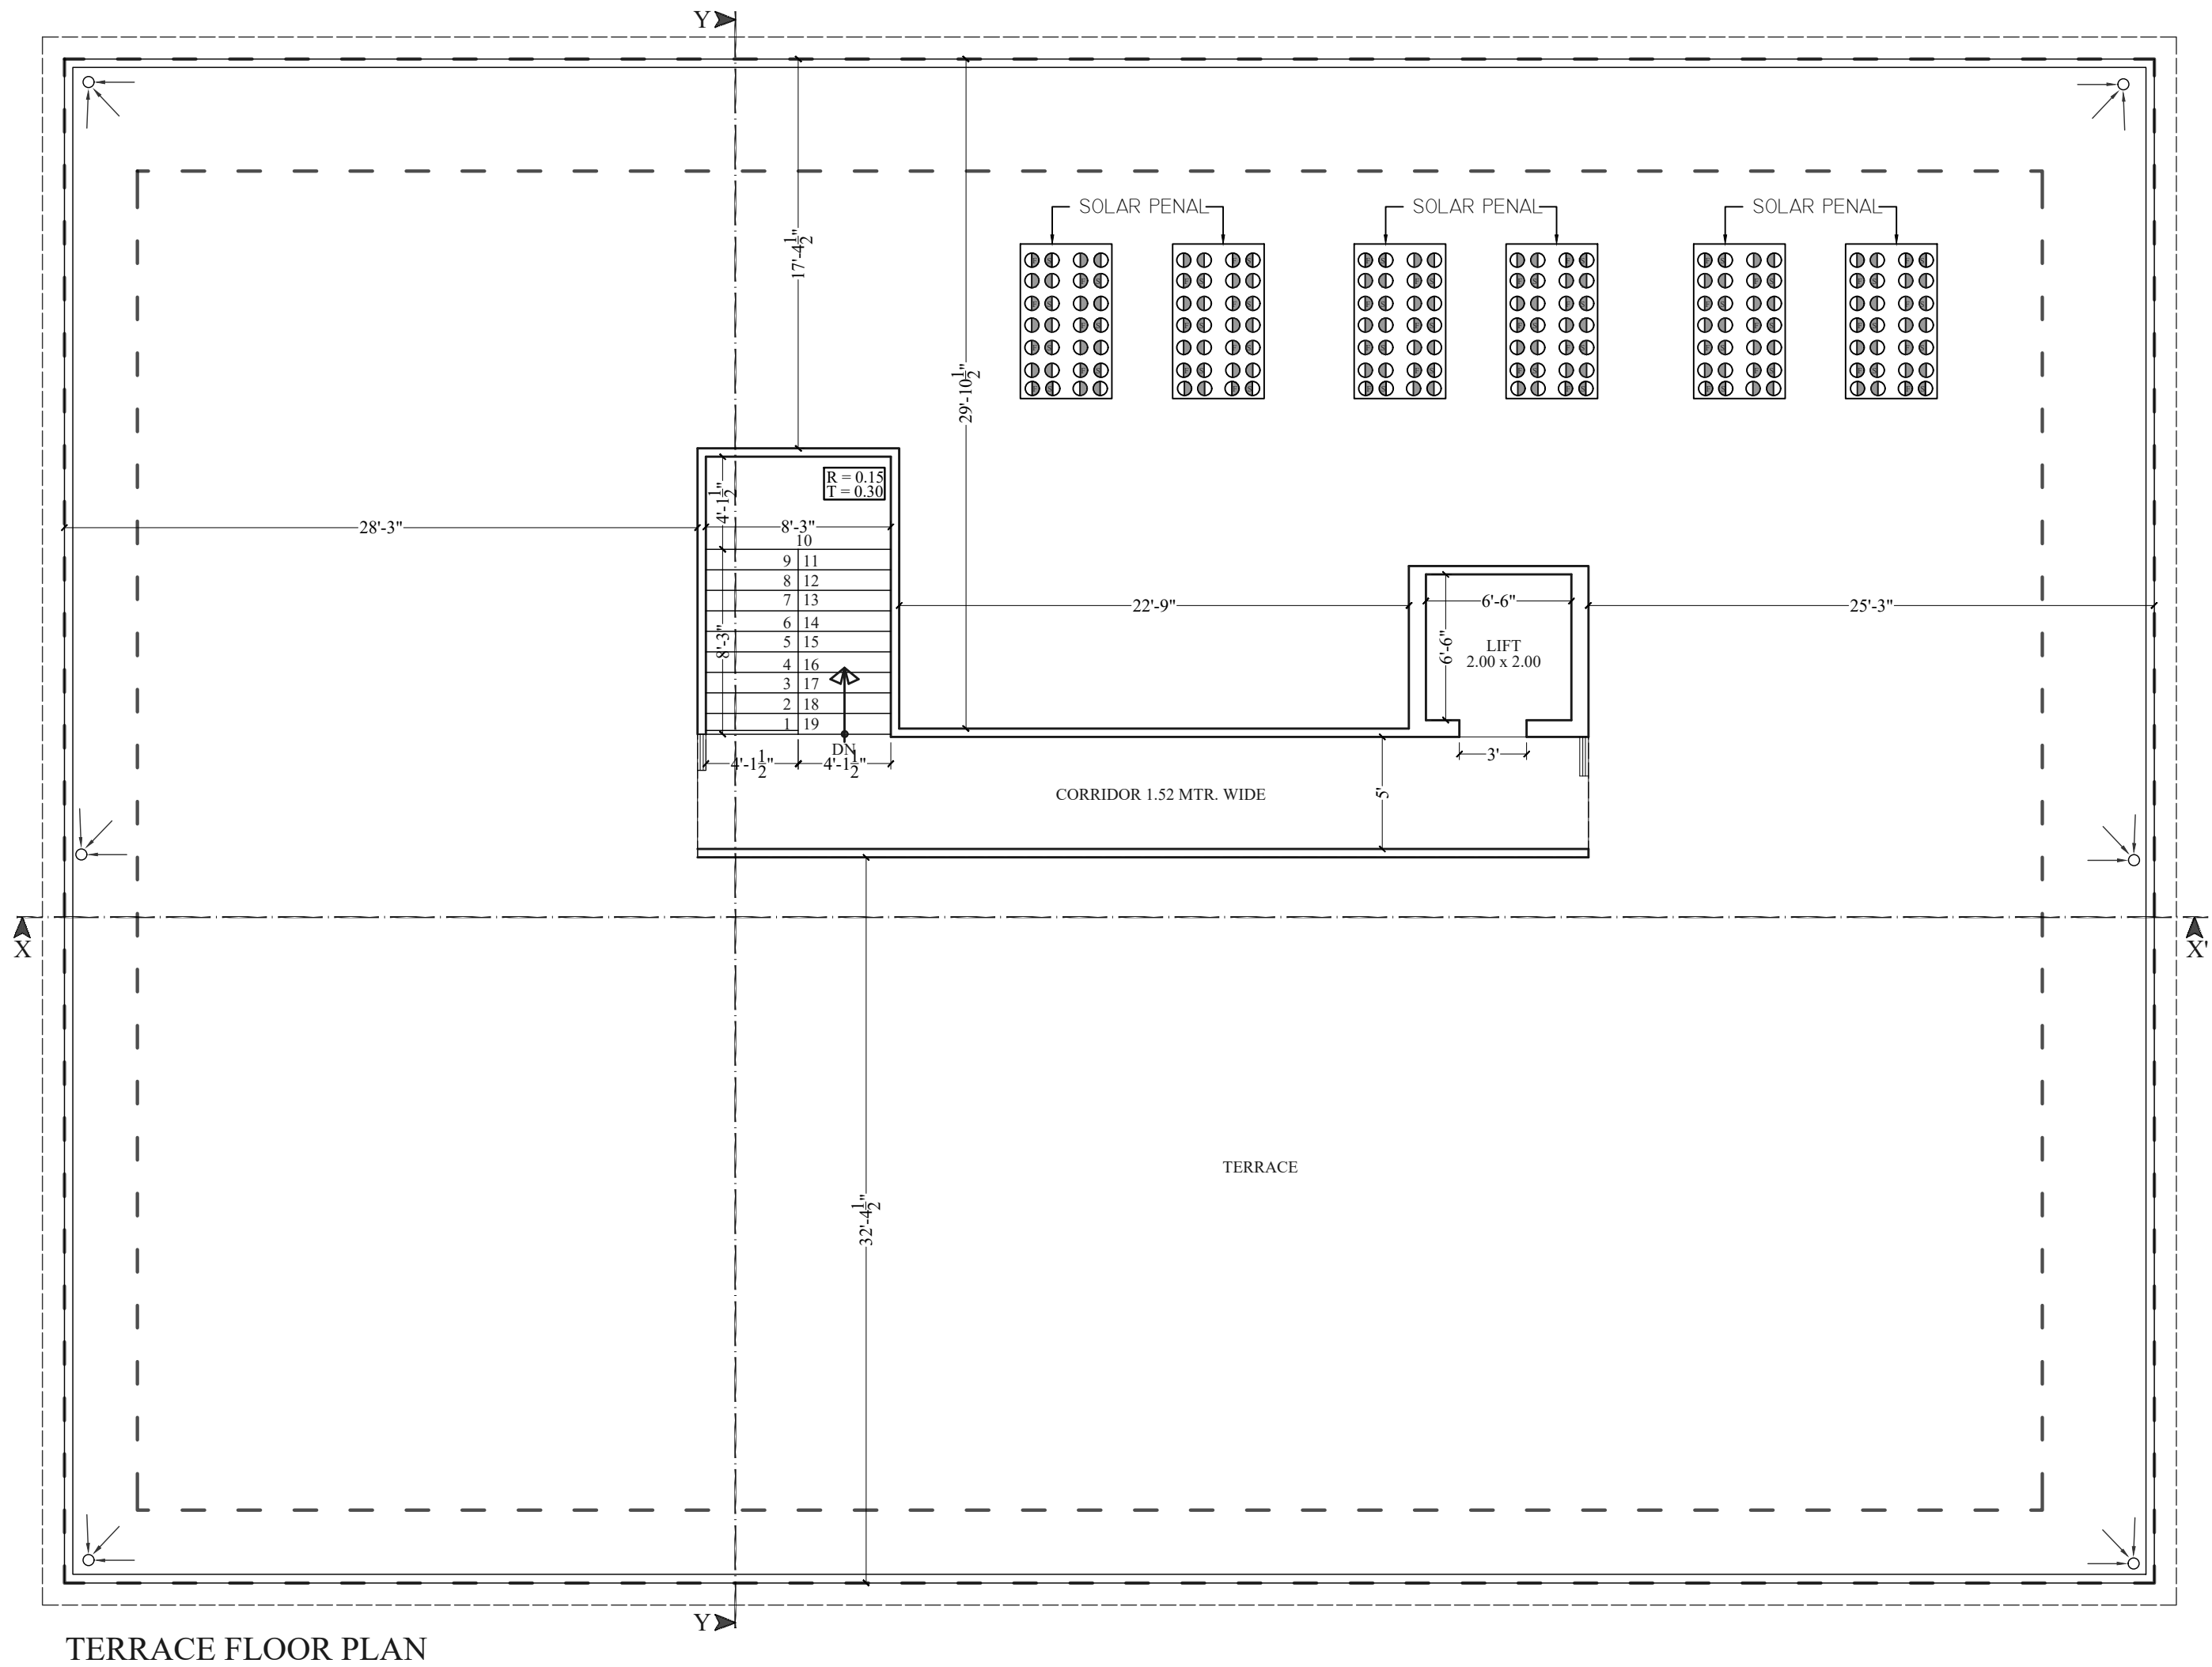

TERRACE FLOOR PLAN

Shree Ram Builders and Developers
[Signature]
Partner




PROJECT TITLE :-
PROPOSED BUILDING AT
PLOT NO.-A-53 & A-54,
NARAYANPURI-A, JAIPUR

BUILDING NAME
ANANDAM HEIGHTS III
DEVELOPER NAME
SHREE RAM BUILDERS & DEVELOPERS

DRAWING TITLE :-
TERRACE FLOOR
WORKING PLAN

ARCHITECT :-
FRANK SQUARE
ARCHITECTURE | PLANNER | DESIGNER
C-49 VIDYA APARTMENT PARAS MARG,
BAPU NAGAR JAIPUR, (RAJ.)
Email-afranksquare@gmail.com
Mobile-9461302542

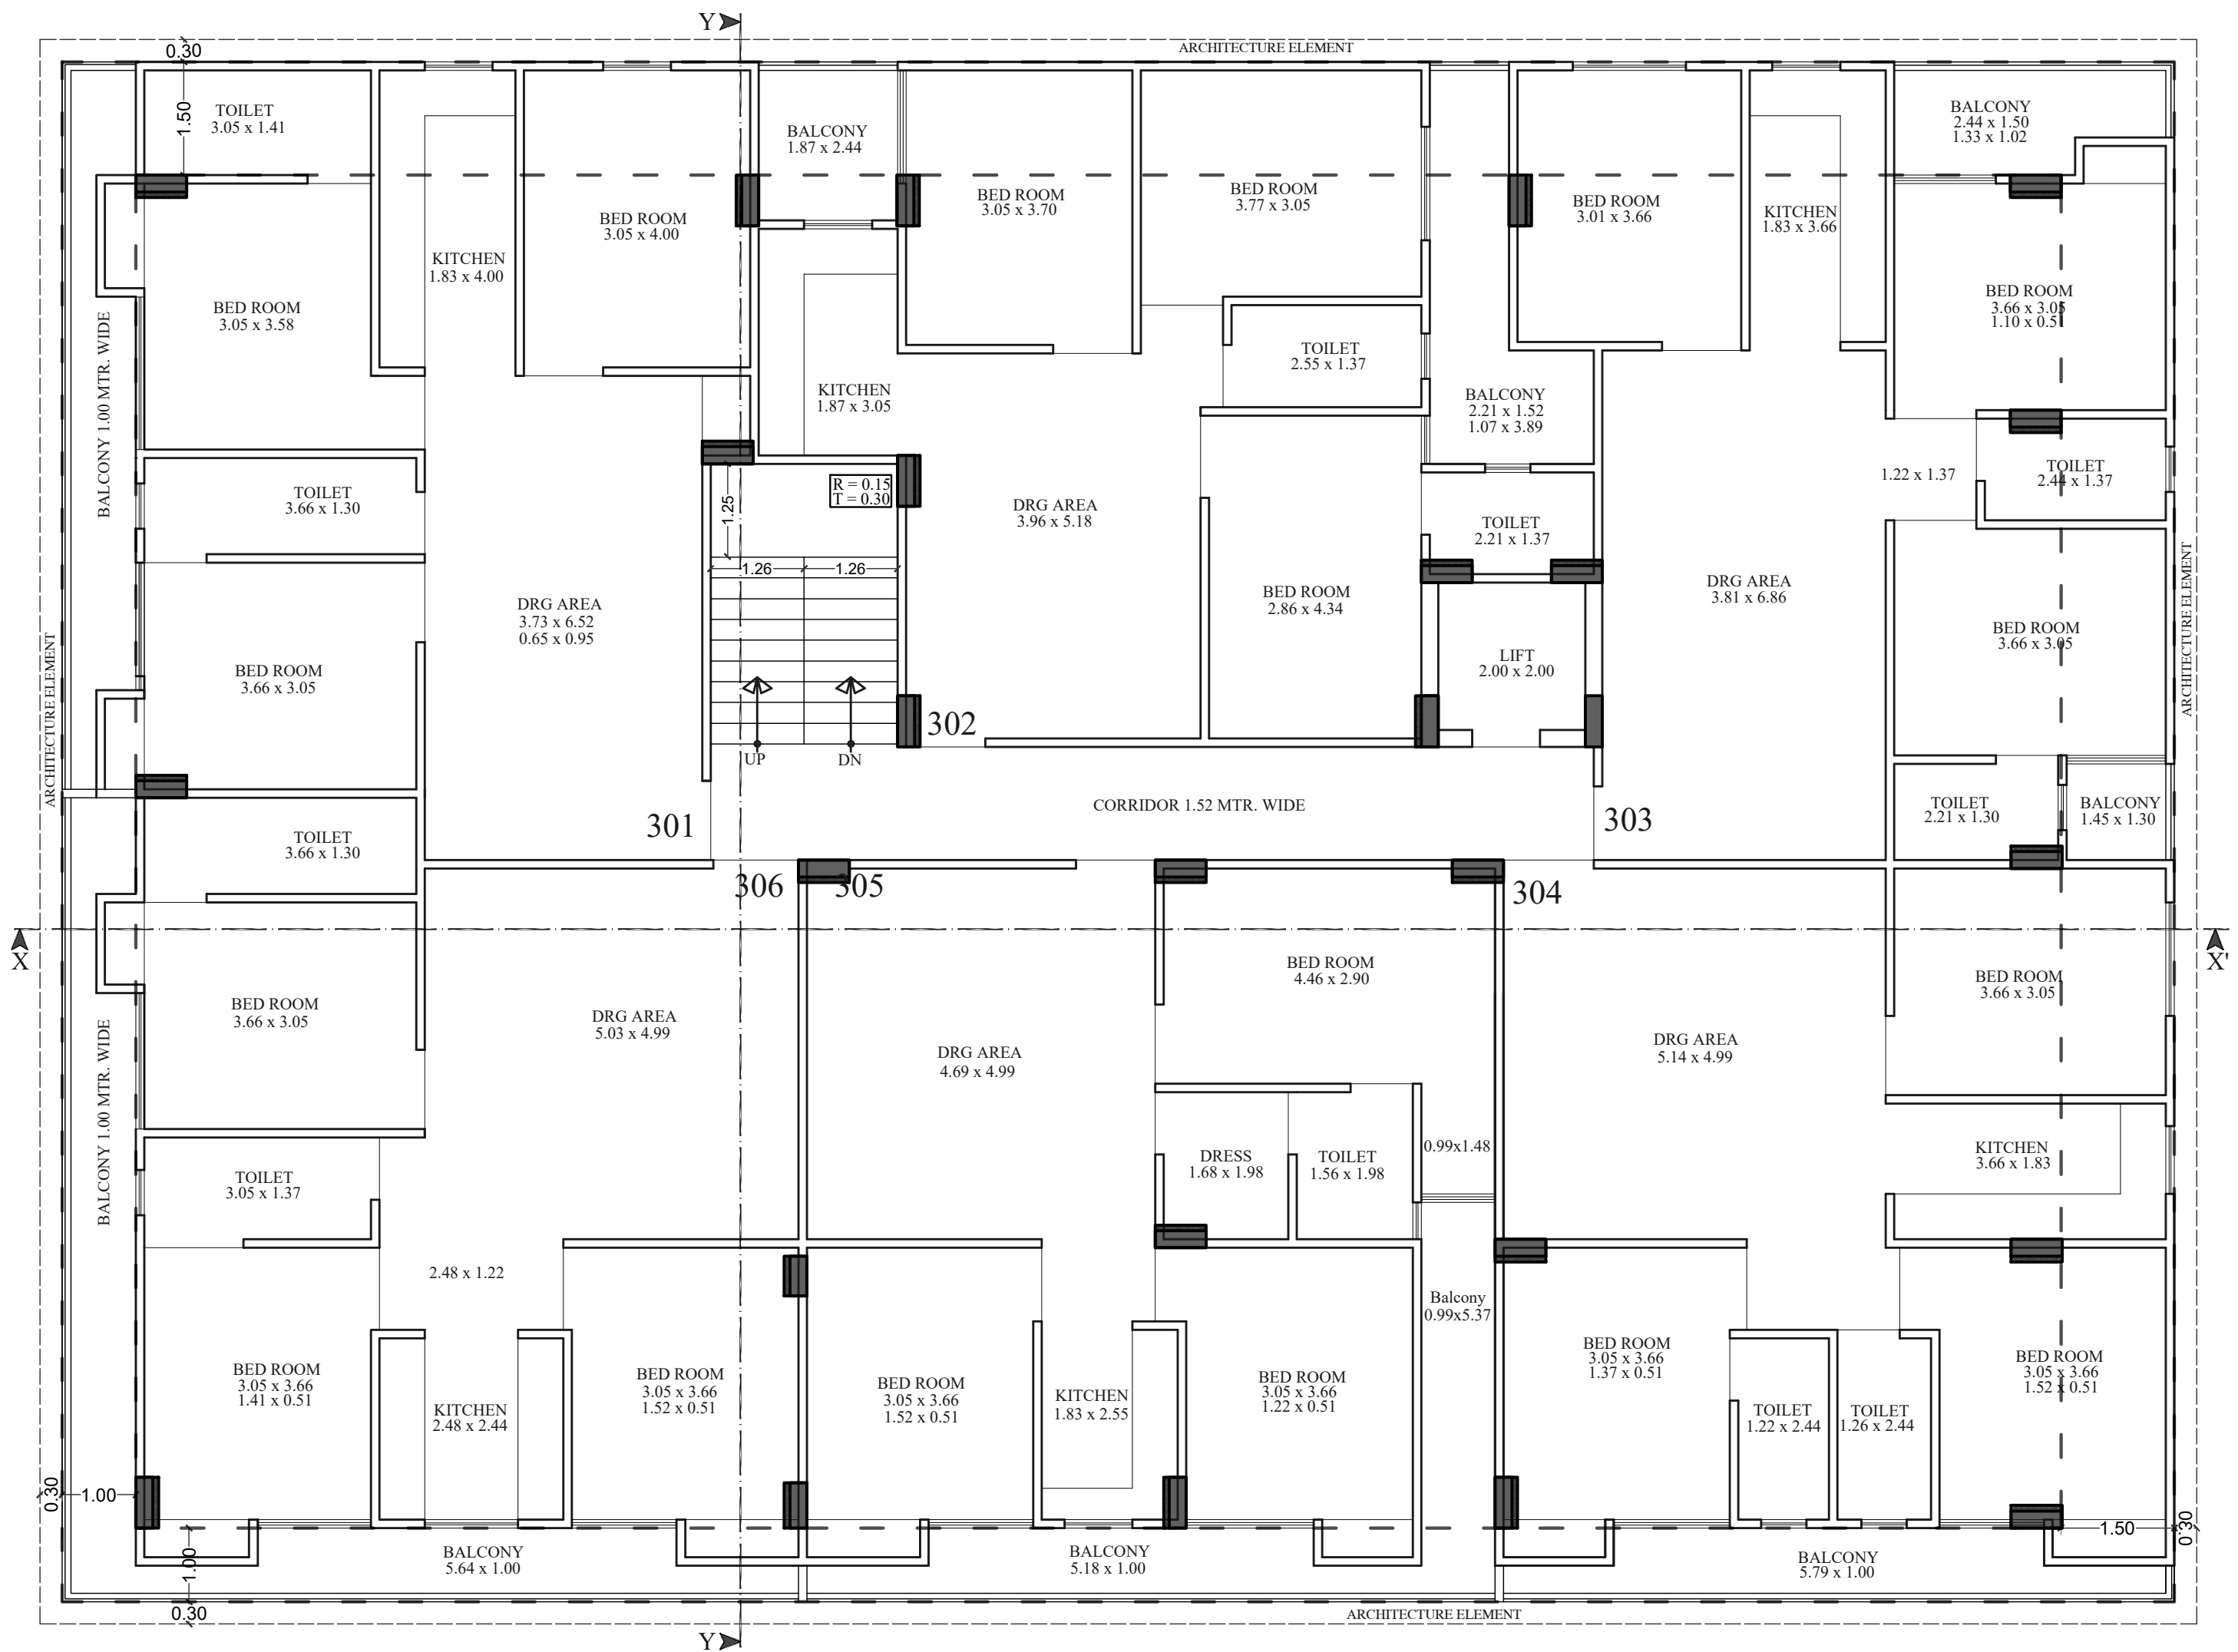


Shree Ram Builders and Developers

Partner



SECOND FLOOR AREA PLAN

AREA IN SQ.MT	FLAT NO.	301 3BHK	302 3BHK	303 3BHK	304 3BHK	305 3BHK	306 3BHK	ADDRESS :- PROPOSED BUILDING AT PLOT NO.-A53 & A54, NARAYANPURI-A, JAIPUR	
BUILTUP AREA		=91.30	= 88.05	= 89.27	= 91.06	= 95.09	=103.36	BUILDING NAME	ANANDAM HEIGHTS III
CARPET AREA		=76.13	= 71.81	= 78.71	= 79.73	= 77.90	=82.89	DEVELOPER NAME	SHREE RAM BUILDERS & DEVELOPERS
BALCONY AREA		= 10.91	= 11.26	= 6.91	= 7.82	= 13.56	= 16.87		

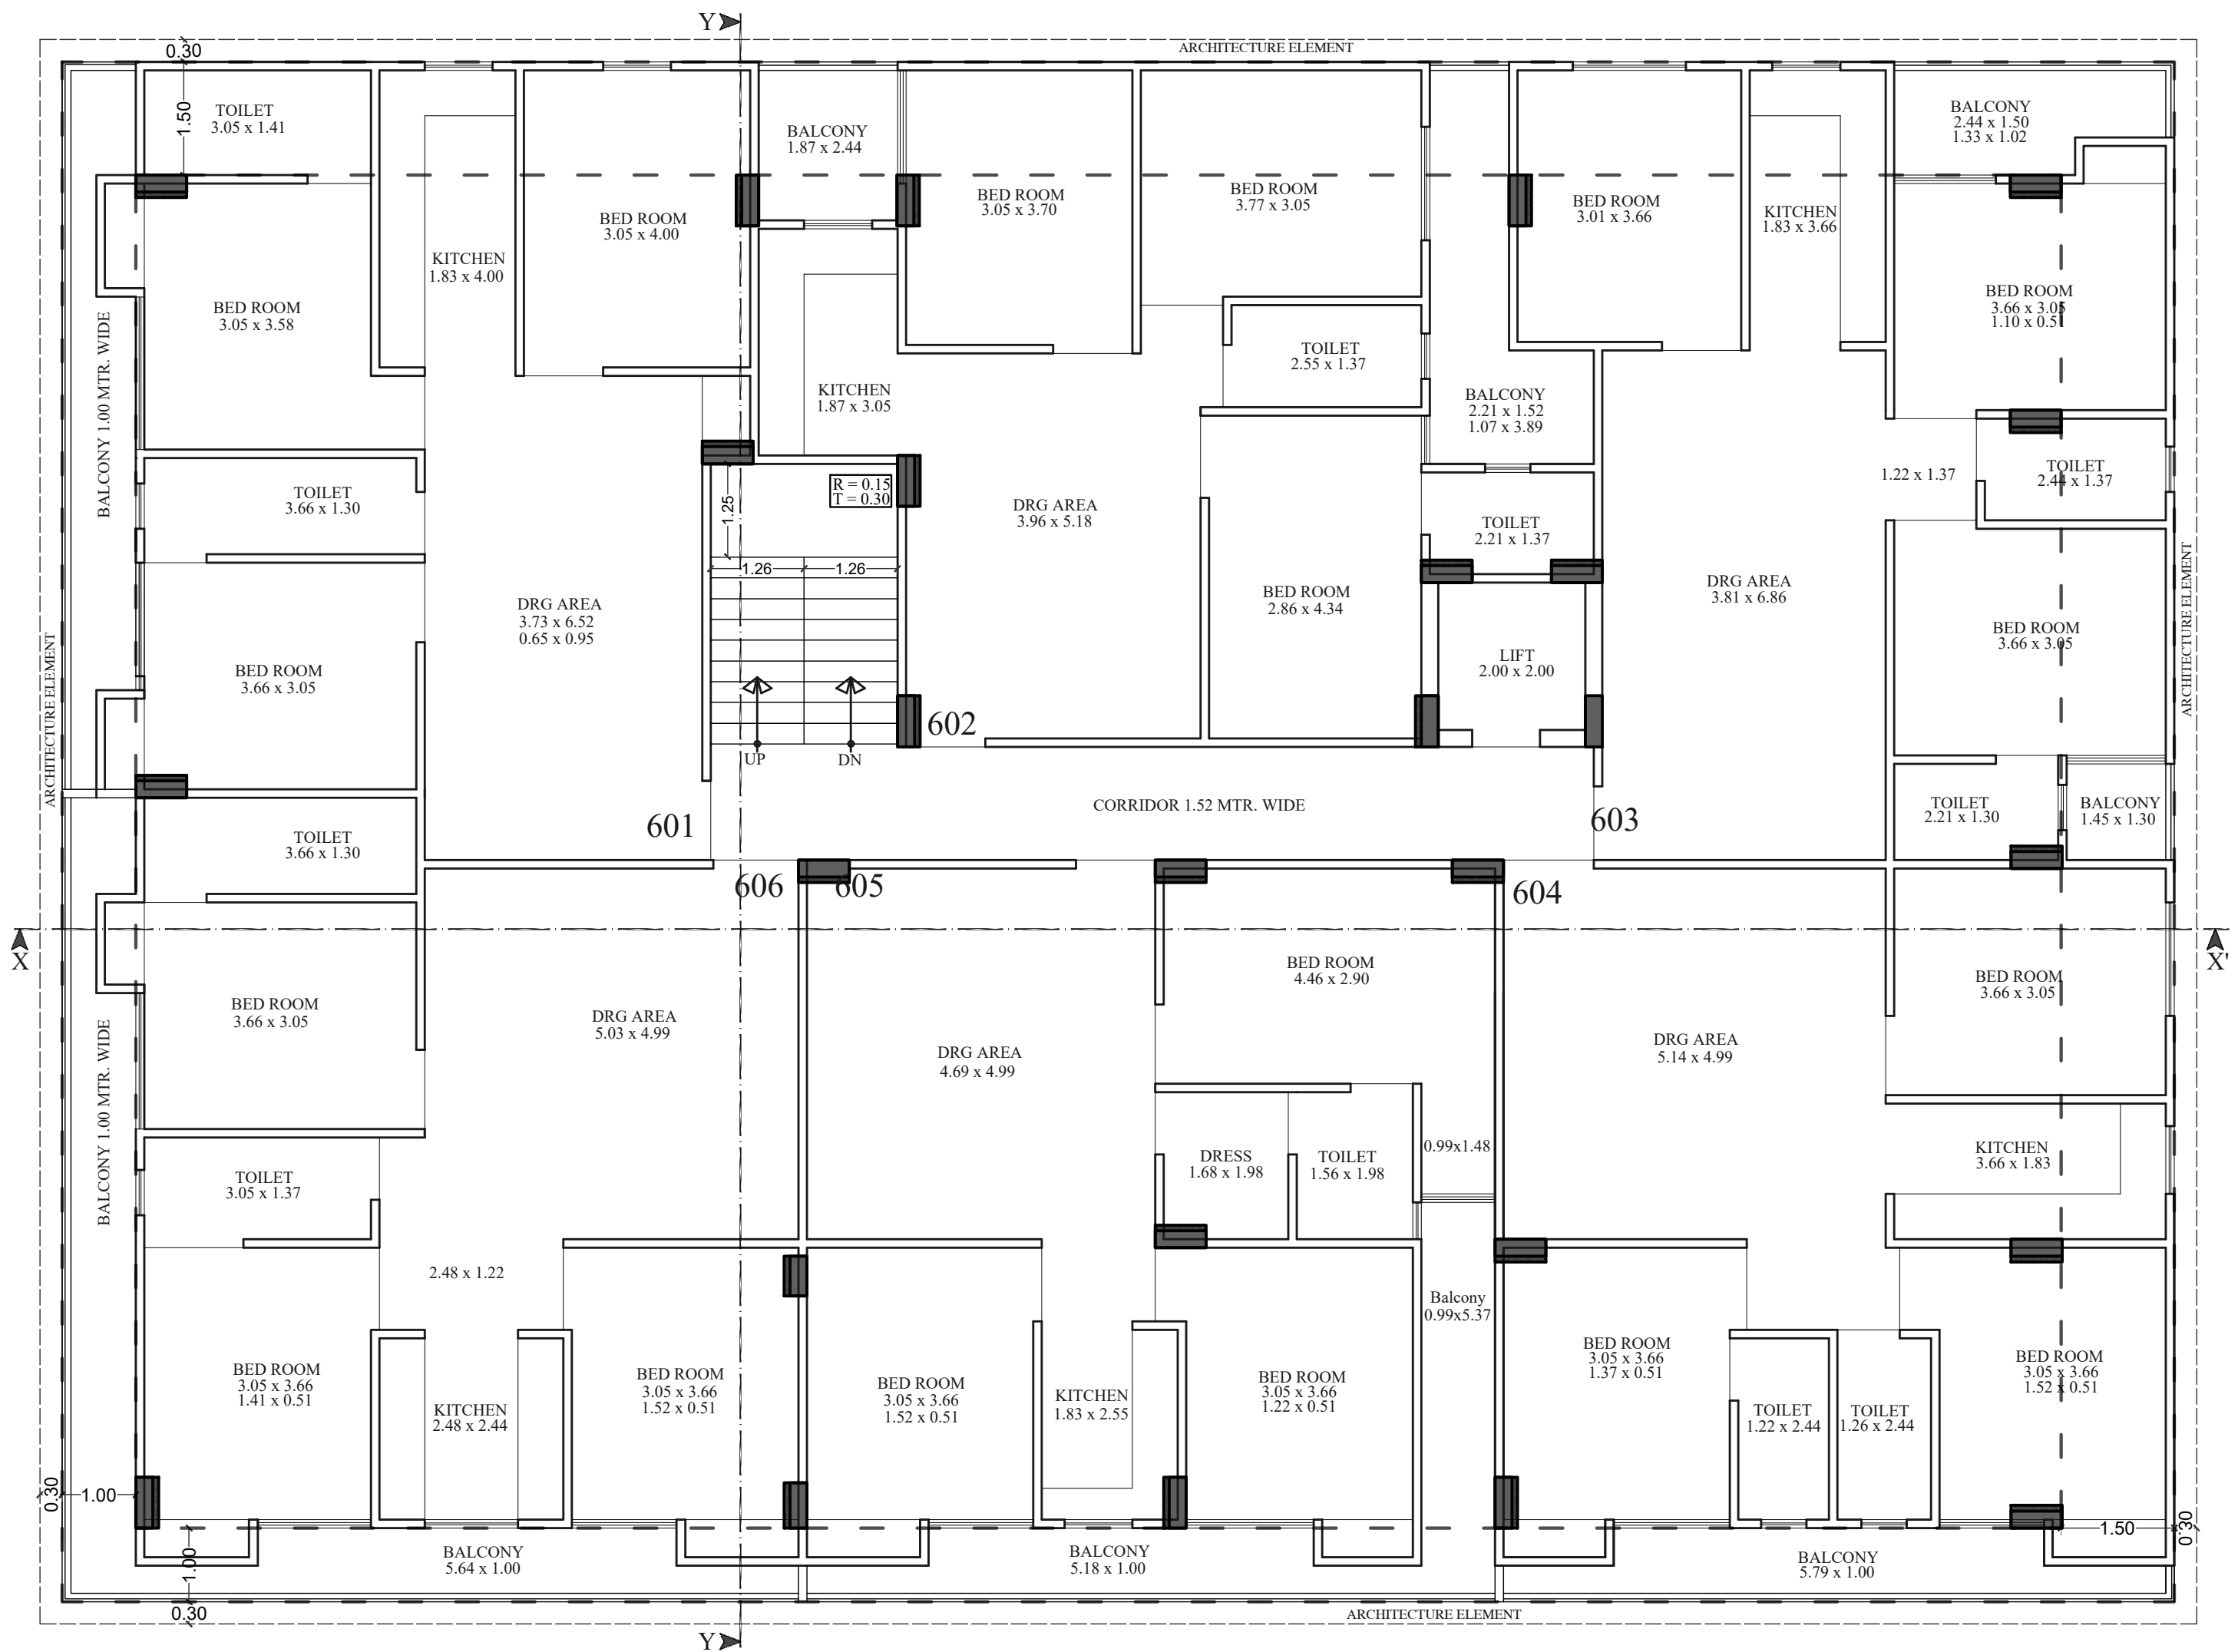

Shree Ram Builders and Developers


(Signature)

Partner



FIFTH FLOOR AREA PLAN

AREA IN SQ.MT	FLAT NO.	601 3BHK	602 3BHK	603 3BHK	604 3BHK	605 3BHK	606 3BHK	ADDRESS :- PROPOSED BUILDING AT PLOT NO.-A53 & A54, NARAYANPURI-A, JAIPUR	
BUILTUP AREA		=91.30	= 88.05	= 89.27	= 91.06	= 95.09	=103.36		
CARPET AREA		=76.13	= 71.81	= 78.71	= 79.73	= 77.90	=82.89	BUILDING NAME	ANANDAM HEIGHTS III
BALCONY AREA		= 10.91	= 11.26	= 6.91	= 7.82	= 13.56	= 16.87	DEVELOPER NAME	SHREE RAM BUILDERS & DEVELOPERS

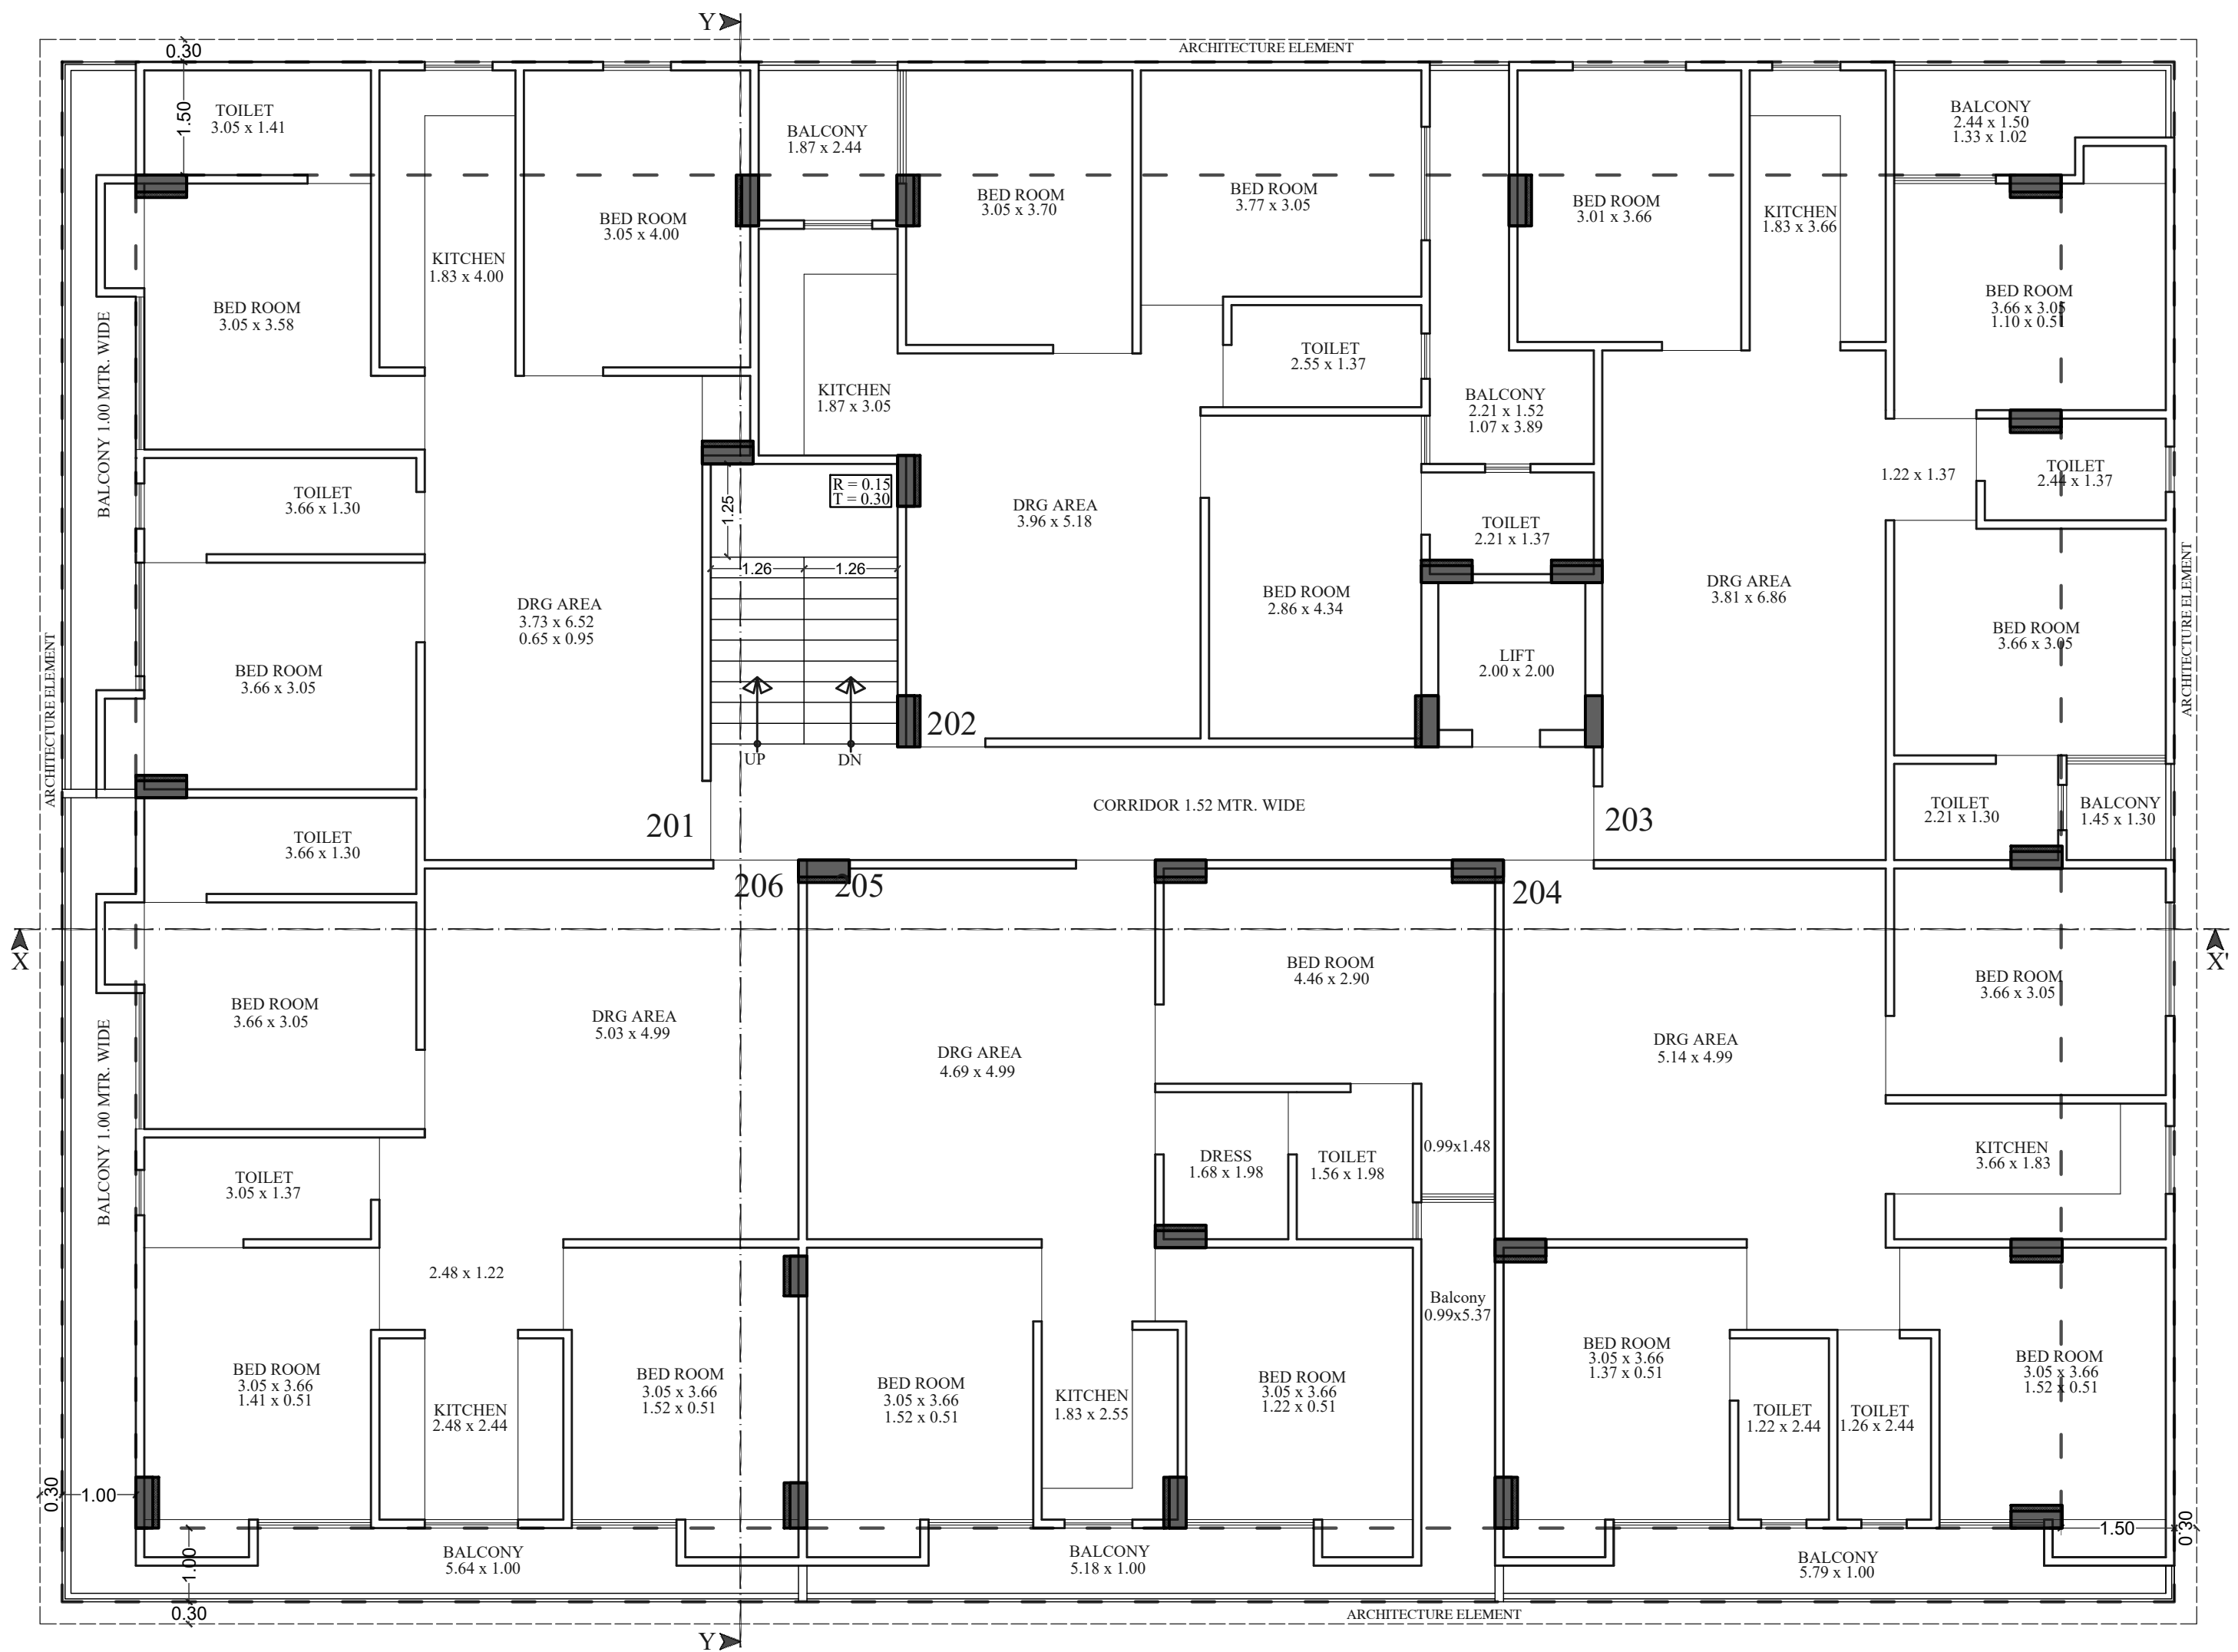

Shree Ram Builders and Developers


[Signature]

Partner



FIRST FLOOR AREA PLAN

AREA IN SQ.MT	FLAT NO.	201 3BHK	202 3BHK	203 3BHK	204 3BHK	205 3BHK	206 3BHK	ADDRESS :- PROPOSED BUILDING AT PLOT NO.-A53 & A54, NARAYANPURI-A, JAIPUR	
BUILTUP AREA		=91.30	= 88.05	= 89.27	= 91.06	= 95.09	=103.36	BUILDING NAME	ANANDAM HEIGHTS III
CARPET AREA		=76.13	= 71.81	= 78.71	= 79.73	= 77.90	=82.89	DEVELOPER NAME	SHREE RAM BUILDERS & DEVELOPERS
BALCONY AREA		= 10.91	= 11.26	= 6.91	= 7.82	= 13.56	= 16.87		

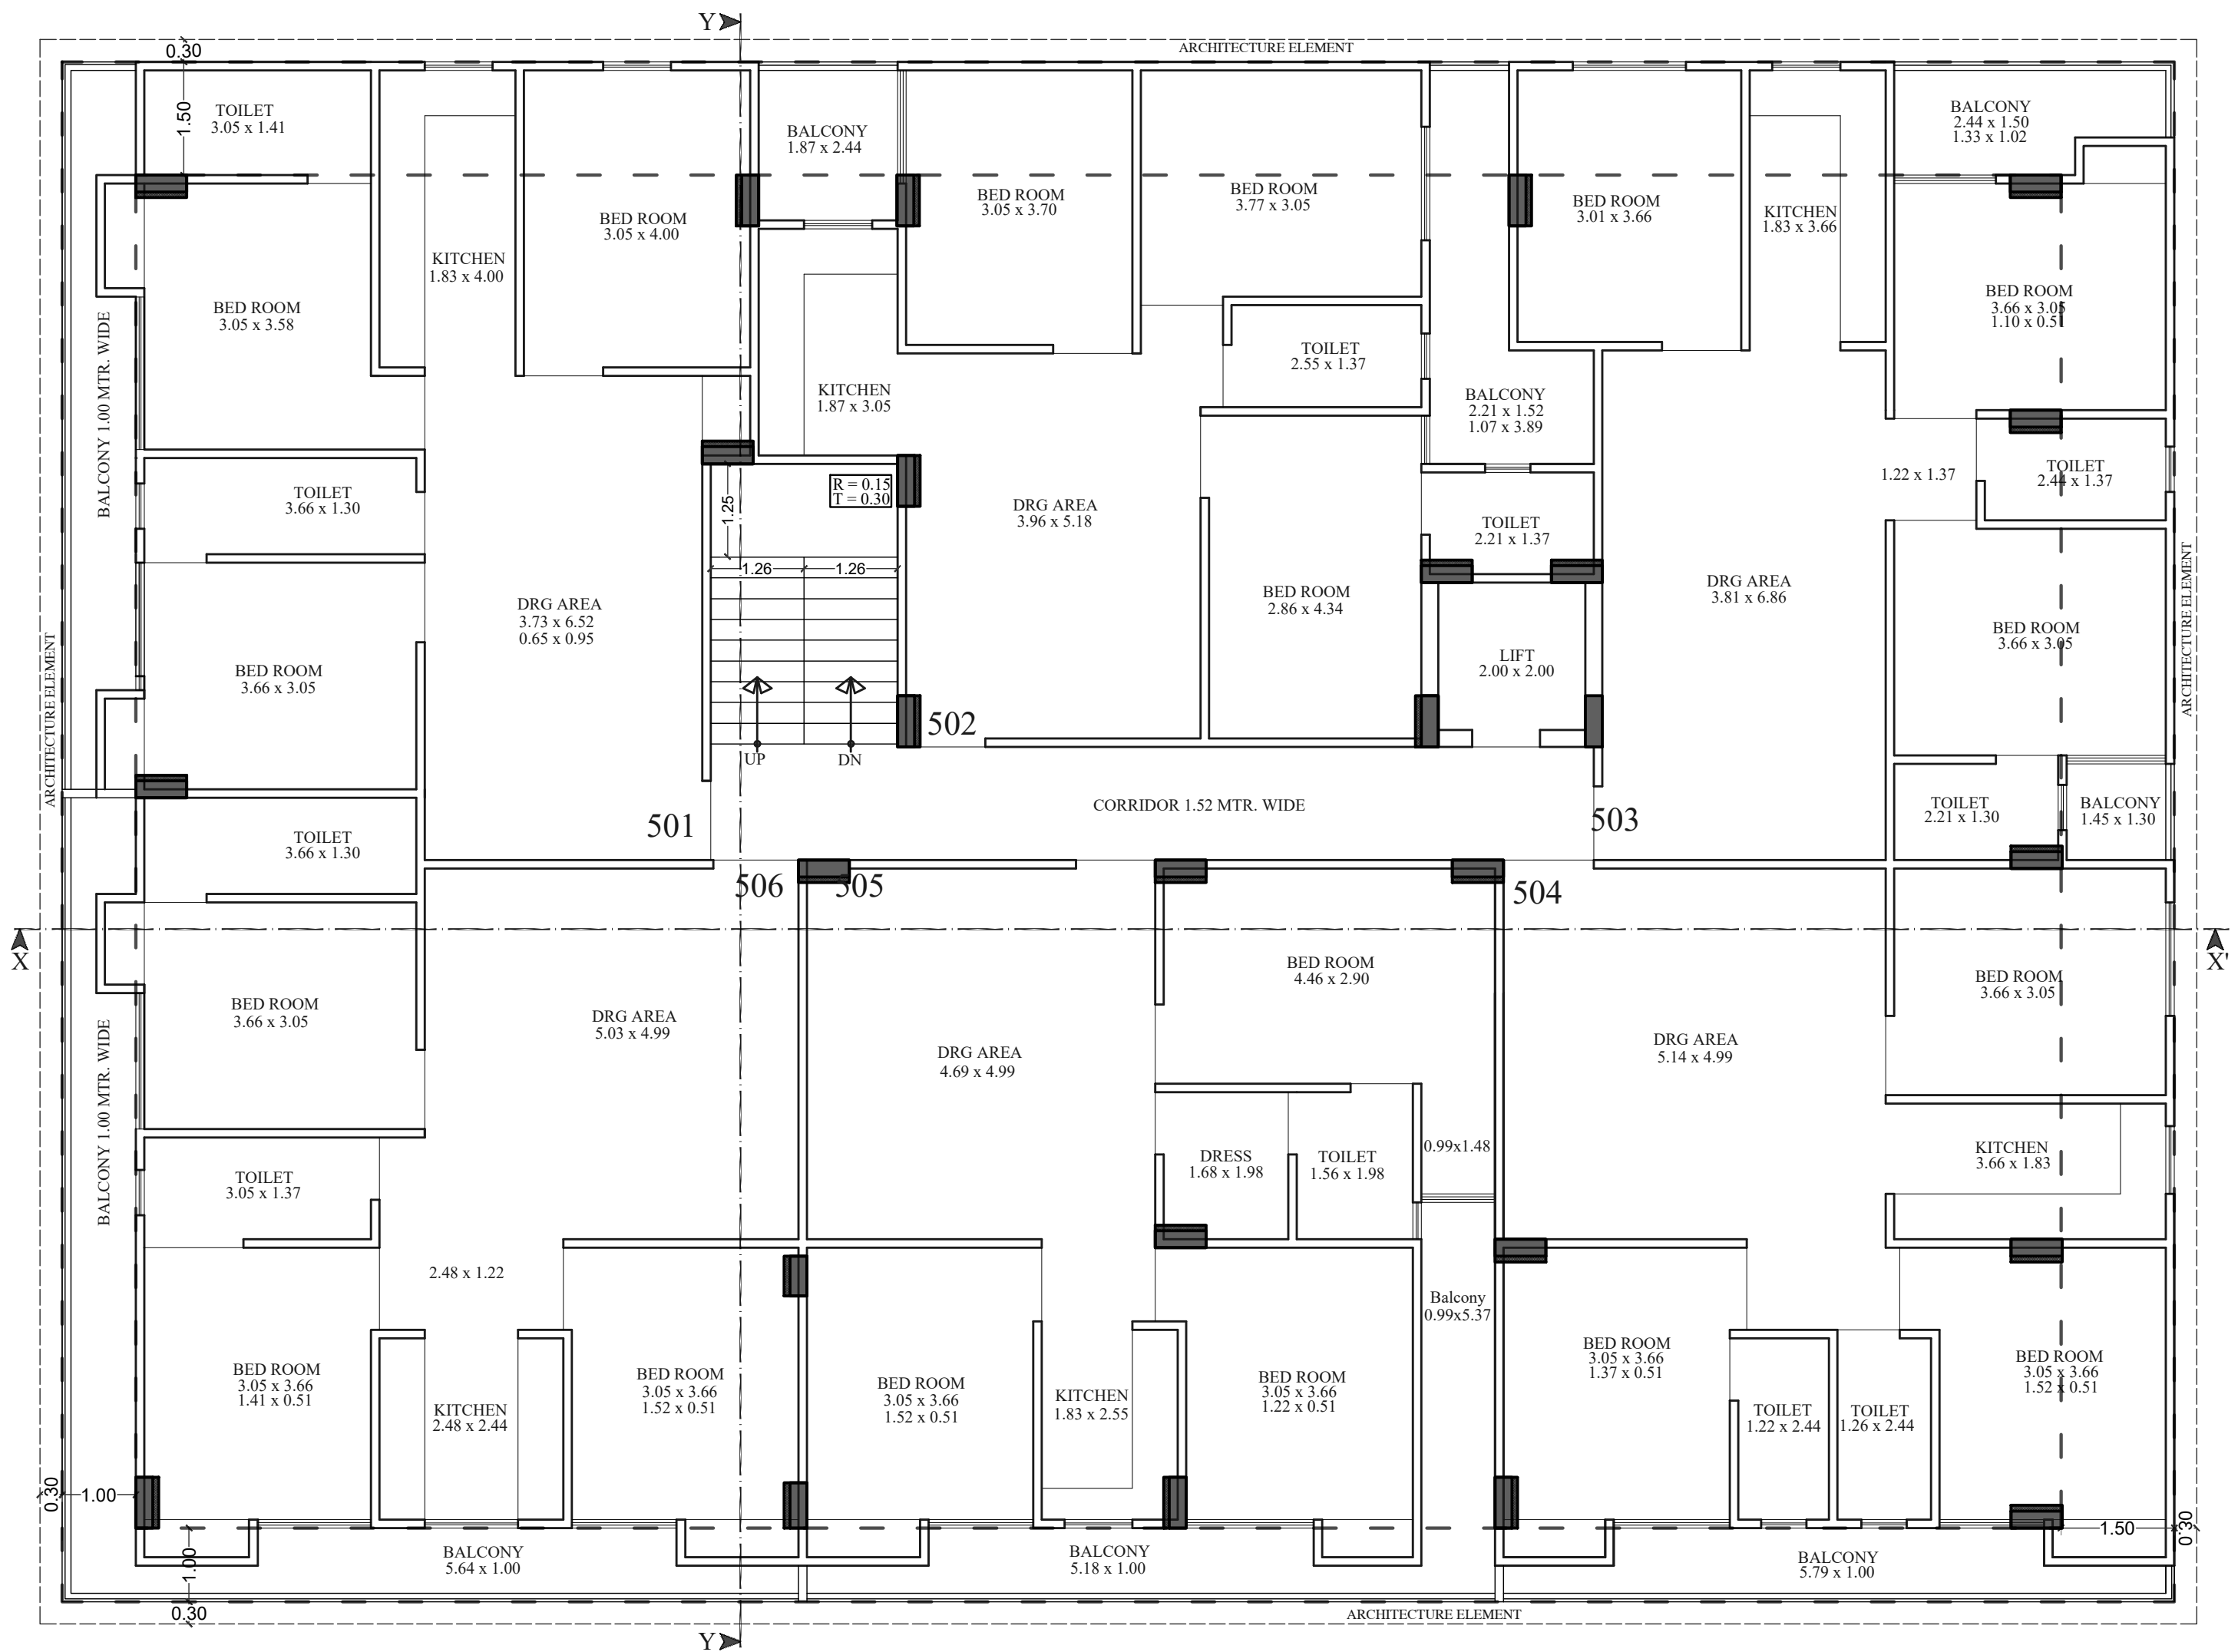

Shree Ram Builders and Developers

Partner



FORTH FLOOR AREA PLAN

AREA IN SQ.MT	FLAT NO.	501 3BHK	502 3BHK	503 3BHK	504 3BHK	505 3BHK	506 3BHK	ADDRESS :- PROPOSED BUILDING AT PLOT NO.-A53 & A54, NARAYANPURI-A, JAIPUR	
BUILTUP AREA		=91.30	= 88.05	= 89.27	= 91.06	= 95.09	=103.36	BUILDING NAME	ANANDAM HEIGHTS III
CARPET AREA		=76.13	= 71.81	= 78.71	= 79.73	= 77.90	=82.89	DEVELOPER NAME	SHREE RAM BUILDERS & DEVELOPERS
BALCONY AREA		= 10.91	= 11.26	= 6.91	= 7.82	= 13.56	= 16.87		