

ARCHITECTS :



V J ARCHITECTS PVT. LTD.
ARCHITECTS ENGINEERS INTERIOR DESIGNERS
10 KHA 2 PYOTI NAGARSAHAKAR MARG JAIPUR
TEL. (0141) 2740007, 2740008-9, TELEFAX (0141) 2740009

STRUCTURAL CONSULTANT:
DESIGN OPTIMALS
862, Gulmohar, Mahaveer Nagar-I, Jaipur
M: +91-9166514798
Email: sgkaushal@yahoo.com


SERVICES CONSULTANT:
VIPUL CONSULTING
F 9 / 354, Chitrakut Scheme, Jaipur
PH: 91-0-93146-10438, 0141-2440946
Mail: vipul8599@yahoo.com

WORKING
DRAWINGS

NORTH



PROJECT:		"SUPARSHWA GARDEN CITY VILLA" TOWNSHIP AT AJMER ROAD, JAIPUR				
NAME OF DRAWING:		GROUND FLOOR DRAINAGE PLAN				
SCALE:- N.T.S.	DATE:- 18-08-2019	DEALT. BY: RAAJ	CHKD. BY: SANJAY	APPD. BY: VIPUL AGARWAL	DRG. NO. VJ 06-SGC-070MS-04	R-0

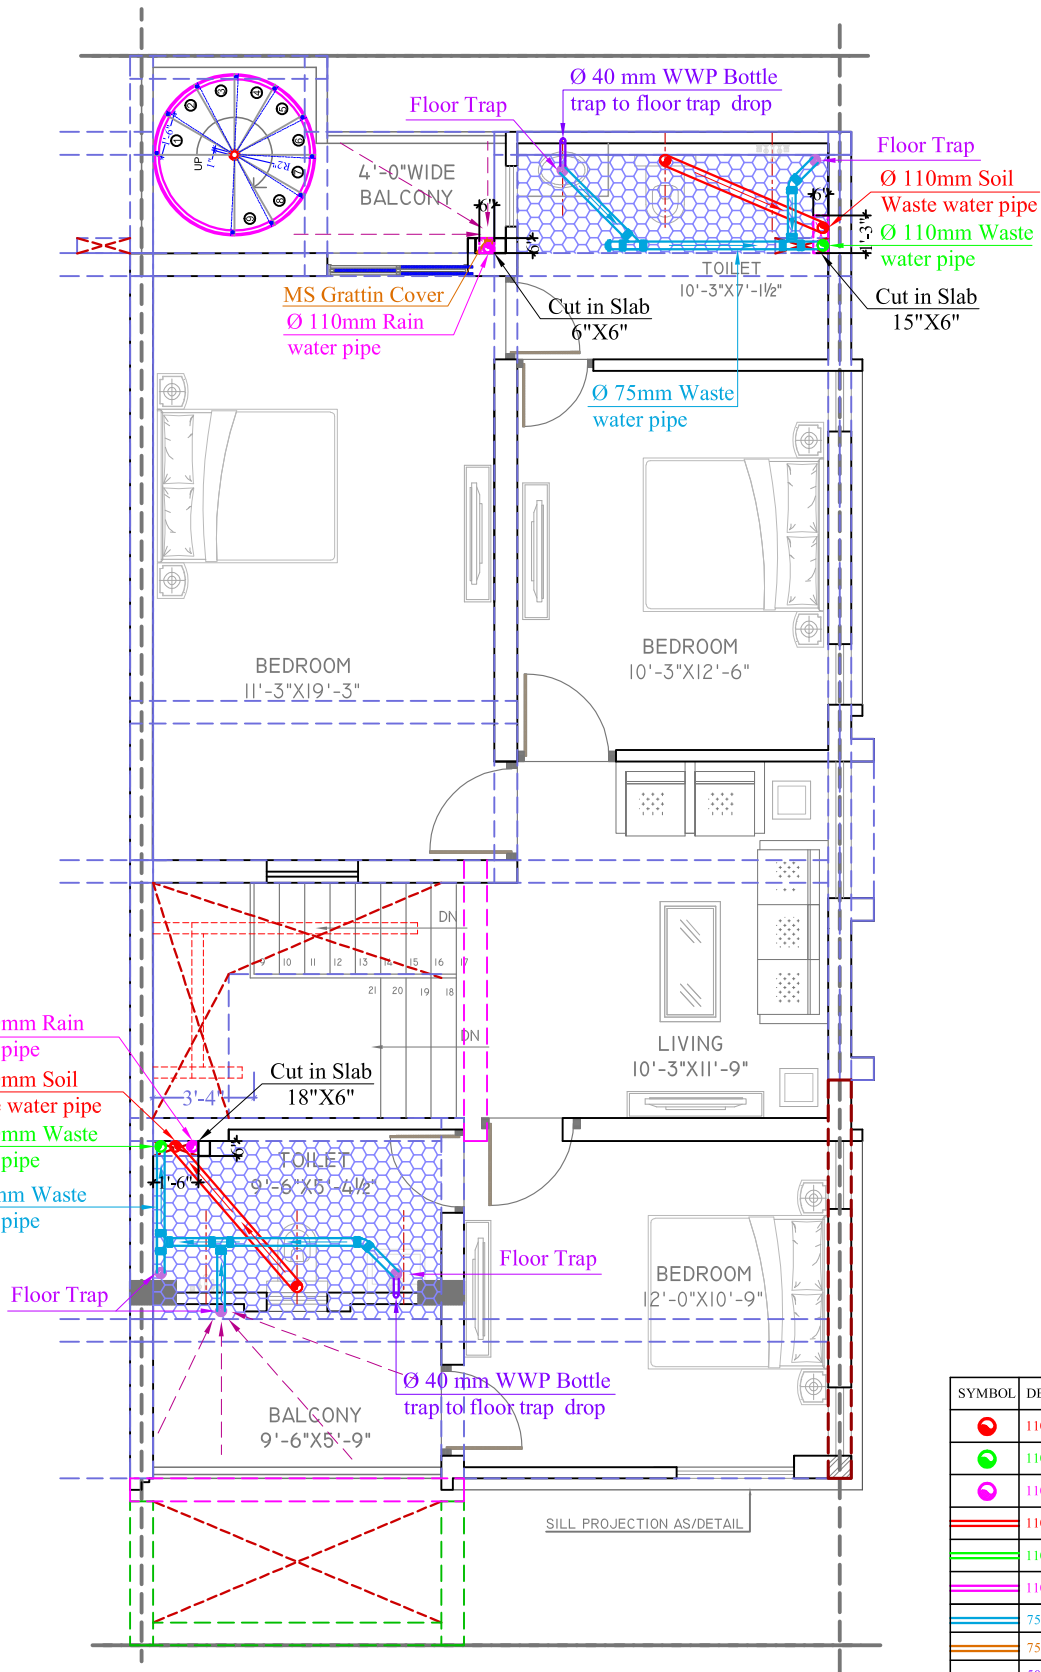

FIRST FLOOR PLAN

SYMBOL	DESCRIPTION
	110 mm Soil Waste Water Pipe
	110 mm Waste Water Pipe
	110 mm Rain Water Pipe
	110 mm Soil Waste Water Pipe
	110 mm Waste Water Pipe
	110 mm Rain Water Pipe
	75 mm Waste Water Pipe Internal Toilet
	75 mm Rain Water Pipe
	50mm Waste Water Pipe Bottle Trap
	Floor Trap
	Vertical MS Grating Cover
	Flow Direction

NO.	DATE	REVISION	BY	CHKD.	APPD.
01	18-08-2018				

THIS DRAWING IS THE PROPERTY OF VJ ARCHITECTS. IT SHALL NOT BE COPIED OR USED WITHOUT THEIR WRITTEN PERMISSION AND KNOWING TO A THIRD PARTY. THE INFORMATION IS ISSUED ON THE UNDERSTANDING THAT NO PART THEREOF SHALL BE REPRODUCED FOR THE PURPOSE OTHER THAN THE EXPRESSED PURPOSE.

DEVELOPER:
SANKALP BUILDERS

ARCHITECTS:
V J ARCHITECTS PVT. LTD.
ARCHITECTS ENGINEERS INTERIOR DESIGNERS
30 KHA 2 PLOT IN AGARSAHAKAR MARG JAIPUR
TEL: 0141 274007, 2740069, TELE FAX: 0141 274009

STRUCTURAL CONSULTANT:
DESIGN OPTIMALS
862, Gulmohar, Mahaveer Nagar-1 Jaipur
M: +91-9166514798
Email: sghkashah@yahoo.com

SERVICES CONSULTANT:
VIPUL CONSULTING
F 9 / 354, Chitrakut Scheme, Jaipur
PH: 0141-24146-10438, 0141-2440946
Mail: vipulb3999@yahoo.com


WORKING DRAWINGS
NORTH

PROJECT: **"SUPARSHWA GARDEN CITY VILLA"**
TOWNSHIP AT AJMER ROAD, JAIPUR

NAME OF DRAWING: **FIRST FLOOR DRAINAGE PLAN**

SCALE: N.T.S. DATE: 18-08-2018 DEALT BY: RAJ APPD. BY: SANJAY VIKUL AGARWAL DRG. NO. **VJ 06-SGC-ADWG-04**

R-0

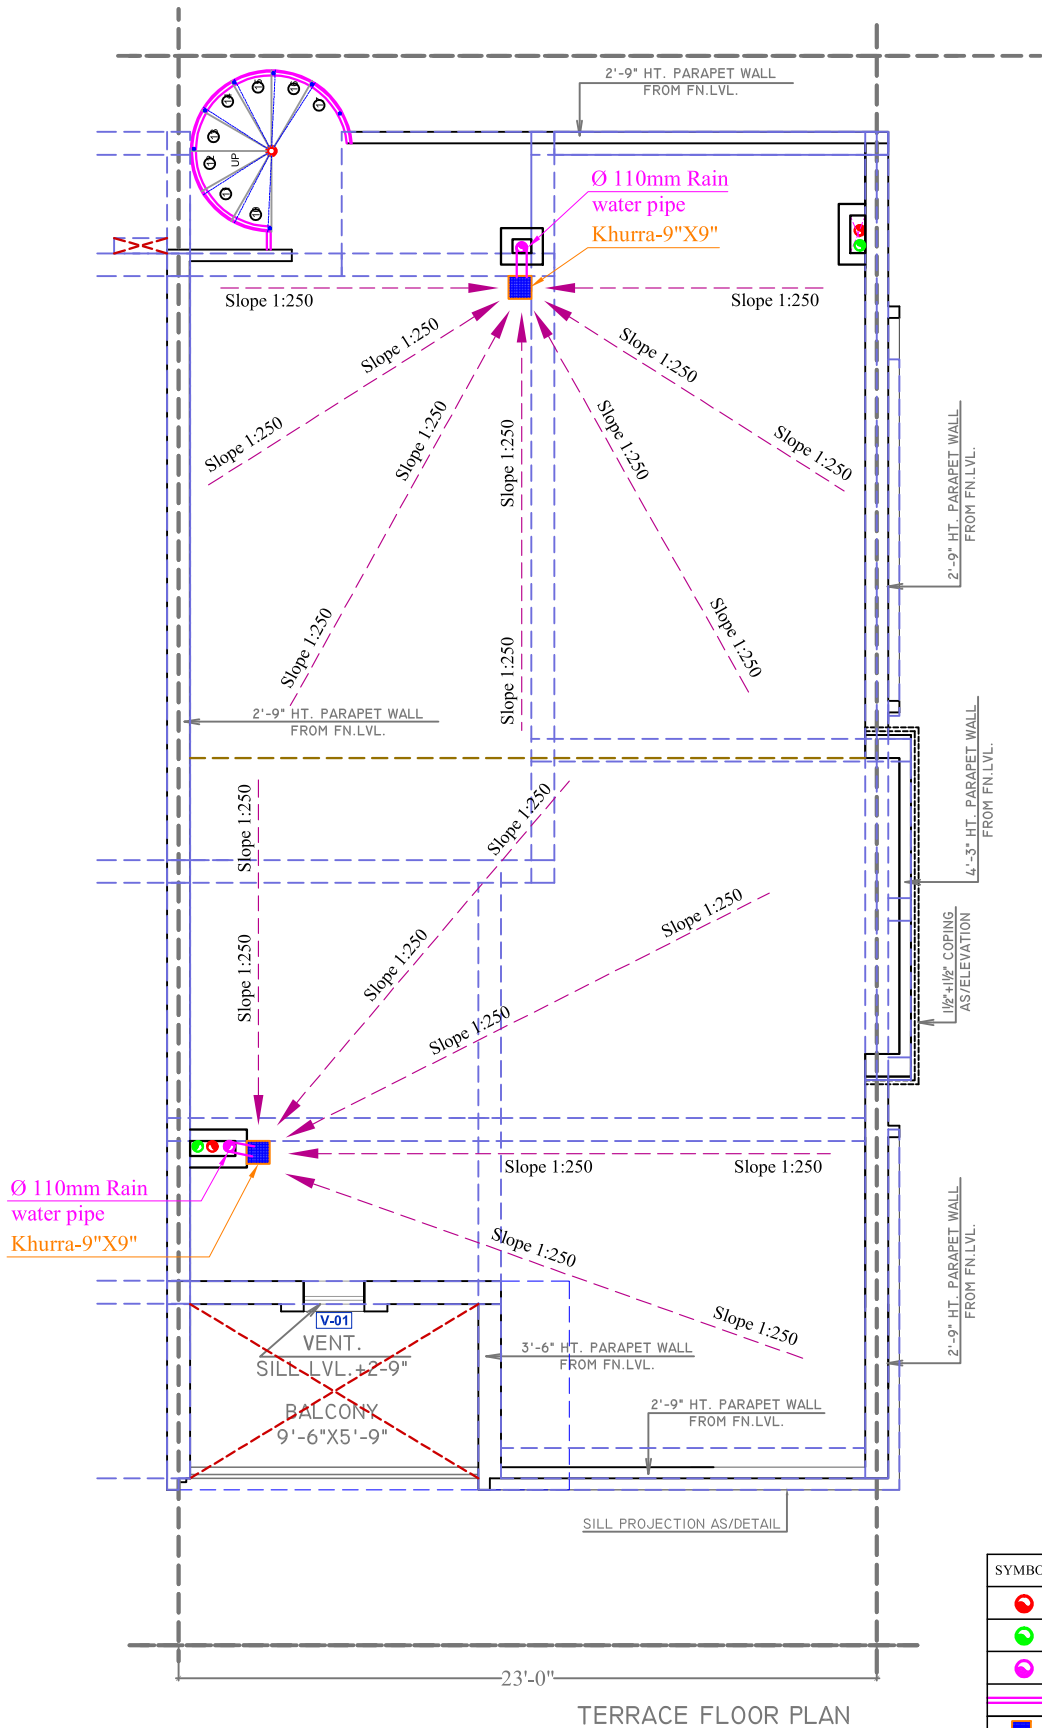

TERRACE FLOOR PLAN

SYMBOL	DESCRIPTION
	110 mm Soil Waste Water Pipe
	110 mm Waste Water Pipe
	110 mm Rain Water Pipe
	110 mm Rain Water Pipe
	Khurra-9"X9"
	Flow Direction

NO.	DATE	REVISION
1	18-08-2018	ISSUED FOR PERMIT
2	18-08-2018	FOR APPROVAL
3	18-08-2018	FOR APPROVAL
4	18-08-2018	FOR APPROVAL
5	18-08-2018	FOR APPROVAL
6	18-08-2018	FOR APPROVAL
7	18-08-2018	FOR APPROVAL
8	18-08-2018	FOR APPROVAL
9	18-08-2018	FOR APPROVAL
10	18-08-2018	FOR APPROVAL

THIS DRAWING IS THE PROPERTY OF V J ARCHITECTS. IT SHALL NOT BE COPIED OR USED WITHOUT THEIR WRITTEN PERMISSION AND KNOWING TO A THIRD PARTY. THE INFORMATION IS ISSUED ON THE UNDERSTANDING THAT NO PART THEREOF SHALL BE SUPERSEDED FOR THE PURPOSE OTHER THAN THE EXPRESSED PURPOSE.


DEVELOPER:	SANKALP BUILDERS
------------	------------------

ARCHITECTS:	V J ARCHITECTS PVT. LTD. ARCHITECTS ENGINEERS INTERIOR DESIGNERS 30 KHA 2 PLOT IN AGARSAHAKAR MARG JAIPUR TEL: 0141 274007, 274006/9, TEL/FAX: 0141 274009
-------------	---

STRUCTURAL CONSULTANT:	DESIGN OPTIMALS 862, Gulmohar, Mahaveer Nagar-1 Jaipur M: +91-9166514798 Email: sghkushal@yahoo.com
SERVICES CONSULTANT:	VIPUL CONSULTING F/9/354, Chitrakut Scheme, Jaipur PH: 0141-2409446-10438, 0141-2409446 Mail: vipulb3999@yahoo.com

WORKING DRAWINGS	NORTH
------------------	-------

PROJECT:	"SUPARSHWA GARDEN CITY VILLA" TOWNSHIP AT AJMER ROAD, JAIPUR
NAME OF DRAWING:	TERRACE FLOOR DRAINAGE PLAN
SCALE:	N.T.S.
DATE:	18-08-2018
DEALT BY:	RAAJ
CHKD BY:	SANJAY
APPD BY:	VIPUL AGARWAL
DRG. NO.	VJ 06-SGC-A-DWG-04
R-0	

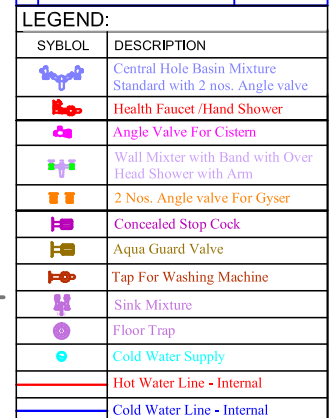

PROJECT:		<u>"SUPARSHA GARDEN CITY VILLA"</u> <u>TOWNSHIP AT AJMER ROAD, JAIPUR</u>				
NAME OF DRAWING:		<u>GROUND FLOOR PLUMBING PLAN</u>				
SCALE:	DATE:	DEALT. BY:	CHKD. BY:	APPD. BY:	DRG. NO.	R-0
1:12.5	18-06-2019	PAAL	SANJAY	APURU AGARWAL	18-06-2019	



PROJECT:		"SUPARSHWA GARDEN CITY VILLA" TOWNSHIP AT AJMER ROAD, JAIPUR				
NAME OF DRAWING:		<u>FIRST FLOOR PLUMBING PLAN</u>				
SCALE:	DATE:	DEALT BY:	CHKD BY:	APPD. BY:	DRG. NO.	R-0
1:12.5	18/01/2018	PAAL	SANJAY	APURU AGARWAL	00000000000000000000	