


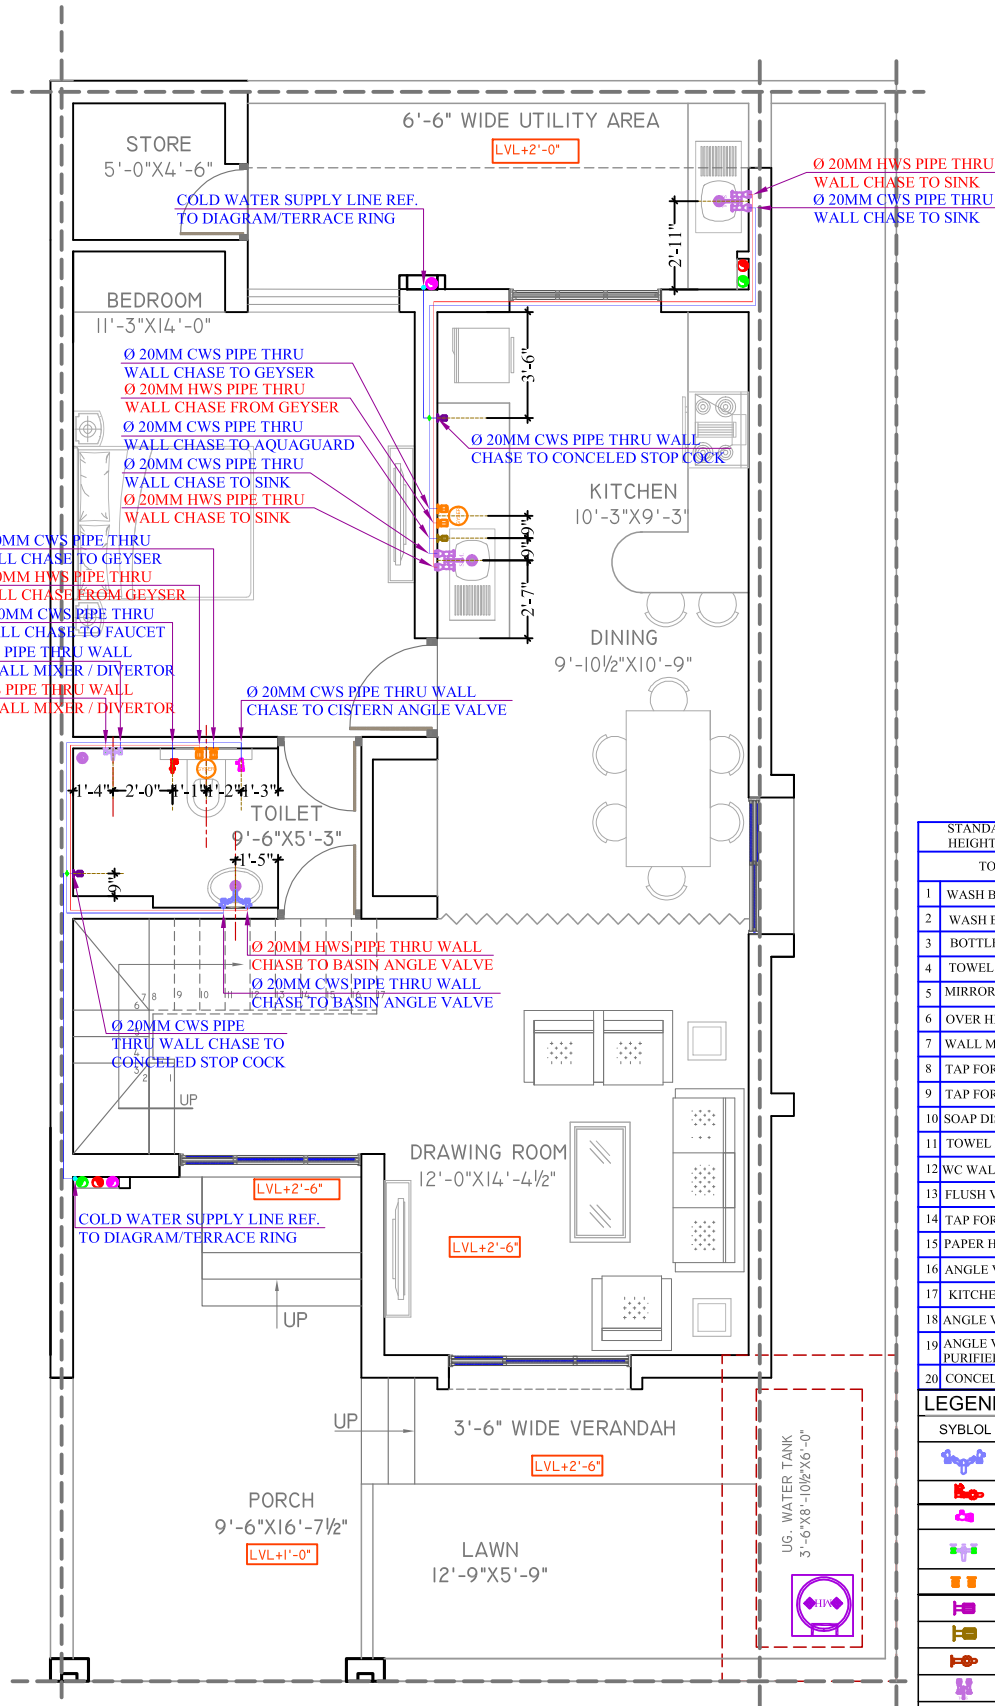


STANDARDS SANITARY APPLIANCES HEIGHTS/AS PER AR.DETAILS		
TOILET/KITCHEN		All Heights For Finish Floor Lvl
1	WASH BASIN MIXER	+800MM
2	WASH BASIN ANGLE VALVE	+450MM
3	BOTTLE TRAP	+450MM
4	TOWEL RING	+950MM
5	MIRROR 450X450mm(BOTTOM)	+950MM
6	OVER HEAD SHOWER	+2025MM
7	WALL MIXER DIVERTOR	+1000MM
8	TAP FOR BATH AREA	+770MM
9	TAP FOR BALCONY/ WASHING	+450MM
10	SOAP DISH	+1000MM
11	TOWEL RAIL	+1500MM
12	WC WALL MOUNTED (TOP)	+400MM
13	FLUSH VALVE	+900MM
14	TAP FOR WC	+300MM
15	PAPER HOLDER	+450MM
16	ANGLE VALVE FOR GYSER	+1950MM
17	KITCHEN SINK MIXER	+1000MM
18	ANGLE VALVE FOR GYSER	+1950MM
19	ANGLE VALVE FOR WATER PURIFIER	+1500MM
20	CONCELED STOP COCK	+2100MM

LEGEND:	
SYBOL	DESCRIPTION
	Central Hole Basin Mixture Standard with 2 nos. Angle valve
	Health Faucet/Hand Shower
	Angle Valve For Cistern
	Wall Mixer with Band with Over Head Shower with Arm
	2 Nos. Angle valve For Gysar
	Concealed Stop Cock
	Aqua Guard Valve
	Tap For Washing Machine
	Sink Mixture
	Floor Trap
	Cold Water Supply
	Hot Water Line - Internal
	Cold Water Line - Internal

GROUND FLOOR PLAN

DEVELOPER:									
---	--	--	--	--	--	--	--	--	--

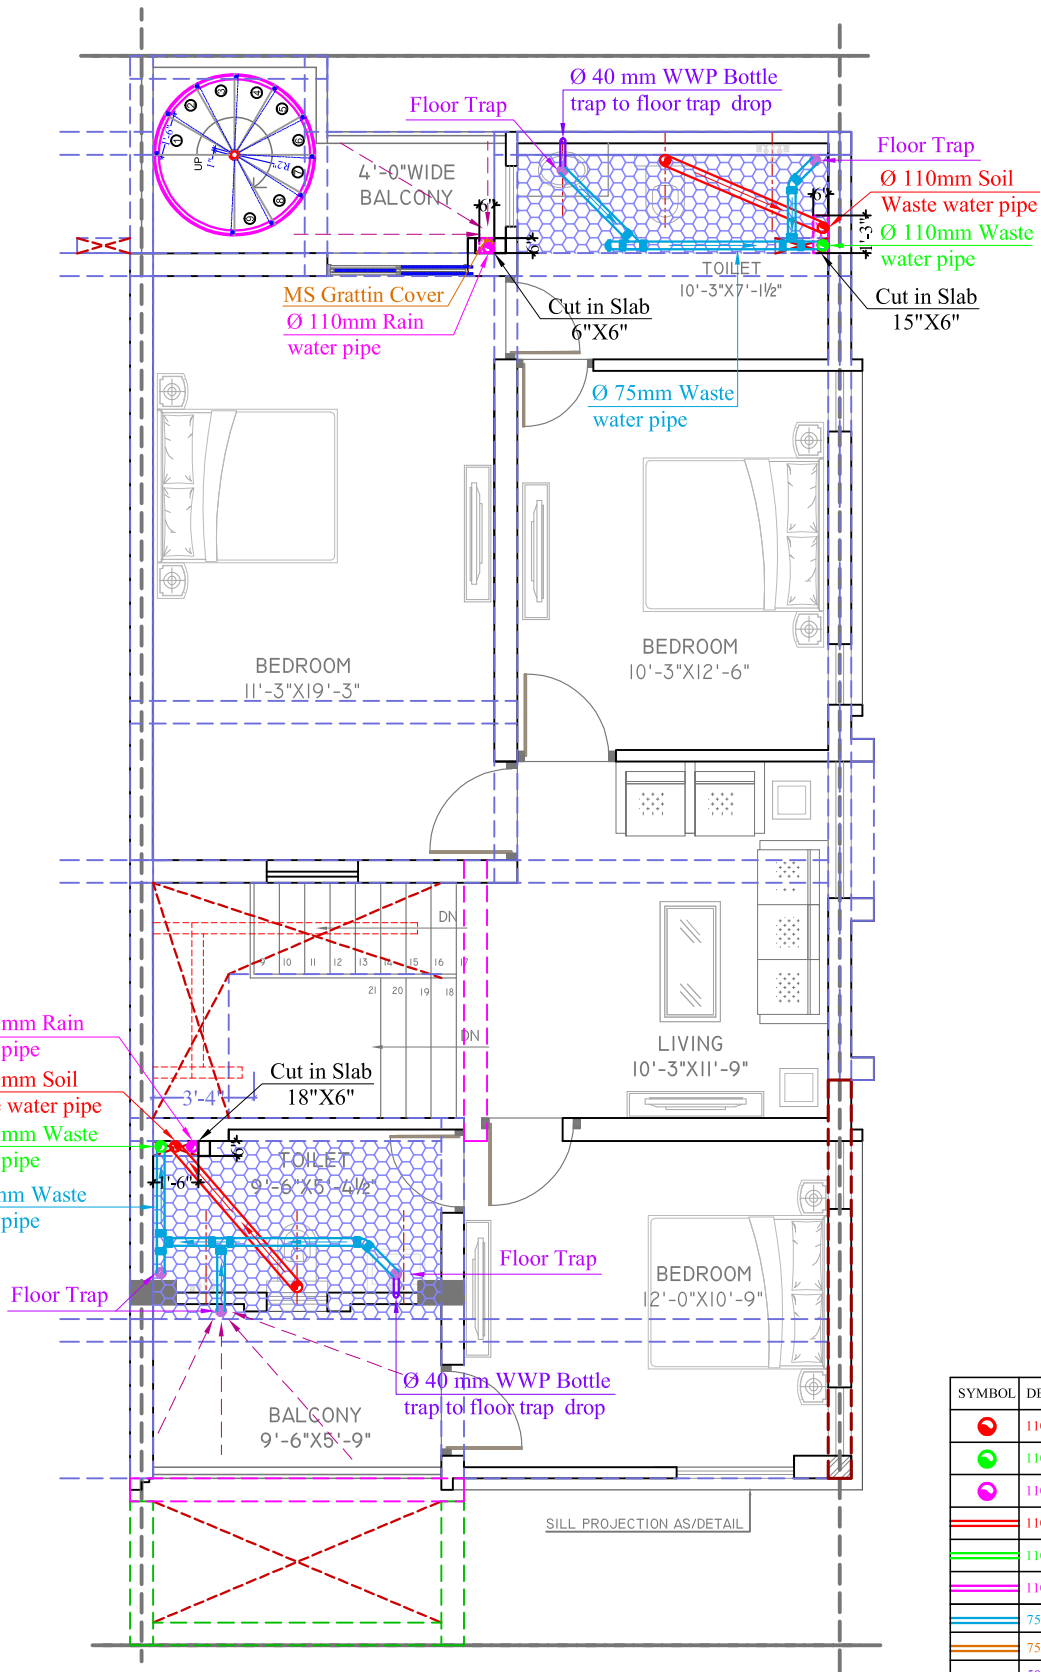

FIRST FLOOR PLAN

SYMBOL	DESCRIPTION
	110 mm Soil Waste Water Pipe
	110 mm Waste Water Pipe
	110 mm Rain Water Pipe
	110 mm Soil Waste Water Pipe
	110 mm Waste Water Pipe
	110 mm Rain Water Pipe
	75 mm Waste Water Pipe Internal Toilet
	75 mm Rain Water Pipe
	50mm Waste Water Pipe Bottle Trap
	Floor Trap
	Vertical MS Grating Cover
	Flow Direction

NO.	REVISION	DATE	BY	CHKD.	APPD.
1					
2					
3					
4					
5					
6					
7					
8					
9					
10					

DEVELOPER:	SANKALP BUILDERS
------------	------------------


ARCHITECTS:	V J ARCHITECTS PVT. LTD.
-------------	--------------------------

STRUCTURAL CONSULTANT:	DESIGN OPTIMALS
SERVICES CONSULTANT:	VIPUL CONSULTING

WORKING DRAWINGS	NORTH
------------------	-------

PROJECT:	"SUPARSHWA GARDEN CITY VILLA"
NAME OF DRAWING:	FIRST FLOOR DRAINAGE PLAN
SCALE:	1:100
DATE:	18-08-2018
DEALT BY:	RAAJ
CHKD BY:	SANJAY
APPD BY:	VIPUL AGARWAL
DRG NO.	VJ 06-SGC-A07W0-04

R-0

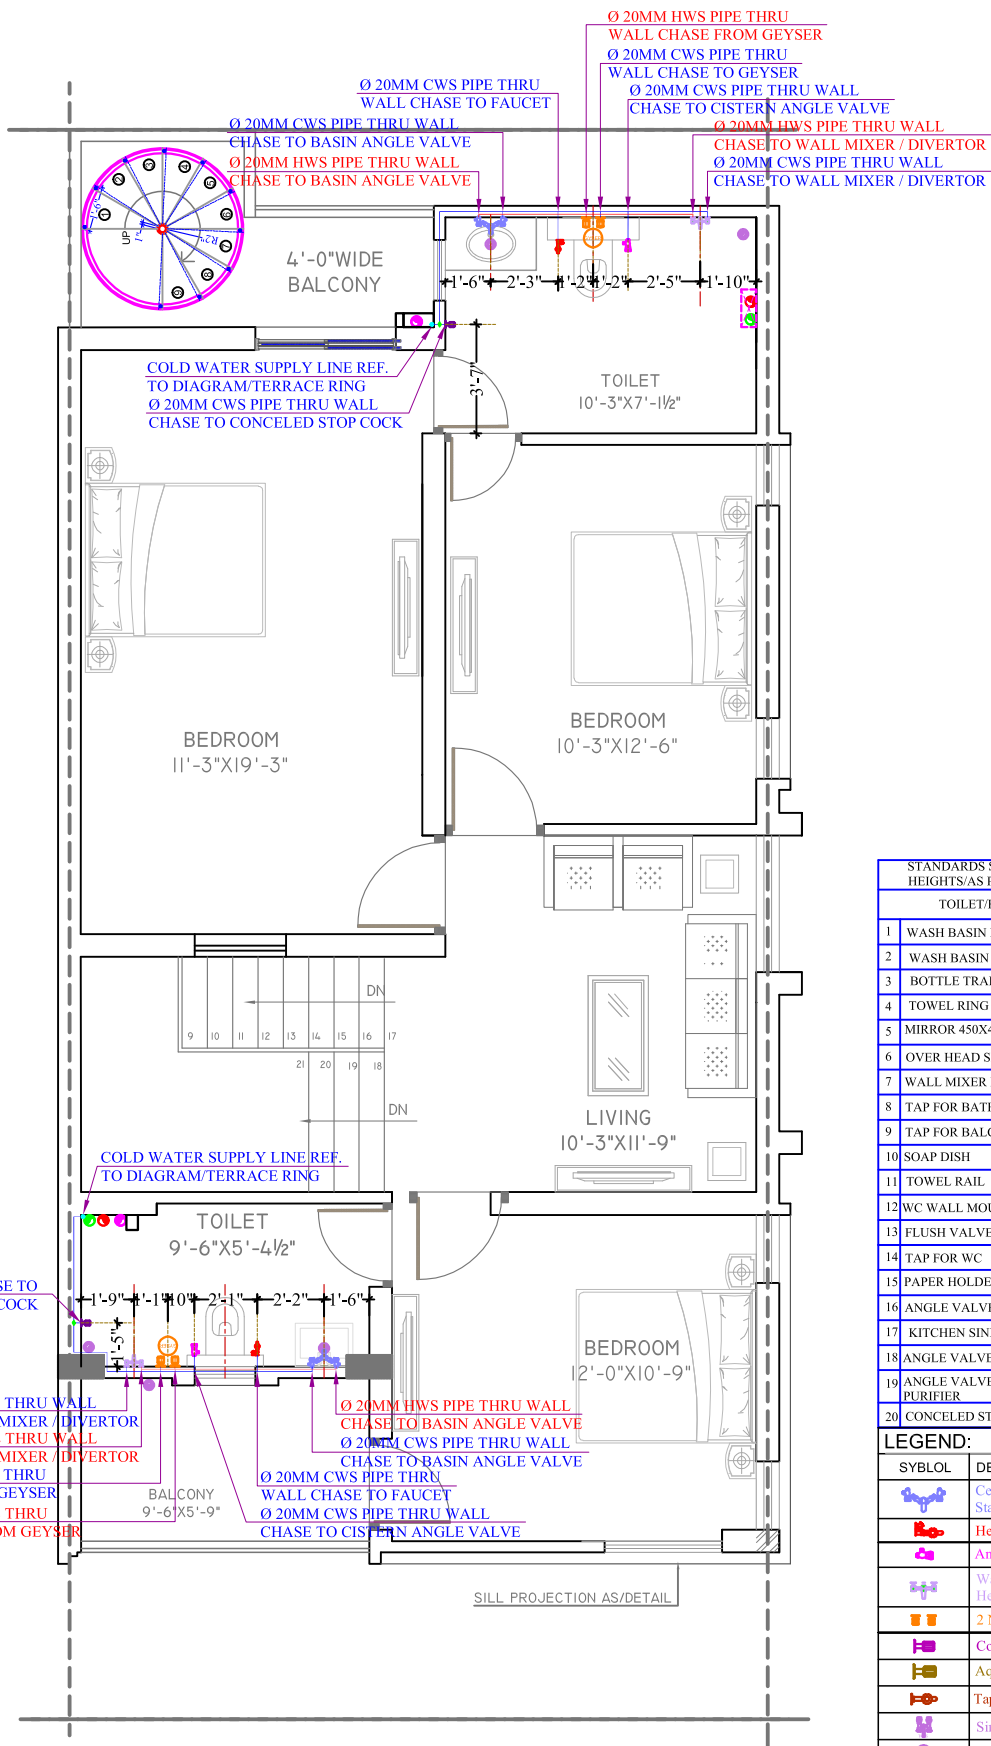

STANDARDS SANITARY APPLIANCES HEIGHTS/AS PER AR.DETAILS	
TOILET/KITCHEN	All Heights For Finish Floor Lvl
1 WASH BASIN MIXER	+800MM
2 WASH BASIN ANGLE VALVE	+450MM
3 BOTTLE TRAP	+450MM
4 TOWEL RING	+950MM
5 MIRROR 450X450mm(BOTTOM)	+950MM
6 OVER HEAD SHOWER	+2025MM
7 WALL MIXER DIVERTOR	+1000MM
8 TAP FOR BATH AREA	+770MM
9 TAP FOR BALCONY/ WASHING	+450MM
10 SOAP DISH	+1000MM
11 TOWEL RAIL	+1500MM
12 WC WALL MOUNTED (TOP)	+400MM
13 FLUSH VALVE	+900MM
14 TAP FOR WC	+300MM
15 PAPER HOLDER	+450MM
16 ANGLE VALVE FOR GYSEY	+1950MM
17 KITCHEN SINK MIXER	+1000MM
18 ANGLE VALVE FOR GYSEY	+1950MM
19 ANGLE VALVE FOR WATER PURIFIER	+1500MM
20 CONCEALED STOP COCK	+2100MM

LEGEND:

SYBLOL	DESCRIPTION
	Central Hole Basin Mixture Standard with 2 nos. Angle valve
	Health Faucet / Hand Shower
	Angle Valve For Cistern
	Wall Mixer with Band with Over Head Shower with Arm
	2 Nos. Angle valve For Gyser
	Concealed Stop Cock
	Aqua Guard Valve
	Tap For Washing Machine
	Sink Mixture
	Floor Trap
	Cold Water Supply
	Hot Water Line - Internal
	Cold Water Line - Internal

FIRST FLOOR PLAN

NO.	REVISION	DATE	BY	CHKD.	APPD.
1					
2					
3					
4					
5					
6					
7					
8					
9					
10					
11					
12					
13					
14					
15					
16					
17					
18					
19					
20					
21					
22					
23					
24					
25					
26					
27					
28					
29					
30					

DEVELOPER:
SANKALP BUILDERS

ARCHITECTS:
V J ARCHITECTS PVT. LTD.
ARCHITECTS CONSULTING
30 KHA 2 PLOT IN AGARSAHAKAR MARG JAIPUR
TEL: (0141) 274007, 274006/9, TELEFAX: (0141) 274009

STRUCTURAL CONSULTANT:
DESIGN OPTIMALS
862, Gulmohar, Mahaveer Nagar-II, Jaipur
ME: +91-9166514798
Email: sghkshah@yahoo.com


SERVICES CONSULTANT:
VIPUL CONSULTING
F/9/354, Chitrakot Scheme, Jaipur
PH: 91-0-93146-10438, 0141-2440946
Mail: vipulb3999@yahoo.com

WORKING DRAWINGS
NORTH

PROJECT: **"SUPARSHWA GARDEN CITY VILLA"**
TOWNSHIP AT AJMER ROAD, JAIPUR

NAME OF DRAWING: **FIRST FLOOR PLUMBING PLAN**

SCALE: N.T.S. DATE: 18-08-2018 DEALT BY: RAJ CHKD BY: SANJAY APPD BY: VIPUL AGARWAL DRG. NO. **VJ 06-SGC-ADWG-04** R-0

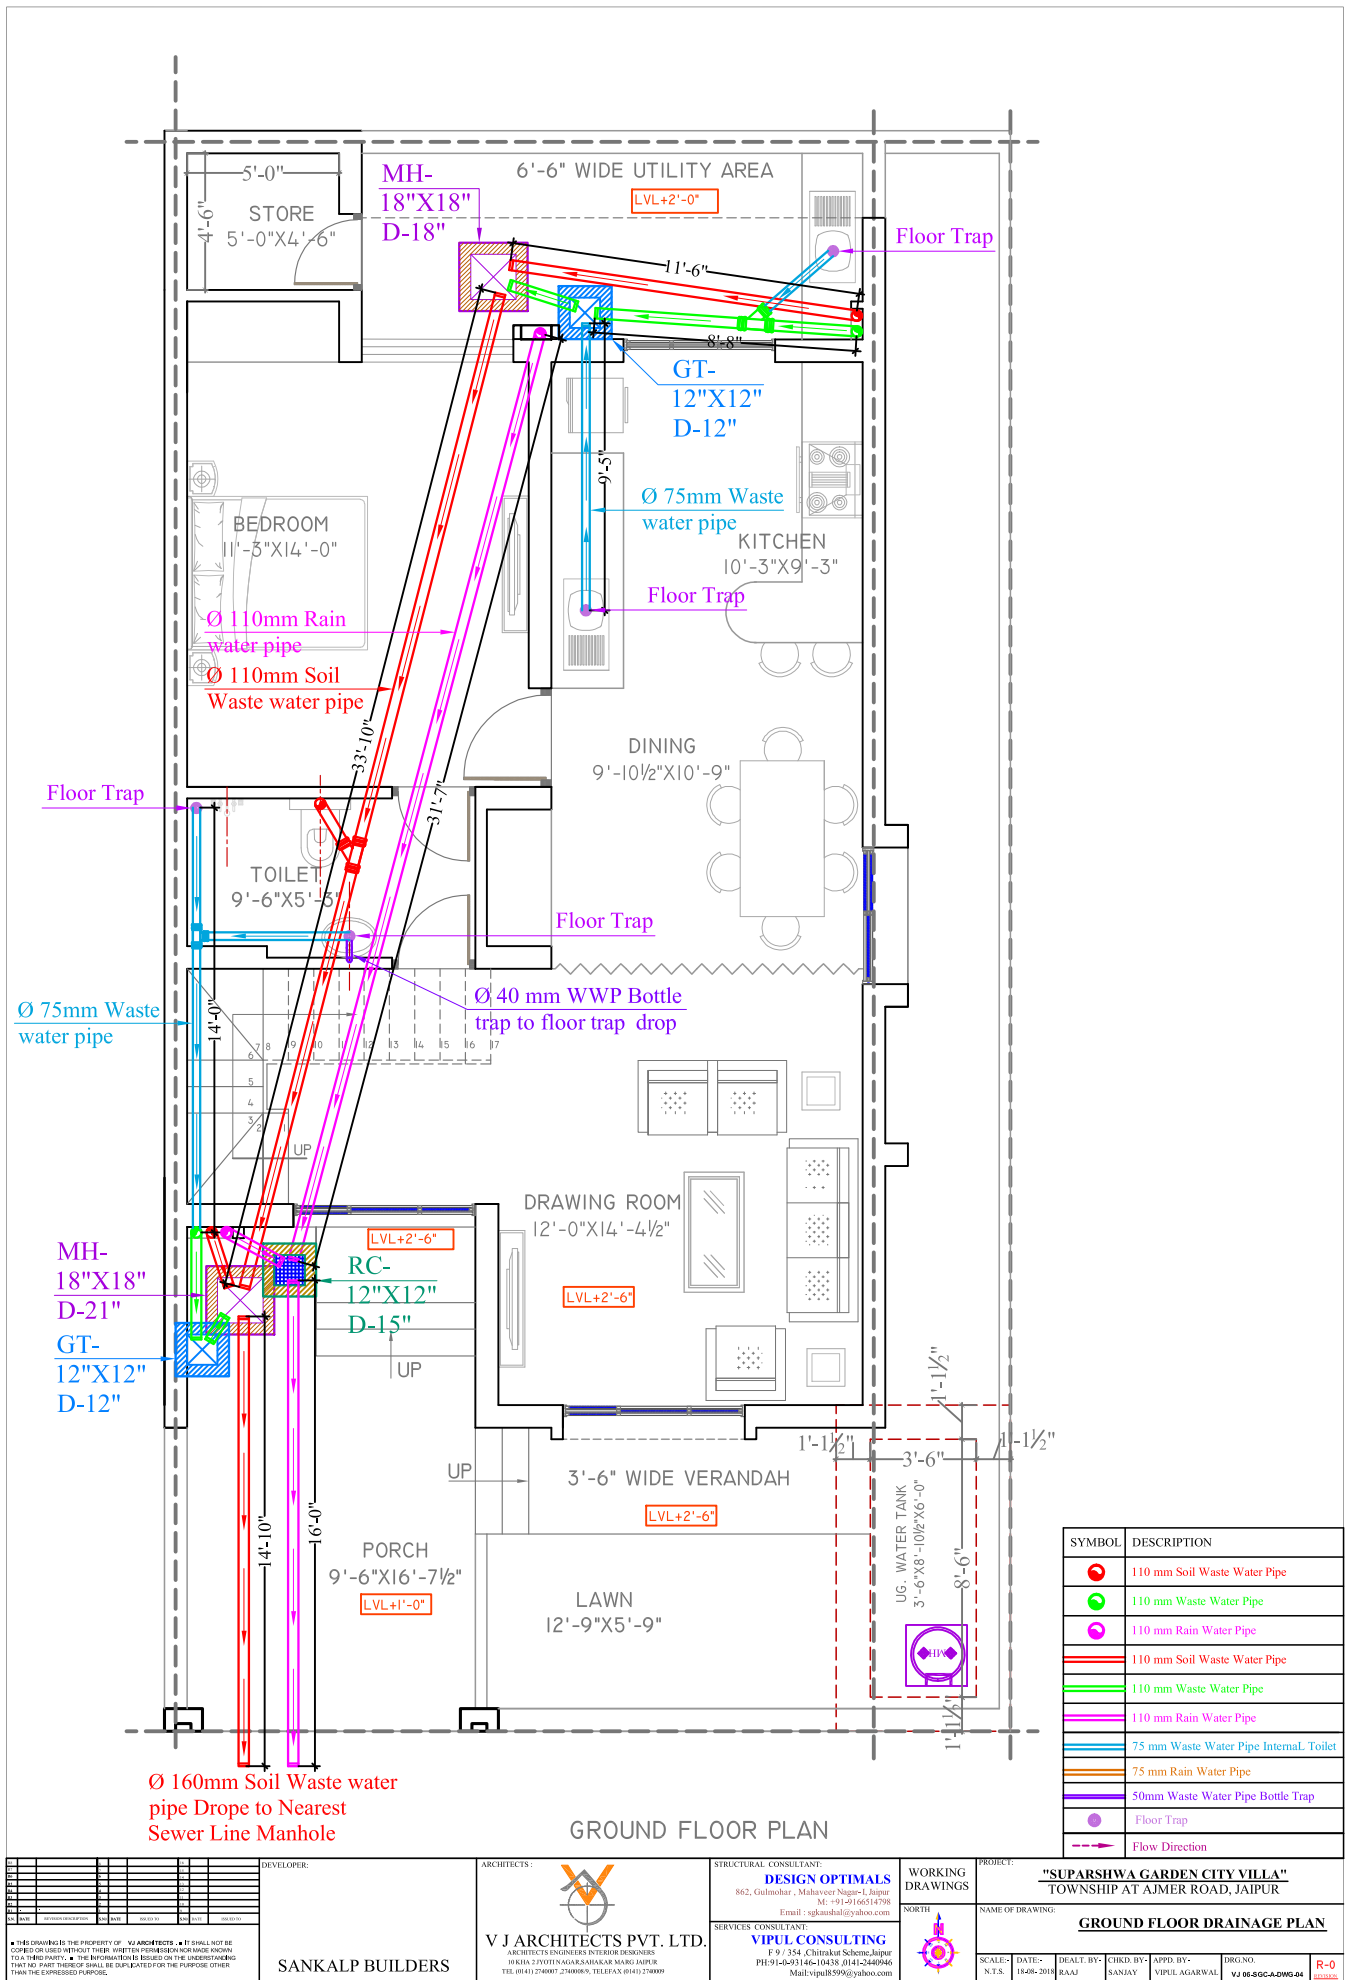

SYMBOL	DESCRIPTION
	110 mm Soil Waste Water Pipe
	110 mm Waste Water Pipe
	110 mm Rain Water Pipe
	110 mm Soil Waste Water Pipe
	110 mm Waste Water Pipe
	110 mm Rain Water Pipe
	75 mm Waste Water Pipe Internal Toilet
	75 mm Rain Water Pipe
	50mm Waste Water Pipe Bottle Trap
	Floor Trap
	Flow Direction

REVISIONS

NO.	DESCRIPTION	DATE
1	ISSUED FOR PERMIT	20/05/2018
2	ISSUED FOR CONSTRUCTION	20/05/2018

DEVELOPER:

SANKALP BUILDERS

ARCHITECTS

V J ARCHITECTS PVT. LTD.
ARCHITECTS ENGINEERS INTERIOR DESIGNERS
30 KHA 2 PLOT IN AGARSAHAKAR MARG JAIPUR
TEL: 0141 274007, 2740069, TELE FAX: 0141 274009

STRUCTURAL CONSULTANT:

DESIGN OPTIMALS
862, Gulmohar, Mahaveer Nagar-2 Jaipur
M: +91-9166514798
Email: sghkshah@yahoo.com

SERVICES CONSULTANT:

VIPUL CONSULTING
F 9/ 354, Chitrakut Scheme, Jaipur
PH: 0141-240146-10438, 0141-2409046
Mail: vipulb3999@yahoo.com

WORKING DRAWINGS

PROJECT:

"SUPARSHWA GARDEN CITY VILLA"
TOWNSHIP AT AJMER ROAD, JAIPUR

NAME OF DRAWING:

GROUND FLOOR DRAINAGE PLAN

SCALE:

N.T.S.

DATE:

18-08-2018

DEALT BY:

RAAJ

CHKD BY:

SANJAY


APPD BY:

VIPUL AGARWAL

DRG. NO.

VJ 06-SGC-A-DWG-04

R-0

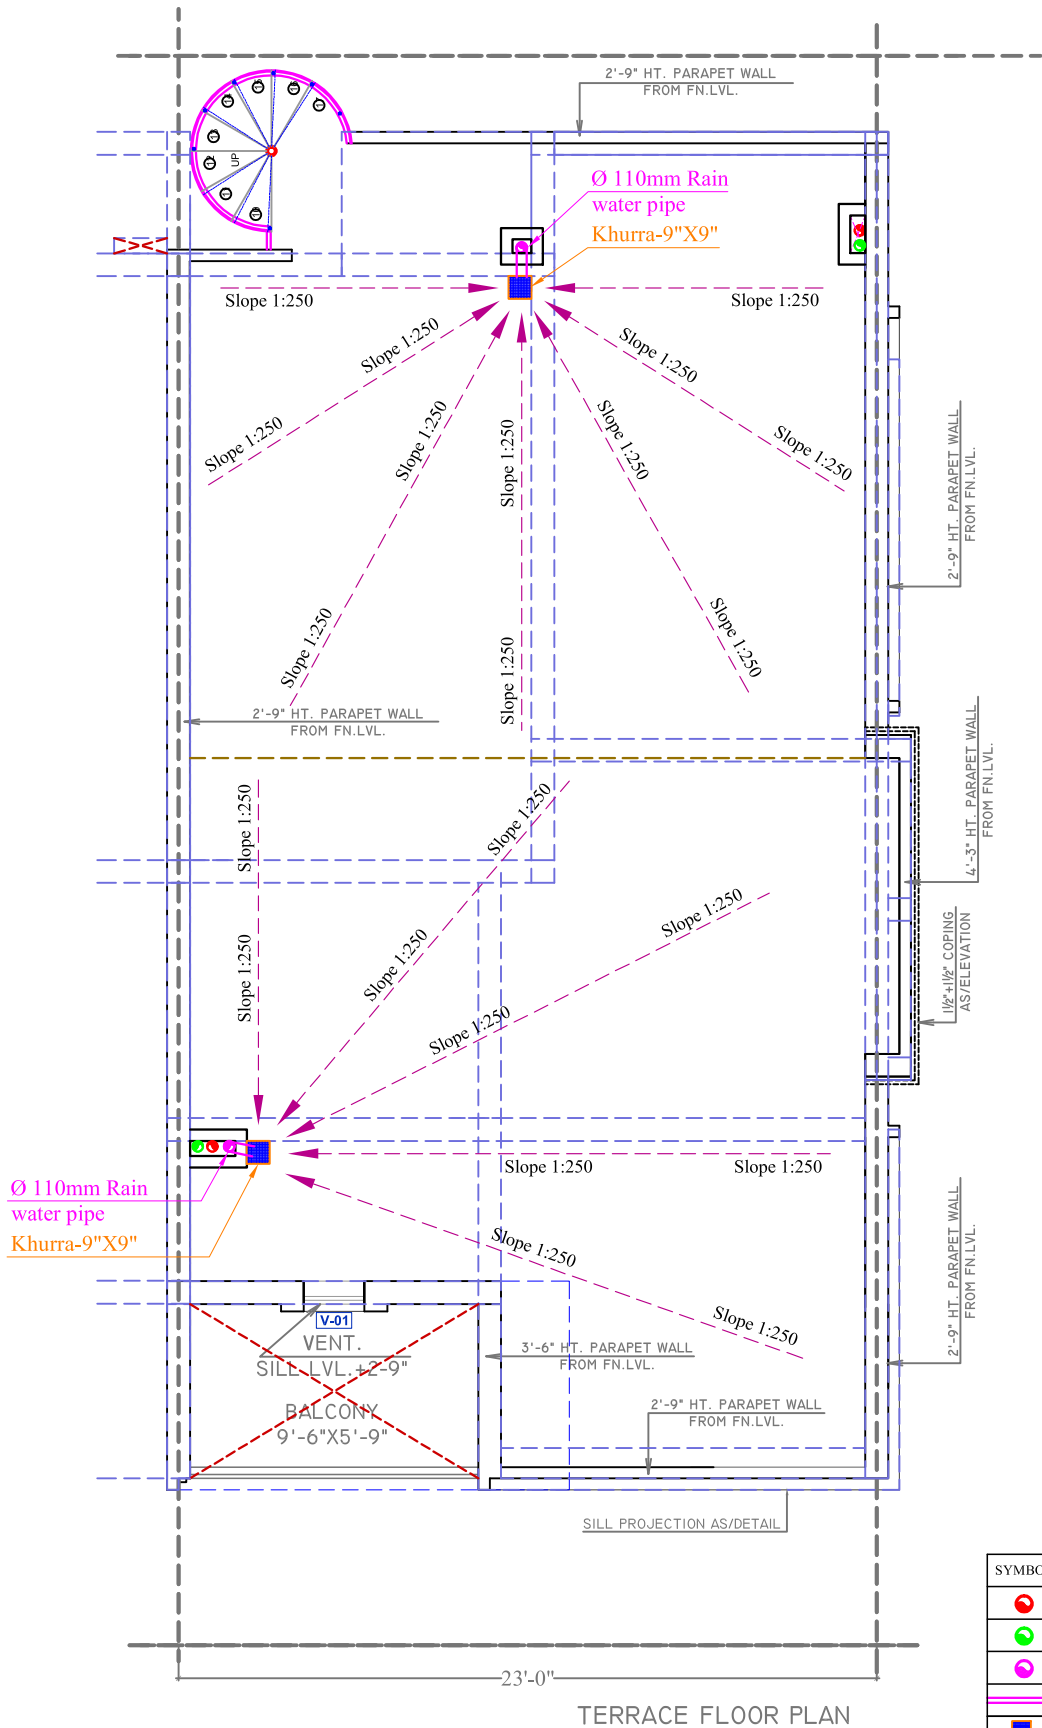

TERRACE FLOOR PLAN

SYMBOL	DESCRIPTION
	110 mm Soil Waste Water Pipe
	110 mm Waste Water Pipe
	110 mm Rain Water Pipe
	110 mm Rain Water Pipe
	Khurra-9\"X9"
	Flow Direction

NO.	DATE	REVISION	BY	CHKD.	APPD.
1	18-08-2018				
2	18-08-2018				
3	18-08-2018				
4	18-08-2018				
5	18-08-2018				
6	18-08-2018				
7	18-08-2018				
8	18-08-2018				
9	18-08-2018				
10	18-08-2018				

DEVELOPER:	SANKALP BUILDERS
------------	------------------

ARCHITECTS:	V J ARCHITECTS PVT. LTD.
ARCHITECTS ENGINEERS INTERIOR DESIGNERS	30 KHA 2 PLOT IN AGARSAHAKAR MARG JAIPUR
TEL: 0141 274007, 274006/9, TEL/FAX: 0141 274009	

STRUCTURAL CONSULTANT:	DESIGN OPTIMALS
862, Gulmohar, Mahaveer Nagar-1, Jaipur	
ME: +91-9166514798	
Email: sghkshah@yahoo.com	
SERVICES CONSULTANT:	VIPUL CONSULTING
F/9/354, Chitrakut Scheme, Jaipur	
PH: 91-0-93146-10438, 0141-2440946	
Mail: vipul@9399@yahoo.com	

WORKING DRAWINGS	
NORTH	

PROJECT:	"SUPARSHWA GARDEN CITY VILLA"
TOWNSHIP AT AJMER ROAD, JAIPUR	
NAME OF DRAWING:	TERRACE FLOOR DRAINAGE PLAN
SCALE:	N.T.S.
DATE:	18-08-2018
DEALT BY:	RAAJ
CHKD BY:	SANJAY
APPD BY:	VIPUL AGARWAL
DWG. NO.	VJ 06-SGC-A-DWG-04
R-0	