


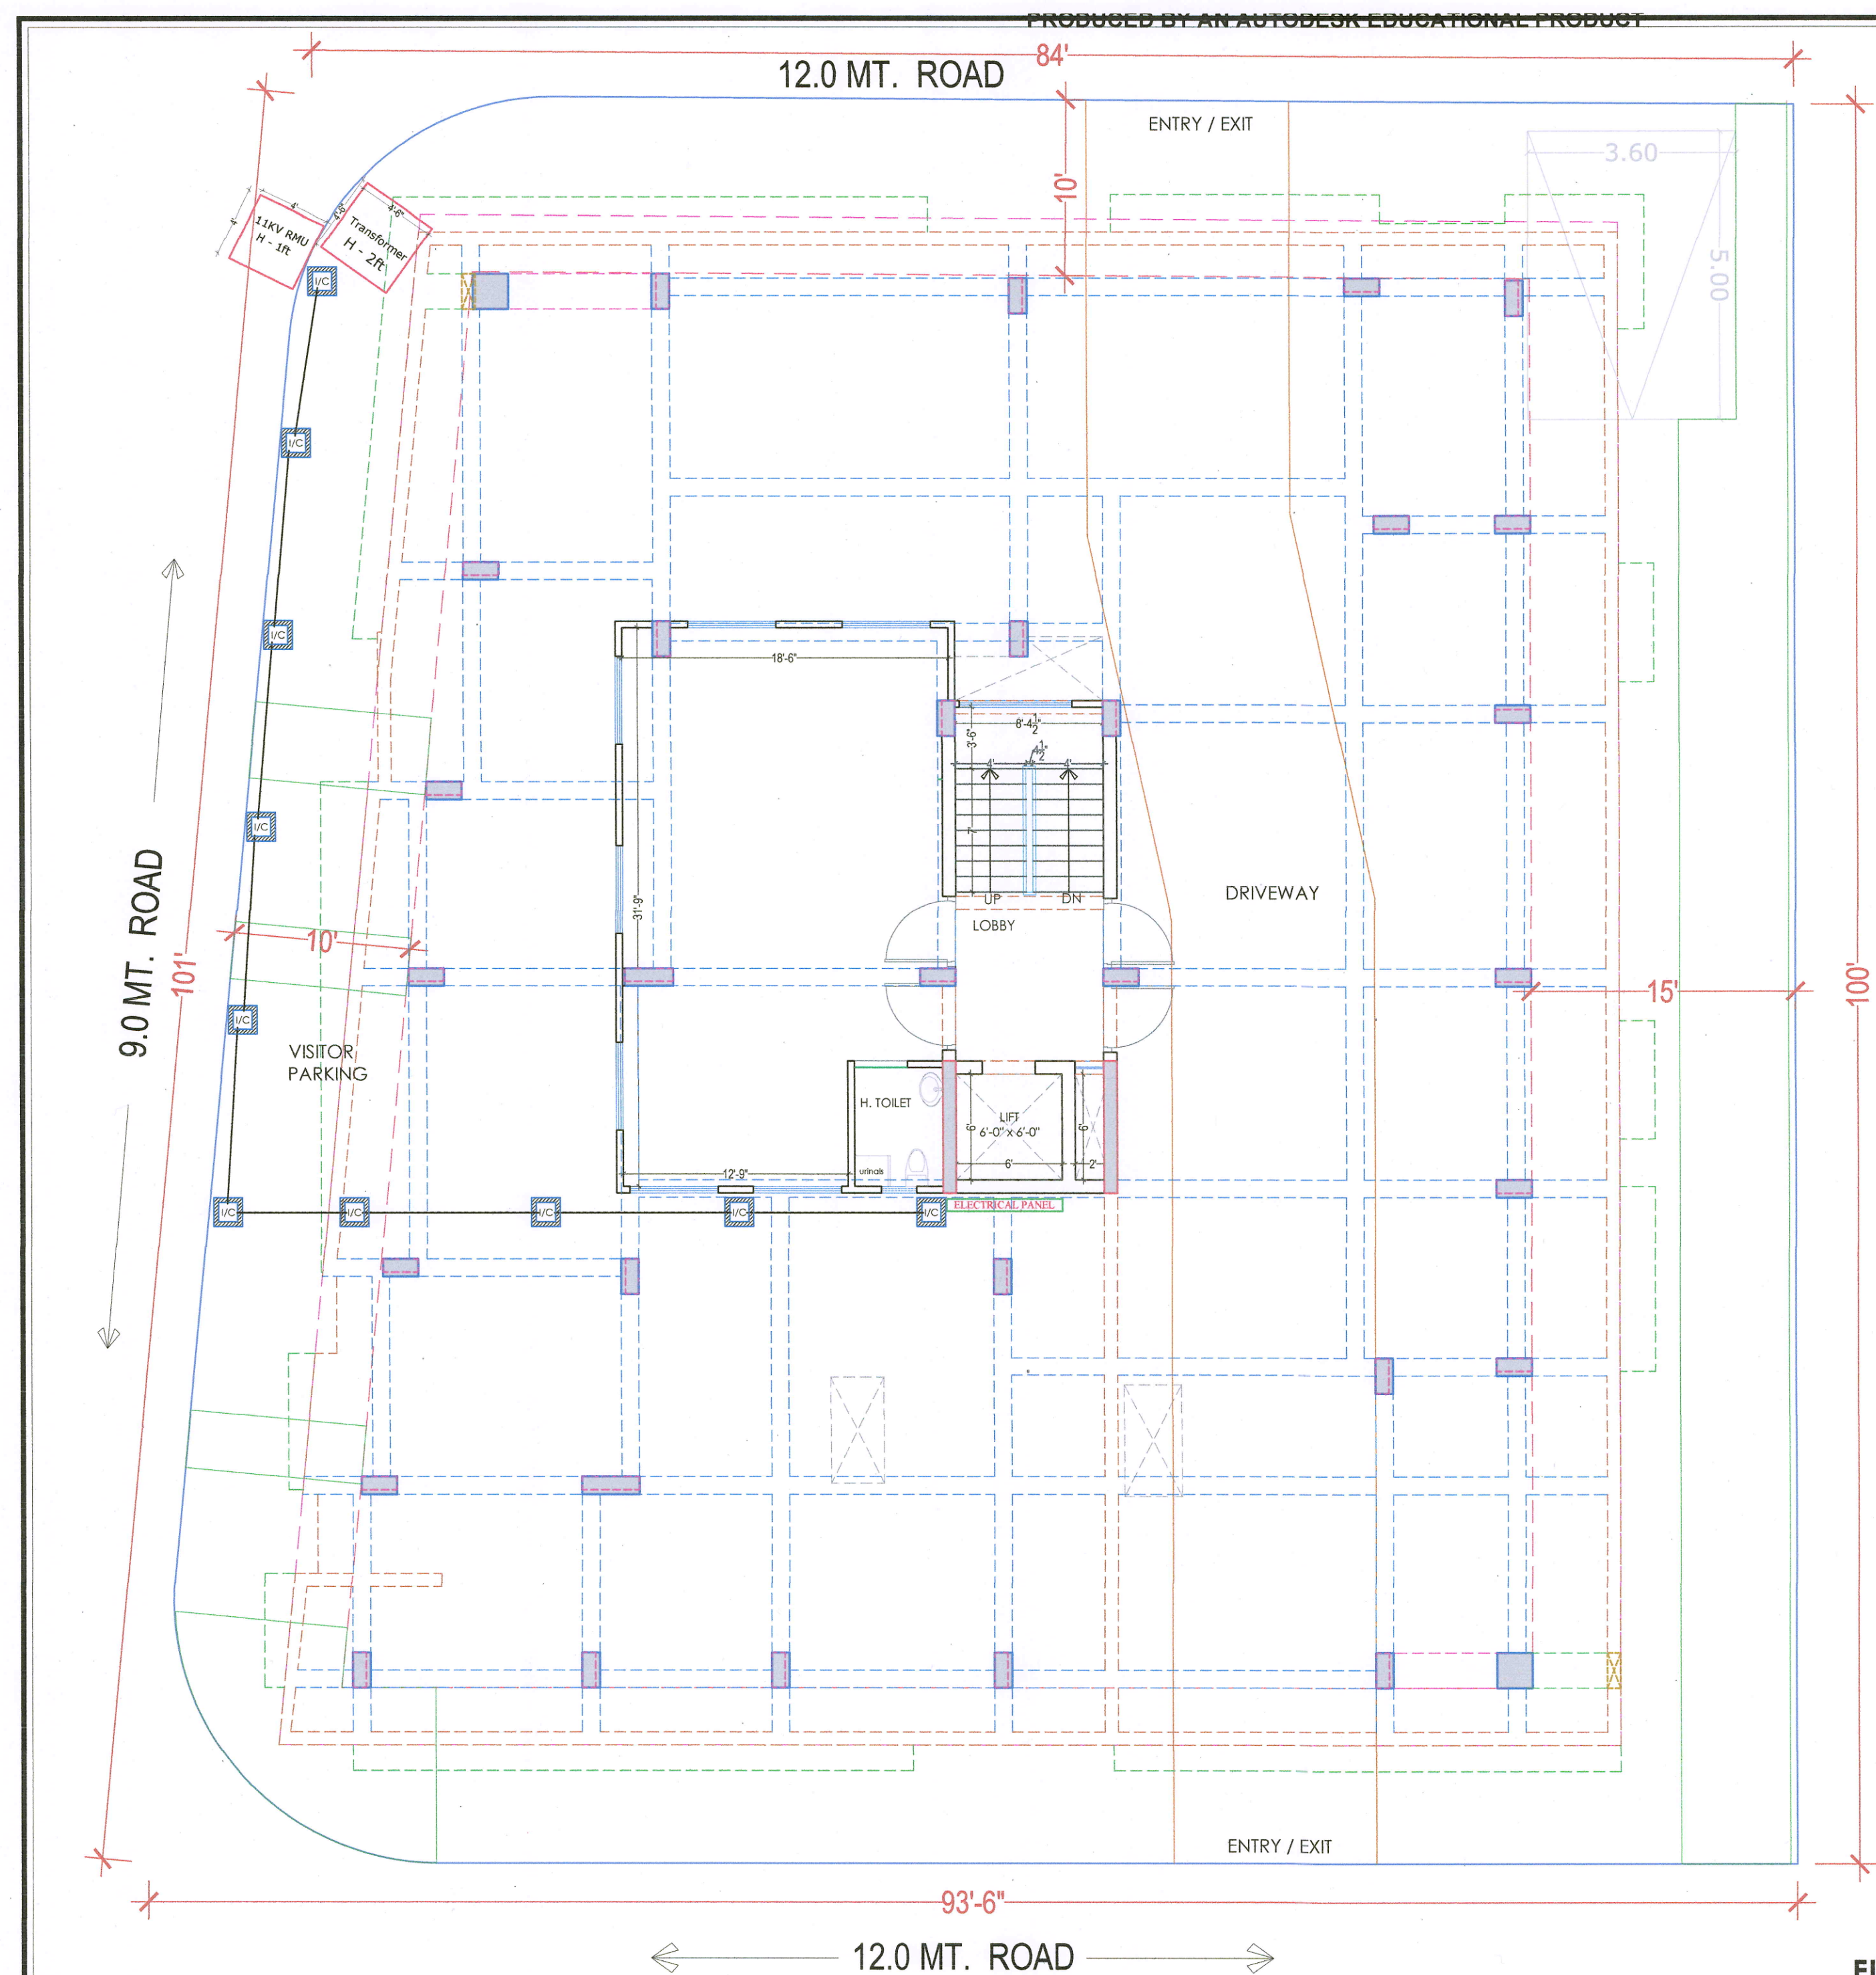


LEGENDS:			
Mounting Height	I D	Symbol	Description
CEILING	FAN/48"		CEILING FAN 48"
CEILING	FAN/30"		CEILING FAN 30"
CEILING	CHI		CHANDELIER
+93"	TL/W		Led Wall Tube Light Make:- Syka Led Cat no:- SSK-15-20W
+93"	BULB		Led Bulb 20W Make:- Syka Led Cat no:- SKC-20W 5.7K/3K
+93"	GL		WALL BRACKETS AS DESIGN FOR GANESH LIGHT
+78"	ML		12x2 Led Mirror Light Make:- Syka Led Cat no:- FPL-12x2
CEILING	DL		Led 6" Down Lighter 20W (Surface Mounted) Make:- Syka Led Cat no:- SDL-15W GLD 6.5K/4K
VENTILATOR HT.	CR		CEILING ROSE
VENTILATOR HT.	EXF		9" DIA FRESH AIR FAN
+24"	2wSB		2w SWITCH BOARD
+42"	SB		SWITCH BOARD (6A SOCKET & SWITCH)
+24"	TEL		TELEPHONE POINT
+24"	LP TEL		6 A PLUG POINT FOR TELEPHONE
+48"	TV		TV COAXIAL POINT
+48"	LP TV		6 A PLUG POINT FOR TV
+24"	LP		6 A PLUG POINT FOR SIDE TABLE
+72"	LP-CH		6 A PLUG POINT FOR CHIMNEY
+12"	LP PC		6 A PLUG FOR COMPUTER POINT
+93"	SAC		SPLIT AC INDOOR UNIT
+42"	PP-MIX		16 A POWER POINT FOR MIXER
+42"	PP-MIC		16 A POWER POINT FOR MICROWAVE
+78"	PP-G		16 A POWER POINT FOR GEYSER
+54"	PP-F		16 A POWER POINT FOR FRIDGE
+78"	PP-WP		16 A POWER POINT FOR WATER PURIFIER
+48"	PP-WM		16 A POWER POINT FOR WASHING MACHINE
+12"	PP-INV		16 A POWER POINT FOR INVERTOR
+93"	PP-AC		25A SWITCH/MCB FOR AC
			CHAMBER (2' X 2')
+18"			6A 2 NOS. SOCKET +1 NOS. 16A SWITCH, TELEPHONE, LAN
+60"	MCB DB		MCB DISTRIBUTION BOARD

M/s SIDDHI VINAYAK HOMES
Narendra
PARTNER

Sharma
Er. SANJEEV SHARMA
B.E (Electrical)

STILT FLOOR
ELECTRICAL ROUTE LAYOUT
(TRANSFORMER, RMU, METER PANEL,
ELECTRICAL CABLE)

PROJECT NAME :													
CRYSTAL HEIGHTS													
DEVELOPER NAME :													
SIDDHI VINAYAK HOMES													
S.No													
DATE													
REVISION DESCRIPTION													
GENERAL NOTES :													
1. All dimension on this drawing are in MKS System Only written dimensions are to be followed. drawing should not be scaled.													
2. All measurements must be checked and verified by the contractors prior to execution of work at the site.													
3. This drawing is to be read in conjunction with all relevant structural, services & facility planning drawings.													
4. Architectural drawings are to be followed for the location of all structural members & masonry walls, for sizes & reinforcement details of structural members, relevant structural drawings are to be referred.													
5. Any discrepancies between architectural, structural and services drawings must be brought to the notice of the architects immediately & prior to execution at site.													
6. Co-ordinate with services such as hvac, plumbing & electrical, etc. is the responsibility of the contractors.													
7. All masonry walls should be aligned with the columns as indicated on the plan, irrespective of the position as calculated with the dimensioning.													
8. For details, refer relevant large scale detail dgs. as indicated.													
PROJECT:													
PROPOSED RESIDENTIAL FLATS ON P. NO.- 115, 116, 117, 118, 119 & 120 SCHEME- GANESH NAGAR -B, JAIPUR													
NAME OF DRAWING: STILT FLOOR ELECTRICAL ROUTE LAYOUT (TRANSFORMER, RMU, METER PANEL, ELECTRICAL CABLE)													
DRAWING	NORTH:												
WORKING DRAWING													
PROJECT NO. :	DATE :												
	01, Jan. - 2024												
SCALE :	REV NO. :												
NTS	R-0												
DRAWING NO. :													
<table><tr><td>PROJECT</td><td>CATEGORY</td><td>BLOCK</td><td>FLOOR</td><td>TYPE</td><td>NUMBER</td></tr><tr><td></td><td></td><td></td><td></td><td></td><td>A-01</td></tr></table>		PROJECT	CATEGORY	BLOCK	FLOOR	TYPE	NUMBER						A-01
PROJECT	CATEGORY	BLOCK	FLOOR	TYPE	NUMBER								
					A-01								

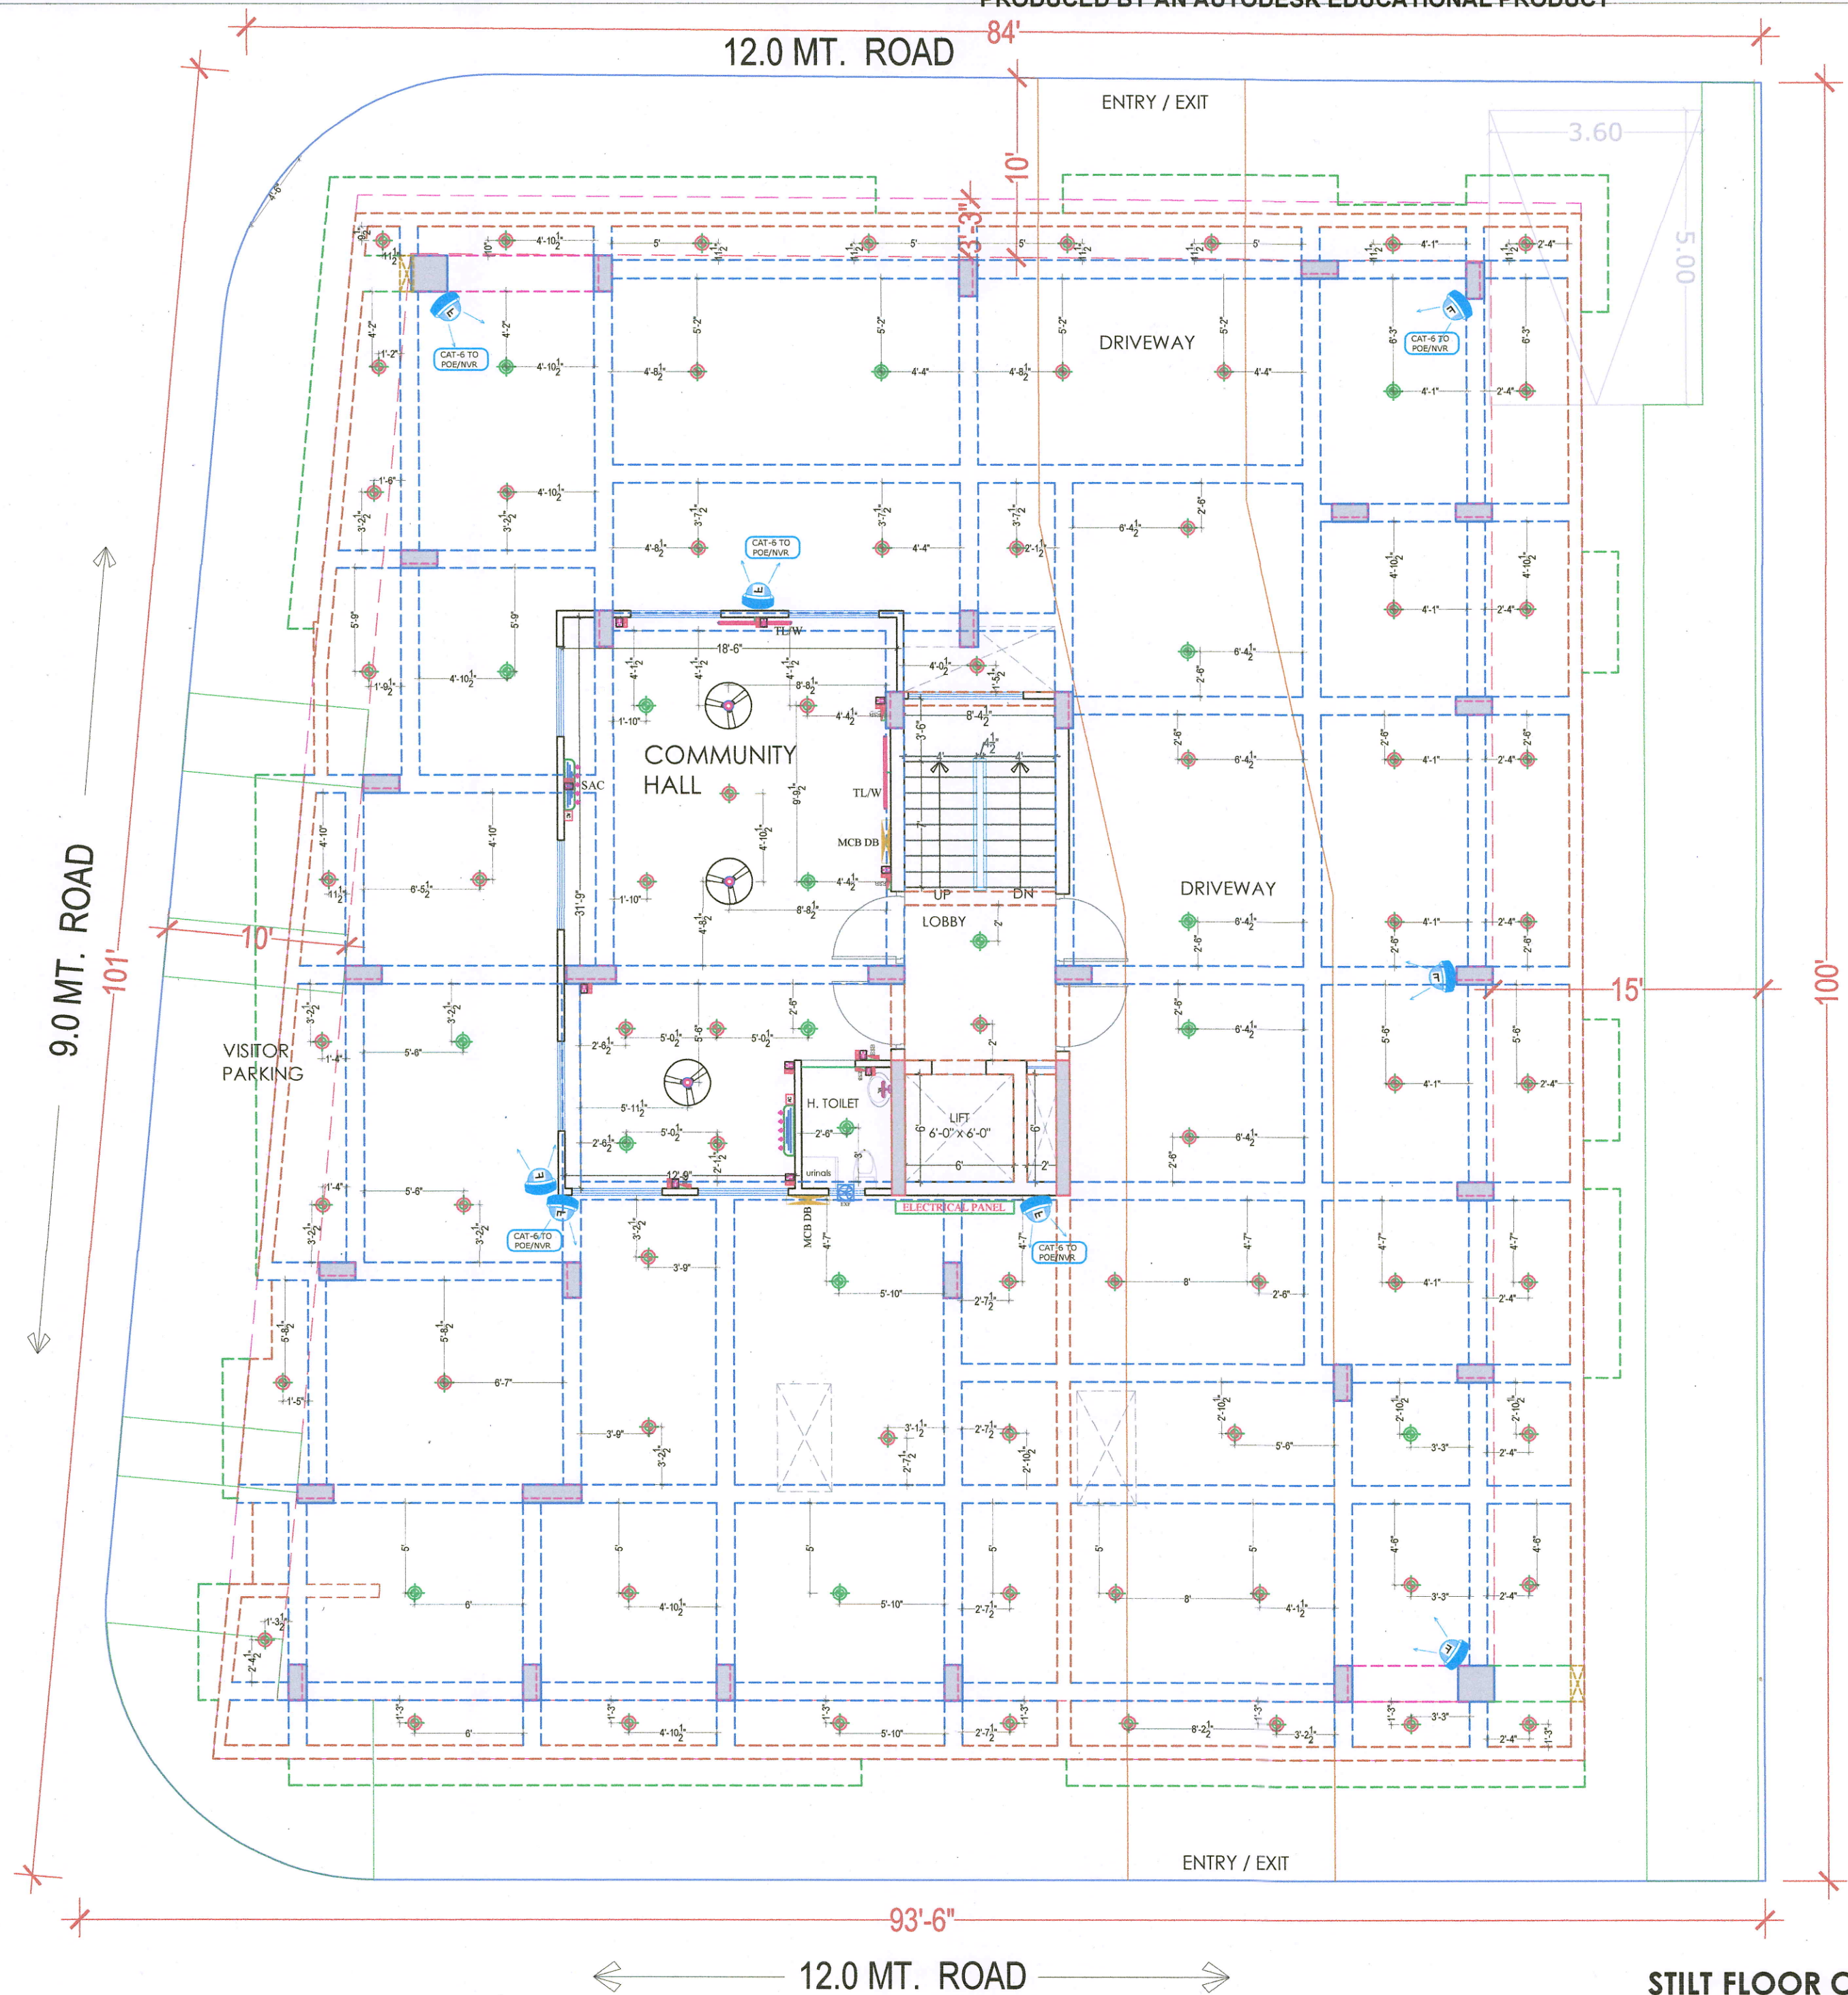

LEGENDS:			
Mounting Height	I D	Symbol	Description
CEILING	FAN/48"		CEILING FAN 48"
CEILING	FAN/30"		CEILING FAN 30"
CEILING	CHI		CHANDELIER
+93"	TL/W		LED Wall Tube Light Make - Syka Led Cat no - SKC-15-20W
+93"	BULB		LED Bulb 20W Make - Syka Led Cat no - SKC-20W 5.7K/5K
+93"	GL		WALL BRACKETS AS DESIGN FOR GANESH LIGHT
+78"	ML		12x2 Led Mirror Light Make - Syka Led Cat no - FPL-12x2
CEILING	DL		LED 6" Down Lighter 20W (Surface Mounted) Make - Syka Led Cat no - SDL-15W GLD 6.5K/4K
VENTILATOR	CR		CEILING ROSE
VENTILATOR	EXF		9" DIA FRESH AIR FAN
+24"	2wSB		2w SWITCH BOARD
+42"	SB		SWITCH BOARD (6A SOCKET & SWITCH)
+24"	TEL		TELEPHONE POINT
+24"	LP TEL		6 A PLUG POINT FOR TELEPHONE
+48"	TV		TV COAXIAL POINT
+48"	LP TV		6 A PLUG POINT FOR TV
+24"	LP		6 A PLUG POINT FOR SIDE TABLE
+72"	LP CH		6 A PLUG POINT FOR CHIMNEY
+12"	LP PC		6 A PLUG POINT FOR COMPUTER POINT
+93"	SAC		SPLIT AC INDOOR UNIT
+42"	PP-MIX		16 A POWER POINT FOR MIXER
+42"	PP-MIC		16 A POWER POINT FOR MICROWAVE
+78"	PP-G		16 A POWER POINT FOR GEYSER
+54"	PP-F		16 A POWER POINT FOR FRIDGE
+78"	PP-WP		16 A POWER POINT FOR WATER PURIFIER
+48"	PP-WM		16 A POWER POINT FOR WASHING MACHINE
+12"	PP-INV		16 A POWER POINT FOR INVERTOR
+93"	PP-AC		25A SWITCH/ MCB FOR AC
			CHAMBER (2' X 2')
+18"			6A 2 NOS. SOCKET +1 NOS. 16A SWITCH, TELEPHONE/LAN
+60"	MCB DB		MCB DISTRIBUTION BOARD

M/s SIDDHI VINAYAK HOMES
Nashik
PARTNER
Sham
Er. SANJEEV SHARMA
B.E (Electrical)

PROJECT NAME :
CRYSTAL HEIGHTS
DEVELOPER NAME :
SIDDHI VINAYAK HOMES

GENERAL NOTES :
1. All dimension on this drawing are in MKS System Only written dimensions are to be followed. drawing should not be scaled.
2. All measurements must be checked and verified by the contractors prior to execution of work at the site.
3. This drawing is to be read in conjunction with all relevant structural, services & facility planning drawings.
4. Architectural drawings are to be followed for the location of all structural members & masonry walls. for sizes & reinforcement details of structural members, relevant structural drawings are to be referred.
5. Any discrepancies between architectural, structural and services drawings must be brought to the notice of the architects immediately & prior to execution at site. Co-ordination with services such as hvac, plumbing & electrical, etc. is the responsibility of the contractors.
6. All masonry walls should be aligned with the columns as indicated on the plan, irrespective of the position as calculated with the dimensioning.
7. For details, refer relevant large scale detail drgs. as indicated.

PROJECT:
PROPOSED RESIDENTIAL FLATS ON
P. NO.- 115, 116, 117, 118, 119 & 120
SCHEME- GANESH NAGAR -B,
JAIPUR

NAME OF DRAWING: STILT FLOOR
CEILING ELECTRICAL LAYOUT,
ELECTRICAL POINT DRAWING,
CAMERA POINT DRAWING

DRAWING NORTH:
WORKING DRAWING
PROJECT NO. :
DATE :
01, Jan. - 2024
SCALE :
NTS
REV NO. :
R-0

DRAWING NO. :
A-01

STILT FLOOR CEILING ELECTRICAL LAYOUT,
ELECTRICAL POINT DRAWING,
CAMERA POINT DRAWING

PROJECT NAME :

CRYSTAL HEIGHTS

DEVELOPER NAME :

SIDDHI VINAYAK HOMES

LEGENDS:			
Mounting Height	I D	Symbol	Description
CEILING	FAN48"		CEILING FAN 48"
CEILING	FAN30"		CEILING FAN 30"
CEILING	CHI		CHANDELIER
+93"	TL/W		Led Wall Tube Light Make- Syka Led Cat no- SSK-TS-20W
+93"	BULB		Led Bulb 20W Make- Syka Led Cat no- SKC-20W 5.7K/5K
+93"	GL		WALL BRACKETS AS DESIGN FOR GANESH LIGHT
+78"	ML		12x2 Led Mirror Light Make- Syka Led Cat no- FPL-12x2
CEILING	DL		Led 6" Down Lighter 20W (Surface Mounted) Make- Syka Led Cat no- SDL-15W GLD 6.5K/4K
VENTILATOR	CR		CEILING ROSE
VENTILATOR	EXF		9" DIA FRESH AIR FAN
+24"	2wSB		2w SWITCH BOARD
+42"	SB		SWITCH BOARD (6A SOCKET & SWITCH)
+24"	TEL		TELEPHONE POINT
+24"	LP TEL		6 A PLUG POINT FOR TELEPHONE
+48"	TV		TV COAXIAL POINT
+48"	LP TV		6 A PLUG POINT FOR TV
+24"	LP		6 A PLUG POINT FOR SIDE TABLE
+72"	LP-CH		6 A PLUG POINT FOR CHIMNEY
+12"	LP-PC		6 A PLUG POINT FOR COMPUTER POINT
+93"	SAC		SPLIT AC INDOOR UNIT
+42"	PP-MIX		16 A POWER POINT FOR MIXER
+42"	PP-MIC		16 A POWER POINT FOR MICROWAVE
+78"	PP-G		16 A POWER POINT FOR GEYSER
+54"	PP-F		16 A POWER POINT FOR FRIDGE
+78"	PP-WP		16 A POWER POINT FOR WATER PURIFIER
+48"	PP-WM		16 A POWER POINT FOR WASHING MACHINE
+12"	PP-INV		16 A POWER POINT FOR INVERTOR
+93"	PP-AC		25A SWITCH/ MCB FOR AC
			CHAMBER (2' X 2')
+18"			6A 2 NOS. SOCKET +1 NOS. 16A SWITCH, TELEPHONELAN
+60"	MCB DB		MCB DISTRIBUTION BOARD

M/s SIDDHI VINAYAK HOMES

Partner

PARTNER

Er. SANJEEV SHARMA
B.E (Electrical)

PROJECT:


PROPOSED RESIDENTIAL FLATS ON
P. NO.- 115, 116, 117, 118, 119 & 120
SCHEME- GANESH NAGAR -B,
JAIPUR

NAME OF DRAWING: **STILT FLOOR
CEILING ELECTRICAL LAYOUT,
ELECTRICAL POINT DRAWING**

DRAWING	NORTH:
WORKING DRAWING	
PROJECT NO. :	DATE :
	01, Jan. - 2024
SCALE :	REV NO. :
NTS	R-0


DRAWING NO. :					
PROJECT	CATEGORY	BLOCK	FLOOR	TYPE	NUMBER

A-01

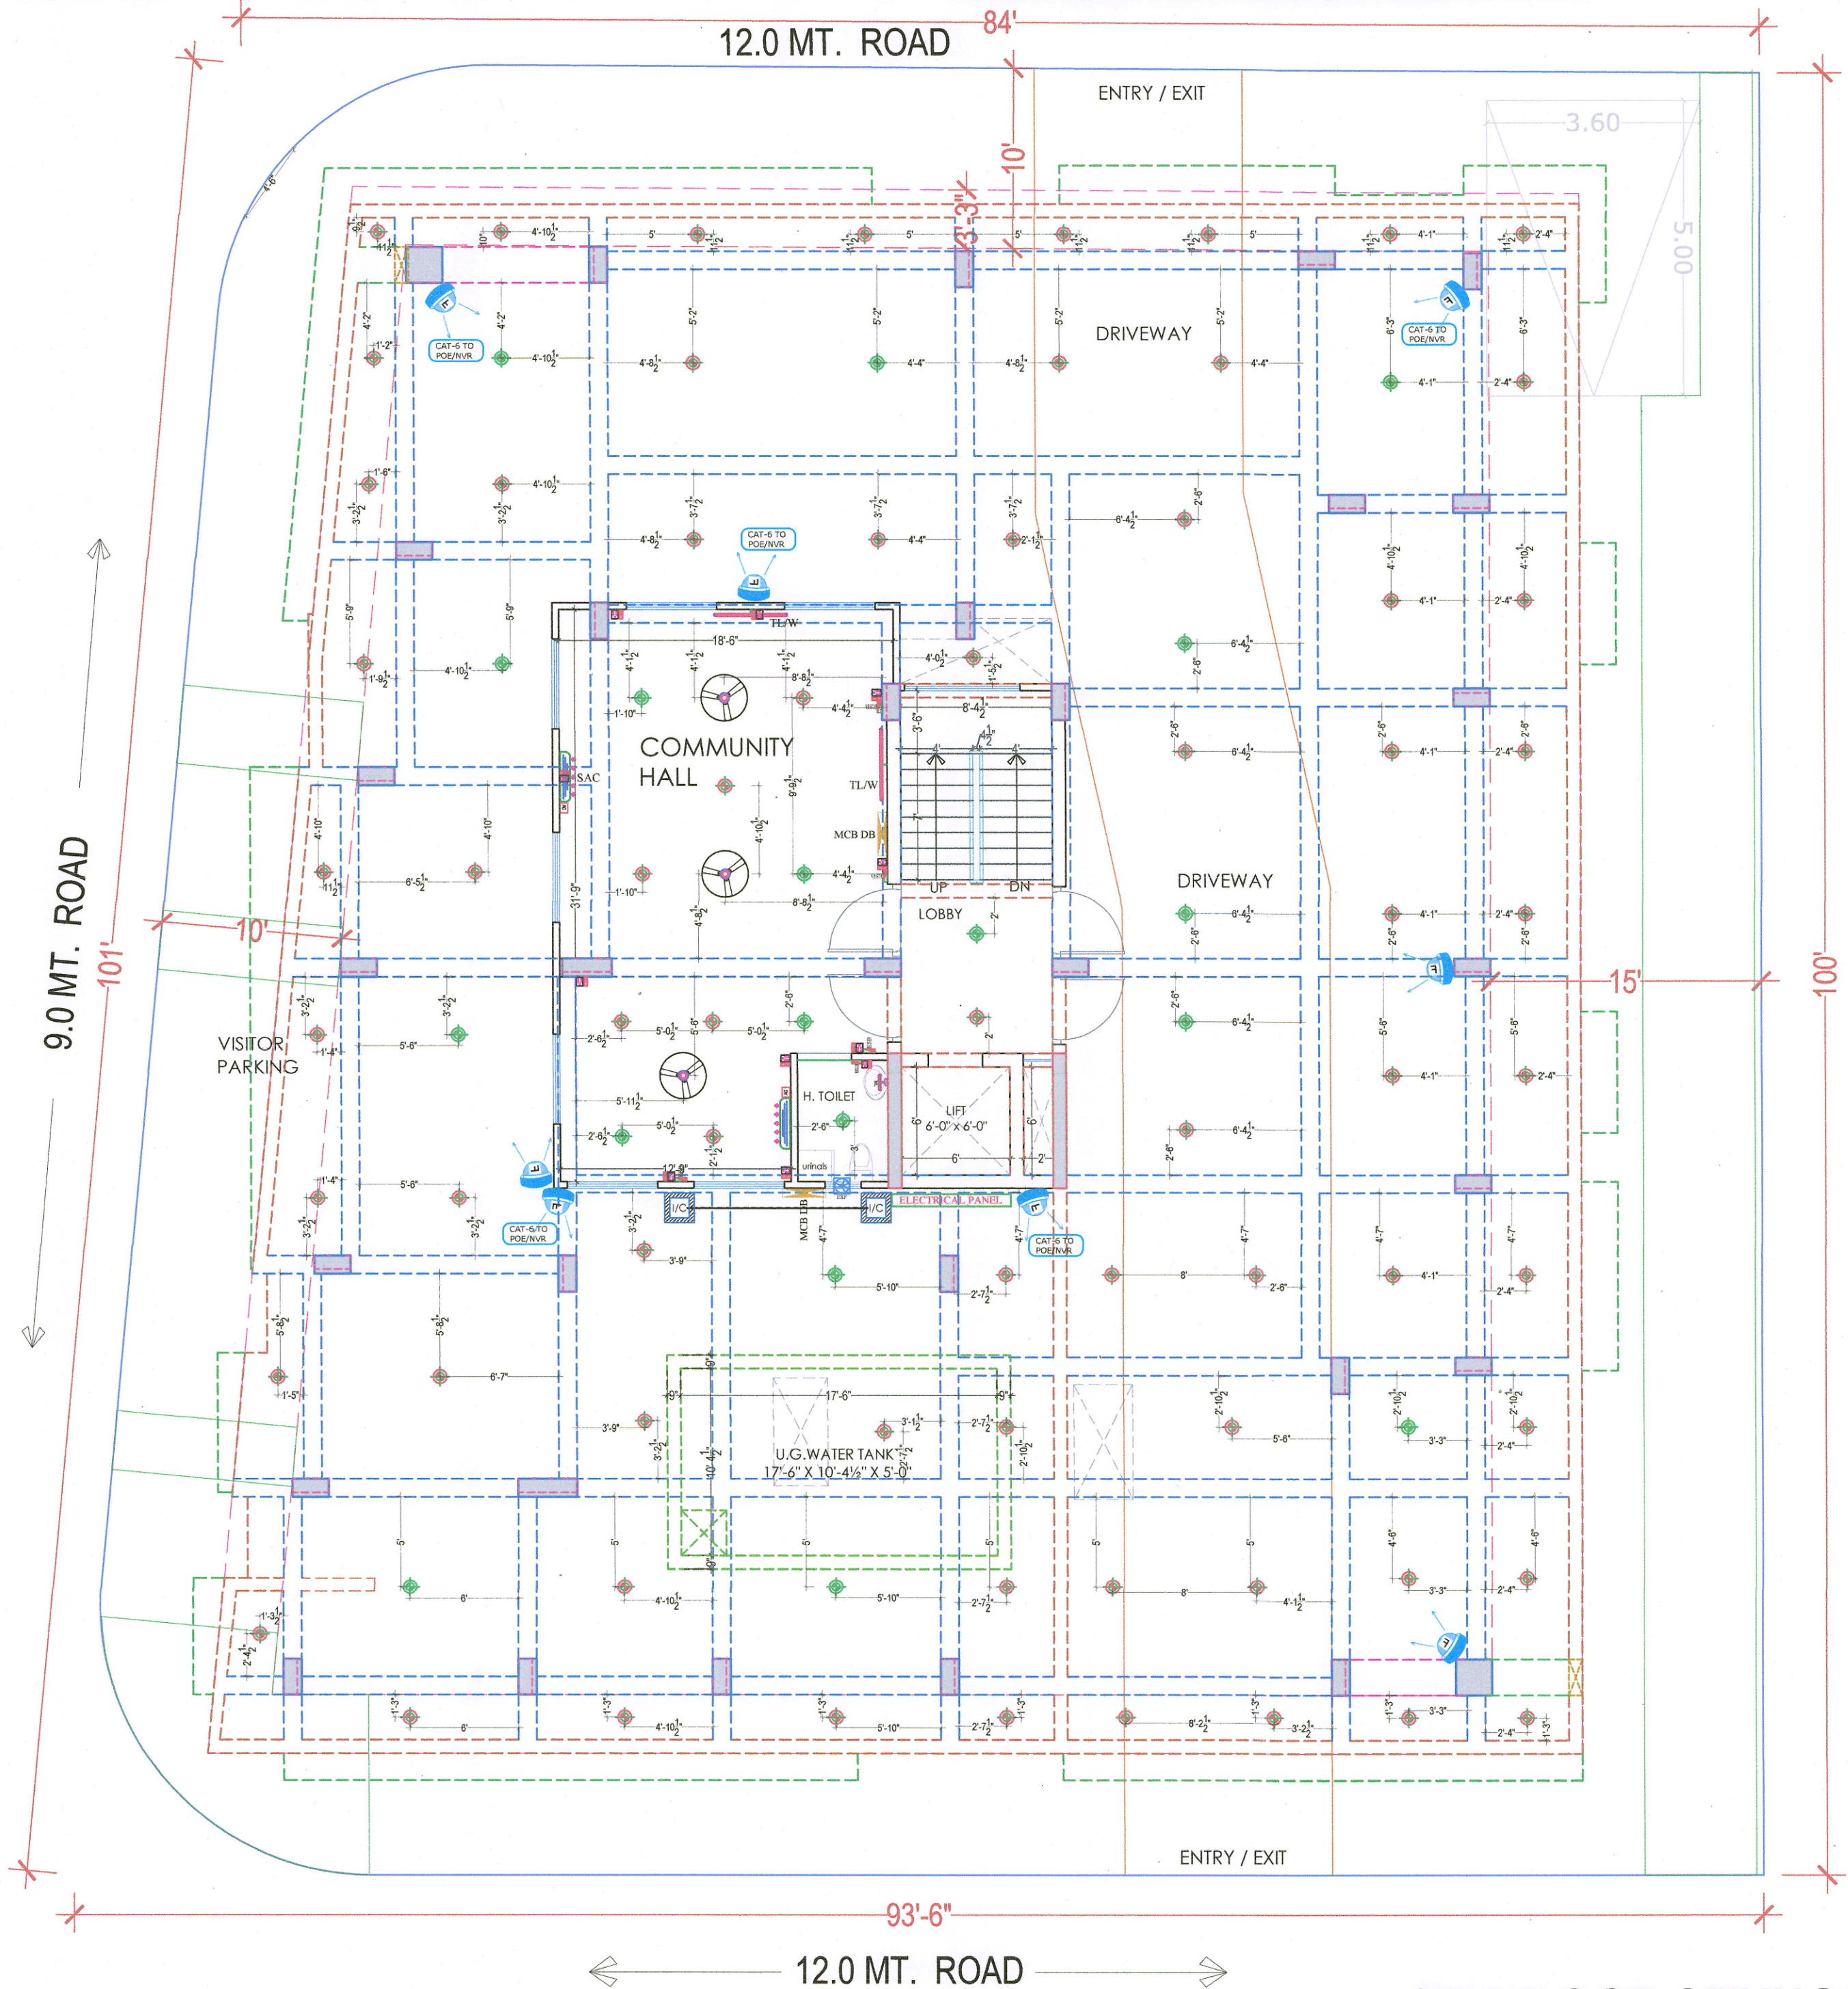

STILT FLOOR CEILING ELECTRICAL LAYOUT,
ELECTRICAL POINT DRAWING

101'
9.0 MT. ROAD

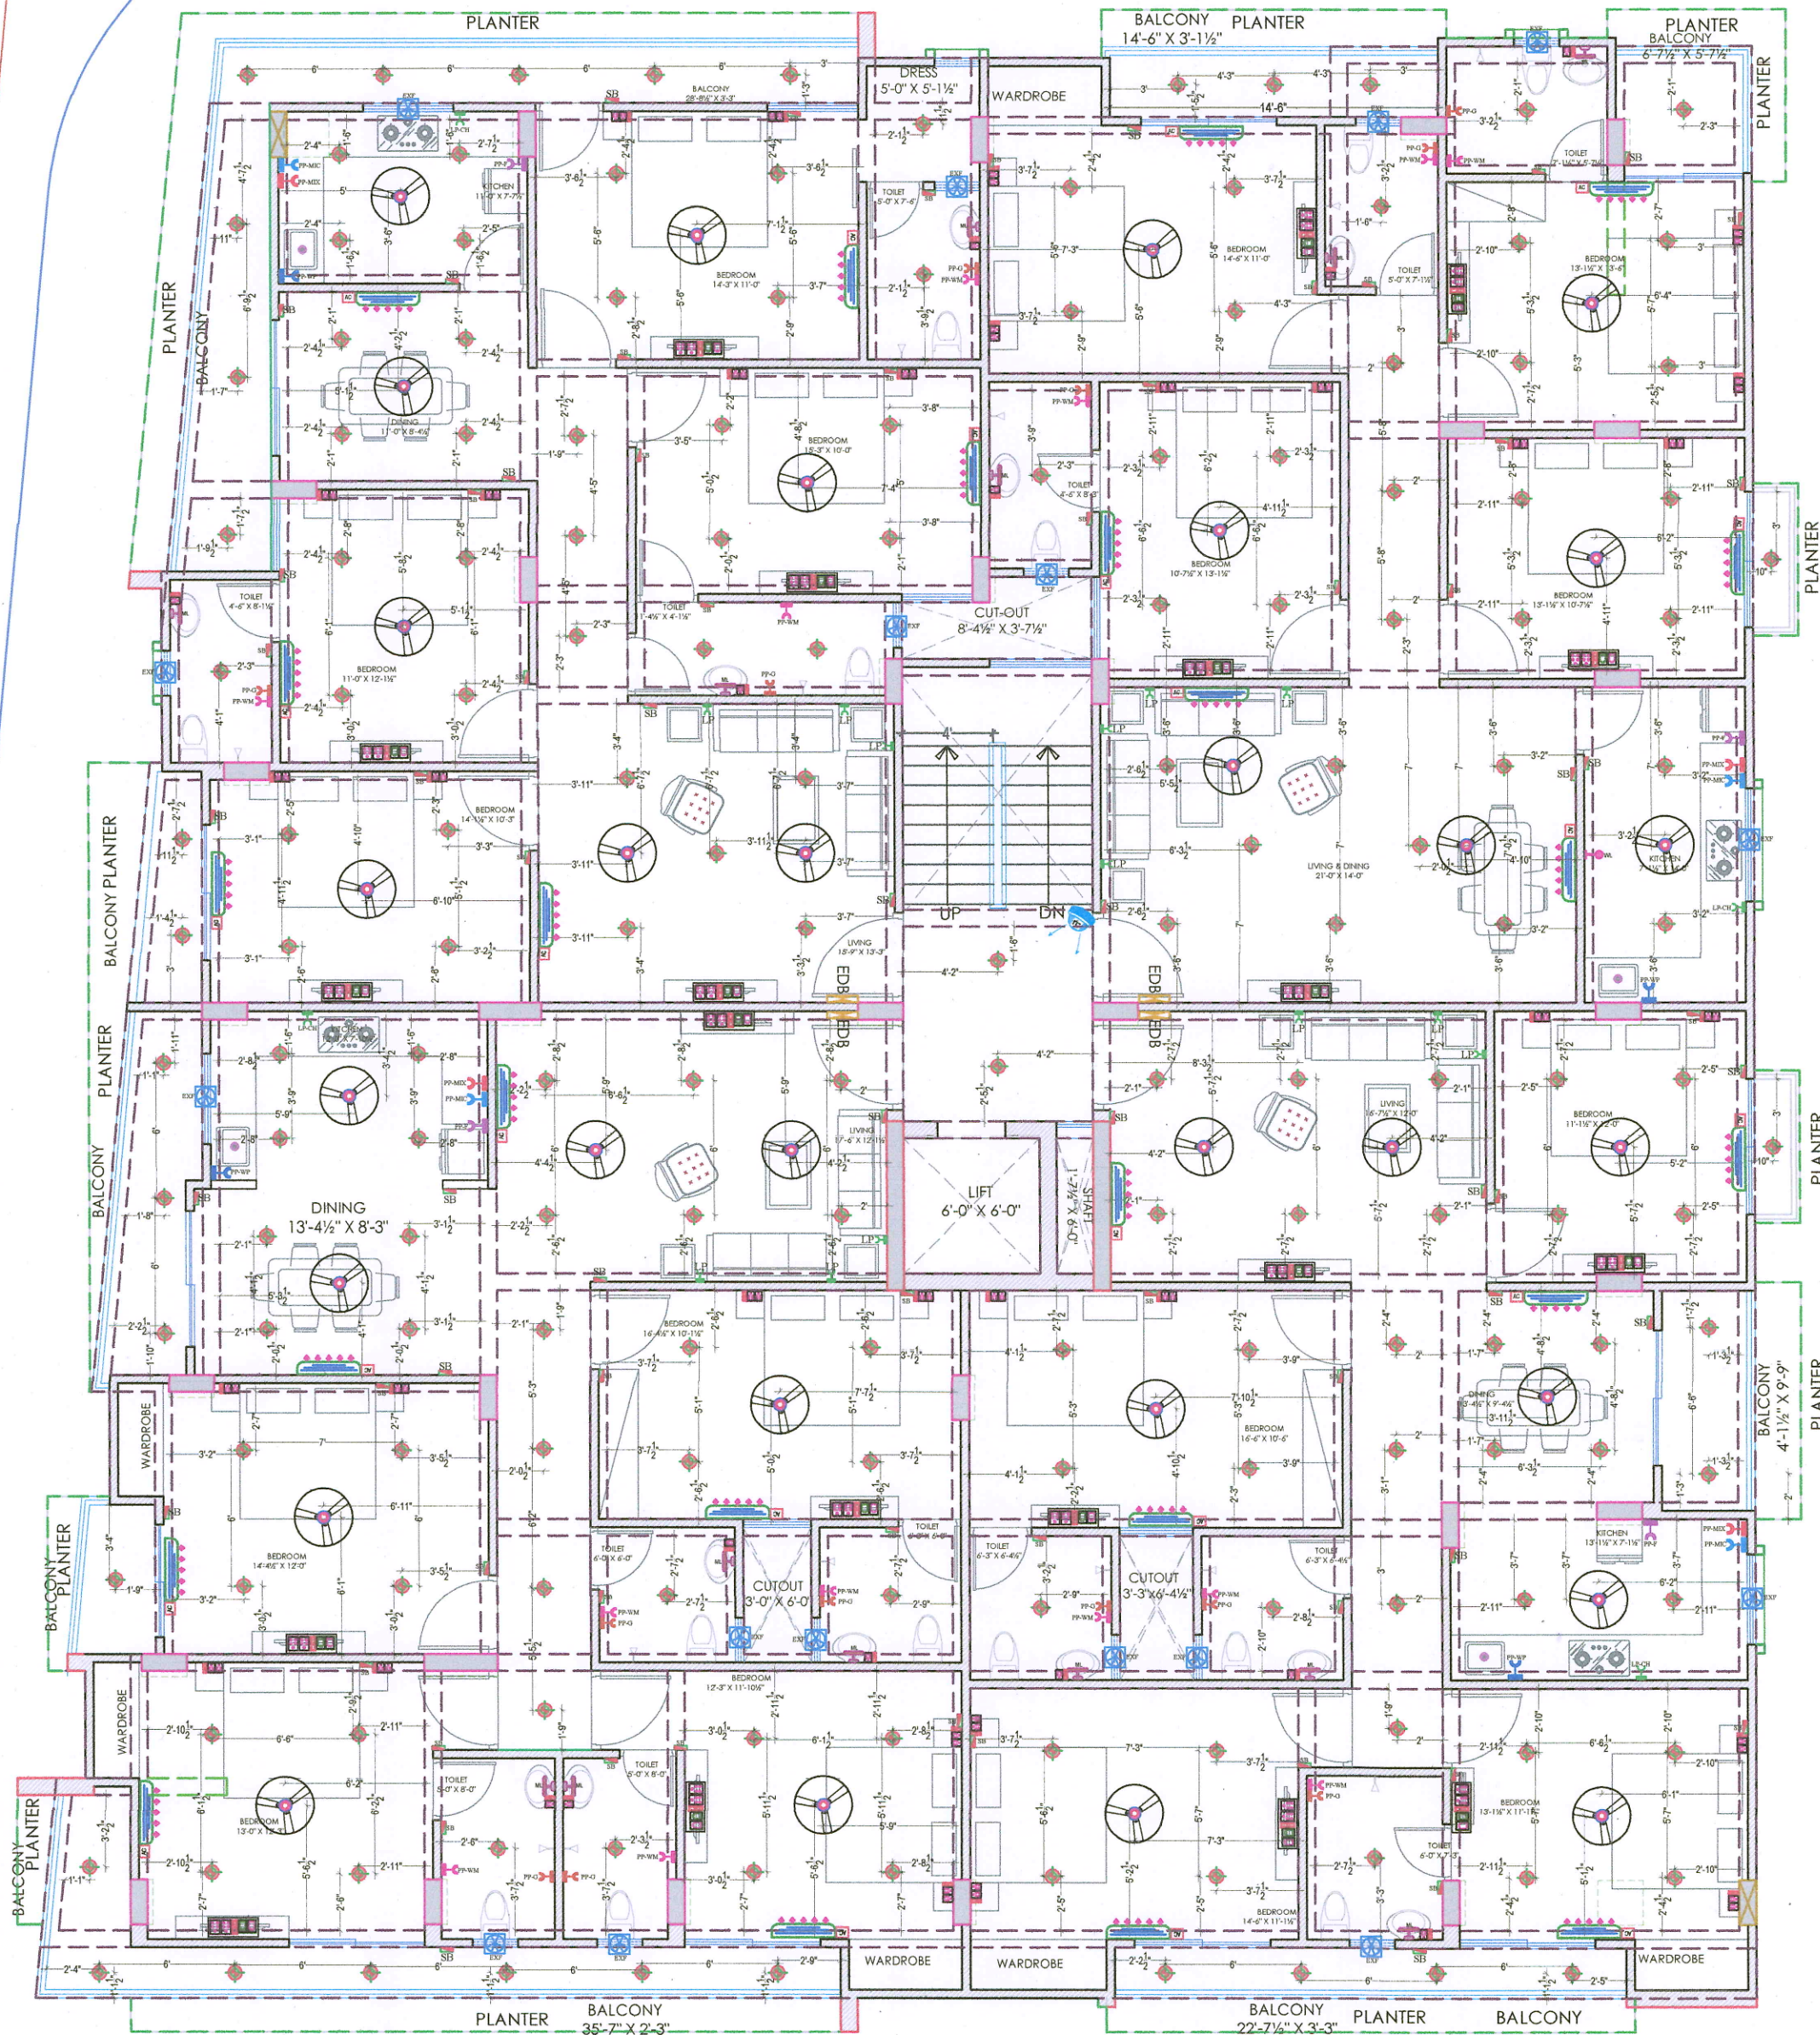

93'-6"

100'

LEGENDS:			
Mounting Height	I D	Symbol	Description
CEILING	FAN/48"		CEILING FAN 48"
CEILING	FAN/30"		CEILING FAN 30"
CEILING	CHI		CHANDELLER
+93"	TL/W		Led Wall Tube Light Make:- Syska Led Cat no:- SSK-TS-20W
+93"	BULB		Led Bulb 20W Make:- Syska Led Cat no:- SKC-20W 5.7K/3K
+93"	GL		WALL BRACKETS AS DESIGN FOR GANESH LIGHT
+78"	ML		12x2 Led Mirror Light Make:- Syska Led Cat no:- FPL-12x2
CEILING	DL		Led 6" Down Lighter 20W (Surface Mounted) Make:- Syska Led Cat no:- SDL-15W GLD 6.5K/4K
VENTILATOR	CR		CEILING ROSE
VENTILATOR	EXF		9" DIA FRESH AIR FAN
+24"	2wSB		2wSWITCH BOARD
+42"	SB		SWITCH BOARD(6A SOCKET & SWITCH)
+24"	TEL		TELEPHONE POINT
+24"	LP TEL		6 A PLUG POINT FOR TELEPHONE
+48"	TV		TV COAXIAL POINT
+48"	LP TV		6 A PLUG POINT FOR TV
+24"	LP		6 A PLUG POINT FOR SIDE TABLE
+72"	LP-CH		6 A PLUG POINT FOR CHIMNEY
+12"	LP PC		6 A PLUG FOR COMPUTER POINT
+93"	SAC		SPLIT AC INDOOR UNIT
+42"	PP-MIX		16 A POWER POINT FOR MIXER
+42"	PP-MIC		16 A POWER POINT FOR MICROWAVE
+78"	PP-G		16 A POWER POINT FOR FRIDGE
+54"	PP-F		16 A POWER POINT FOR FRIDGE
+78"	PP-WP		16 A POWER POINT FOR WATER PURIFIER
+48"	PP-WM		16 A POWER POINT FOR WASHING MACHINE
+12"	PP-INV		16 A POWER POINT FOR INVERTOR
+93"	PP-AC		25A SWITCH/MCB FOR AC
			CHAMBER(2' X 2')
+18"			6A 2 NOS. SOCKET +1 NOS. 16A SWITCH TELEPHONE/LAN
+60"	MCB DB		MCB DISTRIBUTION BOARD

M/s SIDDHI VINAYAK HOMES

Narender

PARTNER

Er. SANJEEV SHARMA
B.E (Electrical)

PROJECT NAME :

CRYSTAL HEIGHTS

DEVELOPER NAME :

SIDDHI VINAYAK HOMES

S.No DATE REVISION DESCRIPTION

GENERAL NOTES :

- All dimension on this drawing are in MKS System Only written dimensions are to be followed. drawing should not be scaled.
- All measurements must be checked and verified by the contractors prior to execution of work at the site.
- This drawing is to be read in conjunction with all relevant structural, services & facility planning drawings.
- Architectural drawings are to be followed for the location of all structural members & masonry walls. for sizes & reinforcement details of structural members, relevant structural drawings are to be referred.
- Any discrepancies between architectural, structural and services drawings must be brought to the notice of the architects immediately & prior to execution at site.
- Co-ordination with services such as HVAC, plumbing & electrical, etc. is the responsibility of the contractors.
- All masonry walls should be aligned with the columns as indicated on the plan, irrespective of the position as calculated with the dimensioning.
- For details, refer relevant large scale detail drgs. as indicated.

PROJECT:

PROPOSED RESIDENTIAL FLATS ON
P. NO.- 115, 116, 117, 118, 119 & 120
SCHEME- GANESH NAGAR -B,
JAIPUR

NAME OF DRAWING:

TYPICAL FLOOR
ELECTRICAL LAYOUT (GROUND TO 5TH.)
(ELECTRICAL POINT,CEILING POINT,TV)

DRAWING
WORKING DRAWING

NORTH:



PROJECT NO. :

DATE :

01, Jan. - 2024

SCALE :

NTS

REV NO. :

R-0

DRAWING NO. :

PROJECT CATEGORY BLOCK FLOOR TYPE NUMBER

A-01

TYPICAL FLOOR ELECTRICAL LAYOUT (GROUND TO 5TH.)
(ELECTRICAL POINT,CEILING POINT,TV)

TYPICAL FLOOR PLAN G+5
ELECTRICAL CABLES,ELECTRICAL
DB,ELECTRICAL SHAFT,CABLE TRAY

LEGENDS:			
Mounting Height	I D	Symbol	Description
CEILING	FAN/48"		CEILING FAN 48"
CEILING	FAN/30"		CEILING FAN 30"
CEILING	CH1		CHANDELIER
+93"	TL/W		Led Wall Tube Light Make:- Syska Led Cat no:- SSK-15-20W
+93"	BULB		Led Bulb 20W Make:- Syska Led Cat no:- SKC-20W 5.7K/3K
+93"	GL		WALL BRACKETS AS DESIGN FOR GANESH LIGHT
+78"	ML		12x2 Led Mirror Light Make:- Syska Led Cat no:- FPL-12x2
CEILING	DL		Led 6" Down Lighter 20W (Surface Mounted) Make:- Syska Led Cat no:- SDL-15W GLD 6.5K/4K
VENTILATOR HT.	CR		CEILING ROSE
VENTILATOR HT.	EXF		9" DIA FRESH AIR FAN
+24"	2wSB		2w SWITCH BOARD
+42"	SB		SWITCH BOARD(6A SOCKET & SWITCH)
+24"	TEL		TELEPHONE POINT
+24"	LP TEL		6 A PLUG POINT FOR TELEPHONE
+48"	TV		TV COAXIAL POINT
+48"	LP TV		6 A PLUG POINT FOR TV
+24"	LP		6 A PLUG POINT FOR SIDE TABLE
+72"	LP-CH		6 A PLUG POINT FOR CHIMNEY
+12"	LPPC		6 A PLUG FOR COMPUTER POINT
+93"	SAC		SPLIT AC INDOOR UNIT
+42"	PP-MIX		16 A POWER POINT FOR MIXER
+42"	PP-MIC		16 A POWER POINT FOR MICROWAVE
+78"	PP-G		16 A POWER POINT FOR GEYSER
+54"	PP-F		16 A POWER POINT FOR FRIDGE
+78"	PP-WP		16 A POWER POINT FOR WATER PURIFIER
+48"	PP-WM		16 A POWER POINT FOR WASHING MACHINE
+12"	PP-INV.		16 A POWER POINT FOR INVERTOR
+93"	PP-AC		25A SWITCH/MCB FOR AC
			CHAMBER(2' X 2')
+18"			6A 2 NOS. SOCKET +1 NOS. 16A SWITCH ,TELEPHONE/LAN
+60"			MCB DISTRIBUTION BOARD

M/s SIDDHI VINAYAK HOMES

Narendra

PARTNER

Sham
Er. SANJEEV SHARMA
B.E (Electrical)

PROJECT NAME :

CRYSTAL HEIGHTS

DEVELOPER NAME :

SIDDHI VINAYAK HOMES

S.No DATE

GENERAL NOTES :

- All dimension on this drawing are in MKS System Only written dimensions are to be followed drawing should not be scaled .
- All measurements must be checked and verified by the contractors prior to execution of work at the site.
- This drawing is to be read in conjunction with all relevant structural, services & facility planning drawings.
- Architectural drawings are to be followed for the location of all structural members & masonry walls, for sizes & reinforcement details of structural members, relevant structural drawings are to be referred.
- Any discrepancies between architectural, structural and services drawings must be brought to the notice of the architects immediately & prior to execution at site.
- Co-ordinao with services such as hvac, plumbing & electrical, etc. is the responsibility of the contractors.
- All masonry walls should be aligned with the columns as indicated on the plan, irrespective of the position as calculated with the dimensioning.
- For details, refer relevant large scale detail dgs. as indicated.

PROJECT:

PROPOSED RESIDENTIAL FLATS ON
P. NO.- 115, 116, 117, 118, 119 & 120
SCHEME- GANESH NAGAR -B,
JAIPUR

NAME OF DRAWING:

TYPICAL FLOOR PLAN G+5
ELECTRICAL CABLES,ELECTRICAL
DB,ELECTRICAL SHAFT,CABLE TRAY

DRAWING

WORKING DRAWING

NORTH:



PROJECT NO. :

DATE :

01, Jan. - 2024

SCALE :

NTS

REV NO. :

R-0

DRAWING NO. :

PROJECT CATEGORY BLOCK FLOOR TYPE NUMBER

A-01

PRODUCED BY AN AUTODESK EDUCATIONAL PRODUCT



Er. SANJEEV SHARMA
B.E (Electrical)