

PROJECT NAME :
CRYSTAL HEIGHTS
DEVELOPER NAME :
SIDDHI VINAYAK HOMES

LEGEND:-	
FIRE HYDRANT MS PIPE	
BALL VALVE	
EXTERNAL FIRE HYDRANT	
EXTERNAL FIRE ROSE CABINET	
FIRE ROSE CABINET	
UPRIGHT SPRINKLER HEAD	
PENDENT SPRINKLER HEAD	
SIDE WALL SPRINKLER HEAD	
FIRE EXTINGUISHER	
FLOW SWITCH	
ISOLATION VALVE	
2 WAY FIRE BRIGADE INLET	


- GENERAL NOTES :
- All dimension on this drawing are in MKS System Only written dimensions are to be followed. drawing should not be scaled.
 - All measurements must be checked and verified by the contractors prior to execution of work at the site.
 - This drawing is to be read in conjunction with all relevant structural, services & facility planning drawings.
 - Architectural drawings are to be followed for the location of all structural members & masonry walls, for sizes & reinforcement details of structural members, relevant structural drawings are to be referred.
 - Any discrepancies between architectural, structural and services drawings must be brought to the notice of the architects immediately & prior to execution at site. Co-ordinate with services such as hvac, plumbing & electrical, etc. as the responsibility of the contractors.
 - All masonry walls should be aligned with the columns as indicated on the plan, irrespective of the position as calculated with the dimensioning.
 - For details, refer relevant large scale detail drgn. as indicated.

PROJECT:
PROPOSED RESIDENTIAL FLATS ON
P. NO.- 115, 116, 117, 118, 119 & 120
SCHEME- GANESH NAGAR -B,
JAIPUR

NAME OF DRAWING:
STILT FLOOR FIRE FIGHTING LAYOUT


DRAWING WORKING DRAWING	NORTH:
PROJECT NO. :	DATE : 15, May. - 2024
SCALE : NTS	REV NO. : R-0

DRAWING NO. :					
PROJECT	CATEGORY	BLOCK	FLOOR	TYPE	NUMBER
					A-01

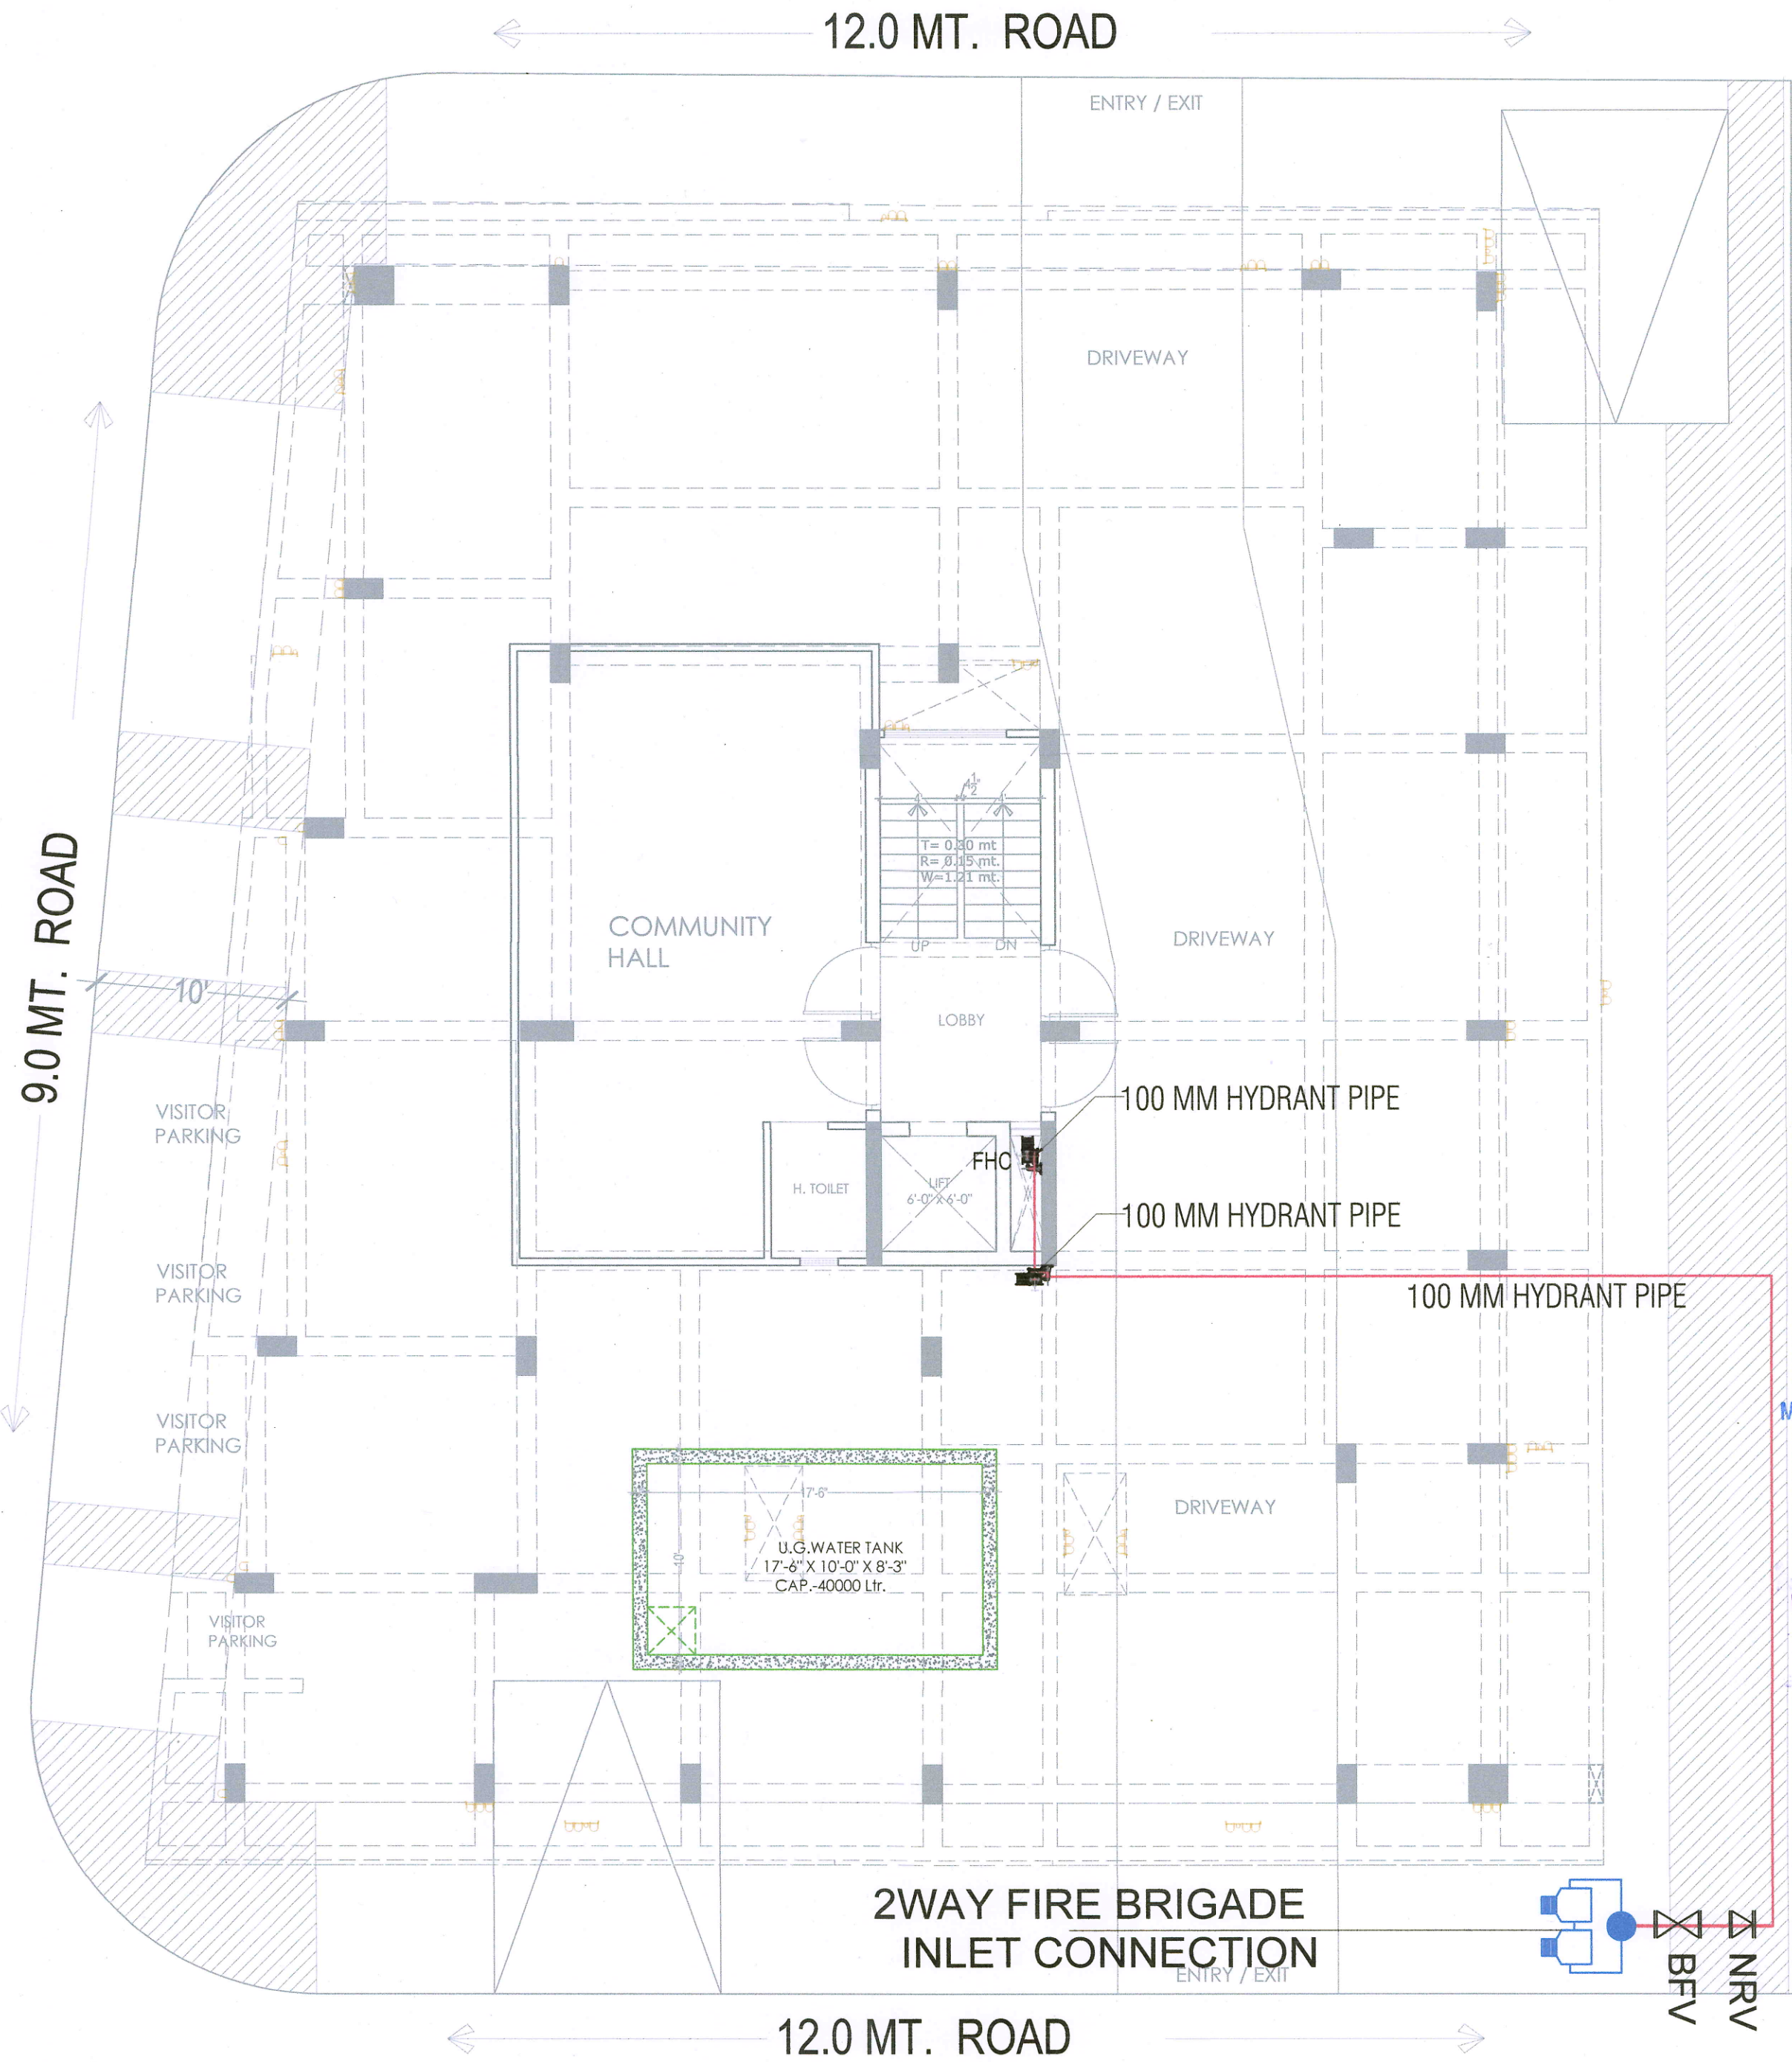

M/s SIDDHI VINAYAK HOMES
Narender
PARTNER

Shravan
Er. SANJEEV SHARMA
B.E (Electrical)

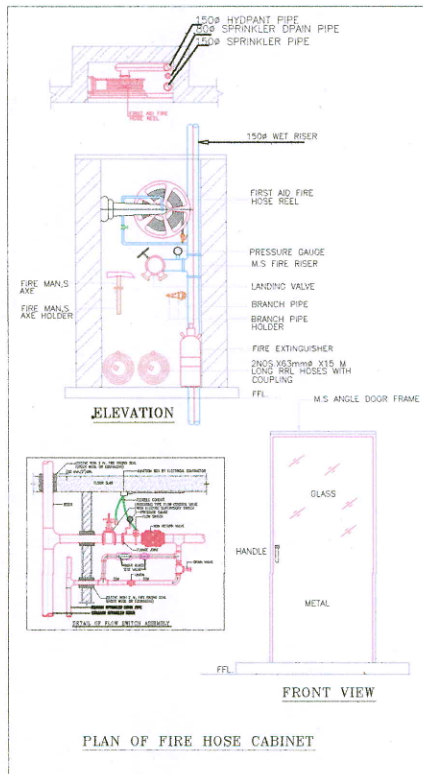

STILT FLOOR FIRE FIGHTING LAYOUT

PROJECT NAME :
CRYSTAL HEIGHTS
DEVELOPER NAME :
SIDDHI VINAYAK HOMES

- S.No. DATE REVISION DESCRIPTION
- GENERAL NOTES :
- All dimension on this drawing are in MKS System Only written dimensions are to be followed. drawing should not be scaled.
 - All measurements must be checked and verified by the contractors prior to execution of work at the site.
 - This drawing is to be read in conjunction with all relevant structural, services & facility planning drawings.
 - Architectural drawings are to be followed for the location of all structural members & masonry walls. for sizes & reinforcement details of structural members, relevant structural drawings are to be referred.
 - Any discrepancies between architectural, structural and services drawings must be brought to the notice of the architects immediately & prior to execution at site. Co-ordinate with services such as hvac, plumbing & electrical, etc. as the responsibility of the contractor.
 - All masonry walls should be aligned with the columns as indicated on the plan, irrespective of the position as calculated with the dimensioning.
 - For details, refer relevant large scale detail drgs. as indicated.

PROJECT:
PROPOSED RESIDENTIAL FLATS ON
P. NO.- 115, 116, 117, 118, 119 & 120
SCHEME- GANESH NAGAR -B,
JAIPUR


NAME OF DRAWING:
**TYPICAL PLAN (GROUND TO 5TH.)
FIRE FIGHTING LAYOUT**

DRAWING
WORKING DRAWING
PROJECT NO. :
SCALE :
NTS
NORTH:
DATE :
15, May. - 2024
REV NO. :
R-0

DRAWING NO. :
A-01



TYPICAL PLAN (GROUND TO 5TH.) FIRE FIGHTING LAYOUT

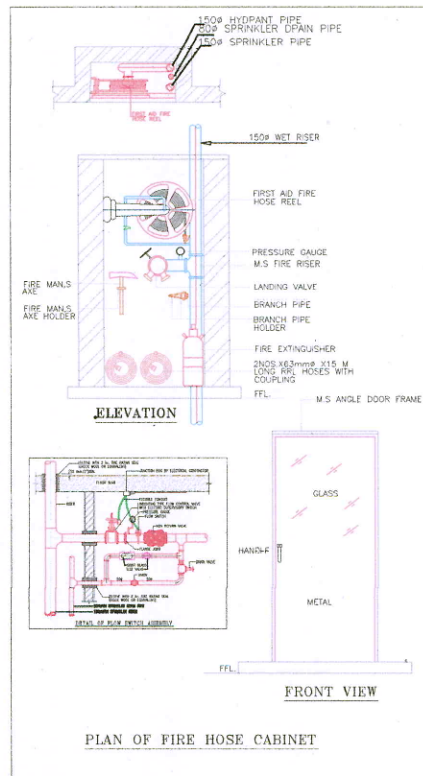

PROJECT NAME :

CRYSTAL HEIGHTS

DEVELOPER NAME :

SIDDHI VINAYAK HOMES

S.No DATE REVISION DESCRIPTION

GENERAL NOTES :

- All dimension on this drawing are in MKS System Only written dimensions are to be followed drawing should not be scaled.
- All measurements must be checked and verified by the contractors prior to execution of work at the site.
- This drawing is to be read in conjunction with all relevant structural, services & facility planning drawings.
- Architectural drawings are to be followed for the location of all structural members & masonry walls, for sizes & reinforcement details of structural members, relevant structural drawings are to be referred.
- Any discrepancies between architectural, structural and services drawings must be brought to the notice of the architects immediately & prior to execution at site.
- Co-ordination with services such as hvac, plumbing & electrical, etc. is the responsibility of the contractor.
- All masonry walls should be aligned with the columns as indicated on the plan, irrespective of the position as calculated with the dimensioning.
- For details, refer relevant large scale detail drgs. as indicated.

PROJECT:

PROPOSED RESIDENTIAL FLATS ON
P. NO.- 115, 116, 117, 118, 119 & 120
SCHEME- GANESH NAGAR -B,
JAIPUR

NAME OF DRAWING:


**TERRACE FLOOR FIRE FIGHTING
LAYOUT**

DRAWING WORKING DRAWING	NORTH: 
PROJECT NO. :	DATE : 15, May. - 2024
SCALE : NTS	REV NO. : R-0

DRAWING NO. :

PROJECT	CATEGORY	BLOCK	FLOOR	TYPE	NUMBER

A-01

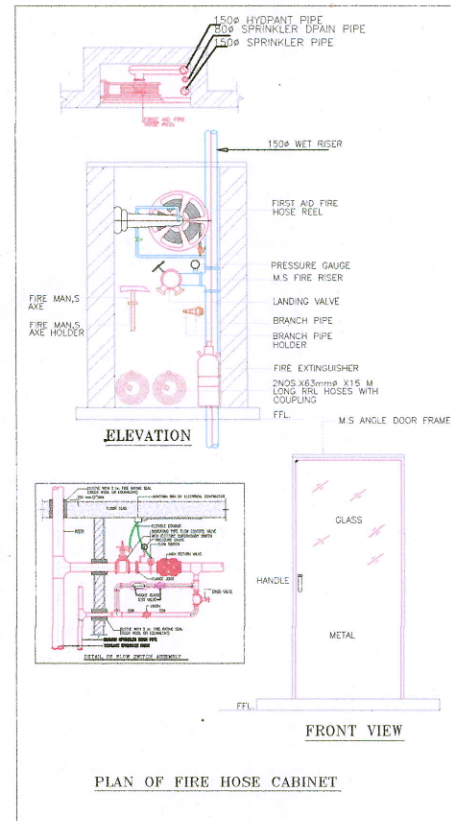

M/s SIDDHI VINAYAK HOMES
Narendra
PARTNER

Sharma
Er. SANJEEV SHARMA
B.E (Electrical)

12.0 MT. ROAD
TERRACE FLOOR FIRE FIGHTING LAYOUT