

OTHERS LAND

114'-10"

OTHERS LAND




51'

1'-9 3/4"

30'-2 1/2"

73'-4 1/2"

P.NO. 18

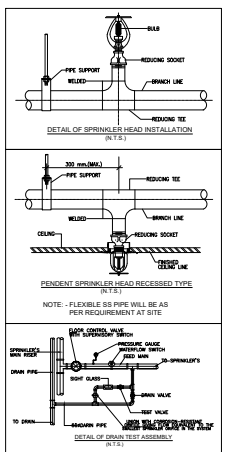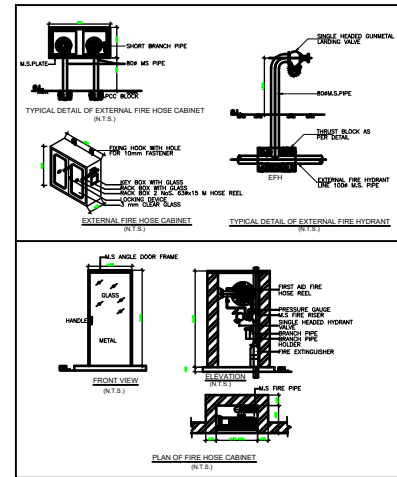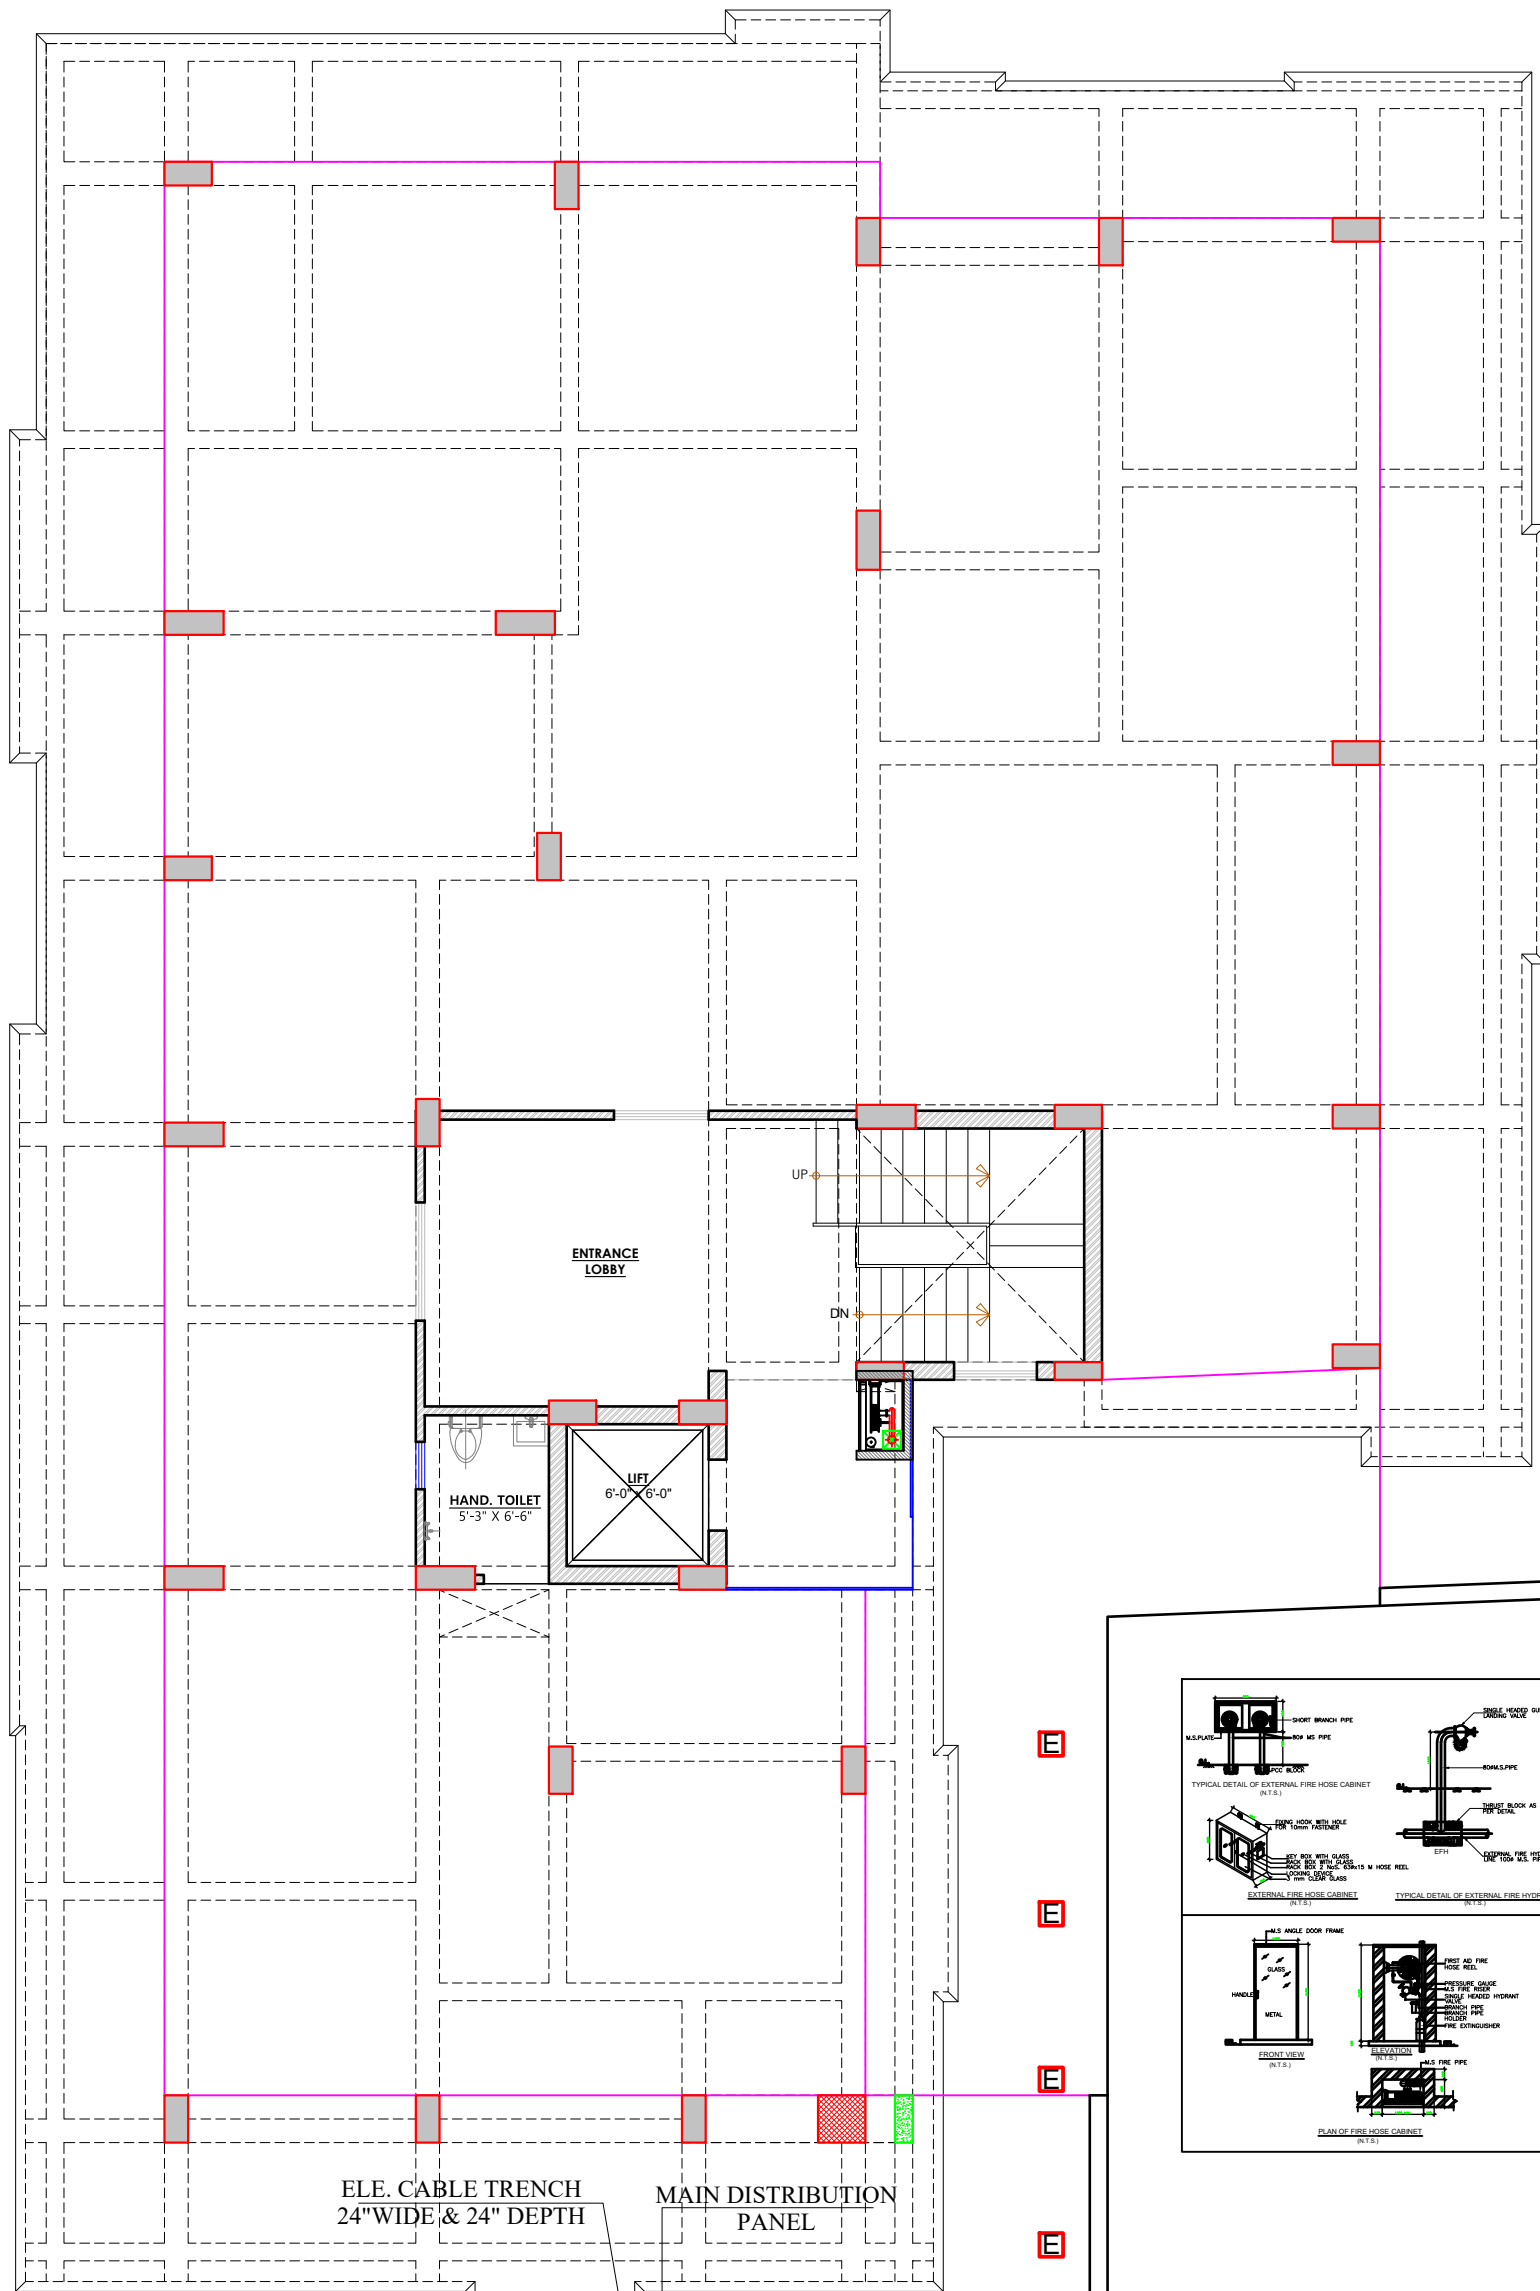

P.NO. 21


**STILT FLOOR PLAN
ELECITICAL DISTRIBUTION PLAN
(EXTERNAL LIGHTING PLAN)**

NAMAN YADAV
Naman Yadav
B.Tech (Service Consultant)

AARADHYA GOVIND DEVELOPERS
Aradhya
PARTNER

PROJECT	
AG HEIGHTS III, Plot No. 19 & 20, Shanti Nagar, Grah Nirman Sahkari Samiti, Ashok Vihar, Village-Manyawas, Jaipur (Raj.)	
ARCHITECT	
WIDEFRAME DESIGNS ARCHITECTS, ENGINEERS, INTERIOR DESIGNERS. B-22, GROUND FLOOR,GANESH MARG,BAPU NAGAR, NEAR JAIN TEMPLE, JAIPUR-302015 Ph : +91141 4820461 Mob : +91 9413042673/+91 9928894029 E-Mail : wideframedesigns@gmail.com	
EXTERNAL LIGHTING PLAN	
WORKING DRAWING	
SH.NO. DATE : 30-04-2024	
02 SCALE:	
NOTE	
THIS DRAWING IS THE SOLE PROPERTY OF WIDEFRAME DESIGNS AND IS NOT TO BE COPIED, USED OR REPRODUCED FOR ANY PURPOSE OTHER THAN FOR WHICH IT HAS BEEN LOANED.	
FILE PATH	
SPDS/2024/11	

OTHERS LAND

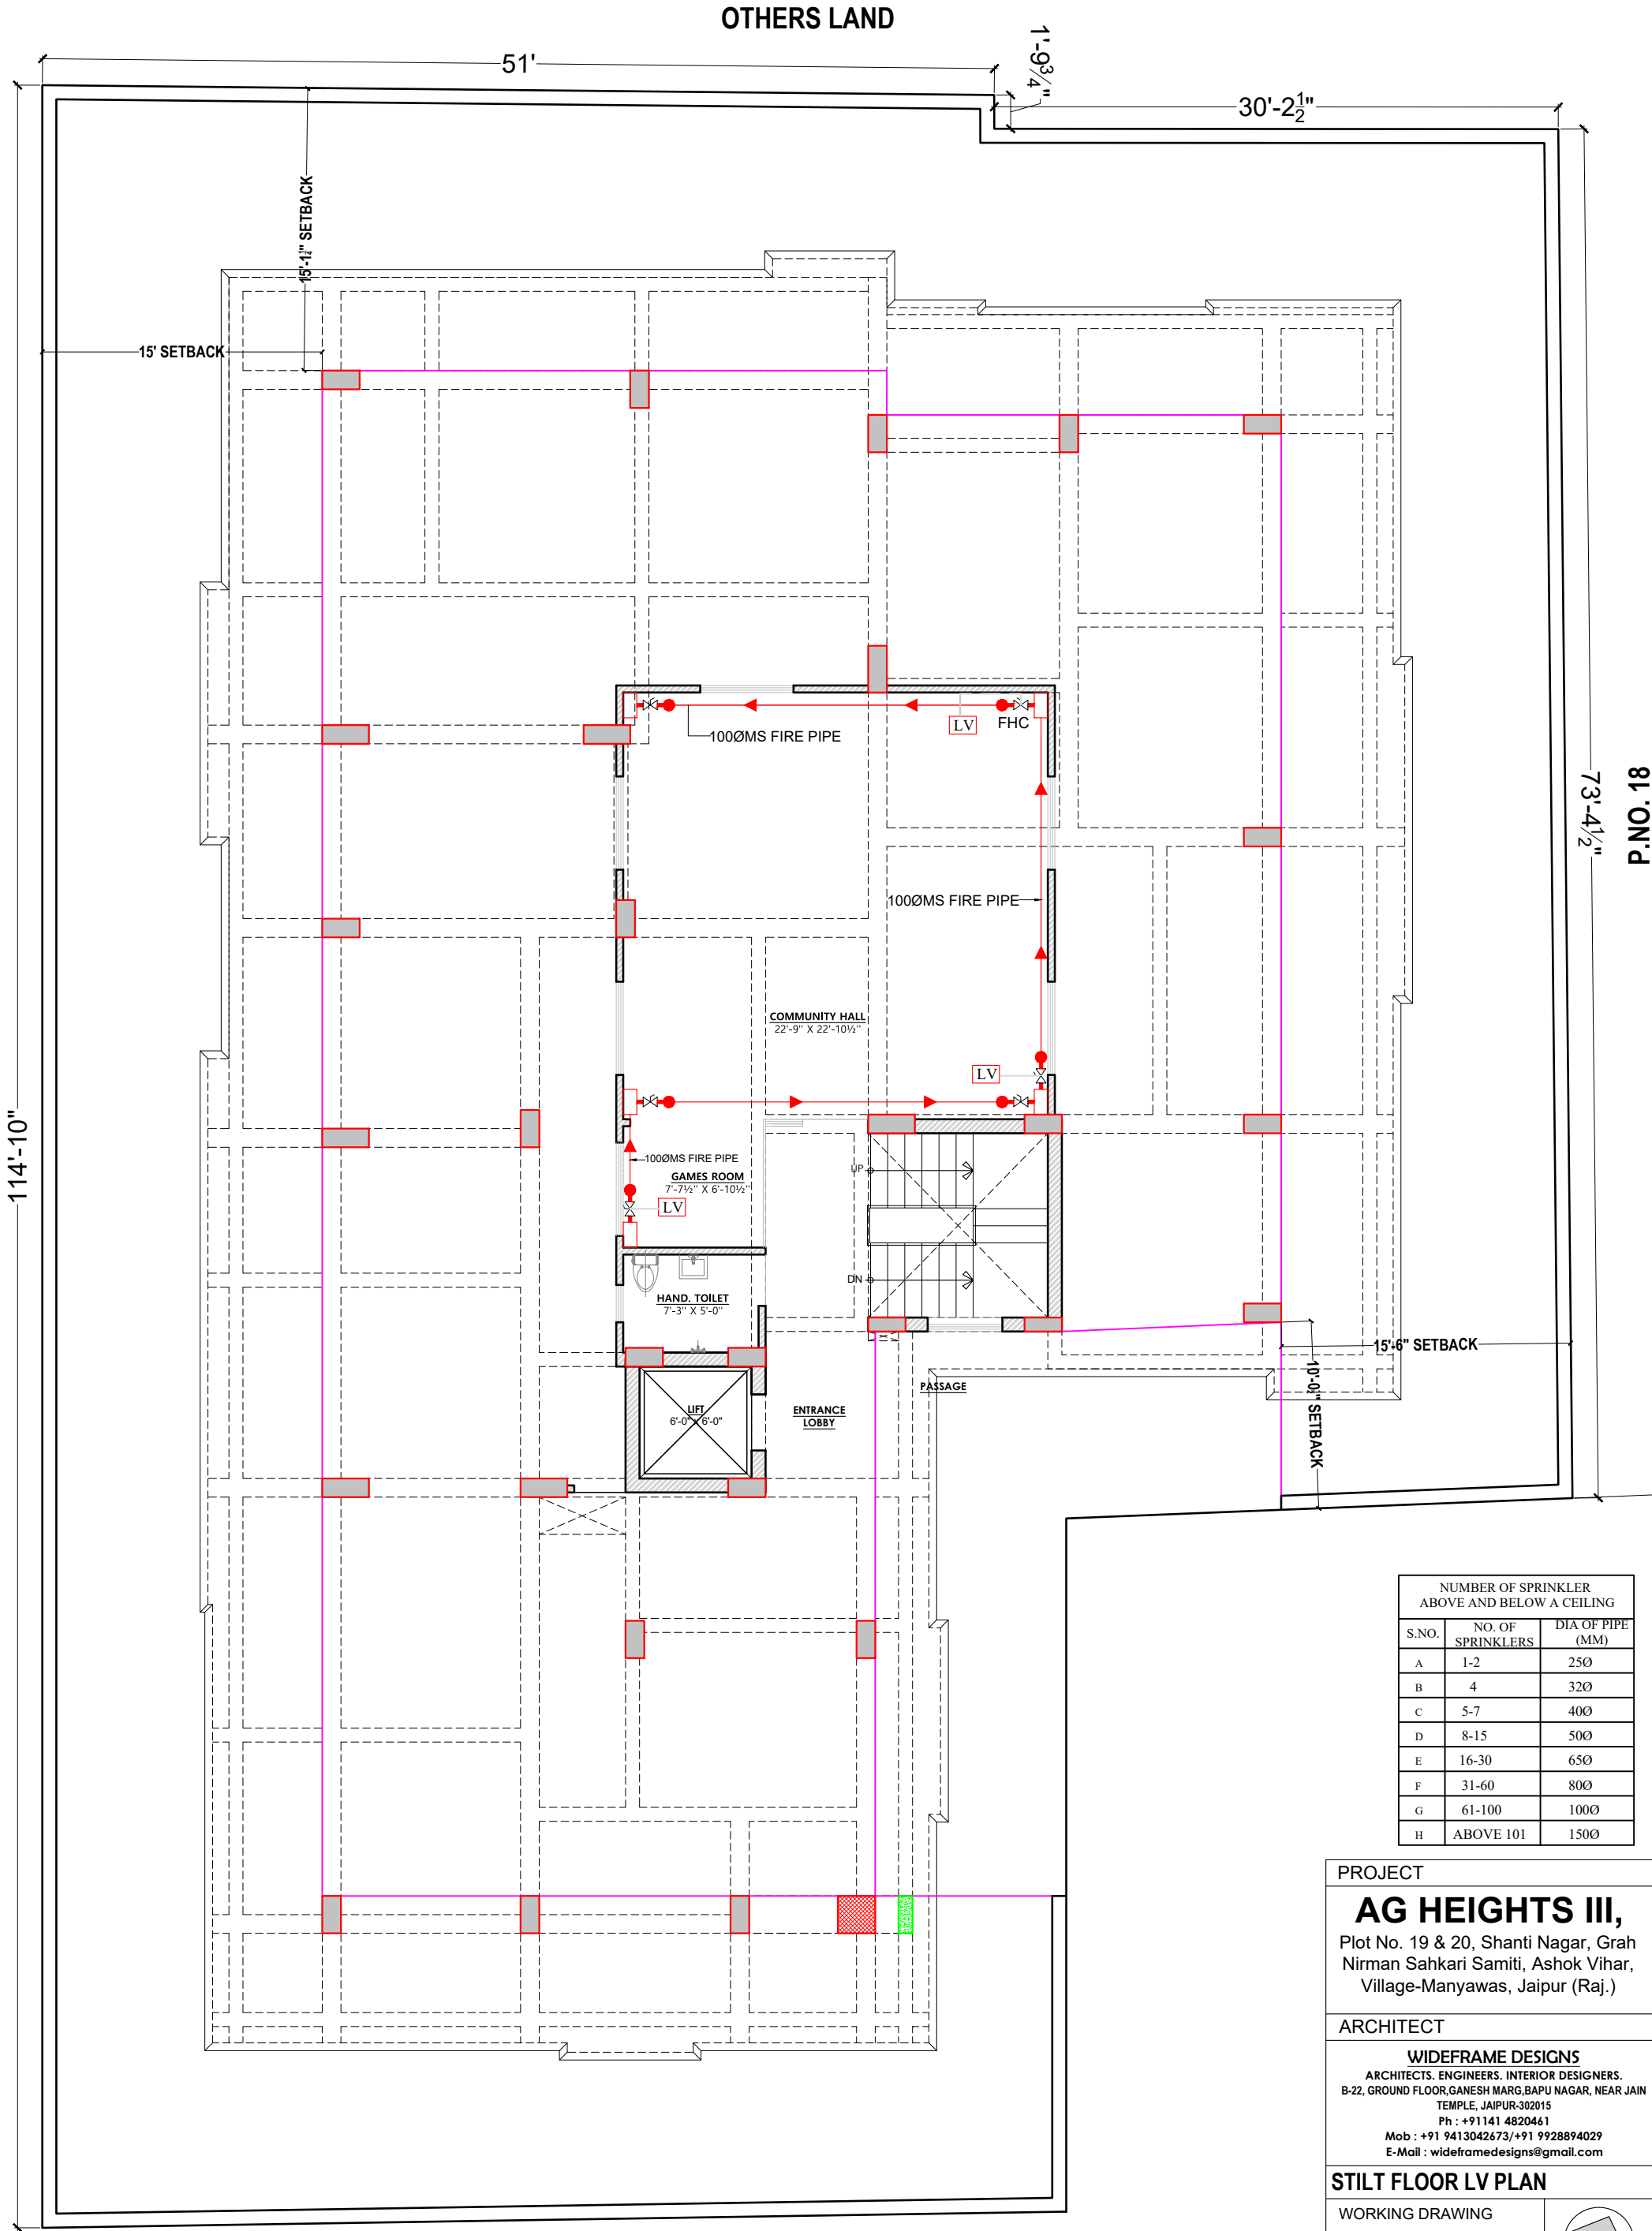

NUMBER OF SPRINKLER ABOVE AND BELOW A CEILING		
S.NO.	NO. OF SPRINKLERS	DIA OF PIPE (MM)
A	1-2	25Ø
B	4	32Ø
C	5-7	40Ø
D	8-15	50Ø
E	16-30	65Ø
F	31-60	80Ø
G	61-100	100Ø
H	ABOVE 101	150Ø

PROJECT

AG HEIGHTS III,
Plot No. 19 & 20, Shanti Nagar, Grah
Nirman Sahkari Samiti, Ashok Vihar,
Village-Manyawas, Jaipur (Raj.)

ARCHITECT

WIDEFRAME DESIGNS
ARCHITECTS. ENGINEERS. INTERIOR DESIGNERS.
B-22, GROUND FLOOR, GANESH MARG, BAPU NAGAR, NEAR JAIN
TEMPLE, JAIPUR-302015
Ph : +911141 4820461
Mob : +91 9413042673/+91 9928894029
E-Mail : wideframedesigns@gmail.com

STILT FLOOR LV PLAN

WORKING DRAWING

SH.NO. DATE : 30-4-2024
02 SCALE:

NOTE

THIS DRAWING IS THE SOLE PROPERTY OF
SURYA PRAKASH DESIGN STUDIO AND IS NOT TO
BE COPIED, USED OR REPRODUCED FOR ANY
PURPOSE OTHER THAN FOR WHICH IT HAS BEEN
LOANED.

FILE PATH


SPDS/2024/11

STILT FLOOR PLAN LV PLAN

AARADHYA GOVIND DEVELOPERS

Nurkesh
PARTNER

NAMAN YADAV
Naman Yadav
B.Tech (Service Consultant)

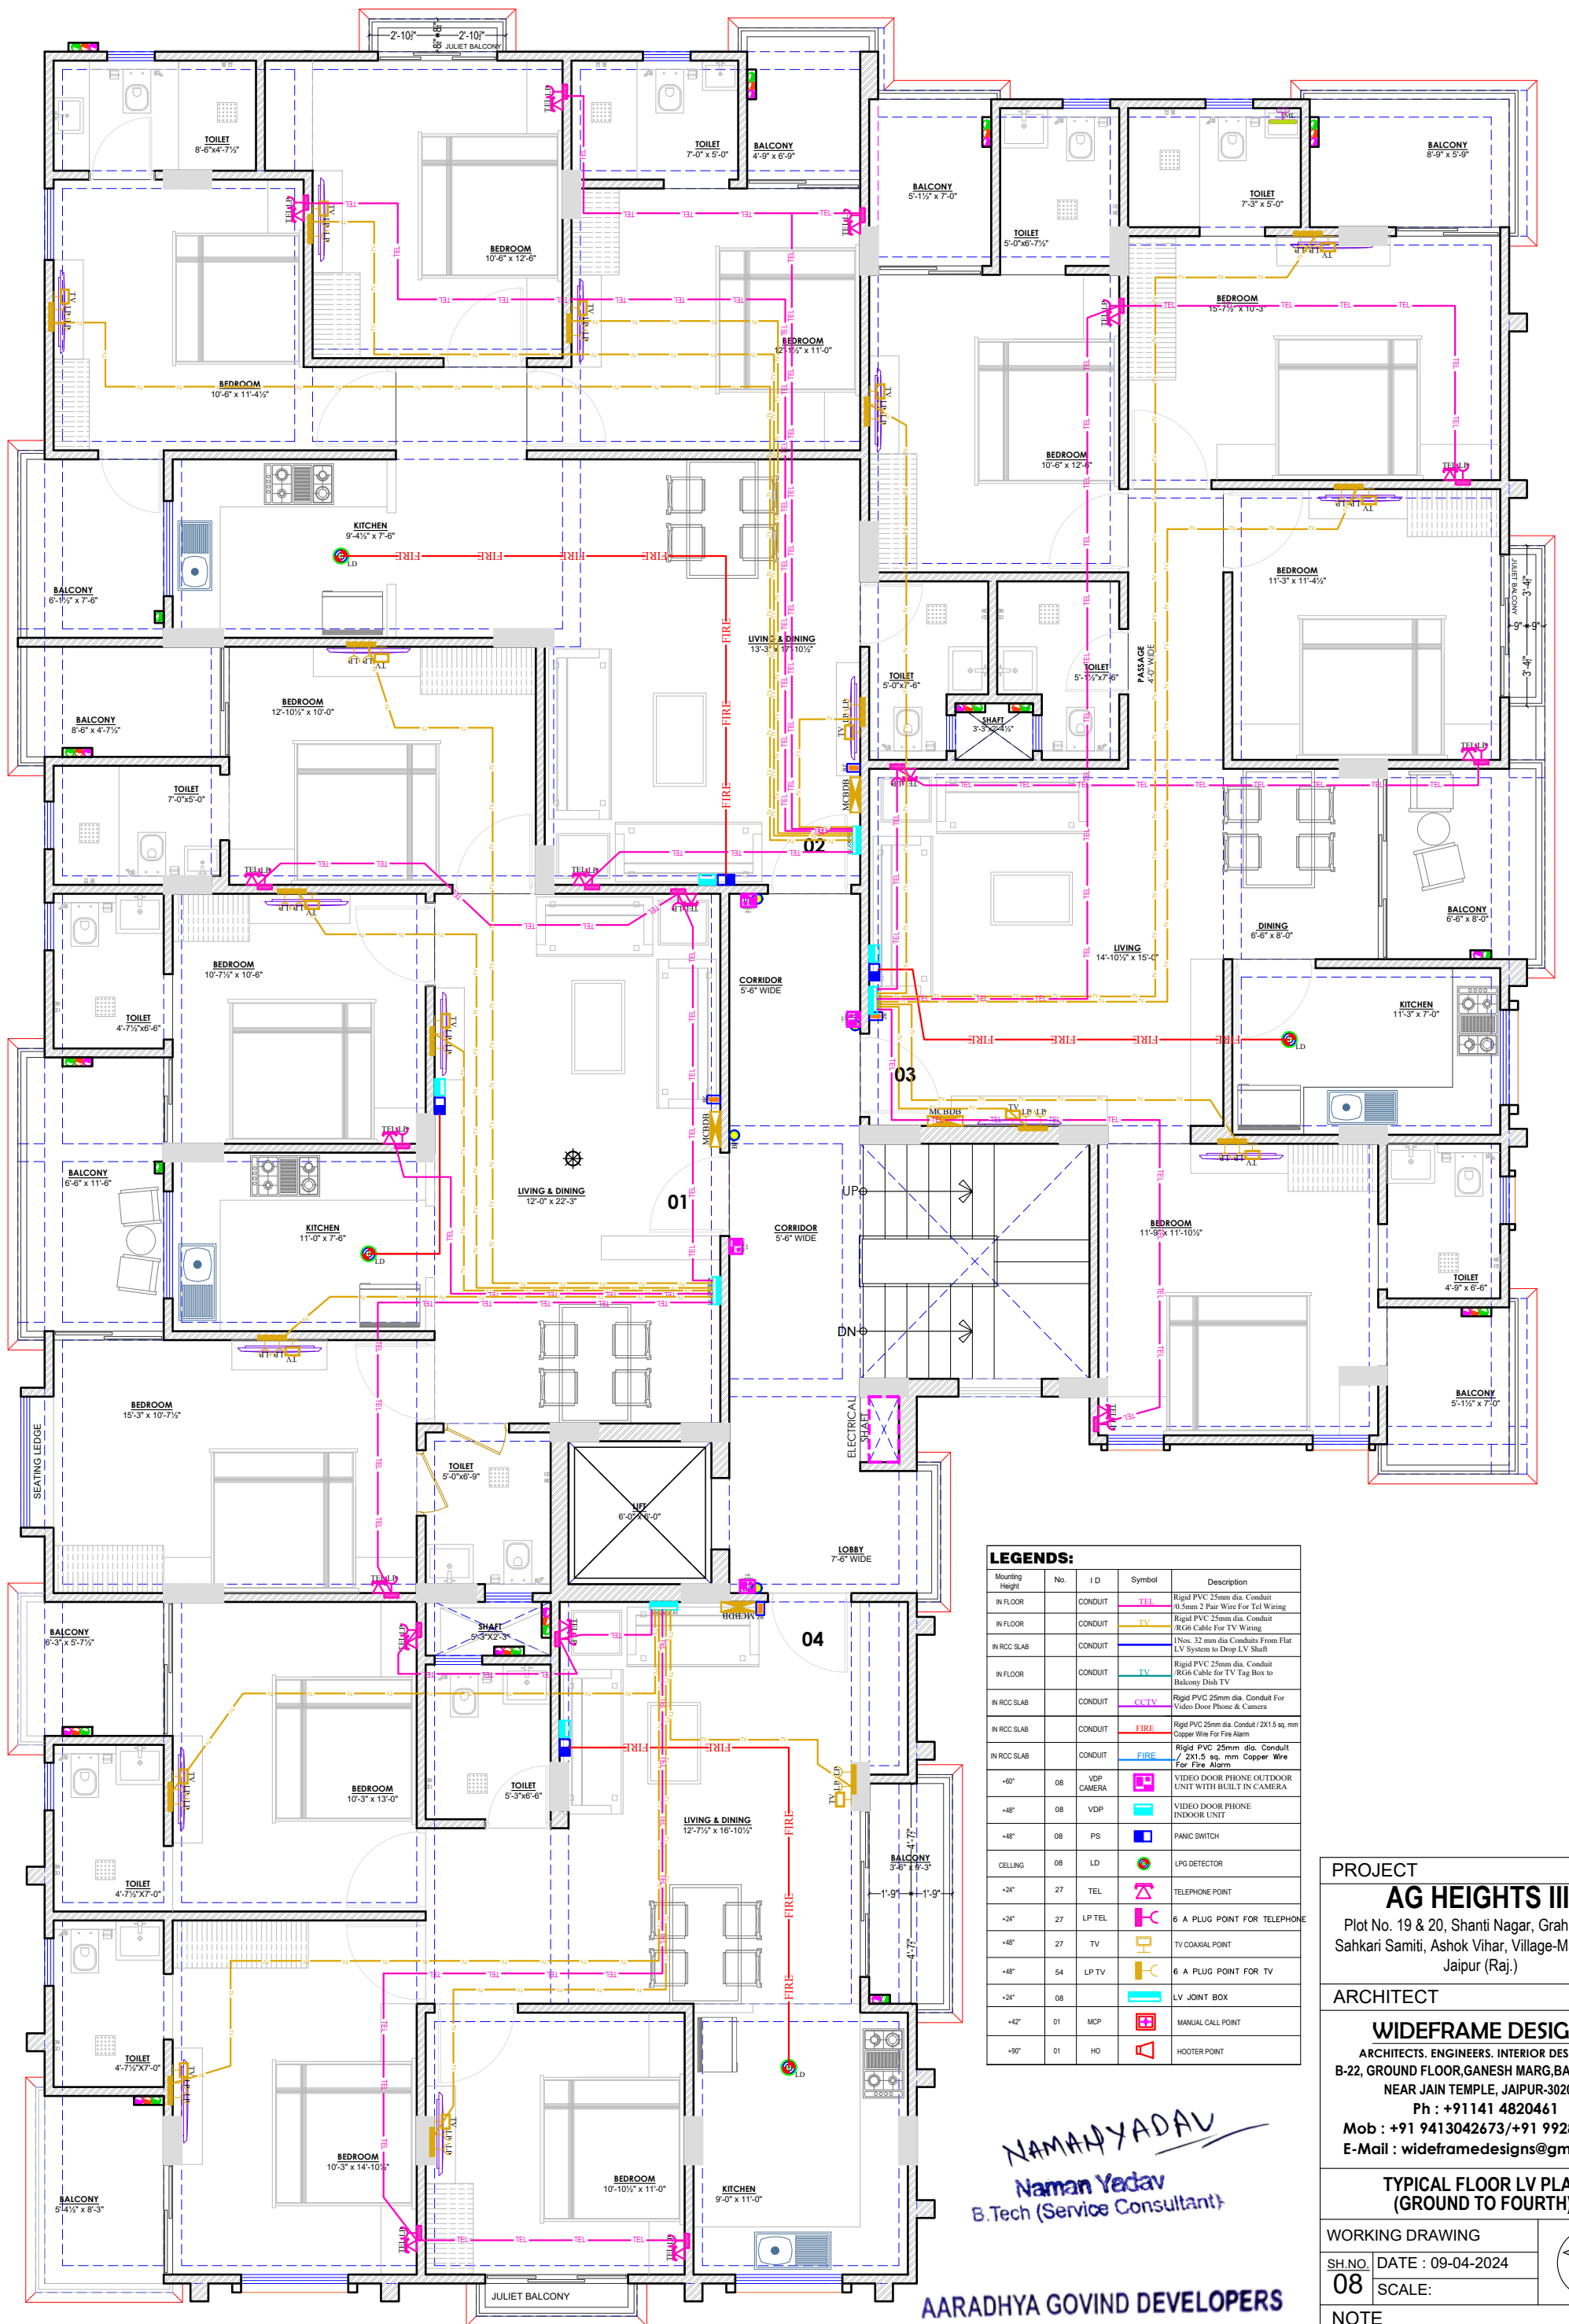

TYPICAL FLOOR LV PLAN
(GROUND TO FOURTH)

LEGENDS:				
Mounting Height	No.	I D	Symbol	Description
IN FLOOR		CONDUIT	TEL	Rigid PVC 25mm dia. Conduit / 0.5mm 2 Pair Wire For Tel Wiring
IN FLOOR		CONDUIT	TV	Rigid PVC 25mm dia. Conduit / RG6 Cable For TV Wiring
IN RCC SLAB		CONDUIT		1 Nos. 32 mm dia Conduits From Flat LV System to Drop LV Shaft
IN FLOOR		CONDUIT	LV	Rigid PVC 25mm dia. Conduit / RG6 Cable for TV Tag Box to Balcony Dish TV
IN RCC SLAB		CONDUIT	LV	Rigid PVC 25mm dia. Conduit For Video Door Phone & Camera
IN RCC SLAB		CONDUIT	FIRE	Rigid PVC 25mm dia. Conduit / 2X1.5 sq. mm Copper Wire For Fire Alarm
IN RCC SLAB		CONDUIT	FIRE	Rigid PVC 25mm dia. Conduit / 2X1.5 sq. mm Copper Wire For Fire Alarm
+6"	08	VDP		VIDEO DOOR PHONE OUTDOOR UNIT WITH BUILT IN CAMERA
+8"	08	VDP		VIDEO DOOR PHONE INDOOR UNIT
+8"	08	PS		PANIC SWITCH
CEILING	08	LD		LPG DETECTOR
+24"	27	TEL		TELEPHONE POINT
+24"	27	LP TEL		6 A PLUG POINT FOR TELEPHONE
+48"	27	TV		TV COAXIAL POINT
+48"	54	LP TV		6 A PLUG POINT FOR TV
+24"	08			LV JOINT BOX
+42"	01	MCP		MANUAL CALL POINT
+50"	01	HO		HOOTER POINT

NAMAN YADAV
Naman Yadav
B.Tech (Service Consultant)

AARADHYA GOVIND DEVELOPERS

Partner

PROJECT

AG HEIGHTS III,
Plot No. 19 & 20, Shanti Nagar, Grah Nirman
Sahkari Samiti, Ashok Vihar, Village-Manyawas,
Jaipur (Raj.)

ARCHITECT

WIDEFRAME DESIGNS
ARCHITECTS. ENGINEERS. INTERIOR DESIGNERS.
B-22, GROUND FLOOR, GANESH MARG, BAPU NAGAR,
NEAR JAIN TEMPLE, JAIPUR-302015
Ph : +91141 4820461
Mob : +91 9413042673/+91 9928894029
E-Mail : wideframedesigns@gmail.com

TYPICAL FLOOR LV PLAN
(GROUND TO FOURTH)

WORKING DRAWING


SH.NO. 08
DATE : 09-04-2024
SCALE:

NOTE

THIS DRAWING IS THE SOLE PROPERTY OF WIDEFRAME DESIGNS AND IS NOT TO BE COPIED, USED OR REPRODUCED FOR ANY PURPOSE OTHER THAN FOR WHICH IT HAS BEEN LOANED.

FILE PATH

SPDS/2024/11

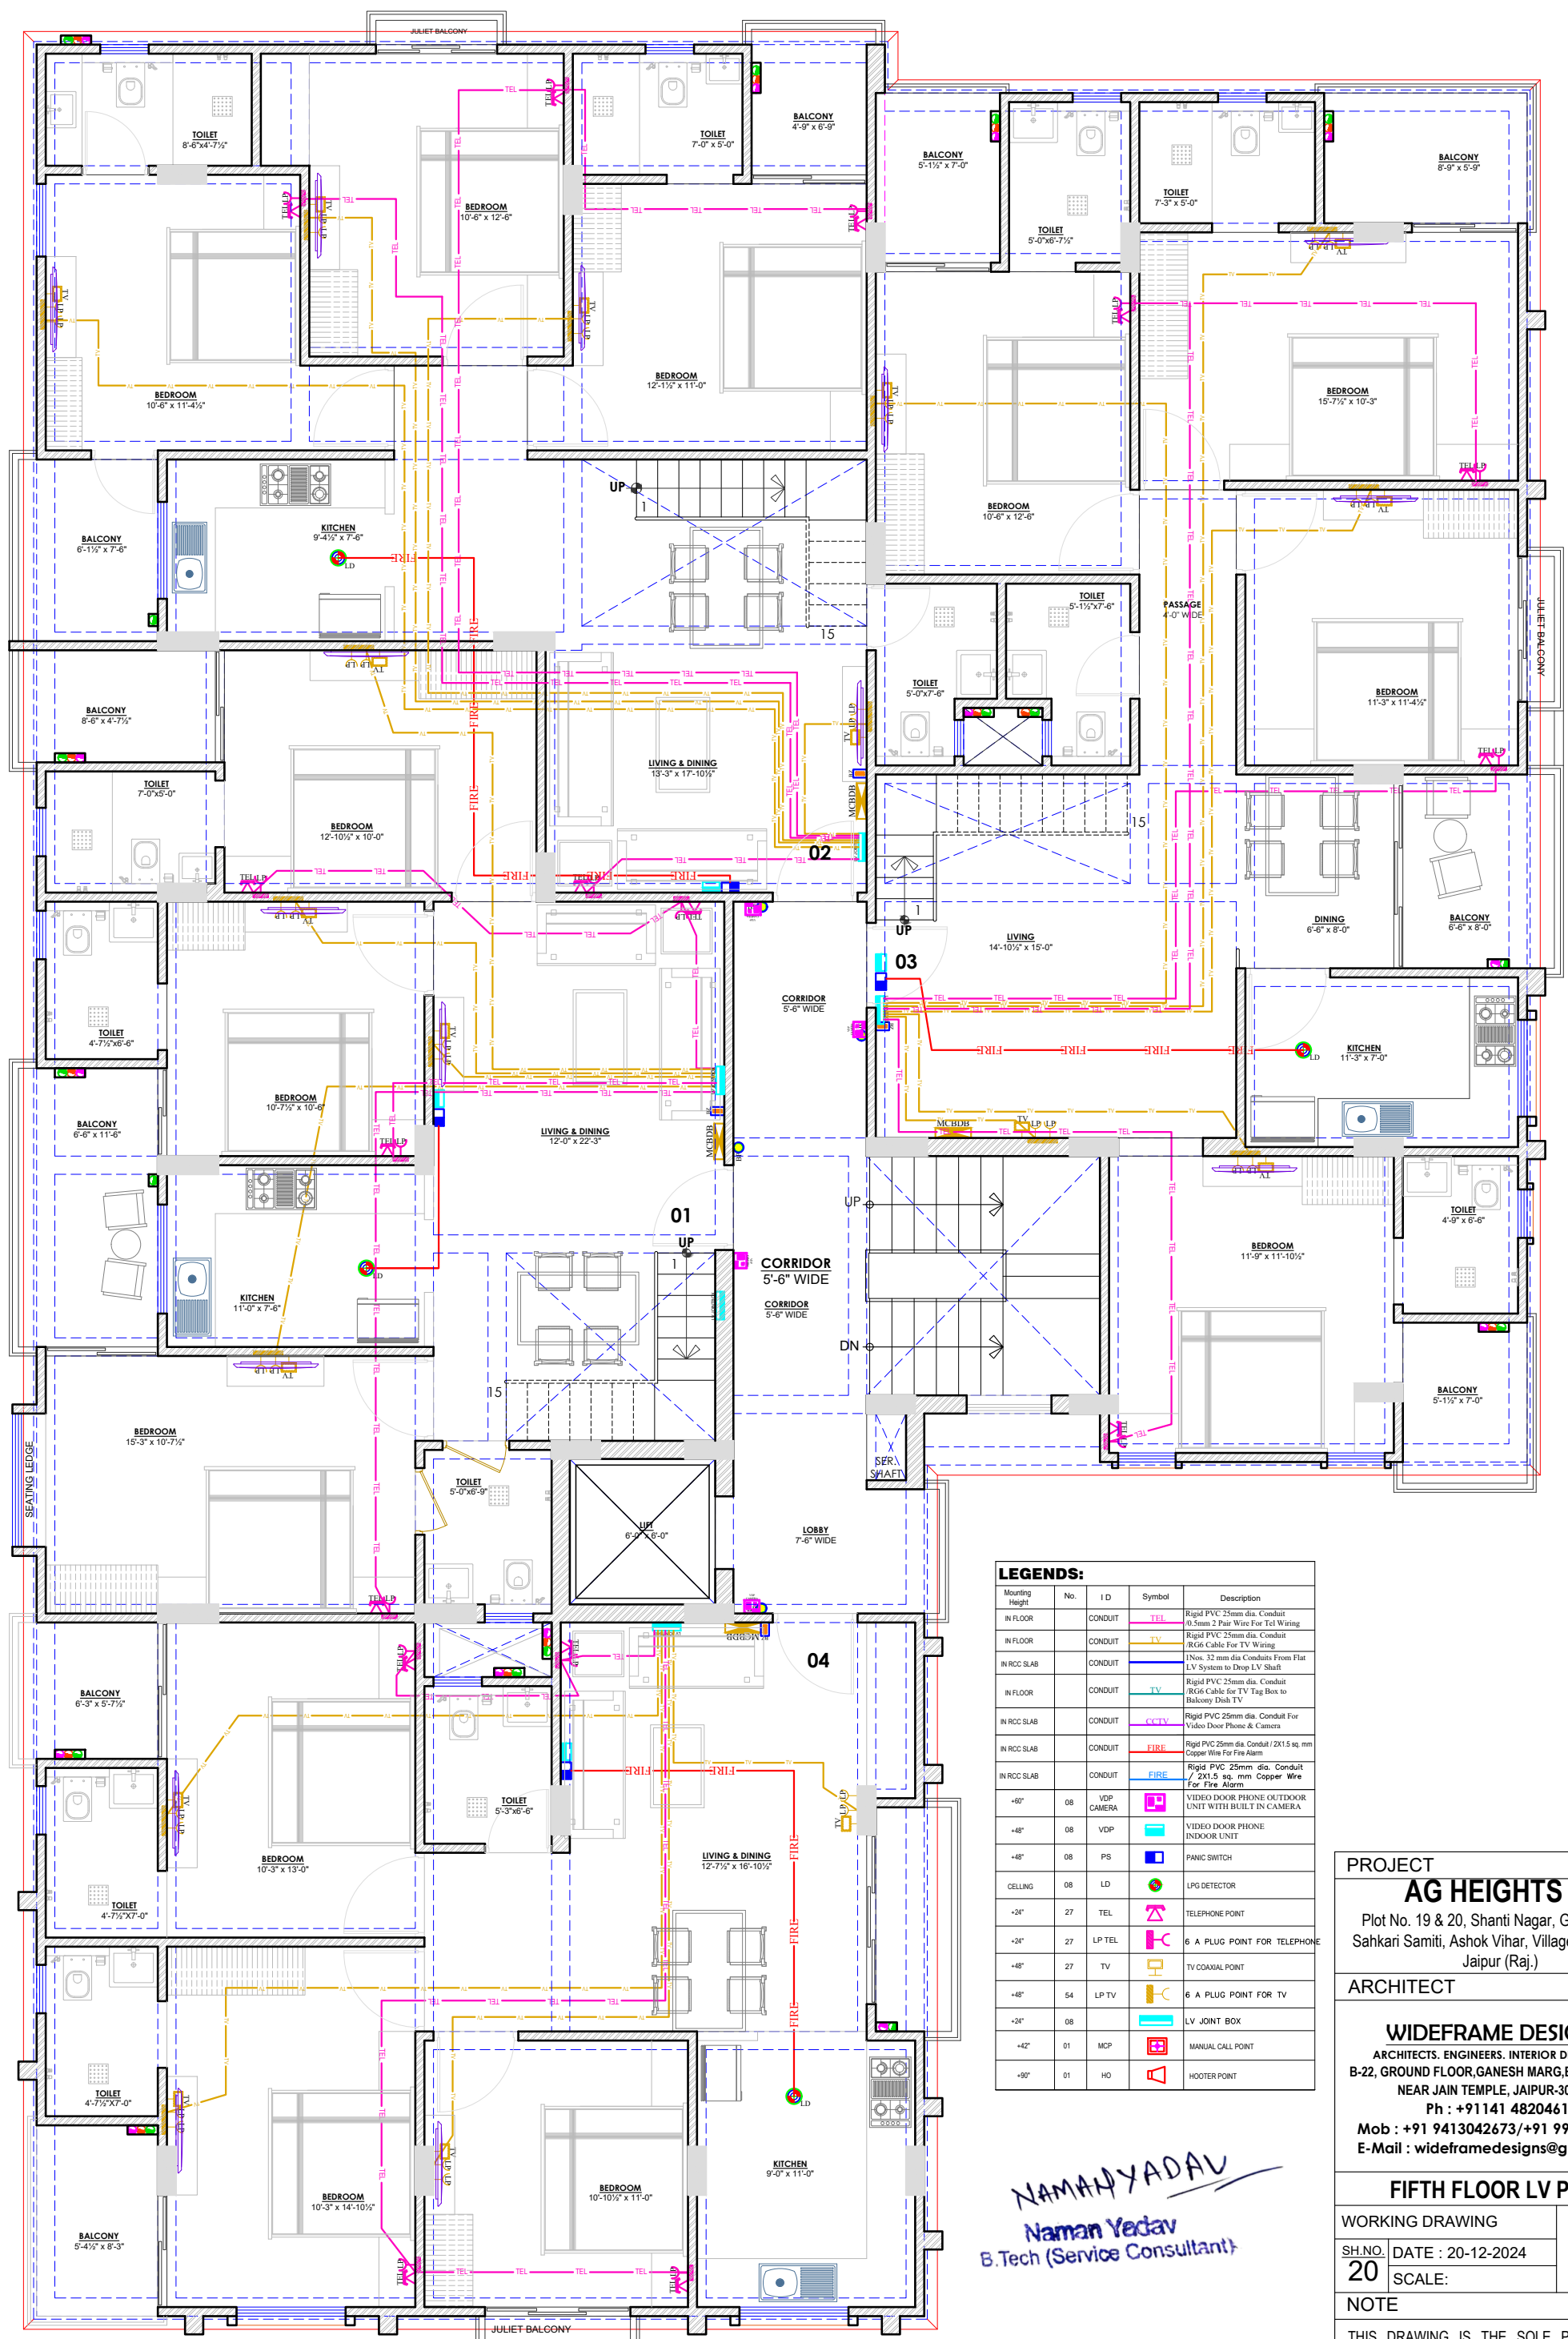

LEGENDS:				
Mounting Height	No.	ID	Symbol	Description
IN FLOOR	CONDUIT		TEL	Rigid PVC 25mm dia. Conduit / 0.5mm 2 Pair Wire For Tel Wiring
IN FLOOR	CONDUIT		TV	Rigid PVC 25mm dia. Conduit / RG6 Cable For TV Wiring
IN RCC SLAB	CONDUIT			1 Nos. 32 mm dia Conduits From Flat LV System to Drop LV Shaft
IN FLOOR	CONDUIT		TV	Rigid PVC 25mm dia. Conduit / RG6 Cable for TV Tag Box to Balcony Dish TV
IN RCC SLAB	CONDUIT		CCTV	Rigid PVC 25mm dia. Conduit For Video Door Phone & Camera
IN RCC SLAB	CONDUIT		FIRE	Rigid PVC 25mm dia. Conduit / 2X1.5 sq. mm Copper Wire For Fire Alarm
IN RCC SLAB	CONDUIT		FIRE	Rigid PVC 25mm dia. Conduit / 2X1.5 sq. mm Copper Wire For Fire Alarm
+6"	08	VDP	VDP CAMERA	VIDEO DOOR PHONE OUTDOOR UNIT WITH BUILT IN CAMERA
+4"	08	VDP	VDP	VIDEO DOOR PHONE INDOOR UNIT
+4"	08	PS	PS	PANIC SWITCH
CELLING	08	LD	LD	LPS DETECTOR
+24"	27	TEL	TEL	TELEPHONE POINT
+24"	27	LP TEL	LP TEL	6 A PLUG POINT FOR TELEPHONE
+48"	27	TV	TV	TV COAXIAL POINT
+48"	54	LP TV	LP TV	6 A PLUG POINT FOR TV
+24"	08			LV JOINT BOX
+42"	01	MCP	MCP	MANUAL CALL POINT
+90"	01	HO	HO	HOOTER POINT

NAMAN YADAV
Naman Yadav
B.Tech (Service Consultant)

AARADHYA GOVIND DEVELOPERS

Partner

FIFTH FLOOR LV PLAN

PROJECT

AG HEIGHTS III,
Plot No. 19 & 20, Shanti Nagar, Grah Nirman
Sahkari Samiti, Ashok Vihar, Village-Manyawas,
Jaipur (Raj.)

ARCHITECT

WIDEFRADE DESIGNS
ARCHITECTS, ENGINEERS, INTERIOR DESIGNERS.
B-22, GROUND FLOOR, GANESH MARG, BAPU NAGAR,
NEAR JAIN TEMPLE, JAIPUR-302015
Ph : +91141 4820461
Mob : +91 9413042673/+91 9928894029
E-Mail : wideframedesigns@gmail.com

FIFTH FLOOR LV PLAN

WORKING DRAWING


SH.NO. 20
DATE : 20-12-2024
SCALE:

NOTE

THIS DRAWING IS THE SOLE PROPERTY OF WIDEFRADE DESIGNS AND IS NOT TO BE COPIED, USED OR REPRODUCED FOR ANY PURPOSE OTHER THAN FOR WHICH IT HAS BEEN LOANED.

FILE PATH

SPDS/2024/11

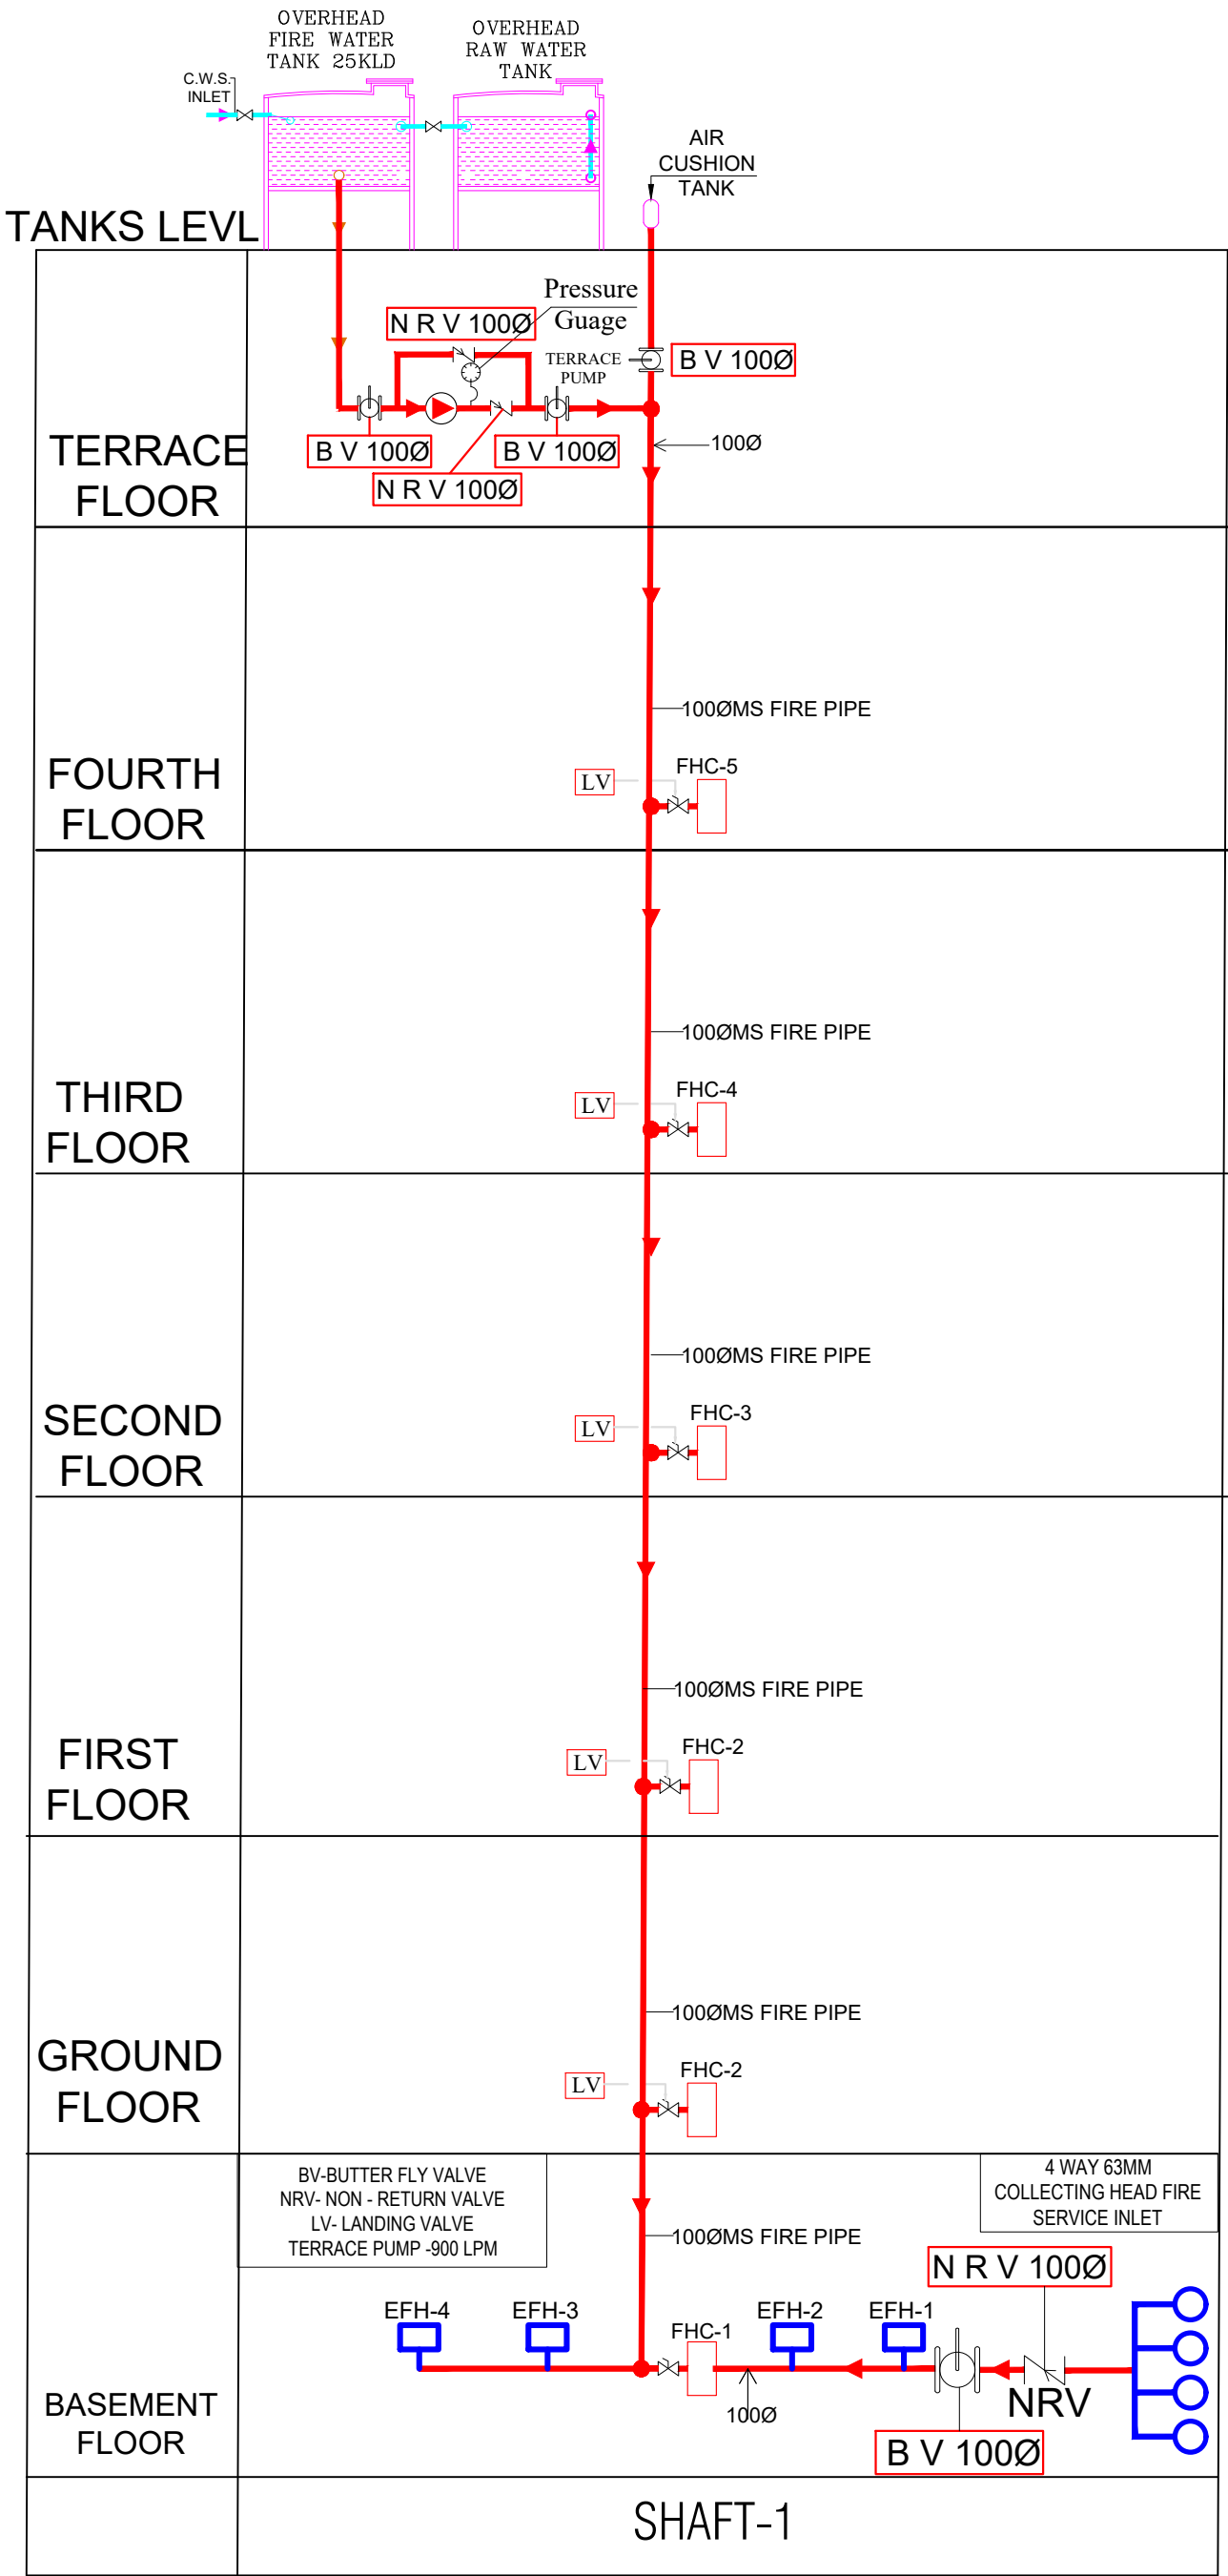




NAMAN YADAV
Naman Yadav
B.Tech (Service Consultant)

AARADHYA GOVIND DEVELOPERS
PARTNER

PROJECT

AG HEIGHTS III,

 Plot No. 19 & 20, Shanti Nagar, Grah Nirman
Sahkari Samiti, Ashok Vihar, Village-Manyawas,
Jaipur (Raj.)

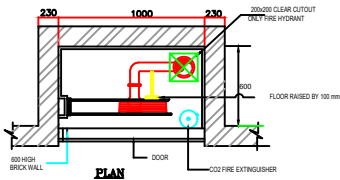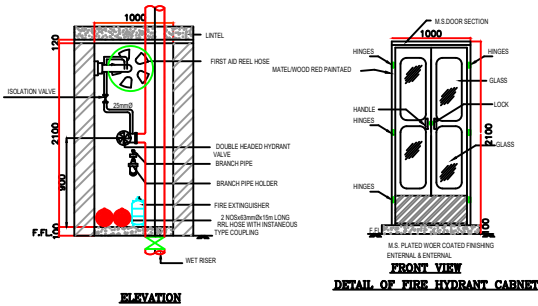

DRAWING:

TYPICAL DETAIL FOR FIRE HOSE CABINET
SCALE=NTS

S.no.	Symbol	Description	Qty.	Size in mm
1.		Butter fly Valve	08	100Ø
2.		Non Return Valve	05	100Ø
3.		Landing Valve Single headed	24	63Ø
4.		Pressure Guage	02	
5.		FHC	24	
6.		External Fire Hose Cabinet	06	



DRAWING TITLE

FIRE SCHEMATIC LAYOUT PLAN

ARCHITECT

WIDEFRADE DESIGNS
ARCHITECTS. ENGINEERS. INTERIOR DESIGNERS.
B-22, GROUND FLOOR, GANESH MARG, BAPU NAGAR,
NEAR JAIN TEMPLE, JAIPUR-302015
Ph : +91141 4820461
Mob : +91 9413042673/+91 9928894029
E-Mail : wideframedesigns@gmail.com

PROJECT TITLE

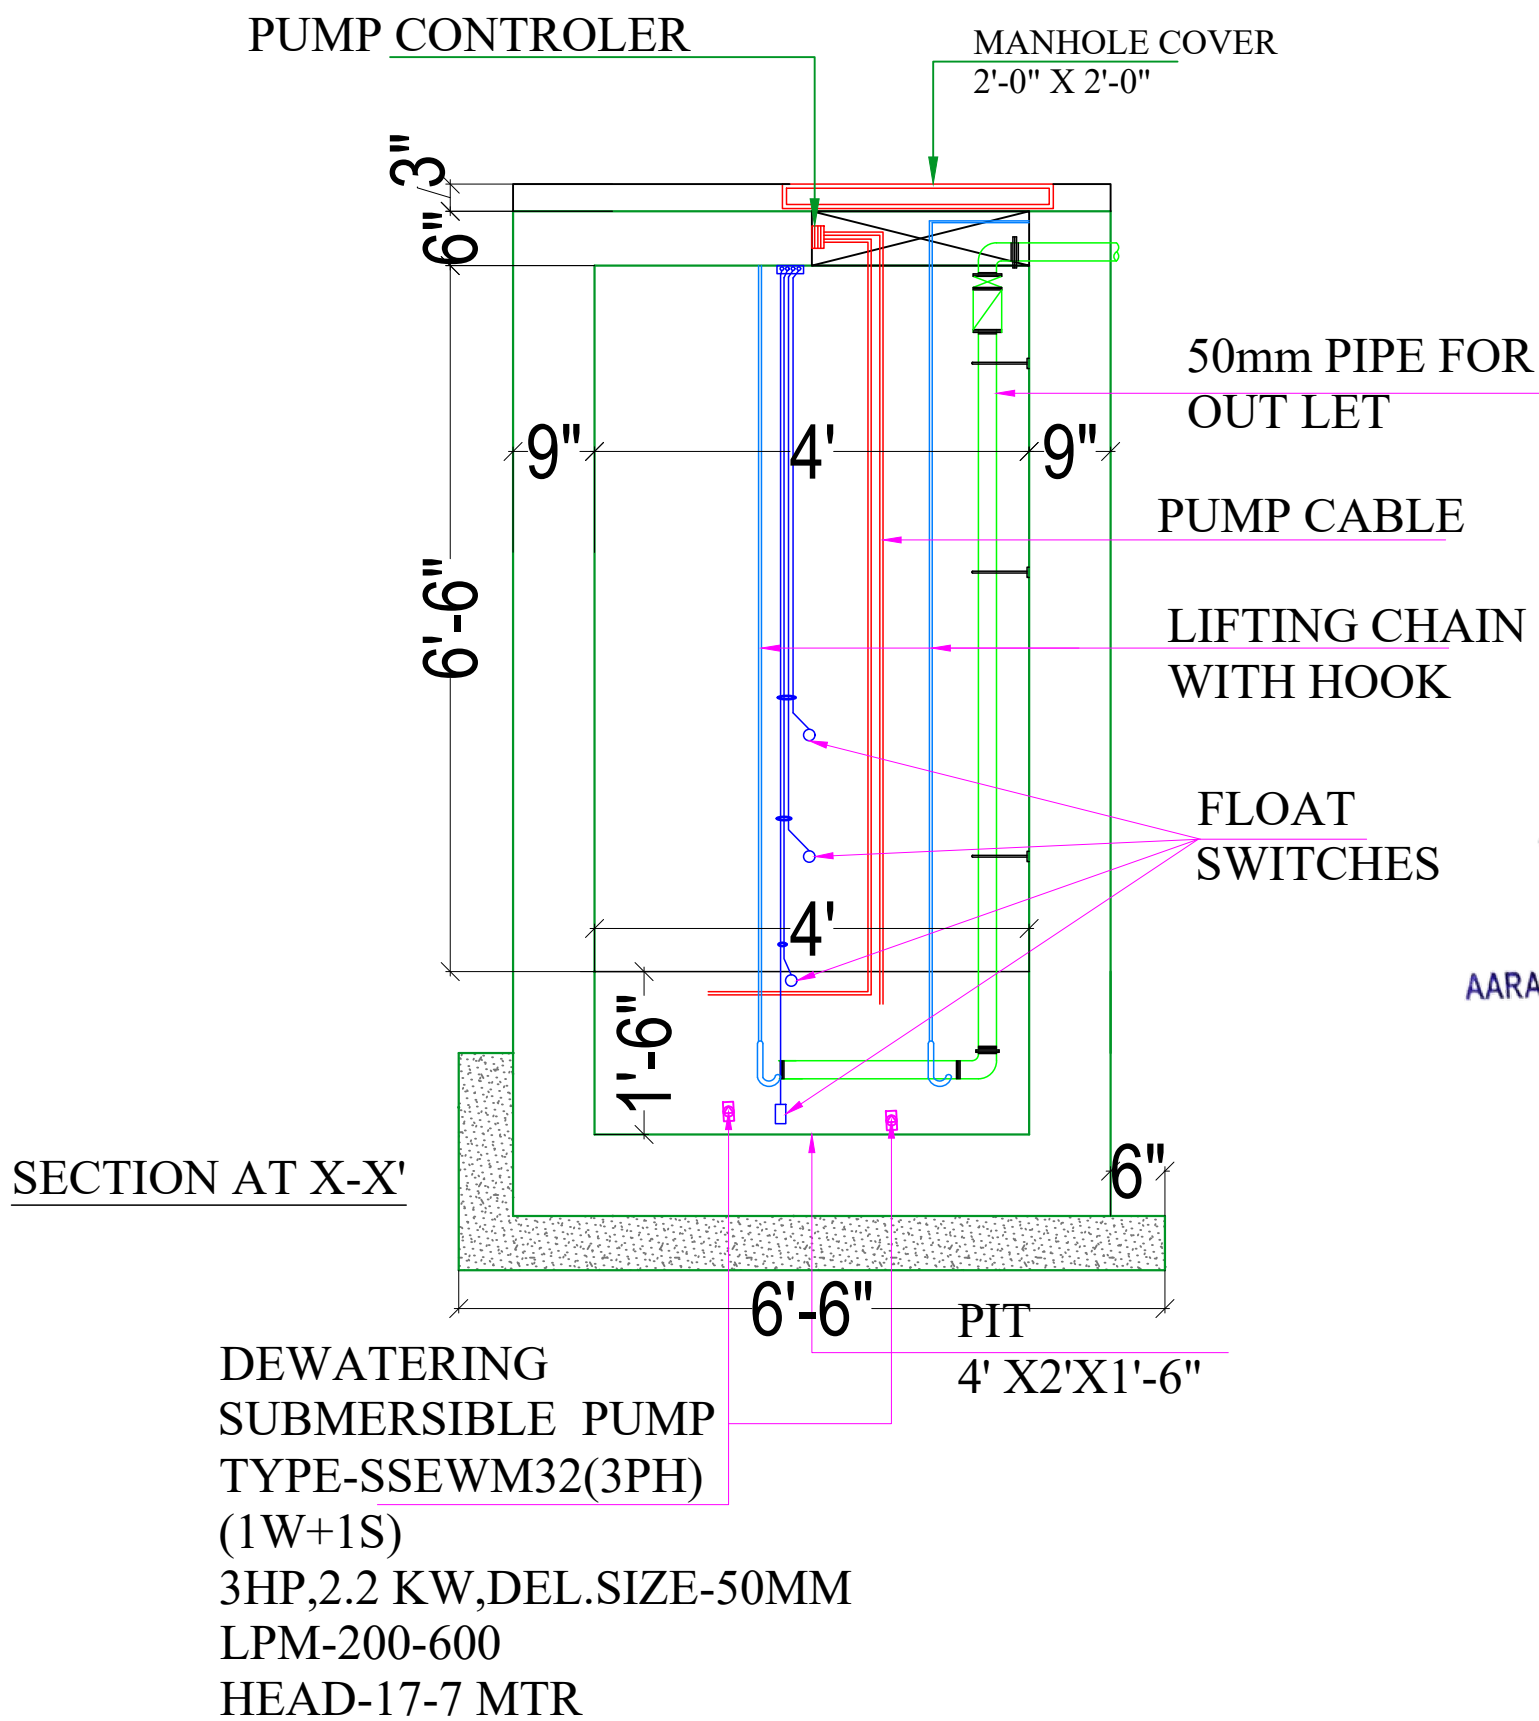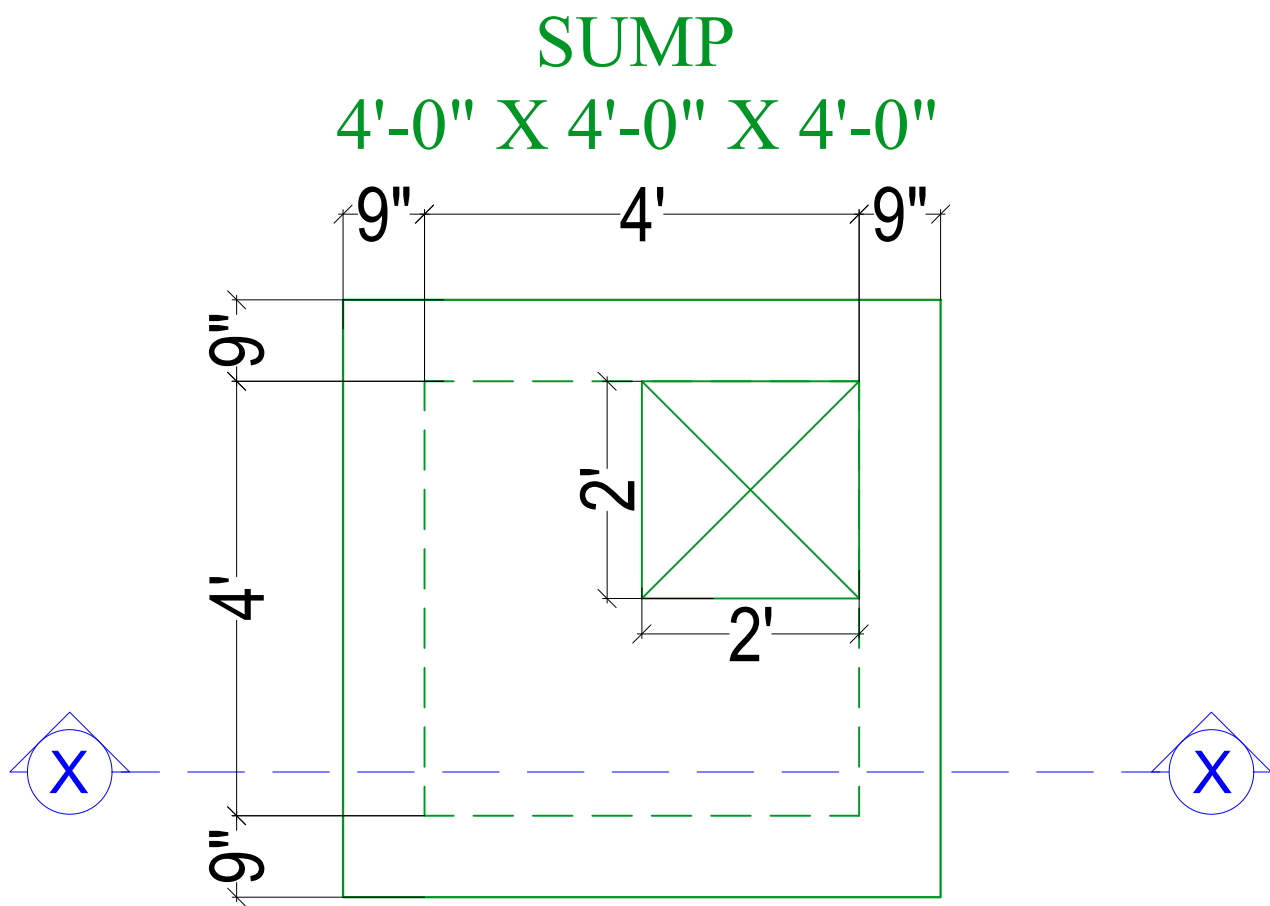

NAMAN YADAV
Naman Yadav
B.Tech (Service Consultant)

AARADHYA GOVIND DEVELOPERS
Ankush
PARTNER

PROJECT	
AG HEIGHTS III, Plot No. 19 & 20, Shanti Nagar, Grah Nirman Sahkari Samiti, Ashok Vihar, Village-Manyawas, Jaipur (Raj.)	
ARCHITECT	
WIDEFRAME DESIGNS ARCHITECTS. ENGINEERS. INTERIOR DESIGNERS. B-22, GROUND FLOOR, GANESH MARG, BAPU NAGAR, NEAR JAIN TEMPLE, JAIPUR-302015 Ph : +91141 4820461 Mob : +91 9413042673/+91 9928894029 E-Mail : wideframedesigns@gmail.com	
TYPICAL SUMP PIT DETAIL	
WORKING DRAWING	
SH.NO. 02	DATE : 30-04-2024 SCALE:
NOTE	
THIS DRAWING IS THE SOLE PROPERTY OF WIDEFRAME DESIGNS AND IS NOT TO BE COPIED, USED OR REPRODUCED FOR ANY PURPOSE OTHER THAN FOR WHICH IT HAS BEEN LOANED.	
FILE PATH	
SPDS/2024/11	

TYPICAL SUMP PIT DETAIL

