


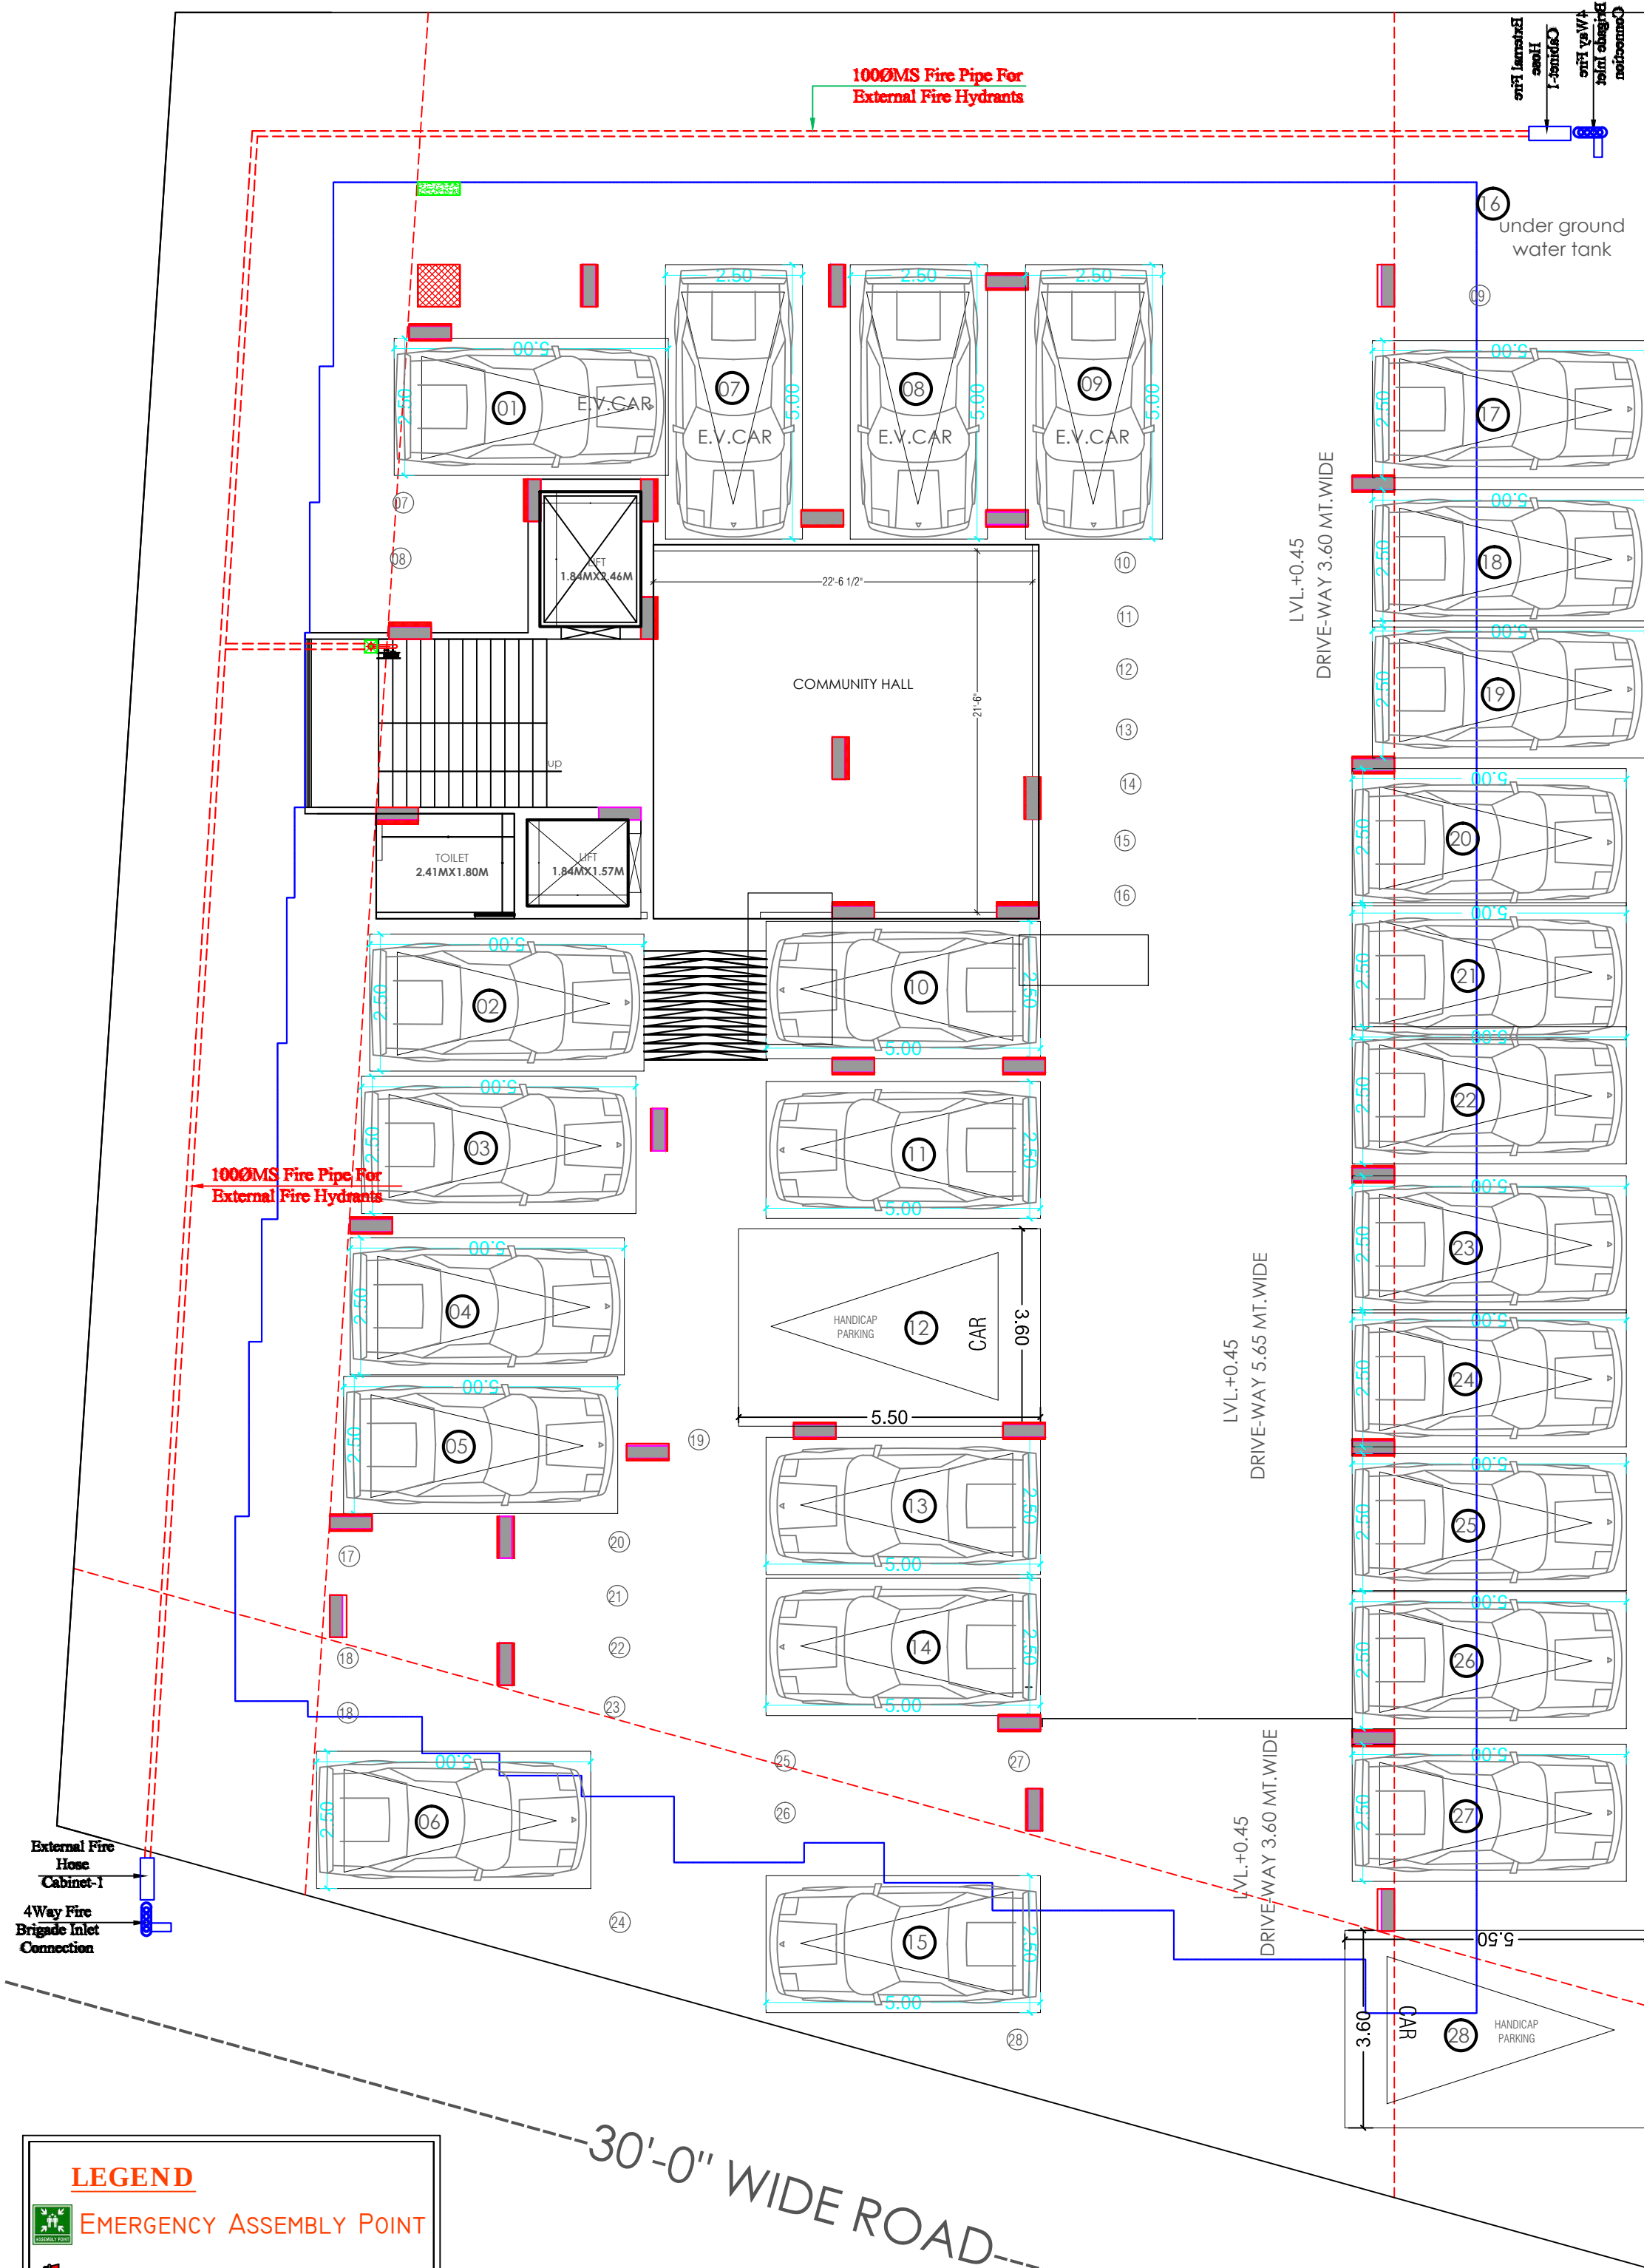

LEGEND

EMERGENCY ASSEMBLY POINT

FIRE POINT

FIRE

EMI

HOSE REEL

OL ROOM

Krishna
KRISHNA KUMAR
B. Tech. (Mechanical)
M.E.P Consultant

For R K DEVELOPERS
Partner

40'-0" WIDE ROAD

30'-0" WIDE ROAD

WARNING

1. This drawing is the sole copyright of Architects VISTAAR and should be used for the purpose expressly issued.

GENERAL NOTES

- All dimensions are in feet and inches.
- Do not scale this drawing follow written dimensions only.
- This drawing should be read in conjunction with other architectural and structural drawings.
- Any discrepancy in the drawing should be immediately brought to the notice of architect.

PROJECT TITLE

SHREEJI RESIDENDY
BUILDING AT PLOT-1, 1A & 1B,
SCHEME GREEN
VILLAS, VILL. NANKISHOREPURA
URF. MANYAWAS, JAIPUR

DRAWING TITLE

STILT(PARKING) FLOOR PLAN

ARCHITECTS

VISTAAR ARCHITECTS &
PLANNERS

Architects :: Interior Designers
B-2/12, Chitrkoot scheme,
main Gandhi Path Opp mall of jaipur, Jaipur
PH. - 0141-4116461, 09001010366

NO.	DATE	BY	REVISION
1	17-01-2024		
SCALE	AS SHOWN		
1:1			



88'

108'-6"

134'-102"

95'

LEGEND



EMERGENCY ASSEMBLY POINT



FIRE POINT



FIRE HYDRANT



EMERGENCY CONTROL ROOM



HOSE REEL

Krishna
KRISHNA KUMAR
B. Tech. (Mechanical)
M.E.P Consultant

For R K DEVELOPERS
Partner

WARNING

1. This drawing is the sole copyright of Architects VISTAAR and should be used for the purpose expressly issued.

GENERAL NOTES

1. All dimensions are in feet and inches.
2. Do not scale this drawing follow written dimensions only.
3. This drawing should be read in conjunction with other architectural and structural drawings.
4. Any discrepancy in the drawing should be immediately brought to the notice of architect.

PROJECT TITLE

SHREEJI RESIDENDY
BUILDING AT PLOT-1, 1A & 1B,
SCHEME GREEN
VILLAS,VILL.NANDKISHOREPURA URF.
MANYAWAS,JAIPUR

DRAWING TITLE

GROUND TO 4TH.FLOOR FIRE FIGHTER

ARCHITECTS

VISTAAR ARCHITECTS & PLANNERS

Architects : Interior Designers
B-2/12, Chitkoot scheme,
main Gandhi Park Opp mall of jaipur, Jaipur
PH: - 0141-4116461, 09901010366

REV.

REV.

DATE

BY

REVISION


17-01-2024

SCALE

AS PER

1:10



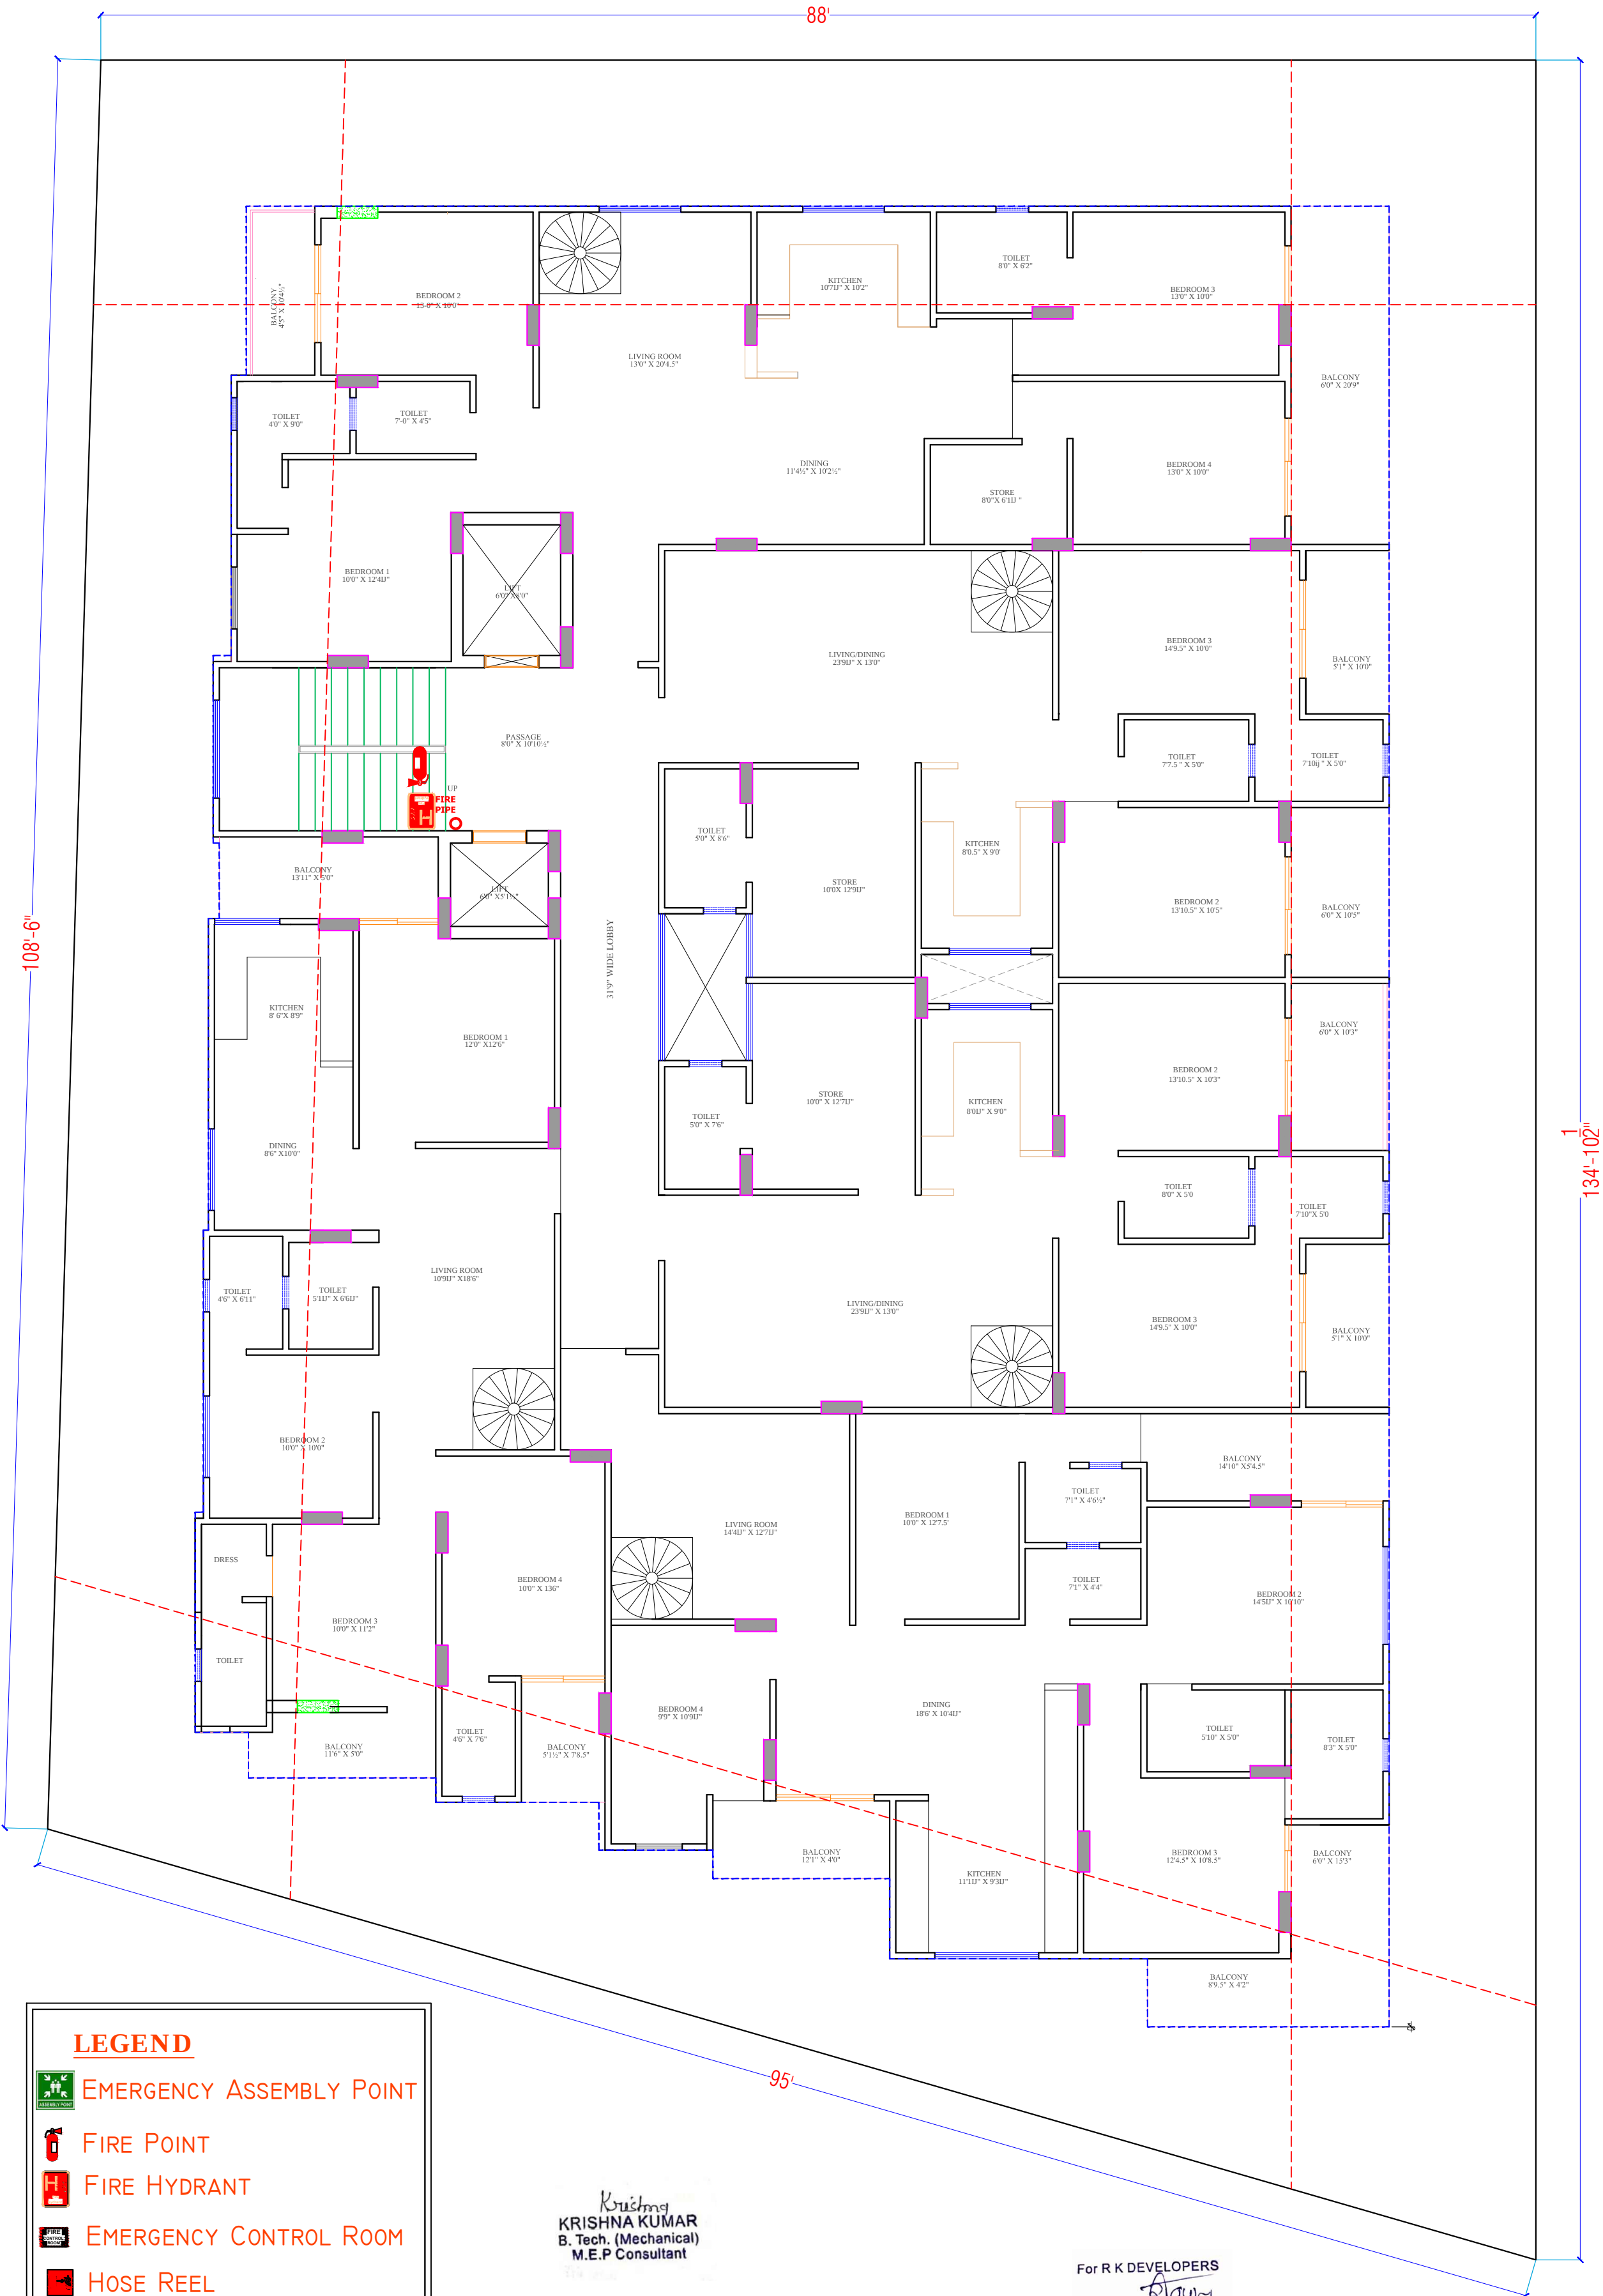

LEGEND

-  EMERGENCY ASSEMBLY POINT
-  FIRE POINT
-  FIRE HYDRANT
-  EMERGENCY CONTROL ROOM
-  HOSE REEL

Krishna
KRISHNA KUMAR
B. Tech. (Mechanical)
M.E.P Consultant

For R K DEVELOPERS
Partner

WARNING

1. This drawing is the sole copyright of Architects VISTAAR and should be used for the purpose expressly issued.

GENERAL NOTES

1. All dimensions are in feet and inches.
2. Do not scale this drawing follow written dimensions only.
3. This drawing should be read in conjunction with other architectural and structural drawings.
4. Any discrepancy in the drawing should be immediately brought to the notice of architect.

PROJECT TITLE

SHREEJI RESIDENDY
BUILDING AT PLOT-1, 1A & 1B,
SCHEME GREEN
VILLAS,VILL.NANDKISHOREPURA URF.
MANYAWAS,JAIPUR

DRAWING TITLE

5TH.FLOOR FIRE FIGHTER

ARCHITECTS

VISTAAR ARCHITECTS & PLANNERS

Architects : Interior Designers
B-2/12, Chaitanyanagar,
main Gandhi Park Opp mall of Jaipur, Jaipur
PH: 0141-4116461,09901010366

REV.	DATE	BY	REVISION
1	17-01-2024		
SCALE	AS SHOWN		
1:10			

