


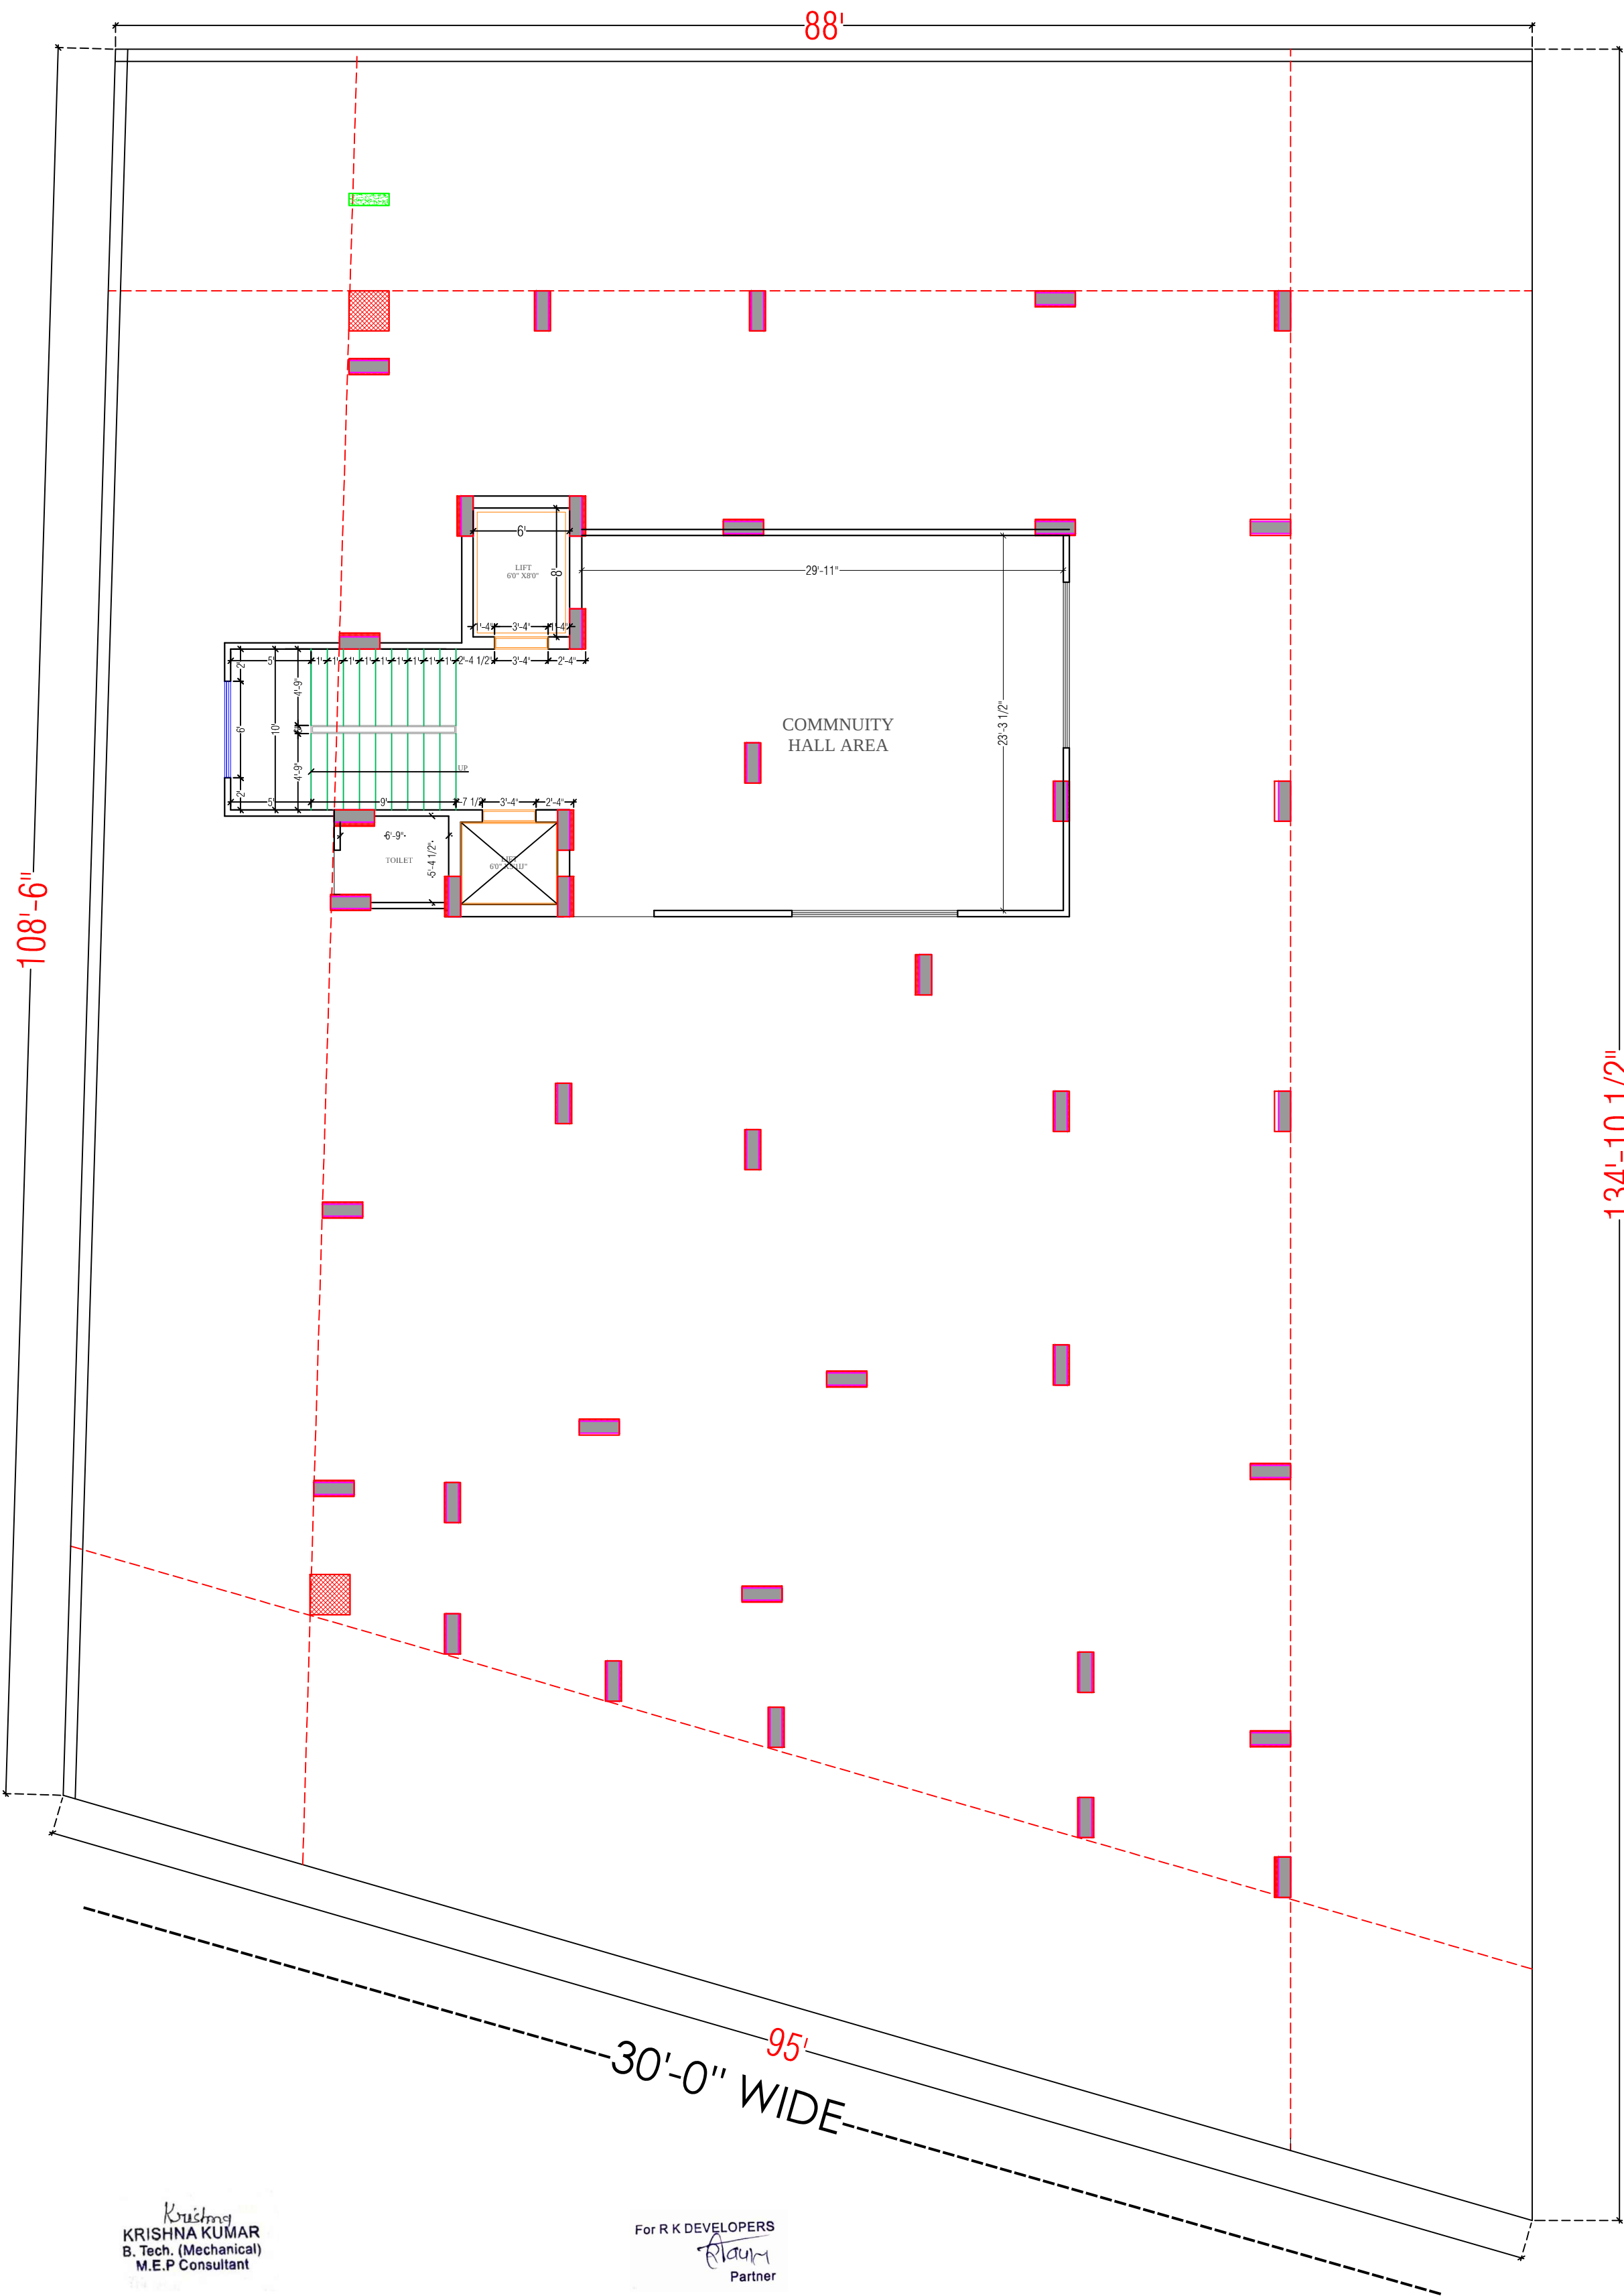

①	RAIN WATER PIPE		
②	WEST WATER PIPE		
③	SOILWATER PIPE		
④	INSPECTION CHAMBER / GULLY TRAP		2'6" DEPTH
⑤	MAN HOLE		2'6" DEPTH
⑥	ELECTRICAL PIPELINE		

LEGENDS		
S.NO.	SYMBOL	DESCRIPTION
1.		SDR-11 Fresh Water Pipe
2.		SDR-11 Solar Water Pipe
3.		Waste Water Pipe (W.P.)
4.		Soil Pipe (S.P.)
5.		Rain Water Pipe (R.W.P.)
6.		Butter Fly Valve(B.F.V.)
7.		Geyser
8.		RO
9.		Single Lever Diverter
10.		Concealed Valve
11.		Angle Valve
12.		Nahani Trap
13.		P-Trap
14.		Tap
15.		Floor Drain (F.D.)
16.		Plain Tee (P-tee)
17.		Gully Trap (G.T.)
18.		

WARNING
1. This drawing is the sole copyright of Architects **VISTAAR** and should be used for the purpose expressly issued.

GENERAL NOTES
1. All dimensions are in feet and inches.
2. Do not scale this drawing follow written dimensions only.
3. This drawing should be read in conjunction with other architectural and structural drawings.
4. Any discrepancy in the drawing should be immediately brought to the notice of architect.

PROJECT TITLE
SHREEJI RESIDENDY
BUILDING AT PLOT-1, 1A & 1B,
SCHEME GREEN
VILLAS,VILLNANDKISHOREPURA URF,
MANYAWAS,JAIPUR


DRAWING TITLE
STILT FLOOR PLUMBING PLAN

PREPARED BY
VISTAAR ARCHITECTS & PLANNERS
Architects :: Interior Designers
B-2/12, Chitrakoot scheme,
main Gandhi Path,Opp mall of jaipur,Jaipur
Ph:- 0141-4116461,09001010366

DESIGN	CHECK	REV.	DATE
WALL	DOOR	WALL	DOOR
SCALE	DATE	SCALE	DATE
SCALE	DATE	SCALE	DATE

Krishna
KRISHNA KUMAR
B. Tech. (Mechanical)
M.E.P Consultant

For R K DEVELOPERS
Ravi
Partner

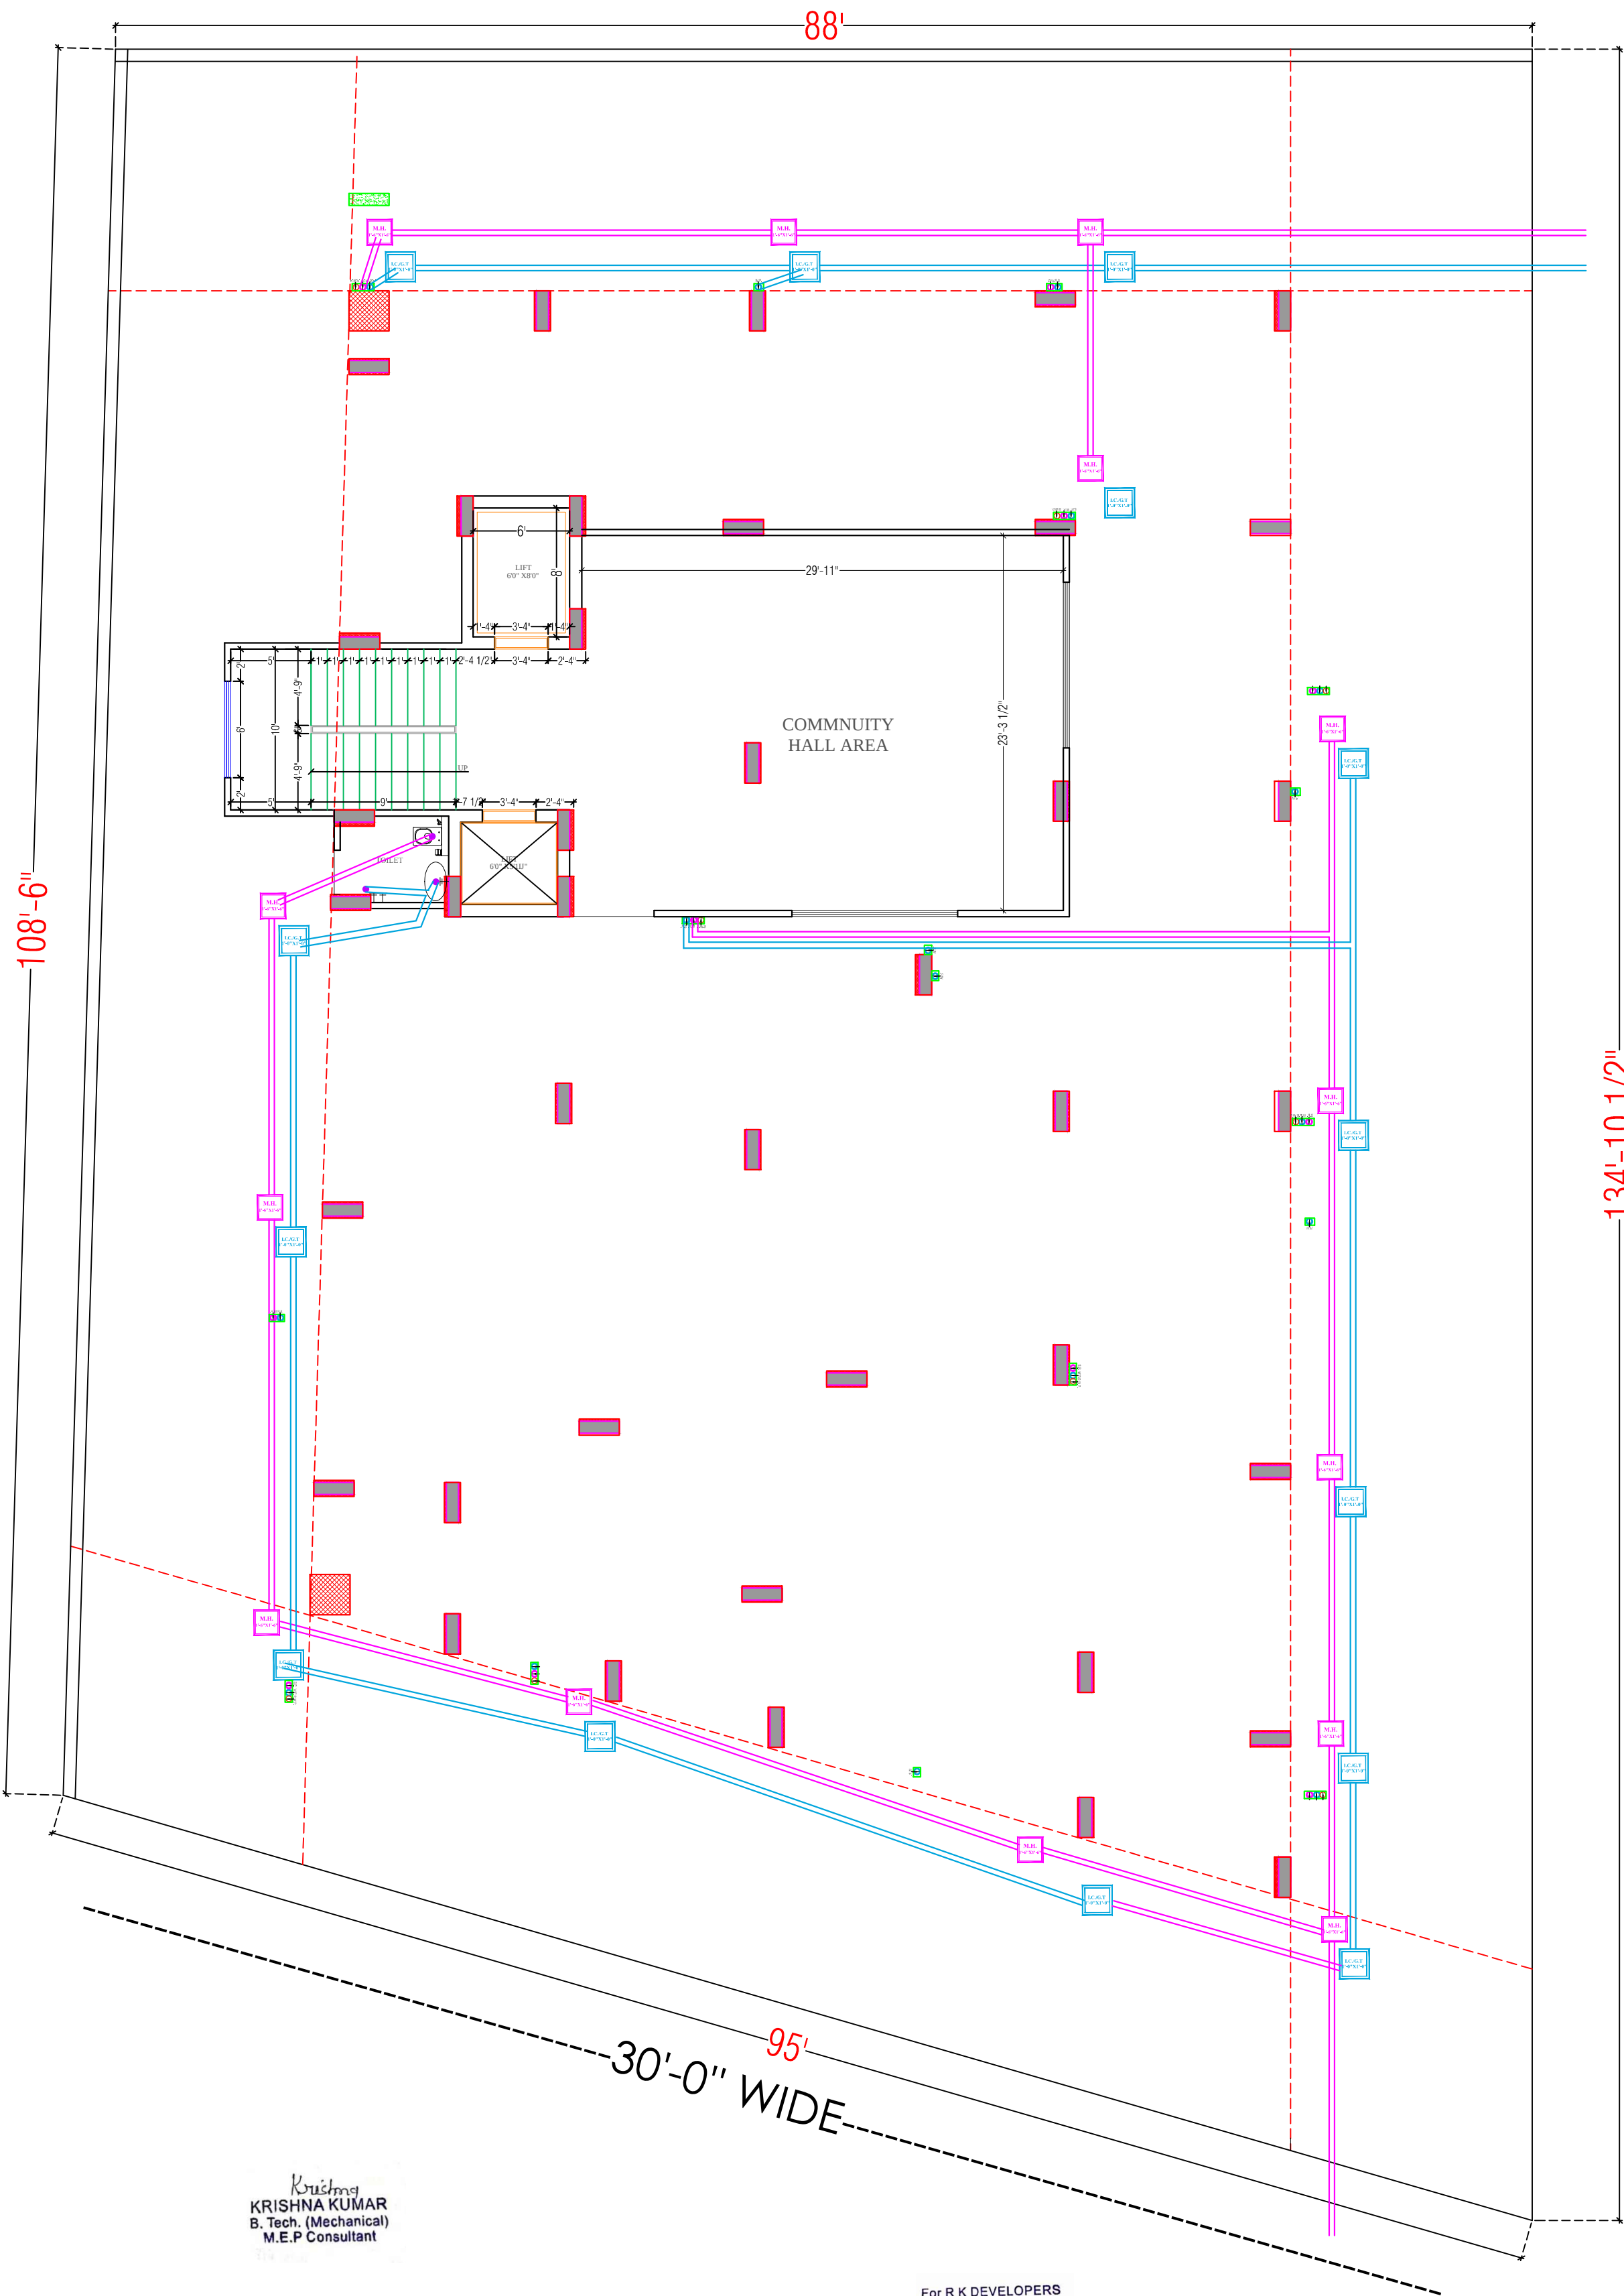

①	RAIN WATER PIPE		
②	WEST WATER PIPE		
③	SOILWATER PIPE		
④	INSPECTION CHAMBER / GULLY TRAP		2'6\"/>
⑤	MAN HOLE		2'6\"/>
⑥	ELECTRICAL PIPELINE		

LEGENDS		
S.NO.	SYMBOL	DESCRIPTION
1.		SDR-11 Fresh Water Pipe
2.		SDR-11 Solar Water Pipe
3.		Waste Water Pipe (W.P.)
4.		Soil Pipe (S.P.)
5.		Rain Water Pipe (R.W.P.)
6.		Butter Fly Valve(B.F.V.)
7.		Geyser
8.		RO
9.		Single Lever Diverter
10.		Concealed Valve
11.		Angle Valve
12.		Nahani Trap
13.		P-Trap
14.		Tap
15.		Floor Drain (F.D.)
16.		Plain Tee (P-tee)
17.		Gully Trap (G.T.)
18.		

WARNING

1. This drawing is the sole copyright of Architects **VISTAAR** and should be used for the purpose expressly issued.

GENERAL NOTES

1. All dimensions are in feet and inches.
2. Do not scale this drawing follow written dimensions only.
3. This drawing should be read in conjunction with other architectural and structural drawings.
4. Any discrepancy in the drawing should be immediately brought to the notice of architect.

PROJECT TITLE

SHREEJI RESIDENDY
BUILDING AT PLOT-1,1A & 1B,
SCHEME GREEN
VILLAS,VILL,NANDKISHOREPURA URF,
MANYAWAS,JAIPUR

DRAWING TITLE

STILT DRAINAGE PLAN

DESIGNED BY

DATE

REV

SCALE

DATE

BY

FOR R K DEVELOPERS

Partner

VISTAAR ARCHITECTS & PLANNERS

Architects :: Interior Designers
B-2/12, Chitrkoot scheme,
main Gandhi Path,Opp mall of Jaipur,Jaipur
PH:- 0141-4116461,0901010366

DATE

SCALE

DATE

BY

FOR R K DEVELOPERS

Partner

88'

108'-6"

134'-102"

95'

Krishna
KRISHNA KUMAR
B. Tech. (Mechanical)
M.E.P. Consultant

For R K DEVELOPERS
Partner

LEGENDS

S.NO.	SYMBOL	DESCRIPTION
1.		SDR-11 Fresh Water Pipe
2.		SDR-11 Solar Water Pipe
3.		Waste Water Pipe (W.P.)
4.		Soil Pipe (S.P.)
5.		Rain Water Pipe (R.W.P.)
6.		Butter Fly Valve (B.F.V.)
7.		Geyser
8.		RO
9.		Single Lever Diverter
10.		Concealed Valve
11.		Angle Valve
12.		Nahani Trap
13.		P-Trap
14.		Tap
15.		Floor Drain (F.D.)
16.		Plain Tee (P-tee)
17.		Gully Trap (G.T.)
18.		

WARNING

1. This drawing is the sole copyright of Architects VISTAAR and should be used for the purpose expressly issued.

GENERAL NOTES

1. All dimensions are in feet and inches.
2. Do not scale this drawing follow written dimensions only.
3. This drawing should be read in conjunction with other architectural and structural drawings.
4. Any discrepancy in the drawing should be immediately brought to the notice of architect.

PROJECT TITLE

SHREEJI RESIDENCY
BUILDING AT PLOT-1, 1A & 1B,
SCHEME GREEN VILLAS, VILL NANDKISHOREPURA URF.
MANYAWAS, JAIPUR

DRAWING TITLE


GROUND TO 4TH FLOOR PLUMBING
PLAN

ARCHITECTS

VISTAAR ARCHITECTS &
PLANNERS
Architects :: Interior Designers
B-2/12, Chitrakoot scheme,
main Gandhi Path, Opp mall of jaipur, Jaipur
PH - 0141-4116461, 09001010366

DATE	DATE	DATE
15/01/2024	17/01/2024	17/01/2024
SCALE	AS SHOWN	
6/15		



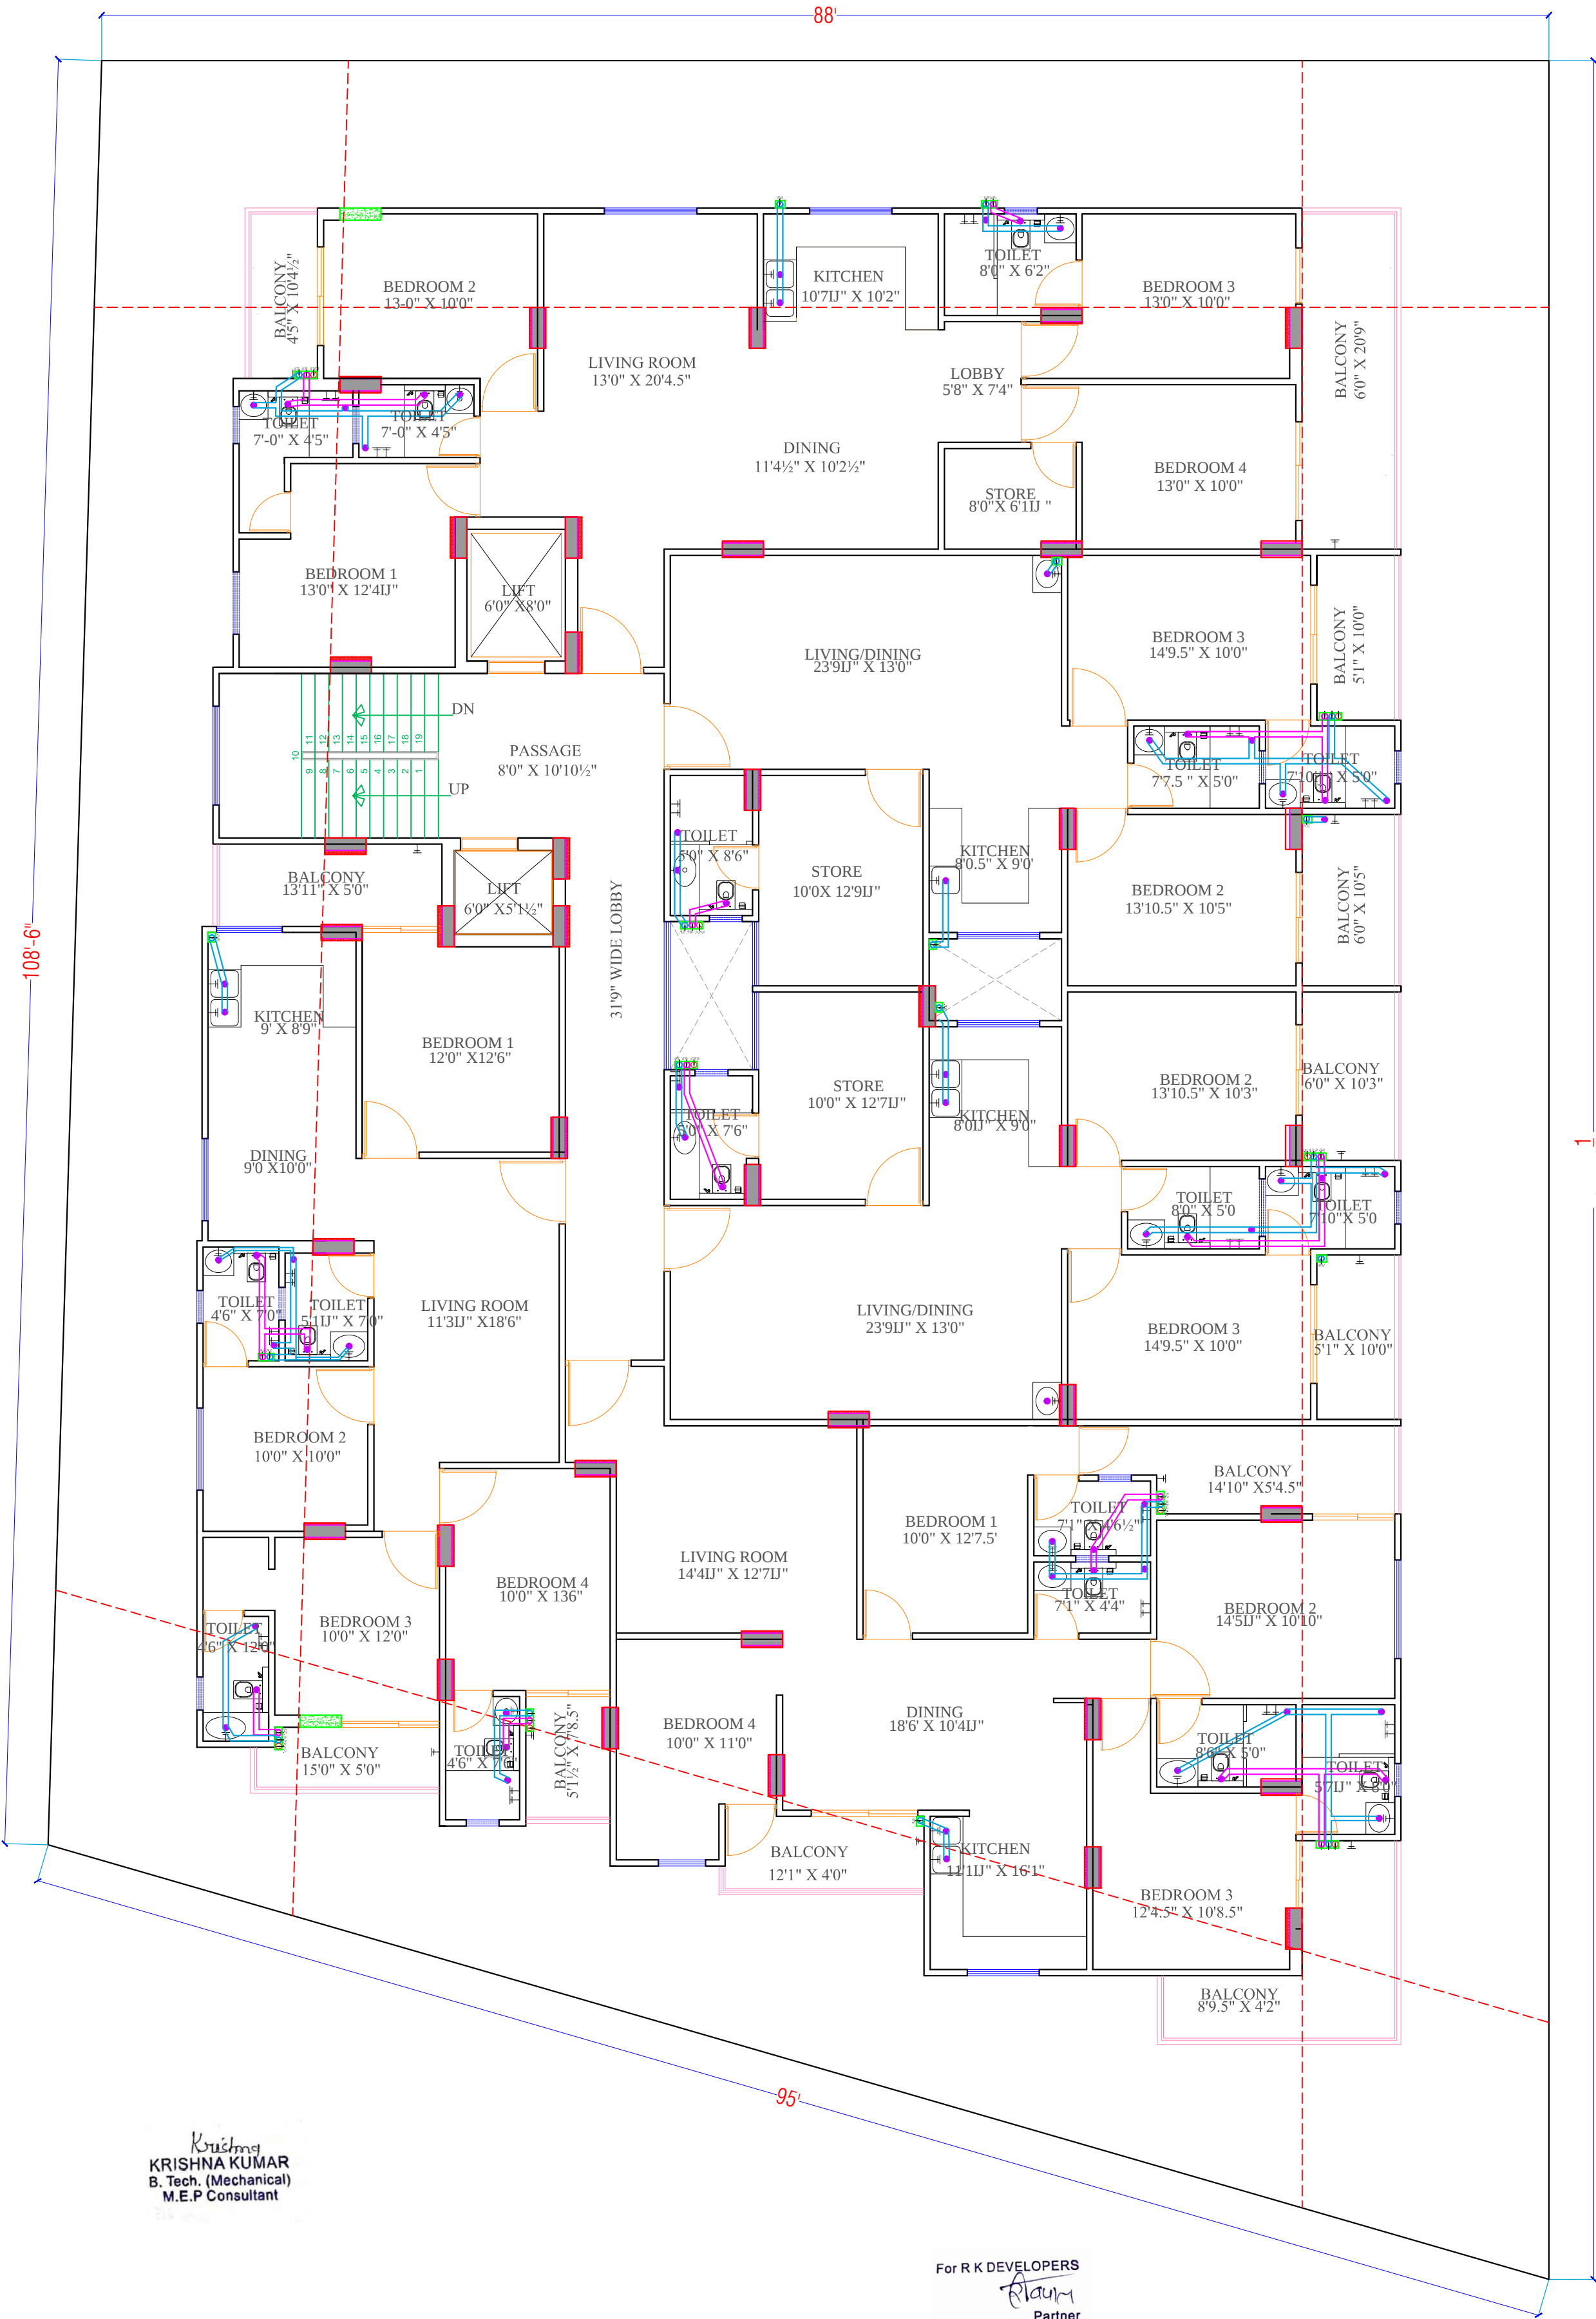

LEGENDS		
S.NO.	SYMBOL	DESCRIPTION
1.		SDR-11 Fresh Water Pipe
2.		SDR-11 Solar Water Pipe
3.		Waste Water Pipe (W.P.)
4.		Soil Pipe (S.P.)
5.		Rain Water Pipe (R.W.P.)
6.		Butter Fly Valve(B.F.V.)
7.		Geyser
8.		RO
9.		Single Lever Diverter
10.		Concealed Valve
11.		Angle Valve
12.		Nahani Trap
13.		P-Trap
14.		Tap
15.		Floor Drain (F.D.)
16.		Plain Tee (P-tee)
17.		Gully Trap (G.T.)
18.		

WARNING

1. This drawing is the sole copyright of Architects VISTAAR and should be used for the purpose expressly issued.

GENERAL NOTES

1. All dimensions are in feet and inches.
2. Do not scale this drawing follow written dimensions only.
3. This drawing should be read in conjunction with other architectural and structural drawings.
4. Any discrepancy in the drawing should be immediately brought to the notice of architect.

PROJECT TITLE

SHREEJI RESIDENDY
BUILDING AT PLOT-1, 1A & 1B,
SCHEME GREEN
VILLAS,VILL.NANDKISHOREPURA URF.
MANYAWAS,JAIPUR

DRAWING TITLE

GROUND TO 4TH.FLOOR DRAINAGE PLAN

ARCHITECTS

VISTAAR ARCHITECTS & PLANNERS

Architects : Interior Designers
B-2/12, Chakraborty scheme,
main Gandhi Park Opp mall of Jaipur, Jaipur
PH: 0141-4116461,09901010366

REV.	DATE	BY	REVISION
01	17-01-2024		

SCALE	JOB NO.
1:10	



Krishna
KRISHNA KUMAR
B. Tech. (Mechanical)
M.E.P Consultant

For R K DEVELOPERS
R K
Partner

88'

108'-6"

134'-102"

95'

Krishna
KRISHNA KUMAR
B. Tech. (Mechanical)
M.E.P. Consultant

For R K DEVELOPERS
Partner

LEGENDS

S.NO.	SYMBOL	DESCRIPTION
1.		SDR-11 Fresh Water Pipe
2.		SDR-11 Solar Water Pipe
3.		Waste Water Pipe (W.P.)
4.		Soil Pipe (S.P.)
5.		Rain Water Pipe (R.W.P.)
6.		Butter Fly Valve(B.F.V.)
7.		Geyser
8.		RO
9.		Single Lever Diverter
10.		Concealed Valve
11.		Angle Valve
12.		Nahani Trap
13.		P-Trap
14.		Tap
15.		Floor Drain (F.D.)
16.		Plain Tee (P-tee)
17.		Gully Trap (G.T.)
18.		

WARNING

1. This drawing is the sole copyright of Architects VISTAAR and should be used for the purpose expressly issued.

GENERAL NOTES

1. All dimensions are in feet and inches.
2. Do not scale this drawing follow written dimensions only.
3. This drawing should be read in conjunction with other architectural and structural drawings.
4. Any discrepancy in the drawing should be immediately brought to the notice of architect.

PROJECT TITLE

SHREEJI RESIDENDY
BUILDING AT PLOT-1, 1A & 1B,
SCHEME GREEN VILLAS, VILL NANDKISHOREPURA URF.
MANYAWAS, JAIPUR

DRAWING TITLE


5TH.FLOOR PLUMBING PLAN

ARCHITECTS

VISTAAR ARCHITECTS &
PLANNERS
Architects :: Interior Designers
B-2/12, Chitrakoot scheme,
main Gandhi Path, Opp mall of jaipur, Jaipur
PH - 0141-4116461, 09001010366

DATE	DATE	DATE
15/01/2024	17/01/2024	17/01/2024
REVISION	REVISION	REVISION
01/01		



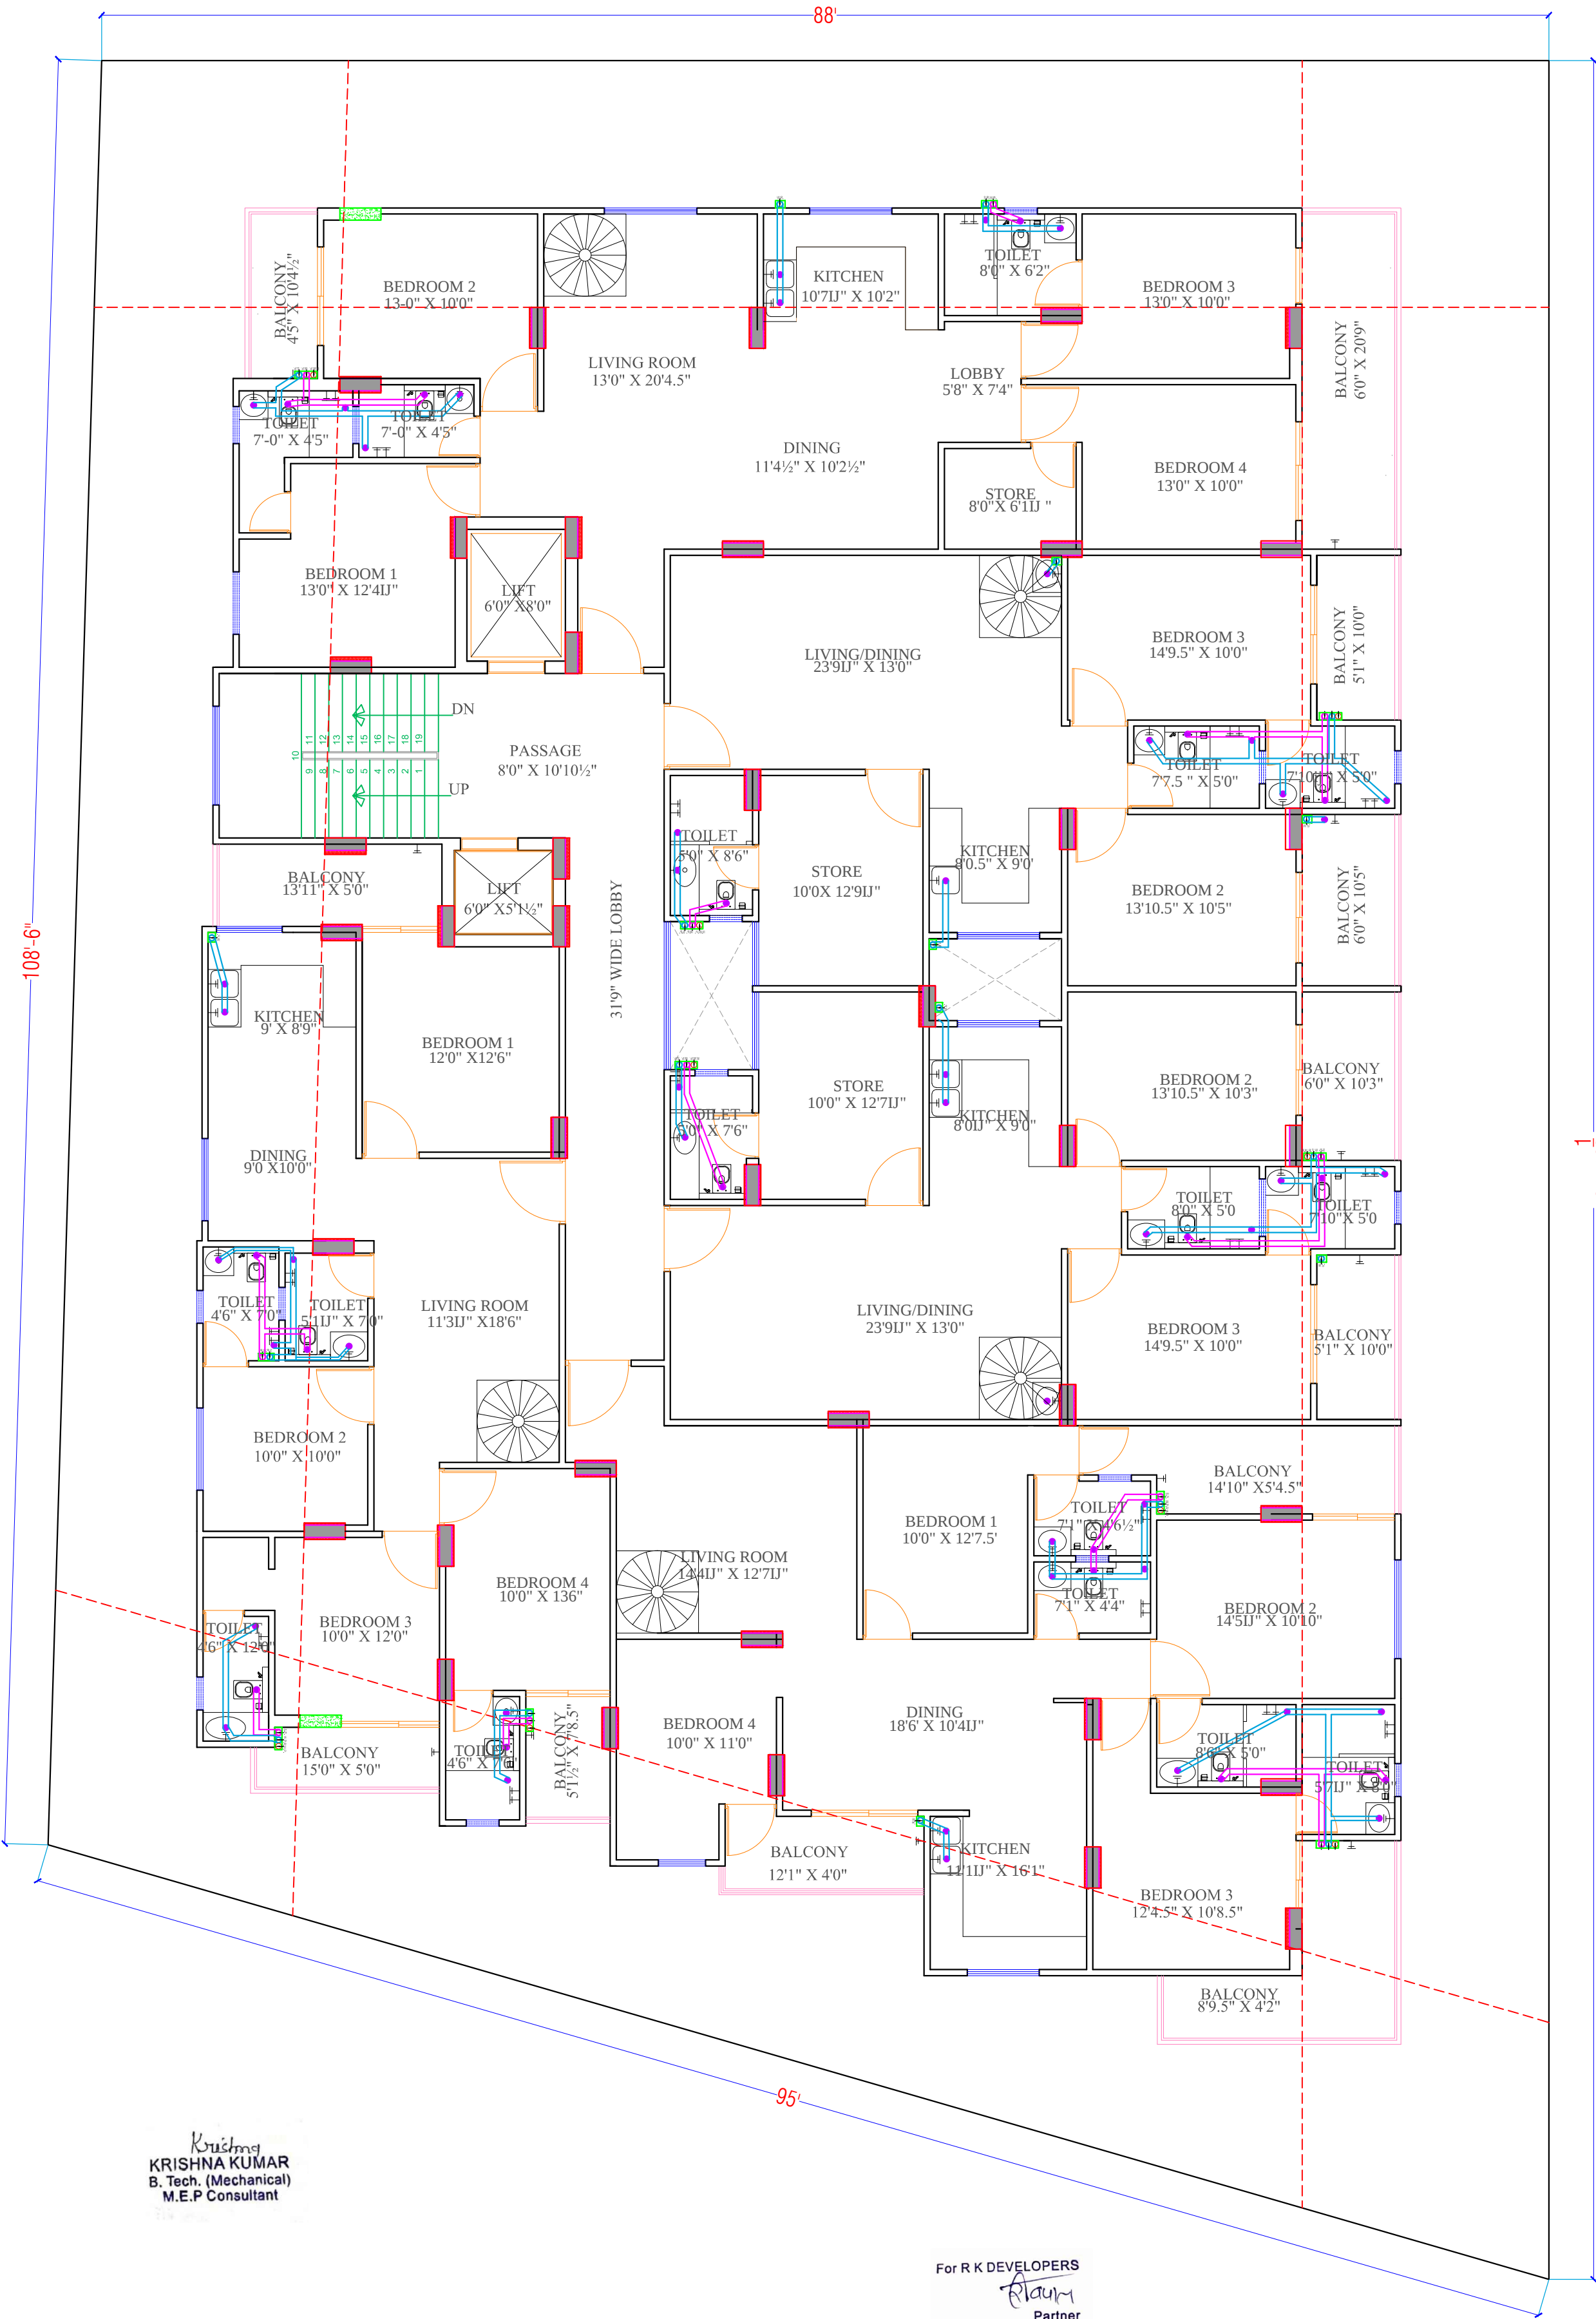

LEGENDS		
S.NO.	SYMBOL	DESCRIPTION
1.		SDR-11 Fresh Water Pipe
2.		SDR-11 Solar Water Pipe
3.		Waste Water Pipe (W.P.)
4.		Soil Pipe (S.P.)
5.		Rain Water Pipe (R.W.P.)
6.		Butter Fly Valve(B.F.V.)
7.		Geyser
8.		RO
9.		Single Lever Diverter
10.		Concealed Valve
11.		Angle Valve
12.		Nahani Trap
13.		P-Trap
14.		Tap
15.		Floor Drain (F.D.)
16.		Plain Tee (P-tee)
17.		Gully Trap (G.T.)
18.		

WARNING

1. This drawing is the sole copyright of Architects VISTAAR and should be used for the purpose expressly issued.

GENERAL NOTES

- All dimensions are in feet and inches.
- Do not scale this drawing follow written dimensions only.
- This drawing should be read in conjunction with other architectural and structural drawings.
- Any discrepancy in the drawing should be immediately brought to the notice of architect.

PROJECT TITLE

SHREEJI RESIDENDY
BUILDING AT PLOT-1, 1A & 1B,
SCHEME GREEN
VILLAS,VILL.NANDKISHOREPURA URF.
MANYAWAS,JAIPUR

DRAWING TITLE

5TH. FLOOR DRAINAGE PLAN


ARCHITECTS

VISTAAR ARCHITECTS &
PLANNERS
Architects - Interior Designers
B-2/12, Chakrasthane,
main Gandhi Park Opp mall of Jaipur, Jaipur
PH - 0141-4116461, 09901010366

REV.	DATE	BY	REVISION
01	17-01-2024		
SCALE	AS SHOWN		
6/11			

Krishna
KRISHNA KUMAR
B. Tech. (Mechanical)
M.E.P Consultant

For R K DEVELOPERS
R K
Partner

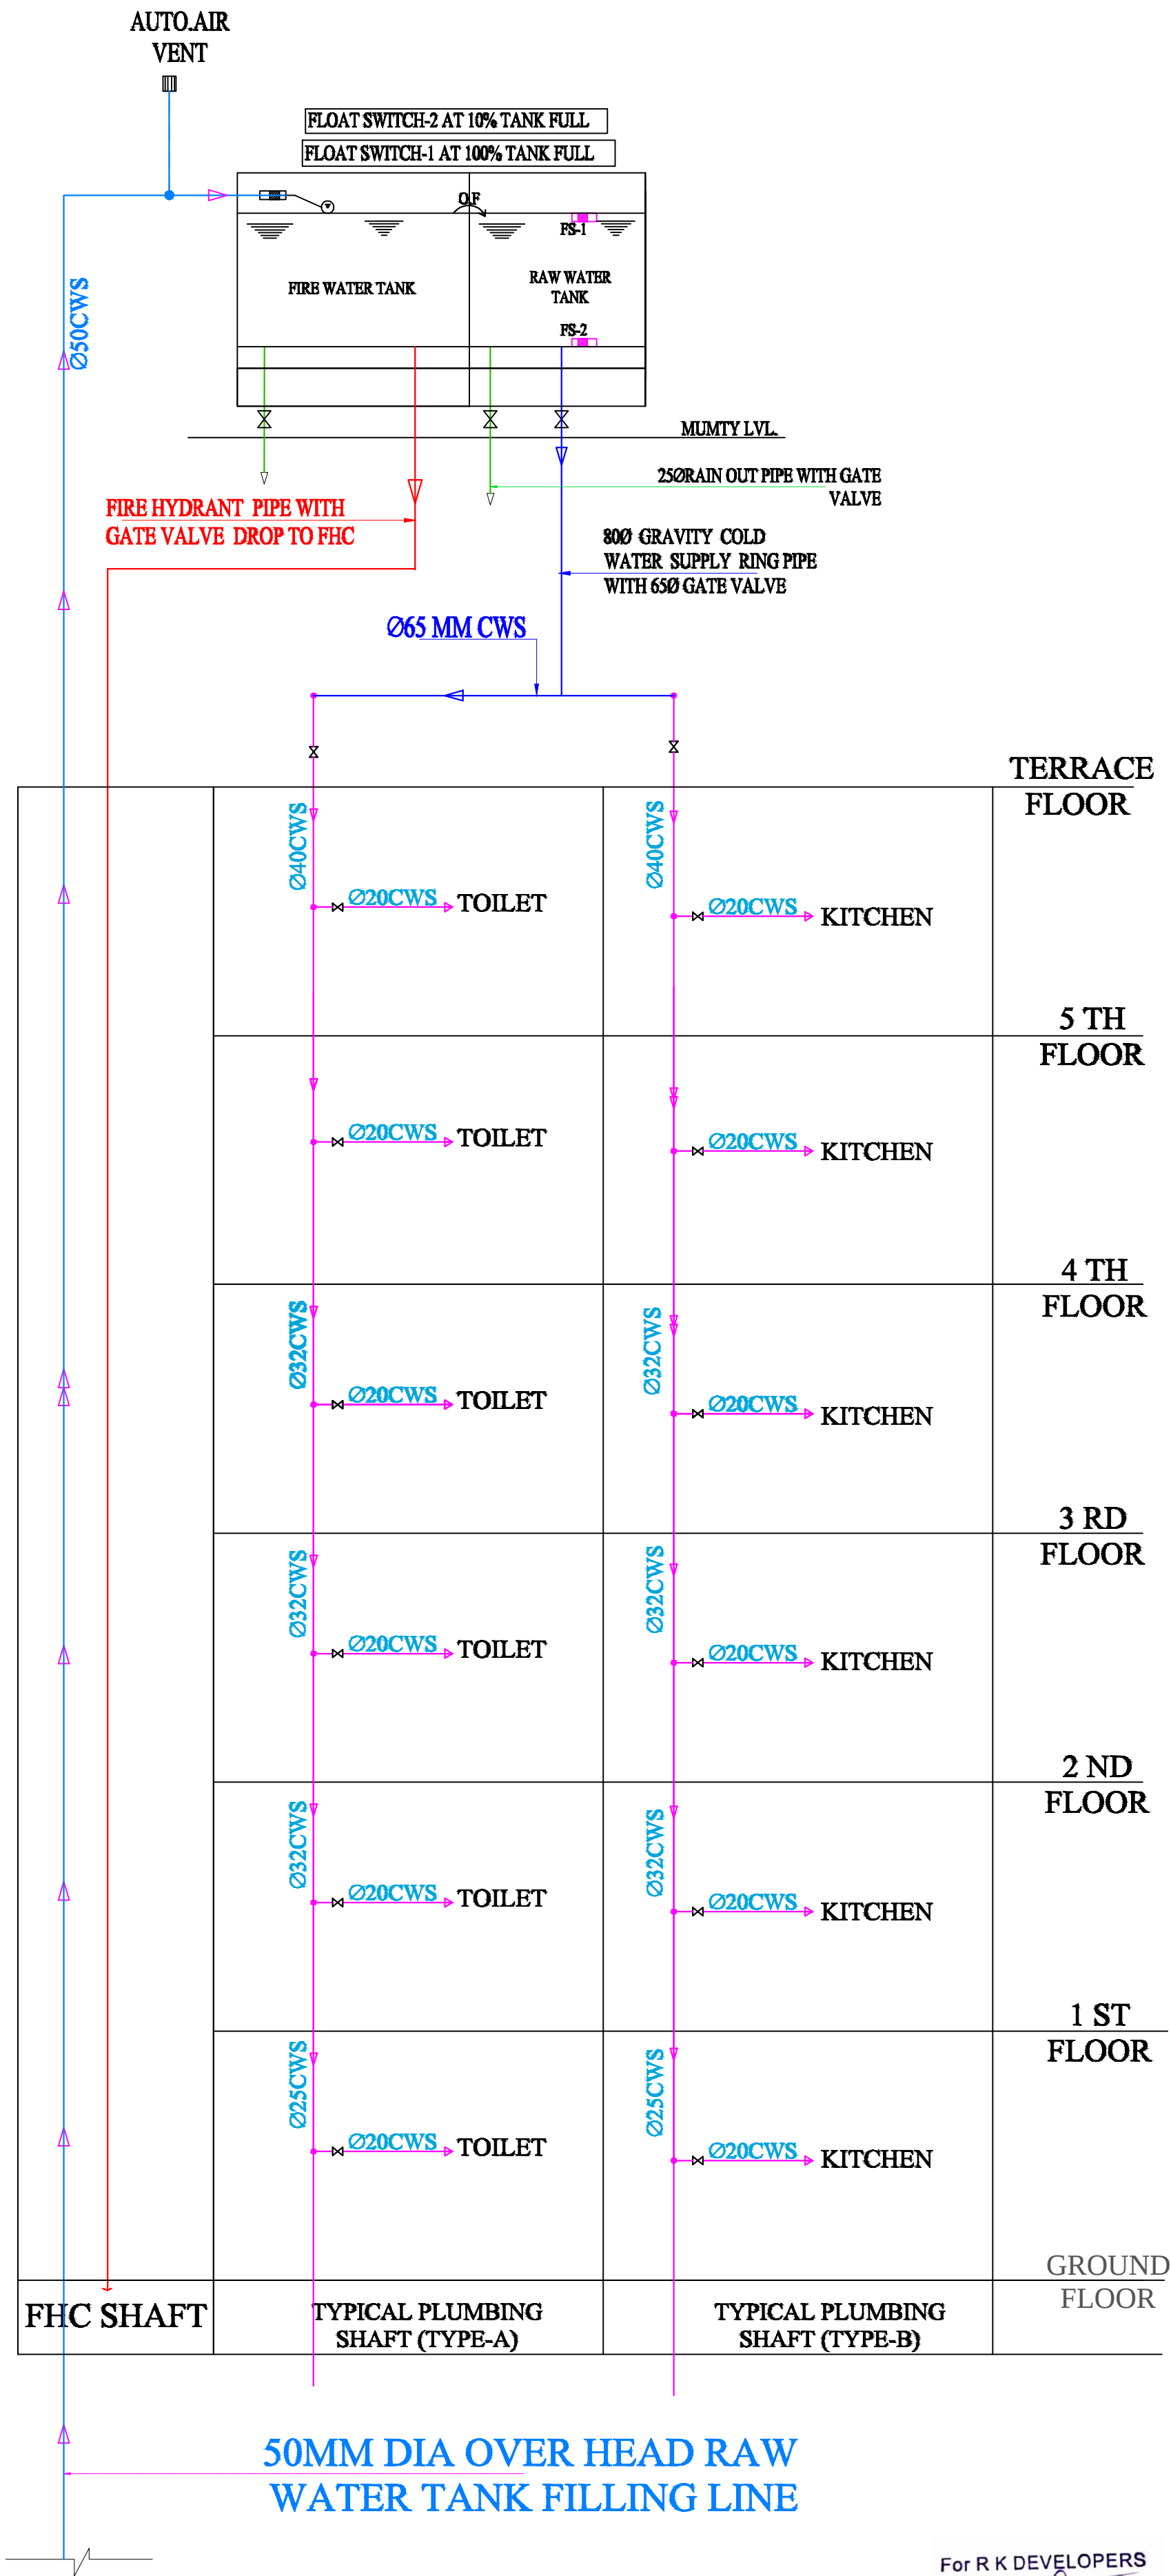

KRISHNA KUMAR
B. Tech. (Mechanical)
M.E.P Consultant

WARNING
1. This drawing is the sole copyright of Architects VISTAAR and should be used for the purpose expressly issued.

GENERAL NOTES
1. All dimensions are in feet and inches.
2. Do not scale this drawing follow written dimensions only.
3. This drawing should be read in conjunction with other architectural and structural drawings.
4. Any discrepancy in the drawing should be immediately brought to the notice of architect.

PROJECT TITLE
SHREEJI RESIDENDY
BUILDING AT PLOT-1, 1A & 1B,
SCHEME GREEN
VILLAS,VILL.NANDKISHOREPURA URF.
MANYAWAS,JAIPUR

DRAWING TITLE
WATER SUPPLY DIAGRAM

ARCHITECTS:
VISTAAR ARCHITECTS &
PLANNERS
Architects - Interior Designers
B-2/12, Chinkot scheme,
main Gandhi Path Opp mall of jaipur,Jaipur
PH: 0141-4116461, 09001010366

REV.	DATE	REV.	NOTES
01	17-07-2024		
02			
03			

For R K DEVELOPERS
Partner