


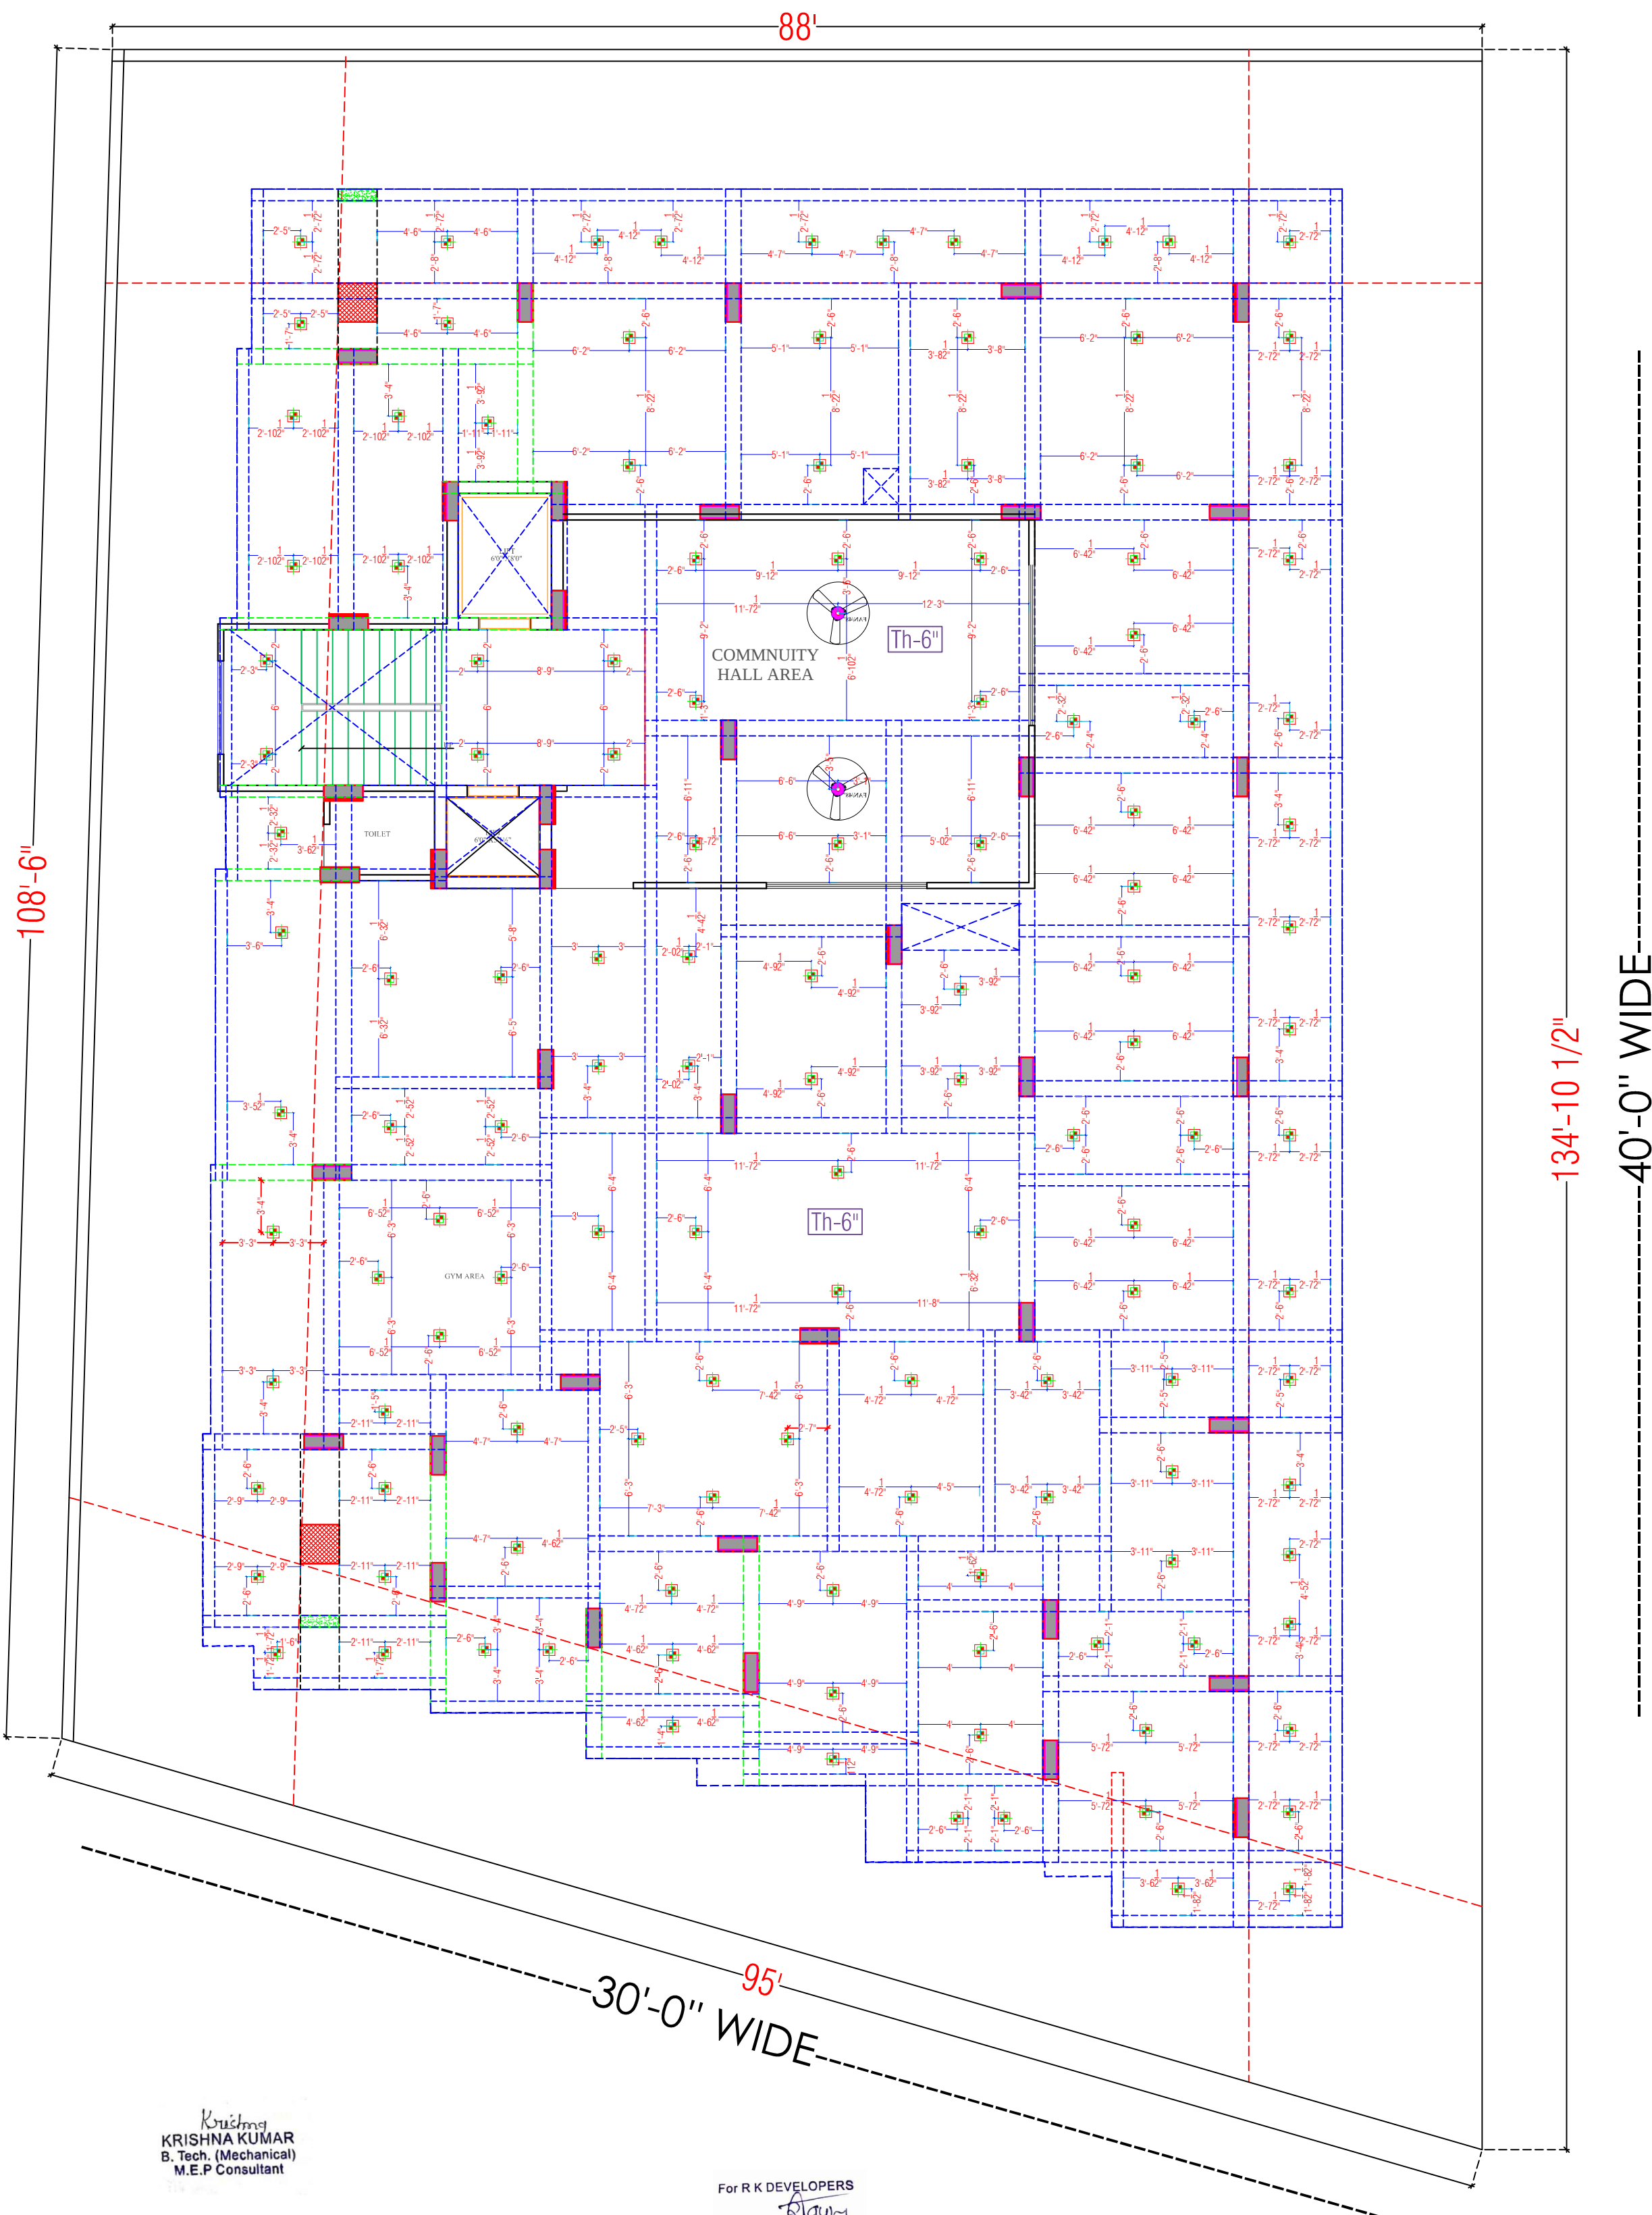

LEGENDS:				
Marking	No.	I D	Symbol	Description
IN FLOOR				CONTROL WIRING
IN CONDUIT				CONTROL WIRING
IN CONDUIT				AC CONTROL WIRING
IN CONDUIT				GYSEK CONTROL WIRING
IN CONDUIT				Buzzer CONTROL WIRING
CEILING	FAN/SP			CEILING FAN 40"
CEILING	FAN/SP			CEILING FAN 50"
+90"	TL			LUXOR WALL TUBELIGHT
+90"	BULB			WALL BRACKETS AS DESIGN LIGHT
+90"	GL			WALL BRACKETS AS DESIGN FOR GYM LIGHT
	GL			WALL BRACKETS AS DESIGN FOR GATE LIGHT
CEILING	CFL			CFL CEILING LIGHT
+21"	FL			FOOT LIGHT
+48"	SB			SWITCH BOARD
+70"	ML			1 X 11 W CFL MIRROR LIGHT
VENTILATOR	CR			CEILING ROSE
VENTILATOR	EXP			3" DIA FRESH AIR FAN
+24"	TEL			TELEPHONE POINT
+27"	TV			TV COAXIAL POINT
+27"	LP TV			5 A PLUG POINT FOR TV
+72"	LP CH			5 A PLUG POINT FOR CHIMNEY
+102"	SAC			SPLIT AC
+102"	PP-SAC			15 A POWER POINT FOR SPLIT AC
+42"	PP-MIX			15 A POWER POINT FOR MIXER
+78"	PP-G			15 A POWER POINT FOR GYSEK
+54"	PP-F			15 A POWER POINT FOR FRIDGE
+78"	PP-WP			15 A POWER POINT FOR WATER PURIFIER
+48"	PP-WM			15 A POWER POINT FOR WASHING MACHINE
+42"	BP			BELL PUSH SWITCH
+90"	BZ			Buzzer Point
+48"	AC			AC STARTER
+60"	MCB DB			MCB DISTRIBUTION BOARD

WARNING
1. This drawing is the sole copyright of Architects **VISTAAR** and should be used for the purpose expressly issued.

GENERAL NOTES
1. All dimensions are in feet and inches.
2. Do not scale this drawing follow written dimensions only.
3. This drawing should be read in conjunction with other architectural and structural drawings.
4. Any discrepancy in the drawing should be immediately brought to the notice of architect.

PROJECT TITLE
SHREEJI RESIDENCY
BUILDING AT PLOT-1, 1A & 1B,
SCHEME GREEN VILLAS, VILL. NANKISHOREPURA
URF, MANYAWAS, JAIPUR

DRAWING TITLE
STILT FLOOR CEILING ELECTRICAL PLAN


DESIGNER
VISTAAR ARCHITECTS & PLANNERS
Architects : Interior Designers
B-2/12, Chitrakoot scheme,
main Gandhi Path, Opp. mail of jaipur, Jaipur
PH. - 0141-4116461, 99001010366

DATE	BY	REV	REVISION
20-06-2021			
20-06-2021			
20-06-2021			

Krishna
KRISHNA KUMAR
B. Tech. (Mechanical)
M.E.P Consultant

For R K DEVELOPERS
Ram
Partner



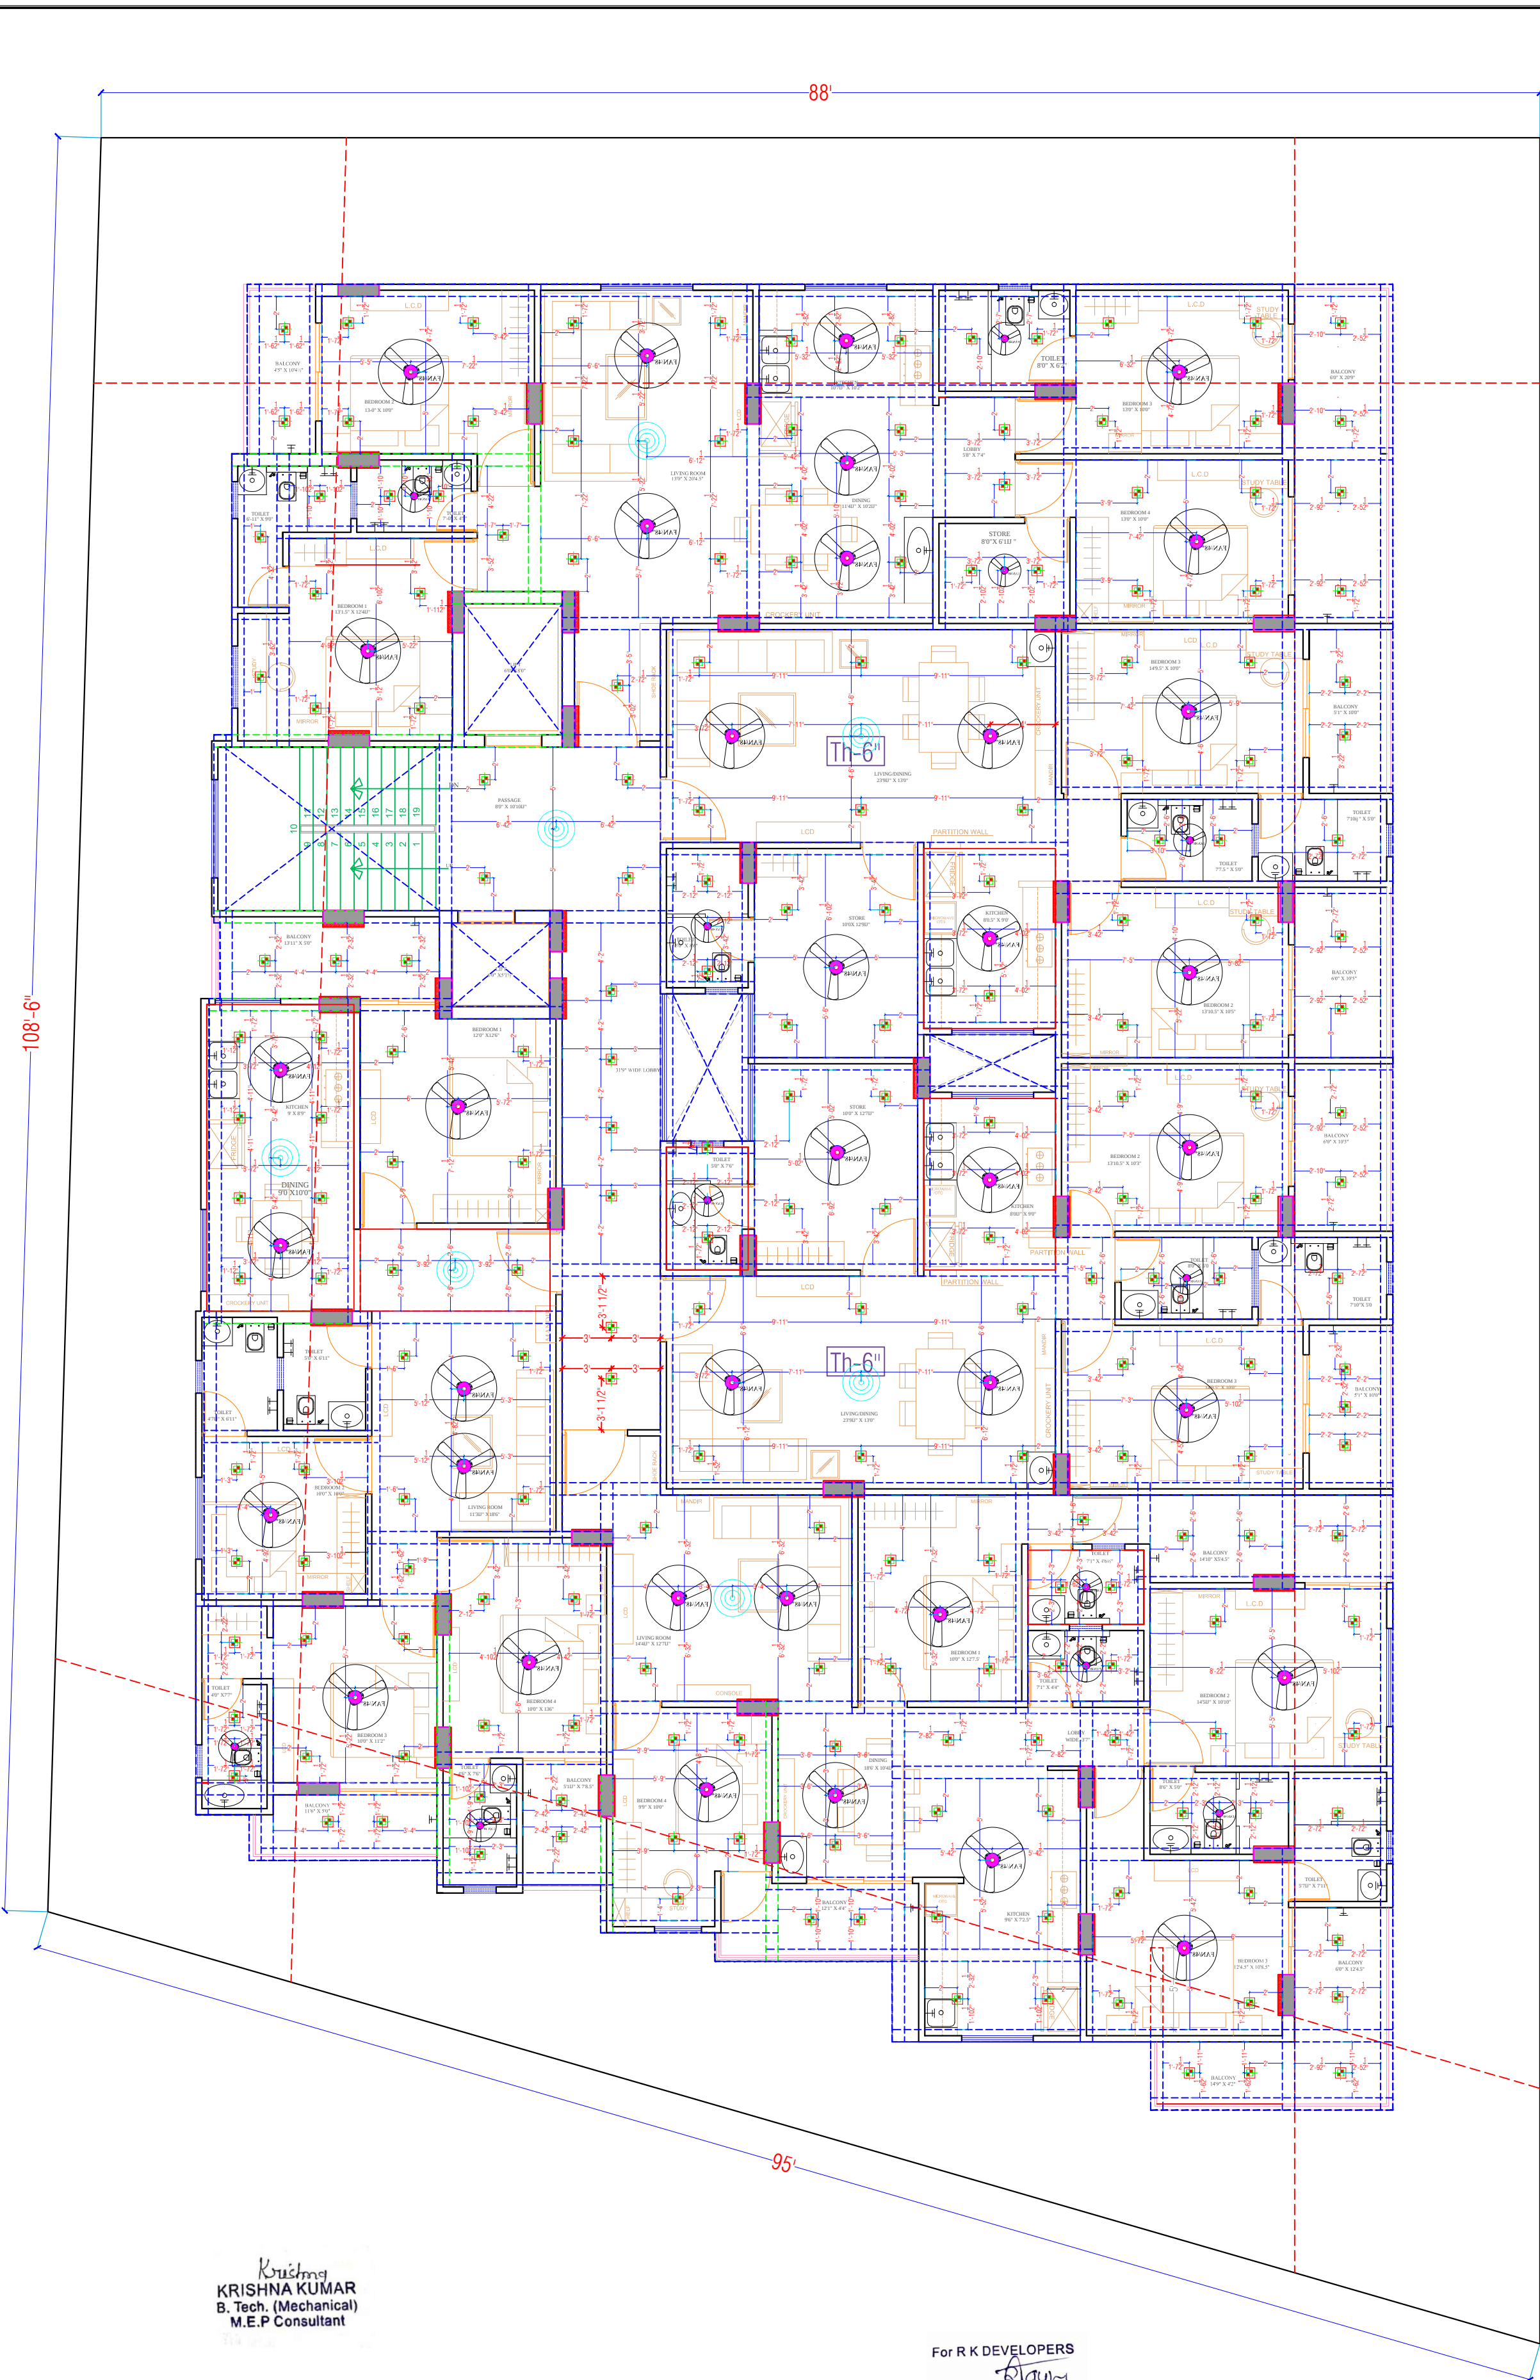

LEGENDS:				
Mounting Height	No.	I D	Symbol	Description
IN FLOOR				CONTROL WIRING
IN CONDUIT				CONTROL WIRING
IN CONDUIT				AC CONTROL WIRING
IN CONDUIT				GYSER CONTROL WIRING
IN CONDUIT				BUZZER CONTROL WIRING
CEILING	FAN 48"			CEILING FAN 48"
CEILING	FAN 36"			CEILING FAN 36"
+90"	TL			1X40W WALL TUBELIGHT
+90"	BULB			WALL BRACKETS AS DESIGN LIGHT
+90"	GL			WALL BRACKETS AS DESIGN FOR GANESH LIGHT
	GL			WALL BRACKETS AS DESIGN FOR GATE LIGHT
CEILING	CFL			CFL CEILING LIGHT
+21"	FL			FOOT LIGHT
+48"	SB			SWITCH BOARD
+75"	ML			1 X 11 W CFL MIRROR LIGHT
VENTILATOR HT.	CR			CEILING ROSE
VENTILATOR HT.	EXP			9" DIA FRESH AIR FAN
+24"	TEL			TELEPHONE POINT
+27"	TV			TV COAXIAL POINT.
+27"	LP TV			6 A PLUG POINT FOR TV
+72"	LP-CH			6 A PLUG POINT FOR CHIMNEY
+102"	SAC			SPLIT AC
+102"	PP-SAC			25 A POWER POINT FOR SPLIT AC
+42"	PP-MIX			15 A POWER POINT FOR MIXER
+78"	PP-G			15 A POWER POINT FOR GEYSER
+54"	PP-F			15 A POWER POINT FOR FRIDGE
+78"	PP-WP			15 A POWER POINT FOR WATER PURIFIER
+48"	PP-WM			15 A POWER POINT FOR WASHING MACHINE
+42"	BP			BELL PUSH SWITCH
+90"	BZ			BUZZER POINT
+48"	AC			AC STARTER
+60"	MCB DB			MCB DISTRIBUTION BOARD

WARNING
1. This drawing is the sole copyright of Architects VISTAAR and should be used for the purpose expressly issued.

GENERAL NOTES
1. All dimensions are in feet and inches.
2. Do not scale this drawing follow written dimensions only.
3. This drawing should be read in conjunction with other architectural and structural drawings.
4. Any discrepancy in the drawing should be immediately brought to the notice of architect.

PROJECT TITLE

SHREEJI RESIDENDY
BUILDING AT PLOT-1, 1A & 1B,
SCHEME GREEN
VILLAS,VILL,NANDKISHOREPURA URF,
MANYAWAS,JAIPUR

DRAWING TITLE

GROUND TO 4TH.FLOOR CEILING ELECTRICAL PLAN


ARCHITECTS

VISTAAR ARCHITECTS & PLANNERS
Architects :: Interior Designers
B-2/12, Chitrkoot scheme,
main Gandhi Path Opp mall of jaipur,Jaipur
PH. - 0141-4116461,09001010366

DATE	17-01-2024	REVISION	
SCALE	AS SHD		
1/11			

Krishna
KRISHNA KUMAR
B. Tech. (Mechanical)
M.E.P Consultant

For R K DEVELOPERS
Raum
Partner

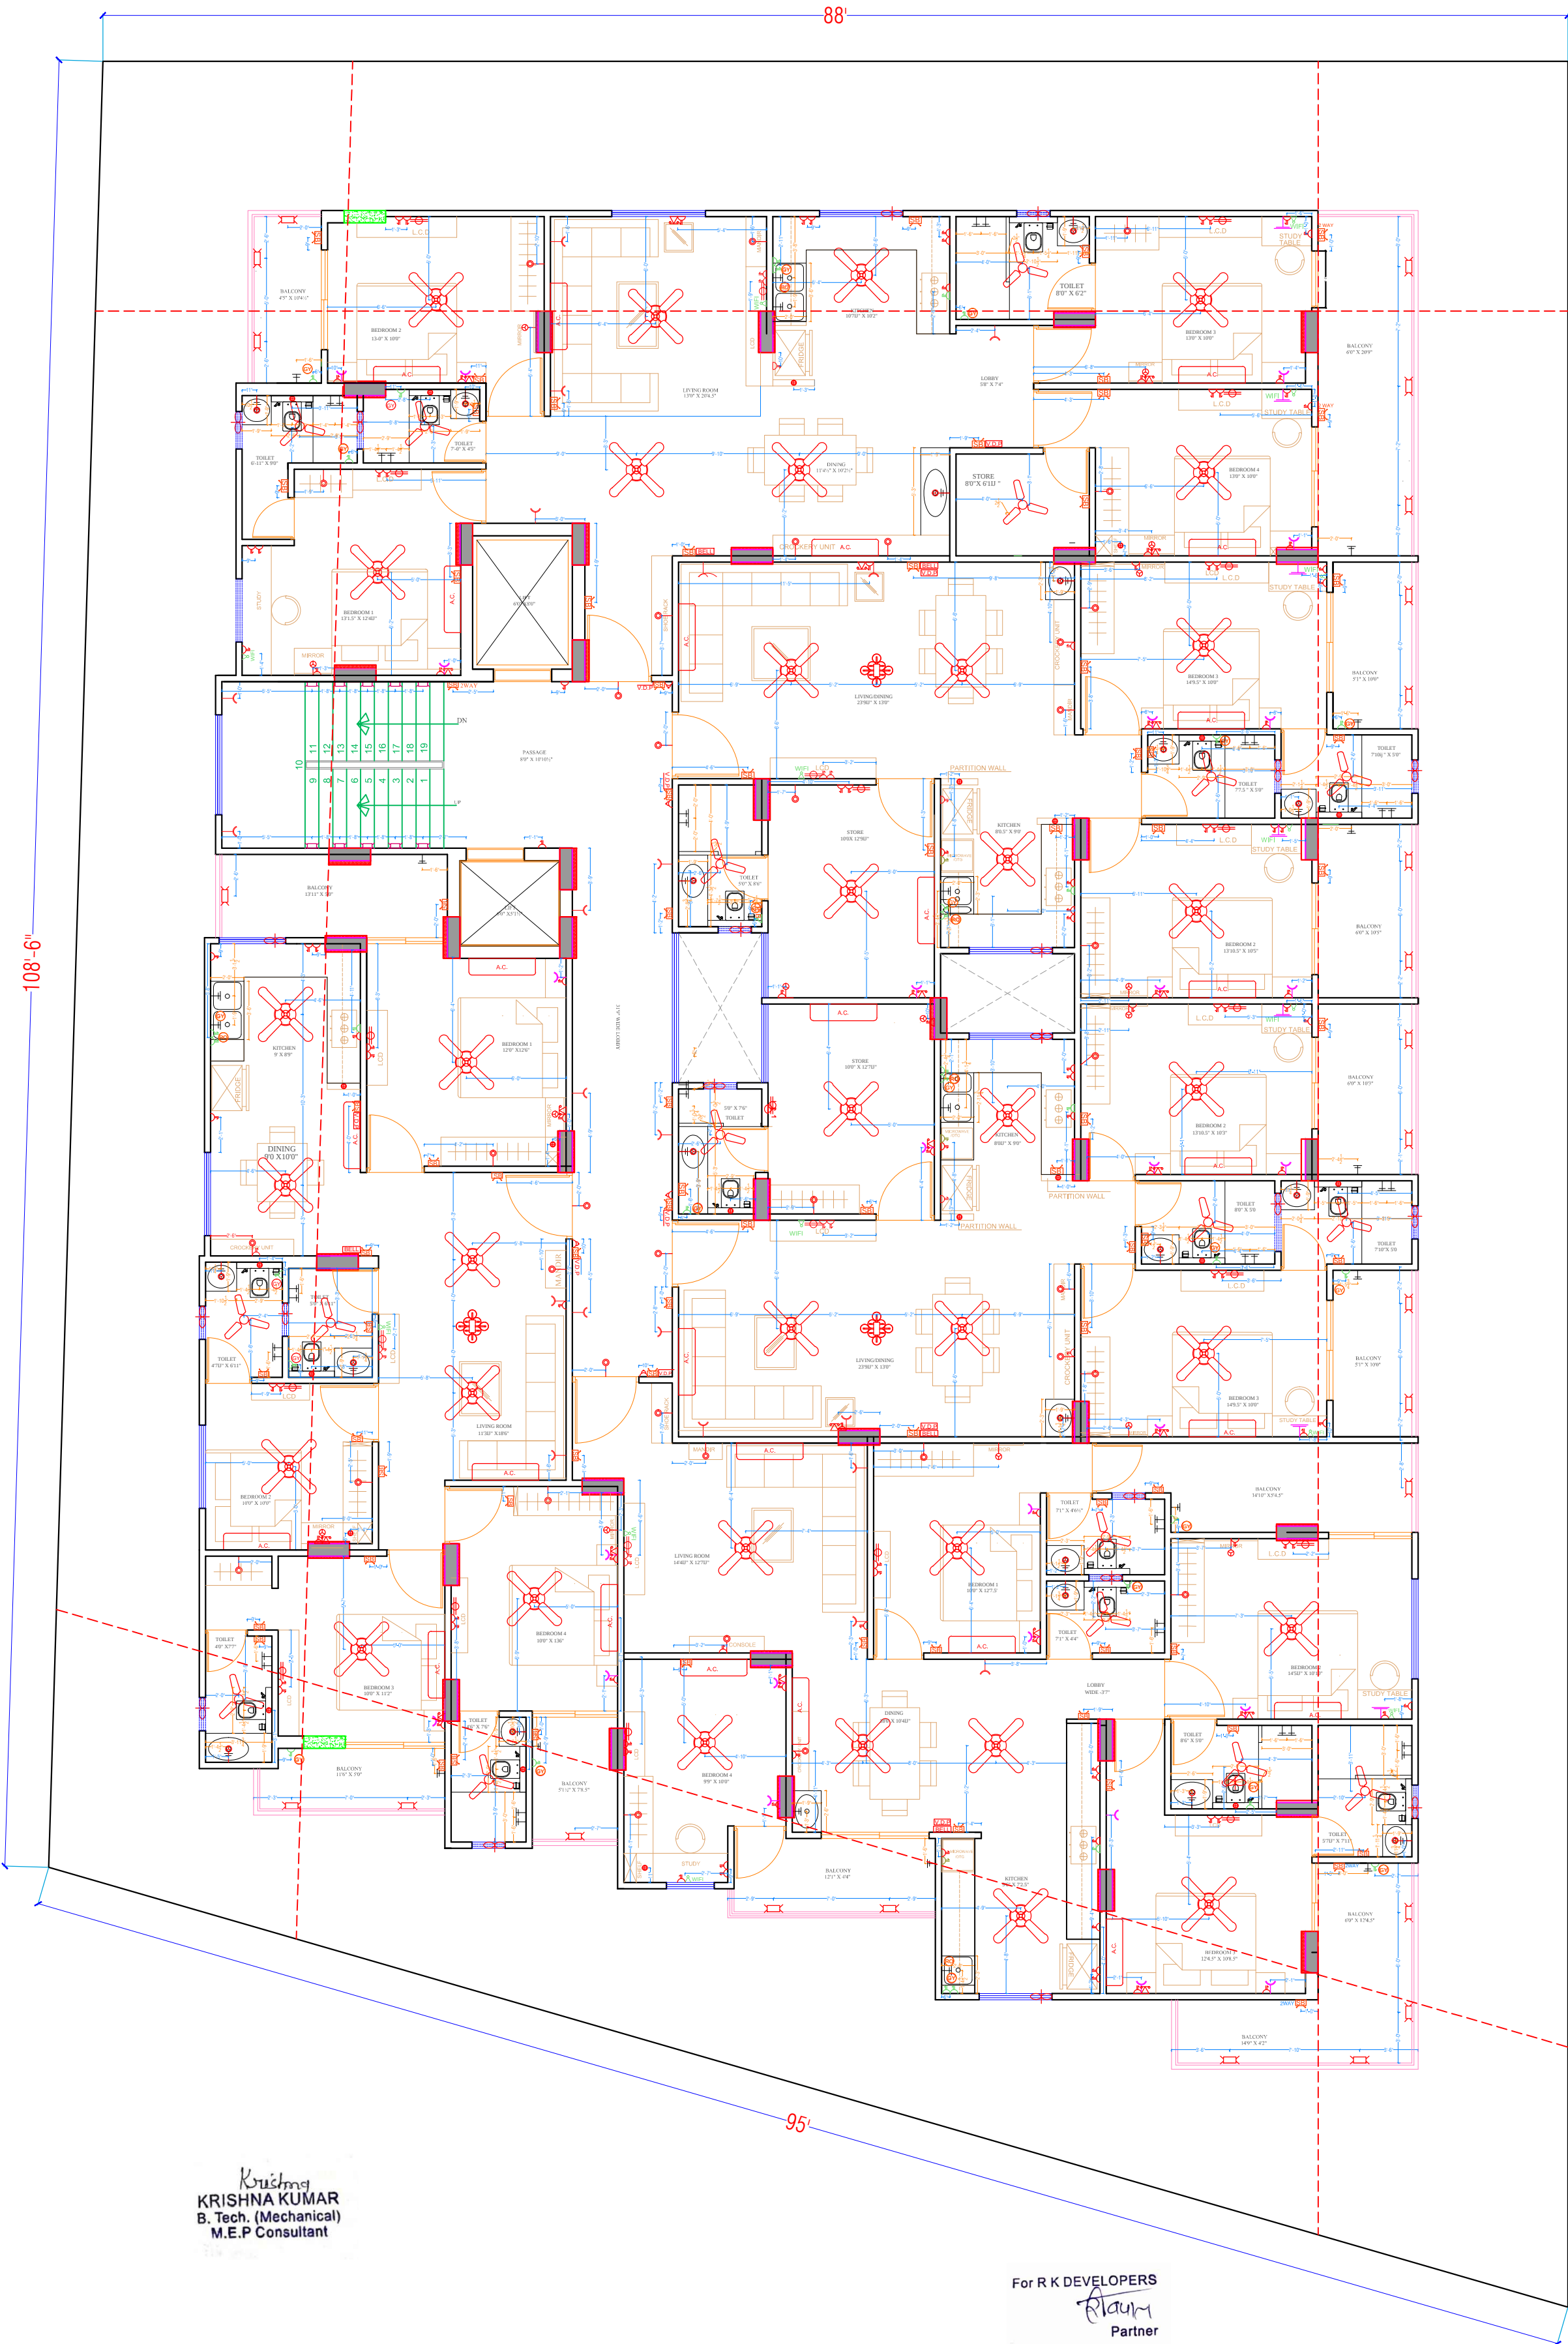

LEGENDS:				
Mounting Height	No.	I D	Symbol	Description
IN FLOOR				CONTROL WIRING
IN CONDUIT				CONTROL WIRING
IN CONDUIT				AC CONTROL WIRING
IN CONDUIT				GYSER CONTROL WIRING
IN CONDUIT				BUZZER CONTROL WIRING
CEILING	FAN 48"			CEILING FAN 48"
CEILING	FAN 30"			CEILING FAN 30"
+90"	TL			1X40W WALL TUBELIGHT
+90"	BULB			WALL BRACKETS AS DESIGN LIGHT
+90"	GL			WALL BRACKETS AS DESIGN FOR GANESH LIGHT
	GL			WALL BRACKETS AS DESIGN FOR GATE LIGHT
CEILING	CFL			CFL CEILING LIGHT
+21"	FL			FOOT LIGHT
+48"	SB			SWITCH BOARD
+75"	ML			1 X 11 W CFL MIRROR LIGHT
VENTILATOR HT.	CR			CEILING ROSE
VENTILATOR HT.	EXP			9" DIA FRESH AIR FAN
+24"	TEL			TELEPHONE POINT
+27"	TV			TV COAXIAL POINT
+27"	LP TV			6 A PLUG POINT FOR TV
+72"	LP-CH			6 A PLUG POINT FOR CHIMNEY
+102"	SAC			SPLIT AC
+102"	PP-SAC			25 A POWER POINT FOR SPLIT AC
+42"	PP-MIX			15 A POWER POINT FOR MIXER
+78"	PP-G			15 A POWER POINT FOR GEYSER
+54"	PP-F			15 A POWER POINT FOR FRIDGE
+78"	PP-WP			15 A POWER POINT FOR WATER PURIFIER
+48"	PP-WM			15 A POWER POINT FOR WASHING MACHINE
+42"	BP			BELL PUSH SWITCH
+90"	BZ			BUZZER POINT
+48"	AC			AC STARTER
+60"	MCB DB			MCB DISTRIBUTION BOARD

WARNING
1. This drawing is the sole copyright of Architects **VISTAAR** and should be used for the purpose expressly issued.

GENERAL NOTES
1. All dimensions are in feet and inches.
2. Do not scale this drawing follow written dimensions only.
3. This drawing should be read in conjunction with other architectural and structural drawings.
4. Any discrepancy in the drawing should be immediately brought to the notice of architect.

PROJECT TITLE
SHREEJI RESIDENCY
BUILDING AT PLOT-1, 1A & 1B,
SCHEME GREEN
VILLAS, VILL. NANDKISHOREPURA URF.
MANYAWAS, JAIPUR

DRAWING TITLE
GROUND TO 4TH.FLOOR WALL ELECTRICAL
PLAN
SERVICE(SLD/DISTRIBUTION DETAILS AFTER LT
PANEL, EARTHING LAYOUT, EXTERNAL LIGHTING
PLAN/LAYOUT, TV & TELEPHONE RISER
DIAGRAM, LIGHTING ARRESTER LOCATION & PIT
LOCATION, COORDINATION DRAWINGS, FIRE
DETECTION & ALARM SYSTEM LAYOUT OF ALL
FLOOR)

ARCHITECTS
VISTAAR ARCHITECTS & PLANNERS
Architects :: Interior Designers
B-2/12, Chittkoot scheme,
main Gandhi Path, Opp mall of Jaipur, Jaipur
PH - 0141-4116461, 09001010366

DATE	DATE	DATE	DATE
17-01-2024			
SCALE	AS SHOWN		
1:1			



Krishna
KRISHNA KUMAR
B. Tech. (Mechanical)
M.E.P Consultant

For R K DEVELOPERS
Raum
Partner

88'

108'-6"

95'

LEGENDS:				
Mounting Height	No.	I D	Symbol	Description
IN FLOOR				CONTROL WIRING
IN CONDUIT				CONTROL WIRING
IN CONDUIT				AC CONTROL WIRING
IN CONDUIT				GYSER CONTROL WIRING
IN CONDUIT				BUZZER CONTROL WIRING
CEILING	FAN 48"			CEILING FAN 48"
CEILING	FAN 30"			CEILING FAN 30"
+90"	TL			1X40W WALL TUBELIGHT
+90"	BULB			WALL BRACKETS AS DESIGN LIGHT
+90"	GL			WALL BRACKETS AS DESIGN FOR GANESH LIGHT
	GL			WALL BRACKETS AS DESIGN FOR GATE LIGHT
CEILING	CFL			CFL CEILING LIGHT
+21"	FL			FOOT LIGHT
+48"	SB			SWITCH BOARD
+75"	ML			1 X 11 W CFL MIRROR LIGHT
VENTILATOR HT.	CR			CEILING ROSE
VENTILATOR HT.	EXP			9" DIA FRESH AIR FAN
+24"	TEL			TELEPHONE POINT
+27"	TV			TV COAXIAL POINT.
+27"	LP TV			6 A PLUG POINT FOR TV
+72"	LP-CH			6 A PLUG POINT FOR CHIMNEY
+102"	SAC			SPLIT AC
+102"	PP-SAC			25 A POWER POINT FOR SPLIT AC
+42"	PP-MIX			15 A POWER POINT FOR MIXER
+78"	PP-G			15 A POWER POINT FOR GEYSER
+54"	PP-F			15 A POWER POINT FOR FRIDGE
+78"	PP-WP			15 A POWER POINT FOR WATER PURIFIER
+48"	PP-WM			15 A POWER POINT FOR WASHING MACHINE
+42"	BP			BELL PUSH SWITCH
+90"	BZ			BUZZER POINT
+48"	AC			AC STARTER
+60"	MCB DB			MCB DISTRIBUTION BOARD

134'-102"

WARNING

1. This drawing is the sole copyright of Architects VISTAAR and should be used for the purpose expressly issued.

GENERAL NOTES

1. All dimensions are in feet and inches.
2. Do not scale this drawing follow written dimensions only.
3. This drawing should be read in conjunction with other architectural and structural drawings.
4. Any discrepancy in the drawing should be immediately brought to the notice of architect.

PROJECT TITLE

SHREEJI RESIDENDY
BUILDING AT PLOT-1, 1A & 1B,
SCHEME GREEN
VILLAS,VILL.NANDKISHOREPURA URF.
MANYAWAS,JAIPUR

DRAWING TITLE

5TH.FLOOR CEILING ELECTRICAL PLAN

ARCHITECTS


VISTAAR ARCHITECTS &
PLANNERS
Architects :: Interior Designers
B-2/12, Chitrkoot scheme,
main Gandhi Path Opp mall of jaipur,Jaipur
PH. - 0141-4116461,09001010366

DATE	DATE	DATE
17-01-2024		
SCALE	AS SHOWN	
1/11		



Krishna
KRISHNA KUMAR
B. Tech. (Mechanical)
M.E.P Consultant

For R K DEVELOPERS
Partner

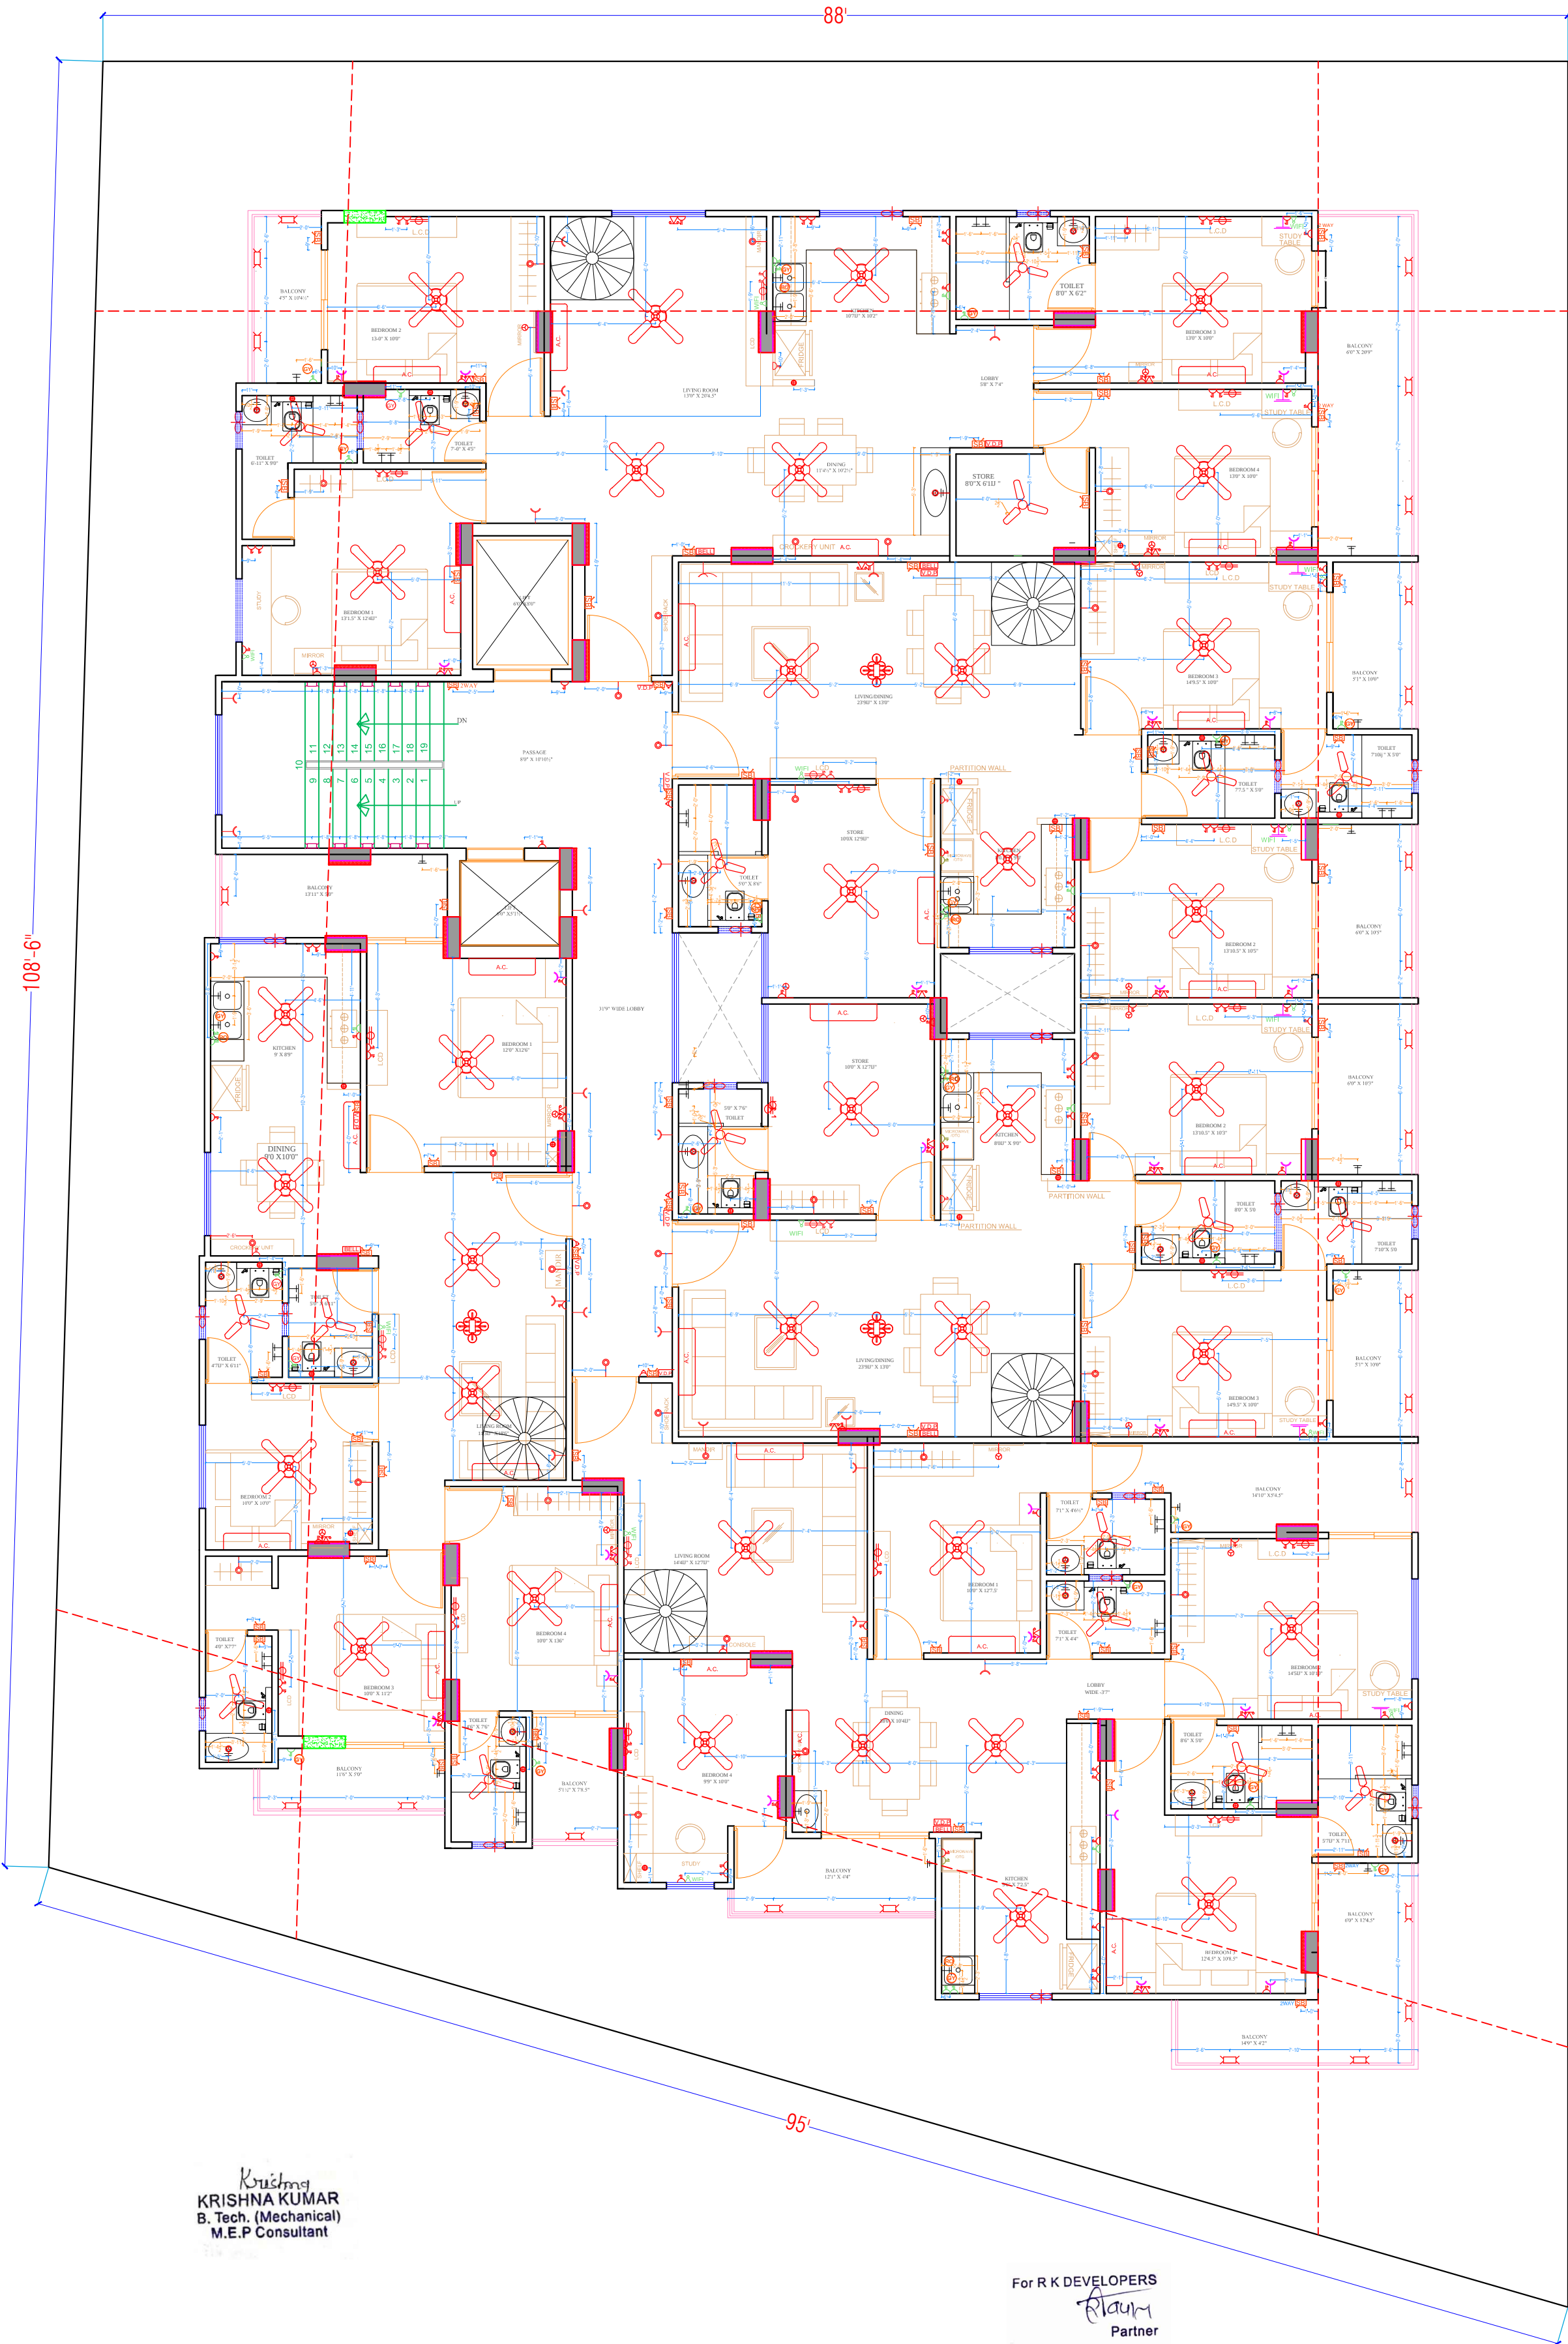

LEGENDS:				
Mounting Height	No.	I D	Symbol	Description
IN FLOOR				CONTROL WIRING
IN CONDUIT				CONTROL WIRING
IN CONDUIT				AC CONTROL WIRING
IN CONDUIT				GYSER CONTROL WIRING
IN CONDUIT				BUZZER CONTROL WIRING
CEILING	FAN/48"			CEILING FAN 48"
CEILING	FAN/30"			CEILING FAN 30"
+90"	TL			1X40W WALL TUBELIGHT
+90"	BULB			WALL BRACKETS-AS DESIGN LIGHT
+90"	GL			WALL BRACKETS-AS DESIGN FOR GANESH LIGHT
	GL			WALL BRACKETS-AS DESIGN FOR GATE LIGHT
CEILING	CFL			CFL CEILING LIGHT
+21"	FL			FOOT LIGHT
+48"	SB			SWITCH BOARD
+75"	ML			1 X 11 W CFL MIRROR LIGHT
VENTILATOR HT.	CR			CEILING ROSE
VENTILATOR HT.	EXP			9" DIA FRESH AIR FAN
+24"	TEL			TELEPHONE POINT
+27"	TV			TV COAXIAL POINT
+27"	LP TV			6 A PLUG POINT FOR TV
+72"	LP-CH			6 A PLUG POINT FOR CHIMNEY
+102"	SAC			SPLIT AC
+102"	PP-SAC			25 A POWER POINT FOR SPLIT AC
+42"	PP-MIX			15 A POWER POINT FOR MIXER
+78"	PP-G			15 A POWER POINT FOR GEYSER
+54"	PP-F			15 A POWER POINT FOR FRIDGE
+78"	PP-WP			15 A POWER POINT FOR WATER PURIFIER
+48"	PP-WM			15 A POWER POINT FOR WASHING MACHINE
+42"	BP			BELL PUSH SWITCH
+90"	BZ			BUZZER POINT
+48"	AC			AC STARTER
+60"	MCB DB			MCB DISTRIBUTION BOARD

WARNING
1. This drawing is the sole copyright of Architects **VISTAAR** and should be used for the purpose expressly issued.

- GENERAL NOTES**
1. All dimensions are in feet and inches.
 2. Do not scale this drawing follow written dimensions only.
 3. This drawing should be read in conjunction with other architectural and structural drawings.
 4. Any discrepancy in the drawing should be immediately brought to the notice of architect.

PROJECT TITLE
SHREEJI RESIDENCY
BUILDING AT PLOT-1, 1A & 1B,
SCHEME GREEN
VILLAS,VILL.NANDKISHOREPURA URF.
MANYAWAS,JAIPUR

DRAWING TITLE
5TH. FLOOR WALL ELECTRICAL PLAN
SERVICE(SLD/DISTRIBUTION DETAILS AFTER LT
PANEL, EARTHING LAYOUT, EXTERNAL LIGHTING
PLAN, LAYOUT TV & TELEPHONE RISER
DIAGRAM, LIGHTING ARRESTER LOCATION & PIT
LOCATION, COORDINATION DRAWINGS, FIRE
DETECTION & ALARM SYSTEM LAYOUT OF ALL
FLOOR)

ARCHITECTS
**VISTAAR ARCHITECTS &
PLANNERS**
Architects :: Interior Designers
B-2/12, Chitrkoot scheme,
main Gandhi Path, Opp mall of jaipur, Jaipur
PH- 0141-4116461, 09001010366

DATE	DATE	DATE	DATE
17-01-2024			
SCALE	ASB 1:1		
1:1			





WARNING

1. This drawing is the sole copyright of Architects **VISTAAR** and should be used for the purpose expressly issued.

GENERAL NOTES

- All dimensions are in feet and inches.
- Do not scale this drawing follow written dimensions only.
- This drawing should be read in conjunction with other architectural and structural drawings.
- Any discrepancy in the drawing should be immediately brought to the notice of architect.

PROJECT TITLE

SHREEJI RESIDENDY
BUILDING AT PLOT-1, 1A & 1B,
SCHEME GREEN
VILLAS,VILLNANDKISHOREPURA URF,
MANYAWAS,JAIPUR

DRAWING TITLE


TELEPHONE
SINGLE LINE DIAGRAM

ARCHITECTS

**VISTAAR ARCHITECTS &
PLANNERS**
Architects - Interior Designers
B-212, DLF Cyber City,
Main Sector 29, Gurgaon, Haryana
PH. - 0141-4116461, 09901010366

DATE	REVISION	BY	DATE
17-07-2024			
17-07-2024			
17-07-2024			
17-07-2024			

NOTE:- THIS SLD HAS BEEN PREPARED AS PER CONCEPT STAGE DATA AVAILABLE WITH US. KINDLY CONTACT US FOR FINAL SLD & DETAILS BEFORE PLACING ORDER FOR FABRICATION. WE SHALL NOT BE RESPONSIBLE, IF THE PANELS ARE UNDER UTILISED OR OVER LOADED AT ANY STAGE.

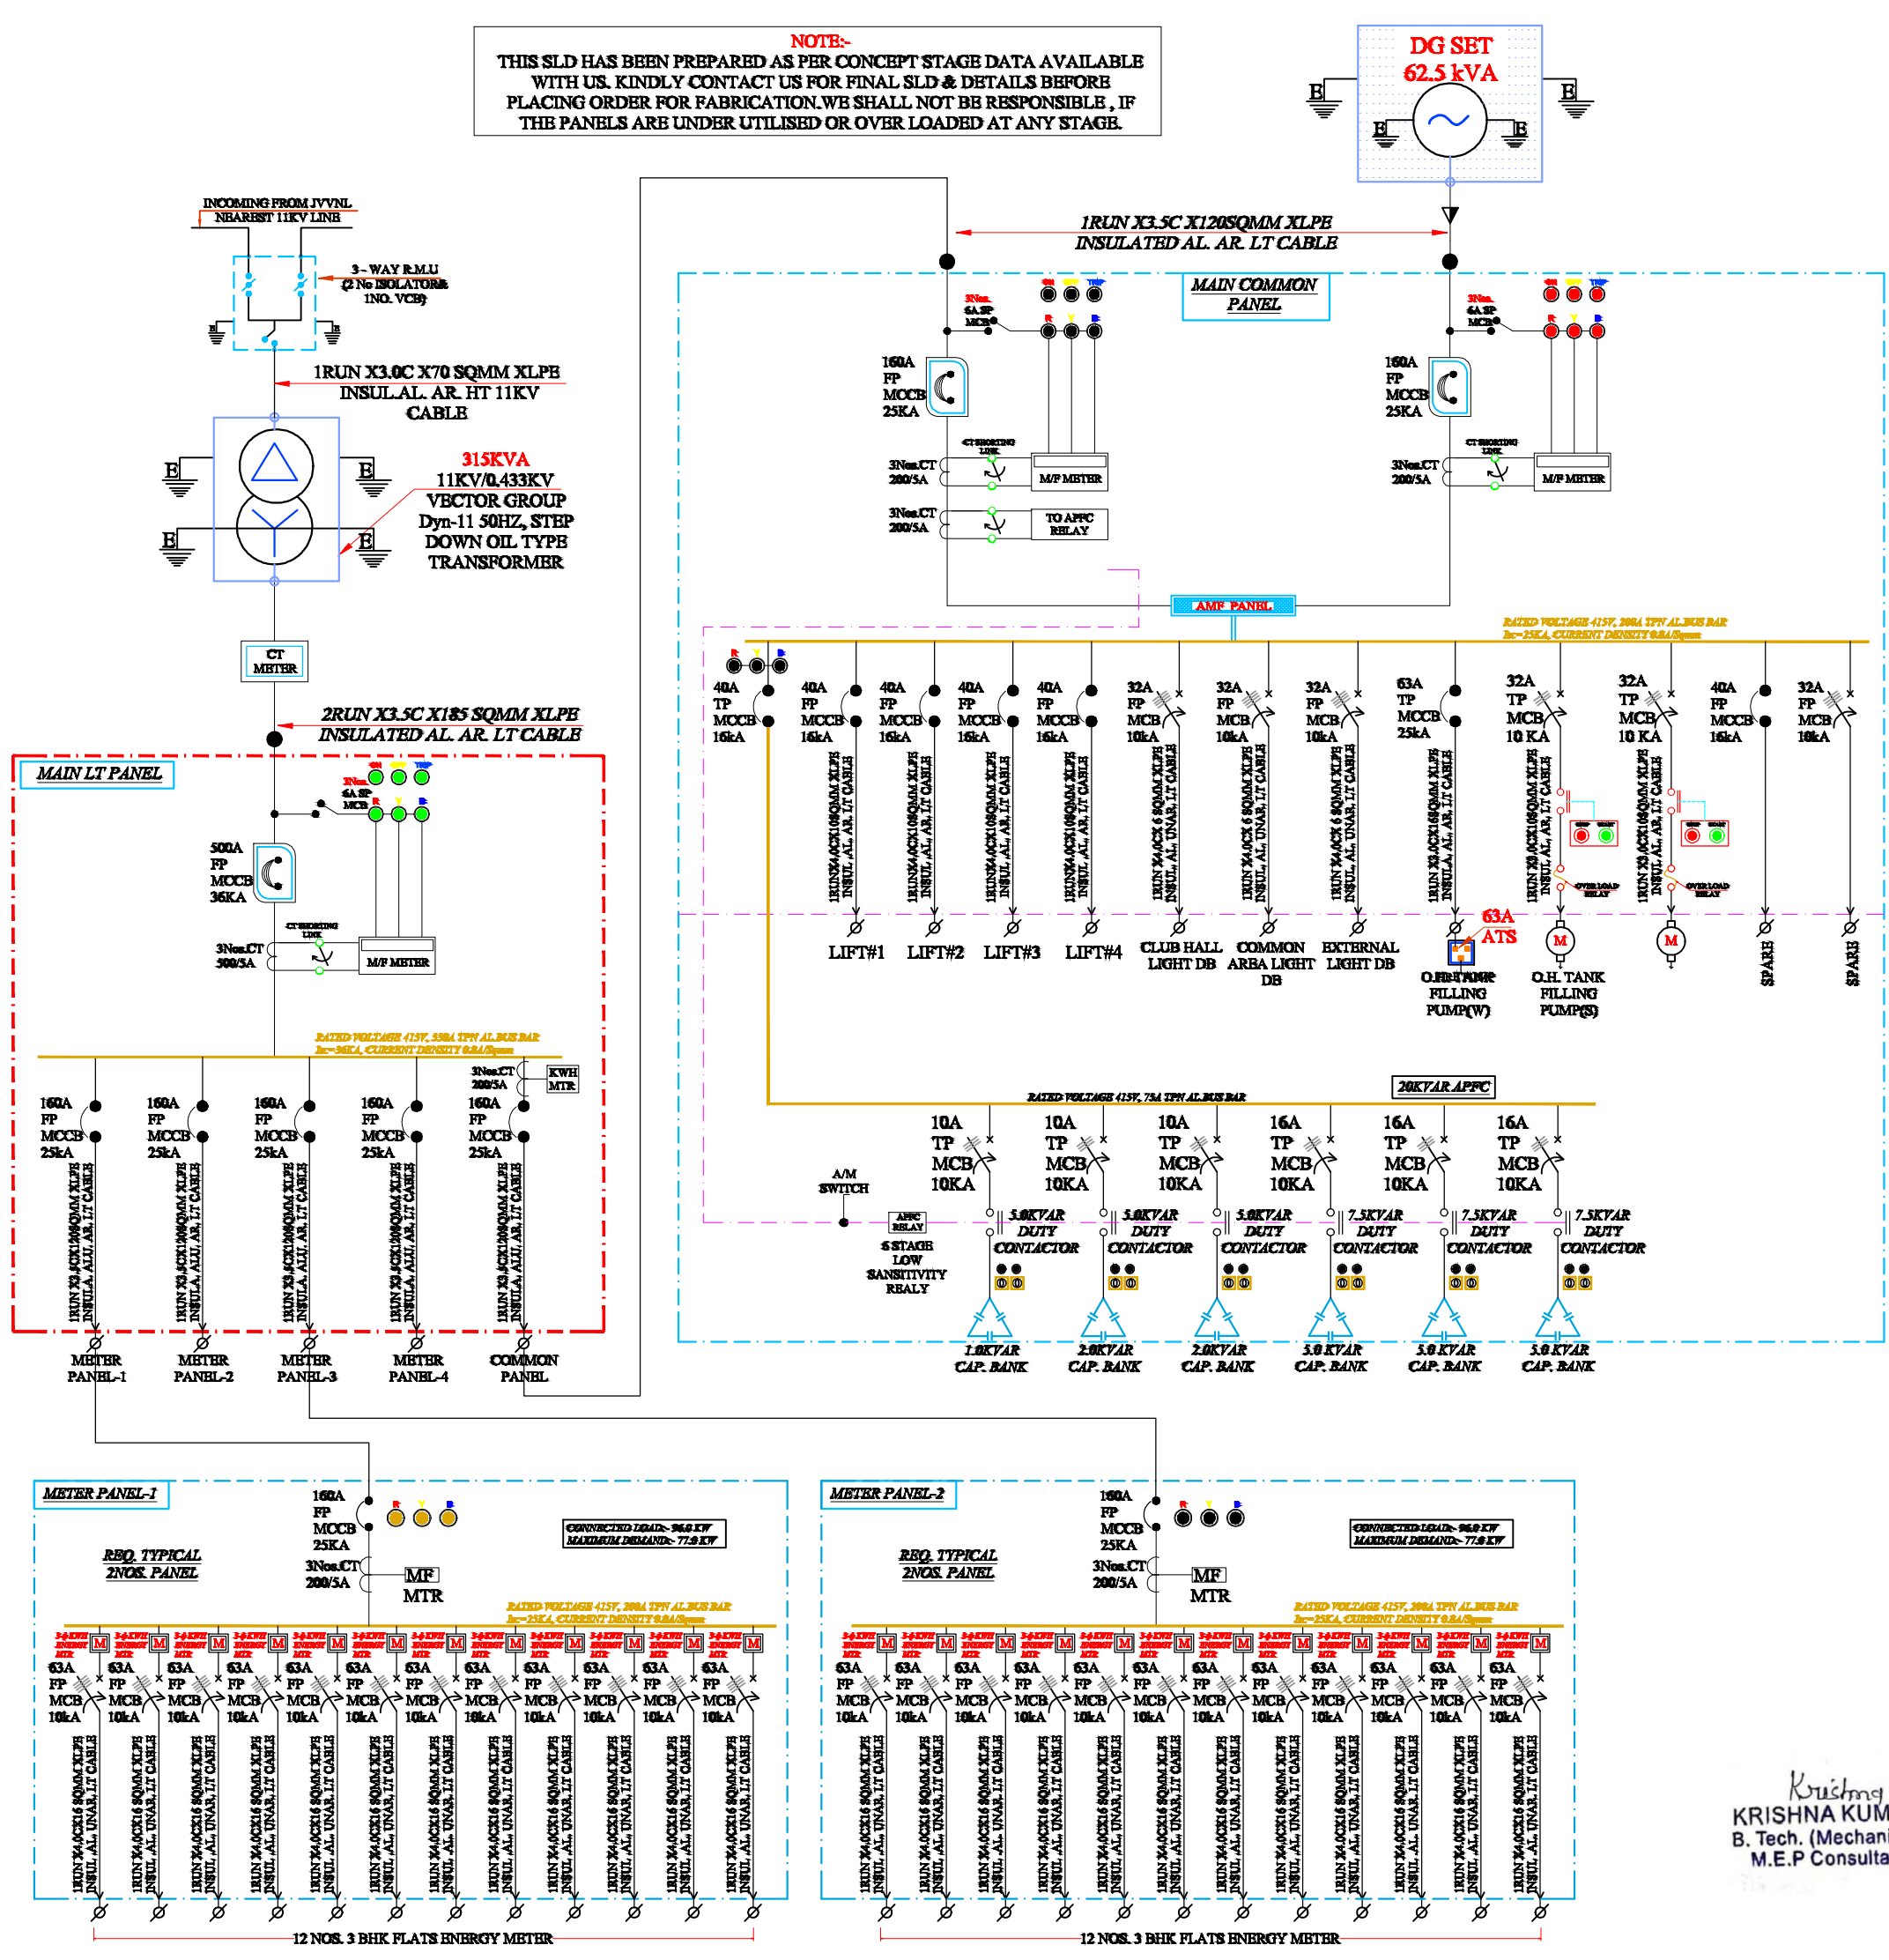

For R K DEVELOPERS
Partner

WARNING
1. This drawing is the sole copyright of Architects **VISTAAR** and should be used for the purpose expressly issued.

GENERAL NOTES
1. All dimensions are in feet and inches.
2. Do not scale this drawing follow written dimensions only.
3. This drawing should be read in conjunction with other architectural and structural drawings.
4. Any discrepancy in the drawing should be immediately brought to the notice of architect.

PROJECT TITLE	
SHREEJI RESIDENDY BUILDING AT PLOT-1, 1A & 1B, SCHEME GREEN VILLAS, VILL. NANDKISHOREPURA URF. MANYAWAS, JAIPUR	
DRAWING TITLE	
ALL DISTRIBUTION PANEL SINGLE LINE DIAGRAM	
ARCHITECTS :	
VISTAAR ARCHITECTS & PLANNERS Architects :: Interior Designers B-2/12, Chitrkoot scheme, main Gandhi Path, Opp mall of jaipur, Jaipur PH- 0141-4116461, 09001010366	
PATH -	
DEN.	DATE
MANUJ KUMAR	17-07-2024
SCALE	JOB NO.
NTS	
REV.	
NORTH	