


SCHEMATIC DIAGRAM
LIGHTNING PROTECTION SYSTEM

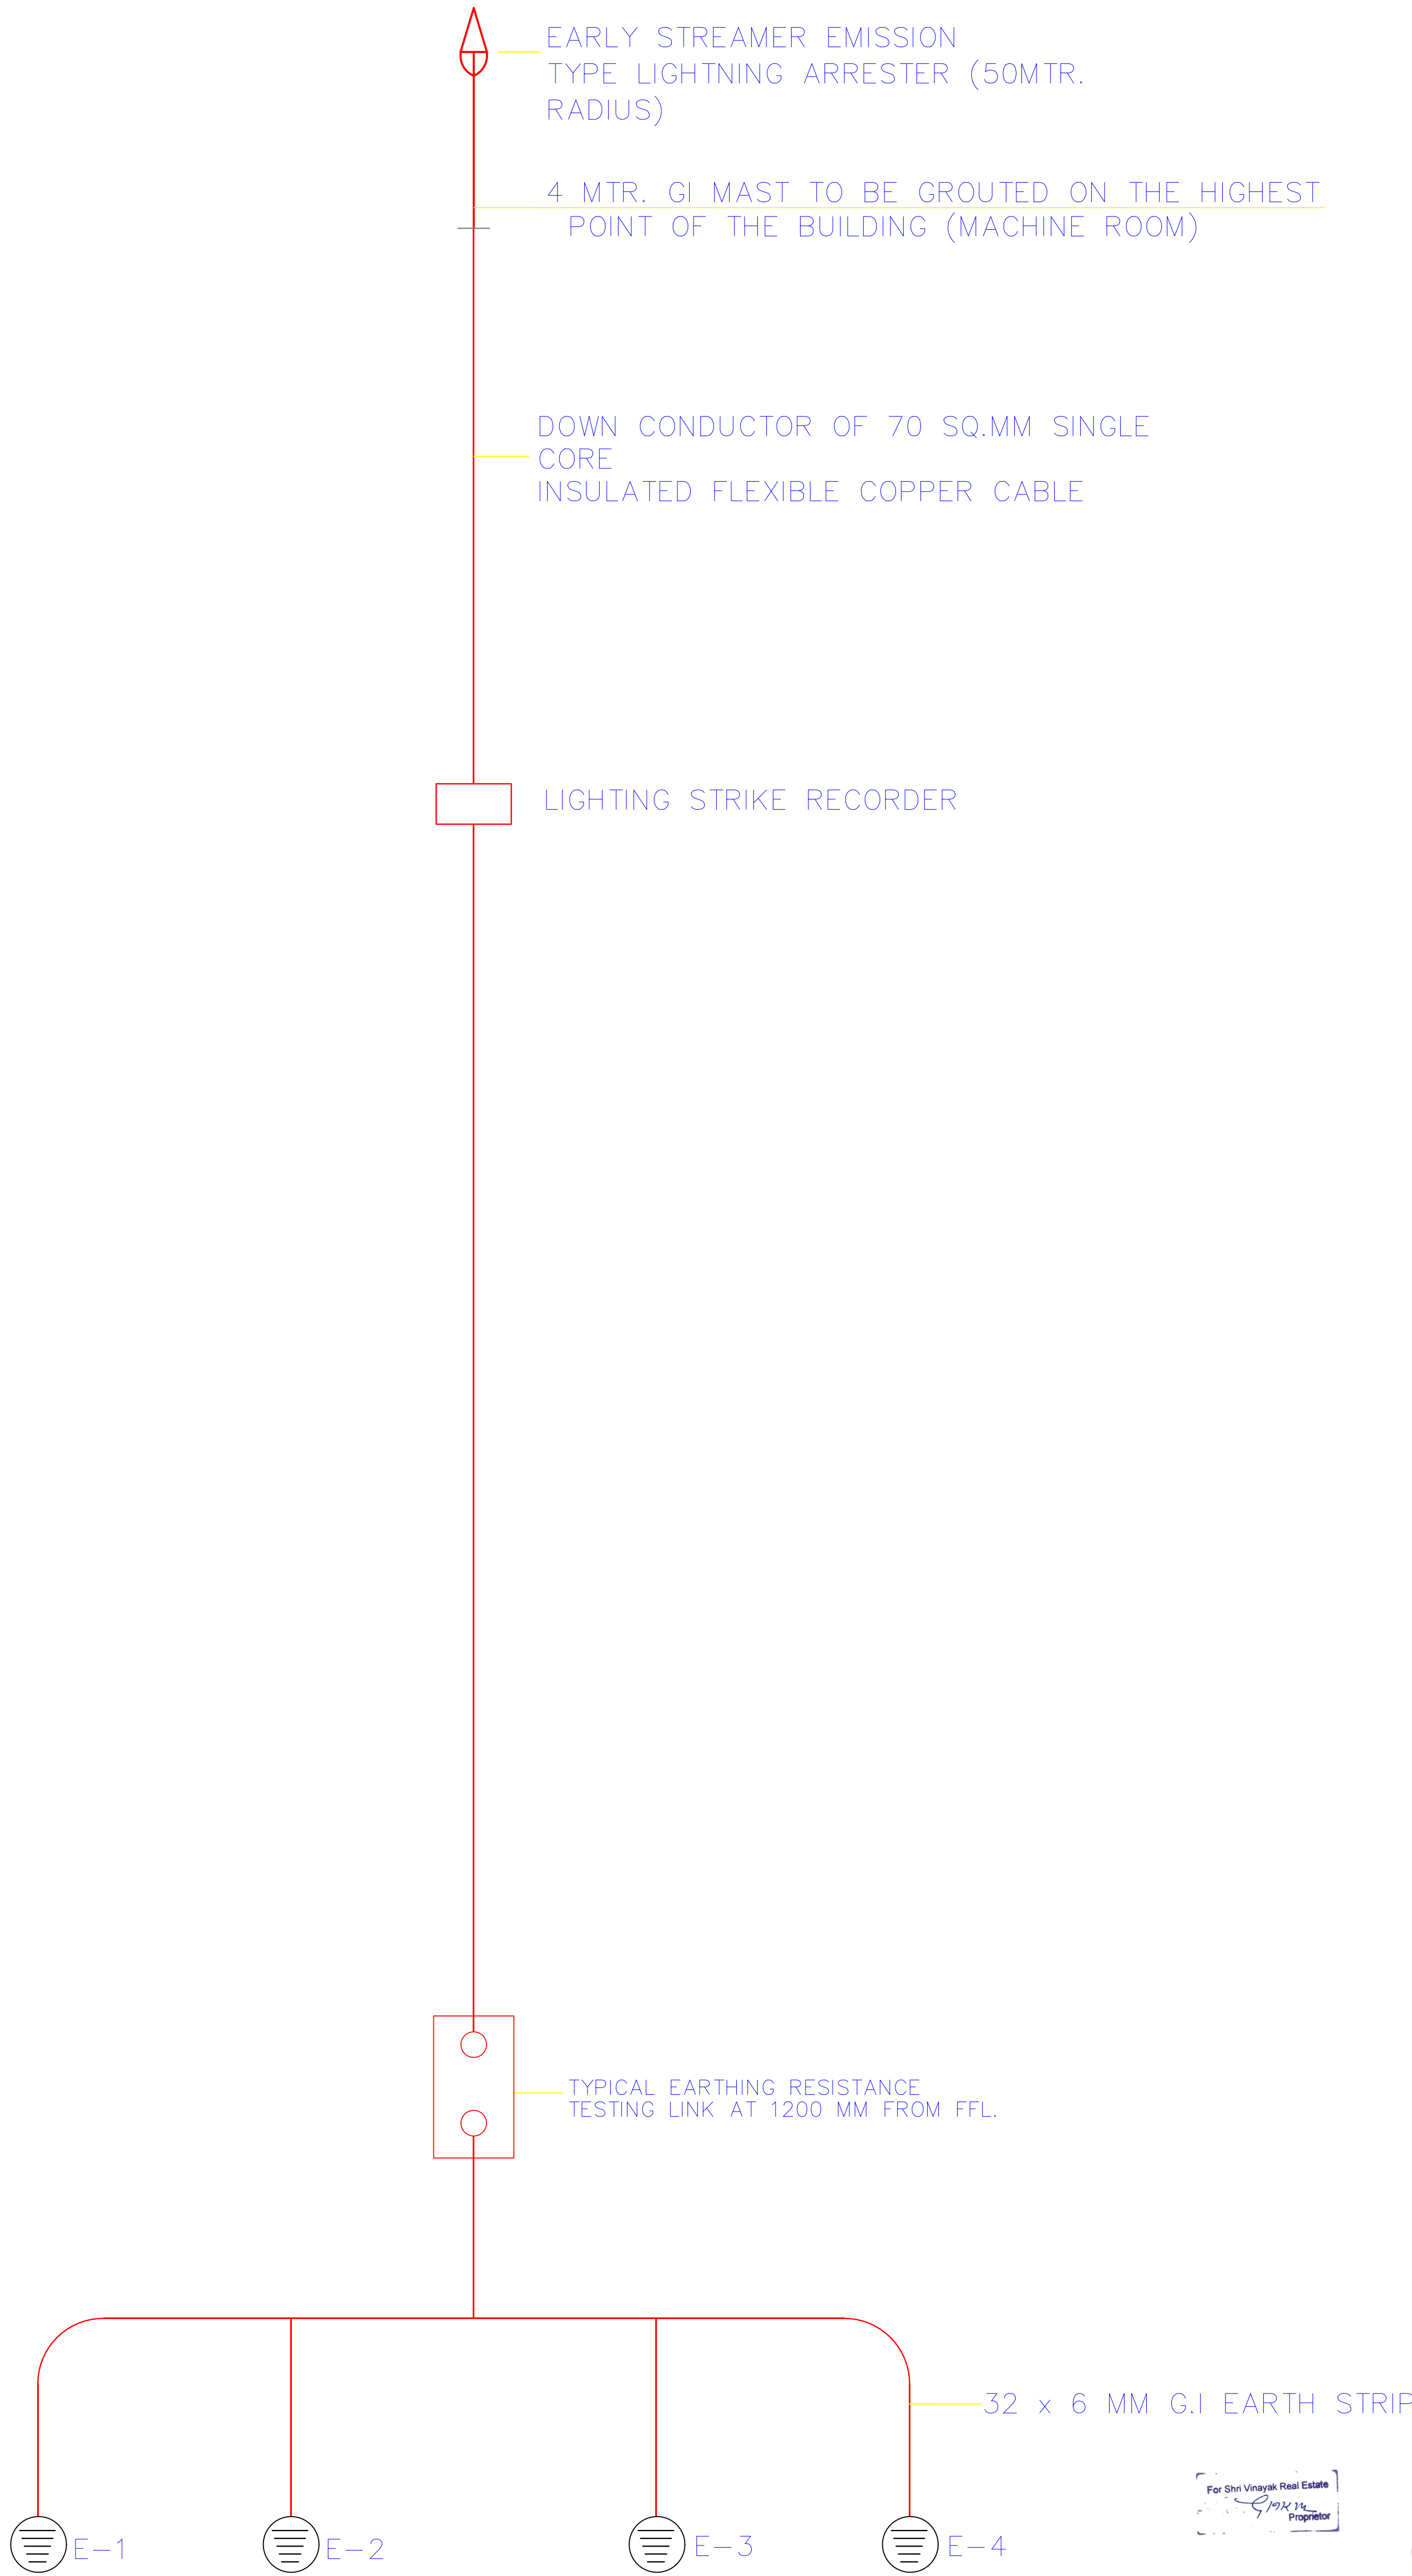


LIGHTENING ARRESTOR SLD

REVISION – 00

GENERAL NOTES :

1. ALL THE DIMENSIONS ON THE DRAWING ARE IN WRITTEN.
2. ONLY WRITTEN DIMENSIONS ARE TO BE FOLLOWED, DRAWING SHOULD NOT BE SCALED IN ANY CIRCUMSTANCES.
3. ALL MEASUREMENTS MUST BE CHECKED AND VERIFIED BY THE CONTRACTORS PRIOR TO EXECUTION OF WORK AT THE SITE.
4. THIS DRAWING IS TO BE READ IN CONJUNCTION WITH ALL RELEVANT STRUCTURAL, ARCHITECTURAL & FACILITY PLANNING DRAWINGS.
5. ANY DISCREPANCIES MUST BE BROUGHT TO THE NOTICE OF THE ENGINEER IMMEDIATELY & PRIOR TO EXECUTION AT SITE.
6. CO-ORDINATION WITH SERVICES SUCH AS HVAC, PLUMBING & ELECTRICAL, ETC. IS THE RESPONSIBILITY OF THE CONTRACTORS.
7. FOR DETAILS, REFER RELEVANT LARGE SCALE DETAIL DRGS. AS INDICATED.

ARCHITECT

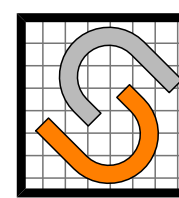 THE **URBAN SQUARE**
ARCHITECT , PLANNER , BPAS
BAPU NAGAR JAIPUR, (RAJ.)
Mobile- 9461302542

For Shri Vinayak Real Estate
Proprietor

PROJECT :-

VINAYAK RESIDENCY I
PROPOSED BUILDING AT PLOT.NO.62,63(West Part),66 (West Part) & 67, PARMANAND NAGAR, NIWAROO ROAD,JHOTWARA,JAIPUR

BUILDER/DEVELOPER/CLIENT:-


DRAWING TITLE:-

LIGHTING ARRESTOR SLD

SUBMITTED FOR :-

PRELIMINARY	☐	APPROVAL	☒
PROPOSAL	☐	GFC	☐


DATE :-	18-03-2024
DRAWN :-	MO.AJARUDIN
APPROVED :-	NARESH

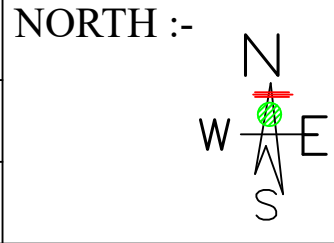

DRAWING NO.:-

SCALE :-

MEP SERVICES CONSULTANT
AMP INFRA SERVICES
VILLA NO 16. SHUBHASIS GEETA
JAISINGHPURA, BHANKROTA &
CHIMANPURA.JAIPUR 302026
EMAIL ID- ampinfrajpr@gmail.com
CONTACT NO. :- 9462866389

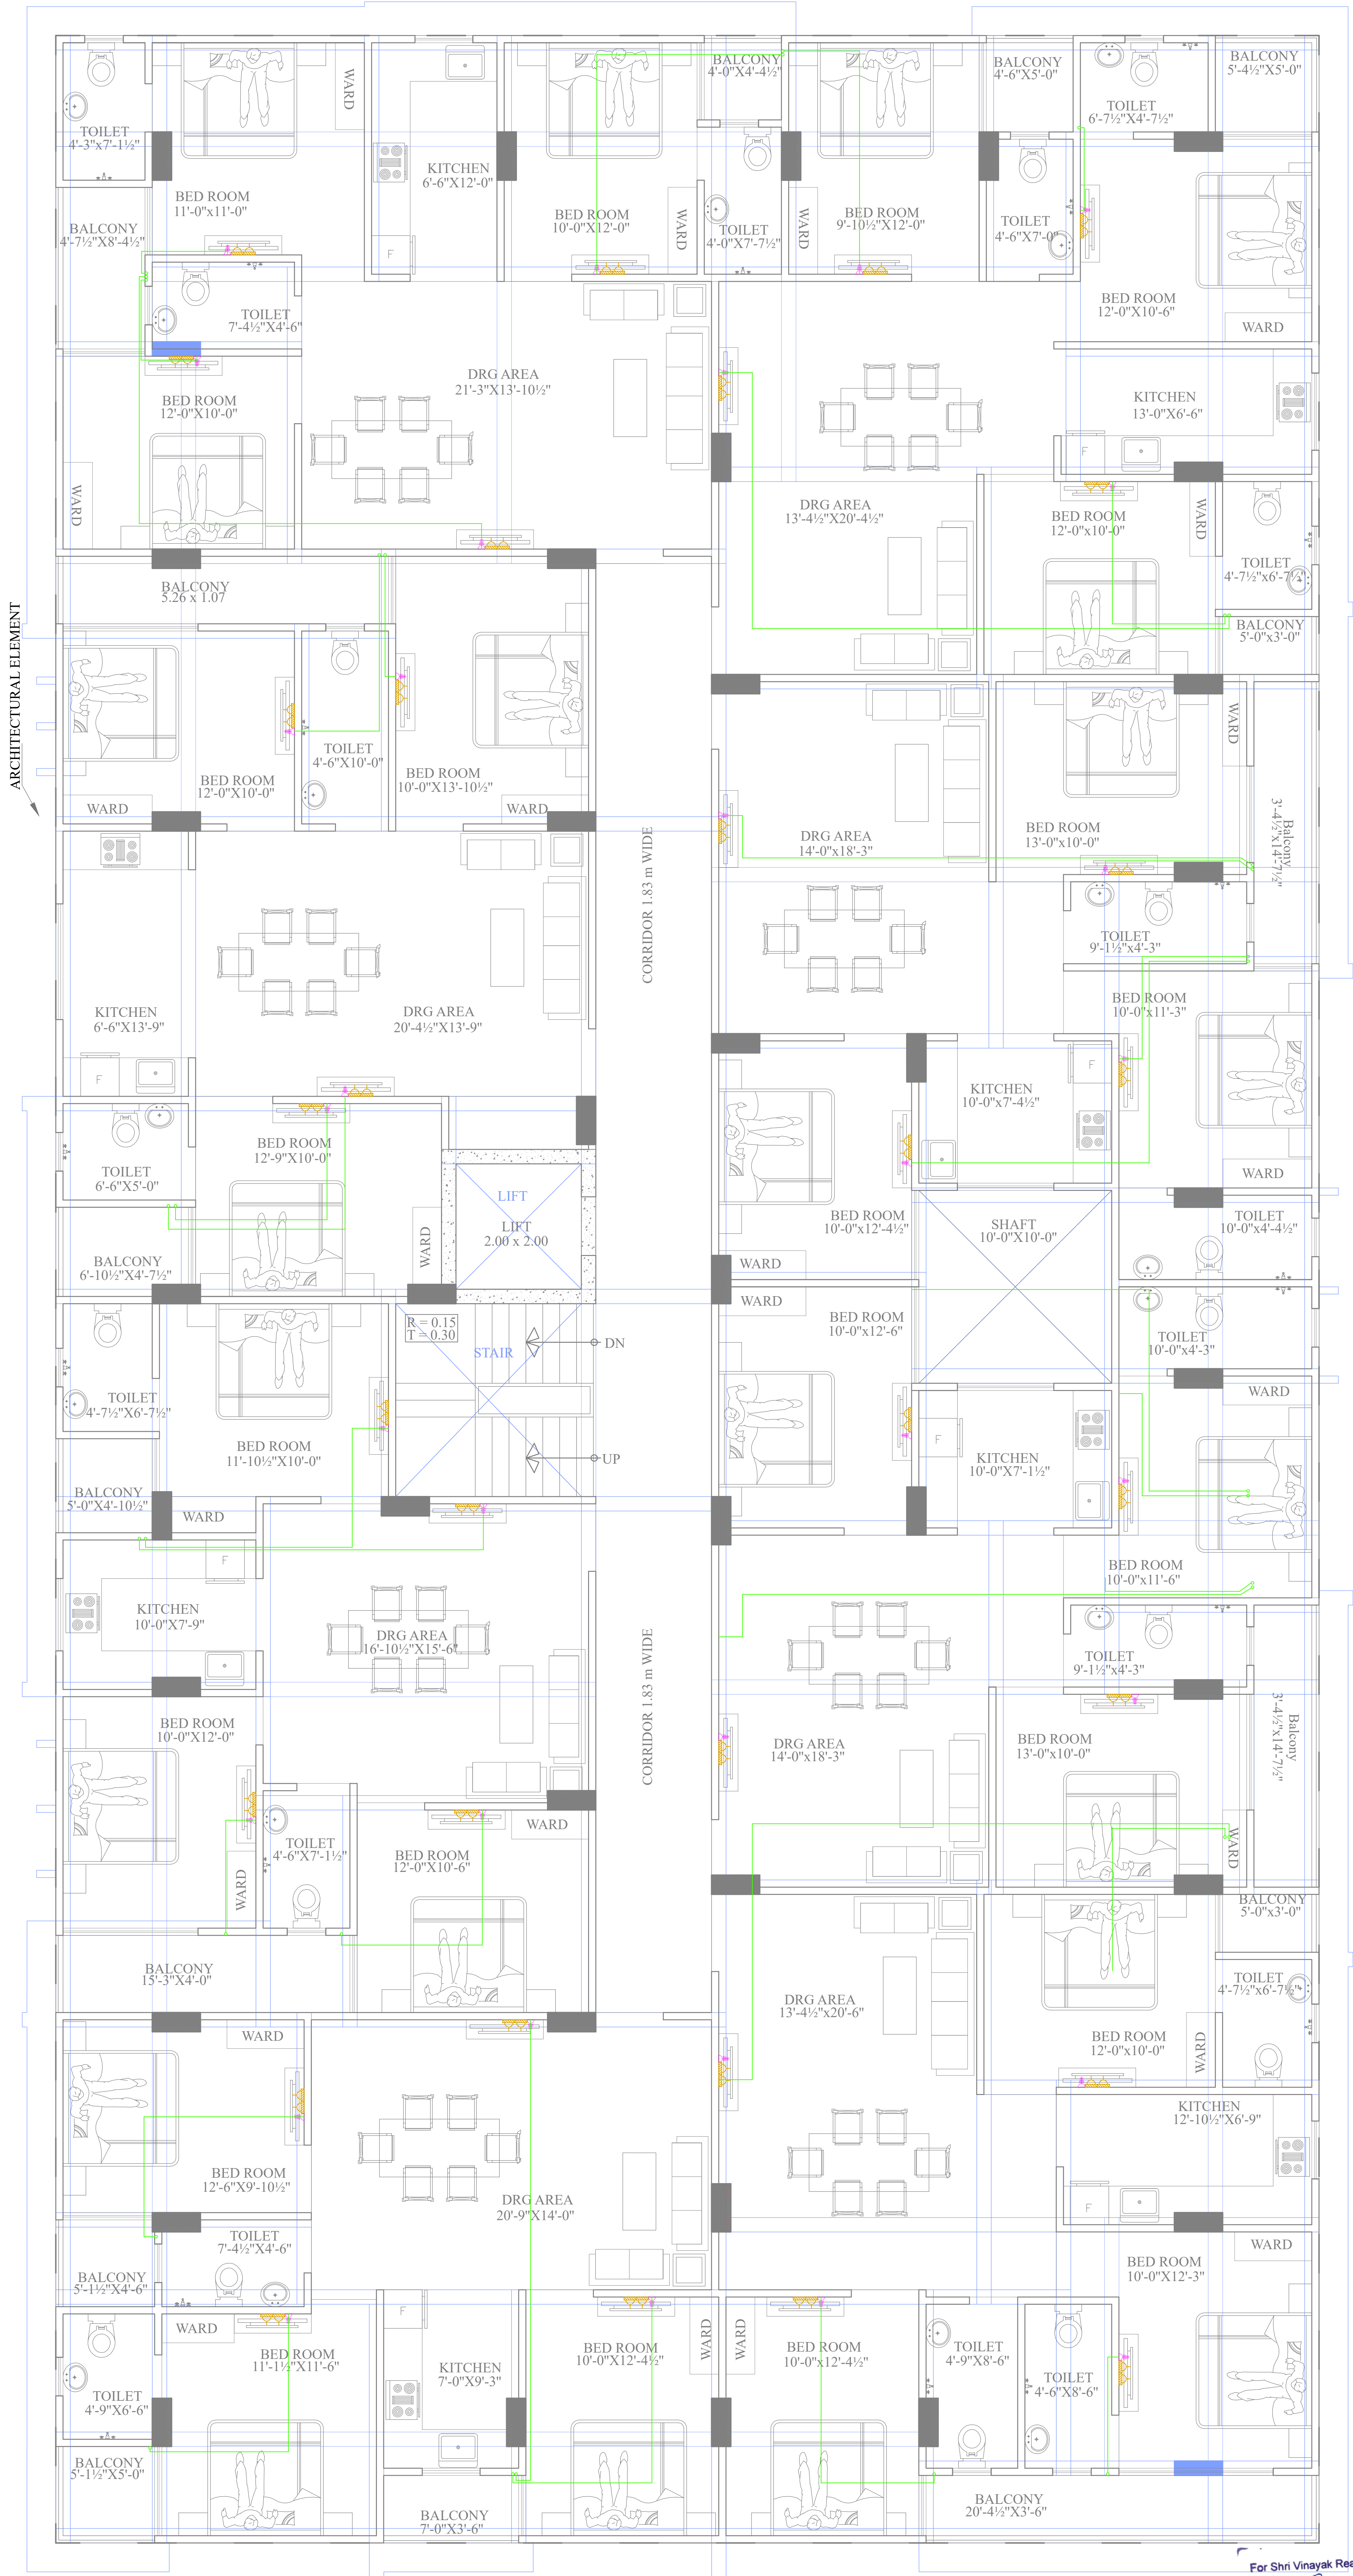

ELECTRICAL LEGEND			
SR.NO.	SYMBOL	DESCRIPTION	HIGHT FROM FFL
1		LED LIGHT POINT AT WALL	+7'-6"
2		LED LIGHT POINT AT CEILING	Ceiling
3		LED TUBE LIGHT POINT	+7'-6"
4		CEILING FAN	Ceiling
5		6A. SOCKET WITH SWITCH General Point	+1'-9"
6		SWITCH BOARD WITH SOCKET	+4'-0"
7		TV CABLE POINT	+2'-6"
8		EXHAUST FAN	Vent. Ht.
9		BELL PUSH	+4'-0"
10		BELL BUZZER	+7'-6"
11		DISTRIBUTION BOARD	+5'-6"
12		2no. 6A. Socket With Switch for TV Supply	+2'-6"
13		6A. Socket With Switch for RO	+4'-6"
14		6A. Socket With Switch for Chimney Point	+5'-6"
15		16A. Socket With Switch for Washing Machine Point	+4'-0"
16		16A. Socket With Switch for Geyser Point	+6'-0"
17		16A. Socket With Switch General Point	+1'-3/4'-0"
18		16A. Socket With Switch for Microwave & Grinder Point	+4'-6"
19		32MM Ø CONDUIT FOR SUBMAIN WIRING	Ceiling
20		3X1 SQMM POINT WIRING	Ceiling
21		2X2.5 + 1X1.5 SQMM LIGHT CIRCUIT WIRING	Ceiling
22		2X4 + 1X2.5 SQMM LIGHT CIRCUIT WIRING	Ceiling
23		16A. SOCKET WITH SWITCH FOR FRIDGE	+4'-0"
24		CEILING ROSE	Vent. Ht.
25		25mm Ø TV Cable Conduit	Ceiling/Flooring
26		25A. AC Socket with Switch	+7'-6"

REVISION — 00

GENERAL NOTES :

1. ALL THE DIMENSIONS ON THE DRAWING ARE IN WRITTEN.
2. ONLY WRITTEN DIMENSIONS ARE TO BE FOLLOWED, DRAWING SHOULD NOT BE SCALED IN ANY CIRCUMSTANCES.
3. ALL MEASUREMENTS MUST BE CHECKED AND VERIFIED BY THE CONTRACTORS PRIOR TO EXECUTION OF WORK AT THE SITE.
4. THIS DRAWING IS TO BE READ IN CONJUNCTION WITH ALL RELEVANT STRUCTURAL, ARCHITECTURAL & FACILITY PLANNING DRAWINGS.
5. ANY DISCREPANCIES MUST BE BROUGHT TO THE NOTICE OF THE ENGINEER IMMEDIATELY & PRIOR TO EXECUTION AT SITE.
6. CO-ORDINATION WITH SERVICES SUCH AS HVAC, PLUMBING & ELECTRICAL, ETC. IS THE RESPONSIBILITY OF THE CONTRACTORS.
7. FOR DETAILS, REFER RELEVANT LARGE SCALE DETAIL DRGS. AS INDICATED.


Er. RAKESH
B.Tech. (Electrical Engineering)

ARCHITECT

 **THE URBAN SQUARE**
ARCHITECT , PLANNER , BPAS
BAPU NAGAR JAIPUR, (RAJ.)
Mobile- 9461302542

PROJECT :-

 
VINAYAK RESIDENCY I
PROPOSED BUILDING AT PLOT.NO.62,63(West Part),66 (West Part) & 67, PARMANAND NAGAR, NIWAROO ROAD,JHOTWARA,JAIPUR

BUILDER/DEVELOPER/CLIENT:-


DRAWING TITLE:-

TYPICAL FLOOR LV SERVICES LAYOUT

SUBMITTED FOR :-

PRELIMINARY	☐	APPROVAL	☐
PROPOSAL	☐	FOR RERA	☒
DATE :-	24-12-2024	NORTH :-	
DRAWN :-	RAKESH		
APPROVED :-	NARESH		
DRAWING NO.:-		SCALE :-	

MEP SERVICES CONSULTANT
AMP INFRA SERVICES
VILLA NO 16. SHUBHASIS GEETA
JAISINGHPURA, BHANKROTA &
CHIMANPURA.JAIPUR 302026
EMAIL ID- ampinfrajpr@gmail.com
CONTACT NO. :- 9462866389

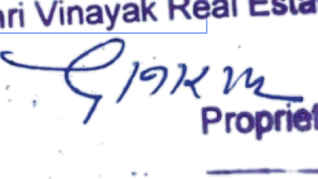For Shri Vinayak Real Estate

Proprietor




ELECTRICAL LEGEND			
SR.NO.	SYMBOL	DESCRIPTION	HIGHT FROM FFL
1		LED LIGHT POINT AT WALL	+7'-6"
2		LED LIGHT POINT AT CEILING	Ceiling
3		LED TUBE LIGHT POINT	+7'-6"
4		CEILING FAN	Ceiling
5		6A. SOCKET WITH SWITCH General Point	+1'-9"
6		SWITCH BOARD WITH SOCKET	+4'-0"
7		TV CABLE POINT	+2'-6"
8		EXHAUST FAN	Vent. Ht.
9		BELL PUSH	+4'-0"
10		BELL BUZZER	+7'-6"
11		DISTRIBUTION BOARD	+5'-6"
12		2no. 6A. Socket With Switch for TV Supply	+2'-6"
13		6A. Socket With Switch for RO	+4'-6"
14		6A. Socket With Switch for Chimney Point	+5'-6"
15		16A. Socket With Switch for Washing Machine Point	+4'-0"
16		16A. Socket With Switch for Geyser Point	+6'-0"
17		16A. Socket With Switch General Point	+1'-3/4'-0"
18		16A. Socket With Switch for Microwave & Grinder Point	+4'-6"
19		32MM Ø CONDUIT FOR SUBMAIN WIRING	Ceiling
20		3X1 SQMM POINT WIRING	Ceiling
21		2X2.5 + 1X1.5 SQMM LIGHT CIRCUIT WIRING	Ceiling
22		2X4 + 1X2.5 SQMM LIGHT CIRCUIT WIRING	Ceiling
23		16A. SOCKET WITH SWITCH FOR FRIDGE	+4'-0"
24		CEILING ROSE	Vent. Ht.
25		25mm Ø TV Cable Conduit	Ceiling/Flooring
26		25A. AC Socket with Switch	+7'-6"

REVISION — 00

1. ALL THE DIMENSIONS ON THE DRAWING ARE IN WRITTEN.
2. ONLY WRITTEN DIMENSIONS ARE TO BE FOLLOWED, DRAWING SHOULD NOT BE SCALED IN ANY CIRCUMSTANCES.
3. ALL MEASUREMENTS MUST BE CHECKED AND VERIFIED BY THE CONTRACTORS PRIOR TO EXECUTION OF WORK AT THE SITE.
4. THIS DRAWING IS TO BE READ IN CONJUNCTION WITH ALL RELEVANT STRUCTURAL, ARCHITECTURAL & FACILITY PLANNING DRAWINGS.
5. ANY DISCREPANCIES MUST BE BROUGHT TO THE NOTICE OF THE ENGINEER IMMEDIATELY & PRIOR TO EXECUTION AT SITE.
6. CO-ORDINATION WITH SERVICES SUCH AS HVAC, PLUMBING & ELECTRICAL, ETC. IS THE RESPONSIBILITY OF THE CONTRACTORS.
7. FOR DETAILS, REFER RELEVANT LARGE SCALE DETAIL DRGS. AS INDICATED :


Er. RAKESH
B.Tech. (Electrical Engineering)

ARCHITECT

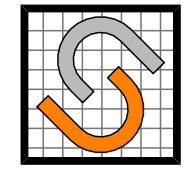 **THE URBAN SQUARE**
ARCHITECT , PLANNER , BPAS
BAPU NAGAR JAIPUR, (RAJ.)
Mobile- 9461302542


PROJECT :-

VINAYAK RESIDENCY I
PROPOSED BUILDING AT PLOT.NO.62,63(West Part),66 (West Part) & 67, PARMANAND NAGAR, NIWAROO ROAD,JHOTWARA,JAIPUR


BUILDER/DEVELOPER/CLIENT:-

DRAWING TITLE:-

TYPICAL FLOOR CCTV SERVICES LAYOUT

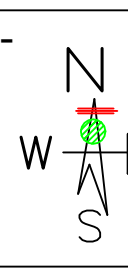SUBMITTED FOR :-			
PRELIMINARY	☐	APPROVAL	☐
PROPOSAL	☐	FOR RERA	☒
DATE :-	10.01.2025	NORTH :-	
DRAWN :-	RAKESH		
APPROVED :-	NARESH		
DRAWING NO.:-		SCALE :-	

MEP SERVICES CONSULTANT
AMP INFRA SERVICES
VILLA NO 16. SHUBHASIS GEETA
JAISINGHPURA, BHANKROTA & CHIMANPURA.JAIPUR 302026
EMAIL ID- ampinfrajpr@gmail.com
CONTACT NO. :- 9462866389

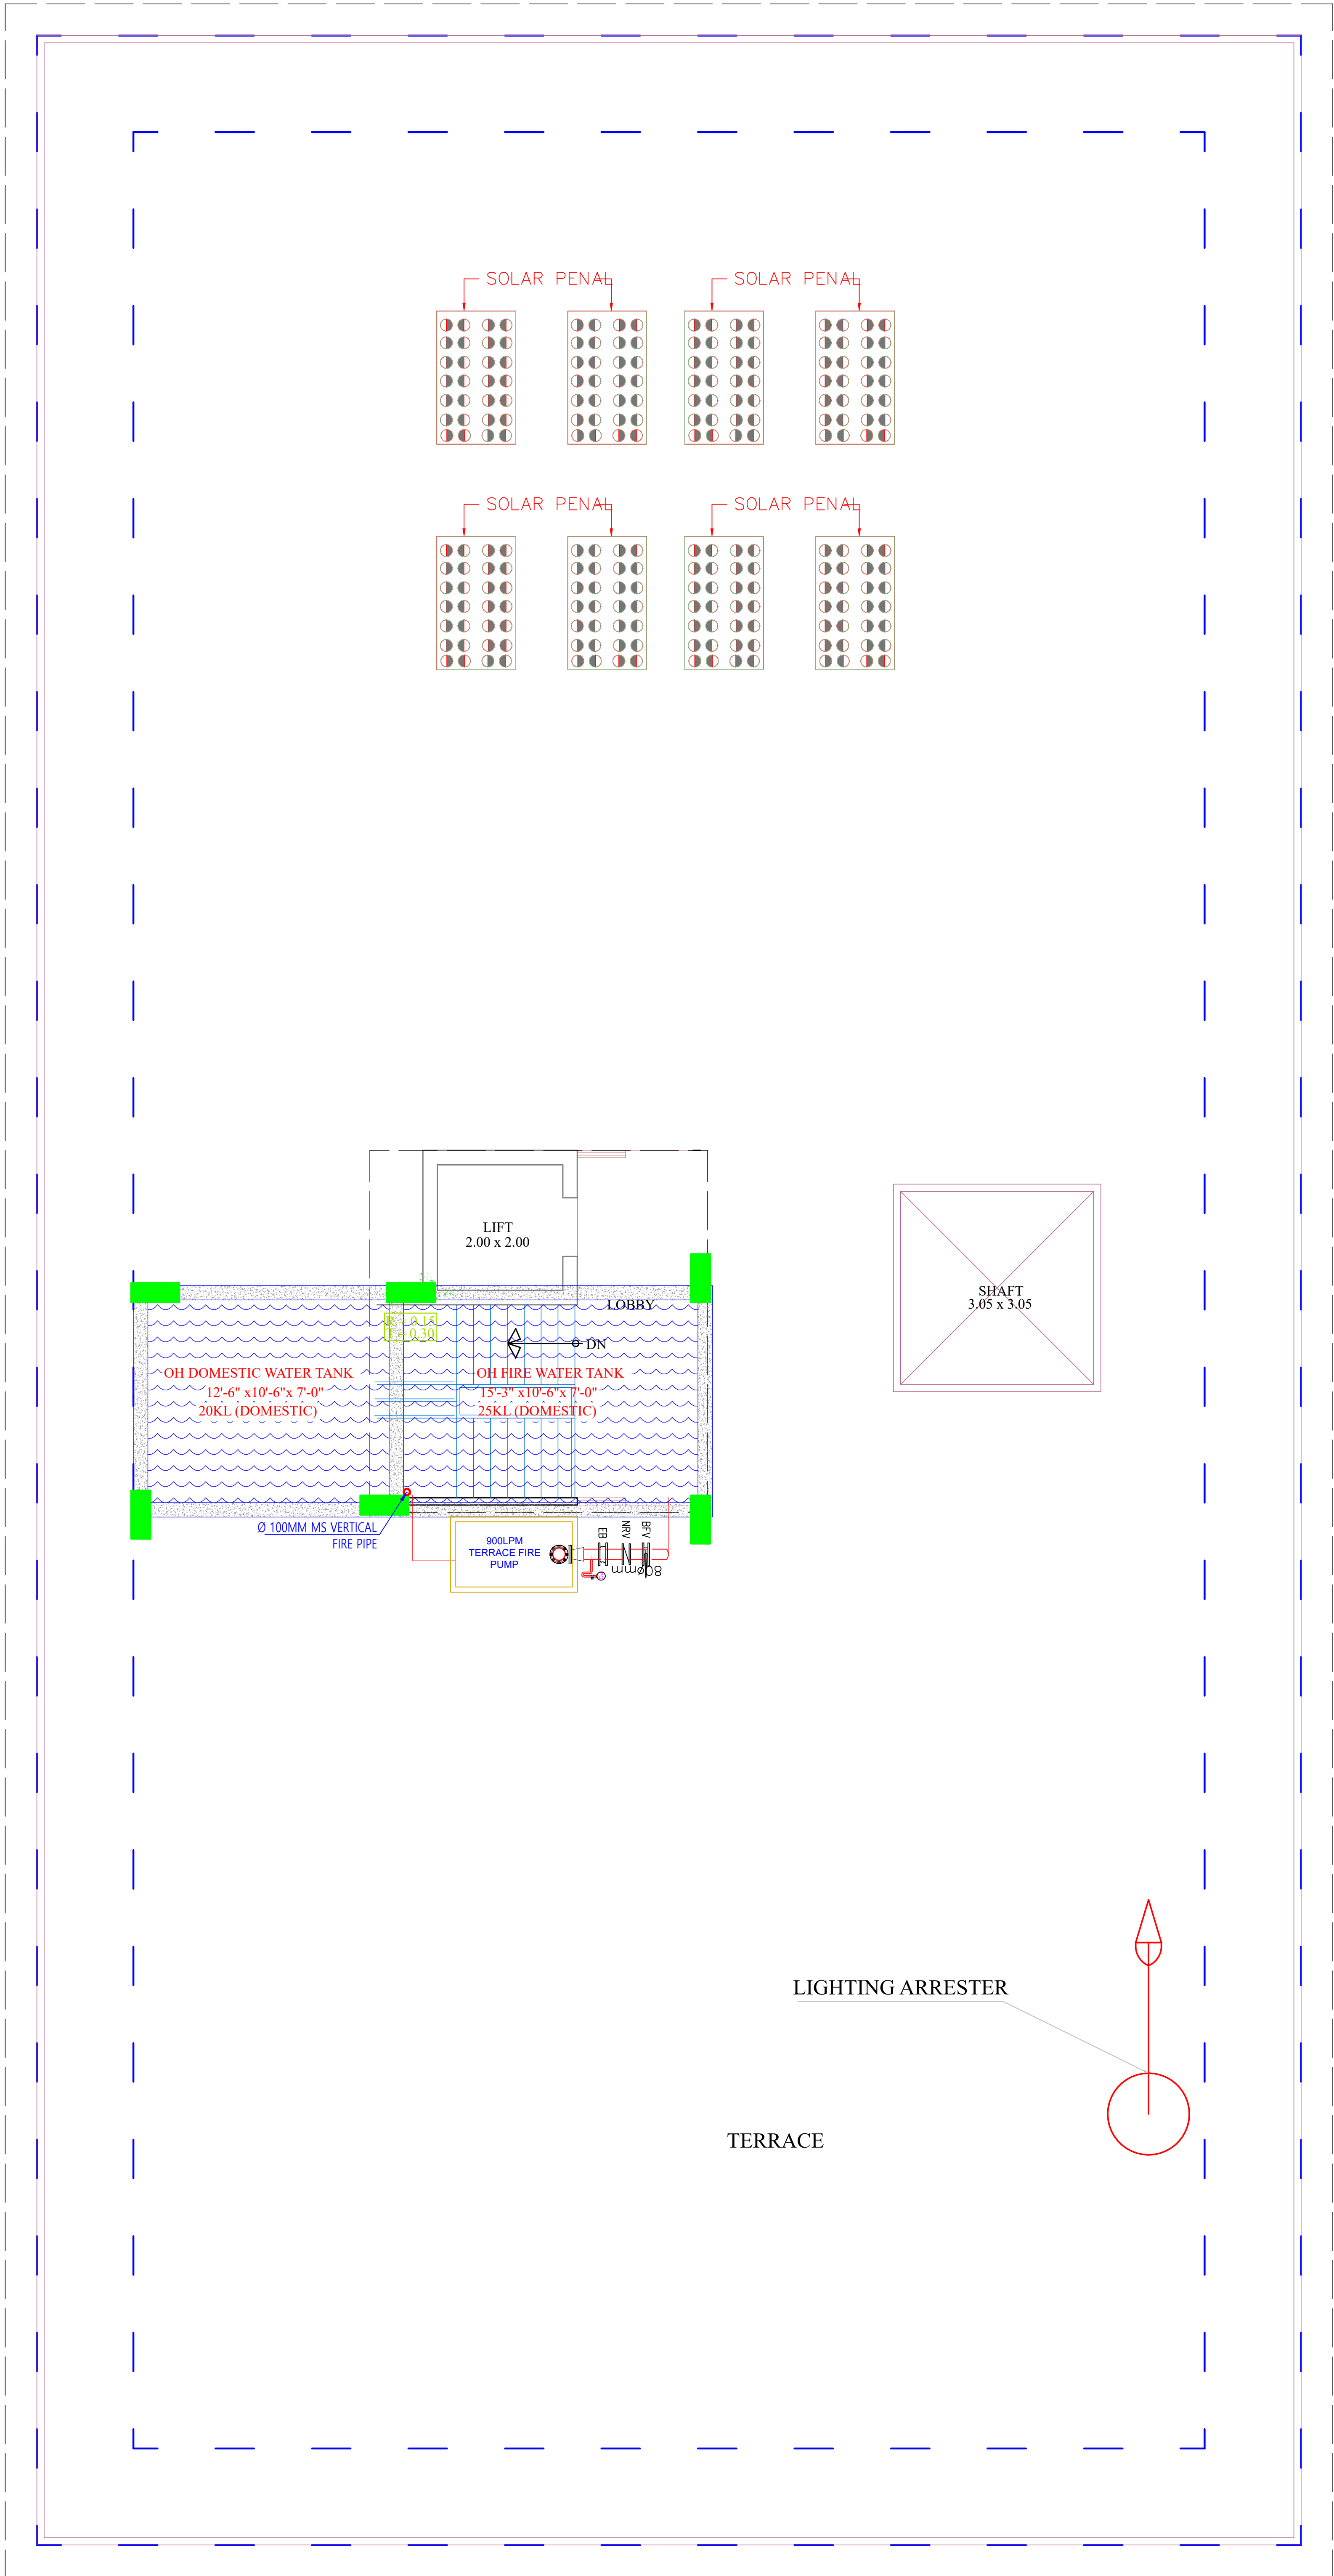

TERRACE FLOOR PLAN

For Shri Vinayak Real Estate
Proprietor

REVISION – 00

GENERAL NOTES :

1. ALL THE DIMENSIONS ON THE DRAWING ARE IN WRITTEN.
2. ONLY WRITTEN DIMENSIONS ARE TO BE FOLLOWED, DRAWING SHOULD NOT BE SCALED IN ANY CIRCUMSTANCES.
3. ALL MEASUREMENTS MUST BE CHECKED AND VERIFIED BY THE CONTRACTORS PRIOR TO EXECUTION OF WORK AT THE SITE.
4. THIS DRAWING IS TO BE READ IN CONJUNCTION WITH ALL RELEVANT STRUCTURAL, ARCHITECTURAL & FACILITY PLANNING DRAWINGS.
5. ANY DISCREPANCIES MUST BE BROUGHT TO THE NOTICE OF THE ENGINEER IMMEDIATELY & PRIOR TO EXECUTION AT SITE.
6. CO-ORDINATION WITH SERVICES SUCH AS HVAC, PLUMBING & ELECTRICAL, ETC. IS THE RESPONSIBILITY OF THE CONTRACTORS.
7. FOR DETAILS, REFER RELEVANT LARGE SCALE DETAIL DRGS. AS INDICATED.

LEGEND

	Symbole	DESCRIPTION
1.		HOSEREEL
2.		FIRE PIPE
3.		FIRE PIPE
4.		FIRE EXTINGUISHER
5.		EXTERNAL YARD HYDRANT

Rakesh
Er. RAKESH
B.Tech. (Electrical Engineering)

ARCHITECT



ARCHITECT , PLANNER , BPAS
BAPU NAGAR JAIPUR, (RAJ.)
Mobile- 9461302542

PROJECT :-

VINAYAK RESIDENCY |
PROPOSED BUILDING AT PLOT.NO.62,63(West Part),66 (West Part) & 67, PARMANAND NAGAR, NIWAROO ROAD,JHOTWARA,JAIPUR

BUILDER/DEVELOPER/CLIENT:-

DRAWING TITLE:-


TERRACE FLOOR LIGHTING ARRESTER LOCATION

SUBMITTED FOR :-

PRELIMINARY	☐	APPROVAL	☒
PROPOSAL	☐	GFC	☐

DATE :-	05-10-2024	NORTH :- N W E S
DRAWN :-	Harendra	
APPROVED :-	NARESH	
DRAWING NO.:-		

MEP SERVICES CONSULTANT
AMP INFRA SERVICES
VILLA NO 16. SHUBHASIS GEETA JAISINGHPURA, BHANKROTA & CHIMANPURA.JAIPUR 302026
EMAIL ID- ampinfrajpr@gmail.com
CONTACT NO. :- 9462866389

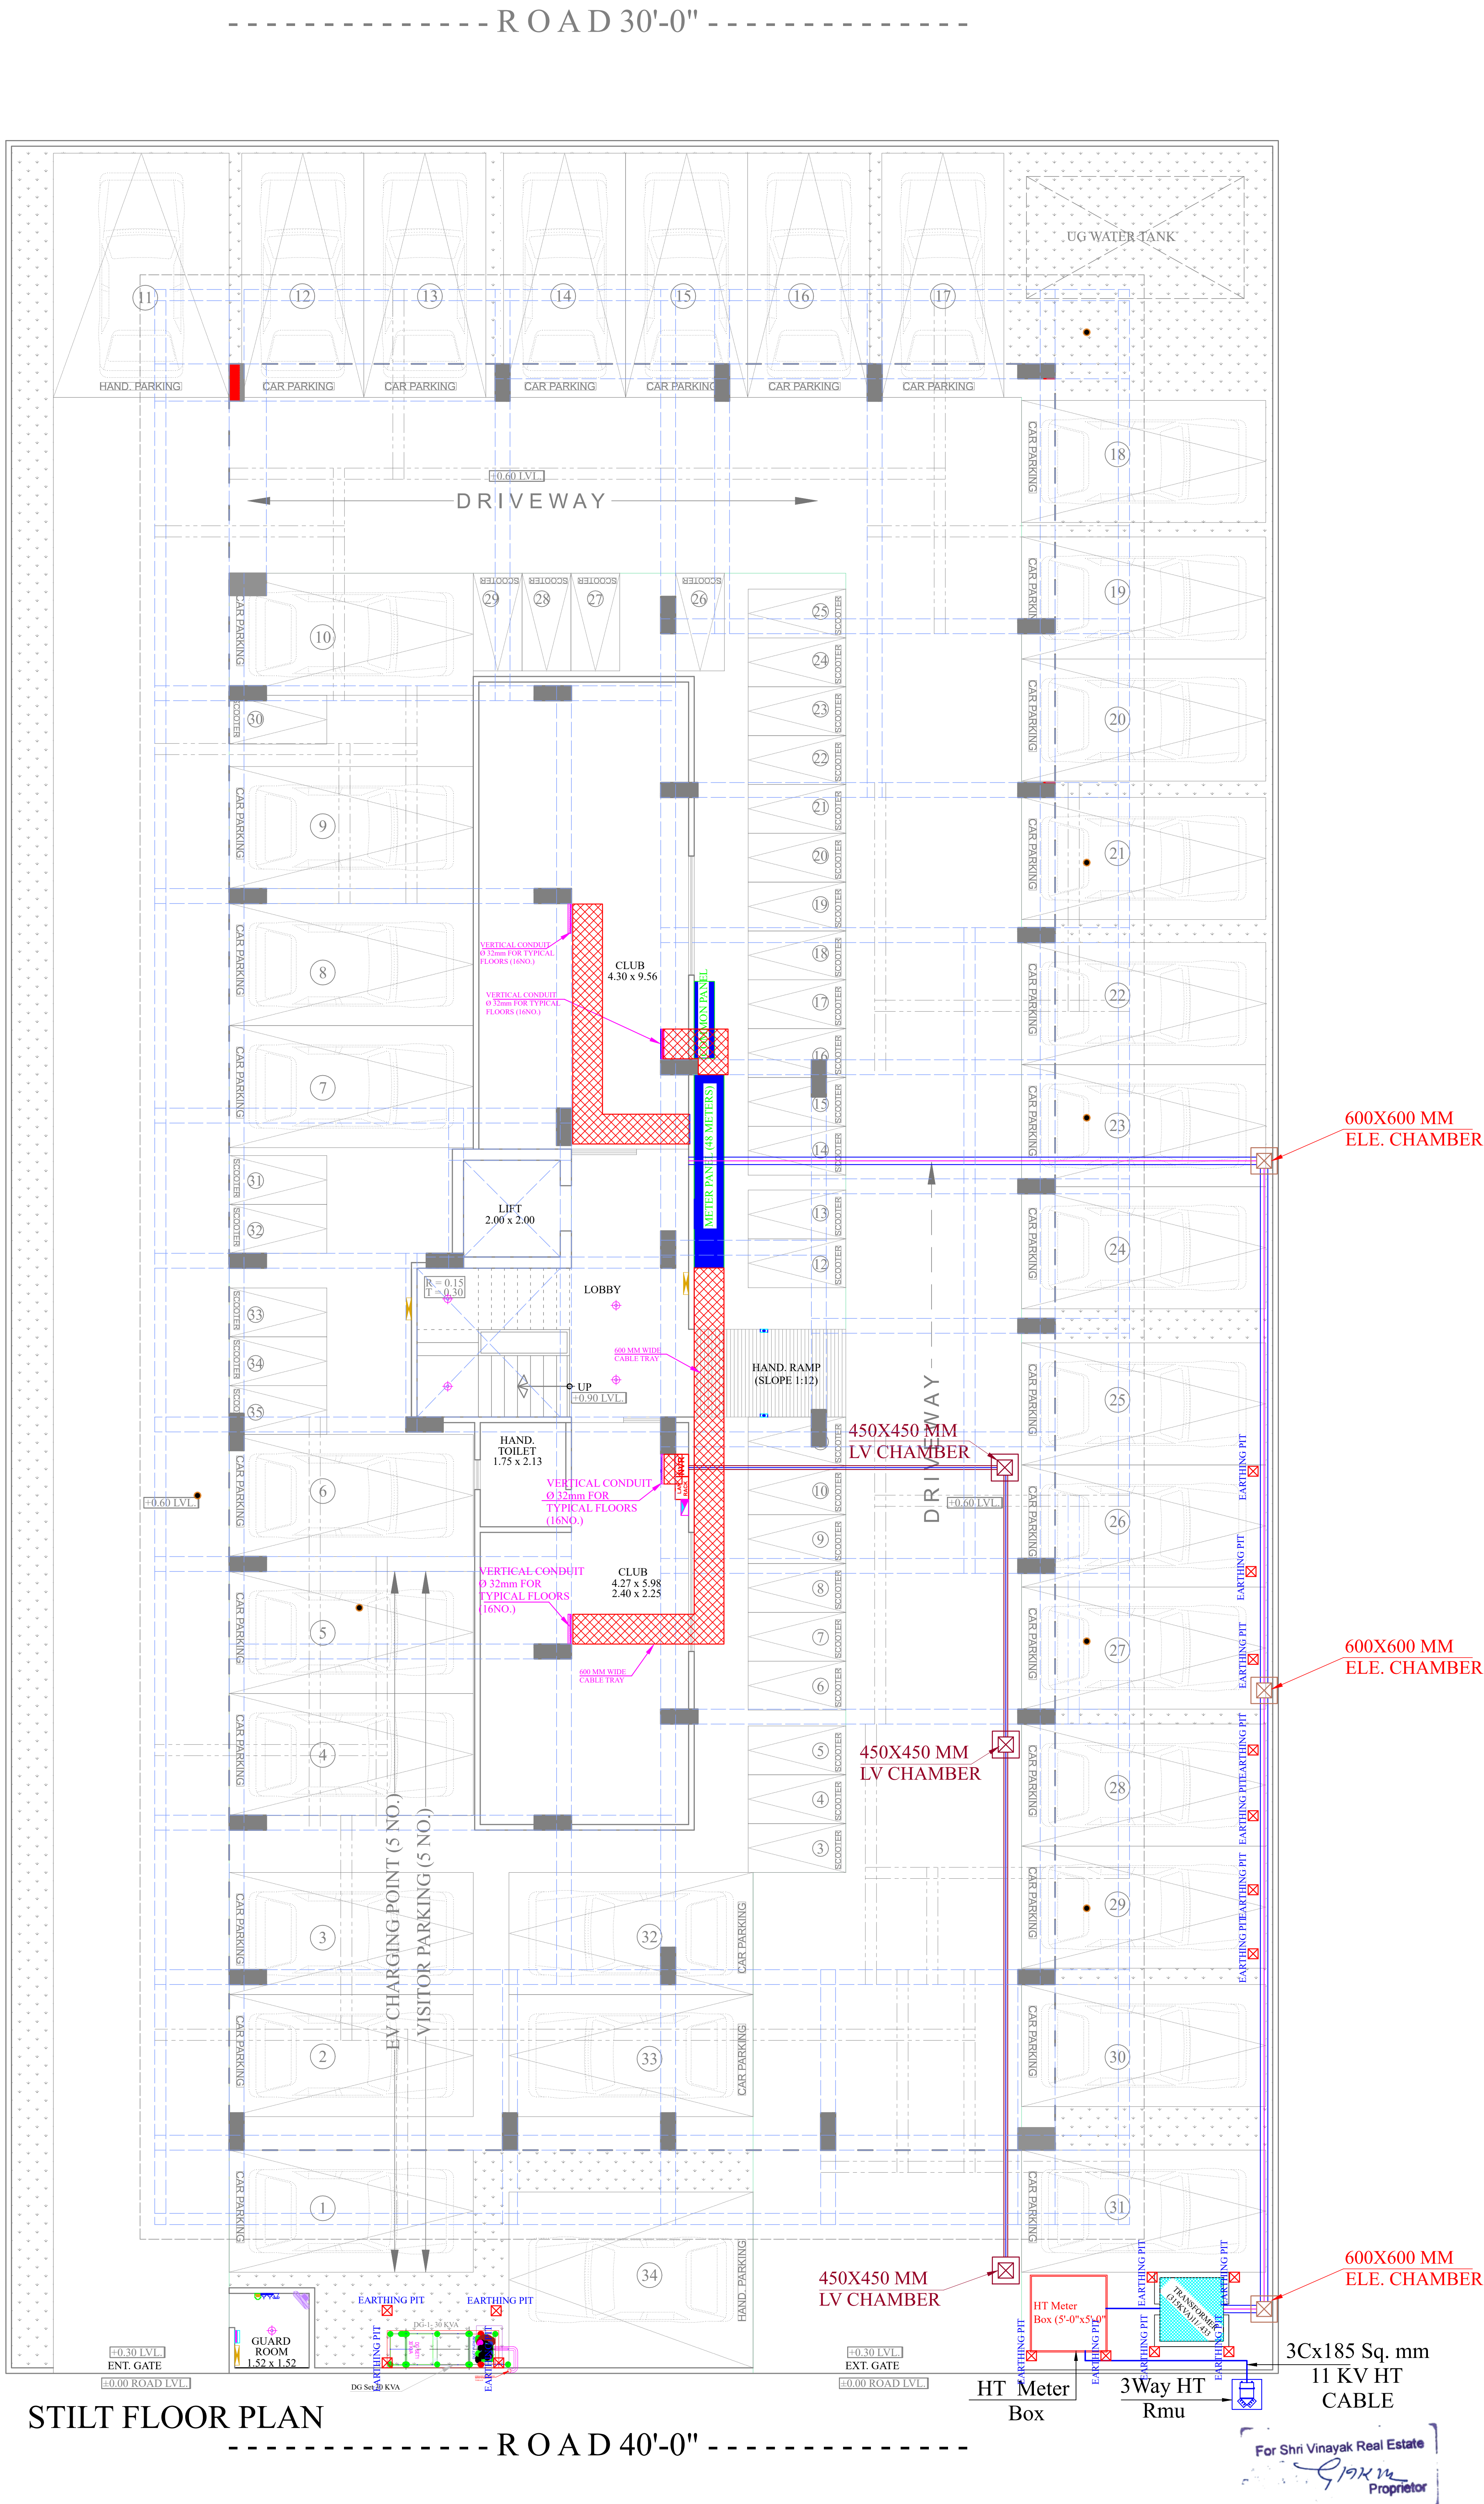

REVISION – 00

- GENERAL NOTES :
- 1. ALL THE DIMENSIONS ON THE DRAWING ARE IN WRITTEN.
 - 2. ONLY WRITTEN DIMENSIONS ARE TO BE FOLLOWED, DRAWING SHOULD NOT BE SCALED IN ANY CIRCUMSTANCES.
 - 3. ALL MEASUREMENTS MUST BE CHECKED AND VERIFIED BY THE CONTRACTORS PRIOR TO EXECUTION OF WORK AT THE SITE.
 - 4. THIS DRAWING IS TO BE READ IN CONJUNCTION WITH ALL RELEVANT STRUCTURAL, ARCHITECTURAL & FACILITY PLANNING DRAWINGS.
 - 5. ANY DISCREPANCIES MUST BE BROUGHT TO THE NOTICE OF THE ENGINEER IMMEDIATELY & PRIOR TO EXECUTION AT SITE.
 - 6. CO-ORDINATION WITH SERVICES SUCH AS HVAC, PLUMBING & ELECTRICAL, ETC. IS THE RESPONSIBILITY OF THE CONTRACTORS.
 - 7. FOR DETAILS, REFER RELEVANT LARGE SCALE DETAIL DRGS. AS INDICATED.

LIGHTING LEGEND

SR.NO.	SYMBOL	DESCRIPTION	HEIGHT FROM FFL
1	[Symbol]	CEILING TUBELIGHT POINT	CEILING
2	[Symbol]	LED CEILING LIGHT POINT	CEILING
3	[Symbol]	LED WALL BRACKET LIGHT POINT AT WALL	+7'-4"
4	[Symbol]	6A SOCKET WITH SWITCH	+2'-0" +4'-0"
5	[Symbol]	GENERAL POINT 16A SOCKET WITH SWITCH	+2'-0" +4'-0"
6	[Symbol]	MDF BOX	+5'-0"
7	[Symbol]	CEILING ROSE	+7'-6"
8	[Symbol]	SWITCH BOARD	+4'-0"
9	[Symbol]	EXHAUST FAN	VENT. HT.
10	[Symbol]	LIGHT & POWER DISTRIBUTION BOARD	+5'-1"
11	[Symbol]	Ø25MM POINT CONDUIT	CEILING
12	[Symbol]	Ø25MM POWER CIRCUIT CONDUIT	CEILING FLOORING
13	[Symbol]	Ø25MM LIGHT CIRCUIT CONDUIT	CEILING FLOORING
14	[Symbol]	CEILING FAN	CEILING

Rakesh
Er. RAKESH
B.Tech. (Electrical Engineering)

ARCHITECT

THE URBAN SQUARE
ARCHITECT , PLANNER , BPAS
BAPU NAGAR JAIPUR, (RAJ.)
Mobile- 9461302542

PROJECT :-
VINAYAK RESIDENCY I
PROPOSED BUILDING AT PLOT.NO.62,63(West Part),66 (West Part) & 67, PARMANAND NAGAR, NIWAROO ROAD,JHOTWARA,JAIPUR

BUILDER/DEVELOPER/CLIENT:-


DRAWING TITLE:-
STILT FLOOR EXTERNAL ELECTRICAL AND CABLE TRAY LAYOUT

SUBMITTED FOR :-

PRELIMINARY	☐	APPROVAL	☐
PROPOSAL	☐	FOR RERA	☒

DATE :-	07-10-2024	NORTH :-
DRAWN :-	RAKESH	
APPROVED :-	NARESH	
DRAWING NO.:-		

CONSULTANT
AMP INFRA SERVICES
VILLA NO 16. SHUBHASIS GEETA JAISINGHPURA, BHANKROTA & CHIMANPURA.JAIPUR 302026
EMAIL ID- ampinfrajpr@gmail.com
CONTACT NO. :- 9462866389

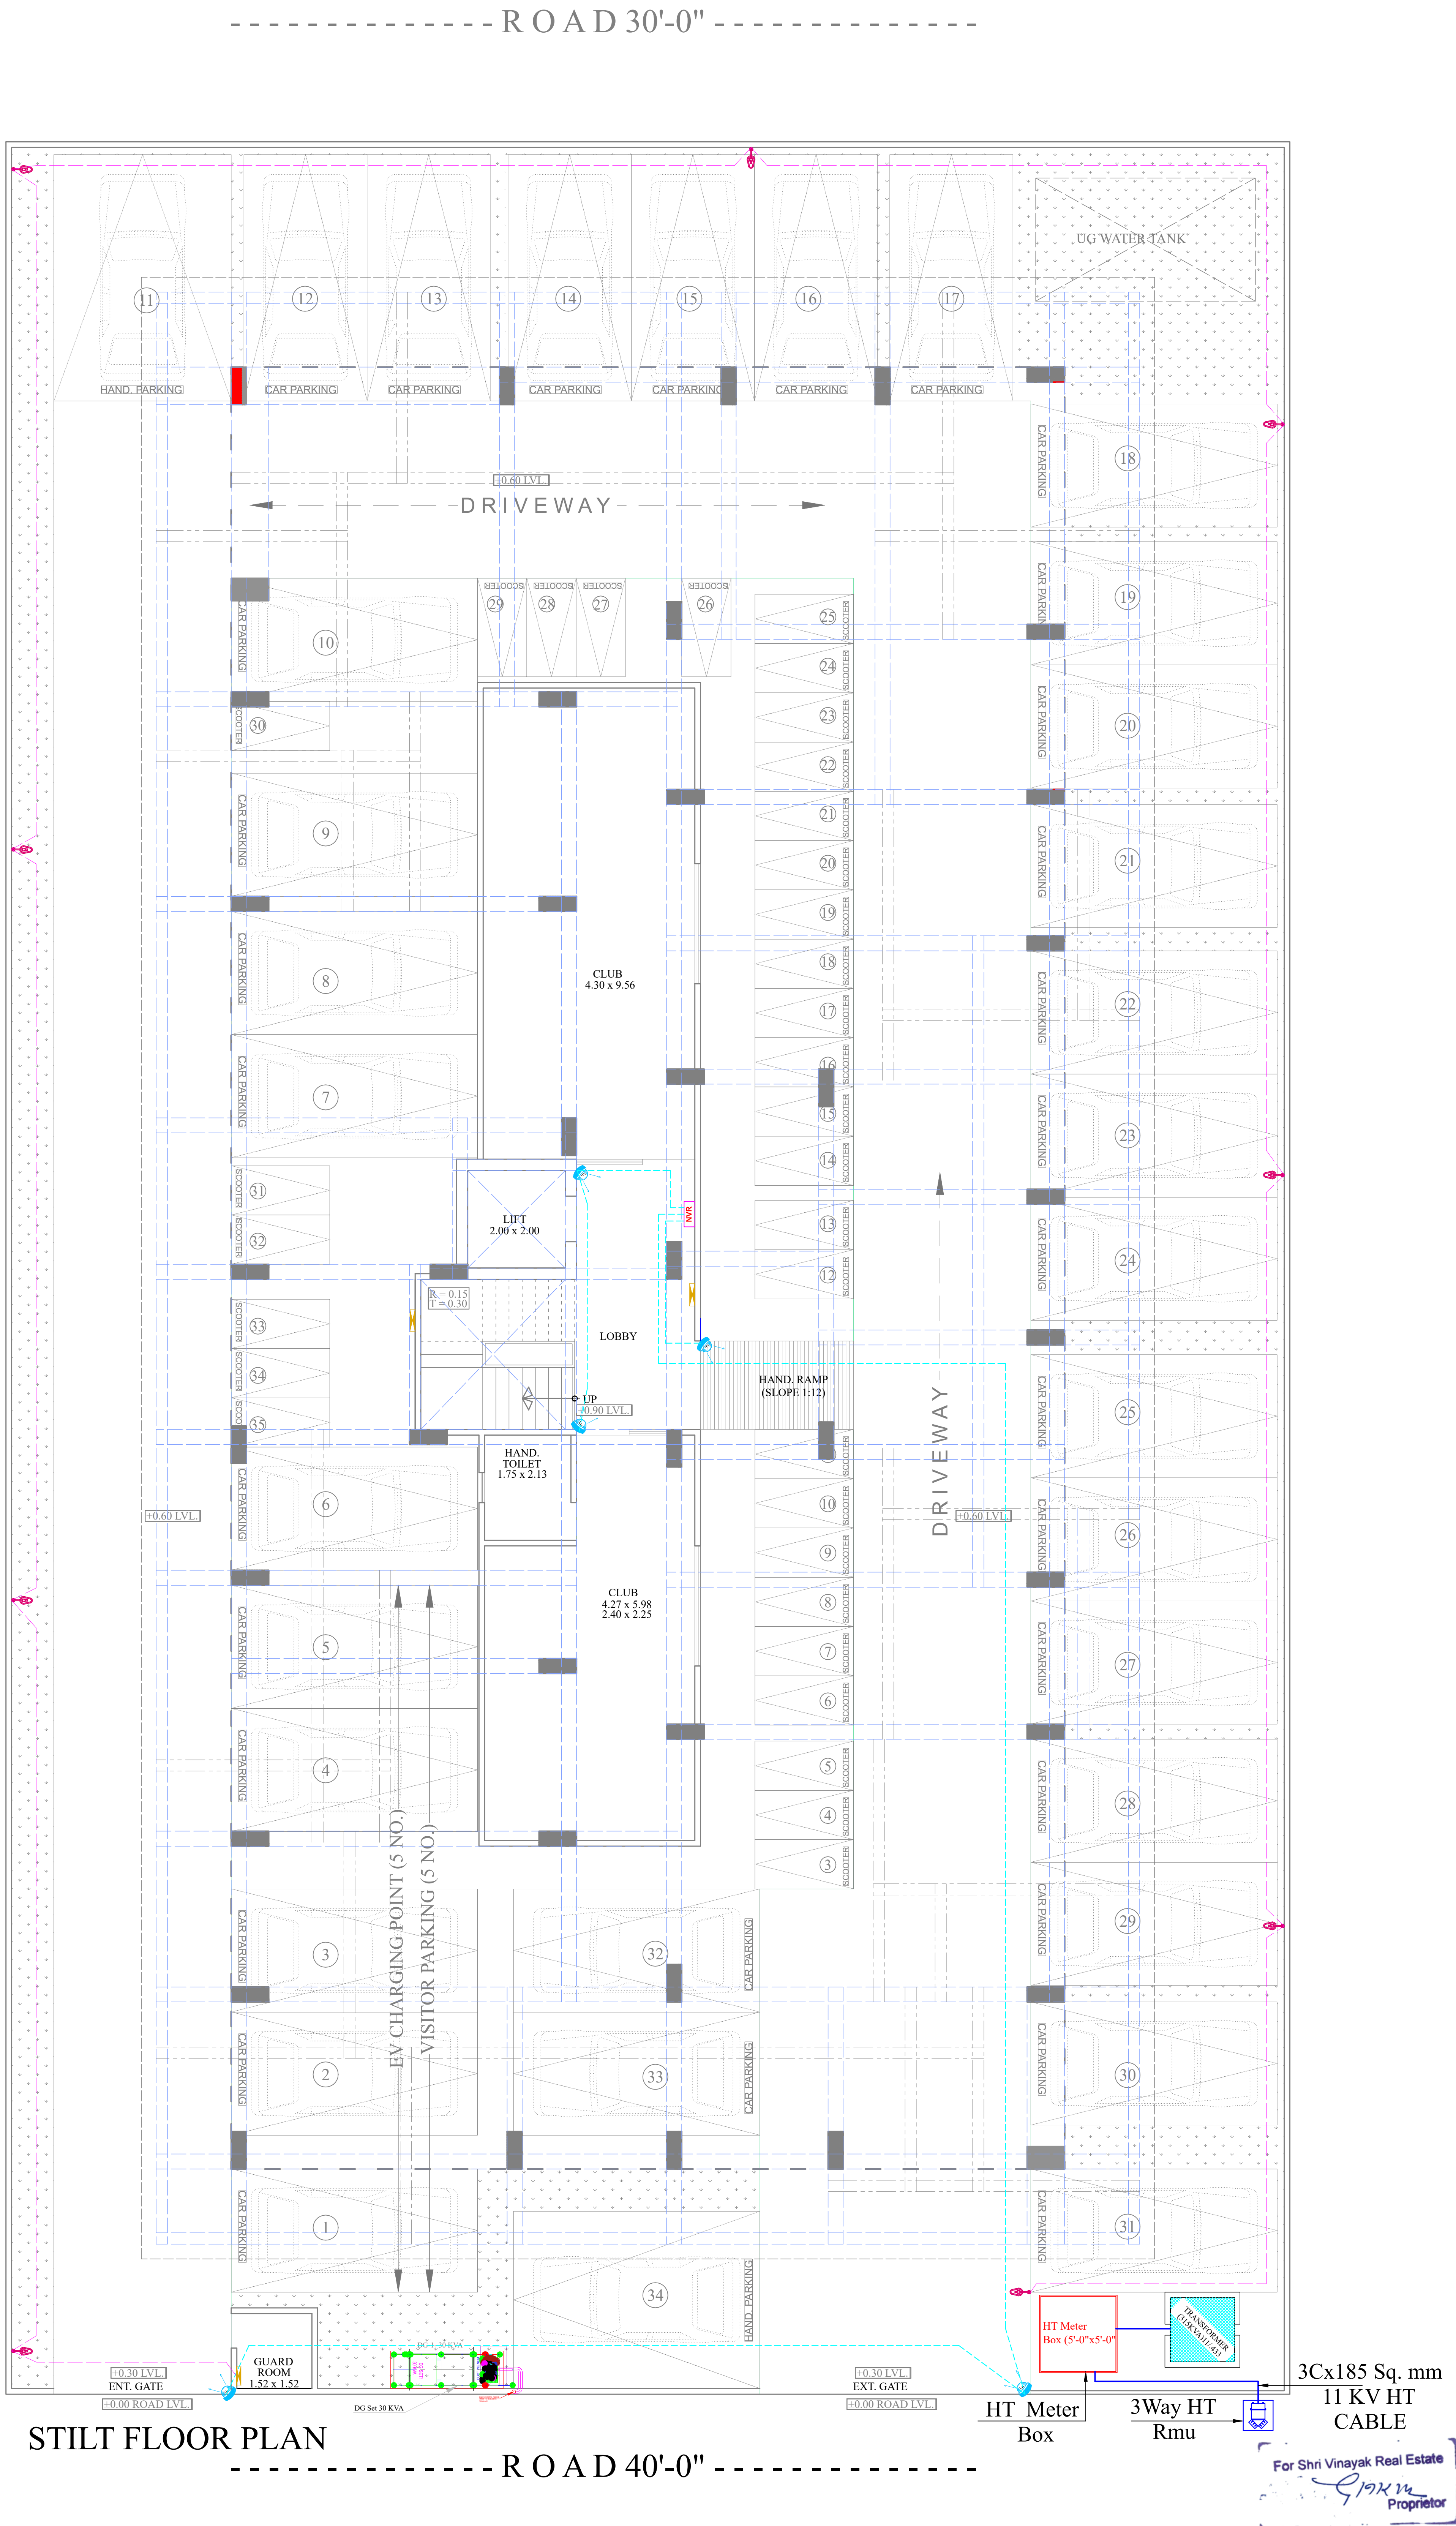

REVISION – 00

GENERAL NOTES :

1. ALL THE DIMENSIONS ON THE DRAWING ARE IN WRITTEN.
2. ONLY WRITTEN DIMENSIONS ARE TO BE FOLLOWED, DRAWING SHOULD NOT BE SCALED IN ANY CIRCUMSTANCES.
3. ALL MEASUREMENTS MUST BE CHECKED AND VERIFIED BY THE CONTRACTORS PRIOR TO EXECUTION OF WORK AT THE SITE.
4. THIS DRAWING IS TO BE READ IN CONJUNCTION WITH ALL RELEVANT STRUCTURAL, ARCHITECTURAL & FACILITY PLANNING DRAWINGS.
5. ANY DISCREPANCIES MUST BE BROUGHT TO THE NOTICE OF THE ENGINEER IMMEDIATELY & PRIOR TO EXECUTION AT SITE.
6. CO-ORDINATION WITH SERVICES SUCH AS HVAC, PLUMBING & ELECTRICAL, ETC. IS THE RESPONSIBILITY OF THE CONTRACTORS.
7. FOR DETAILS, REFER RELEVANT LARGE SCALE DETAIL DRGS. AS INDICATED.

LIGHTING LEGEND

SR.NO.	SYMBOL	DESCRIPTION	HEIGHT FROM FFL
1		CEILING TUBELIGHT POINT	CEILING
2		LED CEILING LIGHT POINT	CEILING
3		LED WALL BRACKET LIGHT POINT AT WALL	+7'-4"
4		6A SOCKET WITH SWITCH	+2'-0" +4'-0"
5		GENERAL POINT 16A SOCKET WITH SWITCH	+2'-0" +4'-0"
6		MDF BOX	+5'-0"
7		CEILING ROSE	+7'-6"
8		SWITCH BOARD	+4'-0"
9		EXHAUST FAN	VENT. HT.
10		LIGHT & POWER DISTRIBUTION BOARD	+5'-1"
11		Ø25MM POINT CONDUIT	CEILING
12		Ø25MM POWER CIRCUIT CONDUIT	CEILING FLOORING
13		Ø25MM LIGHT CIRCUIT CONDUIT	CEILING FLOORING
14		CEILING FAN	CEILING

Rakesh

Er. RAKESH

B.Tech. (Electrical Engineering)

ARCHITECT

THE URBAN SQUARE

ARCHITECT , PLANNER , BPAS

BAPU NAGAR JAIPUR, (RAJ.)

PROJECT-9461302542

VINAYAK RESIDENCY I

PROPOSED BUILDING AT PLOT.NO.62,63(West Part),66 (West Part) & 67, PARMANAND NAGAR, NIWAROO ROAD,JHOTWARA,JAIPUR

BUILDER/DEVELOPER/CLIENT:-

DRAWING TITLE:-

STILT FLOOR LV SERVICES LAYOUT

SUBMITTED FOR :-

PRELIMINARY	☐	APPROVAL	☐
PROPOSAL	☐	FOR RERA	☒

DATE :- 07-10-2024

DRAWN :- RAKESH

APPROVED :- NARESH

DRAWING NO.:-

NORTH :-

N

E

S

W

SCALE :-

CONSULTANT

AMP INFRA SERVICES

VILLA NO 16. SHUBHASIS GEETA JAISINGHPURA, BHANKROTA & CHIMANPURA.JAIPUR 302026

EMAIL ID- ampinfrajpr@gmail.com

CONTACT NO. :- 9462866389