


MAIN PANEL

PROJECT NAME :

ASTHA PRIME

DEVELOPER NAME :

ASTHA REAL ESTATE

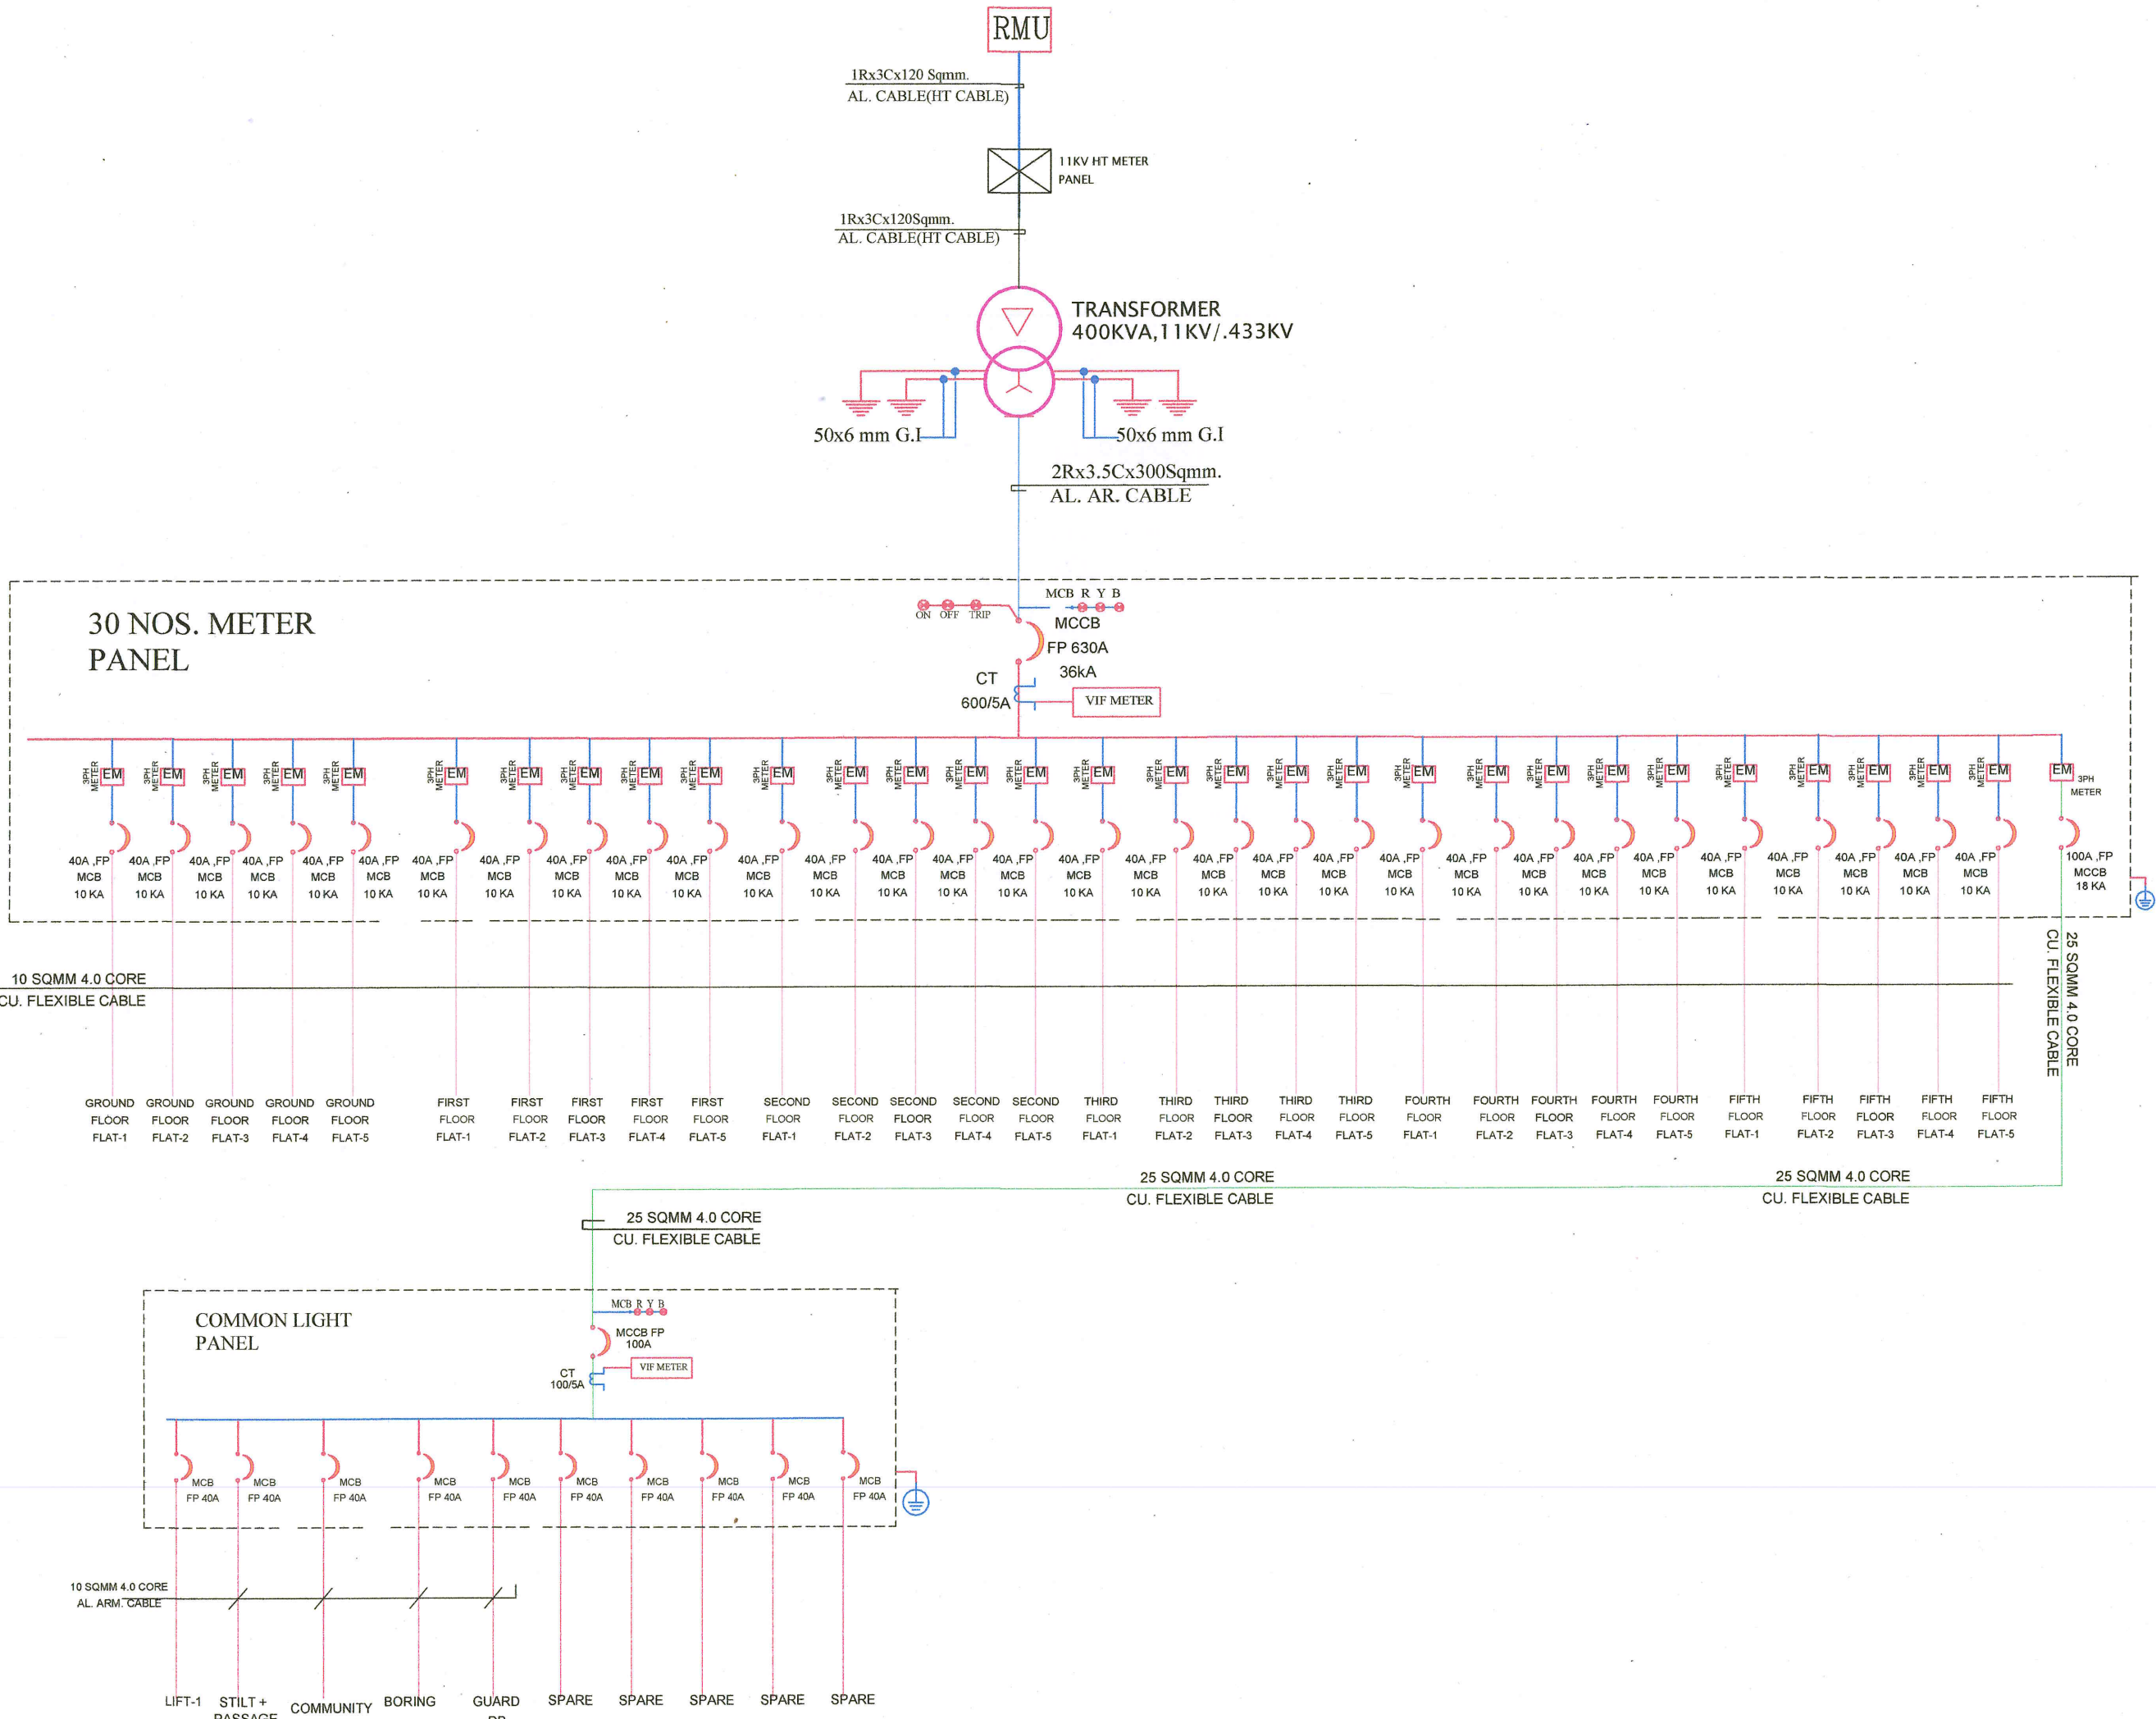

S.No DATE REVISION DESCRIPTION

- GENERAL NOTES :
- All dimensions on this drawing are in MMS System. Only written dimensions are to be followed. Drawing should not be scaled.
 - All measurements must be checked and verified by the contractors prior to execution of work at the site.
 - This drawing is to be read in conjunction with all relevant structural, services & facility planning drawings.
 - Architectural drawings are to be followed for the location of all structural members & masonry walls, for sizes & reinforcement details of structural members, relevant structural drawings are to be referred.
 - Any discrepancies between architectural, structural and services drawings must be brought to the notice of the architect immediately & prior to execution at site.
 - Coordination with services such as truss, plumbing & electrical, etc. is the responsibility of the contractor.
 - All masonry walls should be aligned with the columns as indicated on the plan, irrespective of the position as calculated with the dimensioning.
 - For details, refer relevant large scale detail drawings as indicated.

PROJECT:
PROPOSED RESIDENTIAL FLATS
ON PLOT NO. - 52
SCHEME "RAJLAXMI ELCLAVE-X"
MANPUR DEVRI URF GOLIOWAS,
TEH :- SANGANER, JAIPUR

NAME OF DRAWING:

MAIN PANEL(SLD/DISTRIBUTION
DETAILS AFTER LT PANEL

DRAWING
WORKING DRAWING

PROJECT NO. :
DATE :
27, May, - 2024

SCALE :
NTS
REV NO. :
R-0

DRAWING NO. :
PROJECT CADDIS BLOCK ROOM TYPE NUMBER

A-01

For ASTHA REAL ESTATE
वैष्णव
Proprietor

Shayma
Er. SANJEEV SHARMA
B.E (Electrical)

SINGLE LINE DIAGRAM
MAIN PANEL(SLD/DISTRIBUTION DETAILS AFTER LT PANEL

ROAD 9.0 MTR. WIDE
64'-3"

P.NO.
51

150'-10 1/4"

DRIVEWAY

DRIVEWAY

DRIVEWAY

DRIVEWAY

P.NO.
53

147'-29 1/16"

PATHWAY 3.0 MTR WIDE

P.U

ENTRY

EXIT

ROAD 12.0 MTR. WIDE
52'-9 7/8"

P.NO.
C-01

STILT FLOOR ELECTRICAL ROUTE LAYOUT
(TRANSFORMER,RMU,METER PANEL,ELECTRICAL CABLE)

For ASTHA REAL ESTATE

Proprietor

Er. SANJEEV SHARMA
B.E (Electrical)

PROJECT NAME :

ASTHA PRIME

DEVELOPER NAME :

ASTHA REAL ESTATE

LEGENDS:

Mounting Height	I D	Symbol	Description
CEILING	FAN/48"		CEILING FAN 48"
CEILING	FAN/30"		CEILING FAN 30"
CEILING	CHI		CHANDELIER
+93"	TL/W		Led Wall Tube Light Make:- Syska Led Cat no.- SSK-TS-20W
+93"	BULB		Led Bulb 20W Make:- Syska Led Cat no.- SKC-20W 5.7K/3K
+93"	GL		WALL BRACKETS AS DESIGN FOR GANESH LIGHT
+78"	ML		12x2 Led Mirror Light Make:- Syska Led Cat no.- FPL-12x2
CEILING	DL		Led 6" Down Lighter 20W (Surface Mounted) Make:- Syska Led Cat no.- SDL-15W GLD 6.5K/4K
VENTILATOR HT.	CR		CEILING ROSE
VENTILATOR HT.	EXF		9" DIA FRESH AIR FAN
+24"	2wSB		2w SWITCH BOARD
+42"	SB		SWITCH BOARD(6A SOCKET & SWITCH)
+24"	TEL		TELEPHONE POINT
+24"	LP TEL		6 A PLUG POINT FOR TELEPHONE
+48"	TV		TV COAXIAL POINT
+48"	LP TV		6 A PLUG POINT FOR TV
+24"	LP		6 A PLUG POINT FOR SIDE TABLE
+72"	LP-CH		6 A PLUG POINT FOR CHIMNEY
+12"	LP PC		6 A PLUG POINT FOR COMPUTER POINT
+93"	SAC		SPLIT AC INDOOR UNIT
+42"	PP-MIX		16 A POWER POINT FOR MIXER
+42"	PP-MIC		16 A POWER POINT FOR MICROWAVE
+78"	PP-G		16 A POWER POINT FOR GEYSER
+54"	PP-F		16 A POWER POINT FOR FRIDGE
+78"	PP-WP		16 A POWER POINT FOR WATER PURIFIER
+48"	PP-WM		16 A POWER POINT FOR WASHING MACHINE
+12"	PP-INV.		16 A POWER POINT FOR INVERTOR
+93"	PP-AC		25A SWITCH/MCB FOR AC
			CHAMBER(2' X 2')
+18"			6A 2 NOS. SOCKET +1 NOS. 16A SWITCH ,TELEPHONE,LAN
+60"	MCB DB		MCB DISTRIBUTION BOARD
			CAMERA
			WALL FAN

S.No DATE REVISION DESCRIPTION

GENERAL NOTES :

- All dimension on this drawing are in MKS System Only written dimensions are to be followed drawing should not be scaled.
- All measurements must be checked and verified by the contractors prior to execution of work at the site.
- This drawing is to be read in conjunction with all relevant structural, services & facility planning drawings.
- Architectural drawings are to be followed for the location of all structural members & masonry walls. for sizes & reinforcement details of structural members, relevant structural drawings are to be referred.
- Any discrepancies between architectural, structural and services drawings must be brought to the notice of the architect immediately & prior to execution at site. Co-ordination with services such as hvac, plumbing & electrical, etc. is the responsibility of the contractor.
- All masonry walls should be aligned with the columns as indicated on the plan, irrespective of the position as calculated with the dimensioning.
- For details, refer relevant large scale detail drgs. as indicated.

PROJECT:

PROPOSED RESIDENTIAL FLATS
ON PLOT NO. - 52
SCHEME "RAJLAXMI ELCLAVE-X"
MANPUR DEVRI URF GOLIAWAS,
TEH :- SANGANER ,JAIPUR

NAME OF DRAWING:

STILT FLOOR
ELECTRICAL ROUTE LAYOUT
(TRANSFORMER,RMU,METER PANEL,
ELECTRICAL CABLE)

DRAWING

WORKING DRAWING

PROJECT NO. :

DATE:
27, May. - 2024

SCALE :

NTS

REV NO. :

R-0

DRAWING NO. :

PROJECT CATEGORY BLOCK FLOOR TYPE NUMBER


A-01

PROJECT NAME :

ASTHA PRIME


DEVELOPER NAME :

ASTHA REAL ESTATE

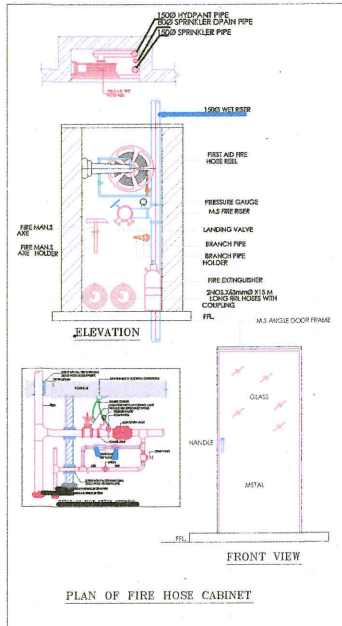

LEGEND:-

FIRE HYDRANT MS PIPE	
BALL VALVE	
EXTERNAL FIRE HYDRANT	
EXTERNAL FIRE HOSE CABINAT	
FIRE HOSE CABINAT	
UPRIGHT SPRINKLER HEAD	
PENDENT SPRINKLER HEAD	
SIDE WALL SPRINKLER HEAD	
FIRE EXTINGUISHER	
FLOW SWITCH	
ISOLATION VALVE	
2 WAY FIRE BRIGADE INLET	

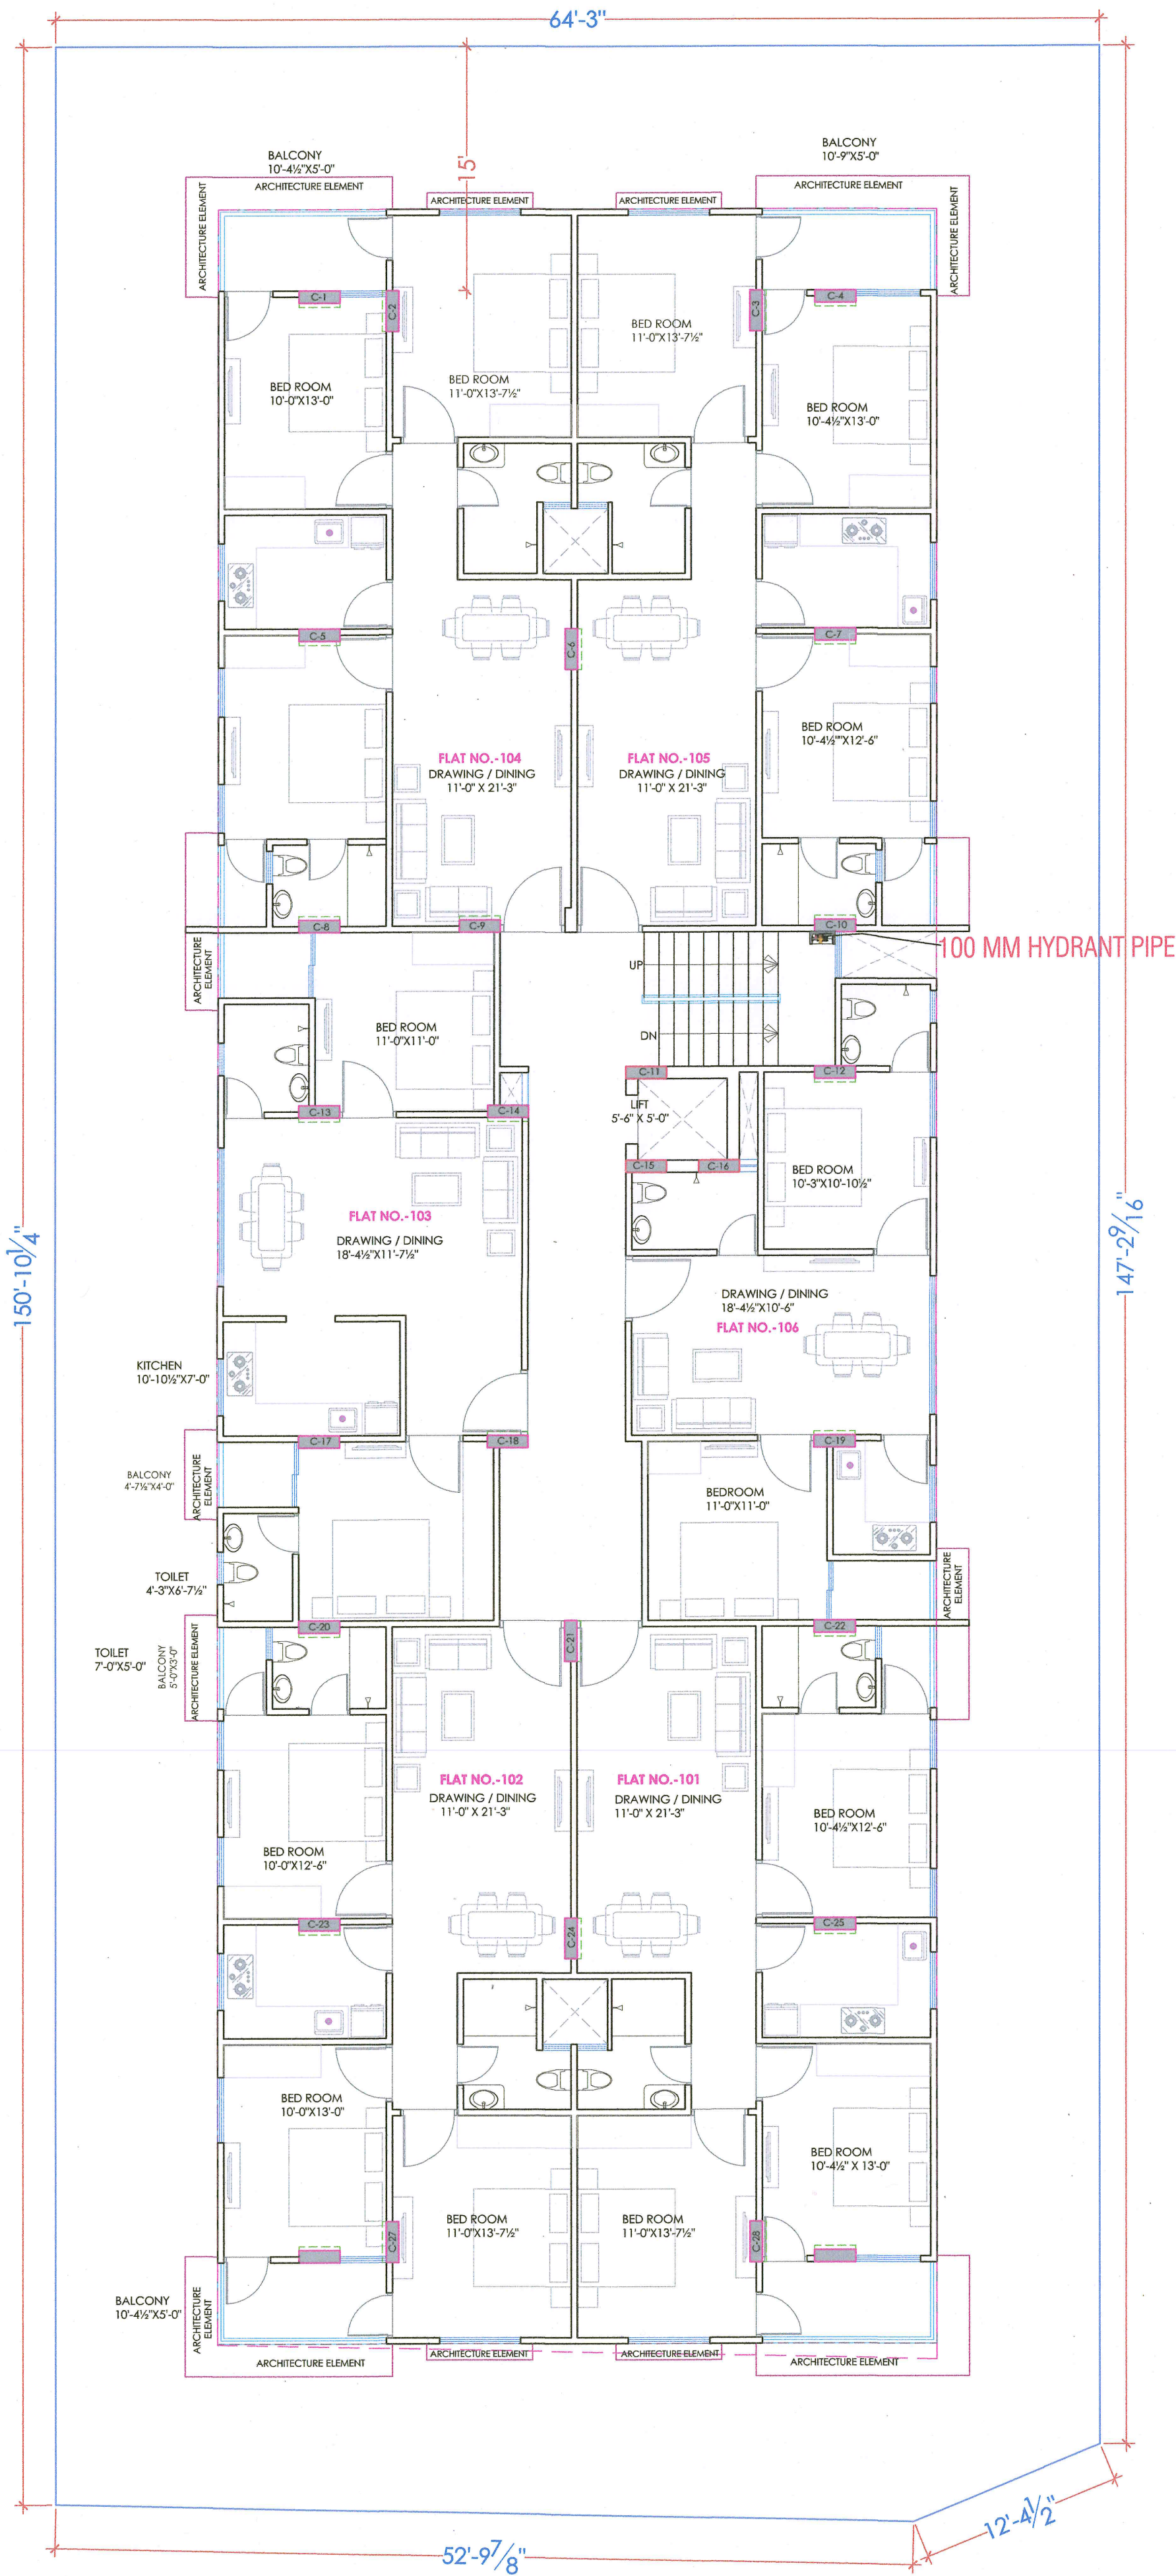

For ASTHA REAL ESTATE
Bhupendra
Proprietor

Sharma
Er. SANJEEV SHARM/
B.E (Electrical)

PROJECT:

PROPOSED RESIDENTIAL FLATS
ON PLOT NO. - 52
SCHEME "RAJLAXMI ELCLAVE-X"
MANPUR DEVRI URF GOLIAWAS,
TEH :- SANGANER, JAIPUR


NAME OF DRAWING:

TYPICAL FLOOR PLAN (GROUND TO
5TH.) FIRE FIGHTING LAYOUT

DRAWING PLUMBING DRAWING	NORTH:
PROJECT NO.:	DATE: 27, May, - 2024
SCALE: NTS	REV NO.: R-0

DRAWING NO.:	
PROJECT	CATEGORY
BLOCK	FLOOR
TYPE	NUMBER

TYPICAL FLOOR PLAN (GROUND TO 5TH.) FIRE FIGHTING LAYOUT

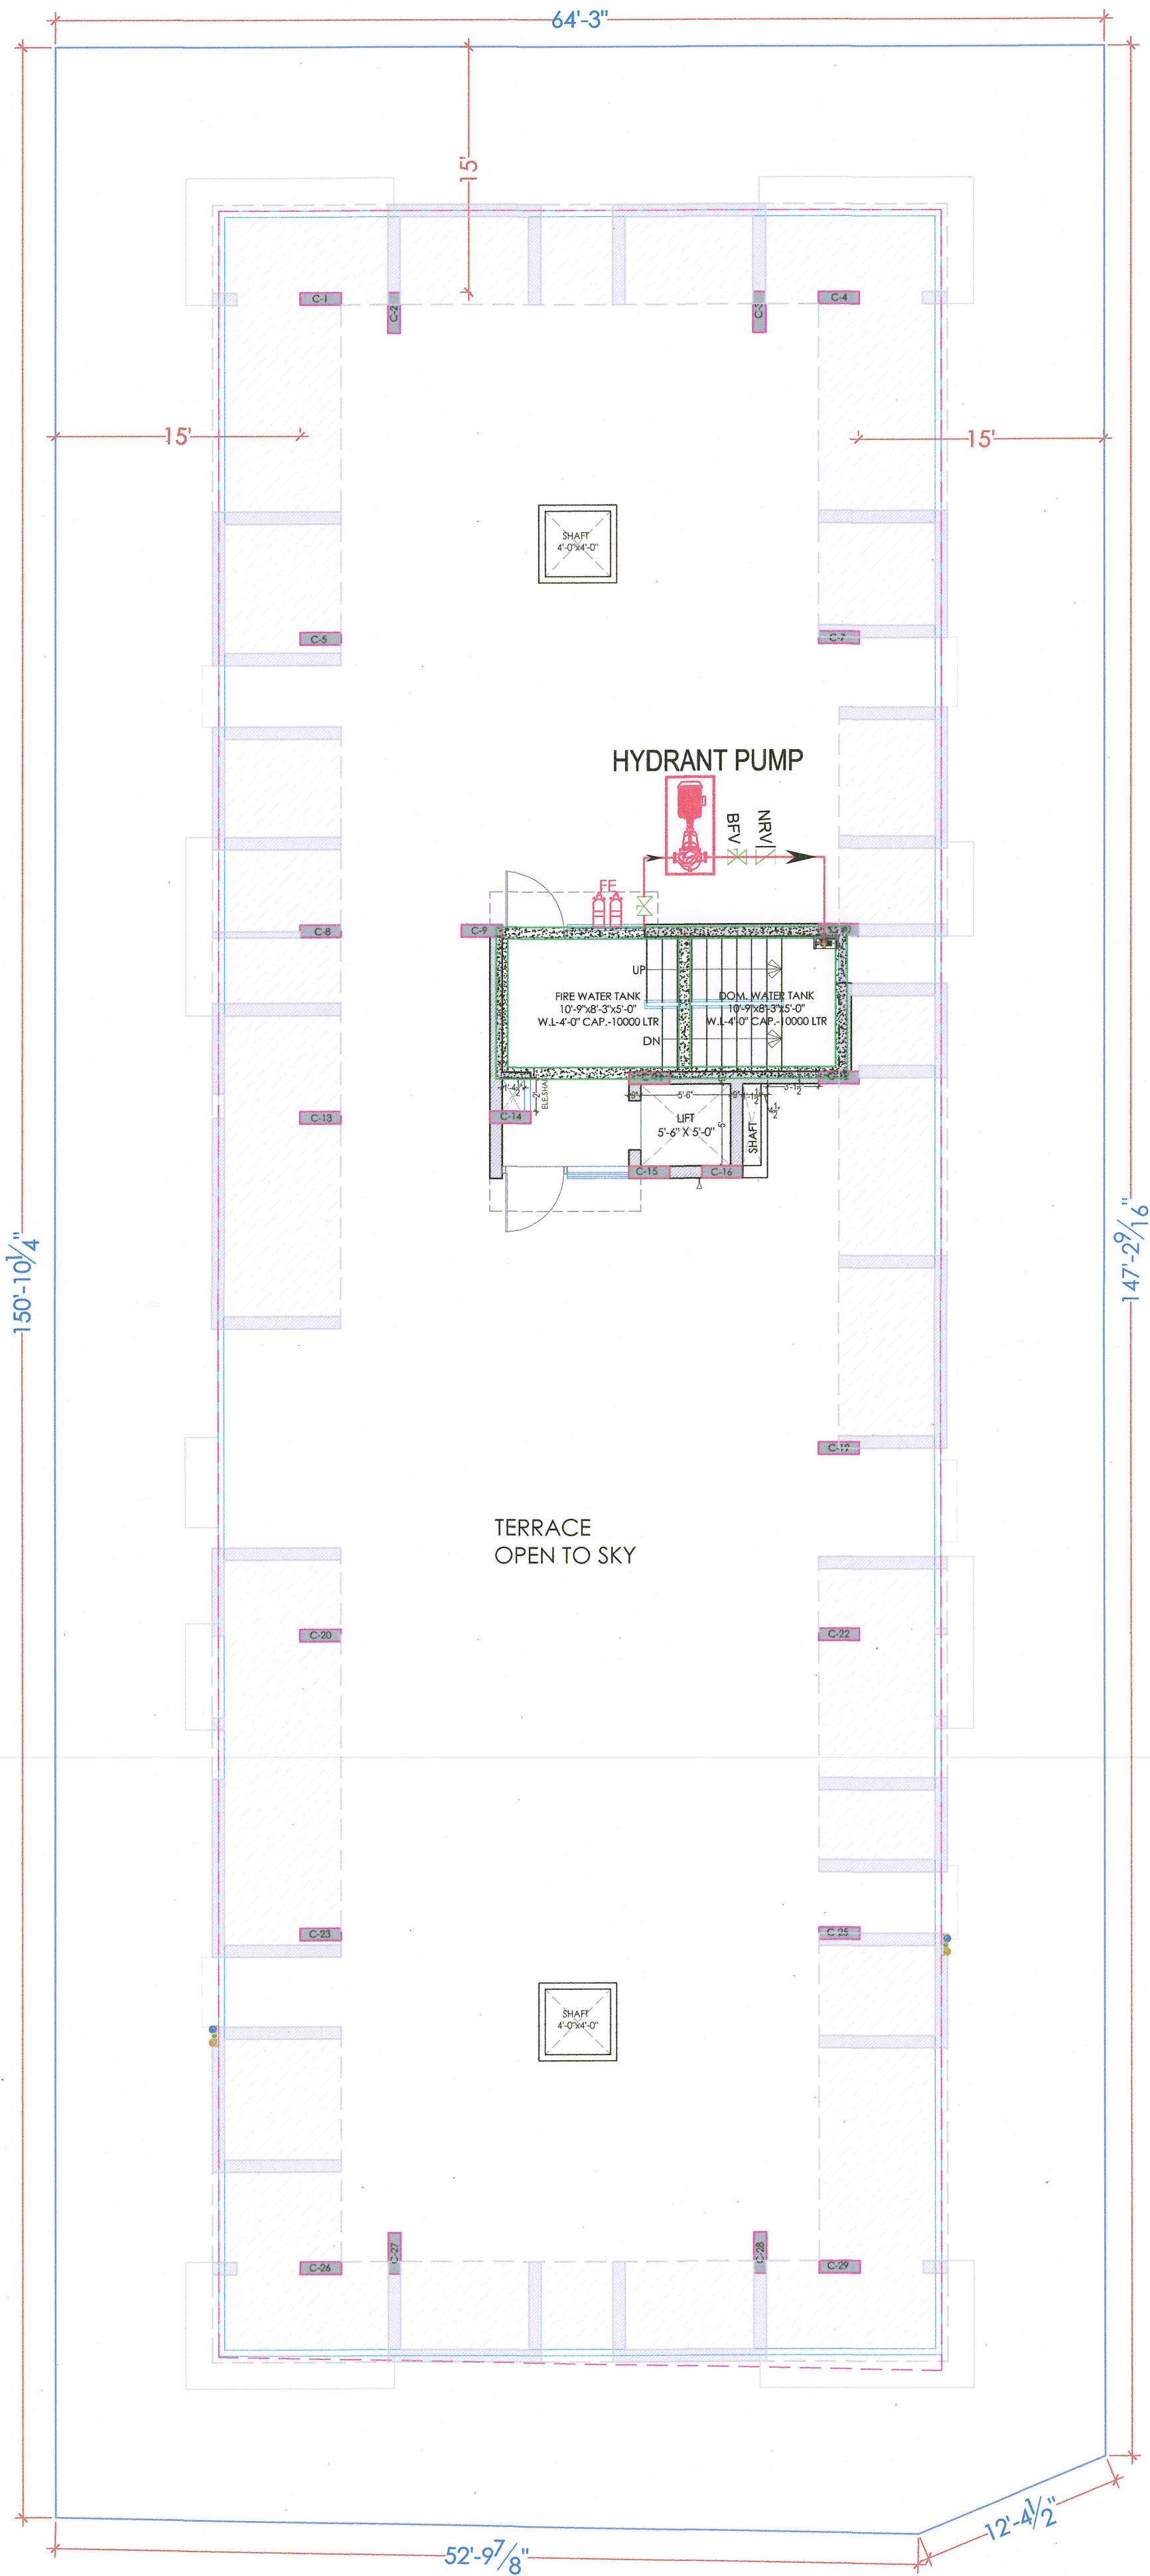


TERRACE FLOOR FIRE FIGHTING LAYOUT

PROJECT NAME :

ASTHA PRIME

DEVELOPER NAME :

ASTHA REAL ESTATE

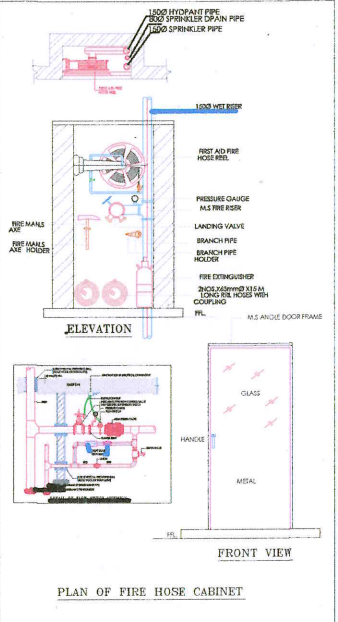

ELEVATION
FRONT VIEW
PLAN OF FIRE HOSE CABINET

LEGEND:-

FIRE HYDRANT MS PIPE	
BALL VALVE	
EXTERNAL FIRE HYDRANT	
EXTERNAL FIRE HOSE CABINET	
FIRE HOSE CABINET	
UPRIGHT SPRINKLER HEAD	
PENDENT SPRINKLER HEAD	
SIDE WALL SPRINKLER HEAD	
FIRE EXTINGUISHER	
FLOW SWITCH	FS
ISOLATION VALVE	IV
2 WAY FIRE BRIGADE INLET	

For ASTHA REAL ESTATE

Proprietor

Er. SANJEEV SHARMA
B.E (Electrical)

PROJECT:
PROPOSED RESIDENTIAL FLATS
ON PLOT NO. - 52
SCHEME - "RAJLAXMI ELCLAVE-X"
MANPUR DEVRI URF GOLIAWAS,
TEH :- SANGANER ,JAIPUR

NAME OF DRAWING:
**TERRACE FLOOR FIRE FIGHTING
LAYOUT**

DRAWING PLUMBING DRAWING	NORTH: 
PROJECT NO. :	DATE : 27, May. - 2024
SCALE : NTS	REV NO. : R-0

DRAWING NO. :
PROJECT CATEGORY BLOCK FLOOR TYPE NUMBER

A-01