

ROAD 9.0 MTR. WIDE
64'-3"

P.NO.
51

150'-10 1/4"

DRIVEWAY

DRIVEWAY

DRIVEWAY

DRIVEWAY

P.NO.
53

147'-29 1/16"

PATHWAY 3.0 MTR WIDE

P.U

ENTRY

EXIT

ROAD 12.0 MTR. WIDE
52'-9 7/8"

P.NO.
C-01

STILT FLOOR ELECTRICAL ROUTE LAYOUT
(TRANSFORMER,RMU,METER PANEL,ELECTRICAL CABLE)

For ASTHA REAL ESTATE

Proprietor

Er. SANJEEV SHARMA
B.E (Electrical)

PROJECT NAME :

ASTHA PRIME

DEVELOPER NAME :

ASTHA REAL ESTATE

LEGENDS:

Mounting Height	I D	Symbol	Description
CEILING	FAN/48"		CEILING FAN 48"
CEILING	FAN/30"		CEILING FAN 30"
CEILING	CHI		CHANDELIER
+93"	TL/W		Led Wall Tube Light Make:- Syska Led Cat no.- SSK-TS-20W
+93"	BULB		Led Bulb 20W Make:- Syska Led Cat no.- SKC-20W 5.7K/3K
+93"	GL		WALL BRACKETS AS DESIGN FOR GANESH LIGHT
+78"	ML		12x2 Led Mirror Light Make:- Syska Led Cat no.- FPL-12x2
CEILING	DL		Led 6" Down Lighter 20W (Surface Mounted) Make:- Syska Led Cat no.- SDL-15W GLD 6.5K/4K
VENTILATOR HT.	CR		CEILING ROSE
VENTILATOR HT.	EXF		9" DIA FRESH AIR FAN
+24"	2wSB		2w SWITCH BOARD
+42"	SB		SWITCH BOARD(6A SOCKET & SWITCH)
+24"	TEL		TELEPHONE POINT
+24"	LP TEL		6 A PLUG POINT FOR TELEPHONE
+48"	TV		TV COAXIAL POINT
+48"	LP TV		6 A PLUG POINT FOR TV
+24"	LP		6 A PLUG POINT FOR SIDE TABLE
+72"	LP-CH		6 A PLUG POINT FOR CHIMNEY
+12"	LP PC		6 A PLUG POINT FOR COMPUTER POINT
+93"	SAC		SPLIT AC INDOOR UNIT
+42"	PP-MIX		16 A POWER POINT FOR MIXER
+42"	PP-MIC		16 A POWER POINT FOR MICROWAVE
+78"	PP-G		16 A POWER POINT FOR GEYSER
+54"	PP-F		16 A POWER POINT FOR FRIDGE
+78"	PP-WP		16 A POWER POINT FOR WATER PURIFIER
+48"	PP-WM		16 A POWER POINT FOR WASHING MACHINE
+12"	PP-INV.		16 A POWER POINT FOR INVERTOR
+93"	PP-AC		25A SWITCH/MCB FOR AC
			CHAMBER(2' X 2')
+18"			6A 2 NOS. SOCKET +1 NOS. 16A SWITCH ,TELEPHONE,LAN
+60"	MCB DB		MCB DISTRIBUTION BOARD
			CAMERA
			WALL FAN

S.No DATE REVISION DESCRIPTION

GENERAL NOTES :

- All dimension on this drawing are in MKS System Only written dimensions are to be followed drawing should not be scaled.
- All measurements must be checked and verified by the contractors prior to execution of work at the site.
- This drawing is to be read in conjunction with all relevant structural, services & facility planning drawings.
- Architectural drawings are to be followed for the location of all structural members & masonry walls. for sizes & reinforcement details of structural members, relevant structural drawings are to be referred.
- Any discrepancies between architectural, structural and services drawings must be brought to the notice of the architect immediately & prior to execution at site. Co-ordination with services such as hvac, plumbing & electrical, etc. is the responsibility of the contractor.
- All masonry walls should be aligned with the columns as indicated on the plan, irrespective of the position as calculated with the dimensioning.
- For details, refer relevant large scale detail drgs. as indicated.

PROJECT:

PROPOSED RESIDENTIAL FLATS
ON PLOT NO. - 52
SCHEME "RAJLAXMI ELCLAVE-X"
MANPUR DEVRI URF GOLIAWAS,
TEH :- SANGANER ,JAIPUR

NAME OF DRAWING:

STILT FLOOR
ELECTRICAL ROUTE LAYOUT
(TRANSFORMER,RMU,METER PANEL,
ELECTRICAL CABLE)

DRAWING

WORKING DRAWING

PROJECT NO. :

DATE:
27, May. - 2024

SCALE :

NTS

REV NO. :

R-0

DRAWING NO. :

PROJECT CATEGORY BLOCK FLOOR TYPE NUMBER

A-01

P.NO.
51

P.NO.
53

147'-2 9/16"

PATHWAY 3.0 MTR WIDE

P.U

P.NO.
C-01

ROAD 9.0 MTR. WIDE
64'-3"

150'-10 1/4"

ROAD 12.0 MTR. WIDE
52'-9 7/8"

EXIT

ENTRY

STILT FLOOR ELECTRICAL ROUTE LAYOUT
(TRANSFORMER,RMU,METER PANEL,ELECTRICAL CABLE)

For ASTHA REAL ESTATE

बेण्णगाम

Proprietor

Er. SANJEEV SHARMA
B.E (Electrical)

PROJECT NAME :

ASTHA PRIME

DEVELOPER NAME :

ASTHA REAL ESTATE

LEGENDS:

Mounting Height	ID	Symbol	Description
CEILING	FAN/48"		CEILING FAN 48"
CEILING	FAN/30"		CEILING FAN 30"
CEILING	CHI		CHANDELIER
+93"	TL/W		Led Wall Tube Light Make:- Syska Led Cat no:- SSK-T5-20W
+93"	BULB		Led Bulb 20W Make:- Syska Led Cat no:- SSK-20W 5.7K/3K
+93"	GL		WALL BRACKETS AS DESIGN FOR GANESH LIGHT
+78"	ML		12x2 Led Mirror Light Make:- Syska Led Cat no:- PPL-12x2
CEILING	DL		Led 6" Down Lighter 20W (Surface Mounted) Make:- Syska Led Cat no:- SDL-15W GLD 6.5K/4K
VENTILATOR HT.	CR		CEILING ROSE
VENTILATOR HT.	EXF		9" DIA FRESH AIR FAN
+24"	2wSB		2w SWITCH BOARD
+42"	SB		SWITCH BOARD (6A SOCKET & SWITCH)
+24"	TEL		TELEPHONE POINT
+24"	LP TEL		6 A PLUG POINT FOR TELEPHONE
+48"	TV		TV COAXIAL POINT
+48"	LP TV		6 A PLUG POINT FOR TV
+24"	LP		6 A PLUG POINT FOR SIDE TABLE
+72"	LP-CH		6 A PLUG POINT FOR CHIMNEY
+12"	LP PC		6 A PLUG FOR COMPUTER POINT
+93"	SAC		SPLIT AC INDOOR UNIT
+42"	PP-MIX		16 A POWER POINT FOR MIXER
+42"	PP-MIC		16 A POWER POINT FOR MICROWAVE
+78"	PP-G		16 A POWER POINT FOR GEYSER
+54"	PP-F		16 A POWER POINT FOR FRIDGE
+78"	PP-WP		16 A POWER POINT FOR WATER PURIFIER
+48"	PP-WM		16 A POWER POINT FOR WASHING MACHINE
+12"	PP-INV.		16 A POWER POINT FOR INVERTOR
+93"	PP-AC		25A SWITCH/AC FOR AC
			CHAMBER (2' X 2')
+18"			6A 2 NOS. SOCKET +1 NOS. 16A SWITCH, TELEPHONE, LAN
+60"	MCB DB		MCB DISTRIBUTION BOARD
			CAMERA
			WALL FAN

S.No	DATE	REVISION DESCRIPTION
GENERAL NOTES :		
1.	All dimension on this drawing are in MKS System Only written dimensions are to be followed. Drawing should not be scaled.	
2.	All measurements must be checked and verified by the contractors prior to execution of work at the site.	
3.	This drawing is to be read in conjunction with all relevant structural, services & facility planning drawings.	
4.	Architectural drawings are to be followed for the location of all structural members & masonry walls. For sizes & reinforcement details of structural members, relevant structural drawings are to be referred.	
5.	Any discrepancies between architectural, structural and services drawings must be brought to the notice of the architects immediately & prior to execution at site.	
6.	Co-ordination with services such as hvac, plumbing & electrical, etc. is the responsibility of the contractor.	
7.	All masonry walls should be aligned with the columns as indicated on the plan, irrespective of the position as calculated with the dimensioning.	
8.	For details, refer relevant large scale detail drawings as indicated.	

PROJECT:
PROPOSED RESIDENTIAL FLATS
ON PLOT NO. - 52
SCHEME "RAJLAXMI ELCLAVE-X"
MANPUR DEVRI URF GOLIAWAS,
TEH :- SANGANER, JAIPUR

NAME OF DRAWING: **STILT FLOOR
CEILING ELECTRICAL LAYOUT,
ELECTRICAL POINT DRAWING,
CAMERA POINT DRAWING**

DRAWING WORKING DRAWING	NORTH:
PROJECT NO. :	DATE: 27, May. - 2024
SCALE: NTS	REV NO. : R-0

DRAWING NO. :	
PROJECT	CATEGORY
BLOCK	FLOOR
TYPE	NUMBER

A-01

ROAD 9.0 MTR. WIDE
64'-3"

PROJECT NAME :

ASTHA PRIME

DEVELOPER NAME :

ASTHA REAL ESTATE

LEGENDS:

Mounting Height	ID	Symbol	Description
CEILING	FAN/48"		CEILING FAN 48"
CEILING	FAN/30"		CEILING FAN 30"
CEILING	CHI		CHANDELIER
+93"	TL/W		Led Wall Tube Light Make:- Syska Led Cat no:- SSK-T5-20W
+93"	BULB		Led Bulb 20W Make:- Syska Led Cat no:- SKC-20W 5.7K/3K
+93"	GL		WALL BRACKETS AS DESIGN FOR GANESH LIGHT
+78"	ML		12x2 Led Mirror Light Make:- Syska Led Cat no:- FPL-12x2
CEILING	DL		Led 6" Down Lighter 20W (Surface Mounted) Make:- Syska Led Cat no:- SDL-15W GLD 6.5K/4K
VENTILATOR HT.	CR		CEILING ROSE
VENTILATOR HT.	EXF		9" DIA FRESH AIR FAN
+24"	2wSB		2wSWITCH BOARD
+42"	SB		SWITCH BOARD(6A SOCKET & SWITCH)
+24"	TEL		TELEPHONE POINT
+24"	LP TEL		6 A PLUG POINT FOR TELEPHONE
+48"	TV		TV COAXIAL POINT
+48"	LP TV		6 A PLUG POINT FOR TV
+24"	LP		6 A PLUG POINT FOR SIDE TABLE
+72"	LP-CH		6 A PLUG POINT FOR CHIMNEY
+12"	LP PC		6 A PLUG FOR COMPUTER POINT
+93"	SAC		SPLIT AC INDOOR UNIT
+42"	PP-MIX		16 A POWER POINT FOR MIXER
+42"	PP-MIC		16 A POWER POINT FOR MICROWAVE
+78"	PP-G		16 A POWER POINT FOR GEYSER
+54"	PP-F		16 A POWER POINT FOR FRIDGE
+78"	PP-WP		16 A POWER POINT FOR WATER PURIFIER
+48"	PP-WM		16 A POWER POINT FOR WASHING MACHINE
+12"	PP-INV.		16 A POWER POINT FOR INVERTOR
+93"	PP-AC		25A SWITCH/MCB FOR AC
			CHAMBER(2' X 2')
+18"			6A 2 NOS. SOCKET +1 NOS. 16A SWITCH ,TELEPHONE,LAN
+60"	MCB DB		MCB DISTRIBUTION BOARD
			CAMERA
			WALL FAN

P.NO.
51

150'-10 1/4"

147'-2 9/16"

52'-9 7/8"

12'-4 1/2"

For ASTHA REAL ESTATE
श्रीगणेश
Proprietor


Sharma
Er. SANJEEV SHARMA
B.E (Electrical)

TYPICAL FLOOR ELECTRICAL LAYOUT (GROUND TO 5TH.)
(ELECTRICAL POINT,CEILING POINT,TV)

S.No		DATE		REVISION DESCRIPTION	
GENERAL NOTES :					
1. All dimension on this drawing are in MKS System Only written dimensions are to be followed. drawing should not be scaled.					
2. All measurements must be checked and verified by the contractors prior to execution of work at the site.					
3. This drawing is to be read in conjunction with all relevant structural, services & facility planning drawings.					
4. Architectural drawings are to be followed for the location of all structural members & masonry walls, for sizes & reinforcement details of structural members, relevant structural drawings are to be referred.					
5. Any discrepancies between architectural, structural and services drawings must be brought to the notice of the architects immediately & prior to execution at site.					
6. Co-ordination with services such as hvac, plumbing & electrical, etc. is the responsibility of the contractors.					
7. All masonry walls should be aligned with the columns as indicated on the plan, irrespective of the position as calculated with the dimensioning.					
8. For details, refer relevant large scale detail dpgs, as indicated.					
PROJECT:					
PROPOSED RESIDENTIAL FLATS ON PLOT NO. - 52					
SCHEME - "RAJLAXMI ELCLAVE-X"					
MANPUR DEVRI URF GOLIAWAS, TEH :- SANGANER ,JAIPUR					
NAME OF DRAWING:					
TYPICAL FLOOR ELECTRICAL LAYOUT G+5 (ELECTRICAL POINT, TV, CEILING POINT,TV)					
DRAWING		NORTH:			
WORKING DRAWING					
PROJECT NO. :		DATE :			
		27, May. - 2024			
SCALE :		REV NO. :			
NTS		R-0			
DRAWING NO. :					
A-01					

ROAD 9.0 MTR. WIDE
64'-3"

PROJECT NAME :
ASTHA PRIME
DEVELOPER NAME :
ASTHA REAL ESTATE

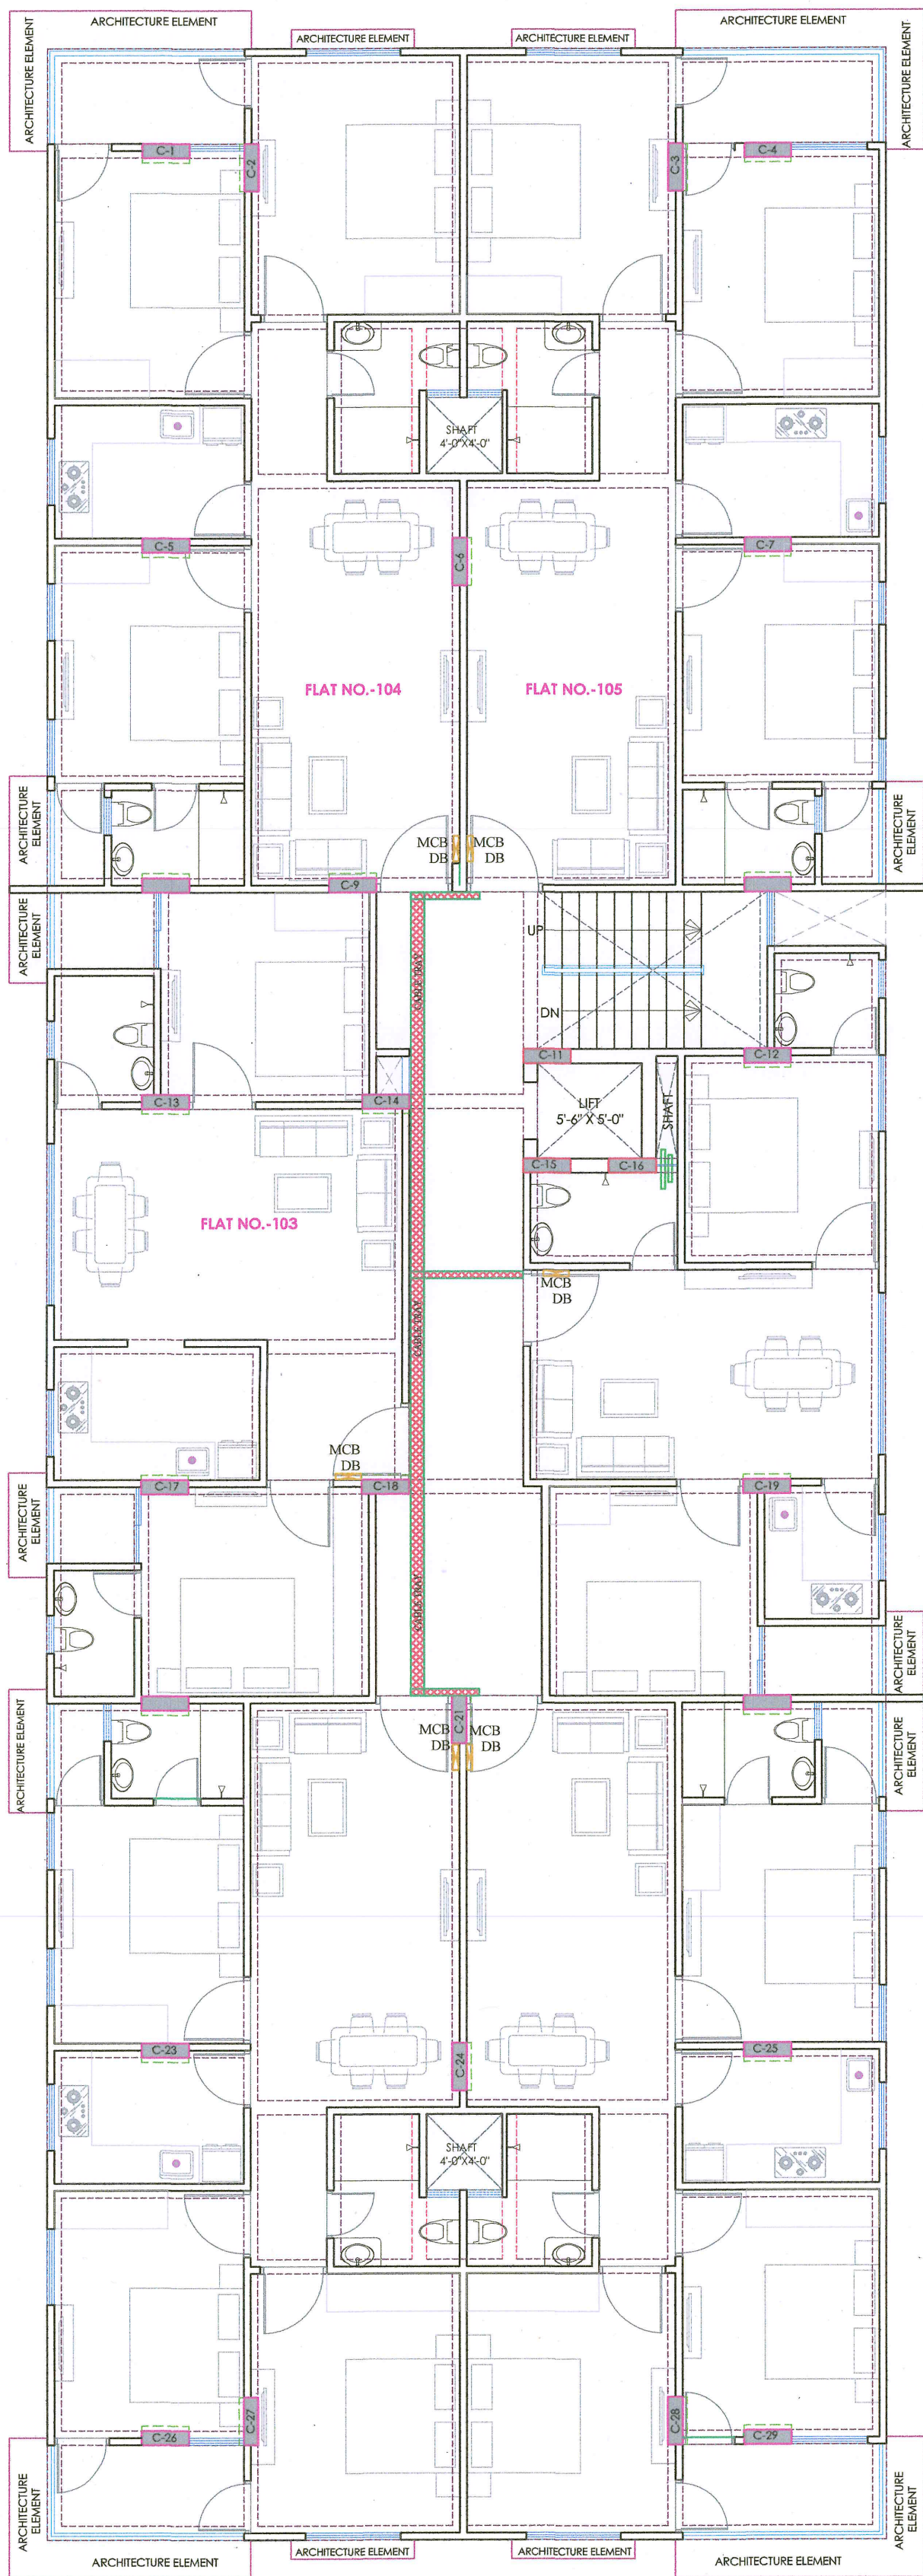


LEGENDS:			
Mounting Height	I D	Symbol	Description
CEILING	FAN/48"		CEILING FAN 48"
CEILING	FAN/30"		CEILING FAN 30"
CEILING	CHI		CHANDELIER
+93"	TL/W		Led Wall Tube Light Make:- Syska Led Cat no:- SSK-T5-20W
+93"	BULB		Led Bulb 20W Make:- Syska Led Cat no:- SKC-20W 5.7K/3K
+93"	GL		WALL BRACKETS AS DESIGN FOR GANESH LIGHT
+78"	ML		12x2 Led Mirror Light Make:- Syska Led Cat no:- FPL-12x2
CEILING	DL		Led 6" Down Lighter 20W (Surface Mounted) Make:- Syska Led Cat no:- SDL-15W GLD 6.5K/4K
VENTILATOR HT.	CR		CEILING ROSE
VENTILATOR HT.	EXF		9" DIA FRESH AIR FAN
+24"	2wSB		2wSWITCH BOARD
+42"	SB		SWITCH BOARD(6A SOCKET & SWITCH)
+24"	TEL		TELEPHONE POINT
+24"	LP TEL		6 A PLUG POINT FOR TELEPHONE
+48"	TV		TV COAXIAL POINT
+48"	LP TV		6 A PLUG POINT FOR TV
+24"	LP		6 A PLUG POINT FOR SIDE TABLE
+72"	LP-CH		6 A PLUG POINT FOR CHIMNEY
+12"	LP PC		6 A PLUG POINT FOR COMPUTER POINT
+93"	SAC		SPLIT AC INDOOR UNIT
+42"	PP-MIX		16 A POWER POINT FOR MIXER
+42"	PP-MIC		16 A POWER POINT FOR MICROWAVE
+78"	PP-G		16 A POWER POINT FOR GEYSER
+54"	PP-F		16 A POWER POINT FOR FRIDGE
+78"	PP-WP		16 A POWER POINT FOR WATER PURIFIER
+48"	PP-WM		16 A POWER POINT FOR WASHING MACHINE
+12"	PP-INV.		16 A POWER POINT FOR INVERTOR
+93"	PP-AC		25A SWITCH/MCB FOR AC
			CHAMBER(2' X 2')
+18"			6A 2 NOS. SOCKET +1 NOS. 16A SWITCH ,TELEPHONE,LAN
+60"	MCB DB		MCB DISTRIBUTION BOARD
			CAMERA
			WALL FAN

S.No	DATE	REVISION DESCRIPTION
GENERAL NOTES :		
1.	All dimension on this drawing are in MKS System Only written dimensions are to be followed. drawing should not be scaled.	
2.	All measurements must be checked and verified by the contractors prior to execution of work at the site.	
3.	This drawing is to be read in conjunction with all relevant structural, services & facility planning drawings.	
4.	Architectural drawings are to be followed for the location of all structural members & masonry walls. for sizes & reinforcement details of structural members, relevant structural drawings are to be referred.	
5.	Any discrepancies between architectural, structural and services drawings must be brought to the notice of the architects immediately & prior to execution at site.	
6.	Co-ordination with services such as hvac, plumbing & electrical, etc. is the responsibility of the contractors.	
7.	All masonry walls should be aligned with the columns as indicated on the plan, irrespective of the position as calculated with the dimensioning.	
8.	For details, refer relevant large scale detail drgs. as indicated.	

PROJECT:
PROPOSED RESIDENTIAL FLATS
ON PLOT NO. - 52
SCHEME "RAJLAXMI ELCLAVE-X"
MANPUR DEVRI URF GOLIAWAS,
TEH :- SANGANER ,JAIPUR

 NAME OF DRAWING:
TYPICAL FLOOR ELECTRICAL
LAYOUT(GROUND TO 5TH.)
(ELECTRICAL CABLES,ELECTRICAL DB,
ELECTRICAL SHAFT, CABLE TRAY)

DRAWING WORKING DRAWING	NORTH: 																		
PROJECT NO. :	DATE : 27, May. - 2024																		
SCALE : NTS	REV NO. : R-0																		
DRAWING NO. :																			
<table border="1"><tr><td></td><td></td><td></td><td></td><td></td><td></td><td></td><td></td><td></td></tr><tr><td>PROJECT</td><td>CATEGORY</td><td>BLOCK</td><td>FLOOR</td><td>TYPE</td><td>NUMBER</td><td colspan="3"></td></tr></table>										PROJECT	CATEGORY	BLOCK	FLOOR	TYPE	NUMBER				
PROJECT	CATEGORY	BLOCK	FLOOR	TYPE	NUMBER														
A-01																			

P.NO.
51

150'-10 1/4"

147'-2 1/16"

52'-9 7/8"

12'-4 1/2"

For ASTHA REAL ESTATE
प्रोप्रायटर
Proprietor

Sharma
Er. SANJEEV SHARMA
B.E.T (Electrical)

TYPICAL FLOOR ELECTRICAL LAYOUT(GROUND TO 5TH.)
(ELECTRICAL CABLES,ELECTRICAL DB, ELECTRICAL SHAFT, CABLE TRAY)


MAIN PANEL

PROJECT NAME :

ASTHA PRIME

DEVELOPER NAME :

ASTHA REAL ESTATE

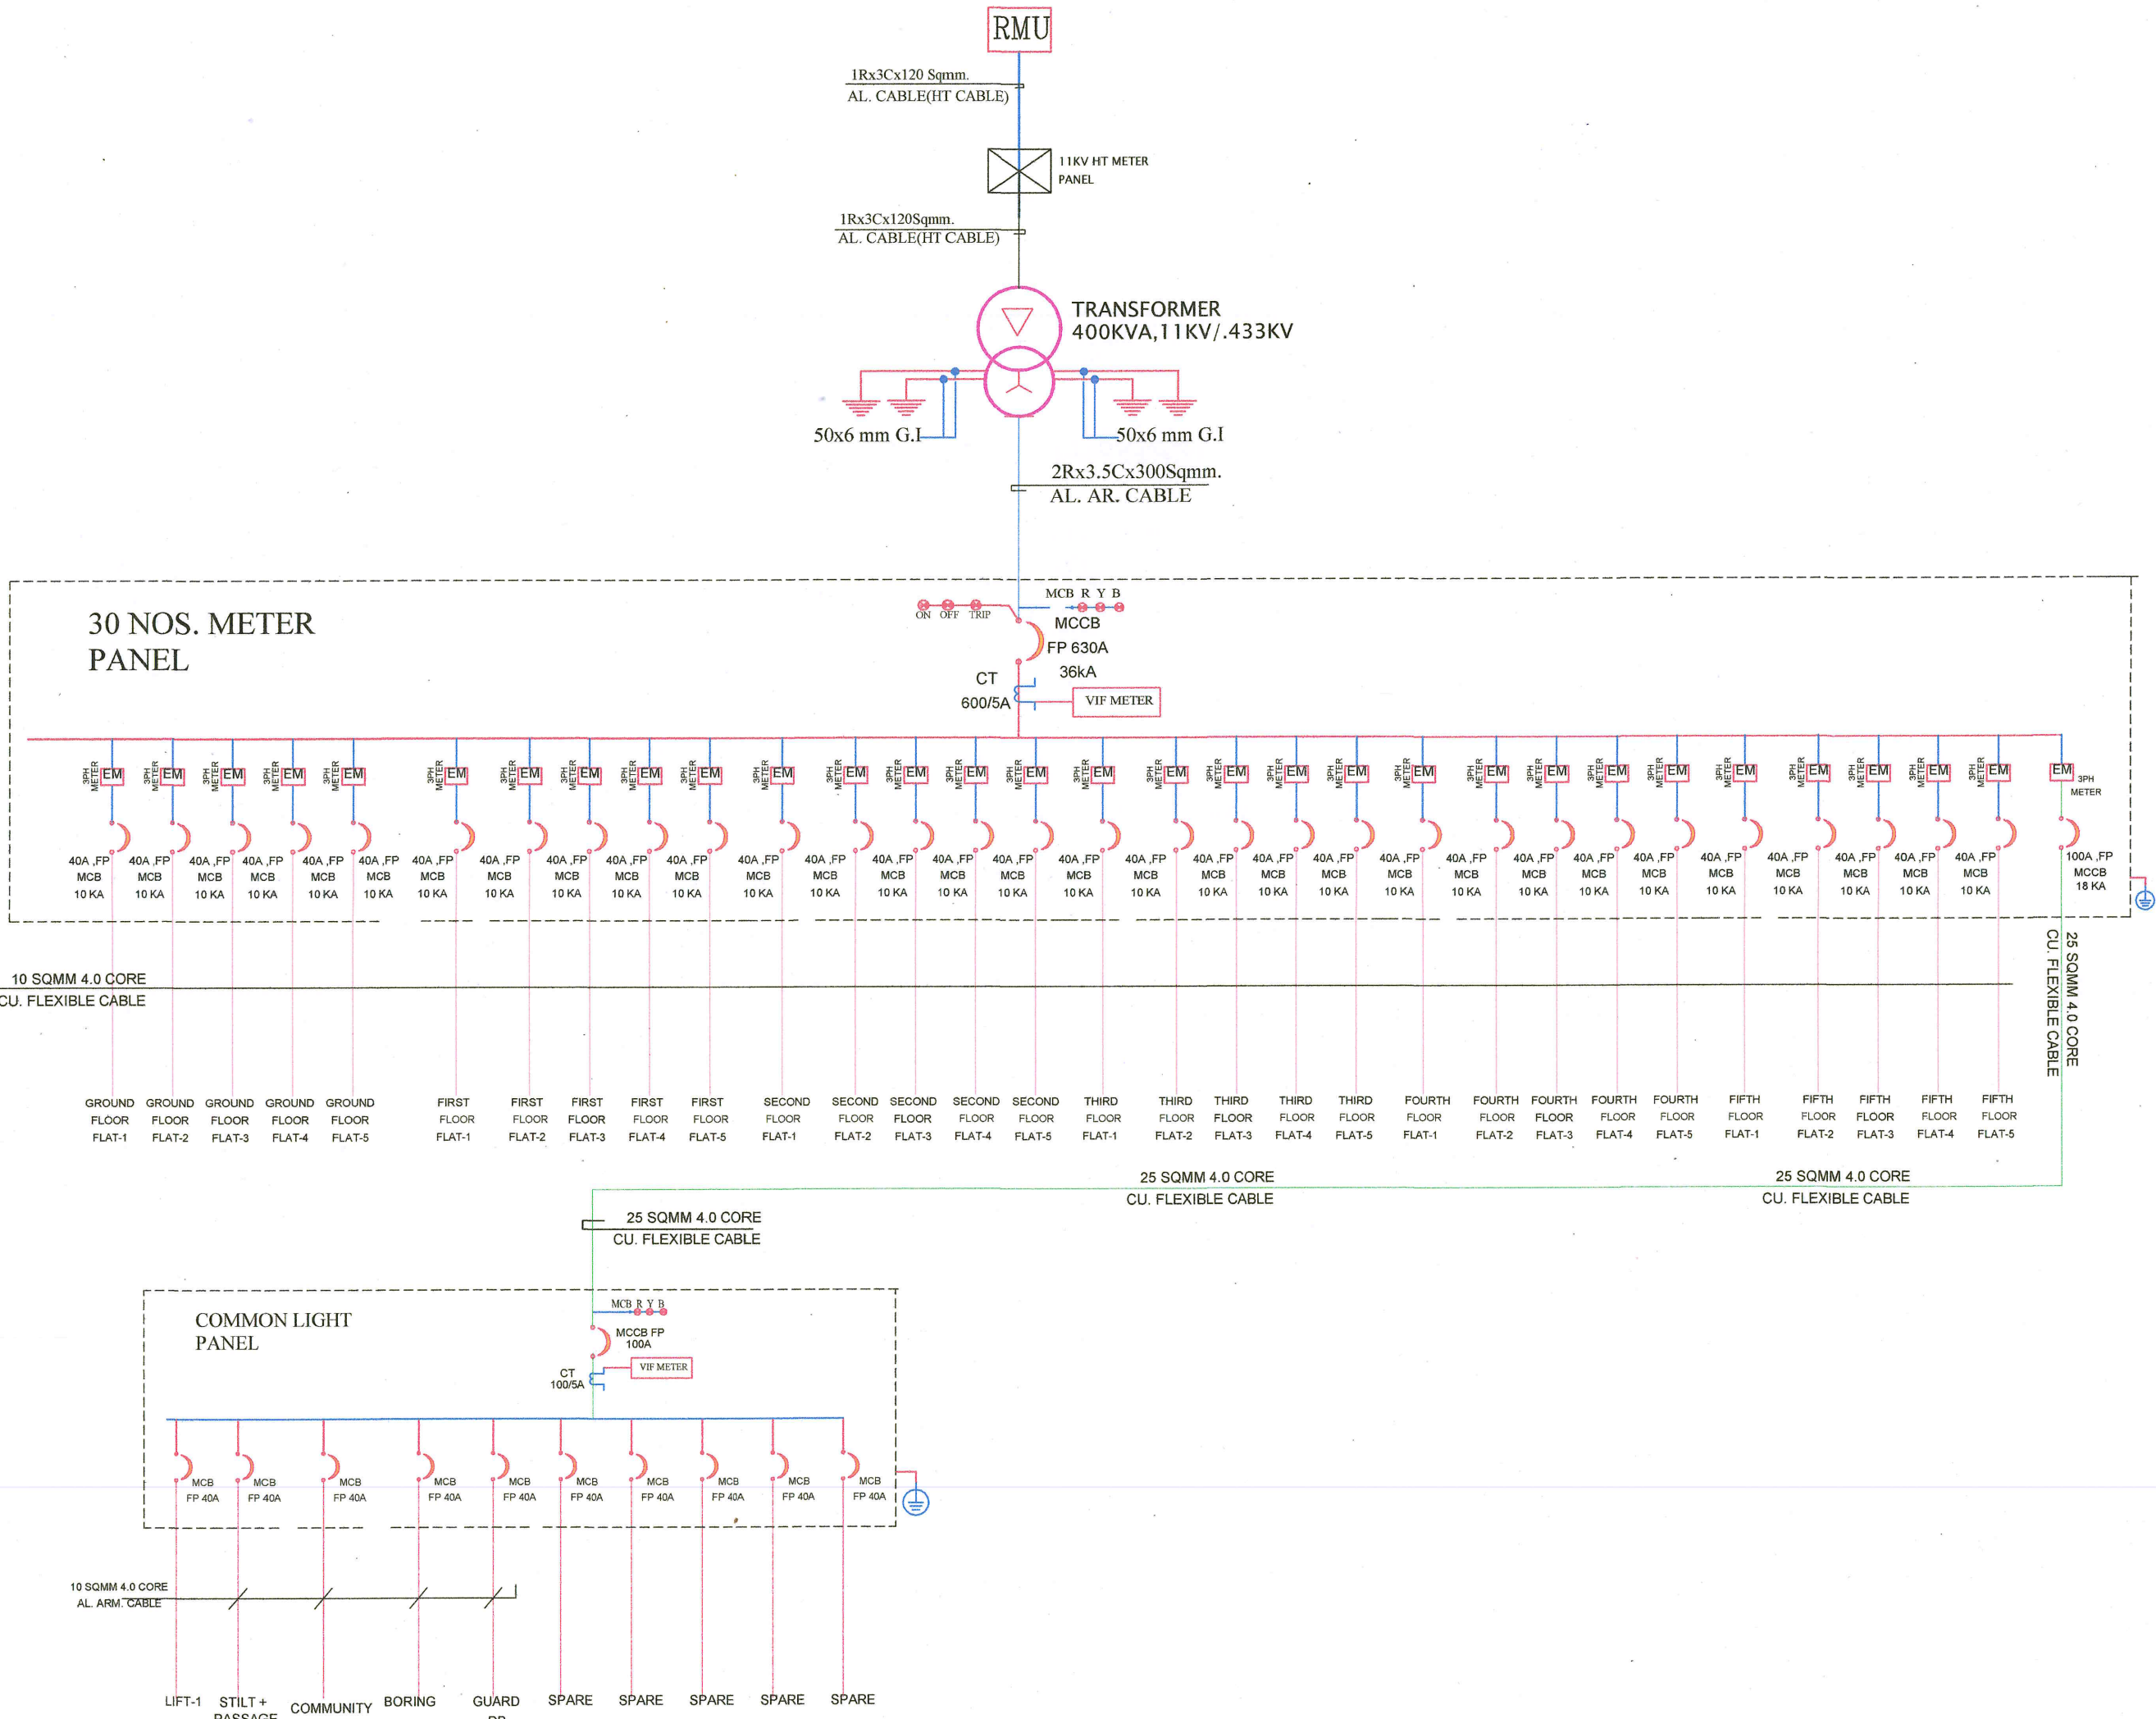

For ASTHA REAL ESTATE
वैष्णव
Proprietor

Shayma
Er. SANJEEV SHARMA
B.E (Electrical)

SINGLE LINE DIAGRAM
MAIN PANEL(SLD/DISTRIBUTION DETAILS AFTER LT PANEL

S.No	DATE	REVISION DESCRIPTION
GENERAL NOTES :		
1.		All dimension on this drawing are in MGS System Only written dimensions are to be followed .drawing should not be scaled.
2.		All measurements must be checked and verified by the contractors prior to execution
3.		Work to be done at the site.
4.		This drawing is to be read in conjunction with all relevant structural, services & facility planning drawings.
5.		Architectural drawings are to be followed for the location of all structural members & masonry walls, for sizes & reinforcement details of structural members, relevant structural drawings are to be referred.
6.		Any discrepancies between architectural, structural and services drawings must be brought to the notice of the architects immediately & prior to execution at site.
7.		Coordination with services such as truss, plumbing & electrical, etc. is the responsibility of the contractor.
8.		All masonry walls should be aligned with the columns as indicated on the plan, irrespective of the position as calculated with the dimensioning.
9.		For details, refer relevant large scale detail drgs. as indicated.
PROJECT:		
PROPOSED RESIDENTIAL FLATS ON PLOT NO. - 52		
SCHEME "RAJLAXMI ELCLAVE-X"		
MANPUR DEVRI URF GOLIOWAS, TEH :- SANGANER ,JAIPUR		
NAME OF DRAWING:		
MAIN PANEL(SLD/DISTRIBUTION DETAILS AFTER LT PANEL		
DRAWING	NORTH:	
WORKING DRAWING		
PROJECT NO. :	DATE :	
	27, May, - 2024	
SCALE :	REV NO. :	
NTS	R-0	
DRAWING NO. :		
PROJECT	CATEGORY	BLOCK
		FLOOR
		TYPE
		NUM
A-01		