


PROJECT NAME :

ASTHA PRIME


DEVELOPER NAME :

ASTHA REAL ESTATE

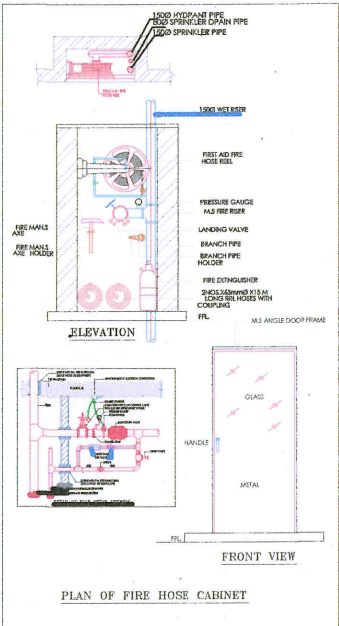

LEGEND:-

FIRE HYDRANT MS PIPE	
BALL VALVE	1/2"
EXTERNAL FIRE HYDRANT	1/2"
EXTERNAL FIRE HOSE CABINAT	1/2"
FIRE HOSE CABINAT	1/2"
UPRIGHT SPRINKLER HEAD	1/2"
PENDENT SPRINKLER HEAD	1/2"
SIDE WALL SPRINKLER HEAD	1/2"
FIRE EXINGUISHER	1/2"
FLOW SWITCH	FS
ISOLATION VALVE	IV
2 WAY FIRE BRIGADE INLET	1/2"

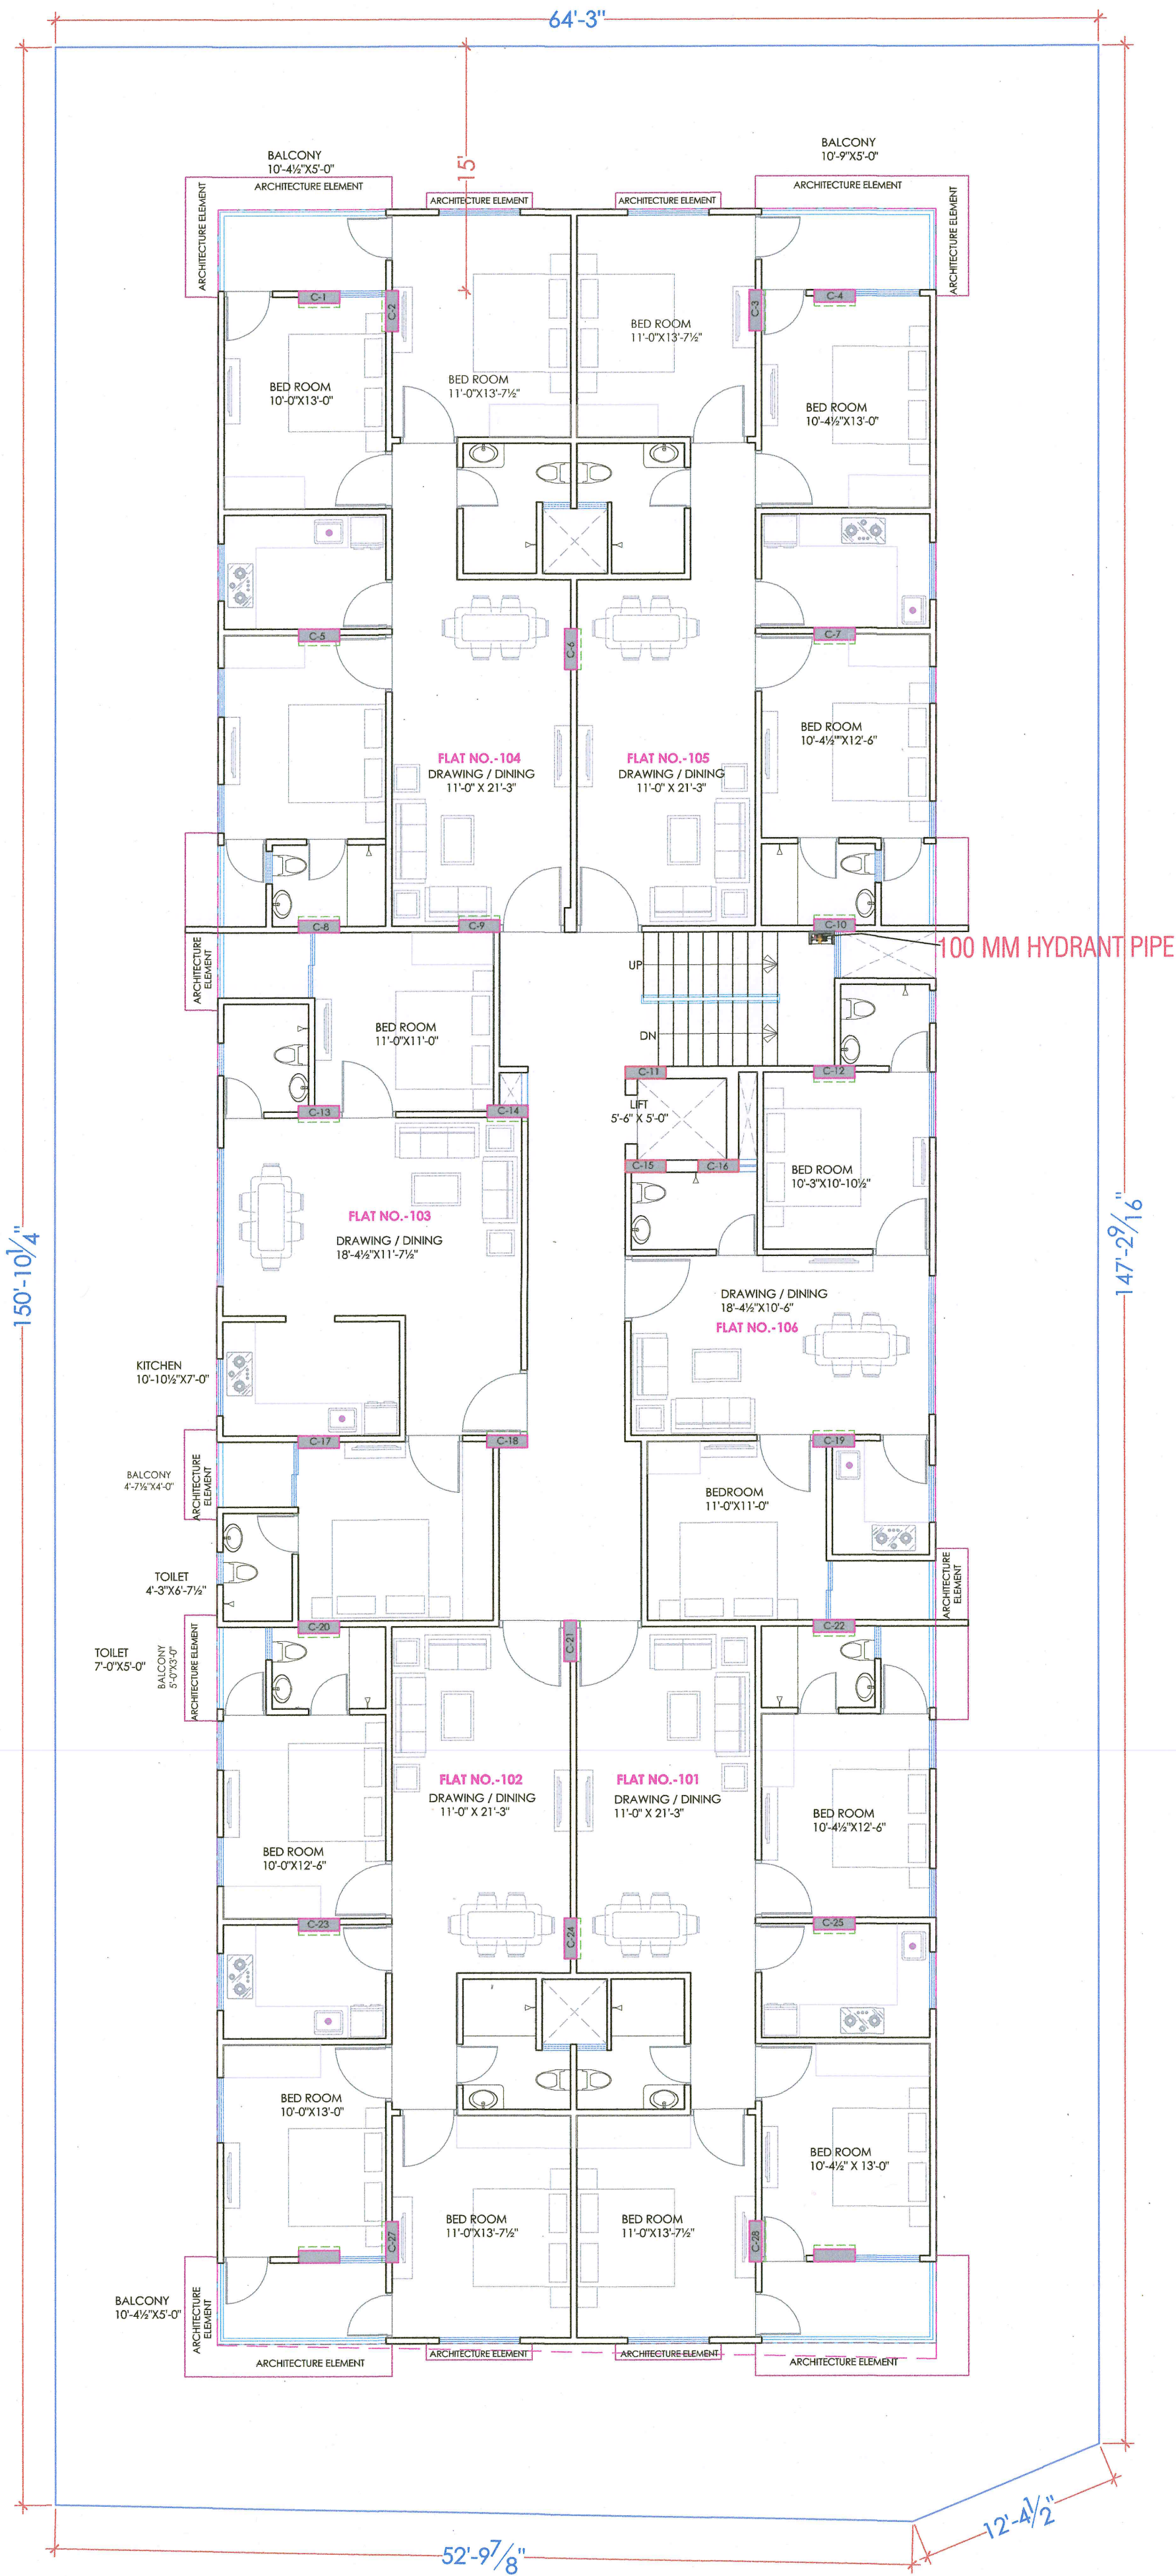

For ASTHA REAL ESTATE
Proprietor

Er. SANJEEV SHARM/
B.E (Electrical)

PROJECT:

PROPOSED RESIDENTIAL FLATS
ON PLOT NO. - 52
SCHEME "RAJLAXMI ELCLAVE-X"
MANPUR DEVRI URF GOLIAWAS,
TEH :- SANGANER ,JAIPUR

NAME OF DRAWING:

TYPICAL FLOOR PLAN (GROUND TO
5TH.) FIRE FIGHTING LAYOUT

DRAWING
PLUMBING DRAWING

PROJECT NO. :

DATE :
27, May, - 2024

SCALE :
NTS

REV NO. :
R-0

DRAWING NO. :
PROJECT CATEGORY BLOCK FLOOR TYPE NUMBER


TYPICAL FLOOR PLAN (GROUND TO 5TH.) FIRE FIGHTING LAYOUT

PROJECT NAME :	
----------------	--

ASTHA PRIME


DEVELOPER NAME :

ASTHA REAL ESTATE

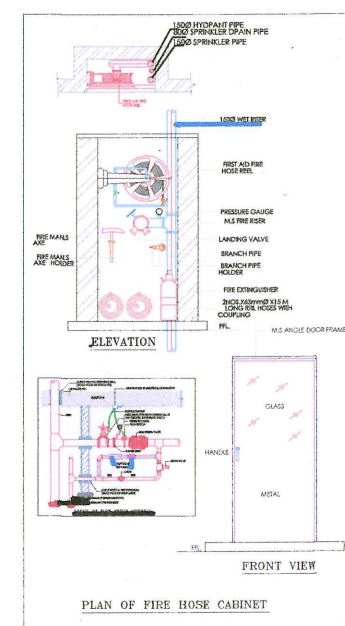

LEGEND:-

LEGEND:-	
FIRE HYDRANT MS PIPE	
DALL VALVE	
EXTERNAL FIRE HYDRANT	
EXTERNAL FIRE HOSE CABINAT	
FIRE HOSE CABINAT	
UPRIGHT SPRINKLER HEAD	
PENDENT SPRINKLER HEAD	
SIDE WALL SPINKLER HEAD	
FIRE EXNGUISHER	
FLOW SWITCH	
ISOLATION VALVE	
2 WAY FIRE BRIGADE INLET	

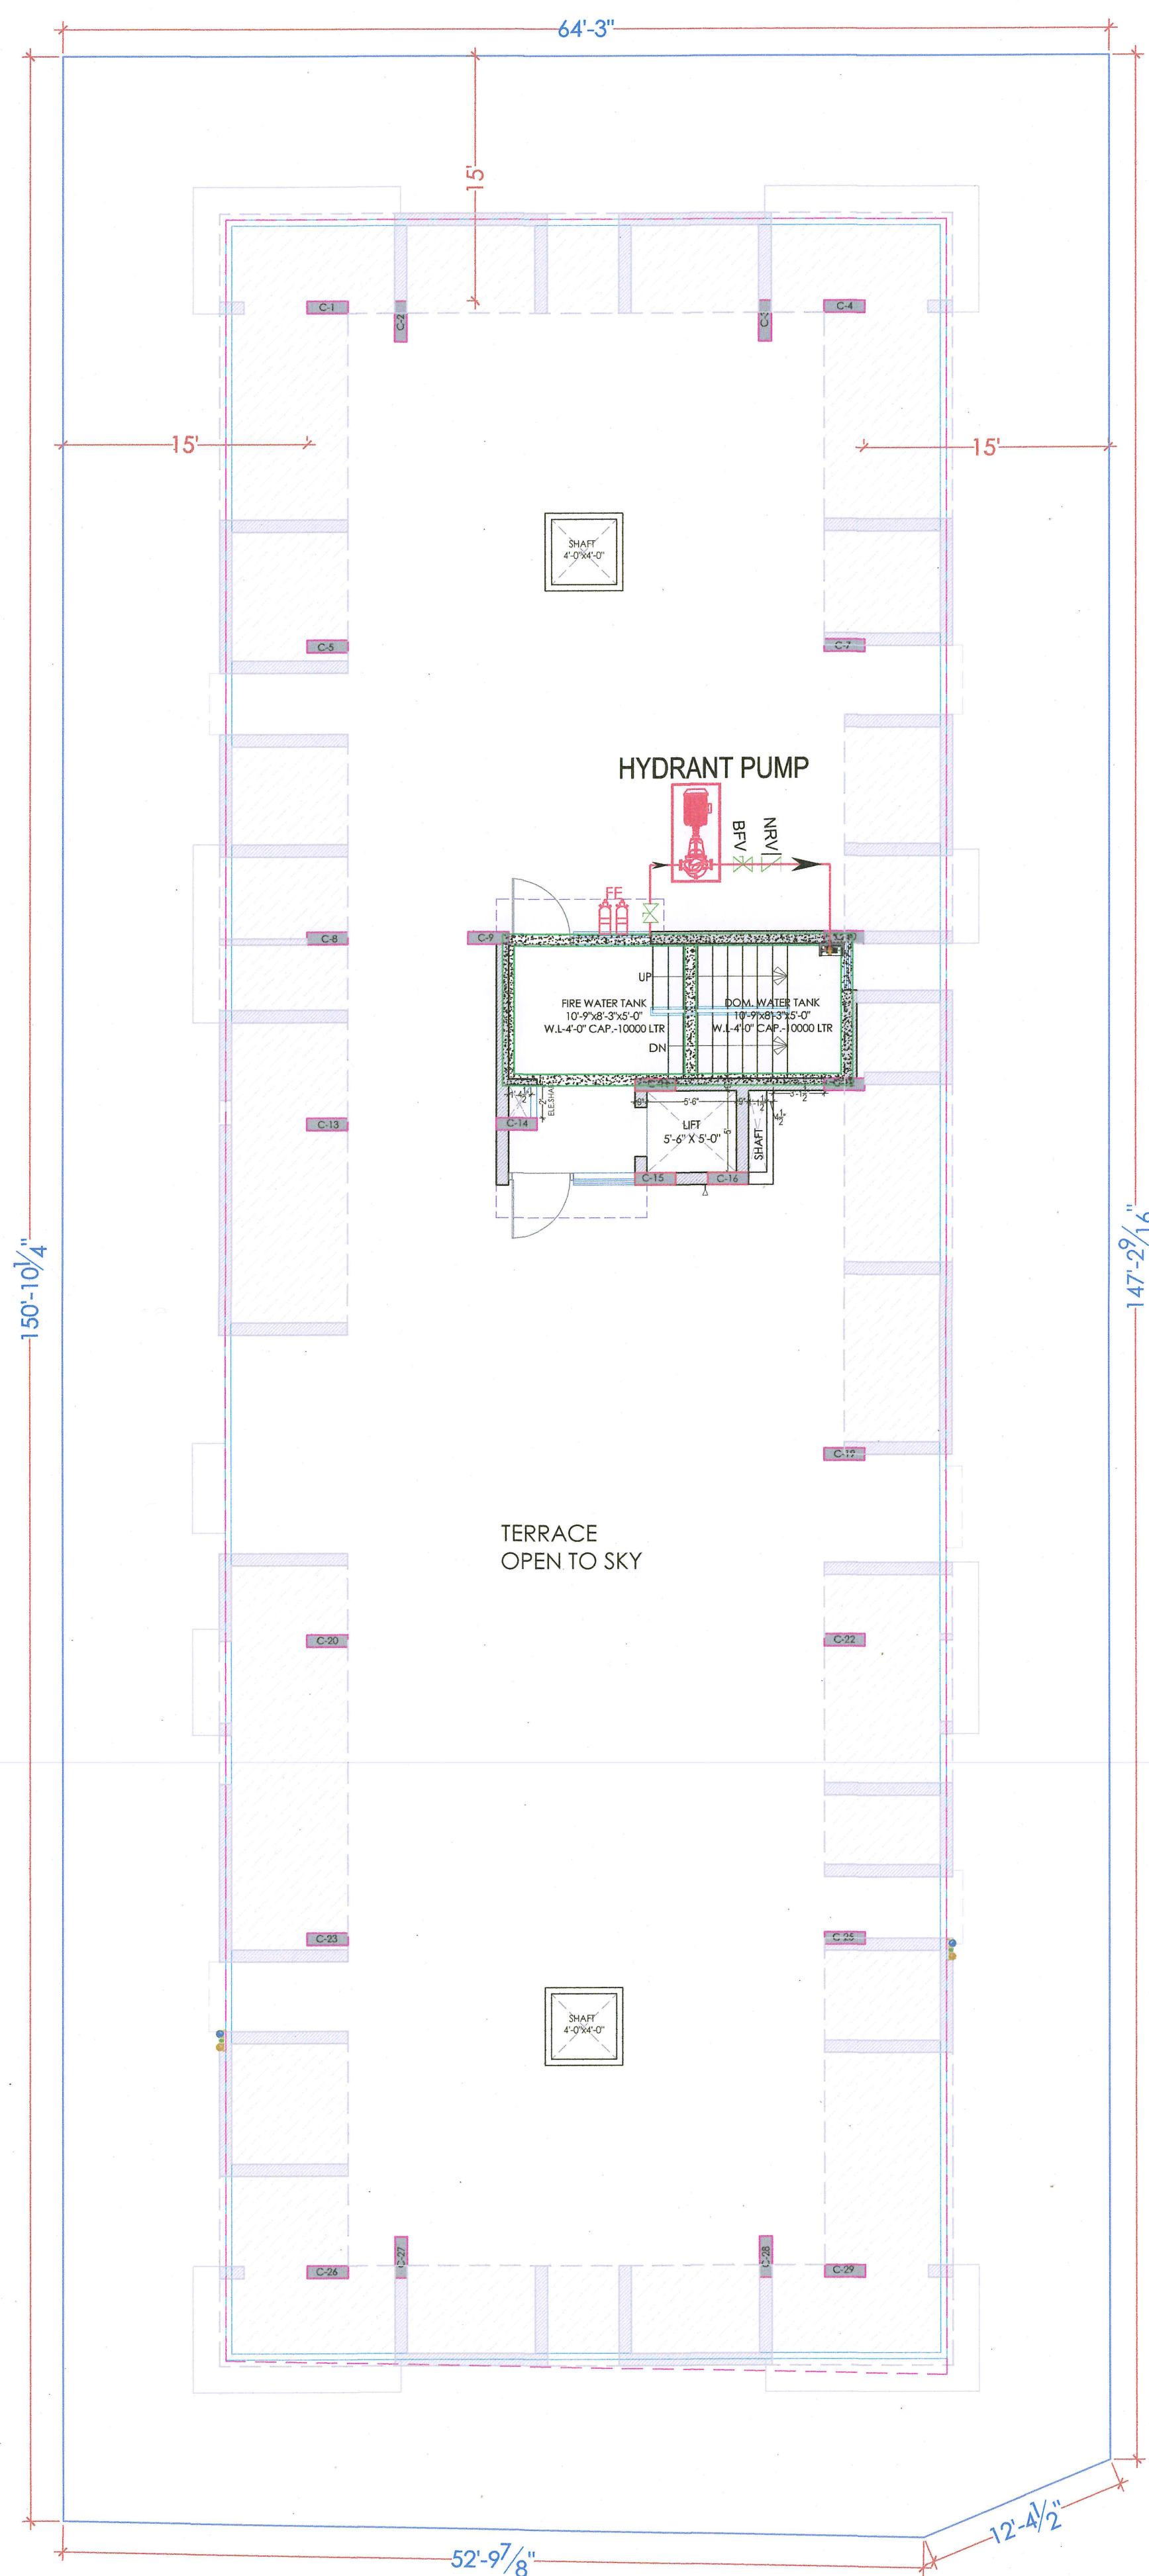

TERRACE FLOOR FIRE FIGHTING LAYOUT

For ASTHA REAL ESTATE
बेणागाम
Proprietor

Er. SANJEEV SHARMA
B.E (Electrical)

PROJECT:

PROPOSED RESIDENTIAL FLATS
ON PLOT NO. - 52
SCHEME_"RAJLAXMI ELCLAVE-X"
MANPUR DEVRI URF GOLIAWAS,
TEH :- SANGANER ,JAIPUR

NAME OF DRAWING:

TERRACE FLOOR FIRE FIGHTING LAYOUT

DRAWING

PLUMBING DRAWING

PROJECT NO. :	DATE : 27. May. - 2024
---------------	---------------------------

SCALE :	REV NO. :
NTS	R-0

DRAWING NO. :

DRAWING NO. :

--	--	--

 /

-

 /

-

 /

--	--	--

 /

--	--

 /

--

PROJECT CATEGORY BLOCK FLOOR TYPE NUMBER

A-01