

OTHER'S  
LAND

PROJECT NAME :

THE SIGNATURE

DEVELOPER NAME :

M/S SHREE ENTERPRISES

ARCHITECTS :

INSIDE

ARCHITECTURE N INTERIORS

Plot no. 72, S.P. Marg, C-Scheme

Jaipur, Rajasthan, India

cont: +91 9950595991, 91

9982812777

e.mail: jeets.arch@gmail.com

3" less

LEGEND:-

|    |                               |      |
|----|-------------------------------|------|
| ①  | SOIL PIPE                     |      |
| ②  | WASTE PIPE                    |      |
| ③  | VENT PIPE                     |      |
| ④  | COLD WATER SUPPLY (CWS)       |      |
| ⑤  | HOT WATER SUPPLY (HWS)        |      |
|    | RAIN WATER PIPE               |      |
| SW | SEWER LINE - EXTERNAL         |      |
| RW | STORM WATER DRAINAGE PIPE     |      |
|    | SEWERAGE MANHOLE (2' x 2')    | M.H. |
|    | STORM WATER MANHOLE (2' x 2') | M.H. |
| GT | GULLY TRAP                    |      |
| BV | BALL VALVE                    |      |
| FT | FLOOR TRAP                    |      |
| FD | FLOOR FLOOR DRAIN             |      |
|    | RAIN WATER COLLECTION CHAMBER |      |
|    | 400/450MM                     |      |
|    | KHURRA                        |      |

P.NO.  
29

195'-6 1/4"

6" less

ER. SANJEEV SHARMA  
B.E. (Electrical)

PROJECT:

PROPOSED RESIDENTIAL FLATS  
ON PLOT NO. -O-29B  
SCHEME- 6-D ENGINEERS COLONY  
"O" BLOCK, JAIPUR.

NAME OF DRAWING:

TYPICAL FLOOR  
(WATER SUPPLY, RAINWATER,  
SANITATION & COMMON  
PLUMBING ) DRAWING

DRAWING

WORKING DRAWING

PROJECT NO. :

DATE :

18-10-2024

SCALE :

NTS

REV NO. :

R-0

DRAWING NO. :

A-01

PROJECT

GROUND

FLOOR

TIME

MARKS

TYPICAL FLOOR (WATER SUPPLY, RAINWATER,  
SANITATION & COMMON PLUMBING ) DRAWING

## THE SIGNATURE

M/S SHREE ENTERPRISES

**4 INSIDE**  
**ARCHITECTURE N INTERIORS**  
Plot no. 72, S.P. Marg , C- Scheme  
jaipur, rajasthan, India  
cont: +91 9950595991 , 91  
9982812777  
e.mail: jeets.arch@gmail.com


| LEGEND:- |                                            |      |
|----------|--------------------------------------------|------|
| ①        | SOIL PIPE                                  |      |
| ②        | WASTE PIPE                                 |      |
| ③        | VENT PIPE                                  |      |
| ④        | COLD WATER SUPPLY (CWS)                    |      |
| ⑤        | HOT WATER SUPPLY (HWS)                     |      |
|          | RAIN WATER PIPE                            |      |
|          | SEWER LINE- EXTERNAL                       |      |
| SW       | STORM WATER DRAINAGE PIPE                  |      |
|          | SEWERAGE MANHOLE (2 x 2)                   | M.H. |
|          | STORM WATER MANHOLE (2 x 2)                | M.H. |
| GT       | GULLY TRAP                                 |      |
| BY       | BALL VALVE                                 |      |
| FT       | FLOOR TRAP                                 |      |
| FD       | FLOOR FLOOR DRAIN                          |      |
|          | RAIN WATER COLLECTION CHAMBER<br>450X450MM |      |
|          | KHURRA                                     |      |

Er. SANJEEV SHARMA  
B.E (Electrical)

NAME OF DRAWING:

**TERRACE FLOOR PLUMBING  
LAYOUT / SANITATION**


|                                                                                       |                                                                                       |                                                                                                     |                                                                                       |
|---------------------------------------------------------------------------------------|---------------------------------------------------------------------------------------|-----------------------------------------------------------------------------------------------------|---------------------------------------------------------------------------------------|
| DRAWING<br><br>WORKING DRAWING                                                        |                                                                                       | NORTH:<br><br> |                                                                                       |
| PROJECT NO. :                                                                         |                                                                                       | DATE :<br><br>20-08-2024                                                                            |                                                                                       |
| SCALE :<br><br>NTS                                                                    |                                                                                       | REV NO. :<br><br>R-0                                                                                |                                                                                       |
| DRAWING NO. :                                                                         |                                                                                       |                                                                                                     |                                                                                       |
|  |  |                |  |
| PROJECT                                                                               | CATEGORY                                                                              | BLOCK                                                                                               | FLOOR                                                                                 |
|  |                                                                                       |                |  |
| TITLE                                                                                 |                                                                                       | NUMBER                                                                                              |                                                                                       |
| A-01                                                                                  |                                                                                       |                                                                                                     |                                                                                       |

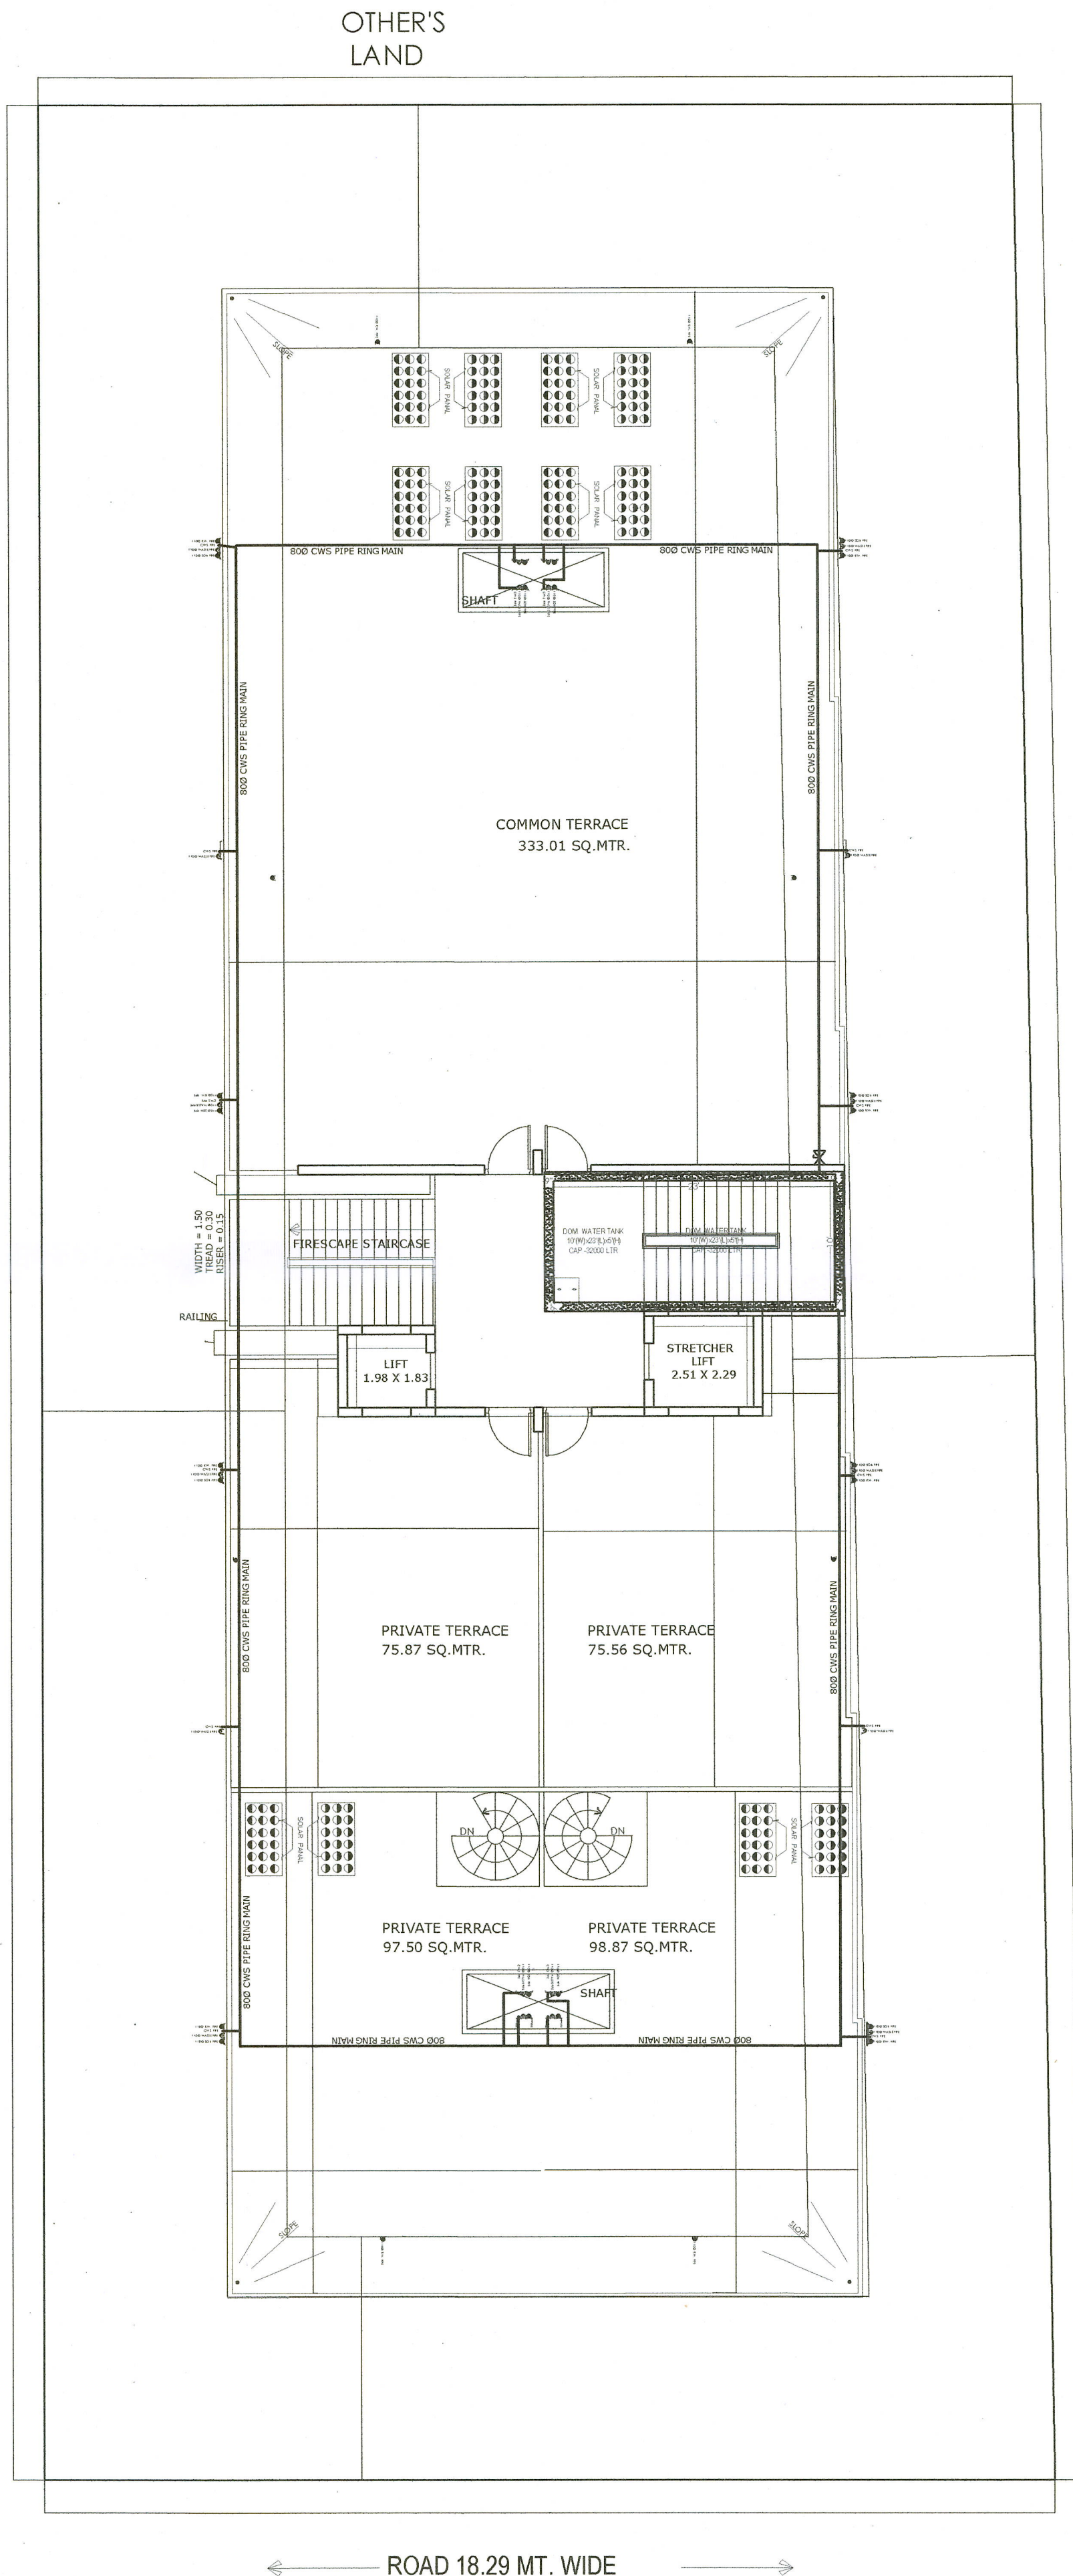

## TERRACE FLOOR PLUMBING LAYOUT /SANITATION

P.NO.  
29

BASEMENT FLOOR PLAN

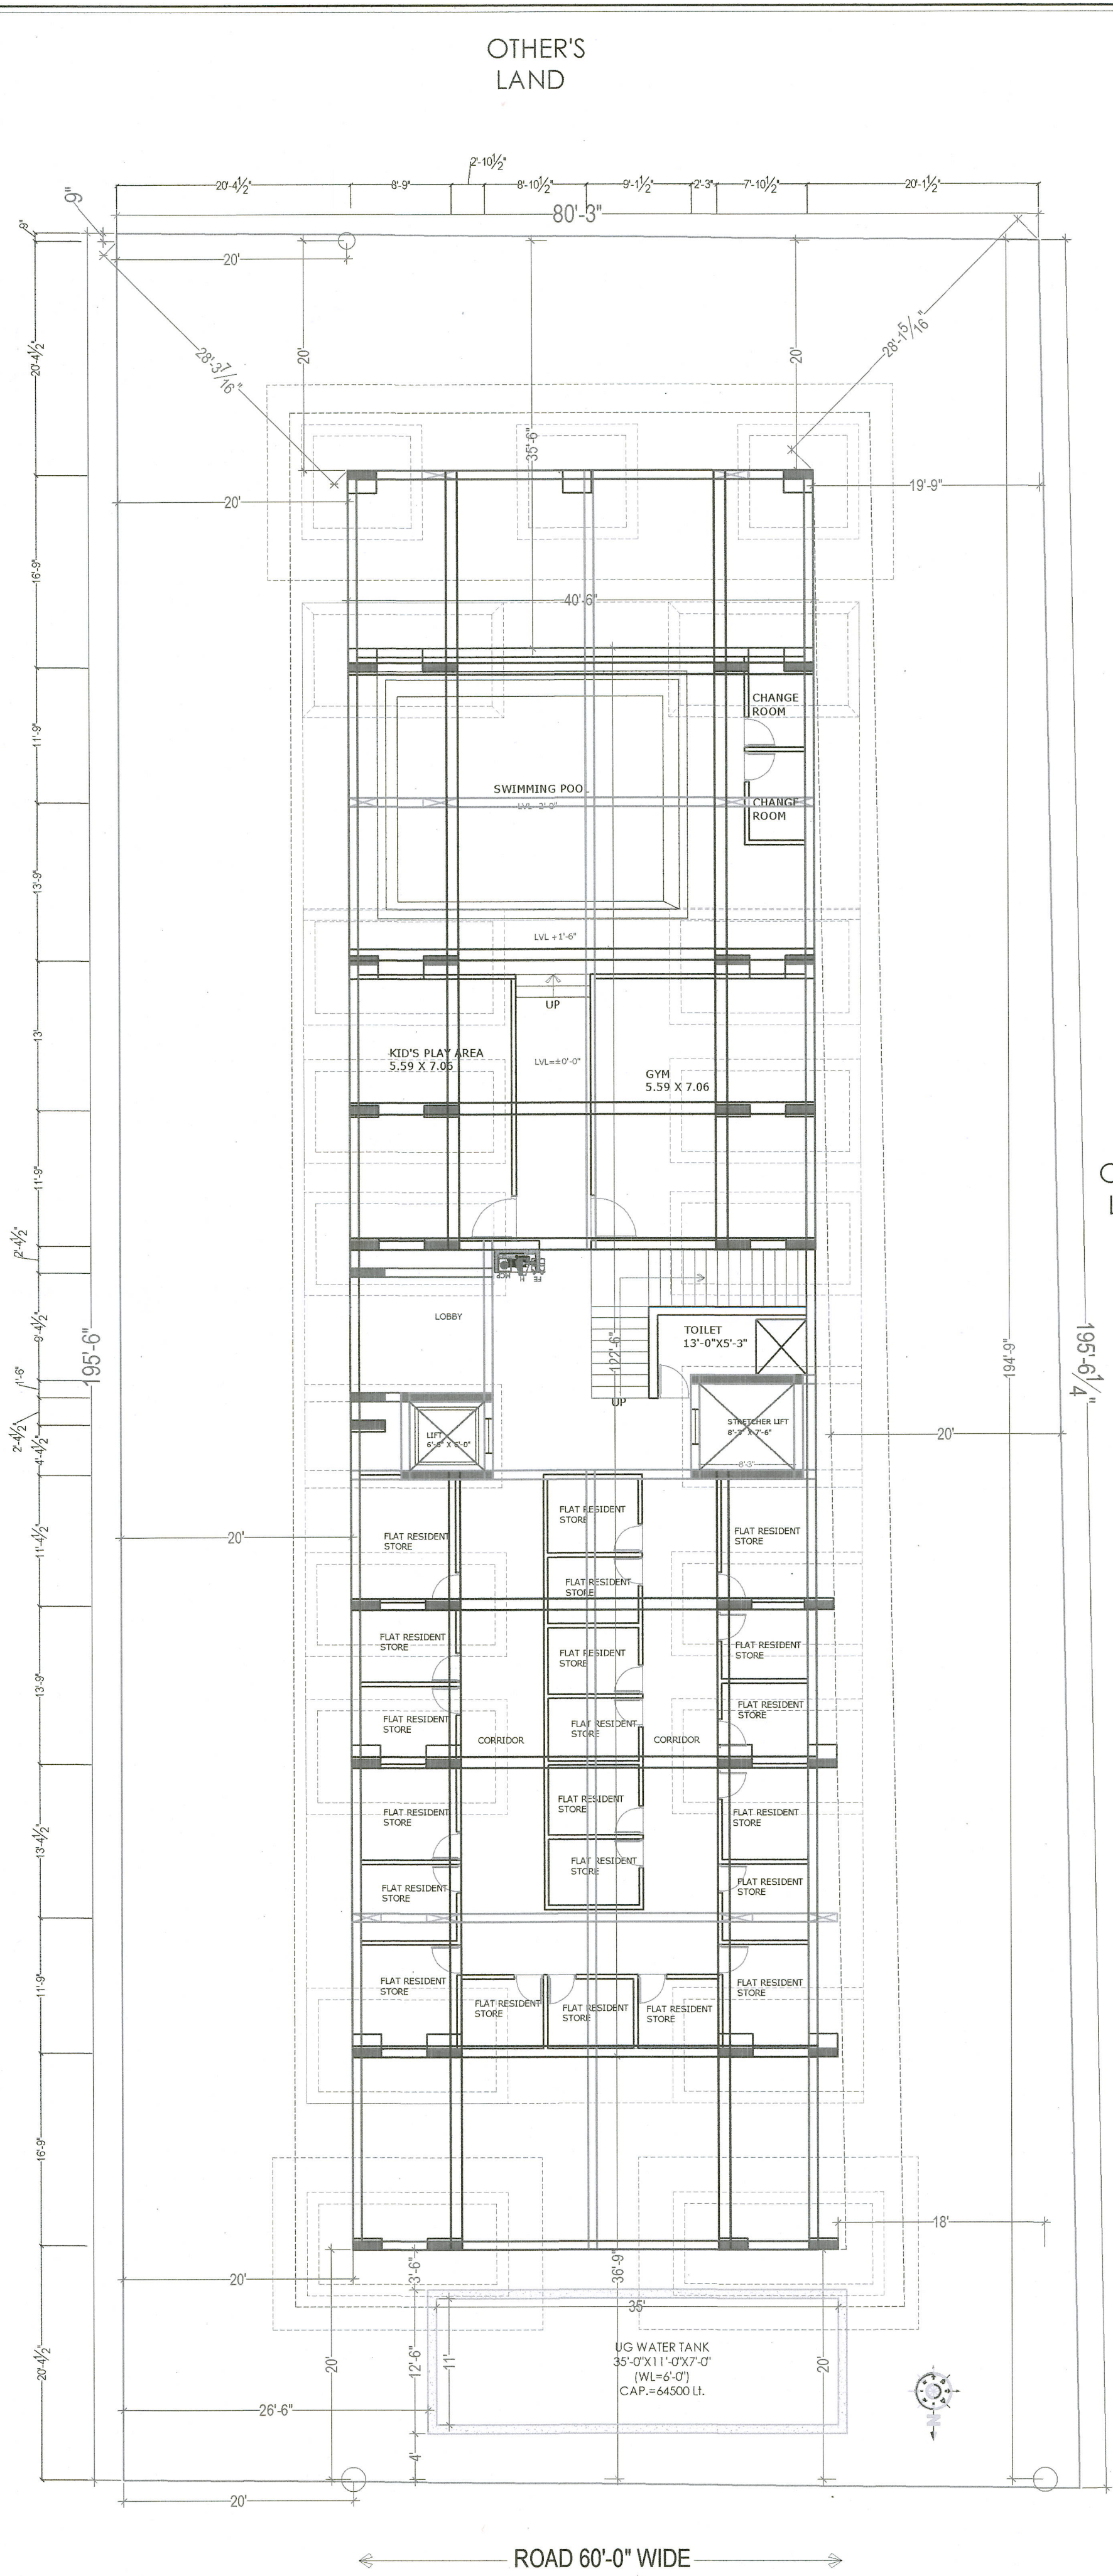

OTHER'S  
LAND

OTHER'S  
LAND

PROJECT NAME :


THE SIGNATURE

DEVELOPER NAME :

M/S SHREE ENTERPRISES

ARCHITECTS :

4 INSIDE  
ARCHITECTURE N INTERIORS  
Plot no. 72, S.P. Marg, C-Scheme  
Jaipur, Rajasthan, India  
cont: +91 9950595991, 91  
9982812777  
e.mail: jeets.arch@gmail.com

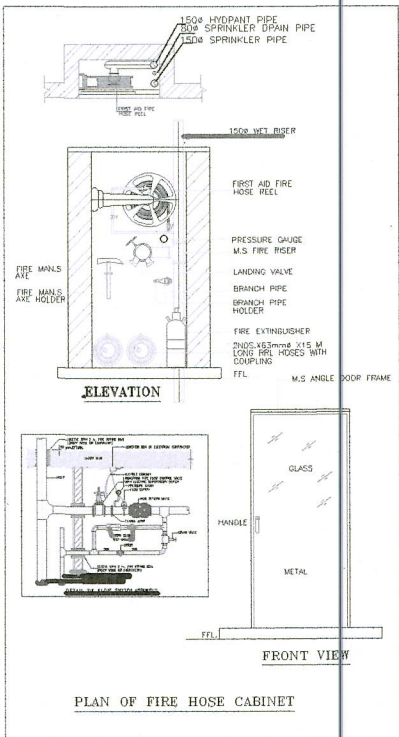

LEGEND:-

|                            |    |
|----------------------------|----|
| FIRE HYDRANT MS PIPE       |    |
| BALL VALVE                 |    |
| EXTERNAL FIRE HYDRANT      |    |
| EXTERNAL FIRE HOSE CABINET |    |
| FIRE HOSE CABINET          |    |
| UPRIGHT SPRINKLER HEAD     |    |
| PENDENT SPRINKLER HEAD     |    |
| SIDE WALL SPRINKLER HEAD   |    |
| FIRE EXTINGUISHER          |    |
| FLOW SWITCH                | FS |
| ISOLATION VALVE            | IV |
| 2 WAY FIRE BRIGADE INLET   |    |

Er. SANJEEV SHARMA  
B.E ( Electrical )

PROJECT:

PROPOSED RESIDENTIAL FLATS  
ON PLOT. NO. -O-29B  
SCHEME- 6-D ENGINEERS COLONY  
"O" BLOCK, JAIPUR.

NAME OF DRAWING:

BASEMENT FLOOR PLAN

DRAWING  
WORKING DRAWING

NORTH:



PROJECT NO. :

DATE :

20-08-2024

SCALE :

NTS


REV NO. :

R-0

DRAWING NO. :



A-01

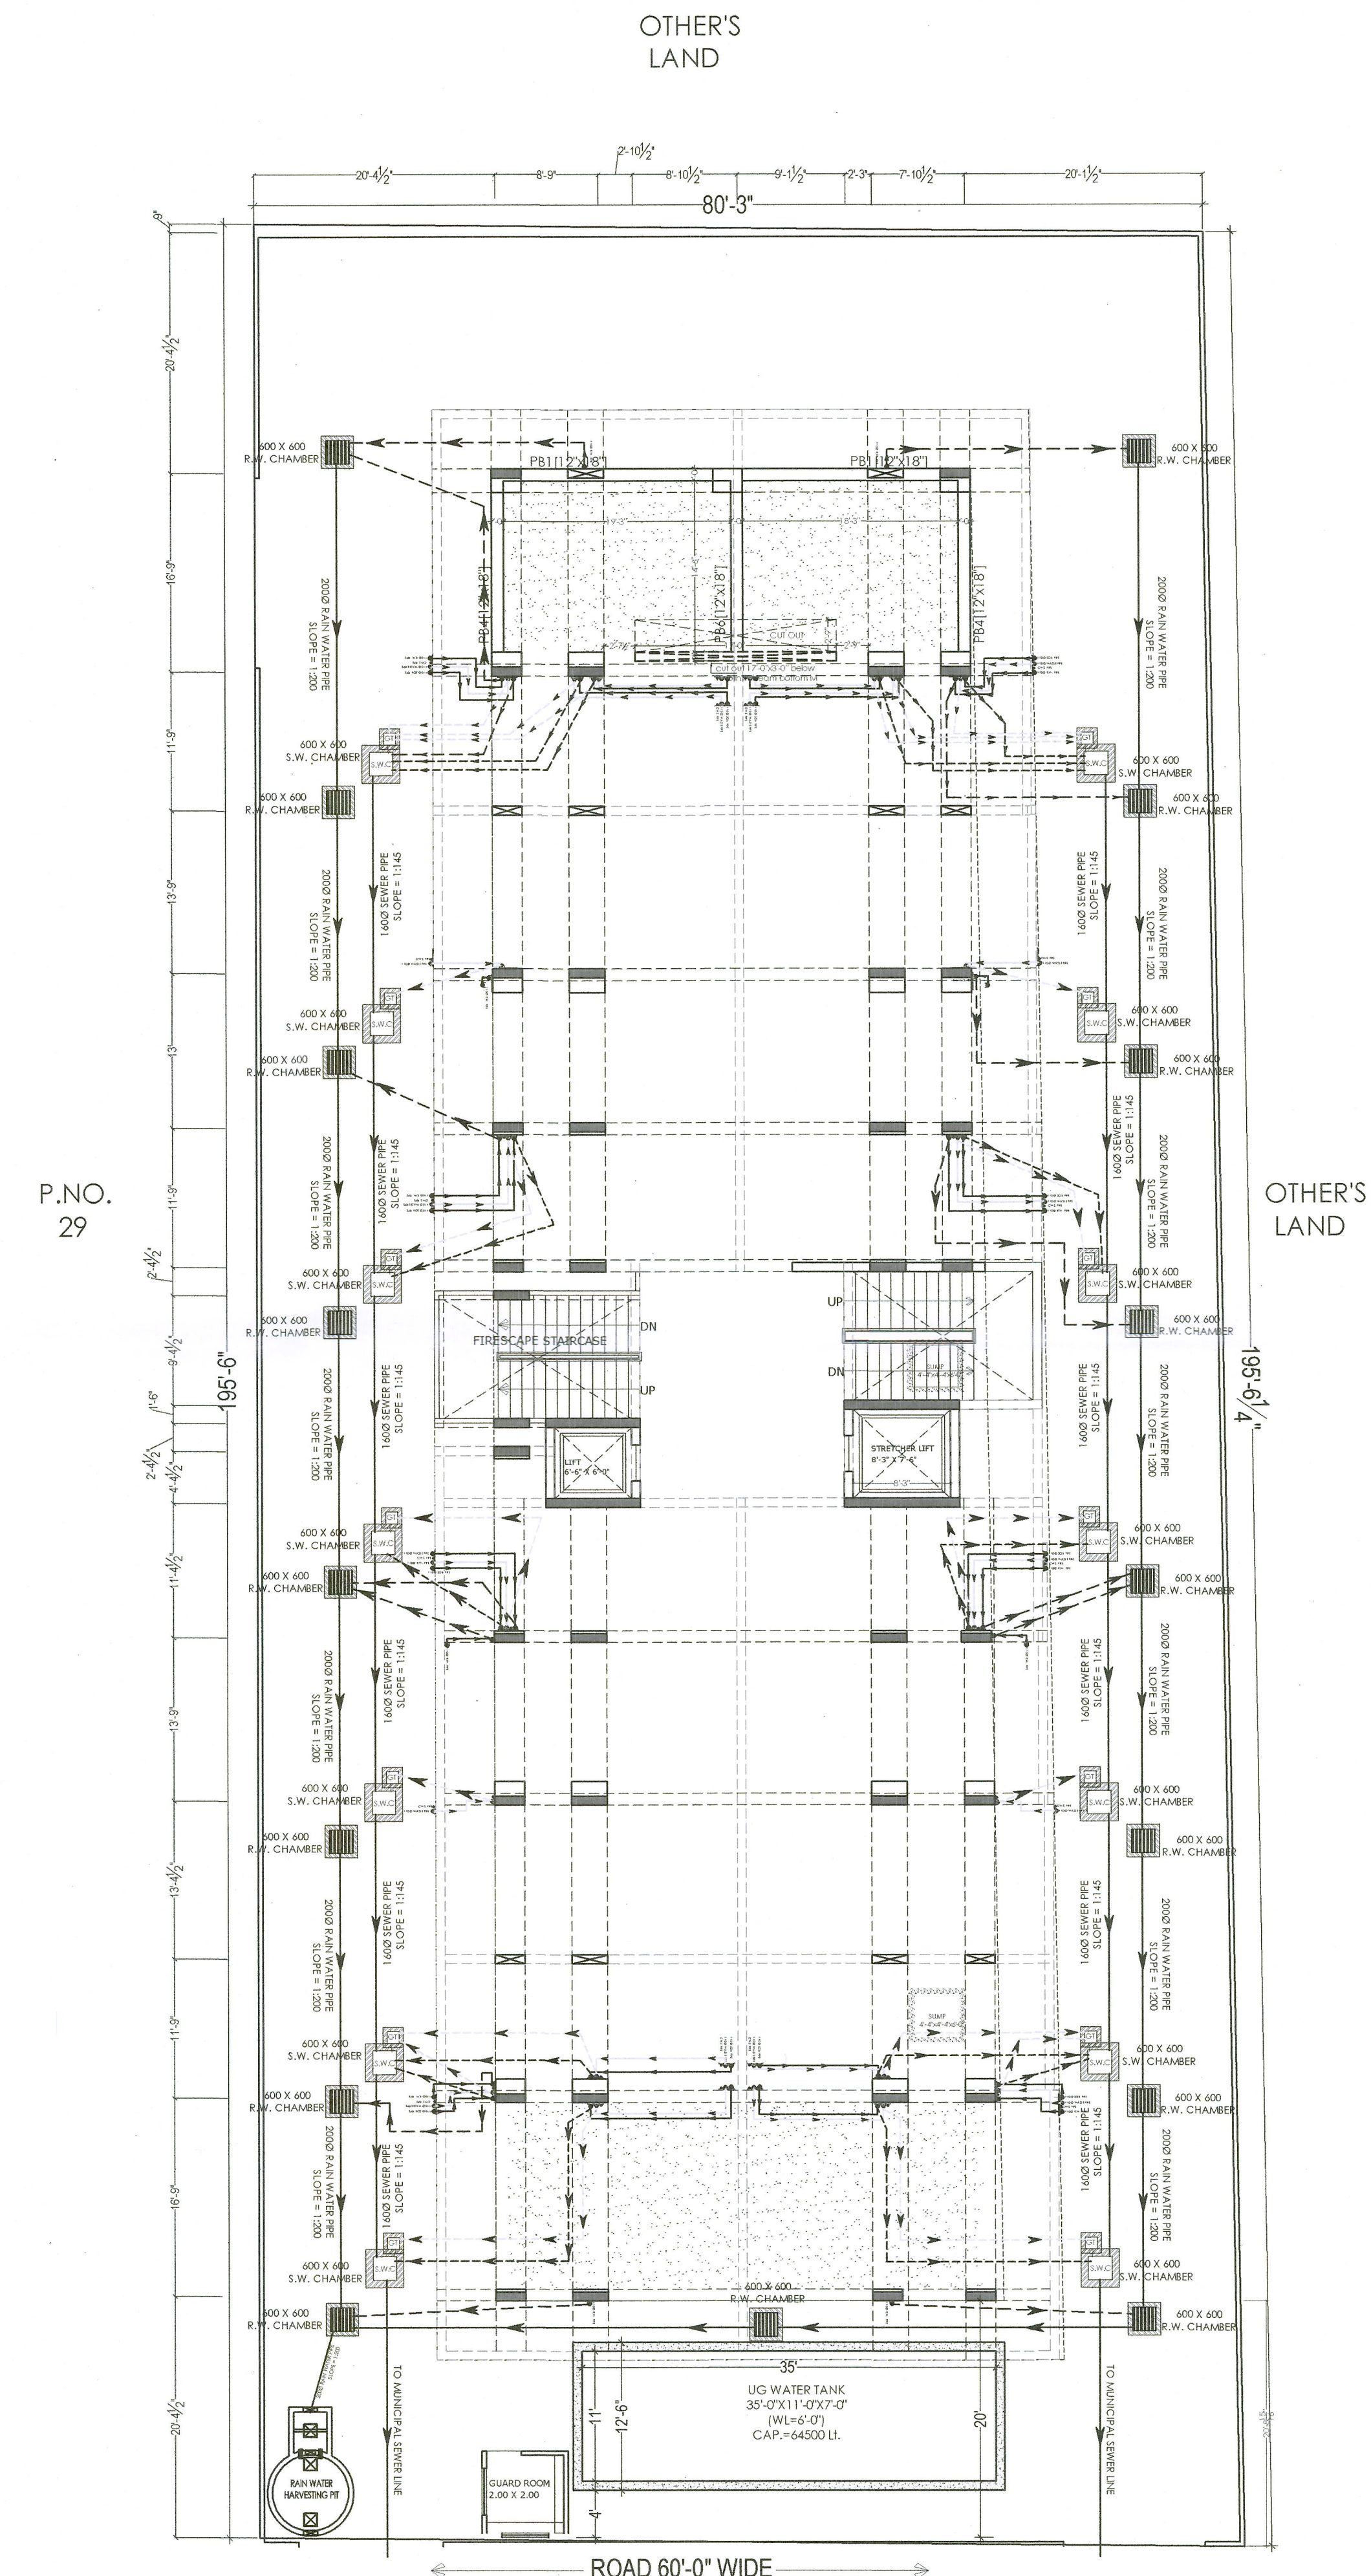

WATER SUPPLY, RAINWATER HARVESTING,  
SANITATION & COMMON PLUMBING DRAWING

PROJECT NAME :  
**THE SIGNATURE**

DEVELOPER NAME :  
**M/S SHREE ENTERPRISES**

ARCHITECTS :  
**INSIDE**  
**ARCHITECTURE N INTERIORS**  
Plot no. 72, S.P. Marg, C-Scheme  
jaipur, rajasthan, India  
cont: +91 9950595991, 91  
9982812777  
e.mail: jeels.arch@gmail.com

LEGEND:-

|    |                                            |      |
|----|--------------------------------------------|------|
| 1  | SOIL PIPE                                  |      |
| 2  | WASTE PIPE                                 |      |
| 3  | VENT PIPE                                  |      |
| 4  | COLD WATER SUPPLY (CWS)                    |      |
| 5  | HOT WATER SUPPLY (HWS)                     |      |
|    | RAIN WATER PIPE                            |      |
| SW | SEWER LINE- EXTERNAL                       |      |
| RW | STORM WATER DRAINAGE PIPE                  |      |
|    | SEWERAGE MANHOLE (2' x 2')                 | M.H. |
|    | STORM WATER MANHOLE (2' x 2')              | M.H. |
| GT | GULLY TRAP                                 |      |
| BV | BALL VALVE                                 |      |
| FT | FLOOR TRAP                                 |      |
| FD | FLOOR FLOOR DRAIN                          |      |
|    | RAIN WATER COLLECTION CHAMBER<br>450X450MM |      |
|    | KHURRA                                     |      |

*Sharma*  
**ER. SANJEEV SHARMA**  
**B.E. (Electrical)**


PROJECT:  
**PROPOSED RESIDENTIAL FLATS  
ON PLOT. NO. -O-29B  
SCHEME- 6-D ENGINEERS COLONY  
"O" BLOCK, JAIPUR.**

NAME OF DRAWING:  
**STILT FLOOR (WATER SUPPLY,  
RAINWATER HARVESTING,  
SANITATION & COMMON  
PLUMBING ) DRAWING**

|                            |                     |
|----------------------------|---------------------|
| DRAWING<br>WORKING DRAWING | NORTH:<br>          |
| PROJECT NO.:               | DATE:<br>20-08-2024 |
| SCALE:<br>NTS              | REV NO.:<br>R-0     |
| DRAWING NO.:               |                     |

A-01

P.NO.  
29

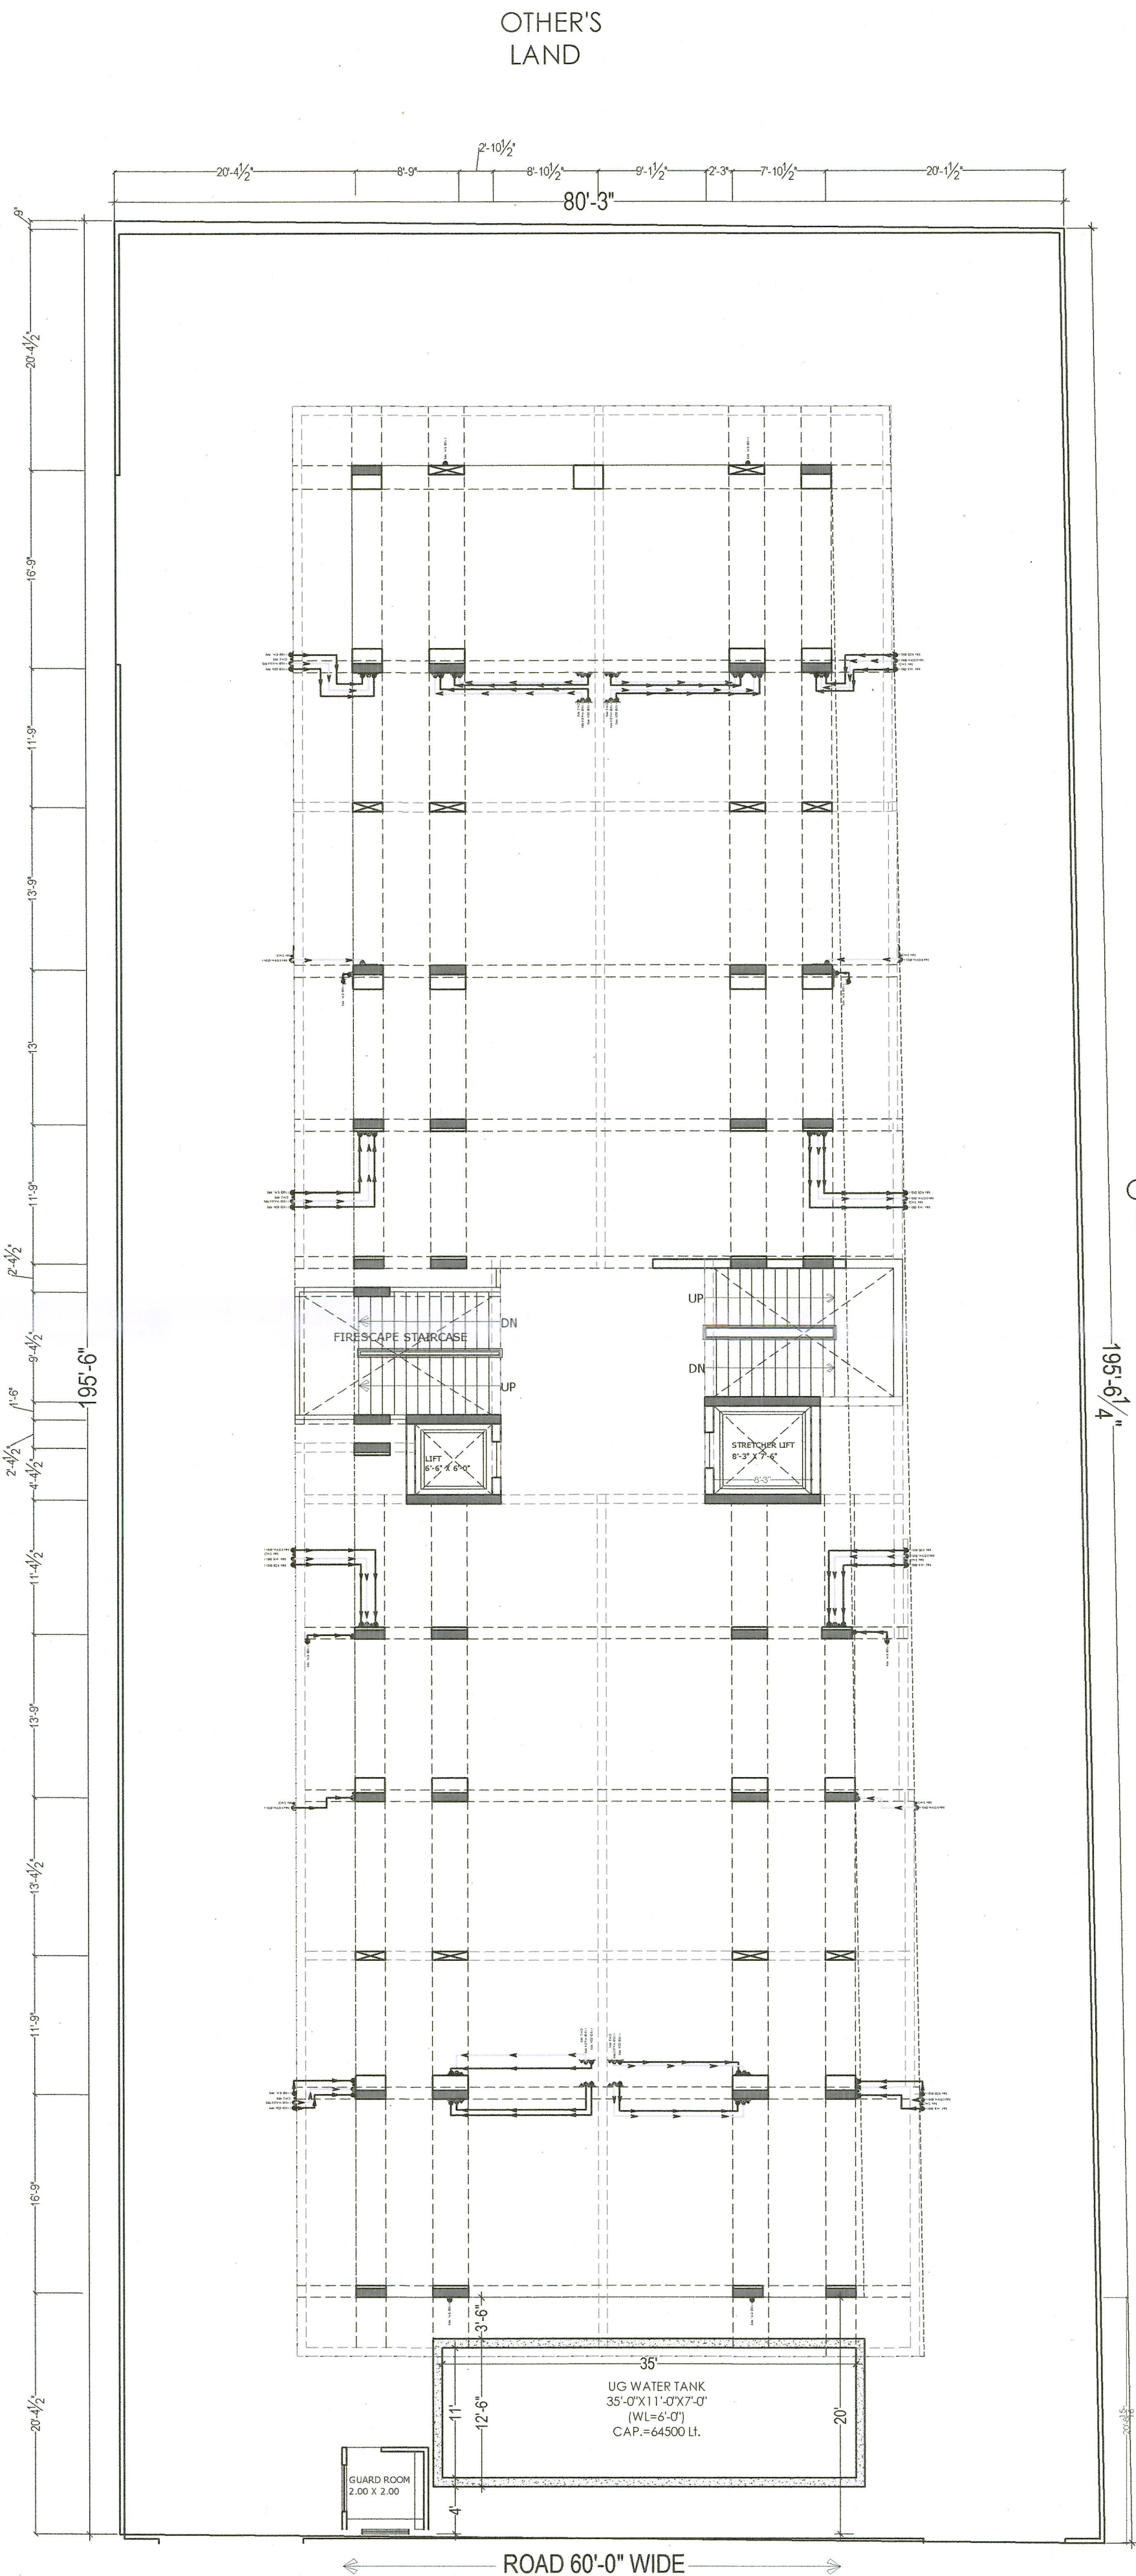

PROJECT NAME :

THE SIGNATURE

DEVELOPER NAME :

M/S SHREE ENTERPRISES

ARCHITECTS :

4 INSIDE  
ARCHITECTURE N INTERIORS  
Plot no. 72, S.P. Marg, C-Scheme  
jaipur, rajasthan, India  
cont: +91 9950595991, 91  
9982812777  
e.mail: jeets.arch@gmail.com

LEGEND:-

|    |                                            |      |
|----|--------------------------------------------|------|
| ①  | SOIL PIPE                                  |      |
| ②  | WASTE PIPE                                 |      |
| ③  | VENT PIPE                                  |      |
| ④  | COLD WATER SUPPLY (CHS)                    |      |
| ⑤  | HOT WATER SUPPLY (HWS)                     |      |
|    | RAIN WATER PIPE                            |      |
| SW | SEWER LINE- EXTERNAL                       |      |
| RW | STORM WATER DRAINAGE PIPE                  |      |
|    | SEWERAGE MANHOLE (2' x 2')                 | M.H. |
|    | STORM WATER MANHOLE (2' x 2')              | M.H. |
| GT | GULLY TRAP                                 |      |
| BV | BALL VALVE                                 |      |
| FT | FLOOR TRAP                                 |      |
| FD | FLOOR FLOOR DRAIN                          |      |
|    | RAIN WATER COLLECTION CHAMBER<br>450X450MM |      |
|    | KHURRA                                     |      |

Er. SANDEEV SHARMA  
B.E (Electrical)

PROJECT:

PROPOSED RESIDENTIAL FLATS  
ON PLOT. NO. -O-29B  
SCHEME- 6-D ENGINEERS COLONY  
"O" BLOCK, JAIPUR.

NAME OF DRAWING:

STILT FLOOR CEILING  
DRAINAGE LAYOUT PLAN /  
SANITATION

DRAWING  
WORKING DRAWING

PROJECT NO. :

DATE :  
20-08-2024

SCALE :  
NTS

REV NO. :  
R-0

DRAWING NO. :

PROJECT CATEGORY BLOCK FLOOR TYPE NUMBER

A-01

## OTHER'S LAND

PROJECT NAME :

THE SIGNATURE

DEVELOPER NAME :

M/S SHREE ENTERPRISES

ARCHITECTS :

**INSIDE**  
**ARCHITECTURE N INTERIORS**  
Plot no. 72, S.P. Marg, C-Scheme  
Jaipur, Rajasthan, India  
Contact: +91 9950595991, 91  
982812777  
E-mail: jeets.arch@gmail.com

**LEGEND:-**

|    |                                         |                                                                                       |       |
|----|-----------------------------------------|---------------------------------------------------------------------------------------|-------|
| ①  | SOIL PIPE                               |    |       |
| ②  | WASTE PIPE                              |    |       |
| ③  | VENT PIPE                               |    |       |
| ④  | COLD WATER SUPPLY (CWS)                 |    |       |
| ⑤  | HOT WATER SUPPLY (HWS)                  |    |       |
|    | RAIN WATER PIPE                         |    |       |
| SW | SEWER LINE- EXTERNAL                    |    |       |
| RW | STORM WATER DRAINAGE PIPE               |    |       |
|    | SEWERAGE MANHOLE (2 x 2)                |    | M. 3. |
|    | STORM WATER MANHOLE (2 x 2)             |    | M. 3. |
| GT | GIRLY TRAP                              |   |       |
| BV | BALL VALVE                              |  |       |
| FT | FLOOR TRAP                              |  |       |
| FD | FLOOR FLOOR DRAIN                       |  |       |
|    | RAIN WATER COLLECTION CHAMBER 450X650MM |  |       |
|    | KHURRA                                  |  |       |

OTHER'S  
LAND

Er. SANJEEV SHARMA  
B.E (Electrical)

PROJECT:

PROPOSED RESIDENTIAL FLATS  
ON PLOT, NO. -O-29B  
SCHEME- 6-D ENGINEERS COLONY  
"O" BLOCK, JAIPUR.

NAME OF DRAWING:

**BASEMENT  
SUMP DRAWING**

DRAWING

WORKING DRAWING

DATE: 20-08-2024

SCALE :  
NTS

REV NO. :  
R-0

DRAWING NO. :

|         |          |       |       |      |        |  |  |  |
|---------|----------|-------|-------|------|--------|--|--|--|
|         |          |       |       |      |        |  |  |  |
| PROJECT | CATEGORY | BLOCK | FLOOR | TYPE | NUMBER |  |  |  |

A-01

## SUMP DRAWING