


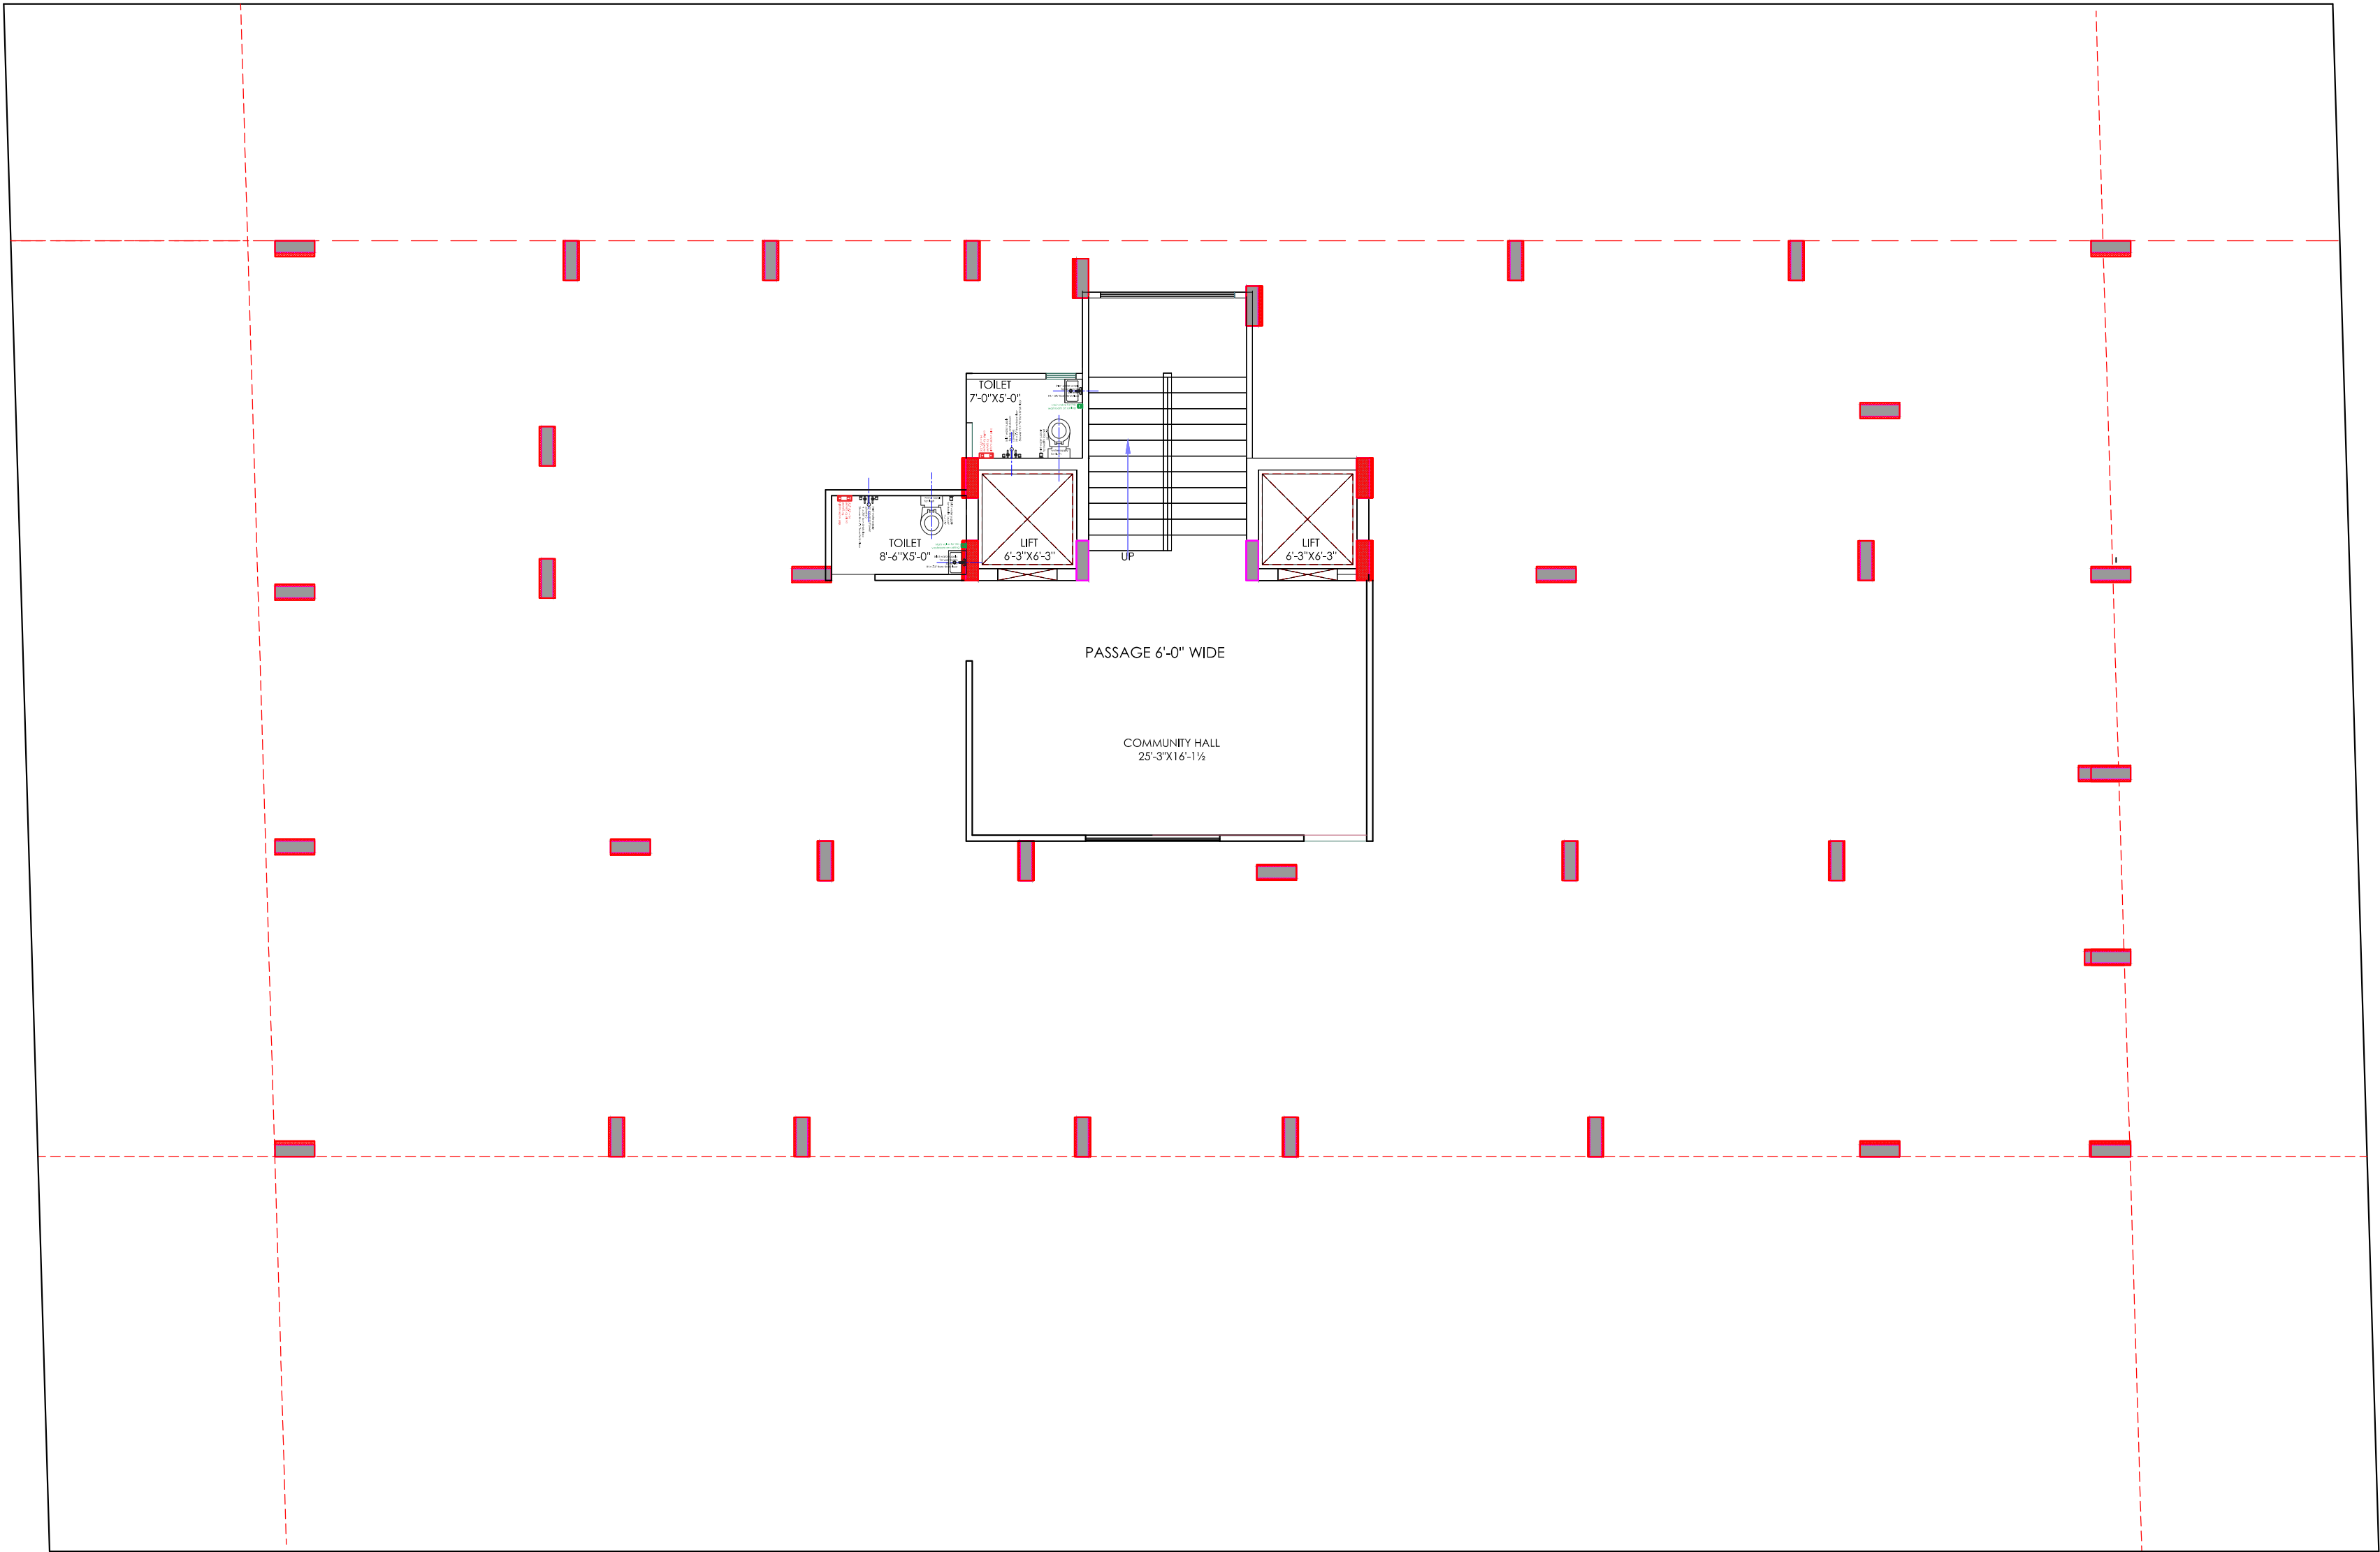

| LEGENDS |        |                          |
|---------|--------|--------------------------|
| S.NO.   | SYMBOL | DESCRIPTION              |
| 1.      |        | SDR-11 Fresh Water Pipe  |
| 2.      |        | SDR-11 Solar Water Pipe  |
| 3.      |        | Waste Water Pipe (W.P.)  |
| 4.      |        | Soil Pipe (S.P.)         |
| 5.      |        | Rain Water Pipe (R.W.P.) |
| 6.      |        | Butter Fly Valve(B.F.V.) |
| 7.      |        | Geyser                   |
| 8.      |        | RO                       |
| 9.      |        | Single Lever Diverter    |
| 10.     |        | Concealed Valve          |
| 11.     |        | Angle Valve              |
| 12.     |        | Nahani Trap              |
| 13.     |        | P-Trap                   |
| 14.     |        | Tap                      |
| 15.     |        | Floor Drain (F.D.)       |
| 16.     |        | Plain Tee (P-tee)        |
| 17.     |        | Gully Trap (G.T.)        |
| 18.     |        |                          |

**WARNING**

1. This drawing is the sole copyright of Architects **VISTAAR** and should be used for the purpose expressly issued.

**GENERAL NOTES**

1. All dimensions are in feet and inches.  
2. Do not scale this drawing follow written dimensions only.  
3. This drawing should be read in conjunction with other architectural and structural drawings.  
4. Any discrepancy in the drawing should be immediately brought to the notice of architect.

PROJECT TITLE

PROJECT:-  
SUNRISE WESTWAY HEIGHTS  
BUILDING AT PLOT NO.-32E & 32F.WESTWAY HEIGHTS(TRUCK  
TERMINAL),VILL.KESHOPURA,ASARPURA ,BHANKROTA,JAIPUR

DRAWING TITLE

STILT FLOOR PLUMBING  
PLAN

SERVICE(SLD)/DISTRIBUTION DETAILS AFTER LT  
PANEL,EARTHING LAYOUT,EXTERNAL LIGHTING  
PLAN,LAYOUT,TV & TELEPHONE RISER  
DIAGRAM,LIGHTING ARRESTER LOCATION & PIT  
LOCATION,COORDINATION DRAWINGS,FIRE  
DETECTION & ALARM SYSTEM LAYOUT OF ALL  
FLOOR)


ARCHITECTS :

**VISTAAR ARCHITECTS & PLANNERS**  
Architects :: Interior Designers  
B-2/12, Chitrkoot scheme,  
main Gandhi Path,Opp mall of jaipur,Jaipur  
PH.- 0141-4116461,09001010366

| DRN.      | DATE       | REV. | NORTH |
|-----------|------------|------|-------|
| ER,SACHIN | 16-08-2024 |      |       |
| SCALE     | JOB NO.    |      |       |
| N.T.S     |            |      |       |

For My Dream House  
Partner

Krishna  
KRISHNA KUMAR  
B.Tech. (Mechanical)  
W.E.P. Consultant

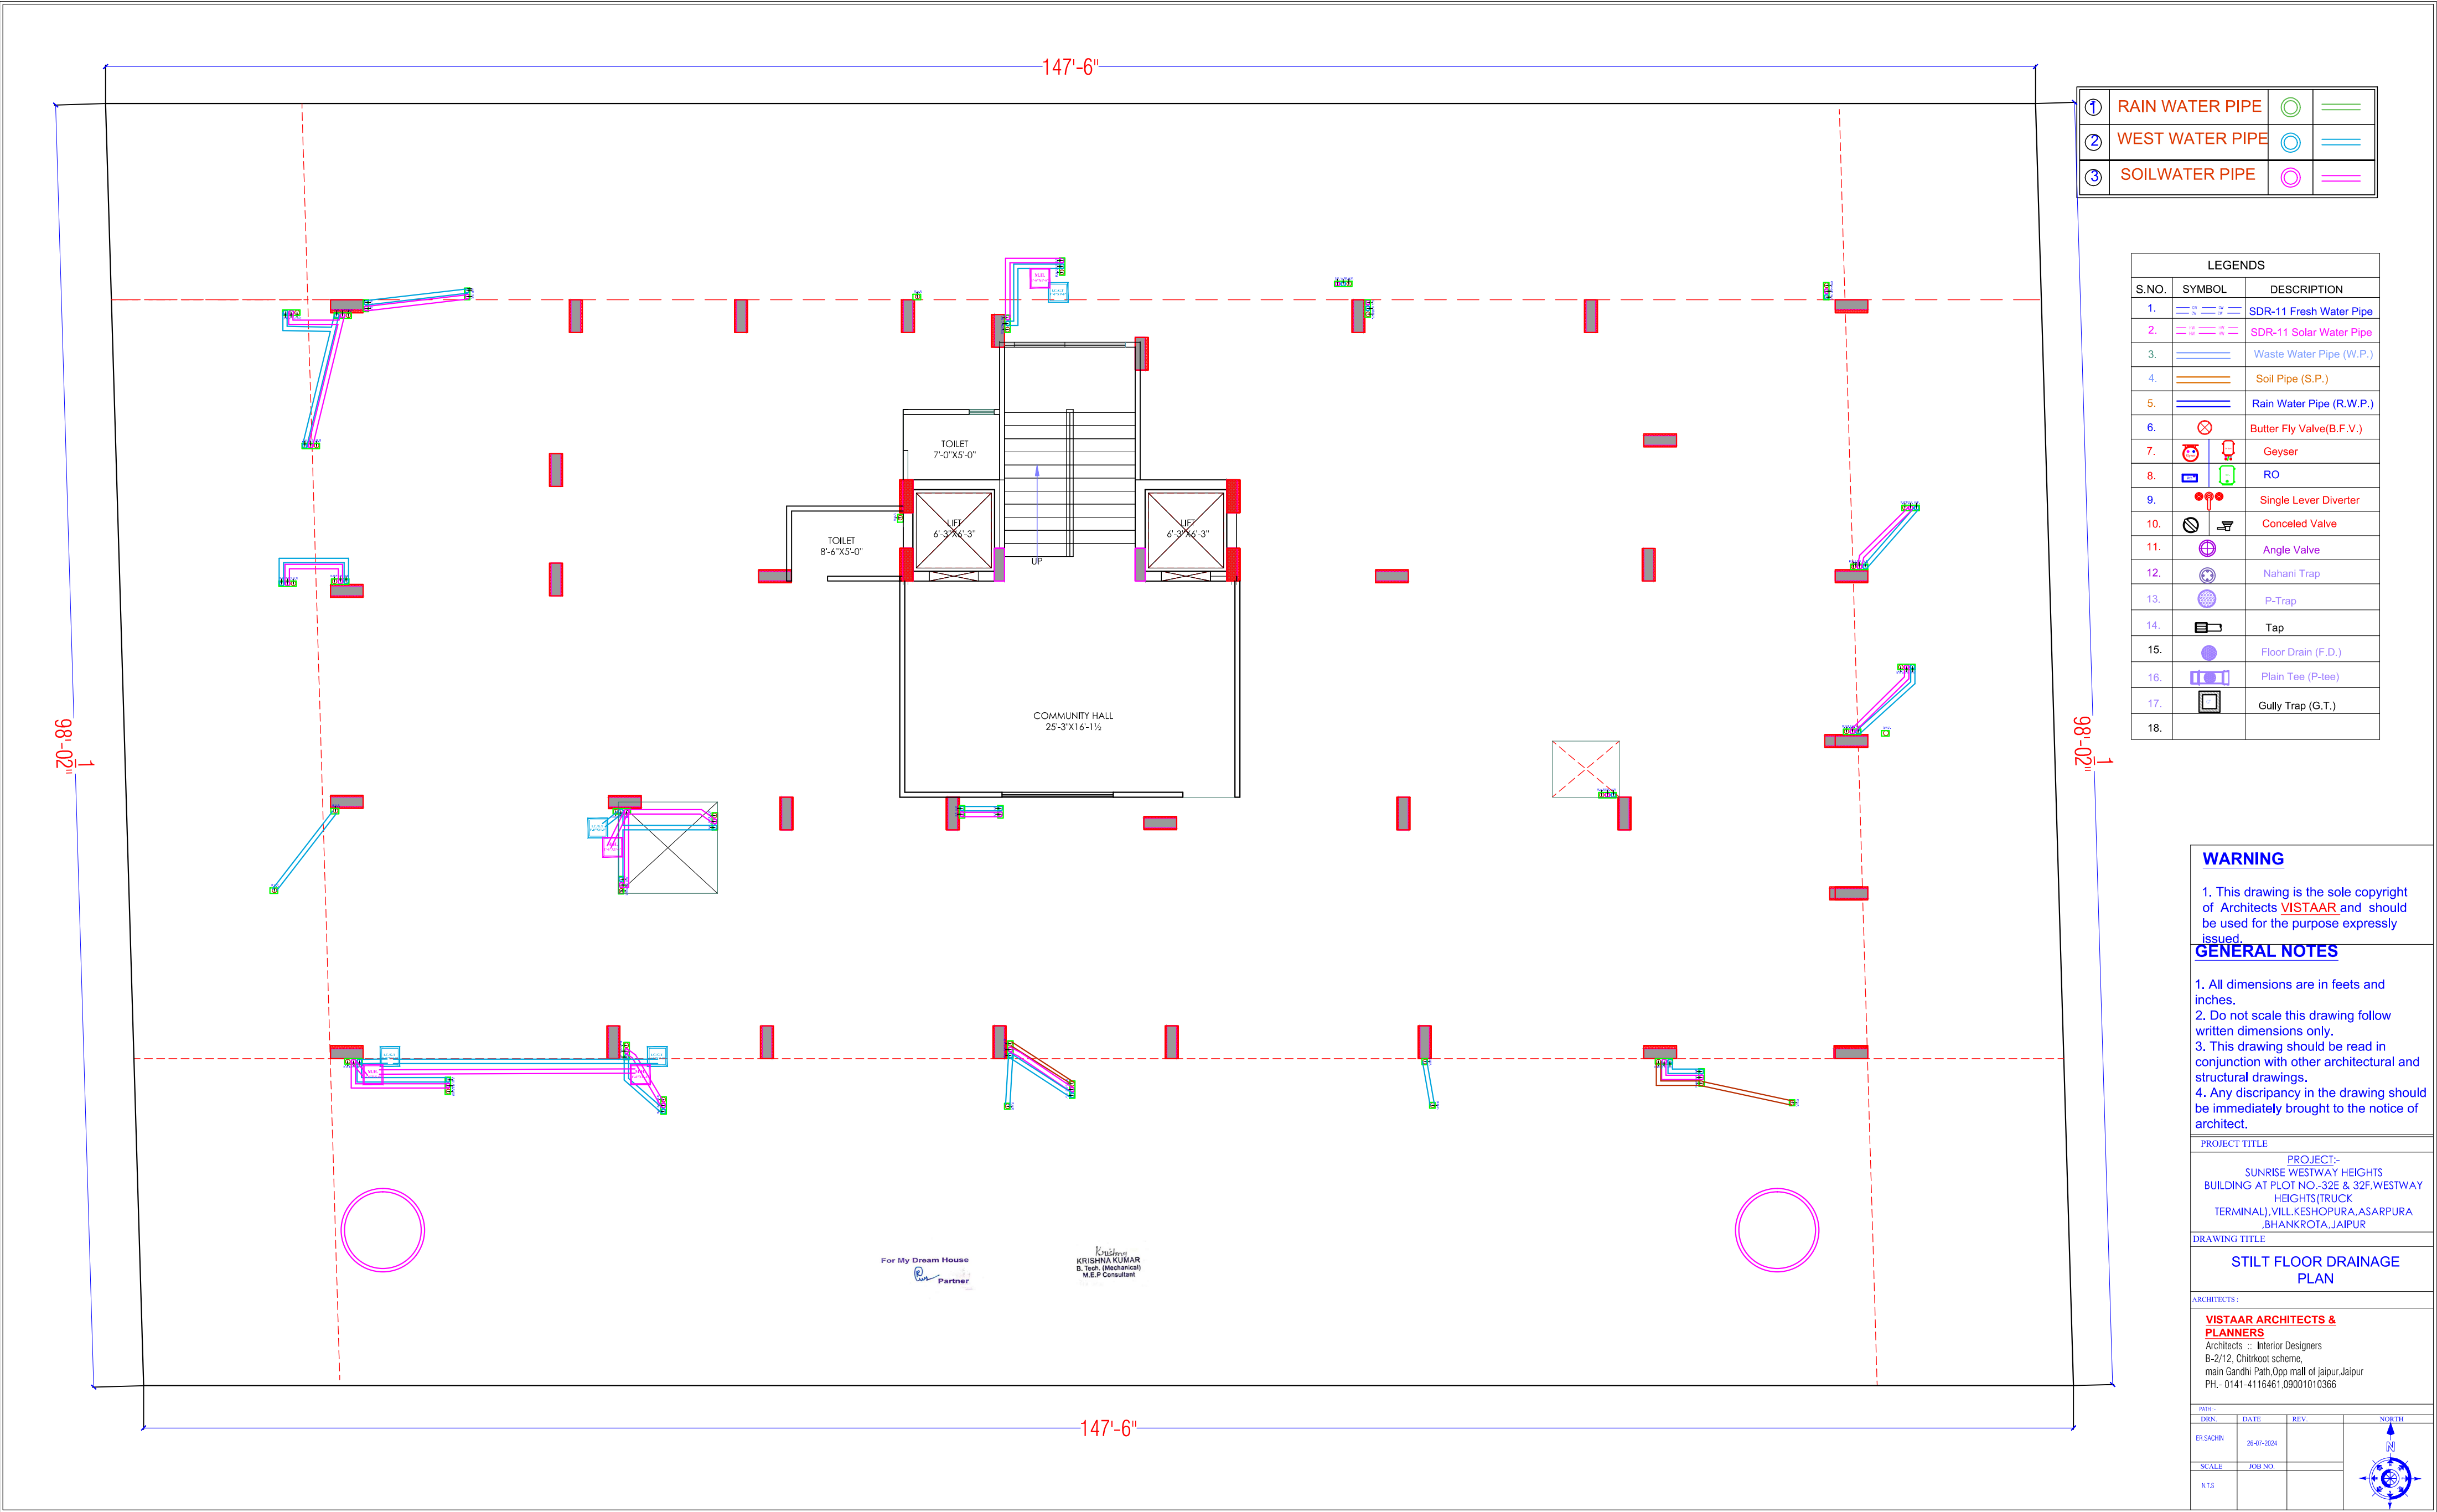

|   |                 |  |  |
|---|-----------------|--|--|
| ① | RAIN WATER PIPE |  |  |
| ② | WEST WATER PIPE |  |  |
| ③ | SOIL WATER PIPE |  |  |

| LEGENDS |        |                           |
|---------|--------|---------------------------|
| S.NO.   | SYMBOL | DESCRIPTION               |
| 1.      |        | SDR-11 Fresh Water Pipe   |
| 2.      |        | SDR-11 Solar Water Pipe   |
| 3.      |        | Waste Water Pipe (W.P.)   |
| 4.      |        | Soil Pipe (S.P.)          |
| 5.      |        | Rain Water Pipe (R.W.P.)  |
| 6.      |        | Butter Fly Valve (B.F.V.) |
| 7.      |        | Geyser                    |
| 8.      |        | RO                        |
| 9.      |        | Single Lever Diverter     |
| 10.     |        | Concealed Valve           |
| 11.     |        | Angle Valve               |
| 12.     |        | Nahani Trap               |
| 13.     |        | P-Trap                    |
| 14.     |        | Tap                       |
| 15.     |        | Floor Drain (F.D.)        |
| 16.     |        | Plain Tee (P-tee)         |
| 17.     |        | Gully Trap (G.T.)         |
| 18.     |        |                           |

**WARNING**

1. This drawing is the sole copyright of Architects **VISTAAR** and should be used for the purpose expressly issued.

**GENERAL NOTES**


1. All dimensions are in feet and inches.
2. Do not scale this drawing follow written dimensions only.
3. This drawing should be read in conjunction with other architectural and structural drawings.
4. Any discrepancy in the drawing should be immediately brought to the notice of architect.

PROJECT TITLE  
PROJECT:-  
SUNRISE WESTWAY HEIGHTS  
BUILDING AT PLOT NO.-32E & 32F.WESTWAY  
HEIGHTS(TRUCK  
TERMINAL).VILL.KESHOPURA,ASARPURA  
BHANKROTA,JAIPUR


DRAWING TITLE  
**STILT FLOOR DRAINAGE  
PLAN**

ARCHITECTS:-  
**VISTAAR ARCHITECTS &  
PLANNERS**  
Architects :: Interior Designers  
B-2/12, Chitirkoot scheme,  
main Gandhi Path,Opp mall of jaipur,Jaipur  
PH.- 0141-4116461,09001010366

| DRN.      | DATE       | REV. | NORTH |
|-----------|------------|------|-------|
| ER.SACHIN | 26-07-2024 |      |       |
| SCALE     | JOB NO.    |      |       |
| NTS       |            |      |       |

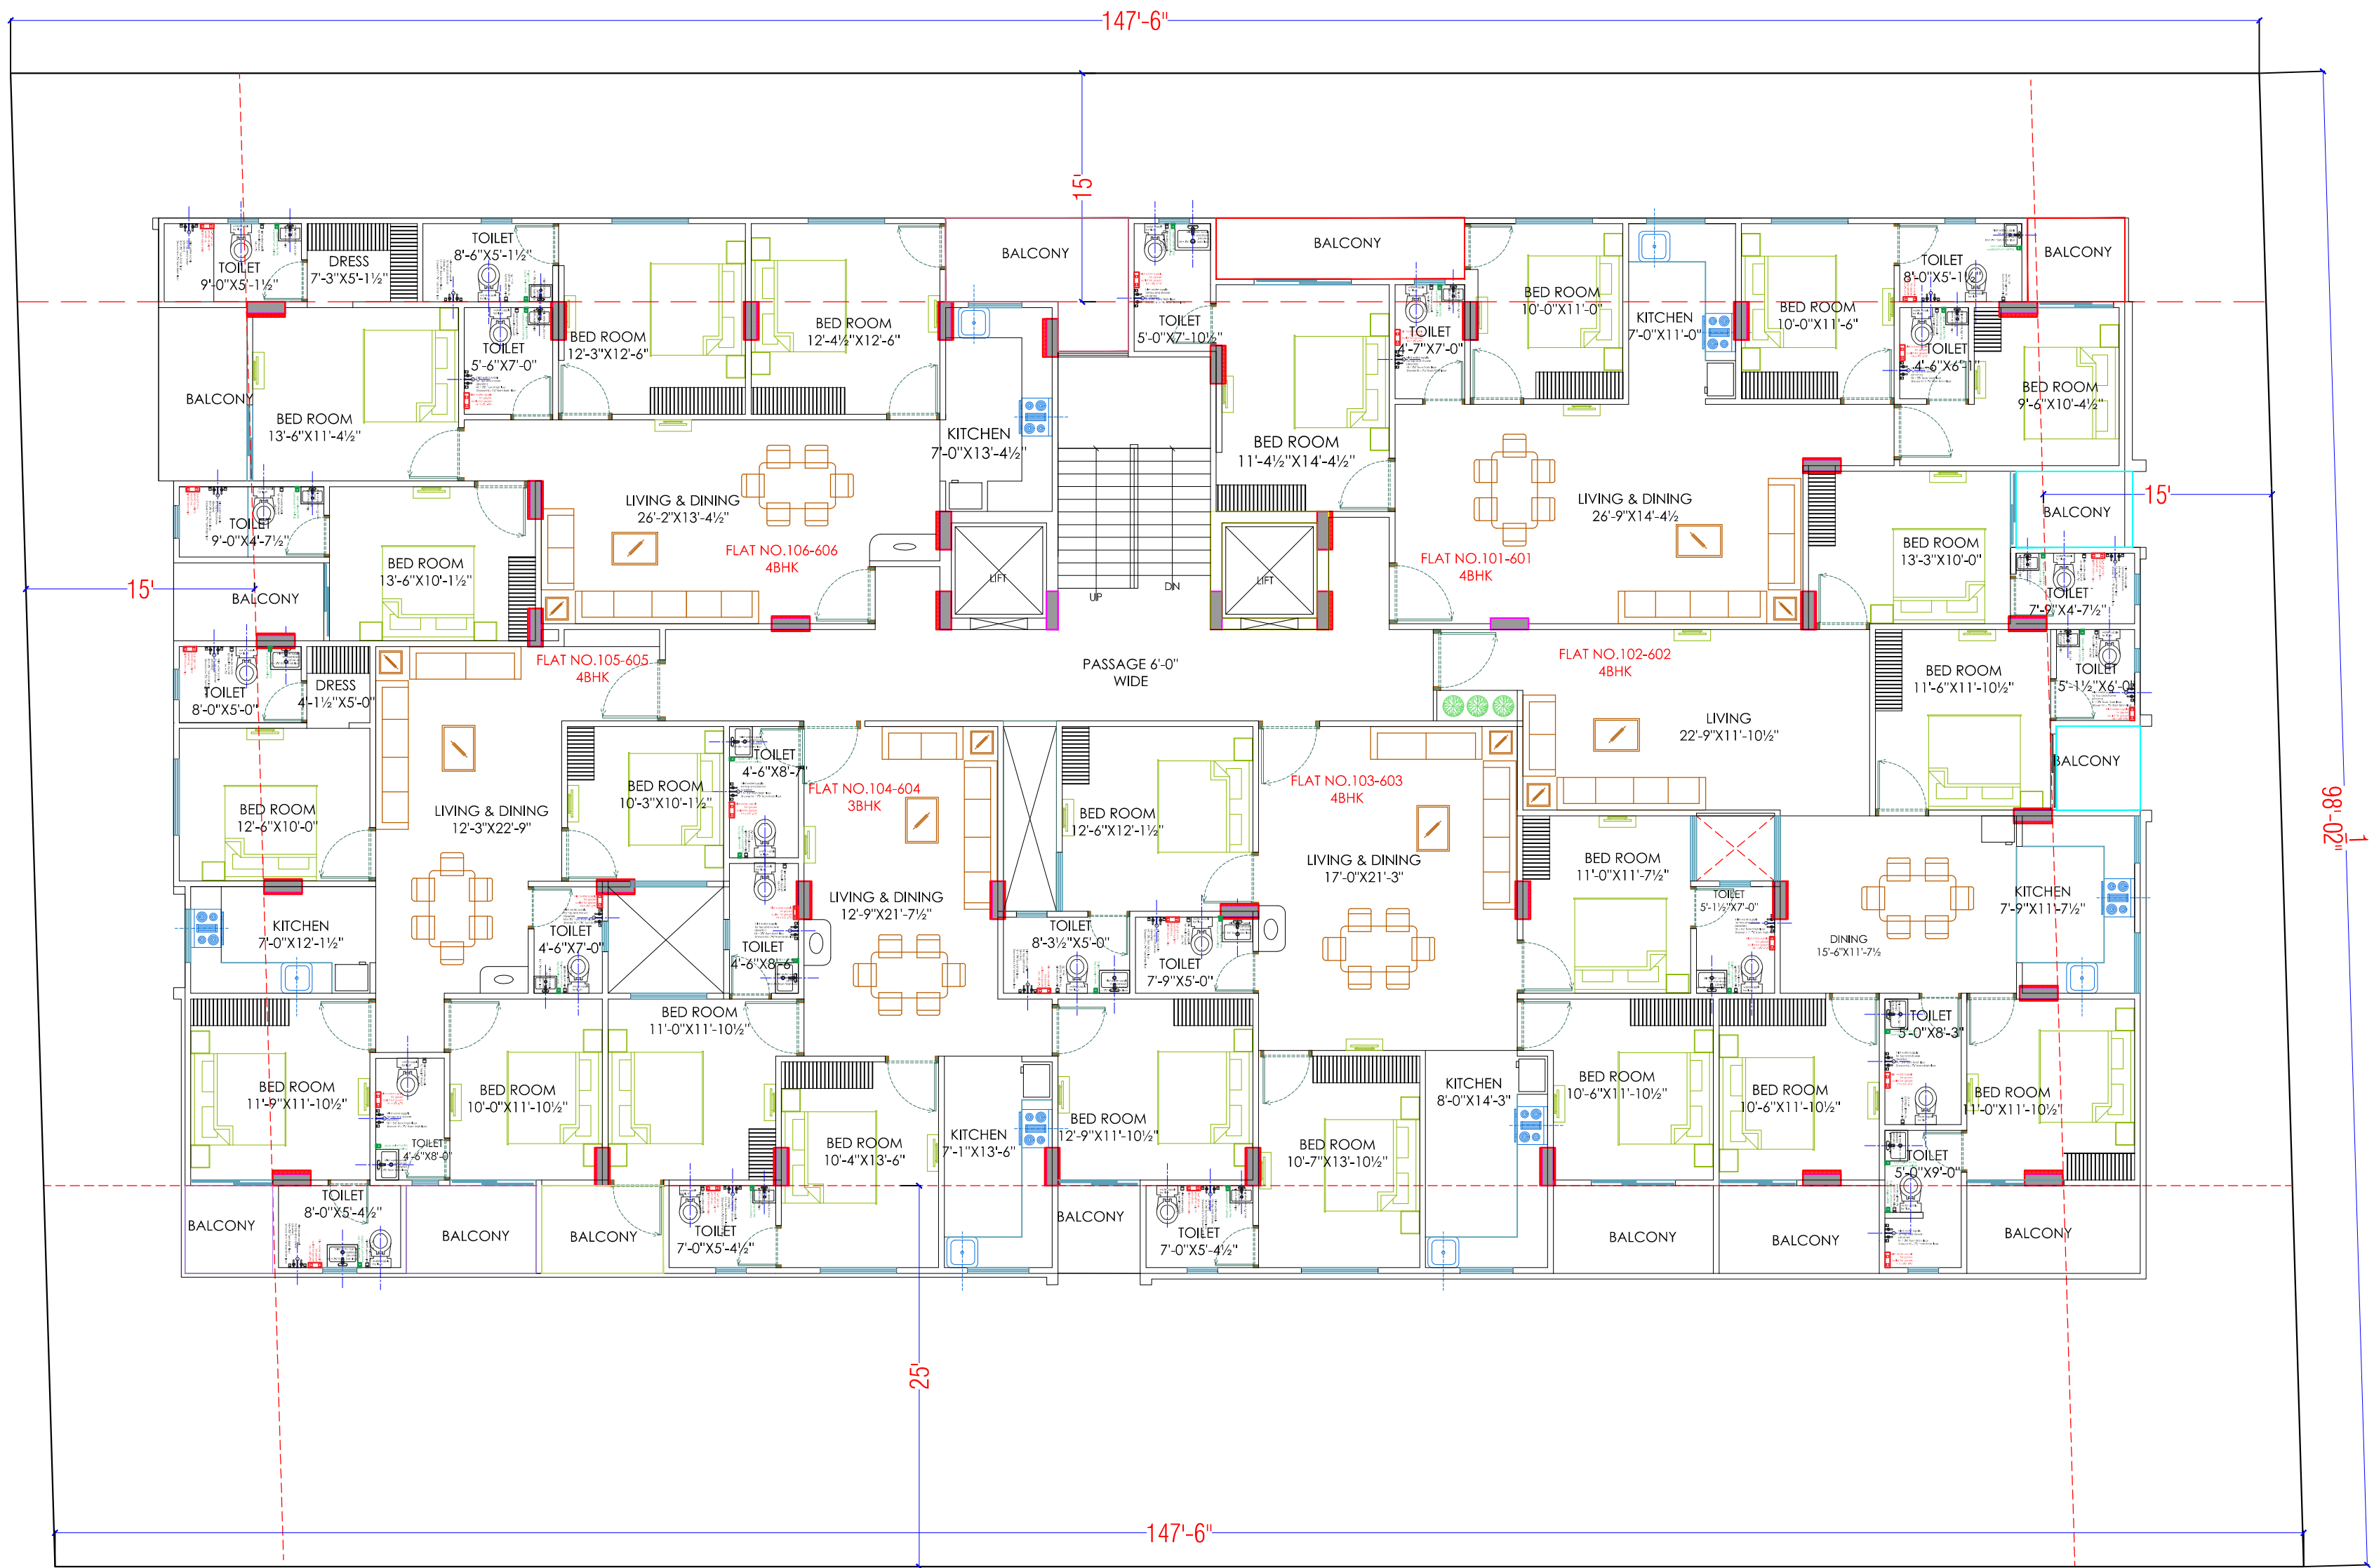



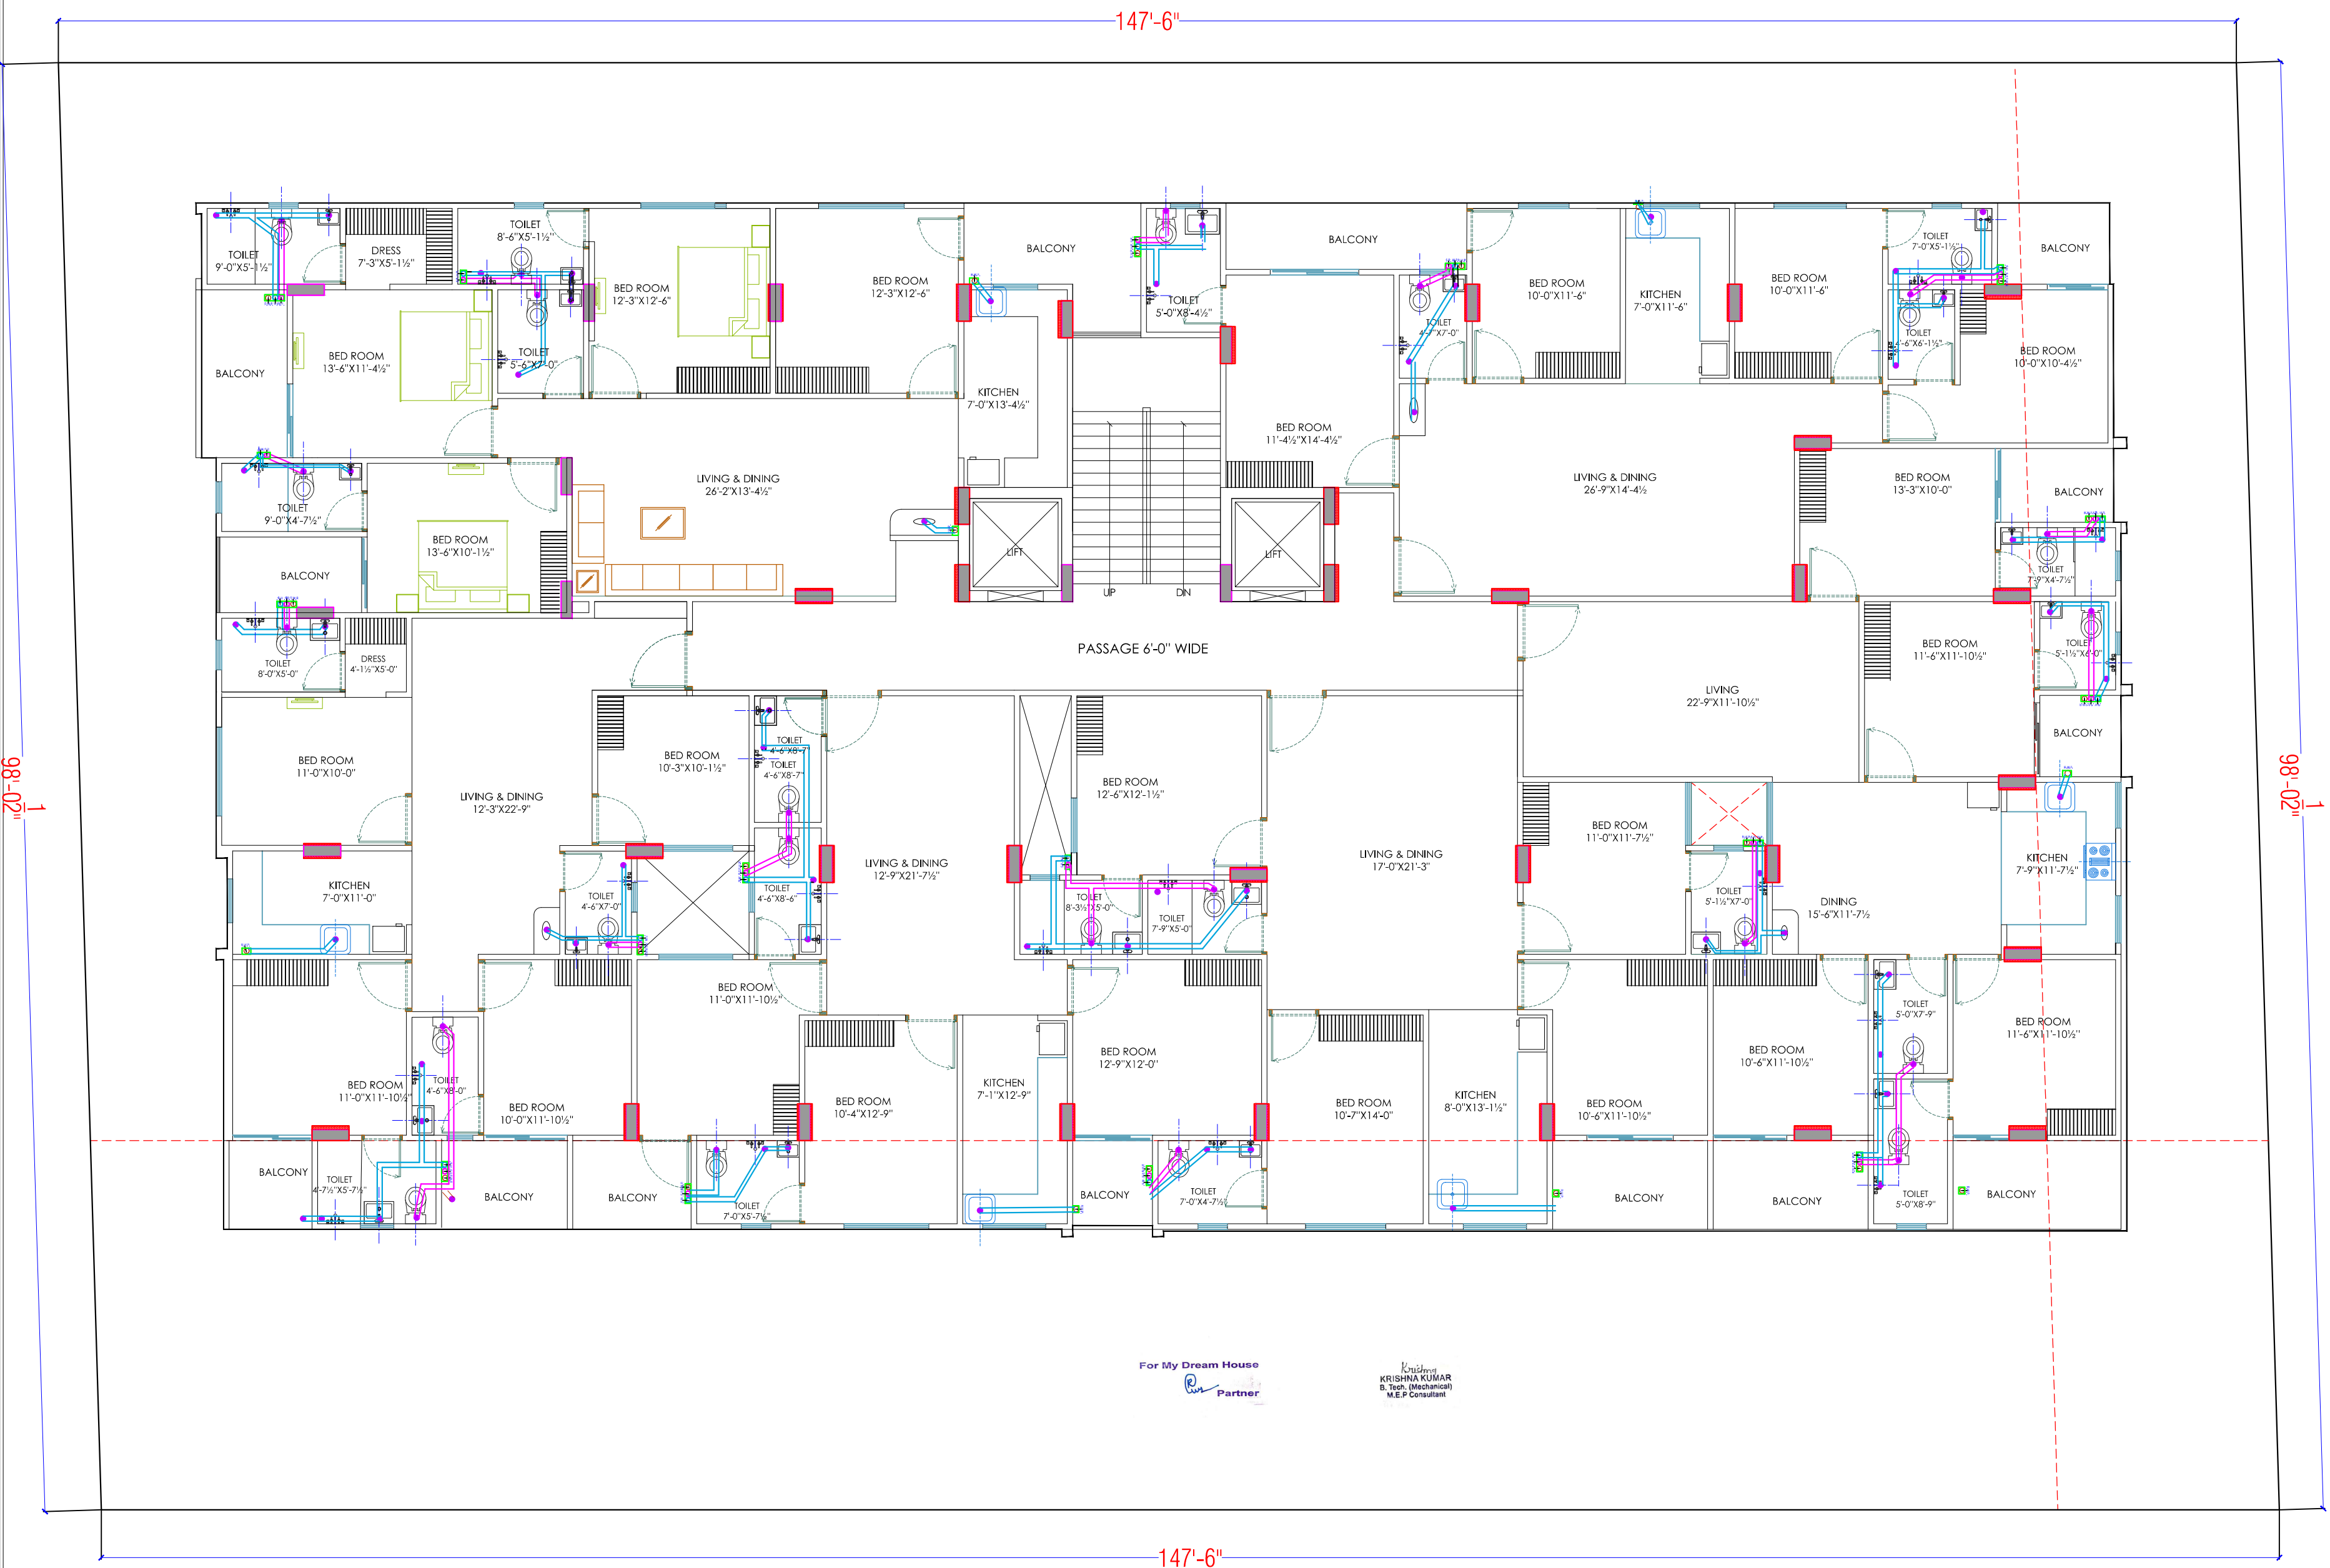

|   |                 |  |  |
|---|-----------------|--|--|
| ① | RAIN WATER PIPE |  |  |
| ② | WEST WATER PIPE |  |  |
| ③ | SOILWATER PIPE  |  |  |

| LEGENDS |        |                           |
|---------|--------|---------------------------|
| S.NO.   | SYMBOL | DESCRIPTION               |
| 1.      |        | SDR-11 Fresh Water Pipe   |
| 2.      |        | SDR-11 Solar Water Pipe   |
| 3.      |        | Waste Water Pipe (W.P.)   |
| 4.      |        | Soil Pipe (S.P.)          |
| 5.      |        | Rain Water Pipe (R.W.P.)  |
| 6.      |        | Butter Fly Valve (B.F.V.) |
| 7.      |        | Geyser                    |
| 8.      |        | RO                        |
| 9.      |        | Single Lever Diverter     |
| 10.     |        | Concealed Valve           |
| 11.     |        | Angle Valve               |
| 12.     |        | Nahani Trap               |
| 13.     |        | P-Trap                    |
| 14.     |        | Tap                       |
| 15.     |        | Floor Drain (F.D.)        |
| 16.     |        | Plain Tee (P-tee)         |
| 17.     |        | Gully Trap (G.T.)         |
| 18.     |        |                           |

#### WARNING

1. This drawing is the sole copyright of Architects **VISTAAR** and should be used for the purpose expressly issued.

#### GENERAL NOTES

1. All dimensions are in feet and inches.
2. Do not scale this drawing follow written dimensions only.
3. This drawing should be read in conjunction with other architectural and structural drawings.
4. Any discrepancy in the drawing should be immediately brought to the notice of architect.

#### PROJECT TITLE

PROJECT:-  
SUNRISE WESTWAY HEIGHTS  
BUILDING AT PLOT NO.-32E & 32F, WESTWAY HEIGHTS (TRUCK TERMINAL), VILL. KESHOPURA, ASARPURA, BHANKROTA, JAIPUR

#### DRAWING TITLE


GROUND TO 5TH FLOOR  
DRAINAGE PLAN

#### ARCHITECTS:

**VISTAAR ARCHITECTS & PLANNERS**

Architects :: Interior Designers  
B-2/12, Chitrkoot scheme,  
main Gandhi Path, Opp mall of jaipur, Jaipur  
PH. - 0141-4116461, 09001010366

| PRP   | DRN     | DATE       | REV. | NORTH |
|-------|---------|------------|------|-------|
| ER    | SACHIN  | 26-07-2024 |      |       |
| SCALE | JOB NO. |            |      |       |
| NTS   |         |            |      |       |

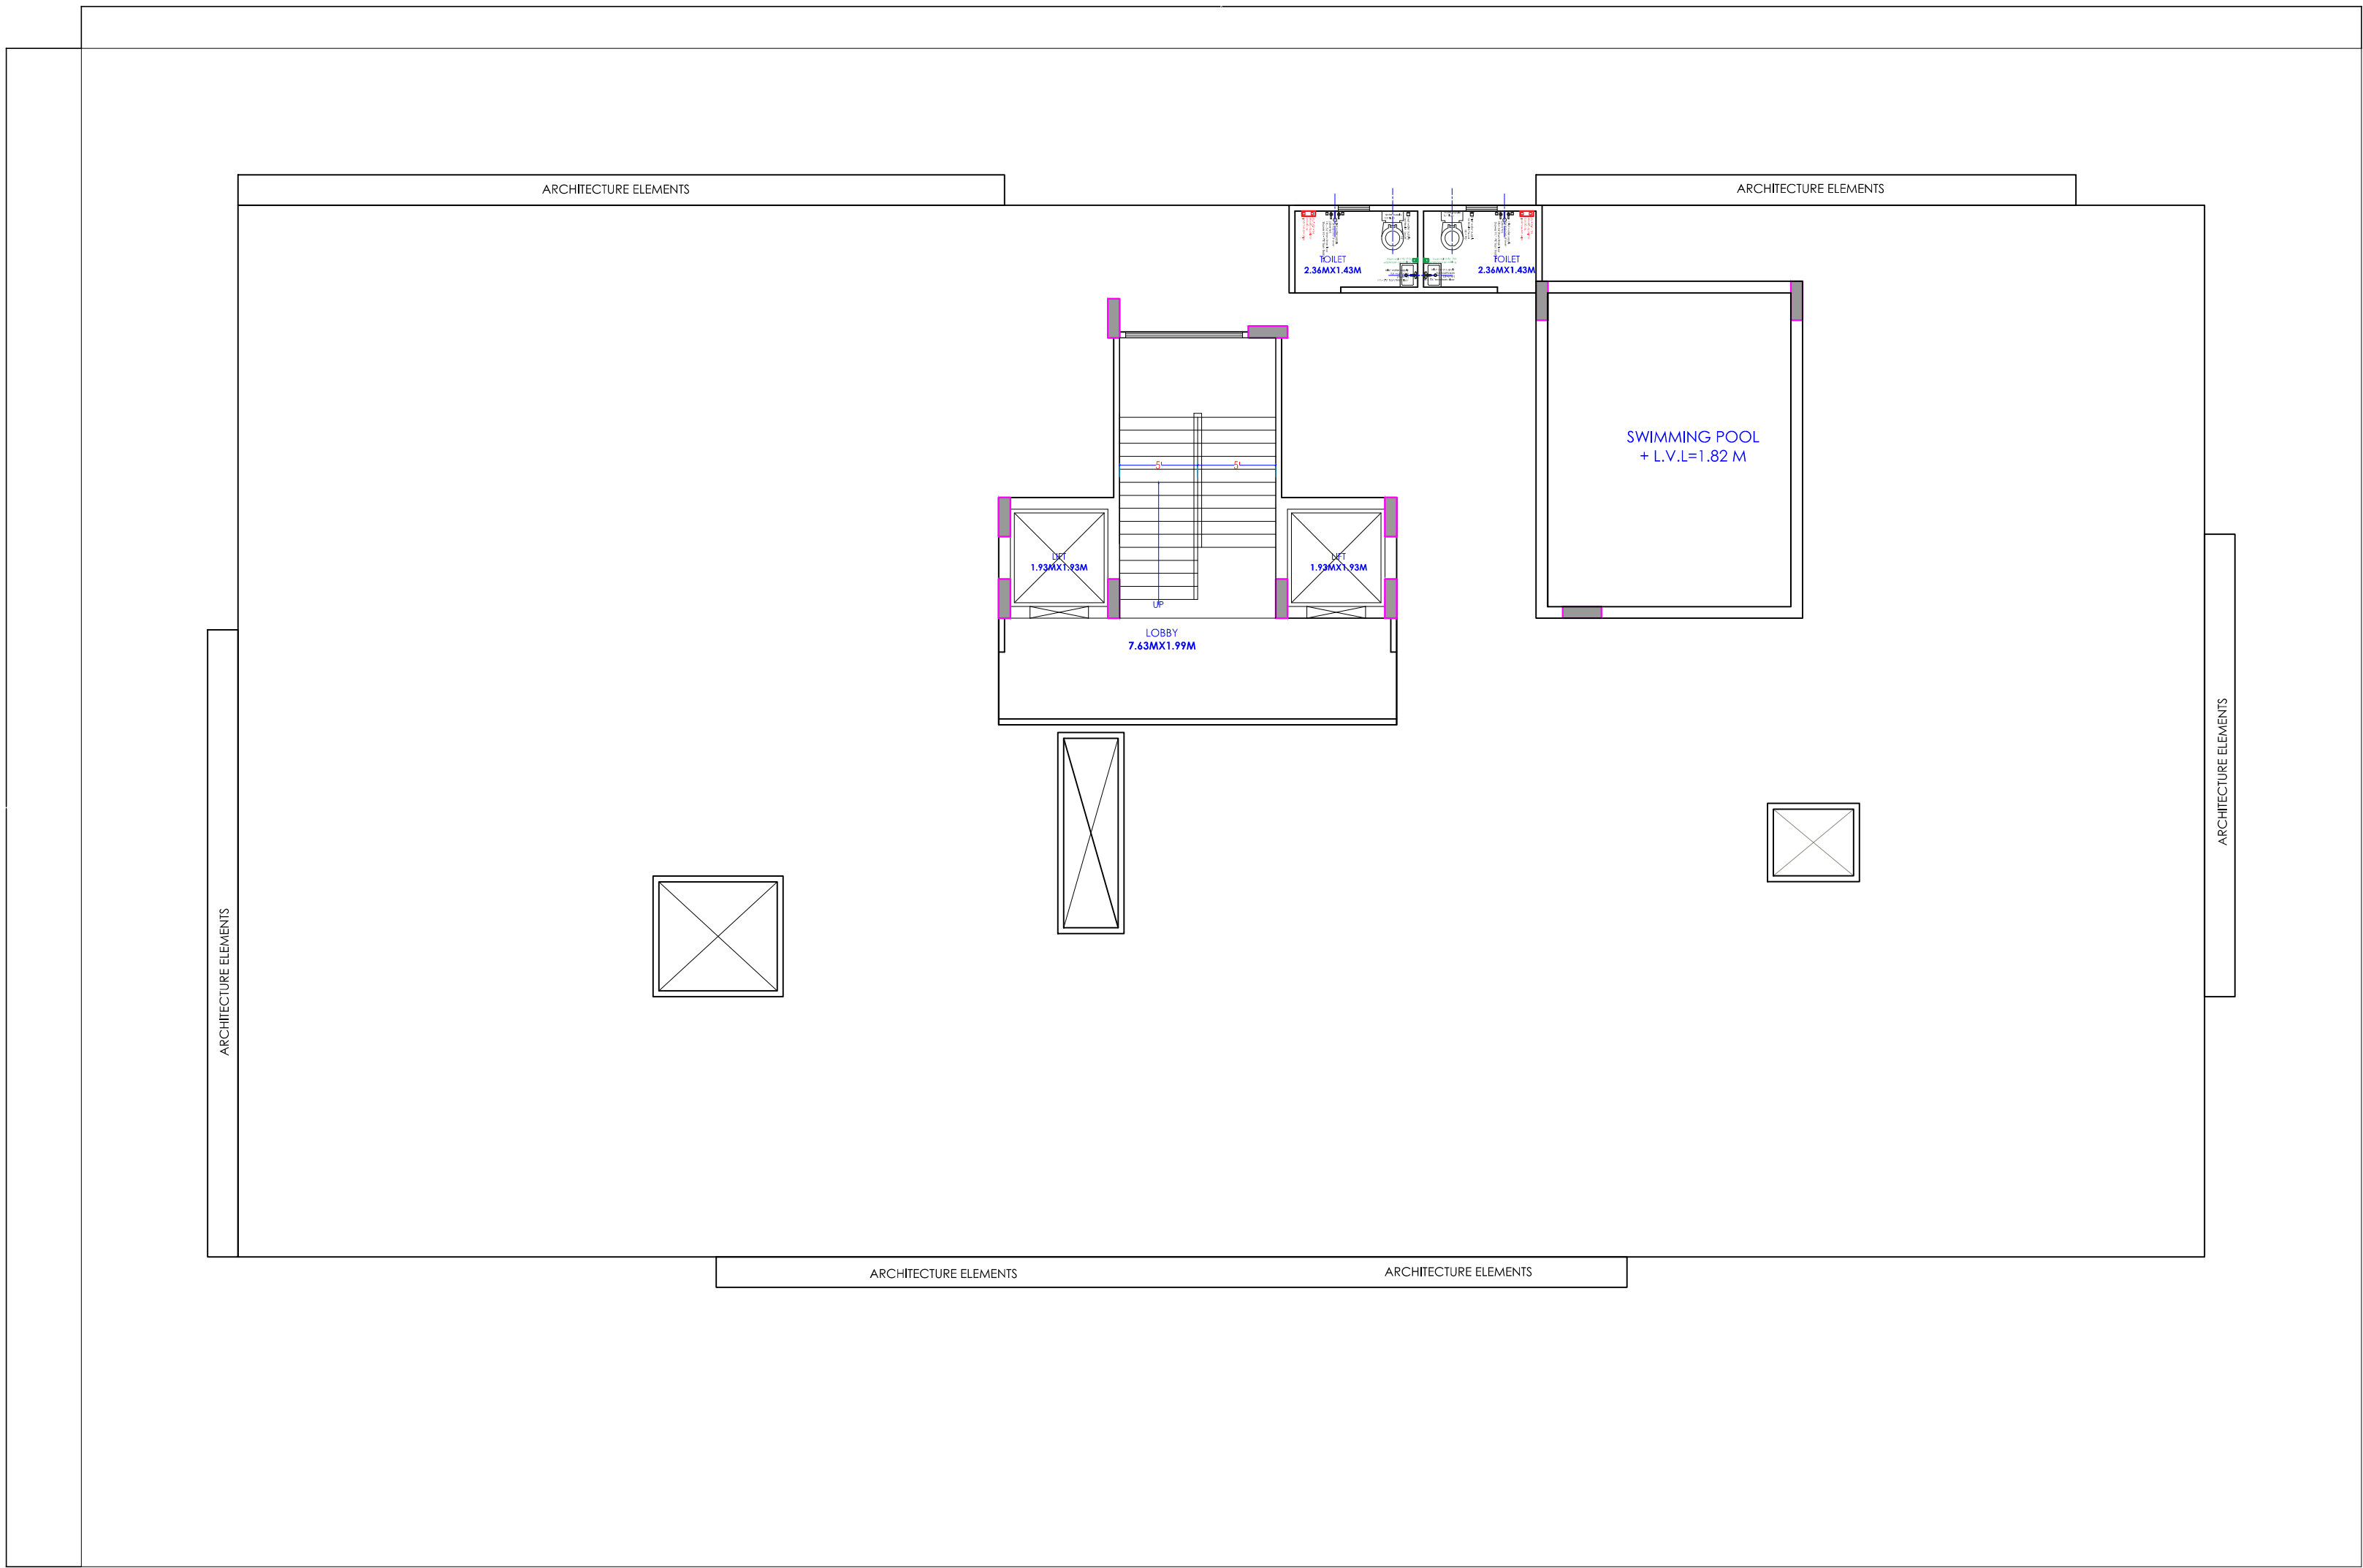

| LEGENDS |        |                          |
|---------|--------|--------------------------|
| S.NO.   | SYMBOL | DESCRIPTION              |
| 1.      |        | SDR-11 Fresh Water Pipe  |
| 2.      |        | SDR-11 Solar Water Pipe  |
| 3.      |        | Waste Water Pipe (W.P.)  |
| 4.      |        | Soil Pipe (S.P.)         |
| 5.      |        | Rain Water Pipe (R.W.P.) |
| 6.      |        | Butter Fly Valve(B.F.V.) |
| 7.      |        | Geyser                   |
| 8.      |        | RO                       |
| 9.      |        | Single Lever Diverter    |
| 10.     |        | Concealed Valve          |
| 11.     |        | Angle Valve              |
| 12.     |        | Nahani Trap              |
| 13.     |        | P-Trap                   |
| 14.     |        | Tap                      |
| 15.     |        | Floor Drain (F.D.)       |
| 16.     |        | Plain Tee (P-tee)        |
| 17.     |        | Gully Trap (G.T.)        |
| 18.     |        |                          |

WARNING

1. This drawing is the sole copyright of Architects **VISTAAR** and should be used for the purpose expressly issued.

GENERAL NOTES

1. All dimensions are in feets and inches.
2. Do not scale this drawing follow written dimensions only.
3. This drawing should be read in conjunction with other architectural and structural drawings.
4. Any discrepancy in the drawing should be immediately brought to the notice of architect.

| PROJECT TITLE                                                                                                                                          |
|--------------------------------------------------------------------------------------------------------------------------------------------------------|
| PROJECT:-<br>SUNRISE WESTWAY HEIGHTS<br>BUILDING AT PLOT NO.-32E & 32F.WESTWAY<br>HEIGHTS(TRUCK TERMINAL),VILL.KESHOPURA,ASARPURA<br>,BHANKROTA,JAIPUR |


| DRAWING TITLE |
|---------------|
|---------------|

|                       |
|-----------------------|
| TERRACE PLUMBING PLAN |
|-----------------------|

| ARCHITECTS :                                                                                                                                                                             |  |  |  |
|------------------------------------------------------------------------------------------------------------------------------------------------------------------------------------------|--|--|--|
| <b>VISTAAR ARCHITECTS &amp; PLANNERS</b><br>Architects :: Interior Designers<br>B-2/12, Chitrkoot scheme,<br>main Gandhi Path,Opp mall of jaipur,Jaipur<br>PH.- 0141-4116461,09001010366 |  |  |  |

| PART :   |            |      |       |
|----------|------------|------|-------|
| DRN.     | DATE       | REV. | NORTH |
| ER,SACHN | 02-08-2024 |      |       |
| SCALE    | JOB NO.    |      |       |
| N.T.S    |            |      |       |



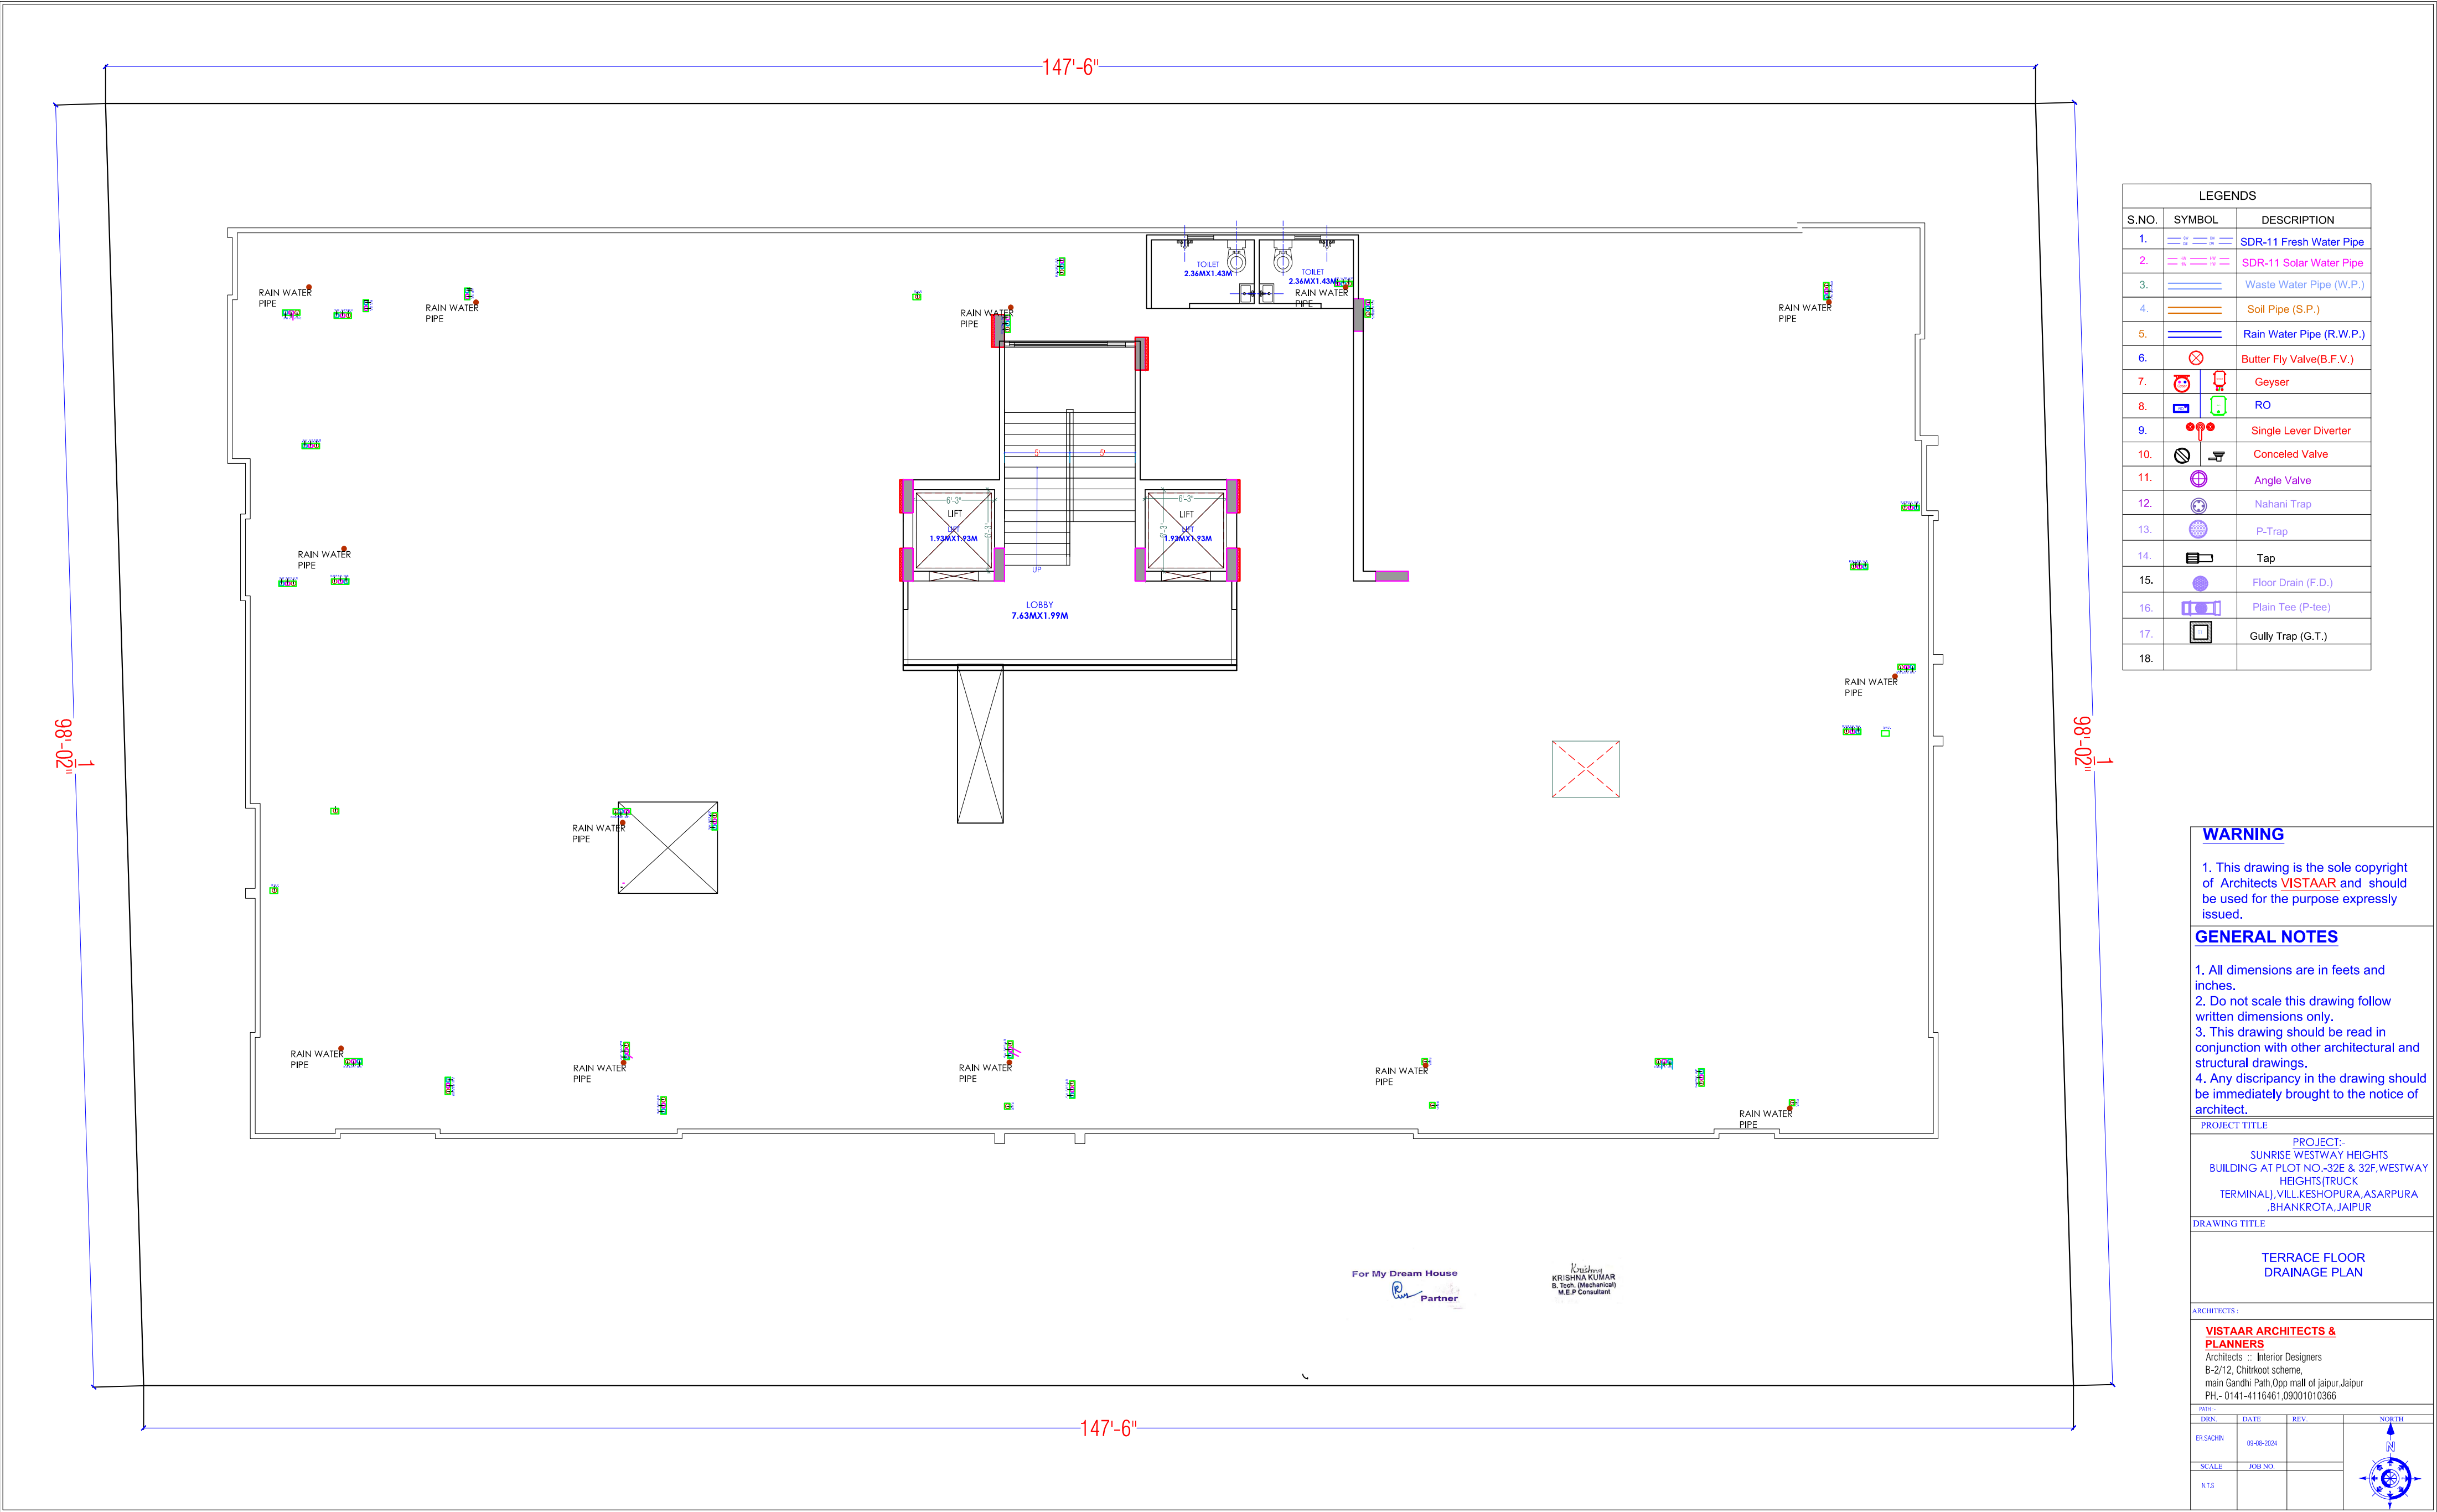

| LEGENDS |        |                          |
|---------|--------|--------------------------|
| S.NO.   | SYMBOL | DESCRIPTION              |
| 1.      |        | SDR-11 Fresh Water Pipe  |
| 2.      |        | SDR-11 Solar Water Pipe  |
| 3.      |        | Waste Water Pipe (W.P.)  |
| 4.      |        | Soil Pipe (S.P.)         |
| 5.      |        | Rain Water Pipe (R.W.P.) |
| 6.      |        | Butter Fly Valve(B.F.V.) |
| 7.      |        | Geyser                   |
| 8.      |        | RO                       |
| 9.      |        | Single Lever Diverter    |
| 10.     |        | Concealed Valve          |
| 11.     |        | Angle Valve              |
| 12.     |        | Nahani Trap              |
| 13.     |        | P-Trap                   |
| 14.     |        | Tap                      |
| 15.     |        | Floor Drain (F.D.)       |
| 16.     |        | Plain Tee (P-tee)        |
| 17.     |        | Gully Trap (G.T.)        |
| 18.     |        |                          |

WARNING

1. This drawing is the sole copyright of Architects VISTAAR and should be used for the purpose expressly issued.

GENERAL NOTES


- 1. All dimensions are in feets and inches.
- 2. Do not scale this drawing follow written dimensions only.
- 3. This drawing should be read in conjunction with other architectural and structural drawings.
- 4. Any discrepancy in the drawing should be immediately brought to the notice of architect.

PROJECT TITLE  
SUNRISE WESTWAY HEIGHTS  
BUILDING AT PLOT NO.-32E & 32F, WESTWAY HEIGHTS (TRUCK  
TERMINAL), VILL KESHOPURA, ASARPURA ,BHANKROTA, JAIPUR

DRAWING TITLE  
TERRACE FLOOR  
DRAINAGE PLAN

ARCHITECTS :  
VISTAAR ARCHITECTS & PLANNERS  
Architects : Interior Designers  
B-2/12, Chitarkoot scheme,  
main Gandhi Path, Opp mall of jaipur, Jaipur  
PH. - 0141-4116461, 09001010366

| DRN.      | DATE       | REV. | NORTH |
|-----------|------------|------|-------|
| ER.SACHIN | 09-08-2024 |      |       |
| SCALE     | JOB NO.    |      |       |
| NTS       |            |      |       |

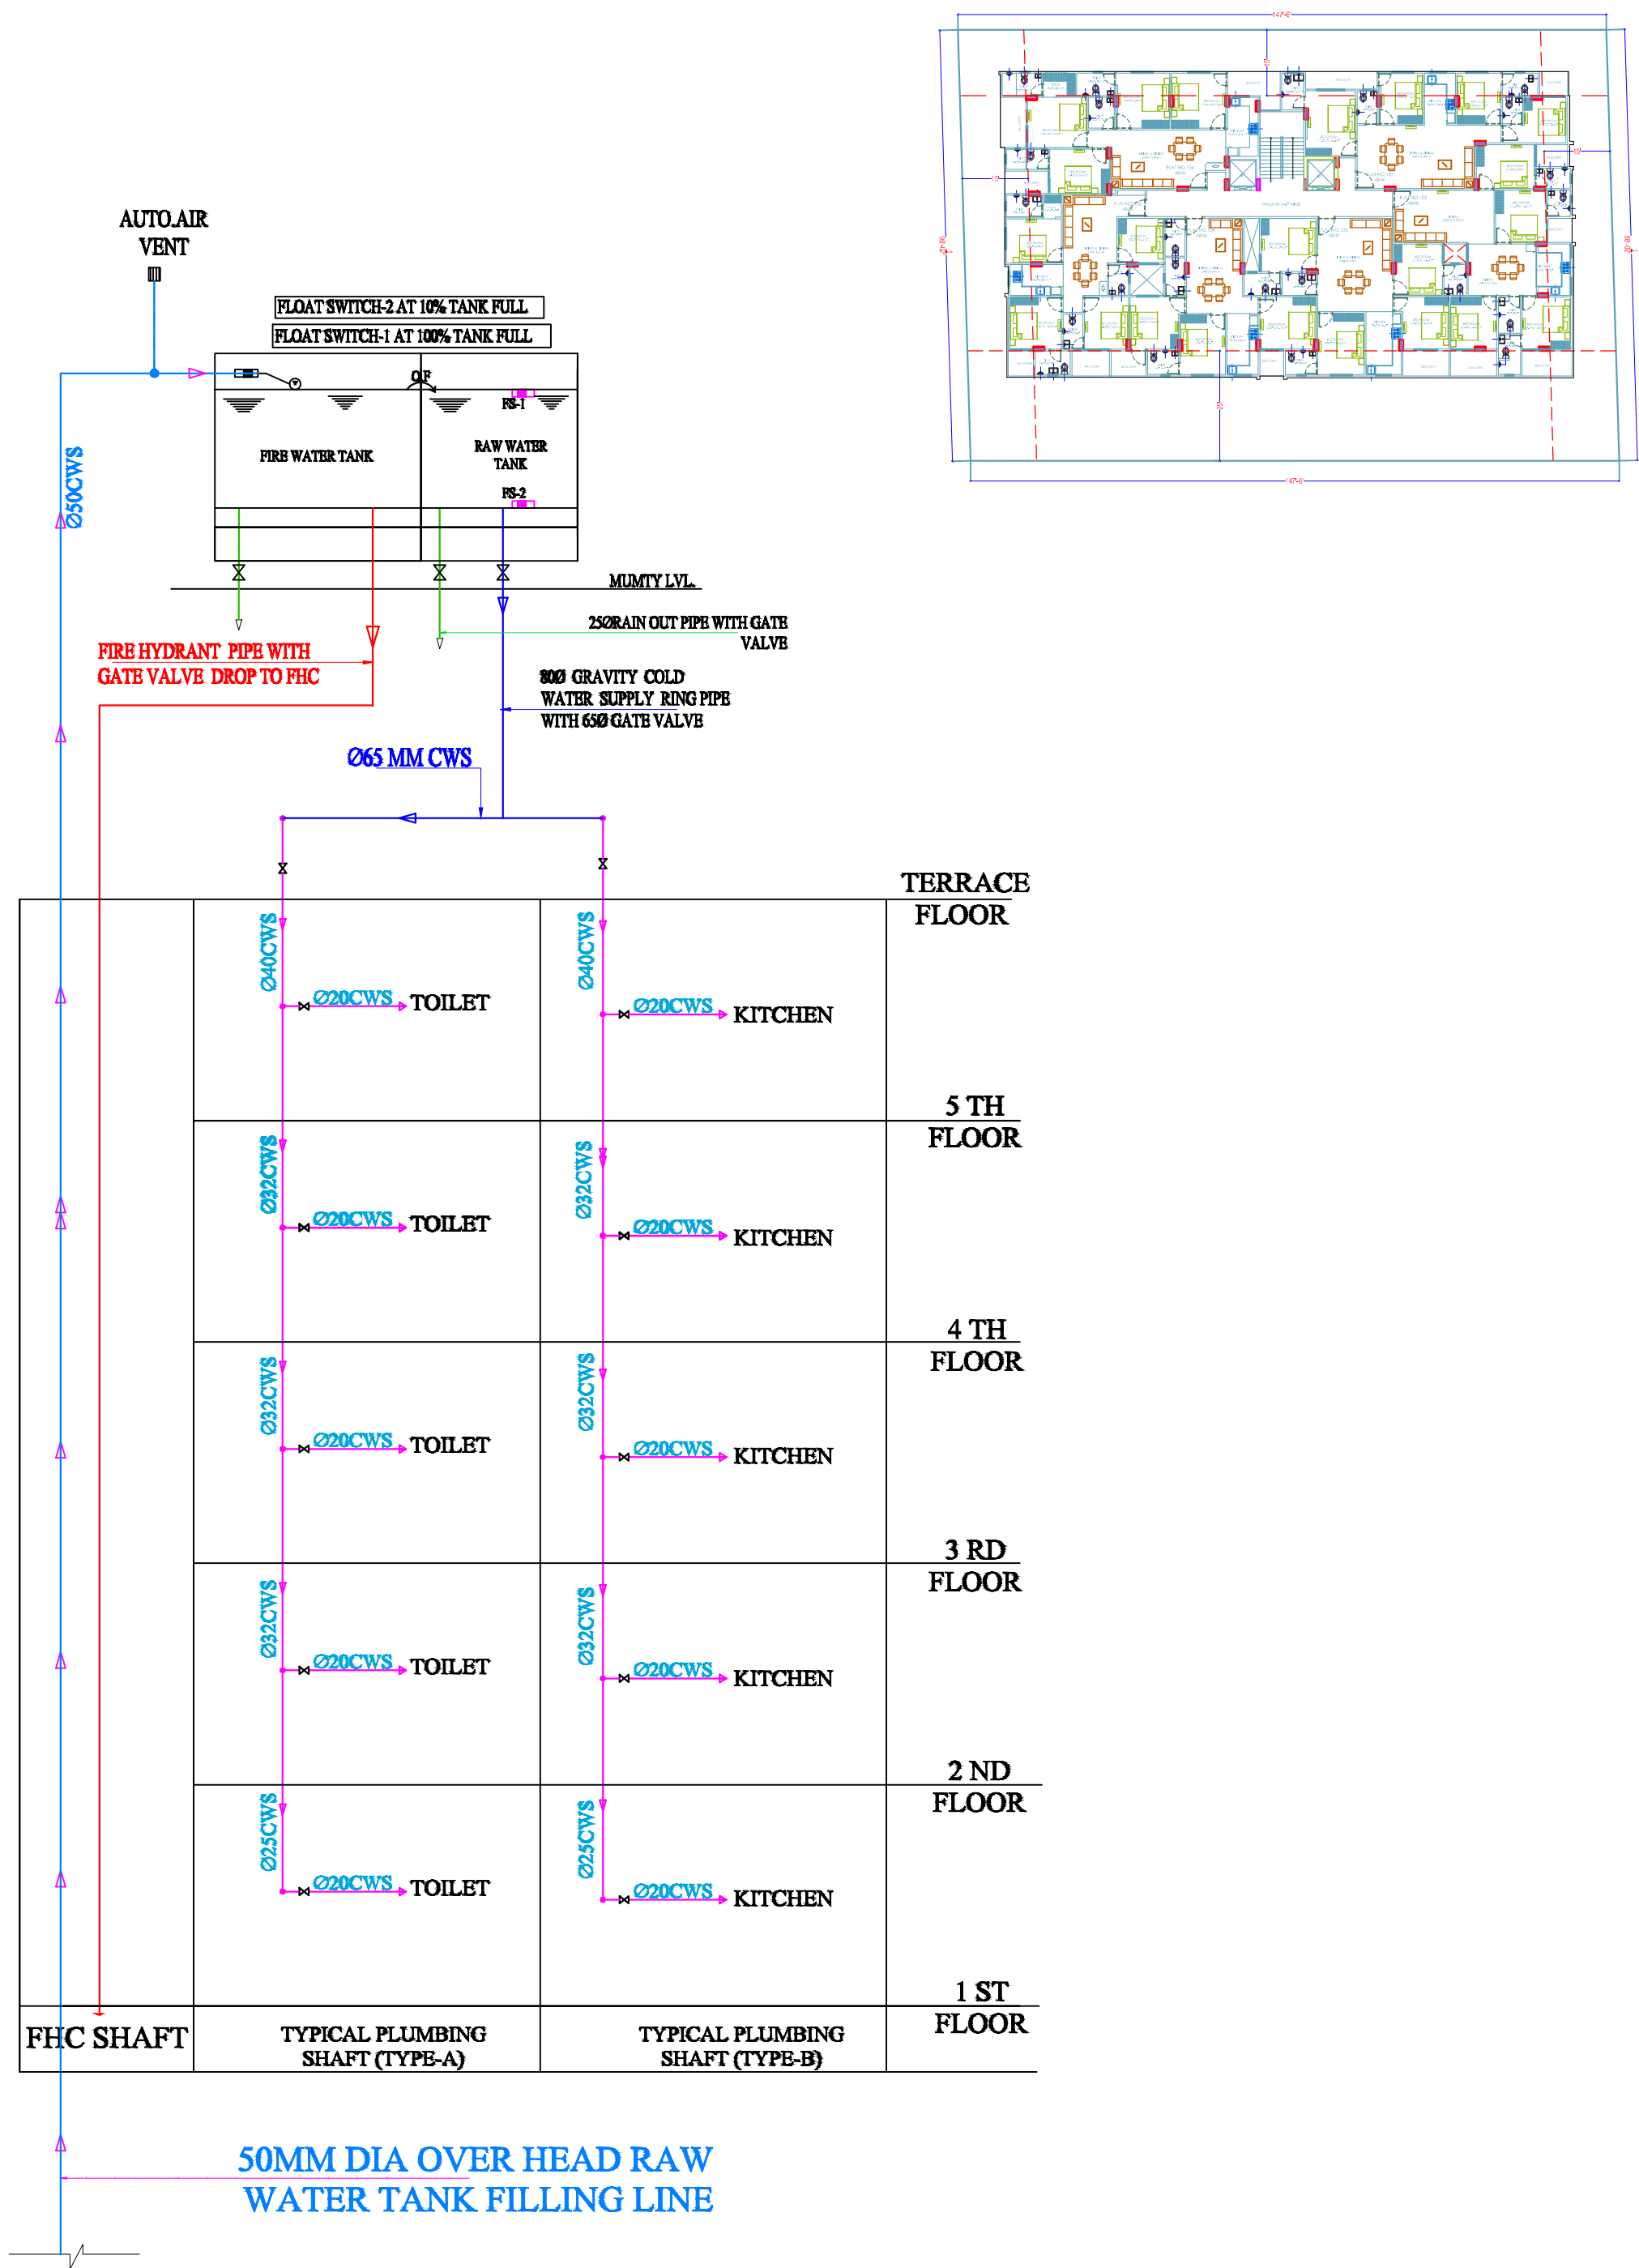

Krishna  
KRISHNA KUMAR  
B. Tech. (Mechanical)  
M.E.P Consultant

For My Dream House  
Partner

**WARNING**

1. This drawing is the sole copyright of Architects **VISTAAR** and should be used for the purpose expressly issued.

**GENERAL NOTES**

1. All dimensions are in feet and inches.
2. Do not scale this drawing follow written dimensions only.
3. This drawing should be read in conjunction with other architectural and structural drawings.
4. Any discrepancy in the drawing should be immediately brought to the notice of architect.

**PROJECT TITLE**

PROJECT:-  
SUNRISE WESTWAY HEIGHTS  
BUILDING AT PLOT NO.-32E &  
32F, WESTWAY HEIGHTS (TRUCK  
TERMINAL), VILL. KESHOPURA, ASARPURA  
, BHANKROTA, JAIPUR

**DRAWING TITLE**

**WATER SUPPLY DIAGRAM**

**ARCHITECTS :**

**VISTAAR ARCHITECTS & PLANNERS**  
Architects :: Interior Designers  
B-2/12, Chitrkoot scheme,  
main Gandhi Path, Opp mall of jaipur, Jaipur-21  
Email-Vistaararchitects.web@gmail.com  
PH.- 0141-4116461, 09001010366

**PATH :-**

| DRN.          | DATE       | REV. | NORTH |
|---------------|------------|------|-------|
| MANOJ KUMAWAT | 26-07-2024 |      |       |
| SCALE         | JOB NO.    |      |       |
| N.T.S         |            |      |       |