



1. This drawing is the sole copyright of Architects VISTAAR and should be used for the purpose expressly issued

1. All dimensions are in feet and inches.
2. Do not scale this drawing follow written dimensions only.
3. This drawing should be read in conjunction with other architectural and structural drawings.
4. Any discrepancy in the drawing should be immediately brought to the notice of architect.


PROJECT:-
SUNRISE WESTWAY HEIGHTS
BUILDING AT PLOT NO.-32E & 32F, WESTWAY
HEIGHTS (TRUCK
TERMINAL), VILL. KESHOPURA, ASARPURA
, BHANKROTA, JAIPUR

STILT FLOOR CEILING ELECTRICAL
PLAN

VISTAAR ARCHITECTS & PLANNERS
Architects :: Interior Designers
B-2/12, Chitrakoot scheme,
main Gandhi Path, Opp mall of jaipur, Jaipur
PH. - 0141-4116461, 09001010366

Krishna
KRISHNA KUMAR
B. Tech. (Mechanical)
M. E. P. Consultant

 Partner

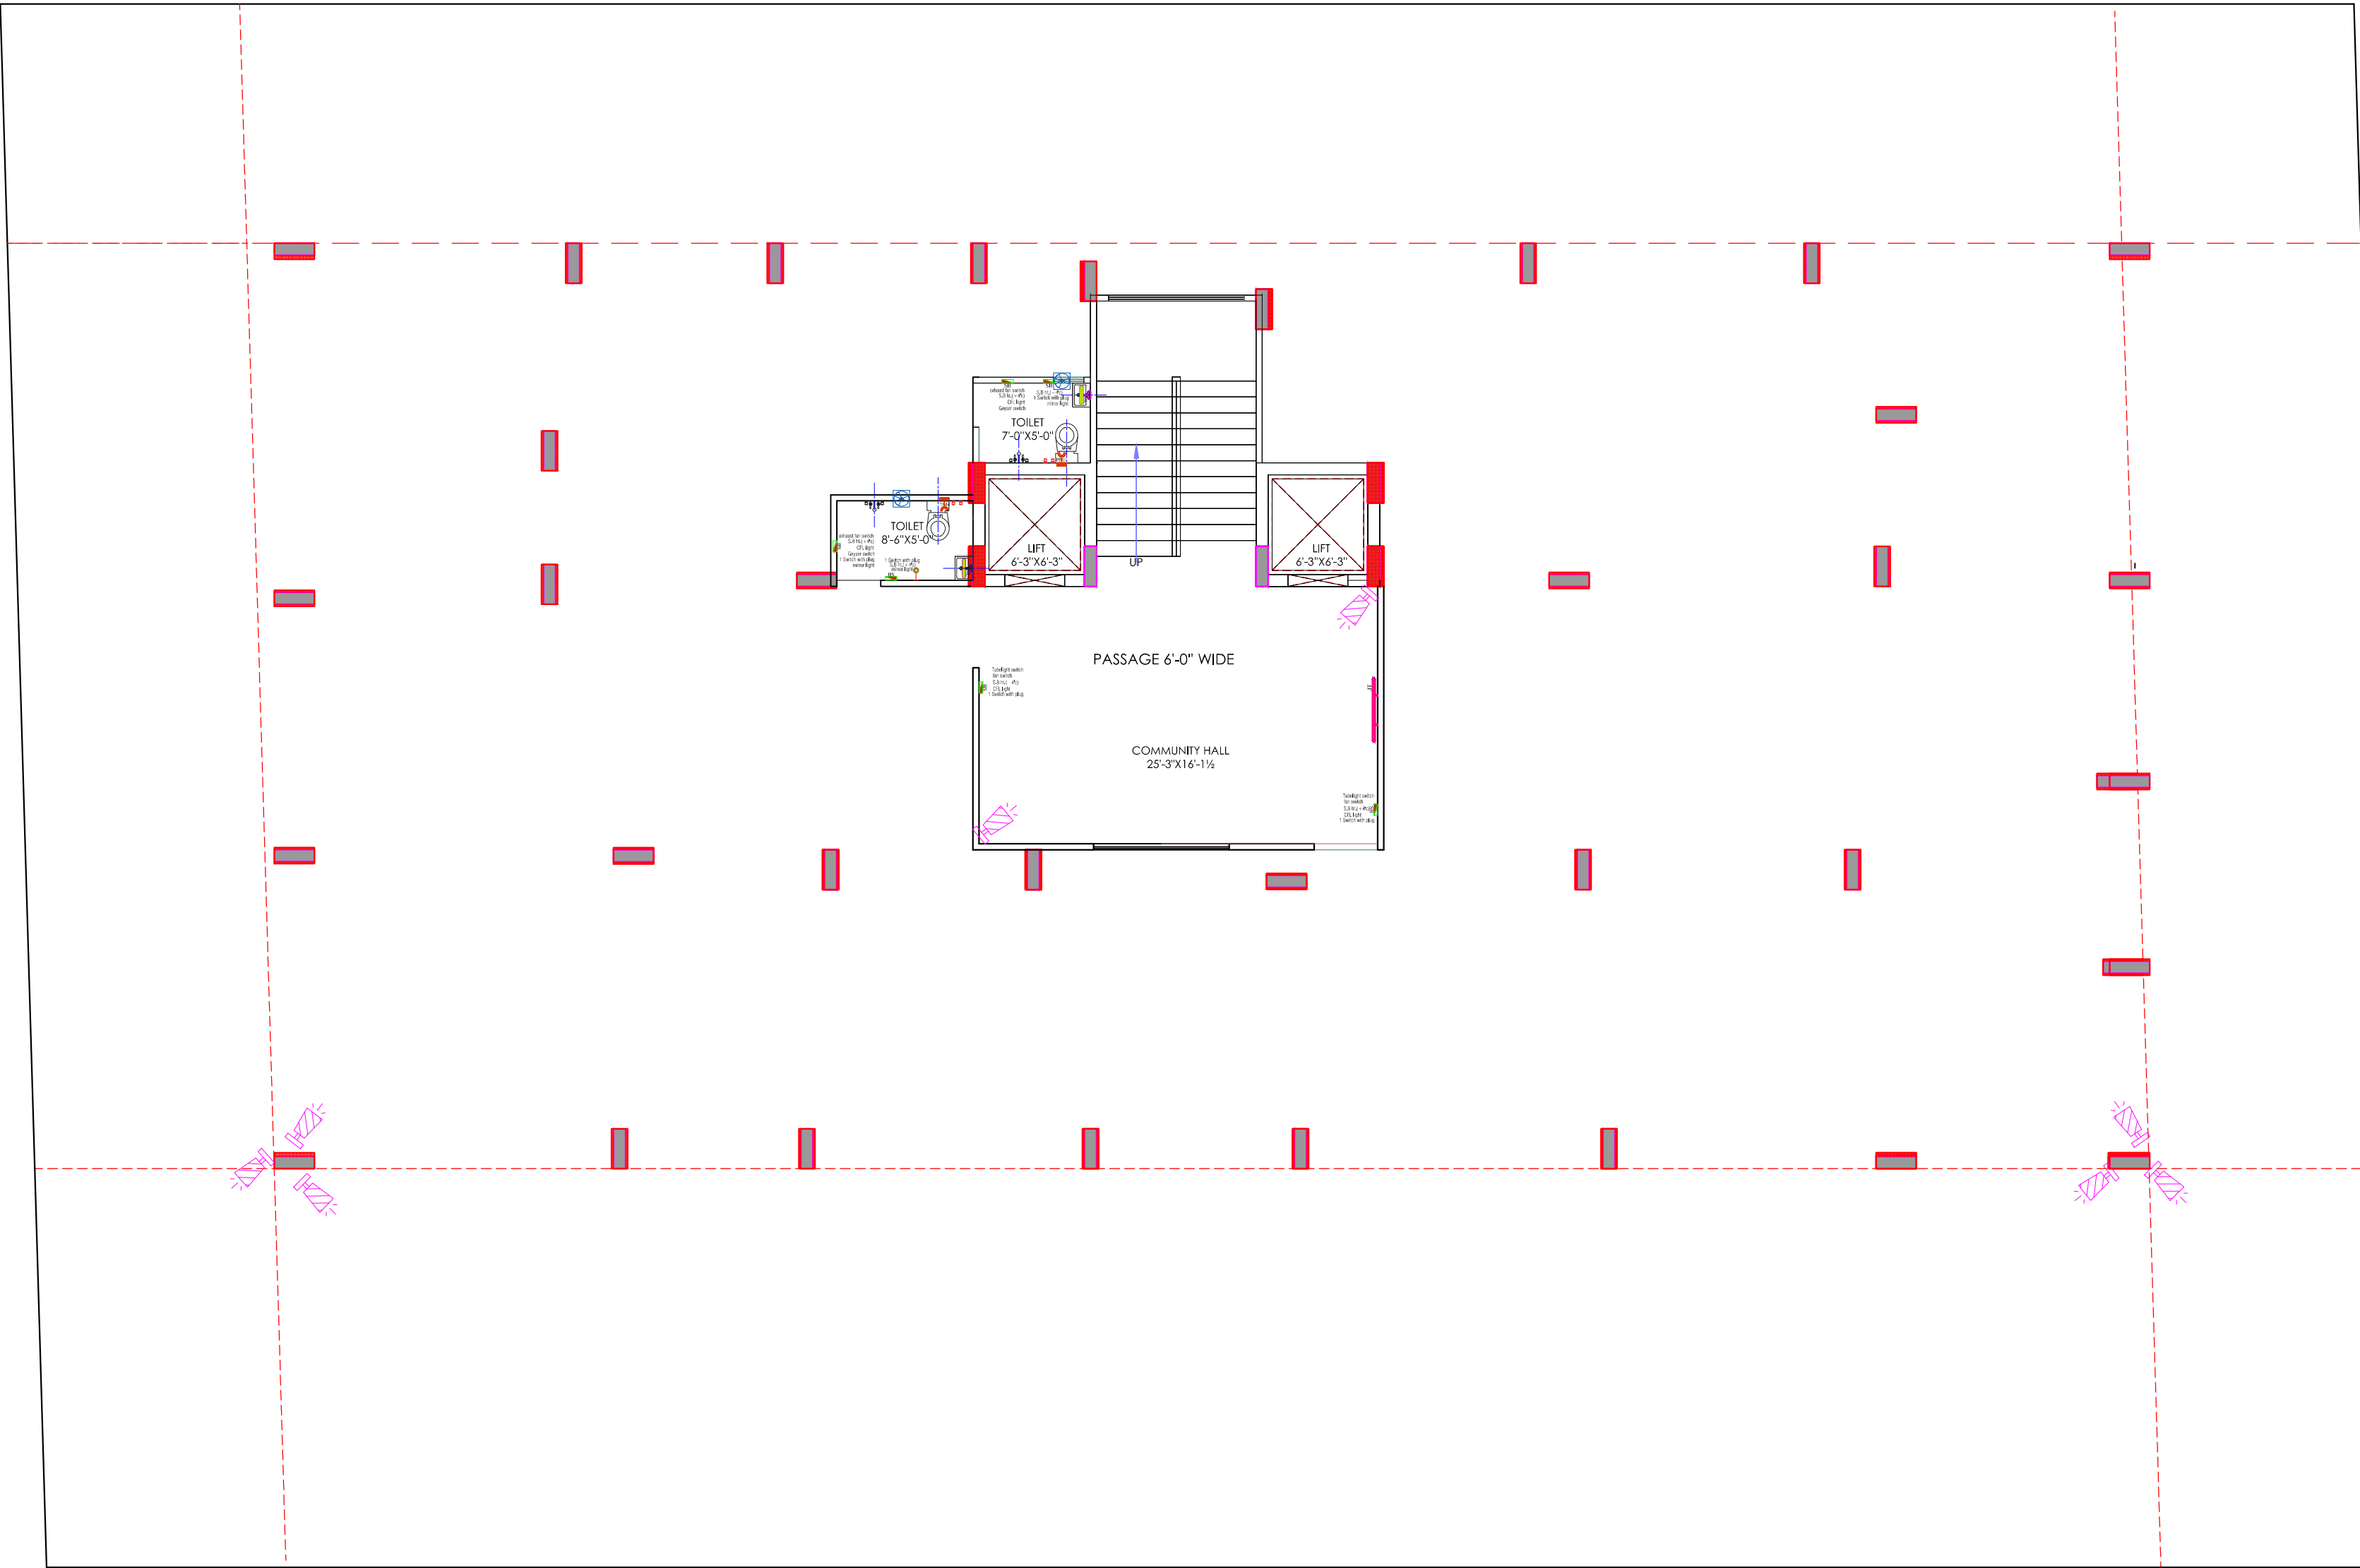

LEGENDS:			
Mounting Height	No.	I.D	Symbol
IN FLOOR			CONTROL WIRING
IN CONDUIT			CONTROL WIRING
IN CONDUIT			AC CONTROL WIRING
IN CONDUIT			DATA CONTROL WIRING
IN CONDUIT			SLIDER CONTROL WIRING
CEILING	08	FAN-40"	CEILING FAN 40"
CEILING	02	FAN-30"	CEILING FAN 30"
100"	04	TL	DOWN WALL TUBELIGHT
100"	04	BULB	WALL BRACKETS AS DESIGN LIGHT
100"	01	GL	WALL BRACKETS AS DESIGN FOR GROUND LIGHT
02	GL		WALL BRACKETS AS DESIGN FOR GROUND LIGHT
CEILING	21	CFL	CFL CEILING LIGHT
+21"	02	FL	FOOT LIGHT
+40"	14	SB	SWITCH BOARD
+70"	03	ML	1 X 11 W CFL MIRROR LIGHT
VENTILATOR	01	CR	CEILING ROSE
VENTILATOR	01	EXP	30 DIA FRESH AIR FAN
+24"	02	TEL	TELEPHONE POINT
+27"	03	TV	TV CORDING POINT
+24"	02	LP TEL	5 A PLUG POINT FOR TELEPHONE
+24"	02	LP TV	5 A PLUG POINT FOR TV
+24"	02	LP	5 A PLUG POINT
+72"	01	LP CH	5 A PLUG POINT FOR CHIMNEY
+102"	03	SAC	500W AC
+102"	03	PP-SAC	25 A POWER POINT FOR 500W AC
+42"	01	PP-MIX	75 A POWER POINT FOR MIXER
+78"	02	PP-G	15 A POWER POINT FOR GEYSER
+54"	01	PP-F	5 A POWER POINT FOR Fridge
+78"	01	PP-MF	5 A POWER POINT FOR MICROWAVE
+48"	01	PP-M	5 A POWER POINT FOR WASHING MACHINE
+42"	02	BP	BELL PUSH SWITCH
+90"	01	BZ	BELL RINGER
+24"	03	AC	AC STARTER
+40"	01	MCB DB	MCB DISTRIBUTION BOARD
03		SB 1.1	SWITCH BOARD NO. 1 LIGHT CIRCUIT NO.
03		AC 1	AC CIRCUIT NO.
05		PL 1	POWER CIRCUIT NO.

WARNING

1. This drawing is the sole copyright of Architects VISTAAR and should be used for the purpose expressly issued.

GENERAL NOTES

- All dimensions are in feet and inches.
- Do not scale this drawing follow written dimensions only.
- This drawing should be read in conjunction with other architectural and structural drawings.
- Any discrepancy in the drawing should be immediately brought to the notice of architect.

PROJECT TITLE
PROJECT:-
SUNRISE WESTWAY HEIGHTS
BUILDING AT PLOT NO.-32E & 32F.WESTWAY HEIGHTS(TRUCK
TERMINAL),VILL.KESHOPURA,ASARPURA ,BHANKROTA,JAIPUR


DRAWING TITLE
STILT FLOOR WALL ELECTRICAL PLAN
SERVICE(SLD)/DISTRIBUTION DETAILS AFTER LT
PANEL,EARTHING LAYOUT,EXTERNAL LIGHTING
PLAN,LAYOUT,TV & TELEPHONE RISER
DIAGRAM,LIGHTING ARRESTER LOCATION & PIT
LOCATION,COORDINATION DRAWINGS,FIRE
DETECTION & ALARM SYSTEM LAYOUT OF ALL
FLOOR)

ARCHITECTS :
VISTAAR ARCHITECTS &
PLANNERS
Architects :: Interior Designers
B-2/12, Chitrkoot scheme,
main Gandhi Path,Opp mall of jaipur,Jaipur
PH.- 0141-4116461,09001010366

DRN.	DATE	REV	NORTH
ER.SACHIN	16-08-2024		
SCALE	JOB NO.		
NTS			

For My Dream House
Partner

KRISHNA KUMAR
B. Tech. (Mechanical)
M.E.P Consultant

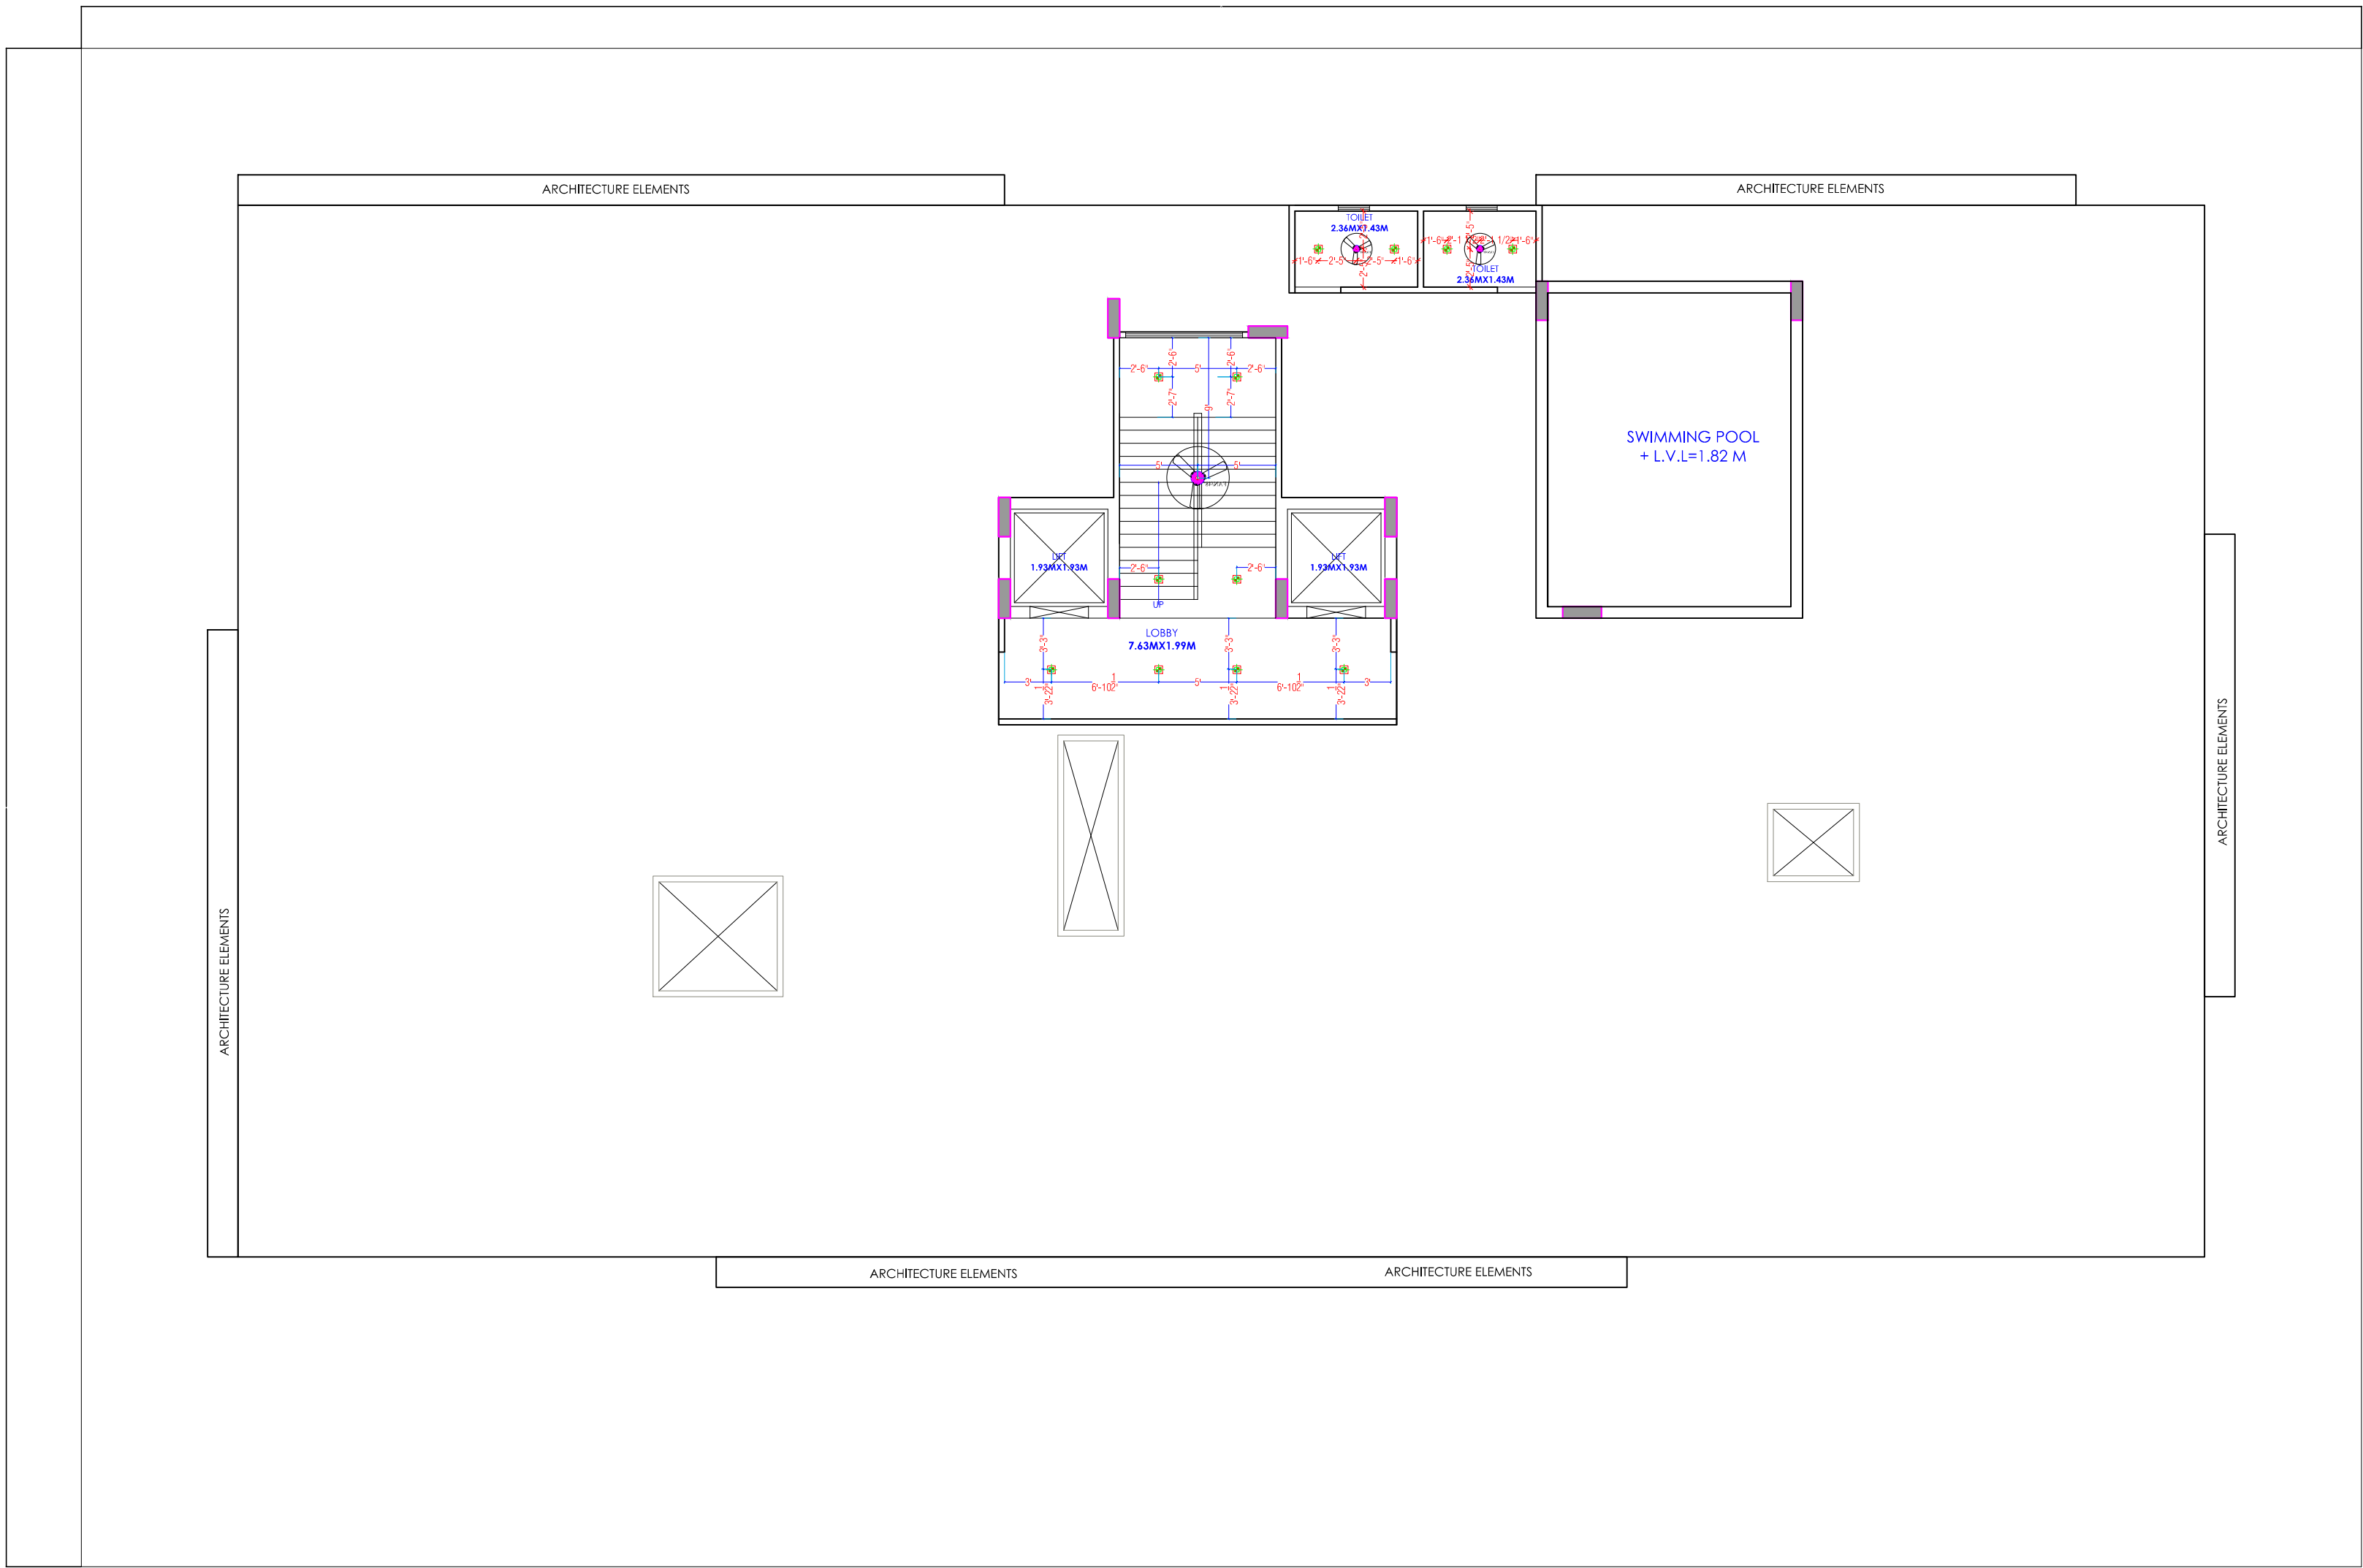

Y
-----ROAD 12 MT.WIDE-----


LEGENDS:			
Mounting Height	No.	Symbol	Description
IN FLOOR			CONTROL WIRING
IN CONDUIT			CONTROL WIRING
IN CONDUIT			AC CONTROL WIRING
IN CONDUIT			OTHER CONTROL WIRING
IN CONDUIT			FLUORESCENT CONTROL WIRING
CEILING	08	FAN/MP	CEILING FAN 40"
CEILING	07	FAN/MP	CEILING FAN 30"
+90"	04	TL	FLUORESCENT WALL LIGHT
+90"	04	BL/L	WALL BRACKETS AS DESIGN LIGHT
+90"	01	GL	WALL BRACKETS AS DESIGN FOR GATE LIGHT
	02	GL	WALL BRACKETS AS DESIGN FOR GATE LIGHT
CEILING	21	CTL	CTL CEILING LIGHT
+21"	02	FL	FOOT LIGHT
+48"	14	SB	SWITCH BOARD
+75"	03	ML	1 X 11 W CFL MIRROR LIGHT
VENTILATOR HT.	03	CR	CEILING ROSE
VENTILATOR HT.	03	EXP	1/2" DIA FRESH AIR FAN
+24"	02	TEL	TELEPHONE POINT
+27"	03	TV	TV CORDAL POINT
+24"	02	LP TEL	6 A PLUS POINT FOR TELEPHONE
+27"	03	LP TV	6 A PLUS POINT FOR TV
+24"	02	LP	6 A PLUS POINT
+27"	01	LP/CH	6 A PLUS POINT FOR CHIMNEY
+100"	03	SAC	1/2" DIA AC
+100"	03	PP-SAC	1/2" DIA POWER POINT FOR AC
+42"	01	PP-MET	1/2" DIA POWER POINT FOR MET
+78"	02	PP-G	1/2" DIA POWER POINT FOR GEYSER
+38"	01	PP-F	1/2" DIA POWER POINT FOR FRIDGE
+28"	01	PP-WP	1/2" DIA POWER POINT FOR WATER PURIFIER
+48"	01	PP-WM	1/2" DIA POWER POINT FOR WASHING MACHINE
+42"	02	BS	BELL PUSH SWITCH
+90"	01	BS	BELLZEEZ POINT
+24"	03	JAC	JAC STARTER
+90"	01	MCB DB	MCB DISTRIBUTION BOARD
	03	SB/L/L	SWITCH BOARD NO LIGHT CIRCUIT NO.
	03	AC/L	AC CIRCUIT NO.
	03		POWER CIRCUIT NO.


WARNING

1. This drawing is the sole copyright of Architects **VISTAAR** and should be used for the purpose expressly issued.

GENERAL NOTES

1. All dimensions are in feet and inches.
2. Do not scale this drawing follow written dimensions only.
3. This drawing should be read in conjunction with other architectural and structural drawings.
4. Any discrepancy in the drawing should be immediately brought to the notice of architect.

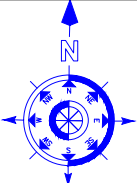PROJECT TITLE				
PROJECT:- SUNRISE WESTWAY HEIGHTS BUILDING AT PLOT NO.-32E & 32F.WESTWAY HEIGHTS(TRUCK TERMINAL),VILL.KESHOPURA,ASARPURA ,BHANKROTA,JAIPUR				
DRAWING TITLE				
TERRACE CEILING ELECTRICAL PLAN				
ARCHITECTS :				
VISTAAR ARCHITECTS & PLANNERS Architects :: Interior Designers B-2/12, Chitrkoot scheme, main Gandhi Path,Opp mall of jaipur,Jaipur PH.- 0141-4116461,09001010366				
DATE				
DRN.	DATE	REV.	NORTH	
SACHIN	02-08-2024			
SCALE		JOB NO.		
N.T.S				

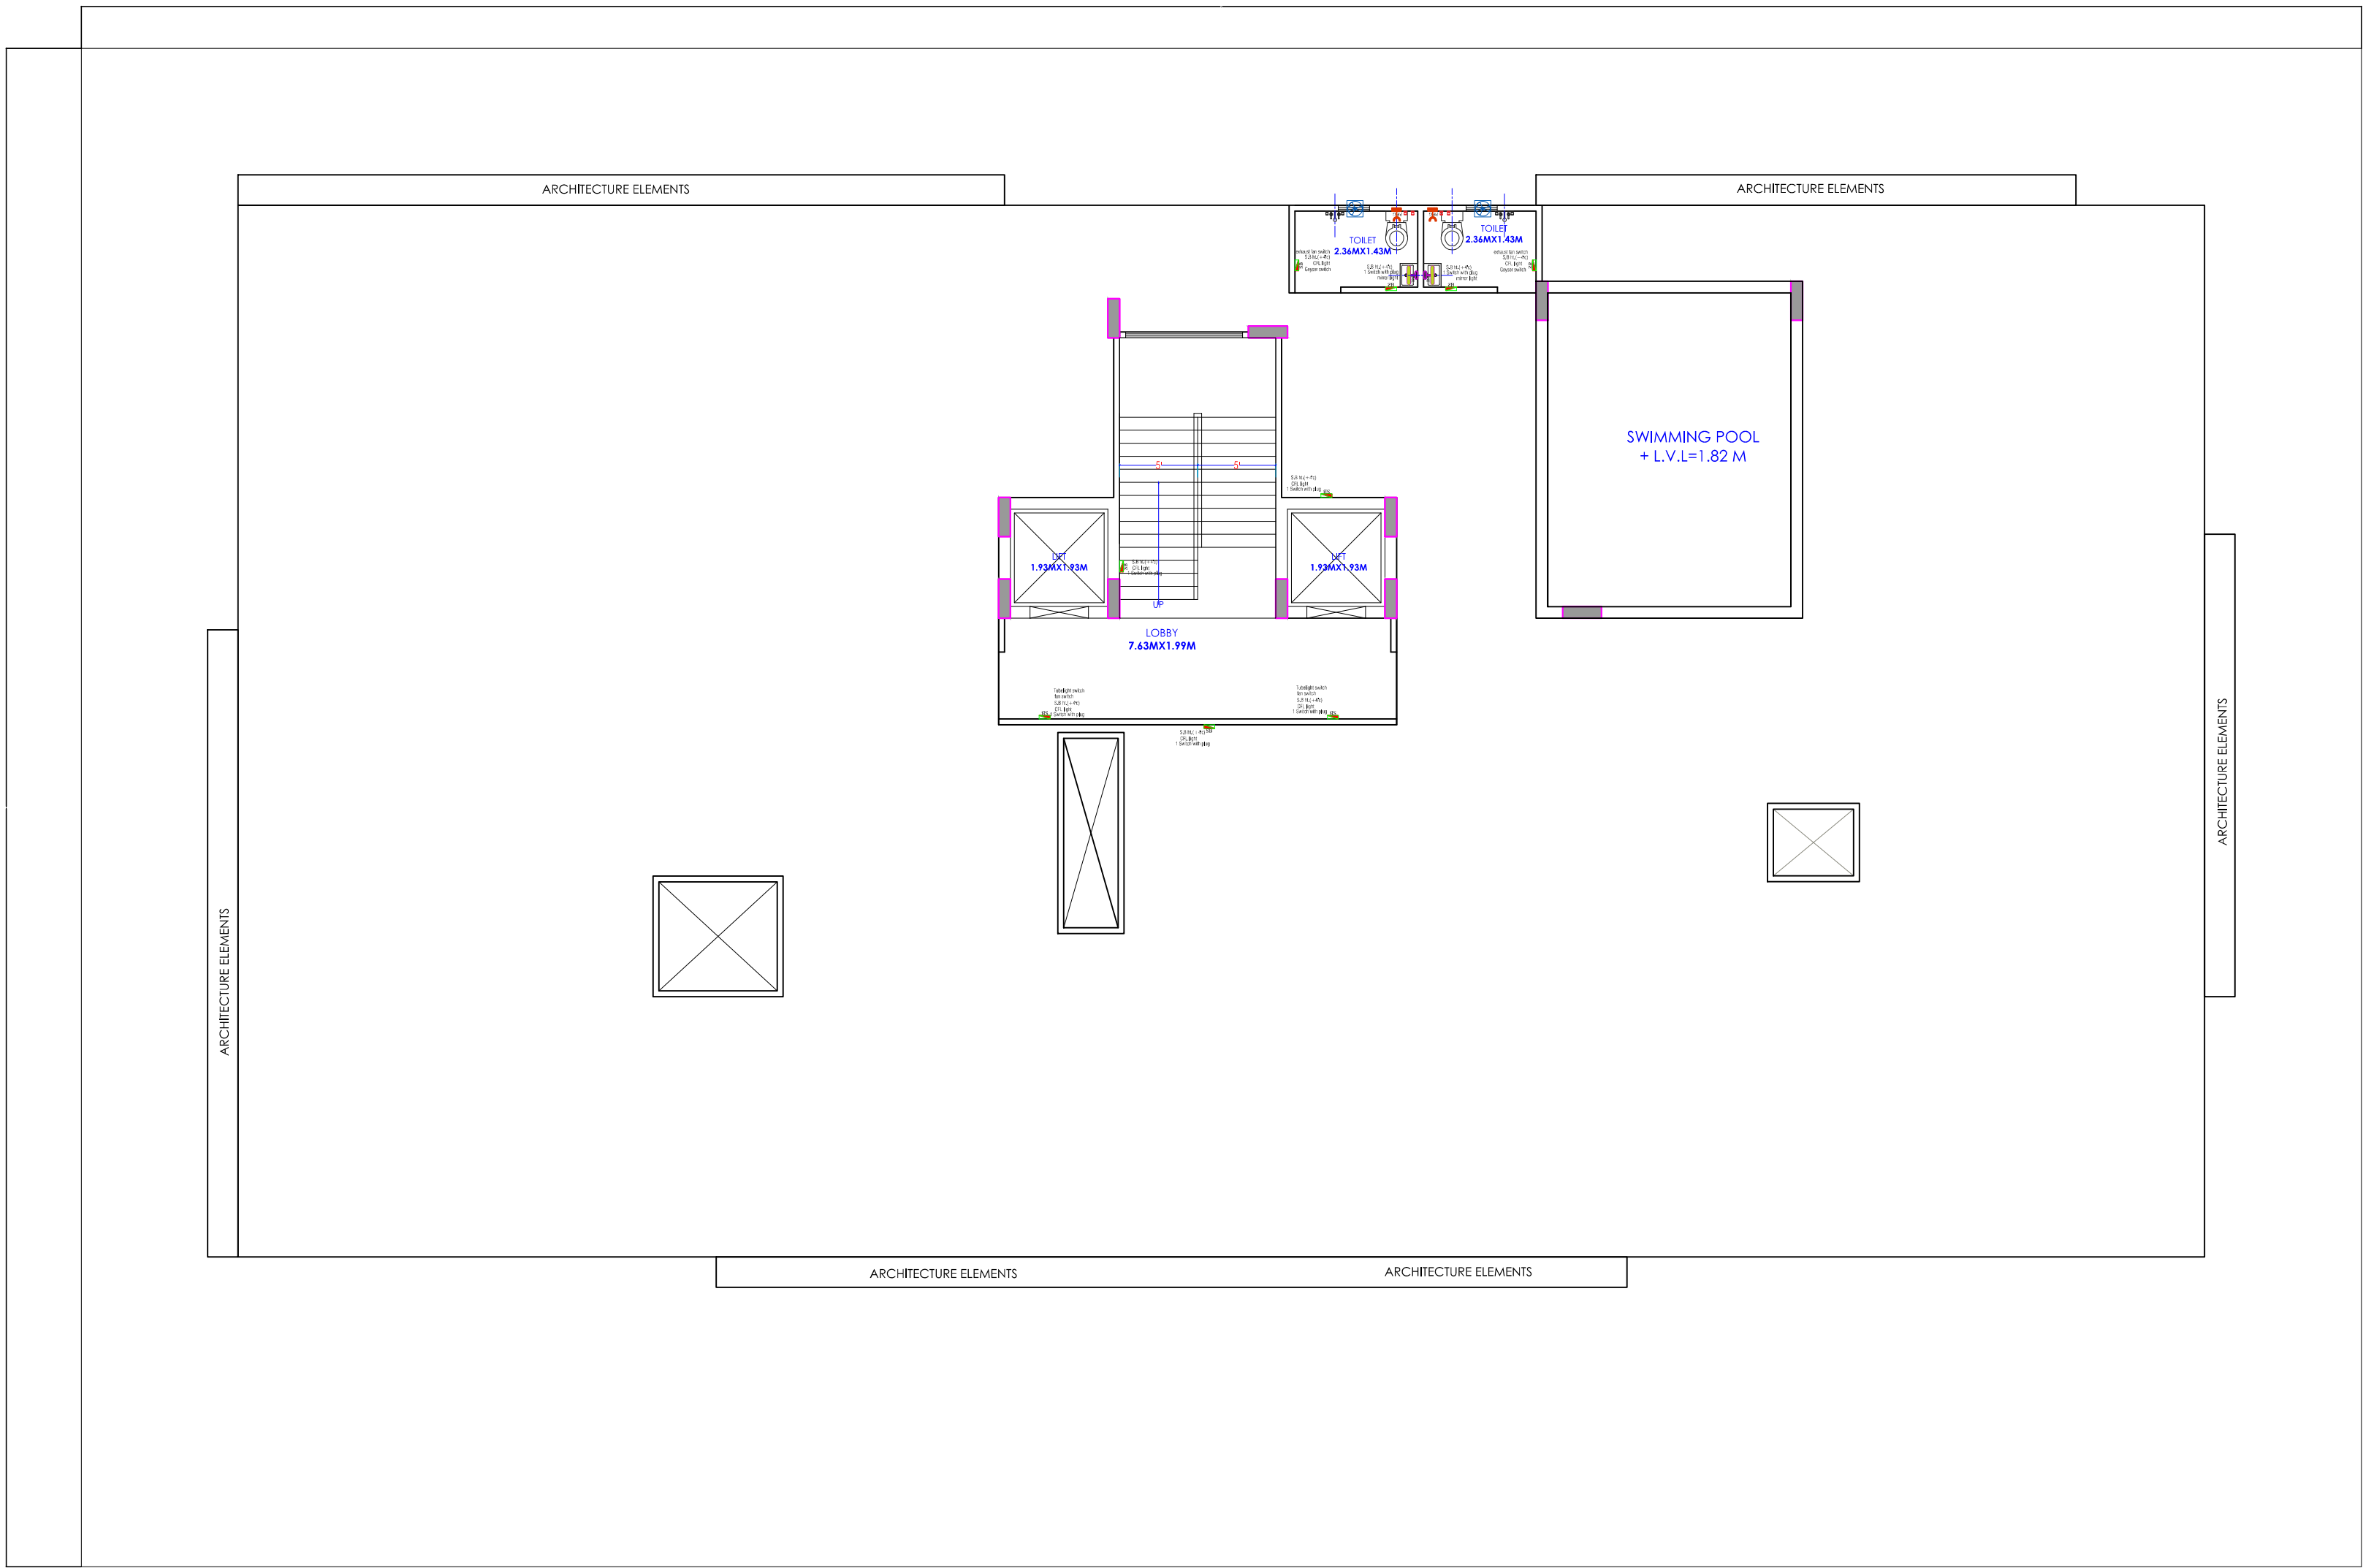

Y
-----ROAD 12 MT.WIDE-----

LEGENDS:			
Mounting Height	No.	Symbol	Description
IN FLOOR			CONTROL WIRING
IN CONDUIT			CONTROL WIRING
IN CONDUIT			AC CONTROL WIRING
IN CONDUIT			OTHER CONTROL WIRING
IN CONDUIT			BLUZZER CONTROL WIRING
CEILING	08	FAN/MP	CEILING FAN 40"
CEILING	07	FAN/MP	CEILING FAN 30"
+10"	04	TL	FLUOR WALL TUBELIGHT
+90"	04	BLER	WALL BRACKETS AS DESIGN LIGHT
+90"	01	GL	WALL BRACKETS AS DESIGN FOR GATEWAY LIGHT
	02	GL	WALL BRACKETS AS DESIGN FOR GATEWAY LIGHT
CEILING	21	CTL	CTL CEILING LIGHT
+21"	02	FL	FOOT LIGHT
+48"	14	SB	SWITCH BOARD
+70"	03	ML	1 X 11 W CFL MIRROR LIGHT
VENTILATOR HT	03	CR	CEILING ROSE
VENTILATOR HT	03	EXP	18" DIA FRESH AIR FAN
+24"	02	TEL	TELEPHONE POINT
+27"	03	TV	TV CORDIAL POINT
+24"	02	LP TEL	6 A PLUS POINT FOR TELEPHONE
+27"	03	LP TV	6 A PLUS POINT FOR TV
+24"	02	LP	6 A PLUS POINT
+27"	01	LP-CH	6 A PLUS POINT FOR CHIMNEY
+100"	03	SAC	100V AC
+100"	03	PP-SAC	15 A POWER POINT FOR 100V AC
+42"	01	PP-MIX	15 A POWER POINT FOR MIXER
+78"	02	PP-G	15 A POWER POINT FOR GEYSER
+38"	01	PP-F	15 A POWER POINT FOR FRIDGE
+28"	01	PP-WP	15 A POWER POINT FOR WASHING MACHINE
+48"	01	PP-WM	15 A POWER POINT FOR WASHING MACHINE
+42"	02	BP	BELL PUSH SWITCH
+90"	01	BL	BLUZZER POINT
+24"	03	JAC	AC STARTER
+90"	01	ACB DB	ACB DISTRIBUTION BOARD
	03	SB/L/L	SWITCH BOARD NO LIGHT CIRCUIT NO.
	03	AC/L/L	AC CIRCUIT NO.
	03		POWER CIRCUIT NO.

WARNING

1. This drawing is the sole copyright of Architects **VISTAAR** and should be used for the purpose expressly issued.

GENERAL NOTES

- All dimensions are in feet and inches.
- Do not scale this drawing follow written dimensions only.
- This drawing should be read in conjunction with other architectural and structural drawings.
- Any discrepancy in the drawing should be immediately brought to the notice of architect.

PROJECT TITLE
PROJECT:-
SUNRISE WESTWAY HEIGHTS
BUILDING AT PLOT NO.-32E & 32F WESTWAY
HEIGHTS (TRUCK TERMINAL), VILL. KESHOPURA, ASARPURA
, BHANKROTA, JAIPUR


DRAWING TITLE
TERRACE WALL ELECTRICAL PLAN

ARCHITECTS :
VISTAAR ARCHITECTS & PLANNERS
Architects :: Interior Designers
B-2/12, Chitrkoot scheme,
main Gandhi Path, Opp mall of jaipur, Jaipur
PH.- 0141-4116461, 09001010366

DATE		REV.		NORTH
DRN.	DATE	REV.		
ER,SACHN	02-08-2024			
SCALE	JOB NO.			
N.T.S				

For My Dream House
Partner

Unishree
KRISHNA KUMAR
B.Tech (Mechanical)
M.E.P Consultant

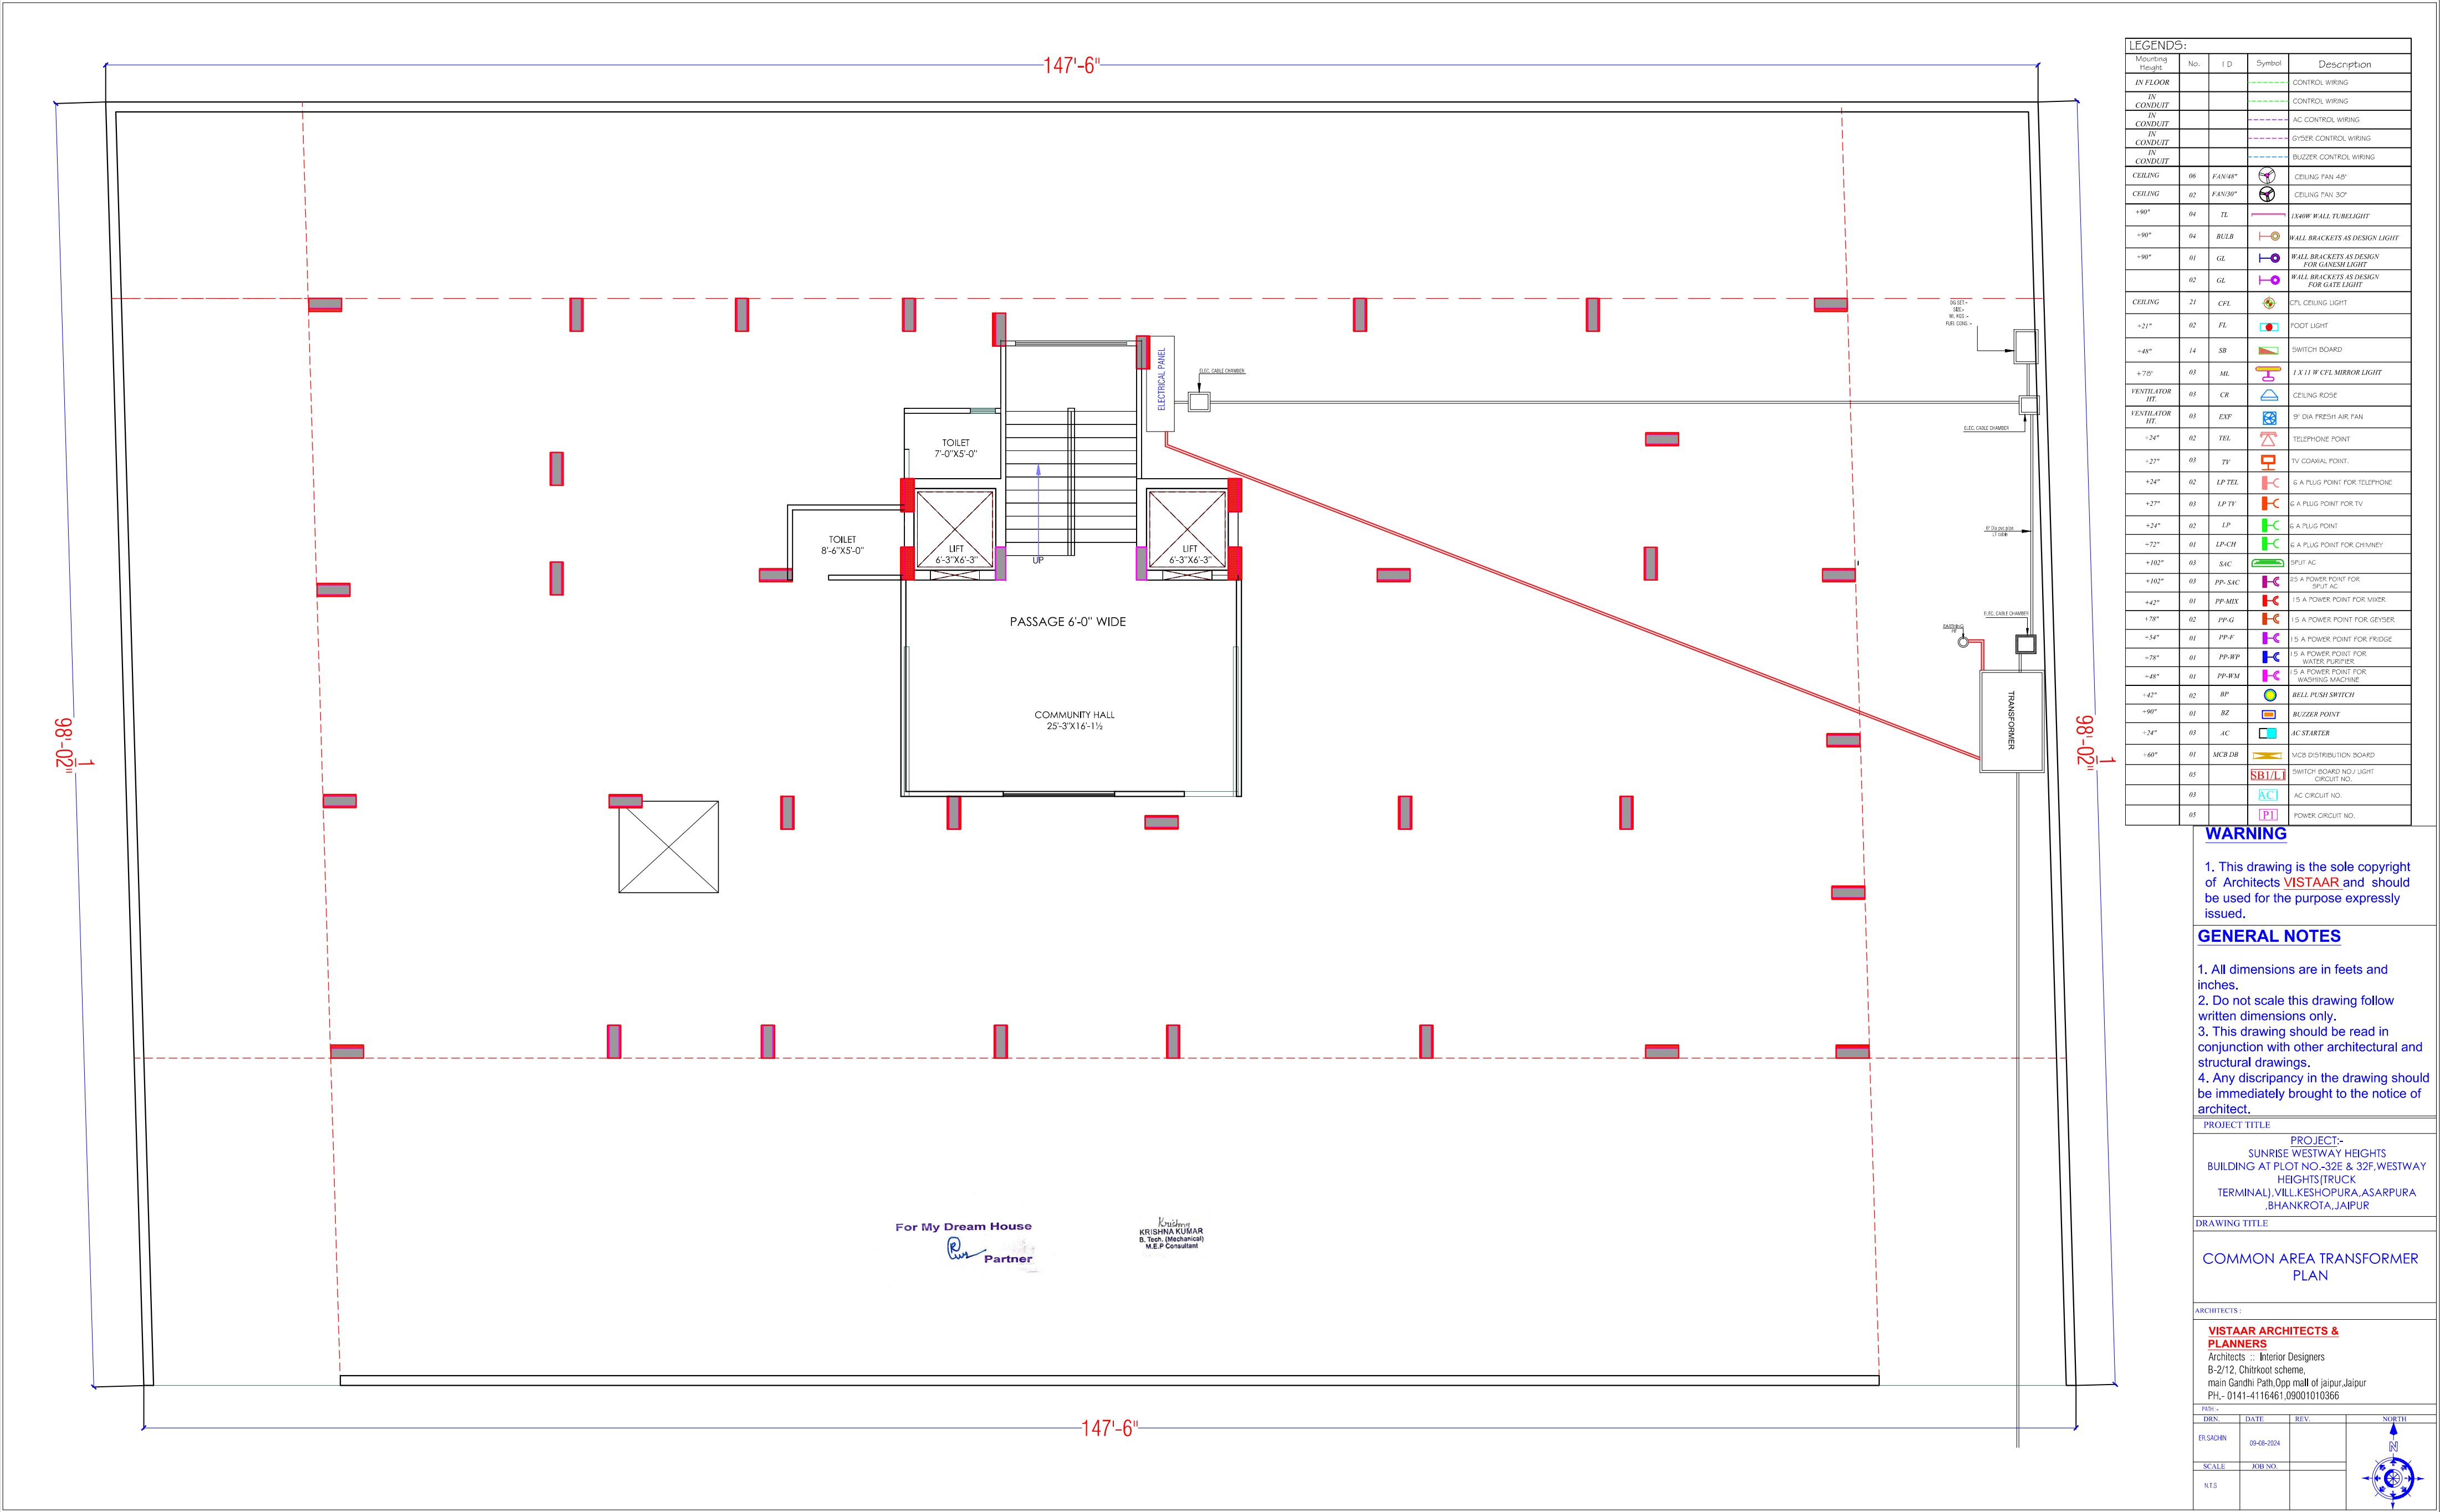

LEGENDS:				
Mounting Height	No.	I D	Symbol	Description
IN FLOOR				CONTROL WIRING
IN CONDUIT				CONTROL WIRING
IN CONDUIT				AC CONTROL WIRING
IN CONDUIT				GYSER CONTROL WIRING
IN CONDUIT				BUZZER CONTROL WIRING
CEILING	06	FAN/48"		CEILING FAN 48"
CEILING	02	FAN/30"		CEILING FAN 30"
+90"	04	TL		1X40W WALL TUBELIGHT
+90"	04	BULB		WALL BRACKETS AS DESIGN LIGHT
+90"	01	GL		WALL BRACKETS AS DESIGN FOR GANESH LIGHT
	02	GL		WALL BRACKETS AS DESIGN FOR GATE LIGHT
CEILING	21	CFL		CFL CEILING LIGHT
+21"	02	FL		FOOT LIGHT
+48"	14	SB		SWITCH BOARD
+70"	03	ML		1 X 11 W CFL MIRROR LIGHT
VENTILATOR HT.	03	CR		CEILING RIDGE
VENTILATOR HT.	03	EXF		9" DIA FRESH AIR FAN
+24"	02	TEL		TELEPHONE POINT
+27"	03	TV		TV COAXIAL POINT
+24"	02	LP TEL		6 A PLUG POINT FOR TELEPHONE
+27"	03	LP TV		6 A PLUG POINT FOR TV
+24"	02	LP		6 A PLUG POINT
+72"	01	LP-CH		6 A PLUG POINT FOR CHIMNEY
+102"	03	SAC		SPLIT AC
+102"	03	PP-SAC		25 A POWER POINT FOR SPLIT AC
+42"	01	PP-MIX		15 A POWER POINT FOR MIXER
+78"	02	PP-G		15 A POWER POINT FOR GEYSER
+54"	01	PP-F		15 A POWER POINT FOR FRIDGE
+78"	01	PP-WP		15 A POWER POINT FOR WATER PURIFIER
+48"	01	PP-WM		5 A POWER POINT FOR WASHING MACHINE
+42"	02	BP		BELL PUSH SWITCH
+90"	01	BZ		BUZZER POINT
+24"	03	AC		AC STARTER
+60"	01	MCB DB		MCB DISTRIBUTION BOARD
	03	SB/L		SWITCH BOARD NO J LIGHT CIRCUIT NO.
	03	AC		AC CIRCUIT NO.
	03	PI		POWER CIRCUIT NO.

WARNING

1. This drawing is the sole copyright of Architects VISTAAR and should be used for the purpose expressly issued.

GENERAL NOTES

- All dimensions are in feet and inches.
- Do not scale this drawing follow written dimensions only.
- This drawing should be read in conjunction with other architectural and structural drawings.
- Any discrepancy in the drawing should be immediately brought to the notice of architect.

PROJECT TITLE
PROJECT:-
SUNRISE WESTWAY HEIGHTS
BUILDING AT PLOT NO.-32E & 32F, WESTWAY
HEIGHTS (TRUCK
TERMINAL), VILL. KESHOPURA, ASARPURA
BHANKROTA, JAIPUR

DRAWING TITLE
COMMON AREA TRANSFORMER
PLAN

ARCHITECTS :
VISTAAR ARCHITECTS &
PLANNERS
Architects : Interior Designers
B-2/12, Chitrkoot scheme,
main Gandhi Path, Opp mall of jaipur, Jaipur
PH. - 0141-4116461, 09001010366

DRN.	DATE	REV.	NORTH
ER.SACHIN	09-08-2024		
SCALE	JOB NO.		
NTS			