


NOTE:-
THIS SLD HAS BEEN PREPARED AS PER CONCEPT STAGE DATA AVAILABLE WITH US. KINDLY CONTACT US FOR FINAL SLD & DETAILS BEFORE PLACING ORDER FOR FABRICATION. WE SHALL NOT BE RESPONSIBLE, IF THE PANELS ARE UNDER UTILISED OR OVER LOADED AT ANY STAGE.

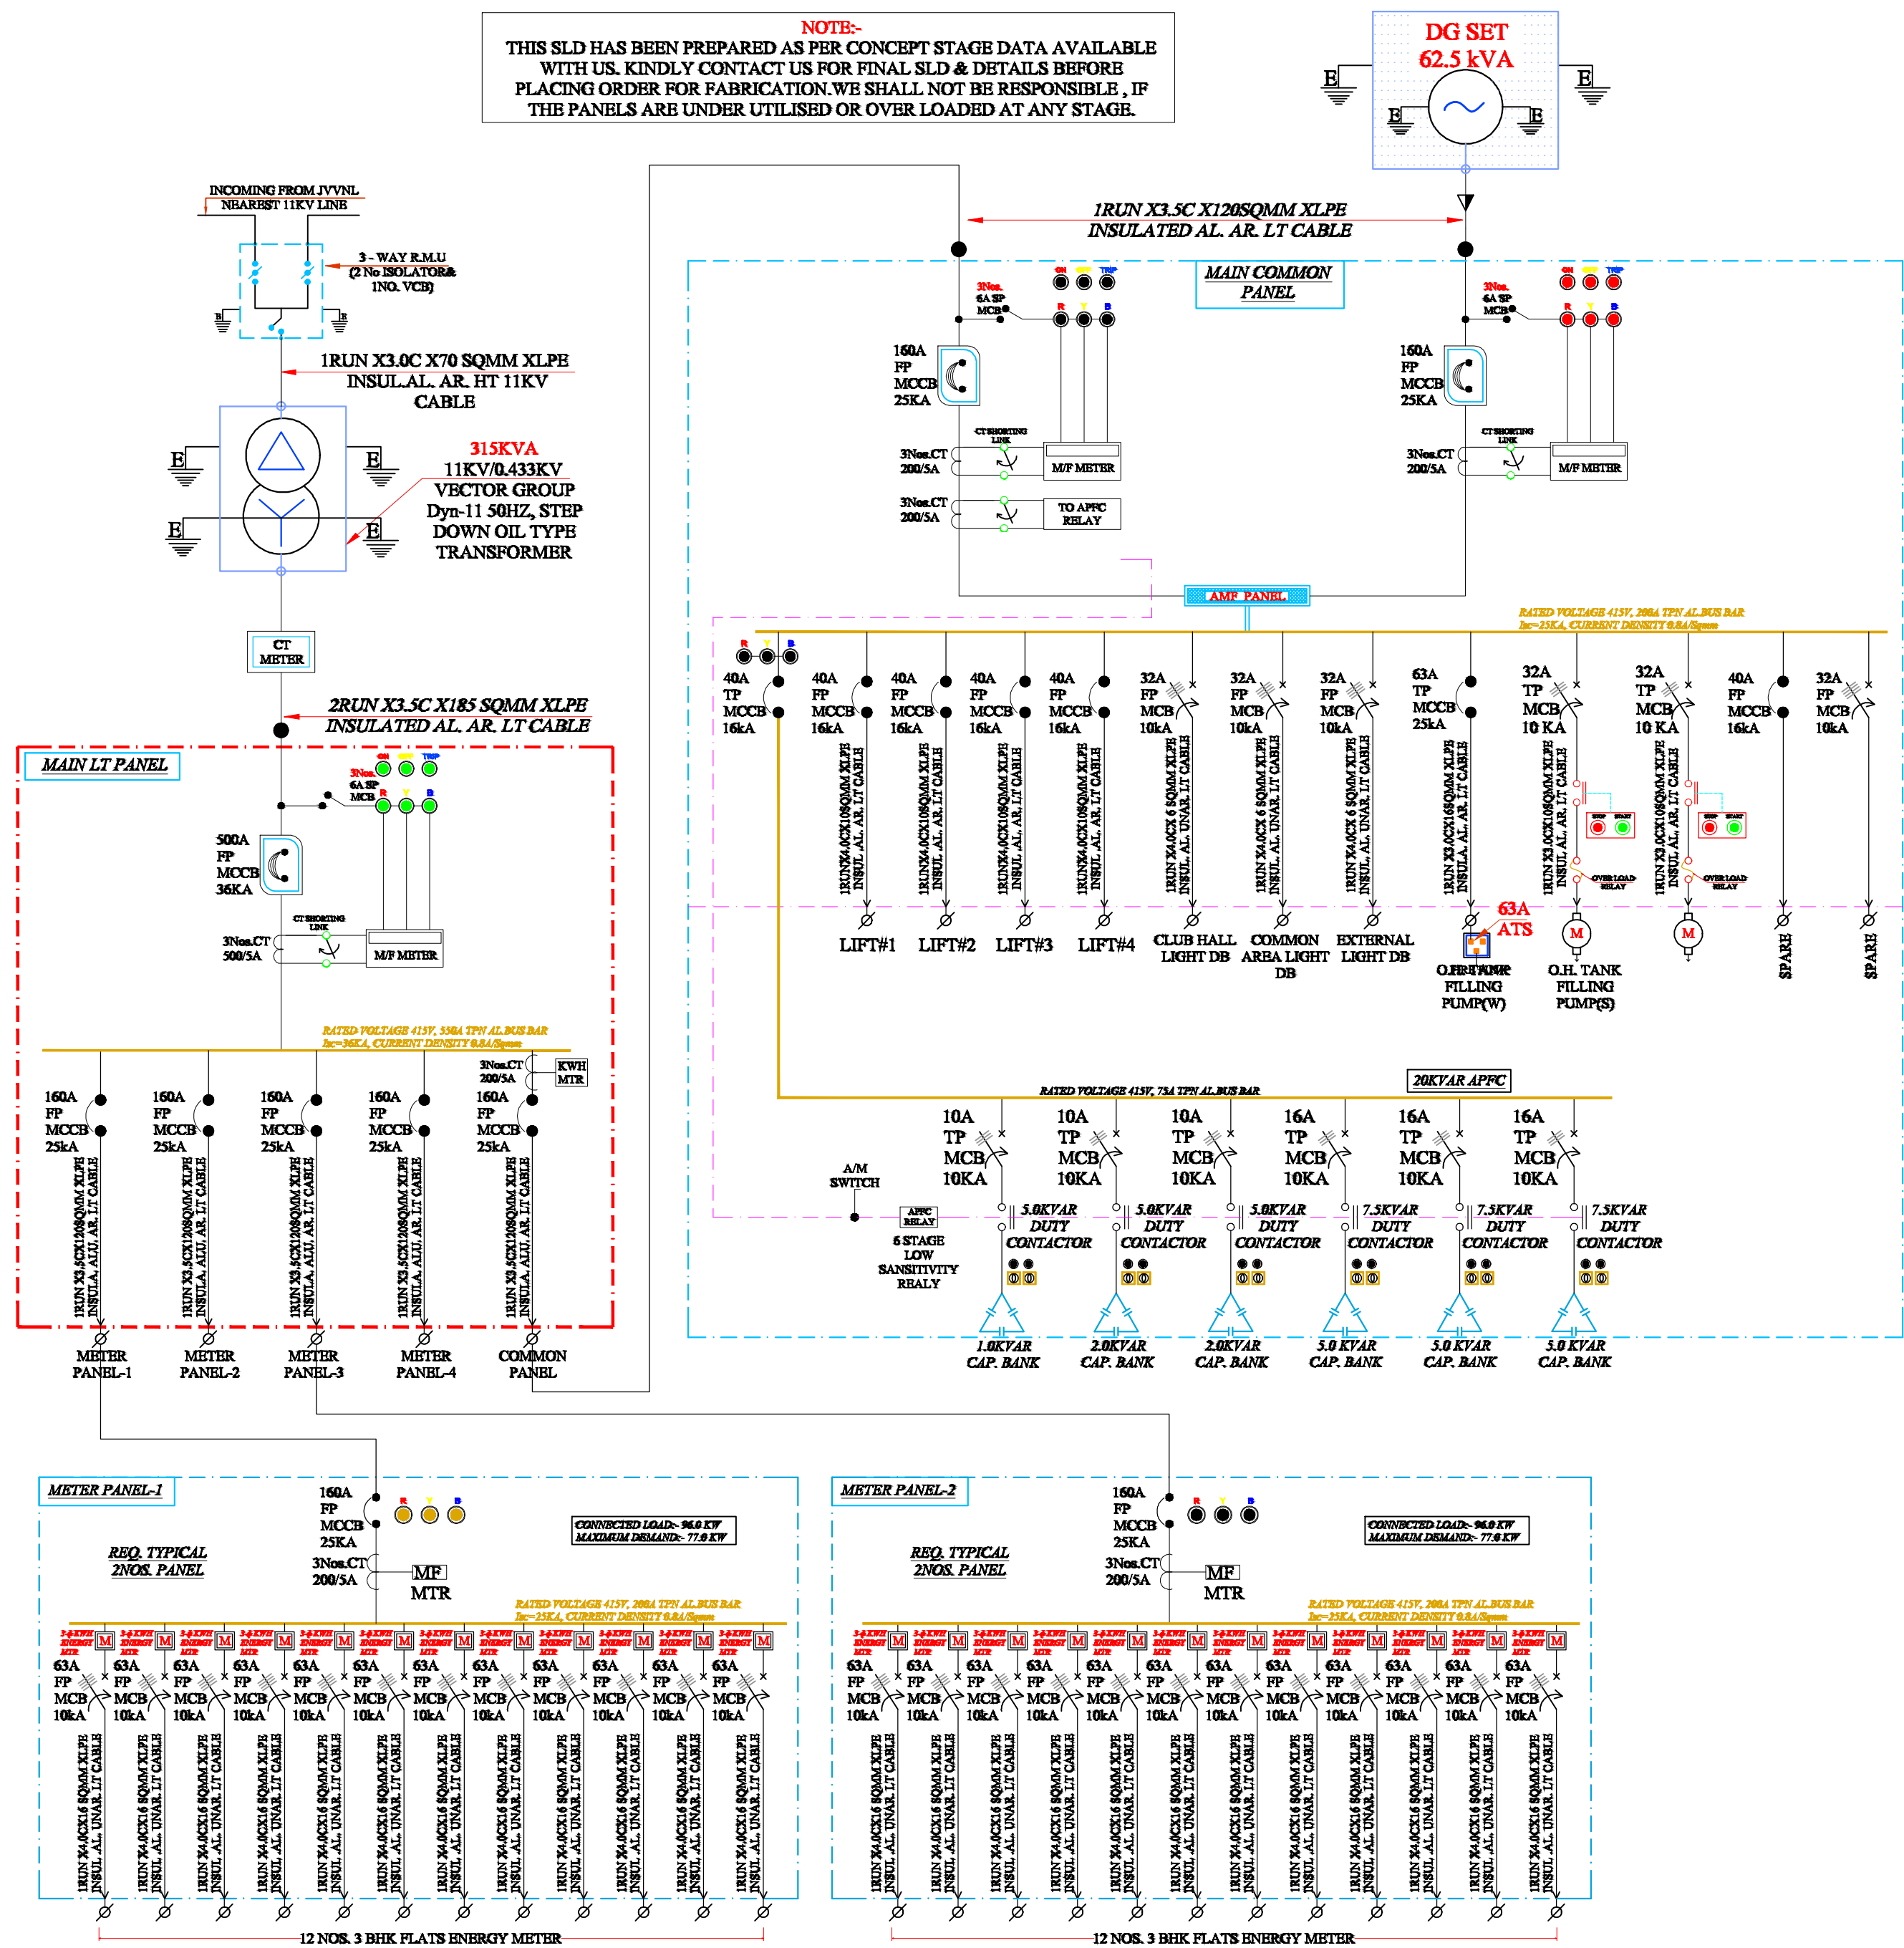

Krishna
KRISHNA KUMAR
B. Tech. (Mechanical)
M.E.P Consultant

For My Dream House
Partner

WARNING

1. This drawing is the sole copyright of Architects VISTAAR and should be used for the purpose expressly issued.

GENERAL NOTES

1. All dimensions are in feet and inches.
2. Do not scale this drawing follow written dimensions only.
3. This drawing should be read in conjunction with other architectural and structural drawings.
4. Any discrepancy in the drawing should be immediately brought to the notice of architect.

PROJECT TITLE

PROJECT:-
SUNRISE WESTWAY HEIGHTS
BUILDING AT PLOT NO.-32E &
32F, WESTWAY HEIGHTS (TRUCK
TERMINAL), VILL. KESHOPURA, ASARPURA
, BHANKROTA, JAIPUR

DRAWING TITLE

ALL DISTRIBUTION PANEL SINGLE LINE
DIAGRAM


ARCHITECTS :

VISTAAR ARCHITECTS & PLANNERS

Architects :: Interior Designers
B-2/12, Chitrkoot scheme,
main Gandhi Path, Opp mall of jaipur, Jaipur-21
Email-Vistaararchitects.web@gmail.com
PH.- 0141-4116461, 09001010366

PATH :-

DRN.	DATE	REV.	NORTH
SACHIN	26-07-2024		
SCALE	JOB NO.		
N.T.S			

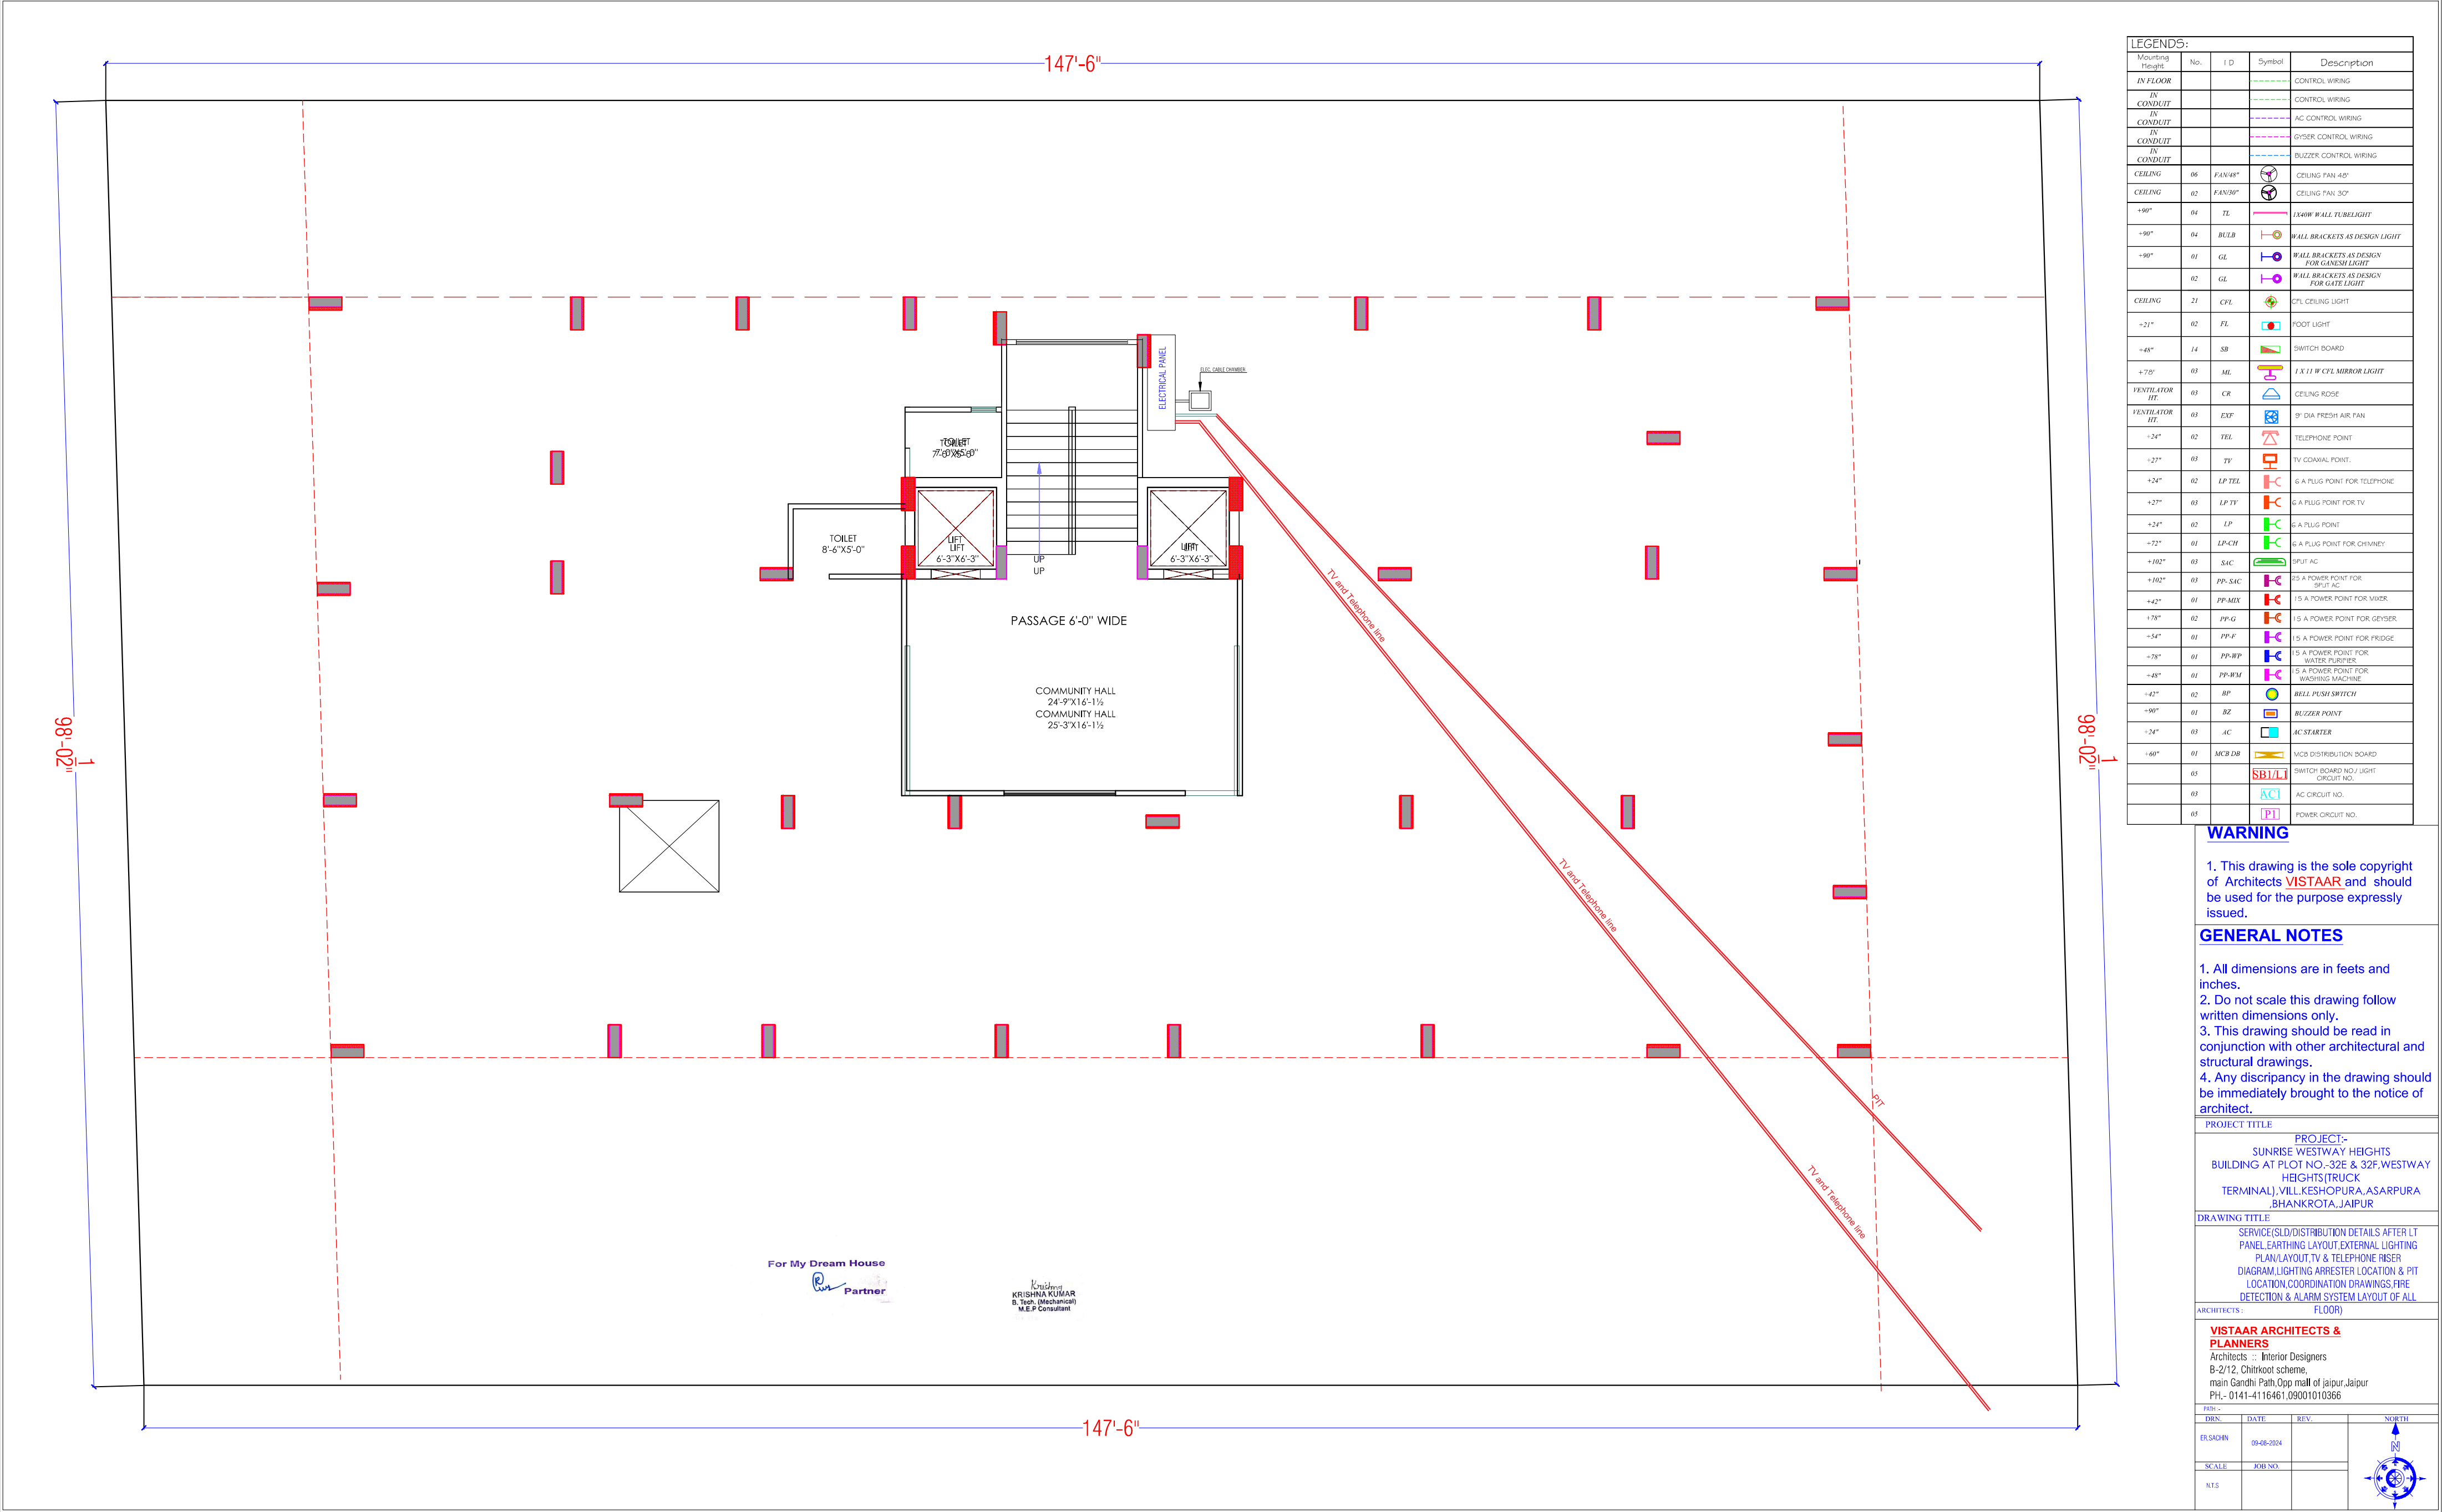

LEGENDS:				
Mounting Height	No.	I D	Symbol	Description
IN FLOOR				CONTROL WIRING
IN CONDUIT				CONTROL WIRING
IN CONDUIT				AC CONTROL WIRING
IN CONDUIT				GYSER CONTROL WIRING
IN CONDUIT				BUZZER CONTROL WIRING
CEILING	06	FAN/48"		CEILING FAN 48"
CEILING	02	FAN/30"		CEILING FAN 30"
+90"	04	TL		1X40W WALL TUBELIGHT
+90"	04	BULB		WALL BRACKETS AS DESIGN LIGHT
+90"	01	GL		WALL BRACKETS AS DESIGN FOR GANESH LIGHT
	02	GL		WALL BRACKETS AS DESIGN FOR GATE LIGHT
CEILING	21	CFL		CFL CEILING LIGHT
+21"	02	FL		FOOT LIGHT
+48"	14	SB		SWITCH BOARD
+70"	03	ML		1 X 11 W CFL MIRROR LIGHT
VENTILATOR HT.	03	CR		CEILING RIDGE
VENTILATOR HT.	03	EXF		9" DIA FRESH AIR FAN
+24"	02	TEL		TELEPHONE POINT
+27"	03	TV		TV COAXIAL POINT
+24"	02	LP TEL		6 A PLUG POINT FOR TELEPHONE
+27"	03	LP TV		6 A PLUG POINT FOR TV
+24"	02	LP		6 A PLUG POINT
+72"	01	LP-CH		6 A PLUG POINT FOR CHIMNEY
+102"	03	SAC		SPLIT AC
+102"	03	PP-SAC		25 A POWER POINT FOR SPLIT AC
+42"	01	PP-MIX		15 A POWER POINT FOR MIXER
+78"	02	PP-G		15 A POWER POINT FOR GEYSER
+54"	01	PP-F		15 A POWER POINT FOR FRIDGE
+78"	01	PP-WP		15 A POWER POINT FOR WATER PURIFIER
+48"	01	PP-WM		5 A POWER POINT FOR WASHING MACHINE
+42"	02	BP		BELL PUSH SWITCH
+90"	01	BZ		BUZZER POINT
+24"	03	AC		AC STARTER
+60"	01	MCB DB		MCB DISTRIBUTION BOARD
	03	SB/LT		SWITCH BOARD NO/LIGHT CIRCUIT NO.
	03	AC		AC CIRCUIT NO.
	03	PI		POWER CIRCUIT NO.

WARNING


1. This drawing is the sole copyright of Architects **VISTAAR** and should be used for the purpose expressly issued.

GENERAL NOTES

1. All dimensions are in feets and inches.
2. Do not scale this drawing follow written dimensions only.
3. This drawing should be read in conjunction with other architectural and structural drawings.
4. Any discrepancy in the drawing should be immediately brought to the notice of architect.

PROJECT TITLE	
PROJECT:- SUNRISE WESTWAY HEIGHTS BUILDING AT PLOT NO.-32E & 32F, WESTWAY HEIGHTS (TRUCK TERMINAL), VILL. KESHOPURA, ASARPURA BHANKROTA, JAIPUR	
DRAWING TITLE	
SERVICE (SLD) DISTRIBUTION DETAILS AFTER LT PANEL, EARTHING LAYOUT, EXTERNAL LIGHTING PLAN, LAYOUT, TV & TELEPHONE RISER DIAGRAM, LIGHTING ARRESTER LOCATION & PIT LOCATION, COORDINATION DRAWINGS, FIRE DETECTION & ALARM SYSTEM LAYOUT OF ALL FLOOR)	
ARCHITECTS :	
VISTAAR ARCHITECTS & PLANNERS Architects :- Interior Designers B-2/12, Chitrakoot scheme, main Gandhi Path, Opp mall of jaipur, Jaipur PH. - 0141-4116461, 09001010366	

DRN.	DATE	REV.	NORTH
ER.SACHIN	09-08-2024		
SCALE	JOB NO.		
NTS			

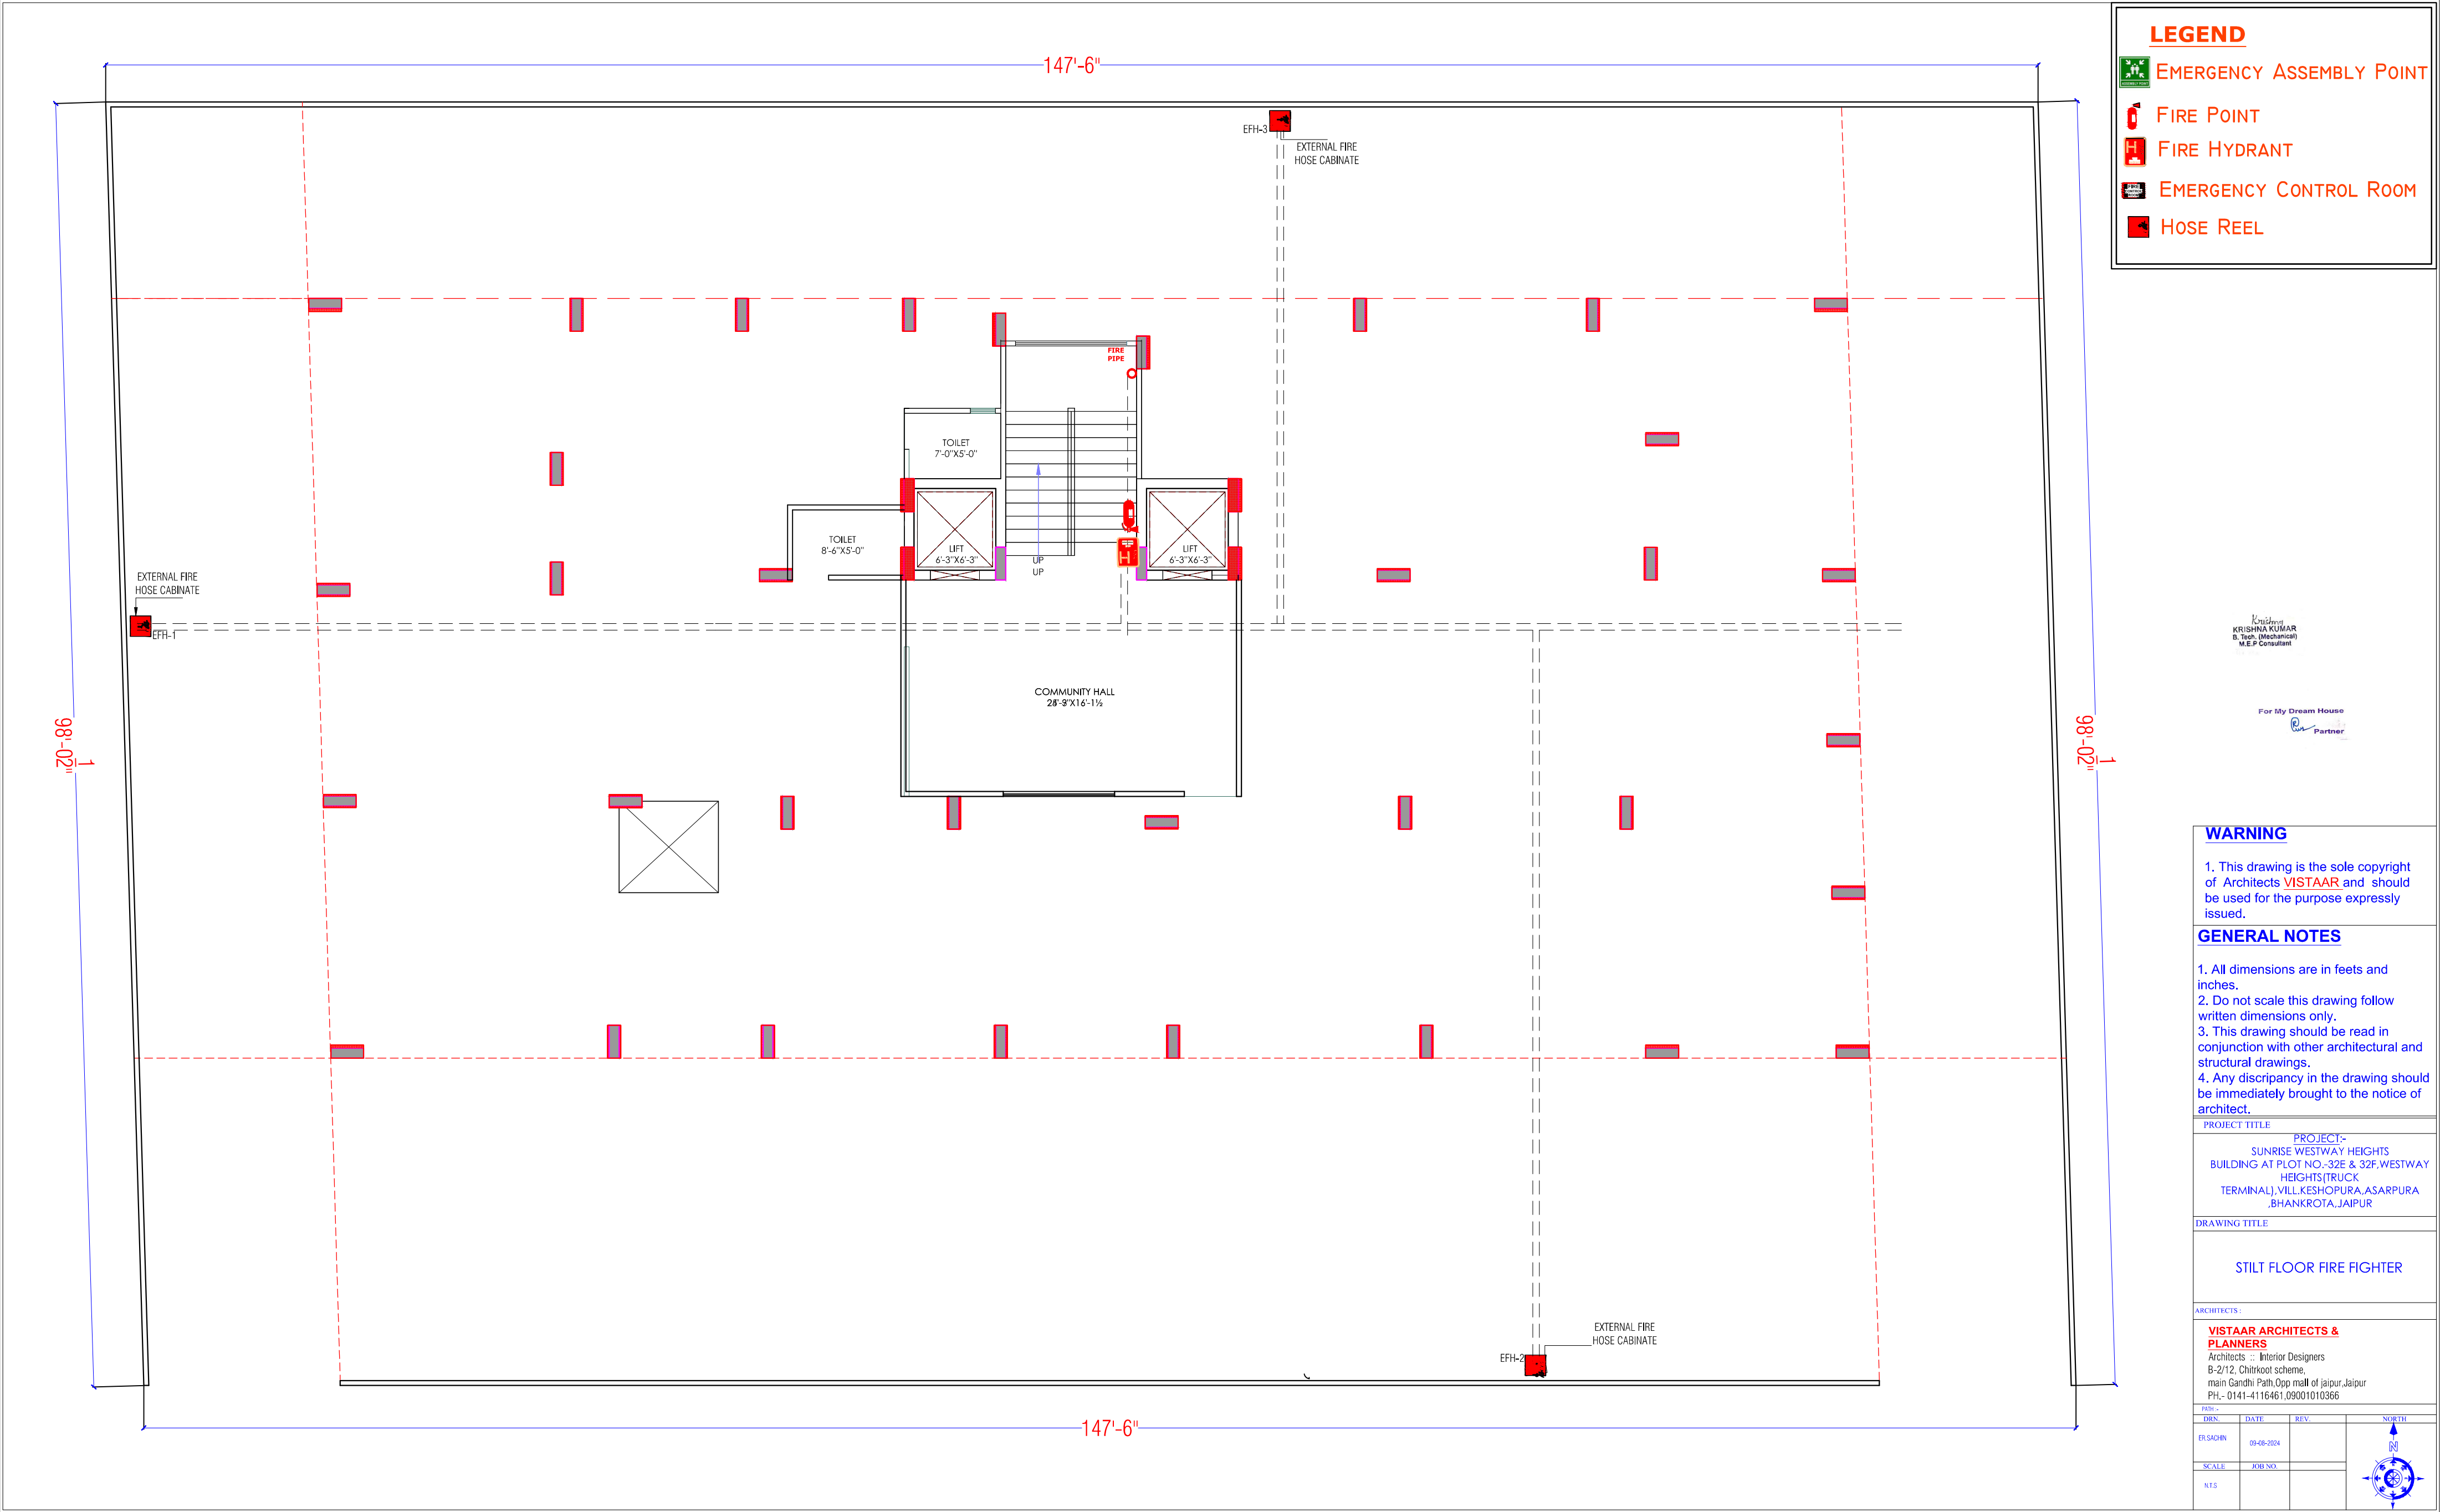

LEGEND

- EMERGENCY ASSEMBLY POINT
- FIRE POINT
- FIRE HYDRANT
- EMERGENCY CONTROL ROOM
- HOSE REEL

Krishna
KRISHNA KUMAR
B.Tech. (Mechanical)
M.E.P. Consultant

For My Dream House
Partner

WARNING

1. This drawing is the sole copyright of Architects **VISTAAR** and should be used for the purpose expressly issued.

GENERAL NOTES

1. All dimensions are in feet and inches.
2. Do not scale this drawing follow written dimensions only.
3. This drawing should be read in conjunction with other architectural and structural drawings.
4. Any discrepancy in the drawing should be immediately brought to the notice of architect.

PROJECT TITLE

PROJECT:-
SUNRISE WESTWAY HEIGHTS
BUILDING AT PLOT NO.-32E & 32F, WESTWAY
HEIGHTS (TRUCK
TERMINAL), VILL. KESHOPURA, ASARPURA
, BHANKROTA, JAIPUR


DRAWING TITLE

STILT FLOOR FIRE FIGHTER

ARCHITECTS :

VISTAAR ARCHITECTS & PLANNERS
Architects : Interior Designers
B-2/12, Chitrakoot scheme,
main Gandhi Path, Opp mall of jaipur, Jaipur
PH. - 0141-4116461, 09001010366

DRN.	DATE	REV.	NORTH
ER.SACHIN	09-08-2024		
SCALE	JOB NO.		
NTS			

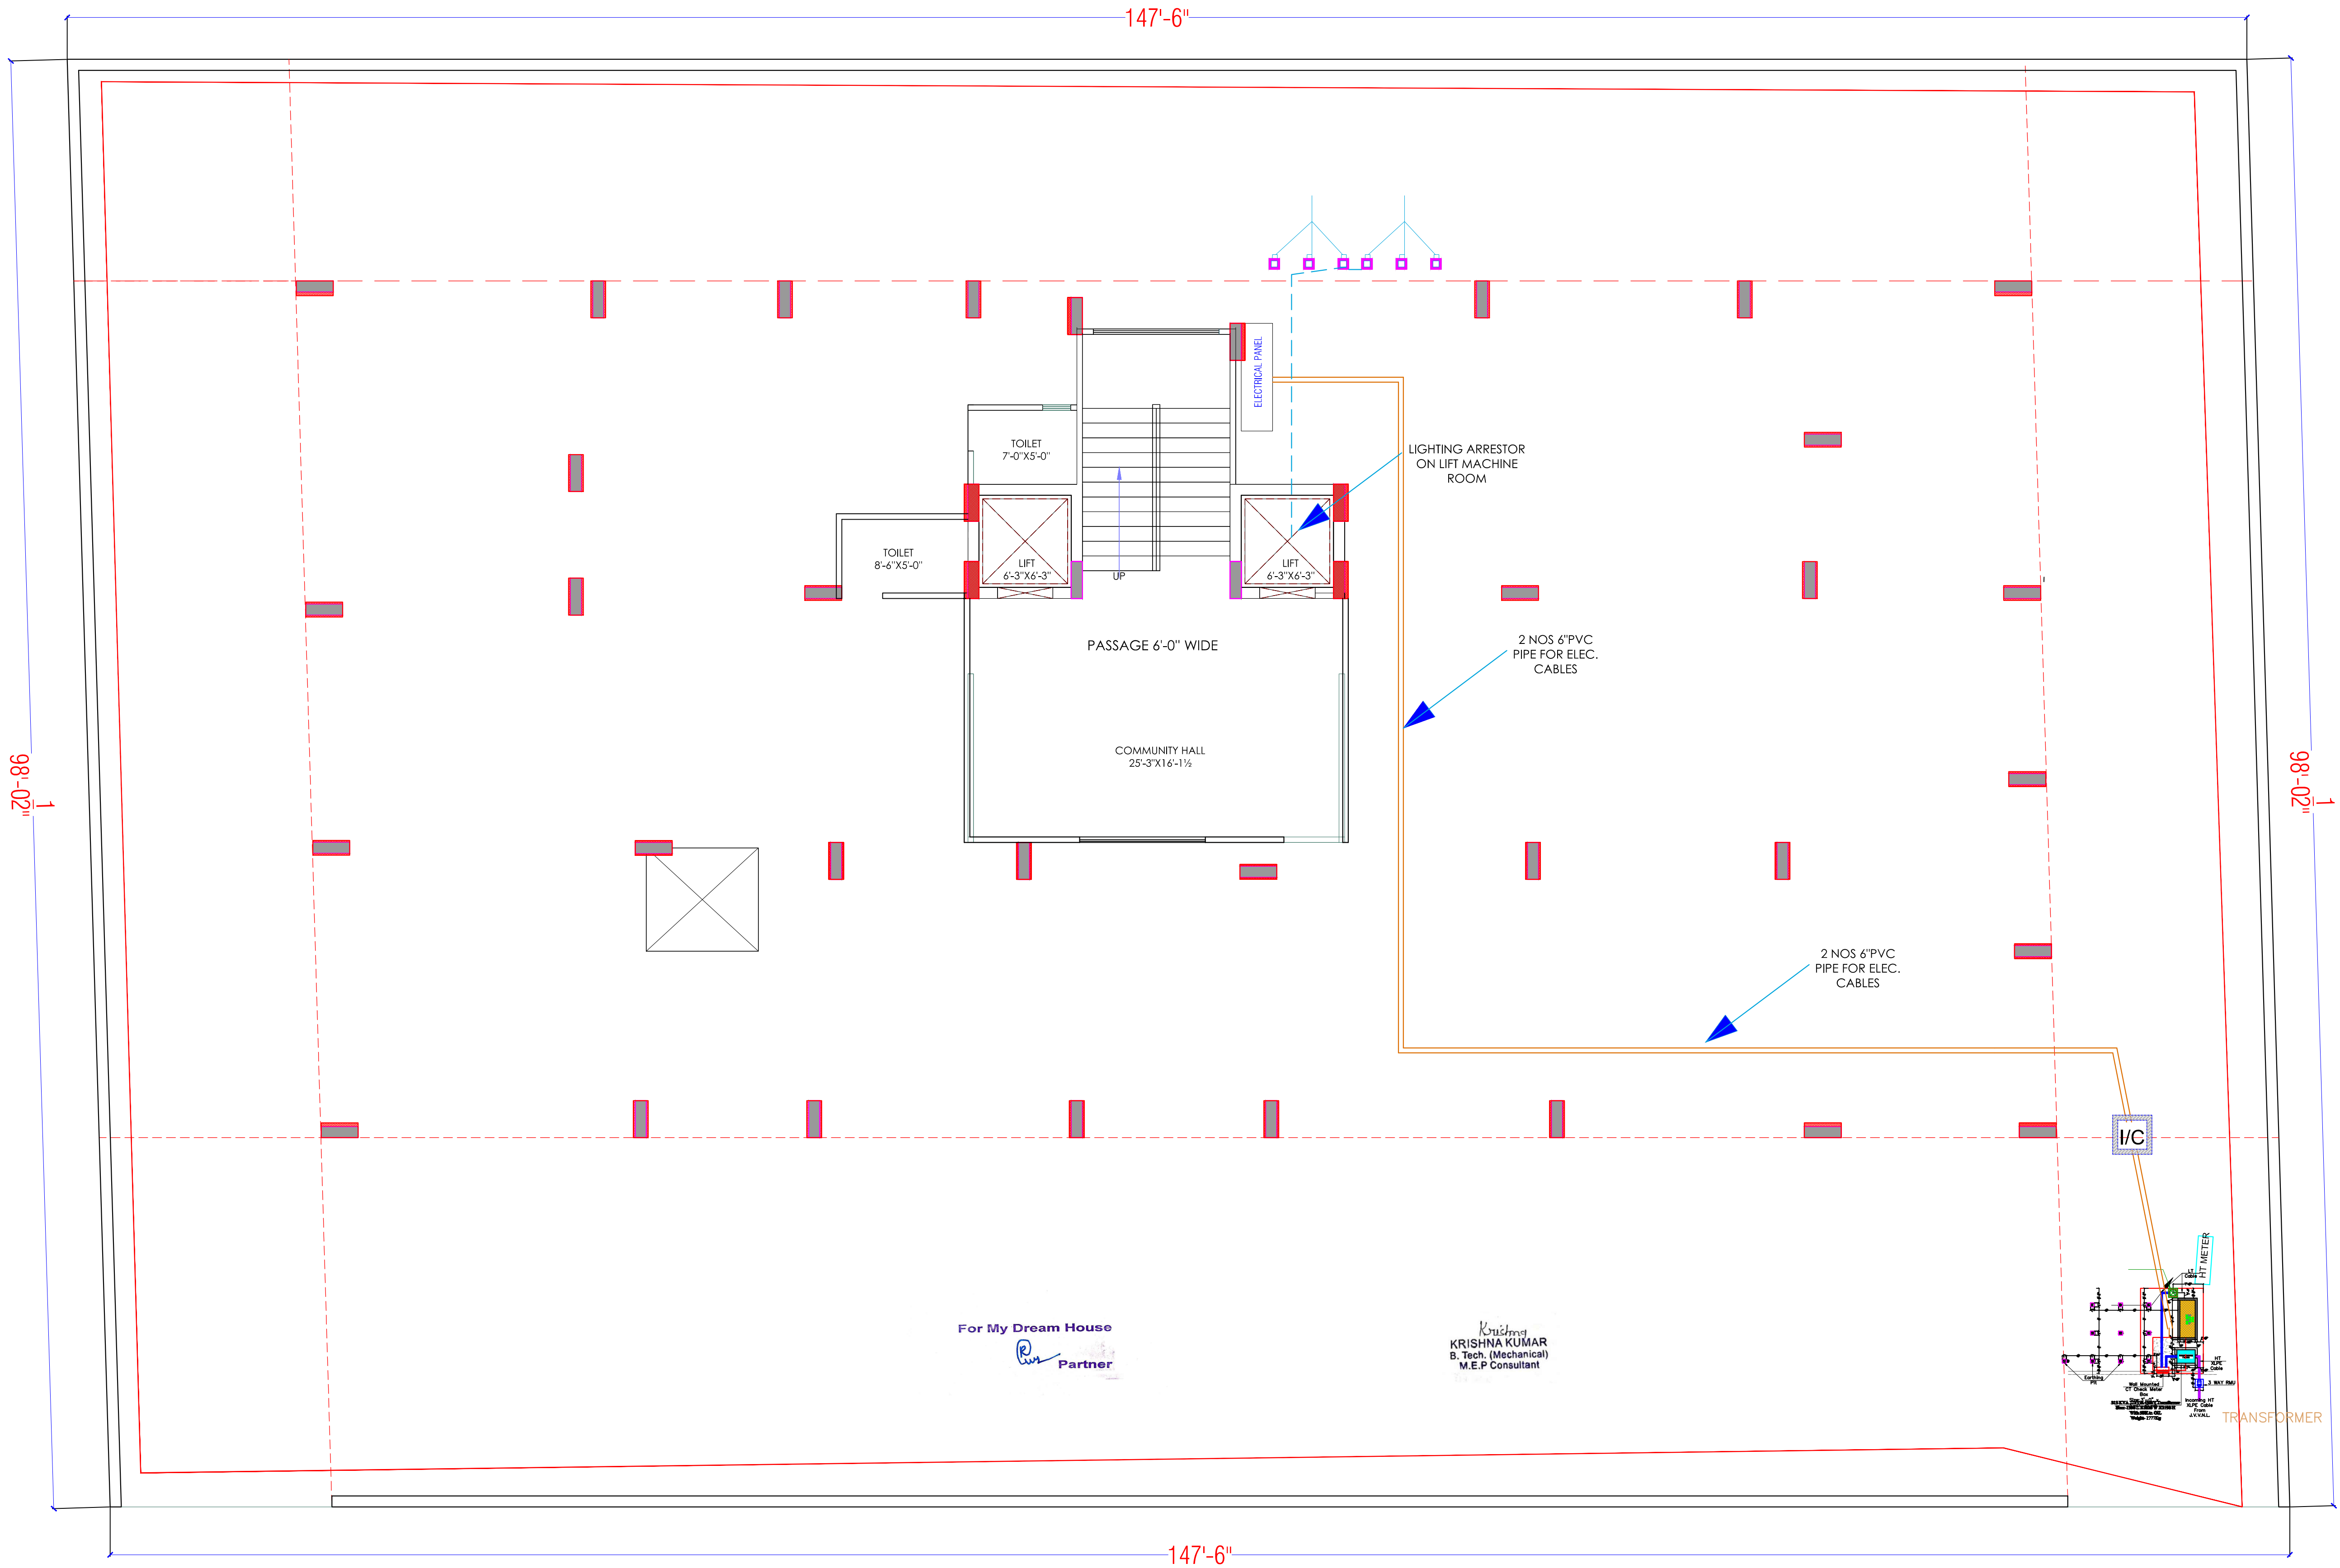

LEGENDS:				
Mounting Height	No.	I D	Symbol	Description
IN FLOOR				CONTROL WIRING
IN CONDUIT				CONTROL WIRING
IN CONDUIT				AC CONTROL WIRING
IN CONDUIT				GEYSER CONTROL WIRING
IN CONDUIT				BUZZER CONTROL WIRING
CEILING	06	FAN44"		CEILING FAN 44"
CEILING	02	FAN30"		CEILING FAN 30"
+90"	04	TL		1X40W WALL TUBELIGHT
+90"	04	BULB		WALL BRACKETS AS DESIGN LIGHT
+90"	01	GL		WALL BRACKETS AS DESIGN FOR GANESH LIGHT
	02	GL		WALL BRACKETS AS DESIGN FOR GATE LIGHT
CEILING	21	CFL		CFL CEILING LIGHT
+21"	02	FL		FOOT LIGHT
+48"	14	SB		SWITCH BOARD
+75"	03	ML		1 X 11" W CFL MIRROR LIGHT
VENTILATOR HT.	03	CR		CEILING ROSE
VENTILATOR HT.	03	EXP		9" DIA FRESH AIR FAN
+24"	02	TEL		TELEPHONE POINT
+27"	03	TV		TV COAXIAL POINT.
+24"	02	LP TEL		6 A PLUG POINT FOR TELEPHONE
+27"	03	LP TV		6 A PLUG POINT FOR TV
+24"	02	LP		6 A PLUG POINT
+72"	01	LP-CH		6 A PLUG POINT FOR CHIMNEY
+102"	03	SAC		3PH/1 AC
+102"	03	PP-SAC		25 A POWER POINT FOR 3PH/1 AC
+42"	01	PP-MIX		15 A POWER POINT FOR MIXER
+78"	02	PP-G		15 A POWER POINT FOR GEYSER
+54"	01	PP-F		15 A POWER POINT FOR FRIDGE
+78"	01	PP-WP		15 A POWER POINT FOR WATER PUMPER
+48"	01	PP-WM		15 A POWER POINT FOR WASHING MACHINE
+42"	02	BP		BELL PUSH SWITCH
+90"	01	BZ		BUZZER POINT
+24"	03	AC		AC STARTER
+60"	01	MCB DB		MCB DISTRIBUTION BOARD
	03		SBI/LI	SWITCH BOARD NO. / LIGHT CIRCUIT NO.
	03		ACI	AC CIRCUIT NO.
	03		PI	POWER CIRCUIT NO.

WARNING

1. This drawing is the sole copyright of Architects **VISTAAR** and should be used for the purpose expressly issued.

GENERAL NOTES

- All dimensions are in feet and inches.
- Do not scale this drawing follow written dimensions only.
- This drawing should be read in conjunction with other architectural and structural drawings.
- Any discrepancy in the drawing should be immediately brought to the notice of architect.

PROJECT TITLE

PROJECT:-
SUNRISE WESTWAY HEIGHTS
BUILDING AT PLOT NO.-32E & 32F, WESTWAY HEIGHTS (TRUCK
TERMINAL), VILL. KESHOPURA, ASARPURA
BHANKROTA, JAIPUR

DRAWING TITLE

PROPOSED STILT FLOOR ELECTRIC
SUB-STATION CABLE ROUTE & LIGHTING
AREESTER & EARTHING PLAN

ARCHITECTS :

VISTAAR ARCHITECTS & PLANNERS

Architects :: Interior Designers
B-212, Chitrakoot scheme,
main Gandhi Path Opp mall of jaipur, Jaipur
PH :- 0141-4116461, 09001010366

DRN	DATE	REV.	NORTH
ERSACHIN	09-08-2024		
SCALE	JOB NO.		
NTS			