


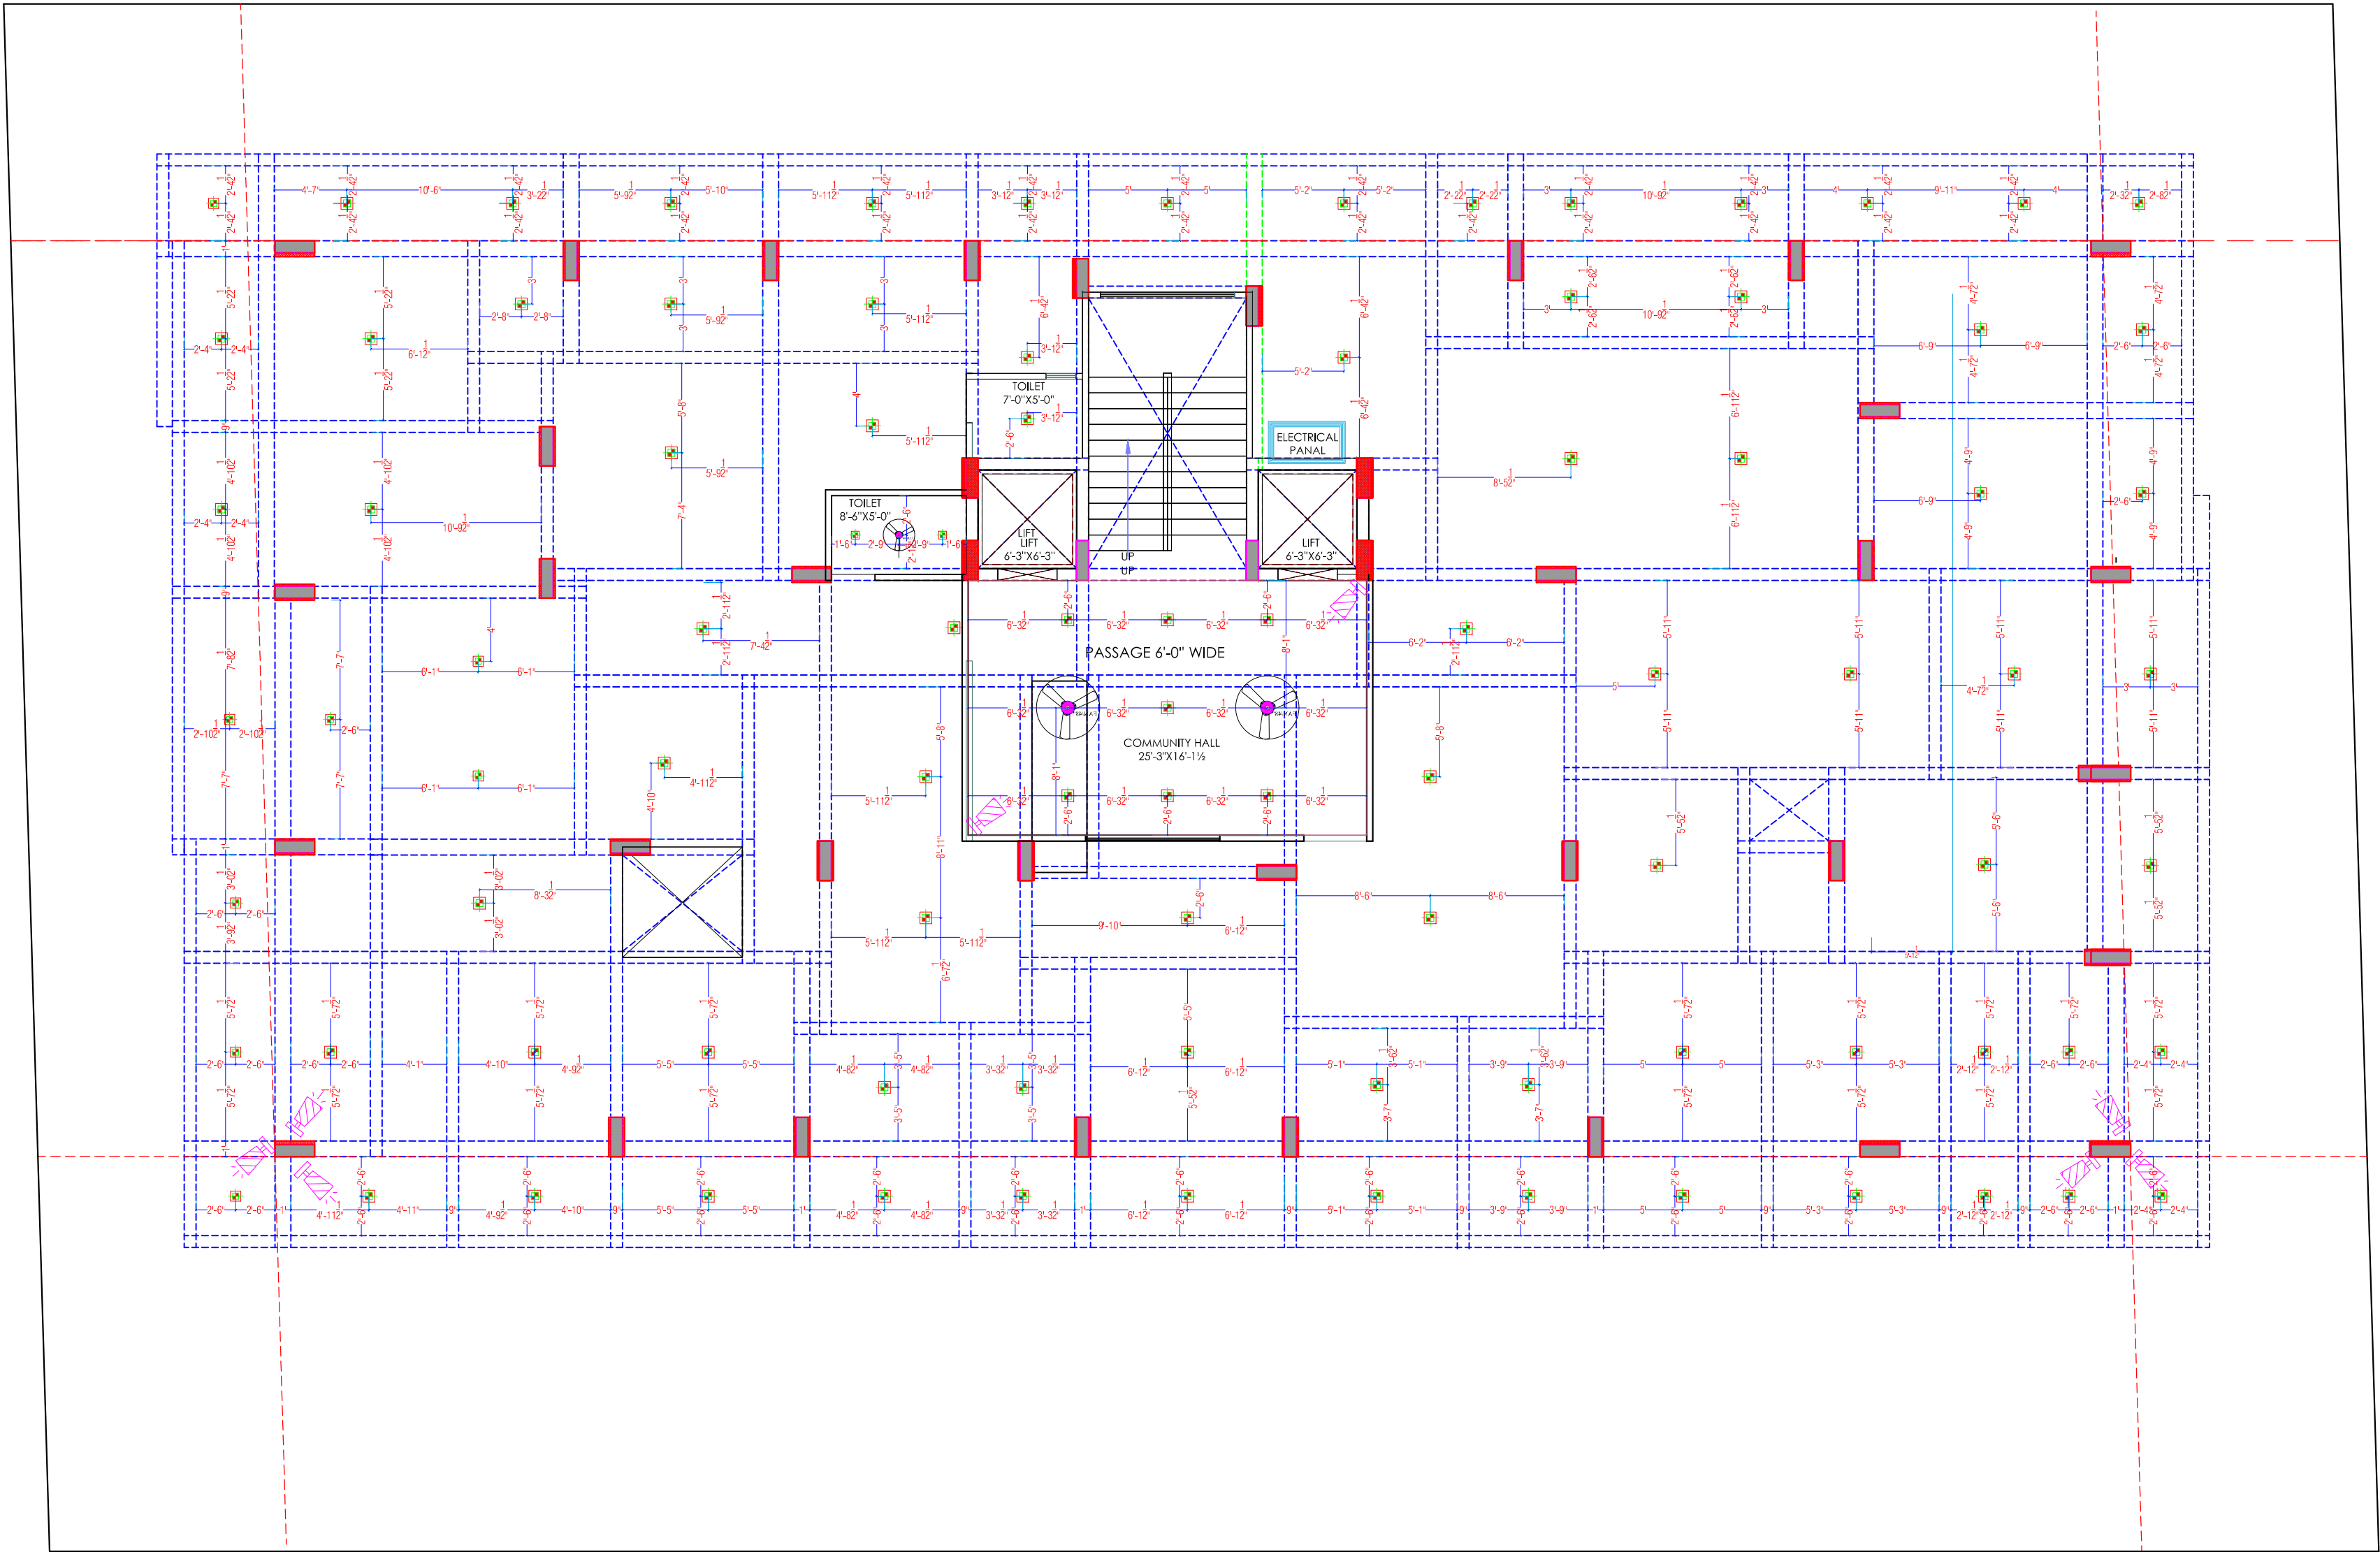

LEGENDS:				
Mounting Height	No.	I D	Symbol	Description
IN FLOOR			---	CONTROL WIRING
IN CONDUIT			---	CONTROL WIRING
IN CONDUIT			---	AC CONTROL WIRING
IN CONDUIT			---	CYCLER CONTROL WIRING
IN CONDUIT			---	BULZER CONTROL WIRING
CEILING	08	FAN-45"		CEILING FAN 45"
CEILING	02	FAN-30"		CEILING FAN 30"
+10"	04	TL		DOWN WALL TUBELIGHT
+10"	04	BULB		WALL BRACKETS AS DESIGN LIGHT
+10"	01	GL		WALL BRACKETS AS DESIGN FOR GLOSS LIGHT
02	GL			WALL BRACKETS AS DESIGN FOR GLOSS LIGHT
CEILING	21	CFL		CFL CEILING LIGHT
+21"	02	FL		FOOT LIGHT
+40"	14	SB		SWITCH BOARD
+70"	03	ML		1 X 11 W CFL MIRROR LIGHT
VENTILATOR BL	03	CR		CEILING ROSE
VENTILATOR BL	01	EXP		30 DIA FRESH AIR FAN
+24"	02	TEL		TELEPHONE POINT
+27"	03	TV		TV COMANL POINT
+34"	02	LP TEL		5 A PLUG POINT FOR TELEPHONE
+27"	03	LP TV		5 A PLUG POINT FOR TV
+24"	02	LP		5 A PLUG POINT
+72"	01	LP CH		5 A PLUG POINT FOR CHIMNEY
+102"	03	SAC		SPLIT AC
+102"	03	PP-SAC		25 A POWER POINT FOR SPLIT AC
+42"	01	PP-MIX		75 A POWER POINT FOR MIXER
+70"	02	PP-G		15 A POWER POINT FOR GEYSER
+54"	01	PP-F		5 A POWER POINT FOR FRIDGE
+78"	01	PP-WP		5 A POWER POINT FOR WATER PUMPING
+48"	01	PP-WM		5 A POWER POINT FOR WASHING MACHINE
+42"	02	BP		BELL PUSH SWITCH
+90"	01	BZ		BELLZ POINT
+24"	03	AC		AC STARTER
+40"	01	MCB DB		MCB DISTRIBUTION BOARD
03		SB 1.1		SWITCH BOARD NO.1 LIGHT CIRCUIT NO.
03		AC		AC CIRCUIT NO.
05		PL		POWER CIRCUIT NO.

WARNING

1. This drawing is the sole copyright of Architects **VISTAAR** and should be used for the purpose expressly issued.

GENERAL NOTES

- All dimensions are in feet and inches.
- Do not scale this drawing follow written dimensions only.
- This drawing should be read in conjunction with other architectural and structural drawings.
- Any discrepancy in the drawing should be immediately brought to the notice of architect.

PROJECT TITLE
PROJECT:-
SUNRISE WESTWAY HEIGHTS
BUILDING AT PLOT NO. 32E & 32F, WESTWAY
HEIGHTS (TRUCK
TERMINAL), VILL. KESHOPURA, ASARPURA
BHANKROTA, JAIPUR

DRAWING TITLE
STILT FLOOR CEILING ELECTRICAL
PLAN


ARCHITECTS :
VISTAAR ARCHITECTS & PLANNERS
Architects :: Interior Designers
B-2/12, Chitrkoot scheme,
main Gandhi Path, Opp mall of jaipur, Jaipur
PH. - 0141-4116461, 09001010366

DRN.	DATE	REV	NORTH
FR.SACHN	16-08-2024		
SCALE	JOB NO.		
NTS			

Krishna
KRISHNA KUMAR
B.Tech. (Mechanical)
M.E.P Consultant

For My Dream House

Partner

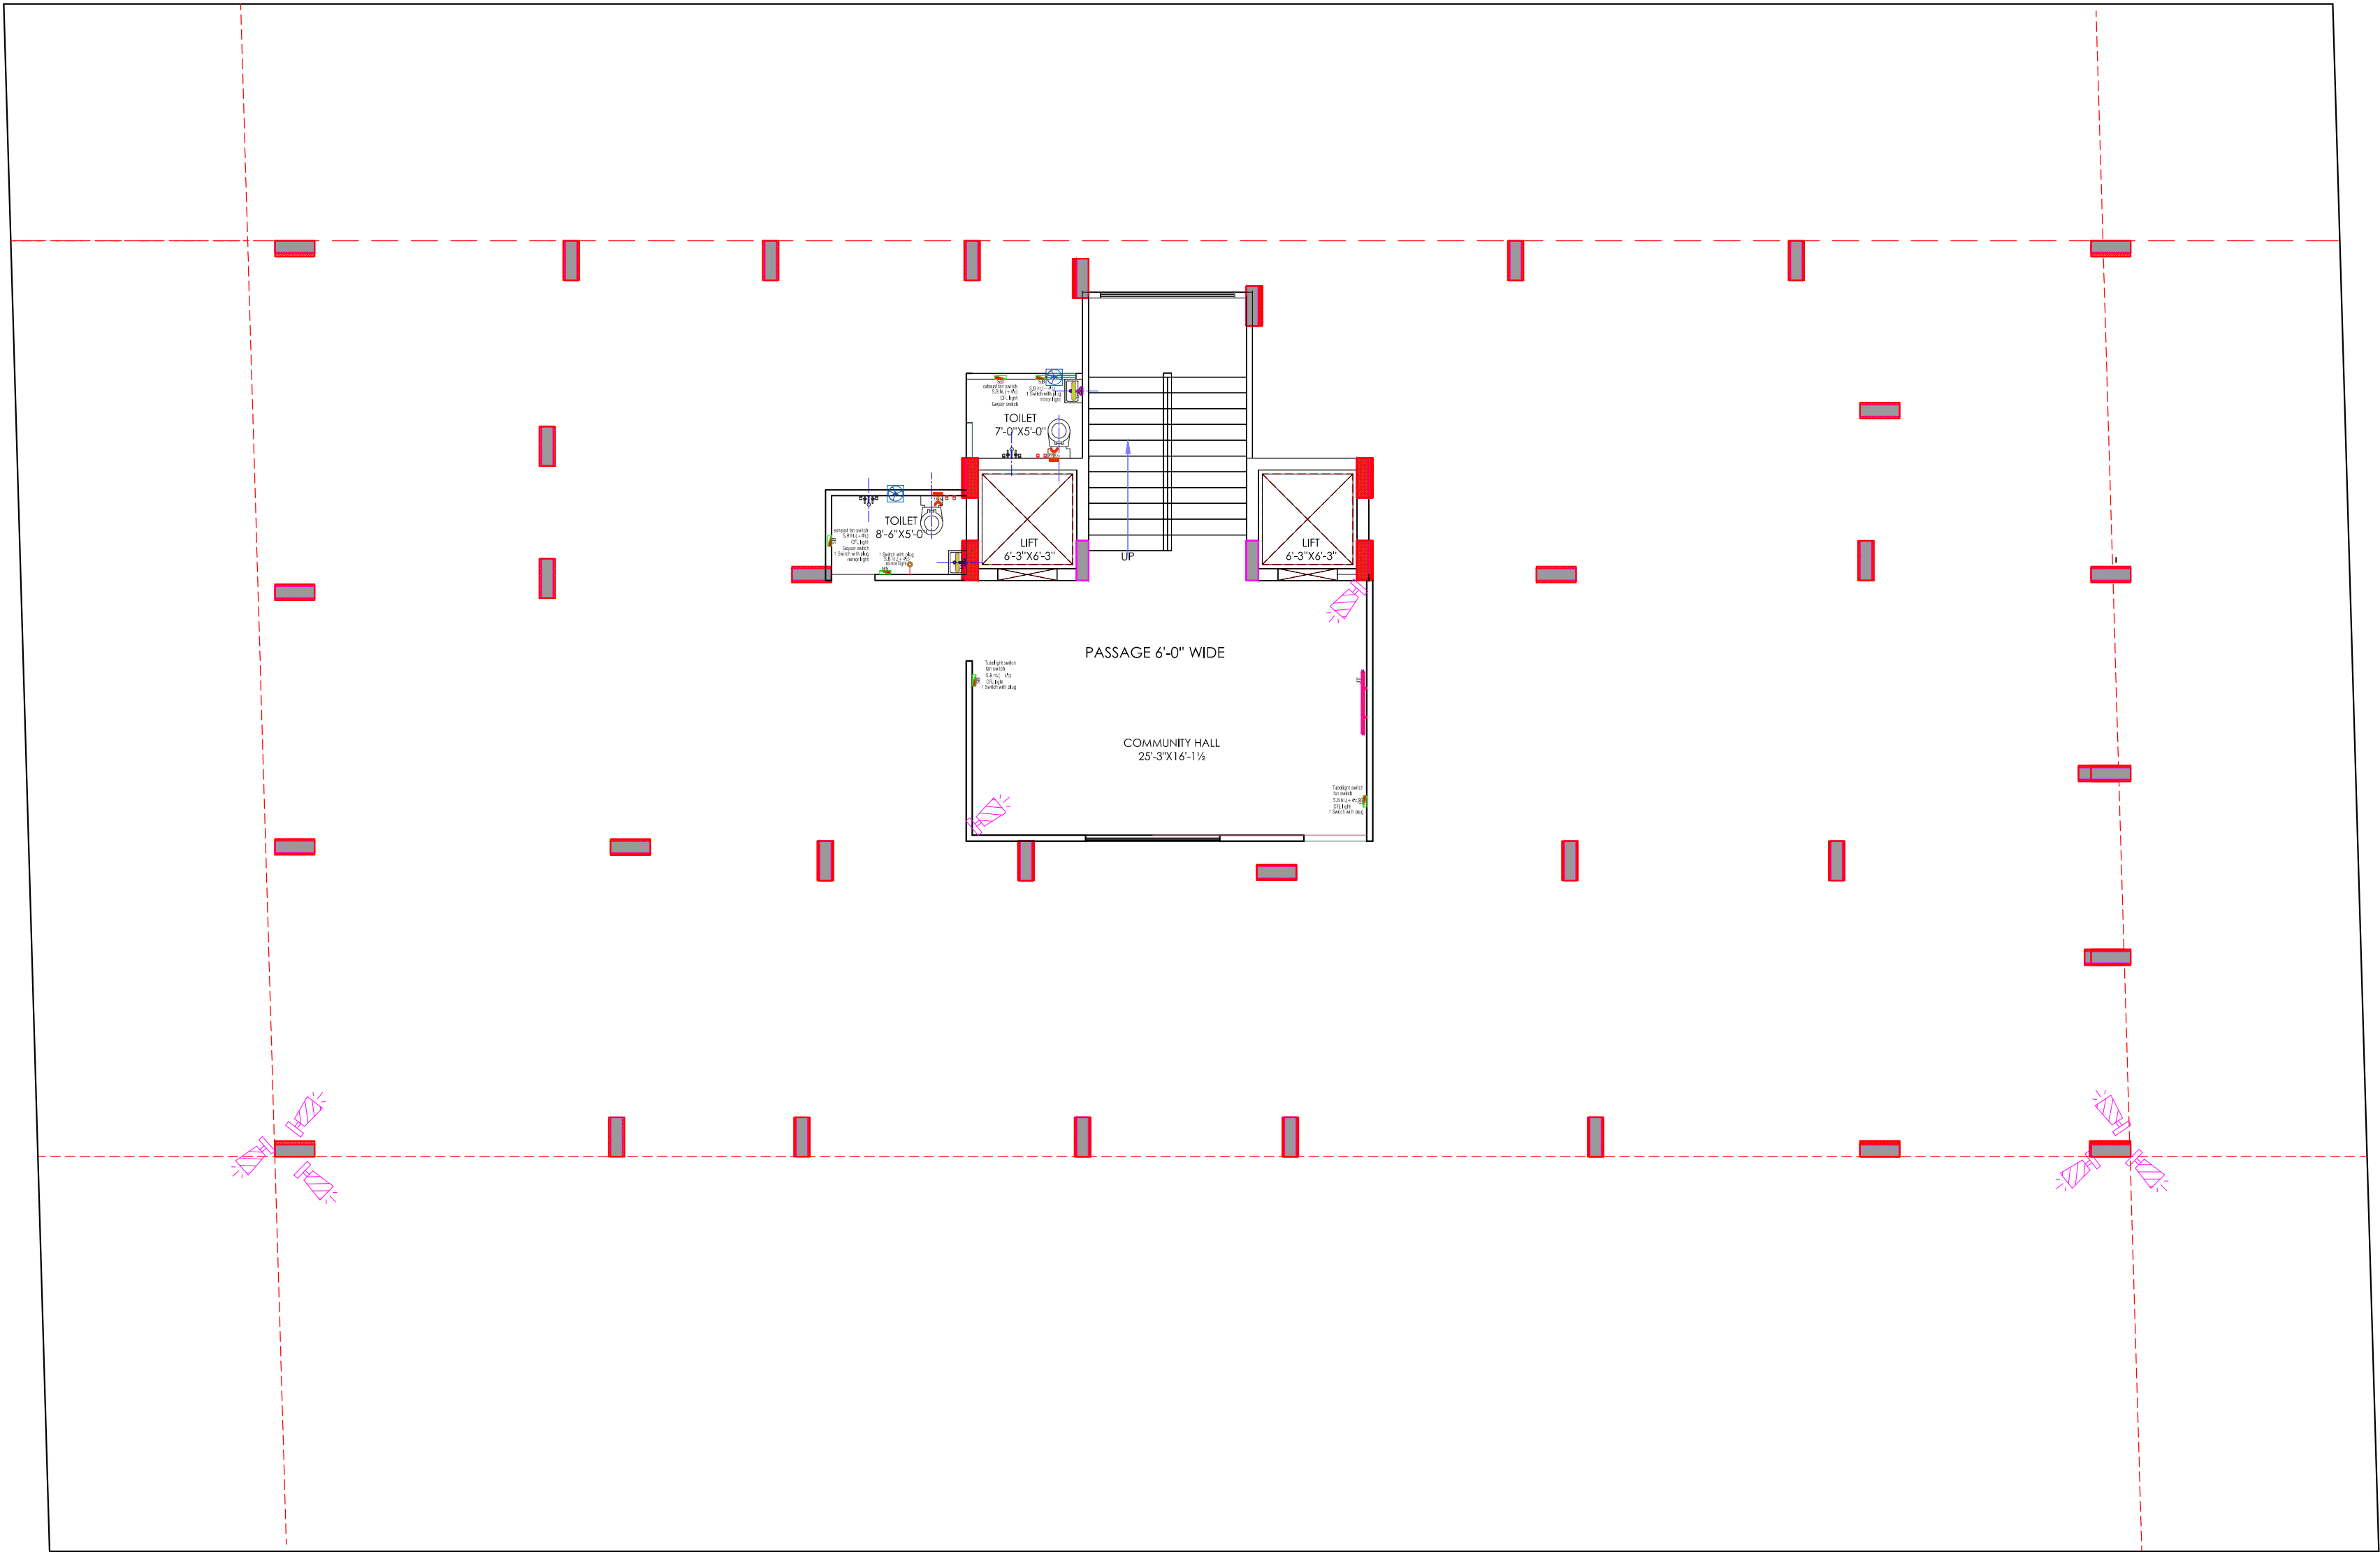

LEGENDS:			
Mounting Height	No.	I.D.	Symbol
IN FLOOR			CONTROL WIRING
IN CONDUIT			CONTROL WIRING
IN CONDUIT			AC CONTROL WIRING
IN CONDUIT			DATA CONTROL WIRING
IN CONDUIT			SLIDER CONTROL WIRING
CEILING	08	FAN-40"	CEILING FAN 40"
CEILING	02	FAN-30"	CEILING FAN 30"
100"	04	TL	DOWN WALL TUBELIGHT
100"	04	BULB	WALL BRACKETS AS DESIGN LIGHT
100"	01	GL	WALL BRACKETS AS DESIGN FOR GROUND LIGHT
02	GL		WALL BRACKETS AS DESIGN FOR GROUND LIGHT
CEILING	21	CFL	CFL CEILING LIGHT
+21"	02	FL	FOOT LIGHT
+40"	14	SB	SWITCH BOARD
+70"	03	ML	1 X 11 W CFL MIRROR LIGHT
VENTILATOR	01	CR	CEILING ROSE
VENTILATOR	01	EXP	30 DIA FRESH AIR FAN
+24"	02	TEL	TELEPHONE POINT
+27"	03	TV	TV CORDING POINT
+24"	02	LP TEL	5 A PLUG POINT FOR TELEPHONE
+24"	02	LP TV	5 A PLUG POINT FOR TV
+24"	02	LP	5 A PLUG POINT
+72"	01	LP CH	5 A PLUG POINT FOR CHIMNEY
+102"	03	SAC	SPOT AC
+102"	03	PP-SAC	25 A POWER POINT FOR SPOT AC
+42"	01	PP-MIX	75 A POWER POINT FOR MIXER
+78"	02	PP-G	15 A POWER POINT FOR GEYSER
+54"	01	PP-F	5 A POWER POINT FOR FRIDGE
+78"	01	PP-MF	5 A POWER POINT FOR MASHING MACHINE
+48"	01	PP-MF	5 A POWER POINT FOR MASHING MACHINE
+42"	02	BP	BELL PUSH SWITCH
+90"	01	BZ	BELL POINT
+24"	03	AC	AC STARTER
+40"	01	MCB DB	MCB DISTRIBUTION BOARD
03		SB 1.1	SWITCH BOARD NO. 1 LIGHT CIRCUIT NO.
03		AC	AC CIRCUIT NO.
05		PL	POWER CIRCUIT NO.

WARNING

1. This drawing is the sole copyright of Architects **VISTAAR** and should be used for the purpose expressly issued.

GENERAL NOTES

- All dimensions are in feet and inches.
- Do not scale this drawing follow written dimensions only.
- This drawing should be read in conjunction with other architectural and structural drawings.
- Any discrepancy in the drawing should be immediately brought to the notice of architect.

PROJECT TITLE
PROJECT:-
SUNRISE WESTWAY HEIGHTS
BUILDING AT PLOT NO.-32E & 32F.WESTWAY HEIGHTS(TRUCK
TERMINAL),VILL.KESHOPURA,ASARPURA ,BHANKROTA,JAIPUR

DRAWING TITLE
STILT FLOOR WALL ELECTRICAL PLAN
SERVICE(SLD/DISTRIBUTION DETAILS AFTER LT PANEL,EARTHING LAYOUT,EXTERNAL LIGHTING PLAN,LAYOUT,TV & TELEPHONE RISER DIAGRAM,LIGHTING ARRESTER LOCATION & PIT LOCATION,COORDINATION DRAWINGS,FIRE DETECTION & ALARM SYSTEM LAYOUT OF ALL FLOOR)

ARCHITECTS :
VISTAAR ARCHITECTS & PLANNERS
Architects :: Interior Designers
B-2/12, Chitrkoot scheme,
main Gandhi Path,Opp mall of jaipur,Jaipur
PH.- 0141-4116461,09001010366

DRN.	DATE	REV	NORTH
ER.SACHN	16-08-2024		
SCALE	JOB NO.		
NTS			


For My Dream House
Partner

KRISHNA KUMAR
B. Tech. (Mechanical)
M.E.P Consultant

98'-0"

147'-6"

147'-6"

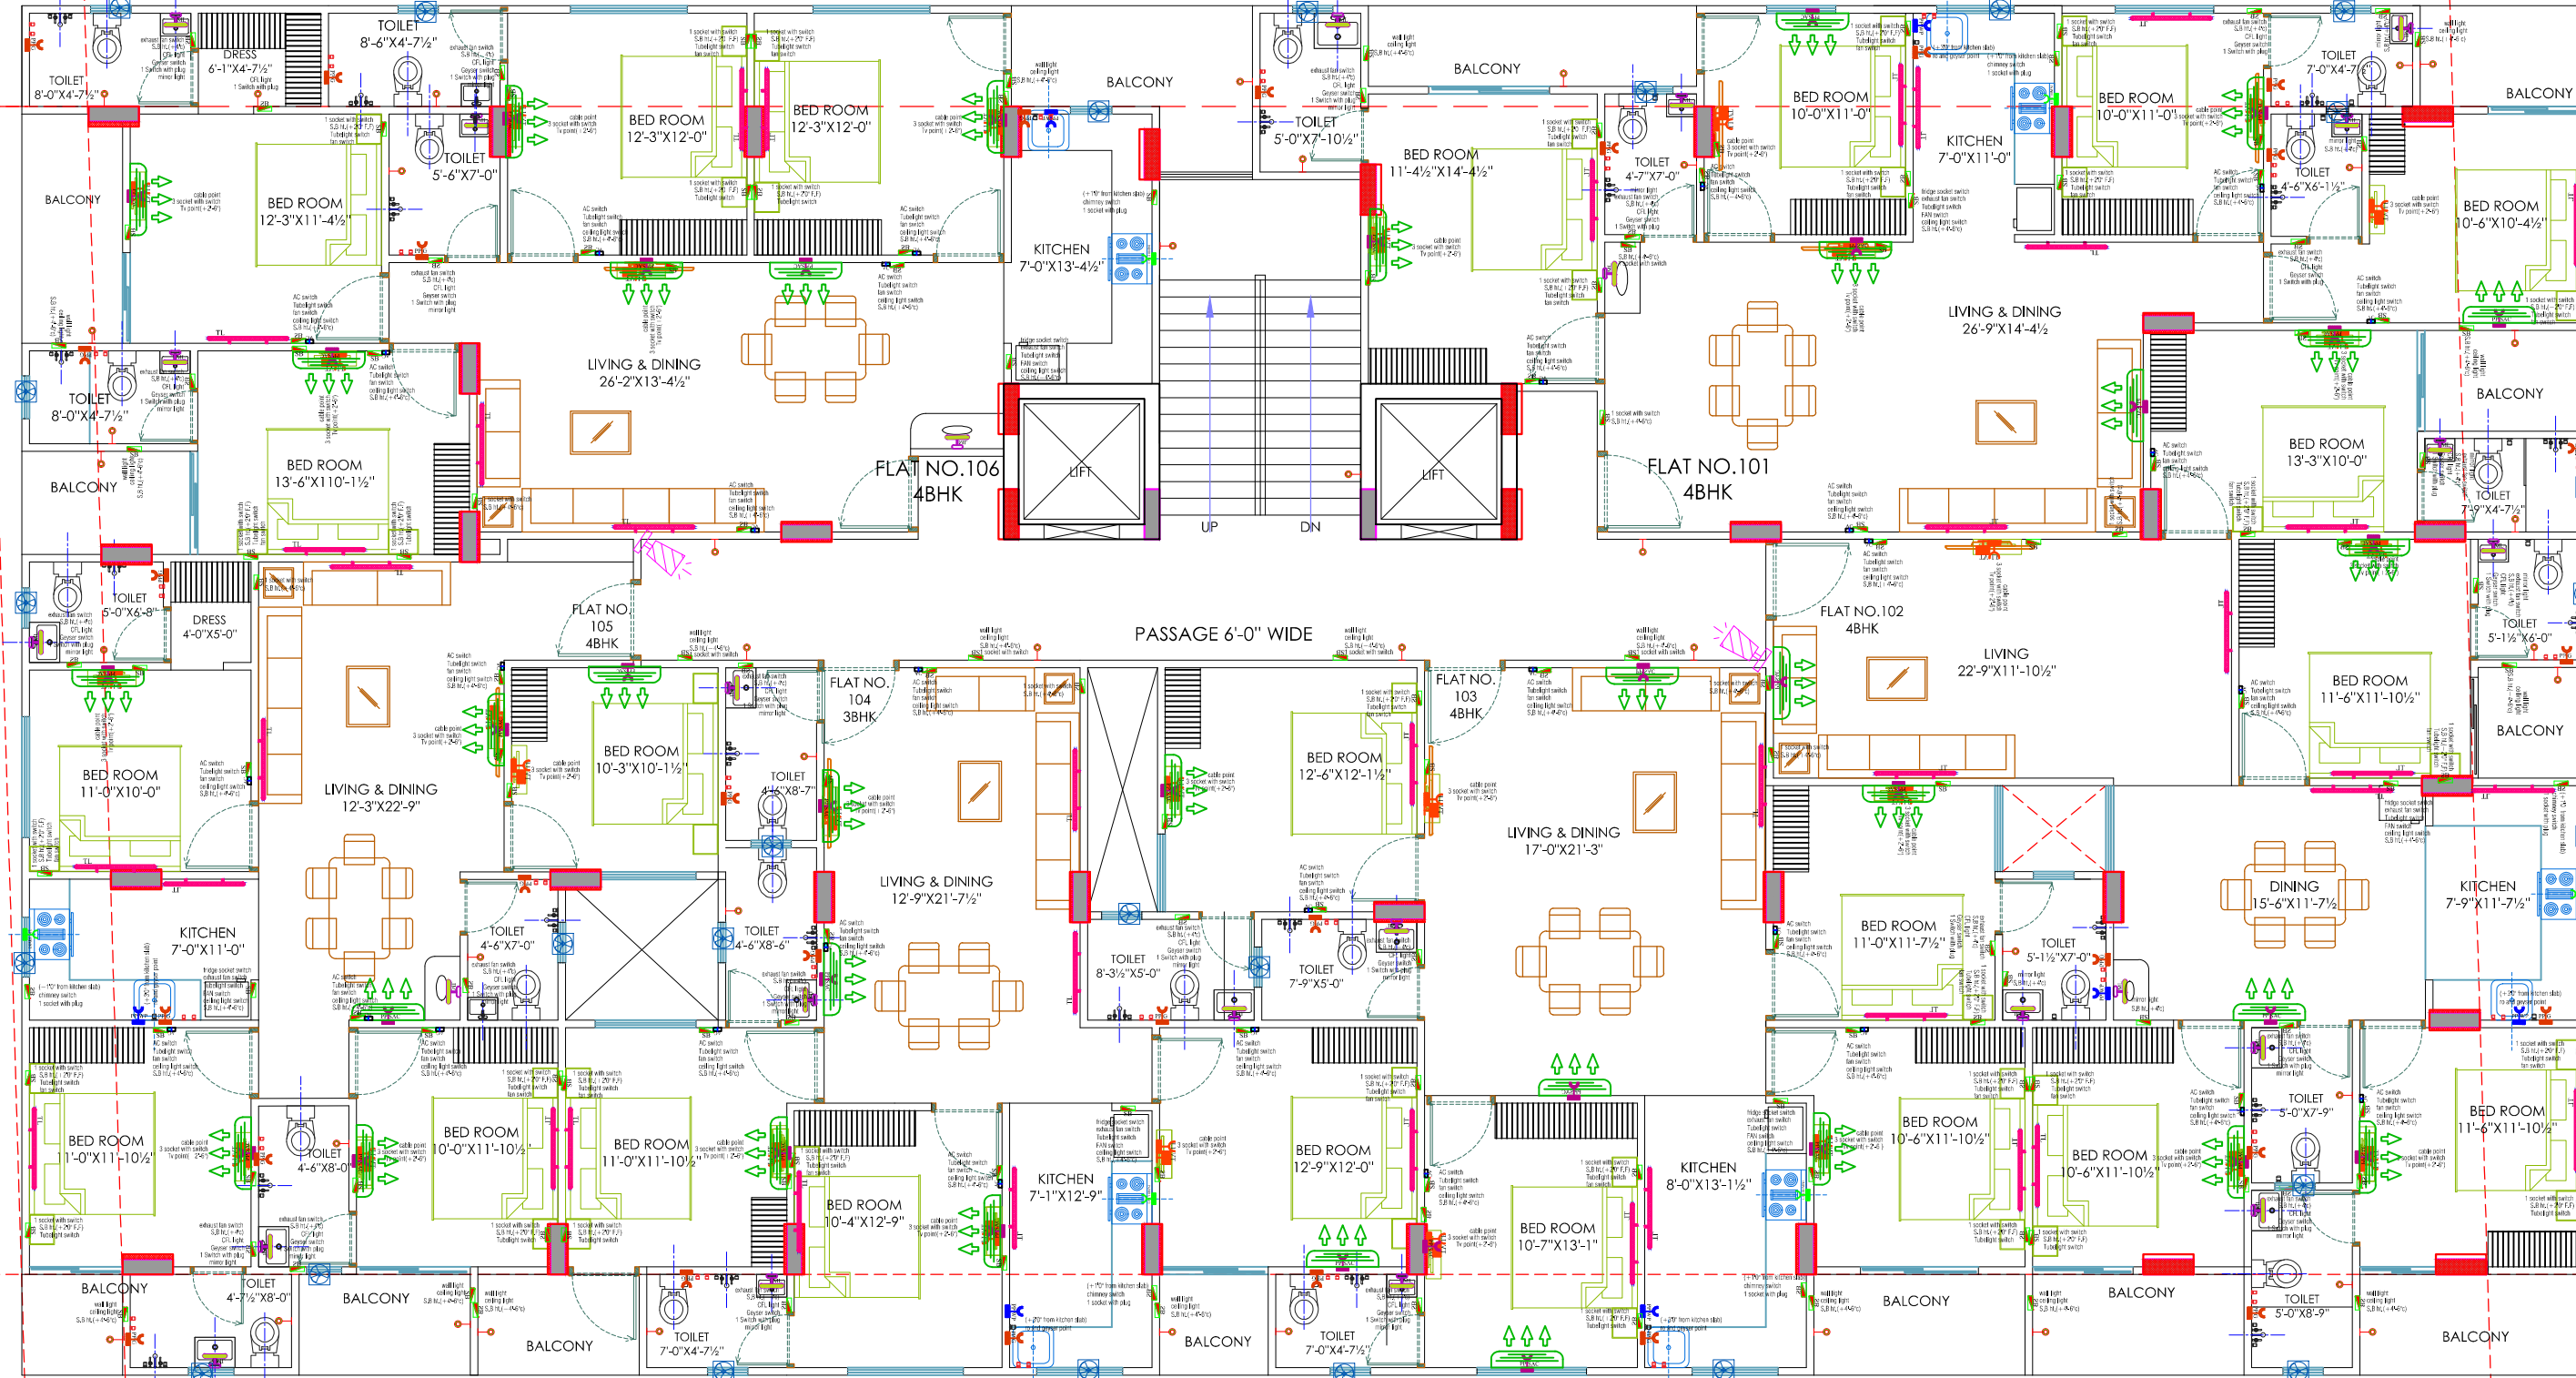

LEGENDS:				
Routing	No.	LD	Symbol	Description
IN FLAVOR				CONTROL WIRING
IN CONDUIT				CONTROL WIRING
IN CONDUIT				AC CONTROL WIRING
IN CONDUIT				CHASSIS CONTROL WIRING
IN CONDUIT				BLUZZER CONTROL WIRING
CEILING	06	PAN/4P		CEILING FAN 4P
CEILING	02	PAN/4P		CEILING FAN 3P
90°	04	TL		EXHAUST WALL TUBELIGHT
90°	04	BLR		WALL BRACKETS AS DESIGN LIGHT
90°	01	GL		WALL BRACKETS AS DESIGN FOR GANESH LIGHT
90°	02	GL		WALL BRACKETS AS DESIGN FOR GATE LIGHT
CEILING	21	CFL		CFL CEILING LIGHT
131°	02	FL		FOOT LIGHT
148°	14	SB		SWITCH BOARD
170°	03	MR		1 X 11 W CFL MIRROR LIGHT
VENTILATOR	03	CR		CEILING ROSE
VENTILATOR	03	EXP		9\" DIA FRESH AIR FAN
124°	02	DEL		TELEPHONE POINT
127°	03	TV		TV CORDING POINT
124°	02	LP TEL		6 A PLUG POINT FOR TELEPHONE
127°	03	LP TV		6 A PLUG POINT FOR TV
124°	02	LP		6 A PLUG POINT
127°	01	LP CH		6 A PLUG POINT FOR CHANNEY
1102°	03	SAC		5 A POWER POINT FOR SPLIT AC
1102°	03	PP-SAC		5 A POWER POINT FOR SPLIT AC
142°	01	PP-MEX		5 A POWER POINT FOR MIXER
178°	02	PP-F		5 A POWER POINT FOR Fridge
154°	01	PP-F		5 A POWER POINT FOR Fridge
178°	01	PP-WP		5 A POWER POINT FOR WASHING MACHINE
148°	01	PP-M		5 A POWER POINT FOR MIRROR
142°	02	BP		BELL PUSH SWITCH
100°	01	BP		BELL POINT
124°	03	AC		AC STARTER
160°	01	MCB DB		MCB DISTRIBUTION BOARD
		SB1/1		SWITCH BOARD NO. 1 LIGHT CONDUIT NO.
		AC		AC CONDUIT NO.
		PL		POWER CIRCUIT NO.

WARNING

1. This drawing is the sole copyright of Architects **VISTAAR** and should be used for the purpose expressly issued.

GENERAL NOTES

1. All dimensions are in feet and inches.
2. Do not scale this drawing follow written dimensions only.
3. This drawing should be read in conjunction with other architectural and structural drawings.
4. Any discrepancy in the drawing should be immediately brought to the notice of architect.

PROJECT TITLE
PROJECT:-
SUNRISE WESTWAY HEIGHTS
BUILDING AT PLOT NO.-32E & 32F, WESTWAY
HEIGHTS (TRUCK
TERMINAL), VILL. KESHOPURA, ASARPURA
BHANKROTA, JAIPUR

DRAWING TITLE
GROUND TO 5TH FLOOR WALL
ELECTRICAL PLAN
SERVICE(SLD) DISTRIBUTION DETAILS AFTER LT
PANEL, EARTHING LAYOUT, EXTERNAL LIGHTING
PLAN, LAYOUT, TV & TELEPHONE RISER
DIAGRAM, LIGHTING ARRESTER LOCATION & PIT
LOCATION, COORDINATION DRAWINGS, FIRE
DETECTION & ALARM SYSTEM LAYOUT OF ALL
FLOOR


ARCHITECTS :
VISTAAR ARCHITECTS & PLANNERS
Architects :: Interior Designers
B-2/12, Chitrkoot scheme,
main Gandhi Path, Opp mall of jaipur, Jaipur
PH. - 0141-4116461, 09001010366

DATE	DATE	REV.	NORTH
22-07-2024			
SCALE	JOB NO.		
NTS			

For My Dream House
Partner

KRISHNA KUMAR
B. Tech. (Mechanical)
M.E.P. Consultant



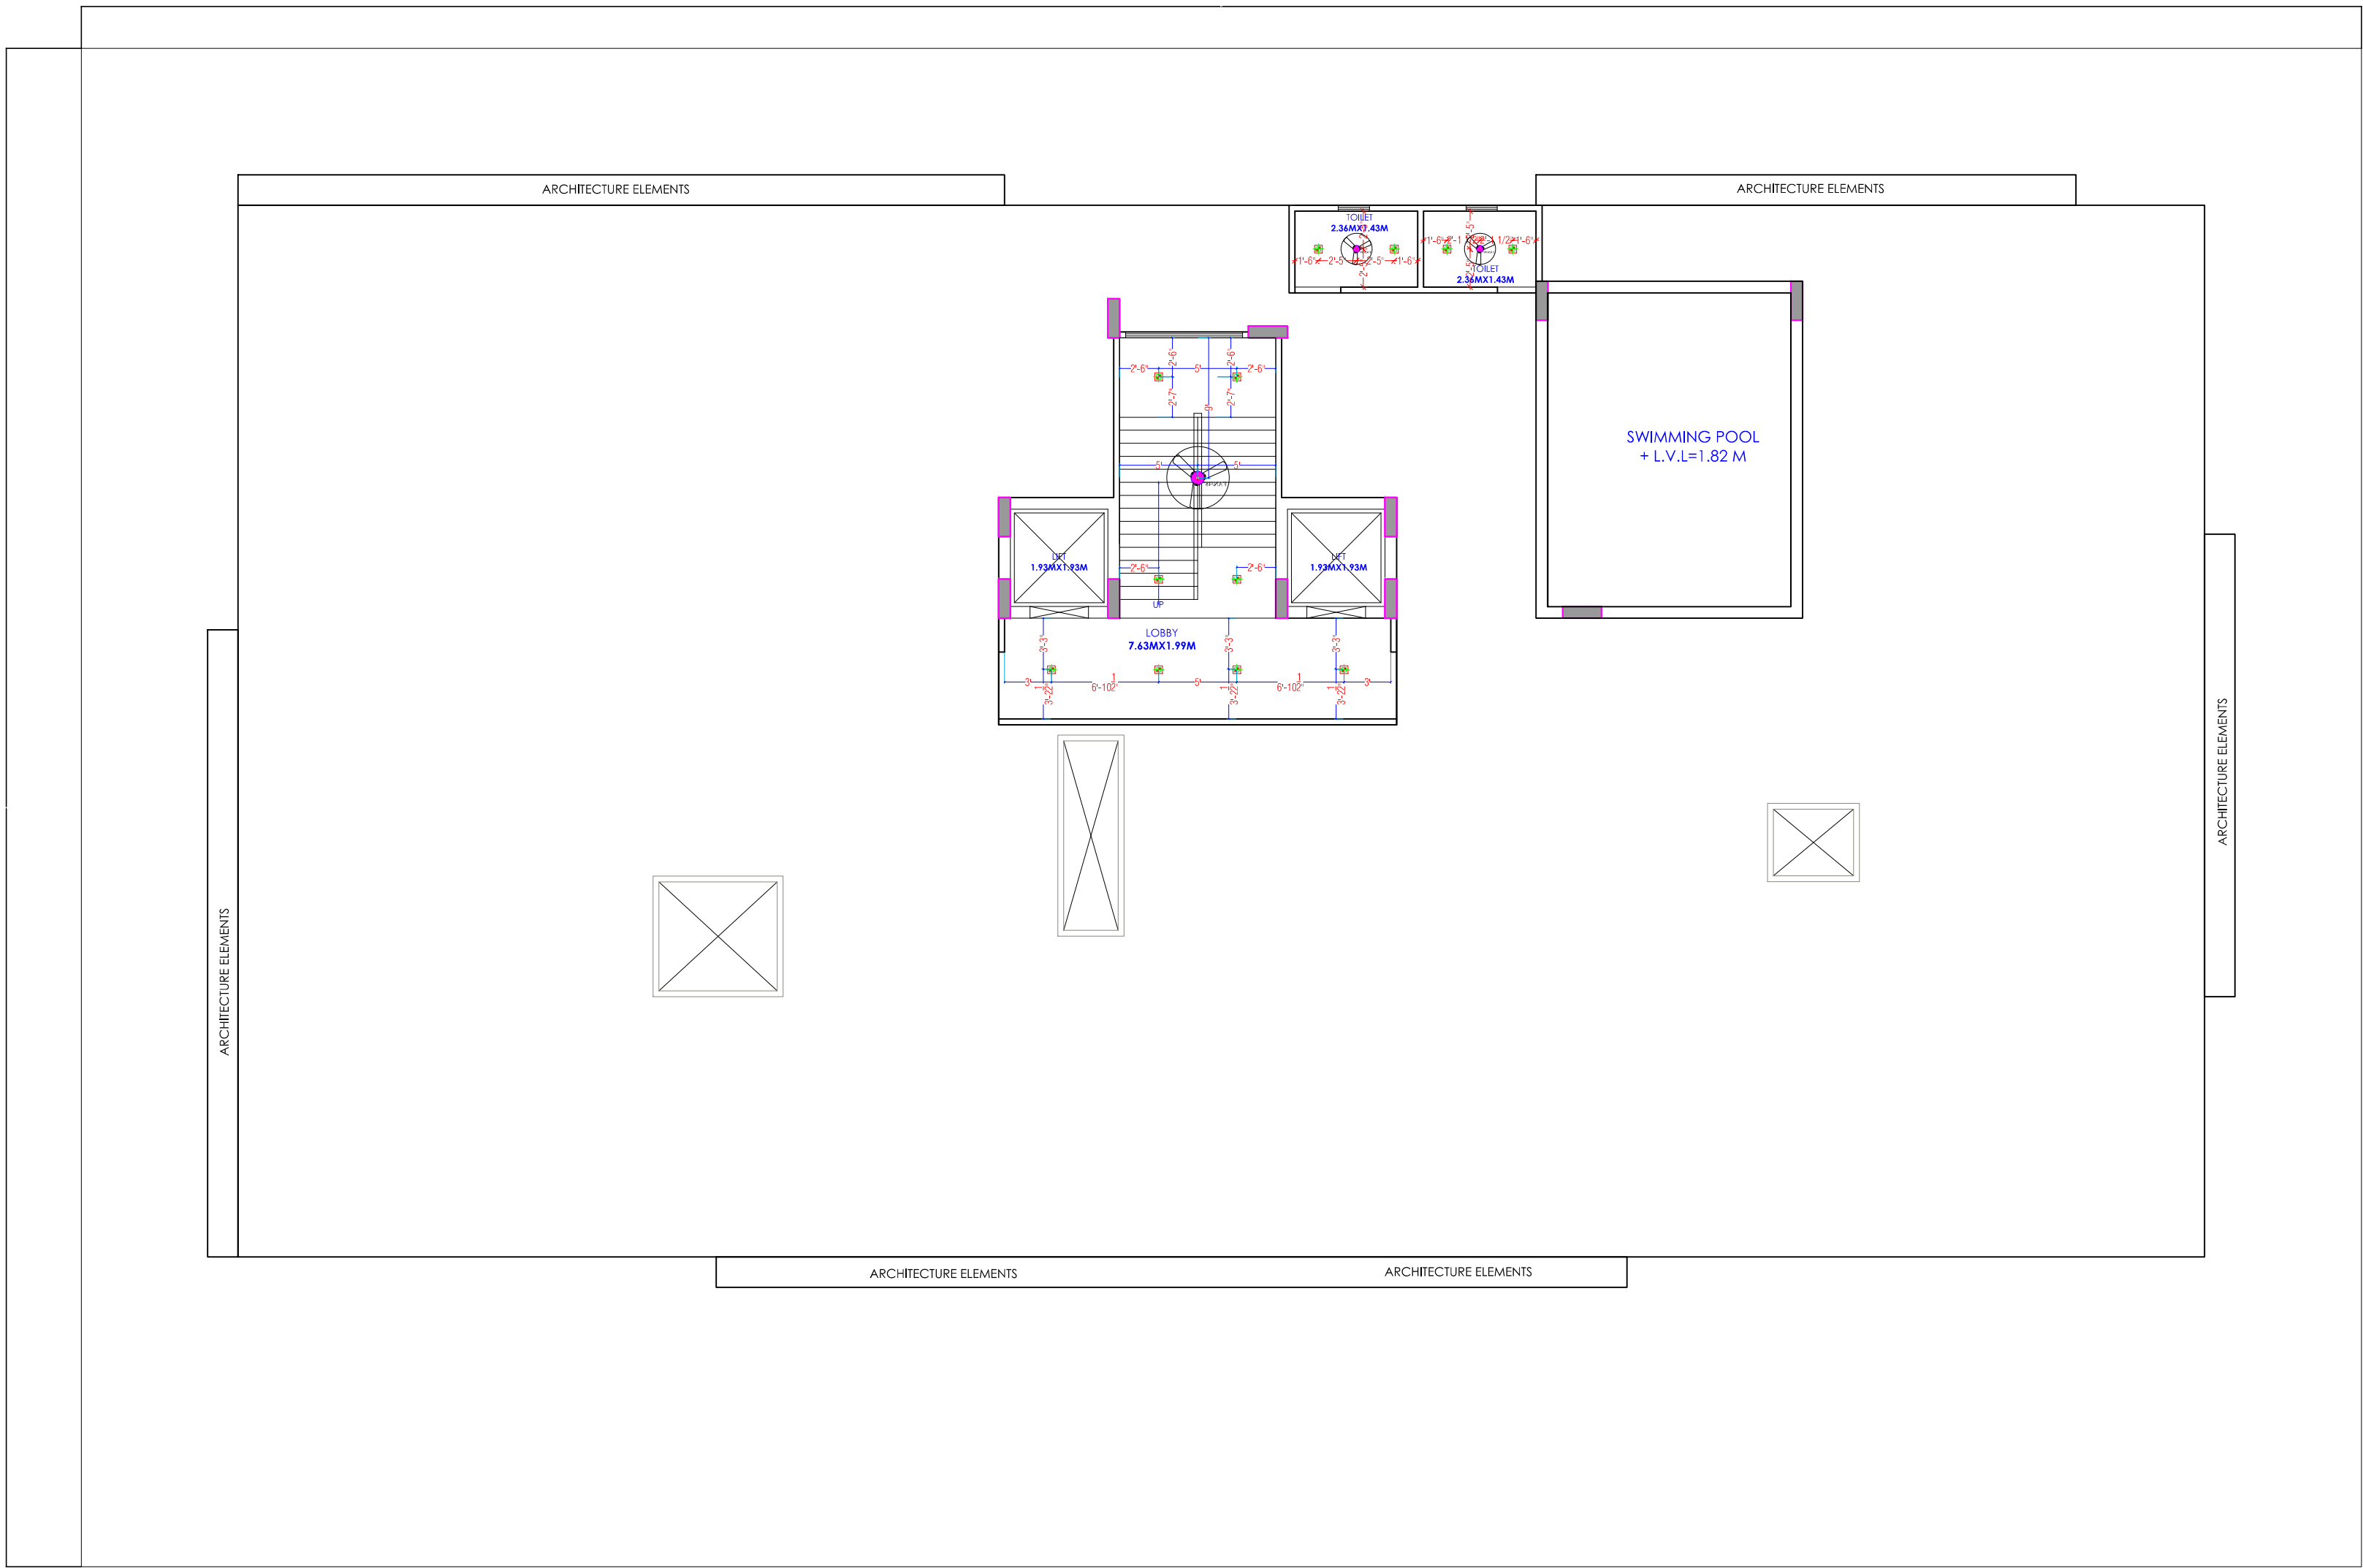

Y
-----ROAD 12 MT.WIDE-----

LEGENDS:			
Mounting Height	No.	Symbol	Description
IN FLOOR			CONTROL WIRING
IN CONDUIT			CONTROL WIRING
IN CONDUIT			AC CONTROL WIRING
IN CONDUIT			OTHER CONTROL WIRING
IN CONDUIT			FLUORESCENT CONTROL WIRING
CEILING	08	FAN/MP	CEILING FAN 40"
CEILING	07	FAN/MP	CEILING FAN 30"
+90"	04	TL	FLUORESCENT WALL LIGHT
+90"	04	TL	WALL BRACKETS AS DESIGN LIGHT
+90"	01	GL	WALL BRACKETS AS DESIGN FOR GATE LIGHT
+90"	02	GL	WALL BRACKETS AS DESIGN FOR GATE LIGHT
CEILING	21	CTL	CTL CEILING LIGHT
+21"	02	FL	FOOT LIGHT
+48"	14	SB	SWITCH BOARD
+75"	03	ML	1 X 11 W CFL MIRROR LIGHT
VENTILATOR HT.	03	CR	CEILING ROSE
VENTILATOR HT.	03	EXP	1/2" DIA FRESH AIR FAN
+24"	02	TEL	TELEPHONE POINT
+27"	03	TV	TV CORDAL POINT
+24"	02	LP TEL	6 A PLUS POINT FOR TELEPHONE
+27"	03	LP TV	6 A PLUS POINT FOR TV
+24"	02	LP	6 A PLUS POINT
+27"	01	LP CH	6 A PLUS POINT FOR CHIMNEY
+100"	03	SAC	1/2" DIA AC
+100"	03	PP SAC	1/2" DIA AC
+42"	01	PP MEY	1/2" DIA AC
+78"	02	PP G	1/2" DIA AC
+38"	01	PP F	1/2" DIA AC
+28"	01	PP HP	1/2" DIA AC
+48"	01	PP WM	1/2" DIA AC
+42"	02	BP	BELL PUSH SWITCH
+90"	01	BZ	BELLZ POINT
+24"	03	AC	AC STARTER
+90"	01	ACB DB	ACB DISTRIBUTION BOARD
03		SB/L/L	SWITCH BOARD NO LIGHT CIRCUIT NO.
03		AC/L	AC CIRCUIT NO.
03		PL	POWER CIRCUIT NO.

WARNING

1. This drawing is the sole copyright of Architects **VISTAAR** and should be used for the purpose expressly issued.

GENERAL NOTES

- All dimensions are in feet and inches.
- Do not scale this drawing follow written dimensions only.
- This drawing should be read in conjunction with other architectural and structural drawings.
- Any discrepancy in the drawing should be immediately brought to the notice of architect.


PROJECT TITLE
PROJECT:-
SUNRISE WESTWAY HEIGHTS
BUILDING AT PLOT NO.-32E & 32F.WESTWAY
HEIGHTS(TRUCK TERMINAL),VILL.KESHOPURA,ASARPURA
,BHANKROTA,JAIPUR

DRAWING TITLE
TERRACE CEILING ELECTRICAL
PLAN
ARCHITECTS :
VISTAAR ARCHITECTS & PLANNERS
Architects :: Interior Designers
B-2/12, Chitrkoot scheme,
main Gandhi Path,Opp mall of jaipur,Jaipur
PH.- 0141-4116461,09001010366

PART			
DRN.	DATE	REV.	NORTH
ER,SACHN	02-08-2024		
SCALE	JOB NO.		
N.T.S			

For My Dream House
Partner

KRISHNA KUMAR
B. Tech. (Mechanical)
M.E.P Consultant

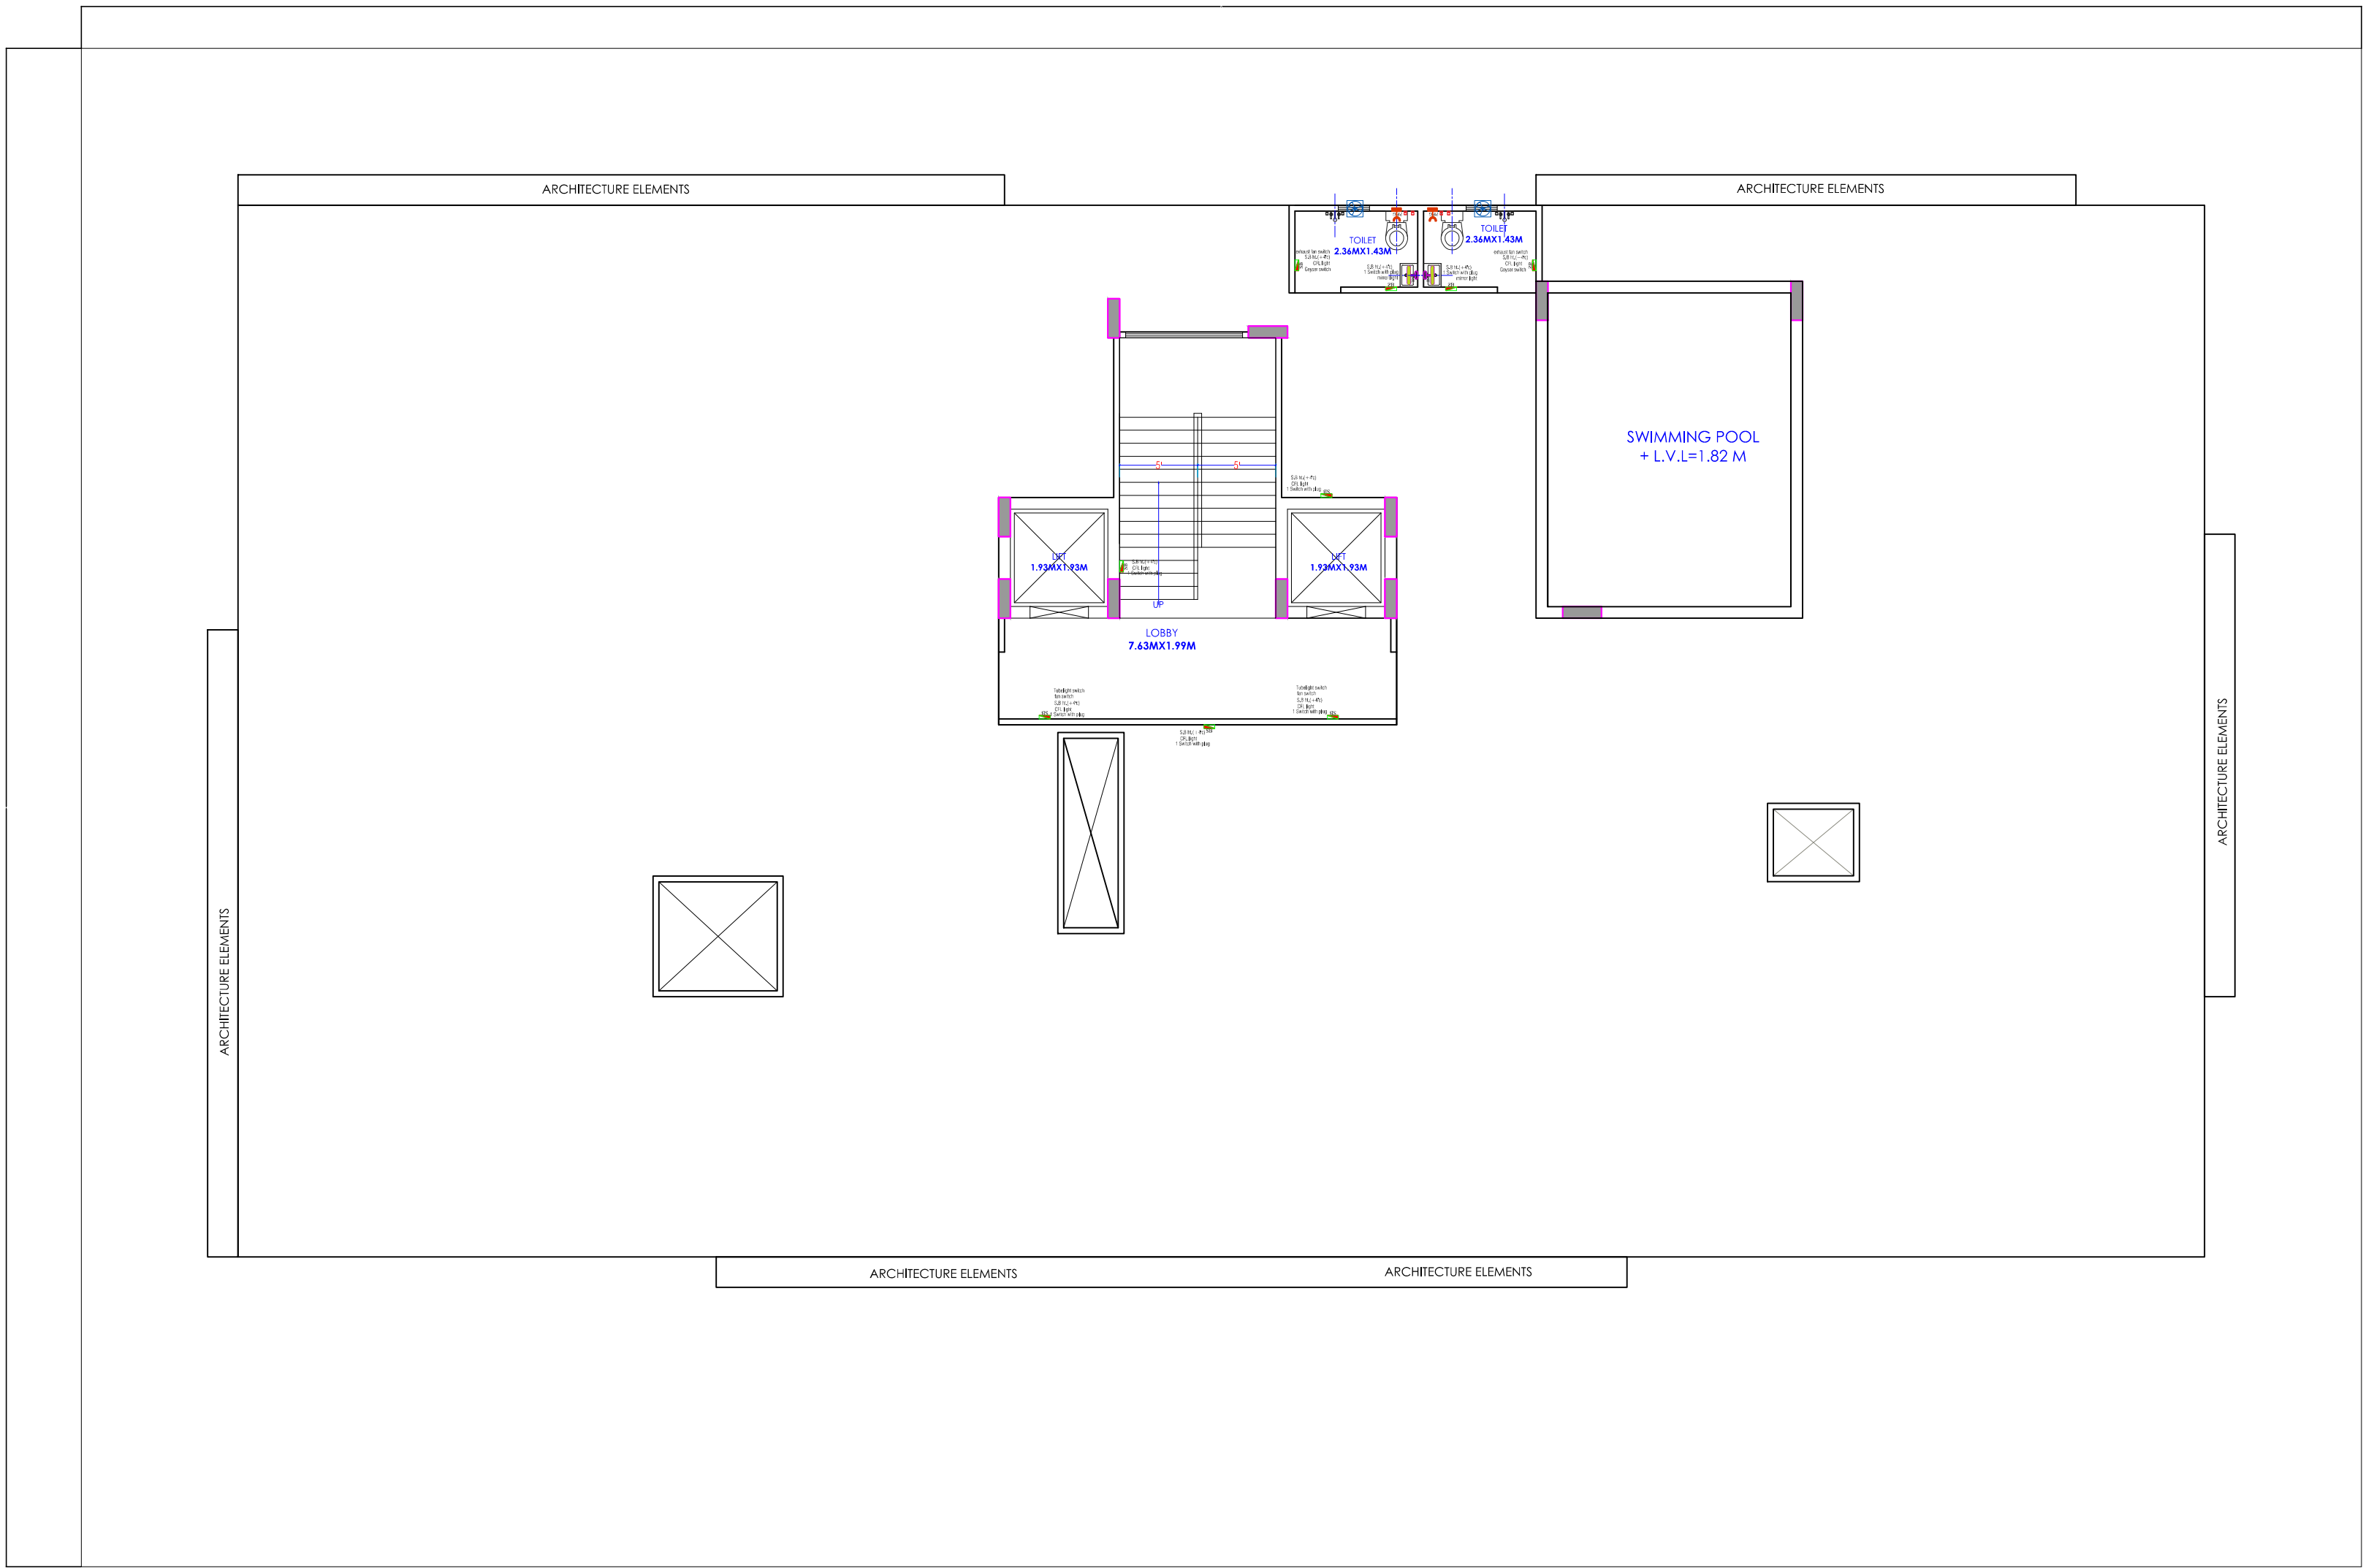

Y
-----ROAD 12 MT.WIDE-----

LEGENDS:			
Mounting Height	No.	Symbol	Description
IN FLOOR			CONTROL WIRING
IN CONDUIT			CONTROL WIRING
IN CONDUIT			AC CONTROL WIRING
IN CONDUIT			OTHER CONTROL WIRING
IN CONDUIT			BLUZZER CONTROL WIRING
CEILING	08	FAN/MP	CEILING FAN 40"
CEILING	07	FAN/MP	CEILING FAN 30"
+10"	04	TL	FLUOR WALL TUBELIGHT
+90"	04	BLER	WALL BRACKETS AS DESIGN LIGHT
+90"	01	GL	WALL BRACKETS AS DESIGN FOR GATEWAY LIGHT
	02	GL	WALL BRACKETS AS DESIGN FOR GATEWAY LIGHT
CEILING	21	CFL	CFL CEILING LIGHT
+21"	02	FL	FOOT LIGHT
+48"	14	SB	SWITCH BOARD
+75"	03	ML	1 X 11 W CFL MIRROR LIGHT
VENTILATOR HT	03	CR	CEILING ROSE
VENTILATOR HT	03	EXP	18" DIA FRESH AIR FAN
+24"	02	TEL	TELEPHONE POINT
+27"	03	TV	TV CORDAL POINT
+24"	02	LP TEL	6 A PLUS POINT FOR TELEPHONE
+27"	03	LP TV	6 A PLUS POINT FOR TV
+24"	02	LP	6 A PLUS POINT
+27"	01	LP-CH	6 A PLUS POINT FOR CHIMNEY
+100"	03	SAC	100' AC
+100"	03	PP-SAC	15 A POWER POINT FOR 100' AC
+42"	01	PP-MIX	15 A POWER POINT FOR MIXER
+78"	02	PP-G	15 A POWER POINT FOR GEYSER
+38"	01	PP-F	15 A POWER POINT FOR FRIDGE
+28"	01	PP-WP	15 A POWER POINT FOR WASHING MACHINE
+48"	01	PP-WM	15 A POWER POINT FOR WASHING MACHINE
+42"	02	BP	BELL PUSH SWITCH
+90"	01	BZ	BELLZEEZ POINT
+24"	03	JAC	AC STARTER
+90"	01	MCB DB	MCB DISTRIBUTION BOARD
03		SB/L/L	SWITCH BOARD NO LIGHT CIRCUIT NO.
03		AC	AC CIRCUIT NO.
03		PI	POWER CIRCUIT NO.

WARNING

1. This drawing is the sole copyright of Architects **VISTAAR** and should be used for the purpose expressly issued.

GENERAL NOTES

- All dimensions are in feet and inches.
- Do not scale this drawing follow written dimensions only.
- This drawing should be read in conjunction with other architectural and structural drawings.
- Any discrepancy in the drawing should be immediately brought to the notice of architect.

PROJECT TITLE
PROJECT:-
SUNRISE WESTWAY HEIGHTS
BUILDING AT PLOT NO.-32E & 32F WESTWAY
HEIGHTS (TRUCK TERMINAL), VILL. KESHOPURA, ASARPURA
, BHANKROTA, JAIPUR


DRAWING TITLE
TERRACE WALL ELECTRICAL PLAN

ARCHITECTS :
VISTAAR ARCHITECTS & PLANNERS
Architects :: Interior Designers
B-2/12, Chitrkoot scheme,
main Gandhi Path, Opp mall of jaipur, Jaipur
PH.- 0141-4116461, 09001010366

DATE			
DRN.	DATE	REV.	NORTH
ER,SACHN	02-08-2024		
SCALE	JOB NO.		
N.T.S			

For My Dream House
ER, SACHN
Partner

Checked by
KRISHNA KUMAR
B. Tech (Mechanical)
M.E.P Consultant

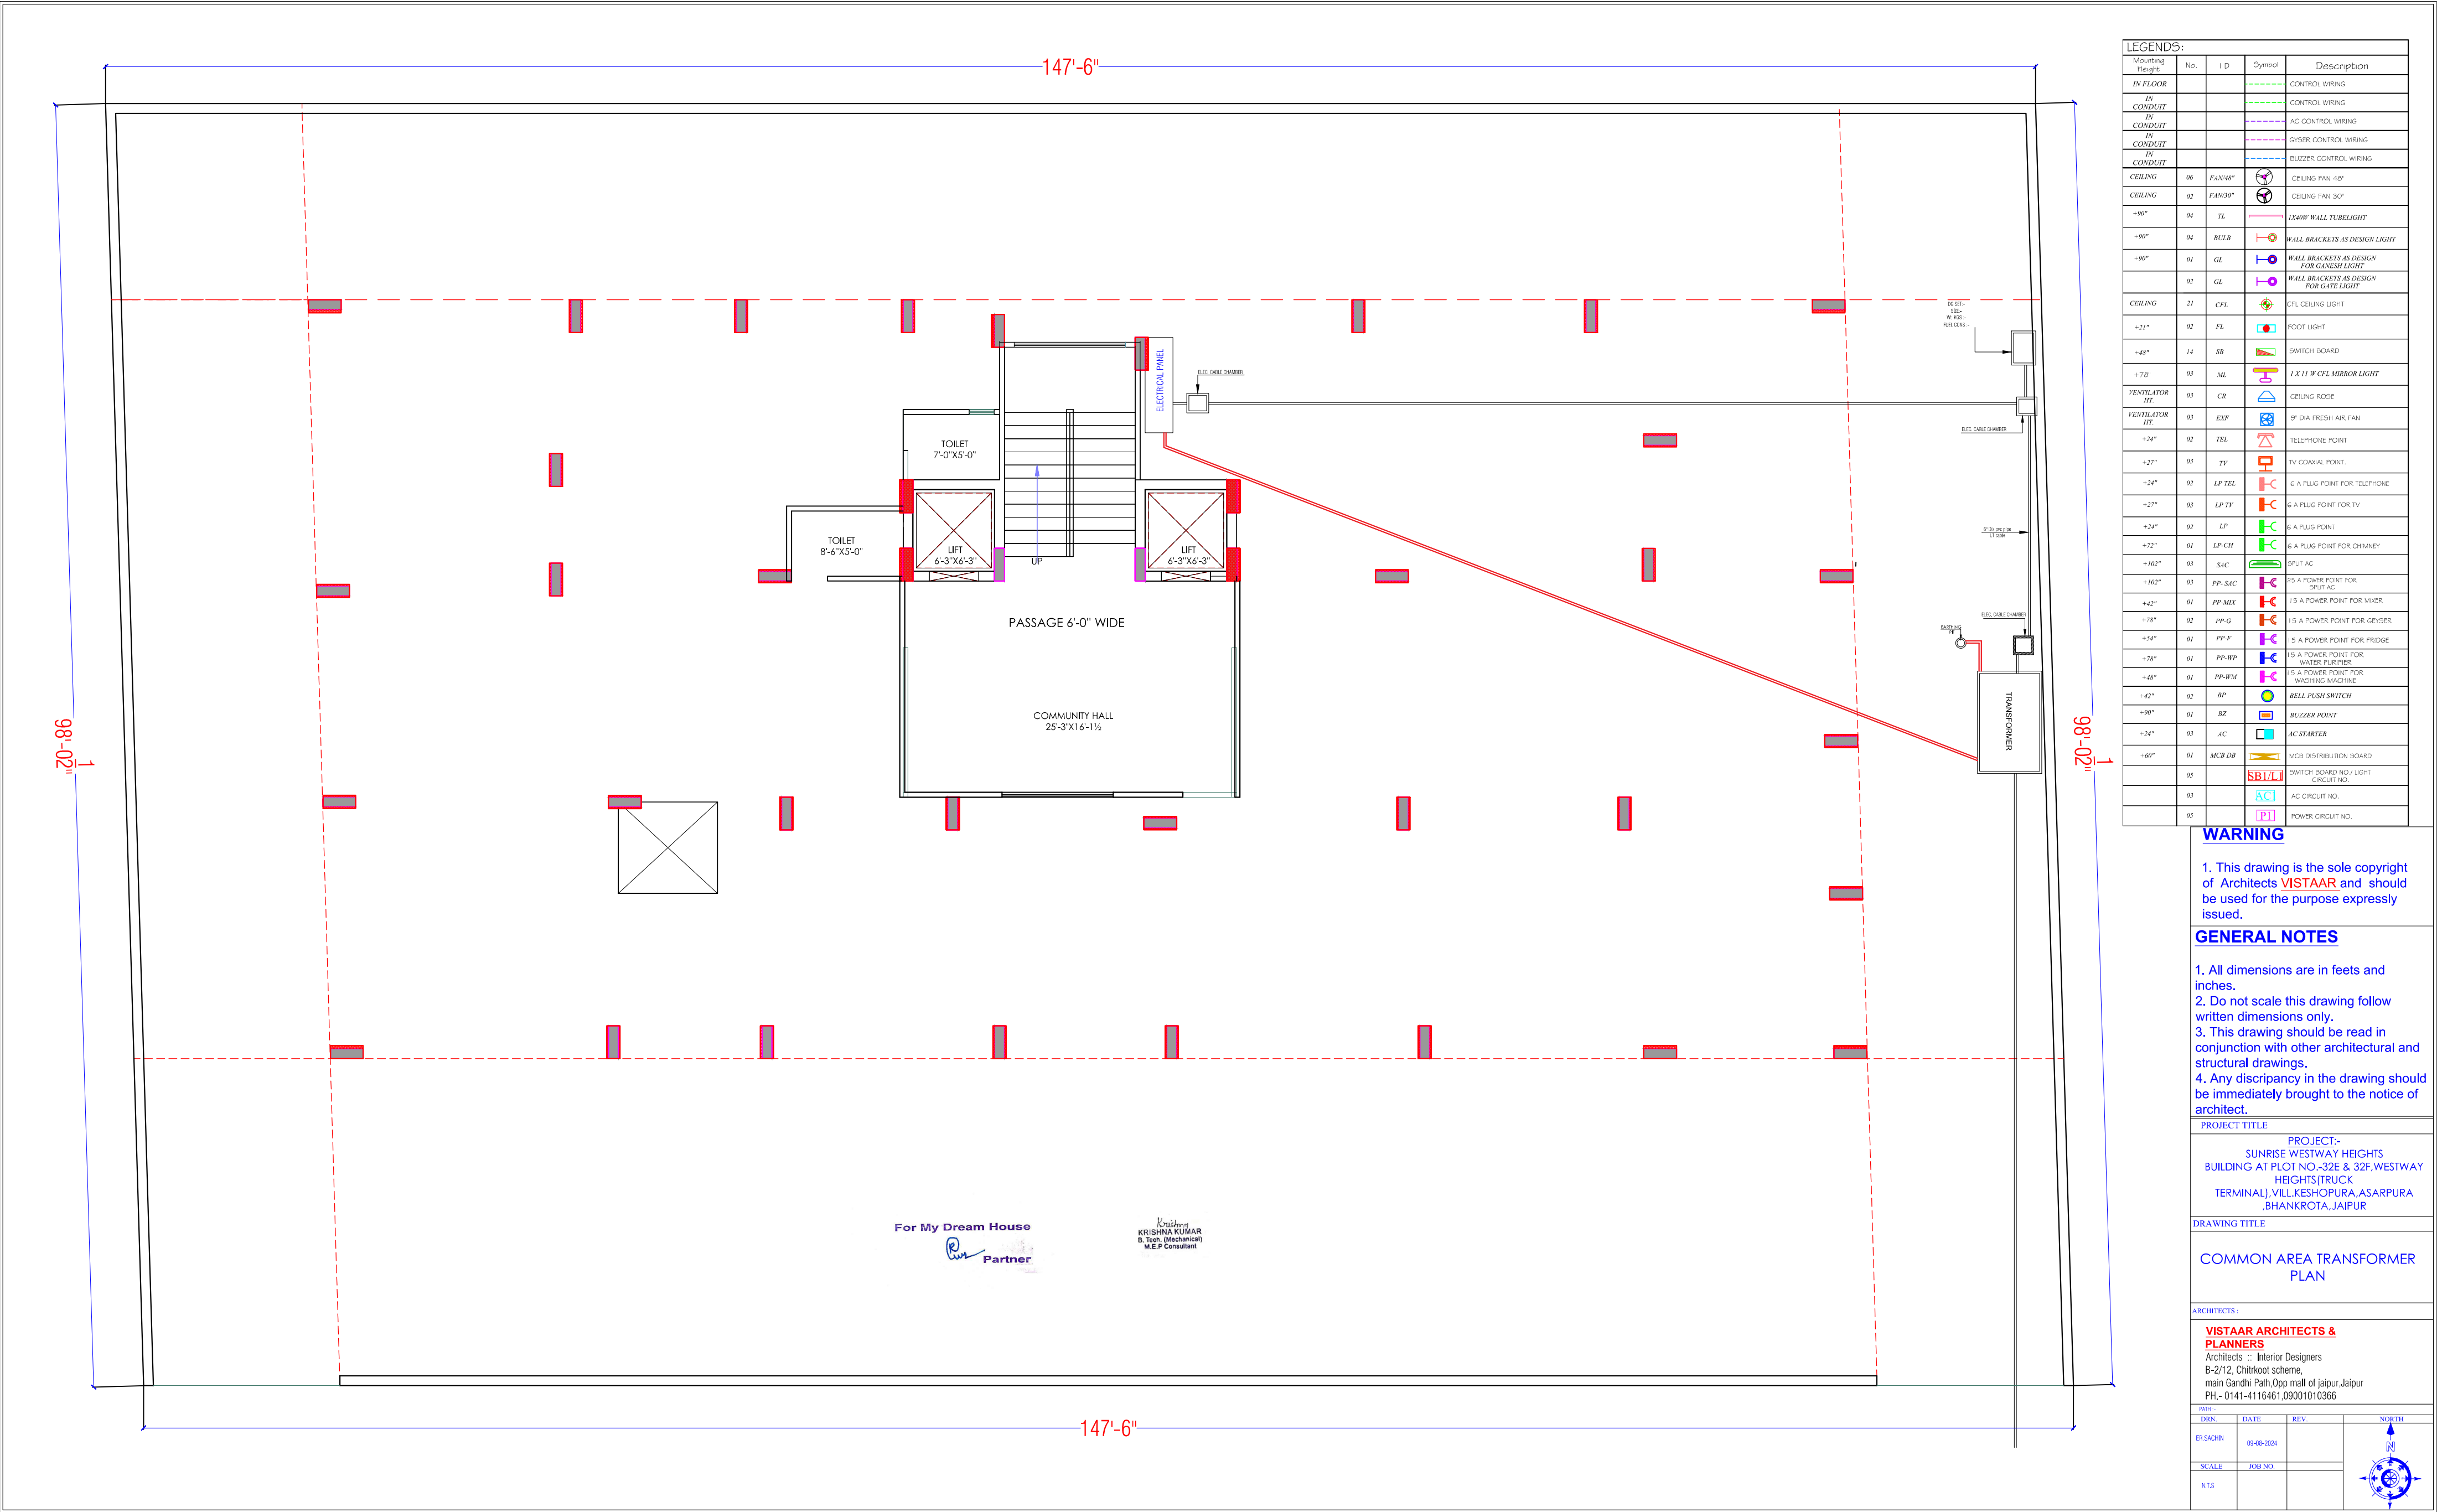

LEGENDS:				
Mounting Height	No.	I D	Symbol	Description
IN FLOOR				CONTROL WIRING
IN CONDUIT				CONTROL WIRING
IN CONDUIT				AC CONTROL WIRING
IN CONDUIT				GYSER CONTROL WIRING
IN CONDUIT				BUZZER CONTROL WIRING
CEILING	06	FAN/48"		CEILING FAN 48"
CEILING	02	FAN/30"		CEILING FAN 30"
+90"	04	TL		1X40W WALL TUBELIGHT
+90"	04	BULB		WALL BRACKETS AS DESIGN LIGHT
+90"	01	GL		WALL BRACKETS AS DESIGN FOR GANESH LIGHT
	02	GL		WALL BRACKETS AS DESIGN FOR GATE LIGHT
CEILING	21	CFL		CFL CEILING LIGHT
+21"	02	FL		FOOT LIGHT
+48"	14	SB		SWITCH BOARD
+70"	03	ML		1 X 11 W CFL MIRROR LIGHT
VENTILATOR HT.	03	CR		CEILING RIDGE
VENTILATOR HT.	03	EXF		9" DIA FRESH AIR FAN
+24"	02	TEL		TELEPHONE POINT
+27"	03	TV		TV COAXIAL POINT
+24"	02	LP TEL		6 A PLUG POINT FOR TELEPHONE
+27"	03	LP TV		6 A PLUG POINT FOR TV
+24"	02	LP		6 A PLUG POINT
+72"	01	LP-CH		6 A PLUG POINT FOR CHIMNEY
+102"	03	SAC		SPLIT AC
+102"	03	PP-SAC		25 A POWER POINT FOR SPLIT AC
+42"	01	PP-MIX		15 A POWER POINT FOR MIXER
+78"	02	PP-G		15 A POWER POINT FOR GEYSER
+54"	01	PP-F		15 A POWER POINT FOR FRIDGE
+78"	01	PP-WP		15 A POWER POINT FOR WATER PURIFIER
+48"	01	PP-WM		5 A POWER POINT FOR WASHING MACHINE
+42"	02	BP		BELL PUSH SWITCH
+90"	01	BZ		BUZZER POINT
+24"	03	AC		AC STARTER
+60"	01	MCB DB		MCB DISTRIBUTION BOARD
	03	SB/L		SWITCH BOARD NO J LIGHT CIRCUIT NO.
	03	AC		AC CIRCUIT NO.
	03	PI		POWER CIRCUIT NO.

WARNING

1. This drawing is the sole copyright of Architects **VISTAAR** and should be used for the purpose expressly issued.

GENERAL NOTES

1. All dimensions are in feets and inches.
2. Do not scale this drawing follow written dimensions only.
3. This drawing should be read in conjunction with other architectural and structural drawings.
4. Any discrepancy in the drawing should be immediately brought to the notice of architect.


PROJECT TITLE
PROJECT:-
SUNRISE WESTWAY HEIGHTS
BUILDING AT PLOT NO.-32E & 32F, WESTWAY
HEIGHTS (TRUCK
TERMINAL), VILL. KESHOPURA, ASARPURA
BHANKROTA, JAIPUR

DRAWING TITLE
COMMON AREA TRANSFORMER
PLAN

ARCHITECTS :
VISTAAR ARCHITECTS & PLANNERS
Architects :- Interior Designers
B-2/12, Chitrakoot scheme,
main Gandhi Path, Opp mall of jaipur, Jaipur
PH. - 0141-4116461, 09001010366

DRN.	DATE	REV.	NORTH
ER.SACHIN	09-08-2024		
SCALE	JOB NO.		
NTS			

NOTE:-
THIS SLD HAS BEEN PREPARED AS PER CONCEPT STAGE DATA AVAILABLE WITH US. KINDLY CONTACT US FOR FINAL SLD & DETAILS BEFORE PLACING ORDER FOR FABRICATION. WE SHALL NOT BE RESPONSIBLE, IF THE PANELS ARE UNDER UTILISED OR OVER LOADED AT ANY STAGE.

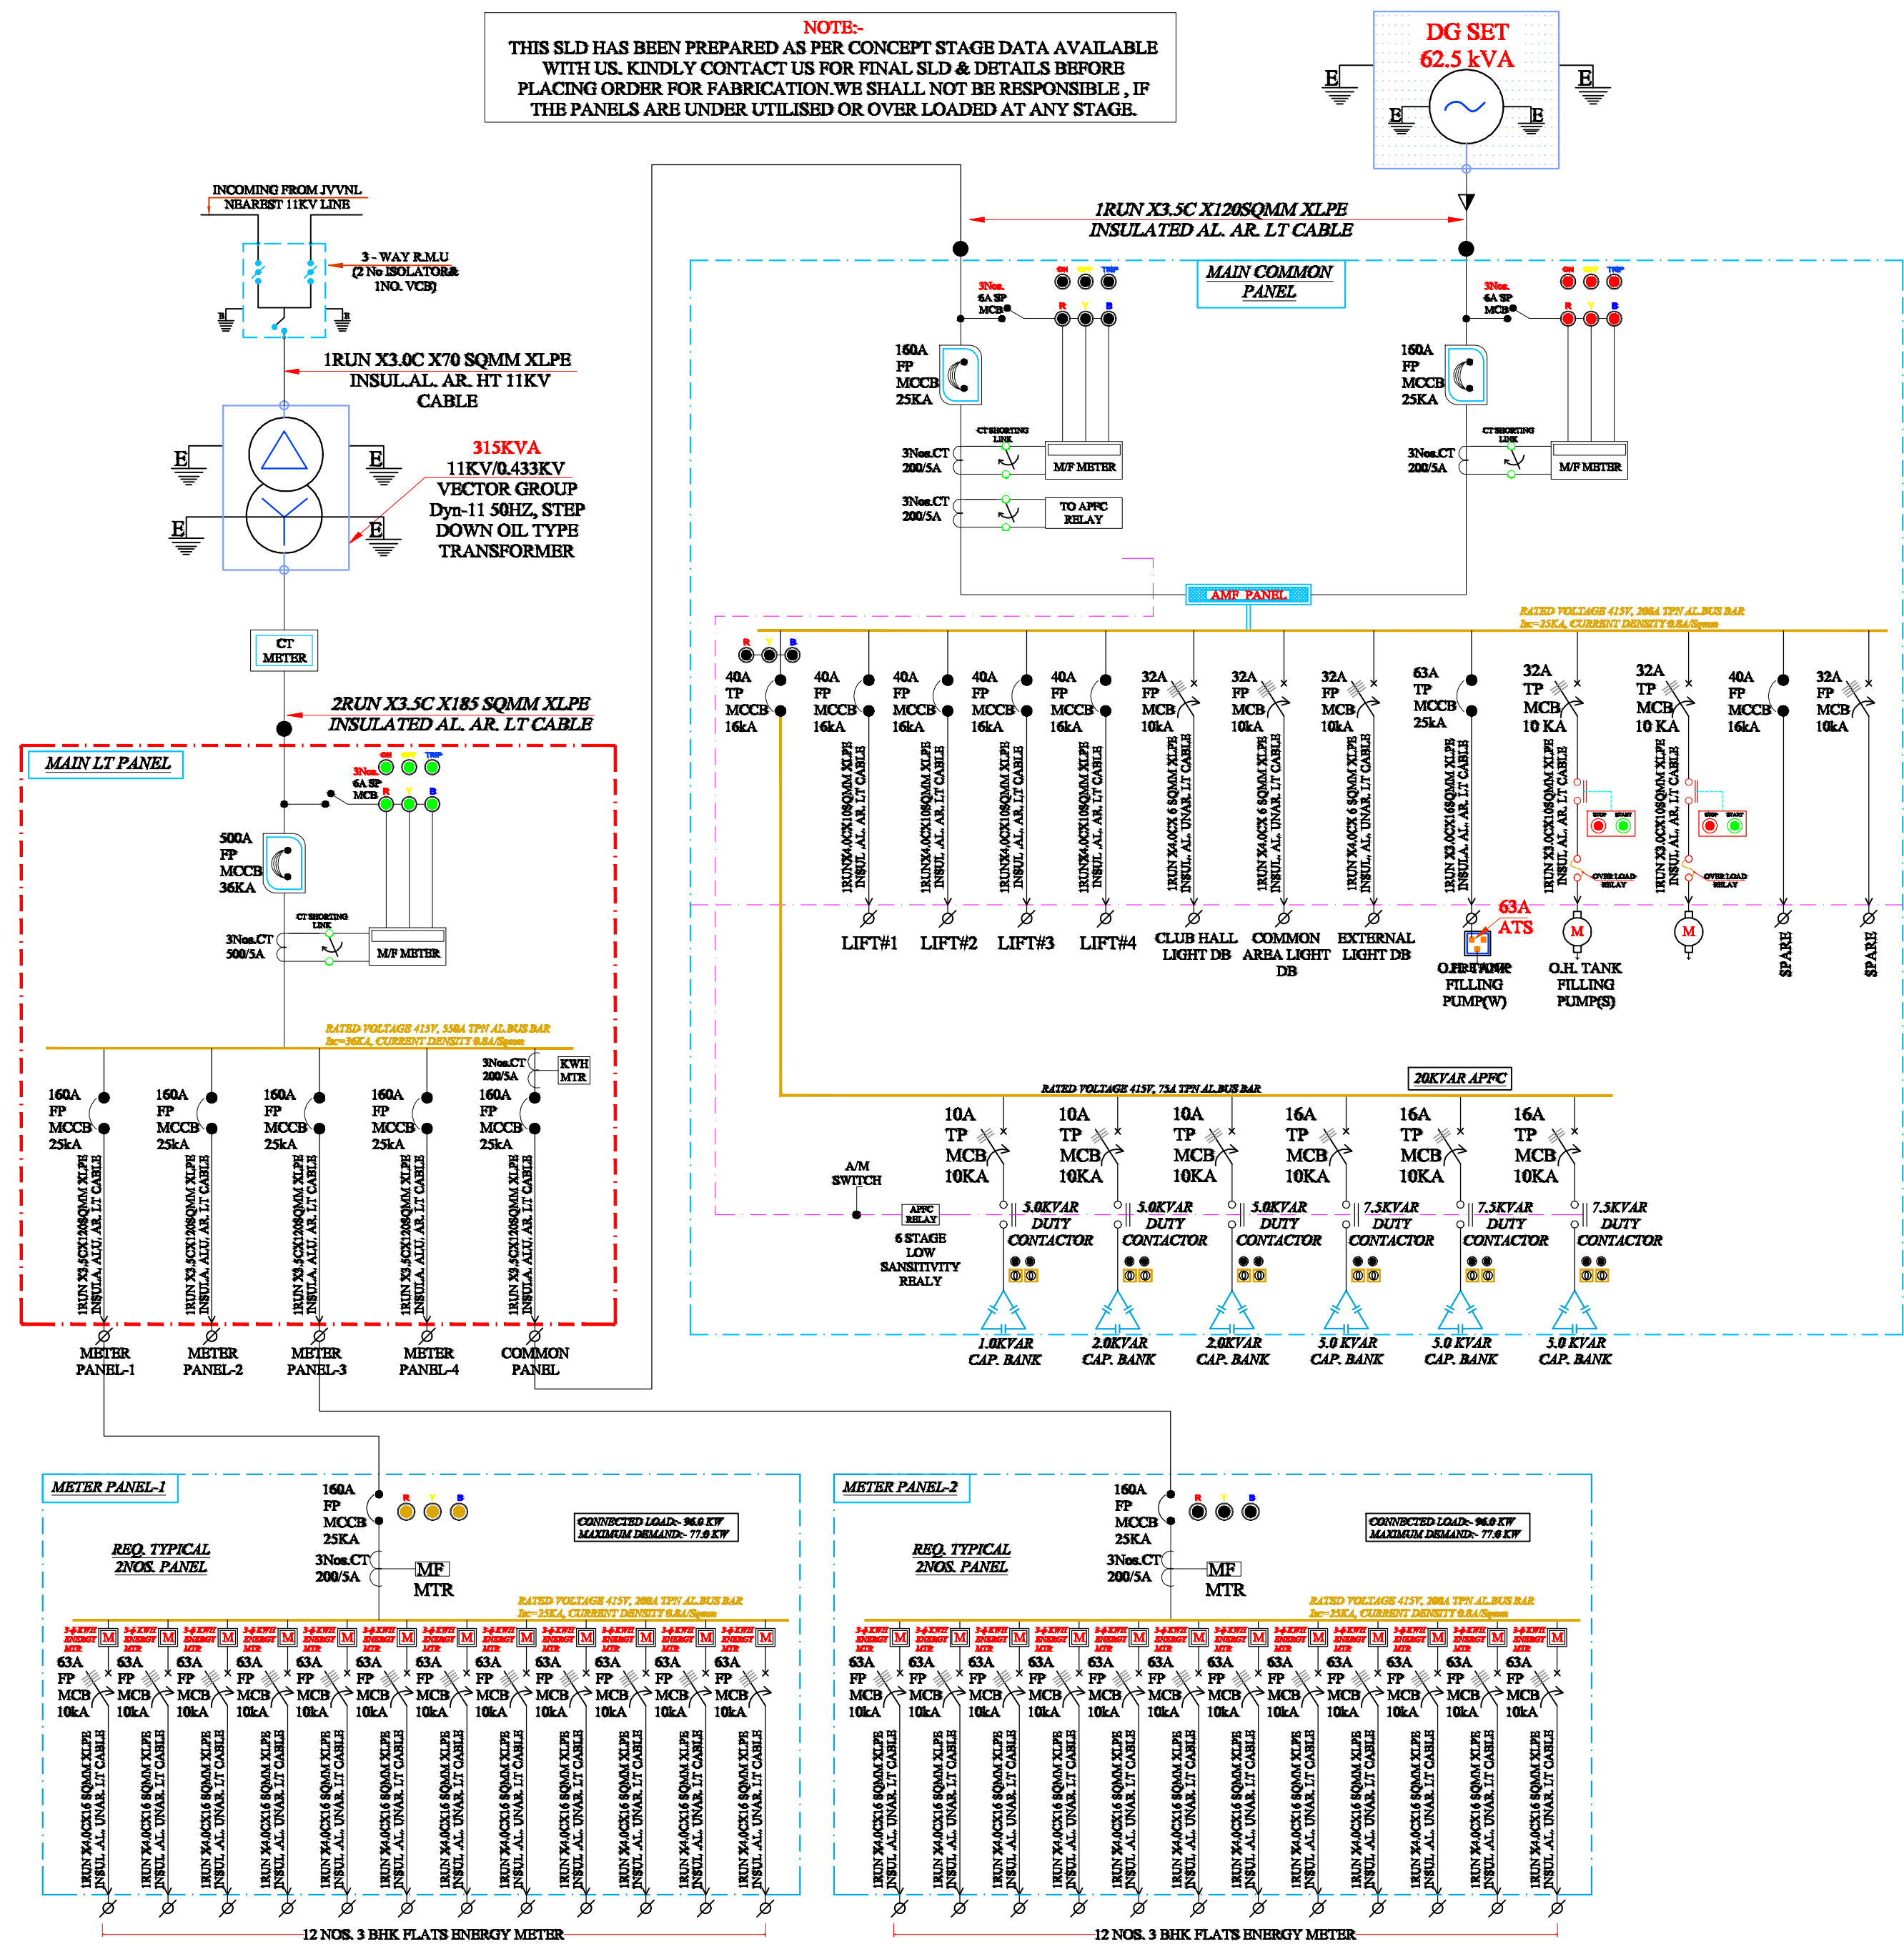

Krishna
KRISHNA KUMAR
B. Tech. (Mechanical)
M.E.P Consultant

For My Dream House
Partner

WARNING

1. This drawing is the sole copyright of Architects VISTAAR and should be used for the purpose expressly issued.

GENERAL NOTES

1. All dimensions are in feet and inches.
2. Do not scale this drawing follow written dimensions only.
3. This drawing should be read in conjunction with other architectural and structural drawings.
4. Any discrepancy in the drawing should be immediately brought to the notice of architect.

PROJECT TITLE

PROJECT:-
SUNRISE WESTWAY HEIGHTS
BUILDING AT PLOT NO.-32E &
32F, WESTWAY HEIGHTS (TRUCK
TERMINAL), VILL. KESHOPURA, ASARPURA
, BHANKROTA, JAIPUR

DRAWING TITLE

ALL DISTRIBUTION PANEL SINGLE LINE
DIAGRAM

ARCHITECTS :

VISTAAR ARCHITECTS & PLANNERS

Architects :: Interior Designers
B-2/12, Chitrkoot scheme,
main Gandhi Path, Opp mall of jaipur, Jaipur-21
Email-Vistaararchitects.web@gmail.com
PH.- 0141-4116461, 09001010366

PATH :-

DRN.	DATE	REV.	NORTH
SACHIN	26-07-2024		
SCALE	JOB NO.		
N.T.S			