

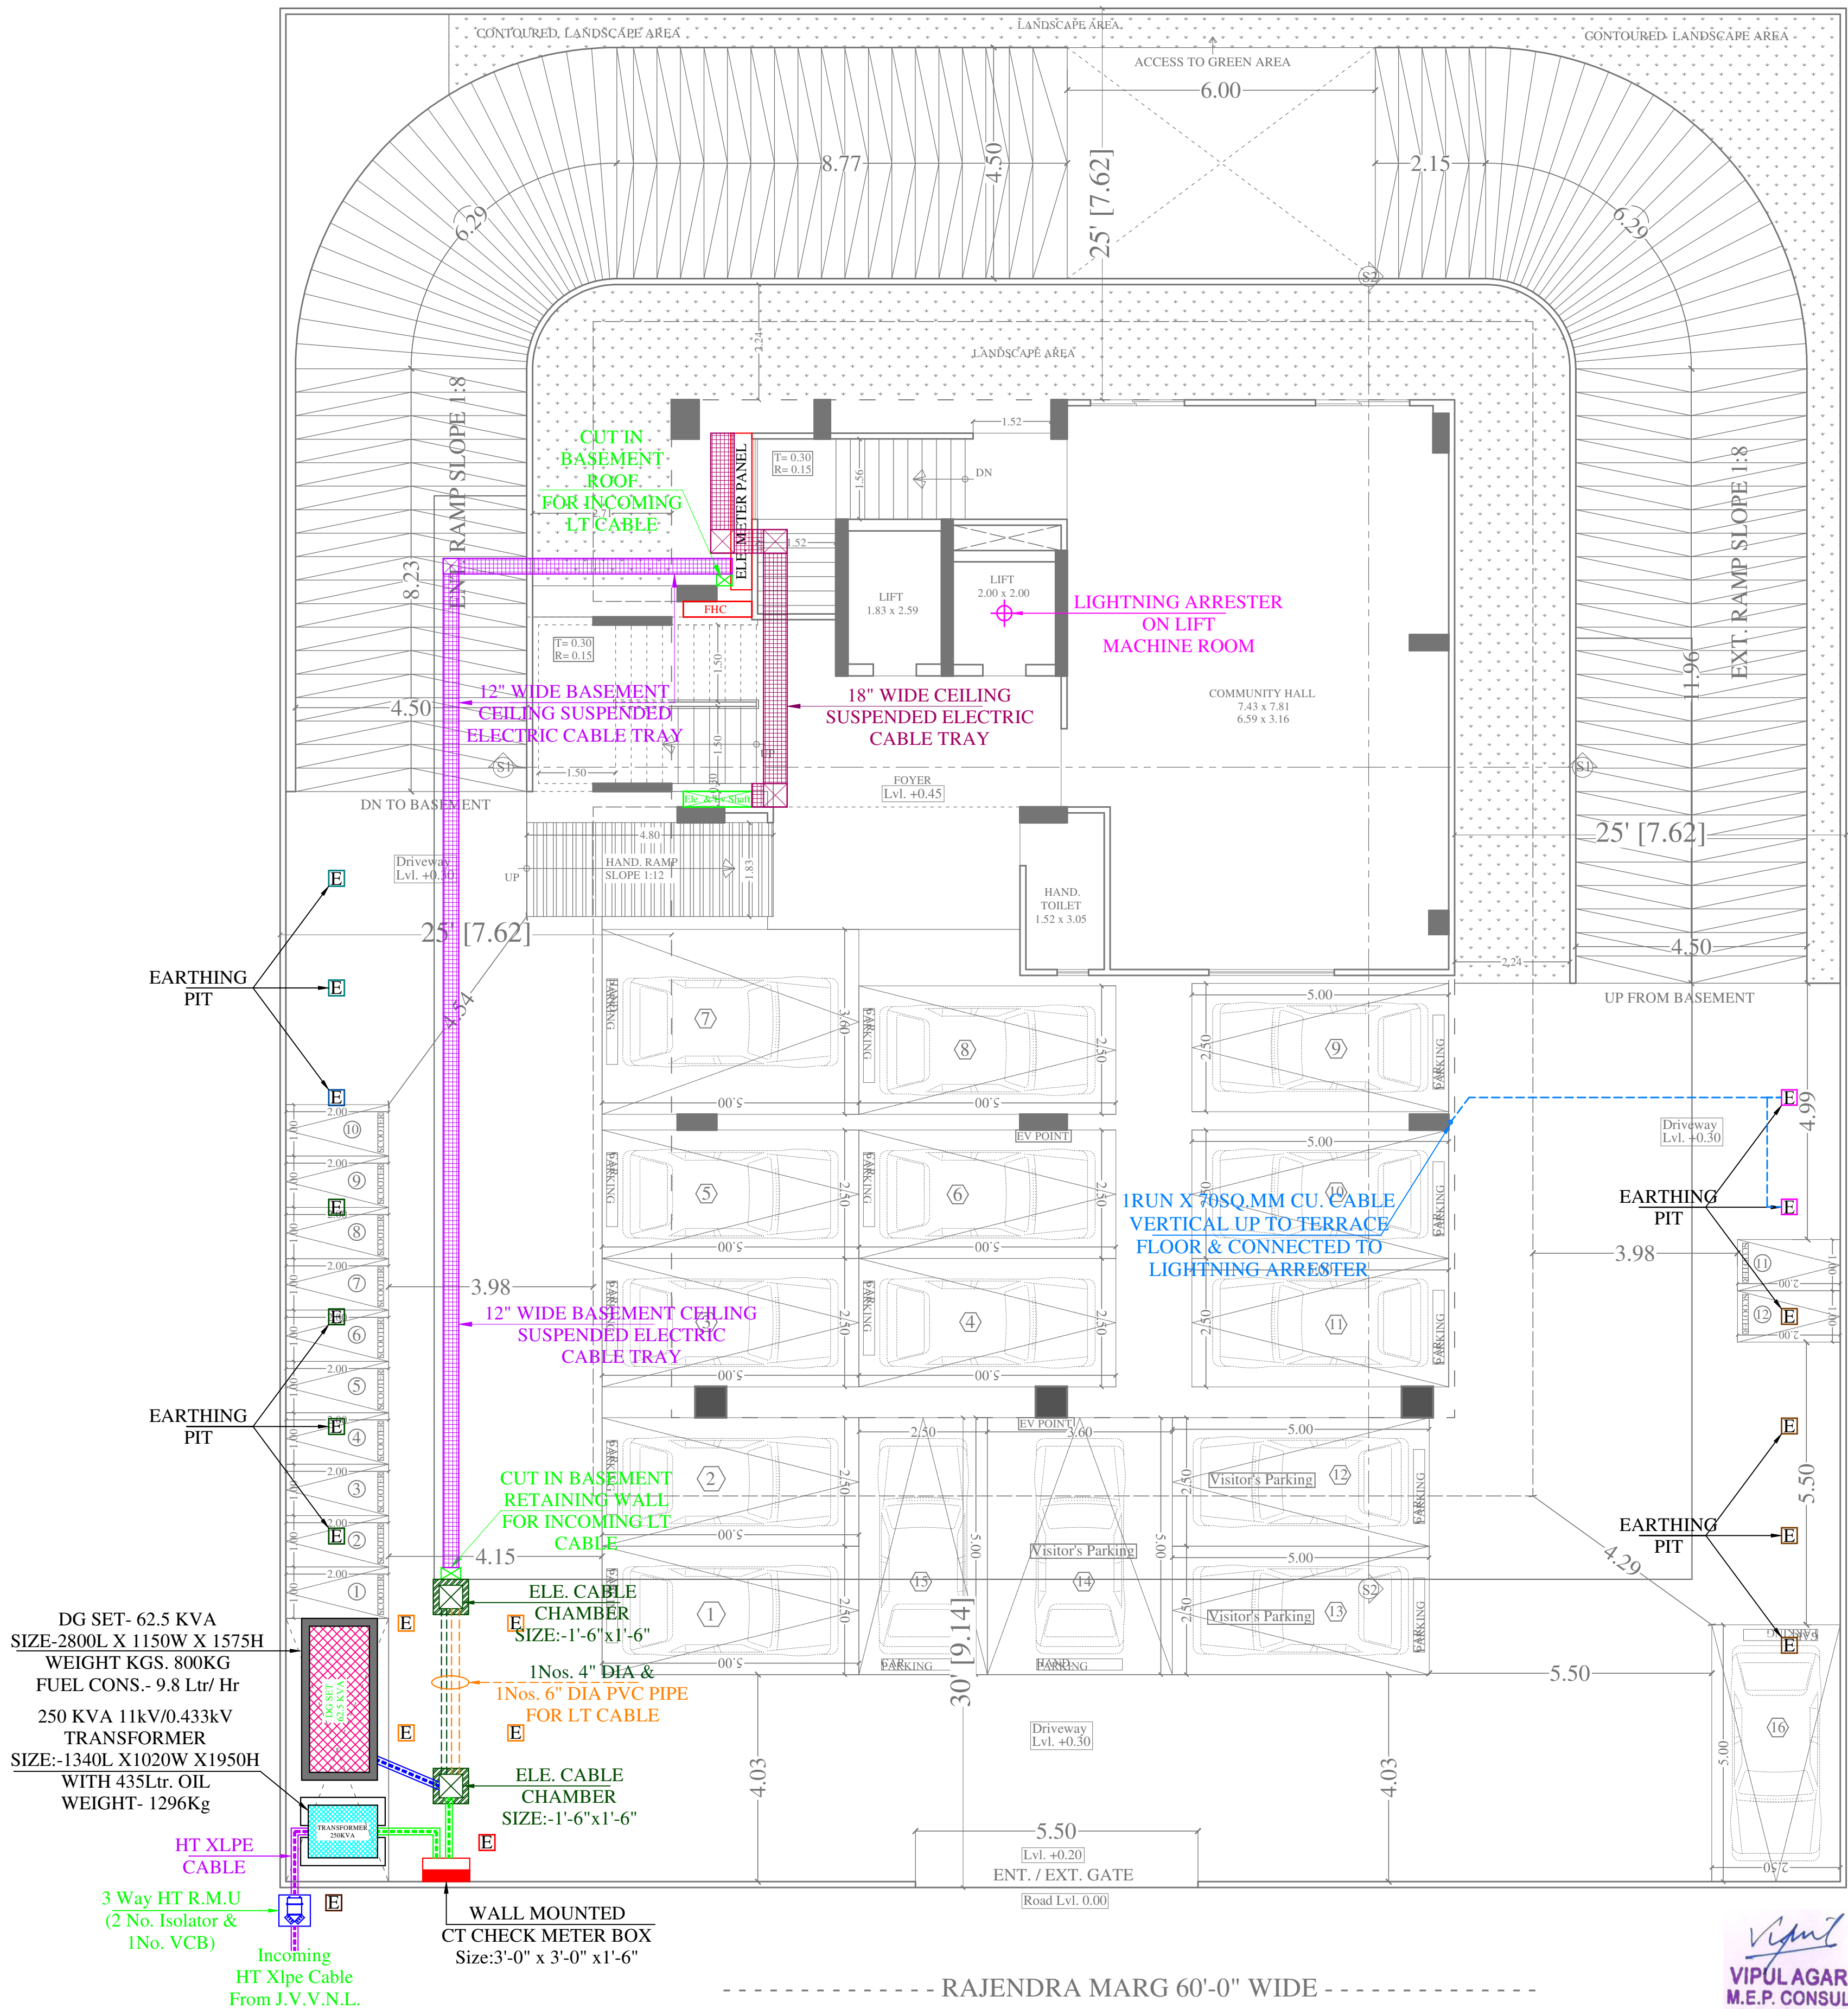


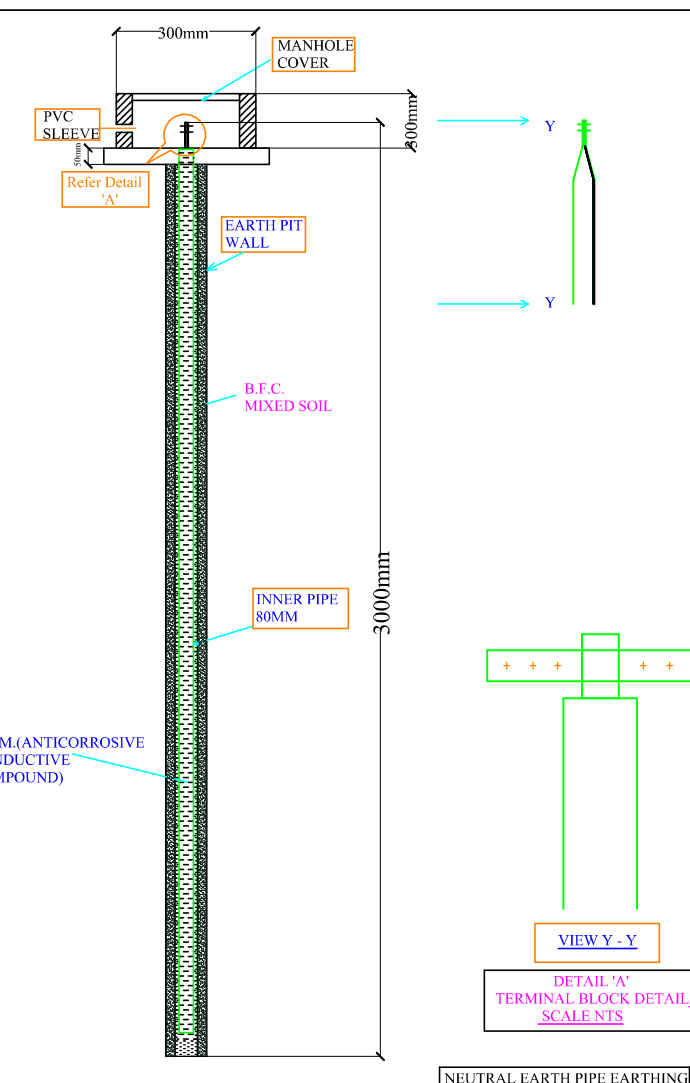

Lightning
Arrester

Model: Stormaster –
ESE - 30 (Level
2/Medium Protection)
(Protection radius - 25M,
Mast Height -2 Mtr)

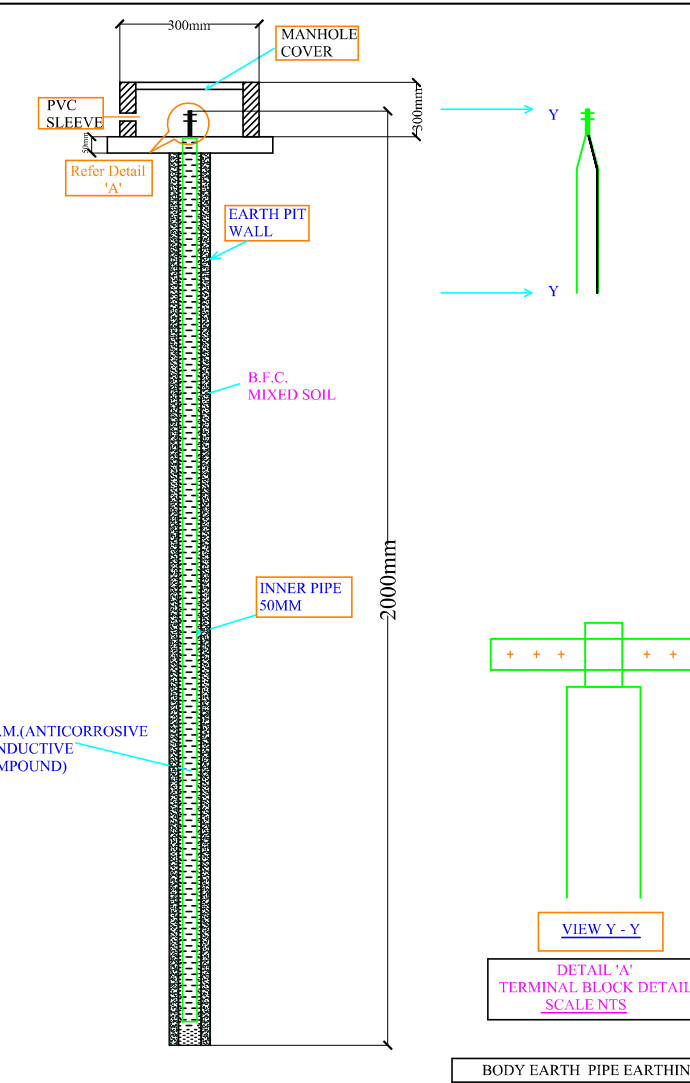

EARTHING DETAILS

01	50MM PIPE(2METER)	3WAY HT RMU BODY EARTH
01	50MM PIPE(2METER)	CT CHECK METER BOX BODY EARTH
02	50MM PIPE(2METER)	TRANSFORMER BODY EARTH
02	80MM PIPE(3METER)	TRANSFORMER NEUTRAL EARTH
02	50MM PIPE(2METER)	DG SET BODY EARTH
02	80MM PIPE(3METER)	DG SET NEUTRAL EARTH
02	50MM PIPE(2METER)	LIGHTNING ARRESTER BODY EARTH
02	50MM PIPE(2METER)	ELECTRIC PANEL BODY EARTH
01	50MM PIPE(2METER)	TELEPHONE EXCH. BODY EARTH
04	50MM PIPE(2METER)	LIFT PANEL BODY EARTH

NOTES:
1. ALL NEUTRAL EARTHS TO BE CONNECTED 50 X 3
GI EARTH STRIP FROM EARTH PIT TO EQUIPMENT.
2. ALL BODY EARTHS TO BE CONNECTED
25 X 3 GI EARTH STRIP FROM EARTH PIT TO
EQUIPMENT.

SERVICE CONSULTANT

ASHI ASSOCIATES

F 9 / 440 , Keshav Marg Chitrakut Scheme,Jaipur
PH:91-0-93146-10438 ,0141-2440946,
Mail:vipul8599@yahoo.com

DEVELOPER NAME:-

PEARL SPYTECH
REALTORS LLP

PROJECT NAME:-


PEARL
PRISTINE

ADDRESS:-

PLOT NO. B-173
RAJENDRA MARG,
BAPU NAGAR, JAIPUR

DRG. TITLE:-

STILT FLOOR ELE. SUB-
STATION, CABLE
ROUTE & LIGHTNING
ARRESTER PLAN

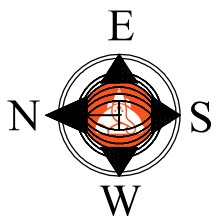


SCALE = 1:100

ARCHITECT :-

SPACE GRID

C-49, VIDYA
APARTMENT, PARAS MARG,
BAPU NAGAR, NEAR JANTA
STORE CIRCLE, JAIPUR-302015
PH-09314918766, 0141-4005506 (O)
Email: info.spacegrid@gmail.com

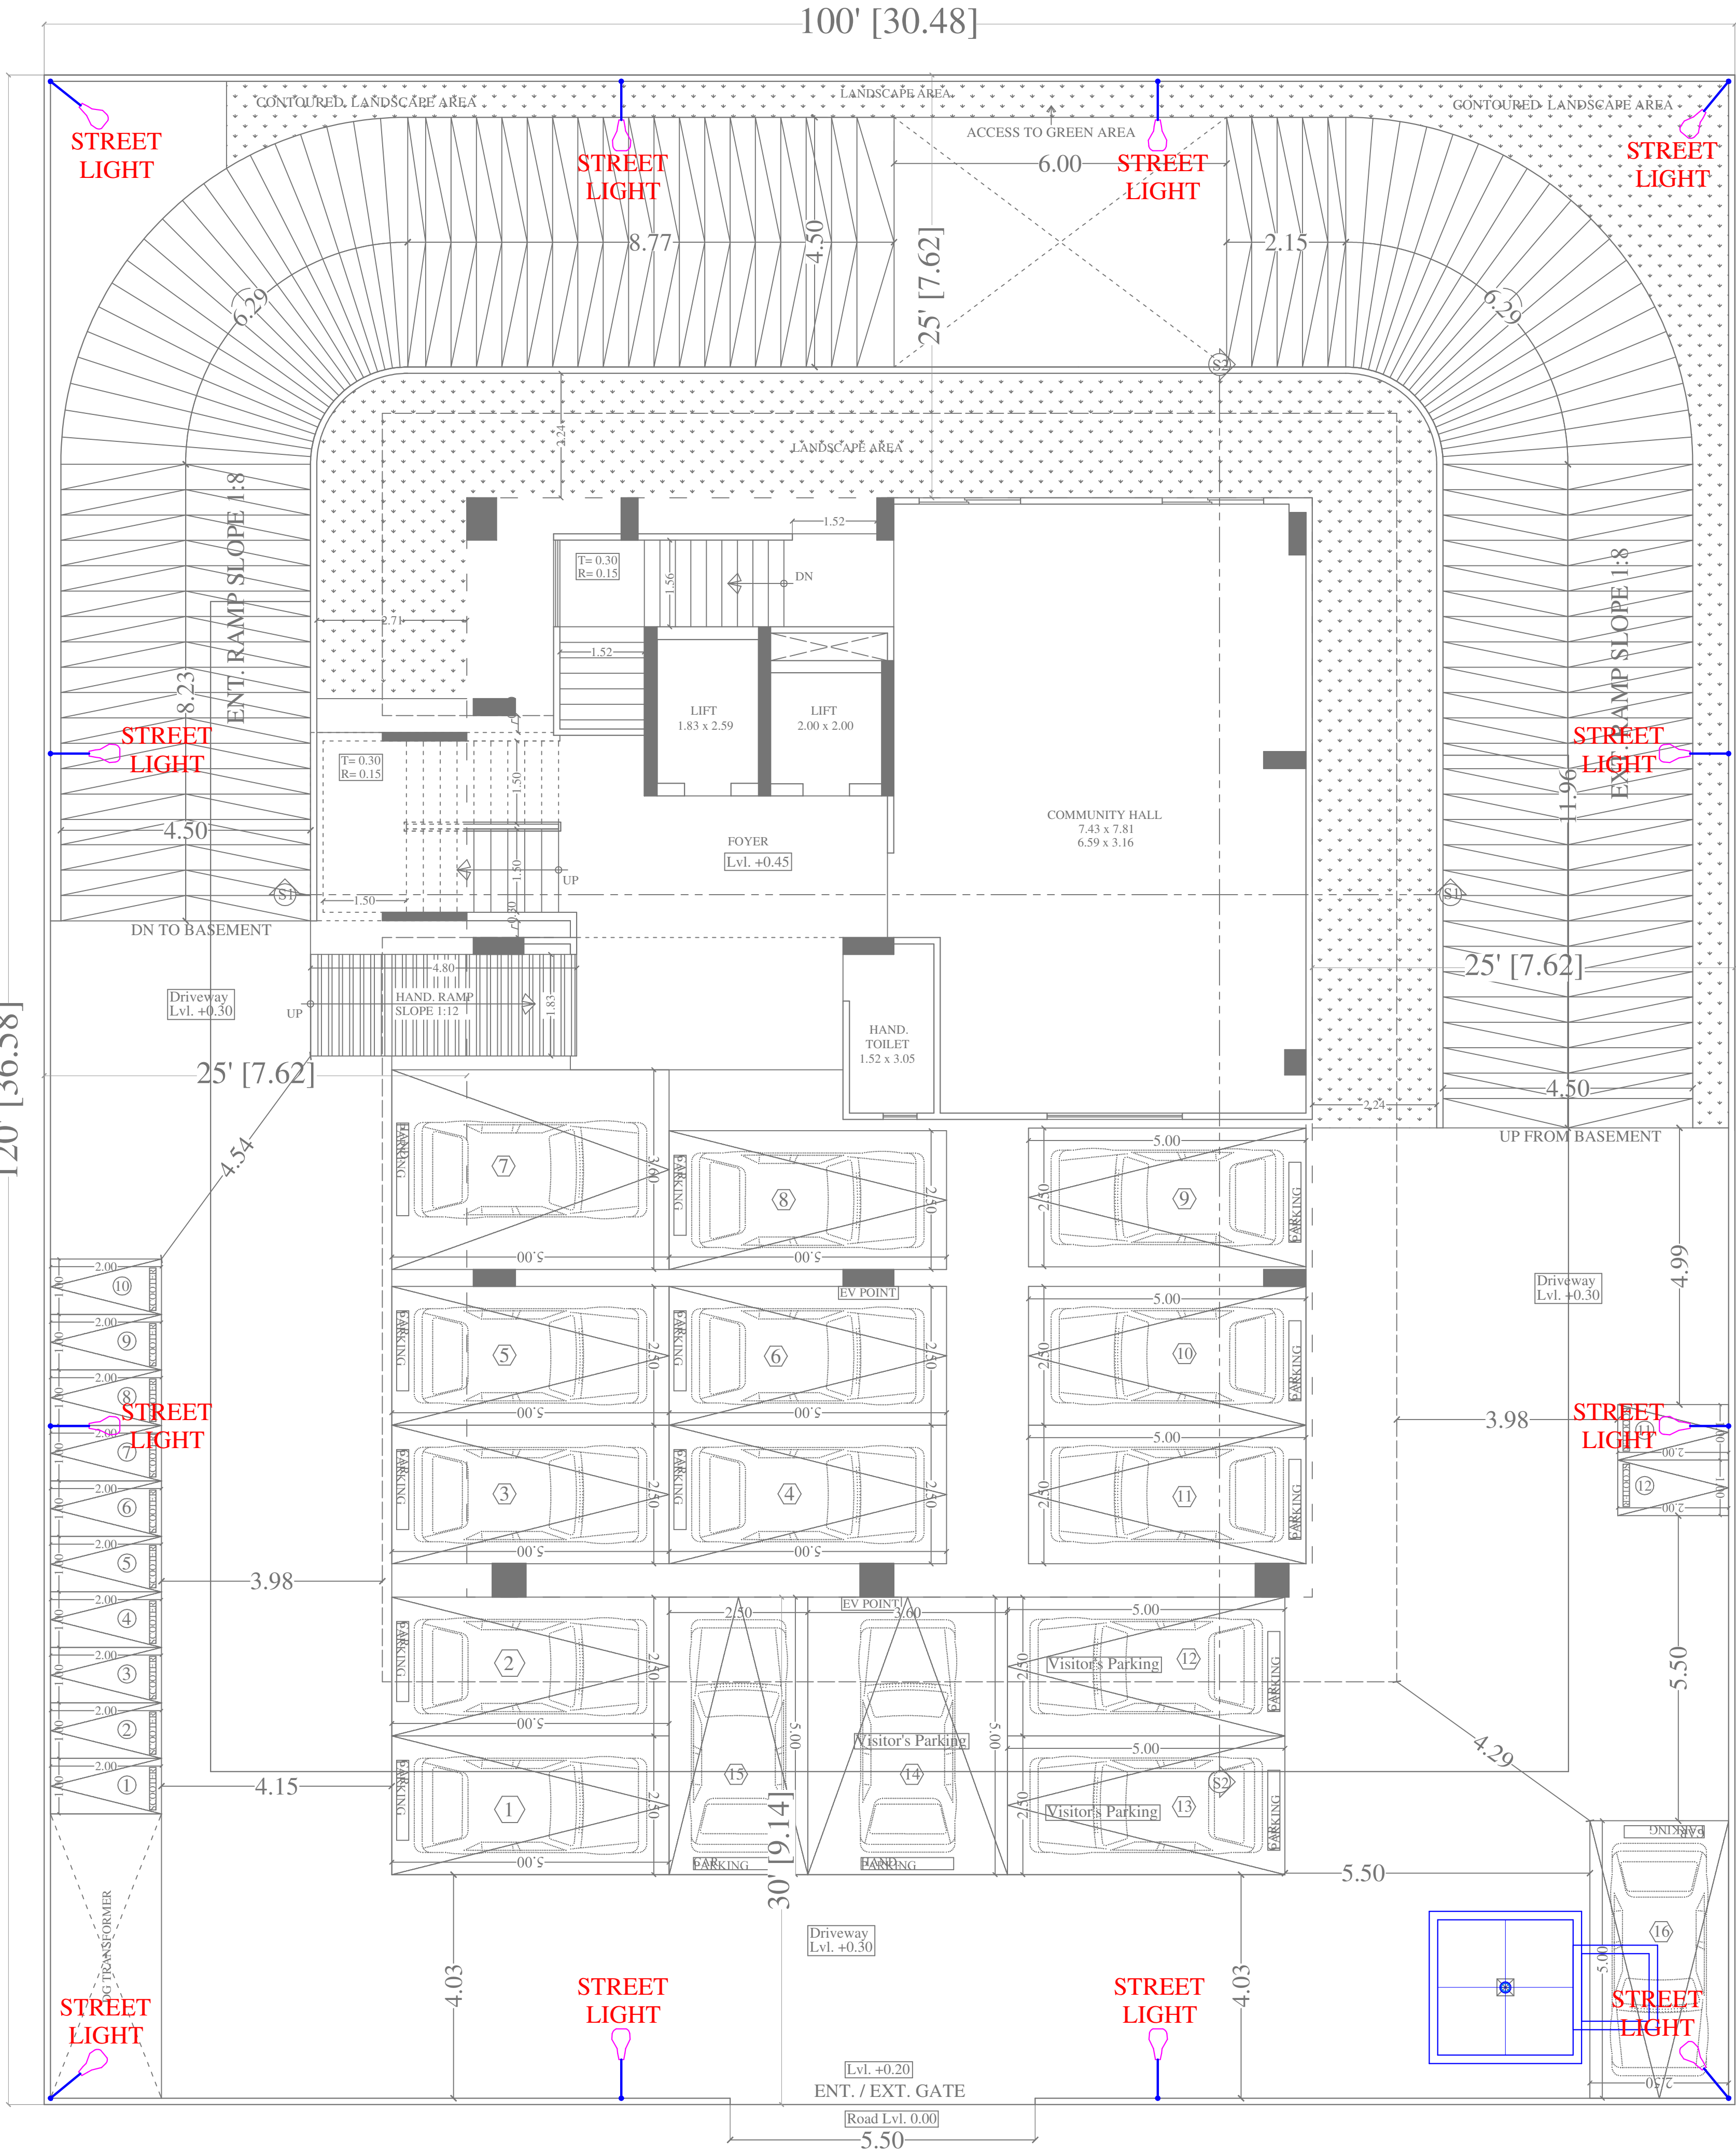

STILT PLAN

RAJENDRA MARG 60'-0" WIDE

Vipul
VIPUL AGARWAL
M.E.P. CONSULTANT
B.E. ELECTRICAL

NOTE:-
ALL EXTERNAL STREET LIGHT
CONTROL BY GUARD ROOM DB

LEGENDS:

Qty.	ID	Symbol	Description
12	PL		STREET LIGHT

SERVICE CONSULTANT
ASHI ASSOCIATES
F 9 / 440 , Keshav Marg Chitrakut Scheme,Jaipur
PH-91-0-93146-10438 ,0141-2440946, Mail:vipul8599@yahoo.com

ARCHITECT :-
SPACE GRID
C-49, VIDYA
APARTMENT, PARAS MARG,
BAPU NAGAR, NEAR JANTA
STORE CIRCLE, JAIPUR-302015
PH-09314918766, 0141-4005506 (O)
Email:-info.spacegrid@gmail.com


DEVELOPER NAME:-
PEARL SPYTECH
REALTORS LLP


PROJECT NAME:-
PEARL PRISTINE

ADDRESS:-
PLOT NO. B-173
RAJENDRA MARG,
BAPU NAGAR, JAIPUR

DRG. TITLE:-
STILT FLOOR
EXTERNAL LIGHTING PLAN

SCALE = 1:100

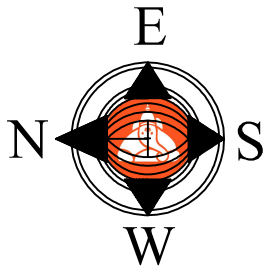

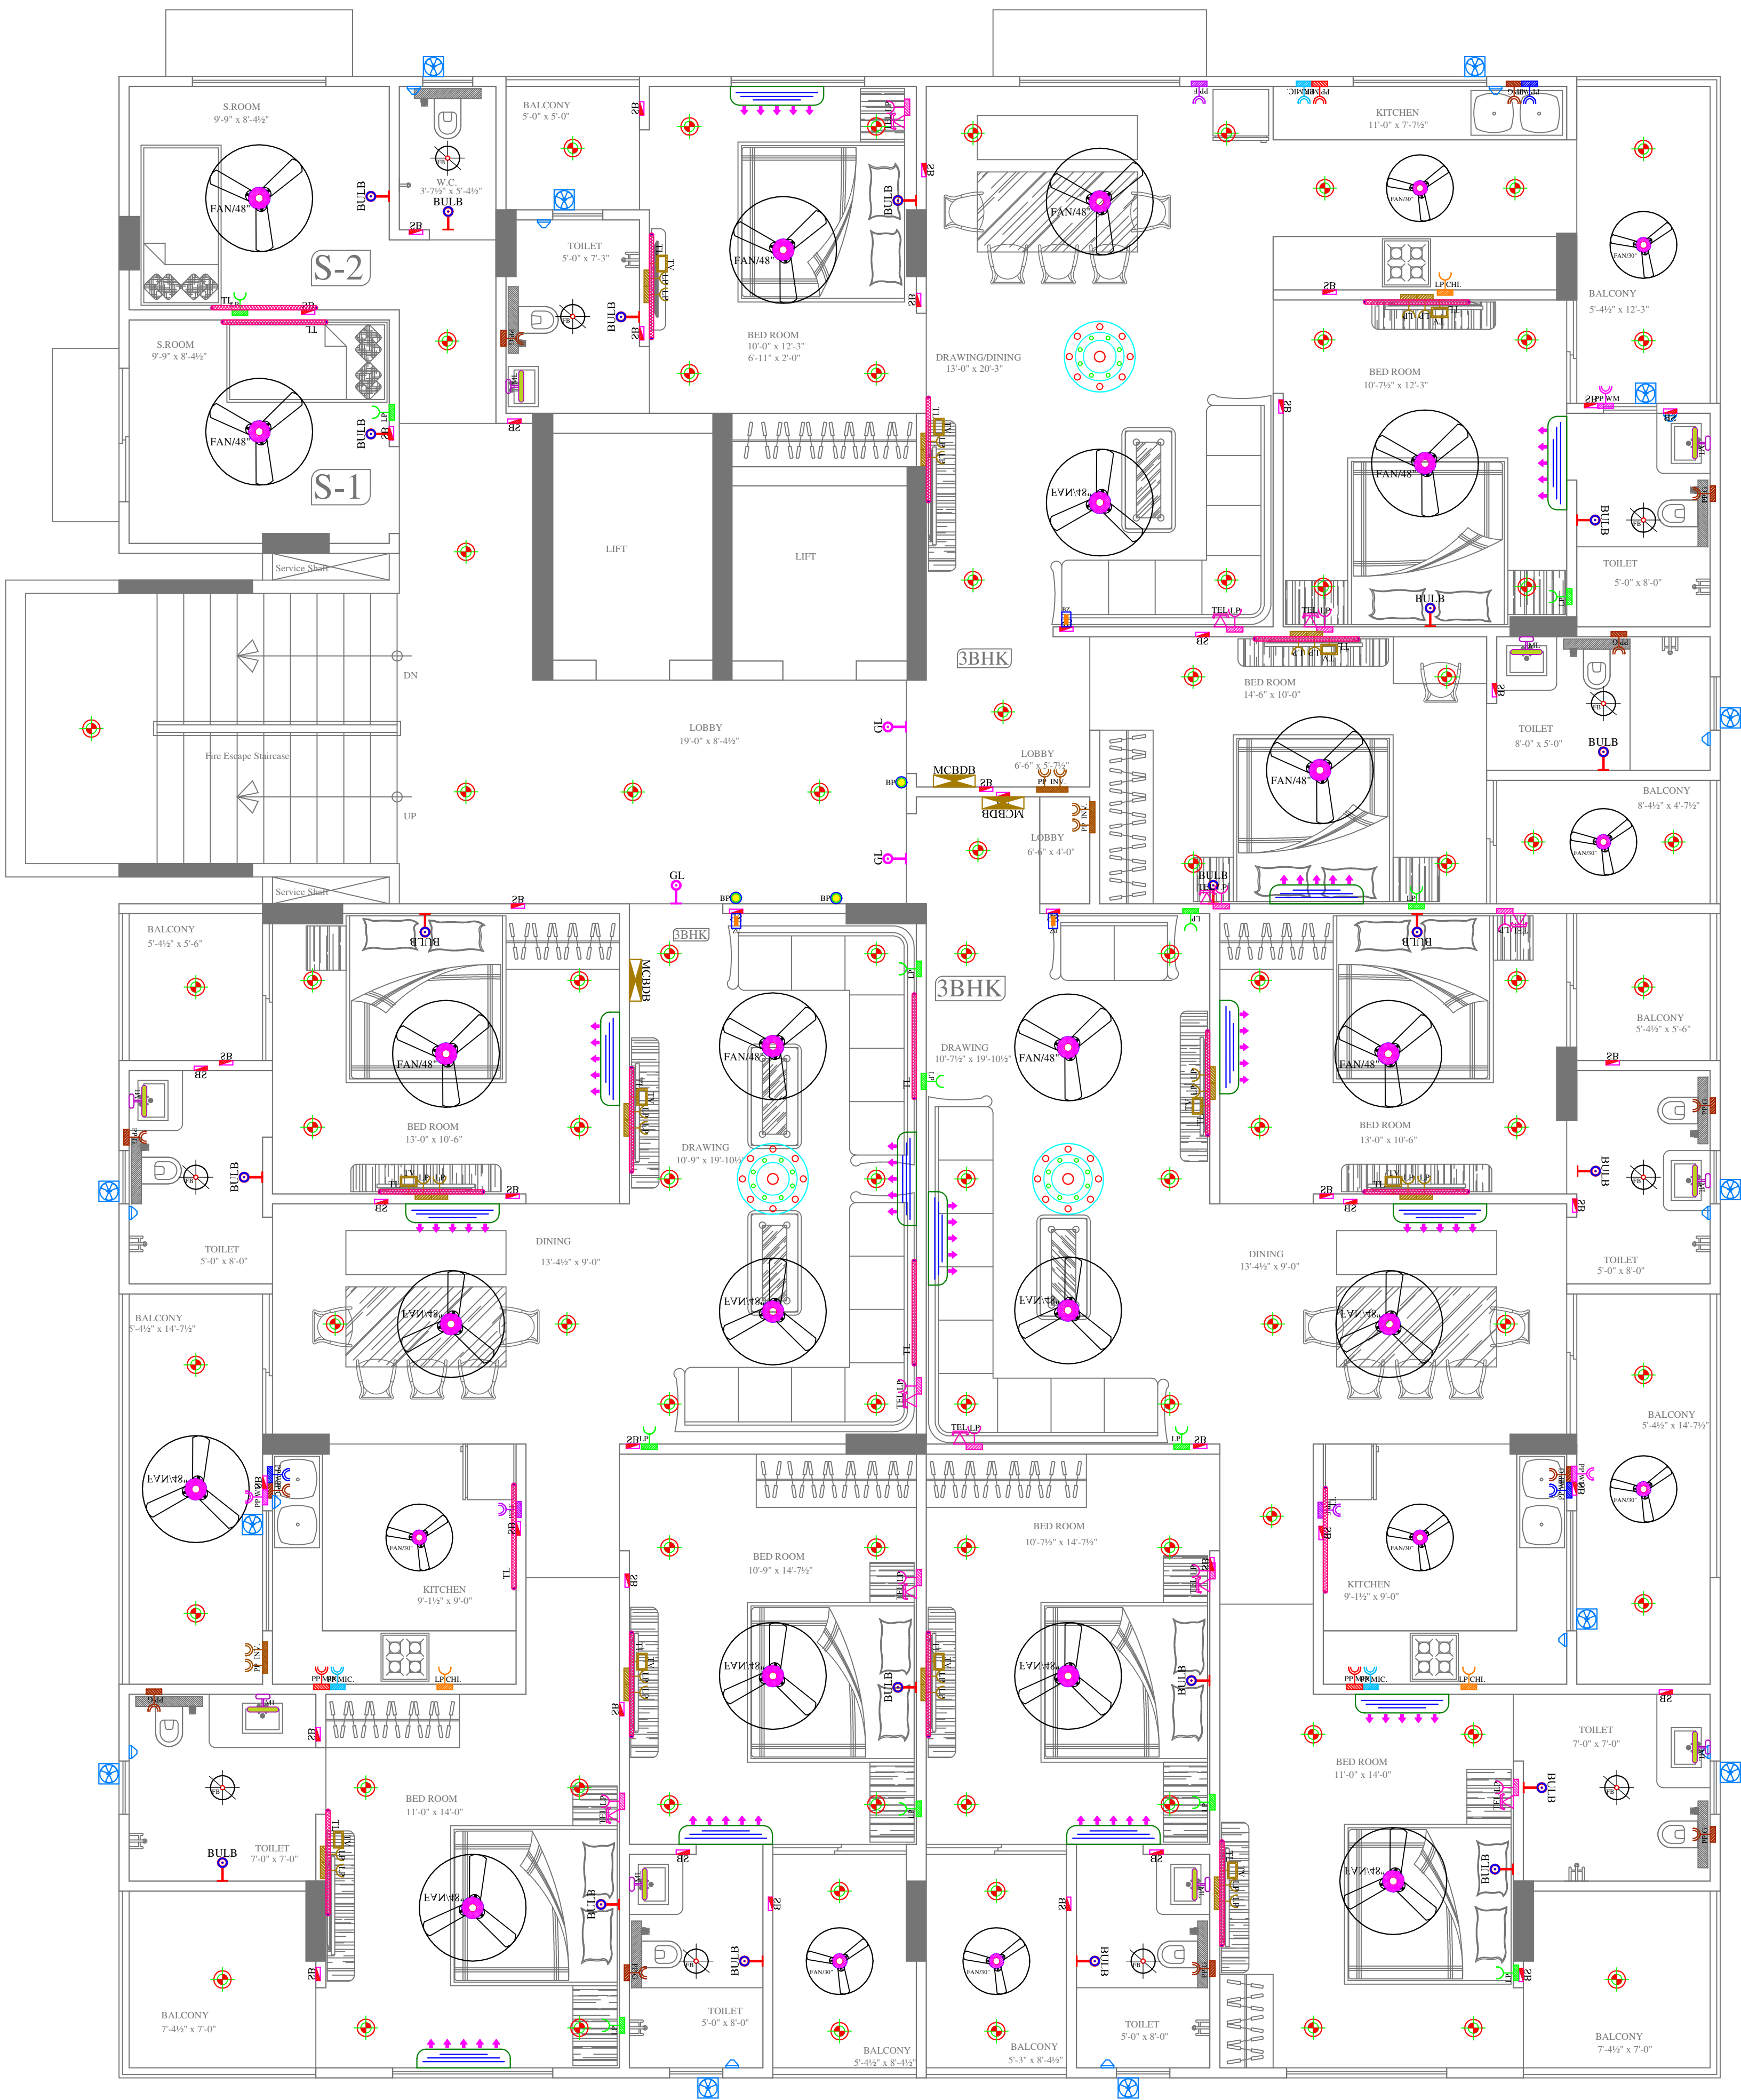

LEGENDS:				
Mounting Height	No.	I D	Symbol	Description
CEILING		FAN/48"		CEILING FAN 48"
CEILING		FAN/30"		CEILING FAN 30"
CEILING		FB		FAN BOX
CEILING		CH1		CHANDELIER
+90"		TLW		Led Wall Tube Light Make:- Syska Led Cat no:- SSK-T3-20W
+90"		BULB		Led Bulb 20W Make:- Syska Led Cat no:- SKC-20W 5.7K/3K
+90"		GL		WALL BRACKETS AS DESIGN FOR GANESH LIGHT
+78"		ML		12x2 Led Mirror Light Make:- Syska Led Cat no:- FPL-12x2
CEILING		DL		Led 6" Down Lighter 20W (Surface Mounted) Make:- Syska Led Cat no:- SDL-15W GLD 6.5K/4K
VENTILATOR HT.		CR		CEILING ROSE
VENTILATOR HT.		EXF		9" DIA FRESH AIR FAN
+42"		SB		SWITCH BOARD
+24"		2WSB		2 WAY SWITCH BOARD
+24"		TEL		TELEPHONE POINT
+24"		LP TEL		6 A PLUG POINT FOR TELEPHONE
+48"		TV		TV COAXIAL POINT
+48"		LP TV		5 A PLUG POINT FOR TV
+24"		LP		6 A PLUG POINT FOR SIDE TABLE
+72"		LP-CH		6 A PLUG POINT FOR CHIMNEY
+90"		SAC		SPLIT AC INDOOR UNIT
+42"		PP-MIX		16 A POWER POINT FOR MIXER
+42"		PP-MIC		16 A POWER POINT FOR MICROWAVE
+78"		PP-G		16 A POWER POINT FOR GEYSER
+54"		PP-F		16 A POWER POINT FOR FRIDGE
+78"		PP-WP		16 A POWER POINT FOR WATER PURIFIER
+48"		PP-WM		16 A POWER POINT FOR WASHING MACHINE
+12"		PP-INV.		16 A POWER POINT FOR INVERTOR
+60"		BP		6 A BELL PUSH
+90"		BZ		BUZZER FOR CALL BELL
+60"		MCB DB		MCB DISTRIBUTION BOARD

SERVICE CONSULTANT

ASHI ASSOCIATES
F 9 / 440 , Keshav Marg Chitrakut Scheme,Jaipur
PH:91-0-93146-10438 ,0141-2440946, Mail:vipul8599@yahoo.com

ARCHITECT :-
SPACE GRID
C-49,VIDYA
APARTMENT,PARAS MARG,
BAPU NAGAR,NEAR JANTA
STORE CIRCLE,
JAIPUR-302015
PH-09314918766,0141-4005506
(6)


DEVELOPER NAME:-
Email:-info.spacegrid@gmail.com
**PEARL SPYTECH
REALTORS LLP**

PROJECT NAME:-
PEARL PRISTINE

ADDRESS:-
**PLOT NO. B-173
RAJENDRA MARG,
BAPU NAGAR, JAIPUR**

DRG. TITLE:-
**TYPICAL (1st TO 4th FLOOR)
ELECTRIC POINT
MARKED PLAN**

SCALE = 1:100

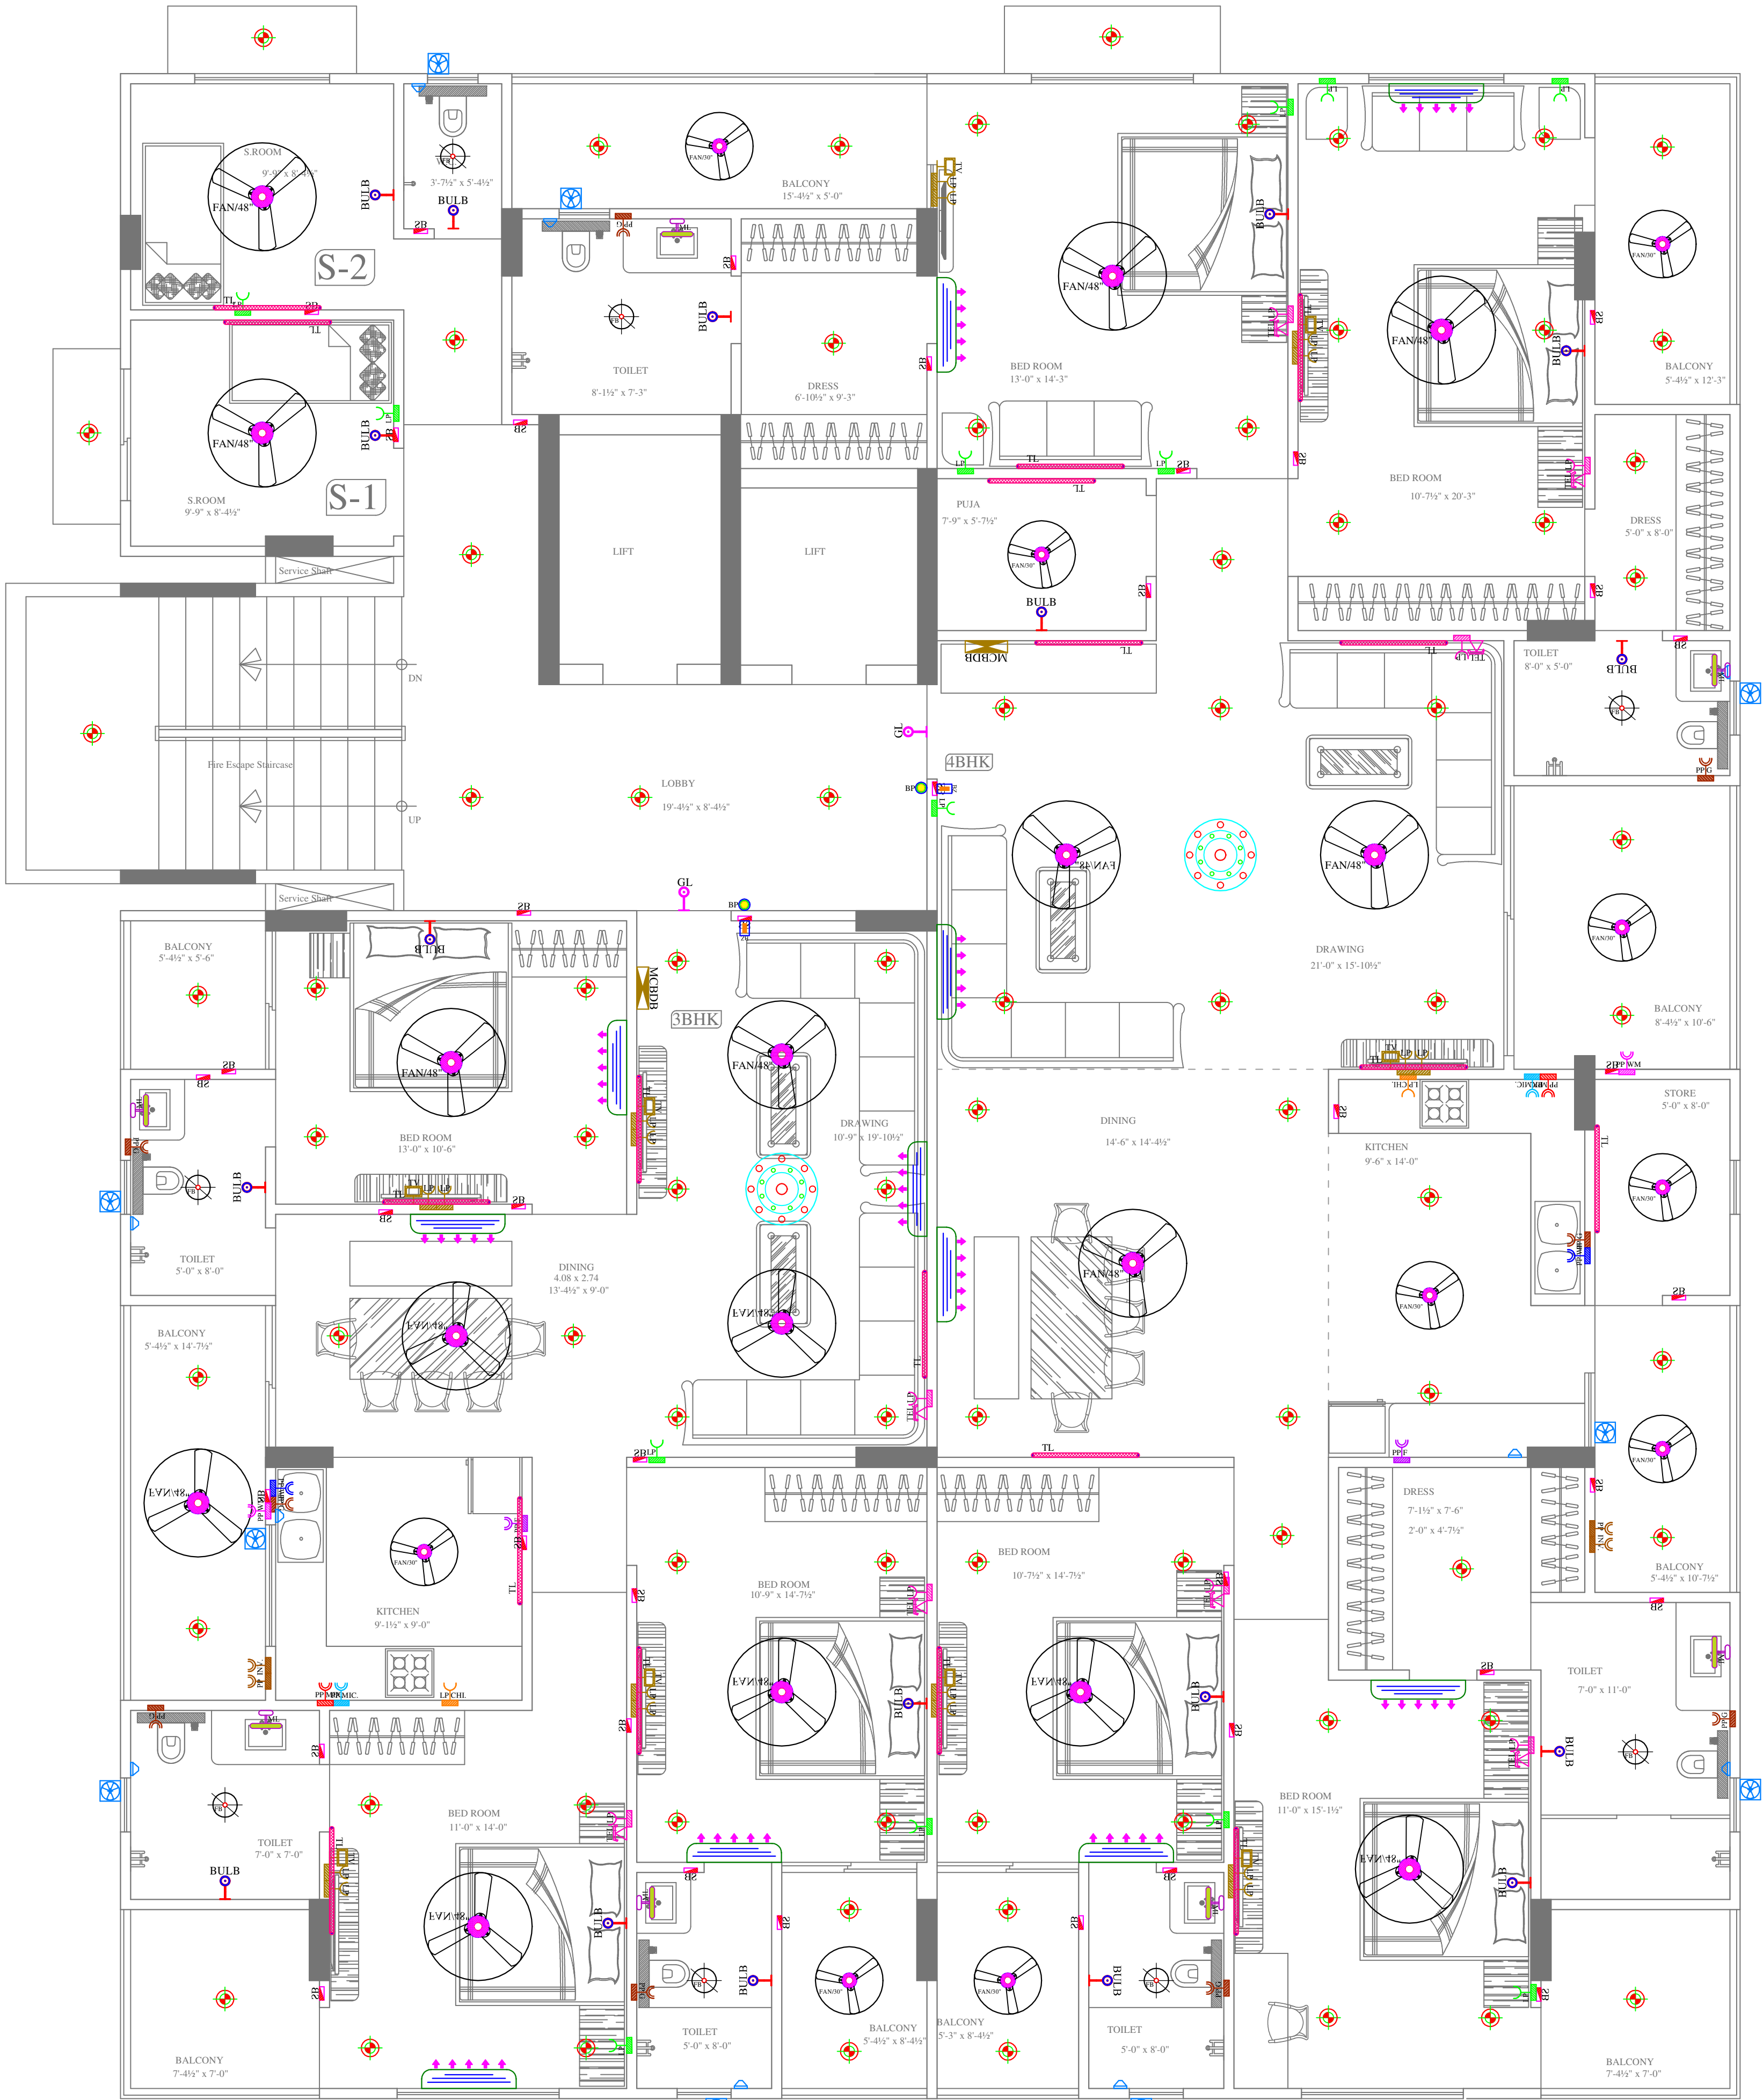

Vipul
VIPUL AGARWAL
M.E.P. CONSULTANT
B.E. ELECTRICAL

LEGENDS:


Mounting Height	No.	ID	Symbol	Description
CEILING		FAN/48"		CEILING FAN 48"
CEILING		FAN/30"		CEILING FAN 30"
CEILING		FB		FAN BOX
CEILING		CH1		CHANDELIER
+90°		TL/W		Led Wall Tube Light Make:- Syoka Led Cat no:- SKC-20W 5.7K/3K
+90°		BULB		Led Bulb 20W Make:- Syoka Led Cat no:- SFL-15W 5.7K/3K
+90°		GL		WALL BRACKETS AS DESIGN FOR GANESH LIGHT
+78°		ML		Led 6" Down Lighter 20W (Surface Mounted) Make:- Syoka Led Cat no:- SDL-15W GLD 6.5K/4K
CEILING		DL		Led 6" Down Lighter 20W (Surface Mounted) Make:- Syoka Led Cat no:- SDL-15W GLD 6.5K/4K
VENTILATOR HT.		CR		CEILING ROSE
VENTILATOR HT.		EXF		9" DIA FRESH AIR FAN
+42°		SB		SWITCH BOARD
+24°		2WSB		2 WAY SWITCH BOARD
+24°		TEL		TELEPHONE POINT
+24°		LP TEL		6 A PLUG POINT FOR TELEPHONE
+48°		TV		TV COAXIAL POINT
+48°		LP TV		5 A PLUG POINT FOR TV
+24°		LP		6 A PLUG POINT FOR SIDE TABLE
+72°		LP-CH		6 A PLUG POINT FOR CHIMNEY
+90°		SAC		SPLIT AC INDOOR UNIT
+42°		PP-MIX		16 A POWER POINT FOR MIXER
+42°		PP-MIC		16 A POWER POINT FOR MICROWAVE
+78°		PP-G		16 A POWER POINT FOR GEYSER
+54°		PP-F		16 A POWER POINT FOR FRIDGE
+78°		PP-WP		16 A POWER POINT FOR WATER PURIFIER
+48°		PP-WM		16 A POWER POINT FOR WASHING MACHINE
+12°		PP-INV.		16 A POWER POINT FOR INVERTOR
+60°		BP		6 A BELL PUSH
+90°		BZ		BUZZER FOR CALL BELL
+60°		MCB DB		MCB DISTRIBUTION BOARD

SERVICE CONSULTANT

ASHI ASSOCIATES

F 9 / 440 , Keshav Marg Chitrakut Scheme,Jaipur
PH:91-0-93146-10438 ,0141-2440946, Mail:vipul8599@yahoo.com

 ARCHITECT :-



SPACE GRID

C-49,VIDYA
APARTMENT,PARAS MARG,
BAPU NAGAR,NEAR JANTA
STORE CIRCLE,
JAIPUR-302015
PH-09314918766,0141-4005506
(9)

DEVELOPER NAME:-
Email:-info.spacegrid@gmail.com

**PEARL SPYTECH
REALTORS LLP**

PROJECT NAME:-

PEARL PRISTINE


ADDRESS:-

**PLOT NO. B-173
RAJENDRA MARG,
BAPU NAGAR, JAIPUR**

DRG. TITLE:-

**TYPICAL (5th TO 9th FLOOR)
ELECTRIC PLAN
MARKED POINT**

SCALE = 1:100

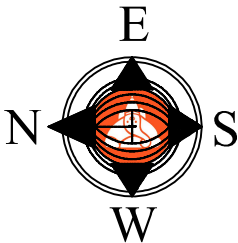

LEGENDS:

Mounting Height	No.	ID	Symbol	Description
CEILING		FAN48"		CEILING FAN 48"
CEILING		FAN30"		CEILING FAN 30"
CEILING		FB		FAN BOX
CEILING		CHI		CHANDELIER
+90°		TL/W		Led Wall Tube Light Make:- Syska Led Cat no:- SKK-T5-20W
+90°		BULB		Led Bulb 20W Make:- Syska Led Cat no:- SKC-20W 5.7K/3K
+90°		GL		WALL BRACKETS AS DESIGN FOR GANESH LIGHT
+78°		ML		12x2 Led Mirror Light Make:- Syska Led Cat no:- FPL-12x2
CEILING		DL		Led Down Lighter 20W (Surface Mounted) Make:- Syska Led Cat no:- SGL-15W GLD 6.5K/4K
VENTILATOR HT.		CR		CEILING ROSE
VENTILATOR HT.		EXF		9" DIA FRESH AIR FAN
+42°		SB		SWITCH BOARD
+24°		2WSB		2 WAY SWITCH BOARD
+24°		TEL		TELEPHONE POINT
+24°		LP TEL		6 A PLUG POINT FOR TELEPHONE
+48°		TV		TV COAXIAL POINT
+48°		LP TV		6 A PLUG POINT FOR TV
+24°		LP		6 A PLUG POINT FOR SIDE TABLE
+72°		LP-CH		6 A PLUG POINT FOR CHIMNEY
+90°		SAC		SPLIT AC INDOOR UNIT
+42°		PP-MIX		16 A POWER POINT FOR MIXER
+42°		PP-MIC		16 A POWER POINT FOR MICROWAVE
+78°		PP-G		16 A POWER POINT FOR GEYSER
+54°		PP-F		16 A POWER POINT FOR FRIDGE
+78°		PP-WP		16 A POWER POINT FOR WATER PURIFIER
+48°		PP-WM		16 A POWER POINT FOR WASHING MACHINE
+12°		PP-INV.		16 A POWER POINT FOR INVERTER
+60°		BP		6 A BELL PUSH
+90°		BZ		BUZZER FOR CALL BELL
+60°		MCB DB		MCB DISTRIBUTION BOARD

SERVICE CONSULTANT

ASHI ASSOCIATES
F 9 / 440 , Keshav Marg Chitrukut Scheme,Jaipur
PH-91-0-93146-10438 ,0141-2440946, Mail:vipul8599@yahoo.com

ARCHITECT :-

SPACE GRID
C-49,VIDYA
APARTMENT,PARAS MARG,
BAPU NAGAR,NEAR JANTA
STORE CIRCLE,
JAIPUR-302015
PH-09314918766,0141-4005506

DEVELOPER NAME:-
Email:-info.spacegrid@gmail.com
PEARL SPYTECH
REALTORS LLP

PROJECT NAME:-

PEARL PRISTINE


ADDRESS:-


PLOT NO. B-173
RAJENDRA MARG,
BAPU NAGAR, JAIPUR

DRG. TITLE:-

10th FLOOR
ELECTRIC POINT
MARKED PLAN

SCALE = 1:100

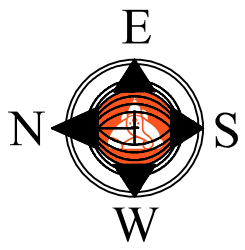

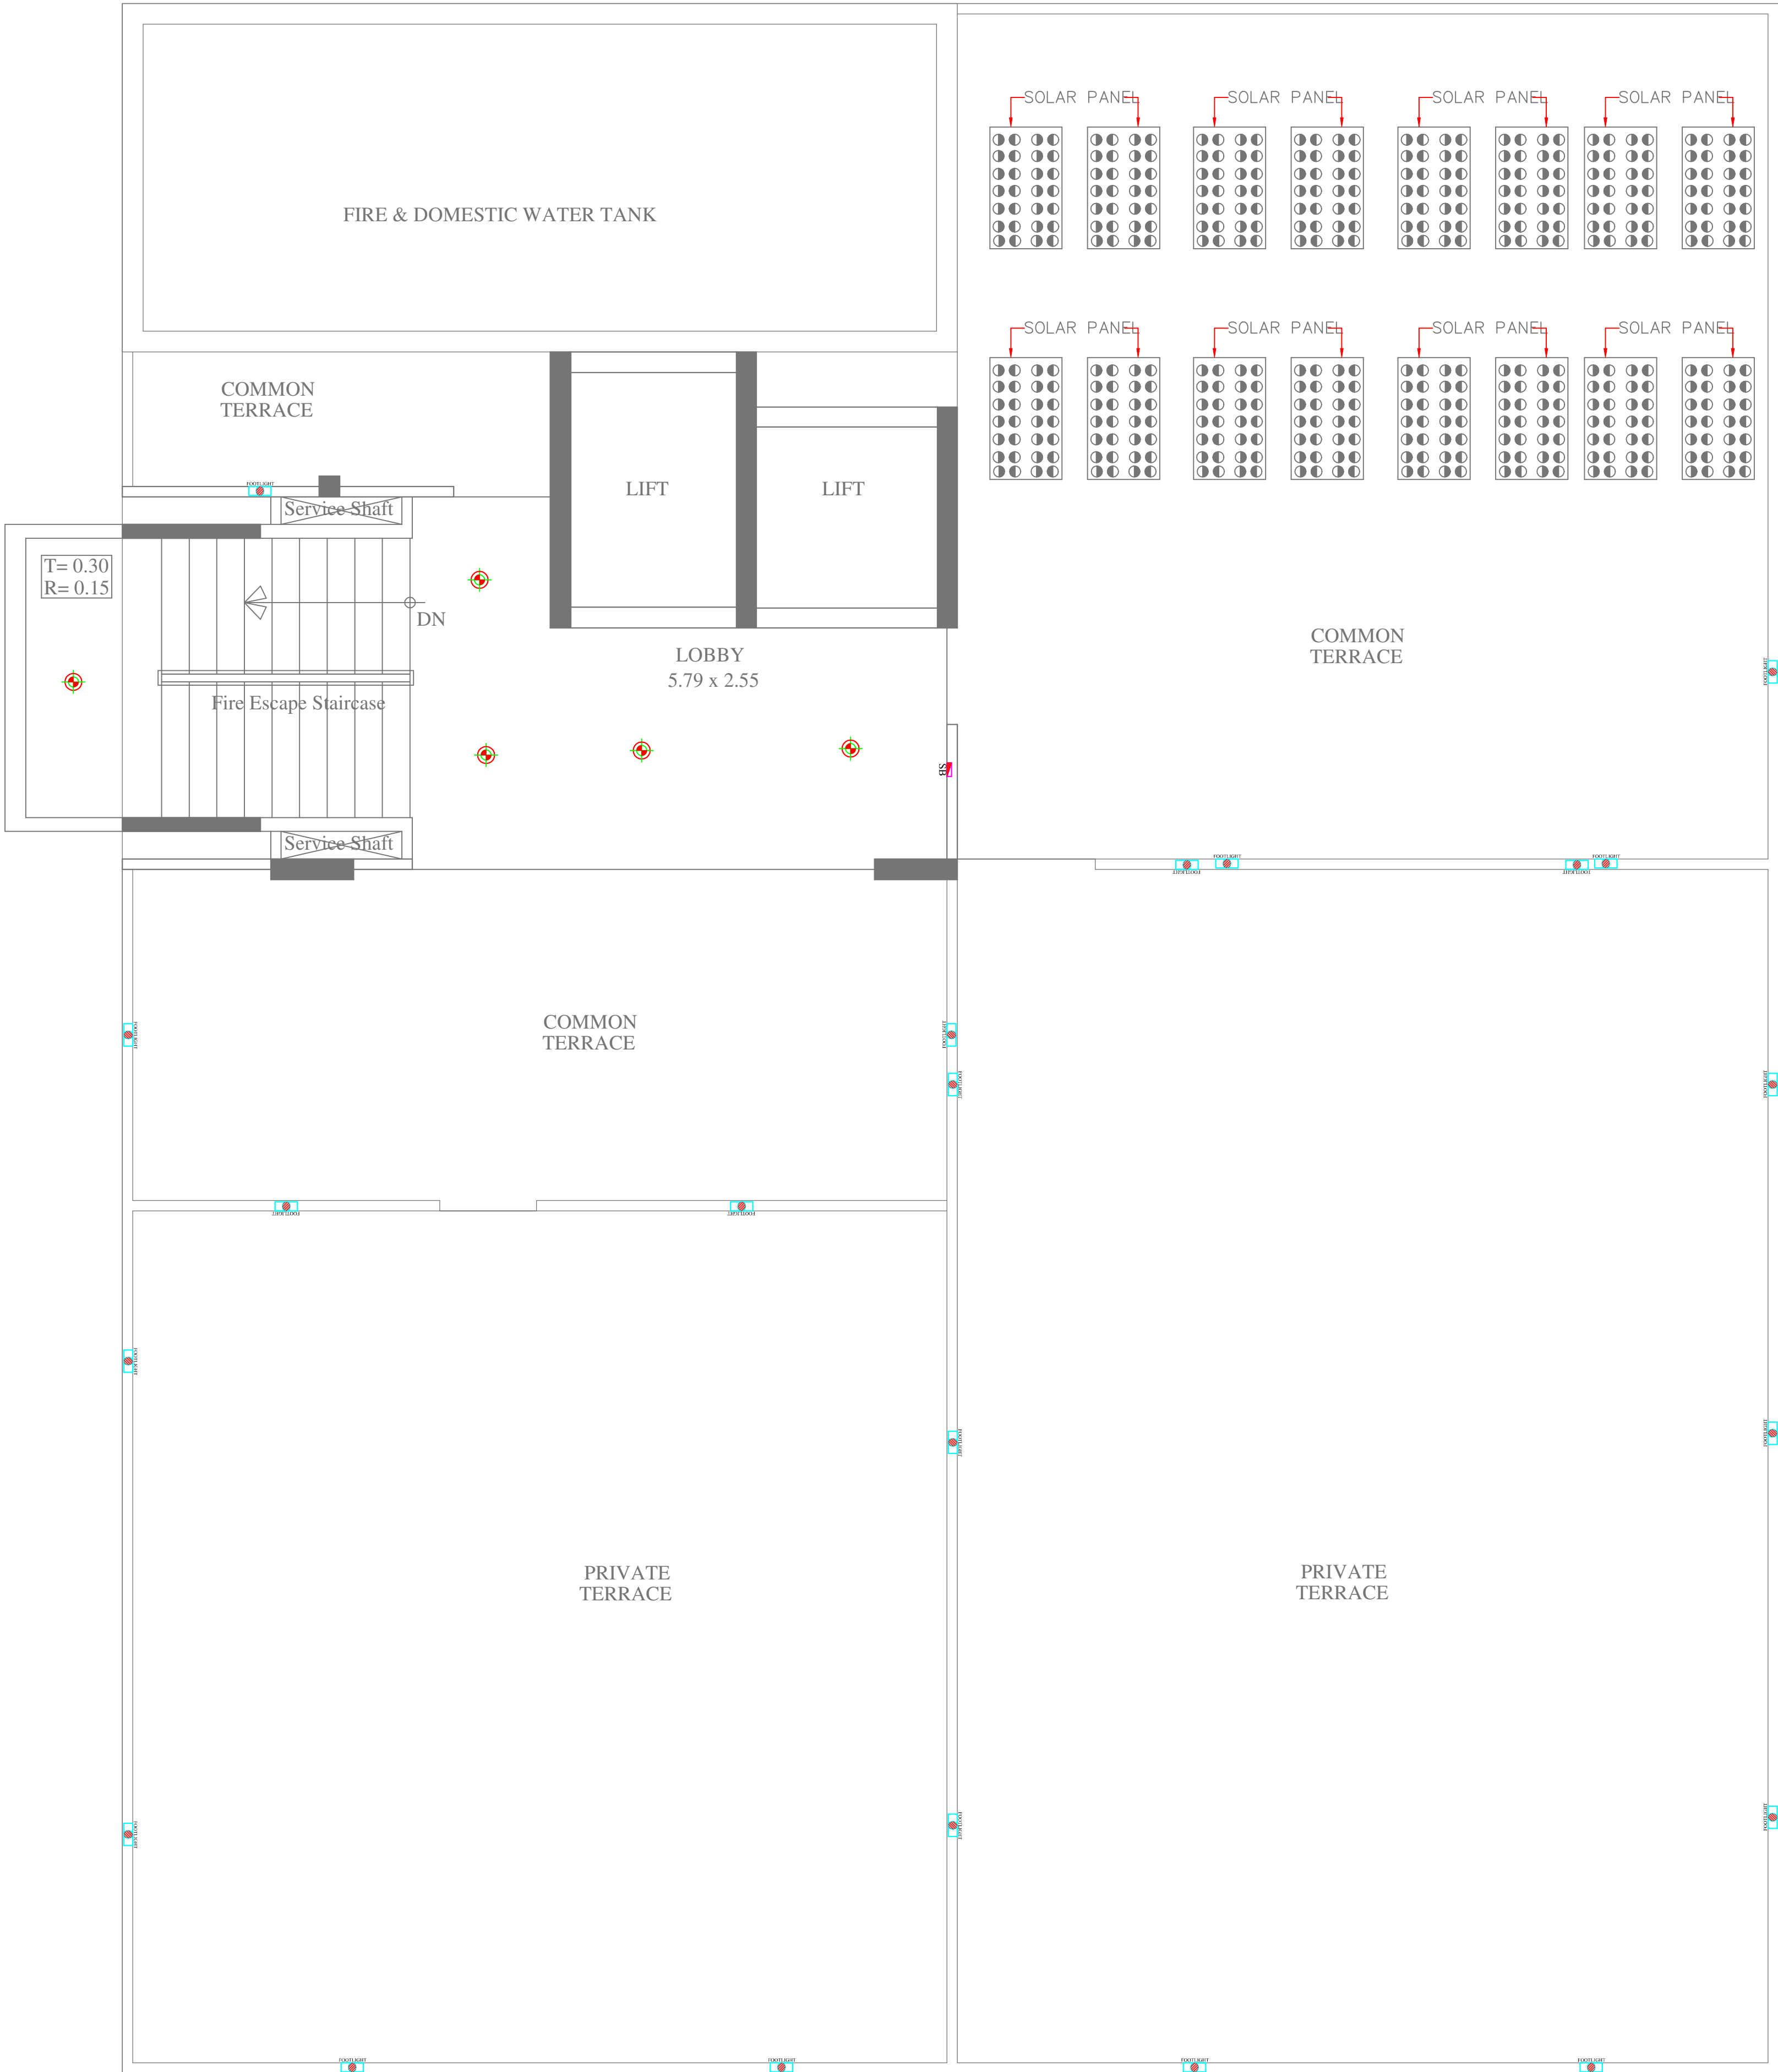

Vipul
VIPUL AGARWAL
M.E.P. CONSULTANT
B.E. ELECTRICAL

LEGENDS:				
Mounting Height	No.	I D	Symbol	Description
CEILING		DL		LED 6' DOWN LIGHTER 20W (SURFACE MOUNTED) MAKE:- SYKA LED CAT NO:- SDL-15W GLD 6.5K/4K
+42"		SB		SWITCH BOARD
+18"		FL		FOOT LIGHT

SERVICE CONSULTANT
ASHI ASSOCIATES
F-9 /440 , Keshav Marg Chitrakut Scheme,Jaipur
PH:91-0-93146-10438 ,0141-2440946, Mail: vipul8599@yahoo.com

ARCHITECT :-
SPACE GRID
C-49, VIDYA
APARTMENT, PARAS MARG,
BAPU NAGAR, NEAR JANTA
STORE CIRCLE,
JAIPUR-302015
PH-09314918766, 0141-4005506
(6)


DEVELOPER NAME:-
Email:- info.spacegrid@gmail.com
PEARL SPYTECH
REALTORS LLP


PROJECT NAME:-
PEARL PRISTINE

ADDRESS:-
PLOT NO. B-173
RAJENDRA MARG,
BAPU NAGAR, JAIPUR

DRG. TITLE:-
TERRACE FLOOR
ELECTRIC POINT
MARKED PLAN


SCALE = 1:100

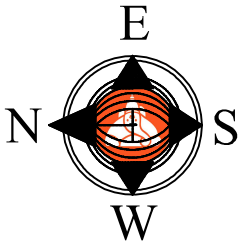

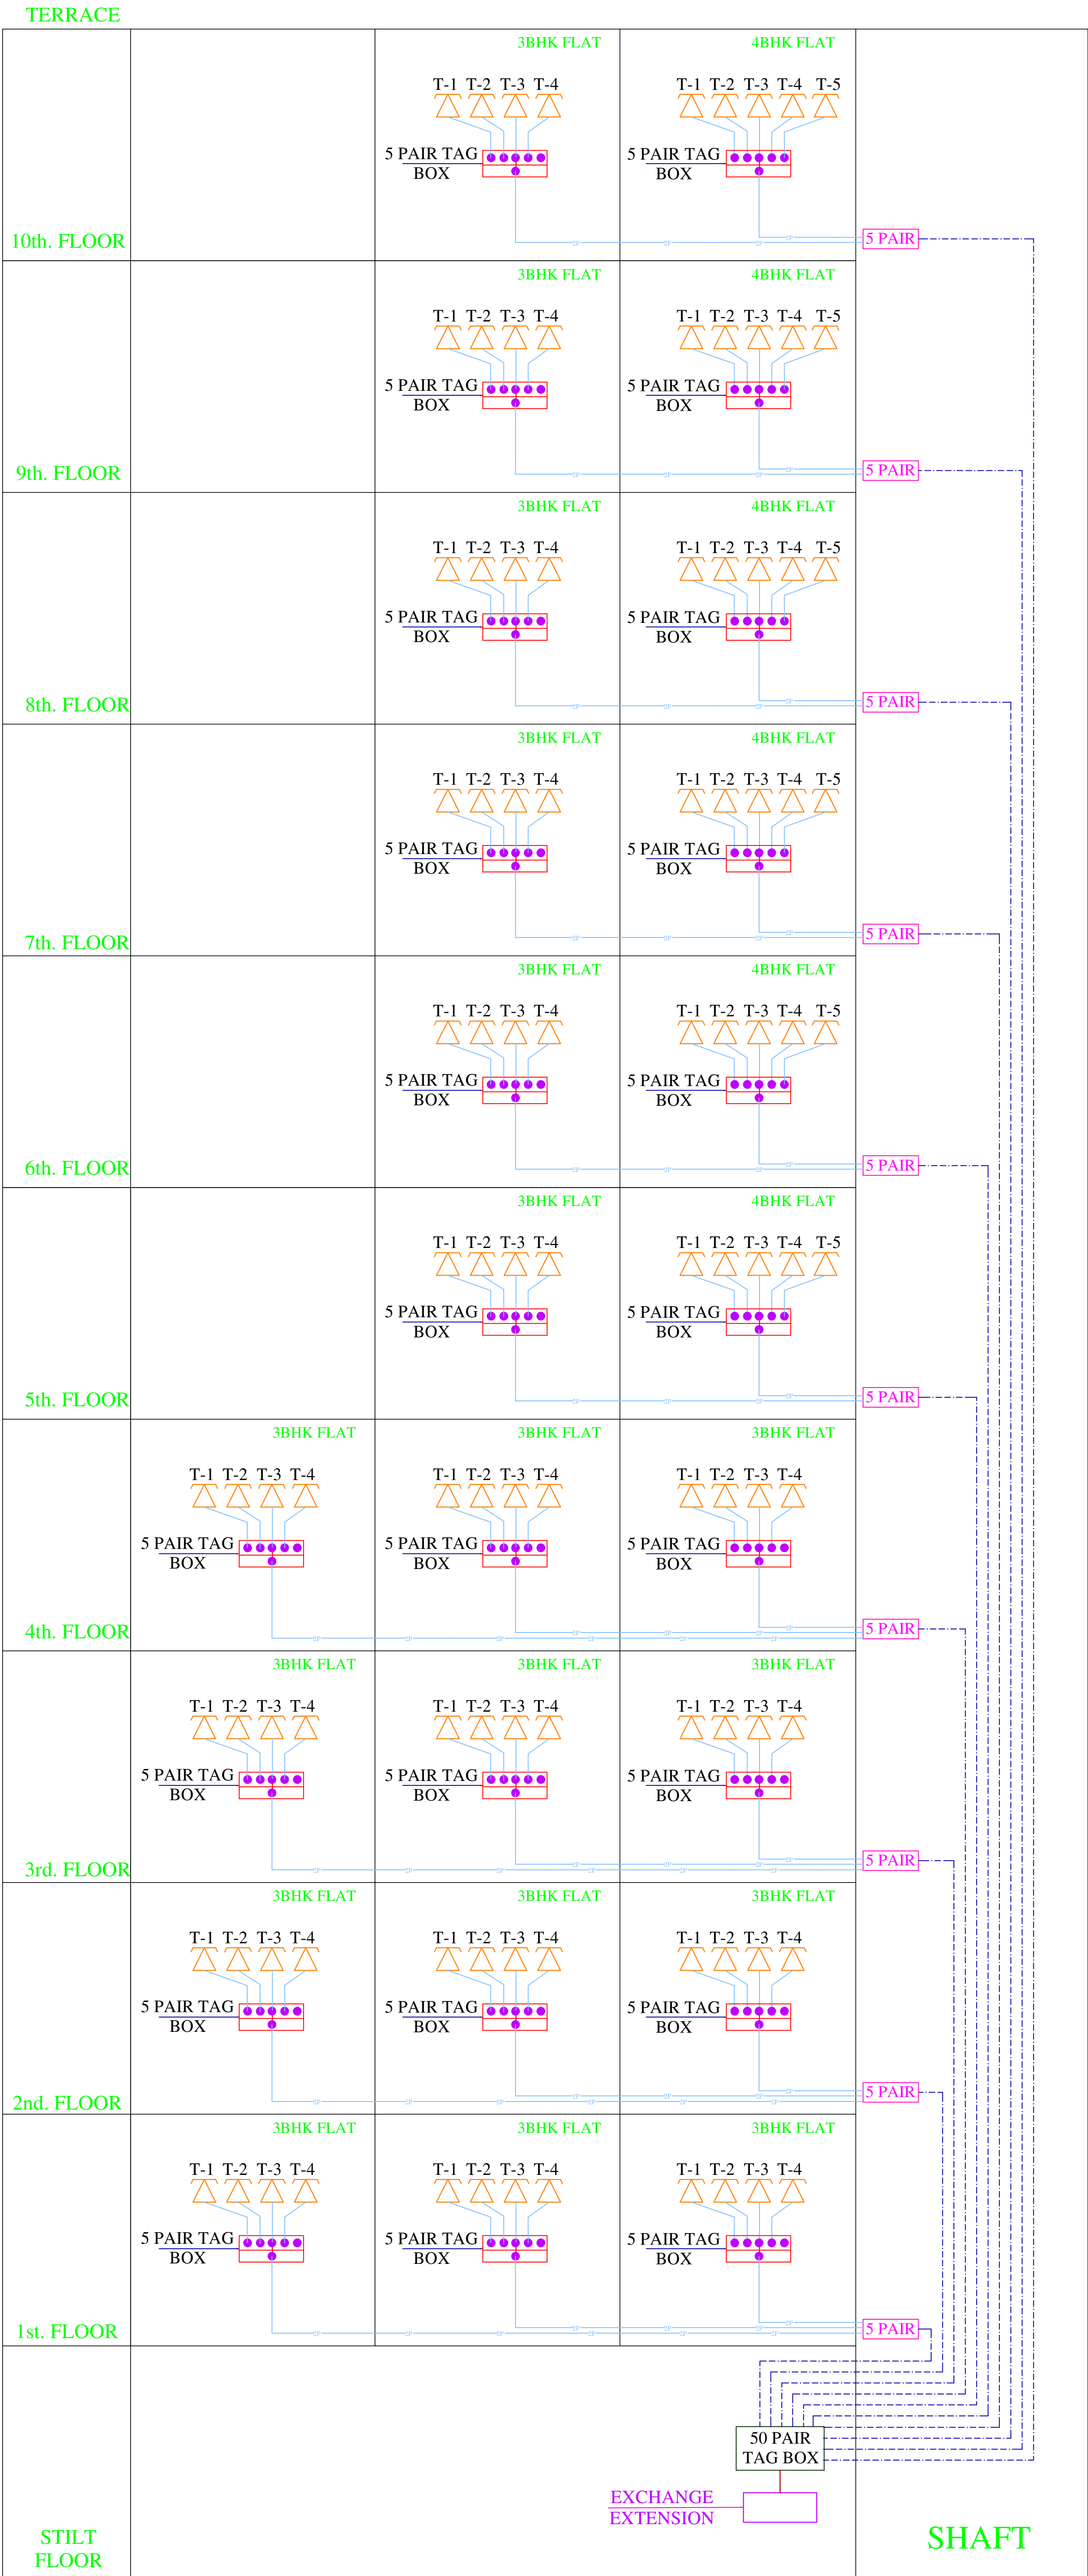


Vipul
VIPUL AGARWAL
M.E.P. CONSULTANT
B.E. ELECTRICAL

CODE	DESCRIPTION
	100 PAIR ARMoured CABLE
	50 PAIR ARMoured CABLE
	5 PAIR ARMoured CABLE
	2 PAIR UNARMoured CABLE
SERVICE CONSULTANT	
ASHI ASSOCIATES F 9 / 440 , Keshav Marg Chitrakut Scheme,Jaipur PH:91-0-93146-10438 ,0141-2440946, Mail:vipul8599@yahoo.com	
DEVELOPER NAME:- PEARL SPYTECH REALTORS LLP	
PROJECT NAME:- PEARL PRISTINE	
ADDRESS:- PLOT NO. B-173 RAJENDRA MARG, BAPU NAGAR, JAIPUR	
DRG. TITLE:- TELEPHONE SINGLE LINE DIAGRAM	
SCALE = 1:100	

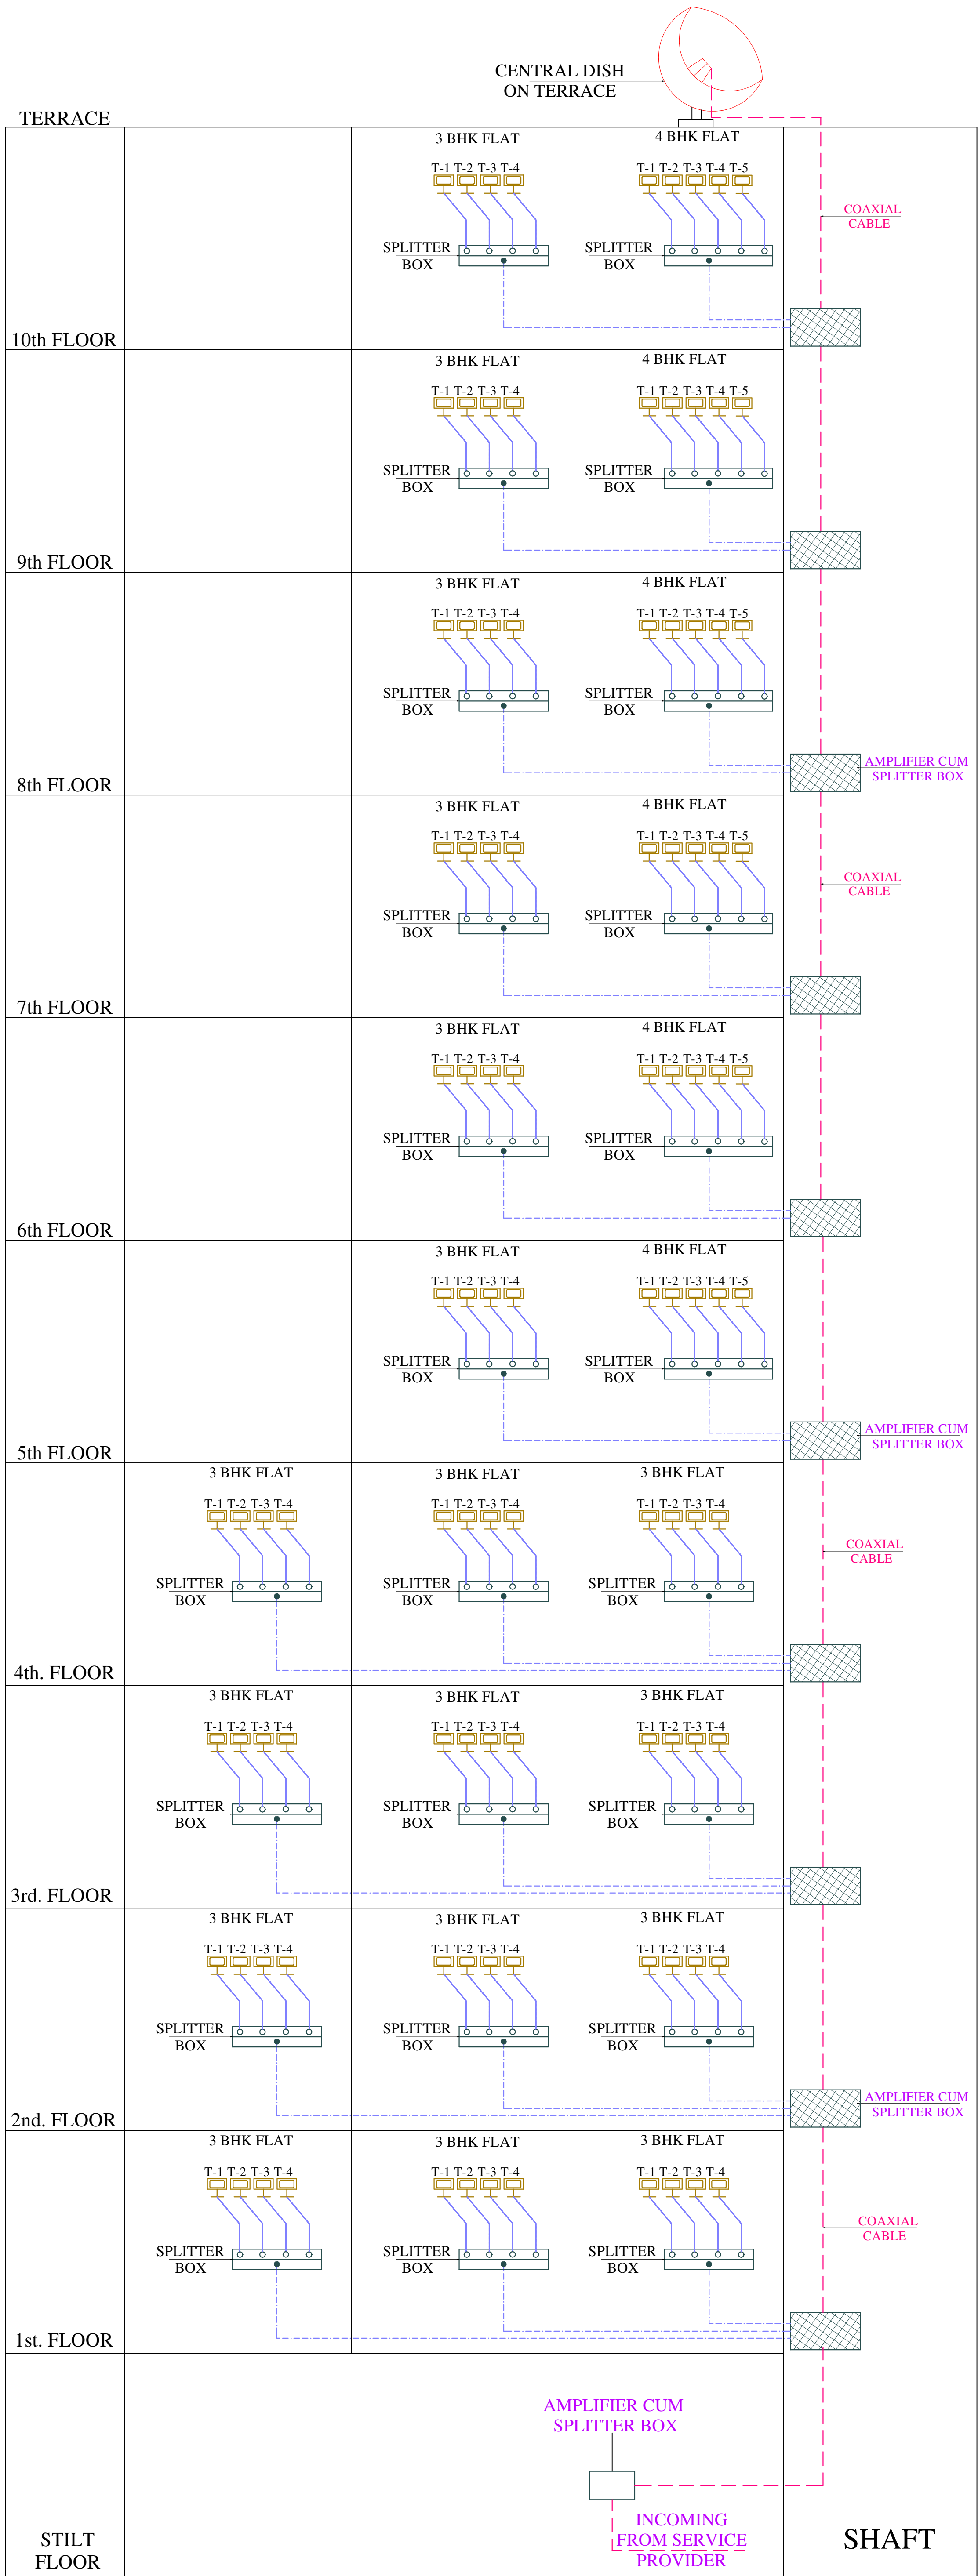

 Vipul
VIPUL AGARWAL
M.E.P. CONSULTANT
B.E. ELECTRICAL

SR.N	CODE	DESCRIPTION
01		COAXIAL CABLE
02		RG-6 COAXIAL CABLE
03		SPLITTER BOX
04		AMPLIFIER CUM SPLITTER BOX

SERVICE CONSULTANT

ASHI ASSOCIATES

F 9 / 440 , Keshav Marg Chitrakut Scheme,Jaipur
PH:91-0-93146-10438 ,0141-2440946, Mail:vipul8599@yahoo.com

DEVELOPER NAME:-

**PEARL SPYTECH
REALTORS LLP**

PROJECT NAME:-

PEARL PRISTINE

ADDRESS:-

**PLOT NO. B-173
RAJENDRA MARG,
BAPU NAGAR, JAIPUR**

DRG. TITLE:-

**TYPICAL
TV SINGLE LINE DIAGRAM**

SCALE = 1:100

