



PROJECT NAME :
TOWN SQUARE III
DEVELOPER NAME :
CM RESIDENCY

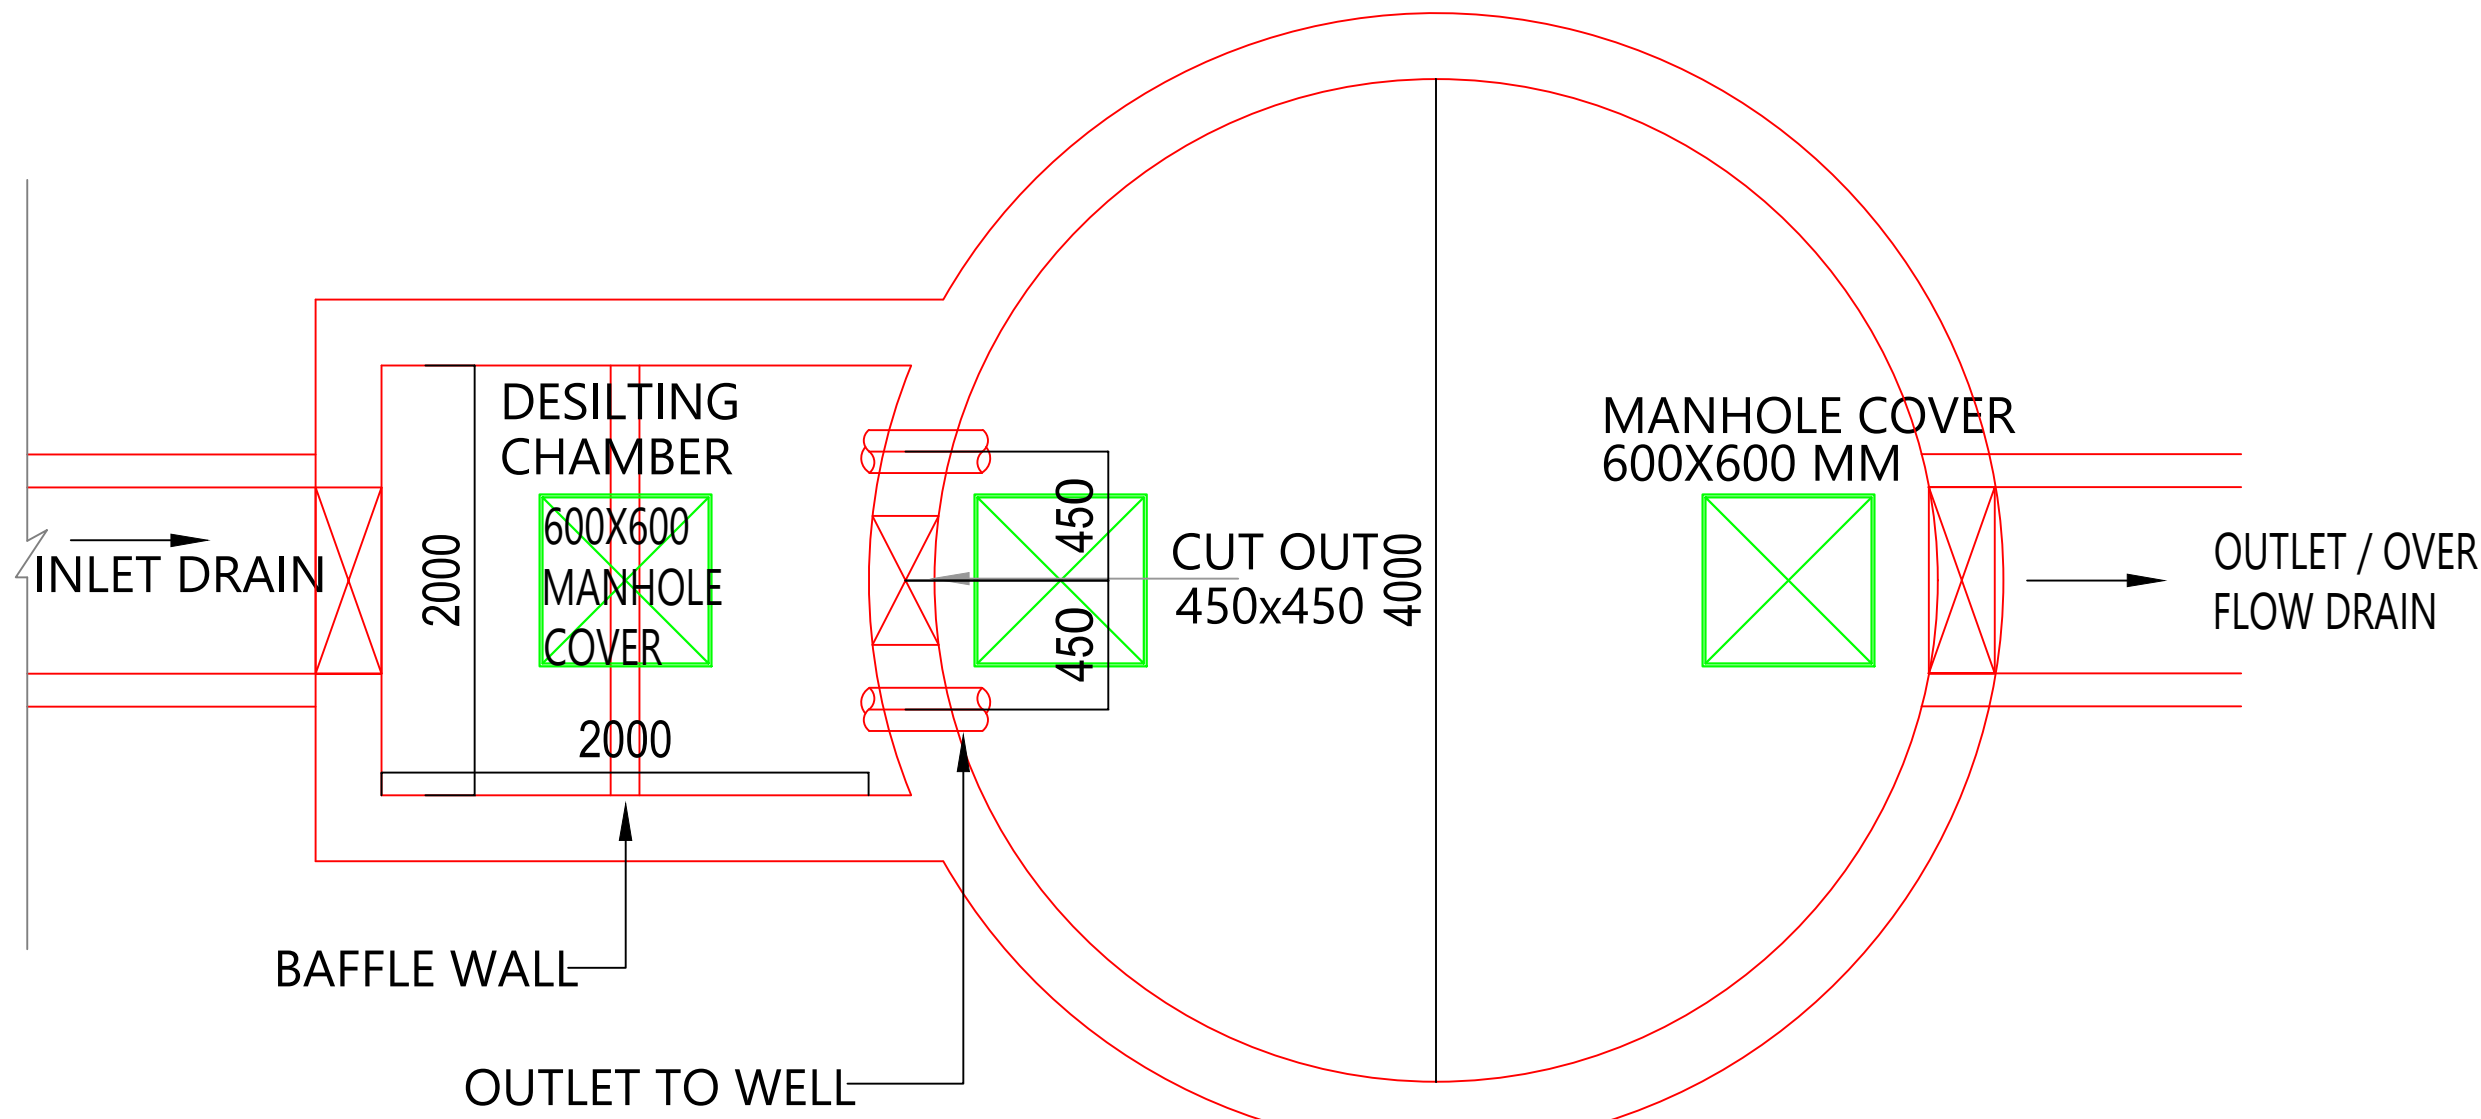

PLAN

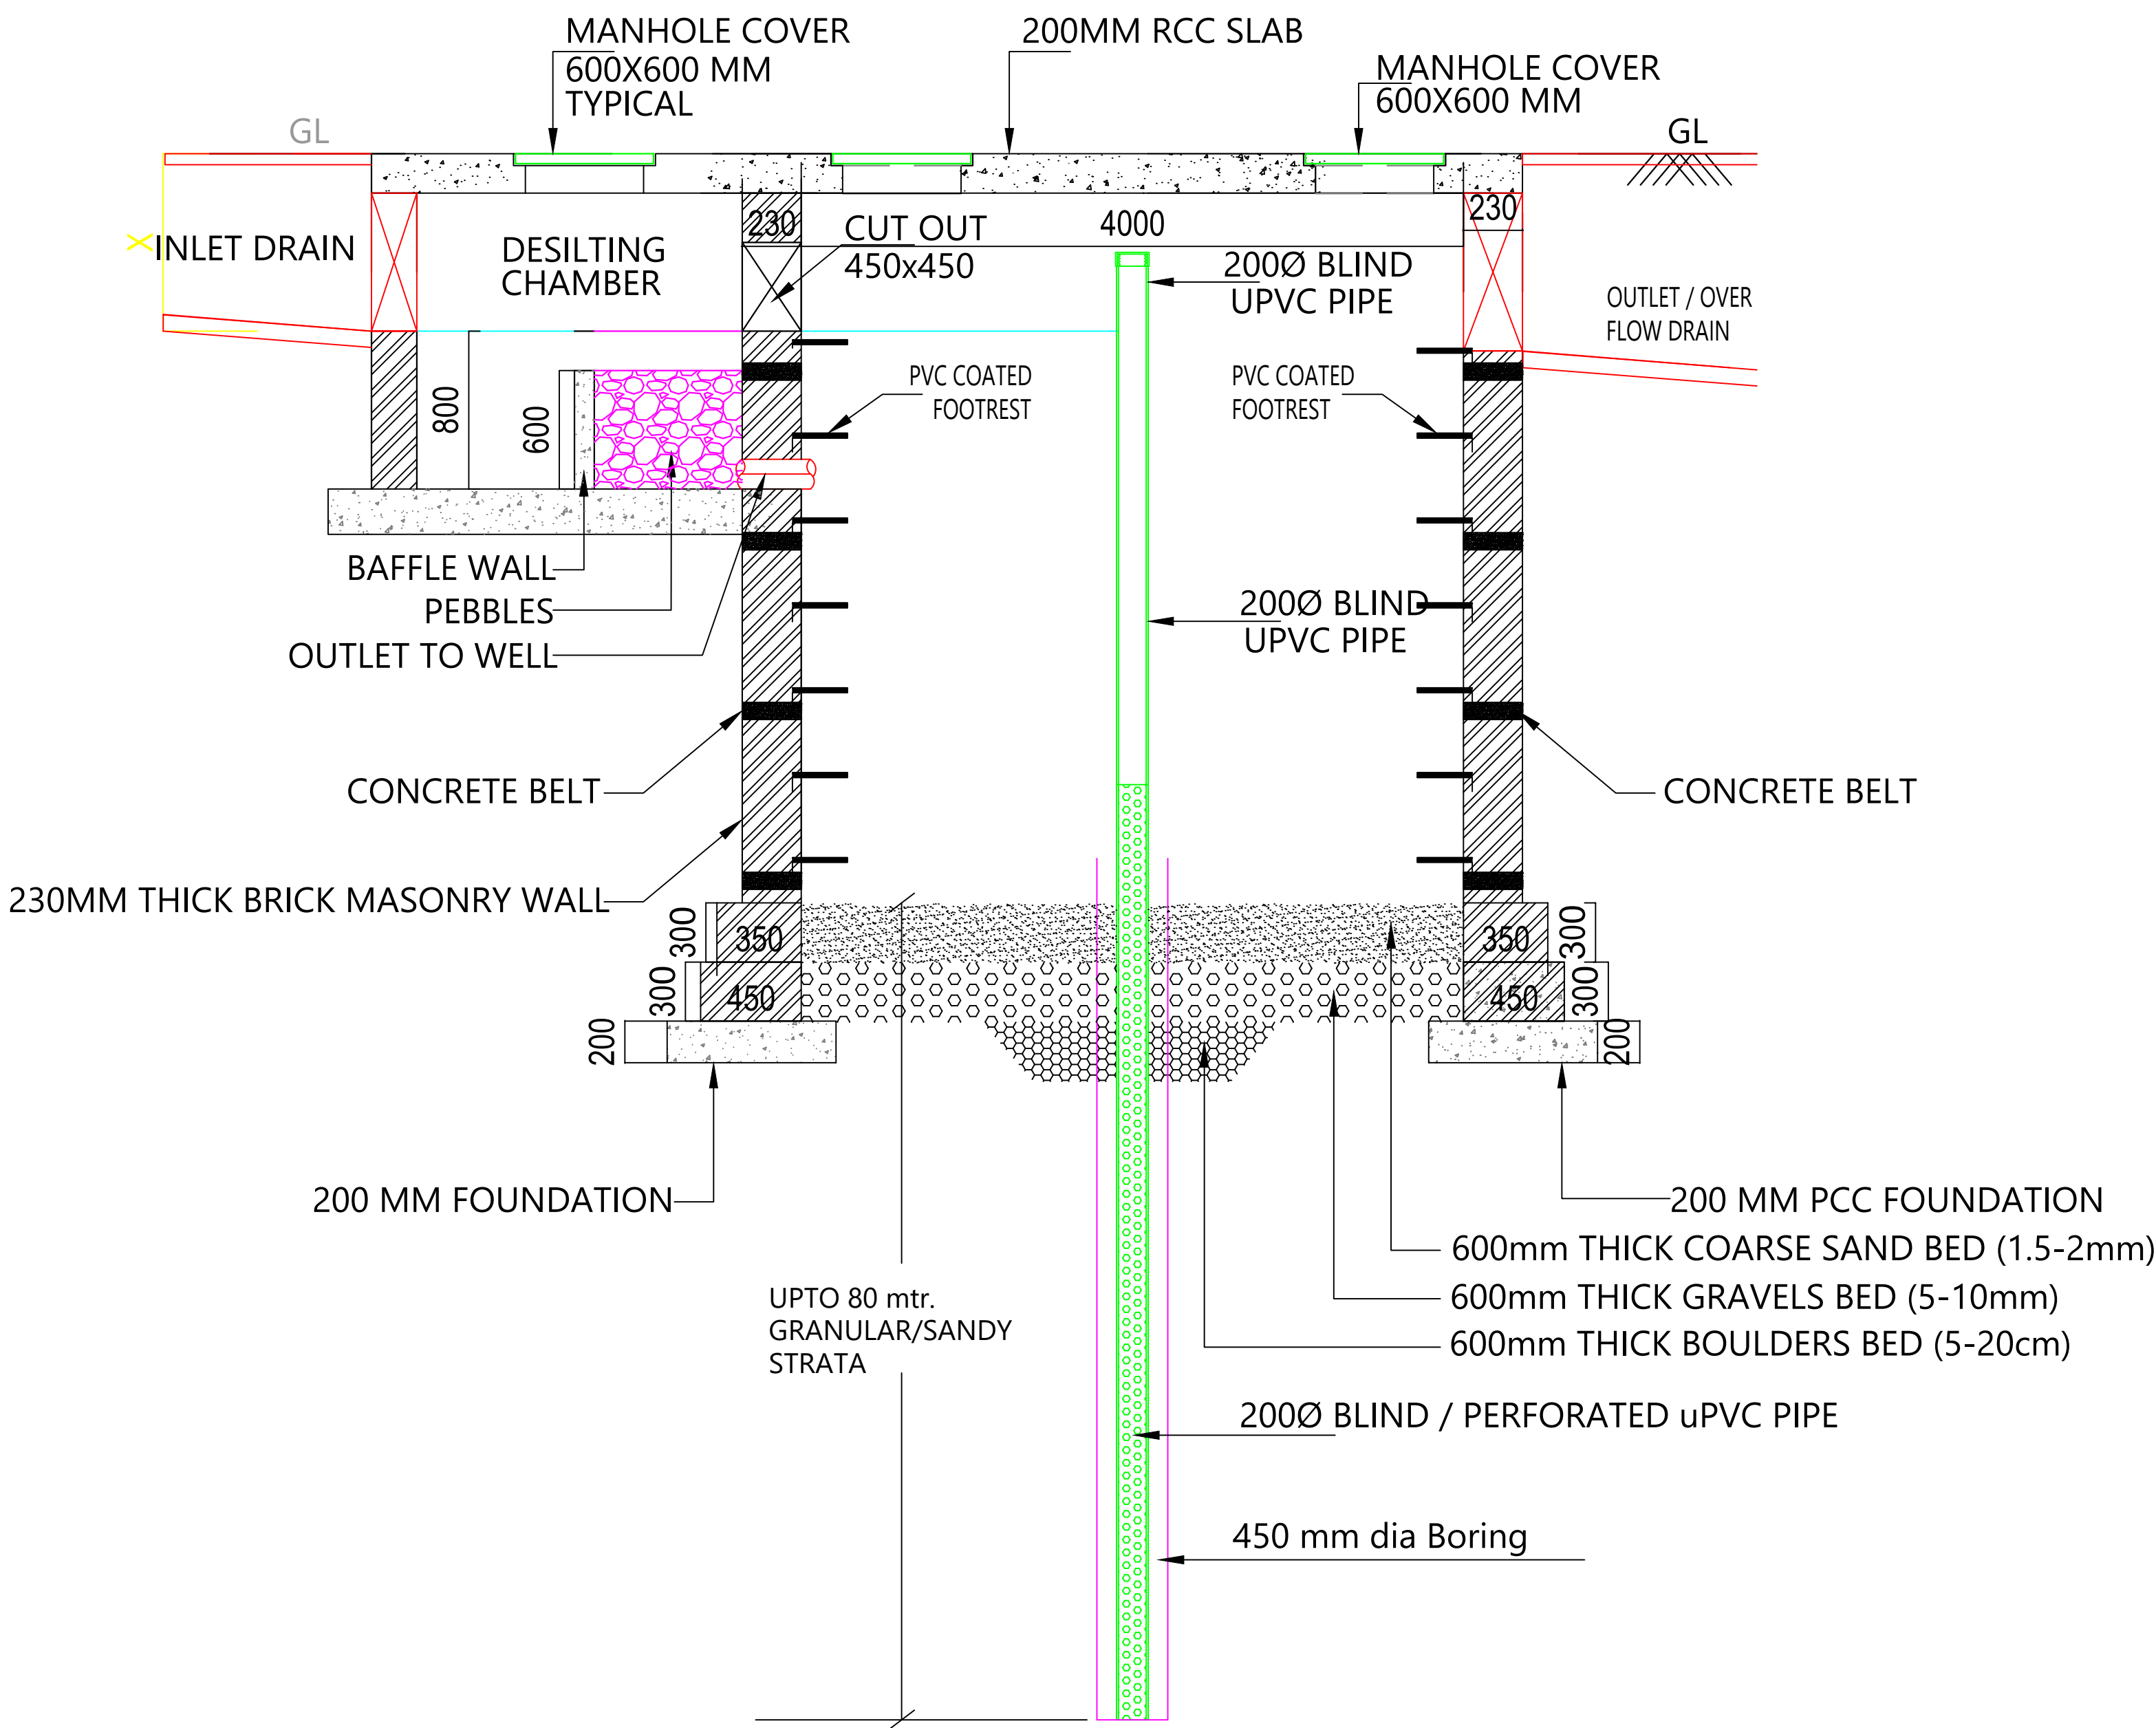

RAIN WATER HARVESTING/ RECHARGING

NOTES:

- ALL DIMENSIONS ARE IN MM. AND INDICATIVE ONLY. SUITABLE AMENDMENTS MAY BE DONE AS PER ACTUAL SITE CONDITIONS.
- THE DIMENSION OF STRUCTURAL ELEMENTS (FOUNDATION, WALL, SLAB ETC.) ARE ONLY INDICATIVE. THESE SHALL BE AS PER STRUCTURAL DRAWINGS.
- THE DIMENSION 'X' SHALL BE CALCULATED ON THE BASIS OF INVERT OF UPSTREAM DRAIN

For- CM RESIDENCY
Proprietor

Er. SANJEEV SHARMA
B.E (Electrical)

LEGEND:-

①	SOIL PIPE	
②	WASTE PIPE	
③	VENT PIPE	
④	COLD WATER SUPPLY (CWS)	
⑤	HOT WATER SUPPLY (HWS)	
	RAIN WATER PIPE	
SW	SEWER LINE- EXTERNAL	
RW	STORM WATER DRAINAGE PIPE	
	SEWERAGE MANHOLE (2' x 2')	M.H.
	STORM WATER MANHOLE (2' x 2')	M.H.
GT	GULLY TRAP	
BV	BALL VALVE	
FT	FLOOR TRAP	
FD	FLOOR FLOOR DRAIN	
	RAIN WATER COLLECTION CHAMBER 450X450MM	
	KHURRA	

PROJECT:
KHASRA NO - 765 / 221 AT REVENUE VILLAGE - NARSINGHPURA URF RIKSHA, TEH. - SANGANER. JAIPUR. (RAJ.)

NAME OF DRAWING:
RAIN WATER HARVESTING PIT SECTION DETAILS PLAN

DRAWING
WORKING DRAWING

NORTH:


PROJECT NO. :
DATE :
20-08-2024

SCALE :
NTS

REV NO. :
R-0

DRAWING NO. :
PROJECT CATEGORY BLOCK FLOOR TYPE NUMBER

A-01

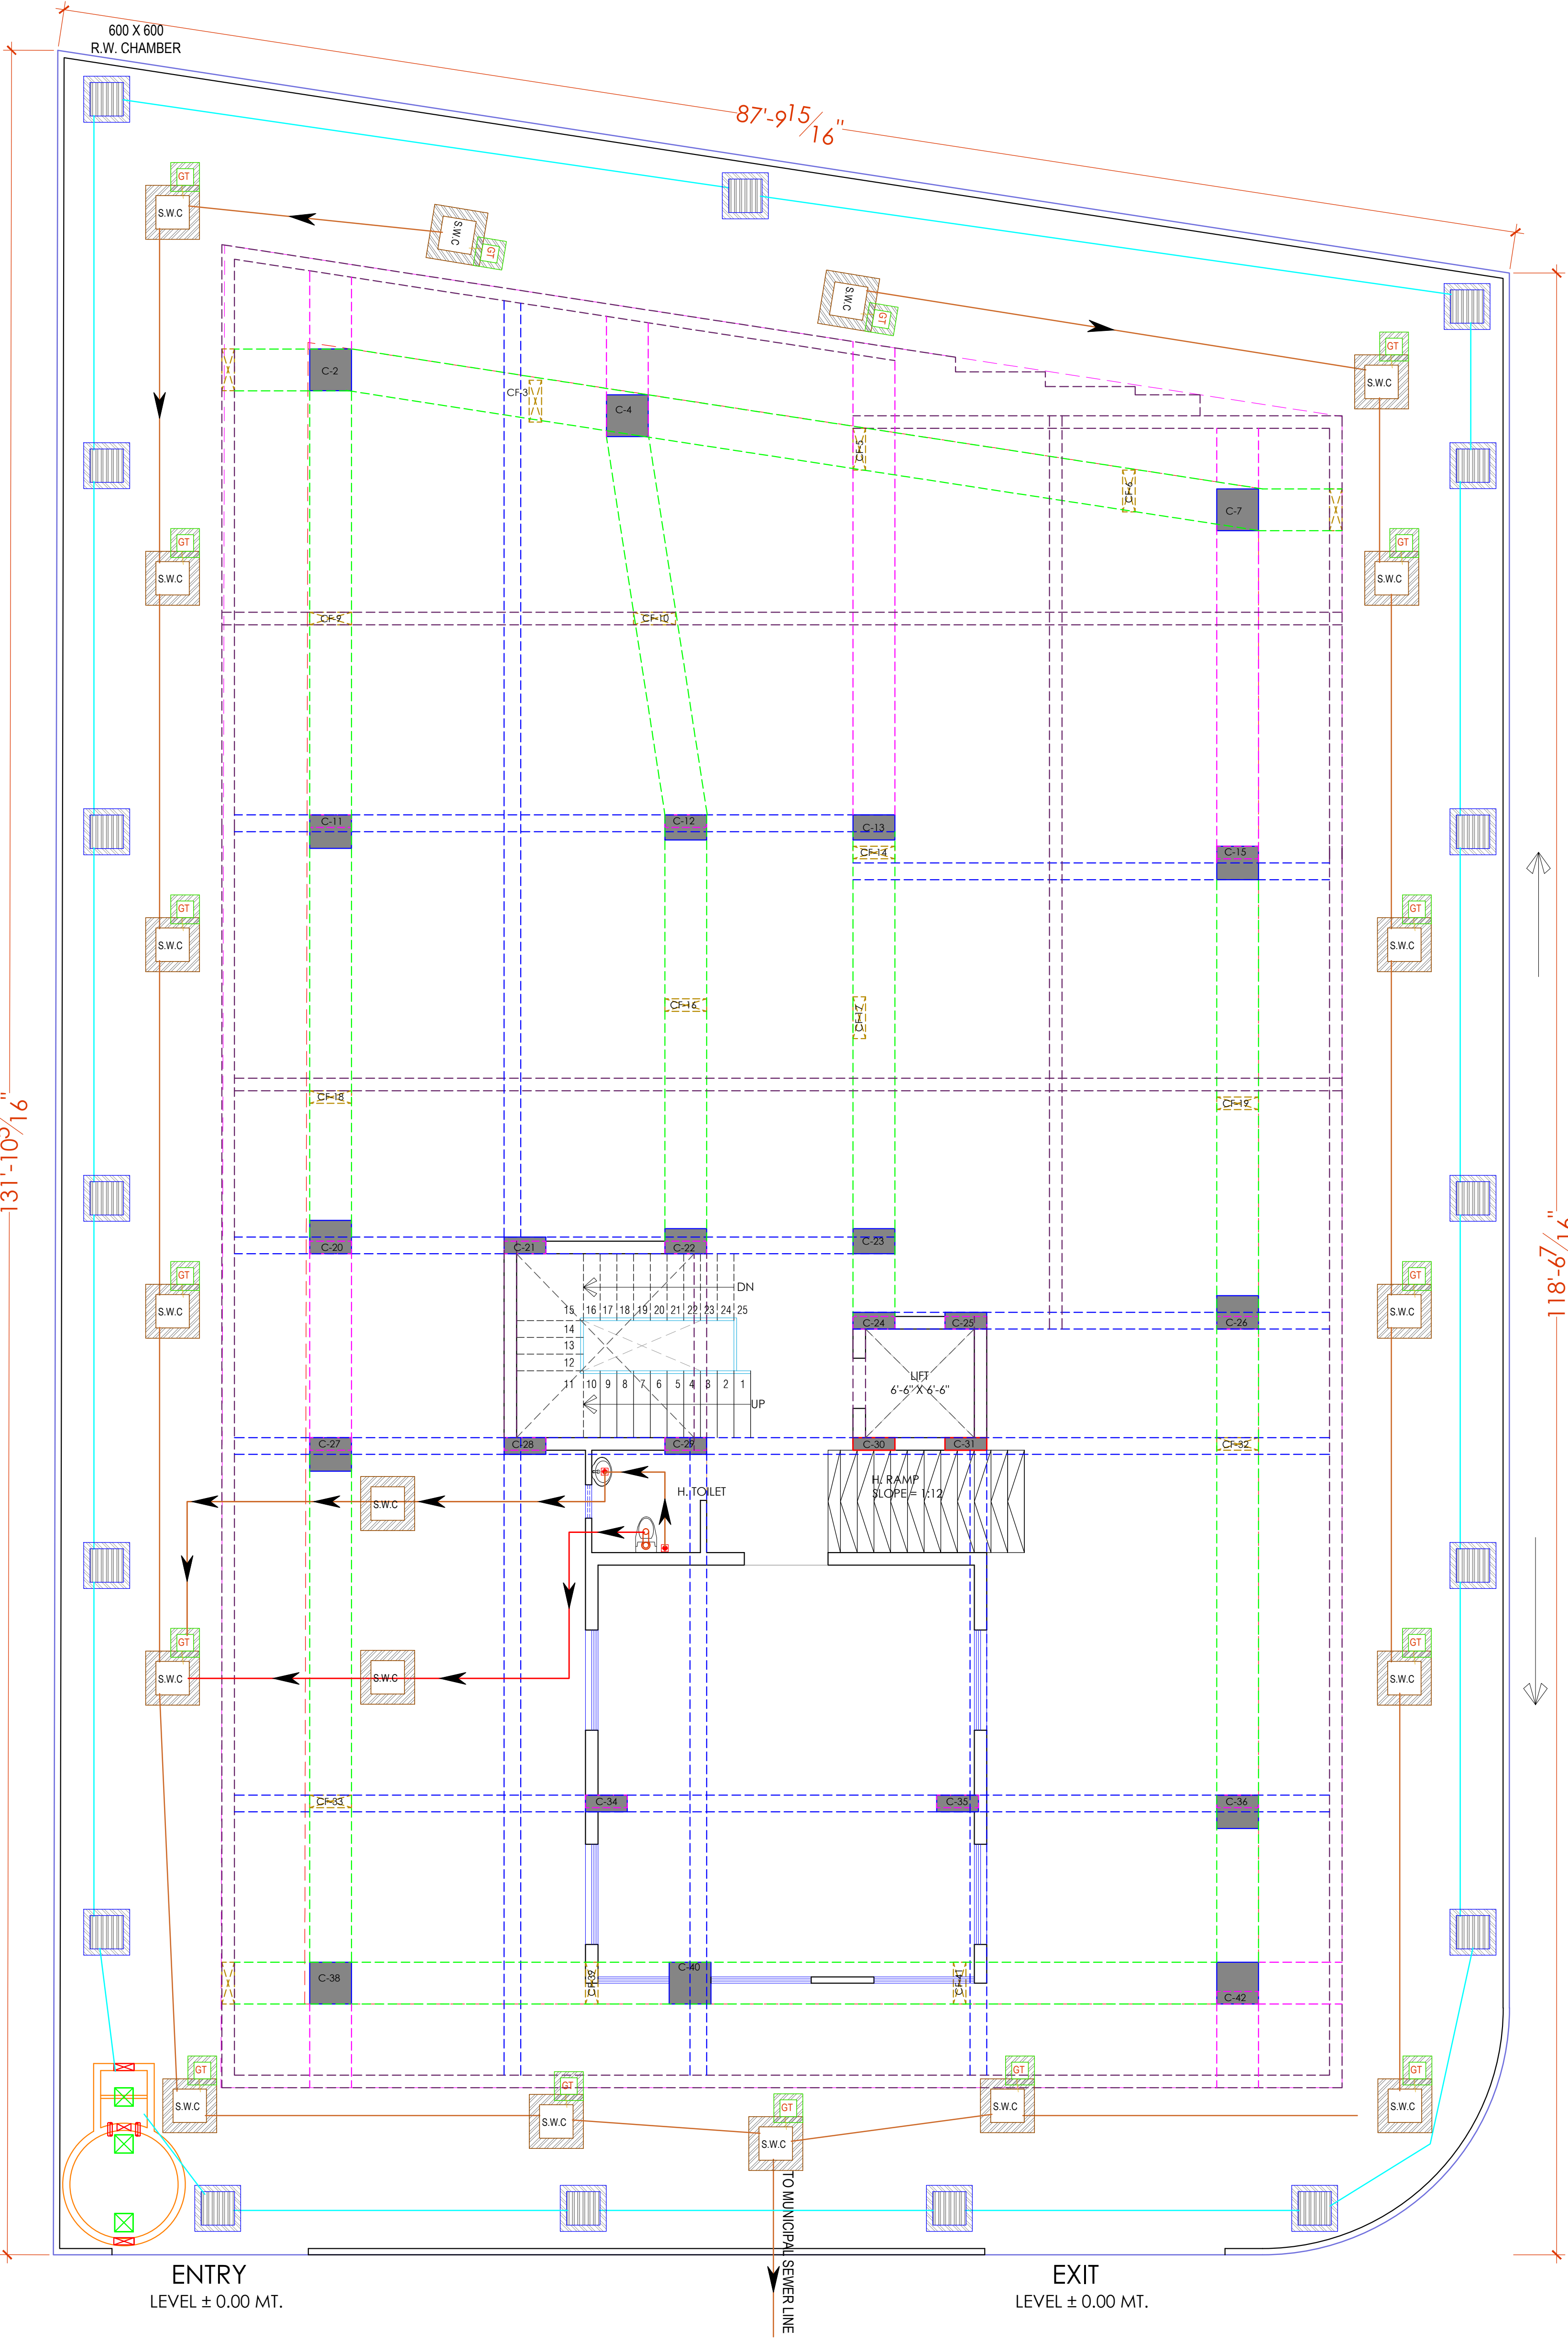

PROJECT NAME :
TOWN SQUARE III
DEVELOPER NAME :
CM RESIDENCY

LEGEND:-

①	SOIL PIPE	
②	WASTE PIPE	
③	VENT PIPE	
④	COLD WATER SUPPLY (CWS)	
⑤	HOT WATER SUPPLY (HWS)	
	RAIN WATER PIPE	
SW	SEWER LINE- EXTERNAL	
RW	STORM WATER DRAINAGE PIPE	
	SEWERAGE MANHOLE (2' x 2')	M.H.
	STORM WATER MANHOLE (2' x 2')	M.H.
GT	GULLY TRAP	
BV	BALL VALVE	
FT	FLOOR TRAP	
FD	FLOOR FLOOR DRAIN	
	RAIN WATER COLLECTION CHAMBER 450X450MM	
	KHURRA	

For- CM RESIDENCY

Proprietor

Er. SANJEEV SHARMA
B.E (Electrical)


PROJECT:
KHASRA NO - 765 / 221 AT REVENUE VILLAGE - NARSINGHPURA URF RIKSHA, TEH. - SANGANER. JAIPUR. (RAJ.)

NAME OF DRAWING:
STILT FLOOR WATER SUPPLY DRAWING, STILT FLOOR EXTERNAL RAIN WATER HARVESTING AND PIPE ROUTE PLAN, STILT FLOOR EXTERNAL SEWERAGE WATER PIPE ROUT PLAN

DRAWING WORKING DRAWING	NORTH:
PROJECT NO. :	DATE : 20-08-2024
SCALE : NTS	REV NO. : R-0

DRAWING NO. :
PROJECT / CATEGORY / BLOCK / FLOOR / TYPE / NUMBER
A-01

STILT FLOOR WATER SUPPLY DRAWING,STILT FLOOR EXTERNAL RAIN WATER HARVESTING AND PIPE ROUTE PLAN,STILT FLOOR EXTERNAL SEWERAGE WATER PIPE ROUT PLAN

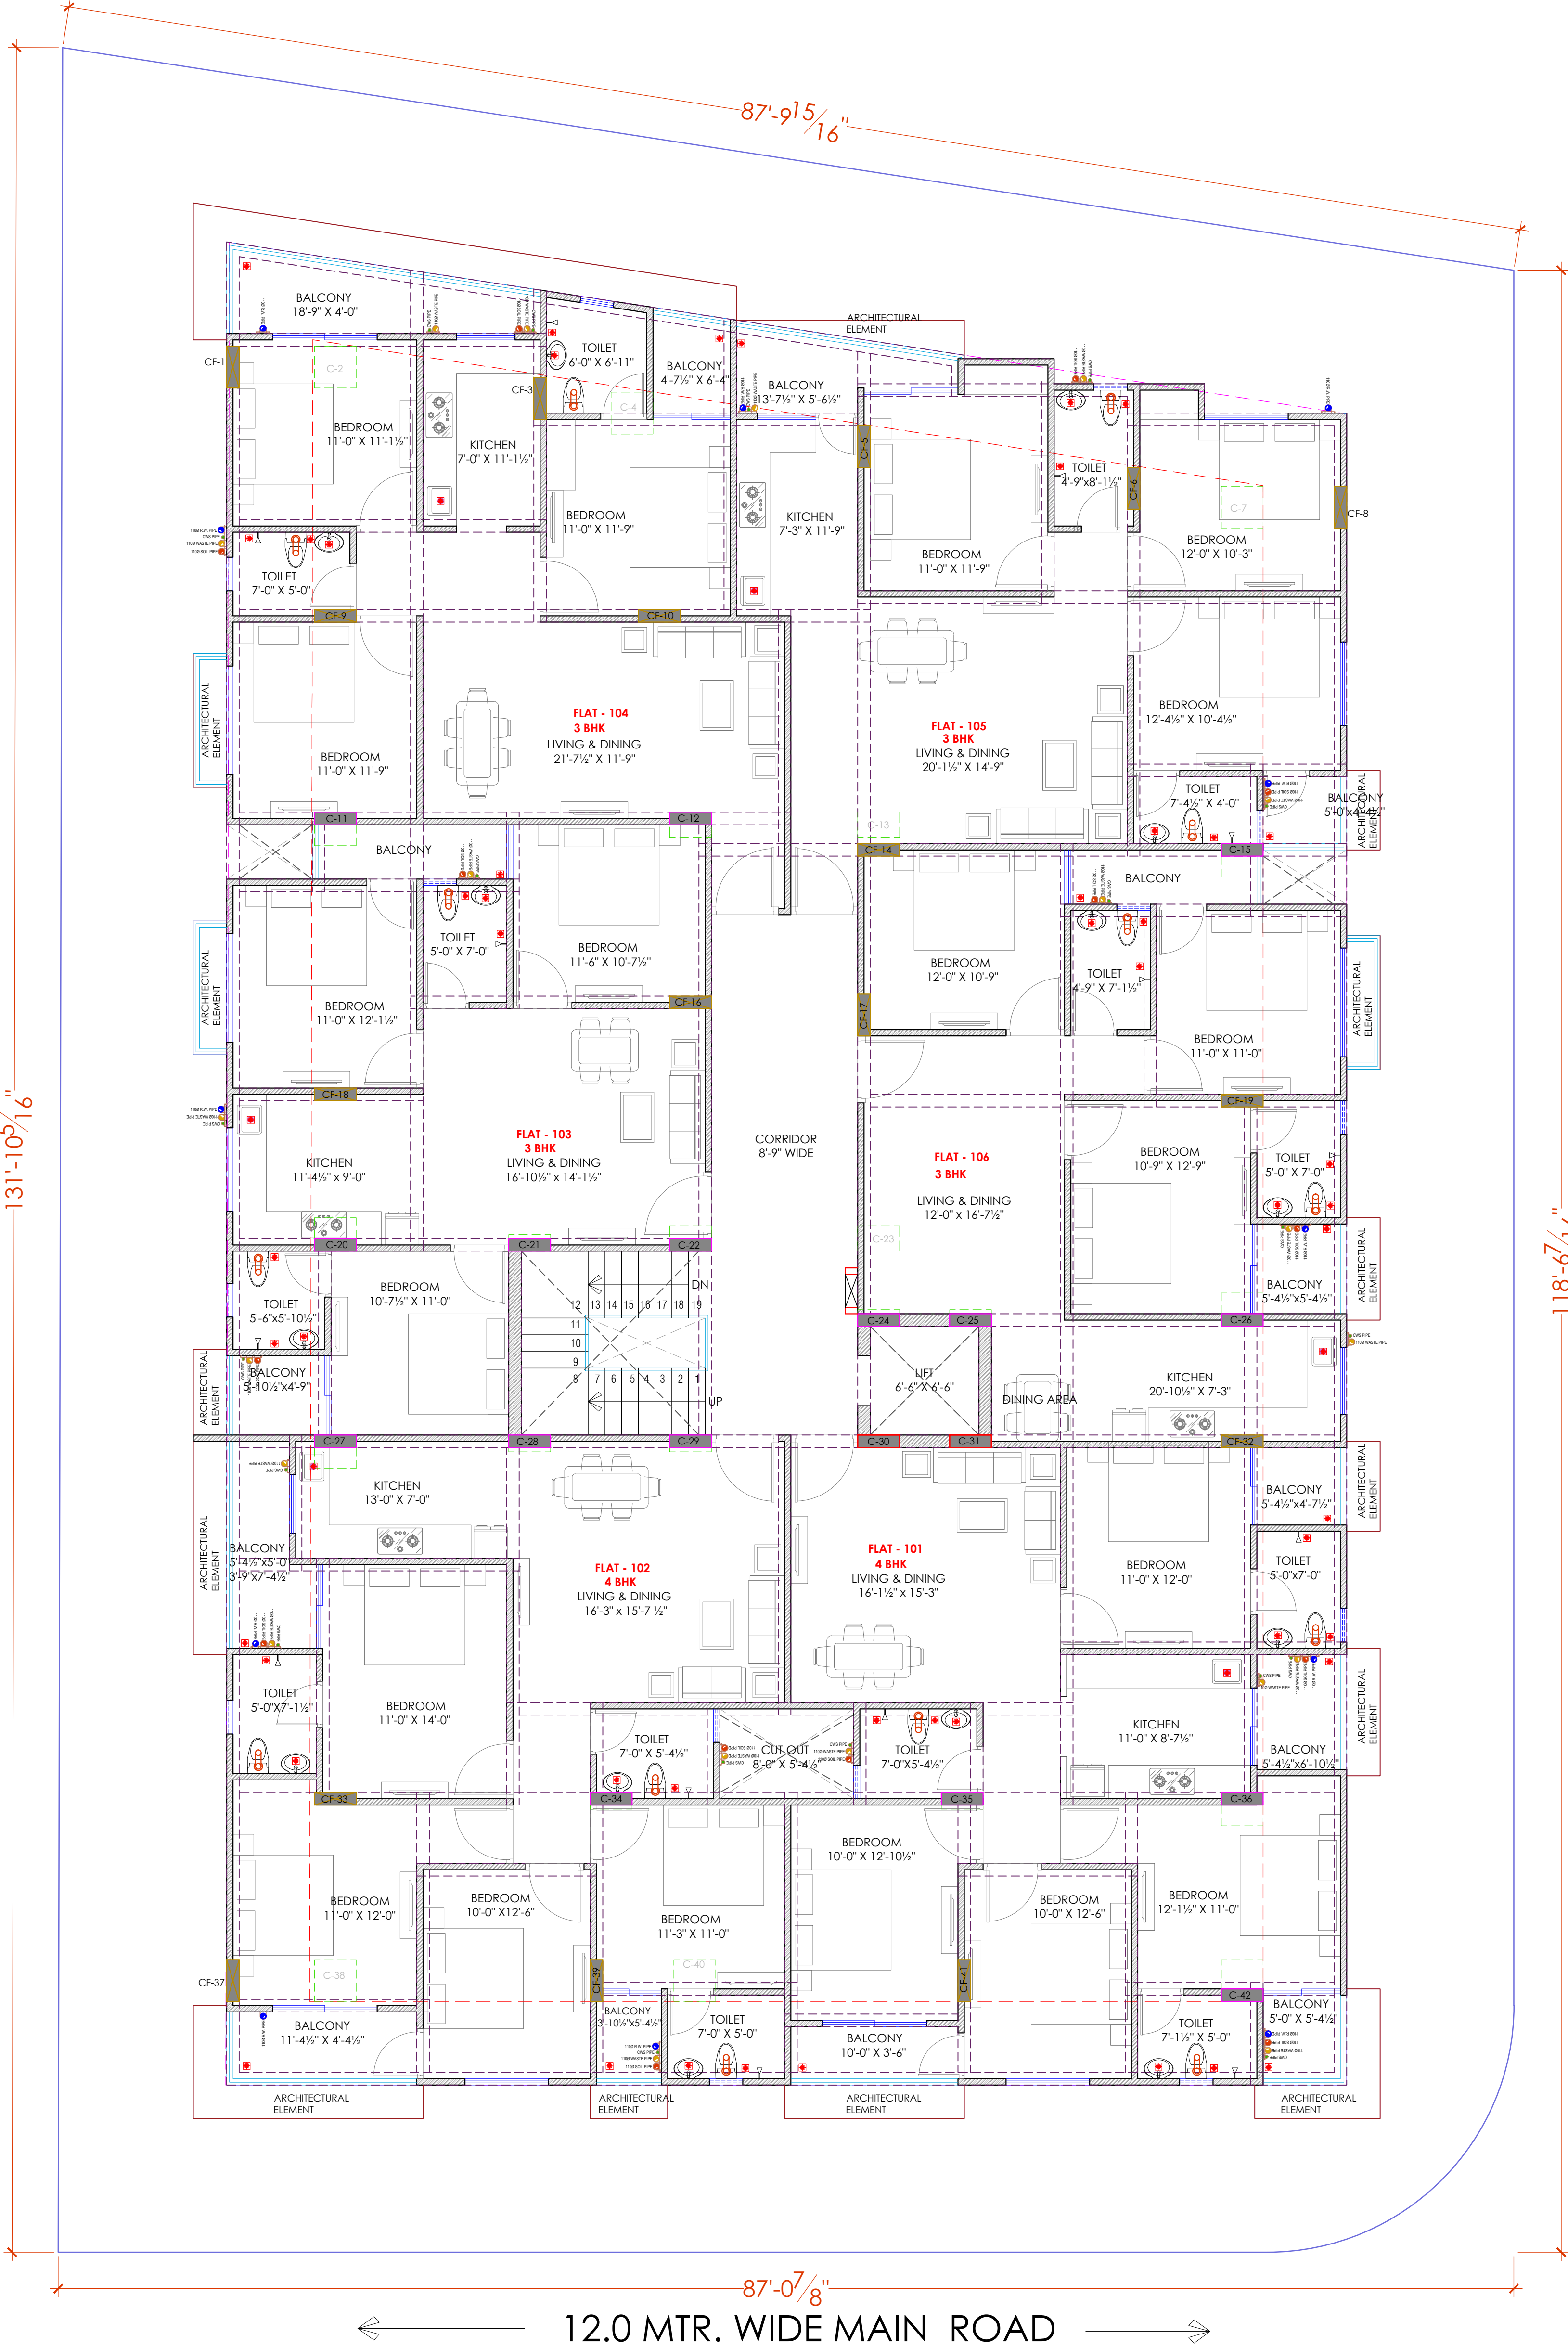

TYPICAL FLOOR (Ground to 4th.) INTERNAL DRAINAGE PLAN, TYPICAL FLOOR INTERNAL PLUMBING PLAN, UG WATER TANK TO OHT FILLING ROUTE PLAN

PROJECT NAME :
TOWN SQUARE III
DEVELOPER NAME :
CM RESIDENCY

LEGEND:-

①	SOIL PIPE	
②	WASTE PIPE	
③	VENT PIPE	
④	COLD WATER SUPPLY (CWS)	
⑤	HOT WATER SUPPLY (HWS)	
	RAIN WATER PIPE	
SW	SEWER LINE- EXTERNAL	
RW	STORM WATER DRAINAGE PIPE	
	SEWERAGE MANHOLE (2' x 2')	M.H.
	STORM WATER MANHOLE (2' x 2')	M.H.
GT	GULLY TRAP	
BV	BALL VALVE	
FT	FLOOR TRAP	
FD	FLOOR FLOOR DRAIN	
	RAIN WATER COLLECTION CHAMBER 450X450MM	
	KHURRA	

For- CM RESIDENCY
Proprietor

Er. SANJEEV SHARMA
B.E (Electrical)


PROJECT:
KHASRA NO - 765 / 221 AT REVENUE VILLAGE - NARSINGHPURA URF RIKSHA, TEH. - SANGANER. JAIPUR. (RAJ.)

NAME OF DRAWING:
TYPICAL FLOOR (Ground to 4th.) INTERNAL DRAINAGE PLAN, TYPICAL FLOOR INTERNAL PLUMBINGPLAN, UG WATER TANK TO OHT FILLING ROUTE PLAN

DRAWING WORKING DRAWING	NORTH:
PROJECT NO. :	DATE : 18-10-2024
SCALE : NTS	REV NO. : R-0

DRAWING NO. :	
PROJECT	CATEGORY
BLOCK	FLOOR
TYPE	NUMBER

A-01

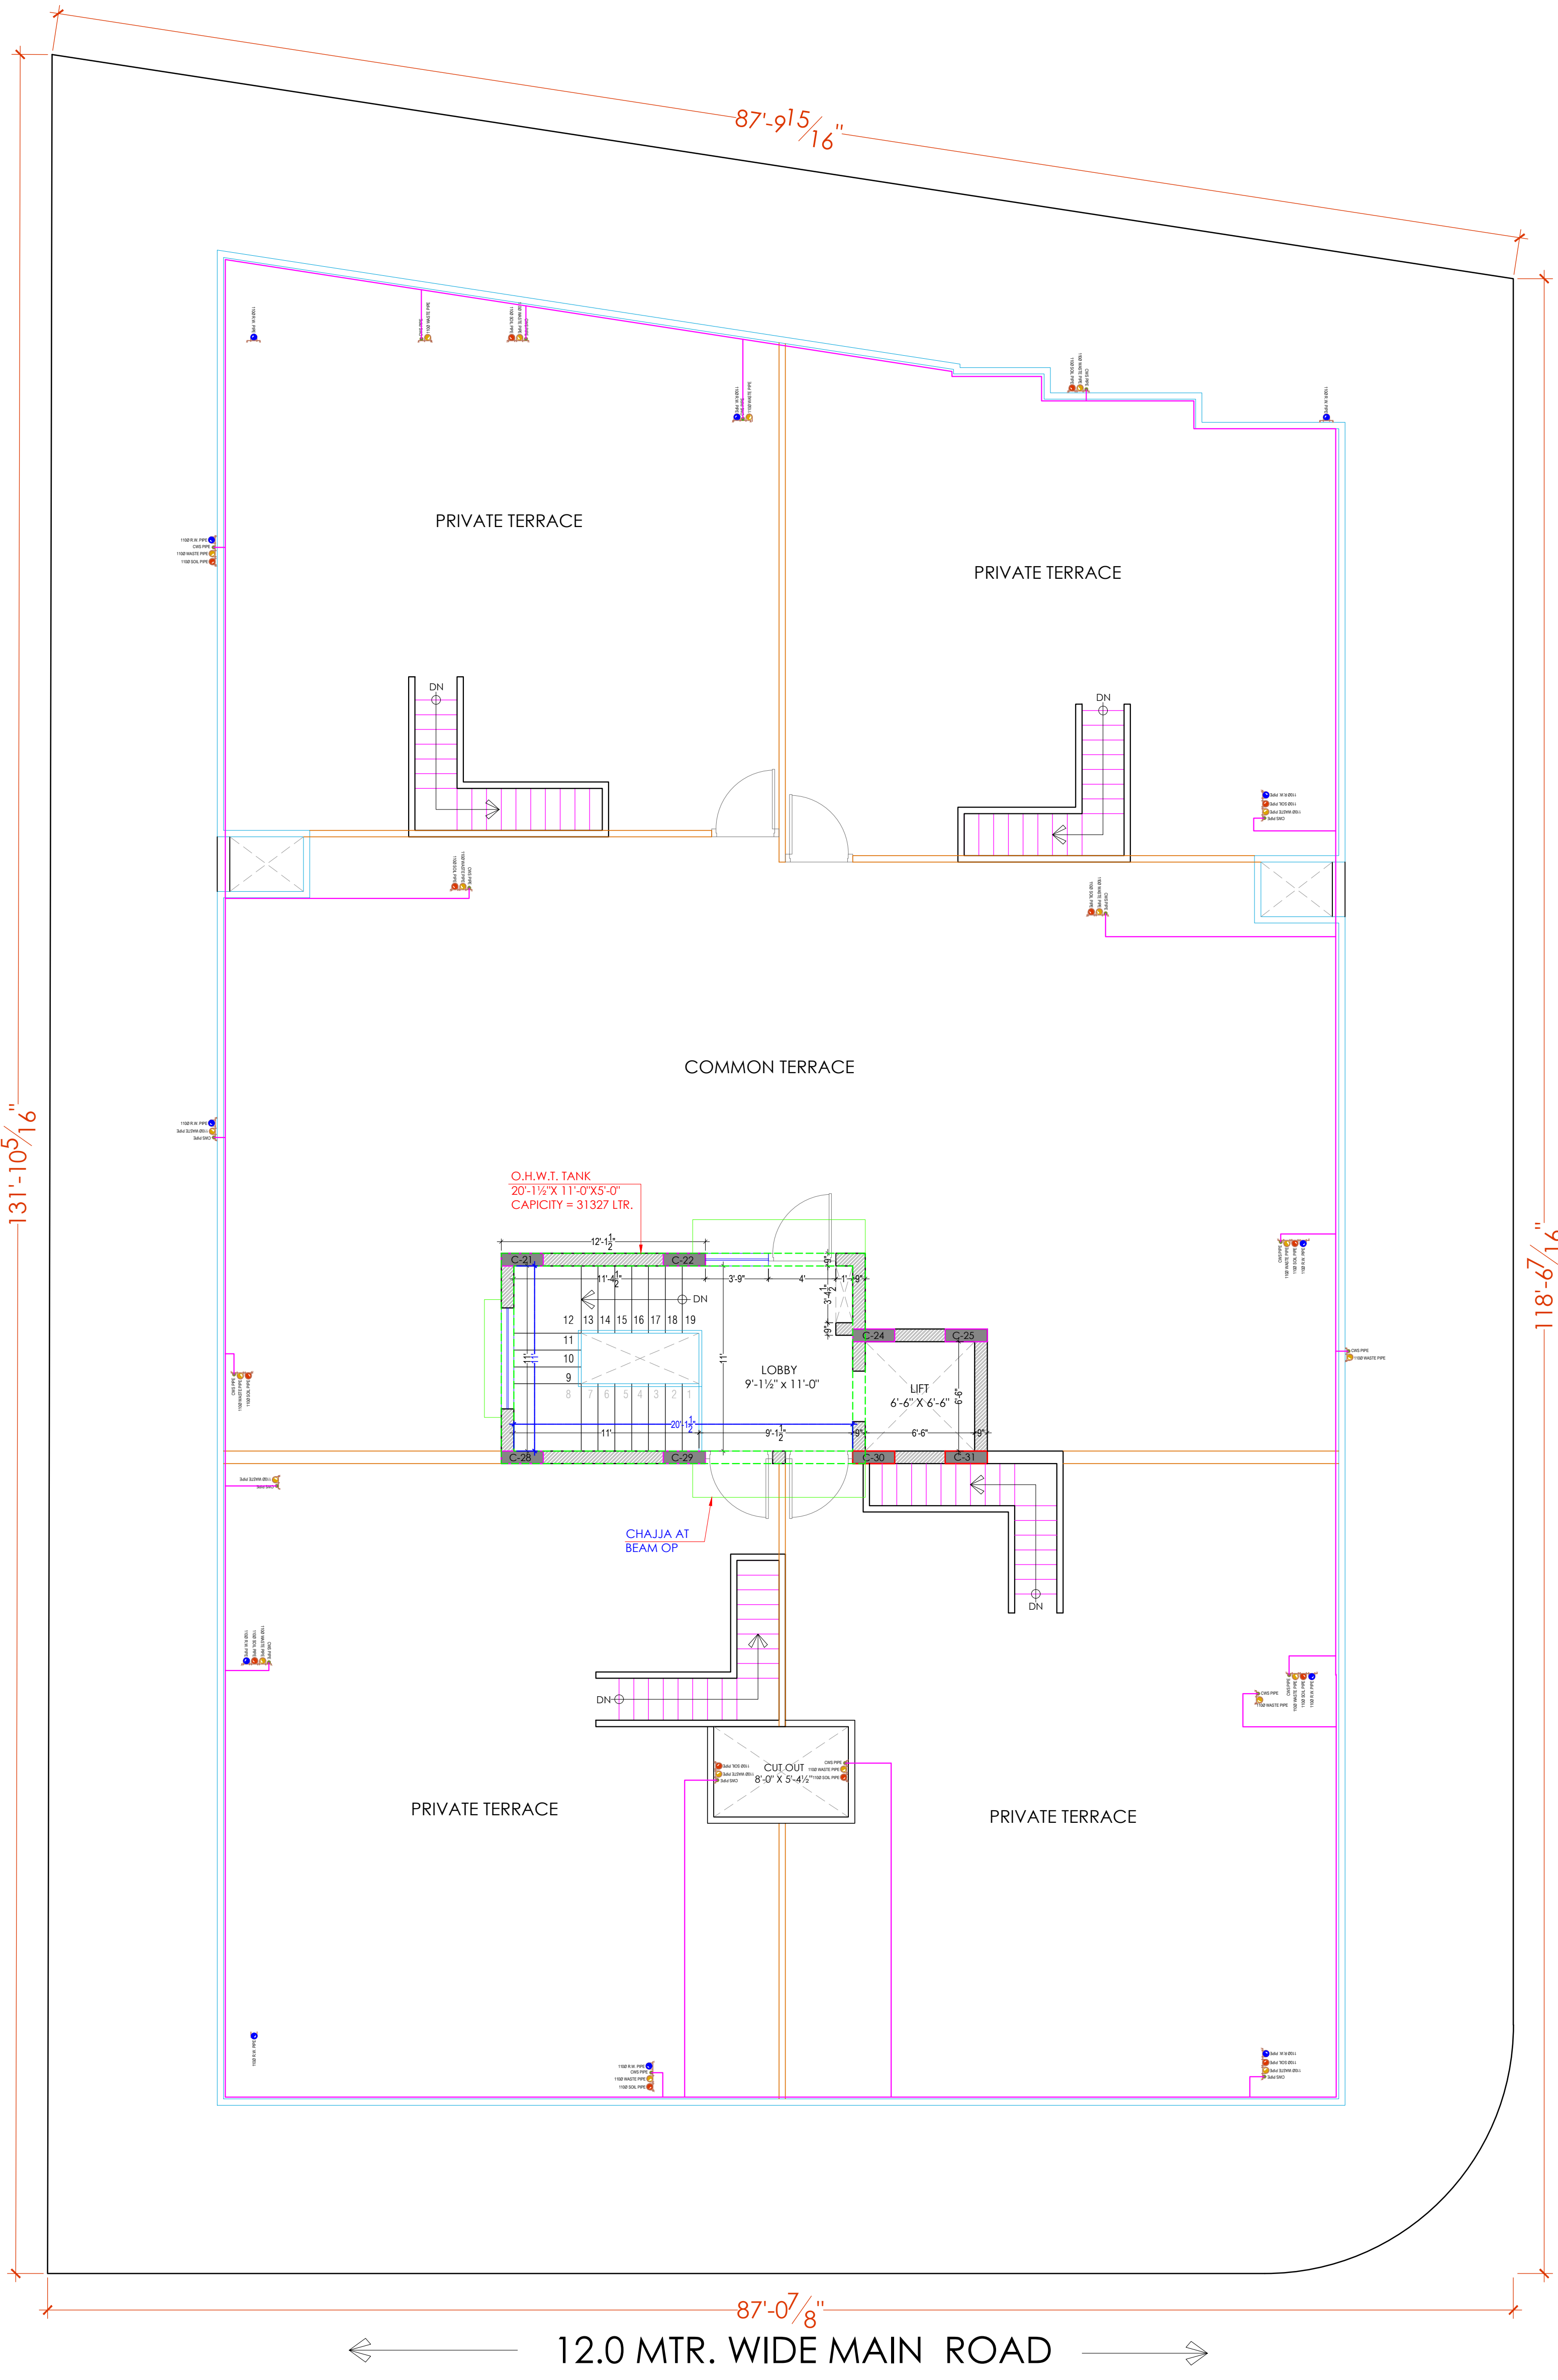

PROJECT NAME :
TOWN SQUARE III
DEVELOPER NAME :
CM RESIDENCY

LEGEND:-

①	SOIL PIPE	
②	WASTE PIPE	
③	VENT PIPE	
④	COLD WATER SUPPLY (CWS)	
⑤	HOT WATER SUPPLY (HWS)	
	RAIN WATER PIPE	
SW	SEWER LINE- EXTERNAL	
RW	STORM WATER DRAINAGE PIPE	
	SEWERAGE MANHOLE (2' x 2')	M.H.
	STORM WATER MANHOLE (2' x 2')	M.H.
GT	GULLY TRAP	
BV	BALL VALVE	
FT	FLOOR TRAP	
FD	FLOOR FLOOR DRAIN	
	RAIN WATER COLLECTION CHAMBER 450X450MM	
	KHURRA	

For- CM RESIDENCY
Proprietor

Er. SANJEEV SHARMA
B.E (Electrical)

PROJECT:
KHASRA NO - 765 / 221 AT REVENUE VILLAGE - NARSINGHPURA URF RIKSHA, TEH. - SANGANER. JAIPUR. (RAJ.)

NAME OF DRAWING:
TERRACE UG WATER TANK TO OHT FILLING ROUTE PLAN

DRAWING WORKING DRAWING	NORTH:
PROJECT NO. :	DATE : 08, Mar. - 2025
SCALE : NTS	REV NO. : R-0

DRAWING NO. :
PROJECT CATEGORY BLOCK FLOOR TYPE NUMBER
A-201

TERRACE UG WATER TANK TO OHT FILLING ROUTE PLAN

PROJECT NAME :
TOWN SQUARE III

DEVELOPER NAME :
CM RESIDENCY

LEGEND:-

①	SOIL PIPE	
②	WASTE PIPE	
③	VENT PIPE	
④	COLD WATER SUPPLY (CWS)	
⑤	HOT WATER SUPPLY (HWS)	
	RAIN WATER PIPE	
SW	SEWER LINE- EXTERNAL	
RW	STORM WATER DRAINAGE PIPE	
	SEWERAGE MANHOLE (2' x 2')	M.H.
	STORM WATER MANHOLE (2' x 2')	M.H.
GT	GULLY TRAP	
BV	BALL VALVE	
FT	FLOOR TRAP	
FD	FLOOR FLOOR DRAIN	
	RAIN WATER COLLECTION CHAMBER 450X450MM	
	KHURRA	

For- CM RESIDENCY

Proprietor

Er. SANJEEV SHARMA
B.E (Electrical)

PROJECT:
KHASRA NO - 765 / 221 AT REVENUE
VILLAGE - NARSINGHPURA URF RIKSHA,
TEH. - SANGANER. JAIPUR. (RAJ.)

NAME OF DRAWING:
**5TH.FLOOR INTERNAL DRAINAGE PLAN,
INTERNAL PLUMBING PLAN,
UG WATER TANK TO OHT
FILLING ROUTE PLAN**

DRAWING WORKING DRAWING	NORTH:
PROJECT NO. :	DATE : 18-10-2024
SCALE : NTS	REV NO. : R-0

DRAWING NO. :	PROJECT	CATEGORY	BLOCK	FLOOR	TYPE	NUMBER
A-01						

5TH.FLOOR INTERNAL DRAINAGE PLAN, INTERNAL
PLUMBING PLAN, UG WATER TANK TO OHT FILLING ROUTE PLAN