

PROJECT NAME :
TOWN SQUARE III

DEVELOPER NAME :
CM RESIDENCY

LEGENDS:			
Mounting Height	ID	Symbol	Description
CEILING	FAN48"		CEILING FAN 48"
CEILING	FAN30"		CEILING FAN 30"
CEILING	CHI		CHANDELIER
+93"	TLW		Led Wall Tube Light
+93"	BULB		Led Bulb 20W
+93"	GL		WALL BRACKETS AS DESIGN FOR GANESH LIGHT
+78"	ML		12x2 Led Mirror Light
CEILING	DL		Led 6" Down Light 20W (Surface Mounted)
VENTILATOR HT.	CR		CEILING ROSE
VENTILATOR HT.	EXF		9" DIA FRESH AIR FAN
+24"	2wSB		2w SWITCH BOARD
+42"	SB		SWITCH BOARD 6A SOCKET & SWITCH
+24"	TEL		TELEPHONE POINT
+24"	LP TEL		6 A PLUG POINT FOR TELEPHONE
+48"	TV		TV COAXIAL POINT
+48"	LP TV		6 A PLUG POINT FOR TV
+24"	LP		6 A PLUG POINT FOR SIDE TABLE
+72"	LP CH		6 A PLUG POINT FOR CHIMNEY
+12"	LP PC		6 A PLUG POINT FOR COMPUTER POINT
+93"	SAC		SPLIT AC INDOOR UNIT
+42"	PP-MIX		16 A POWER POINT FOR MIXER
+42"	PP-MIC		16 A POWER POINT FOR MICROWAVE
+78"	PP-G		16 A POWER POINT FOR GEYSER
+54"	PP-F		16 A POWER POINT FOR FRIDGE
+78"	PP-WP		16 A POWER POINT FOR WATER PURIFIER
+48"	PP-WM		16 A POWER POINT FOR WASHING MACHINE
+12"	PP-INV		16 A POWER POINT FOR INVERTOR
+93"	PP-AC		25A SWITCH MCB FOR AC
			CHAMBER 2 X 2
+18"			6A 2 NOS. SOCKET 1 NOS. 16A SWITCH, TELEPHONE LAN, MODEM
BSS	6A 5S		6A 5S FAN REGULATOR SWITCH
BAC	6A 5S		6A 5S CAMERA
EV	32A		32A SINGLE PHASE EV CHARGING
PS	1R x 3C (1P+N+E) x 6SQMM		1R x 3C (1P+N+E) x 6SQMM COPPER CABLE
			2.2KW THREE PHASE SUPPLY
			1R x 5C (3P+N+E) x 2.5SQMM COPPER CABLE

For- CM RESIDENCY
Proprietor

Er. SANJEEV SHARMA
B.E (Electrical)


PROJECT ADDRESS:
KHASRA NO - 765 / 221 AT REVENUE VILLAGE - NARSINGHPURA URF RIKSHA, TEH. - SANGANER, JAIPUR. (RAJ.)

NAME OF DRAWING:
STILT FLOOR EXTERNAL LIGHTING, CEILING ELECTRICAL LAYOUT, ELECTRICAL POINT DRAWING, CAMERA POINT DRAWING

DRAWING: WORKING DRAWING
PROJECT NO.:
DATE: 20-08-2024


SCALE: NTS
REV NO.: R-0

DRAWING NO.:
PROJECT CATEGORY BLOCK FLOOR TYPE NAME
A-01

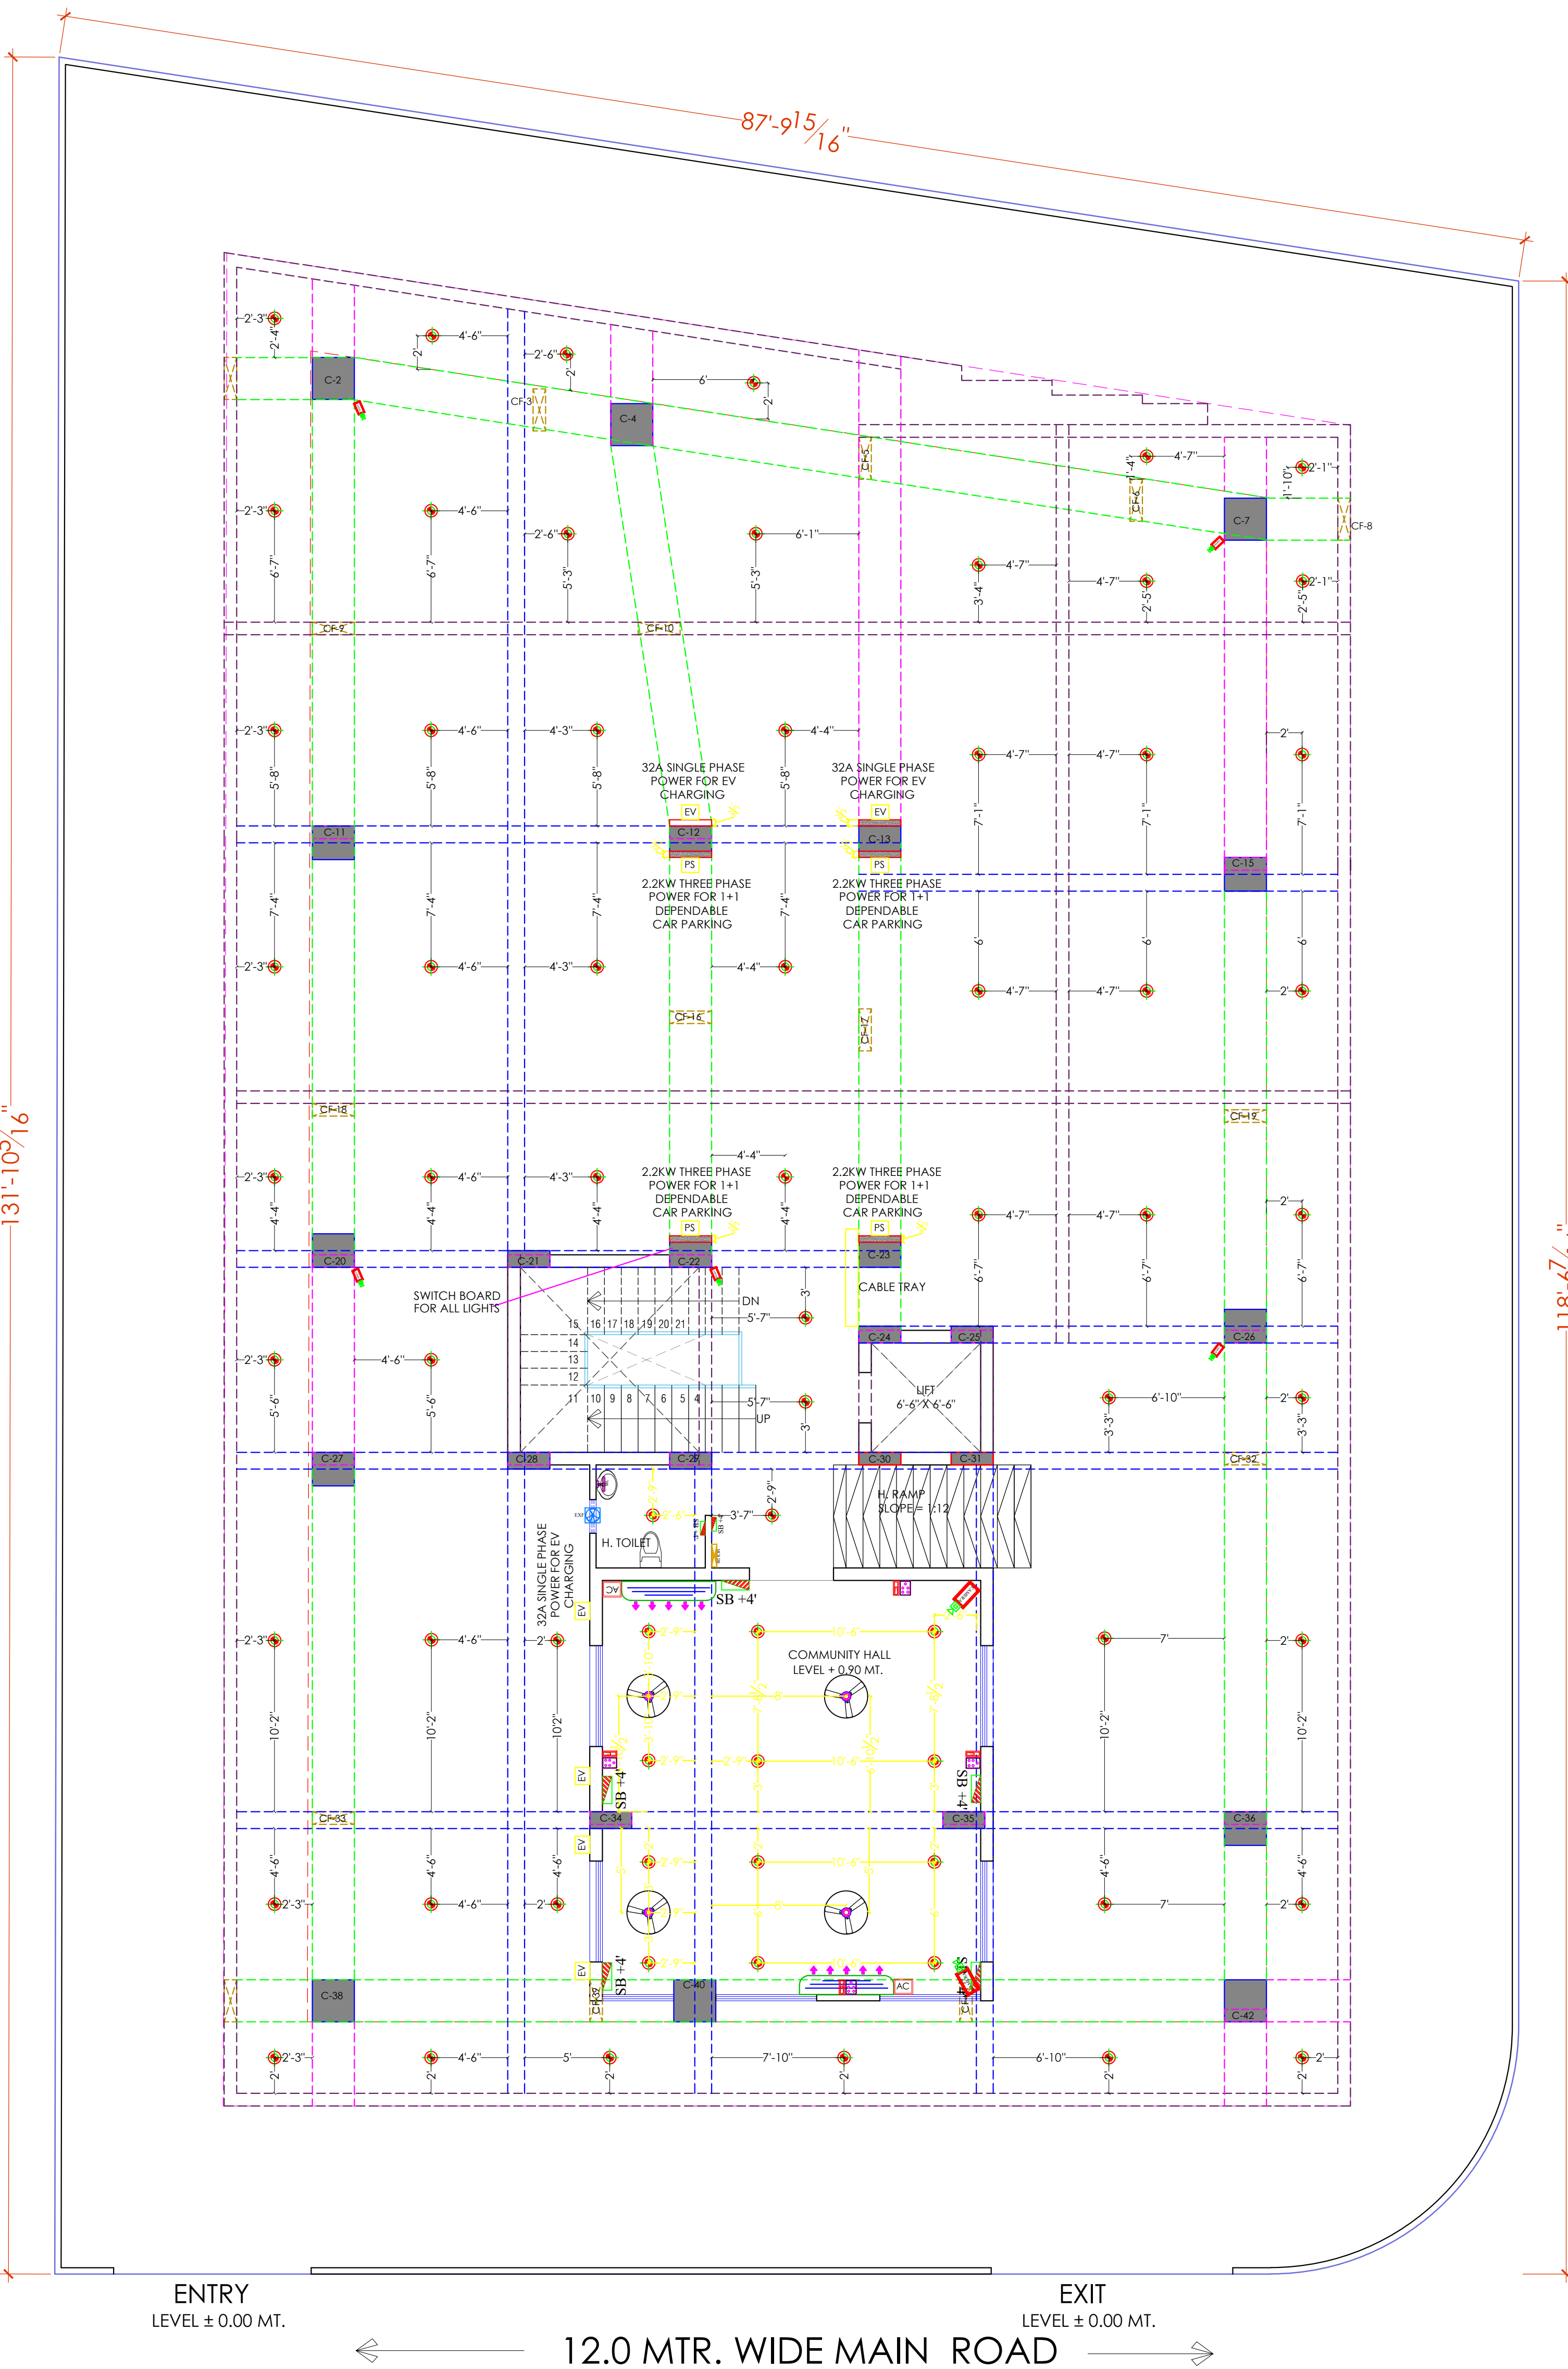

STILT FLOOR EXTERNAL LIGHTING, CEILING ELECTRICAL LAYOUT,
ELECTRICAL POINT DRAWING, CAMERA POINT DRAWING

	25 MM PVC CONDUIT FOR JB TO WALL POINT
	32 MM PVC CONDUIT FOR DB TO JB (JUNCTION BOX)

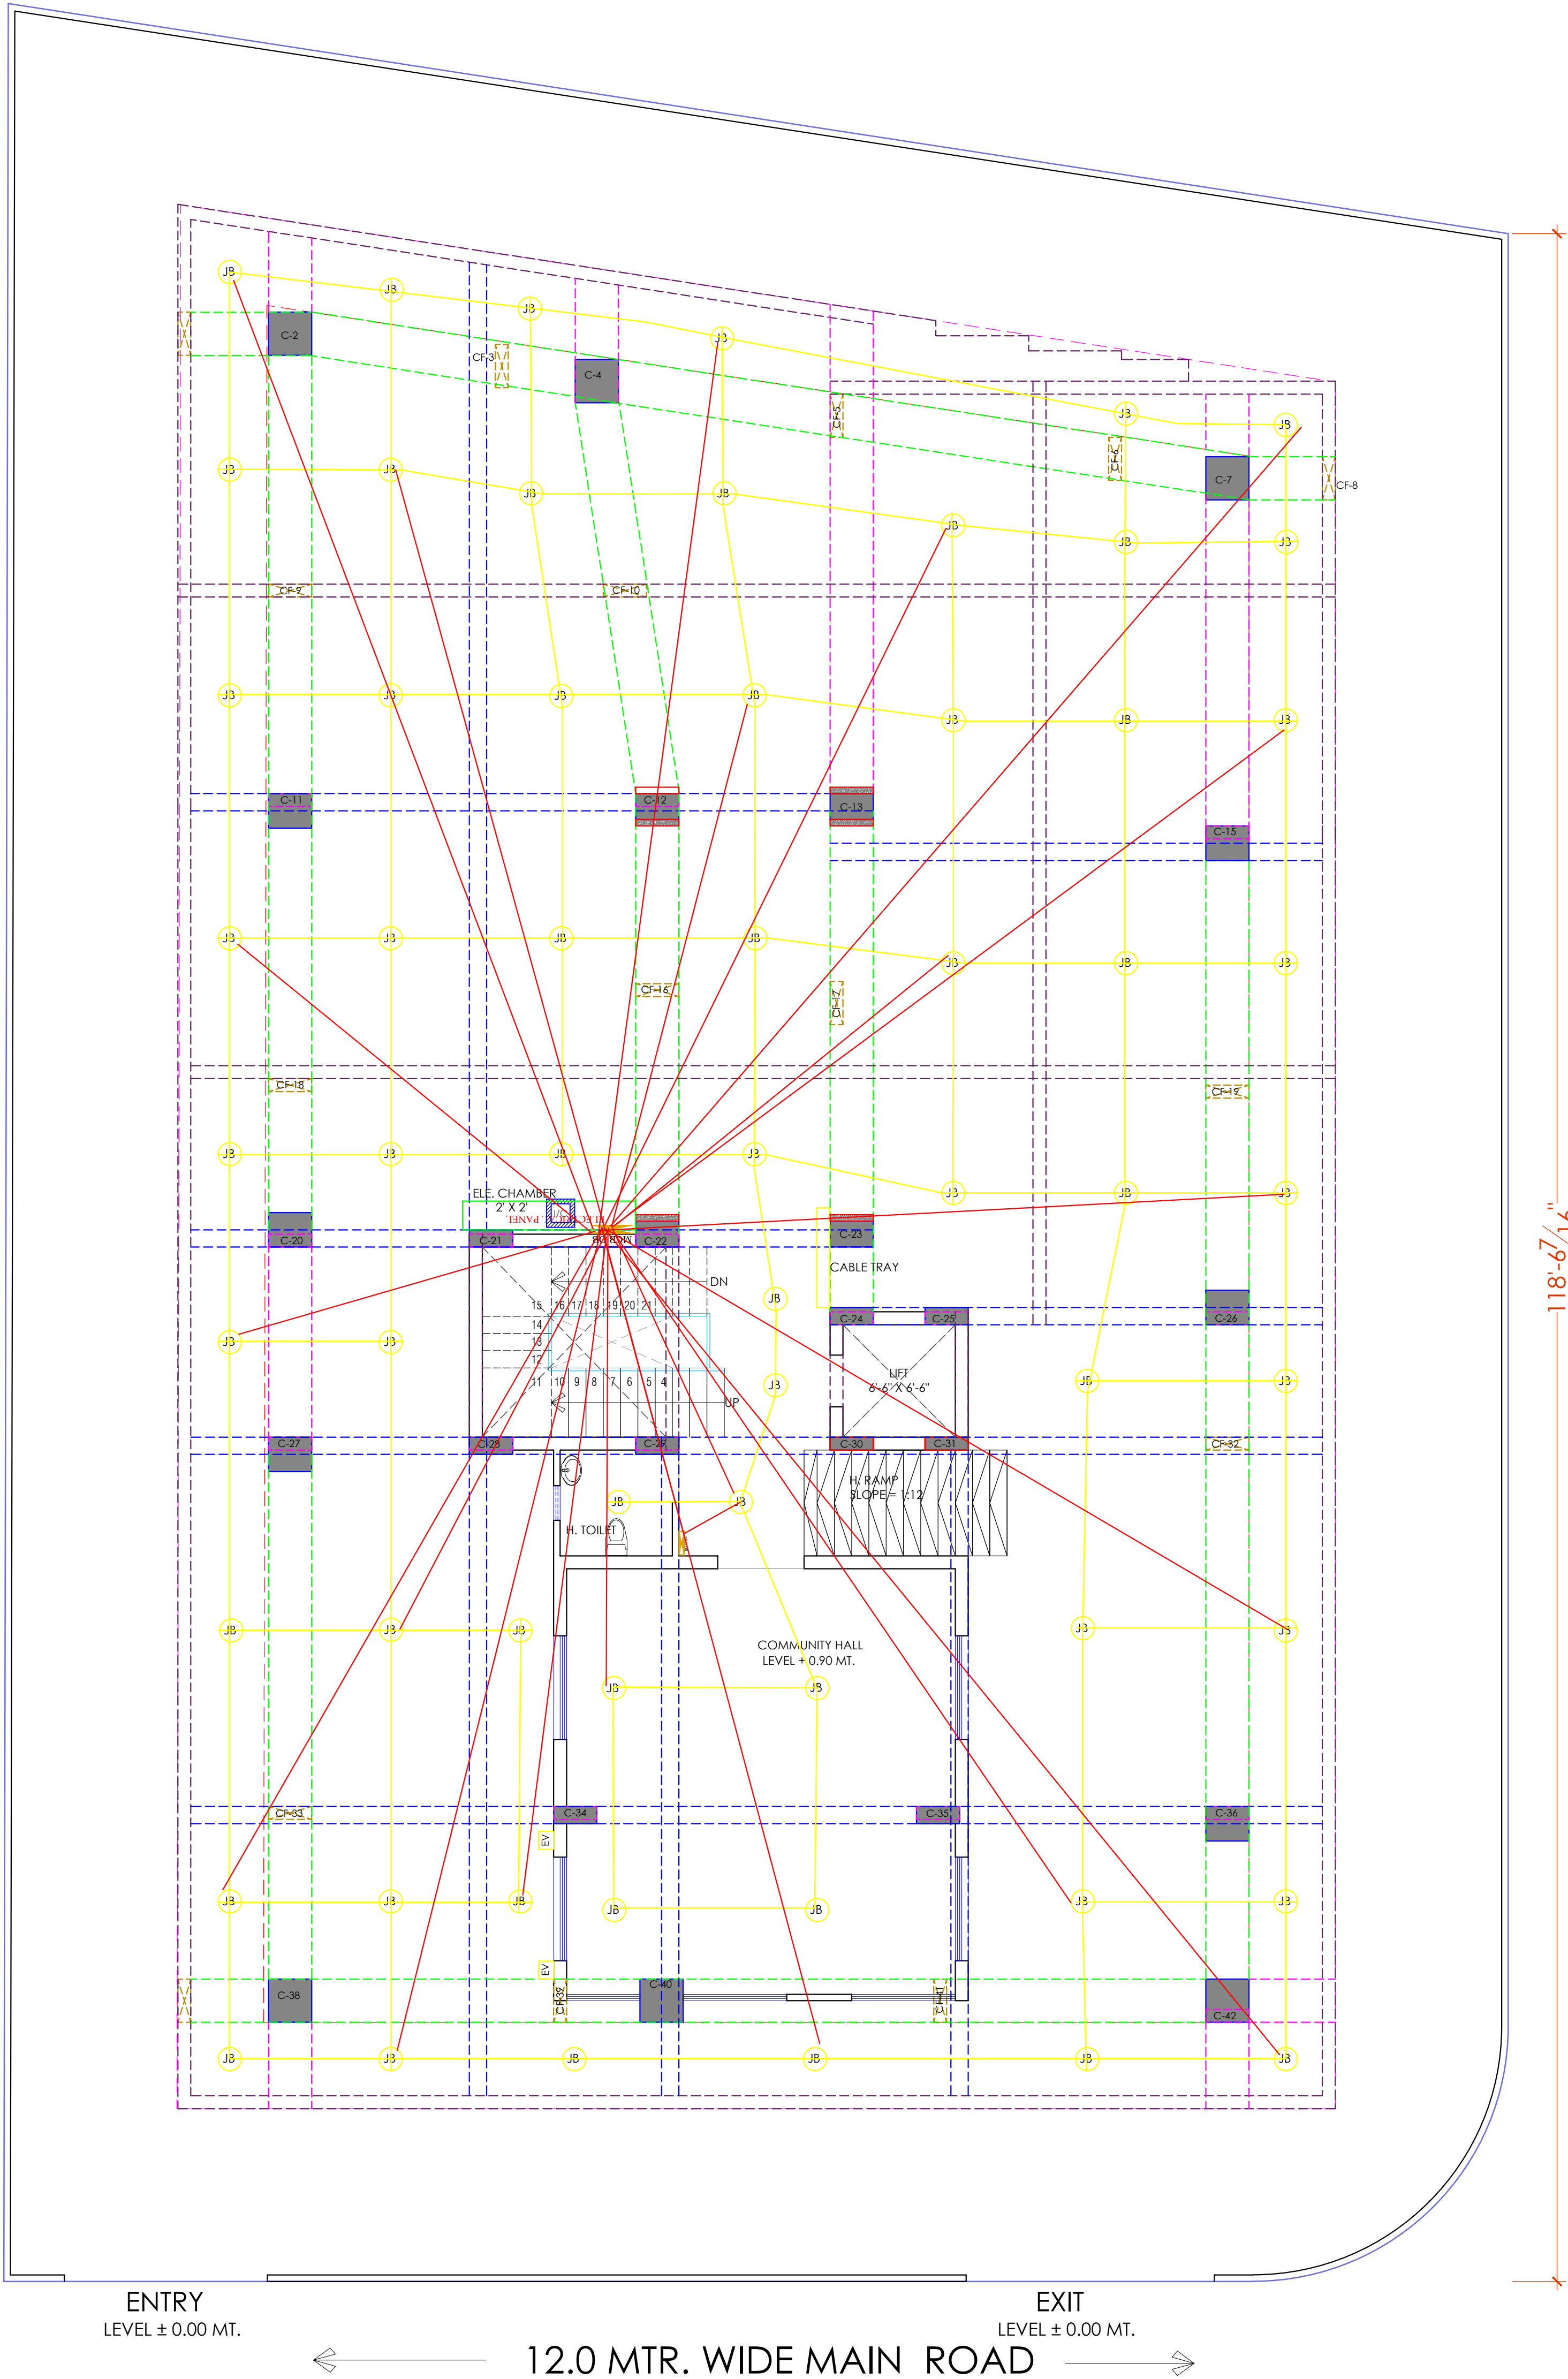

STILT FLOOR LV CONDUIT PLAN
STILT FLOOR ELECTRIC CONDUIT PLAN

PROJECT NAME :
TOWN SQUARE III
DEVELOPER NAME :
CM RESIDENCY

LEGENDS:			
Mounting Height	ID	Symbol	Description
CEILING	FAN48"		CEILING FAN 48"
CEILING	FAN30"		CEILING FAN 30"
CEILING	CHI		CHANDIELIER
+93"	TLW		Led Wall Tube Light
+93"	BULB		Led Bulb 20W
+93"	GL		WALL BRACKETS AS DESIGN FOR GANESH LIGHT
+78"	ML		12x2 Led Mirror Light
CEILING	DL		Led 6" Down Lighter 20W (Surface Mounted)
VENTILATOR HT.	CR		CEILING ROSE
VENTILATOR HT.	EXF		9" DIA FRESH AIR FAN
+24"	2wSB		2w SWITCH BOARD
+42"	SB		SWITCH BOARD/AA SOCKET & SWITCH
+24"	TEL		TELEPHONE POINT
+24"	LP TEL		6 A PLUG POINT FOR TELEPHONE
+48"	TV		TV COAXIAL POINT
+48"	LP TV		6 A PLUG POINT FOR TV
+24"	LP		6 A PLUG POINT FOR SIDE TABLE
+72"	LP CH		6 A PLUG POINT FOR CHIMNEY
+12"	LP PC		6 A PLUG POINT FOR COMPUTER POINT
+93"	SAC		SPLIT AC INDOOR UNIT
+42"	PP MIX		16 A POWER POINT FOR MIXER
+42"	PP MIC		16 A POWER POINT FOR MICROWAVE
+78"	PP G		16 A POWER POINT FOR GEYSER
+54"	PP F		16 A POWER POINT FOR FRIDGE
+78"	PP WP		16 A POWER POINT FOR WATER PURIFIER
+48"	PP WM		16 A POWER POINT FOR WASHING MACHINE
+12"	PP INV		16 A POWER POINT FOR INVERTOR
+93"	PP AC		25A SWITCH/MB FOR AC
			CHAMBER (2' X 2')
+18"			AA 3 NOS SOCKET + 1 NOS AA SWITCH TELEPHONE JUNCTION
BSS	AA 3 NOS		FAN REGULATOR SWITCH
BAC	6A 5S		6A 5S CAMERA
EV	32A		32A SINGLE PHASE EV CHARGING 1R x 3C (1P+N+E) x 2.5SQMM COPPER CABLE
PS	23KW		23KW THREE PHASE SUPPLY 1R x 5C (3P+N+E) x 2.5SQMM COPPER CABLE

For- CM RESIDENCY
Proprietor

Er. SANJEEV SHARMA
B.E (Electrical)

PROJECT ADDRESS:
KHASRA NO - 765 / 221 AT REVENUE VILLAGE - NARSINGHPURA URF RIKSHA, TEH. - SANGANER, JAIPUR. (RAJ.)

NAME OF DRAWING:
STILT FLOOR LV CONDUIT PLAN
STILT FLOOR ELECTRIC CONDUIT PLAN

DRAWING WORKING DRAWING	NORTH:
PROJECT NO.:	DATE: 20-08-2024
SCALE: NTS	REV NO.: R-0

DRAWING NO.:			
PROJECT	CATEGORY	BLOCK	FLOOR
A-01			

PROJECT NAME :
TOWN SQUARE III
DEVELOPER NAME :
CM RESIDENCY

LEGENDS:			
Mounting Height	ID	Symbol	Description
CEILING	FAN-48"		CEILING FAN 48"
CEILING	FAN-30"		CEILING FAN 30"
CEILING	CHU		CHANDELIER
+93"	TL/W		Led Wall Tube Light
+93"	BULB		Led Bulb 20W
+93"	GL		WALL BRACKETS AS DESIGN FOR GANESH LIGHT
+78"	ML		12x2 Led Mirror Light
CEILING	DL		Led 6" Down Lighter 20W (Surface Mounted)
VENTILATOR HT.	CR		CEILING ROSE
VENTILATOR HT.	EXF		9" DIA FRESH AIR FAN
+24"	2xSB		2xSWITCH BOARD
+142"	SB		SWITCH BOARD/SA SOCKET & SWITCH
+24"	TEL		TELEPHONE POINT
+24"	LP TEL		6 A PLUG POINT FOR TELEPHONE
+48"	TV		TV COAXIAL POINT
+48"	LP TV		6 A PLUG POINT FOR TV
+24"	LP		6 A PLUG POINT FOR SIDE TABLE
+72"	LP-CH		6 A PLUG POINT FOR CHIMNEY
+12"	LP PC		6 A PLUG FOR COMPUTER POINT
+93"	SAC		SPLIT AC INDOOR UNIT
+42"	PP-MIX		16 A POWER POINT FOR MIXER
+42"	PP-MIC		16 A POWER POINT FOR MICROWAVE
+78"	PP-G		16 A POWER POINT FOR GEYSER
+54"	PP-F		16 A POWER POINT FOR FRIDGE
+78"	PP-WP		16 A POWER POINT FOR WATER PURIFIER
+48"	PP-WM		16 A POWER POINT FOR WASHING MACHINE
+12"	PP-INV.		16 A POWER POINT FOR INVERTOR
+93"	PP-AC		25A SWITCH/ACB FOR AC
			CHAMBER(2 X 2)
+18"			6A/5A SOCKET 1 MCB 16A SWITCH TELEPHONE LAN
+60"	MCB DB		MCB DISTRIBUTION BOARD
			CAMERA
			WALL FAN
BSB			6A/5A FAN REGULATOR IL SWITCH
BAC			6A/5A/25A AC

12.0 MTR. WIDE MAIN ROAD

For- CM RESIDENCY
Proprietor

Er. SANJEEV SHARMA
B.E (Electrical)

PROJECT:
KHASRA NO - 765 / 221 AT REVENUE VILLAGE - NARSINGHPURA URF RIKSHA, TEH. - SANGANER. JAIPUR. (RAJ.)

NAME OF DRAWING:
TYPICAL FLOOR G+5TH
(ELECTRICAL POINT, CEILING POINT,TV)

DRAWING
WORKING DRAWING


NORTH:

PROJECT NO. :
DATE :
27, Feb. - 2025

SCALE :
NTS
REV NO. :
R-1


DRAWING NO. :
PROJECT CATEGORY BLOCK FLOOR TYPE NUMBER

A-201

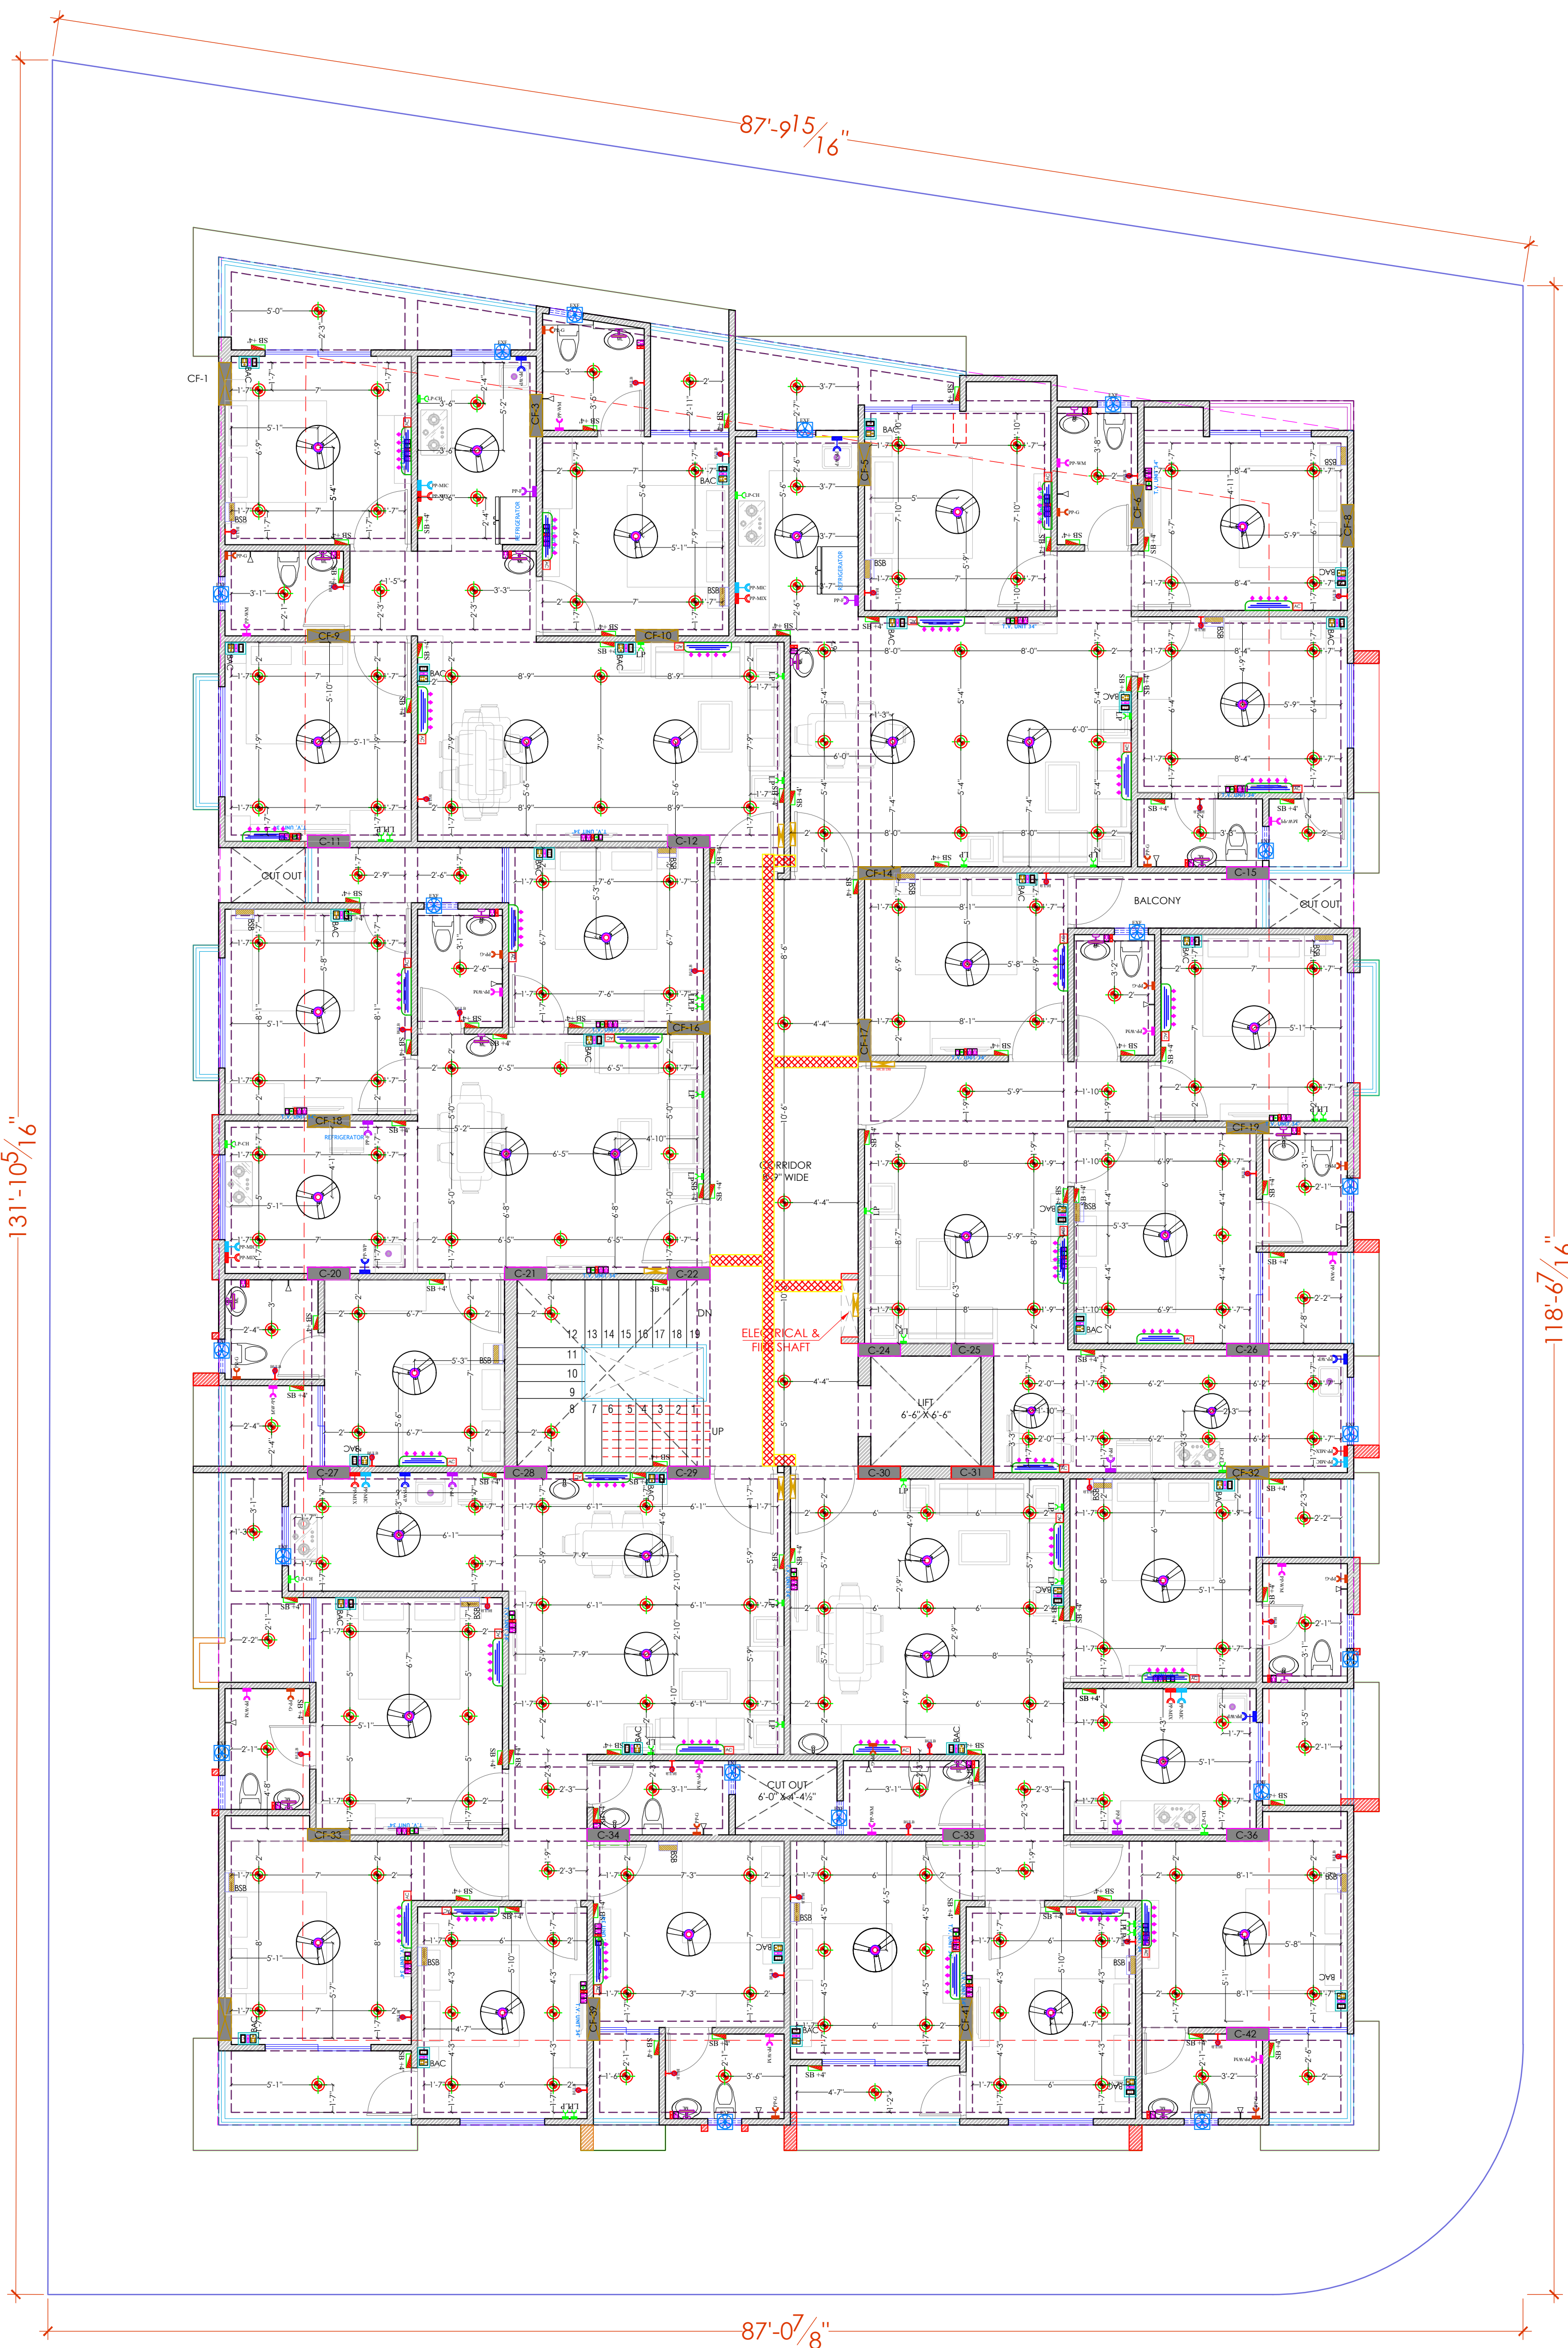

TYPICAL FLOOR G+4TH
(ELECTRICAL POINT, CEILING POINT,TV)

	25 MM PVC CONDUIT FOR JB TO WALL POINT
	32 MM PVC CONDUIT FOR DB TO JB (JUNCTION BOX)

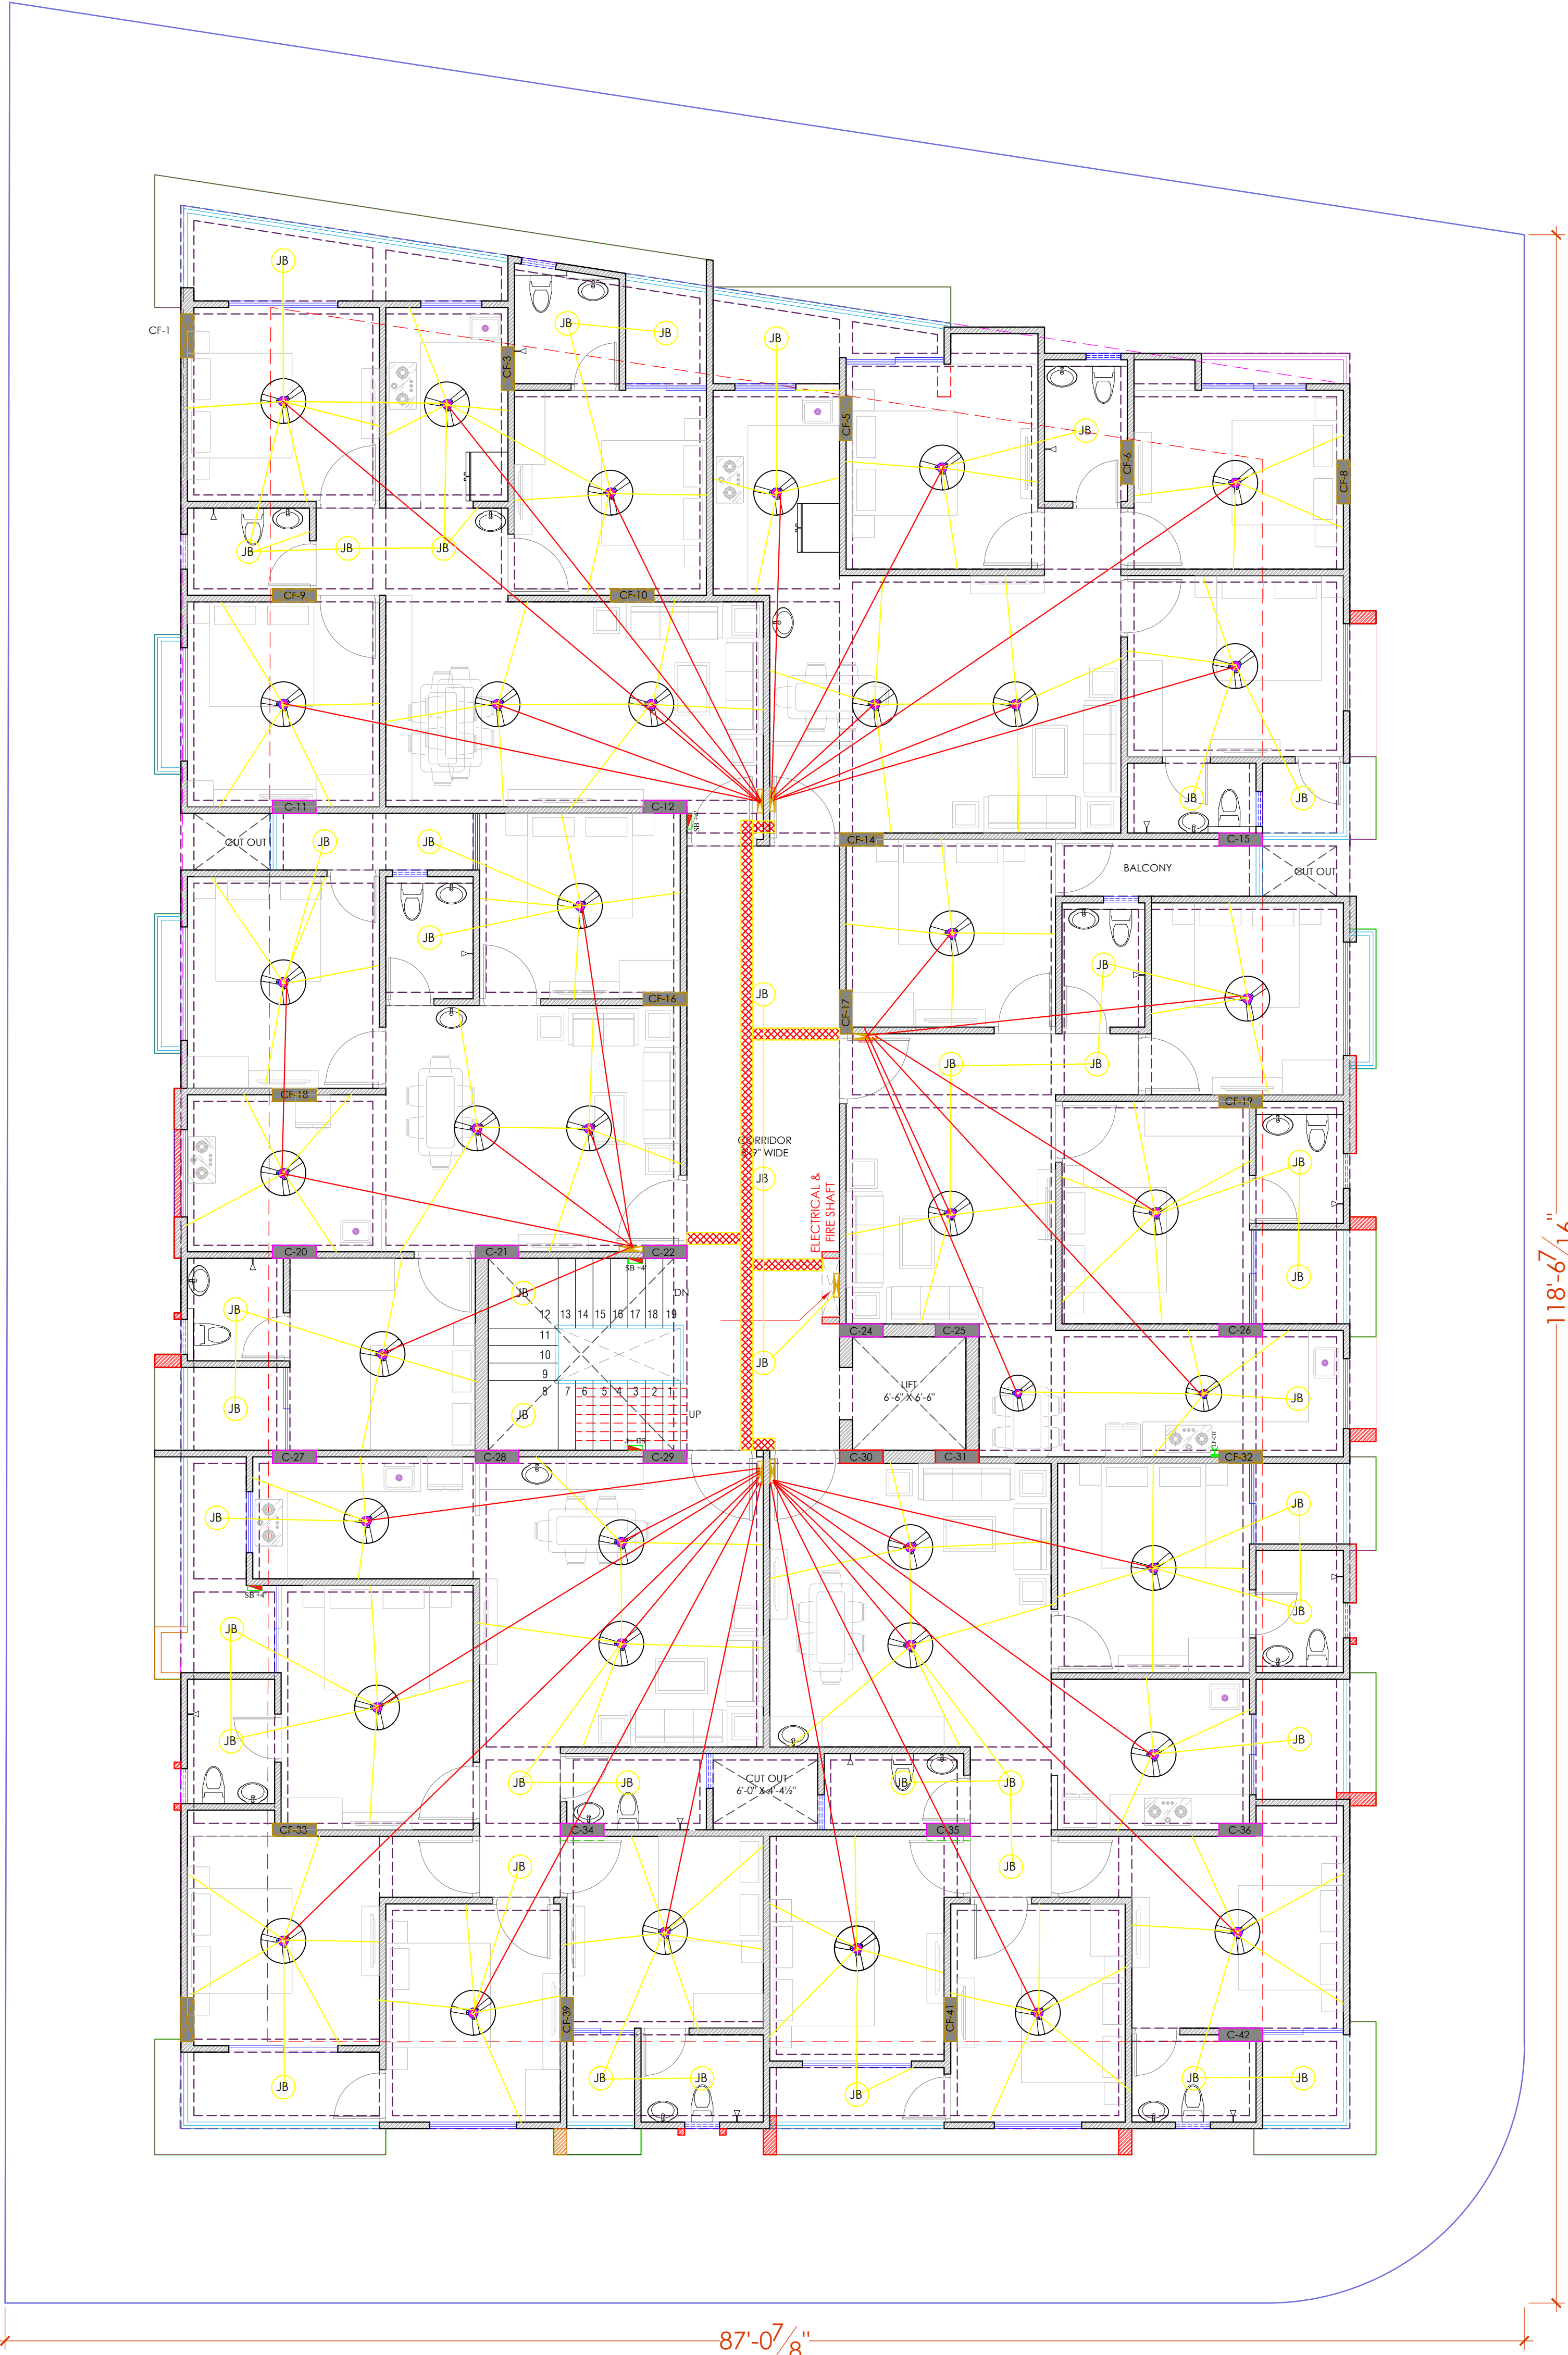

TYPICAL FLOOR (GROUND TO 4TH) LV CONDUIT PLAN, ELECTRIC CONDUIT PLAN,ELECTRICAL DB, ELECTRICAL SHAFT, CABLE TRAY

PROJECT NAME :
TOWN SQUARE III
DEVELOPER NAME :
CM RESIDENCY

LEGENDS:			
Mounting Height	I D	Symbol	Description
CEILING	FAN 48"		CEILING FAN 48"
CEILING	FAN 30"		CEILING FAN 30"
CEILING	CH1		CHANDIELIER
+93"	TL/W		Led Wall Tube Light
+93"	BULB		Led Bulb 20W
+93"	GL		WALL BRACKETS AS DESIGN FOR GANESH LIGHT
+78"	ML		12x2 Led Mirror Light
CEILING	DL		Led 6" Down Lighter 20W (Surface Mounted)
VENTILATOR HT.	CR		CEILING ROSE
VENTILATOR HT.	EXF		9" DIA FRESH AIR FAN
+24"	2xSB		2xSWITCH BOARD
+42"	SB		SWITCH BOARD(SA SOCKET & SWITCH)
+24"	TEL		TELEPHONE POINT
+24"	LP TEL		6 A PLUG POINT FOR TELEPHONE
+48"	TV		TV COAXIAL POINT
+48"	LP TV		6 A PLUG POINT FOR TV
+24"	LP		6 A PLUG POINT FOR SIDE TABLE
+72"	LP CH		6 A PLUG POINT FOR CHIMNEY
+12"	LP PC		6 A PLUG FOR COMPUTER POINT
+93"	SAC		SPLIT AC INDOOR UNIT
+42"	PP-MIX		16 A POWER POINT FOR MIXER
+42"	PP-MIC		16 A POWER POINT FOR MICROWAVE
+78"	PP-G		16 A POWER POINT FOR GEYSER
+54"	PP-F		16 A POWER POINT FOR FRIDGE
+78"	PP-WP		16 A POWER POINT FOR WATER PURIFIER
+48"	PP-WM		16 A POWER POINT FOR WASHING MACHINE
+12"	PP-INV		16 A POWER POINT FOR INVERTER
+93"	PP-AC		25A SWITCH/MCB FOR AC
			CHAMBER(2' X 2')
+18"			6A 2 NOS SOCKET + 1 NOS 16A SWITCH, TELEPHONE JUNCTION
+60"	MCB DB		MCB DISTRIBUTION BOARD
			CAMERA
			WALL FAN
BSB			6A 5/3 FAN REGULATOR IL SWITCH
BAC			6A 5/5 .25 A AC

For- CM RESIDENCY
Proprietor

ER. SANJEEV SHARMA
B.E (Electrical)

PROJECT:															
KHASRA NO - 765 / 221 AT REVENUE VILLAGE - NARSINGHPURA URF RIKSHA TEH. - SANGANER. JAIPUR. (RAJ.)															
NAME OF DRAWING:															
TYPICAL FLOOR (GROUND TO 5TH) LV CONDUIT PLAN, ELECTRIC CONDUIT PLAN,ELECTRICAL DB ELECTRICAL SHAFT, CABLE TRAY															
DRAWING: WORKING DRAWING	NORTH: 														
PROJECT NO.:	DATE: 27, Feb. - 2025														
SCALE: NTS	REV NO. : R-1														
DRAWING NO.:															
<table><tr><td> </td><td> - </td><td> - </td><td> </td><td> </td><td> </td><td> </td></tr><tr><td>PROJECT</td><td>CATEGORY</td><td>BLOCK</td><td>FLOOR</td><td>TYPE</td><td>NUMBER</td><td></td></tr></table>			-	-					PROJECT	CATEGORY	BLOCK	FLOOR	TYPE	NUMBER	
	-	-													
PROJECT	CATEGORY	BLOCK	FLOOR	TYPE	NUMBER										
A-201															

PROJECT NAME :

TOWN SQUARE III

DEVELOPER NAME :

CM RESIDENCY

LEGENDS:

Mounting Height	ID	Symbol	Description
CEILING	FAN48"		CEILING FAN 48"
CEILING	FAN30"		CEILING FAN 30"
CEILING	CHU		CHANDELIER
+93"	TL/W		Led Wall Tube Light
+93"	BULB		Led Bulb 20W
+93"	GL		WALL BRACKETS AS DESIGN FOR GANESH LIGHT
+78"	ML		12x2 Led Mirror Light
CEILING	DL		Led 6" Down Lighter 20W (Surface Mounted)
VENTILATOR HT.	CR		CEILING ROSE
VENTILATOR HT.	EXF		9" DIA FRESH AIR FAN
+24"	2wSB		2w SWITCH BOARD
+42"	SB		SWITCH BOARD (6A SOCKET & SWITCH)
+24"	TEL		TELEPHONE POINT
+24"	LP TEL		6A PLUG POINT FOR TELEPHONE
+48"	TV		TV COAXIAL POINT
+48"	LP TV		6A PLUG POINT FOR TV
+24"	LP		6A PLUG POINT FOR SIDE TABLE
+72"	LP-CH		6A PLUG POINT FOR CHIMNEY
+12"	LP-PC		6A PLUG POINT FOR COMPUTER POINT
+93"	SAC		SPLIT AC INDOOR UNIT
+42"	PP-MIX		16A POWER POINT FOR MIXER
+42"	PP-MIC		16A POWER POINT FOR MICROWAVE
+78"	PP-G		16A POWER POINT FOR GEYSER
+54"	PP-F		16A POWER POINT FOR FRIDGE
+78"	PP-WP		16A POWER POINT FOR WATER PURIFIER
+48"	PP-WM		16A POWER POINT FOR WASHING MACHINE
+12"	PP-INV		16A POWER POINT FOR INVERTOR
+93"	PP-AC		25A SWITCH/ACB FOR AC
			CHAMBER (2' X 2')
+18"			6A 2 NOS. SOCKET + 1 NOS. 16A SWITCH, TELEPHONE, LAN
+60"	MCB DB		MCB DISTRIBUTION BOARD
			CAMERA
			WALL FAN
BSB			6A S/S FAN REGULATOR, T/S SWITCH
BAC			6A S/S 25A AC

For- CM RESIDENCY

Proprietor

Er. SANJEEV SHARMA
B.E (Electrical)

PROJECT:

KHASRA NO - 765 / 221 AT REVENUE VILLAGE - NARSINGHPURA URF RIKSHA, TEH. - SANGANER. JAIPUR. (RAJ.)

NAME OF DRAWING:

5th FLOOR
(ELECTRICAL POINT, CEILING POINT, TV)

DRAWING

WORKING DRAWING

NORTH:



PROJECT NO. :

DATE :

27, Feb. - 2025

SCALE :

NTS

REV NO. :

R-1

DRAWING NO. :

PROJECT	CATEGORY	BLOCK	FLOOR	TYPE	NUMBER

A-201

12.0 MTR. WIDE MAIN ROAD

5th FLOOR

(ELECTRICAL POINT, CEILING POINT, TV)