


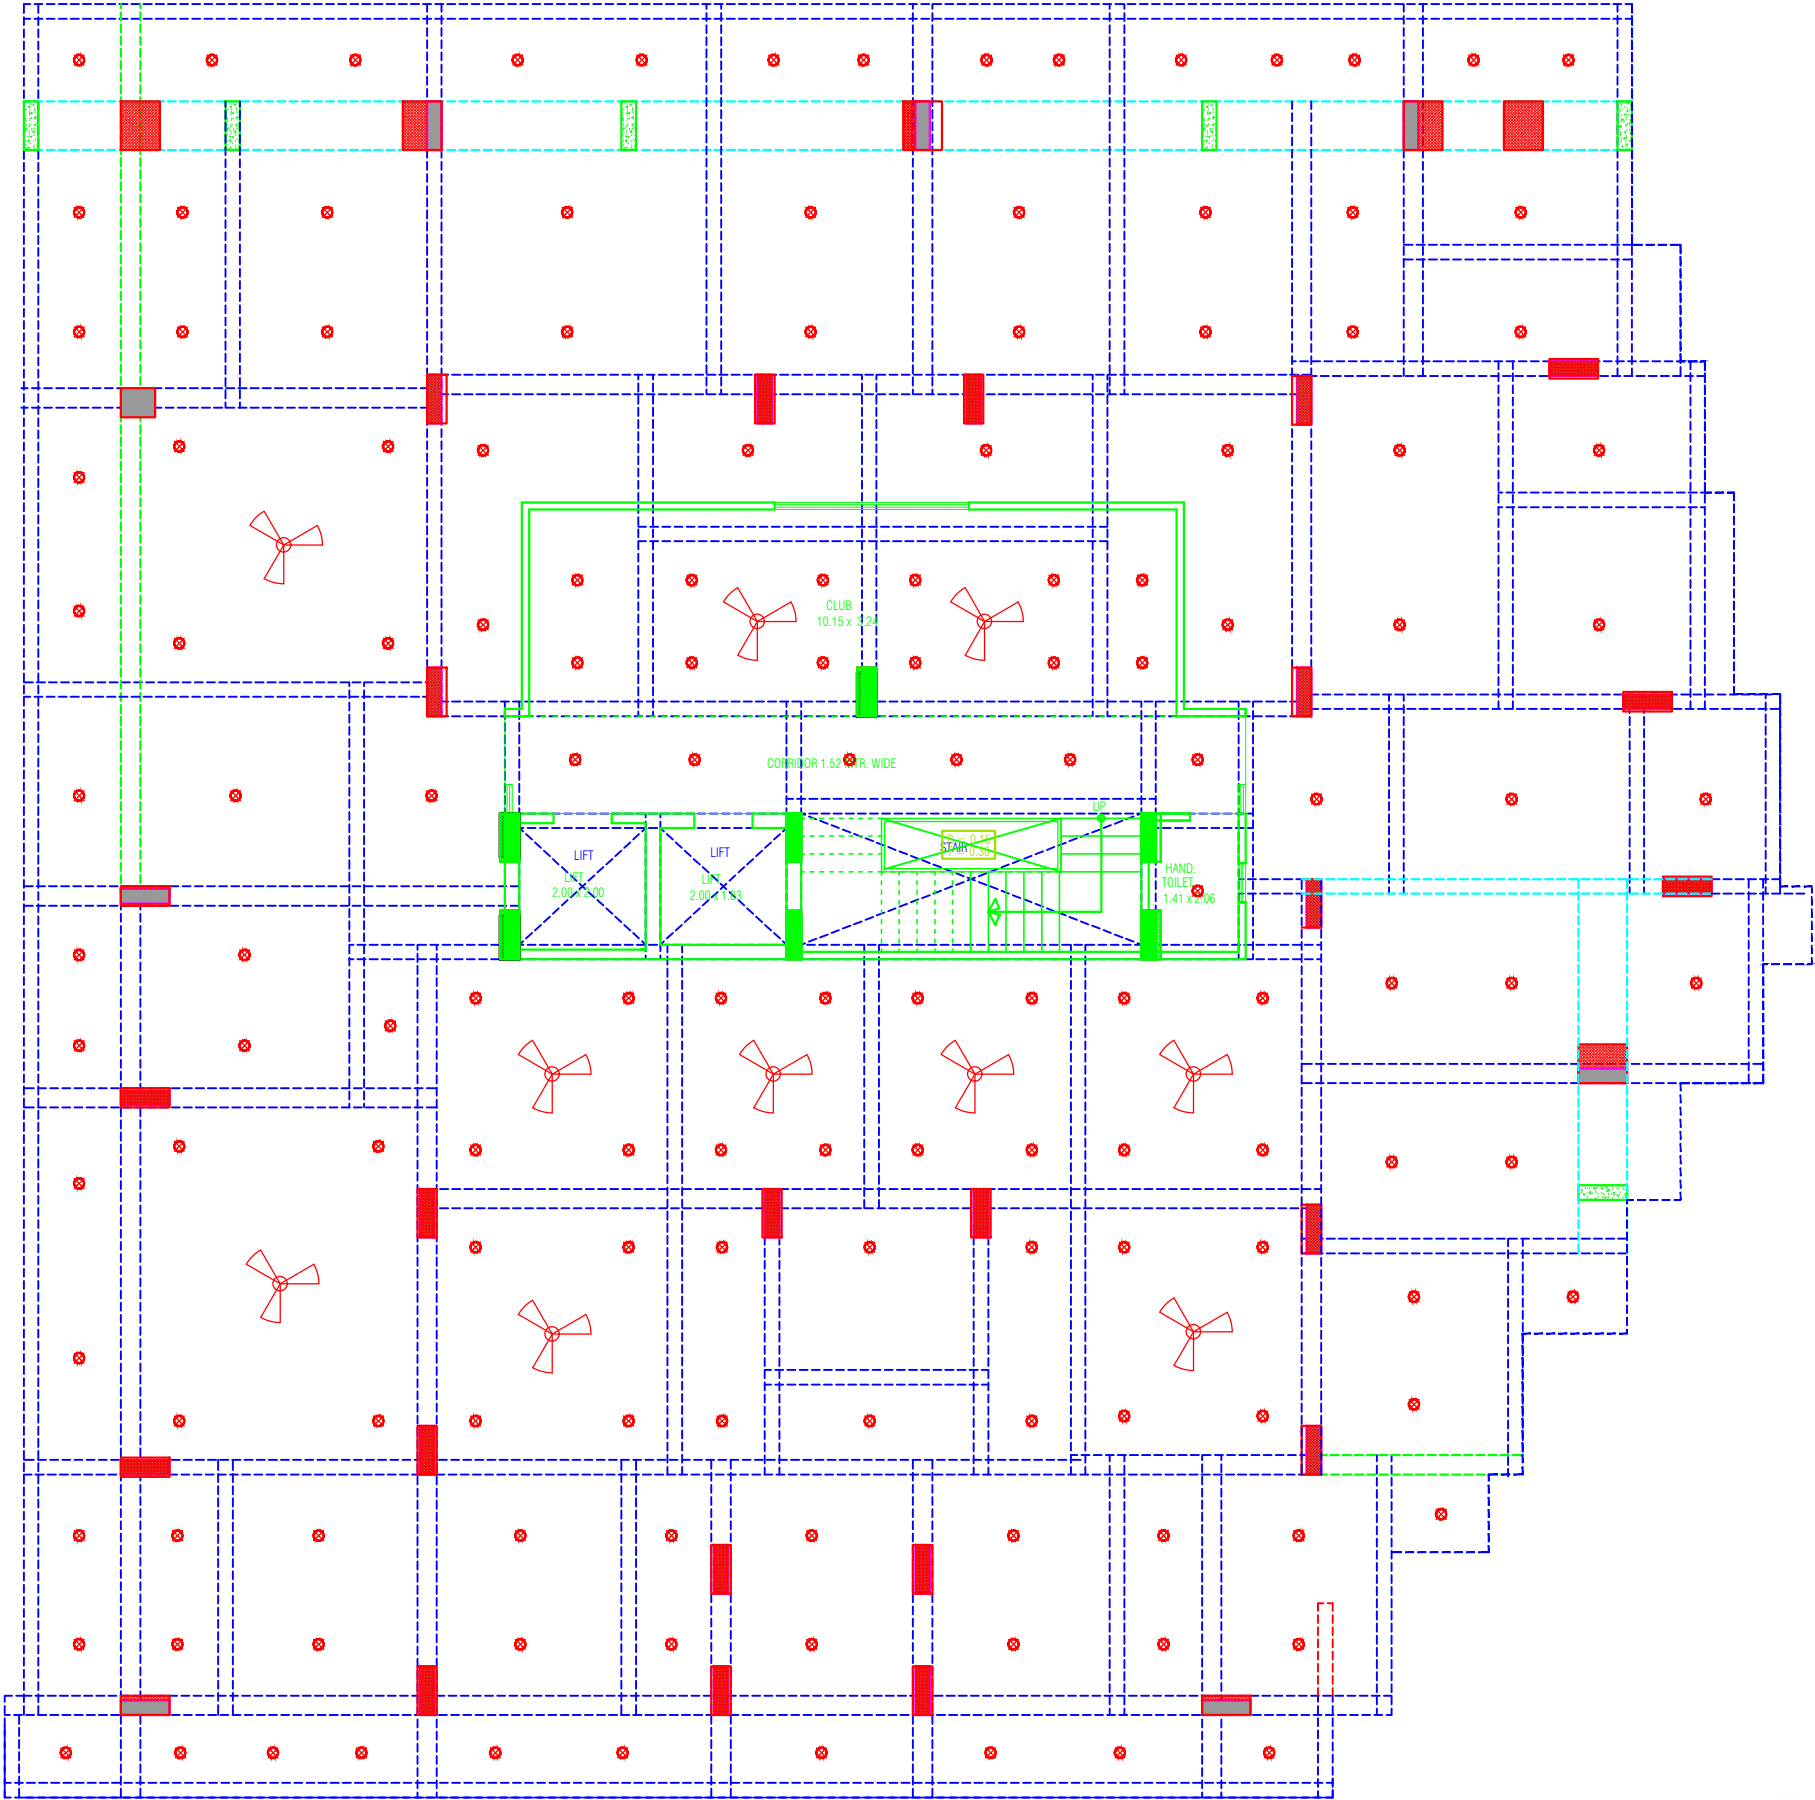


NO	ITEM	SYMBOL
1	CEILING FAN	ROOF
2	TUBE LIGHT	+8'6"
3	BULB	+8'6"
4	POWER POINT	+1'6"
5	BED POINT	+4'3"
6	CEILING LIGHT	ROOF
7	A.C.POINT	+6'6"
8	SWITCH BOARD	+4'3"
9	EXHAUST	VENT
10	TELEPHONE	+1'6"
11	GYSER	+6'0"
12	BELL POINT	+8'6"
13	T.V.	+1'6"
14	M.BOX	M.B.
15	M.C.B.	+6'6"
16	FANCY LIGHT	+8'6"
17	HANGING LIGHT	ROOF

M/S Shivam Builders and Developers
Partner

RAMESH KUMAWAT
M.E.P. CONSULTANT
B.E. CIVIL

PROJECT TITLE :- PROPOSED BUILDING AT PLOT NO-26,27,28,29,30,& 31, KRISHNA SAROVER JAIPUR	BUILDING NAME SHIVAM GRAND	DRAWING TITLE :- STILT FLOOR ELECTRIC PLAN	SPACE CONSULTANT PLOT-A-173, JAGDAMBA NAGAR, HEERAPURA POWER HOWER, JAIPUR (RAJ) 302024	DRN. BY		DATE	NORTH
				APPD. BY		REVISION	
	DEVELOPER NAME SHIVAM BUILDERS AND DEVELOPERS			SCALE			

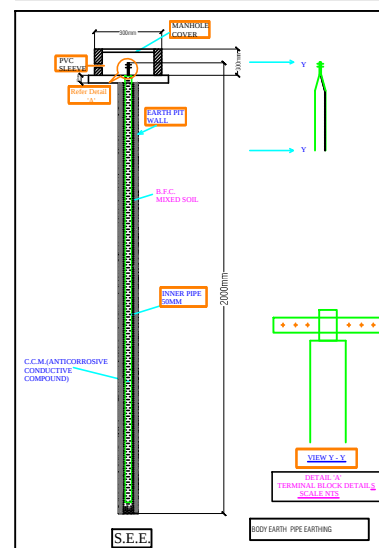

SEAL:-

RAMESH KUMAR
M.E.P. CONSULTANT
P.E. CIVIL

PLOT-A-173, JAGDAMBA NAGAR, HEERAPURA
POWER HOWER, JAIPUR (RAJ) 302024

 FRANK SQUARE

ARCHITECTURE | PLANNER | DESIGNER
C-49 VIDYA APARTMENT PARAS MARG,
BAPU NAGAR JAIPUR, (RAJ.) Email-affranksquare@gmail.com
Mobile-9461302542

PROPOSED BUILDING AT PLOT
NO-26,27,28,29,30,& 31, KRISHNA
SAROVER JAIPUR


BUILDING NAME	SHIVAM GRAND
---------------	--------------

DEVELOPER NAME	SHIVAM BUILDERS AND DEVELOPERS
----------------	--------------------------------

DRAWING:

STILT FLOOR
ELECTRIC SUB STATION,
CABLE ROUTE &
LIGHTNING ARRESTER FOR RERA
SUBMISSION PLAN

DATE	
SCALE:-	N.T.S.

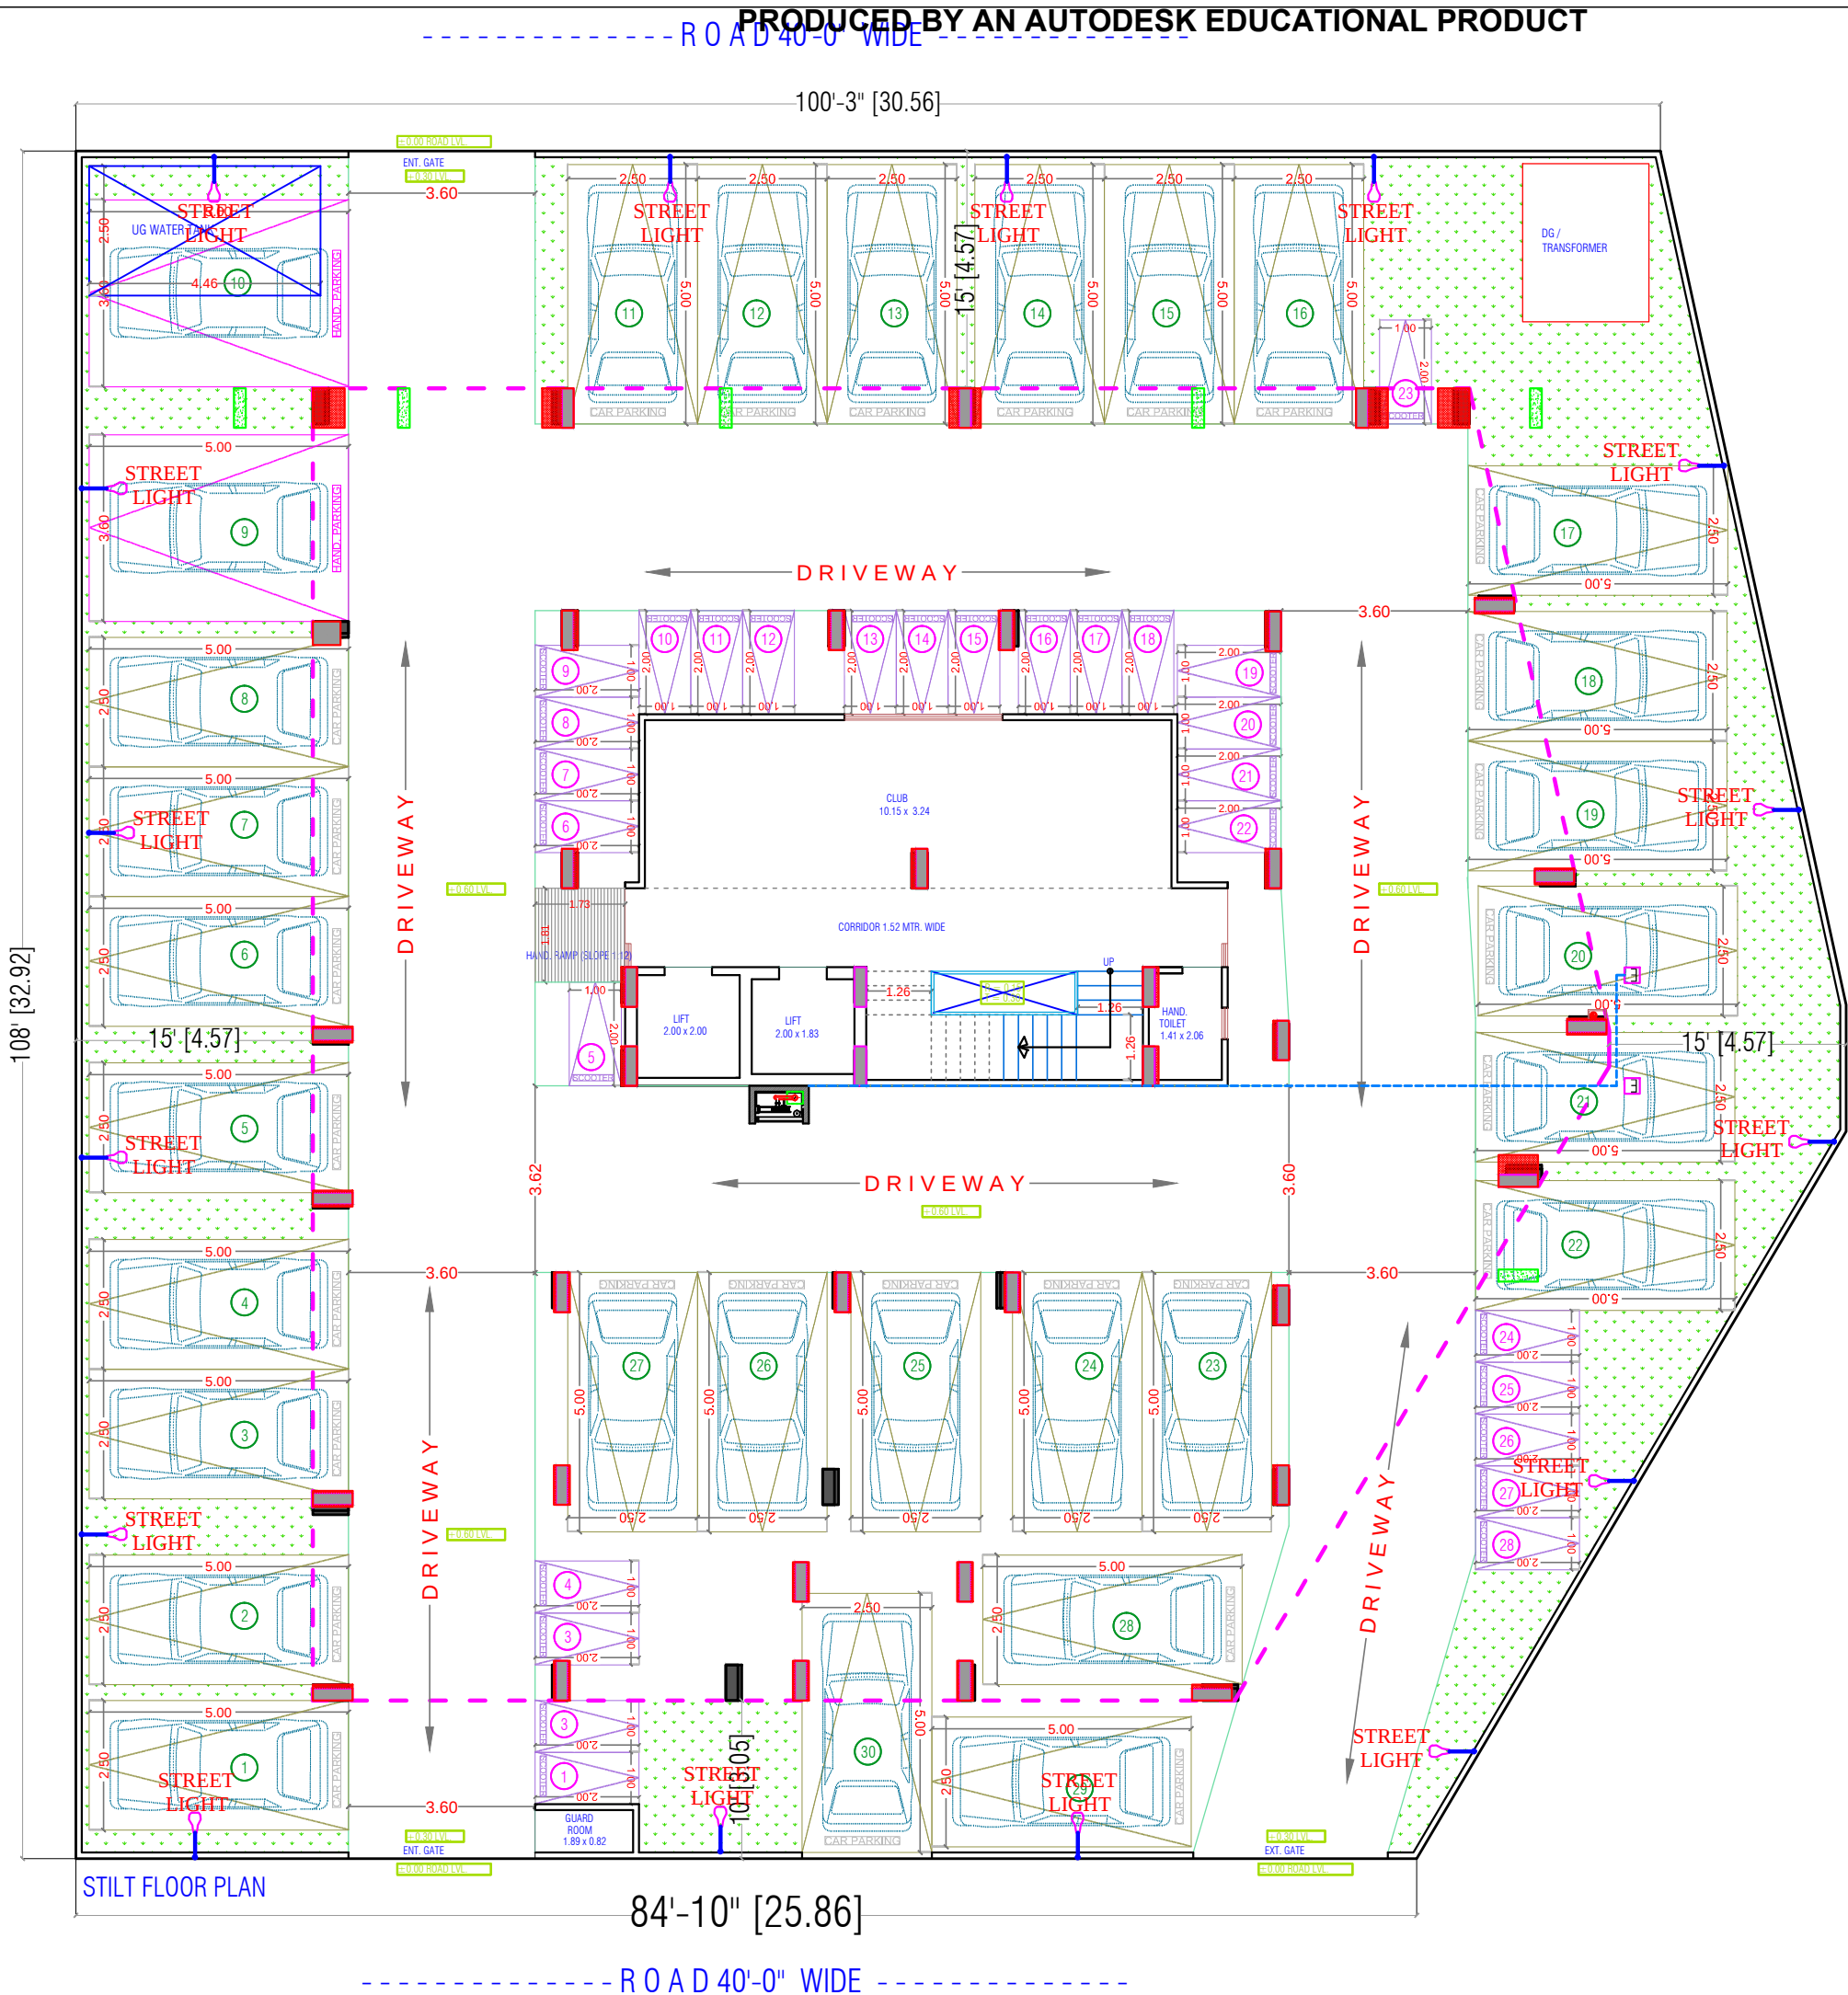

LEGENDS:

Qty.	I D	Symbol	Description
14	PL		STREET LIGHT

SIGN:-

Shivam Builders and Developers
PARTNER

RAMESH KUMAWAT
M.E.P. CONSULTANT
B.E. CIVIL

SPACE CONSULTANT

PLOT-A-173, JAGDAMBA NAGAR, HEERAPURA
POWER HOWER, JAIPUR (RAJ) 302024

ARCHITECT :-



FRANK SQUARE

ARCHITECTURE | PLANNER | DESIGNER
C-49 VIDYA APARTMENT PARAS MARG,
BAPU NAGAR JAIPUR, (RAJ.) Email-franksquare@gmail.com
Mobile-9461302542

PROJECT :-

PROPOSED BUILDING AT PLOT
NO-26,27,28,29,30,& 31, KRISHNA
SAROVER JAIPUR

BUILDING NAME

SHIVAM GRAND

DEVELOPER NAME

SHIVAM BUILDERS AND DEVELOPERS


DRAWING:

STILT FLOOR
EXTERNAL STREET LIGHT
FOR RERA SUBMISSION PLAN

DATE

SCALE:-

N.T.S.

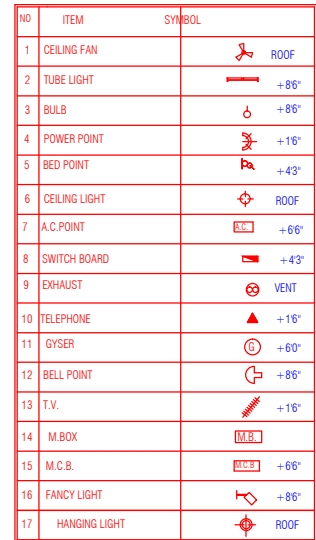

M/S Shivam Builders and Developers
Jaigopal Singh
PARTNER


RAMESH KUMAWAT
M.E.P. CONSULTANT
B.E. CIVIL

PROJECT TITLE :-
PROPOSED BUILDING AT PLOT
NO-26,27,28,29,30,& 31,
KRISHNA SAROVER JAIPUR

SHIVAM GRAND

SHIVAM BUILDERS AND DEVELOPERS


SERVICE DRAWING SLD/DISTRIBUTION AFTER
LT PANEL, EARTHING LAYOUT, EXTERNAL
LIGHTING PLAN, TV & TELEPHONE
RISER, LIGHTING ARRESTR, & PIT LOCATION

PLOT-A-173, JAGDAMBA NAGAR, HEERAPURA
POWER HOWER, JAIPUR (RAJ) 302024

DATE

REVISION

N.T.S

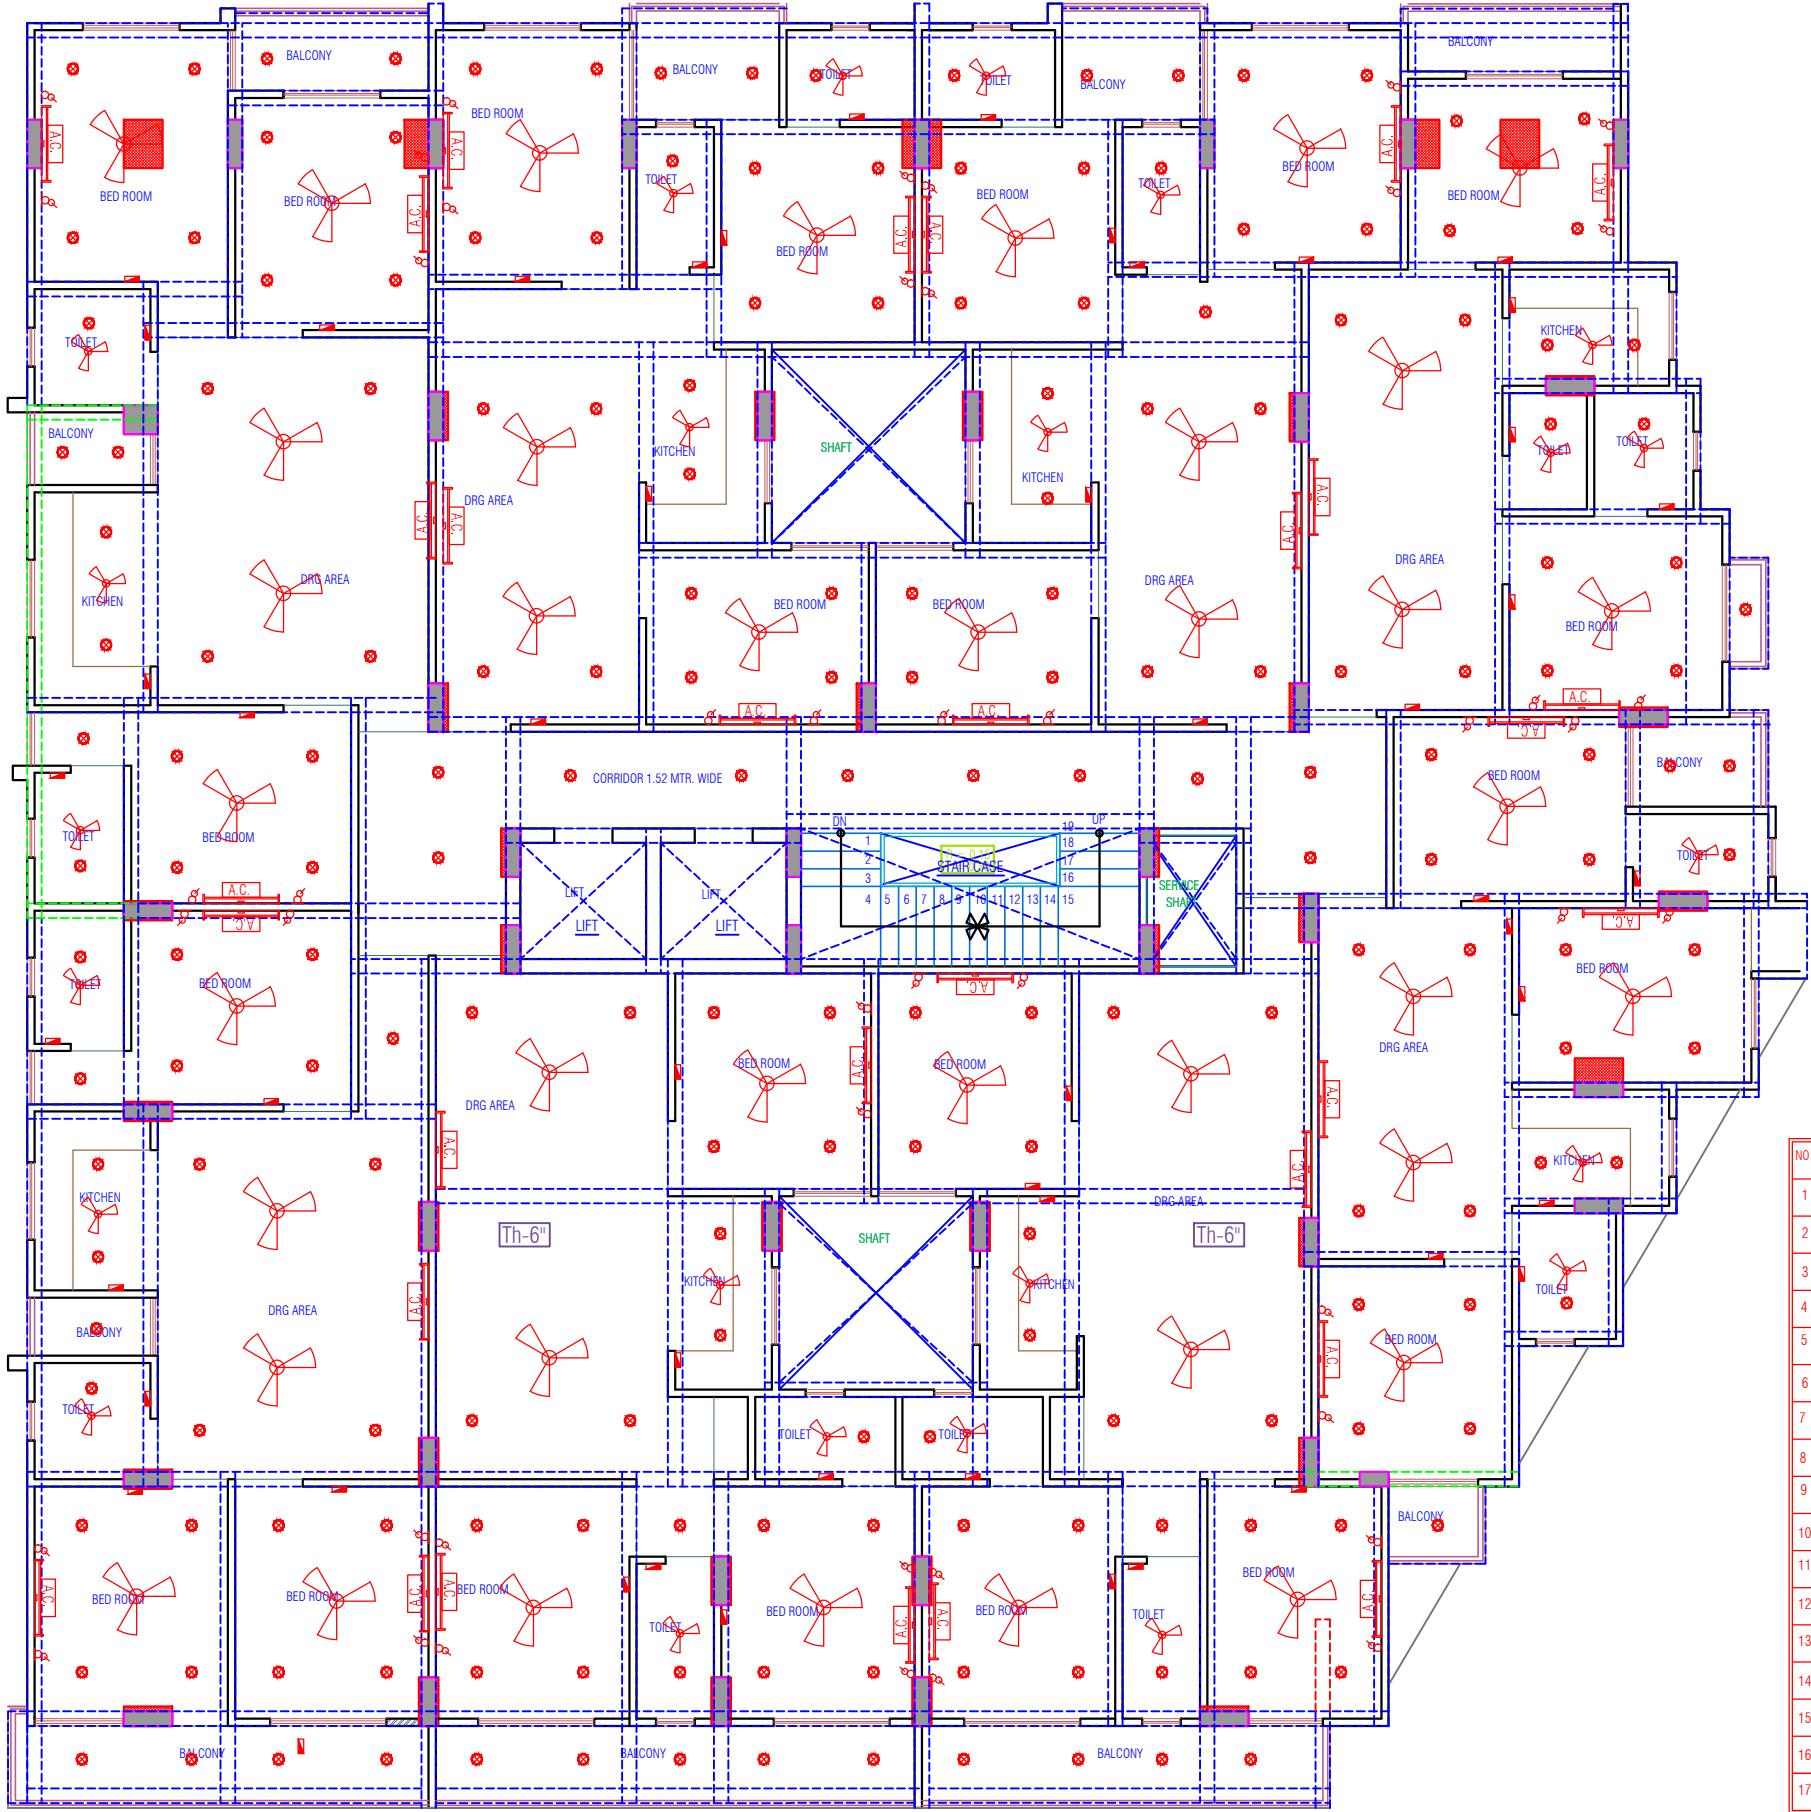


NO	ITEM	SYMBOL
1	CEILING FAN	ROOF
2	TUBE LIGHT	+8'6"
3	BULB	+8'6"
4	POWER POINT	+1'6"
5	BED POINT	+4'3"
6	CEILING LIGHT	ROOF
7	A.C.POINT	+6'6"
8	SWITCH BOARD	+4'3"
9	EXHAUST	VENT
10	TELEPHONE	+1'6"
11	GYSER	+6'0"
12	BELL POINT	+8'6"
13	T.V.	+1'6"
14	M.BOX	M.B.
15	M.C.B.	M.C.B. +6'6"
16	FANCY LIGHT	+8'6"
17	HANGING LIGHT	ROOF

M/S Shivam Builders and Developers
Shivam Builders and Developers
PARTNER

Ramesh Kumawat
RAMESH KUMAWAT
M.E.P. CONSULTANT
B.E. CIVIL

PROJECT TITLE :- PROPOSED BUILDING AT PLOT NO-26,27,28,29,30,& 31, KRISHNA SAROVER JAIPUR	BUILDING NAME SHIVAM GRAND		DRAWING TITLE :- TYPICAL FLOOR ELECTRIC PLAN	SPACE CONSULTANT PLOT-A-173, JAGDAMBA NAGAR, HEERAPURA POWER HOWER, JAIPUR (RAJ) 302024	DRN. BY			NORTH
	DEVELOPER NAME SHIVAM BUILDERS AND DEVELOPERS				APPD. BY		DATE	
					REVISION			
					SCALE			

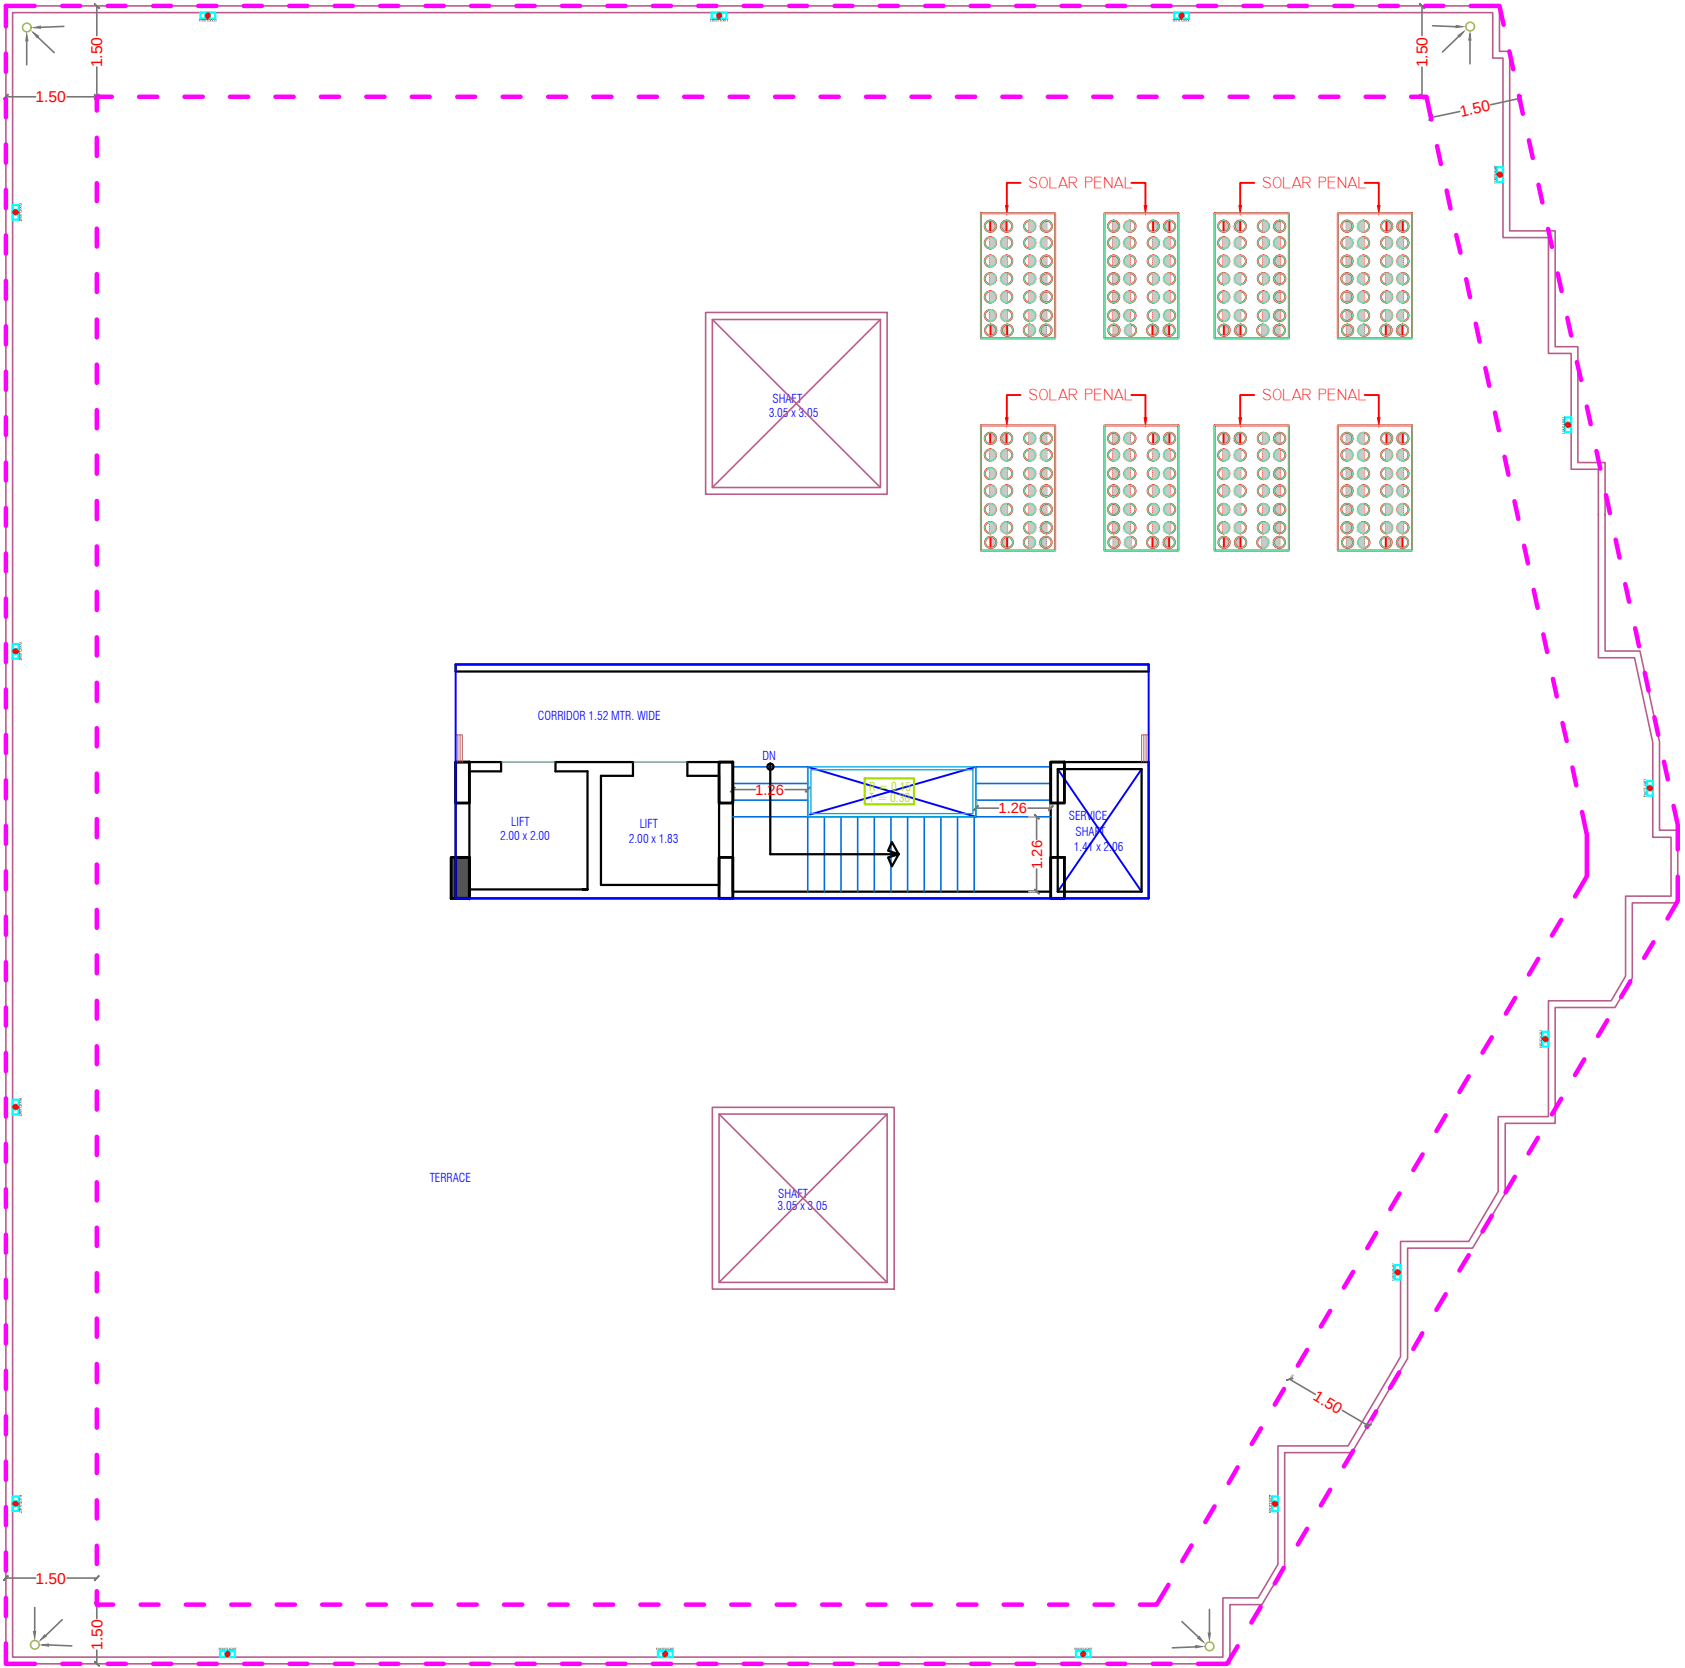

TERRACE FLOOR PLAN

RAMESH KUMAWAT
M.E.P. CONSULTANT
B.E. CIVIL

M/S Shivam Builders and Developers
PARTNER

LEGENDS:				
Mounting Height	No.	I D	Symbol	Description
+90"		TL/W		LED WALL TUBE LIGHT
+2"		FL		FOOT LIGHT
CEILING		DL		LED DOWN LIGHTE (SURFACE MOUNTED)
+42"				

PROJECT TITLE :- PROPOSED BUILDING AT PLOT NO-26,27,28,29,30,& 31, KRISHNA SAROVER JAIPUR	BUILDING NAME SHIVAM GRAND	DRAWING TITLE :- TERRACE FLOOR ELECTRIC POINT	SPACE CONSULTANT PLOT-A-173, JAGDAMBA NAGAR, HEERAPURA POWER HOWER, JAIPUR (RAJ) 302024	DRN. BY		DATE	NORTH
	DEVELOPER NAME SHIVAM BUILDERS AND DEVELOPERS			APPD. BY		REVISION	
				SCALE			