














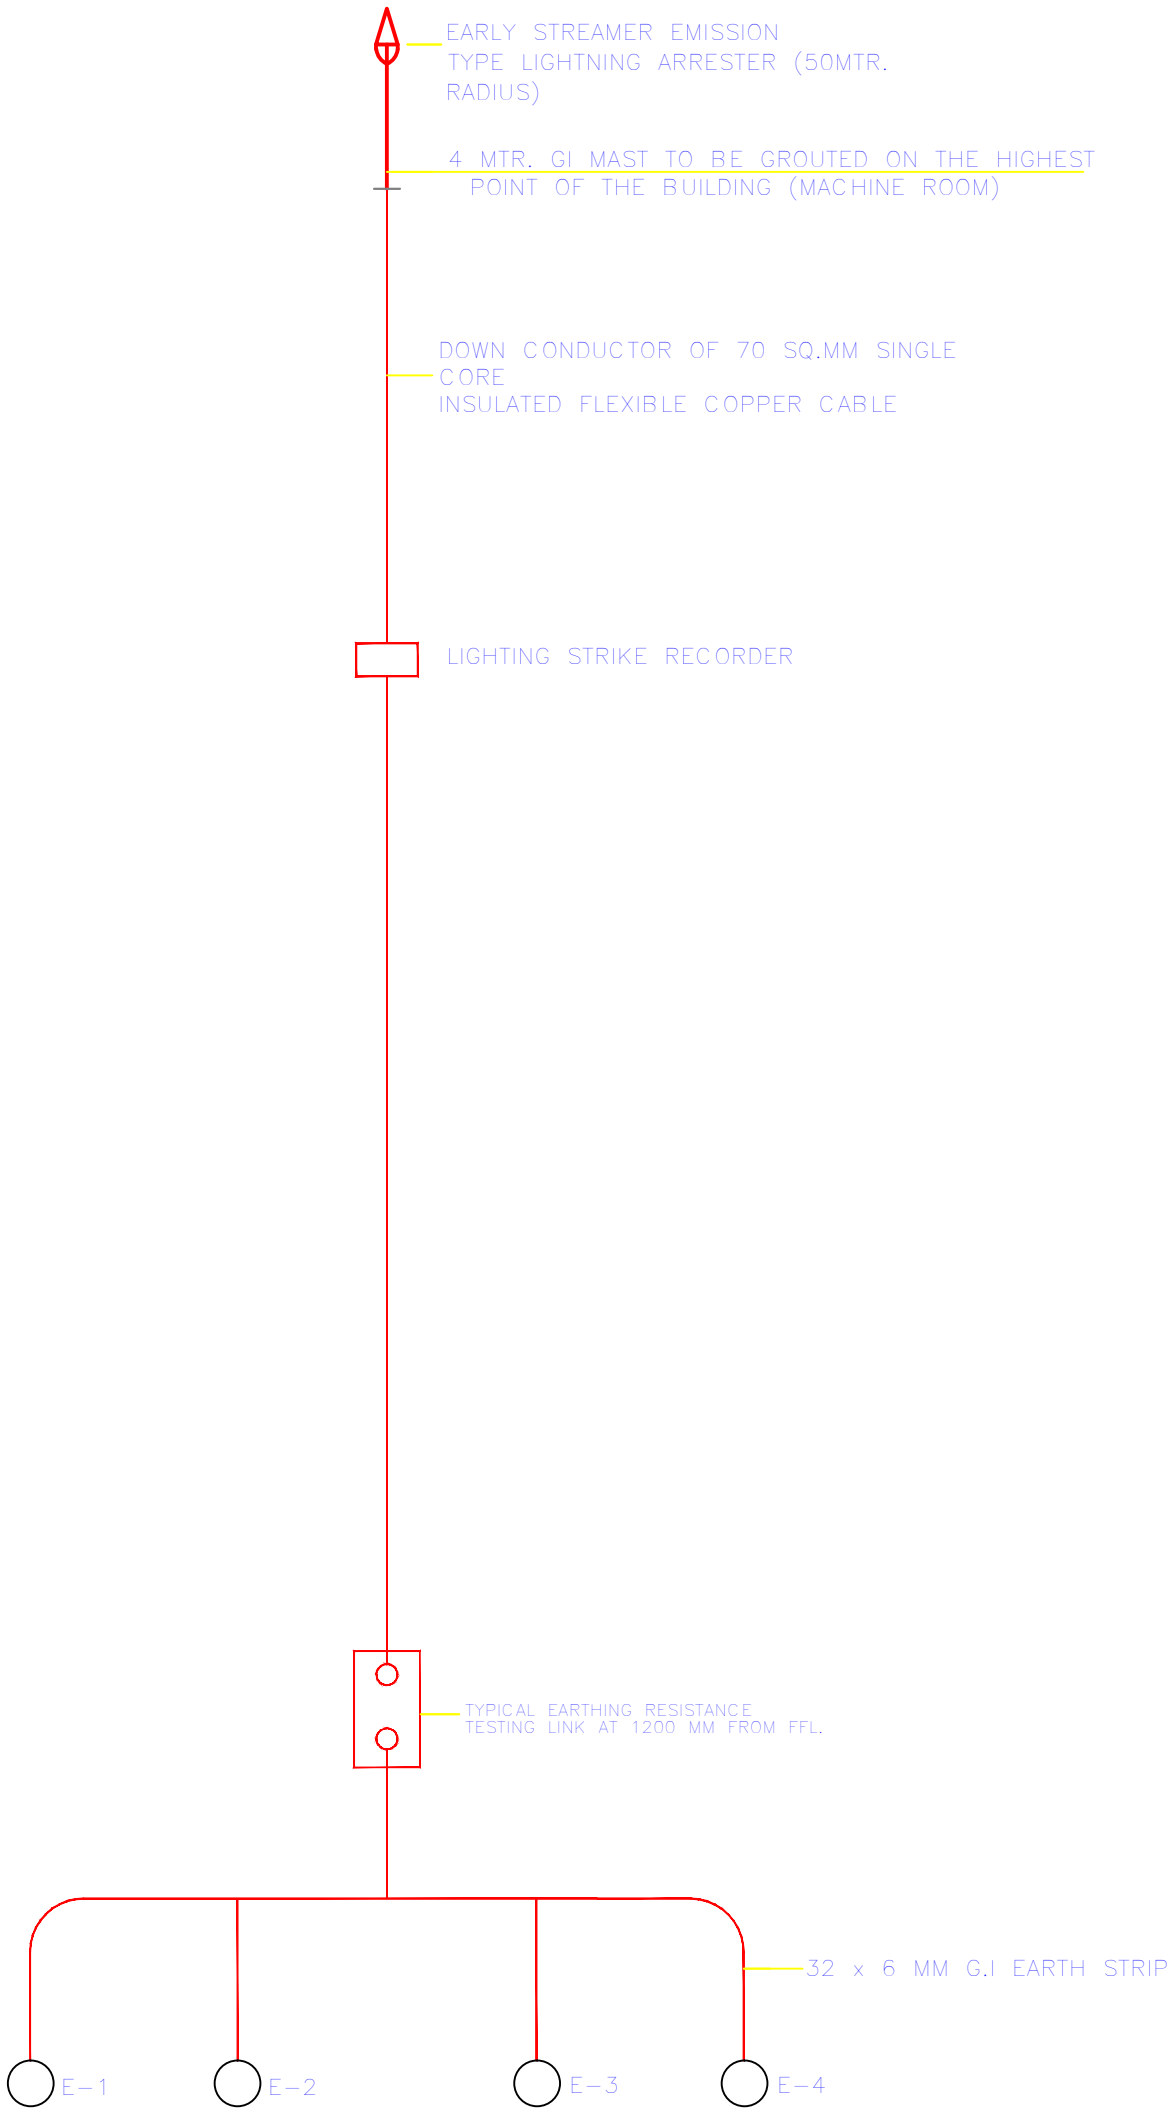




REVISION - 00			
GENERAL NOTES :			
1. ALL THE DIMENSIONS ON THE DRAWINGS ARE IN WRITTEN.			
2. ONLY WRITTEN DIMENSIONS ARE TO BE FOLLOWED, DRAWING SHOULD NOT BE SCALED IN ANY CIRCUMSTANCES.			
3. ALL MEASUREMENTS MUST BE CHECKED AND VERIFIED BY THE CONTRACTORS PRIOR TO EXECUTION OF WORK AT THE SITE.			
4. THIS DRAWING IS TO BE READ IN CONJUNCTION WITH ALL RELEVANT STRUCTURAL, ARCHITECTURAL & FACILITY PLANNING DRAWINGS.			
5. ANY DISCREPANCIES MUST BE BROUGHT TO THE NOTICE OF THE ENGINEER IMMEDIATELY & PRIOR TO EXECUTION AT SITE.			
6. CO-ORDINATION WITH SERVICES SUCH AS HVAC, PLUMBING & ELECTRICAL, ETC. IS THE RESPONSIBILITY OF THE CONTRACTORS.			
7. FOR DETAILS, REFER RELEVANT LARGE SCALE DETAIL DRGS. AS INDICATED.			
LIGHTING LEGEND			
SR.NO	SYMBOL	DESCRIPTION	HEIGHT FROM FFL
1		CEILING TUBELIGHT POINT	CEILING
2		LED CEILING LIGHT POINT	CEILING
3		LED WALL BRACKET LIGHT POINT AT WALL	+7'-4"
4		6A SOCKET WITH SWITCH	+2'-0"
5		GENERAL POINT 16A SOCKET WITH SWITCH	+2'-0"
6		MDF BOX	+5'-0"
7		CEILING ROSE	+7'-0"
8		SWITCH BOARD	+4'-0"
9		EXHAUST FAN	VENT. HT.
10		LIGHT & POWER DISTRIBUTION BOARD	+5'-1"
11		Ø25MM POINT CONDUIT	CEILING
12		Ø25MM POWER CIRCUIT CONDUIT	CEILING FLOORING
13		Ø25MM LIGHT CIRCUIT CONDUIT	CEILING FLOORING
14		CEILING FAN	CEILING
ARCHITECT			
<div>ARCHITECT :-</div> <div> FRANK SQUARE ARCHITECTURE PLANNER DESIGNER C-49 VIDYA APARTMENT PARAS MARG, BAPU NAGAR JAIPUR, (RAJ.) Email-afranksquare@gmail.com Mobile-9461302542</div>			
PROJECT :-			
PROPOSED BUILDING AT PLOT NO-26,27,28,29,30.& 31, KRISHNA SAROVER JAIPUR			
BUILDER/DEVELOPER/CLIENT:-			
SHIVAM BUILDERS AND DEVELOPERS			
DRAWING TITLE:- MAIN PANEL SLD			
BUILDING NAME			
SHIVAM GRAND			
SUBMITTED FOR :-			
PRELIMINARY	<input type="checkbox"/>	APPROVAL	<input type="checkbox"/>
PROPOSAL	<input type="checkbox"/>	FOR RERA	<input checked="" type="checkbox"/>
DATE :-			NORTH :-
DRAWN :-			
APPROVED :-			
DRAWING NO.:-			SCALE :-
CONSULTANT			
AMP INFRA SERVICES VILLA NO 16. SHUBHASIS GEETA JAISINGHPURA, BHANKROTA & CHIMANPURA,JAIPUR 302026 EMAIL ID- ampinfrajr@gmail.com CONTACT NO. :- 9462866389			

SCHEMATIC DIAGRAM
LIGHTNING PROTECTION SYSTEM

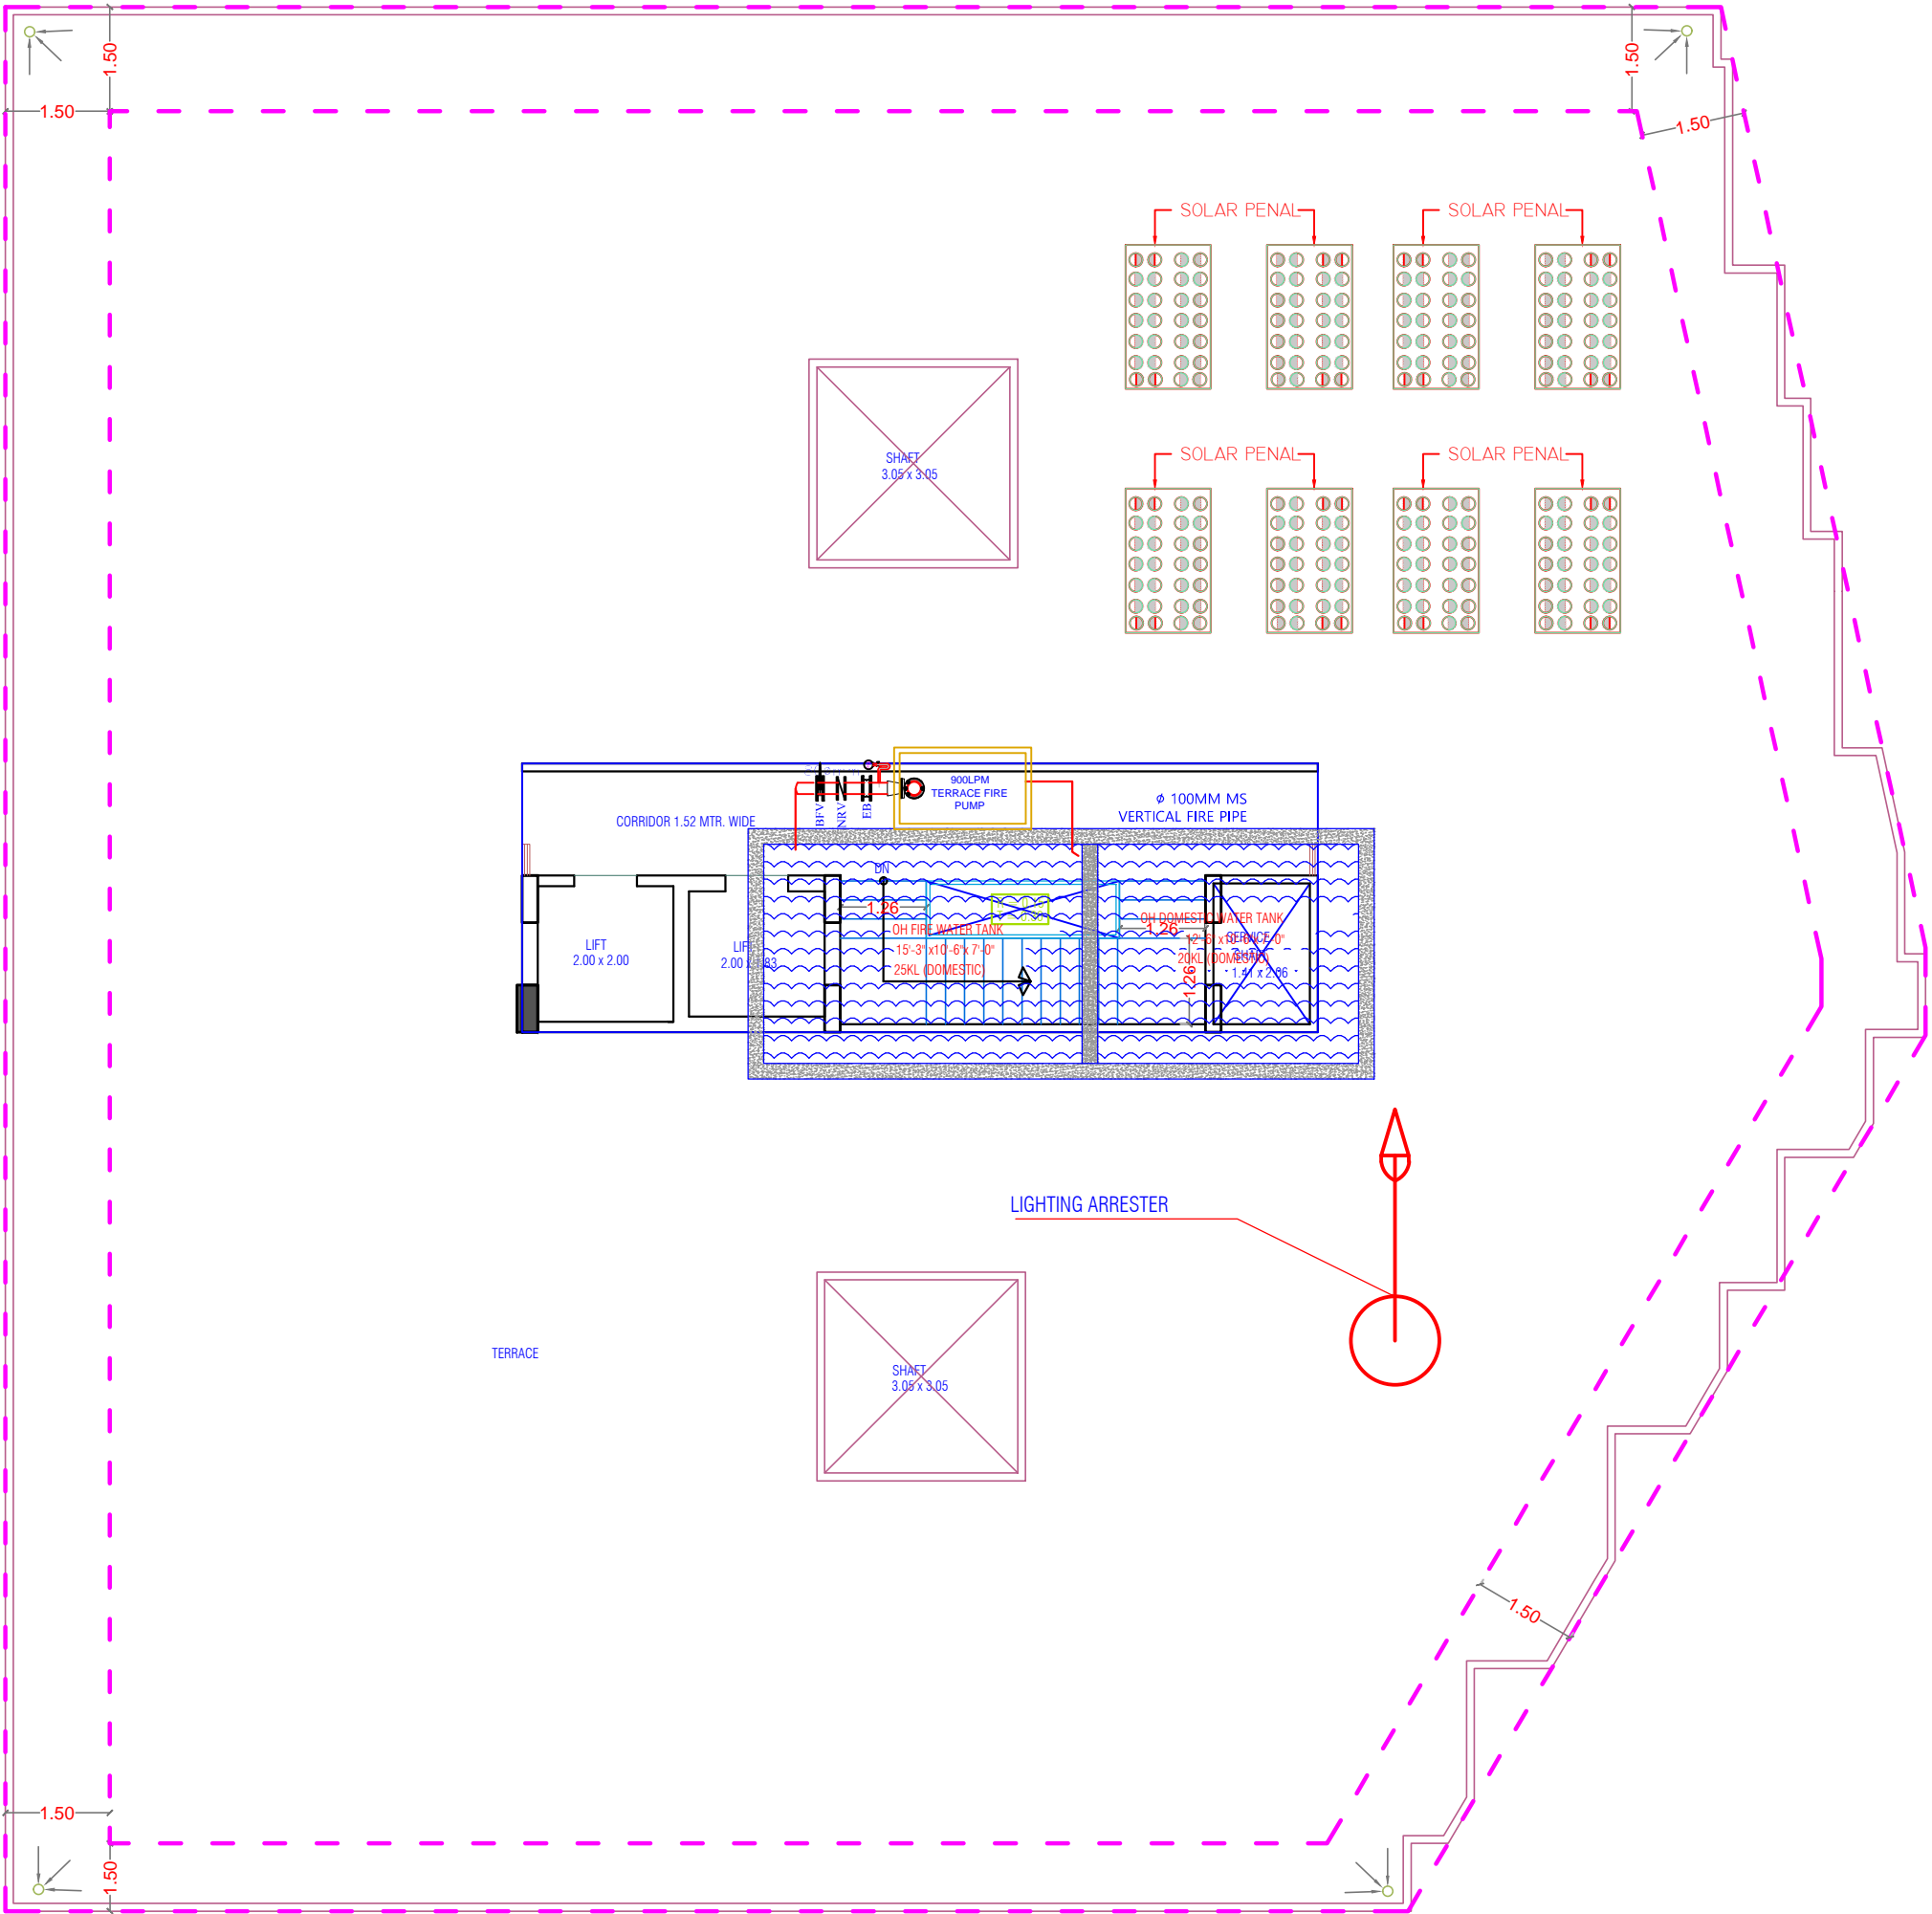


LIGHTENING ARRESTOR SLD






Shivam Builders and Developers
PARTNER

RAMESH KUMAWAT
M.E.P. CONSULTANT
B.E. CIVIL

PROJECT TITLE :- PROPOSED BUILDING AT PLOT NO-26,27,28,29,30,& 31, KRISHNA SAROVER JAIPUR	BUILDING NAME SHIVAM GRAND	DRAWING TITLE :- LIGHTENING ARRESTOR SLD	SPACE CONSULTANT PLOT-A-173, JAGDAMBA NAGAR, HEERAPURA POWER HOWER, JAIPUR (RAJ) 302024	DRN. BY		DATE	NORTH
				APPD. BY		REVISION	
	DEVELOPER NAME SHIVAM BUILDERS AND DEVELOPERS			SCALE			



TERRACE FLOOR PLAN

LEGEND		
	Symbole	DESCRIPTION
1.		HOSEREEL
2.		FIRE PIPE
3.		FIRE PIPE
4.		FIRE EXTINGUISHER
5.		EXTERNAL YARD HYDRANT

PROJECT TITLE :-
PROPOSED BUILDING AT PLOT
NO-26,27,28,29,30,& 31,
KRISHNA SAROVER JAIPUR

BUILDING NAME	SHIVAM GRAND
DEVELOPER NAME	SHIVAM BUILDERS AND DEVELOPERS

DRAWING TITLE :-

TARRACE FLOOR
LIGHTING ARRESTER
LOCATION

SPACE CONSULTANT	DRN. BY		DATE
PLOT-A-173, JAGDAMBA NAGAR, HEERAPURA POWER HOWER, JAIPUR (RAJ) 302024	APPD. BY		REVISION
	SCALE		

			NORTH

M/S Shivam Builders and Developers
Partner

RAMESH KUMAWAT
M.E.P. CONSULTANT
B.E. CIVIL