


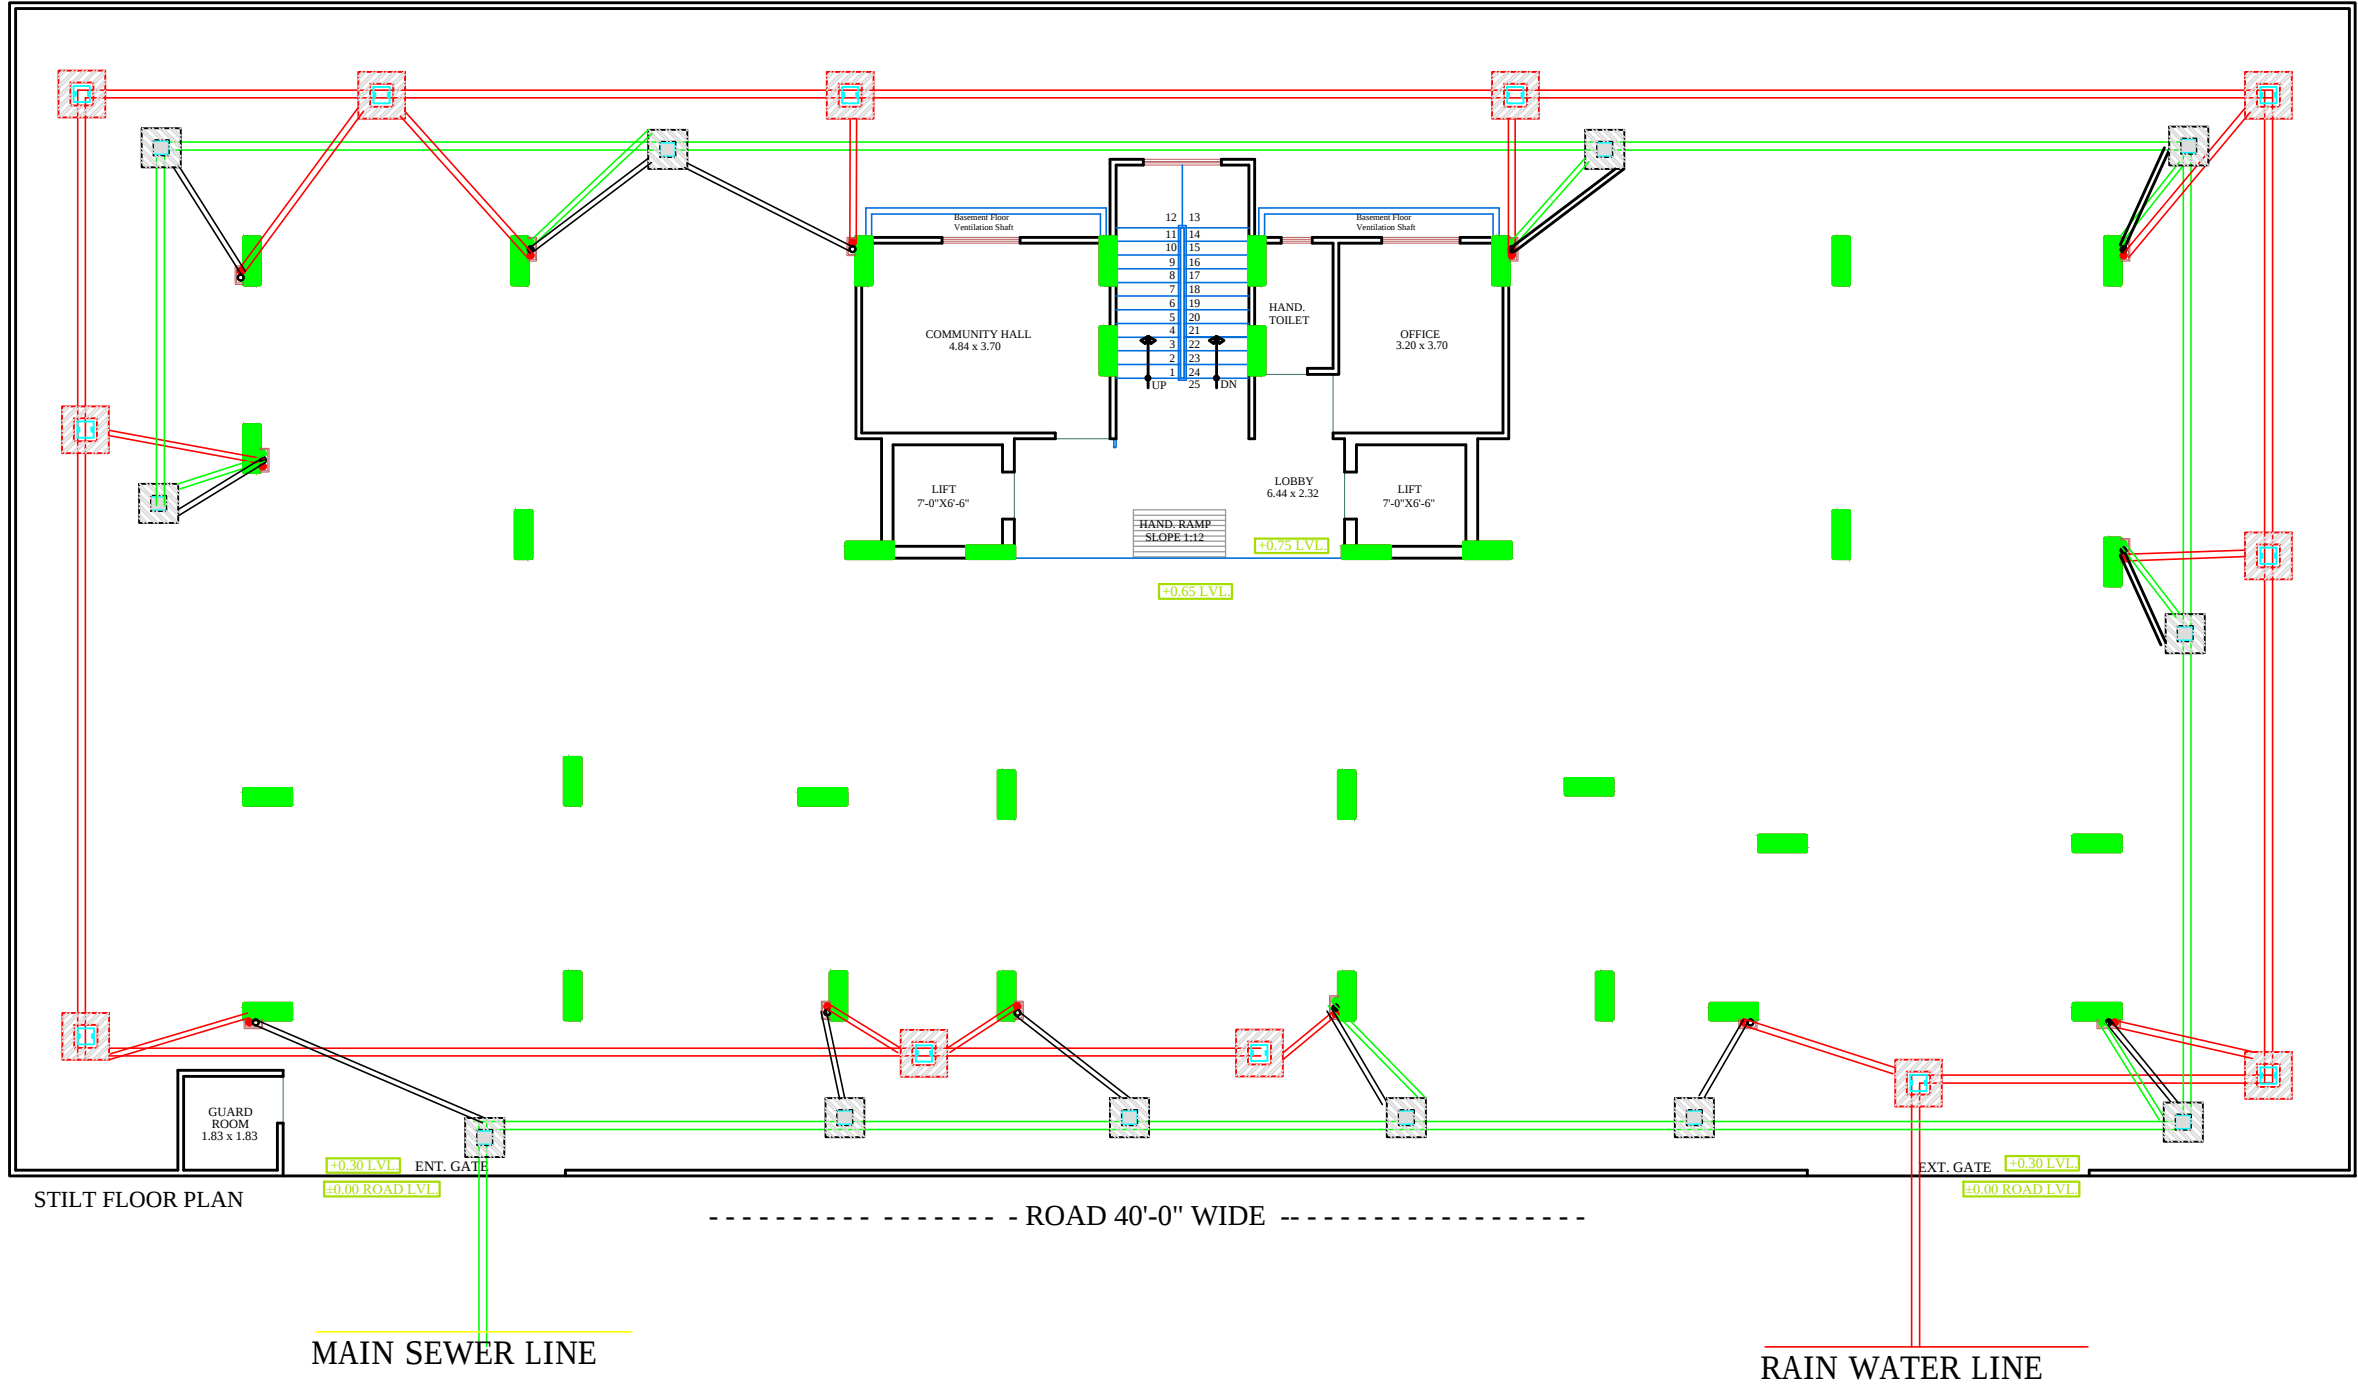

For Parth Sarthi Build Estate (P) Ltd.

मेधा 12/11/24  
Director

RAMESH KUMAWAT  
M.E.P. CONSULTANT  
B.E. CIVIL


| SYMBOL | DESCRIPTION                          |
|--------|--------------------------------------|
|        | Ø 110 mm Soil Waste Water Pipe       |
|        | Ø 110 mm Waste Water Pipe            |
|        | Ø 110 mm Rain Water Pipe             |
|        | Ø 160 mm Rain Water Pipe Slope 1:200 |
|        | Ø 110 mm Rain Water Pipe Slope 1:200 |
|        | RC-12"X12" Depth According to Slope  |
|        | RC-18"X18" Depth According to Slope  |
|        | RC-24"X24" Depth According to Slope  |
|        | Flow Direction                       |


|                                                                                                              |                                                         |                                                     |                                                                                               |          |  |          |       |
|--------------------------------------------------------------------------------------------------------------|---------------------------------------------------------|-----------------------------------------------------|-----------------------------------------------------------------------------------------------|----------|--|----------|-------|
| PROJECT TITLE :-<br><br>PROPOSED BUILDING AT PLOT<br>NO. F-28, F-29 & F-30, 6-D<br>ENGINEERS COLONY , JAIPUR | BUILDING NAME<br><br>PARTH AANGAN                       | DRAWING TITLE :-<br><br>STILT FLOOR<br>WATER SUPPLY | SPACE CONSULTANT<br>PLOT-A-173, JAGDAMBA NAGAR, HEERAPURA<br>POWER HOWER, JAIPUR (RAJ) 302024 | DRN. BY  |  | DATE     | NORTH |
|                                                                                                              | DEVELOPER NAME<br><br>PARTH SARTHI BUILD ESTATE (P)LTD. |                                                     |                                                                                               | APPD. BY |  | REVISION |       |
|                                                                                                              |                                                         |                                                     |                                                                                               | SCALE    |  |          |       |

PRODUCED BY AN AUTODESK EDUCATIONAL PRODUCT

PRODUCED BY AN AUTODESK EDUCATIONAL PRODUCT

| SYMBOL                                                                                                                                                                                      | DESCRIPTION                                 |
|---------------------------------------------------------------------------------------------------------------------------------------------------------------------------------------------|---------------------------------------------|
|                                                                                                                                                                                             | Ø 110 mm Soil Waste Water Pipe              |
|                                                                                                                                                                                             | Ø 110 mm Waste Water Pipe                   |
|                                                                                                                                                                                             | Ø 110 mm Rain Water Pipe                    |
|                                                                                                                                                                                             | Ø 160 mm Soil Waste Water Pipe Slope 1:150  |
|                                                                                                                                                                                             | Ø 110 mm Waste Water Pipe Slope 1:150       |
|                                                                                                                                                                                             | Ø 75 mm Waste Water Pipe Slope 1:150        |
|                                                                                                                                                                                             | 50mm Waste Water Pipe Bottle Trap           |
|                                                                                                                                                                                             | Floor Trap                                  |
|                                                                                                                                                                                             | P-Trap Required                             |
|                                                                                                                                                                                             | Gully Trap-12"X12" Depth According to Slope |
|                                                                                                                                                                                             | Main Hole-18"X18" Depth According to Slope  |
|                                                                                                                                                                                             | Main Hole-24"X24" Depth According to Slope  |
|                                                                                                                                                                                             | Main Hole-36"X32" Depth According to Slope  |
|                                                                                                                                                                                             | Flow Direction                              |
| SIGN:-                                                                                                                                                                                      |                                             |
| <br>RAMESH KUMAWAT<br>M.E.P CONSULTANT<br>B.E. CIVIL                                                                                                                                        |                                             |
| For Parth Sarthi Build Estate (P) Ltd.<br>Director                                                                                                                                          |                                             |
| SPACE CONSULTANT<br>PLOT-A-173, JAGDAMBA NAGAR, HEERAPURA<br>POWER HOWER, JAIPUR (RAJ) 302024                                                                                               |                                             |
| ARCHITECT :-<br><br>FRANK SQUARE<br>ARCHITECTURE   PLANNER   DESIGNER<br>C-49 VIDYA APARTMENT PARAS MARG,<br>BAPU NAGAR JAIPUR, (RAJ.)<br>Email-afranksquare@gmail.com<br>Mobile-9461302542 |                                             |
| PROJECT :-<br>PROPOSED BUILDING AT PLOT<br>NO. F-28, F-29 & F-30, 6-D<br>ENGINEERS COLONY , JAIPUR                                                                                          |                                             |
| BUILDING NAME<br>PARTH AANGAN                                                                                                                                                               |                                             |
| DEVELOPER NAME<br>PARTH SARTHI BUILD ESTATE (P)LTD.                                                                                                                                         |                                             |
| DRAWING: STILT FLOOR<br>EXTERNAL SEWERAGE<br>CHAMBER & PIPE ROUTE FOR<br>RERA SUBMISSION PLAN                                                                                               |                                             |
| DATE                                                                                                                                                                                        |                                             |
| SCALE:-                                                                                                                                                                                     | N.T.S.                                      |

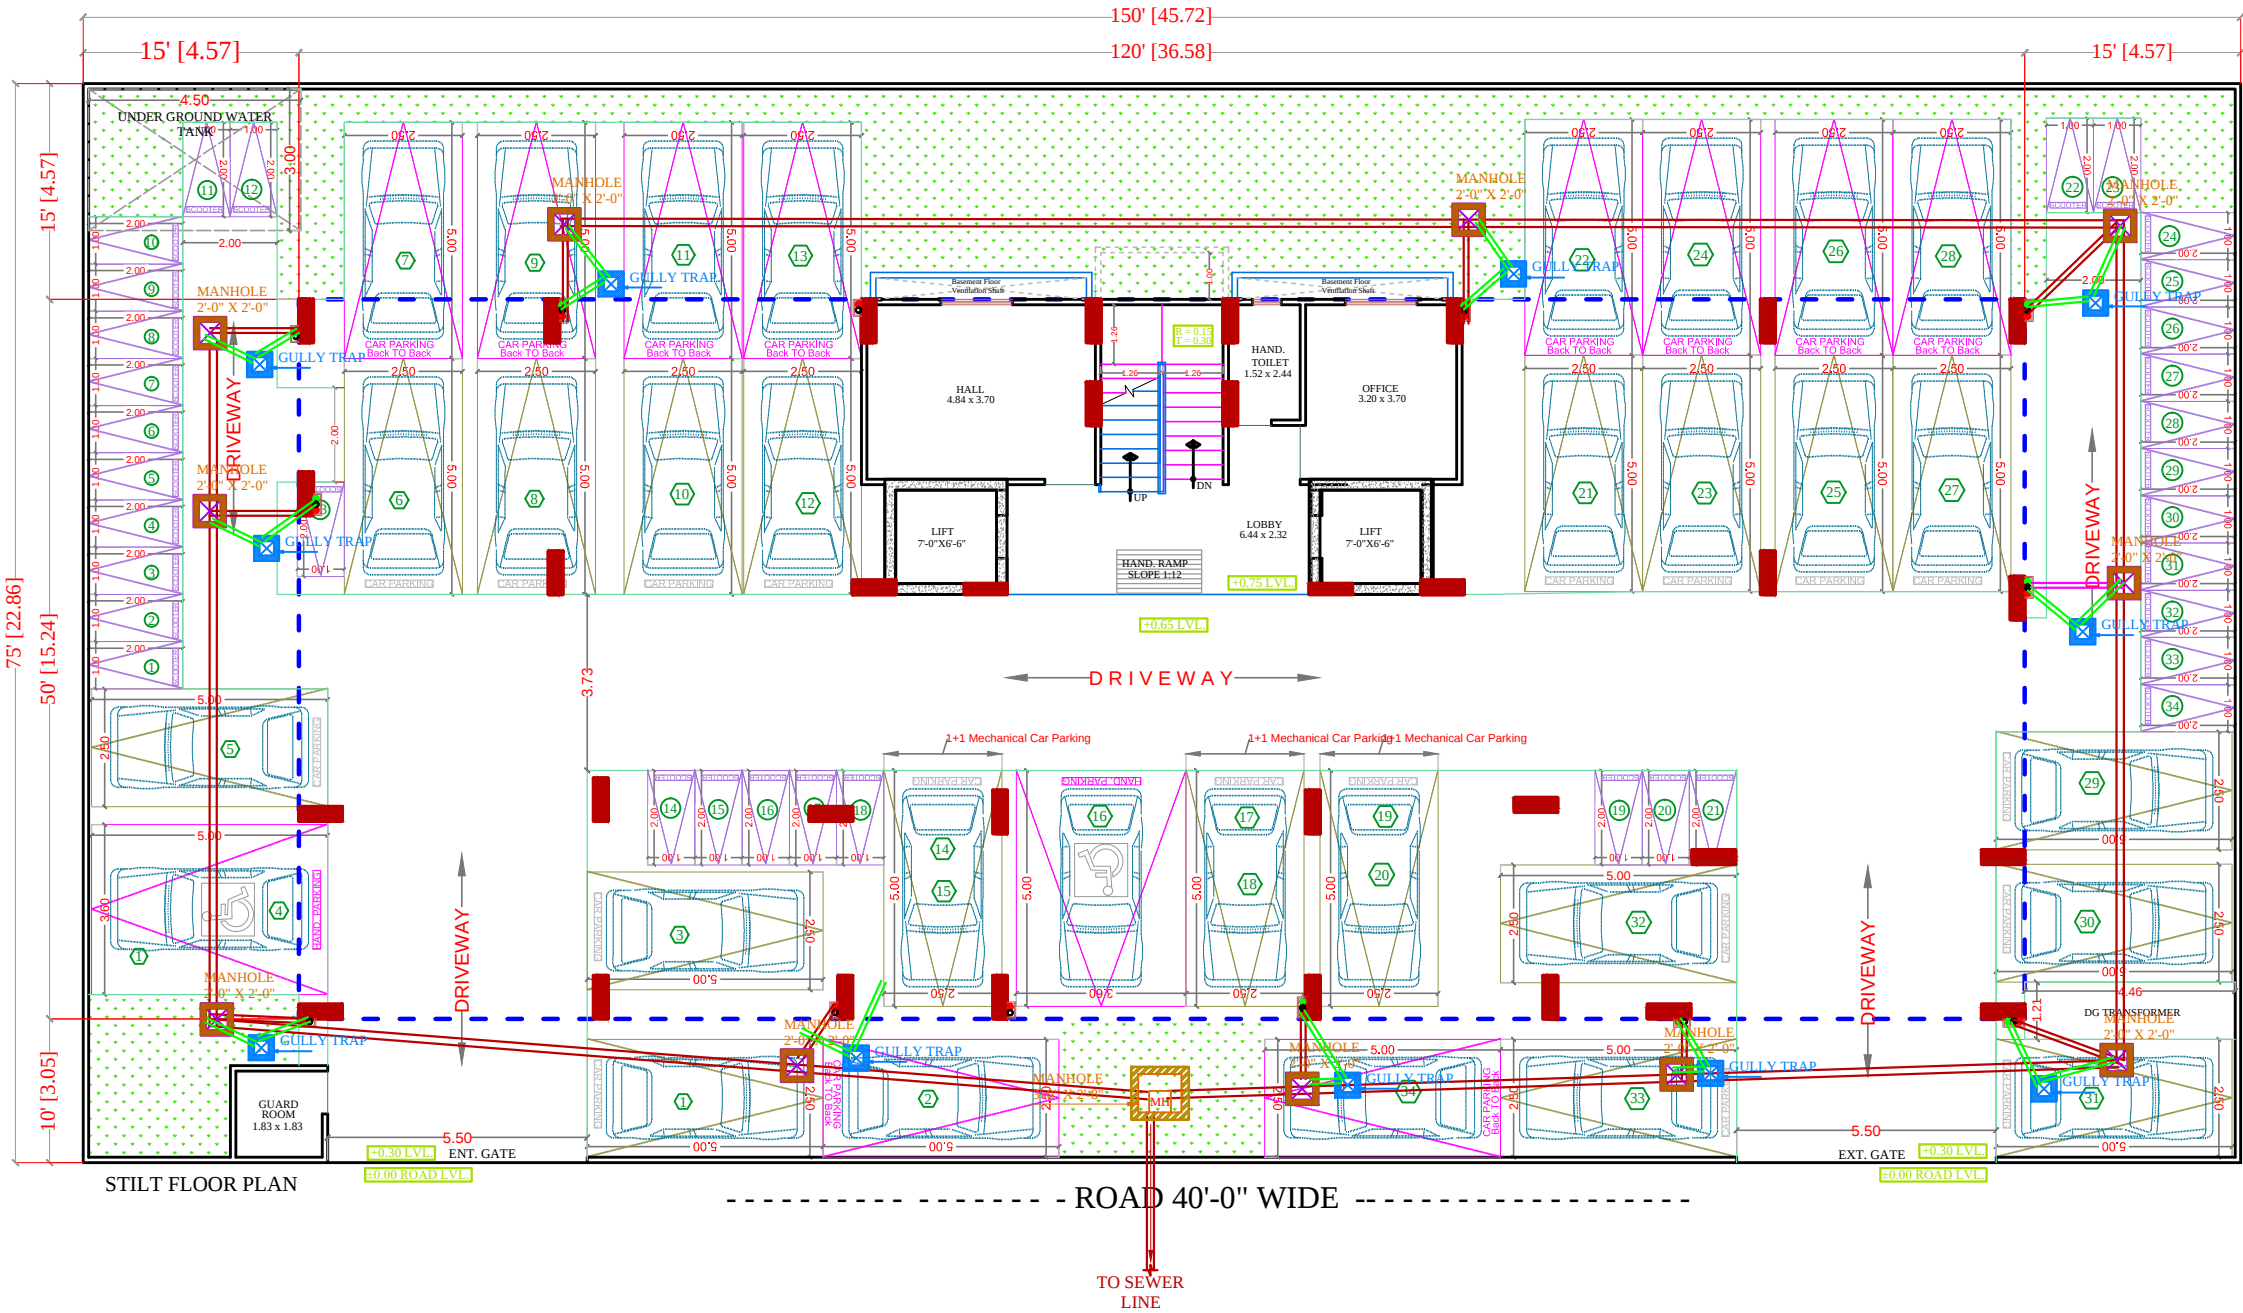

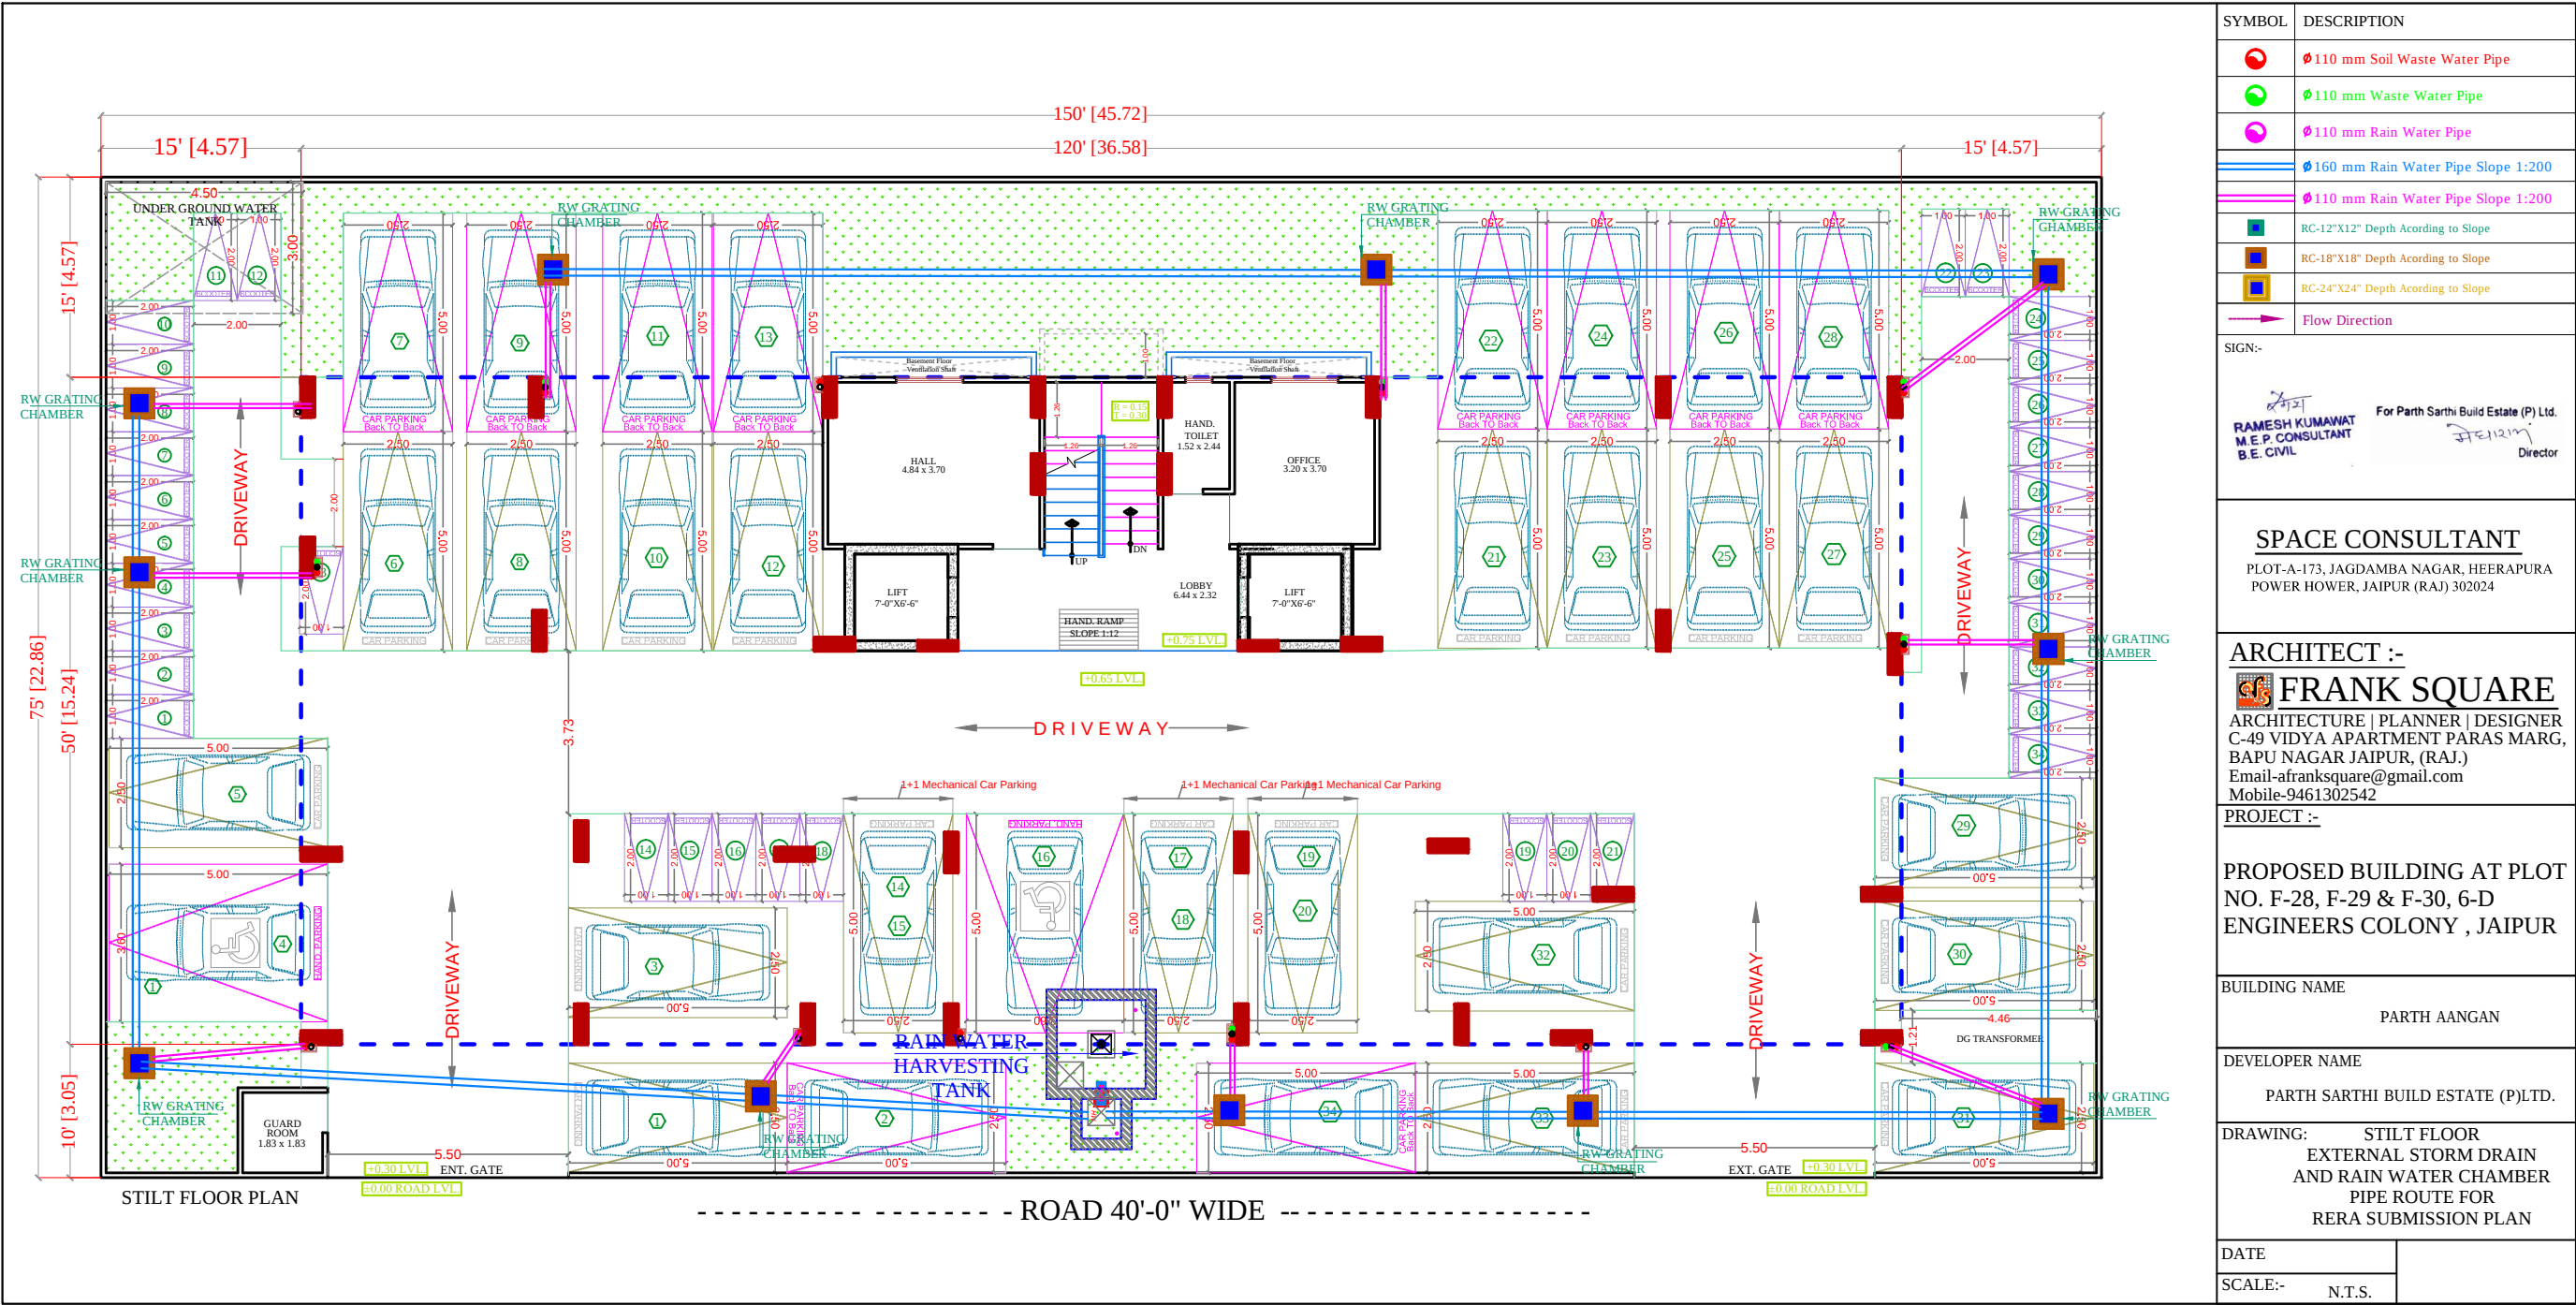

PRODUCED BY AN AUTODESK EDUCATIONAL PRODUCT

PRODUCED BY AN AUTODESK EDUCATIONAL PRODUCT



1st TO 5th FLOOR PLAN

| All Heights For<br>Finish Floor Lvl | SYMBOL       | SYMBOL | DESCRIPTION                                                                                                          |
|-------------------------------------|--------------|--------|----------------------------------------------------------------------------------------------------------------------|
| +1000MM                             |              |        | Ø 20MM CWS PIPE THRU WALL CHASE TO SINK<br>Ø 20MM HWS PIPE THRU WALL CHASE TO SINK                                   |
| +1950MM                             |              |        | Ø 20MM CWS PIPE THRU WALL CHASE TO GEYSER<br>Ø 20MM HWS PIPE THRU WALL CHASE FROM GEYSER                             |
| +1500MM                             |              |        | Ø 20MM CWS PIPE THRU WALL CHASE TO AQUAGUARD                                                                         |
| +450MM                              |              |        | Ø 20MM CWS PIPE THRU WALL CHASE TO BASIN ANGLE VALVE<br>Ø 20MM HWS PIPE THRU WALL CHASE TO BASIN ANGLE VALVE         |
| +800MM                              |              |        | Ø 20MM CWS PIPE THRU WALL CHASE TO BASIN ANGLE VALVE<br>Ø 20MM HWS PIPE THRU WALL CHASE TO BASIN ANGLE VALVE         |
| +2100MM                             |              |        | Ø 20MM CWS PIPE THRU WALL CHASE TO CONCEALED STOP COCK                                                               |
| +300MM                              |              |        | Ø 20MM CWS PIPE THRU WALL CHASE TO FAUCET                                                                            |
| +1000MM WALL MIXER DIVERTOR         |              |        | Ø 20MM CWS PIPE THRU WALL CHASE TO WALL MIXER / DIVERTOR<br>Ø 20MM HWS PIPE THRU WALL CHASE TO WALL MIXER / DIVERTOR |
| +2025MM O.H.SHOWER                  |              |        | Ø 20MM CWS PIPE THRU WALL CHASE TO TAP                                                                               |
| +600MM                              |              |        | Ø 20MM CWS PIPE THRU WALL CHASE TO TAP                                                                               |
| +450MM                              |              |        | Ø 20MM CWS PIPE THRU WALL CHASE TO CISTERN ANGLE VALVE                                                               |
| +1200MM                             |              |        | Ø 20MM CWS PIPE THRU WALL CHASE TO URINAL ANGLE VALVE                                                                |
| +450MM                              |              |        | Ø 20MM CWS PIPE THRU WALL CHASE TO BASIN ANGLE VALVE                                                                 |
| +1000MM                             | AS PER/ARCHL |        | SOAP DISH                                                                                                            |
| +1500MM                             | AS PER/ARCHL |        | TOWEL RAIL                                                                                                           |
| +450MM                              | AS PER/ARCHL |        | PAPER HOLDER                                                                                                         |
|                                     |              |        | COLD WATER SUPPLY LINE<br>HOT WATER SUPPLY LINE                                                                      |

For Parth Sarthi Build Estate (P) Ltd.

मेधा 12/17  
Director


RAMESH KUMAWAT  
M.E.P. CONSULTANT  
B.E. CIVIL

|                                                                                                              |                                                         |                                                        |                     |          |      |          |       |
|--------------------------------------------------------------------------------------------------------------|---------------------------------------------------------|--------------------------------------------------------|---------------------|----------|------|----------|-------|
| PROJECT TITLE :-<br><br>PROPOSED BUILDING AT PLOT<br>NO. F-28, F-29 & F-30, 6-D<br>ENGINEERS COLONY , JAIPUR | BUILDING NAME<br><br>PARTH AANGAN                       | DRAWING TITLE :-<br><br>TYPICAL FLOOR<br>PLUMBING PLAN | SERVICES CONSULTANT | DRN. BY  |      |          | NORTH |
|                                                                                                              |                                                         |                                                        |                     |          | DATE |          |       |
|                                                                                                              | DEVELOPER NAME<br><br>PARTH SARTHI BUILD ESTATE (P)LTD. |                                                        |                     | APPD. BY |      | REVISION |       |
|                                                                                                              |                                                         |                                                        |                     | SCALE    |      |          |       |

|             |         |
|-------------|---------|
| APPRVD BY : | DATE.:- |
|-------------|---------|


  
RAMESH KUMAWAT  
M.E.P. CONSULTANT  
B.E. CIVIL

# WATER SUPPLY SCHEMATIC DIAGRAM

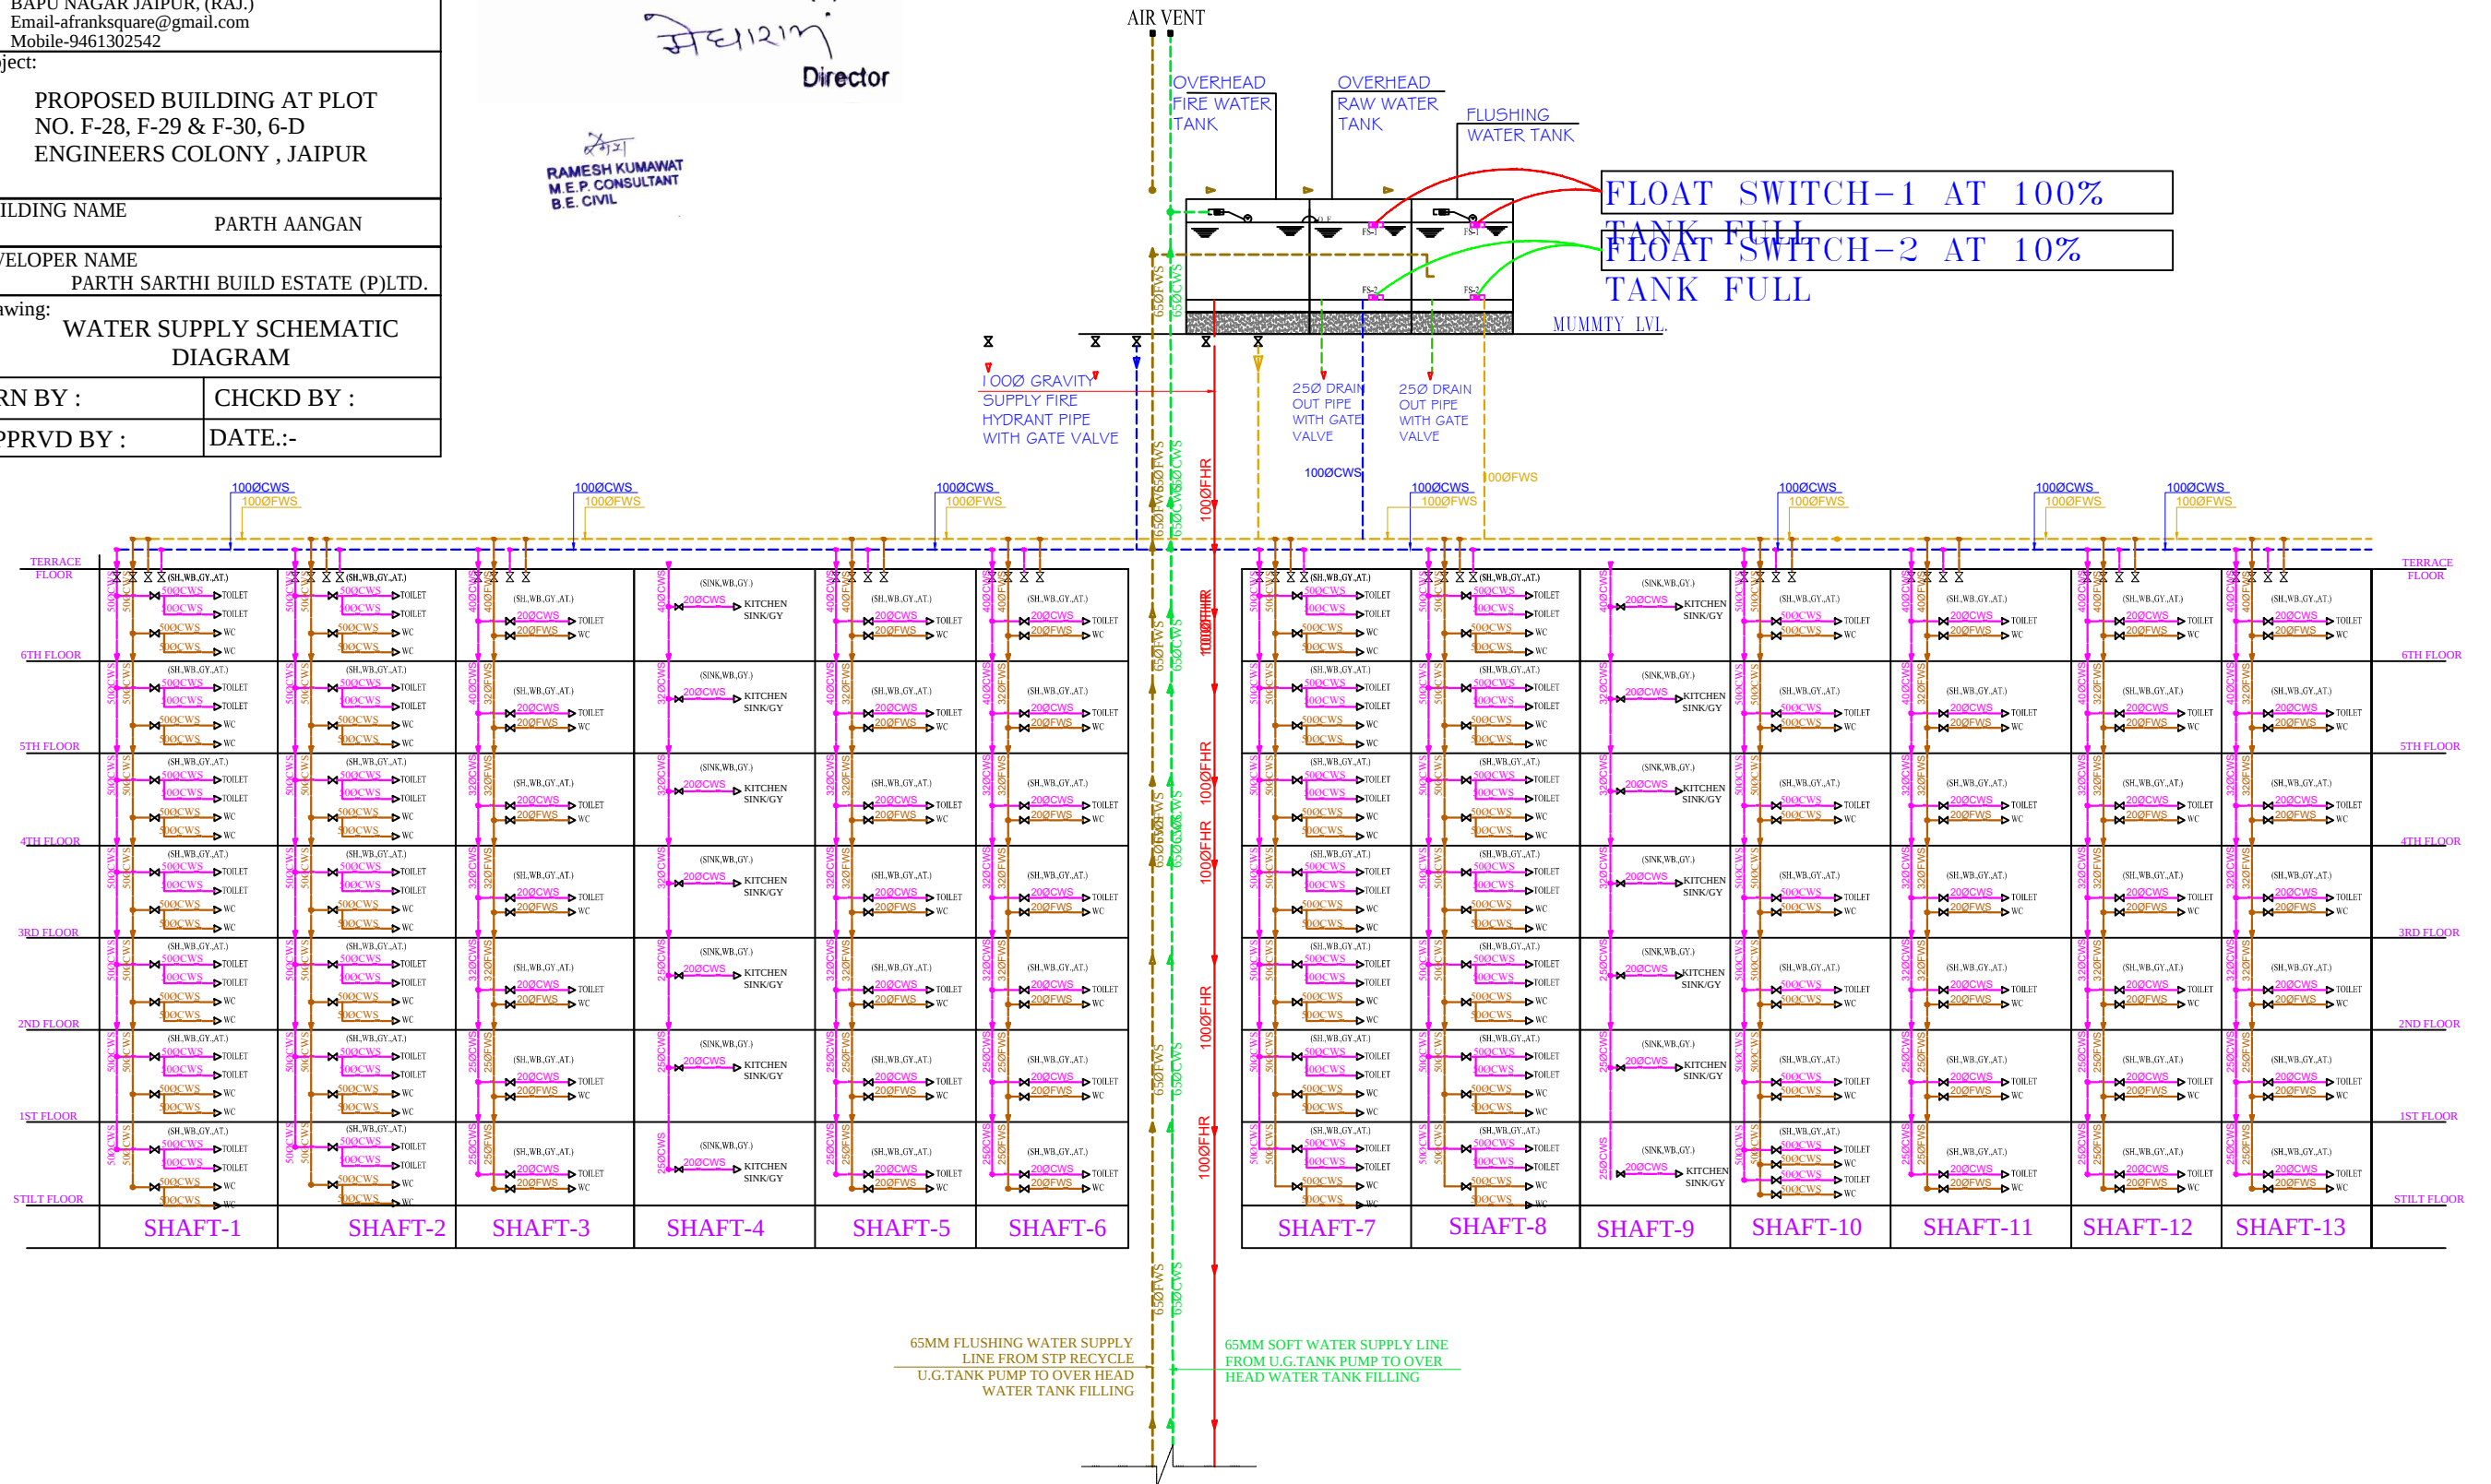

PRODUCED BY AN AUTODESK EDUCATIONAL PRODUCT

PRODUCED BY AN AI TONESK EDUCATIONAL PRODUCT

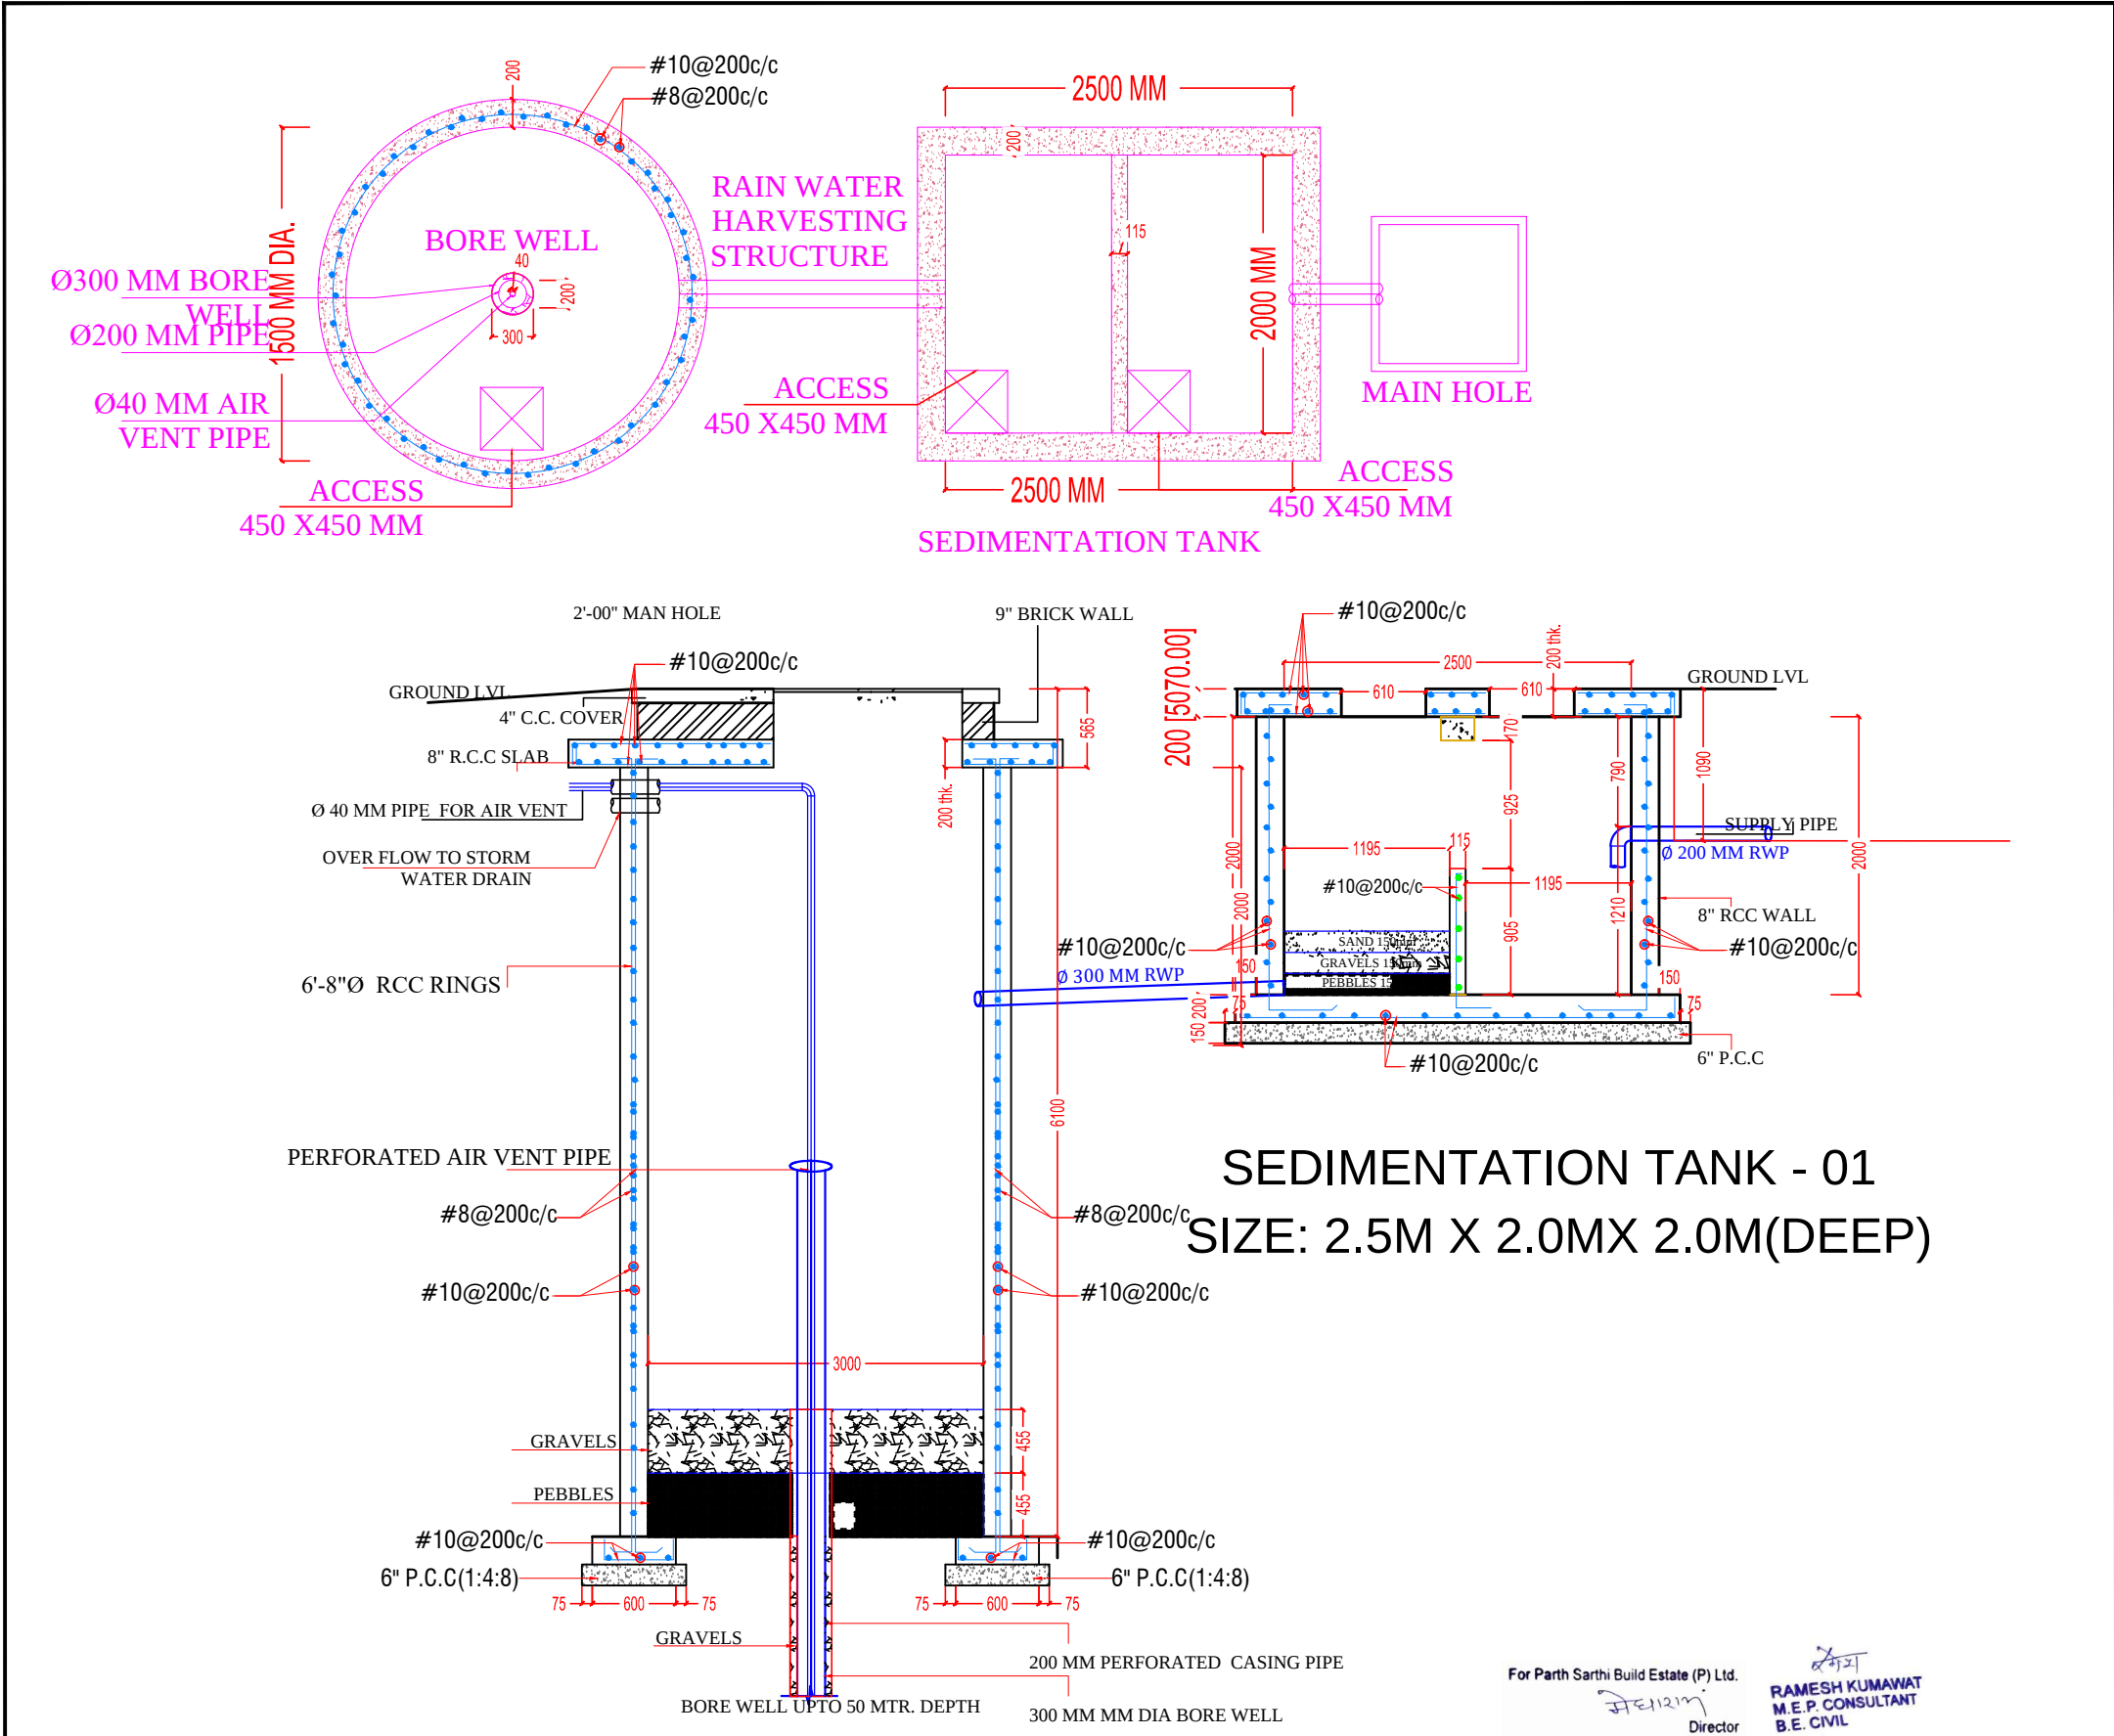

|                                                                                                          |                                   |                                               |                                                                                                      |          |          |  |
|----------------------------------------------------------------------------------------------------------|-----------------------------------|-----------------------------------------------|------------------------------------------------------------------------------------------------------|----------|----------|--|
| PROJECT TITLE :-<br>PROPOSED BUILDING AT PLOT<br>NO. F-28, F-29 & F-30, 6-D<br>ENGINEERS COLONY , JAIPUR | BUILDING NAME                     | DRAWING TITLE :-<br><br>RAIN WATER HARVESTING | <u>SPACE CONSULTANT</u><br>PLOT-A-173, JAGDAMBA NAGAR, HEERAPURA<br>POWER HOWER, JAIPUR (RAJ) 302024 | DRN. BY  |          |  |
|                                                                                                          | PARTH AANGAN                      |                                               |                                                                                                      | DATE     |          |  |
|                                                                                                          | DEVELOPER NAME                    |                                               |                                                                                                      | APPD. BY | REVISION |  |
|                                                                                                          | PARTH SARTHI BUILD ESTATE (P)LTD. |                                               |                                                                                                      | SCALE    |          |  |