


PRODUCED BY AN AUTODESK EDUCATIONAL PRODUCT

PRODUCED BY AN AUTODESK EDUCATIONAL PRODUCT

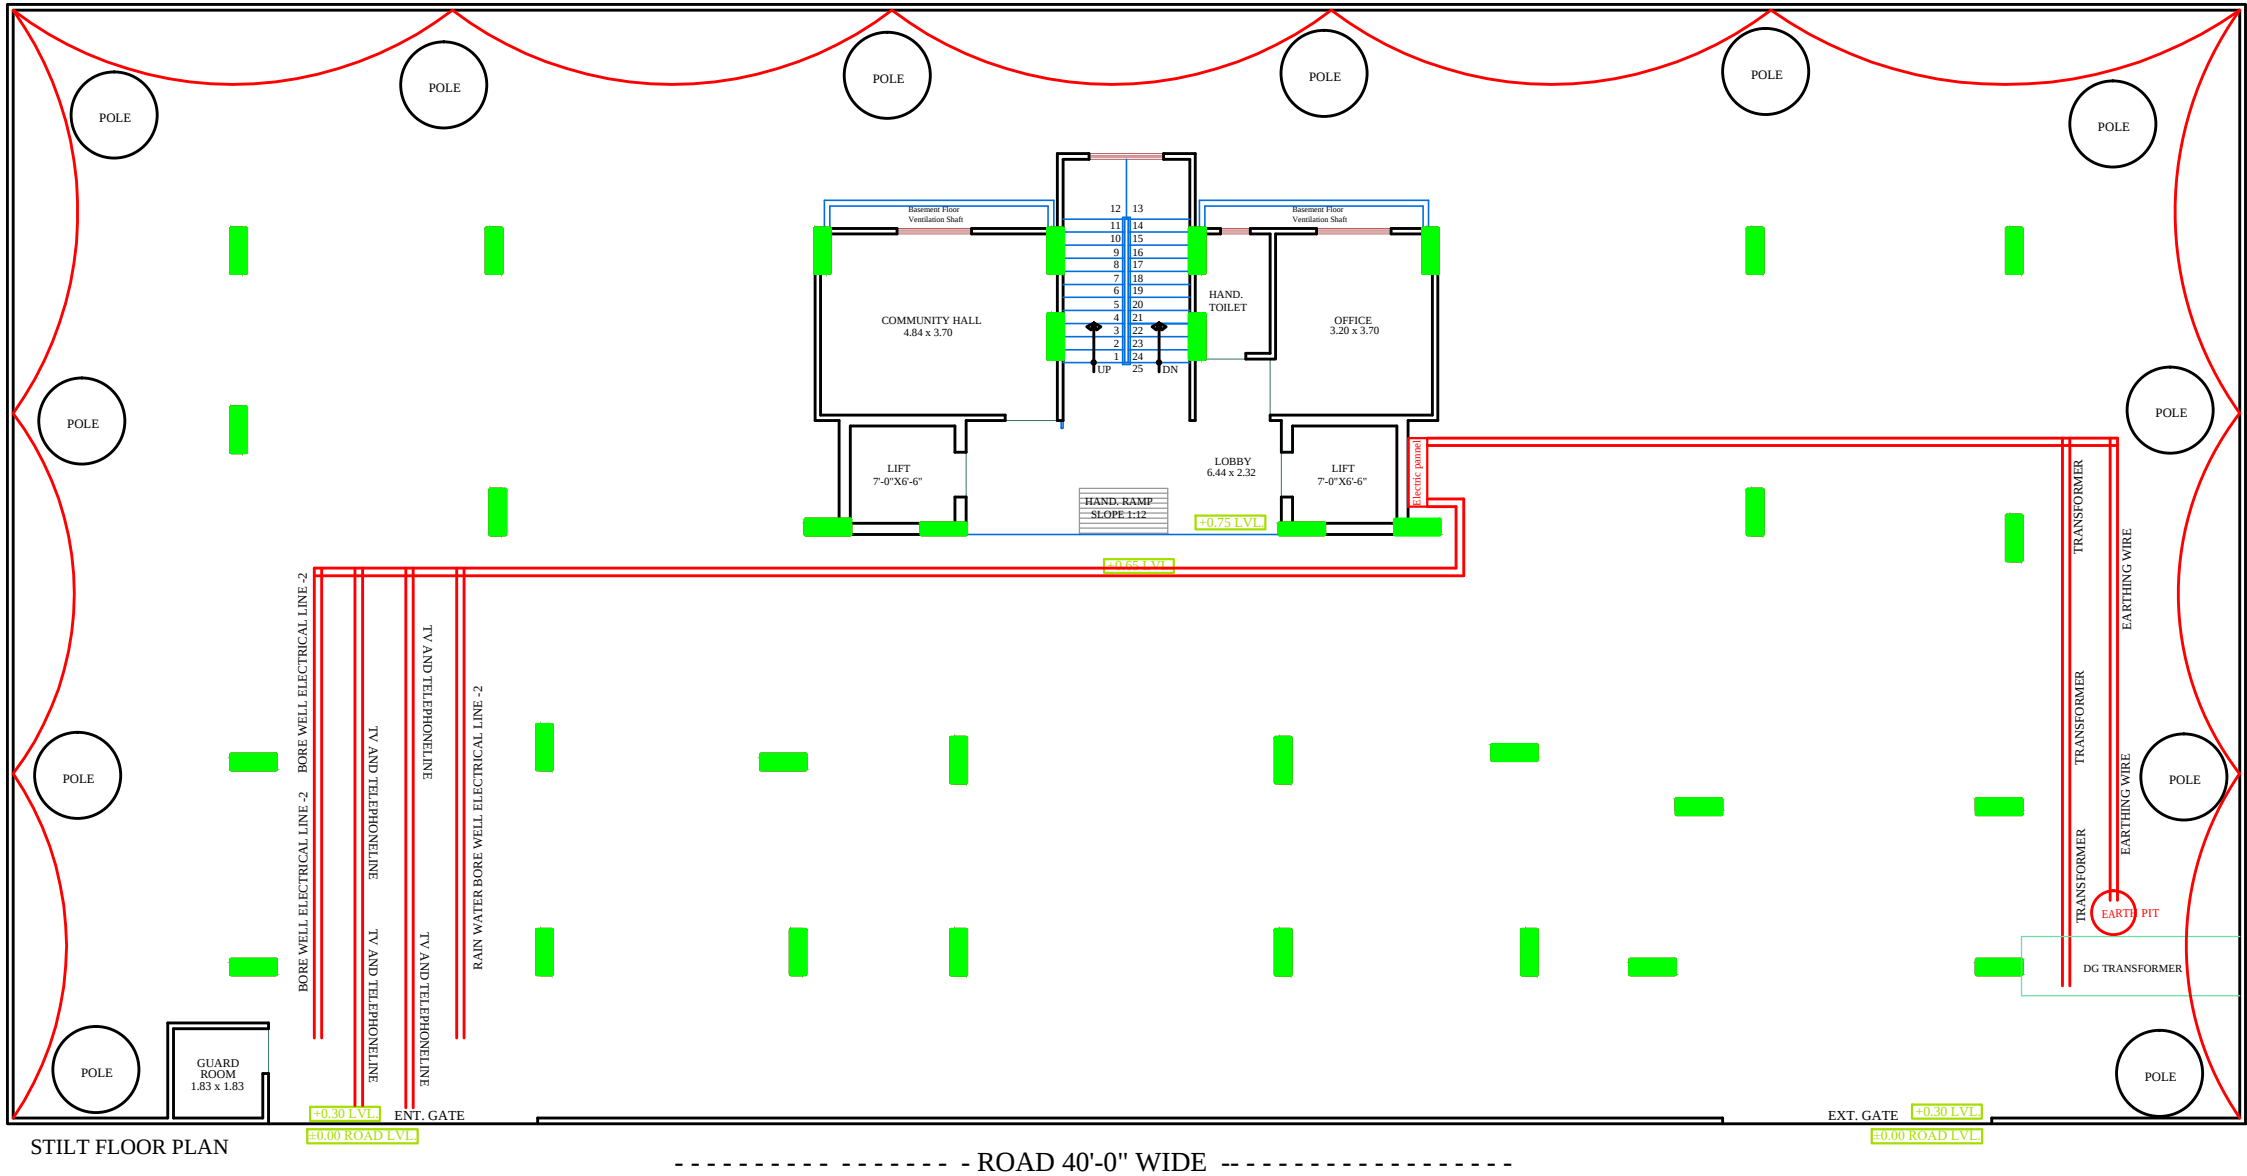

NO	ITEM	SYMBOL
1	CEILING FAN	ROOF
2	TUBE LIGHT	+8'6"
3	BULB	+8'6"
4	POWER POINT	+1'6"
5	BED POINT	+4'3"
6	CEILING LIGHT	ROOF
7	A.C.POINT	+6'6"
8	SWITCH BOARD	+4'3"
9	EXHAUST	VENT
10	TELEPHONE	+1'6"
11	GYSER	+6'0"
12	BELL POINT	+8'6"
13	T.V.	+1'6"
14	M.BOX	+6'6"
15	M.C.B.	+6'6"
16	FANCY LIGHT	+8'6"
17	HANGING LIGHT	ROOF


STILT (PARKING) FLOOR PLAN

PROJECT TITLE :- PROPOSED BUILDING AT PLOT NO. F-28, F-29 & F-30, 6-D ENGINEERS COLONY , JAIPUR	BUILDING NAME PARTH AANGAN	DRAWING TITLE :- SERVICE DRAWING SLD/DISTRIBUTION AFTER LT PANEL, EARTHING LAYOUT,EXTERNAL LIGHTING PLAN, TV & TELEPHONE RISER,LIGHTING ARRESTR, & PIT LOCATION COMMON AREA TRANSFORMER	SPACE CONSULTANT PLOT-A-173, JAGDAMBA NAGAR, HEERAPURA POWER HOWER, JAIPUR (RAJ) 302024	DRN. BY		DATE	
	DEVELOPER NAME PARTH SARTHI BUILD ESTATE (P)LTD.			APPD. BY		REVISION	
				SCALE	N.T.S		

For Parth Sarthi Build Estate (P) Ltd.

मेधा २०२१
Director

रामेश
RAMESH KUMAWAT
M.E.P. CONSULTANT
B.E. CIVIL

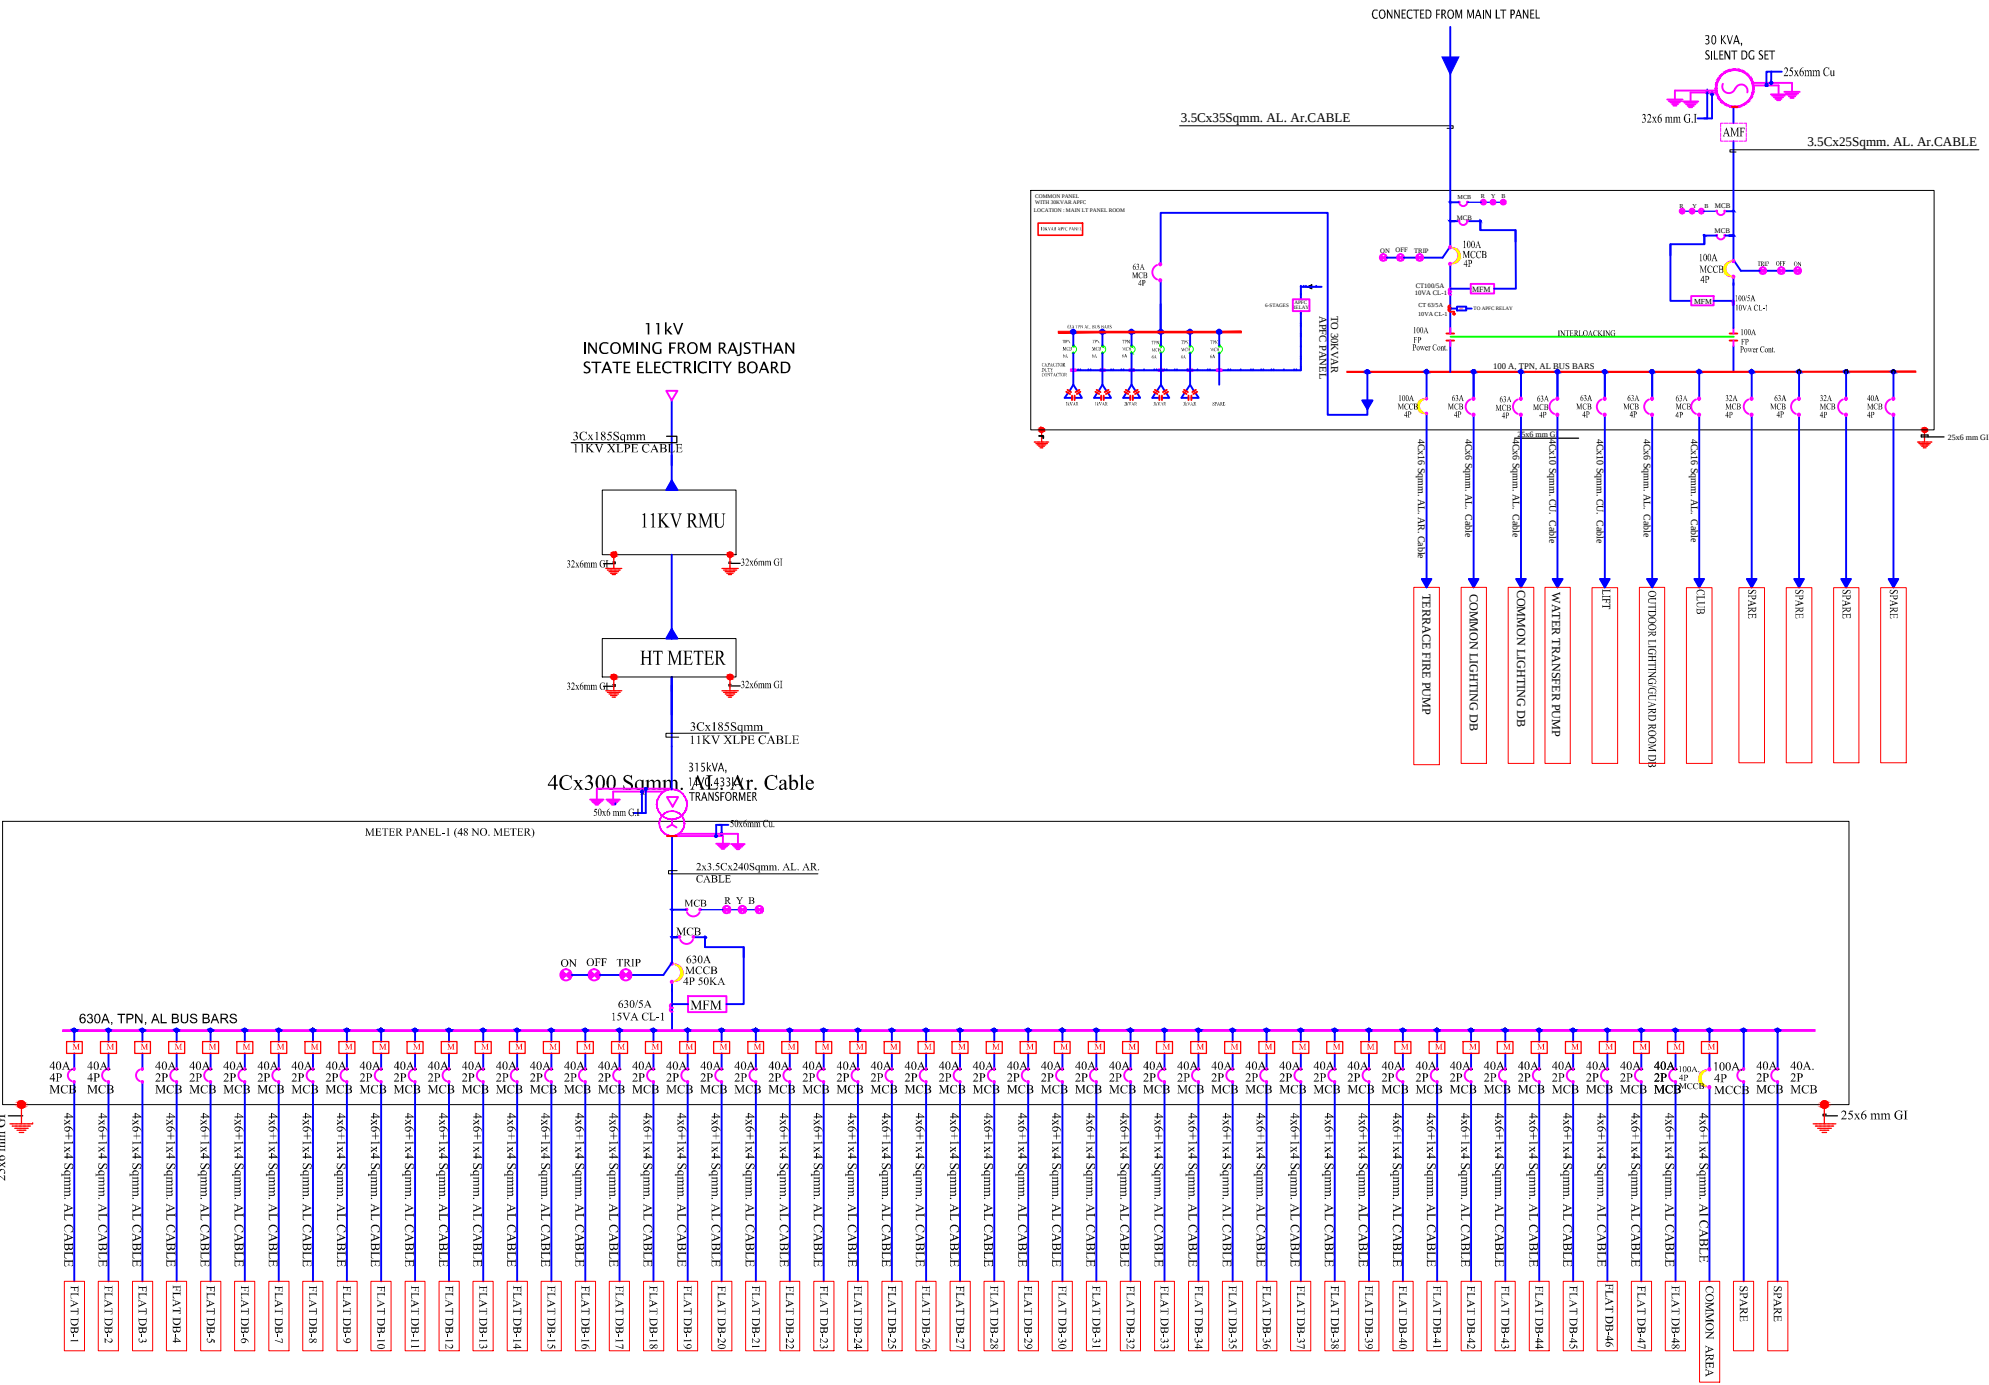

LEGEND	
SYMB.	DESCRIPTION
[Symbol]	AMMETER
[Symbol]	VOLT METER
[Symbol]	POWER FACTOR METER
[Symbol]	VOLTMETER, AMMETER, FREQUENCY METER
[Symbol]	FREQUENCY METER
[Symbol]	KILOWATT HOUR METER
[Symbol]	KILOWATT METER
[Symbol]	AMMETER SELECTOR SWITCH
[Symbol]	VOLTMETER SELECTOR SWITCH
[Symbol]	LOCKOUT RELAY
[Symbol]	SUPERVISORY TRIP RELAY
[Symbol]	UNDER VOLTAGE DEVICE
[Symbol]	OVER VOLTAGE DEVICE
[Symbol]	REVERSE POWER PHASE DEVICE
[Symbol]	DIFFERENTIAL PROTECTION RELAY
[Symbol]	OVER CURRENT & EARTH FAULT RELAY
[Symbol]	MULTI FUNCTION RELAY
[Symbol]	ELECTRICALLY OPERATED MANUALLY DRAWN OUT
[Symbol]	CONTROL FUSE
[Symbol]	CURRENT TRANSFORMER
[Symbol]	TRIVECTOR METER
[Symbol]	INDICATING LAMP
[Symbol]	OVER LOAD RELAY
[Symbol]	POWER CONTACTOR
[Symbol]	POTENTIAL TRANSFORMER
[Symbol]	DUAL SOURCE ELECTRONIC ENERGY METER
[Symbol]	GROUNDING
[Symbol]	MICRO PROCESSOR BASED RELEASE
[Symbol]	ELECTRONIC ENERGY METER
[Symbol]	AIR CIRCUIT BREAKER
[Symbol]	VACUUM CIRCUIT BREAKER
[Symbol]	MINIATURE CIRCUIT BREAKER
[Symbol]	MOULDED CASE CIRCUIT BREAKER
[Symbol]	MOTOR PROTECTION CIRCUIT BREAKER

REVISION - 00			
GENERAL NOTES :			
1. ALL THE DIMENSIONS ON THE DRAWING ARE IN WRITTEN.			
2. ONLY WRITTEN DIMENSIONS ARE TO BE FOLLOWED, DRAWING SHOULD NOT BE SCALED IN ANY CIRCUMSTANCES.			
3. ALL MEASUREMENTS MUST BE CHECKED AND VERIFIED BY THE CONTRACTORS PRIOR TO EXECUTION OF WORK AT THE SITE.			
4. THIS DRAWING IS TO BE READ IN CONJUNCTION WITH ALL RELEVANT STRUCTURAL, ARCHITECTURAL & FACILITY PLANNING DRAWINGS.			
5. ANY DISCREPANCIES MUST BE BROUGHT TO THE NOTICE OF THE ENGINEER IMMEDIATELY & PRIOR TO EXECUTION AT SITE.			
6. CO-ORDINATION WITH SERVICES SUCH AS HVAC, PLUMBING & ELECTRICAL, ETC. IS THE RESPONSIBILITY OF THE CONTRACTORS.			
7. FOR DETAILS, REFER RELEVANT LARGE SCALE DETAIL DRGS. AS INDICATED.			
LIGHTING LEGEND			
R.NO	SYMBOL	DESCRIPTION	HEIGHT FROM FFL
1		CEILING TUBELIGHT POINT	CEILING
2		LED CEILING LIGHT POINT	CEILING
3		LED WALL BRACKET LIGHT POINT AT WALL	+7.4"
4		6A SOCKET WITH SWITCH	+2.0"
5		GENERAL POINT 16A SOCKET WITH SWITCH	+2.0"
6		MDF BOX	+5.0"
7		CEILING ROSE	+7.4"
8		SWITCH BOARD	+4.0"
9		EXHAUST FAN	VENT. HT.
10		LIGHT & POWER DISTRIBUTION BOARD	+9.1"
11		Ø25MM POINT CONDUIT	CEILING
12		Ø25MM POWER CIRCUIT CONDUIT	CEILING FLOORING
13		Ø25MM LIGHT CIRCUIT CONDUIT	CEILING FLOORING
14		CEILING FAN	CEILING
ARCHITECT			
ARCHITECT :-			
 FRANK SQUARE			
ARCHITECTURE PLANNER DESIGNER C-49 VIDYA APARTMENT PARAS MARG, BAPU NAGAR JAIPUR, (RAJ.) Email:-franksquare@gmail.com Mobile-9461302542			
PROJECT :-			
PROPOSED BUILDING AT PLOT NO. F-28, F-29 & F-30, 6-D ENGINEERS COLONY , JAIPUR			
BUILDER/DEVELOPER/CLIENT:-			
PARTH SARTHI BUILD ESTATE (P) LTD.			
BUILDING NAME		PARTH AANGAN	
DRAWING TITLE:-		MAIN PANEL SLD	
SUBMITTED FOR :-			
PRELIMINARY		☐ APPROVAL	☒
PROPOSAL		☐ FOR RERA	☒
DATE :-		NORTH :-	
DRAWN :-			
APPROVED :-			
DRAWING NO.:-		SCALE :-	
CONSULTANT			
AMP INFRA SERVICES VILLA NO 16. SHUBHASIS GEETA JAISINGHPURA, BHANKROTA & CHIMANPURA,JAIPUR 302026 EMAIL ID- ampinfrajr@gmail.com CONTACT NO. :- 9462866389			


For Parth Sarthi Build Estate (P) Ltd.

[Signature]
Director

[Stamp]
RAMESH KUMAR
M.E.P. CONSULTANT
B.E. CIVIL



SCHEMATIC DIAGRAM
LIGHTNING PROTECTION SYSTEM

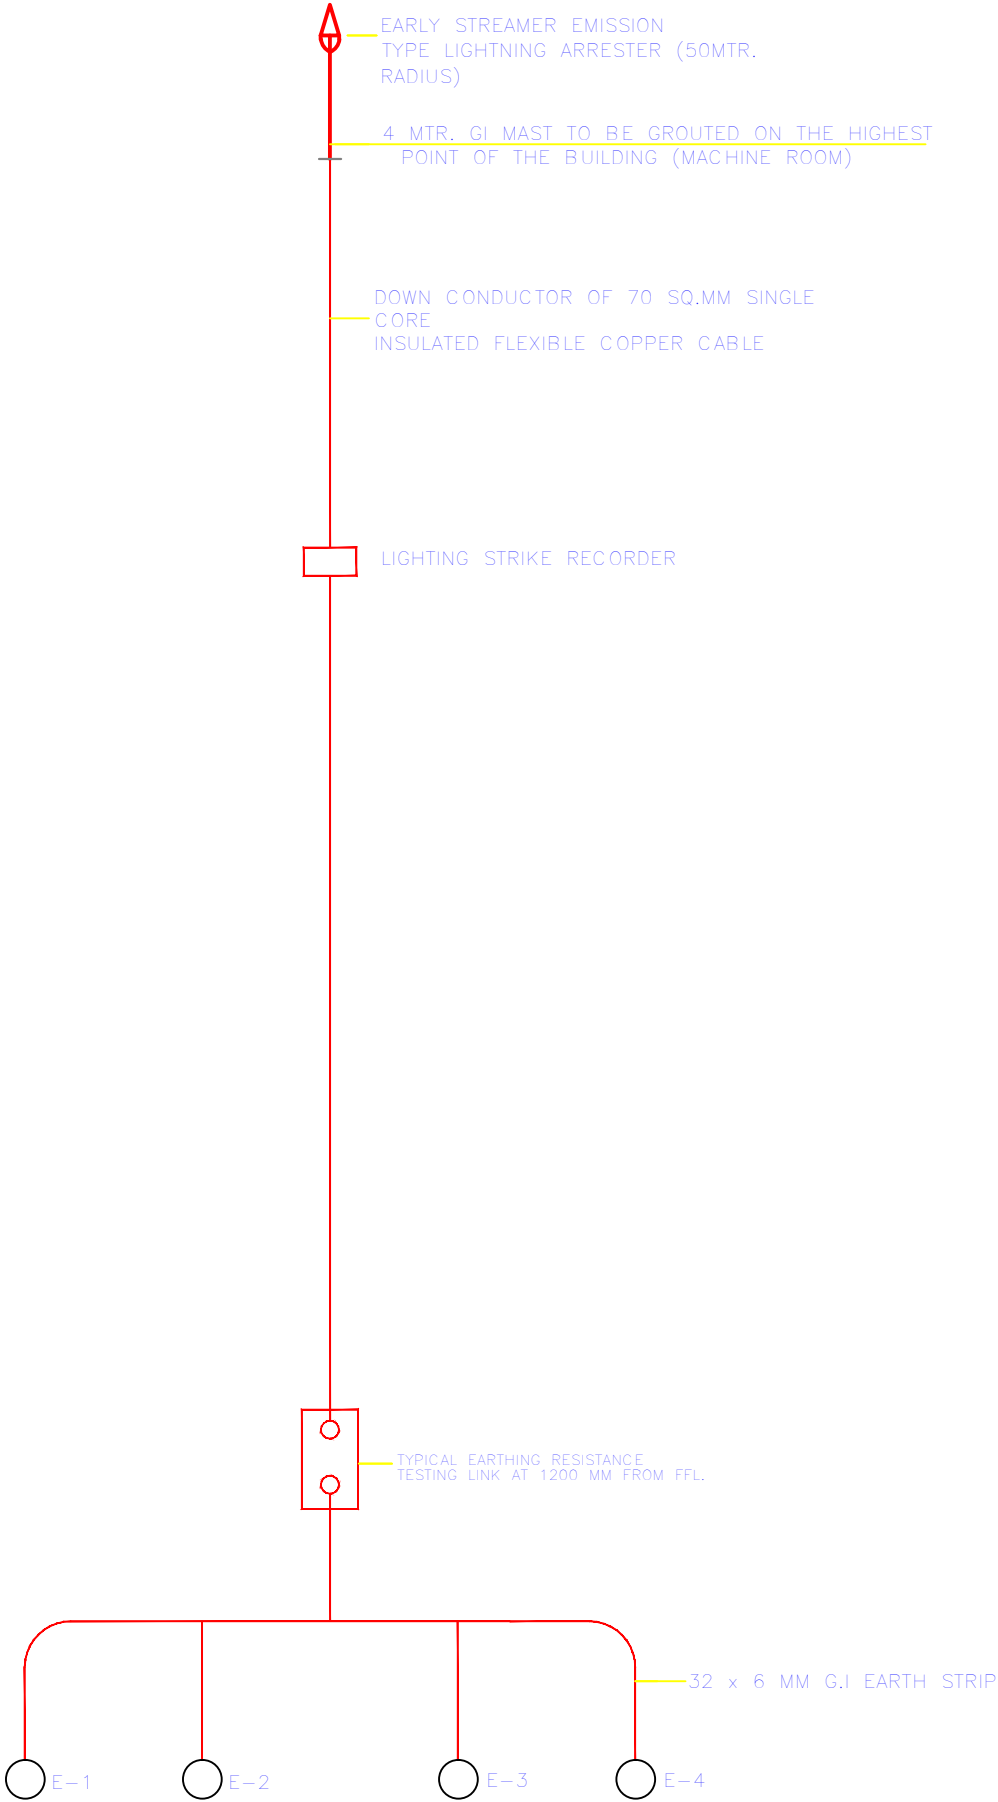


LIGHTENING ARRESTOR SLD

For Parth Sarthi Build Estate (P) Ltd.

मेधिराम
Director

रमेश
RAMESH KUMAWAT
M.E.P. CONSULTANT
B.E. CIVIL

PROJECT TITLE :- PROPOSED BUILDING AT PLOT NO. F-28, F-29 & F-30, 6-D ENGINEERS COLONY , JAIPUR	BUILDING NAME PARTH AANGAN	DRAWING TITLE :- LIGHTENING ARRESTOR SLD	SPACE CONSULTANT PLOT-A-173, JAGDAMBA NAGAR, HEERAPURA POWER HOWER, JAIPUR (RAJ) 302024	DRN. BY		DATE	
	DEVELOPER NAME PARTH SARTHI BUILD ESTATE (P)LTD.			APPD. BY		REVISION	
				SCALE			

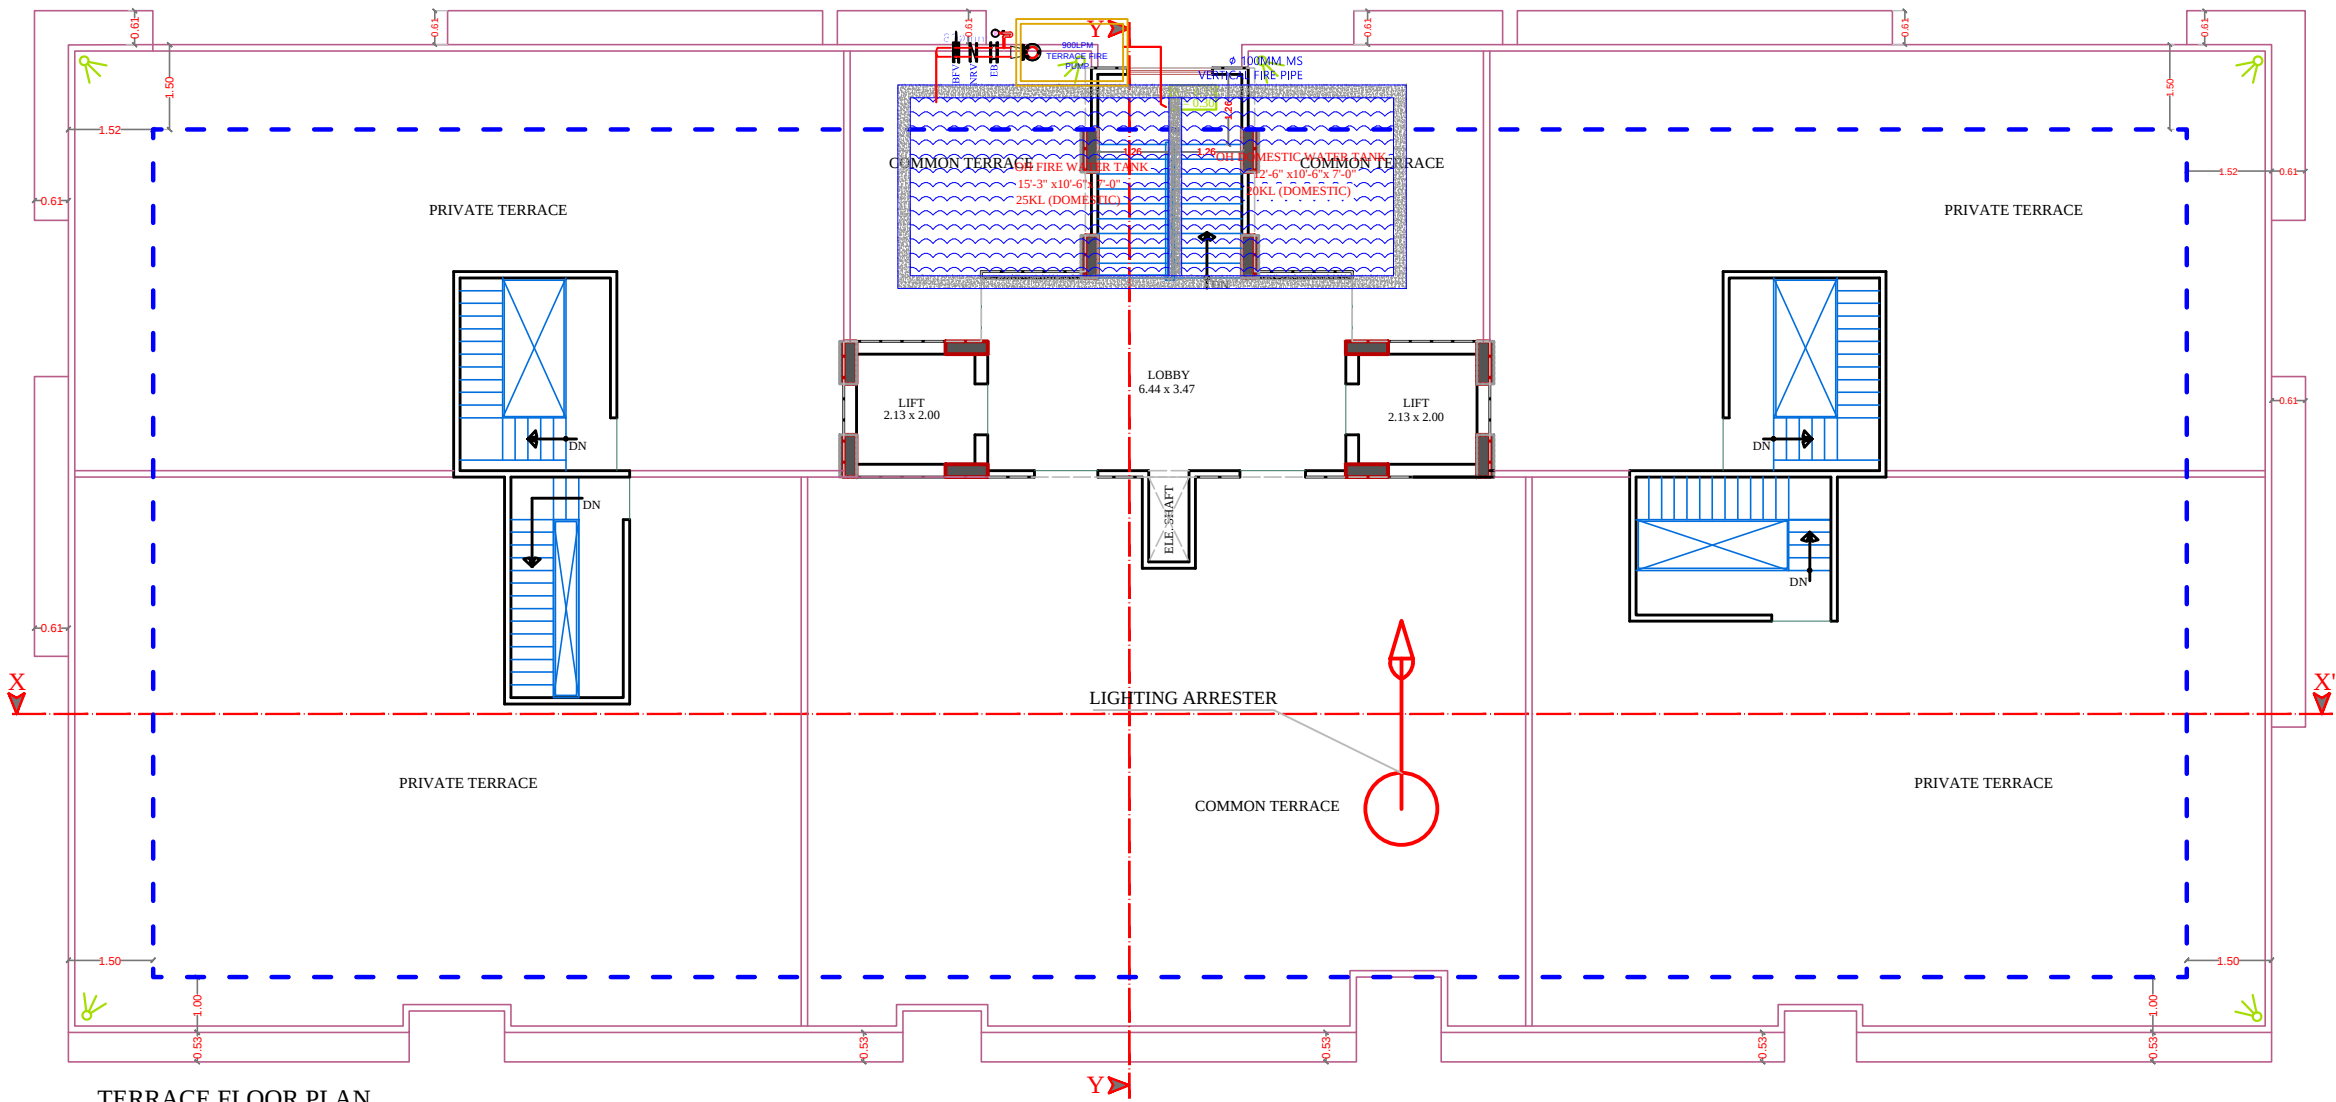

TERRACE FLOOR PLAN


For Parth Sarthi Build Estate (P) Ltd.

Director

RAMESH KUMAWAT
M.E.P. CONSULTANT
B.E. CIVIL

LEGEND		
	Symbole	DESCRIPTION
1.		HOSEREEL
2.		FIRE PIPE
3.		FIRE PIPE
4.		FIRE EXTINGUISHER
5.		EXTERNAL YARD HYDRANT

PROJECT TITLE :- PROPOSED BUILDING AT PLOT NO. F-28, F-29 & F-30, 6-D ENGINEERS COLONY , JAIPUR	BUILDING NAME PARTH AANGAN	DRAWING TITLE :- TARRACE FLOOR LIGHTING ARRESTER LOCATION	SPACE CONSULTANT PLOT-A-173, JAGDAMBA NAGAR, HEERAPURA POWER HOWER, JAIPUR (RAJ) 302024	DRN. BY		DATE	NORTH
				APPD. BY		REVISION	
	DEVELOPER NAME PARTH SARTHI BUILD ESTATE (P)LTD.			SCALE			

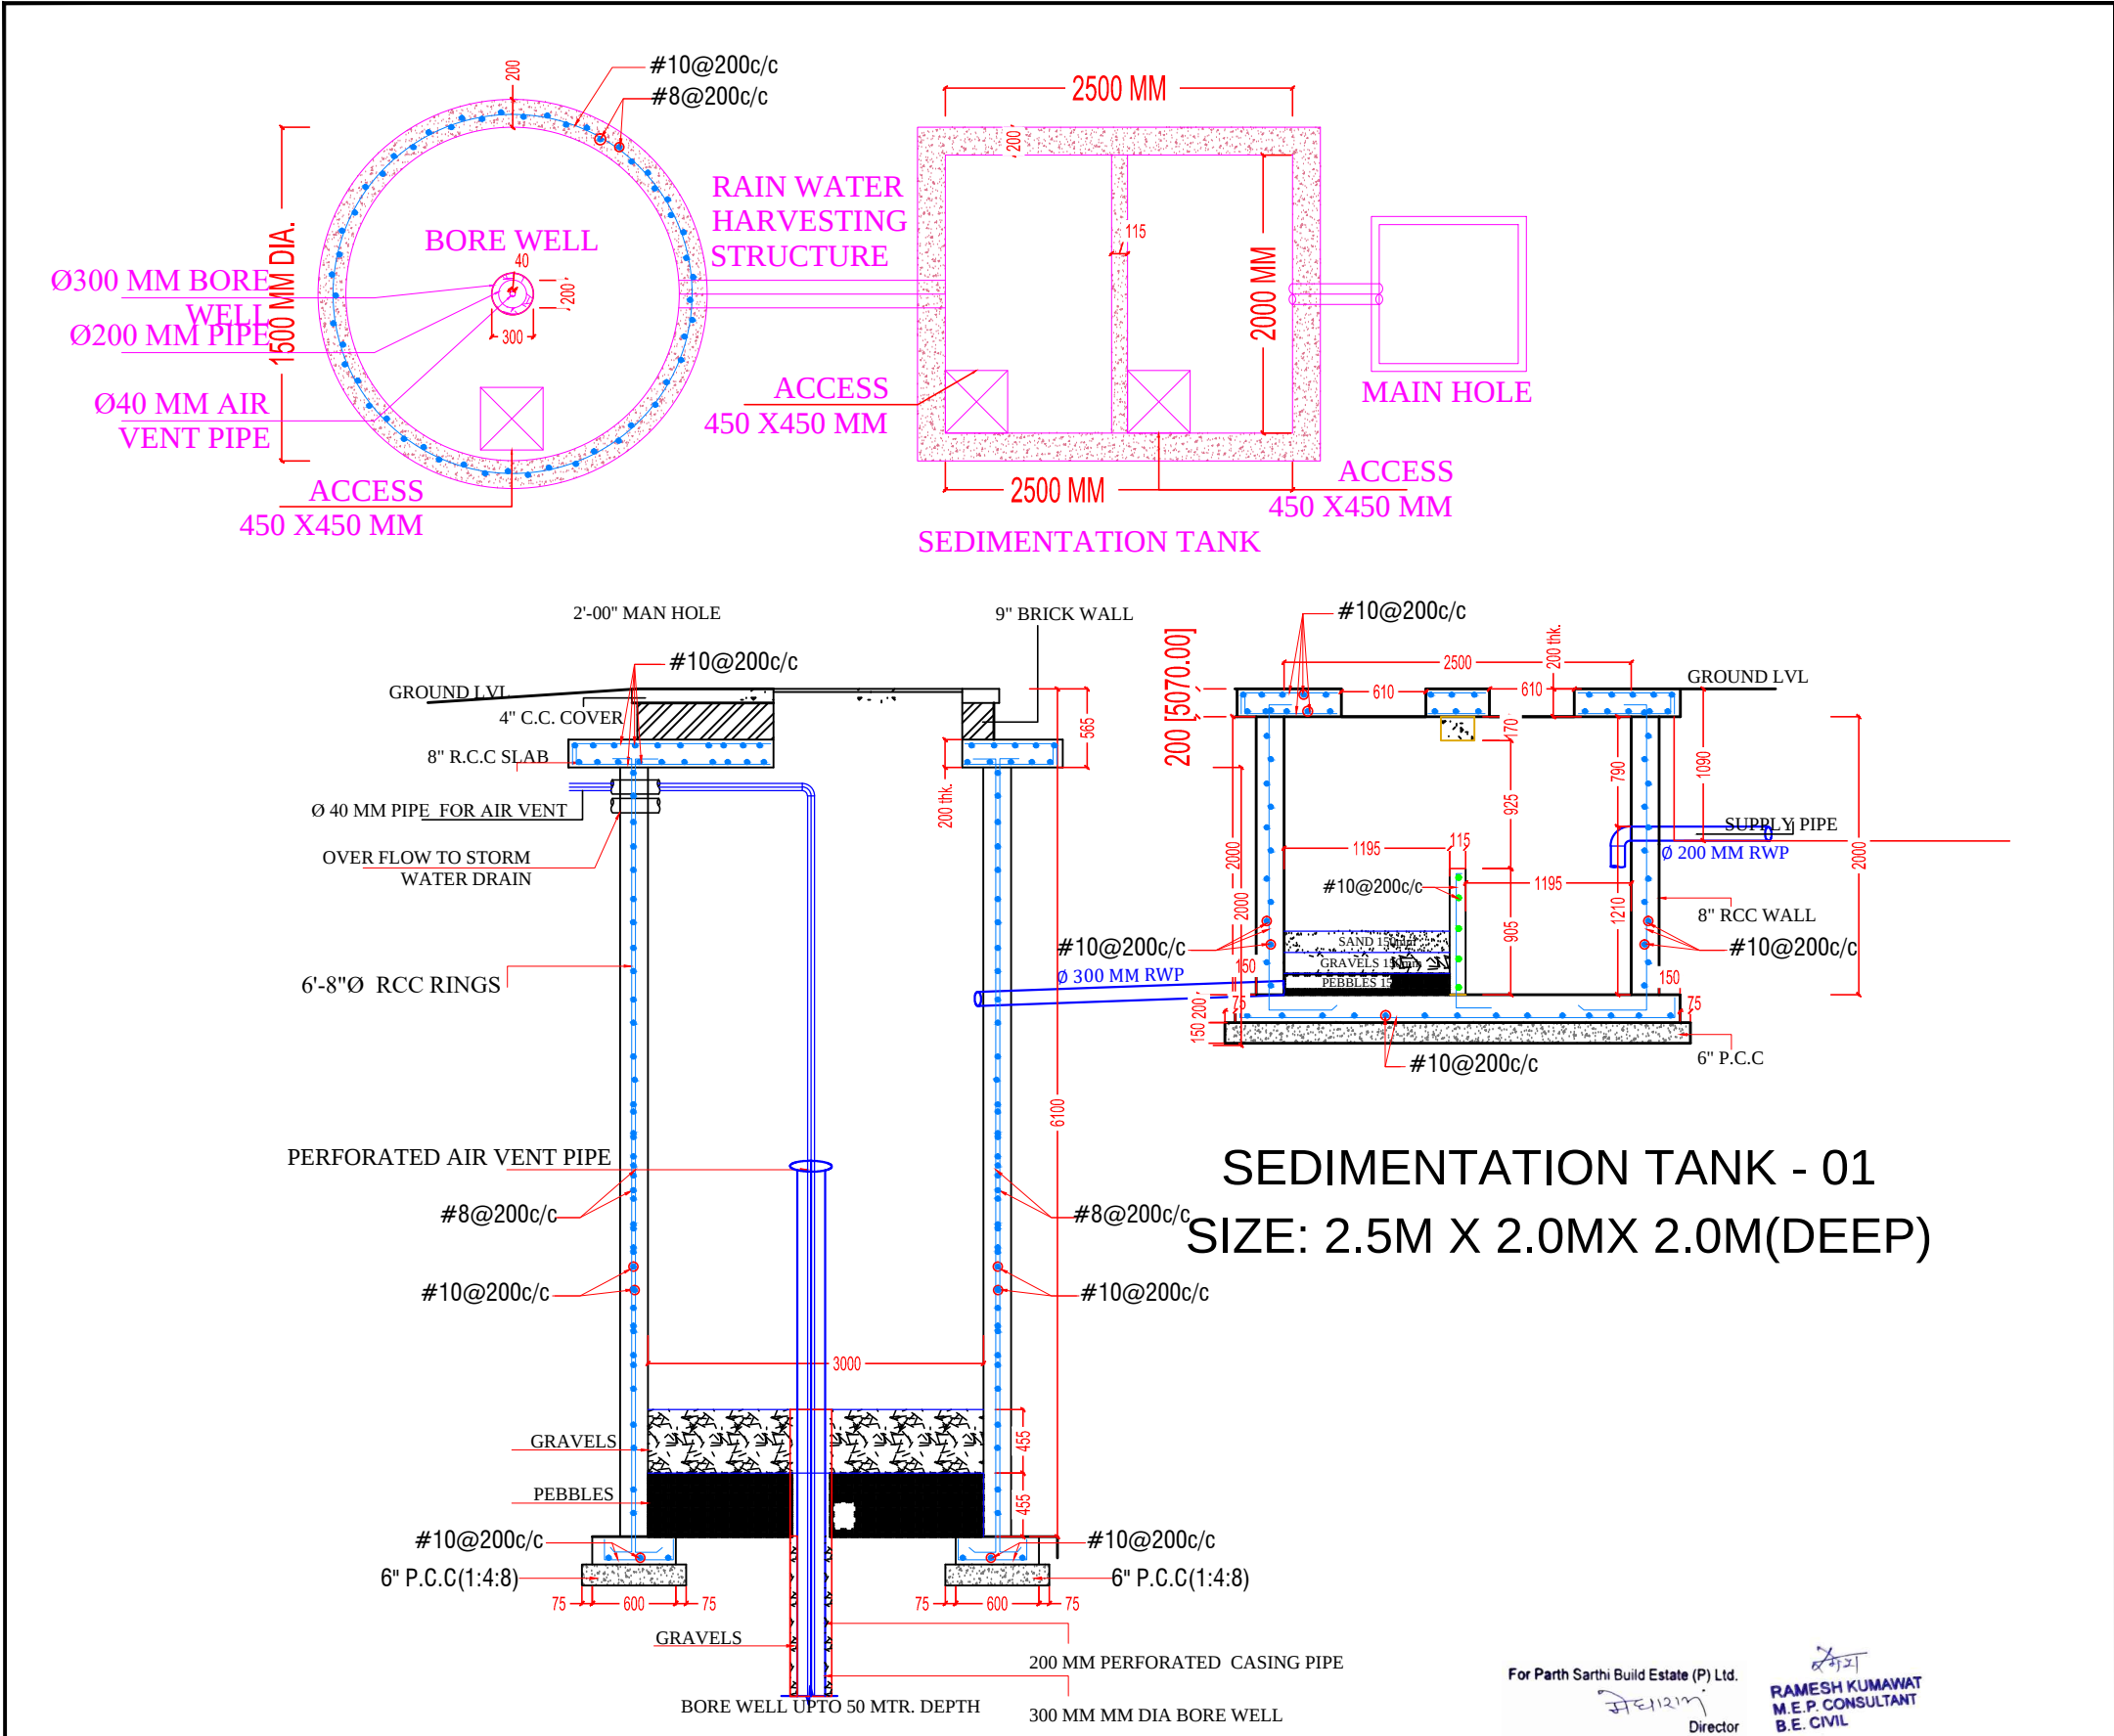

SEDIMENTATION TANK - 01
SIZE: 2.5M X 2.0MX 2.0M(DEEP)

For Parth Sarthi Build Estate (P) Ltd.

Director

RAMESH KUMAWAT
M.E.P. CONSULTANT
B.E. CIVIL

PROJECT TITLE :- PROPOSED BUILDING AT PLOT NO. F-28, F-29 & F-30, 6-D ENGINEERS COLONY , JAIPUR	BUILDING NAME PARTH AANGAN		DRAWING TITLE :- RAIN WATER HARVESTING	SPACE CONSULTANT PLOT-A-173, JAGDAMBA NAGAR, HEERAPURA POWER HOWER, JAIPUR (RAJ) 302024	DRN. BY	DATE	
	DEVELOPER NAME PARTH SARTHI BUILD ESTATE (P)LTD.				APPD. BY	REVISION	
					SCALE		

WATER SUPPLY SCHEMATIC DIAGRAM

SERVICES CONSULTANT:
PLOT-A-173, JAGDAMBA NAGAR ,HEERAPURA
POWER HOWER ,JAIPUR (RAJ) 302024

ARCHITECTS:-
FRANK SQUARE
ARCHITECTURE | PLANNER | DESIGNER
C-49 VIDYA APARTMENT PARAS MARG,
BAPU NAGAR JAIPUR, (RAJ.)
Email-afranksquare@gmail.com
Mobile-9461302542

Project:
PROPOSED BUILDING AT PLOT
NO. F-28, F-29 & F-30, 6-D
ENGINEERS COLONY , JAIPUR

BUILDING NAME
PARTH AANGAN

DEVELOPER NAME
PARTH SARTHI BUILD ESTATE (P)LTD.

Drawing:
WATER SUPPLY SCHEMATIC
DIAGRAM

DRN BY : CHCKD BY :

APPRVD BY : DATE:-

For Parth Sarthi Build Estate (P) Ltd.

मेधाराम
Director
RAMESH KUMAWAT
M.E.P. CONSULTANT
B.E. CIVIL

