



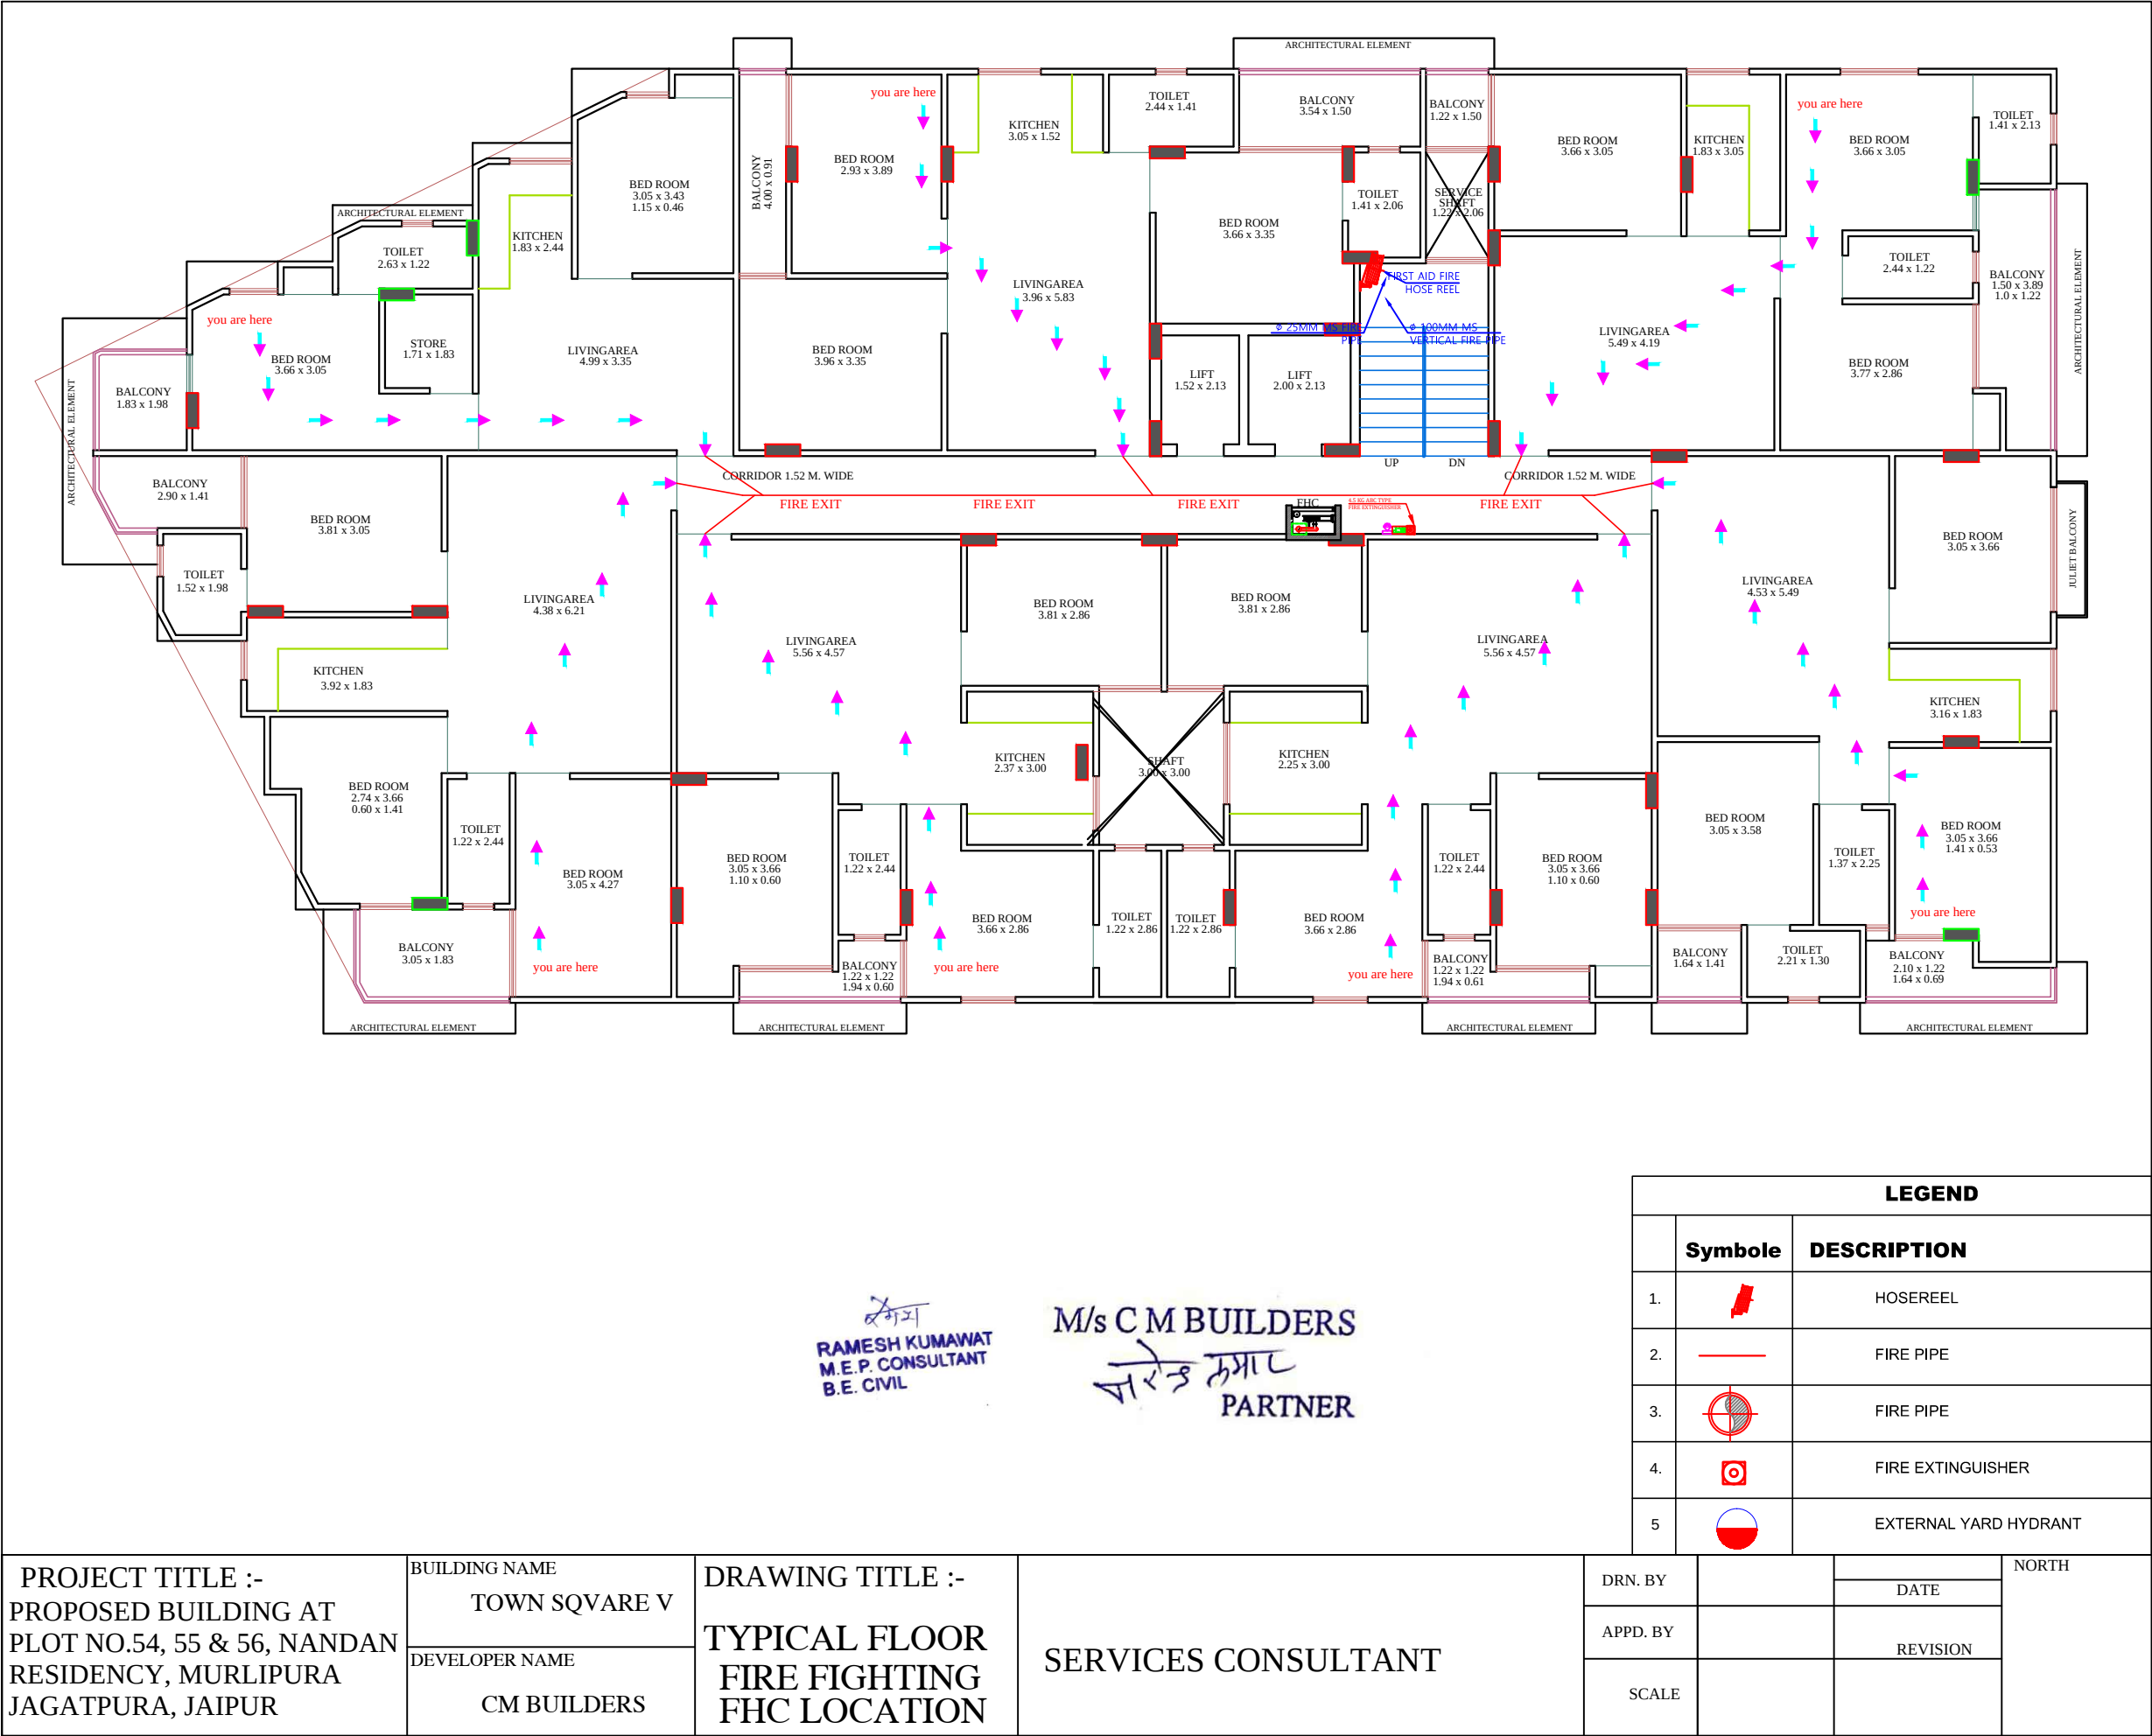

PRODUCED BY AN AUTODESK EDUCATIONAL PRODUCT

PRODUCED BY AN AUTODESK EDUCATIONAL PRODUCT

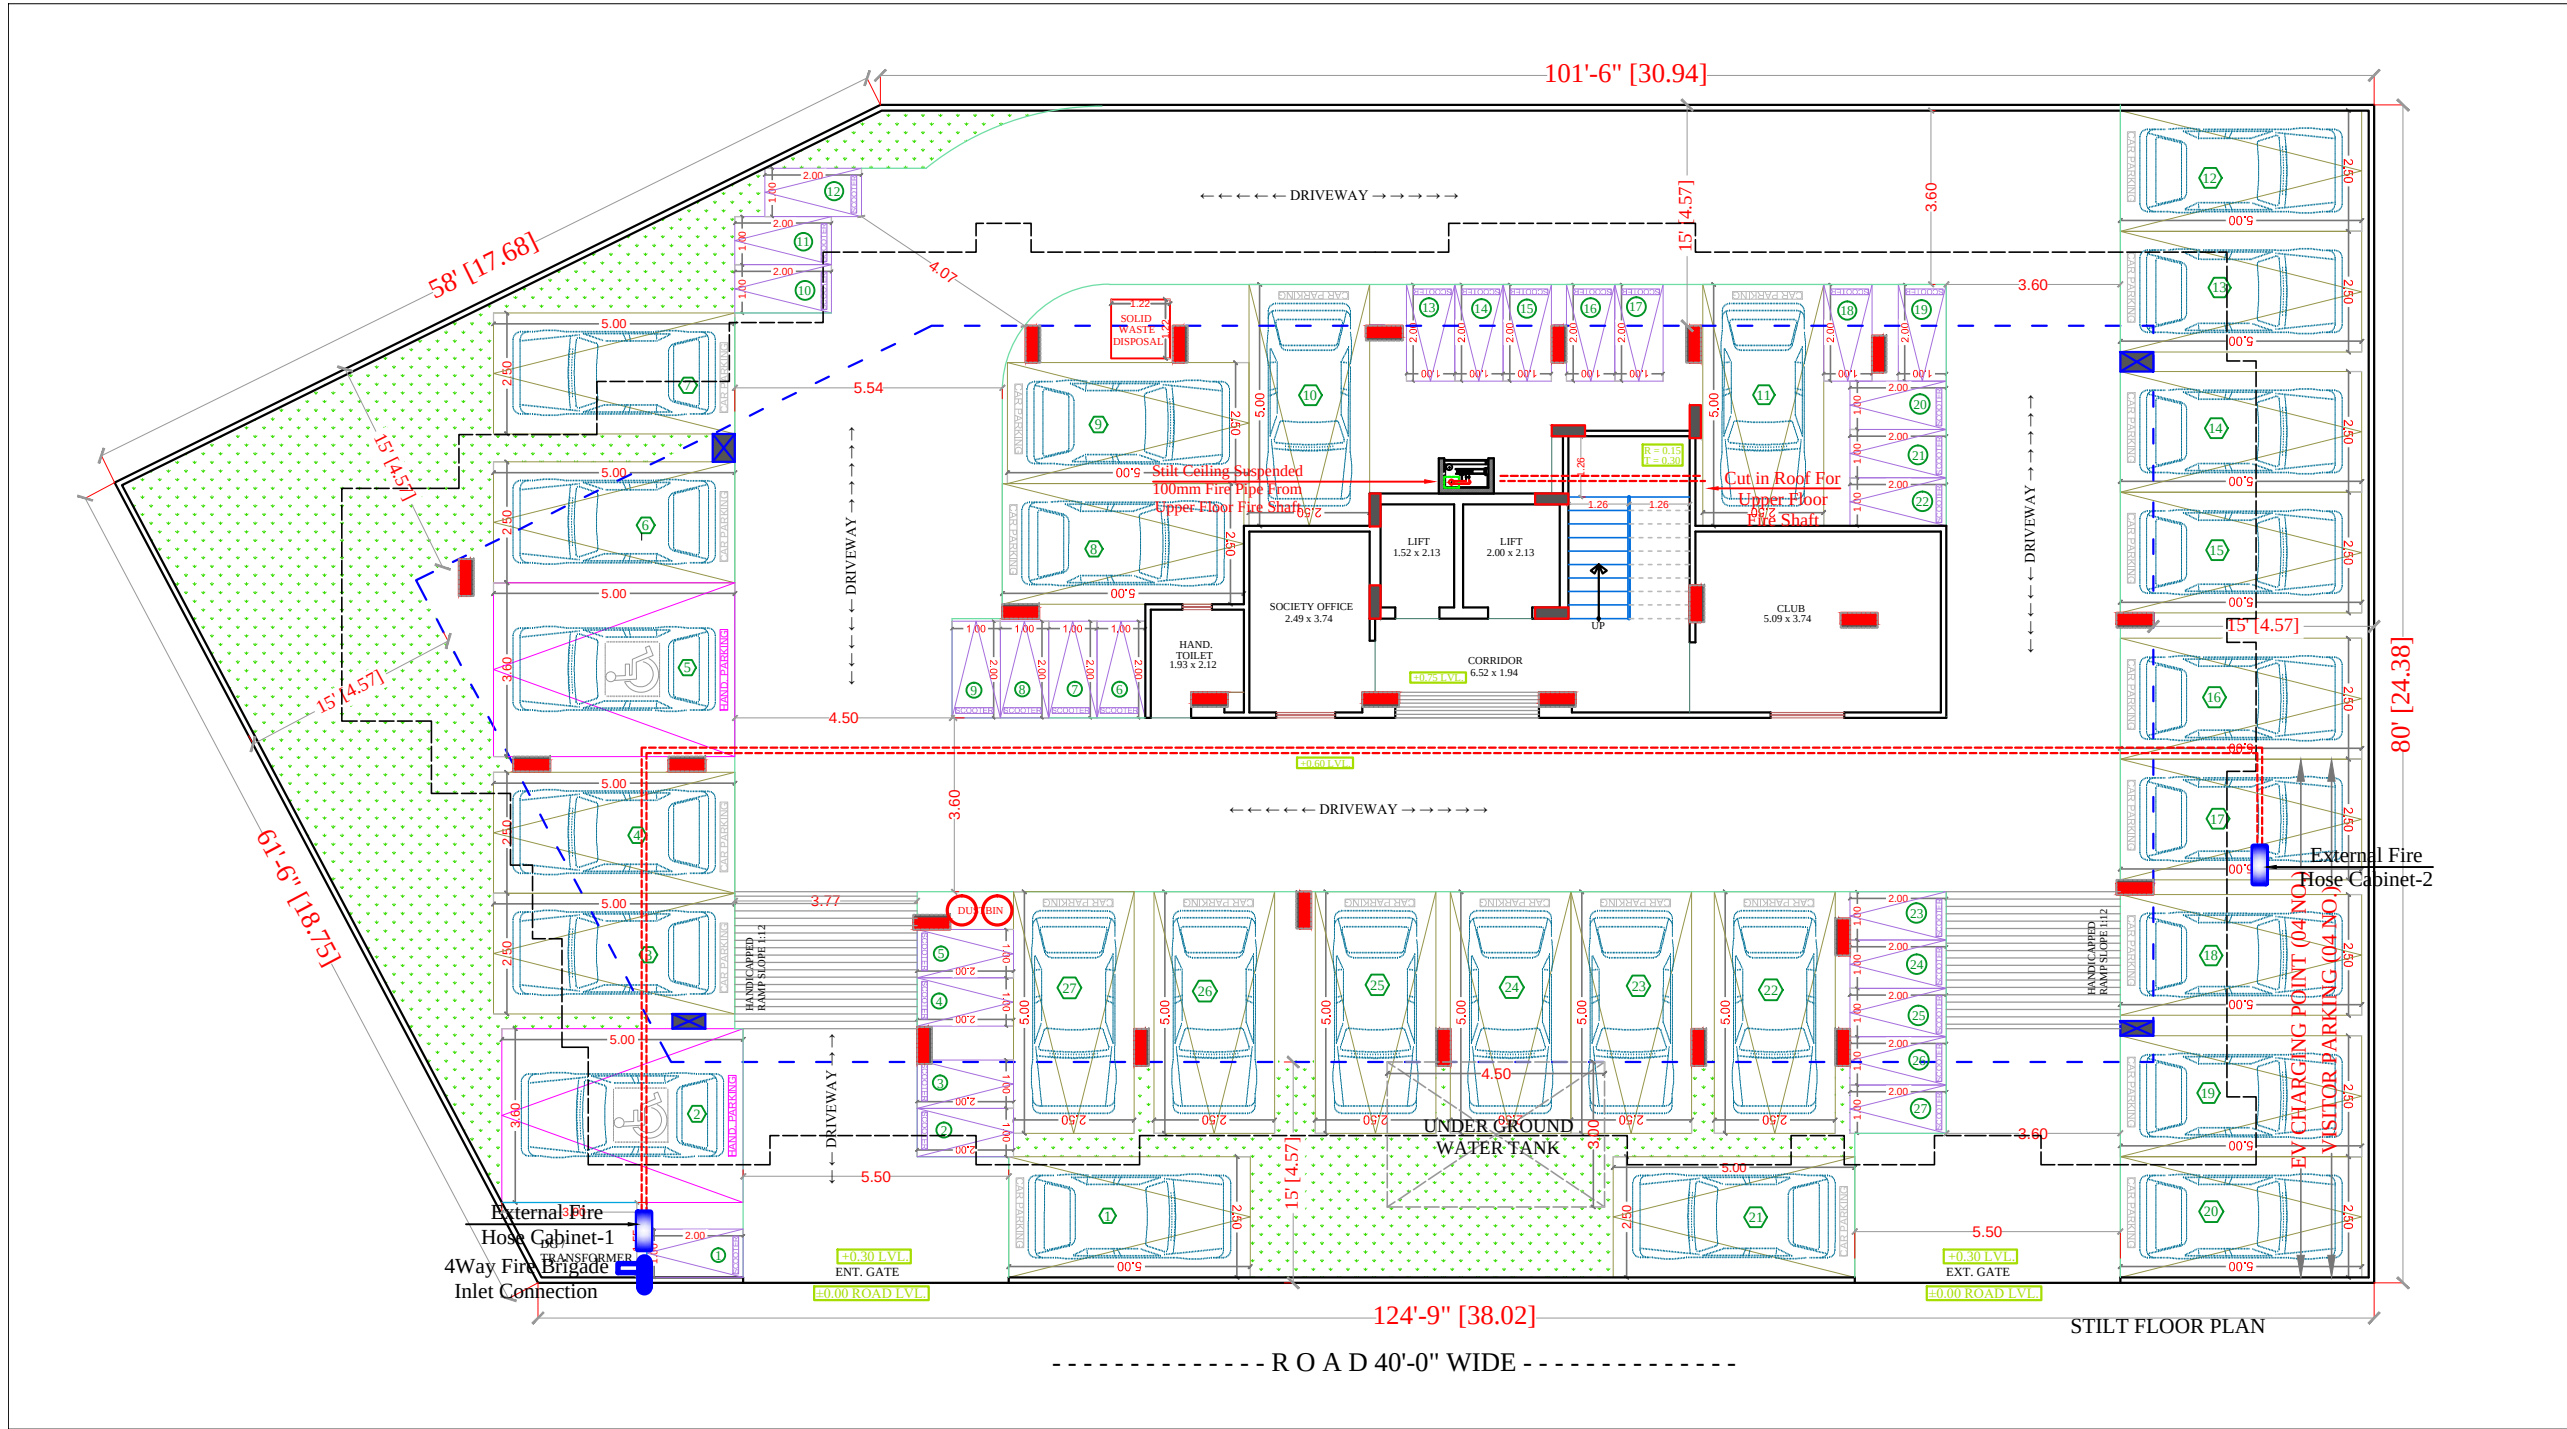

SYMBOL	QTY.	DESCRIPTION
	02	EXTERNAL FIRE HOSE CABINET
	01	FIRE HOSE CABINET

1000MS FIRE PIPE FOR EXTERNAL FIRE HYDRANTS

SEAL:-

RAMESH KUMARWAT
M.E.P. CONSULTANT
B.E. CIVIL

M/s C.M. BUILDERS
PARTNER

SPACE CONSULTANT

PLOT-A-173, JAGDAMBA NAGAR, HEERAPURA
POWER HOWER, JAIPUR (RAJ.) 302024

ARCHITECT :-

FRANK SQUARE
ARCHITECTURE | PLANNER | DESIGNER
C-49 VIDYA APARTMENT PARAS MARG,
BAPU NAGAR JAIPUR, (RAJ.)
Email-afranksquare@gmail.com
Mobile-9461302542

PROJECT :-

PROPOSED BUILDING AT
PLOT NO.54, 55 & 56, NANDAN
RESIDENCY, MURLIPURA
JAGATPURA, JAIPUR

BUILDING NAME TOWN SQUARE V

DEVELOPER NAME CM BUILDERS

DRAWING: STILT FLOOR
EXTERNAL FIRE HYDRANT FOR
RERA SUBMISSION PLAN



रमेश कुमावत
RAMESH KUMAWAT
M.E.P. CONSULTANT
B.E. CIVIL

M/s C M BUILDERS
पारस कुमार
PARTNER

PROJECT TITLE :-
PROPOSED BUILDING AT
PLOT NO.54, 55 & 56, NANDAN
RESIDENCY, MURLIPURA
JAGATPURA, JAIPUR

BUILDING NAME
TOWN SQVARE V
DEVELOPER NAME
CM BUILDERS

DRAWING TITLE :-
TYPICAL FLOOR
FIRE FIGHTING

SERVICES CONSULTANT

DRN. BY


APPD. BY

SCALE

DATE

REVISION

NORTH

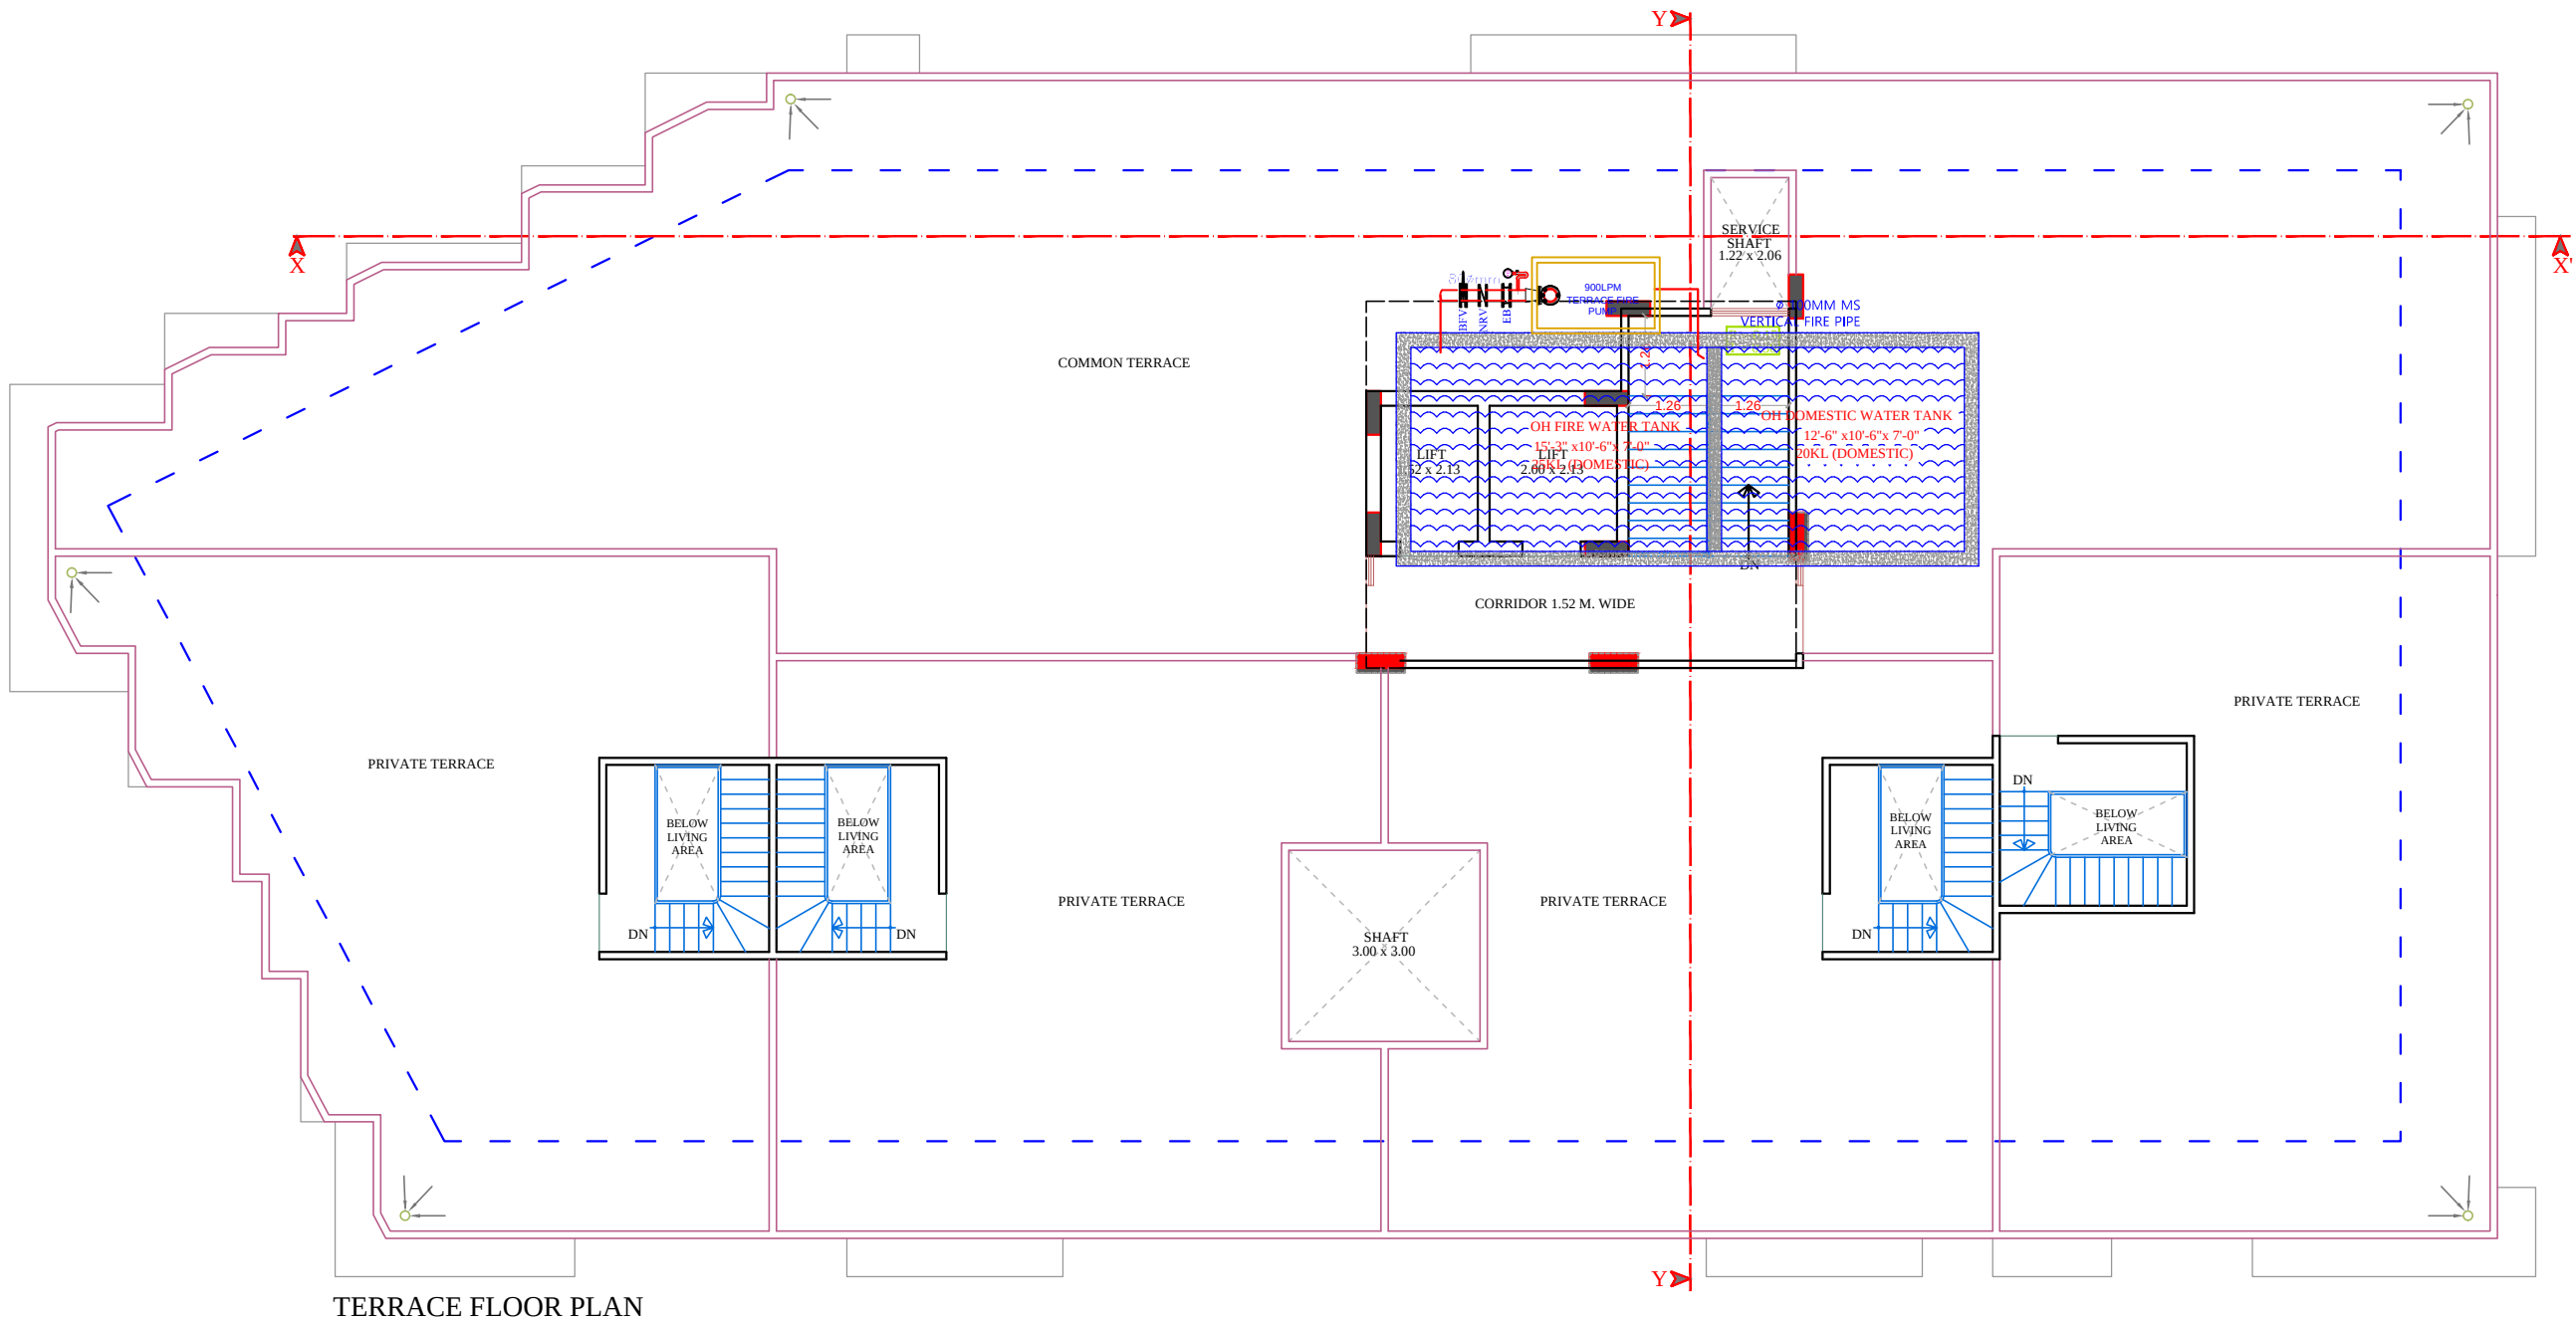

TERRACE FLOOR PLAN

LEGEND		
	Symbole	DESCRIPTION
1.		HOSEREEL
2.		FIRE PIPE
3.		FIRE PIPE
4.		FIRE EXTINGUISHER
5.		EXTERNAL YARD HYDRANT

RAMESH KUMAWAT
M.E.P. CONSULTANT
B.E. CIVIL

M/s C M BUILDERS

PARTNER

PROJECT TITLE :- PROPOSED BUILDING AT PLOT NO.54, 55 & 56, NANDAN RESIDENCY, MURLIPURA JAGATPURA, JAIPUR	BUILDING NAME TOWN SQVARE V	DRAWING TITLE :- TARRACE FLOOR FIRE FIGHTING	SPACE CONSULTANT PLOT-A-173, JAGDAMBA NAGAR, HEERAPURA POWER HOWER, JAIPUR (RAJ) 302024	DRN. BY			NORTH
					DATE		
	DEVELOPER NAME CM BUILDERS			APPD. BY		REVISION	
				SCALE			