


SCHEMATIC DIAGRAM
LIGHTNING PROTECTION SYSTEM

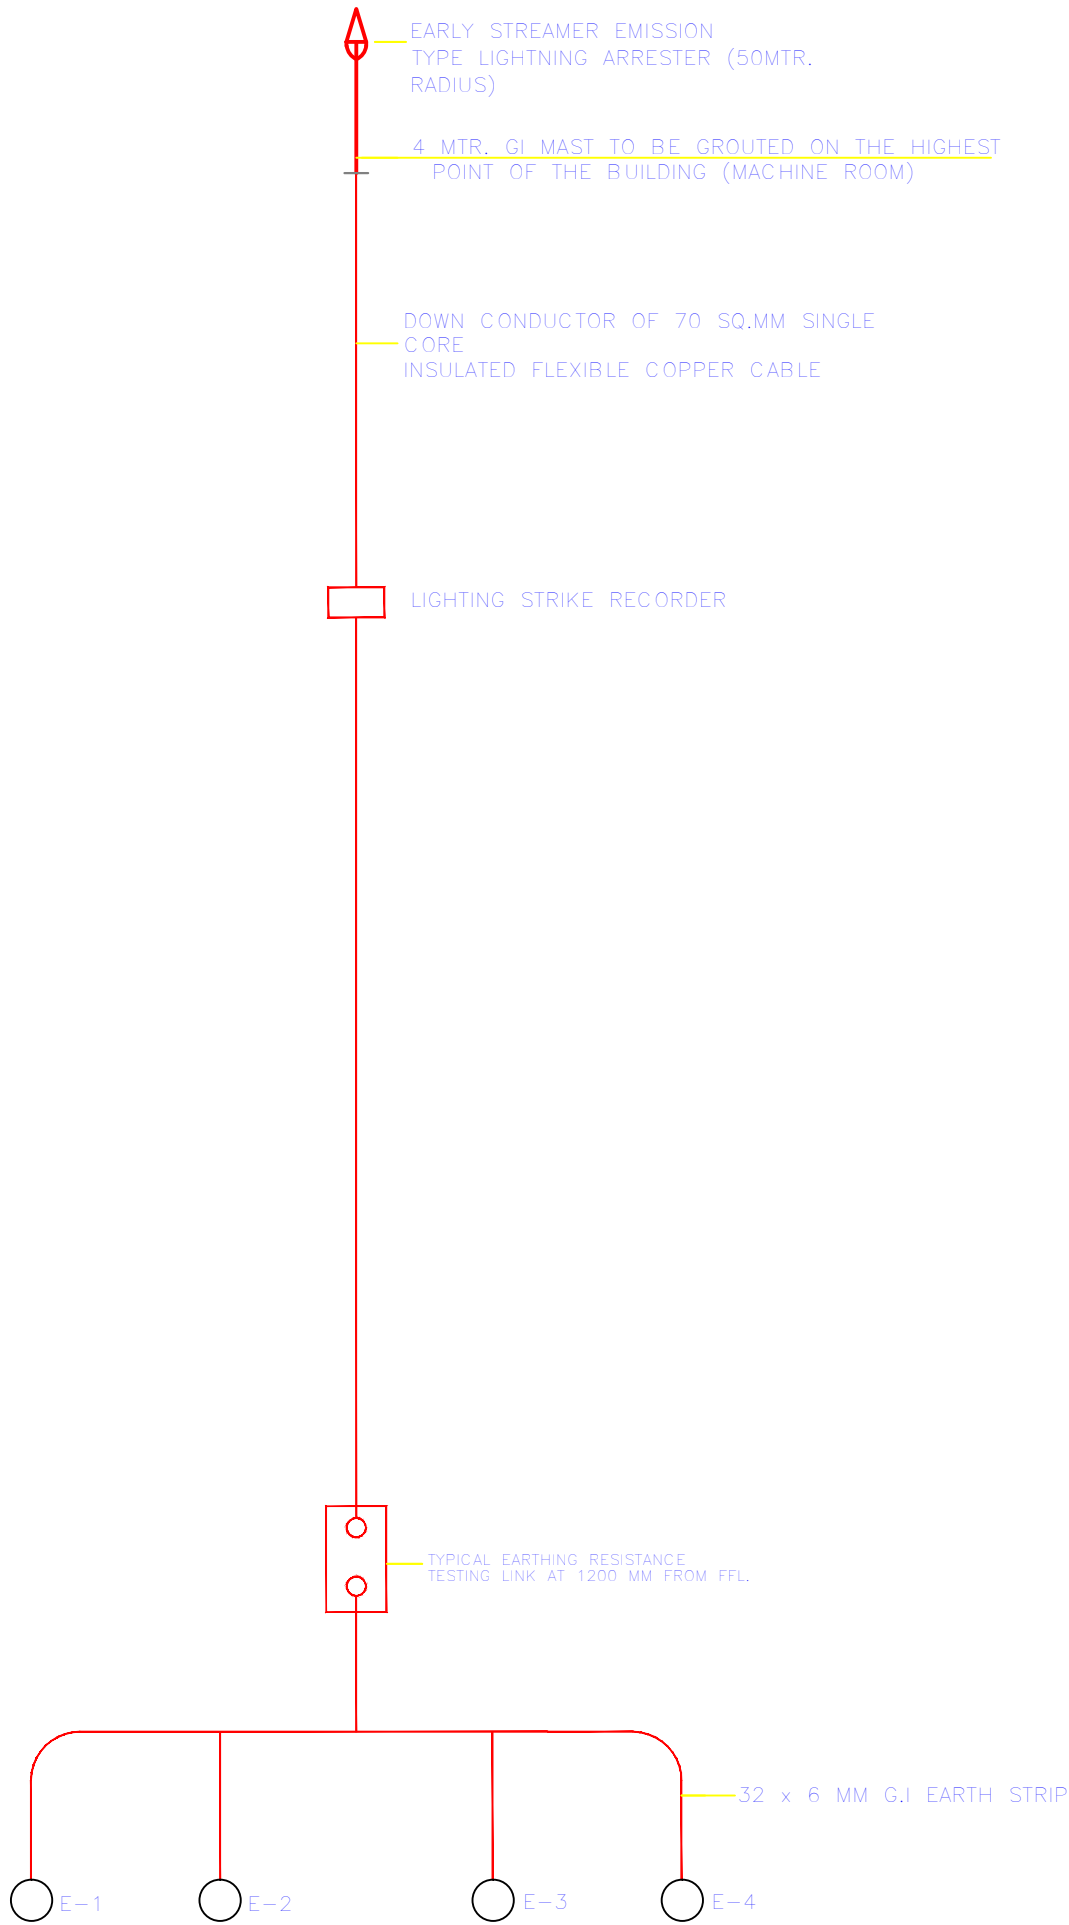


LIGHTENING ARRESTOR SLD

RAMESH KUMAWAT
M.E.P. CONSULTANT
B.E. CIVIL

M/s CM BUILDERS
PARTNER

PROJECT TITLE :- PROPOSED BUILDING AT PLOT NO.54, 55 & 56, NANDAN RESIDENCY, MURLIPURA JAGATPURA, JAIPUR	BUILDING NAME TOWN SQVARE V	DRAWING TITLE :- LIGHTENING ARRESTOR SLD	SPACE CONSULTANT PLOT-A-173, JAGDAMBA NAGAR, HEERAPURA POWER HOWER, JAIPUR (RAJ) 302024	DRN. BY		DATE	NORTH
	DEVELOPER NAME CM BUILDERS			APPD. BY		REVISION	
				SCALE			

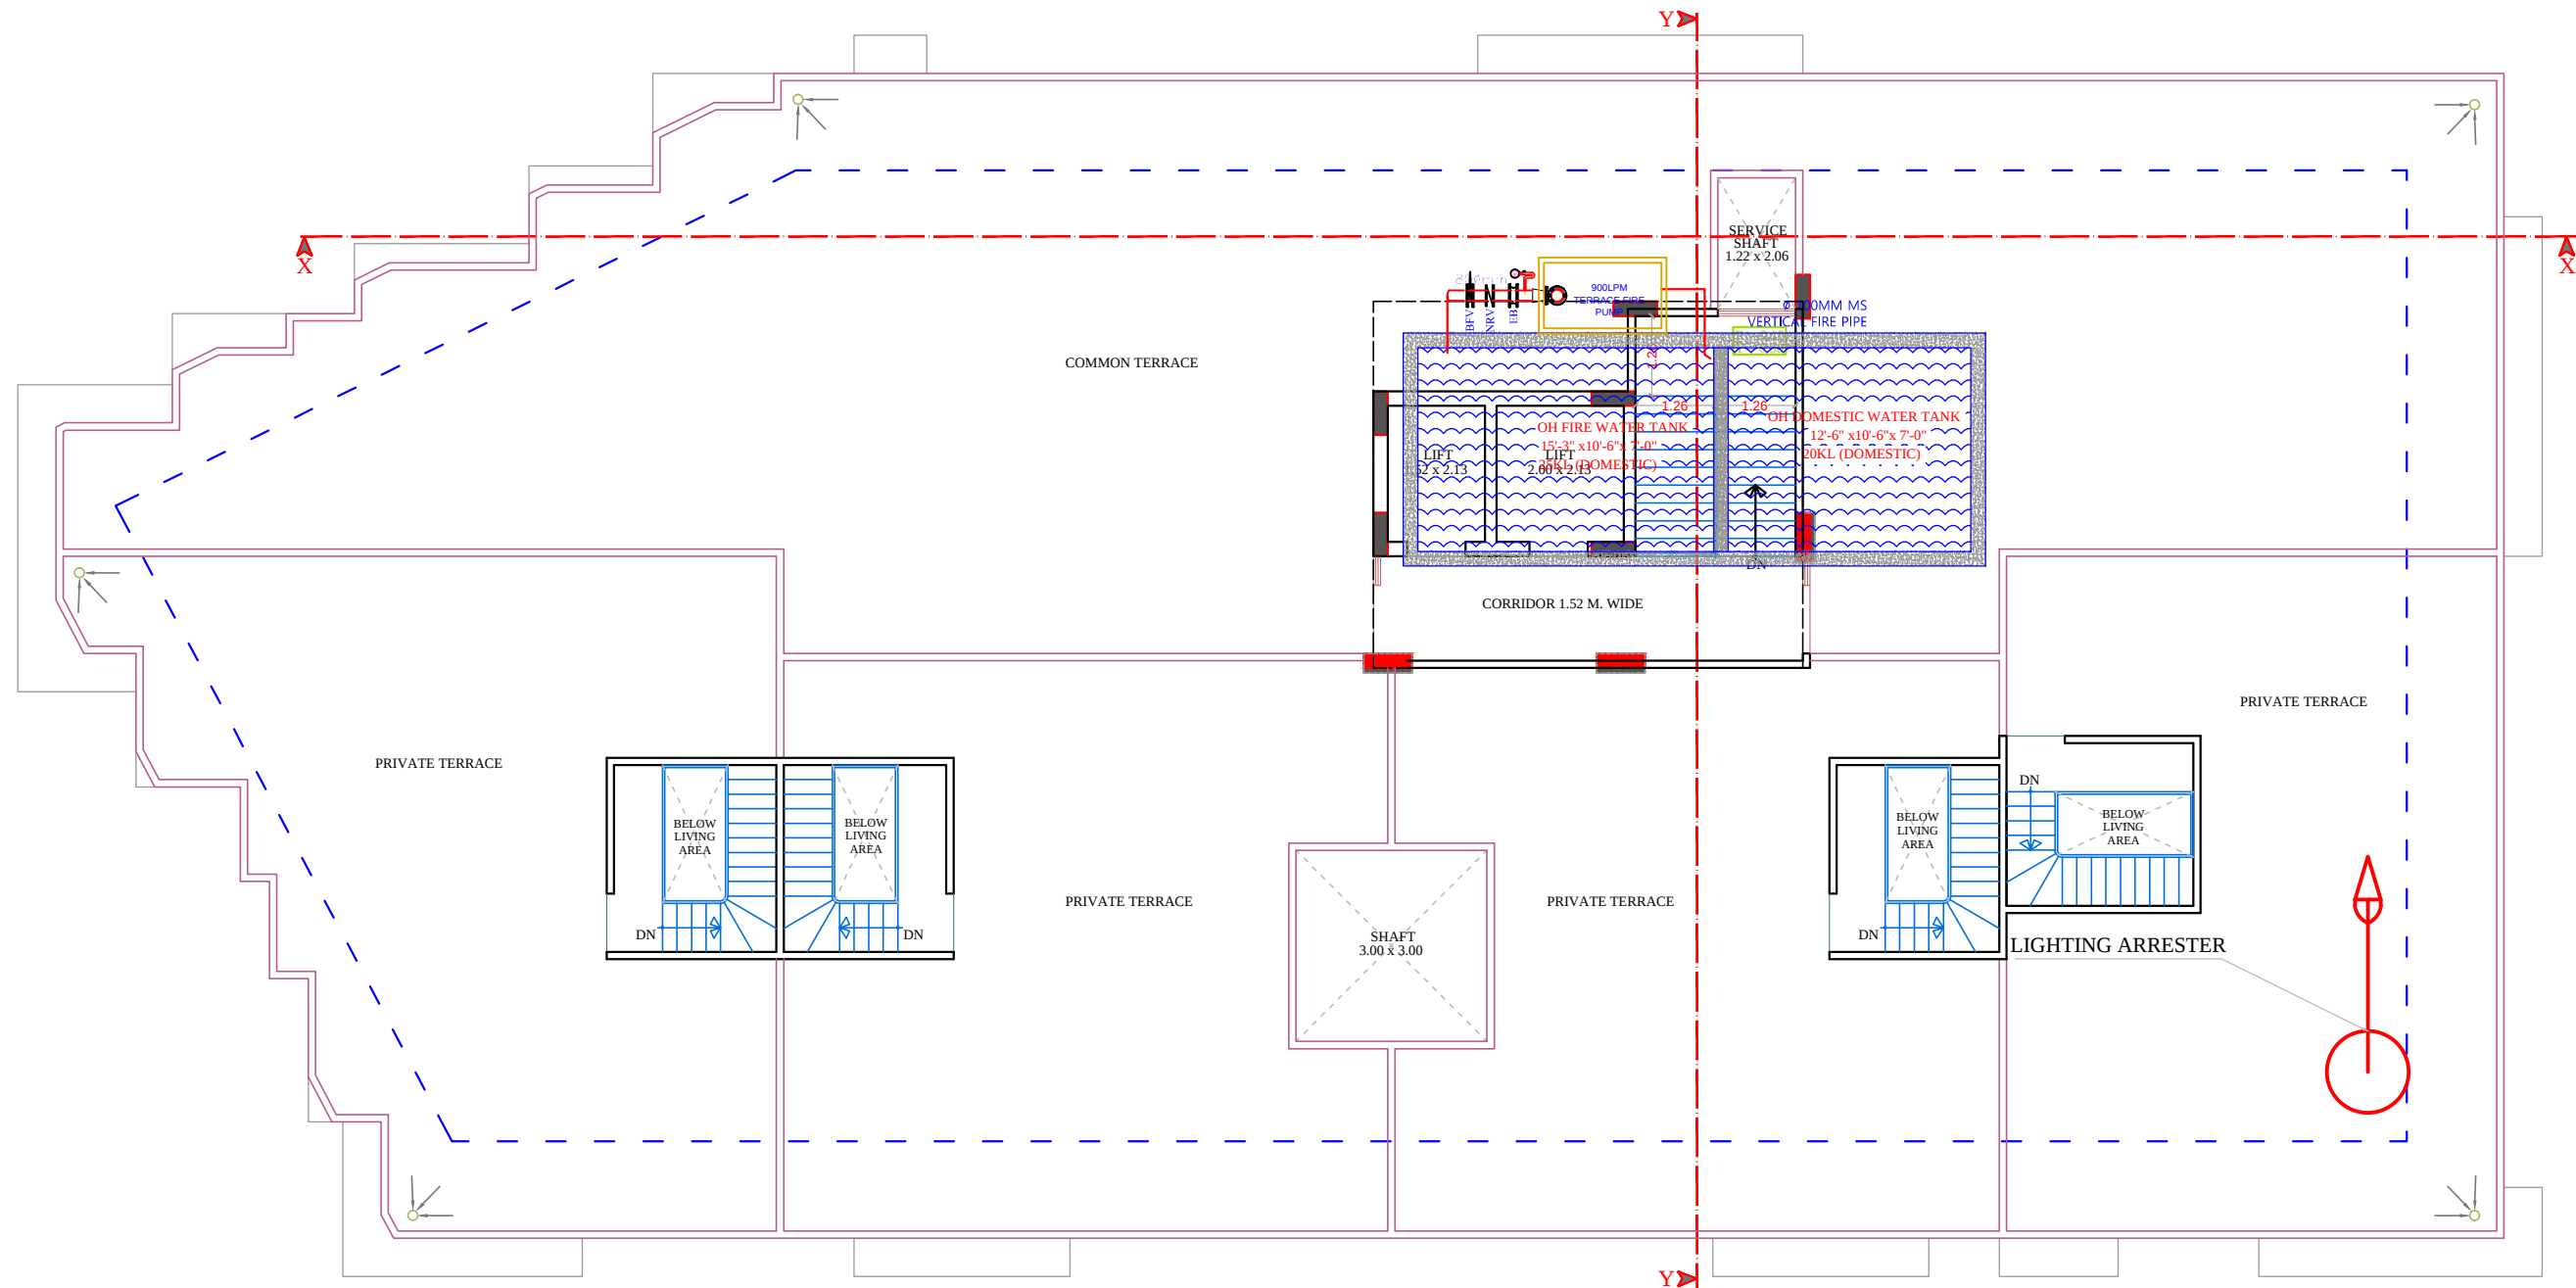


TERRACE FLOOR PLAN

LEGEND		
	Symbole	DESCRIPTION
1.		HOSEREEL
2.		FIRE PIPE
3.		FIRE PIPE
4.		FIRE EXTINGUISHER
5.		EXTERNAL YARD HYDRANT

PROJECT TITLE :- PROPOSED BUILDING AT PLOT NO.54, 55 & 56, NANDAN RESIDENCY, MURLIPURA JAGATPURA, JAIPUR	BUILDING NAME TOWN SQVARE V	DRAWING TITLE :- TARRACE FLOOR LIGHTING ARRESTER LOCATION	SPACE CONSULTANT PLOT-A-173, JAGDAMBA NAGAR, HEERAPURA POWER HOWER, JAIPUR (RAJ) 302024	DRN. BY			NORTH
					DATE		
	DEVELOPER NAME CM BUILDERS			APPD. BY		REVISION	
				SCALE			

RAMESH KUMAWAT
M.E.P. CONSULTANT
B.E. CIVIL

M/s C M BUILDERS
PARTNER

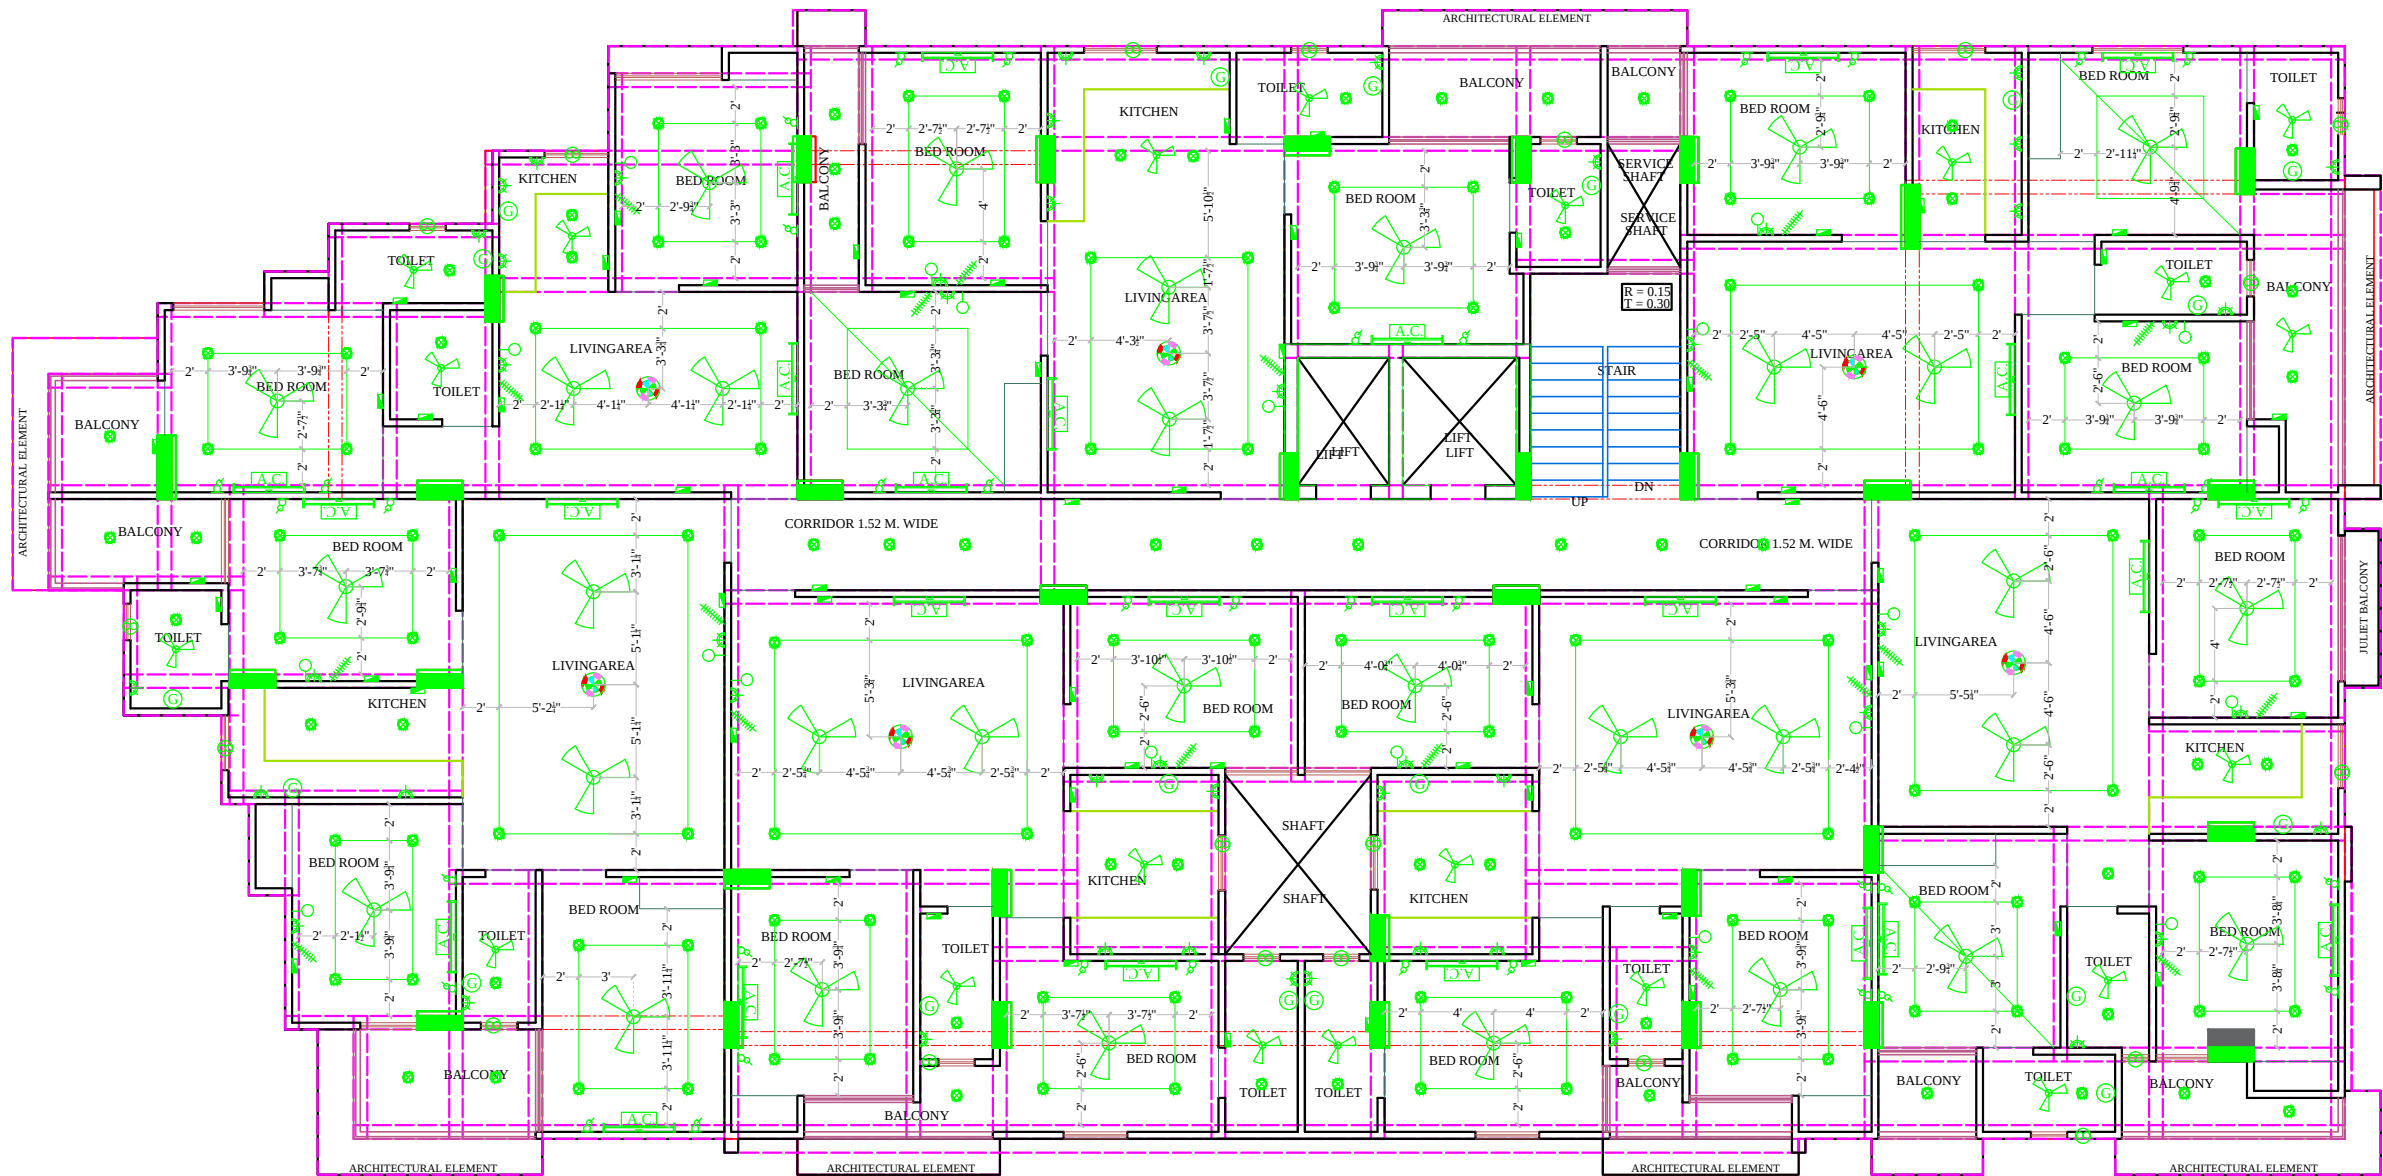


NO	ITEM	SYMBOL
1	CEILING FAN	ROOF
2	TUBE LIGHT	+8'6"
3	BULB	+8'6"
4	POWER POINT	+1'6"
5	BED POINT	+4'3"
6	CEILING LIGHT	ROOF
7	A.C.POINT	+6'6"
8	SWITCH BOARD	+4'3"
9	EXHAUST	VENT
10	TELEPHONE	+1'6"
11	GYSER	+6'0"
12	BELL POINT	+8'6"
13	T.V.	+1'6"
14	M.BOX	[M.B]
15	M.C.B.	[M.C.B.] +6'6"
16	FANCY LIGHT	+8'6"
17	HANGING LIGHT	ROOF

रमेश कुमार
RAMESH KUMAWAT
M.E.P. CONSULTANT
B.E. CIVIL

M/s CM BUILDERS
पार्टनेर
PARTNER

PROJECT TITLE :- PROPOSED BUILDING AT PLOT NO.54, 55 & 56, NANDAN RESIDENCY, MURLIPURA JAGATPURA, JAIPUR	BUILDING NAME TOWN SQUARE V	DRAWING TITLE :- TYPICAL FLOOR ELECTRIC PLAN	SPACE CONSULTANT PLOT-A-173, JAGDAMBA NAGAR, HEERAPURA POWER HOWER, JAIPUR (RAJ) 302024	DRN. BY		DATE	NORTH
				APPD. BY		REVISION	
	DEVELOPER NAME CM BUILDERS			SCALE			

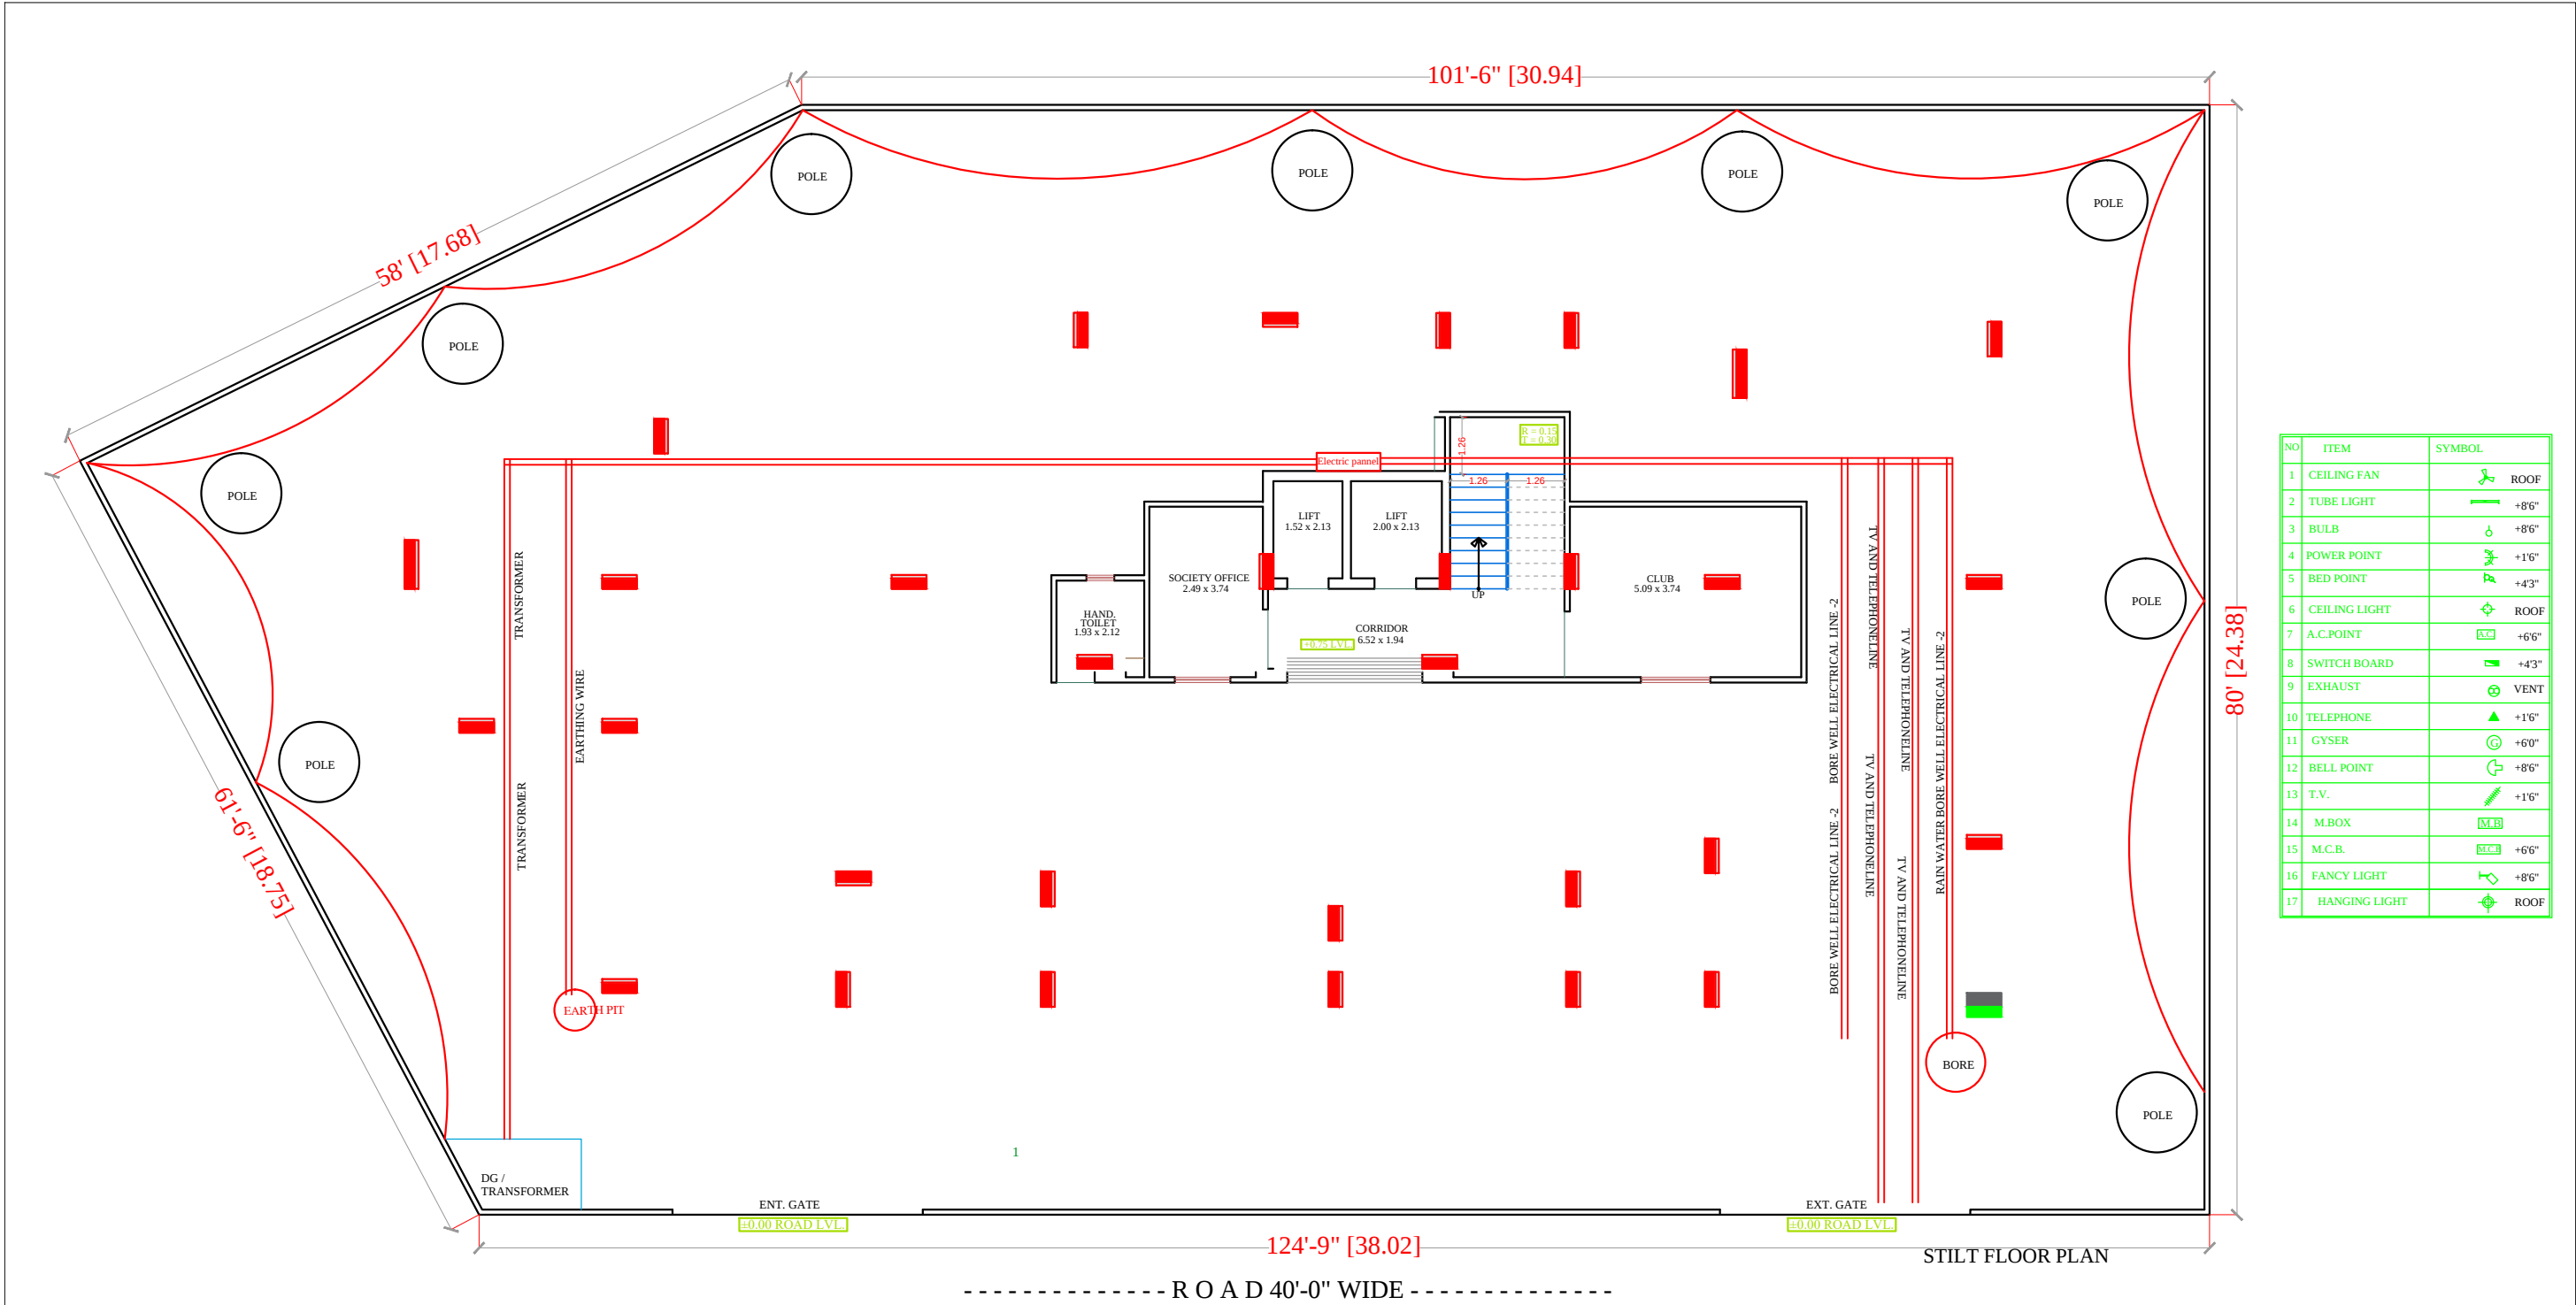

NO	ITEM	SYMBOL
1	CEILING FAN	ROOF
2	TUBE LIGHT	+8'6"
3	BULB	+8'6"
4	POWER POINT	+1'6"
5	BED POINT	+4'3"
6	CEILING LIGHT	ROOF
7	A.C.POINT	+6'6"
8	SWITCH BOARD	+4'3"
9	EXHAUST	VENT
10	TELEPHONE	+1'6"
11	GYSER	+6'0"
12	BELL POINT	+8'6"
13	T.V.	+1'6"
14	M.BOX	M.B
15	M.C.B.	M.C.B +6'6"
16	FANCY LIGHT	+8'6"
17	HANGING LIGHT	ROOF

STILT (PARKING) FLOOR PLAN

PROJECT TITLE :- PROPOSED BUILDING AT PLOT NO.54, 55 & 56, NANDAN RESIDENCY, MURLIPURA JAGATPURA, JAIPUR	BUILDING NAME TOWN SQVARE V	DRAWING TITLE :- SERVICE DRAWING SLD/DISTRIBUTION AFTER LT PANEL, EARTHING LAYOUT,EXTERNAL LIGHTING PLAN, TV & TELEPHONE RISER,LIGHTING ARRESTR, & PIT LOCATION COMMON AREA TRANSFORMER	SPACE CONSULTANT PLOT-A-173, JAGDAMBA NAGAR, HEERAPURA POWER HOWER, JAIPUR (RAJ) 302024	DRN. BY		DATE	NORTH
	DEVELOPER NAME CM BUILDERS			APPD. BY		REVISION	
				SCALE			

RAMESH KUMAWAT
M.E.P. CONSULTANT
B.E. CIVIL

M/s C M BUILDERS
PARTNER

