



SCALE 1:350

NOTE:-
(1) SCHEME BOUNDARY SHOWN
(2) H.T. LINE SHOWN
(3) KHASRA BOUNDARY SHOWN

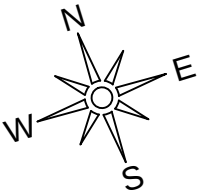

APPROVED MANGLAM TOWN SHIP

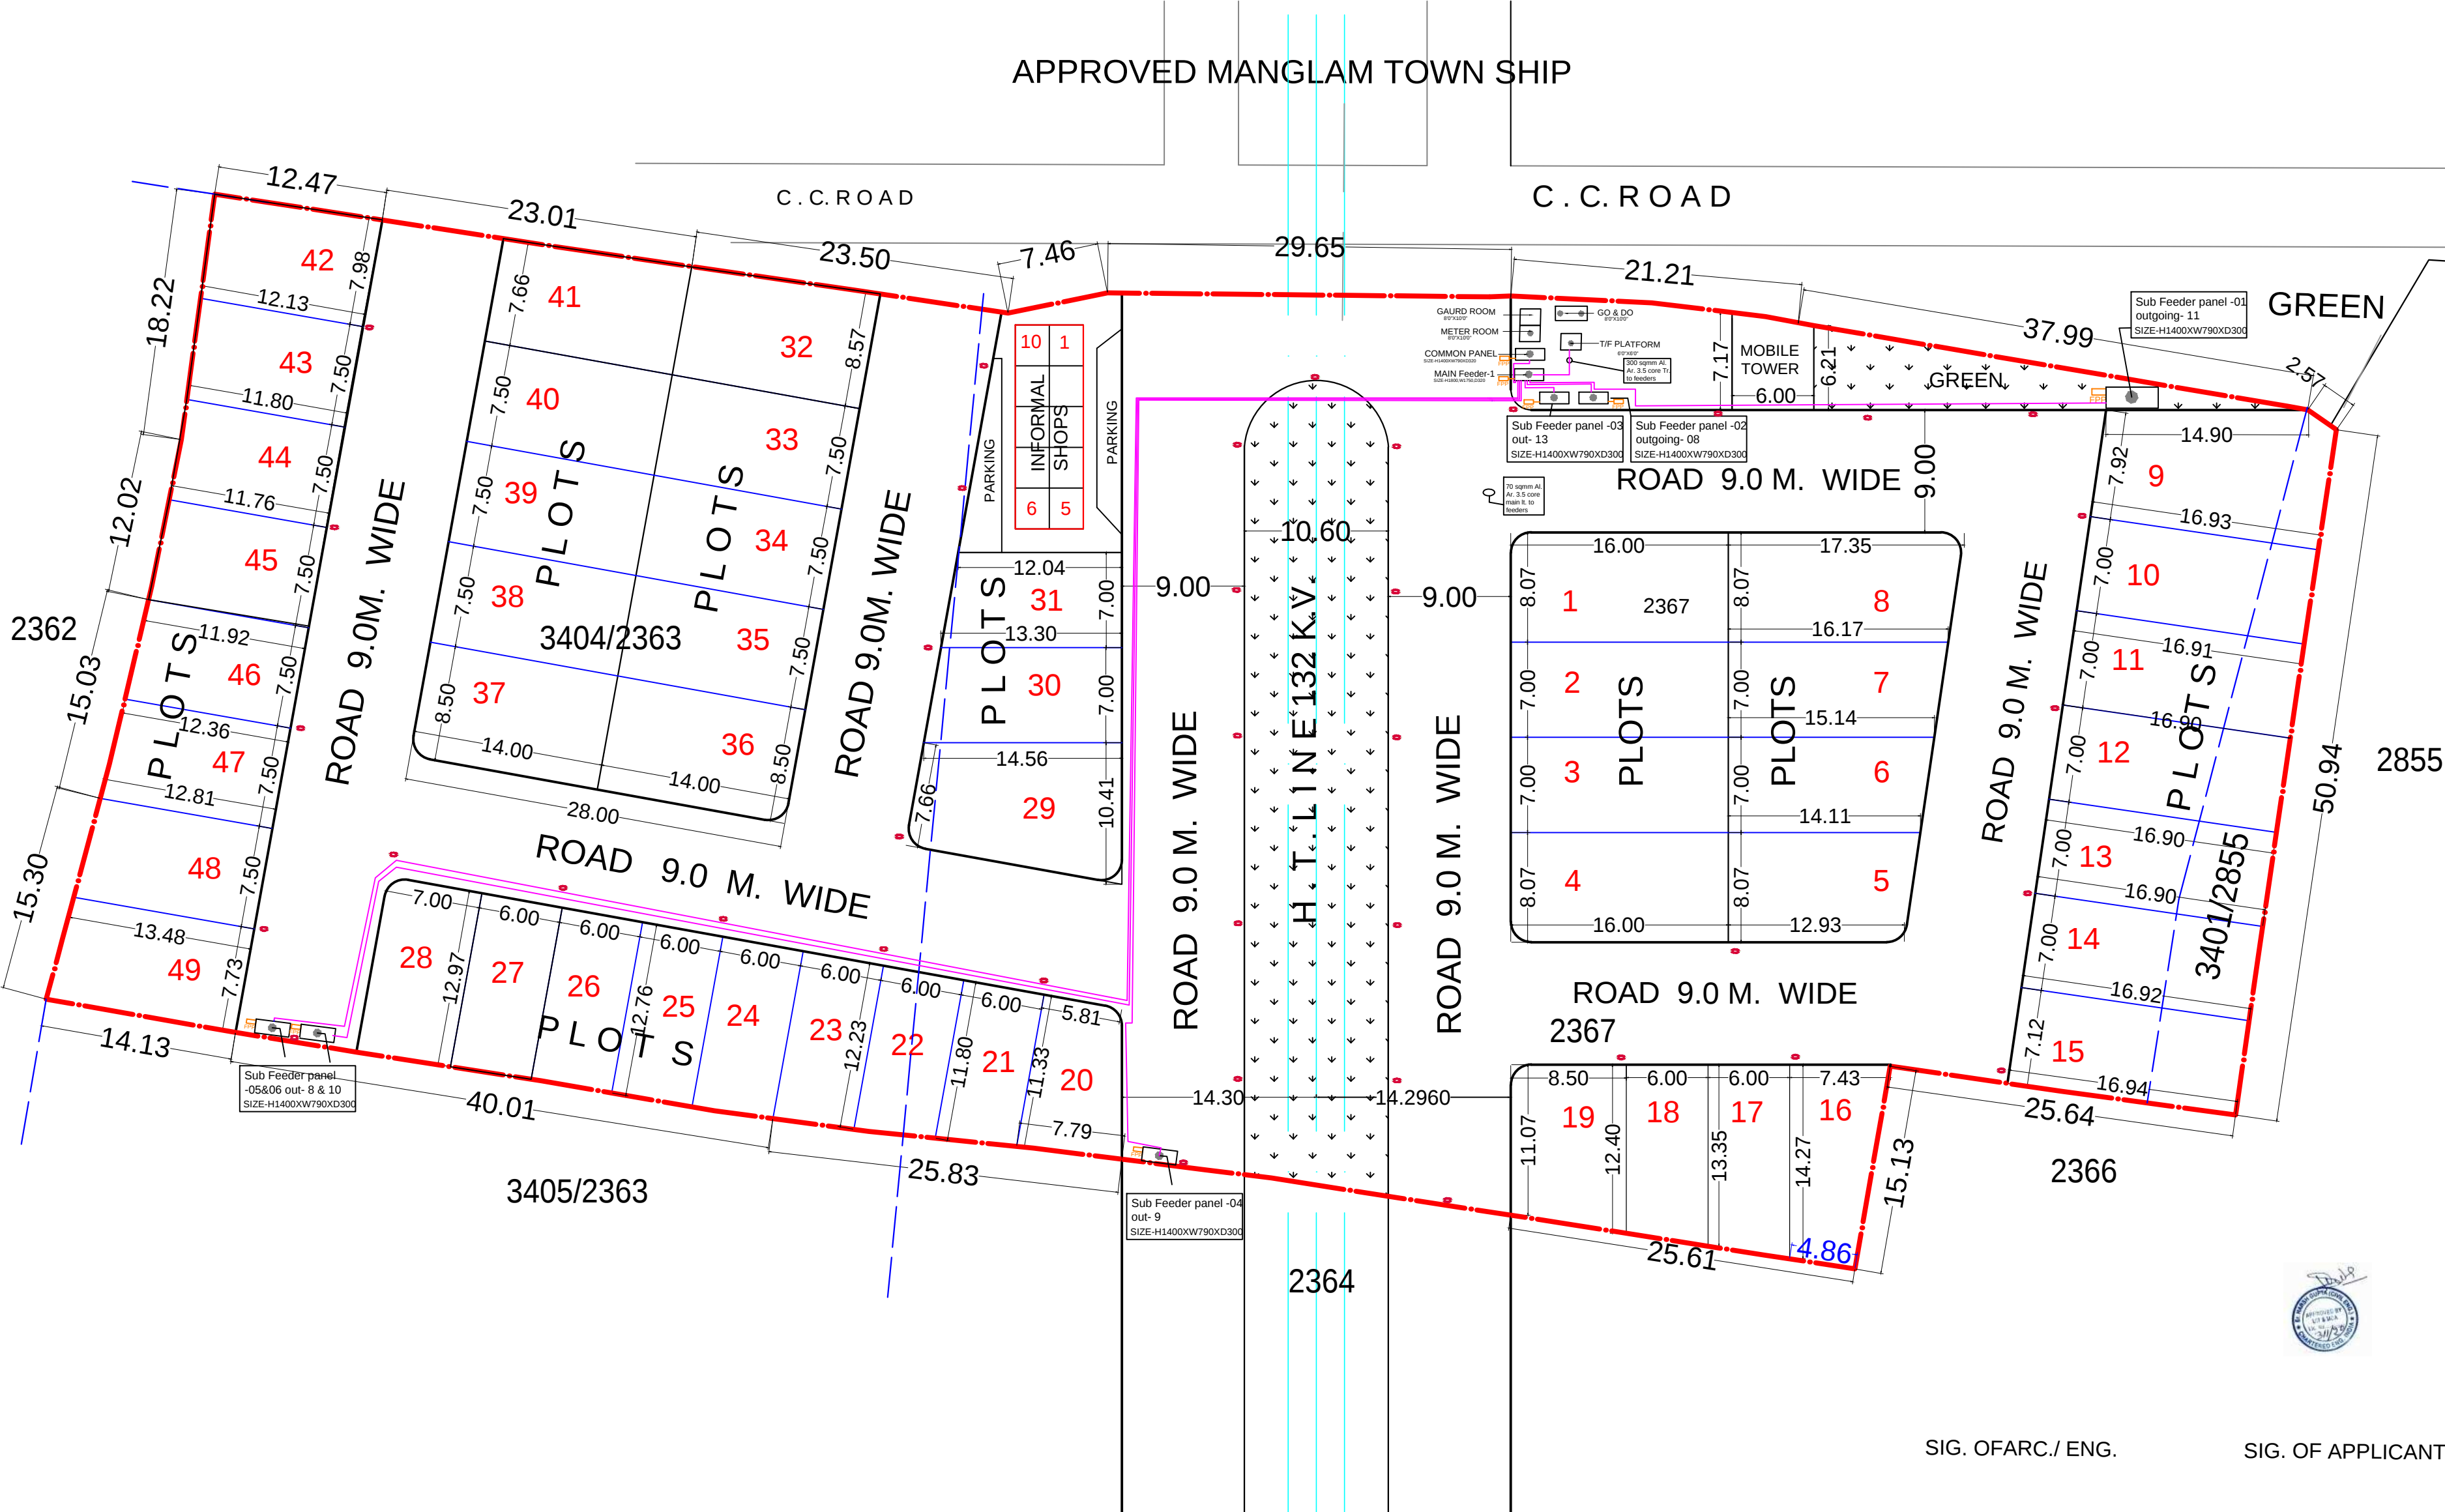

GENERAL NOTES:-
ALL DIMENSIONS ARE IN MILLIMETRES AND ARE UNFINISHED DIMENSIONS UNLESS OTHERWISE SPECIFIED.
ALL OPENING DIMENSIONS TO BE CHECKED AND VERIFIED AT SITE BEFORE FABRICATION OF CASEMENTS.
ALL LEVELS ARE IN MILLIMETRES AND ARE FINISHED LEVELS OTHER THAN WHAT IS MENTIONED FOR OPEN TERRACES.
DO NOT SCALE DRAWINGS. ONLY WRITTEN DIMENSIONS SHALL BE FOLLOWED. ANY DISCREPANCIES NOTED SHALL BE BROUGHT TO THE NOTICE OF THE ARCHITECT PRIOR TO EXECUTION.
FOR DETAILS SUCH AS DOORS, WINDOWS, GRILLS, GATES, SKYLIGHT, TOILETS, STAIRCASES, HANDRAILS, RAILING, ETC. REFER RESPECTIVE ARCHITECTURAL DRAWINGS.
THESE DRAWINGS SHALL BE CORRELATED AND READ IN CONJUNCTION WITH RESPECTIVE CONSULTANT'S APPROVED DRAWINGS FOR STRUCTURAL MEMBERS, SERVICES SUCH AS PLUMBING, SANITARY/ELECTRICAL/AIR-CONDITIONING, VENTILATION, RAINWATER DRAINAGE & WATERPROOFING AND LANDSCAPING. ANY DISCREPANCIES NOTED SHALL BE BROUGHT TO THE NOTICE OF THE ARCHITECT PRIOR TO EXECUTION.
ALL OPEN/EXPOSED TERRACE ROOF SLABS TO HAVE WATERPROOFING AND INSULATION TREATMENT AS PER SPECIFICATIONS.

ON'S	SYMBOL	DESCRIPTION	QTY
1		SINGLE 1X24W STREET LIGHT	40 NOS.
2		FEEDER PILLAR-IP65	08 NOS.

R0	FOR APPROVAL	29.08.24	SADDAM
REV.NO.	DESCRIPTION	DATE	SIGN

REVISIONS			
MANGLAM TOWN SHIP			

RESIDENTIAL TOWNSHIP

ELECTRICAL LAYOUT

DESIGN CONSULTANTS
M/S STARMAX SOLUTIONS, ALWAR

APPROVAL					
DRAWN SADDAM	DESIGN SAKEEL	DATE 29.08.24	SCALE NTS	PROJ.NO R0	

SIG. OFARC./ ENG.

SIG. OF APPLICANT