

| | | |
|---|---------------------------------|----------|
| ① | RAIN WATER PIPE | — |
| ② | WEST WATER PIPE | — |
| ③ | SOIL WATER PIPE | — |
| ④ | INSPECTION CHAMBER / GULLY TRAP | 2' DEPTH |
| ⑤ | MAN HOLE | 2' DEPTH |
| ⑥ | ELECTRICAL PIPELINE | — |

| LEGENDS | | |
|---------|--------|---------------------------|
| S.N.O. | SYMBOL | DESCRIPTION |
| 1 | — | SDR-11 Fresh Water Pipe |
| 2 | — | SDR-11 Solar Water Pipe |
| 3 | — | Waste Water Pipe (W.P.) |
| 4 | — | Soil Pipe (S.P.) |
| 5 | — | Rain Water Pipe (R.W.P.) |
| 6 | ⊗ | Butter Fly Valve (B.F.V.) |
| 7 | ⊕ | Geyser |
| 8 | ⊖ | RO |
| 9 | ⊕ | Single Lever Diverter |
| 10 | ⊖ | Concealed Valve |
| 11 | ⊕ | Angle Valve |
| 12 | ⊖ | Nahani Trap |
| 13 | ⊕ | P-Trap |
| 14 | ⊖ | Tap |
| 15 | ⊕ | Floor Drain (F.D.) |
| 16 | ⊖ | Plain Tee (P-tee) |
| 17 | ⊕ | Gully Trap (G.T.) |

WARNING
 1. This drawing is the sole copyright of Architects VISTAAR and should be used for the purpose expressly issued.

GENERAL NOTES
 1. All dimensions are in feet and inches.
 2. Do not scale this drawing follow written dimensions only.
 3. This drawing should be read in conjunction with other architectural and structural drawings.
 4. Any discrepancy in the drawing should be immediately brought to the notice of architect.


PROJECT TITLE
 SHREEI RESIDENCY BUILDING AT PLOT-1, 1A & 1B. SCHEME GREEN VILLAS, VILL. NANKDISHOREPURA URF, MANYAWAS, JAIPUR

DRAWING TITLE
 SANITATION (STORM WATER DRAINAGE, SEWERAGE (S.P.) SOLID WATER DISPOSAL) AND RAIN WATER HARVESTING PLAN

DESIGNER
 VISTAAR ARCHITECTS & PLANNERS
 Architects - Interior Designers
 30/21, Chandra shikara, near Gandhi Park, DDA mall of Jaipur, Jaipur
 Ph: 0141-4116401, 09909101099

Krishna
KRISHNA KUMAR
 B. Tech. (Mechanical)
 M.E.P. Consultant

For R K DEVELOPERS
 Partner

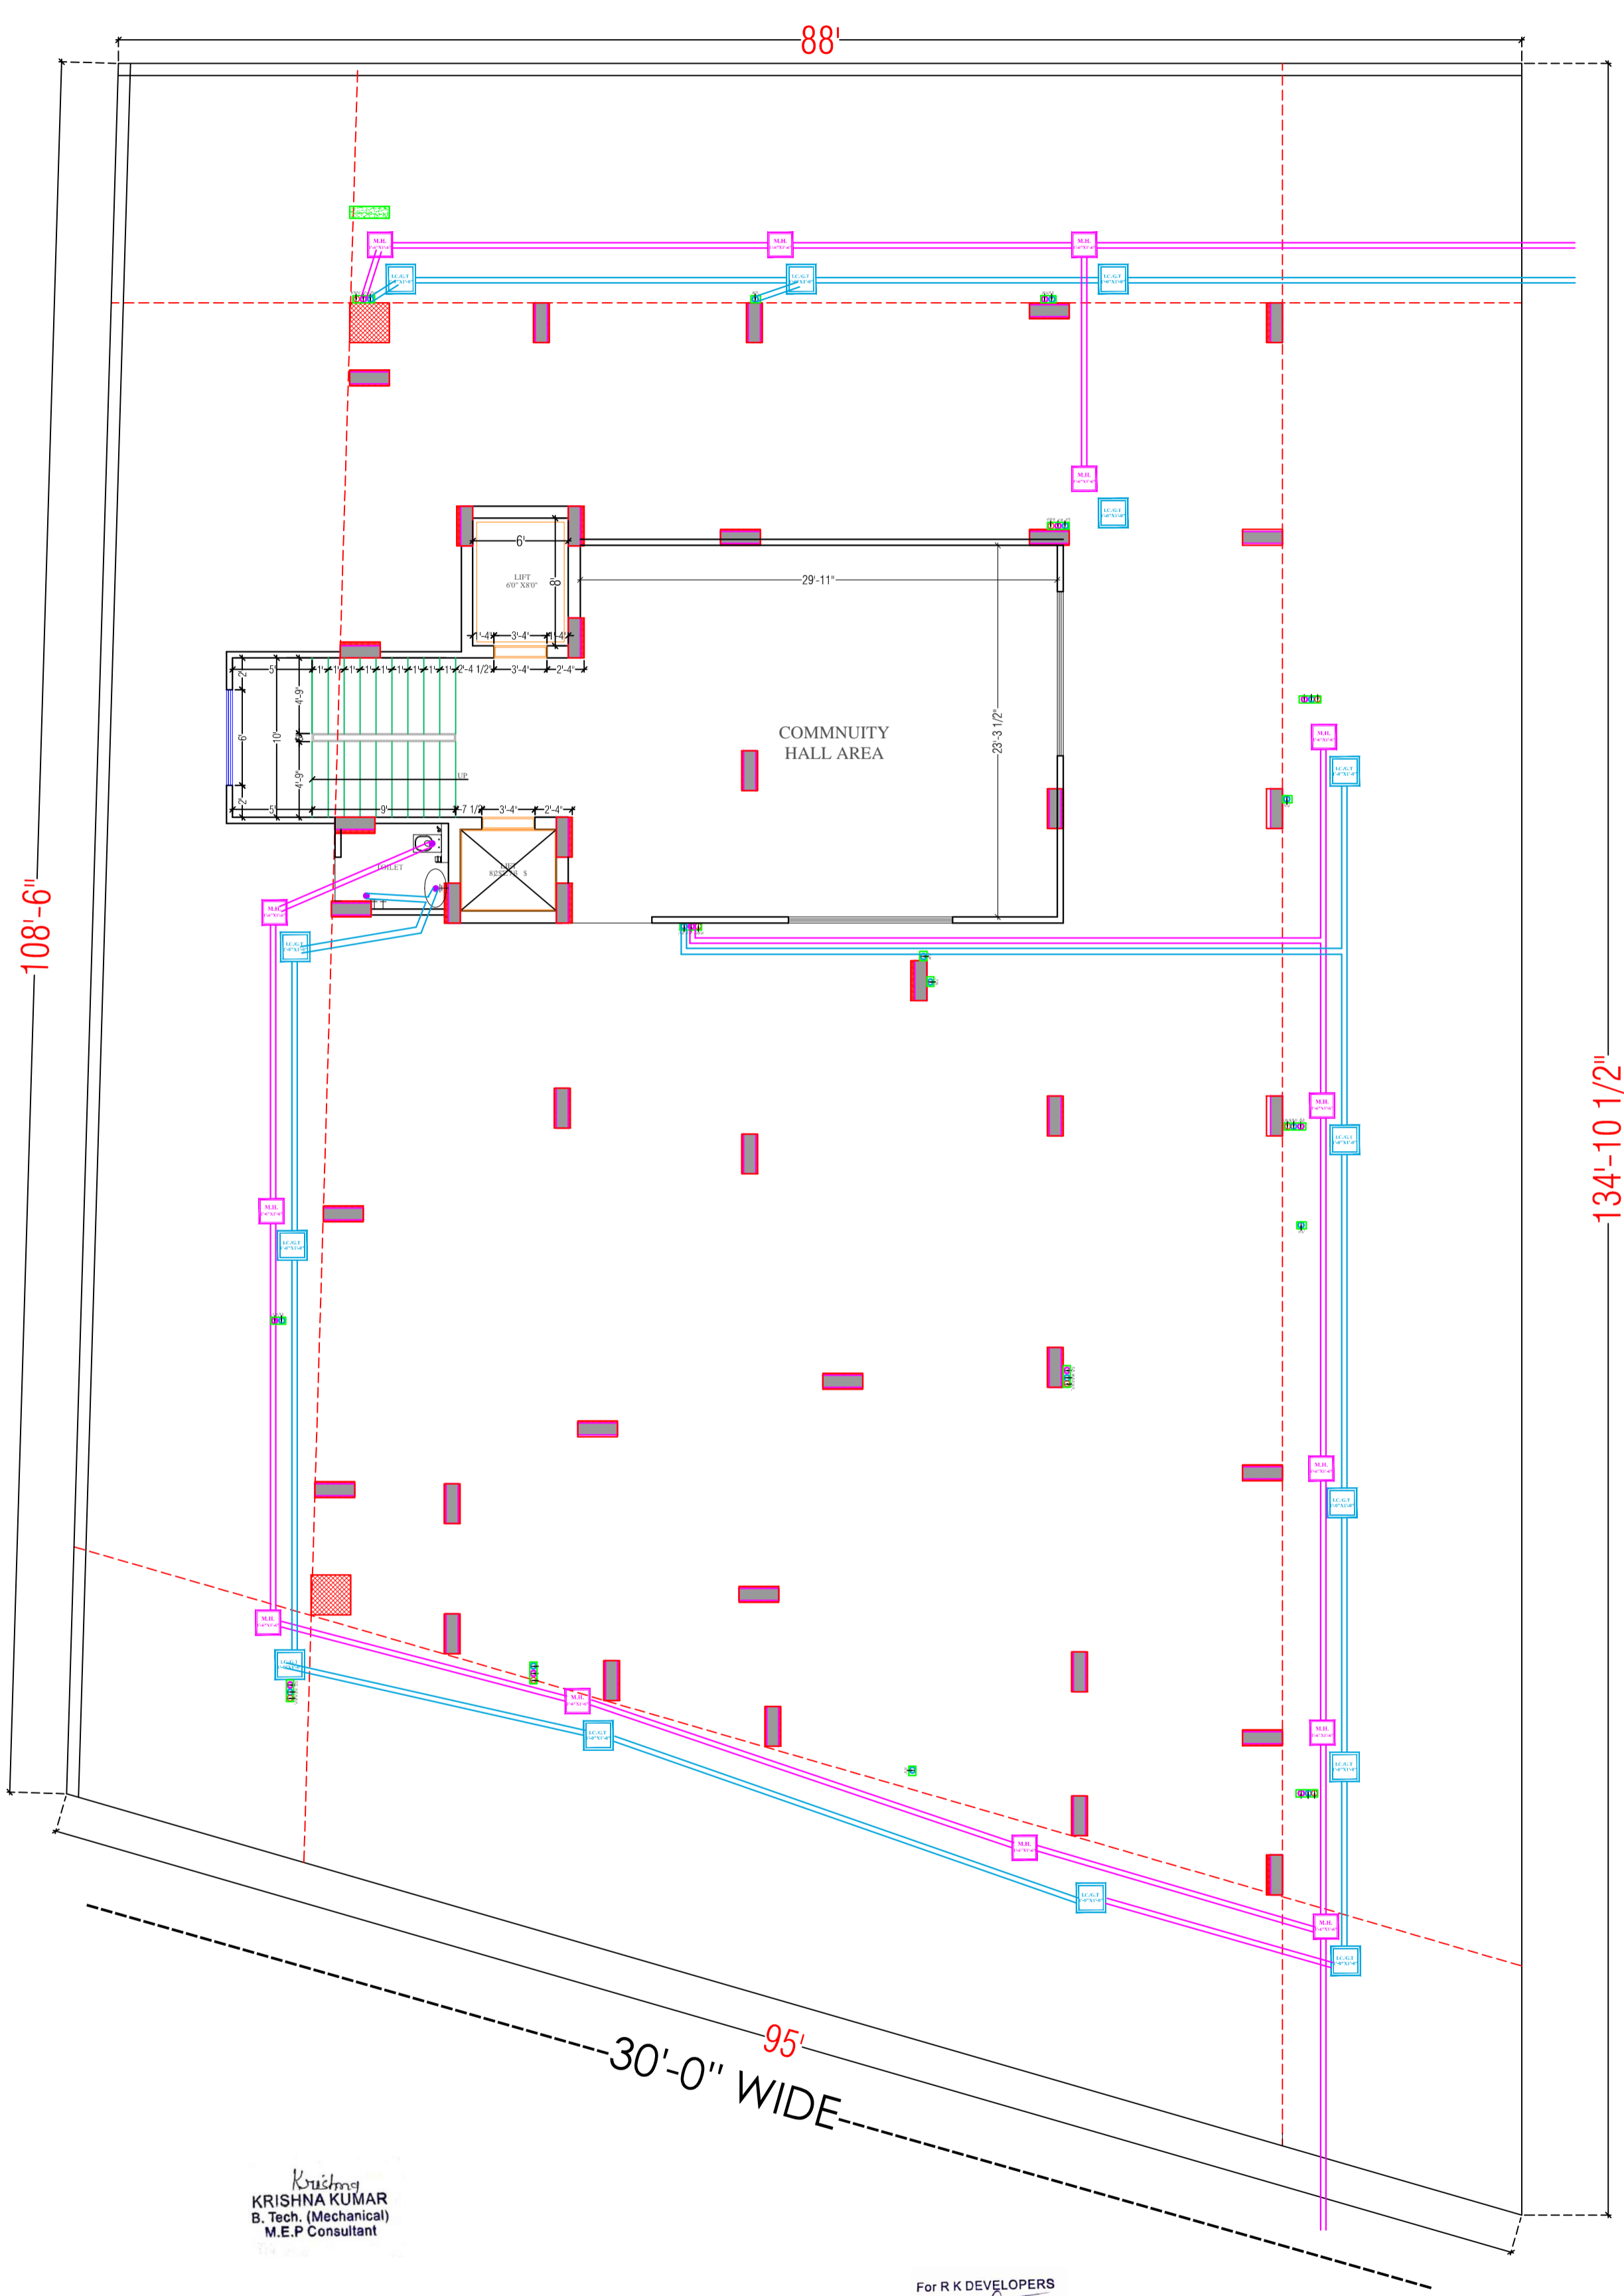

| | | |
|---|---------------------------------|-----------|
| ① | RAIN WATER PIPE | |
| ② | WEST WATER PIPE | |
| ③ | SOIL WATER PIPE | |
| ④ | INSPECTION CHAMBER / GULLY TRAP | 28" DEPTH |
| ⑤ | MAN HOLE | 28" DEPTH |
| ⑥ | ELECTRICAL PIPELINE | |

| LEGENDS | | |
|---------|--------|--------------------------|
| S.NO. | SYMBOL | DESCRIPTION |
| 1. | | SDR-11 Fresh Water Pipe |
| 2. | | SDR-11 Solar Water Pipe |
| 3. | | Waste Water Pipe (W.P.) |
| 4. | | Soil Pipe (S.P.) |
| 5. | | Rain Water Pipe (R.W.P.) |
| 6. | | Butter Fly Valve(B.F.V.) |
| 7. | | Geyser |
| 8. | | RO |
| 9. | | Single Lever Diverter |
| 10. | | Concealed Valve |
| 11. | | Angle Valve |
| 12. | | Nahani Trap |
| 13. | | P-Trap |
| 14. | | Tap |
| 15. | | Floor Drain (F.D.) |
| 16. | | Plain Tee (P-tee) |
| 17. | | Gully Trap (G.T.) |
| 18. | | |

WARNING
 1. This drawing is the sole copyright of Architects VISTAAR and should be used for the purpose expressly issued.

GENERAL NOTES
 1. All dimensions are in feet and inches.
 2. Do not scale this drawing follow written dimensions only.
 3. This drawing should be read in conjunction with other architectural and structural drawings.
 4. Any discrepancy in the drawing should be immediately brought to the notice of architect.

PROJECT TITLE
 SHREEJI RESIDENDY
 BUILDING AT PLOT-1, 1A & 1B,
 SCHEME GREEN
 VILLAS, VILL NANKISHOREPURA URF,
 MANYAWAS, JAIPUR

DRAWING TITLE
 STILT DRAINAGE PLAN

PREPARED BY
VISTAAR ARCHITECTS & PLANNERS
 Architects :: Interior Designers
 B-2/12, Chitrkoot scheme,
 main Gandhi Path, Opp. mall of Jaipur, Jaipur
 PH- 0141-4116461, 03001010366

| NO. | DATE | REV. | REVISION |
|-----|------------|------|----------|
| 001 | 24-06-2024 | | |
| 002 | | | |
| 003 | | | |

Krishna
KRISHNA KUMAR
 B. Tech. (Mechanical)
 M.E.P Consultant

For R K DEVELOPERS
R K
 Partner