


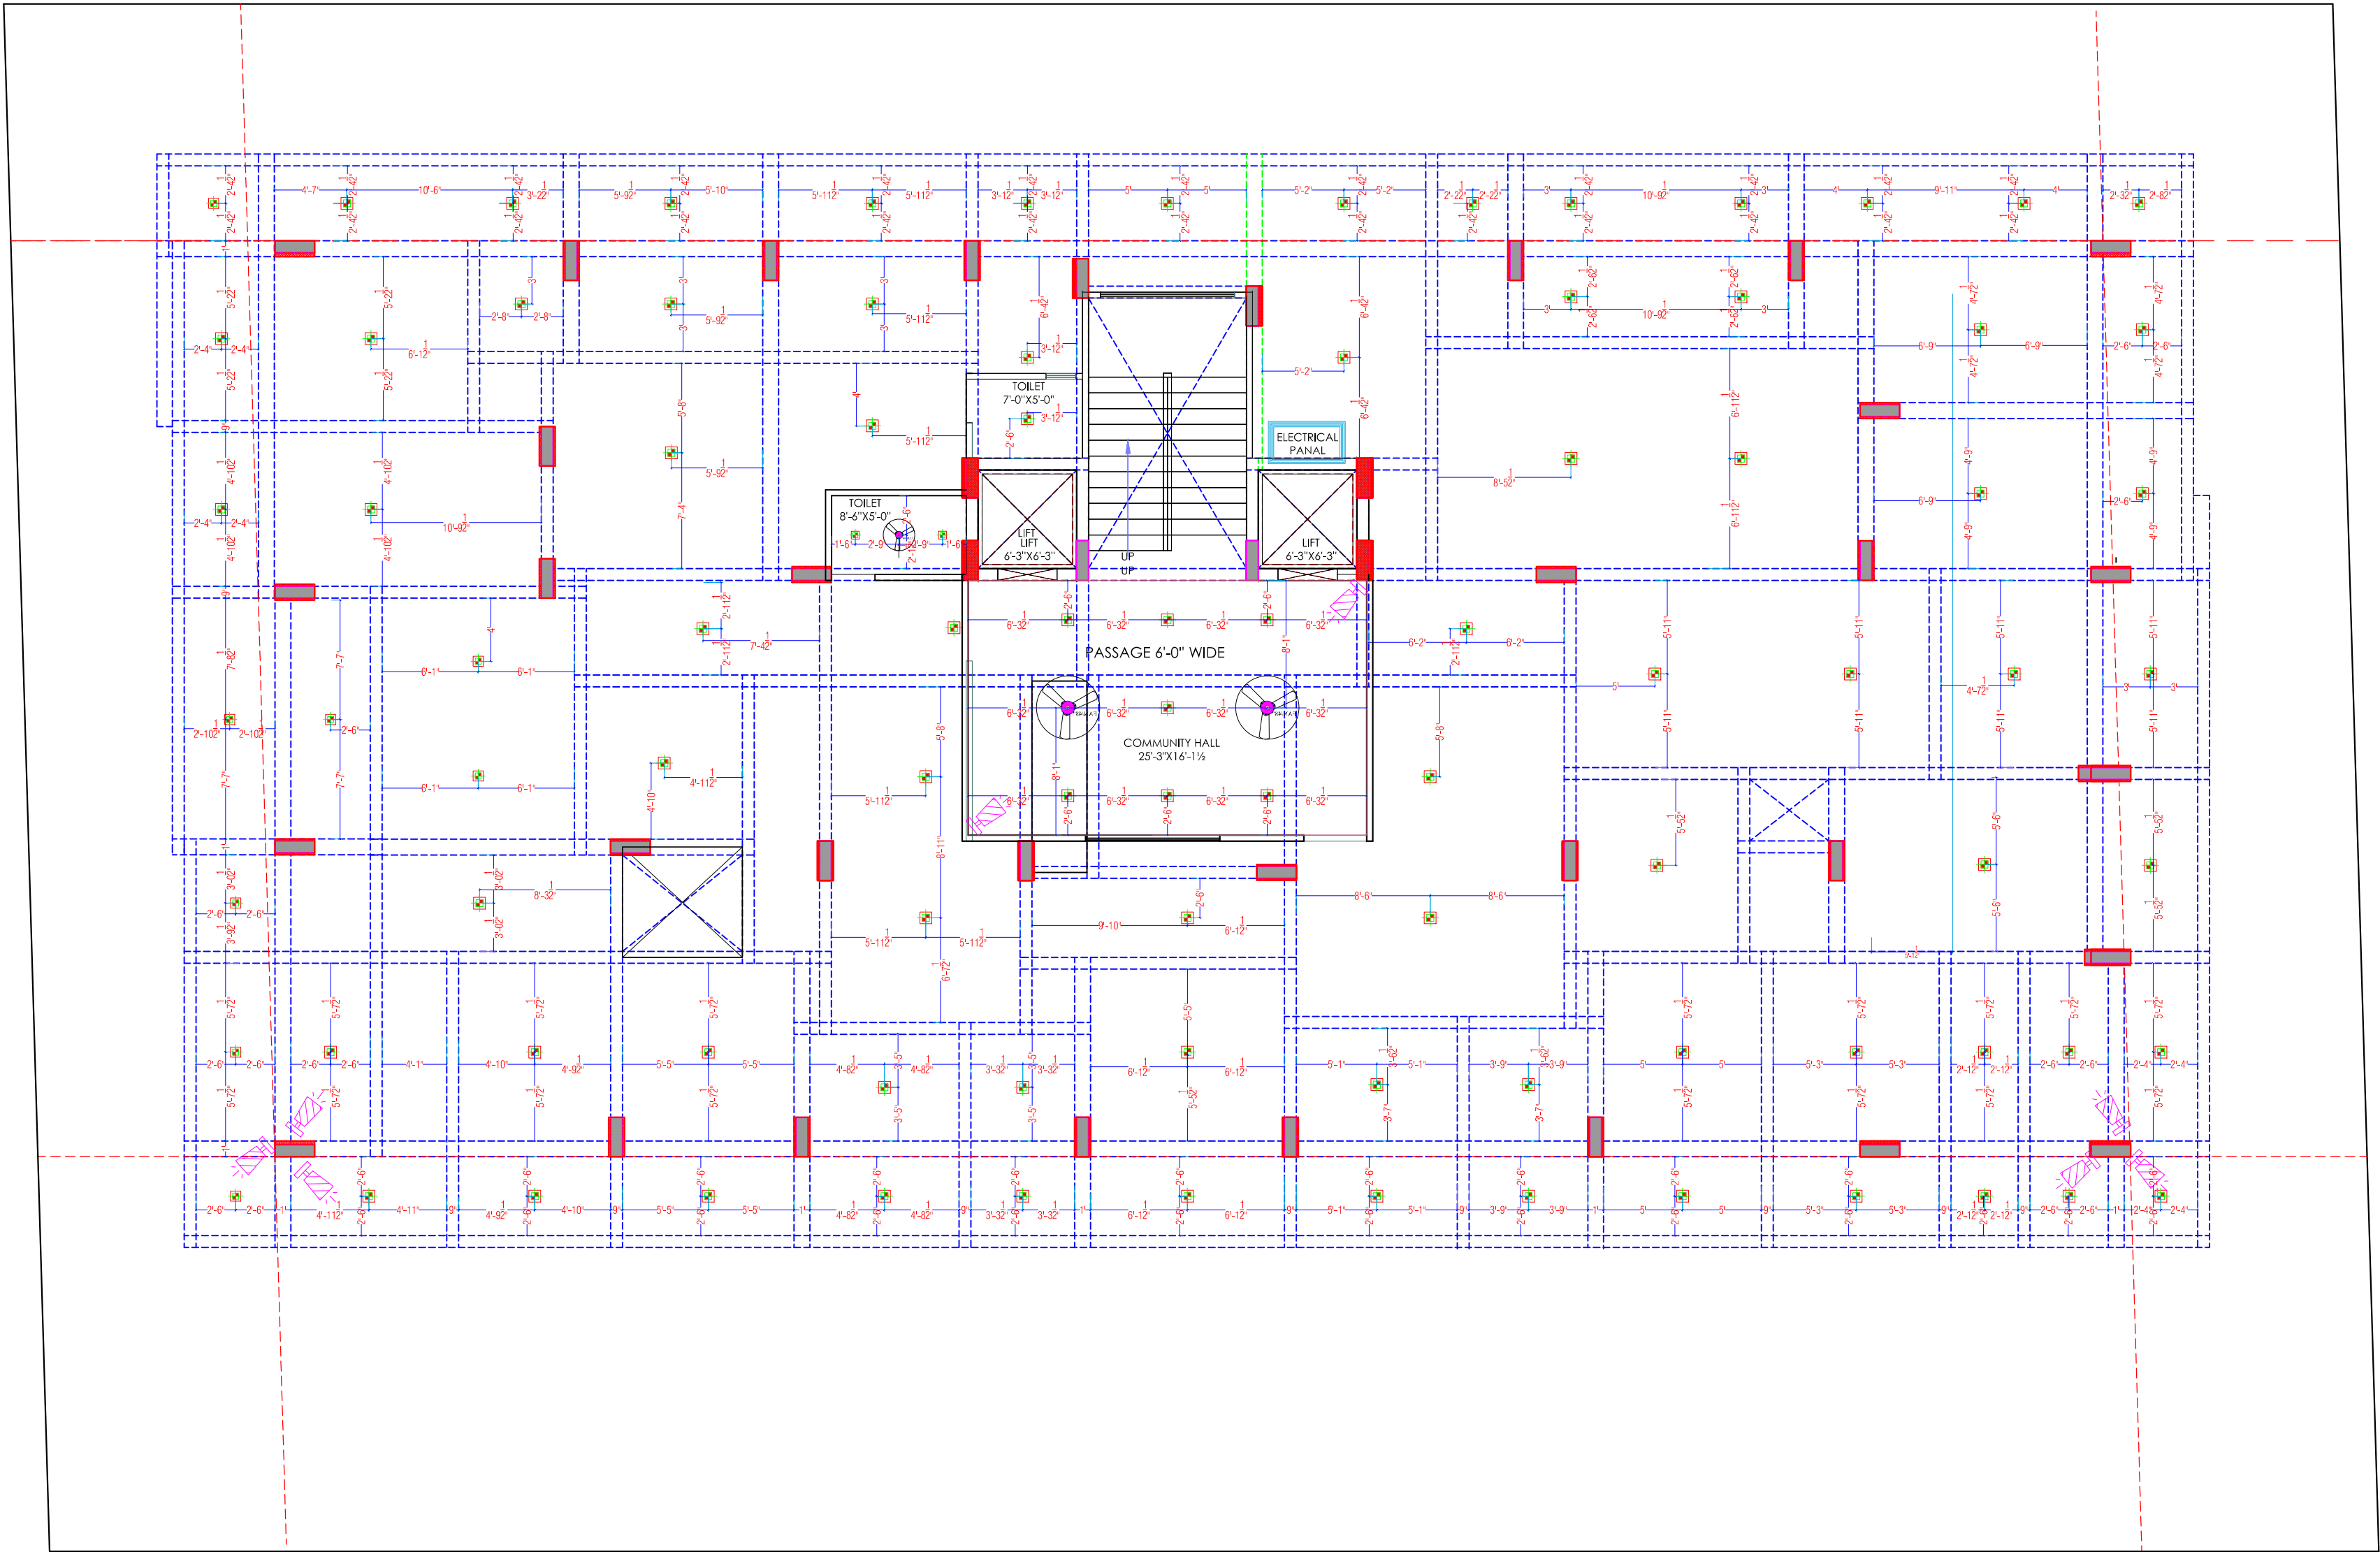

LEGENDS:				
Mounting Height	No.	I D	Symbol	Description
IN FLOOR				CONTROL WIRING
IN CONDUIT				CONTROL WIRING
IN CONDUIT				AC CONTROL WIRING
IN CONDUIT				OTHER CONTROL WIRING
IN CONDUIT				BULZER CONTROL WIRING
CEILING	08	FAN-45"		CEILING FAN 45"
CEILING	02	FAN-30"		CEILING FAN 30"
+90"	04	TL		DOWN WALL TUBELIGHT
+90"	04	BULB		WALL BRACKETS AS DESIGN LIGHT
+90"	01	GL		WALL BRACKETS AS DESIGN FOR GLOSSY LIGHT
02	GL			WALL BRACKETS AS DESIGN FOR GLOSSY LIGHT
CEILING	21	CFL		CFL CEILING LIGHT
+21"	02	FL		FOOT LIGHT
+40"	14	SB		SWITCH BOARD
+70"	03	ML		1 X 11 W CFL MIRROR LIGHT
VENTILATOR HT.	03	CR		CEILING ROSE
VENTILATOR HT.	01	EXP		30 DIA FRESH AIR FAN
+24"	02	TEL		TELEPHONE POINT
+27"	03	TV		TV COWAN POINT
+34"	02	LP TEL		5 A PLUG POINT FOR TELEPHONE
+27"	03	LP TV		5 A PLUG POINT FOR TV
+24"	02	LP		5 A PLUG POINT
+72"	01	LP CH		5 A PLUG POINT FOR CHIMNEY
+102"	03	SAC		SPLIT AC
+102"	03	PP-SAC		25 A POWER POINT FOR SPLIT AC
+42"	01	PP-MIX		75 A POWER POINT FOR MIXER
+70"	02	PP-G		15 A POWER POINT FOR GEYSER
+54"	01	PP-F		5 A POWER POINT FOR FRIDGE
+78"	01	PP-WF		5 A POWER POINT FOR WATER PURIFIER
+48"	01	PP-WM		5 A POWER POINT FOR WASHING MACHINE
+42"	02	BP		BELL PUSH SWITCH
+90"	01	BZ		BELL POINT
+24"	03	AC		AC STARTER
+40"	01	MCB DB		MCB DISTRIBUTION BOARD
03				SWITCH BOARD NO.1 LIGHT CIRCUIT NO.
03				AC CIRCUIT NO.
05				POWER CIRCUIT NO.

WARNING

1. This drawing is the sole copyright of Architects **VISTAAR** and should be used for the purpose expressly issued.

GENERAL NOTES

1. All dimensions are in feet and inches.
2. Do not scale this drawing follow written dimensions only.
3. This drawing should be read in conjunction with other architectural and structural drawings.
4. Any discrepancy in the drawing should be immediately brought to the notice of architect.

PROJECT TITLE
PROJECT:-
SUNRISE WESTWAY HEIGHTS
BUILDING AT PLOT NO. 32E & 32F, WESTWAY
HEIGHTS (TRUCK
TERMINAL), VILL. KESHOPURA, ASARPURA
BHANKROTA, JAIPUR


DRAWING TITLE
STILT FLOOR CEILING ELECTRICAL
PLAN

ARCHITECTS :
VISTAAR ARCHITECTS & PLANNERS
Architects :: Interior Designers
B-2/12, Chitrkoot scheme,
main Gandhi Path, Opp mall of jaipur, Jaipur
PH. - 0141-4116461, 09001010366

DRN.	DATE	REV	NORTH
FR.SACHN	16-08-2024		
SCALE	JOB NO.		
NTS			

Krishna
KRISHNA KUMAR
B.Tech. (Mechanical)
M.E.P Consultant

For My Dream House

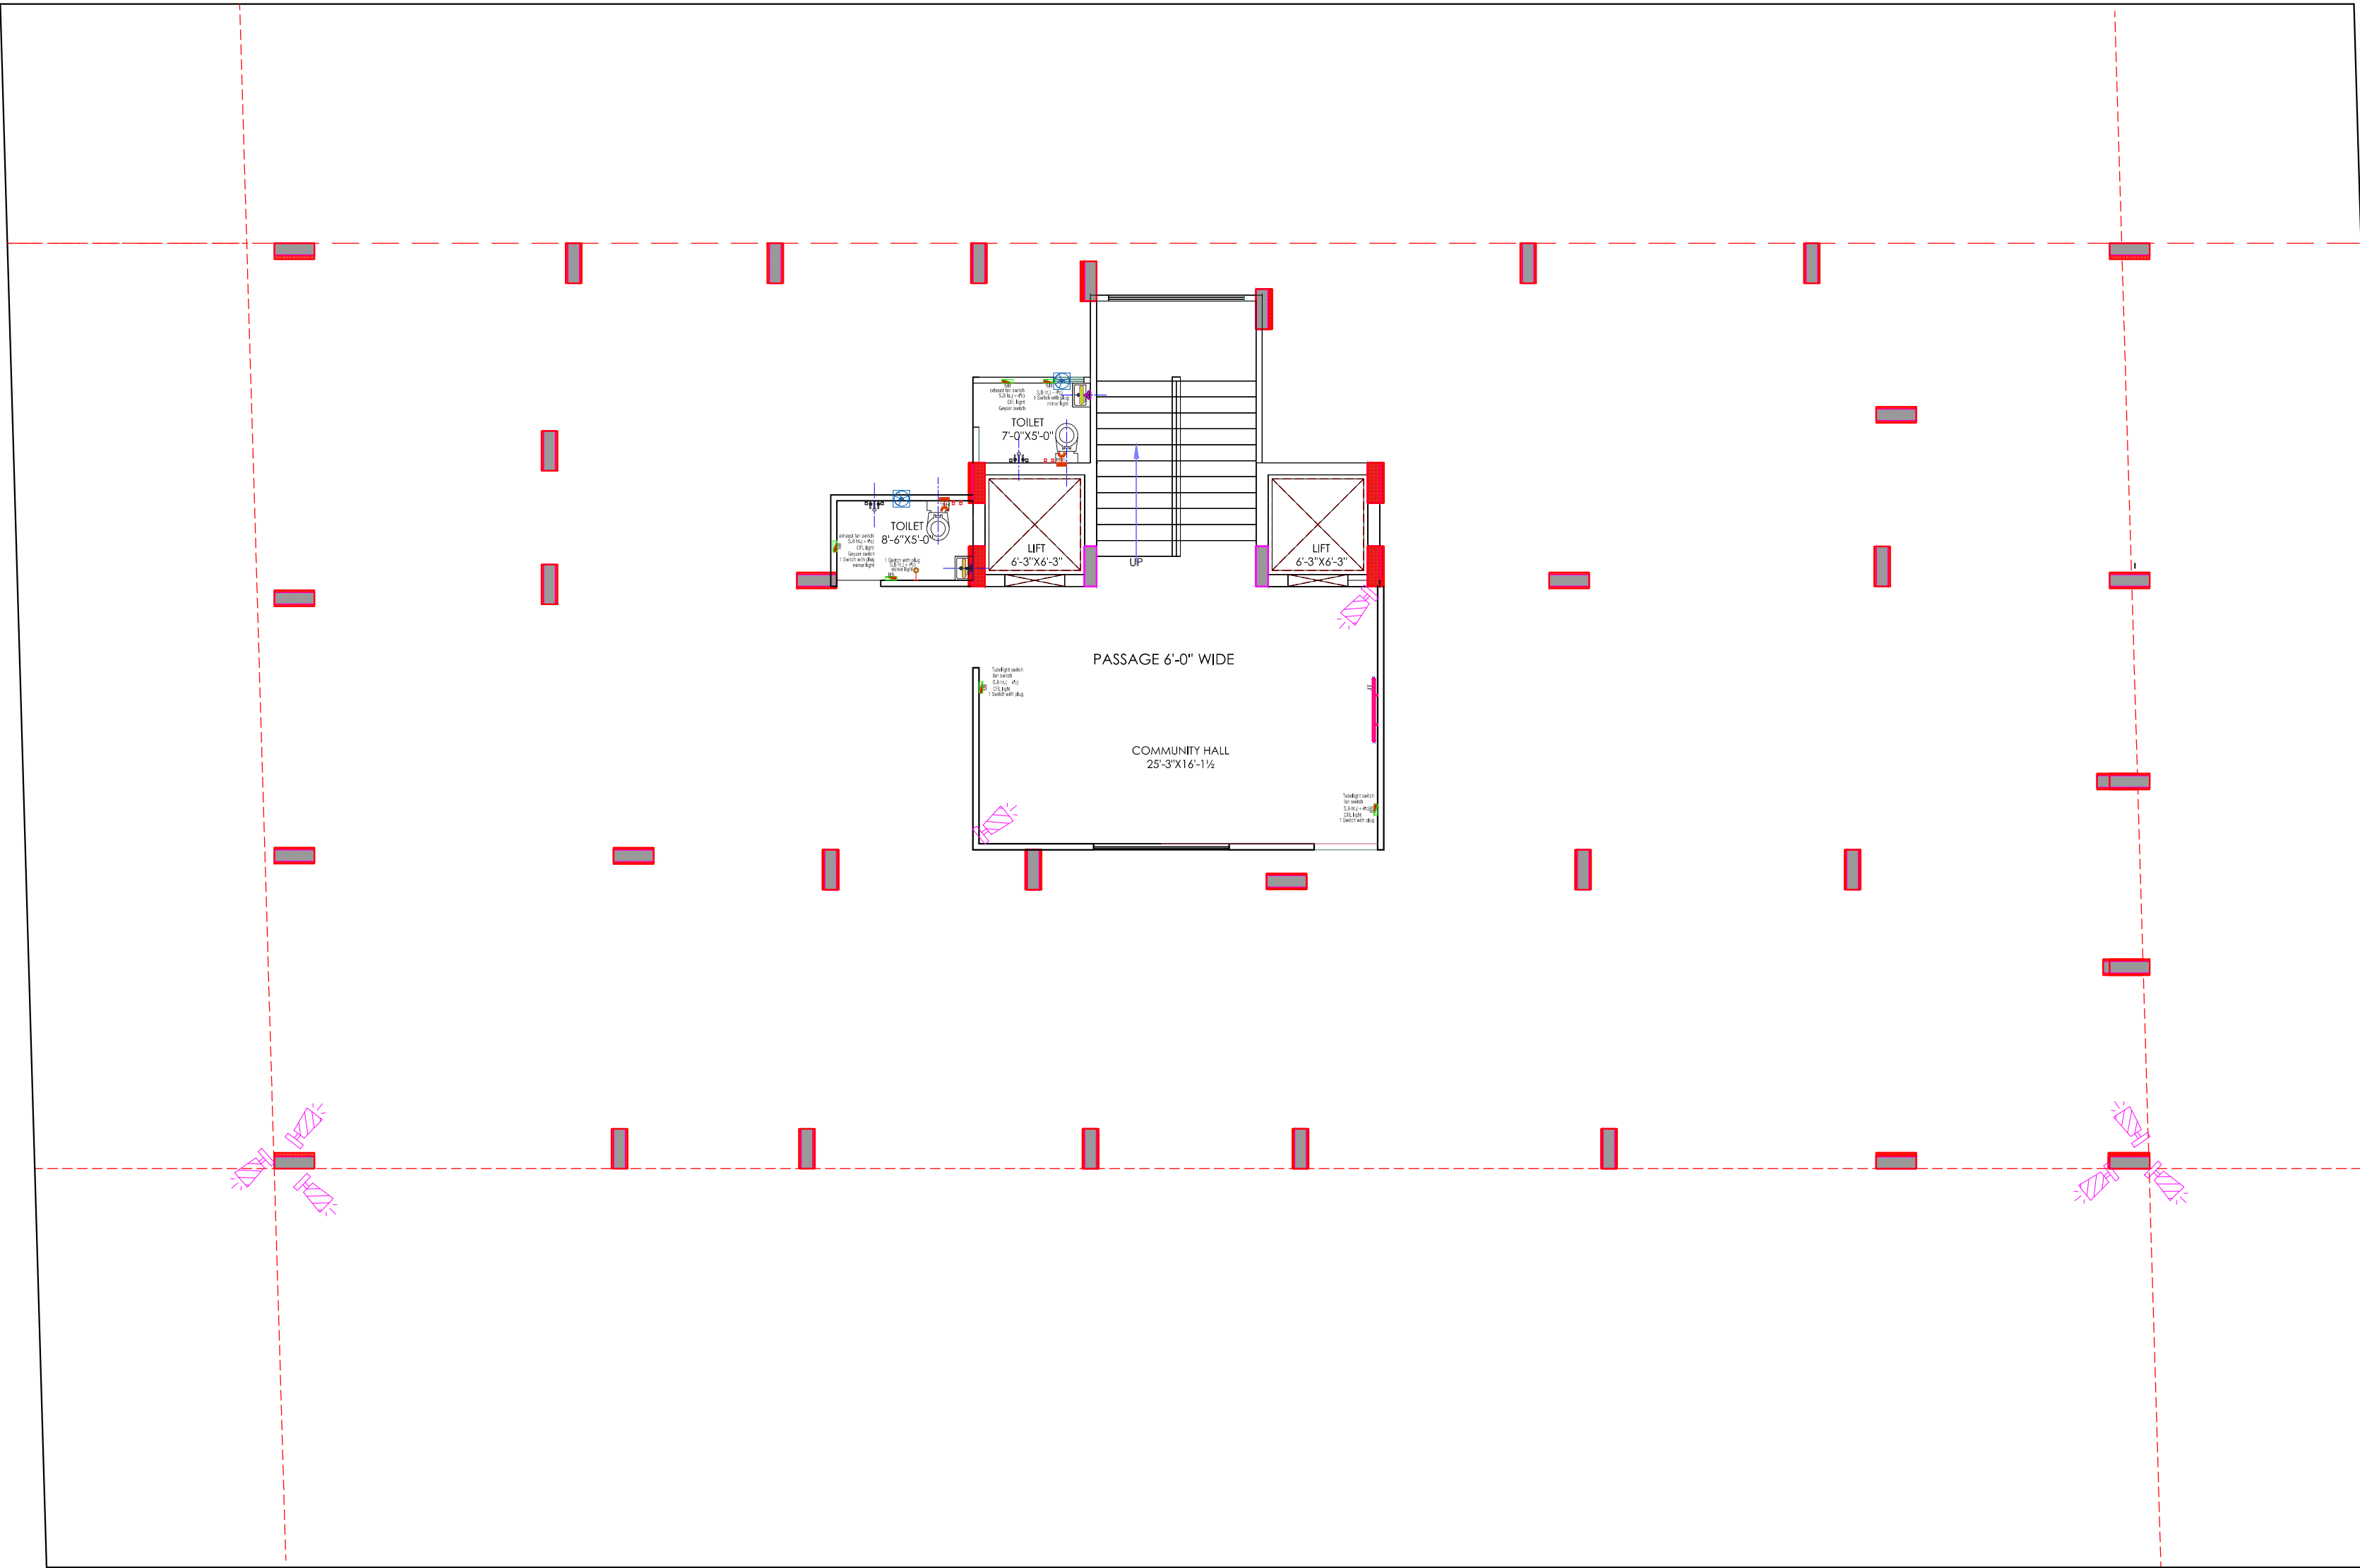

LEGENDS:			
Mounting Height	No.	I.D	Description
IN FLOOR			CONTROL WIRING
IN CONDUIT			CONTROL WIRING
IN CONDUIT			AC CONTROL WIRING
IN CONDUIT			DATA CONTROL WIRING
IN CONDUIT			SLIDER CONTROL WIRING
CEILING	08	FAN-45"	CEILING FAN 45"
CEILING	02	FAN-30"	CEILING FAN 30"
100"	04	TL	DOWN WALL TUBELIGHT
100"	04	BULB	WALL BRACKETS AS DESIGN LIGHT
100"	01	GL	WALL BRACKETS AS DESIGN FOR GROUND LIGHT
02	GL		WALL BRACKETS AS DESIGN FOR GROUND LIGHT
CEILING	21	CFL	CFL CEILING LIGHT
+21"	02	FL	FOOT LIGHT
+40"	14	SB	SWITCH BOARD
+70"	03	ML	1 X 11 W CFL MIRROR LIGHT
VENTILATOR	01	CR	CEILING ROSE
VENTILATOR	01	EXP	30 DIA FRESH AIR FAN
+24"	02	TEL	TELEPHONE POINT
+27"	03	TV	TV COWAN POINT
+24"	02	LP TEL	5 A PLUG POINT FOR TELEPHONE
+24"	02	LP TV	5 A PLUG POINT FOR TV
+24"	02	LP	5 A PLUG POINT
+72"	01	LP CH	5 A PLUG POINT FOR CHIMNEY
+102"	03	SAC	500W AC
+102"	03	PP-SAC	25 A POWER POINT FOR 500W AC
+42"	01	PP-MIX	75 A POWER POINT FOR MIXER
+78"	02	PP-G	15 A POWER POINT FOR GEYSER
+54"	01	PP-F	5 A POWER POINT FOR Fridge
+78"	01	PP-MF	5 A POWER POINT FOR BASKET FREEZER
+48"	01	PP-M	5 A POWER POINT FOR WASHING MACHINE
+42"	02	BP	BELL PUSH SWITCH
+90"	01	BZ	BELL POINT
+24"	03	AC	AC STARTER
+40"	01	MCB DB	MCB DISTRIBUTION BOARD
03		SB 1.1	SWITCH BOARD NO 1 LIGHT CIRCUIT NO.
03		AC 1	AC CIRCUIT NO.
05		PL 1	POWER CIRCUIT NO.

WARNING

1. This drawing is the sole copyright of Architects **VISTAAR** and should be used for the purpose expressly issued.

GENERAL NOTES

- All dimensions are in feet and inches.
- Do not scale this drawing follow written dimensions only.
- This drawing should be read in conjunction with other architectural and structural drawings.
- Any discrepancy in the drawing should be immediately brought to the notice of architect.

PROJECT TITLE
PROJECT:-
SUNRISE WESTWAY HEIGHTS
BUILDING AT PLOT NO.-32E & 32F.WESTWAY HEIGHTS(TRUCK
TERMINAL),VILL.KESHOPURA,ASARPURA ,BHANKROTA,JAIPUR


DRAWING TITLE
STILT FLOOR WALL ELECTRICAL PLAN
SERVICE(SLD)/DISTRIBUTION DETAILS AFTER LT PANEL,EARTHING LAYOUT,EXTERNAL LIGHTING PLAN,LAYOUT,TV & TELEPHONE RISER DIAGRAM,LIGHTING ARRESTER LOCATION & PIT LOCATION,COORDINATION DRAWINGS,FIRE DETECTION & ALARM SYSTEM LAYOUT OF ALL FLOOR)

ARCHITECTS :
VISTAAR ARCHITECTS & PLANNERS
Architects :: Interior Designers
B-2/12, Chitrkoot scheme,
main Gandhi Path,Opp mall of jaipur,Jaipur
PH.- 0141-4116461,09001010366

DRN.	DATE	REV	NORTH
ER.SACHN	16-08-2024		
SCALE	JOB NO.		
NTS			

For My Dream House
Partner

KRISHNA KUMAR
B. Tech. (Mechanical)
M.E.P Consultant

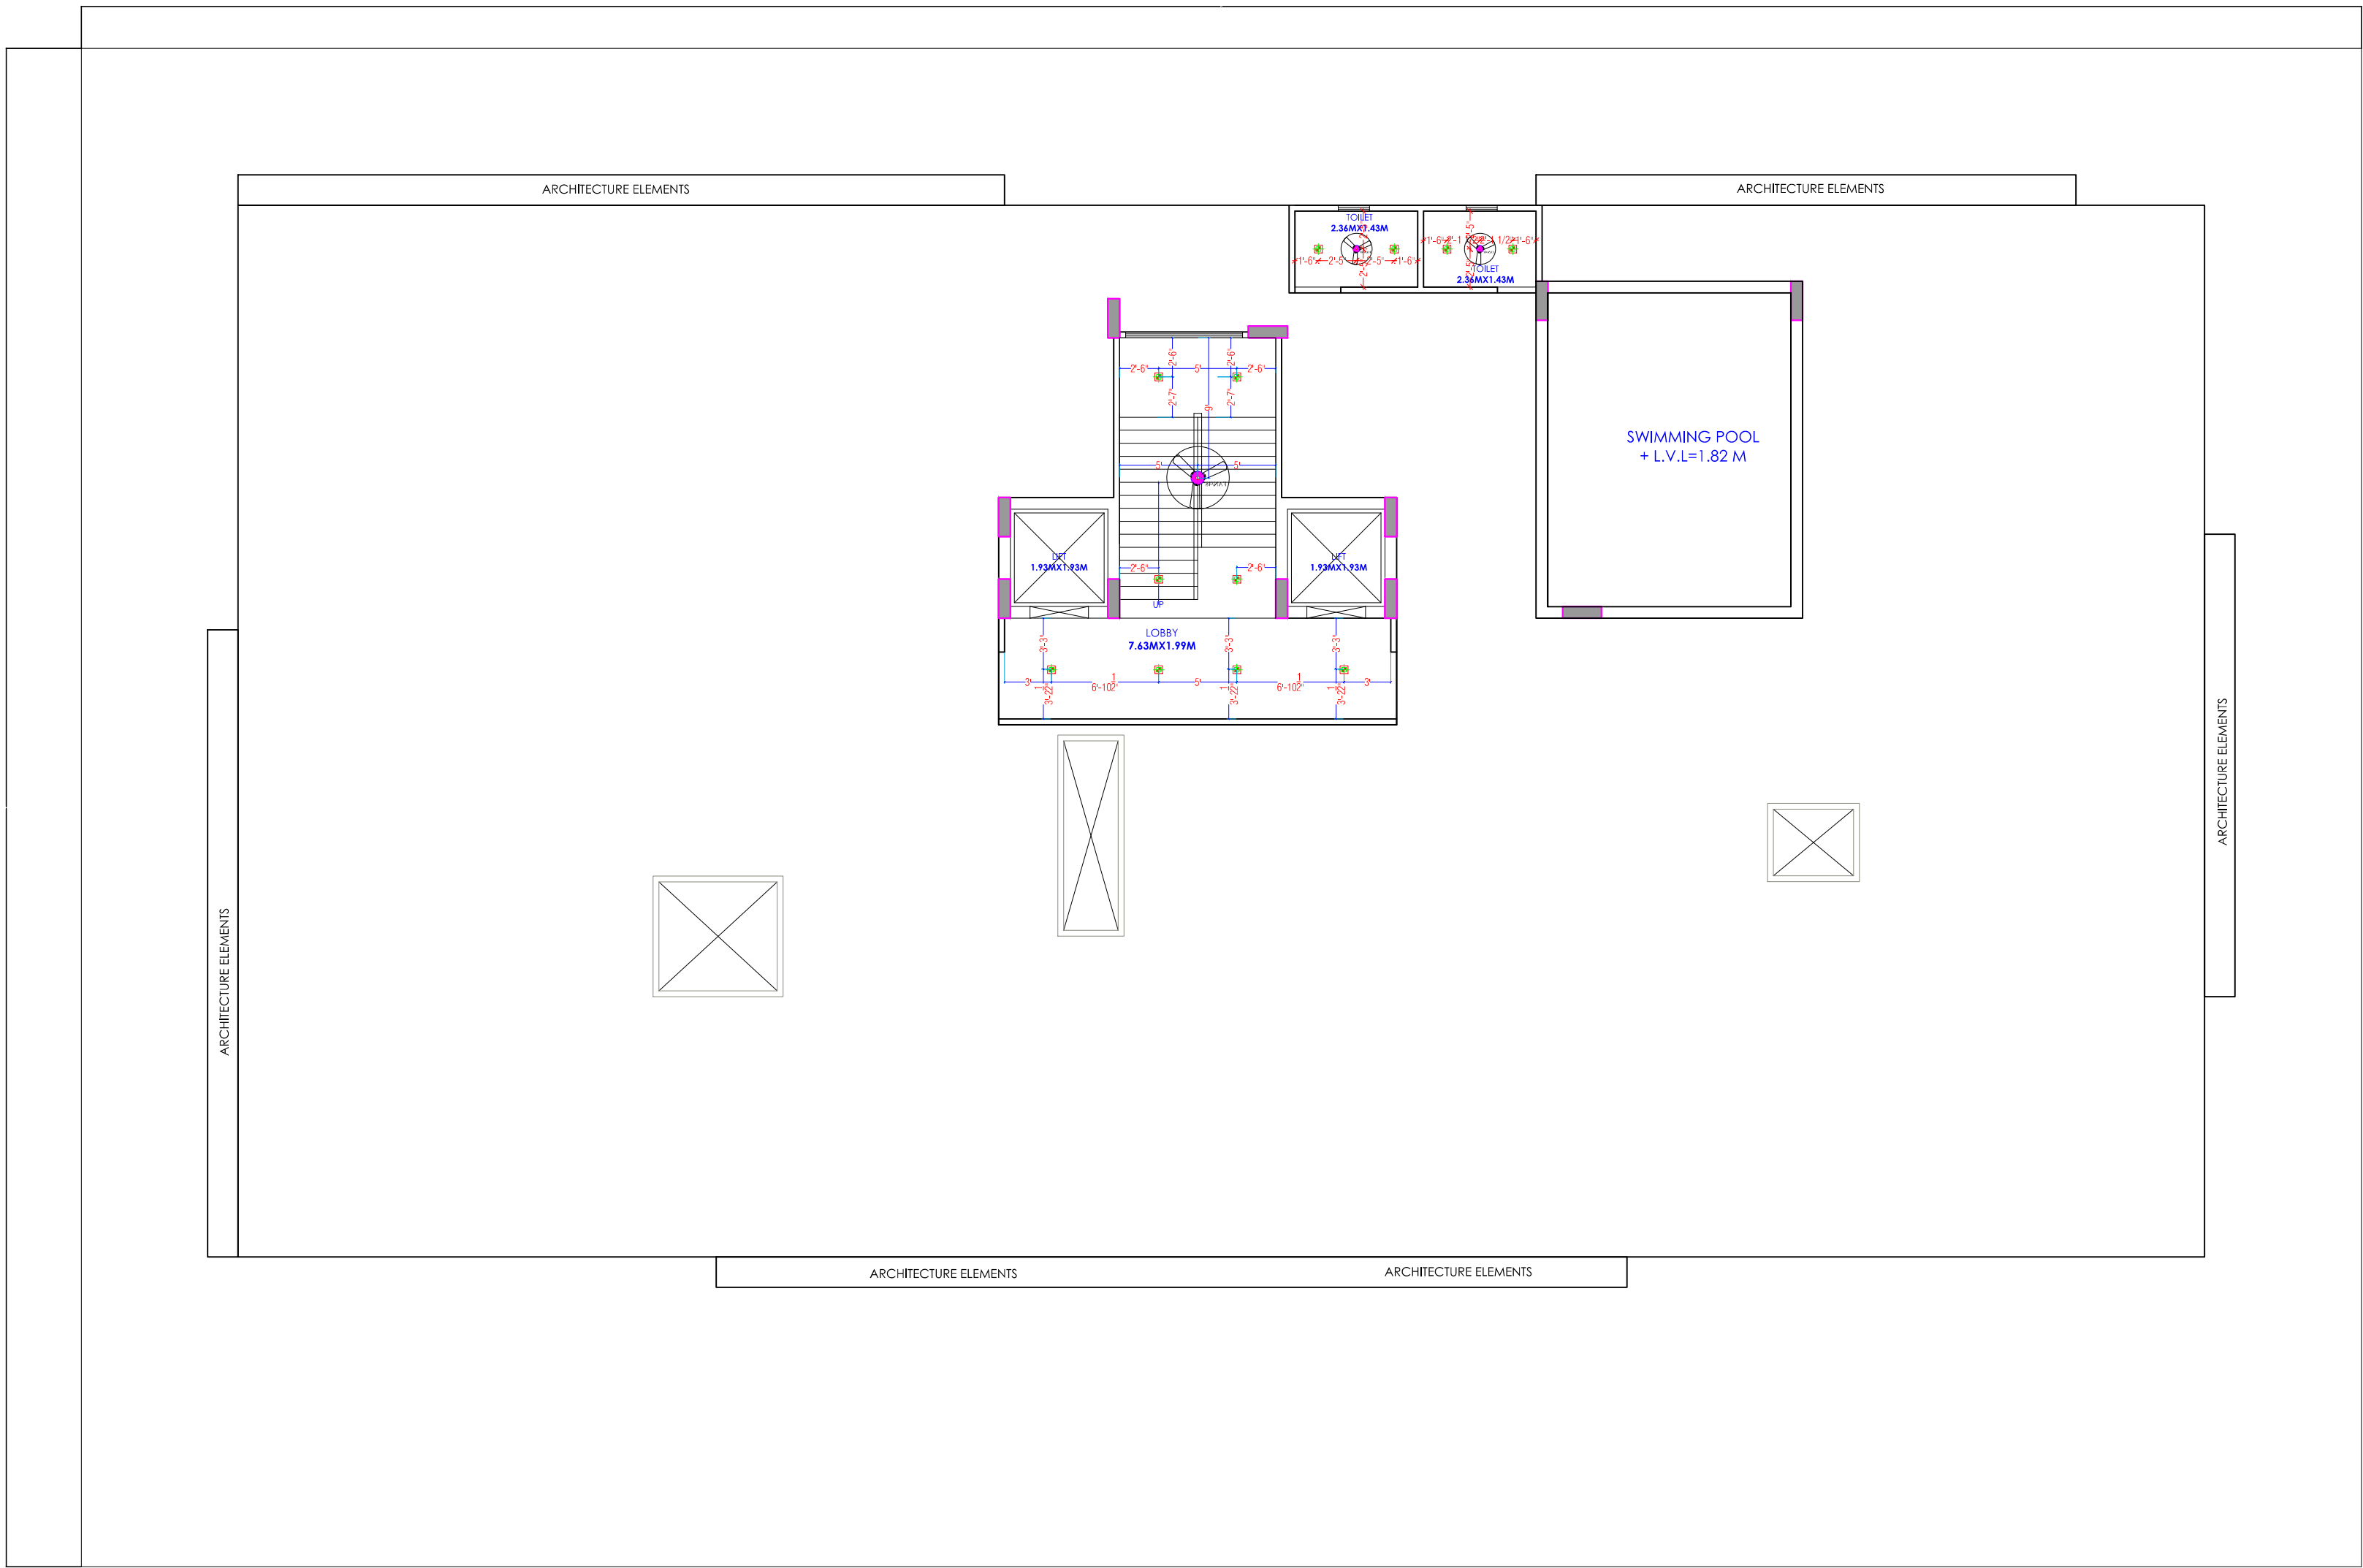

Y
-----ROAD 12 MT.WIDE-----


LEGENDS:			
Mounting Height	No.	Symbol	Description
IN FLOOR			CONTROL WIRING
IN CONDUIT			CONTROL WIRING
IN CONDUIT			AC CONTROL WIRING
IN CONDUIT			OTHER CONTROL WIRING
IN CONDUIT			FLUORESCENT CONTROL WIRING
CEILING	08	FAN/MP	CEILING FAN 40"
CEILING	07	FAN/MP	CEILING FAN 30"
+90"	04	TL	FLUORESCENT WALL LIGHT
+90"	01	GL	WALL BRACKETS AS DESIGN FOR GATEWAY LIGHT
CEILING	21	CTL	CTL CEILING LIGHT
+21"	02	FL	FOOT LIGHT
+48"	14	SB	SWITCH BOARD
+75"	03	ML	1 X 11 W CFL MIRROR LIGHT
VENTILATOR HT.	03	CR	CEILING ROSE
VENTILATOR HT.	03	EXP	1/2" DIA FRESH AIR FAN
+24"	02	TEL	TELEPHONE POINT
+27"	03	TV	TV CORNER POINT
+24"	02	LP TEL	6 A PLUS POINT FOR TELEPHONE
+27"	03	LP TV	6 A PLUS POINT FOR TV
+24"	02	LP	6 A PLUS POINT
+27"	01	LP CH	6 A PLUS POINT FOR CHIMNEY
+100"	03	SAC	1/2" DIA FRESH AIR FAN
+100"	03	PP SAC	1/2" DIA FRESH AIR FAN
+42"	01	PP MEY	1/2" DIA FRESH AIR FAN
+78"	02	PP G	1/2" DIA FRESH AIR FAN
+38"	01	PP F	1/2" DIA FRESH AIR FAN
+28"	01	PP HP	1/2" DIA FRESH AIR FAN
+48"	01	PP WM	1/2" DIA FRESH AIR FAN
+42"	02	BP	BELL PUSH SWITCH
+90"	01	BL	BELLZ POINT
+24"	03	AC	AC STARTER
+90"	01	ACB DB	ACB DISTRIBUTION BOARD
03		SB/L/L	SWITCH BOARD NO. LIGHT CIRCUIT NO.
03		AC	AC CIRCUIT NO.
03		PL	POWER CIRCUIT NO.


WARNING

1. This drawing is the sole copyright of Architects **VISTAAR** and should be used for the purpose expressly issued.

GENERAL NOTES

- All dimensions are in feet and inches.
- Do not scale this drawing follow written dimensions only.
- This drawing should be read in conjunction with other architectural and structural drawings.
- Any discrepancy in the drawing should be immediately brought to the notice of architect.

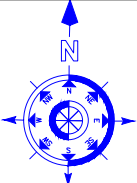PROJECT TITLE				
PROJECT:- SUNRISE WESTWAY HEIGHTS BUILDING AT PLOT NO.-32E & 32F.WESTWAY HEIGHTS(TRUCK TERMINAL),VILL.KESHOPURA,ASARPURA ,BHANKROTA,JAIPUR				
DRAWING TITLE				
TERRACE CEILING ELECTRICAL PLAN				
ARCHITECTS :				
VISTAAR ARCHITECTS & PLANNERS Architects :: Interior Designers B-2/12, Chitrkoot scheme, main Gandhi Path,Opp mall of jaipur,Jaipur PH.- 0141-4116461,09001010366				
DATE				
DRN.	DATE	REV.	NORTH	
SACHIN	02-08-2024			
SCALE		JOB NO.		
N.T.S				

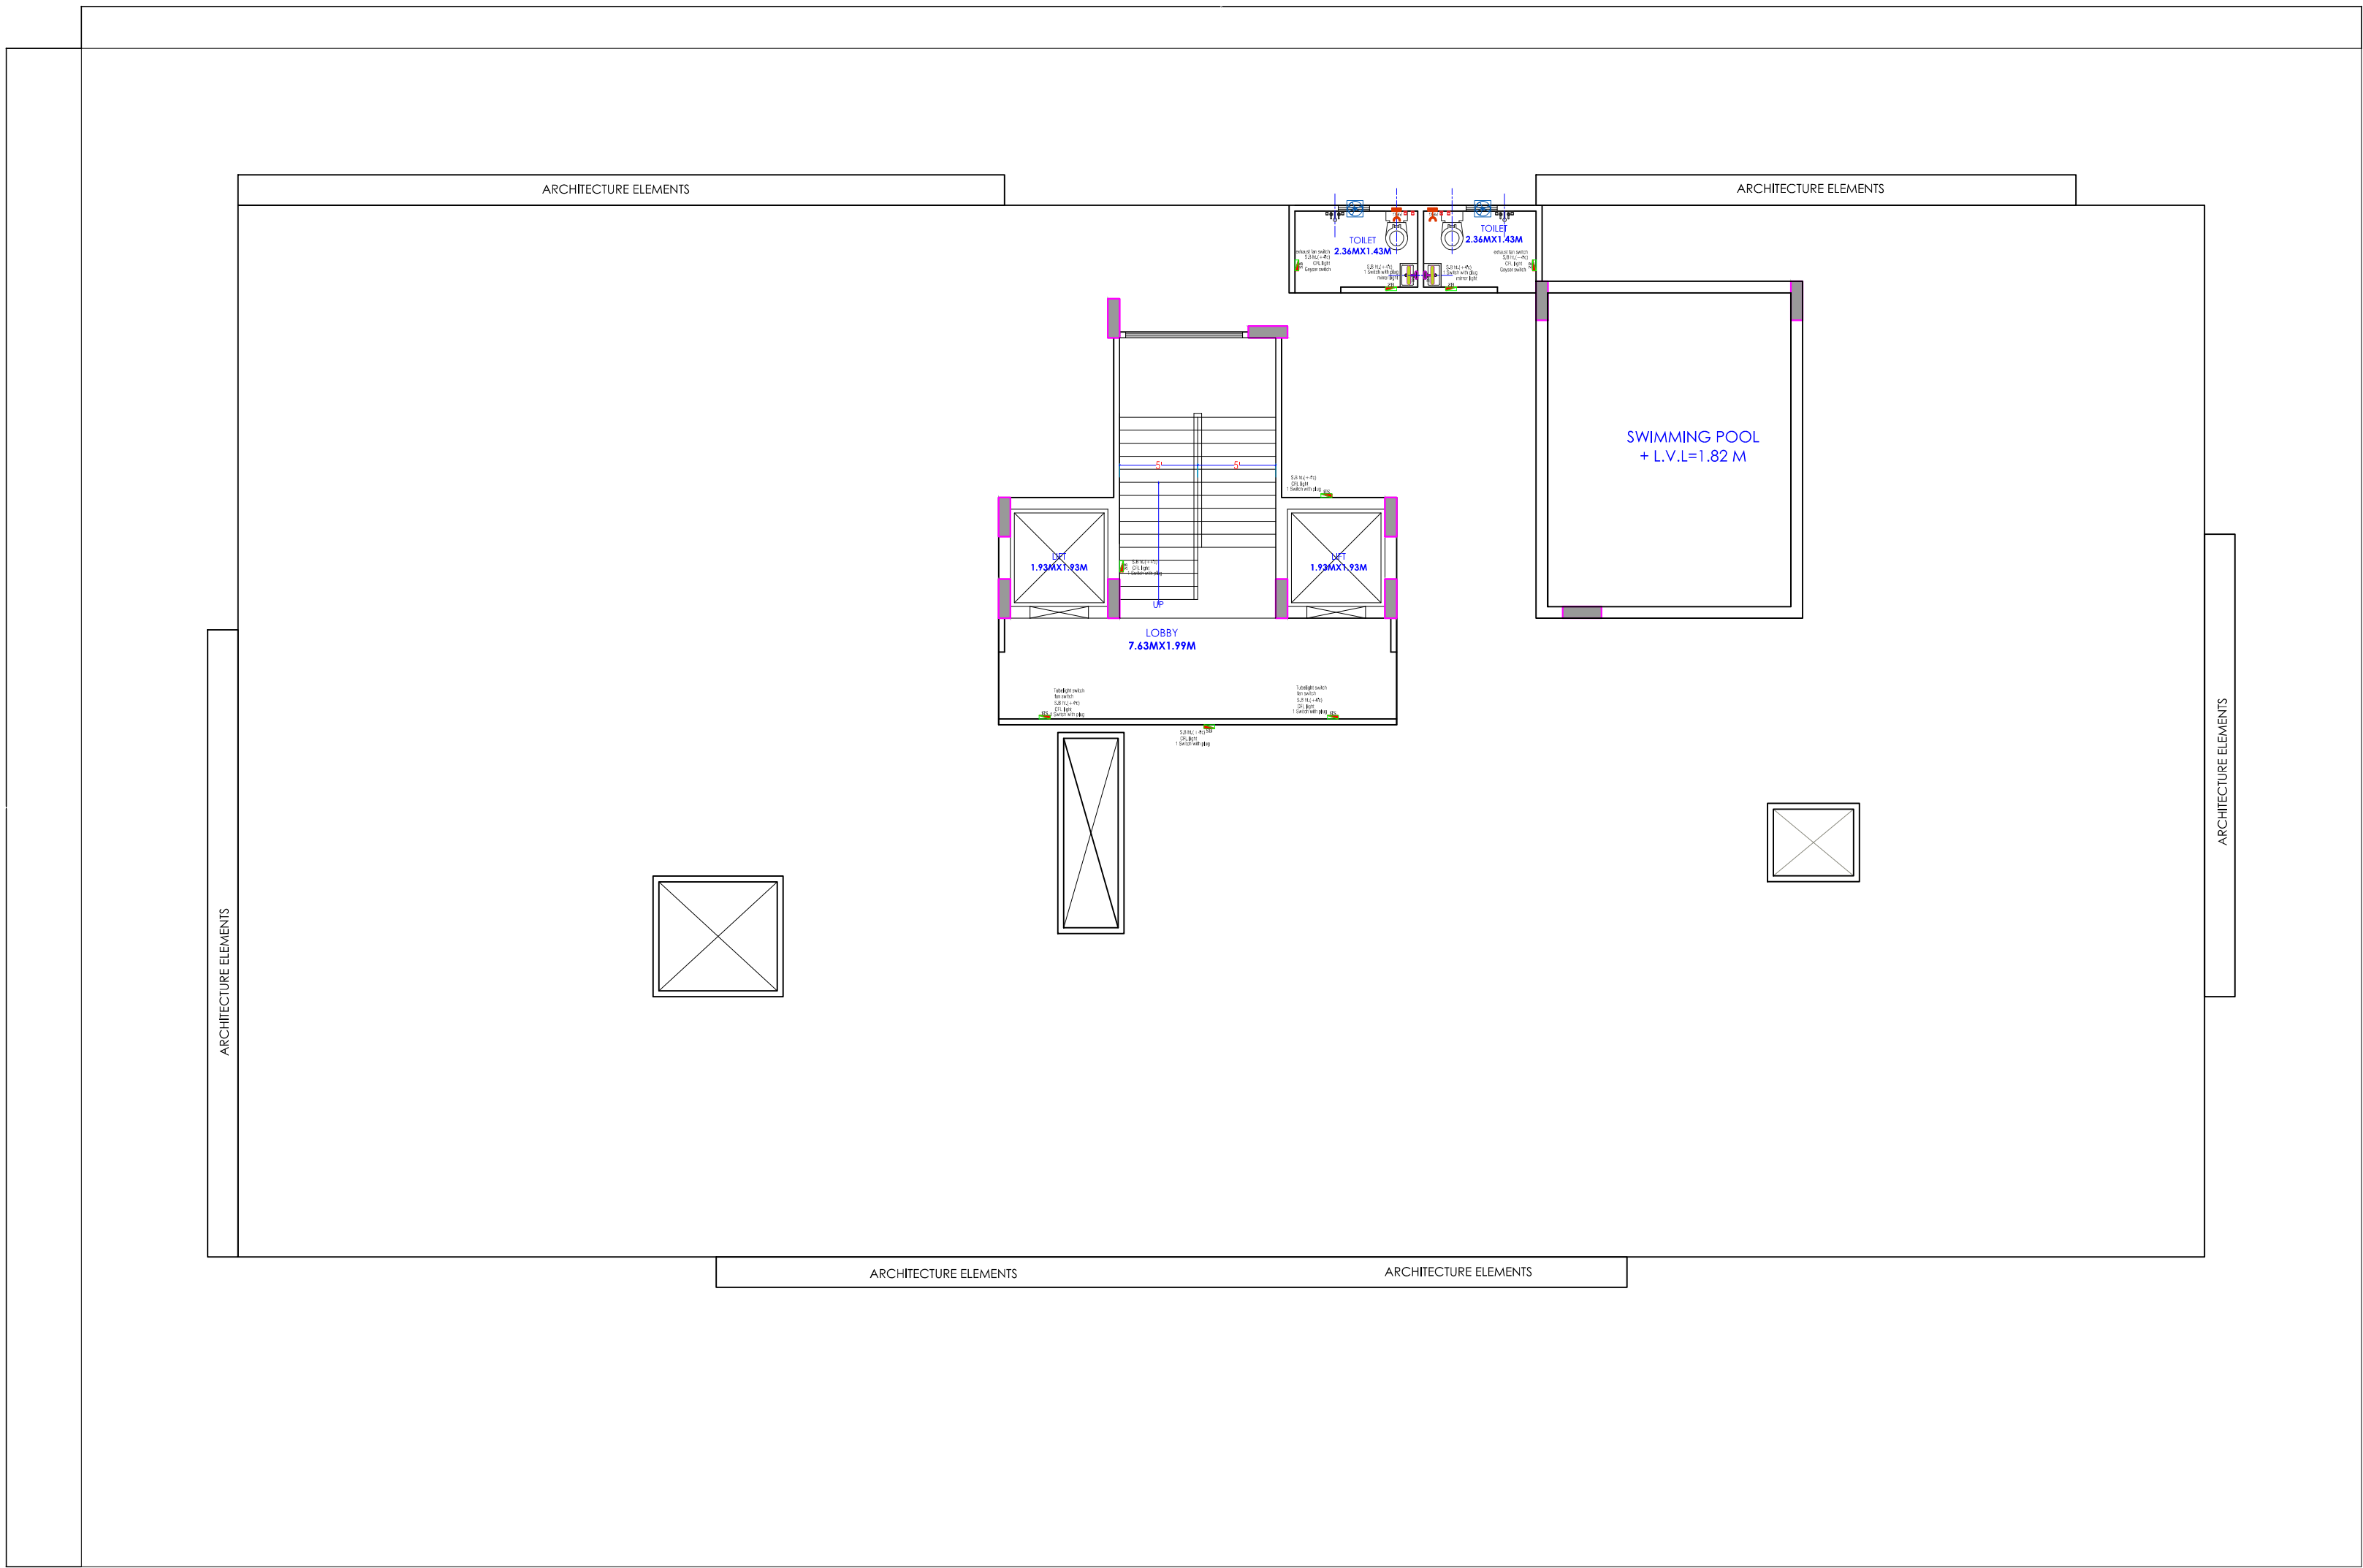

Y
-----ROAD 12 MT.WIDE-----

LEGENDS:			
Mounting Height	No.	Symbol	Description
IN FLOOR			CONTROL WIRING
IN CONDUIT			CONTROL WIRING
IN CONDUIT			AC CONTROL WIRING
IN CONDUIT			OTHER CONTROL WIRING
IN CONDUIT			BLUZZER CONTROL WIRING
CEILING	08	FAN/MP	CEILING FAN 40"
CEILING	07	FAN/MP	CEILING FAN 30"
+10"	04	TL	FLUOR WALL TUBELIGHT
+90"	04	BLER	WALL BRACKETS AS DESIGN LIGHT
+90"	01	GL	WALL BRACKETS AS DESIGN FOR GATEWAY LIGHT
	02	GL	WALL BRACKETS AS DESIGN FOR GATEWAY LIGHT
CEILING	21	CTL	CTL CEILING LIGHT
+21"	02	FL	FOOT LIGHT
+48"	14	SB	SWITCH BOARD
+70"	03	ML	1 X 11 W CFL MIRROR LIGHT
VENTILATOR HT	03	CR	CEILING ROSE
VENTILATOR HT	03	EXP	18" DIA FRESH AIR FAN
+24"	02	TEL	TELEPHONE POINT
+27"	03	TV	TV CORDIAL POINT
+24"	02	LP TEL	6 A PLUS POINT FOR TELEPHONE
+27"	03	LP TV	6 A PLUS POINT FOR TV
+24"	02	LP	6 A PLUS POINT
+27"	01	LP-CH	6 A PLUS POINT FOR CHIMNEY
+100"	03	SAC	100V AC
+100"	03	PP-SAC	15 A POWER POINT FOR 100V AC
+42"	01	PP-MIX	15 A POWER POINT FOR MIXER
+78"	02	PP-G	15 A POWER POINT FOR GEYSER
+38"	01	PP-F	15 A POWER POINT FOR FRIDGE
+28"	01	PP-WP	15 A POWER POINT FOR WASHING MACHINE
+48"	01	PP-WM	15 A POWER POINT FOR WASHING MACHINE
+42"	02	BP	BELL PUSH SWITCH
+90"	01	BZ	BELLZEEZ POINT
+24"	03	JAC	AC STARTER
+90"	01	MCB DB	MCB DISTRIBUTION BOARD
03		SB/L/L	SWITCH BOARD NO LIGHT CIRCUIT NO.
03		AC	AC CIRCUIT NO.
03		PI	POWER CIRCUIT NO.

WARNING

1. This drawing is the sole copyright of Architects **VISTAAR** and should be used for the purpose expressly issued.

GENERAL NOTES

- All dimensions are in feet and inches.
- Do not scale this drawing follow written dimensions only.
- This drawing should be read in conjunction with other architectural and structural drawings.
- Any discrepancy in the drawing should be immediately brought to the notice of architect.

PROJECT TITLE
PROJECT:-
SUNRISE WESTWAY HEIGHTS
BUILDING AT PLOT NO.-32E & 32F WESTWAY
HEIGHTS (TRUCK TERMINAL), VILL. KESHOPURA, ASARPURA
, BHANKROTA, JAIPUR

DRAWING TITLE
TERRACE WALL ELECTRICAL PLAN

ARCHITECTS :
VISTAAR ARCHITECTS & PLANNERS
Architects :: Interior Designers
B-2/12, Chitrkoot scheme,
main Gandhi Path, Opp mall of jaipur, Jaipur
PH.- 0141-4116461, 09001010366

DATE			
DRN.	DATE	REV.	NORTH
ER,SACHN	02-08-2024		
SCALE	JOB NO.		
N.T.S			

For My Dream House
ER, SACHN
Partner

Checked by
KRISHNA KUMAR
B.Tech (Mechanical)
M.E.P Consultant