

ROAD 9.0 MTR. WIDE

64'-3"

ELECTRICAL
EQUIPMENT

P.NO.
51

150'-10 1/4"

DRIVEWAY

DRIVEWAY

DRIVEWAY

DRIVEWAY

P.NO.
53

147'-29 1/16"

PATHWAY 3.0 MTR WIDE

P.U

ENTRY

EXIT

ROAD 12.0 MTR. WIDE

52'-9 7/8"

12'-4 1/2"

P.NO.
C-01

STILT FLOOR ELECTRICAL ROUTE LAYOUT
(TRANSFORMER,RMU,METER PANEL,ELECTRICAL CABLE)

For ASTHA REAL ESTATE

Proprietor

Er. SANJEEV SHARMA
B.E (Electrical)

PROJECT NAME :

ASTHA PRIME

DEVELOPER NAME :

ASTHA REAL ESTATE

LEGENDS:

Mounting Height	I D	Symbol	Description
CEILING	FAN/48"		CEILING FAN 48"
CEILING	FAN/30"		CEILING FAN 30"
CEILING	CHI		CHANDELIER
+93"	TL/W		Led Wall Tube Light Make:- Syska Led Cat no.- SSK-TS-20W
+93"	BULB		Led Bulb 20W Make:- Syska Led Cat no. SKC-20W 5.7K/3K
+93"	GL		WALL BRACKETS AS DESIGN FOR GANESH LIGHT
+78"	ML		12x2 Led Mirror Light Make:- Syska Led Cat no.- FPL-12x2
CEILING	DL		Led 6" Down Lighter 20W (Surface Mounted) Make:- Syska Led Cat no.- SDL-15W GLD 6.5K/4K
VENTILATOR HT.	CR		CEILING ROSE
VENTILATOR HT.	EXF		9" DIA FRESH AIR FAN
+24"	2wSB		2w SWITCH BOARD
+42"	SB		SWITCH BOARD(6A SOCKET & SWITCH)
+24"	TEL		TELEPHONE POINT
+24"	LP TEL		6 A PLUG POINT FOR TELEPHONE
+48"	TV		TV COAXIAL POINT
+48"	LP TV		6 A PLUG POINT FOR TV
+24"	LP		6 A PLUG POINT FOR SIDE TABLE
+72"	LP-CH		6 A PLUG POINT FOR CHIMNEY
+12"	LP PC		6 A PLUG POINT FOR COMPUTER POINT
+93"	SAC		SPLIT AC INDOOR UNIT
+42"	PP-MIX		16 A POWER POINT FOR MIXER
+42"	PP-MIC		16 A POWER POINT FOR MICROWAVE
+78"	PP-G		16 A POWER POINT FOR GEYSER
+54"	PP-F		16 A POWER POINT FOR FRIDGE
+78"	PP-WP		16 A POWER POINT FOR WATER PURIFIER
+48"	PP-WM		16 A POWER POINT FOR WASHING MACHINE
+12"	PP-INV.		16 A POWER POINT FOR INVERTOR
+93"	PP-AC		25A SWITCH/MCB FOR AC
			CHAMBER(2' X 2')
+18"			6A 2 NOS. SOCKET +1 NOS. 16A SWITCH ,TELEPHONE,LAN
+60"	MCB DB		MCB DISTRIBUTION BOARD
			CAMERA
			WALL FAN

S.No DATE REVISION DESCRIPTION

GENERAL NOTES :

- All dimension on this drawing are in MKS System Only written dimensions are to be followed drawing should not be scaled.
- All measurements must be checked and verified by the contractors prior to execution of work at the site.
- This drawing is to be read in conjunction with all relevant structural, services & facility planning drawings.
- Architectural drawings are to be followed for the location of all structural members & masonry walls. for sizes & reinforcement details of structural members, relevant structural drawings are to be referred.
- Any discrepancies between architectural, structural and services drawings must be brought to the notice of the architect immediately & prior to execution at site. Co-ordination with services such as hvac, plumbing & electrical, etc. is the responsibility of the contractor.
- All masonry walls should be aligned with the columns as indicated on the plan, irrespective of the position as calculated with the dimensioning.
- For details, refer relevant large scale detail drgs. as indicated.

PROJECT:

PROPOSED RESIDENTIAL FLATS
ON PLOT NO. - 52
SCHEME "RAJLAXMI ELCLAVE-X"
MANPUR DEVRI URF GOLIAWAS,
TEH :- SANGANER ,JAIPUR

NAME OF DRAWING:

STILT FLOOR
ELECTRICAL ROUTE LAYOUT
(TRANSFORMER,RMU,METER PANEL,
ELECTRICAL CABLE)

DRAWING

WORKING DRAWING

PROJECT NO. :

DATE:
27, May. - 2024

SCALE :

NTS

DRAWING NO. :

PROJECT CATEGORY BLOCK FLOOR TYPE NUMBER

A-01

P.NO.
51

P.NO.
53

147'-2 3/16"

PATHWAY 3.0 MTR WIDE

P.U

P.NO.
C-01

PROJECT NAME :
ASTHA PRIME

DEVELOPER NAME :
ASTHA REAL ESTATE

Mounting Height	ID	Symbol	Description
CEILING	FAN/48"		CEILING FAN 48"
CEILING	FAN/30"		CEILING FAN 30"
CEILING	CHI		CHANDELIER
+93"	TL/W		Led Wall Tube Light Make:- Syska Led Cat no:- SSK-T5-20W
+93"	BULB		Led Bulb 20W Make:- Syska Led Cat no:- SSK-20W 5.7K/3K
+93"	GL		WALL BRACKETS AS DESIGN FOR GANESH LIGHT
+78"	ML		12x2 Led Mirror Light Make:- Syska Led Cat no:- PPL-12x2
CEILING	DL		Led 6" Down Lighter 20W (Surface Mounted) Make:- Syska Led Cat no:- SDL-15W GLD 6.5K/4K
VENTILATOR HT.	CR		CEILING ROSE
VENTILATOR HT.	EXP		9" DIA FRESH AIR FAN
+24"	2wSB		2wSWITCH BOARD
+42"	SB		SWITCH BOARD(6A SOCKET & SWITCH)
+24"	TEL		TELEPHONE POINT
+24"	LP TEL		6 A PLUG POINT FOR TELEPHONE
+48"	TV		TV COAXIAL POINT
+48"	LP TV		6 A PLUG POINT FOR TV
+24"	LP		6 A PLUG POINT FOR SIDE TABLE
+72"	LP-CH		6 A PLUG POINT FOR CHIMNEY
+12"	LP PC		6 A PLUG FOR COMPUTER POINT
+93"	SAC		SPLIT AC INDOOR UNIT
+42"	PP-MIX		16 A POWER POINT FOR MIXER
+42"	PP-MIC		16 A POWER POINT FOR MICROWAVE
+78"	PP-G		16 A POWER POINT FOR GEYSER
+54"	PP-F		16 A POWER POINT FOR FRIDGE
+78"	PP-WP		16 A POWER POINT FOR WATER PURIFIER
+48"	PP-WM		16 A POWER POINT FOR WASHING MACHINE
+12"	PP-INV.		16 A POWER POINT FOR INVERTOR
+93"	PP-AC		25A SWITCH/ MCB FOR AC
			CHAMBER(2' X 2')
+18"			6A 2 NOS. SOCKET +1 NOS. 16A SWITCH ,TELEPHONE,LAN
+60"	MCB DB		MCB DISTRIBUTION BOARD
			CAMERA
			WALL FAN

S.No	DATE	REVISION DESCRIPTION
GENERAL NOTES :		
1. All dimension on this drawing are in MKS System Only written dimensions are to be followed. Drawing should not be scaled.		
2. All measurements must be checked and verified by the contractors prior to execution of work at the site.		
3. This drawing is to be read in conjunction with all relevant structural, services & facility planning drawings.		
4. Architectural drawings are to be followed for the location of all structural members & masonry walls. For sizes & reinforcement details of structural members, relevant structural drawings are to be referred.		
5. Any discrepancies between architectural, structural and services drawings must be brought to the notice of the architects immediately & prior to execution at site.		
6. Co-ordination with services such as hvac, plumbing & electrical, etc. is the responsibility of the contractor.		
7. All masonry walls should be aligned with the columns as indicated on the plan, irrespective of the position as calculated with the dimensioning.		
8. For details, refer relevant large scale detail drgs. as indicated.		

PROJECT:

PROPOSED RESIDENTIAL FLATS
ON PLOT NO. - 52
SCHEME "RAJLAXMI ELCLAVE-X"
MANPUR DEVRI URF GOLIAWAS,
TEH :- SANGANER ,JAIPUR

NAME OF DRAWING:


STILT FLOOR
CEILING ELECTRICAL LAYOUT,
ELECTRICAL POINT DRAWING,
CAMERA POINT DRAWING

DRAWING	NORTH:
WORKING DRAWING	
PROJECT NO. :	DATE :
	27, May. - 2024
SCALE :	REV NO. :
NTS	R-0

DRAWING NO. :

PROJECT	CATEGORY	BLOCK	FLOOR	TYPE	NUMBER

A-01

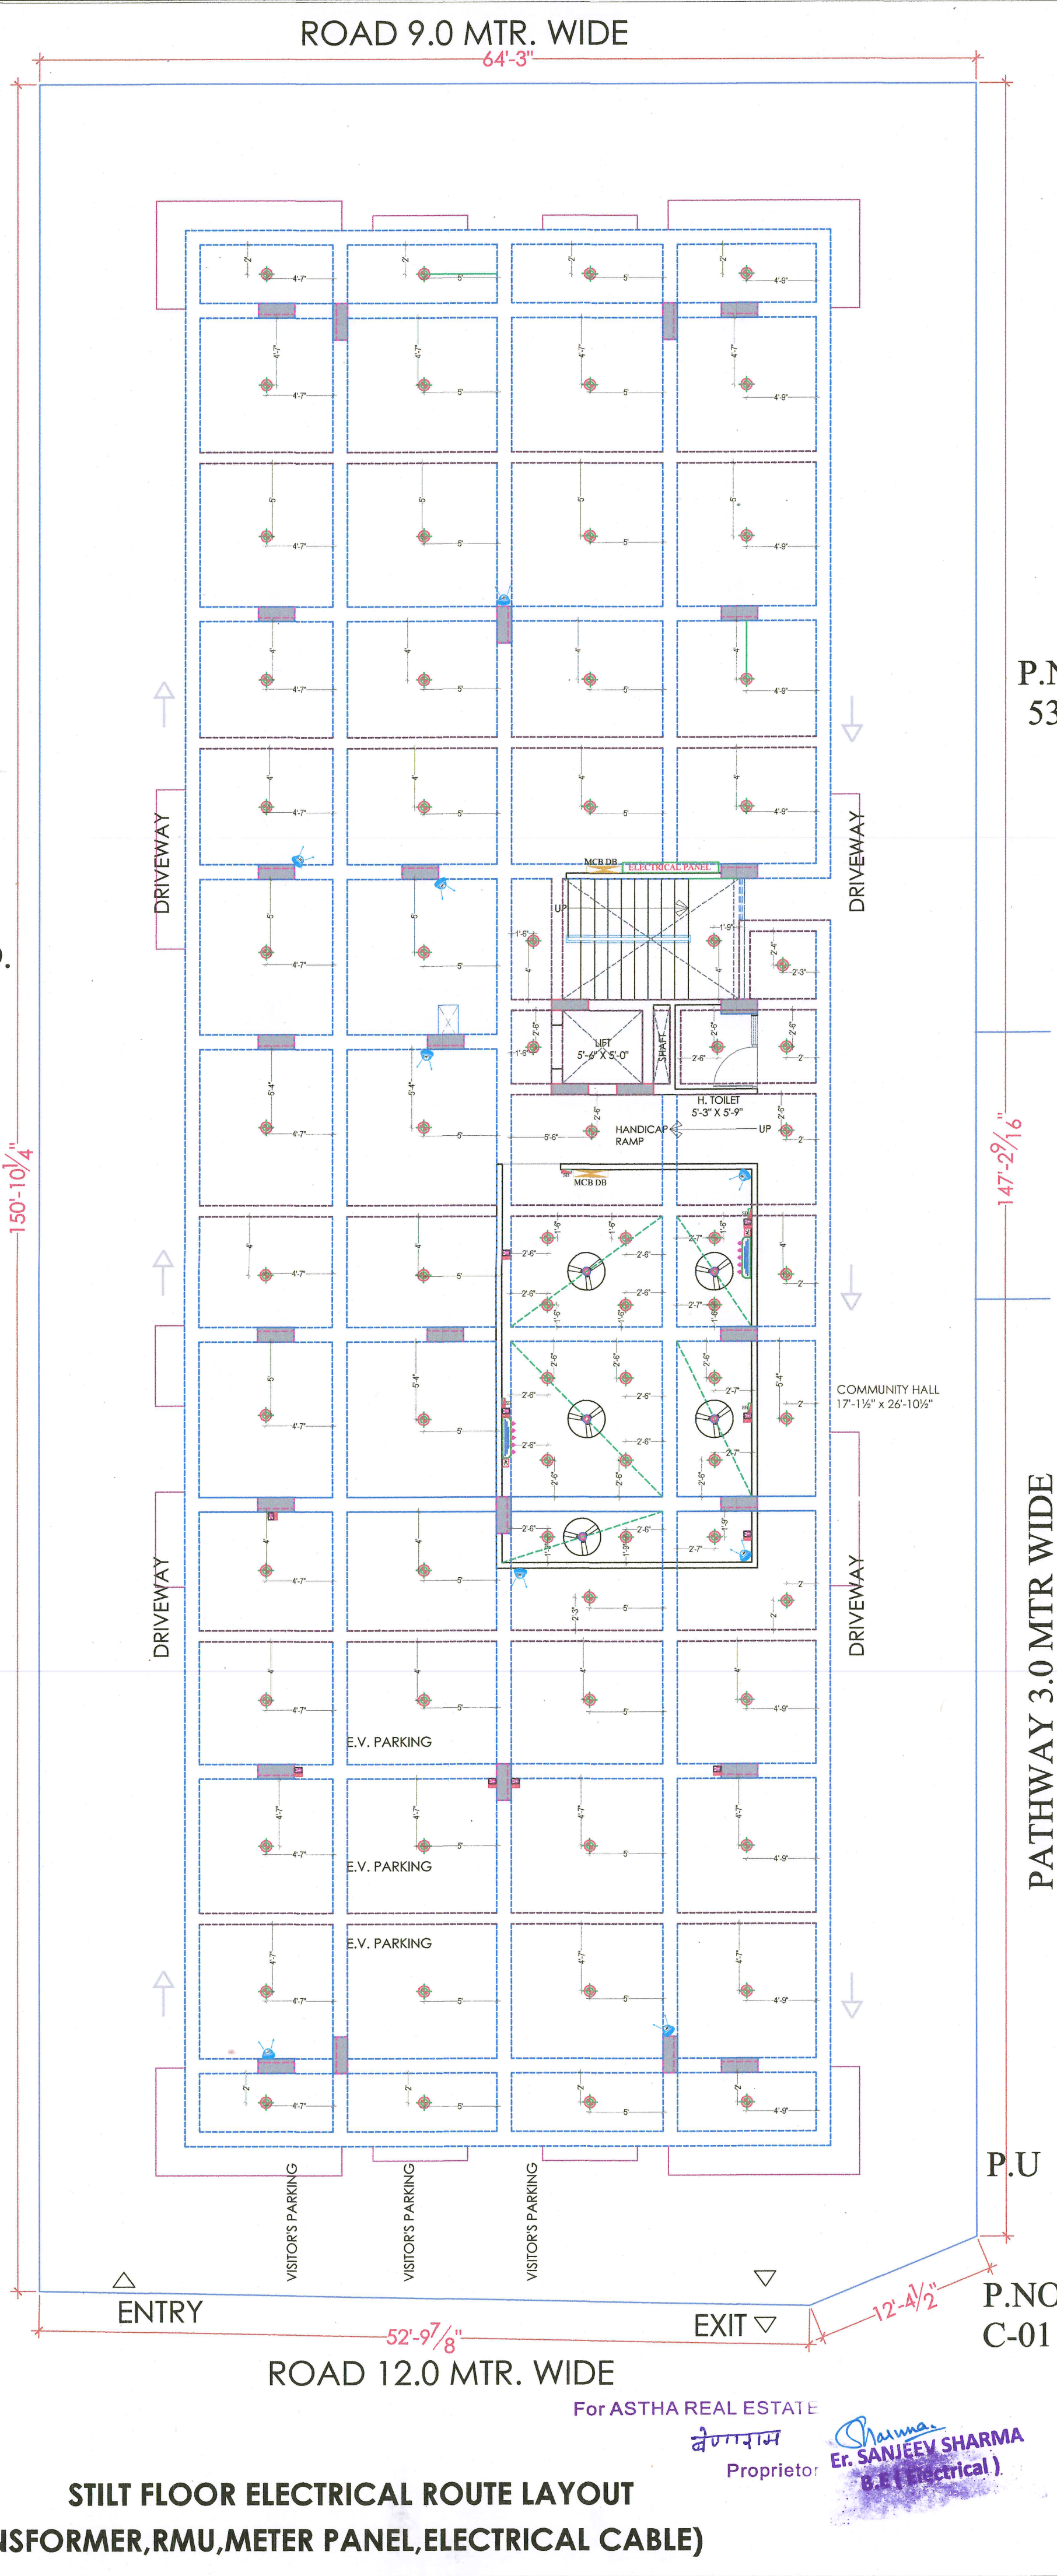

STILT FLOOR ELECTRICAL ROUTE LAYOUT
(TRANSFORMER, RMU, METER PANEL, ELECTRICAL CABLE)

For ASTHA REAL ESTATE

बेणगराम

Proprietor

Er. SANJEEV SHARMA
B.E (Electrical)