
 



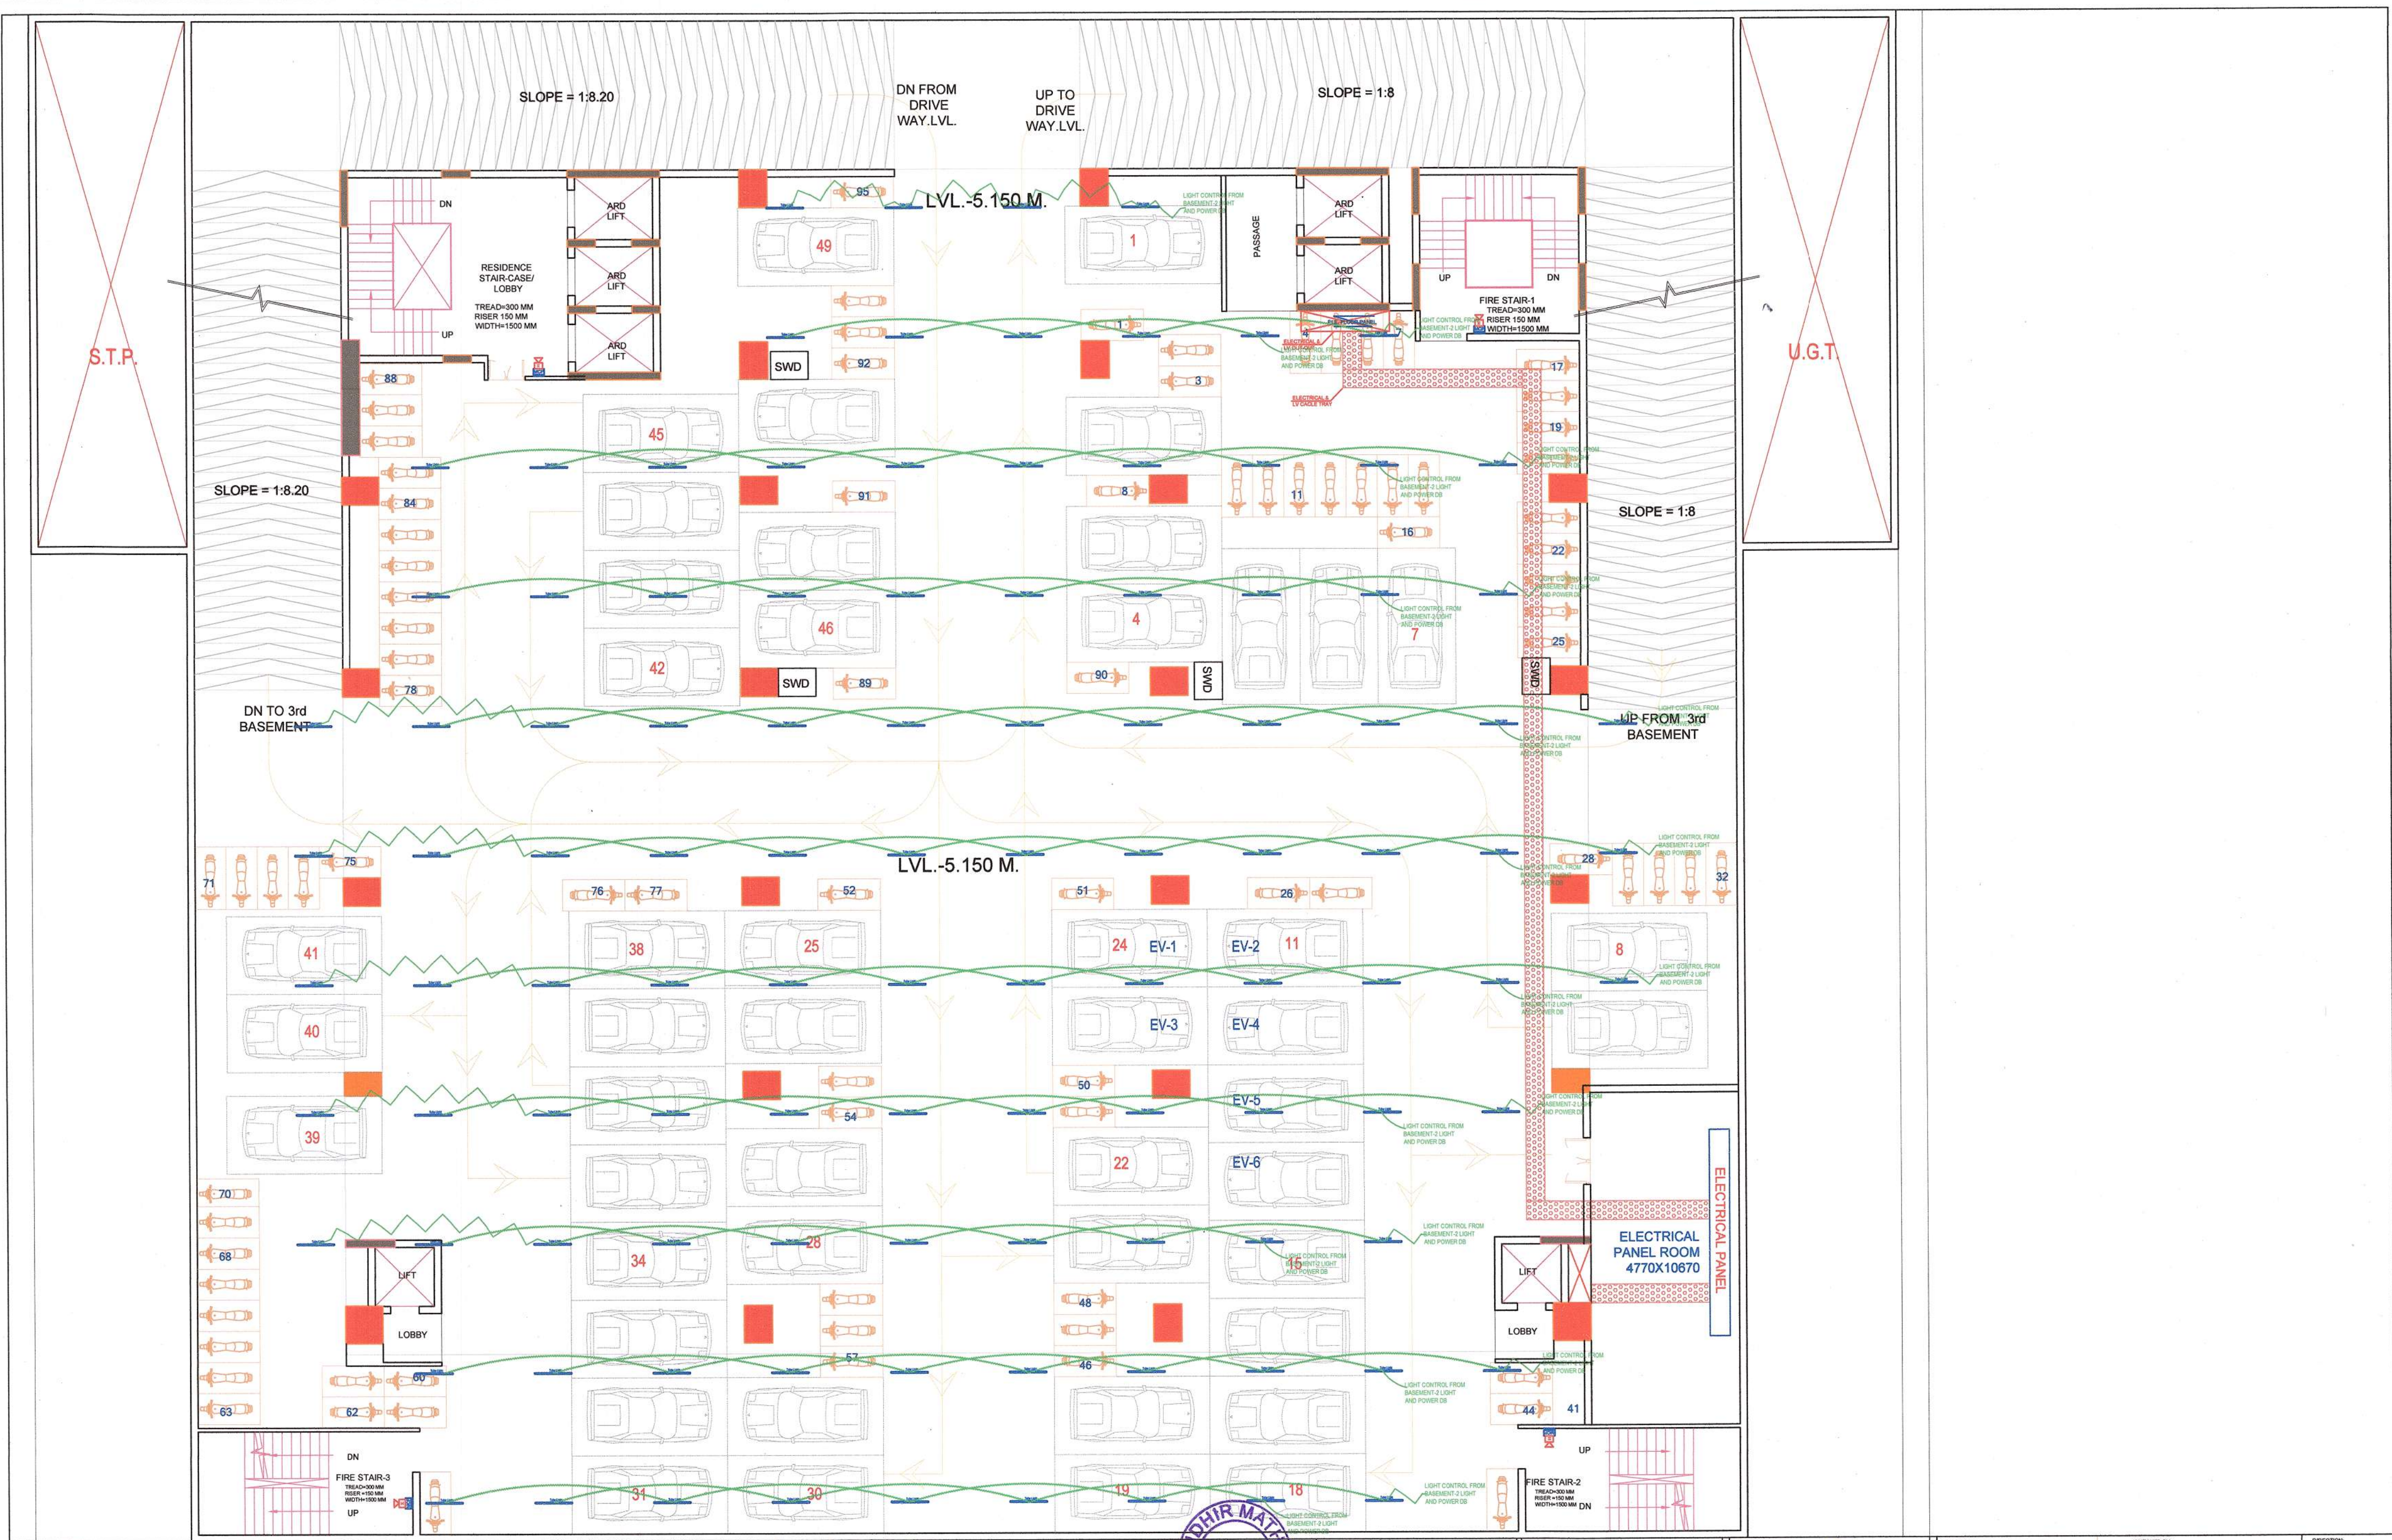

REV. NO.	DESCRIPTION TO REVISION	REV. BY	DATE	ARCHITECT	DESIGNER	PROJECT NAME	PROJECT ADDRESS	CLIENT NAME	CLIENT ADDRESS	CLIENT PHONE	CLIENT EMAIL	CLIENT WEBSITE	CLIENT LOGO	CLIENT NAME	CLIENT ADDRESS	CLIENT PHONE	CLIENT EMAIL	CLIENT WEBSITE	CLIENT LOGO
1																			
2																			
3																			
100																			



REV. NO.		DESCRIPTION TO REVISION		REV. BY		DATE		ARCHITECTS		STAMP		PROJECT NAME		DWP TITLE		DRP CONSULTANT		CHECKED BY		DIRECTION							
								Tushar Sogani Designs Pvt. Ltd. architects n designers Studio :- 400, F-72, "SURYODAY", Subhash Marg, Bagadiya Bhawan, C-Scheme, Jaipur-302001 TEL:- +91-141-4004560, 4004537 email: studio@tsdplarch.com website : www.tsdplarch.com				VIRAT NRI AVENUE		BASEMENT-1 ELCTRICAL PLAN						DEALT BY: DEVENDRA		SACHIN		N			
												PROJECT ADDRESS Commercial and Studio Apartment at Plot no. 230/ D, Sector-23, Pratap Nagar Scheme, Sanganer, Jaipur		CLIENT VIRAT BUILDHOME PVT. LTD.				DRAWN NO: SHMEPVGR-00		SCALE NTS		SHEET SIZE A1		DATE 17/03/2025			

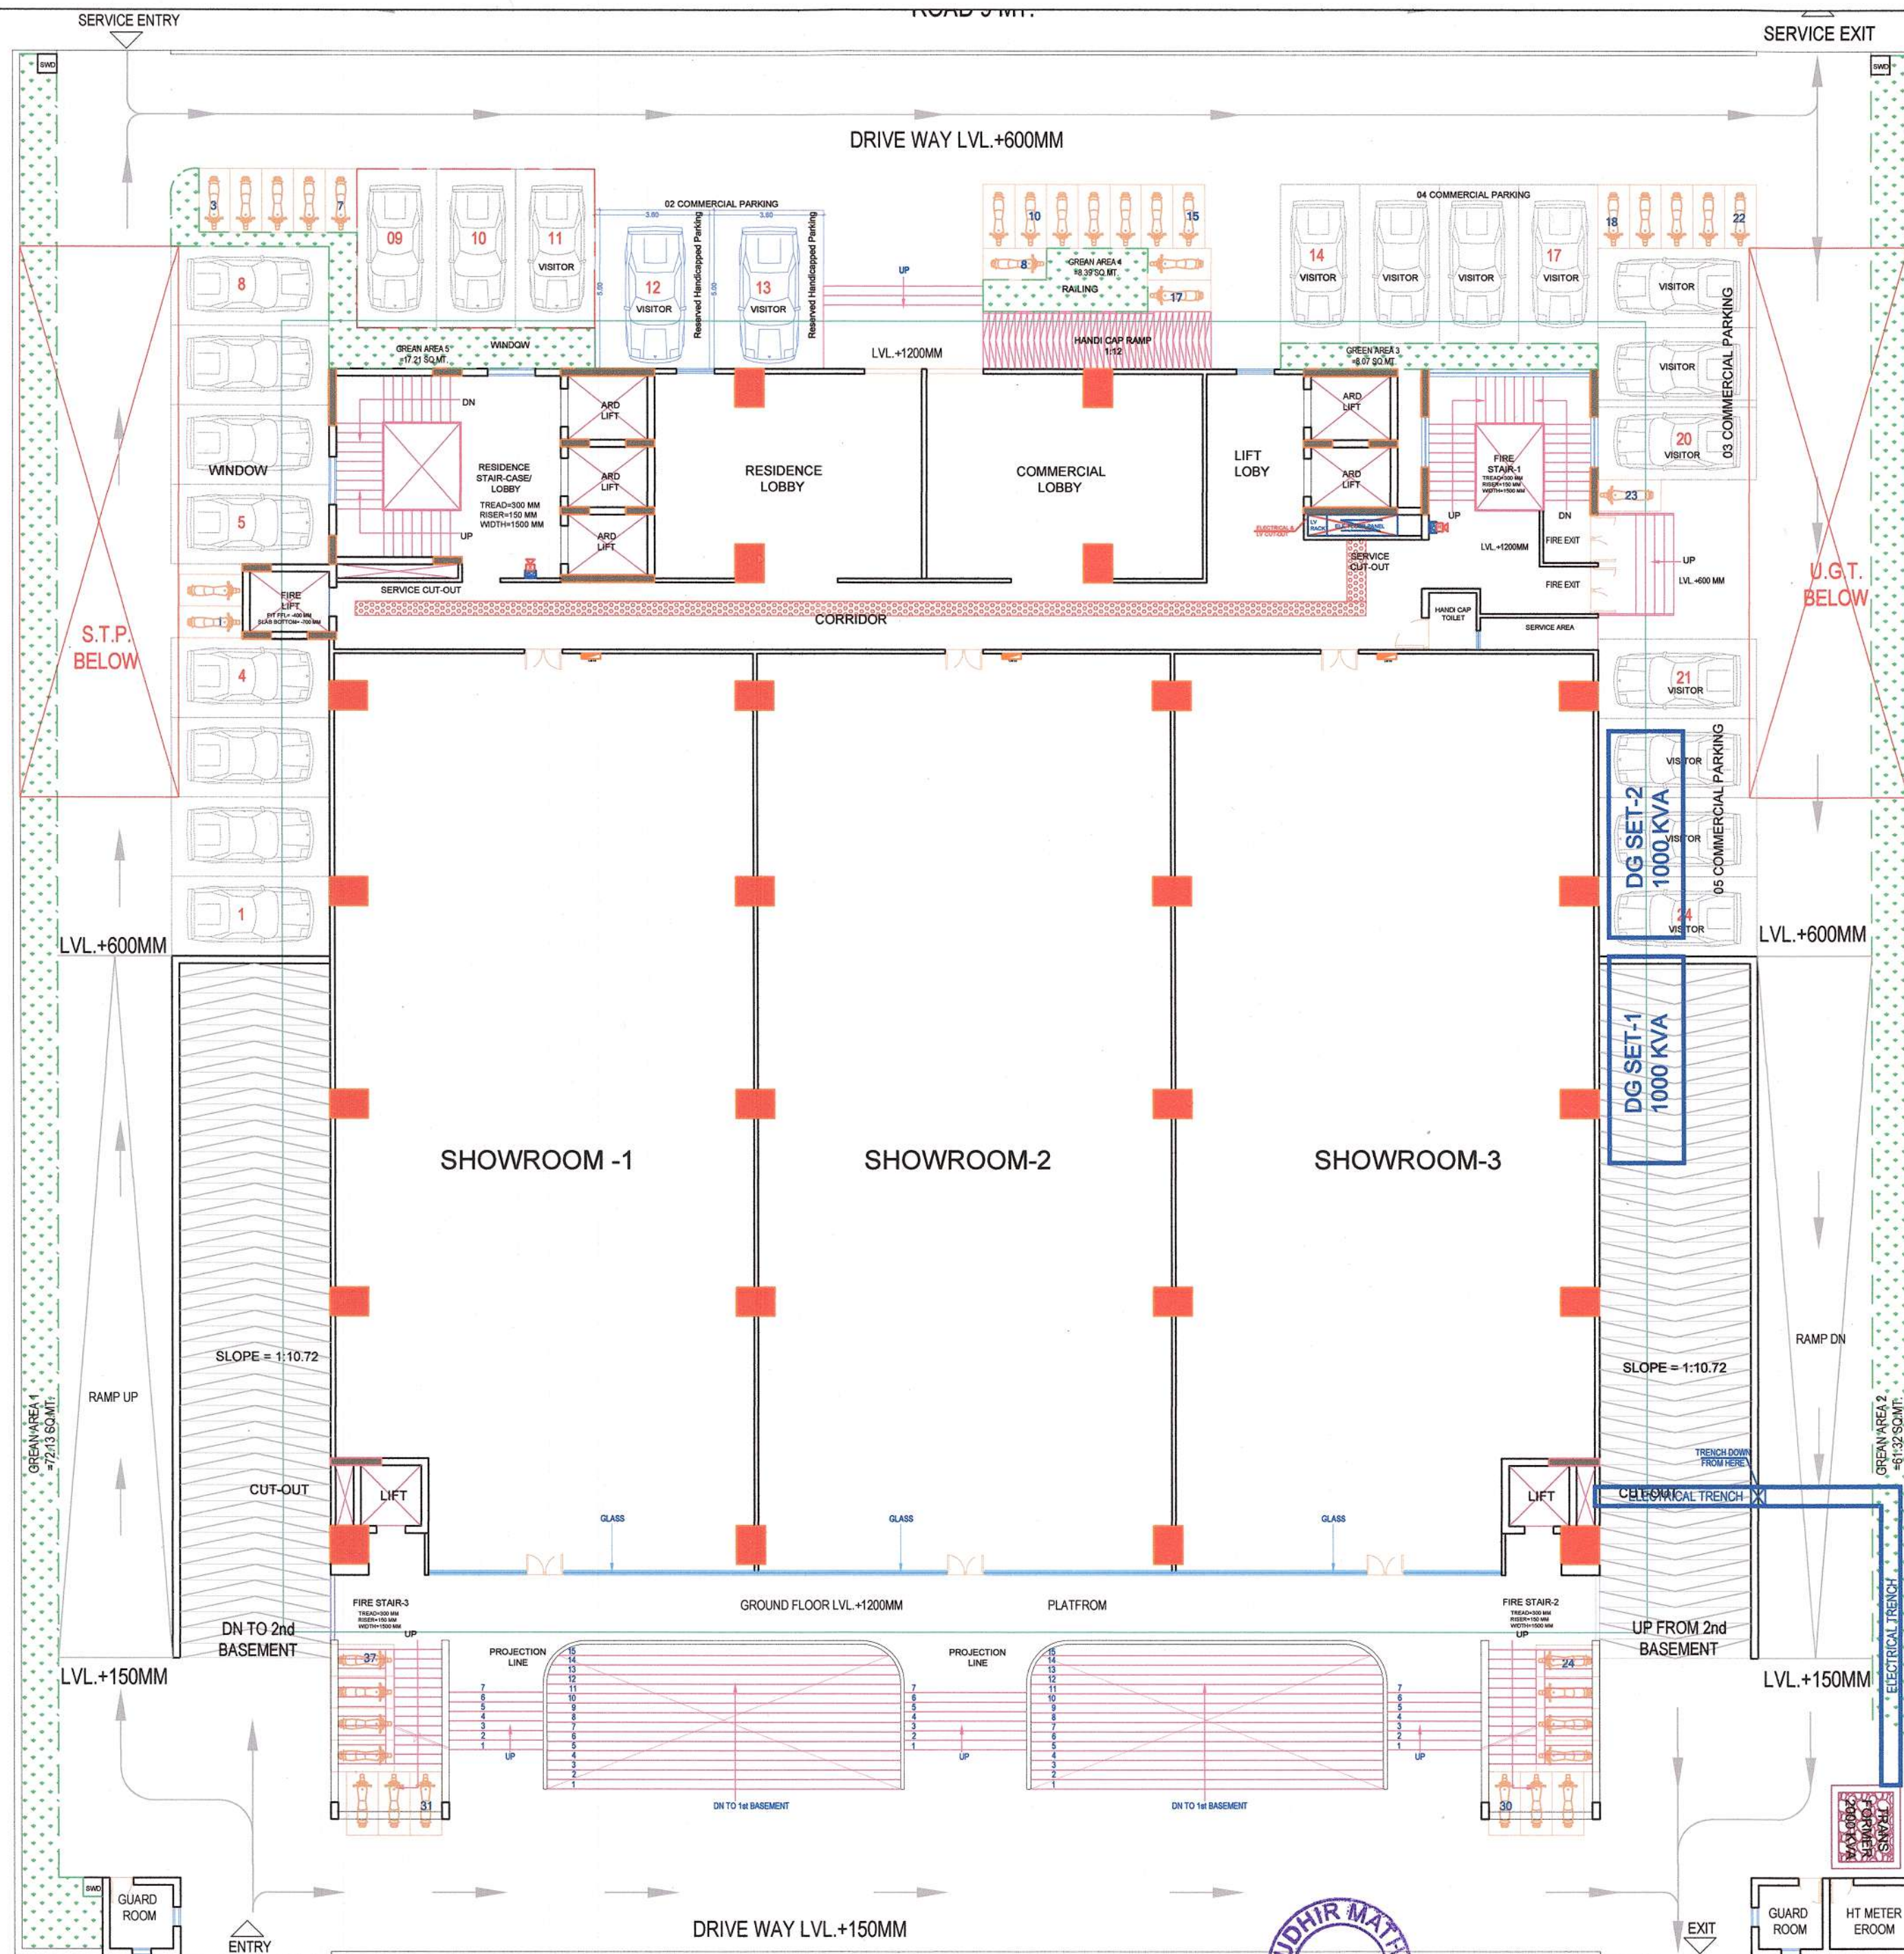

Electrical Legend			
Symbol	Description		Height from FFL
	Light and Power DB		Bottom+5'-6"
	Wall Mounted Hooter		+9'-0"
	Manual Call Point		+4'-0"

REV. NO.	DESCRIPTION TO REVISION	REV. BY	DATE	ARCHITECT	PROJECT NAME	PROJECT ADDRESS	CLIENT	DESIGNER	CHECKED BY	DATE	DIRECTION
1				Tushar Sogani Designs Pvt. Ltd.	VIRAT NRI AVENUE	Commercial and Studio Apartment at Plot no. 230/ D, Sector-23, Pratap Nagar Scheme, Sanganer, Jaipur	VIRAT BUILDHOME PVT. LTD.	SHRESHTHA	DEVENDRA	17/03/2025	N