


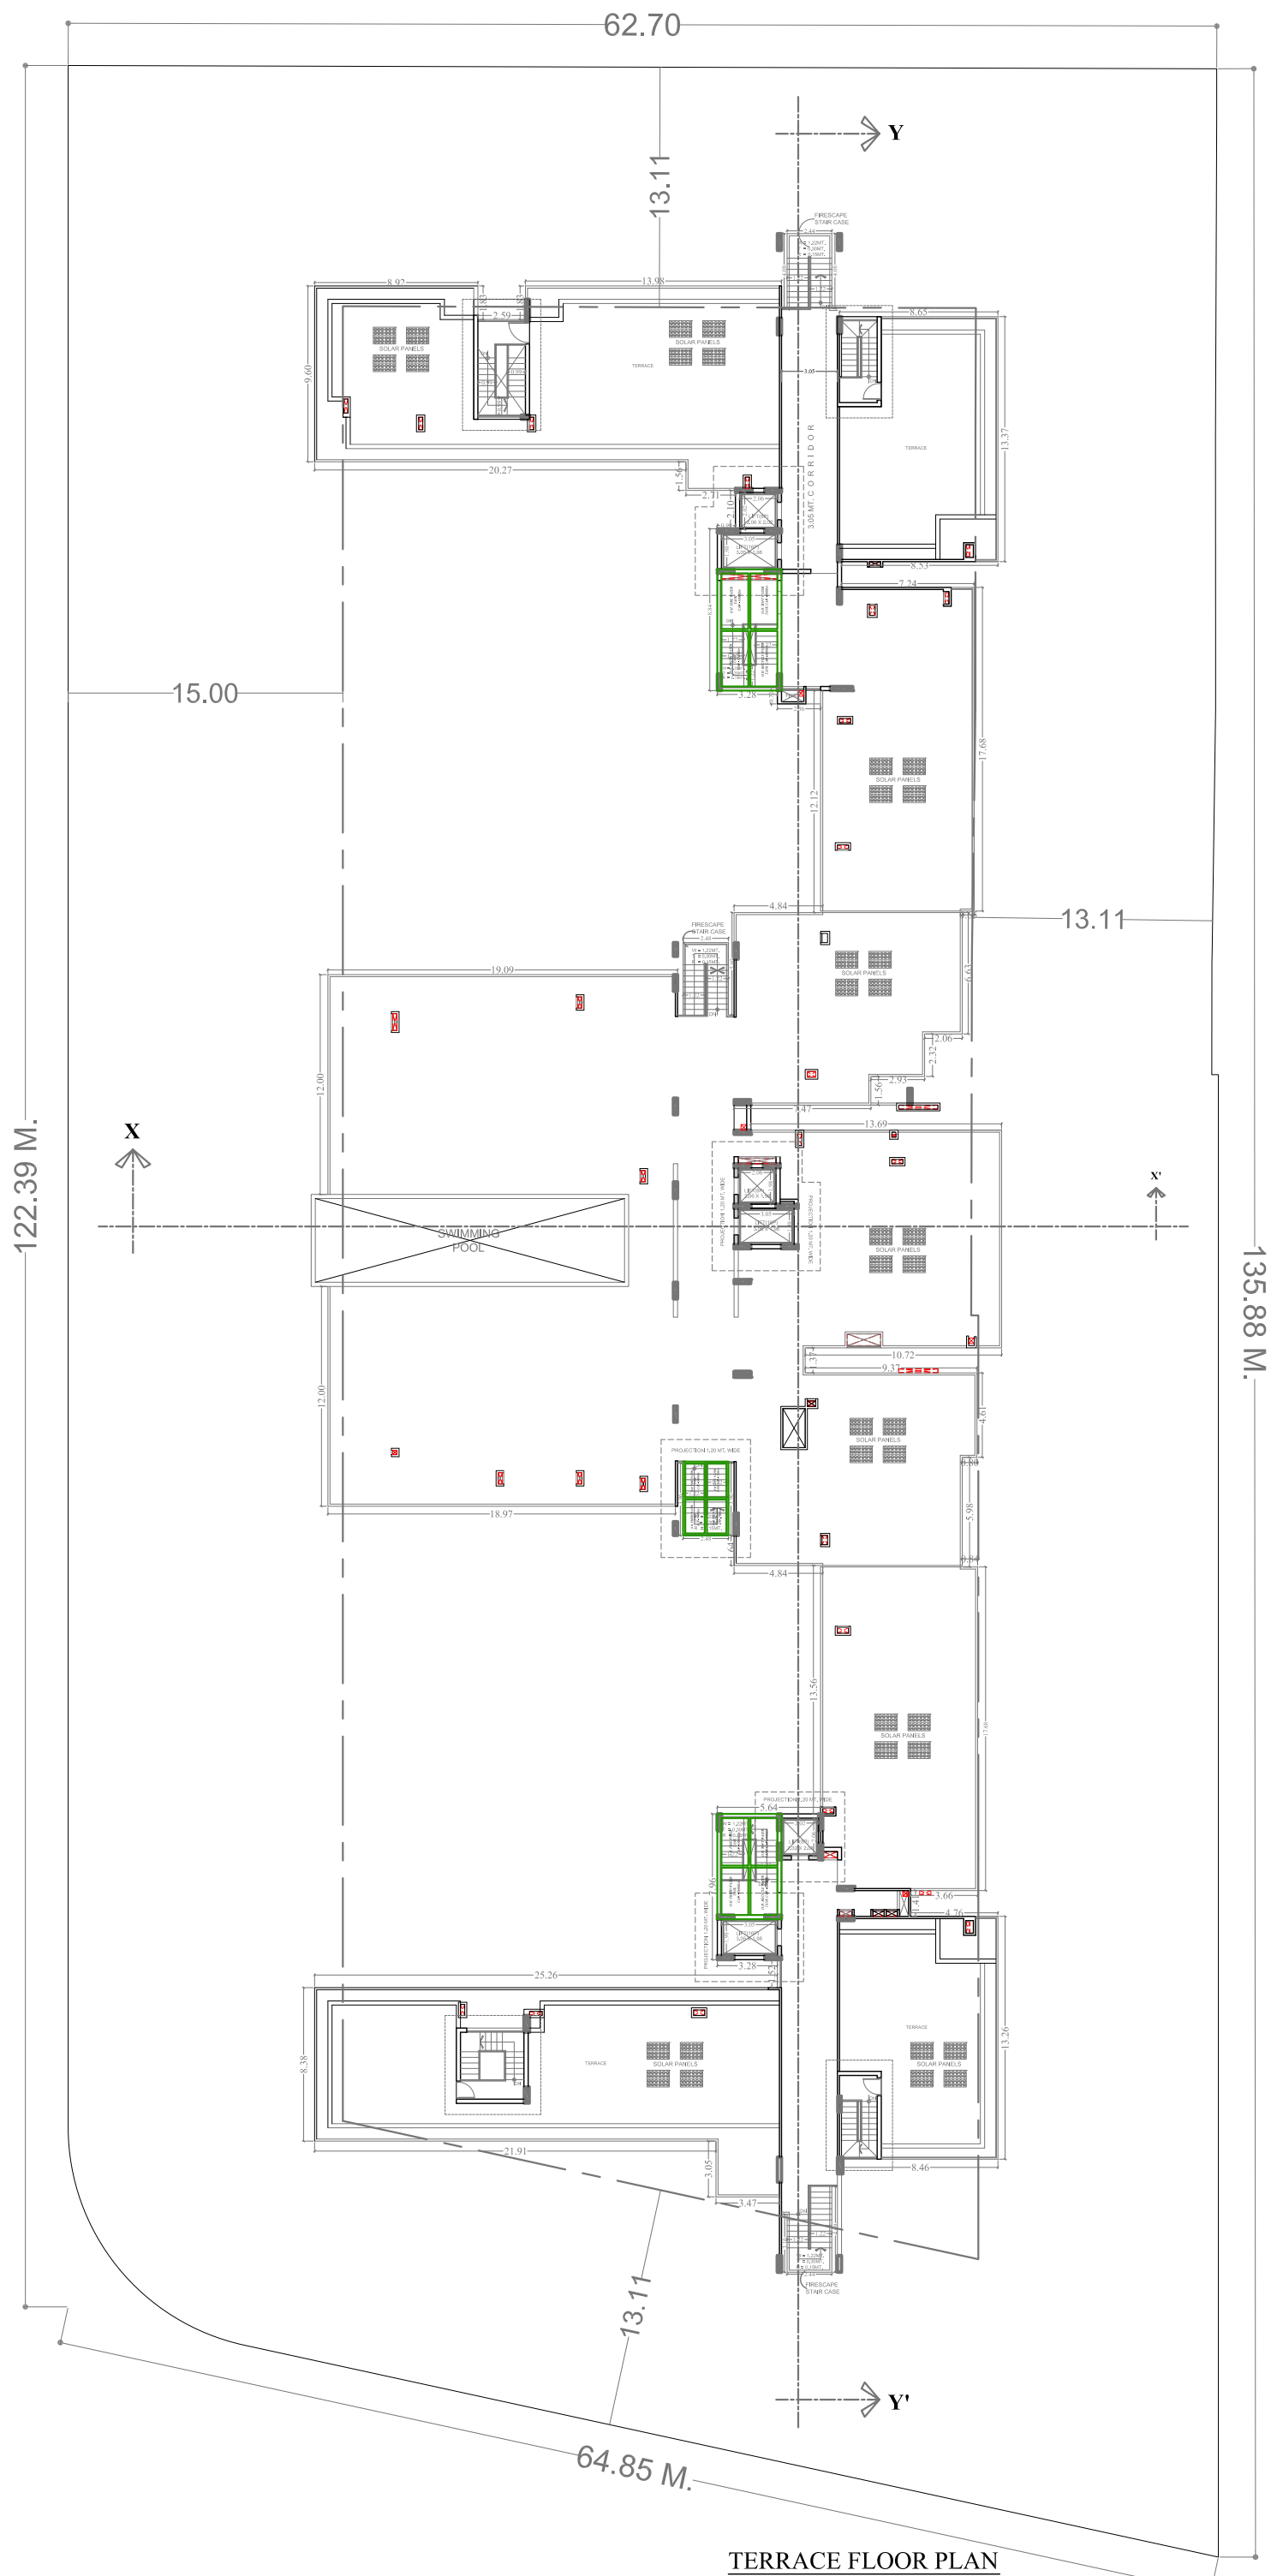

TERRACE FLOOR PLAN

DRAWING TITLE	
TERRACE FLOOR PLAN	
PROJECT TITLE:- PROPOSED RESIDENTIAL APARTMENT AT PLOT NO. (A-4) JDA AIRPORT PLAZA SCHEME, TONK ROAD, JAIPUR.	
DRAWING TITLE	
SOLAR ENERGY	
SCALE 1:100	NORTH POINT
OWNER	ARCHITECT



SYMBOL	QTY.	DESCRIPTION
	14	RAIN WATER CHAMBER
		1600 RAIN WATER PIPE
	03	RAIN WATER HARVESTING TANK SIZE-3.5M(L) X 3.0M(W) X 3.75M(D) EFFECTIVE DEPTH
	03	SILTING PIT SIZE-1.5M L & 1M. WIDTH
	13	SEWERAGE MANHOLE
		200mm Soil Waste Water pipe
		Fresh Water Supply pipe
		Recycle Water Supply pipe

SERVICES CONSULTANT:
VIPUL CONSULTING
F: 91440, Kharar Mang Chhokri Scheme, Jaipur
PH: 91-93146-10438, 0141-2440944
Mail: vipul8599@rediffmail.com
REV. NO. 01, DATE: 05-07-2017

DRAWING TITLE
TRANSFORMER

PROJECT TITLE:-
PROPOSED RESIDENTIAL APARTMENT
AT PLOT NO. 3 (A-4) IDA AIRPORT PLAZA SCHEME,
TONK ROAD, JAIPUR.

ARCHITECT

SCALE 1:100
NORTH POINT

OWNER
ARCHITECT