


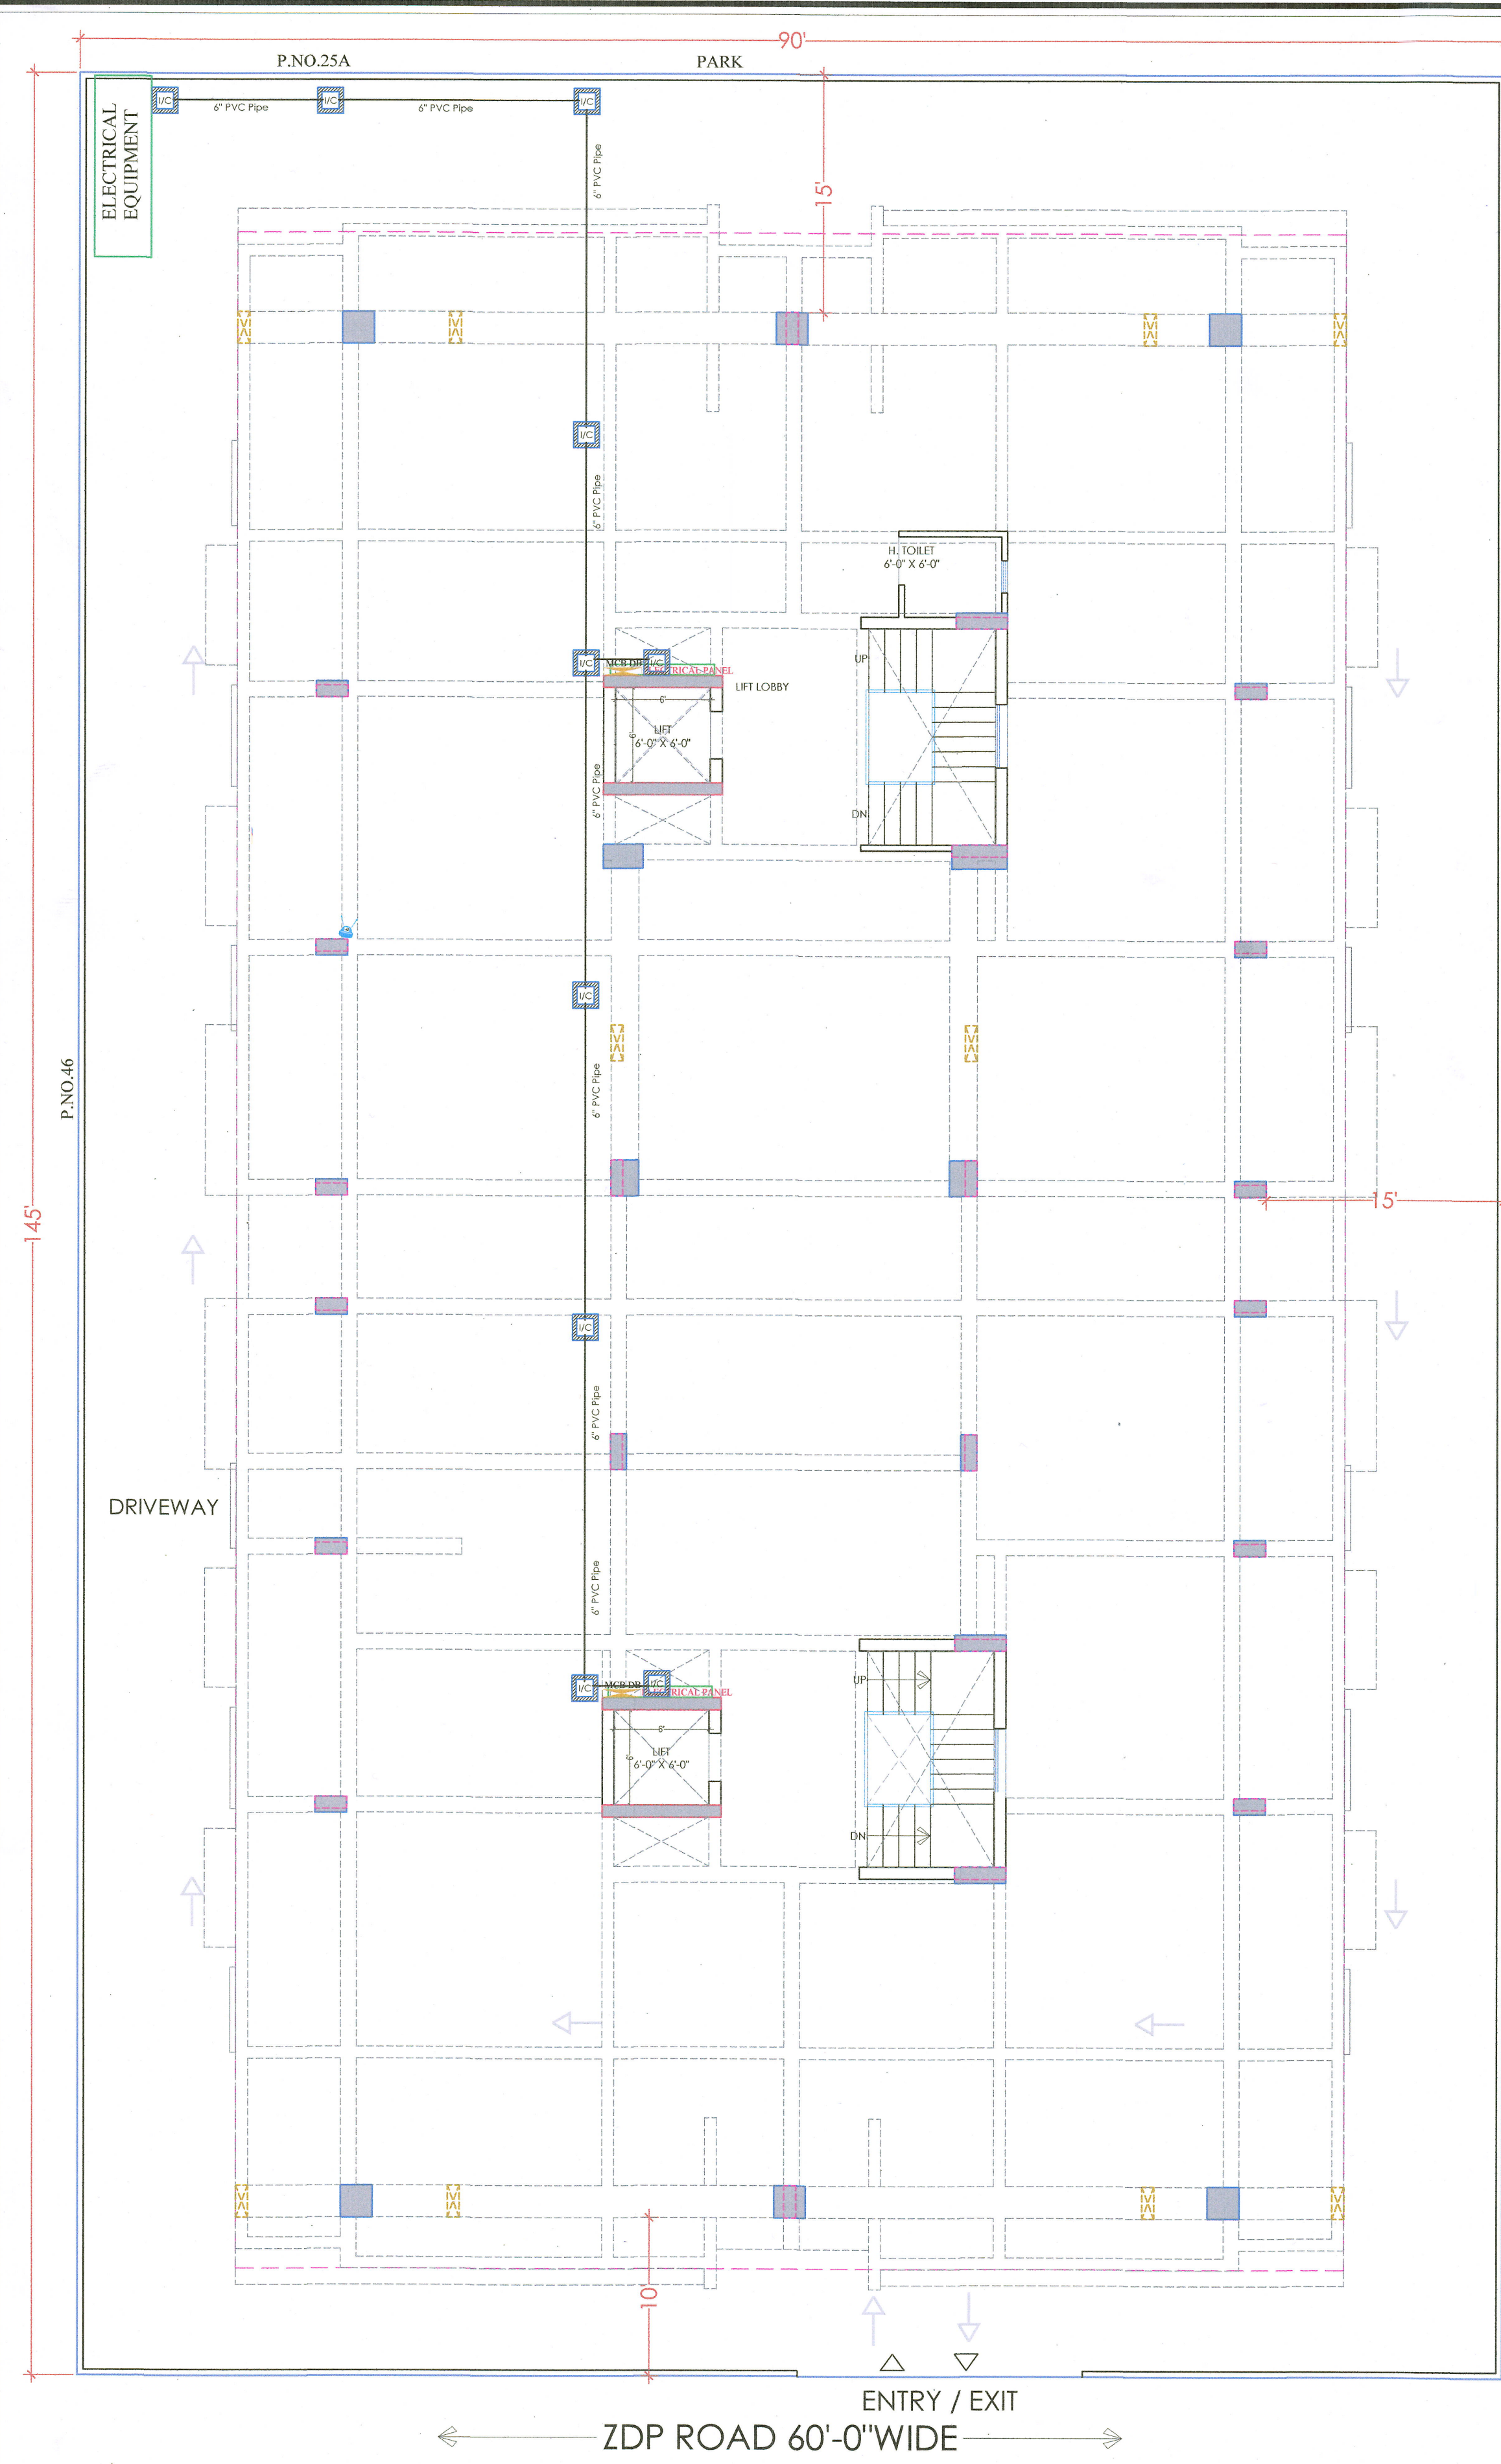

PROJECT NAME:
THE ROYAL PALACE

DEVELOPER NAME:
SHREE RAM INFRA

M/s Shree Ram Infra
TIG
Partner

LEGENDS:			
Mounting Height	ID	Symbol	Description
CEILING	FAN40"		CEILING FAN 40"
CEILING	FAN30"		CEILING FAN 30"
CEILING	CH		CHANDELIER
+9'3"	TLW		Lod Wall Tube Light
+9'3"	BULB		Lod Bulb 20W
+9'3"	GL		WALL BRACKETS AS DESIGN FOR GANESH LIGHT
+7'8"	ML		(2x) Lod Mirror Light
CEILING	DL		Lod 6" Down Lighter 20W (Surface Mounted)
VENTILATION HT	CR		CEILING ROSE
VENTILATION HT	EF		9" DIA FRESH AIR FAN
+2'4"	2xSB		2x SWITCH BOARD
+4'2"	SB		SWITCH BOARD/Socket & SWITCH
+2'4"	TEL		TELEPHONE POINT
+2'4"	LPTL		6 A PLUG POINT FOR TELEPHONE
+4'8"	TV		TV COAXIAL POINT
+4'8"	LP TV		6 A PLUG POINT FOR TV
+2'4"	LP		6 A PLUG POINT FOR SIDE TABLE
+7'2"	LP-CH		6 A PLUG POINT FOR CHIMNEY
+1'2"	LP-PC		6 A PLUG POINT FOR COMPUTER POINT
+9'3"	SAC		SPLIT AC INDOOR UNIT
+4'2"	PP-MIX		16 A POWER POINT FOR MIXER
+4'2"	PP-MIC		16 A POWER POINT FOR MICROWAVE
+7'8"	PP-G		16 A POWER POINT FOR GEYSER
+5'4"	PP-F		16 A POWER POINT FOR FRIDGE
+7'8"	PP-WP		16 A POWER POINT FOR WATER PURIFIER
+4'8"	PP-WM		16 A POWER POINT FOR WASHING MACHINE
+1'2"	PP-INV		16 A POWER POINT FOR INVERTER
+9'3"	PP-AC		25A SWITCH/MCB FOR AC
			CHAMBER 2 X 2
+1'8"			6A 2 NOS. SOCKET & 16A SWITCH, TELEPHONE LAN
+6'0"	MCB DB		MCB DISTRIBUTION BOARD
			CAMERA
			WALL FAN
BSB			6A S/S FAN REGULATOR, SWITCH
BAC			6A S/S 25A AC

GENERAL NOTES:

- All dimensions on this drawing are in Meters. Only written dimensions are to be used.
- All measurements must be checked and verified by the contractor prior to execution.
- It shall be the responsibility of the contractor to ensure that the drawing is to be used in conjunction with all relevant structural, services & building drawings.
- Architectural drawings are to be followed for the location of all structural members, masonry walls, for notes & reinforcement details of structural members, relevant structural drawings are to be referred.
- Any discrepancies between architectural, structural and services drawings must be reported to the client of the project immediately prior to execution of the work.
- Co-ordination with services such as water, plumbing & electrical, etc. is to be completed prior to execution.
- All materials must be approved by the client prior to execution of the work.
- For details, refer relevant large scale detail drawings, as indicated.

PROJECT:
PROPOSED RESIDENTIAL "THE ROYAL PALACE" BUILDING ON PLOT NO. - 45 SCHEME - 24 (RAJAT VIHAR), JAIPUR.

NAME OF DRAWING:
STILT FLOOR ELECTRICAL ROUTE LAYOUT (TRANSFORMER, RMU, METER PANEL, ELECTRICAL CABLE)

DRAWING	NORTH			
WORKING DRAWING				
PROJECT NO.:	DATE:			
	20-08-2024			
SCALE:	REV NO.:			
NTS	R-0			
DRAWING NO.:				
PROJECT	CATEGORY	ROOM	TYPE	NUMBER
A-01				

**STILT FLOOR ELECTRICAL ROUTE LAYOUT
(TRANSFORMER, RMU, METER PANEL, ELECTRICAL CABLE)**

Er. SANDEEP SHARMA
D.E.Electrical

