


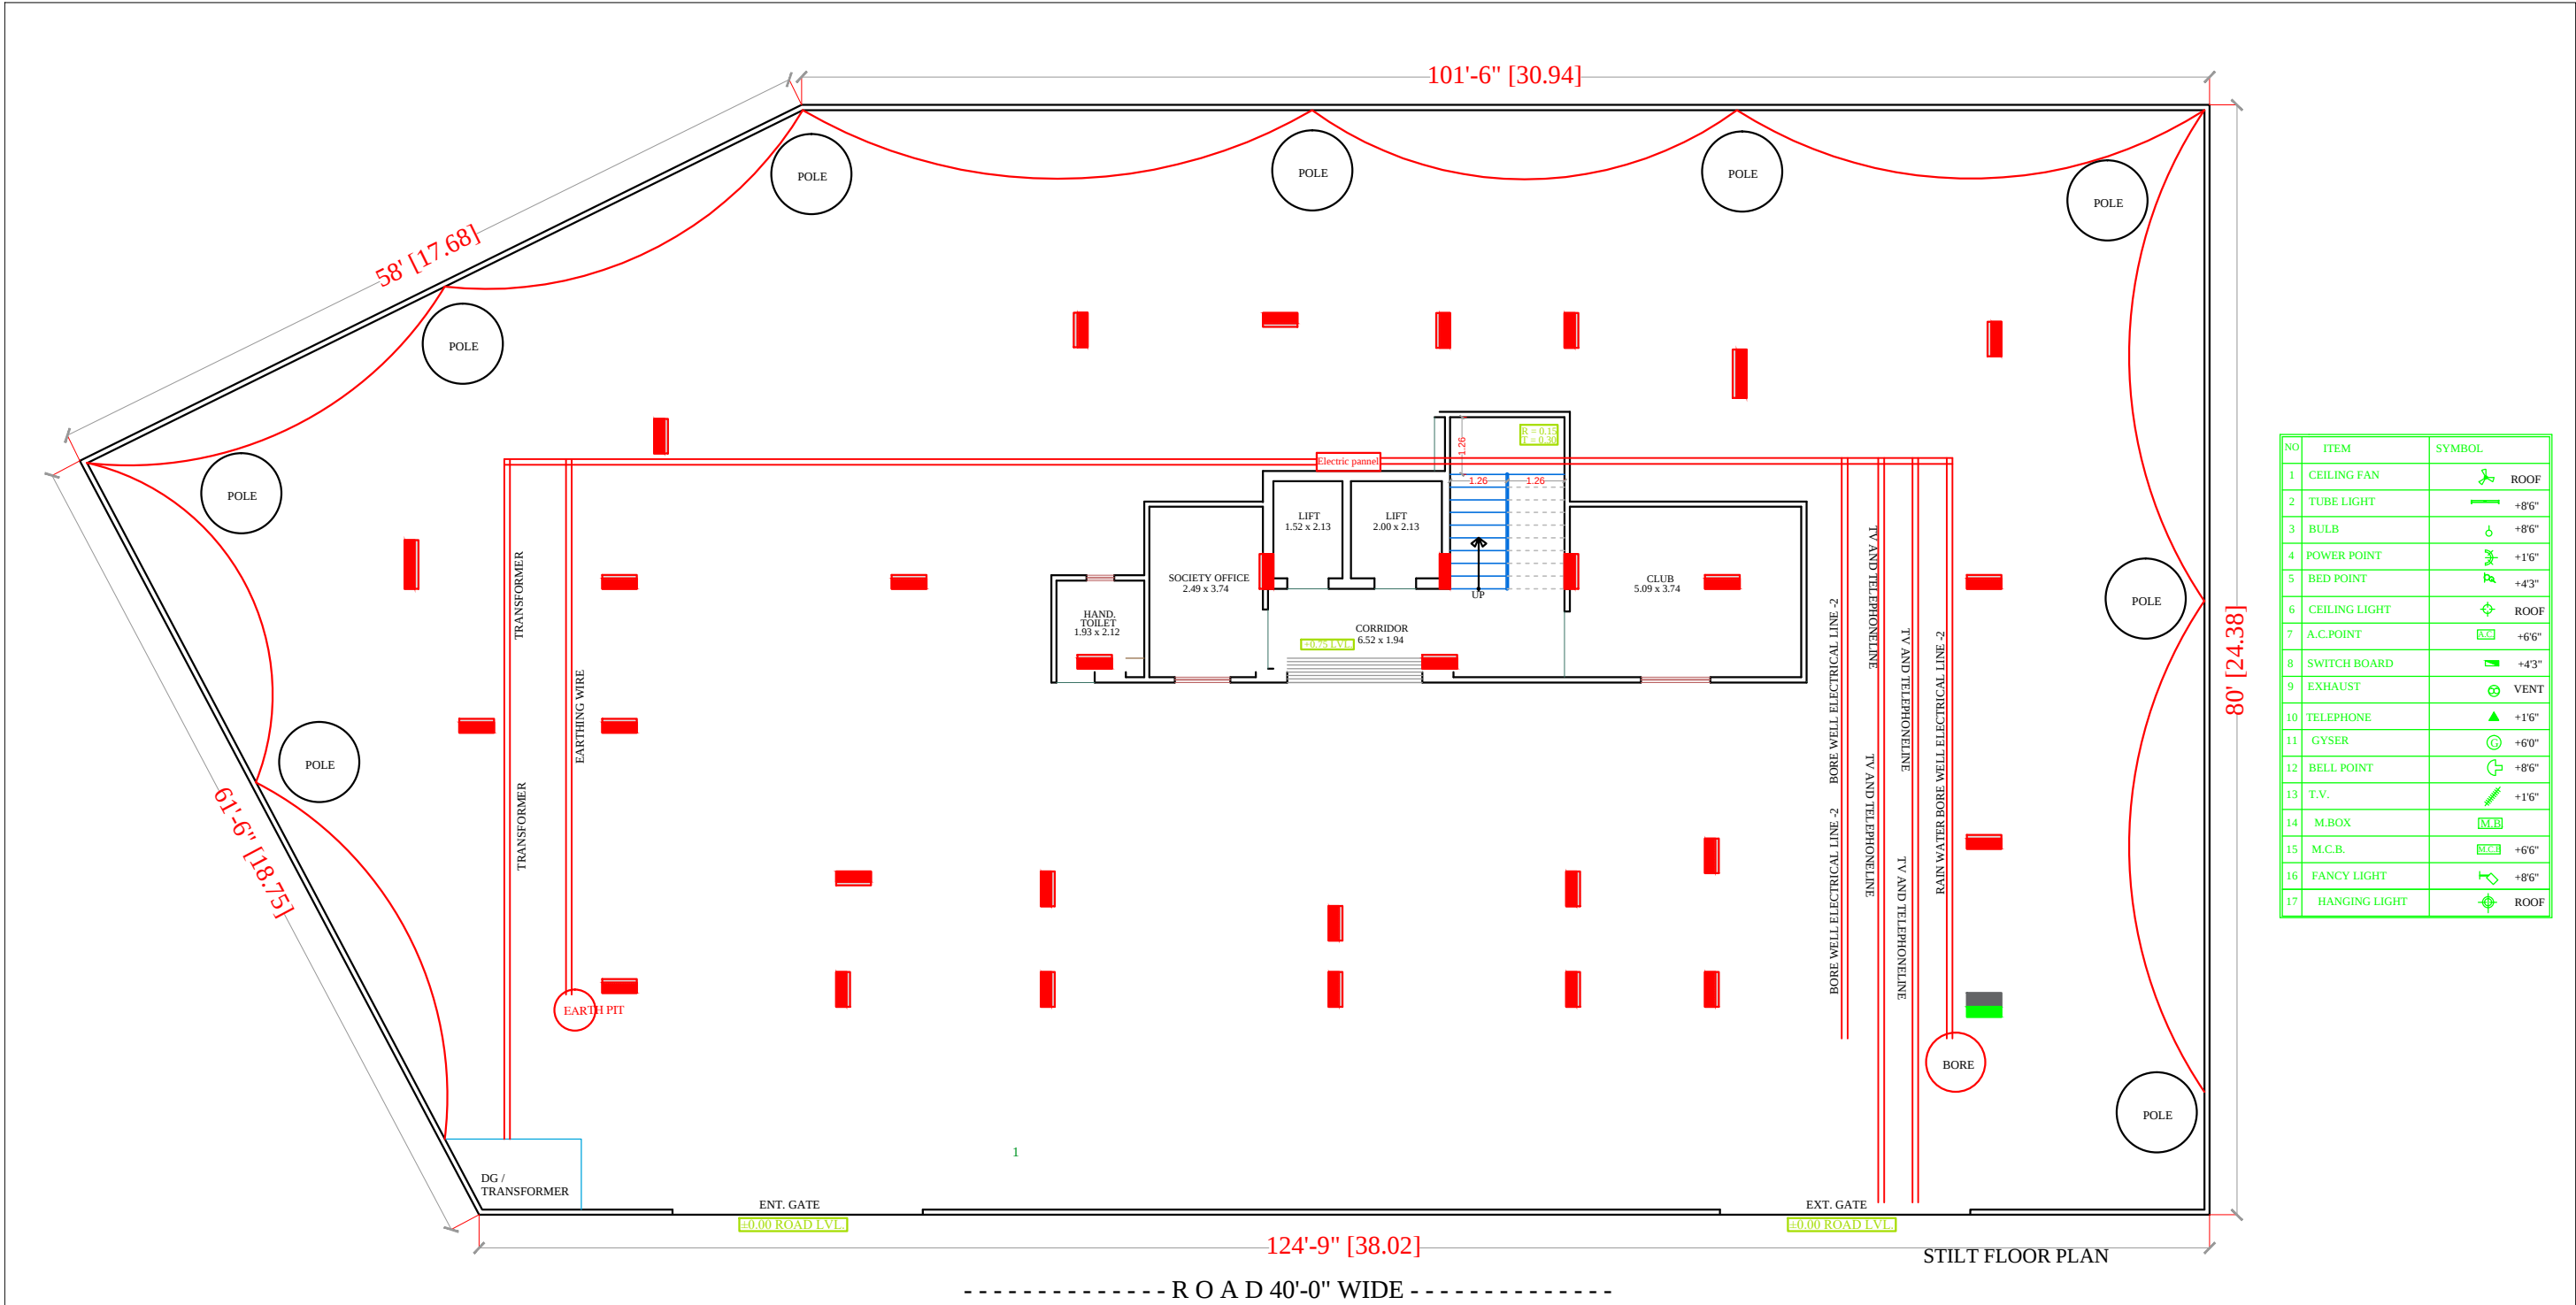

NO	ITEM	SYMBOL
1	CEILING FAN	ROOF
2	TUBE LIGHT	+8'6"
3	BULB	+8'6"
4	POWER POINT	+1'6"
5	BED POINT	+4'3"
6	CEILING LIGHT	ROOF
7	A.C.POINT	+6'6"
8	SWITCH BOARD	+4'3"
9	EXHAUST	VENT
10	TELEPHONE	+1'6"
11	GYSER	+6'0"
12	BELL POINT	+8'6"
13	T.V.	+1'6"
14	M.BOX	M.B
15	M.C.B.	M.C.B +6'6"
16	FANCY LIGHT	+8'6"
17	HANGING LIGHT	ROOF

STILT (PARKING) FLOOR PLAN

PROJECT TITLE :- PROPOSED BUILDING AT PLOT NO.54, 55 & 56, NANDAN RESIDENCY, MURLIPURA JAGATPURA, JAIPUR	BUILDING NAME TOWN SQVARE V	DRAWING TITLE :- SERVICE DRAWING SLD/DISTRIBUTION AFTER LT PANEL, EARTHING LAYOUT,EXTERNAL LIGHTING PLAN, TV & TELEPHONE RISER,LIGHTING ARRESTR, & PIT LOCATION COMMON AREA TRANSFORMER	SPACE CONSULTANT PLOT-A-173, JAGDAMBA NAGAR, HEERAPURA POWER HOWER, JAIPUR (RAJ) 302024	DRN. BY		DATE	NORTH
	DEVELOPER NAME CM BUILDERS			APPD. BY		REVISION	
				SCALE			

RAMESH KUMAWAT
M.E.P. CONSULTANT
B.E. CIVIL

M/s C M BUILDERS
PARTNER

