



WATER SUPPLY LEGEND:-	
	VALVE
	DWS-DOMESTIC WATER SUPPLY
	FWS-FLUSHING WATER SUPPLY
	R.C.C. HUME PIPE FOR ROAD CORISING
	COLD WATER SUPPLY (FROM MUNICIPALITY)
	IRRIGATION LINE FROM S.T.P.
	GARDEN HYDRANT
	WATER METER
	BUTTERFLY VALVE CHAMBER

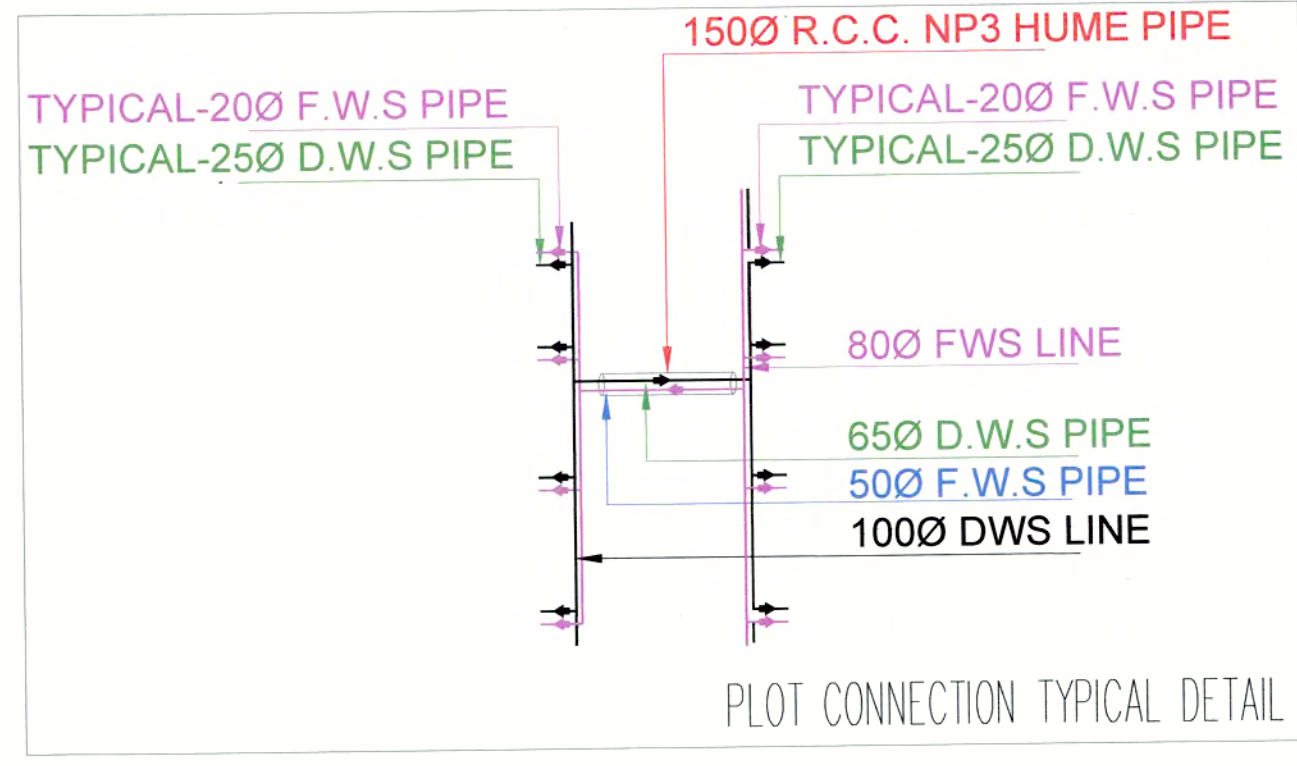

SOMANATH BEHERA
B. TECH CIVIL
MEP CONSULTANT

PLUMBING & FIRE FIGHTING CONSULTANT: BEHERA ASSOCIATES PVT.LTD F-623A, LADO SARAI BEHIND ONG FILLING STATION NEW DELHI - 110030 PH: 011-40583898 MOB: 9811911853 EMAIL: behera.associates@gmail.com	
rev. no. date revision	
PROJECT: Direction	
Promoter Name: Verat Technoplast Private Limited Project Name: City Greens Project Address: Khasra No. 618, Revenue Village-Kumdesar, Bikaner-334003	
DRG. TITLE: SITE PLAN (WATER SUPPLY LAYOUT)	
DRG/ NO. PL/BA-H-B-01C	
OWNER:	
drawing released for ☐ APPROVAL ☐ G.F.C. ☒ SUBMISSION ☐ CONSTRUCTION	
scale:- A1 - 1:500 date:- 07-05-24	
drawn by:- RAJ ckd by:- S.BEHERA	

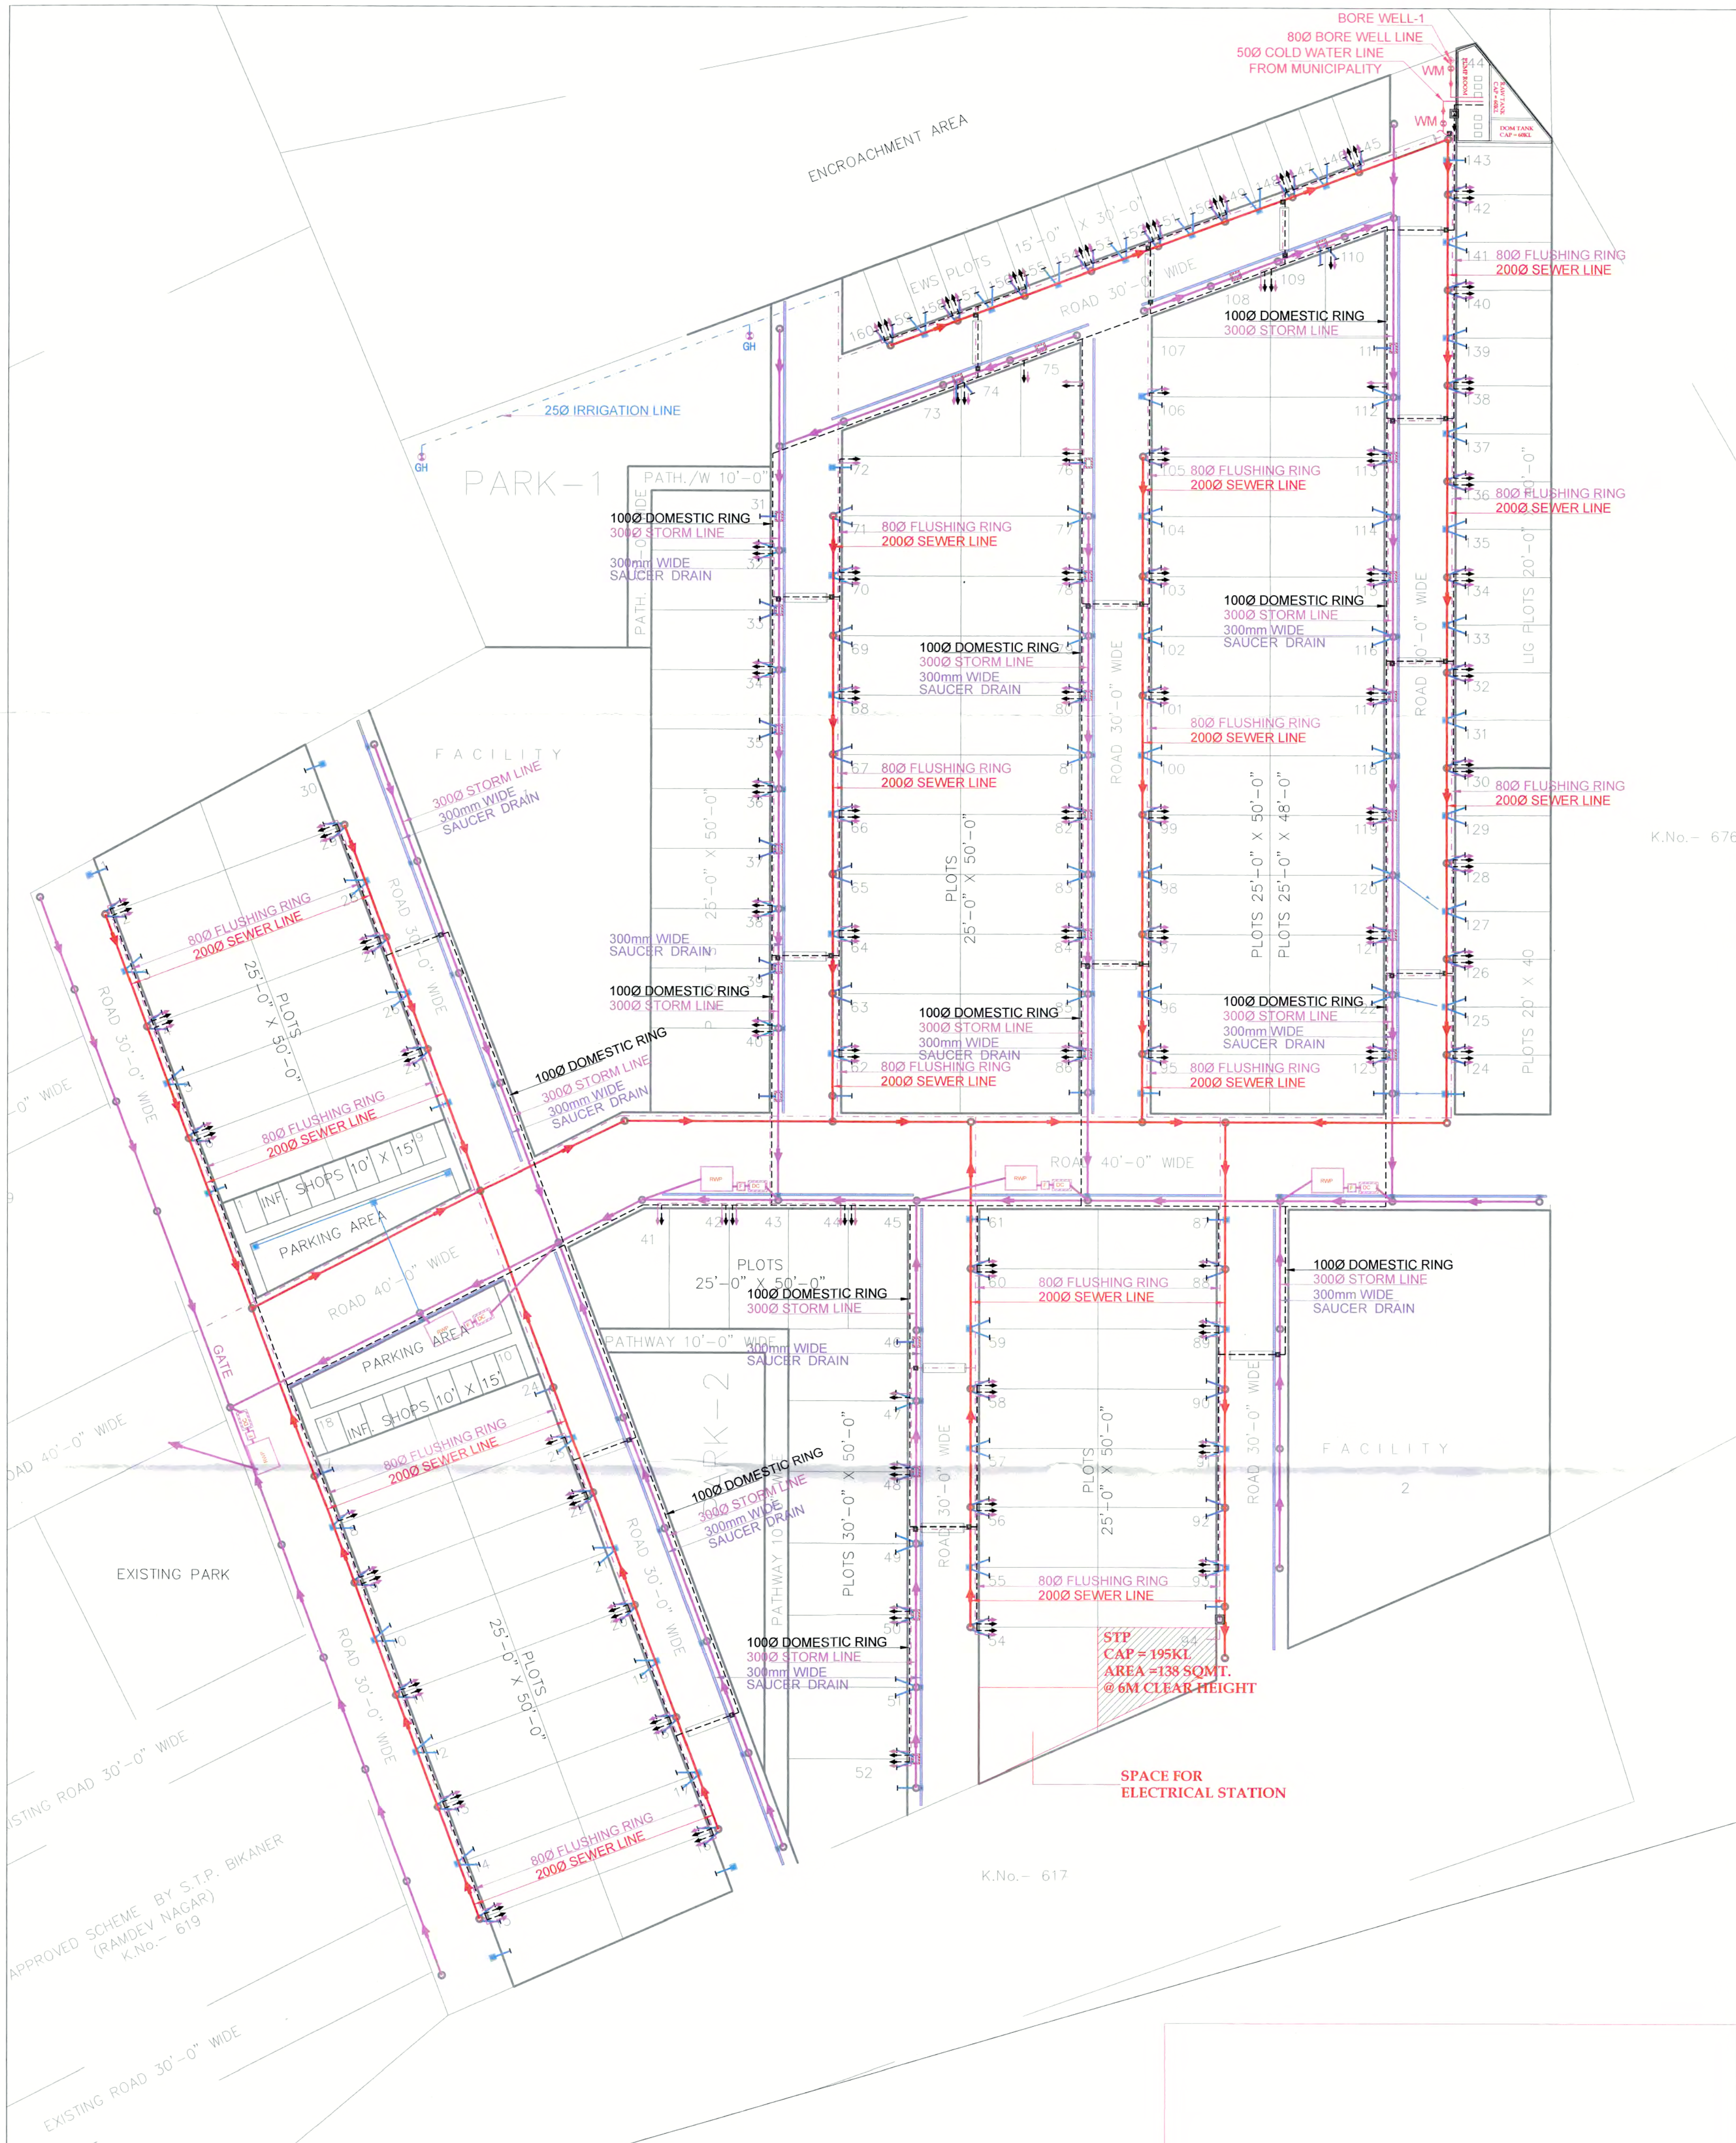

PLUMBING LEGEND:-

	SEWER MANHOLE(910mm & ABOVE)
	SEWER MANHOLE
	SW-SEWER LINE
	1500mm SOIL & WASTE WATER PIPE(FROM PLOT)

SEWER MANHOLE SIZE :-

DIA OF M.H	DEPTH OF MH
910mm Dia	900 TO 1650
1220mm Dia	1650 TO 2300
1520mm Dia	2300 & ABOVE

PLUMBING LEGEND:-

	STORM MANHOLE(910mm & ABOVE)
	STORM CATCH BASIN
	ST- STORM WATER LINE
	1500mm RAIN WATER PIPE(FROM PLOT)
	RAIN WATER HARVESTING PIT
	CATCH DRAIN (450x300mm)

PLUMBING NOTE FOR STORM WATER :-


CATCH BASIN SIZE (MM)	DEPTH OF CB (MM)
CB - 600 X 600 mm	600 - 750 mm
CB - 750 X 750 mm	750 TO 900 mm

Plumbing Note :-

DIA OF M.H	DEPTH OF MH
910mm Dia	900 TO 1650
1220mm Dia	1650 TO 2300
1520mm Dia	2300 & ABOVE

WATER SUPPLY LEGEND:-

	VALVE
	DWS-DOMESTIC WATER SUPPLY
	FWS-FLUSHING WATER SUPPLY
	R.C.C. HUME PIPE FOR ROAD CORISING
	COLD WATER SUPPLY (FROM MUNICIPALITY)
	IRRIGATION LINE FROM S.T.P.
	GARDEN HYDRANT
	WATER METER
	BUTTERFLY VALVE CHAMBER

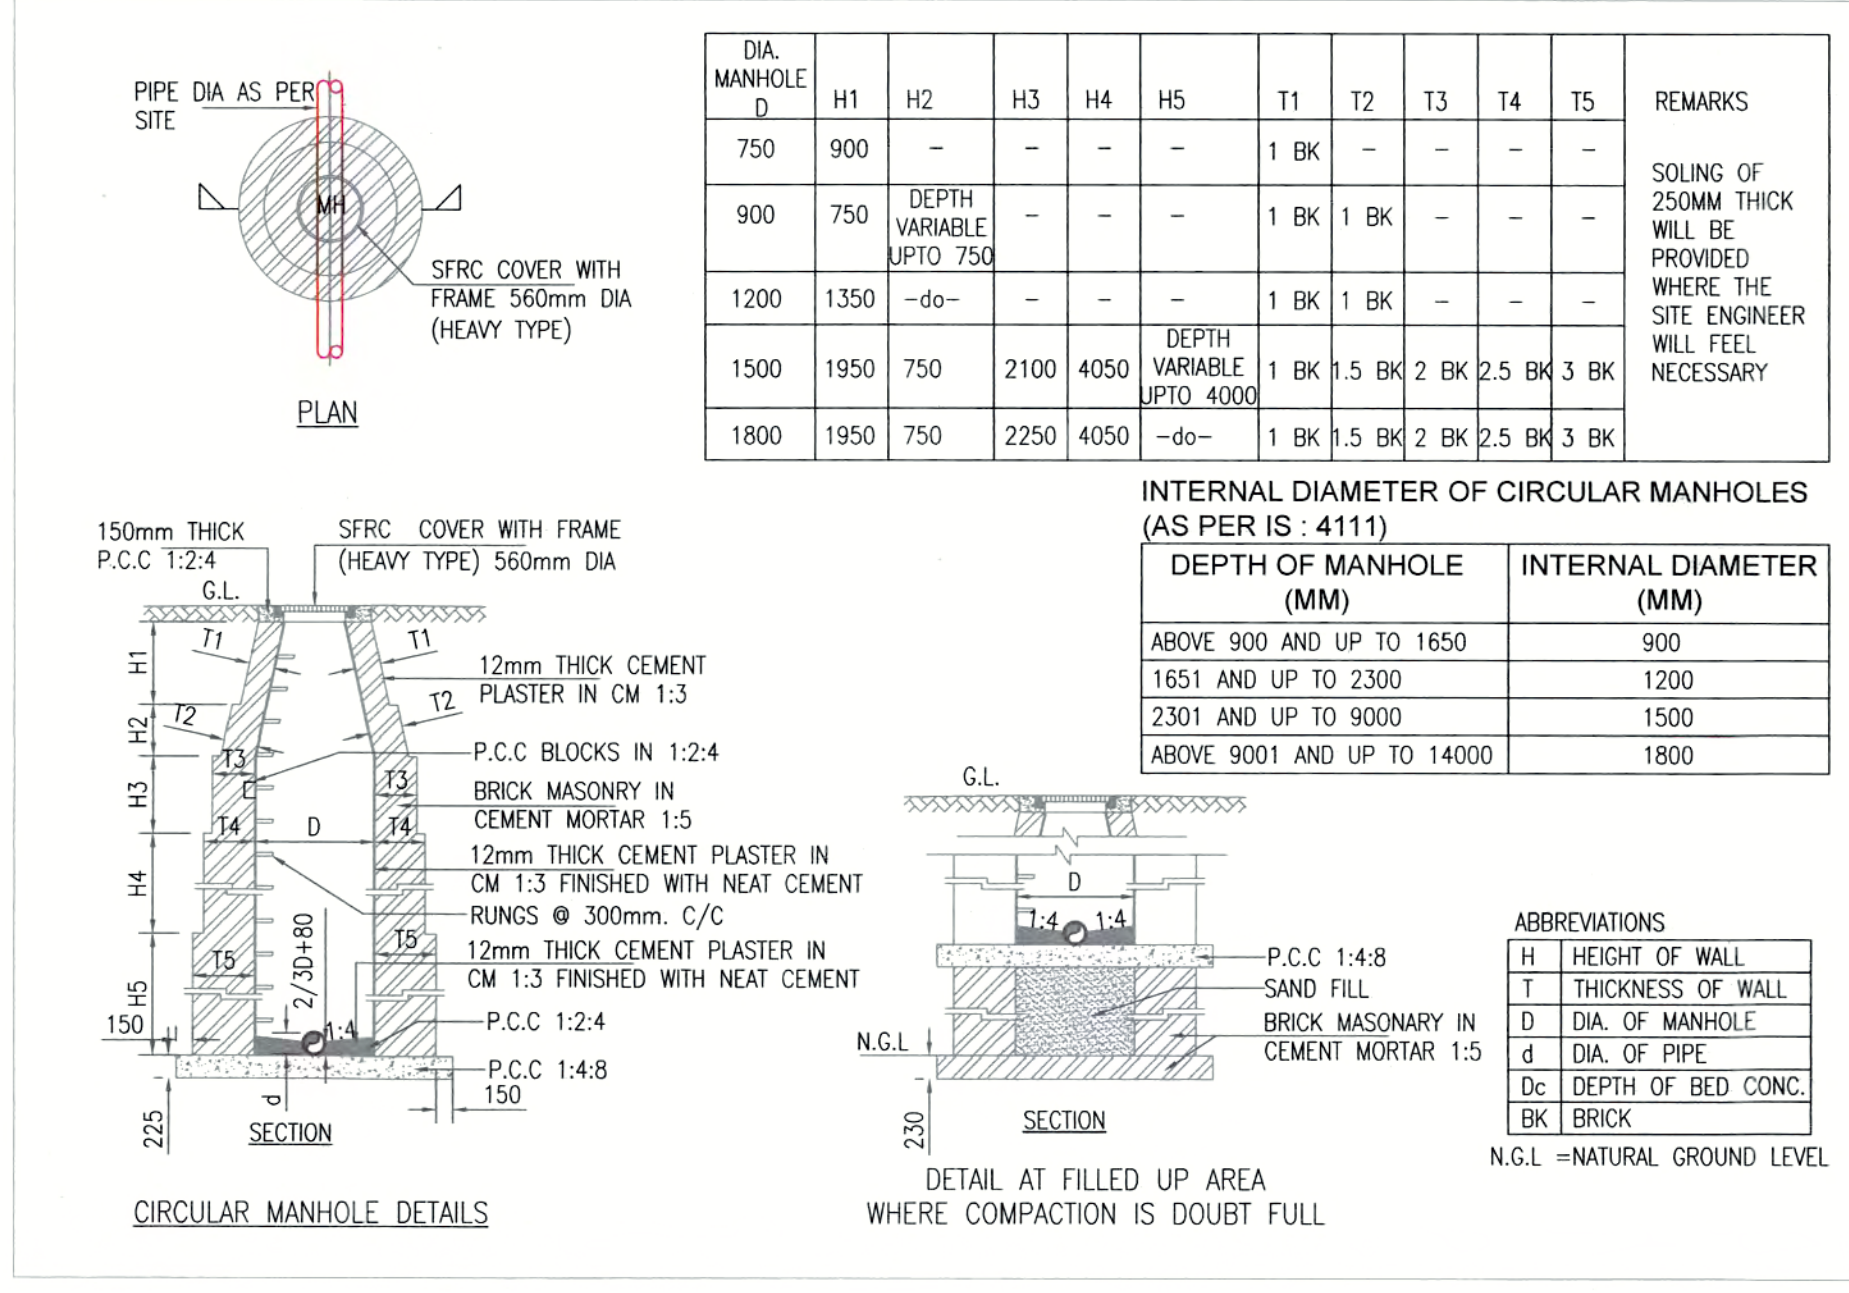

SOMANATH BEHERA
B. TECH CIVIL
MEP CONSULTANT

PLUMBING & FIRE FIGHTING CONSULTANT:

BEHERA ASSOCIATES PVT.LTD
F-623a, LADO SARAI
BEHIND ONG FILLING STATION
NEW DELHI - 110030
PH-011-40583898 MOB:9811911853
EMAIL-behera.associates@gmail.com

PROJECT:

Promoter Name: Veral Technoplast Private Limited
Project Name: City Greens
Project Address: Kharsa No. 618, Revenue Village-Khimdisar, Bikaner-340003

DRG. TITLE:

SITE PLAN

DRG/ NO. PL/BA/H-B-01

OWNER:

drawing released for

APPROVAL SUBMISSION G.F.C. CONSTRUCTION

scale:- A1 - 1:500 date:- 07-05-24

drawn by:- RAJ ckd by:- S.BEHERA