


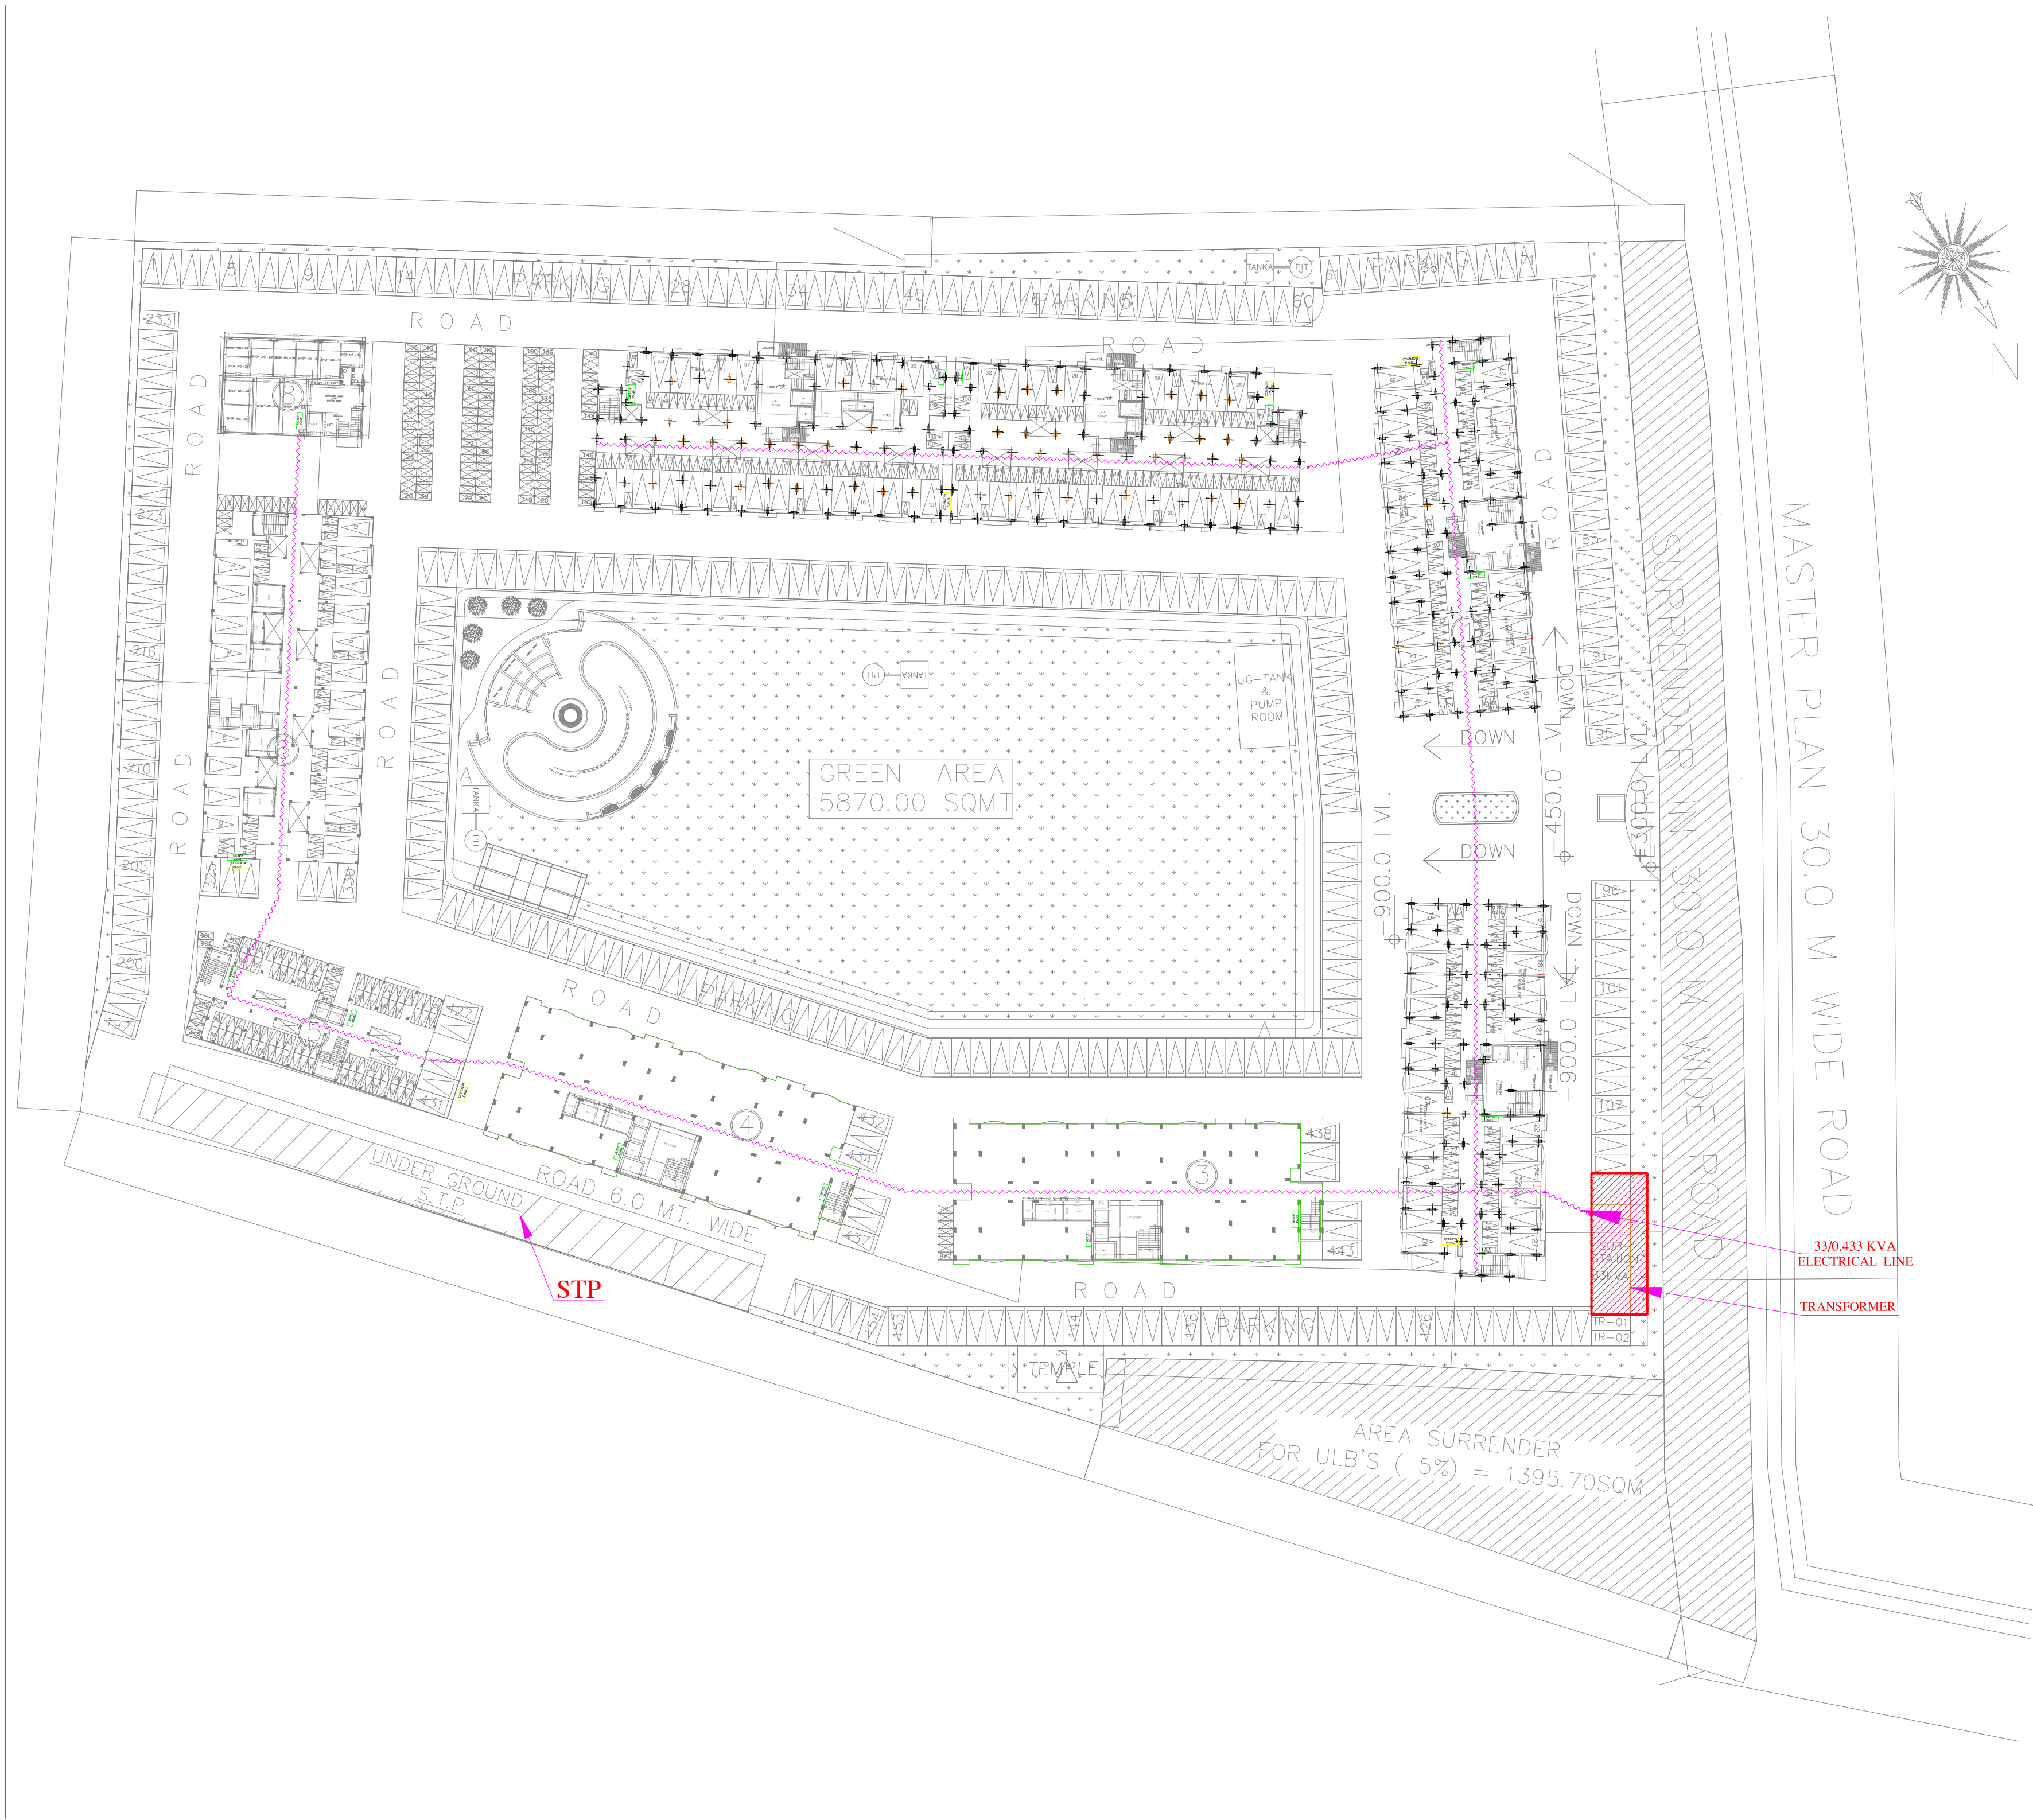

METER
PANEL

METER PANEL

COMMON
PANEL

COMMON PANEL

CABLE TRENCH

CABLE TRENCH

LT Room &
Transformer

LT Room &
Transformer

Karan Kamra
B.Tech (Service Consultant)

CONSULTANT:-

**KASHVI
BUILDING SERVICES CONSULTANTS**
B-101, II Floor side Ganesh Nagar, New
Delhi-110018
Engg : KARAN KAMRA (B.Tech, CIVIL)
Email-kk.241338@gmail.com

DRAWING TITLE:-

ELECTRICAL LAYOUT PLAN

CLIENT:-

TREHAN APNA GHAR PVT. LTD.
290, NAYA-BASS, ALWAR. RAJASTHAN
Alwar Office: C/O PHOOL BAGH SERVICE STATION
NEAR CIRCUIT HOUSE, ALWAR. Tel. 0144-3241400

PROJECT:-

TREHAN VILASA HEIGHTS
KHASRA NO :- **1205, 1206** AT
VILLAGE PIPLI, NEEMRANA, TEH.- BEHROR
DISTT.-ALWAR (RAJ.)

DATE:-

SCALE:-

N.T.S