


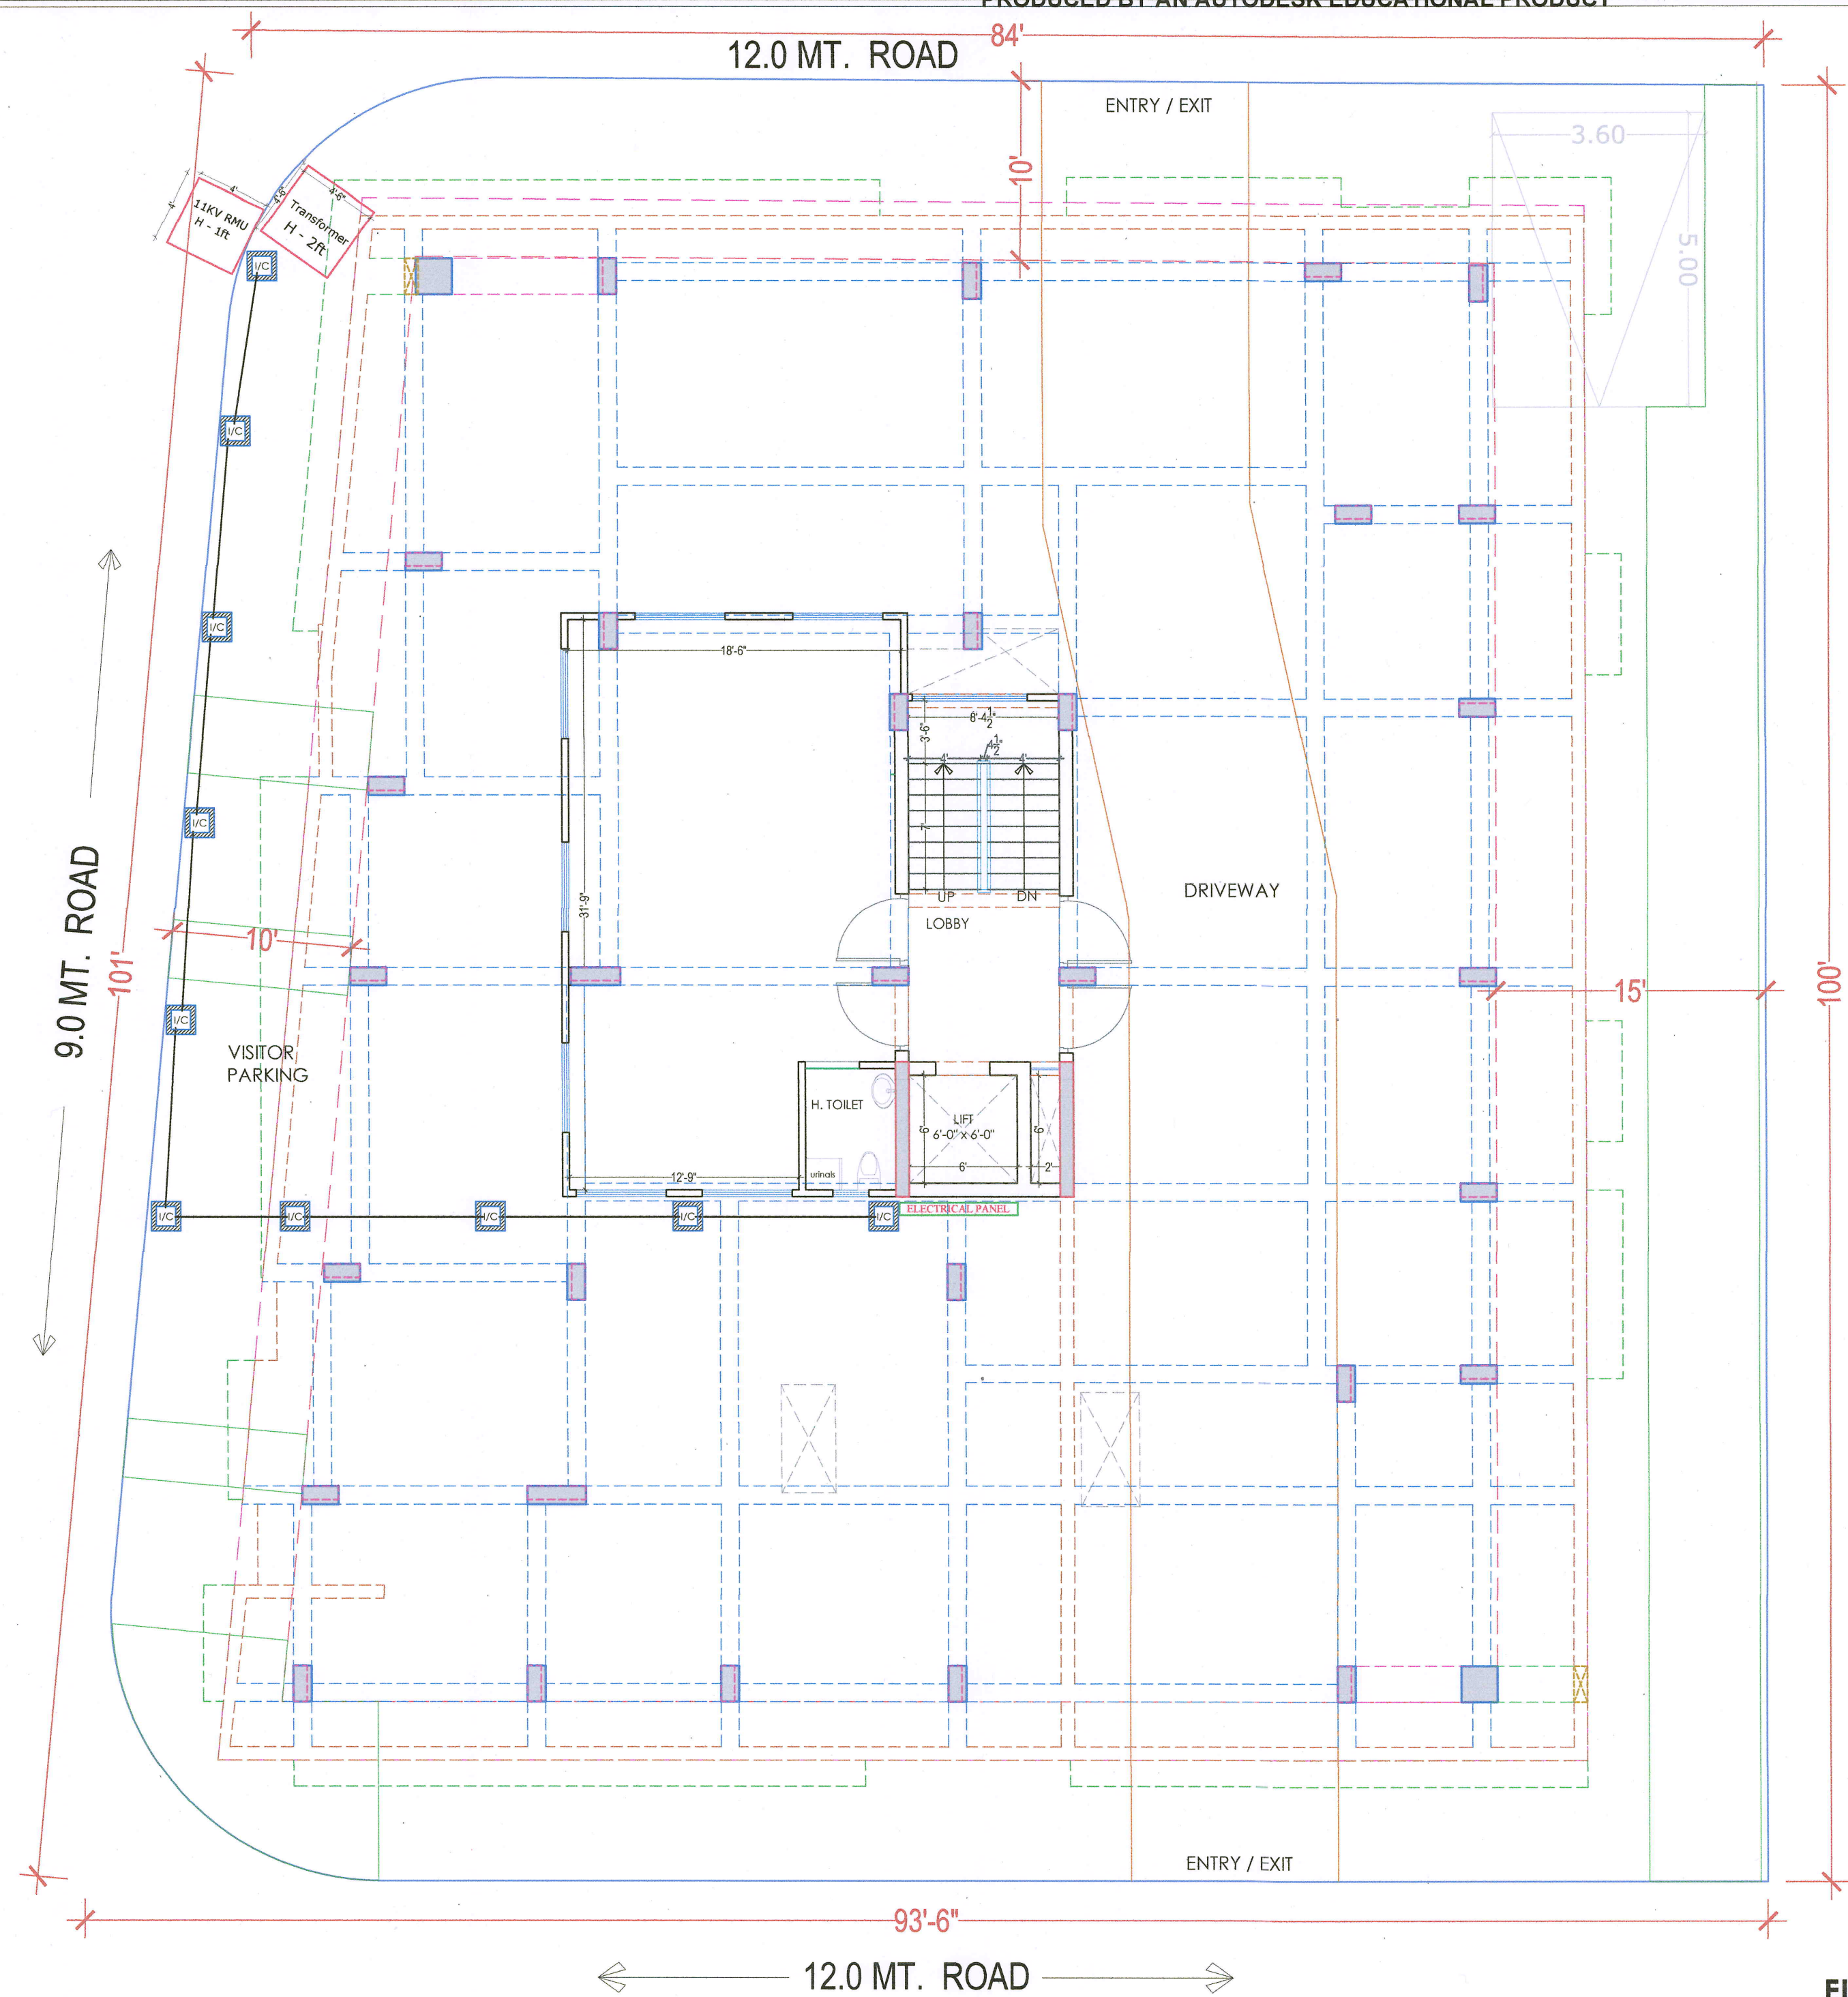

LEGENDS:			
Mounting Height	I D	Symbol	Description
CEILING	FAN/48"		CEILING FAN 48"
CEILING	FAN/30"		CEILING FAN 30"
CEILING	CHI		CHANDELIER
+93"	TL/W		Led Wall Tube Light Make:- Syka Led Cat no:- SSK-15-20W
+93"	BULB		Led Bulb 20W Make:- Syka Led Cat no:- SKC-20W 5.7K/3K
+93"	GL		WALL BRACKETS AS DESIGN FOR GANESH LIGHT
+78"	ML		12x2 Led Mirror Light Make:- Syka Led Cat no:- FPL-12x2
CEILING	DL		Led 6" Down Lighter 20W (Surface Mounted) Make:- Syka Led Cat no:- SDL-15W GLD 6.5K/4K
VENTILATOR HT.	CR		CEILING ROSE
VENTILATOR HT.	EXF		9" DIA FRESH AIR FAN
+24"	2wSB		2w SWITCH BOARD
+42"	SB		SWITCH BOARD(6A SOCKET & SWITCH)
+24"	TEL		TELEPHONE POINT
+24"	LP TEL		6 A PLUG POINT FOR TELEPHONE
+48"	TV		TV COAXIAL POINT
+48"	LP TV		6 A PLUG POINT FOR TV
+24"	LP		6 A PLUG POINT FOR SIDE TABLE
+72"	LP-CH		6 A PLUG POINT FOR CHIMNEY
+12"	LP-PC		6 A PLUG FOR COMPUTER POINT
+93"	SAC		SPLIT AC INDOOR UNIT
+42"	PP-MIX		16 A POWER POINT FOR MIXER
+42"	PP-MIC		16 A POWER POINT FOR MICROWAVE
+78"	PP-G		16 A POWER POINT FOR GEYSER
+54"	PP-F		16 A POWER POINT FOR FRIDGE
+78"	PP-WP		16 A POWER POINT FOR WATER PURIFIER
+48"	PP-WM		16 A POWER POINT FOR WASHING MACHINE
+12"	PP-INV		16 A POWER POINT FOR INVERTOR
+93"	PP-AC		25A SWITCH/MCB FOR AC
			CHAMBER(2' X 2')
+18"			6A 2 NOS. SOCKET +1 NOS. 16A SWITCH ,TELEPHONE,LAN
+60"	MCB DB		MCB DISTRIBUTION BOARD

M/s SIDDHI VINAYAK HOMES
Narendra
PARTNER

Sharma
Er. SANJEV SHARMA
B.E (Electrical)

STILT FLOOR
ELECTRICAL ROUTE LAYOUT
(TRANSFORMER,RMU,METER PANEL,
ELECTRICAL CABLE)

PROJECT NAME :	
CRYSTAL HEIGHTS	
DEVELOPER NAME :	
SIDDHI VINAYAK HOMES	
S.No	
DATE	
REVISION DESCRIPTION	
GENERAL NOTES :	
1. All dimension on this drawing are in MKS System Only written dimensions are to be followed. drawing should not be scaled.	
2. All measurements must be checked and verified by the contractors prior to execution of work at the site.	
3. This drawing is to be read in conjunction with all relevant structural, services & facility planning drawings.	
4. Architectural drawings are to be followed for the location of all structural members & masonry walls, for sizes & reinforcement details of structural members, relevant structural drawings are to be referred.	
5. Any discrepancies between architectural, structural and services drawings must be brought to the notice of the architects immediately & prior to execution at site.	
6. Co-ordinate with services such as hvac, plumbing & electrical, etc. is the responsibility of the contractors.	
7. All masonry walls should be aligned with the columns as indicated on the plan, irrespective of the position as calculated with the dimensioning.	
8. For details, refer relevant large scale detail dgs. as indicated.	
PROJECT:	
PROPOSED RESIDENTIAL FLATS ON P. NO.- 115, 116, 117, 118, 119 & 120 SCHEME- GANESH NAGAR -B, JAIPUR	
NAME OF DRAWING: STILT FLOOR ELECTRICAL ROUTE LAYOUT (TRANSFORMER,RMU,METER PANEL, ELECTRICAL CABLE)	
DRAWING WORKING DRAWING	NORTH:
PROJECT NO. :	DATE : 01, Jan. - 2024
SCALE : NTS	REV NO. : R-0
DRAWING NO. :	
PROJECT CATEGORY BLOCK FLOOR TYPE NUMBER	
A-01	

PROJECT NAME :
CRYSTAL HEIGHTS
DEVELOPER NAME :
SIDDHI VINAYAK HOMES

LEGENDS:			
Mounting Height	I D	Symbol	Description
CEILING	FAN48"		CEILING FAN 48"
CEILING	FAN30"		CEILING FAN 30"
CEILING	CHI		CHANDELIER
+93"	TL/W		Led Wall Tube Light Make- Syka Led Cat no- SSKC-TS-20W
+93"	BULB		Led Bulb 20W Make- Syka Led Cat no- SKC-20W 5.7K/5K
+93"	GL		WALL BRACKETS AS DESIGN FOR GANESH LIGHT
+78"	ML		12x2 Led Mirror Light Make- Syka Led Cat no- FPL-12x2
CEILING	DL		Led 6" Down Lighter 20W (Surface Mounted) Make- Syka Led Cat no- SDL-15W GLD 6.5K/4K
VENTILATOR HT.	CR		CEILING ROSE
VENTILATOR HT.	EXF		9" DIA FRESH AIR FAN
+24"	2wSB		2w SWITCH BOARD
+42"	SB		SWITCH BOARD (6A SOCKET & SWITCH)
+24"	TEL		TELEPHONE POINT
+24"	LP TEL		6 A PLUG POINT FOR TELEPHONE
+48"	TV		TV COAXIAL POINT
+48"	LP TV		6 A PLUG POINT FOR TV
+24"	LP		6 A PLUG POINT FOR SIDE TABLE
+72"	LP-CH		6 A PLUG POINT FOR CHIMNEY
+12"	LP-PC		6 A PLUG POINT FOR COMPUTER POINT
+93"	SAC		SPLIT AC INDOOR UNIT
+42"	PP-MIX		16 A POWER POINT FOR MIXER
+42"	PP-MIC		16 A POWER POINT FOR MICROWAVE
+78"	PP-G		16 A POWER POINT FOR GEYSER
+54"	PP-F		16 A POWER POINT FOR FRIDGE
+78"	PP-WP		16 A POWER POINT FOR WATER PURIFIER
+48"	PP-WM		16 A POWER POINT FOR WASHING MACHINE
+12"	PP-INV		16 A POWER POINT FOR INVERTOR
+93"	PP-AC		25A SWITCH/ MCB FOR AC
			CHAMBER (2' X 2')
+18"			6A 2 NOS. SOCKET +1 NOS. 16A SWITCH, TELEPHONELAN
+60"	MCB DB		MCB DISTRIBUTION BOARD


- GENERAL NOTES :
- All dimension on this drawing are in MKS System Only written dimensions are to be followed. drawing should not be scaled.
 - All measurements must be checked and verified by the contractors prior to execution of work at the site.
 - This drawing is to be read in conjunction with all relevant structural, services & facility planning drawings.
 - Architectural drawings are to be followed for the location of all structural members & masonry walls, for sizes & reinforcement details of structural members, relevant structural drawings are to be referred.
 - Any discrepancies between architectural, structural and services drawings must be brought to the notice of the architects immediately & prior to execution at site.
 - Co-ordination with services such as hvac, plumbing & electrical, etc. is the responsibility of the contractors.
 - All masonry walls should be aligned with the columns as indicated on the plan, irrespective of the position as calculated with the dimensioning.
 - For details, refer relevant large scale detail drgs. as indicated.

PROJECT:
PROPOSED RESIDENTIAL FLATS ON
P. NO.- 115, 116, 117, 118, 119 & 120
SCHEME- GANESH NAGAR -B,
JAIPUR

NAME OF DRAWING: **STILT FLOOR
CEILING ELECTRICAL LAYOUT,
ELECTRICAL POINT DRAWING**

DRAWING WORKING DRAWING	NORTH:
PROJECT NO. :	DATE : 01, Jan. - 2024
SCALE : NTS	REV NO. : R-0

DRAWING NO. :
PROJECT CATEGORY BLOCK FLOOR TYPE NUMBER
A-01

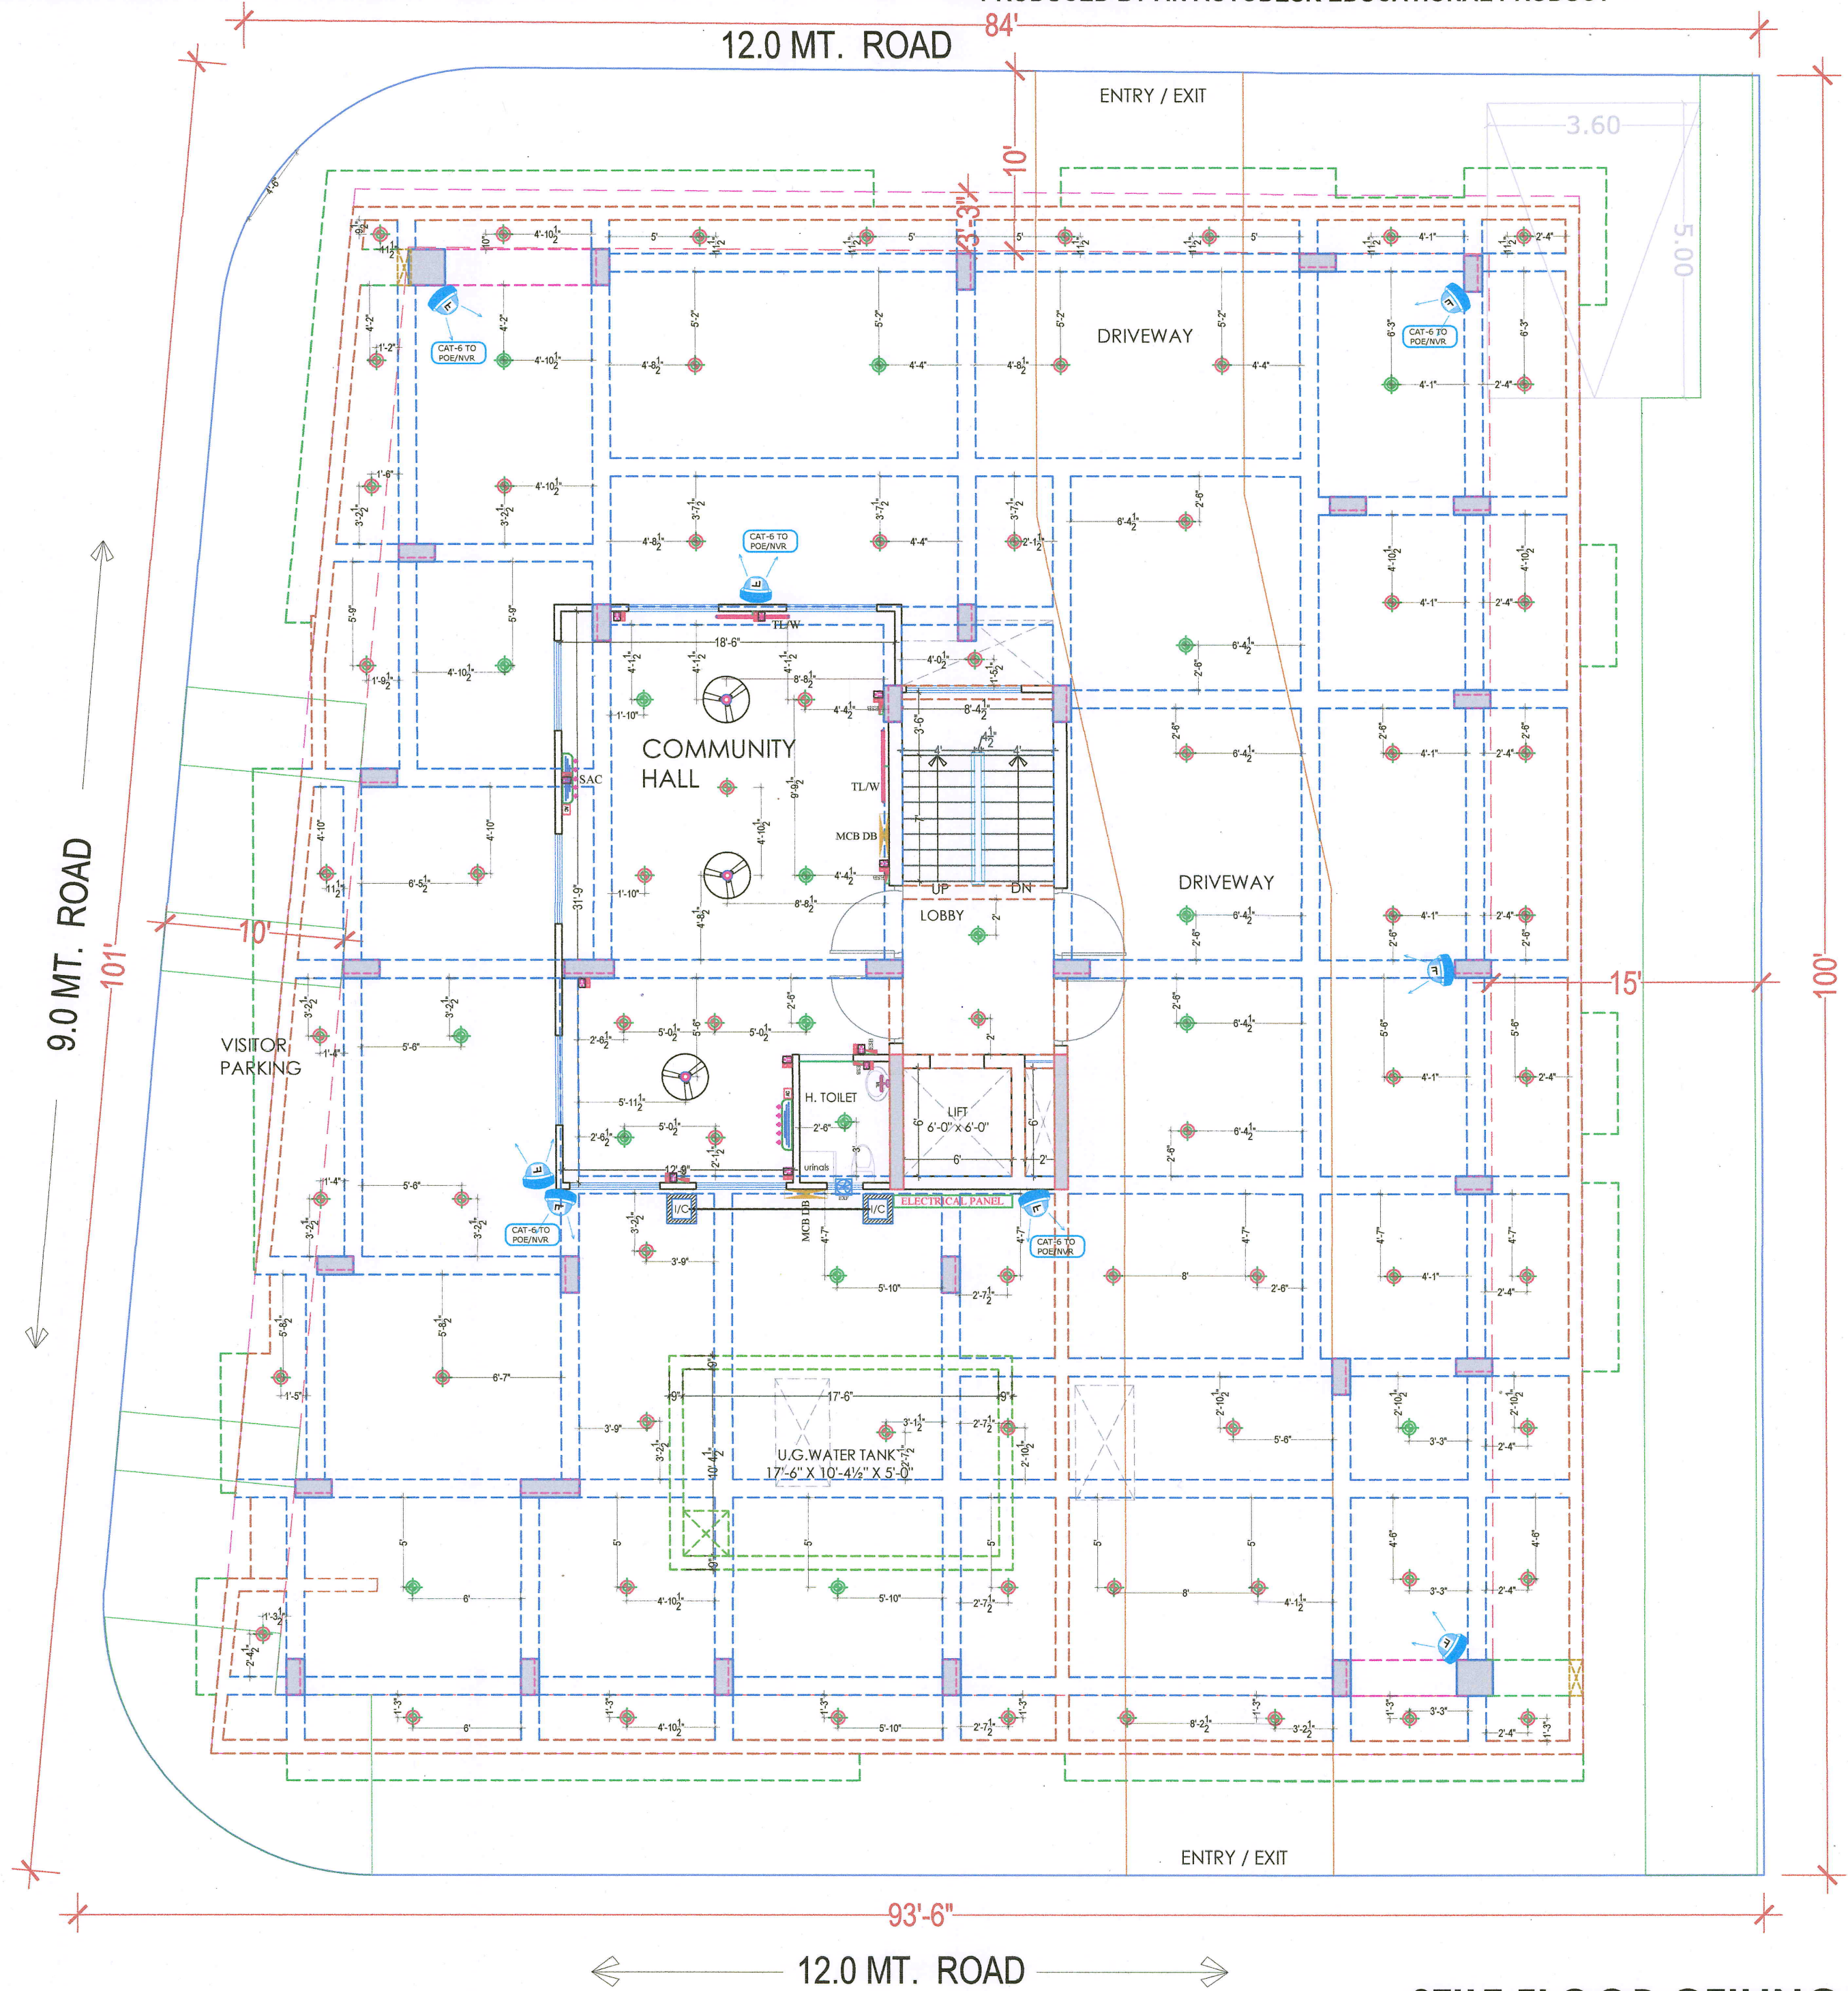

STILT FLOOR CEILING ELECTRICAL LAYOUT,
ELECTRICAL POINT DRAWING