


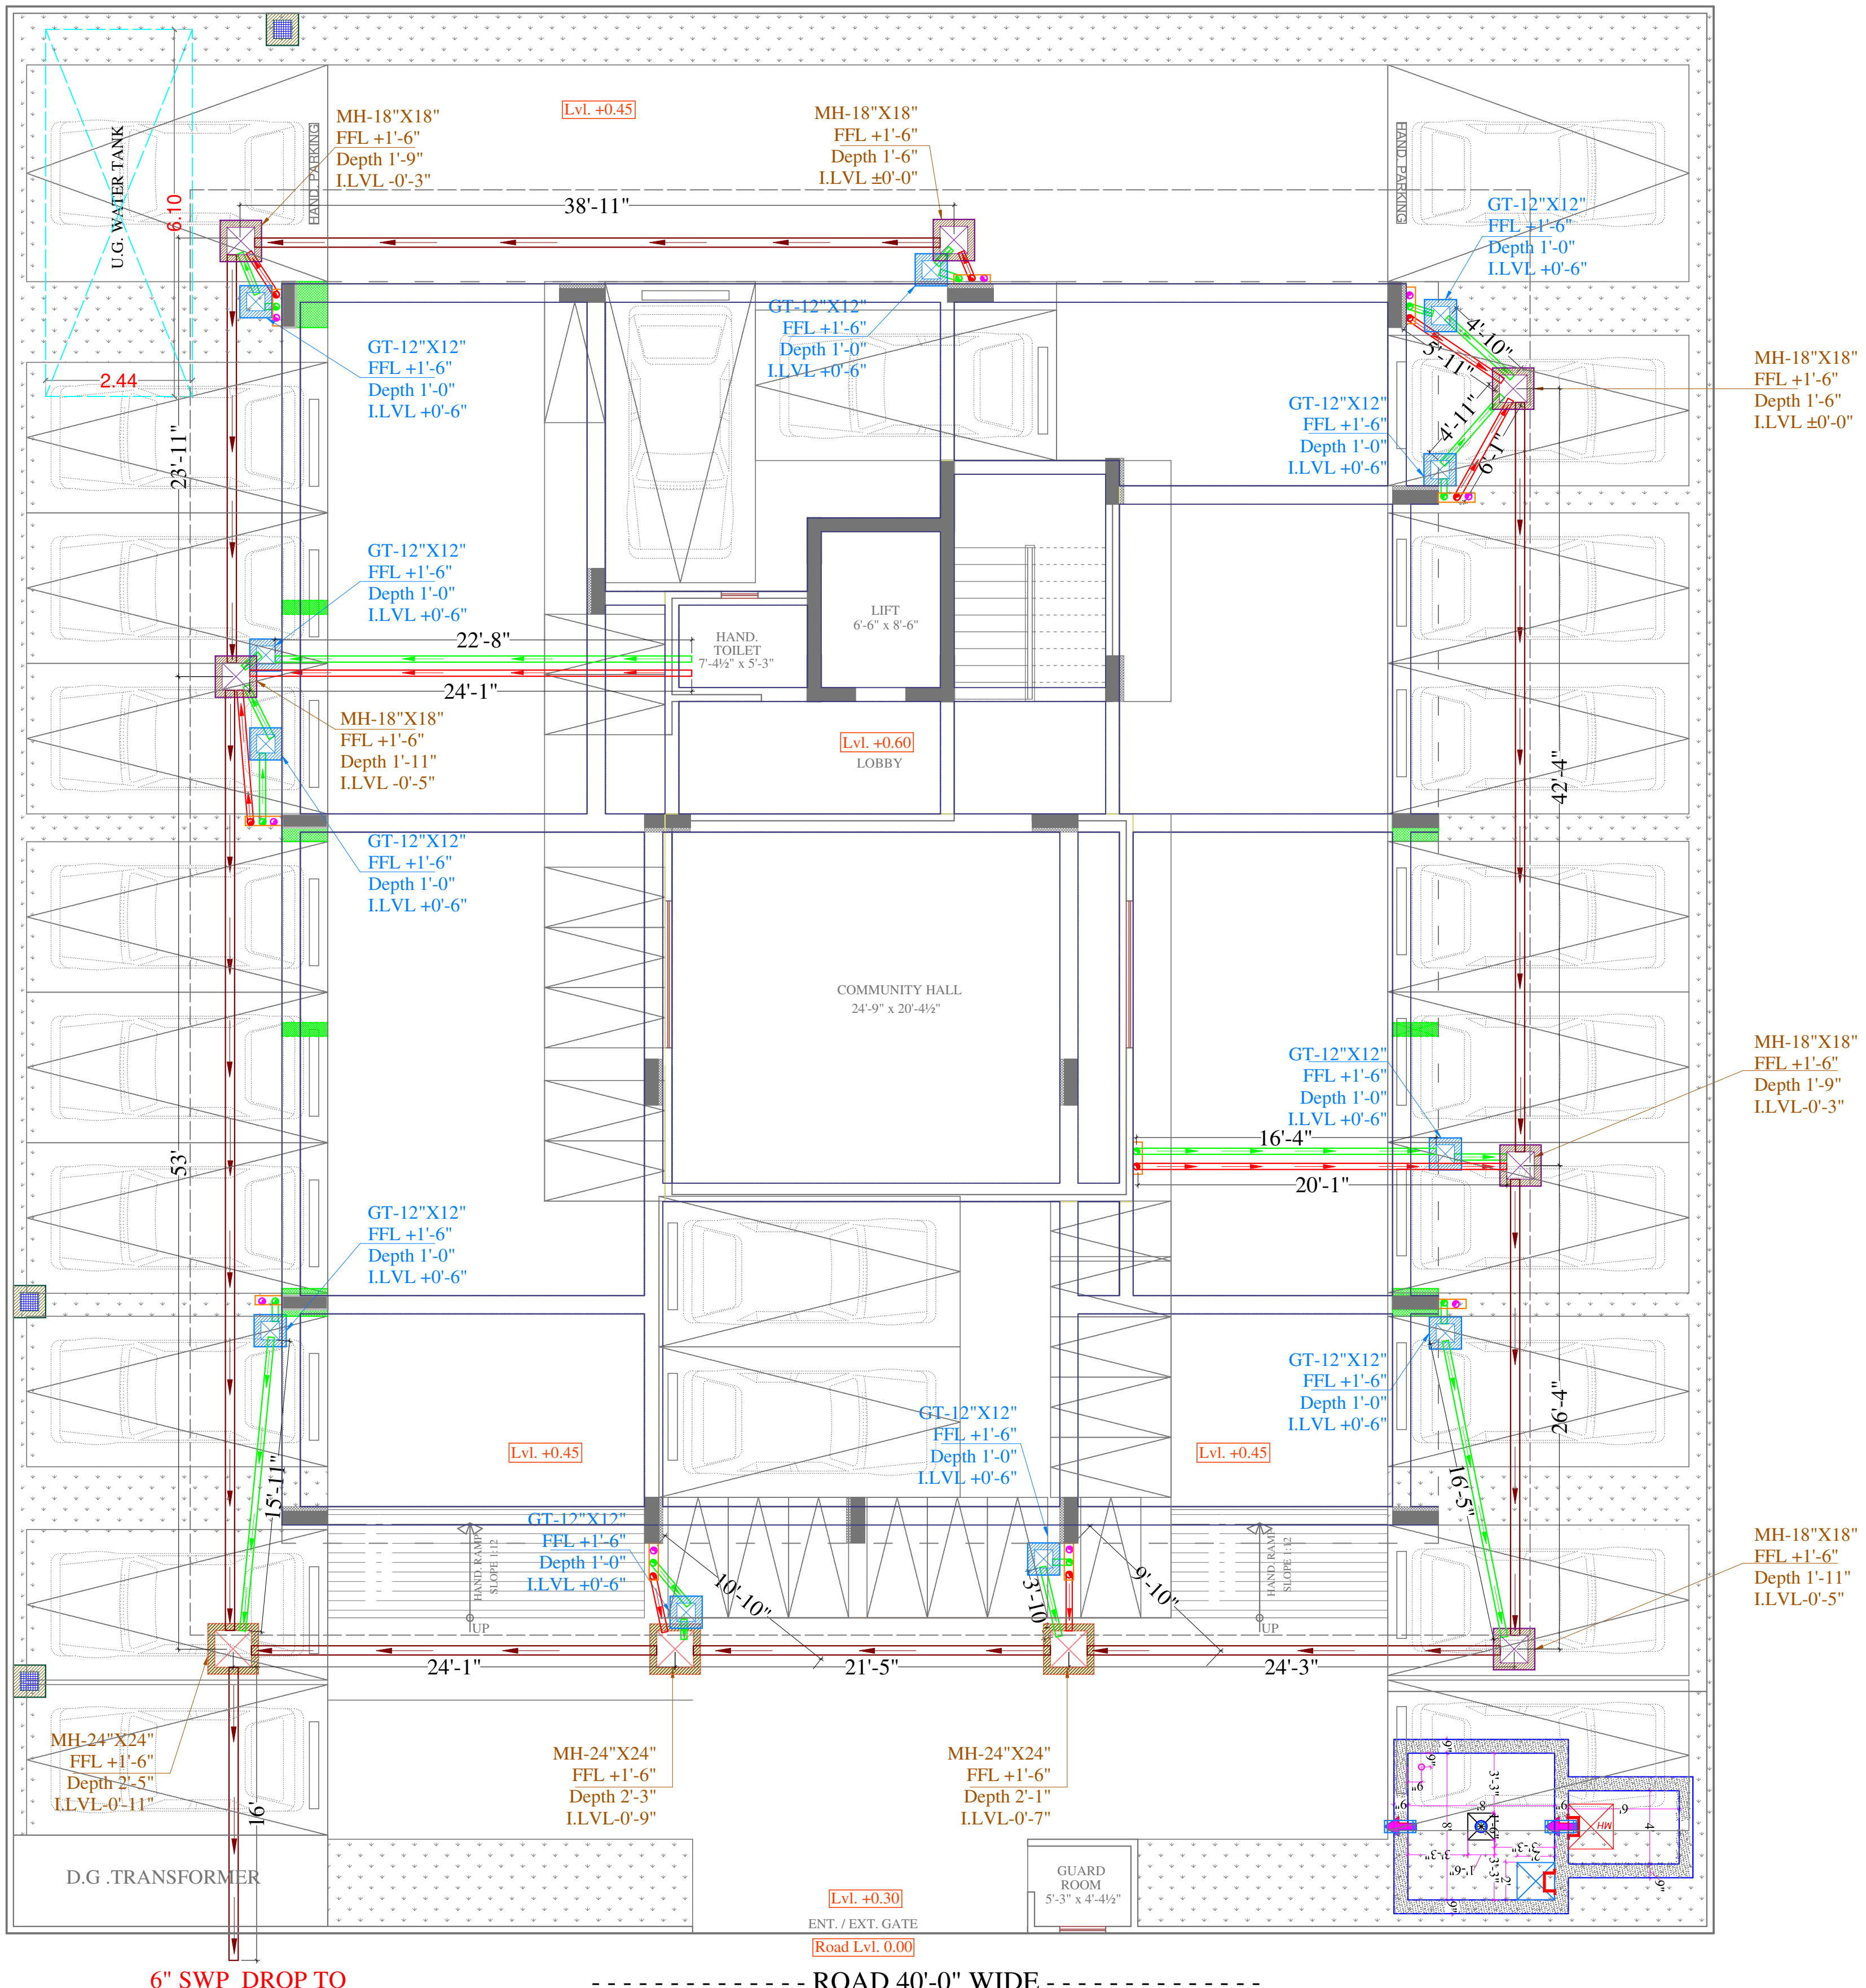

6" SWP DROP TO OUTSIDE AS PER SITE CONDITION

----- ROAD 40'-0" WIDE -----

STILT FLOOR PLAN

SYMBOL	DESCRIPTION
	110 mm Soil Waste Water Pipe
	110 mm Waste Water Pipe
	110 mm Rain Water Pipe
	160 mm Soil Waste Water Pipe Slope 1:200
	110 mm Soil Waste Water Pipe Slope 1:150
	110 mm Waste Water Pipe Slope 1:150
	Gully Trap-300X300mm Depth According to Slope
	Main Hole-450X450mm Depth According to Slope
	Main Hole-600X600mm Depth According to Slope
	Flow Direction

SERVICES CONSULTANT:
ASHI ASSOCIATES
F 9 / 440 , Keshav Marg Chitrakut Scheme,Jaipur
PH:91-0-93146-10438 ,0141-2440946
Mail:vipul8599@yahoo.com

Vipul
VIPUL AGARWAL
M.E.P. CONSULTANT
B.E. ELECTRICAL

DEVELOPER: OM BUILDERS & DEVELOPERS	
PROJECT OM SHIVANTA	
DRG. TITLE:- EXTERNAL SEWERAGE WATER PIPE ROUTE PLAN	
DATE : 07-05-2024	SCALE : N.T.S
Drawn By:- SNEHA	
Checked By:- SANJAY	
APPD By:- VIPUL AGARWAL	

ARCHITECT :-
SPACE GRID
C-49,VIDYA APARTMENT,PARAS MARG,
BAPU NAGAR,NEAR JANTA STORE
CIRCLE, JAIPUR-302015
PH-09314918766,0141-4005506 (O)
Email:-info.spacegrid@gmail.com