



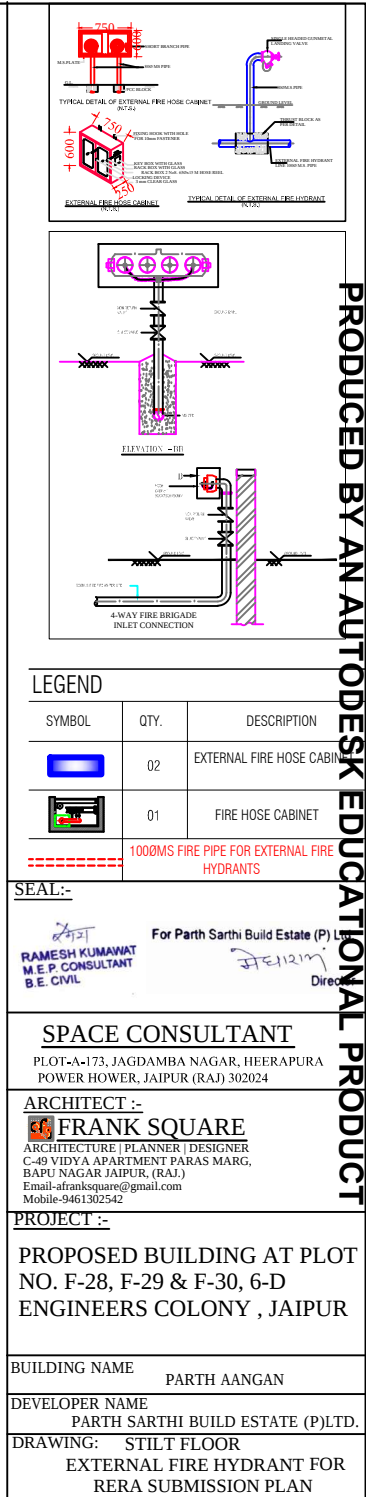



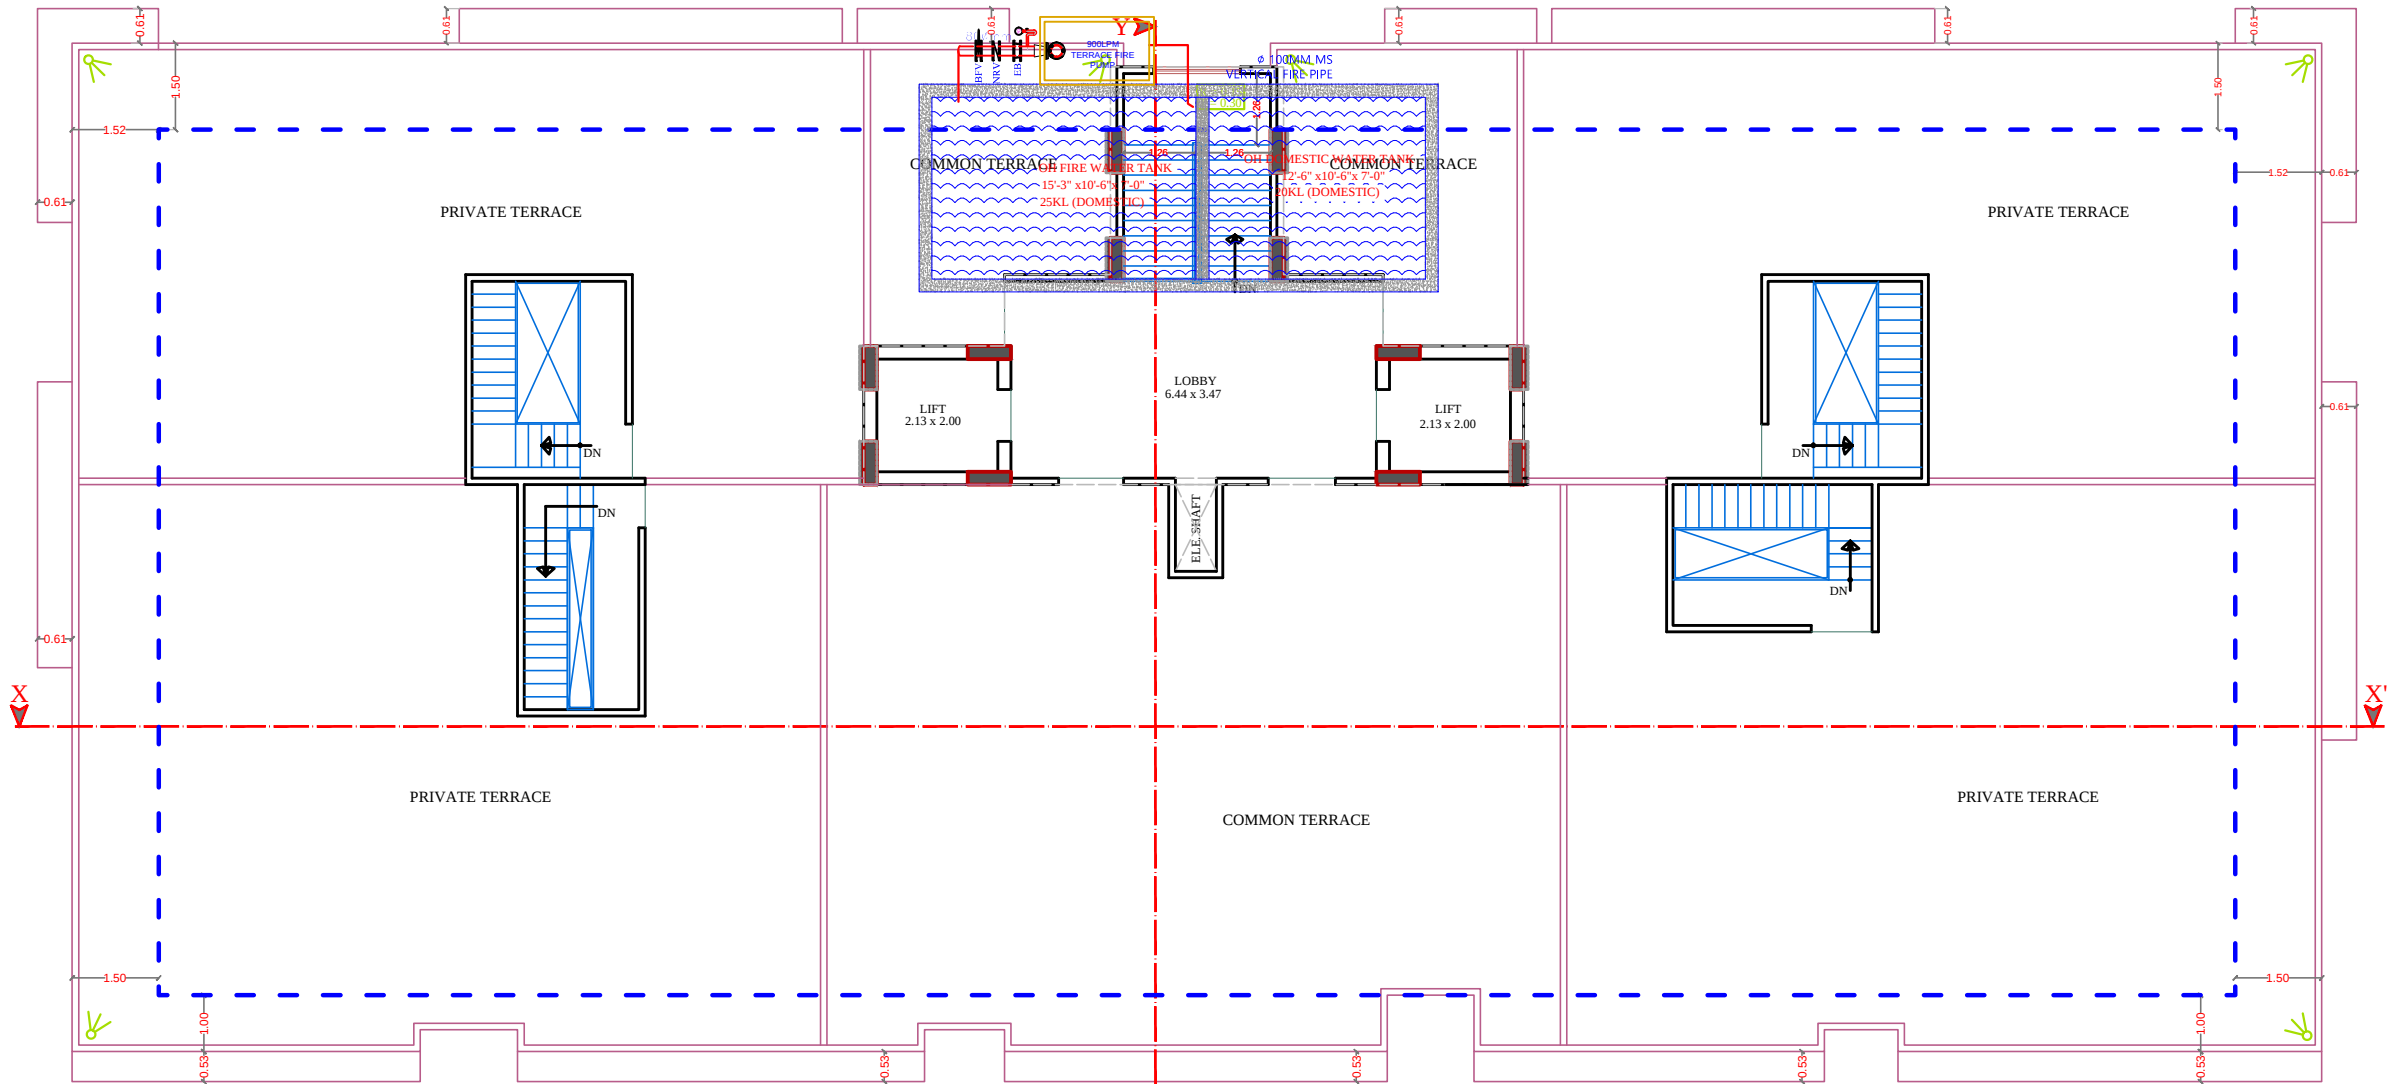

TERRACE FLOOR PLAN

For Parth Sarthi Build Estate (P) Ltd.

मेधा 12/17
Director

रमेश
RAMESH KUMAWAT
M.E.P. CONSULTANT
B.E. CIVIL

LEGEND		
	Symbole	DESCRIPTION
1.		HOSEREEL
2.		FIRE PIPE
3.		FIRE PIPE
4.		FIRE EXTINGUISHER
5.		EXTERNAL YARD HYDRANT

PROJECT TITLE :- PROPOSED BUILDING AT PLOT NO. F-28, F-29 & F-30, 6-D ENGINEERS COLONY , JAIPUR	BUILDING NAME	DRAWING TITLE :- TARRACE FLOOR FIRE FIGHTING	SPACE CONSULTANT PLOT-A-173, JAGDAMBA NAGAR, HEERAPURA POWER HOWER, JAIPUR (RAJ) 302024	DRN. BY			NORTH
	PARTH AANGAN				DATE		
	DEVELOPER NAME			APPD. BY	REVISION		
	PARTH SARTHI BUILD ESTATE (P)LTD.			SCALE			