


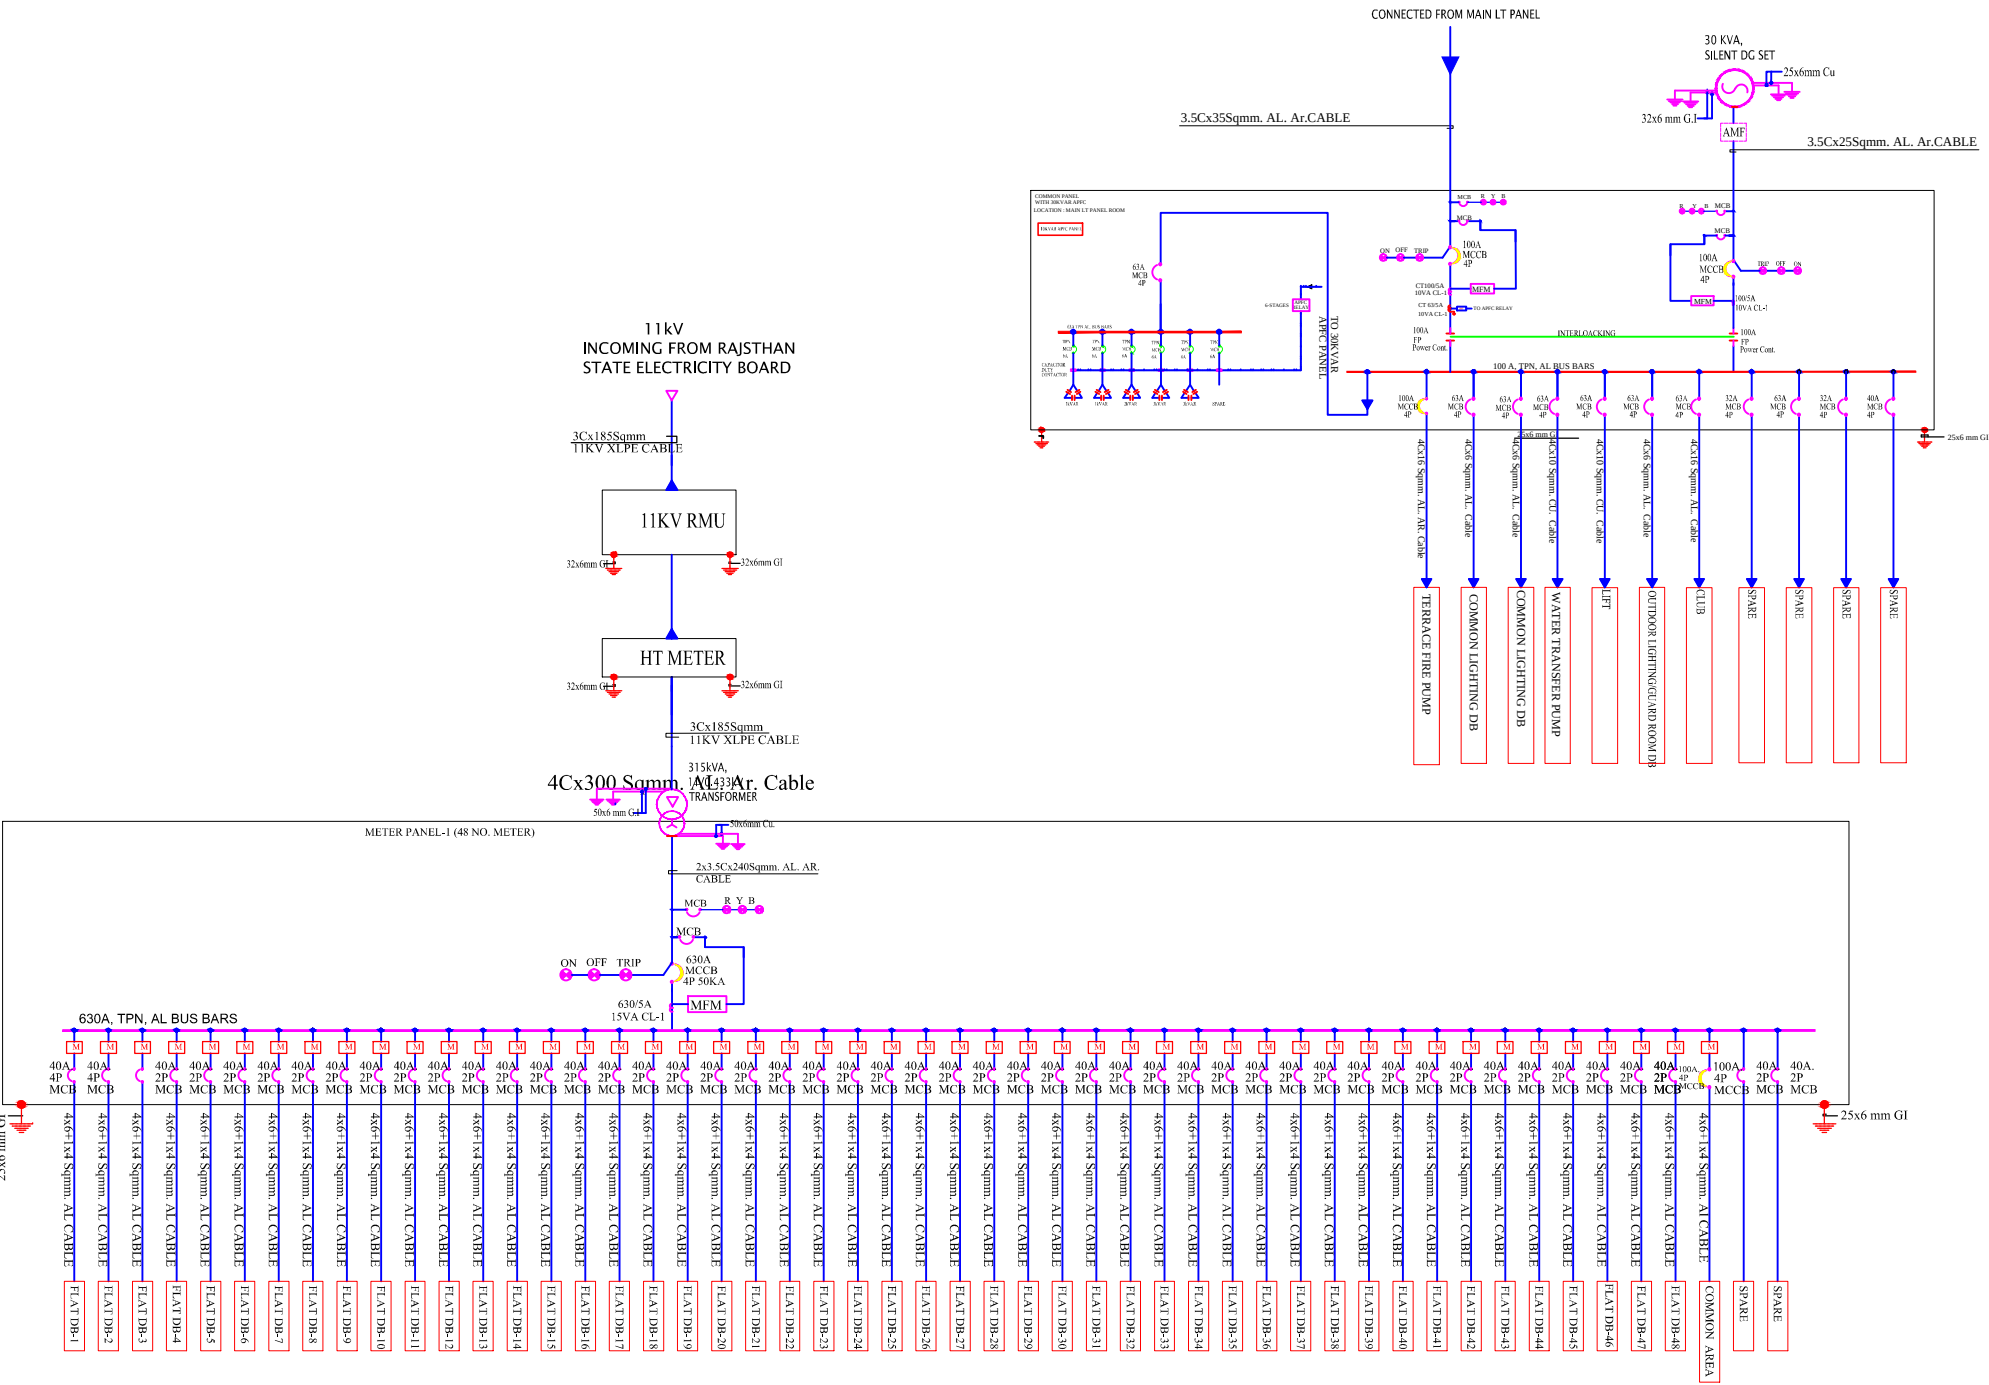


LEGEND	
SYMB.	DESCRIPTION
[Symbol]	AMMETER
[Symbol]	VOLT METER
[Symbol]	POWER FACTOR METER
[Symbol]	VOLTMETER, AMMETER, FREQUENCY METER
[Symbol]	FREQUENCY METER
[Symbol]	KILOWATT HOUR METER
[Symbol]	KILOWATT METER
[Symbol]	AMMETER SELECTOR SWITCH
[Symbol]	VOLTMETER SELECTOR SWITCH
[Symbol]	LOCKOUT RELAY
[Symbol]	SUPERVISORY TRIP RELAY
[Symbol]	UNDER VOLTAGE DEVICE
[Symbol]	OVER VOLTAGE DEVICE
[Symbol]	REVERSE POWER PHASE DEVICE
[Symbol]	DIFFERENTIAL PROTECTION RELAY
[Symbol]	OVER CURRENT & EARTH FAULT RELAY
[Symbol]	MULTI FUNCTION RELAY
[Symbol]	ELECTRICALLY OPERATED MANUALLY DRAWN OUT
[Symbol]	CONTROL FUSE
[Symbol]	CURRENT TRANSFORMER
[Symbol]	TRIVECTOR METER
[Symbol]	INDICATING LAMP
[Symbol]	OVER LOAD RELAY
[Symbol]	POWER CONTACTOR
[Symbol]	POTENTIAL TRANSFORMER
[Symbol]	DUAL SOURCE ELECTRONIC ENERGY METER
[Symbol]	GROUNDING
[Symbol]	MICRO PROCESSOR BASED RELEASE
[Symbol]	ELECTRONIC ENERGY METER
[Symbol]	AIR CIRCUIT BREAKER
[Symbol]	VACUUM CIRCUIT BREAKER
[Symbol]	MINIATURE CIRCUIT BREAKER
[Symbol]	MOULDED CASE CIRCUIT BREAKER
[Symbol]	MOTOR PROTECTION CIRCUIT BREAKER



REVISION - 00			
GENERAL NOTES :			
1. ALL THE DIMENSIONS ON THE DRAWING ARE IN WRITTEN. 2. ONLY WRITTEN DIMENSIONS ARE TO BE FOLLOWED, DRAWING SHOULD NOT BE SCALED IN ANY CIRCUMSTANCES. 3. ALL MEASUREMENTS MUST BE CHECKED AND VERIFIED BY THE CONTRACTORS PRIOR TO EXECUTION OF WORK AT THE SITE. 4. THIS DRAWING IS TO BE READ IN CONJUNCTION WITH ALL RELEVANT STRUCTURAL, ARCHITECTURAL & FACILITY PLANNING DRAWINGS. 5. ANY DISCREPANCIES MUST BE BROUGHT TO THE NOTICE OF THE ENGINEER IMMEDIATELY & PRIOR TO EXECUTION AT SITE. 6. CO-ORDINATION WITH SERVICES SUCH AS HVAC, PLUMBING & ELECTRICAL, ETC. IS THE RESPONSIBILITY OF THE CONTRACTORS. 7. FOR DETAILS, REFER RELEVANT LARGE SCALE DETAIL DRGS. AS INDICATED.			
LIGHTING LEGEND			
SR.NO.	SYMBOL	DESCRIPTION	HEIGHT FROM FFL
1	[Symbol]	CEILING TUBELIGHT POINT	CEILING
2	[Symbol]	LED CEILING LIGHT POINT	CEILING
3	[Symbol]	LED WALL BRACKET LIGHT POINT AT WALL	+7.4"
4	[Symbol]	6A SOCKET WITH SWITCH	+2.0"
5	[Symbol]	GENERAL POINT 15A SOCKET WITH SWITCH	+2.0"
6	[Symbol]	MDF BOX	+5.0"
7	[Symbol]	CEILING HOSE	+7.4"
8	[Symbol]	SWITCH BOARD	+4.0"
9	[Symbol]	EXHAUST FAN	VENT. HT.
10	[Symbol]	LIGHT & POWER DISTRIBUTION BOARD	+9.1"
11	[Symbol]	Ø25MM POINT CONDUIT	CEILING
12	[Symbol]	Ø25MM POWER CIRCUIT CONDUIT	CEILING FLOORING
13	[Symbol]	Ø25MM LIGHT CIRCUIT CONDUIT	CEILING FLOORING
14	[Symbol]	CEILING FAN	CEILING
ARCHITECT			
ARCHITECT :- FRANK SQUARE ARCHITECTURE PLANNER DESIGNER C-49 VIDYA APARTMENT PARAS MARG, BAPU NAGAR JAIPUR, (RAJ.) Email-franksquare@gmail.com Mobile-9461302542			
PROJECT :-			
PROPOSED BUILDING AT PLOT NO. F-28, F-29 & F-30, 6-D ENGINEERS COLONY , JAIPUR			
BUILDER/DEVELOPER/CLIENT:-			
PARTH SARTHI BUILD ESTATE (P) LTD.			
BUILDING NAME PARTH AANGAN			
DRAWING TITLE:- MAIN PANEL SLD			
SUBMITTED FOR :-			
PRELIMINARY ☐ APPROVAL ☒			
PROPOSAL ☐ FOR RERA ☒			
DATE :-			NORTH :-
DRAWN :-			
APPROVED :-			
DRAWING NO.:-			SCALE :-
CONSULTANT			
AMP INFRA SERVICES VILLA NO 16, SHUBHASIS GEETA JAISINGHPURA, BHANKROTA & CHIMANPURA, JAIPUR 302026 EMAIL ID- ampinfrajr@gmail.com CONTACT NO. :- 9462866389			

For Parth Sarthi Build Estate (P) Ltd.

[Signature]
Director

[Signature]
RAMESH KUMAR
M.E.P. CONSULTANT
B.E. CIVIL

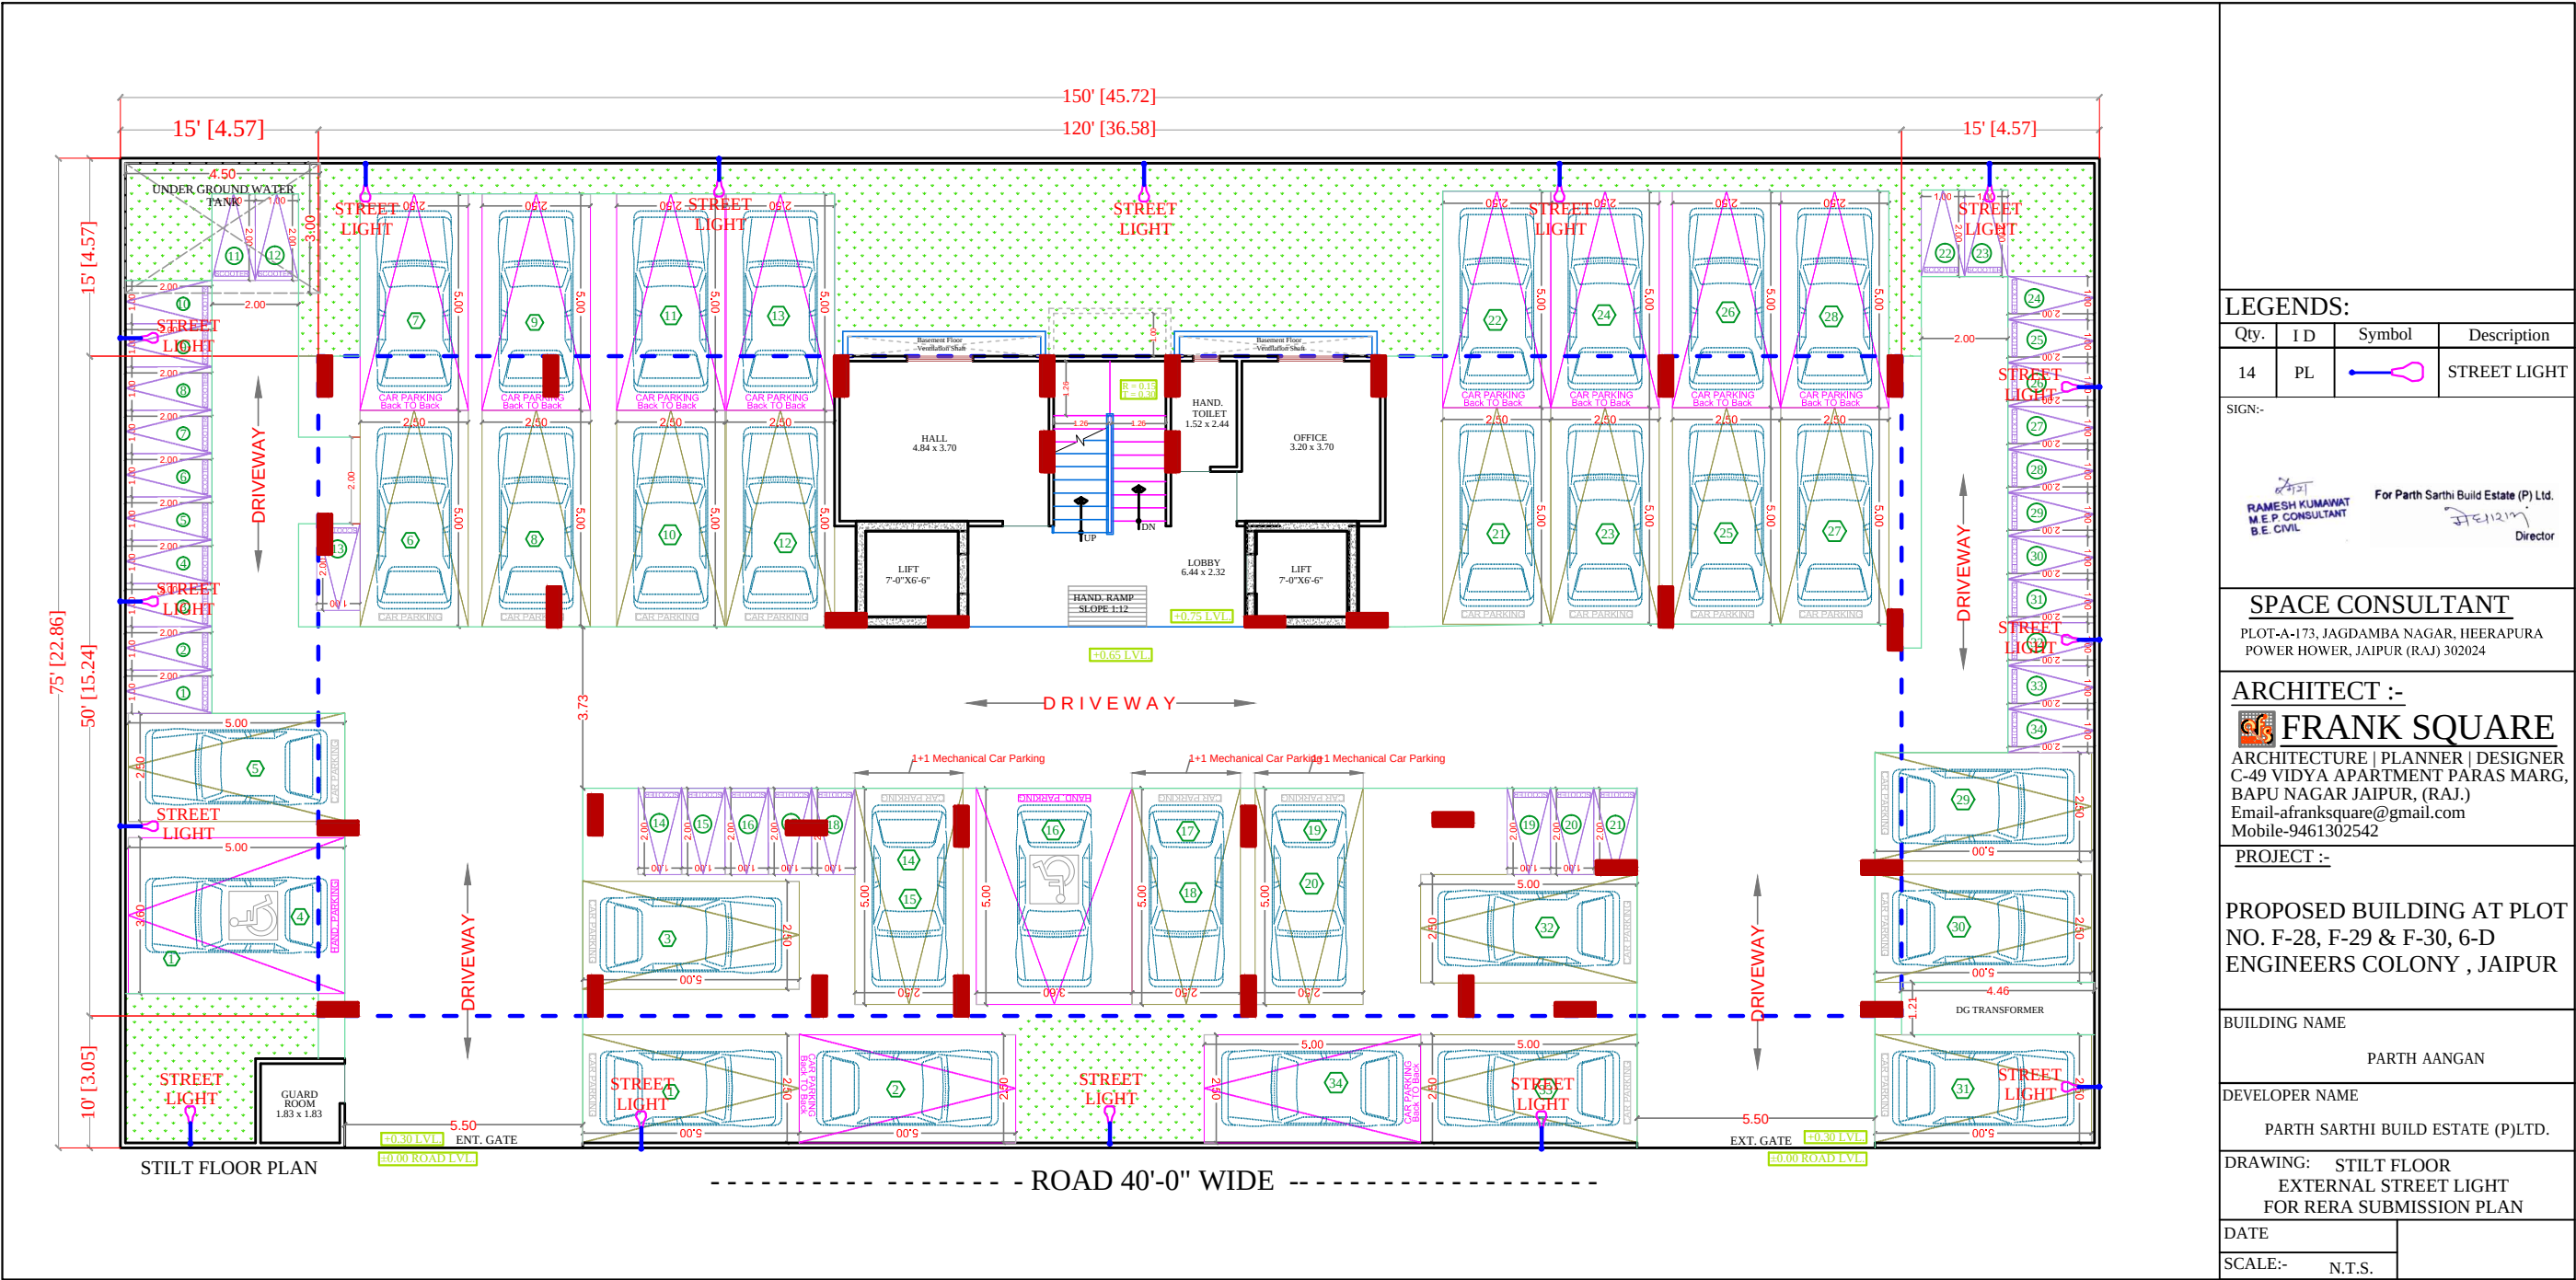

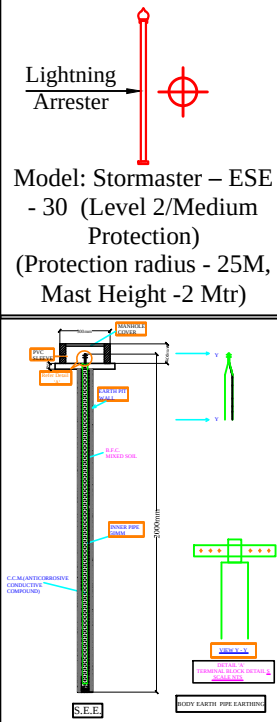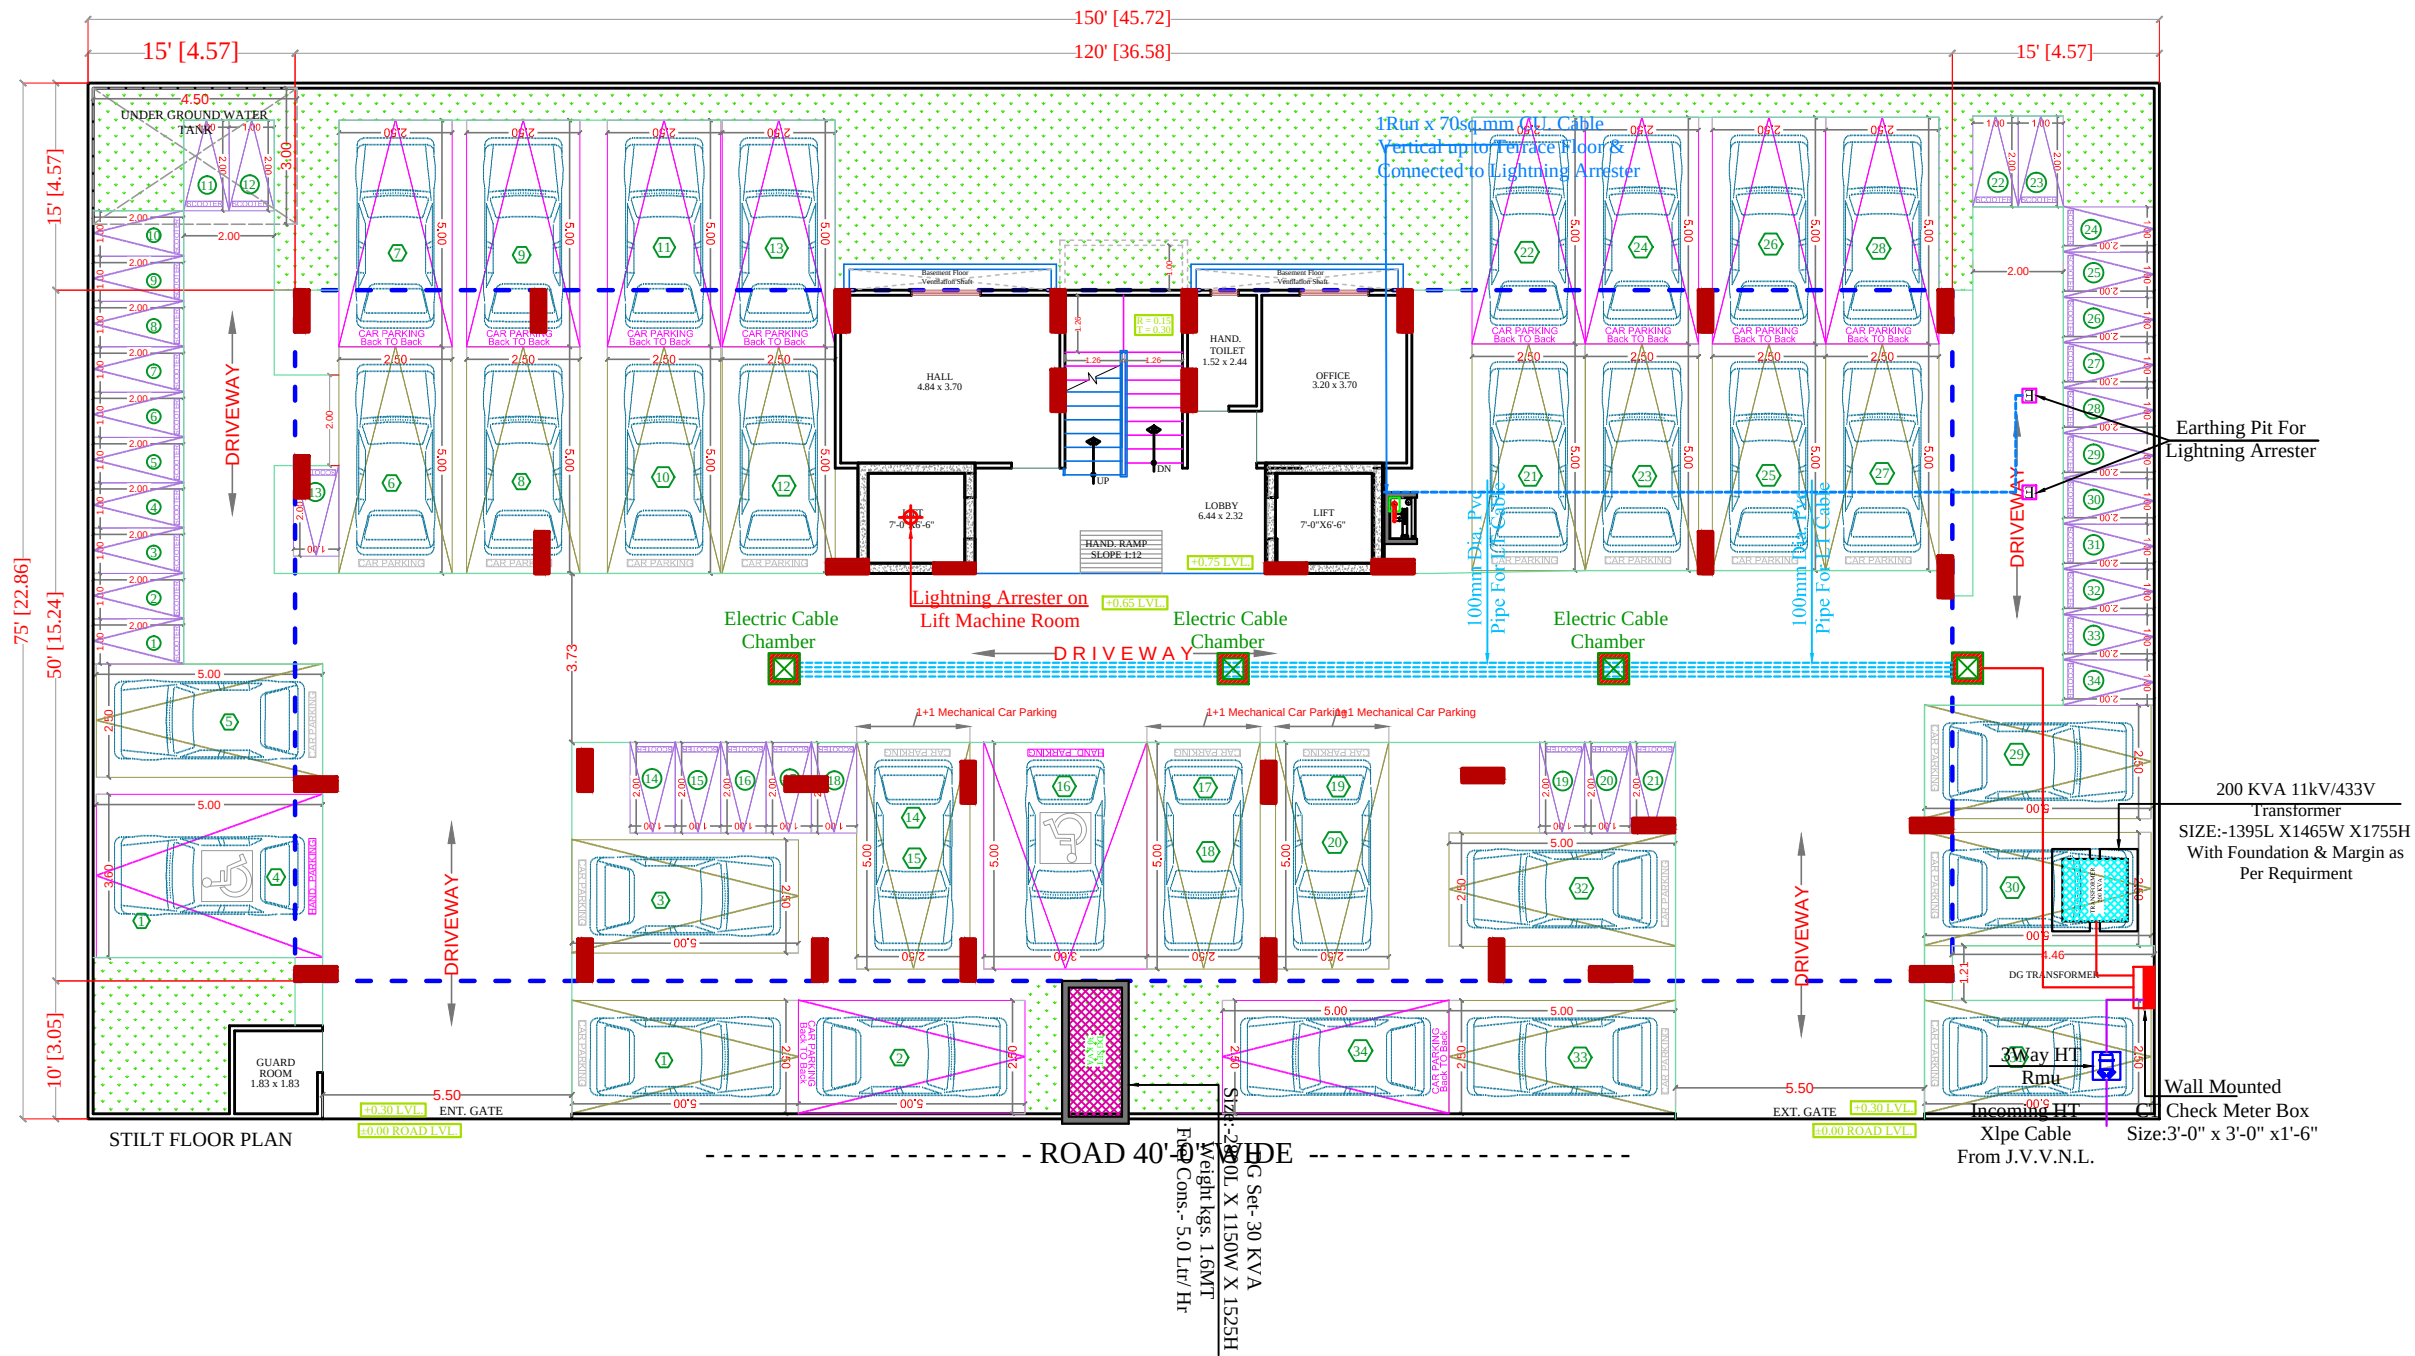

SIGN:-
For Parth Sarthi Build Estate (P) Ltd.
RAMESH KUMAR
M.E.P. CONSULTANT
S.E. CIVIL
Director

SPACE CONSULTANT
PLOT-A-173, JAGDAMBA NAGAR, HEERAPURA
POWER HOWER, JAIPUR (RAJ) 302024

ARCHITECT :-
FRANK SQUARE
ARCHITECTURE | PLANNER | DESIGNER
C-49 VIDYA APARTMENT PARAS MARG,
BAPU NAGAR JAIPUR, (RAJ.)
Email-afanksquare@gmail.com
Mobile-9461302542

PROJECT :-
PROPOSED BUILDING AT PLOT
NO. F-28, F-29 & F-30, 6-D
ENGINEERS COLONY , JAIPUR


BUILDING NAME PARTH AANGAN

DEVELOPER NAME PARTH SARTHII BUILD ESTATE (P) LTD.

DRAWING: STILT FLOOR
ELECTRIC SUB STATION,
CABLE ROUTE &
LIGHTNING ARRESTER FOR
RERA SUBMISSION PLAN

DATE
SCALE:- N.T.S.

PRODUCED BY AN AUTODESK EDUCATIONAL PRODUCT

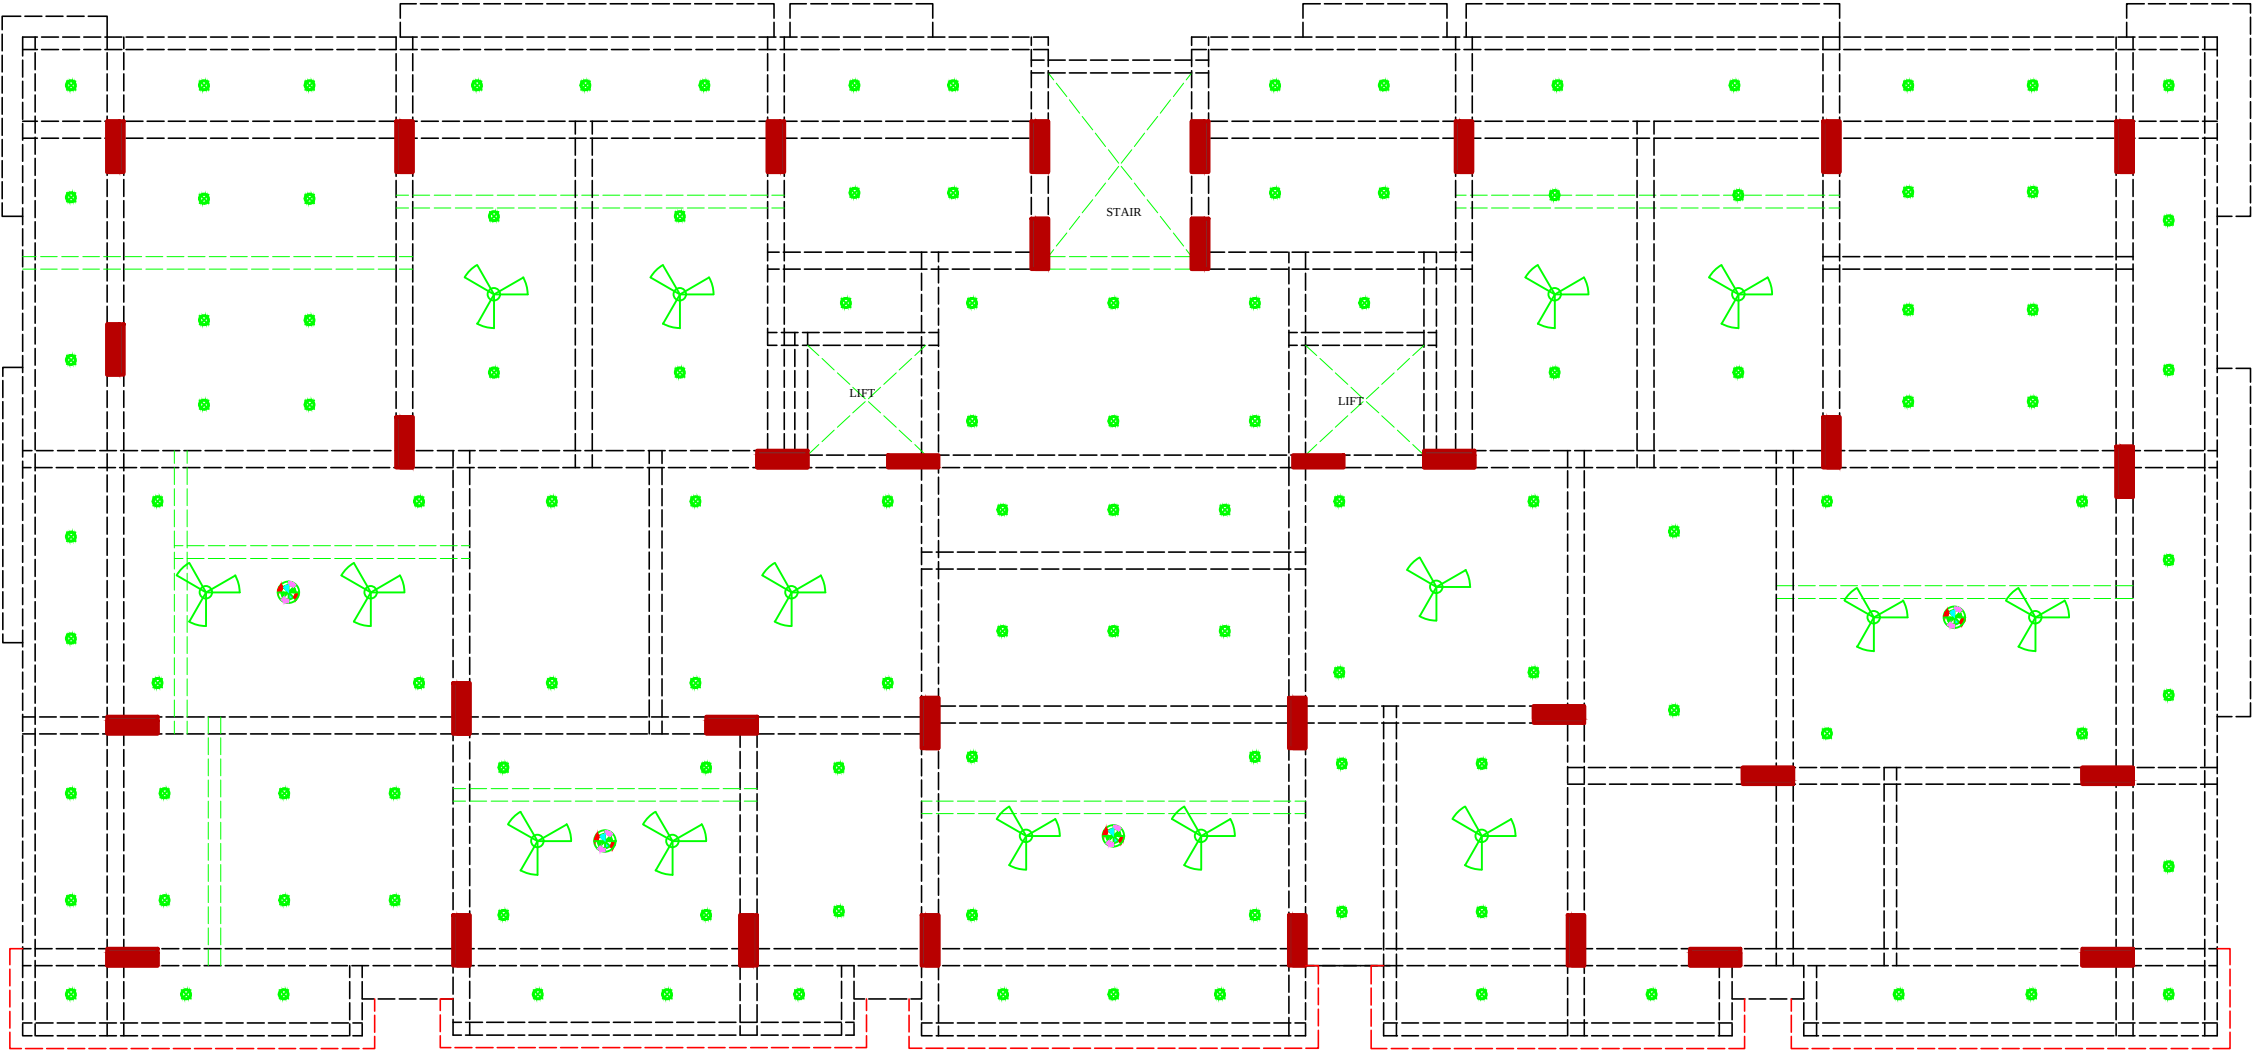

NO	ITEM	SYMBOL
1	CEILING FAN	ROOF
2	TUBE LIGHT	+8'6"
3	BULB	+8'6"
4	POWER POINT	+1'6"
5	BED POINT	+4'3"
6	CEILING LIGHT	ROOF
7	A.C.POINT	+6'6"
8	SWITCH BOARD	+4'3"
9	EXHAUST	VENT
10	TELEPHONE	+1'6"
11	GYSER	+6'0"
12	BELL POINT	+8'6"
13	T.V.	+1'6"
14	M.BOX	M.B.
15	M.C.B.	M.C.B.
16	FANCY LIGHT	+8'6"
17	HANGING LIGHT	ROOF

For Parth Sarthi Build Estate (P) Ltd.

मेधा 12/11/24
Director

RAMESH KUMAWAT
M.E.P. CONSULTANT
B.E. CIVIL

PROJECT TITLE :-
PROPOSED BUILDING AT PLOT
NO. F-28, F-29 & F-30, 6-D
ENGINEERS COLONY , JAIPUR

BUILDING NAME
PARTH AANGAN
DEVELOPER NAME
PARTH SARTHI BUILD ESTATE (P)LTD.

DRAWING TITLE :-
STILT FLOOR
ELECTRIC PLAN


SPACE CONSULTANT
PLOT-A-173, JAGDAMBA NAGAR, HEERAPURA
POWER HOWER, JAIPUR (RAJ) 302024

DRN. BY
APPD. BY
SCALE
DATE
REVISION

NORTH

PRODUCED BY AN AUTODESK EDUCATIONAL PRODUCT

PRODUCED BY AN AUTODESK EDUCATIONAL PRODUCT

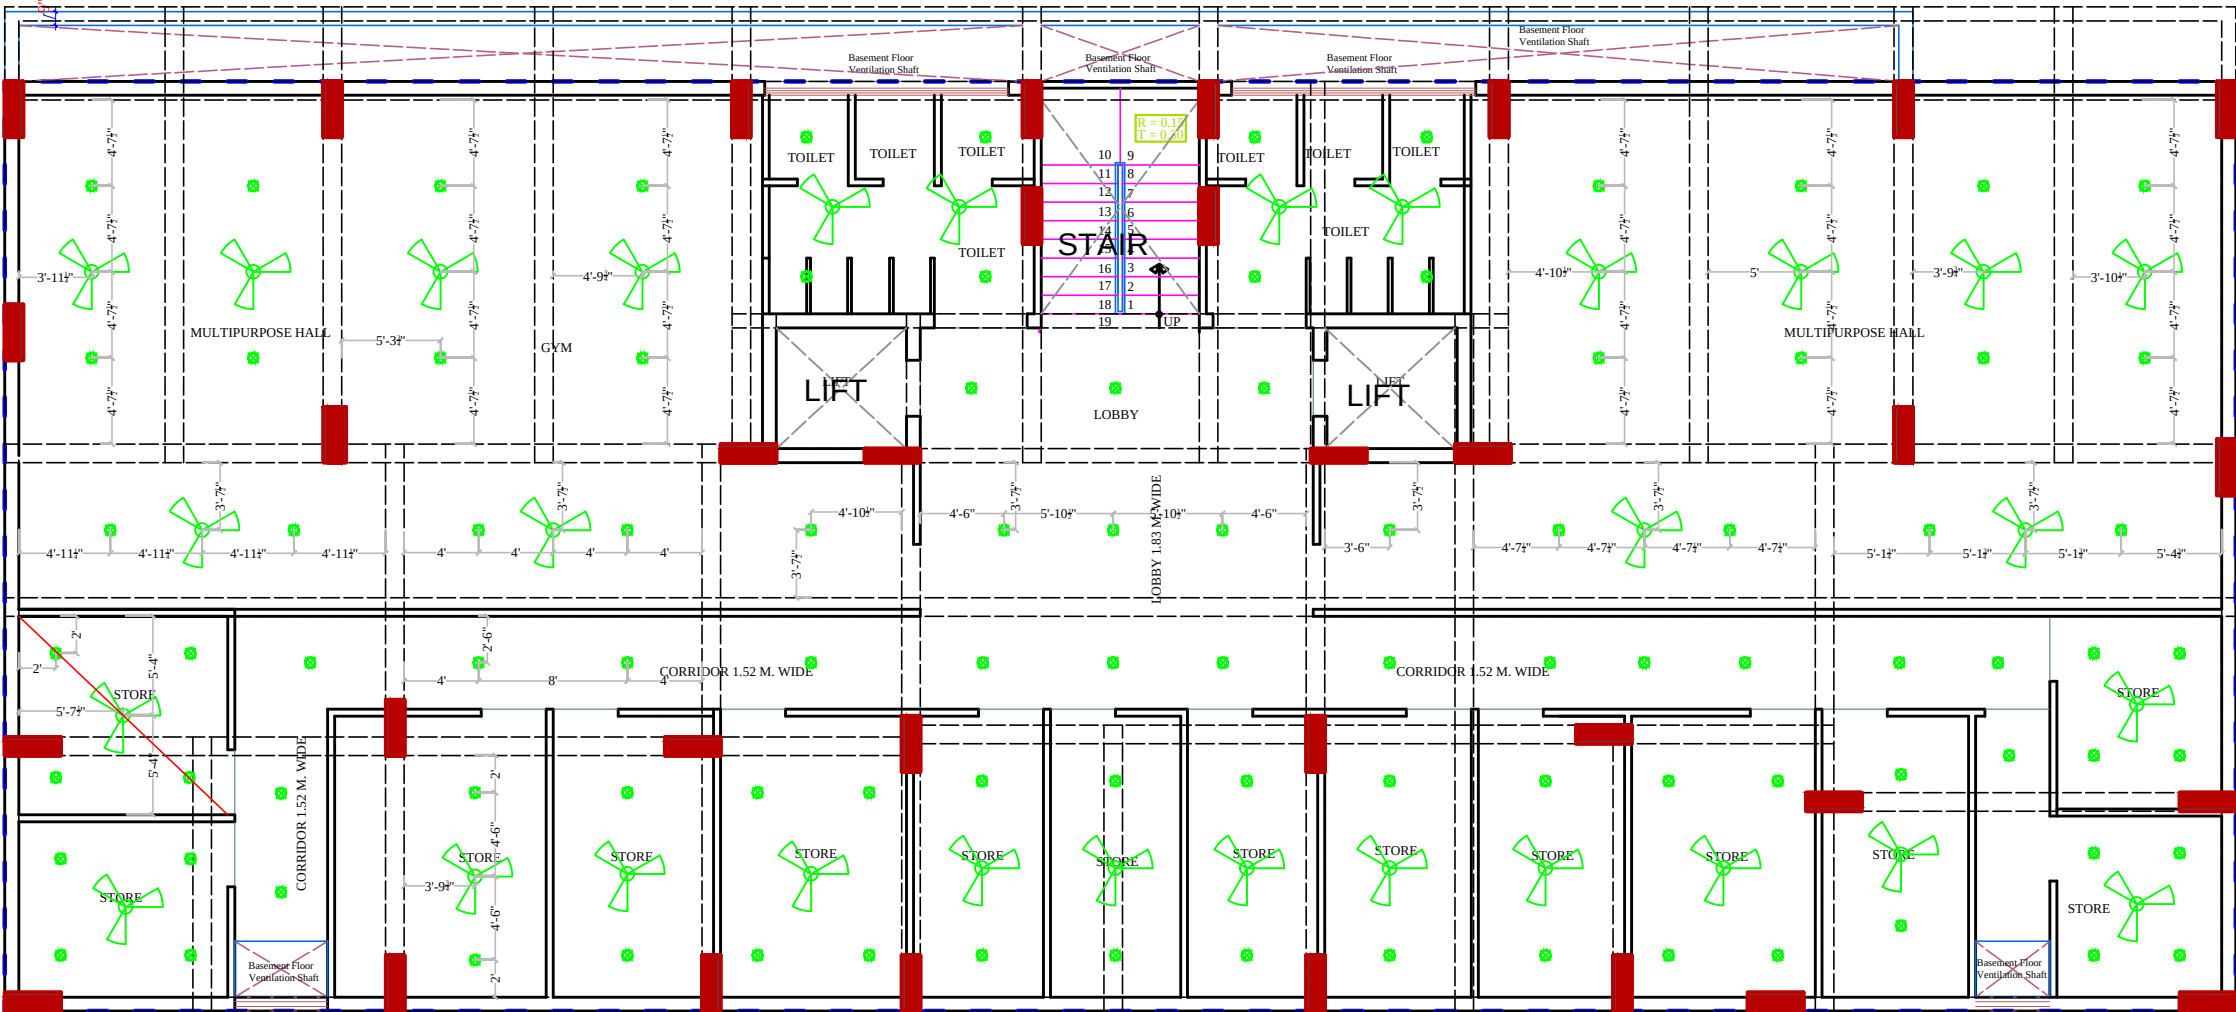

NO	ITEM	SYMBOL
1	CEILING FAN	ROOF
2	TUBE LIGHT	+8'6"
3	BULB	+8'6"
4	POWER POINT	+1'6"
5	BED POINT	+4'3"
6	CEILING LIGHT	ROOF
7	A.C.POINT	+6'6"
8	SWITCH BOARD	+4'3"
9	EXHAUST	VENT
10	TELEPHONE	+1'6"
11	GYSER	+6'0"
12	BELL POINT	+8'6"
13	T.V.	+1'6"
14	M.BOX	M.B
15	M.C.B.	M.C.B. +6'6"
16	FANCY LIGHT	+8'6"
17	HANGING LIGHT	ROOF

For Parth Sarthi Build Estate (P) Ltd.

मेधाश्री

Director

RAMESH KUMAWAT
M.E.P. CONSULTANT
B.E. CIVIL

PRODUCED BY AN AUTODESK EDUCATIONAL PRODUCT


PROJECT TITLE :-
PROPOSED BUILDING AT PLOT
NO. F-28, F-29 & F-30, 6-D
ENGINEERS COLONY , JAIPUR

BUILDING NAME
PARTH AANGAN
DEVELOPER NAME
PARTH SARTHI BUILD ESTATE (P)LTD.

DRAWING TITLE :-
BASEMENT FLOOR
ELECTRIC PLAN
SPACE CONSULTANT
PLOT-A-173, JAGDAMBA NAGAR, HEERAPURA
POWER HOWER, JAIPUR (RAJ) 302024

DRN. BY		DATE
APPD. BY		REVISION
SCALE		

NORTH

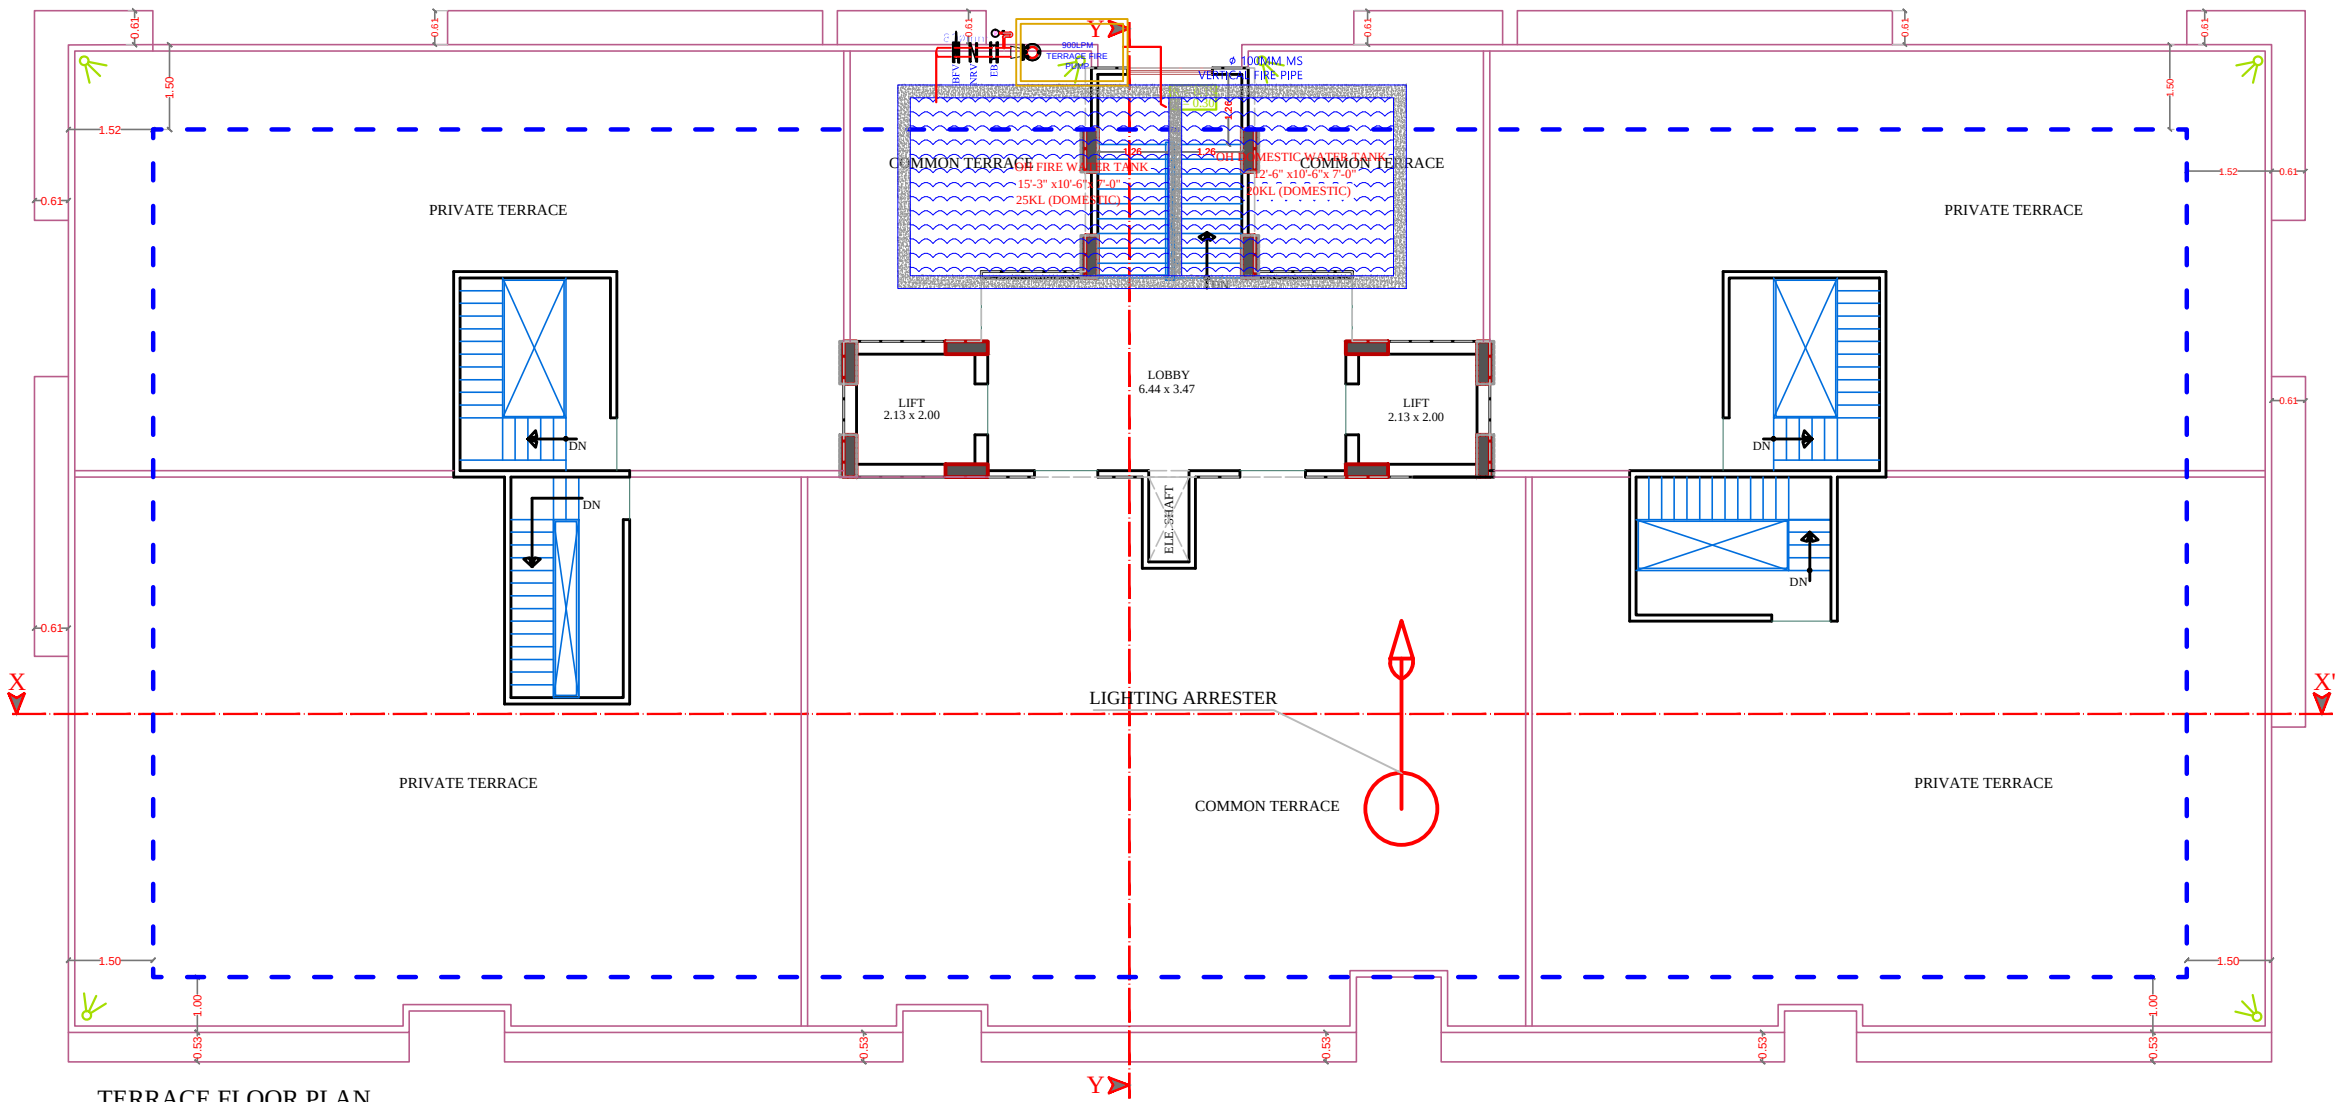

TERRACE FLOOR PLAN


For Parth Sarthi Build Estate (P) Ltd.
[Signature]
Director

[Signature]
RAMESH KUMAWAT
M.E.P. CONSULTANT
B.E. CIVIL

LEGEND		
	Symbole	DESCRIPTION
1.		HOSEREEL
2.		FIRE PIPE
3.		FIRE PIPE
4.		FIRE EXTINGUISHER
5.		EXTERNAL YARD HYDRANT

PROJECT TITLE :- PROPOSED BUILDING AT PLOT NO. F-28, F-29 & F-30, 6-D ENGINEERS COLONY , JAIPUR	BUILDING NAME PARTH AANGAN	DRAWING TITLE :- TARRACE FLOOR LIGHTING ARRESTER LOCATION	SPACE CONSULTANT PLOT-A-173, JAGDAMBA NAGAR, HEERAPURA POWER HOWER, JAIPUR (RAJ) 302024	DRN. BY		DATE	NORTH
	DEVELOPER NAME PARTH SARTHI BUILD ESTATE (P)LTD.			APPD. BY		REVISION	
				SCALE			

SCHEMATIC DIAGRAM
LIGHTNING PROTECTION SYSTEM

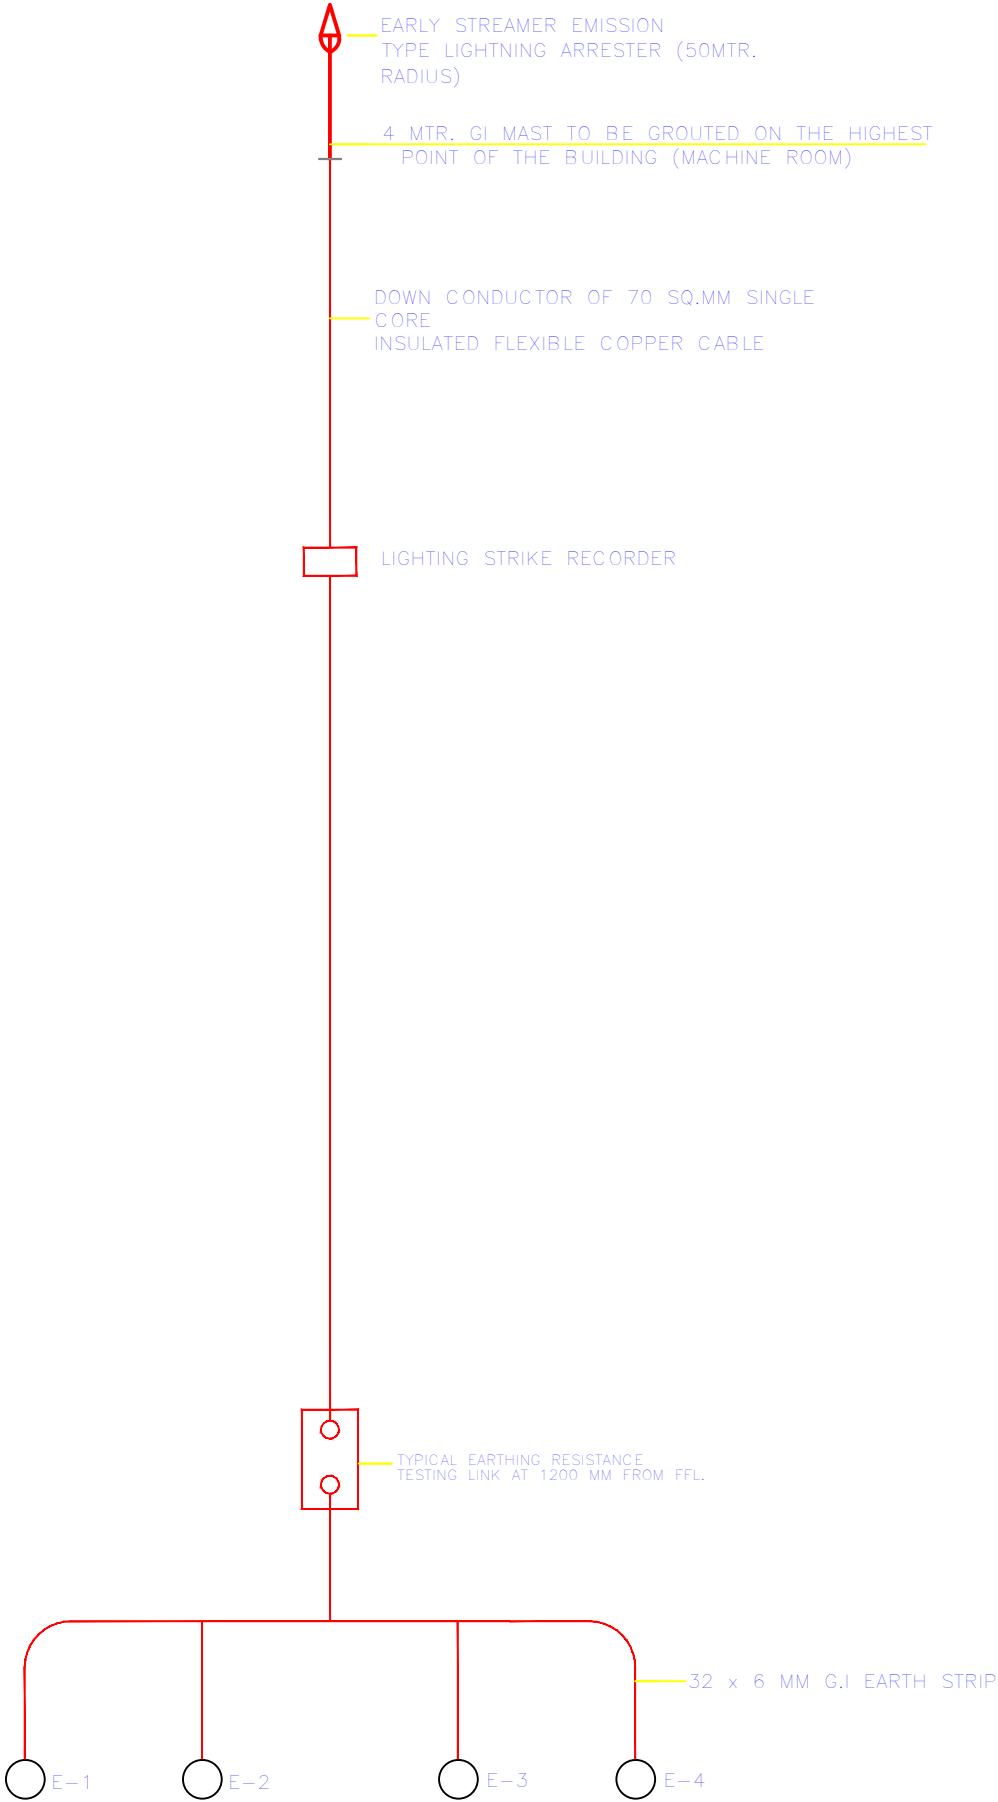

LIGHTENING ARRESTOR SLD

For Parth Sarthi Build Estate (P) Ltd.


मेधाश्री
Director

रमेश
RAMESH KUMAWAT
M.E.P. CONSULTANT
B.E. CIVIL

PROJECT TITLE :- PROPOSED BUILDING AT PLOT NO. F-28, F-29 & F-30, 6-D ENGINEERS COLONY , JAIPUR	BUILDING NAME PARTH AANGAN	DRAWING TITLE :- LIGHTENING ARRESTOR SLD	SPACE CONSULTANT PLOT-A-173, JAGDAMBA NAGAR, HEERAPURA POWER HOWER, JAIPUR (RAJ) 302024	DRN. BY		DATE	
	DEVELOPER NAME PARTH SARTHI BUILD ESTATE (P)LTD.			APPD. BY		REVISION	
				SCALE			

PRODUCED BY AN AUTODESK EDUCATIONAL PRODUCT

PRODUCED BY AN AUTODESK EDUCATIONAL PRODUCT

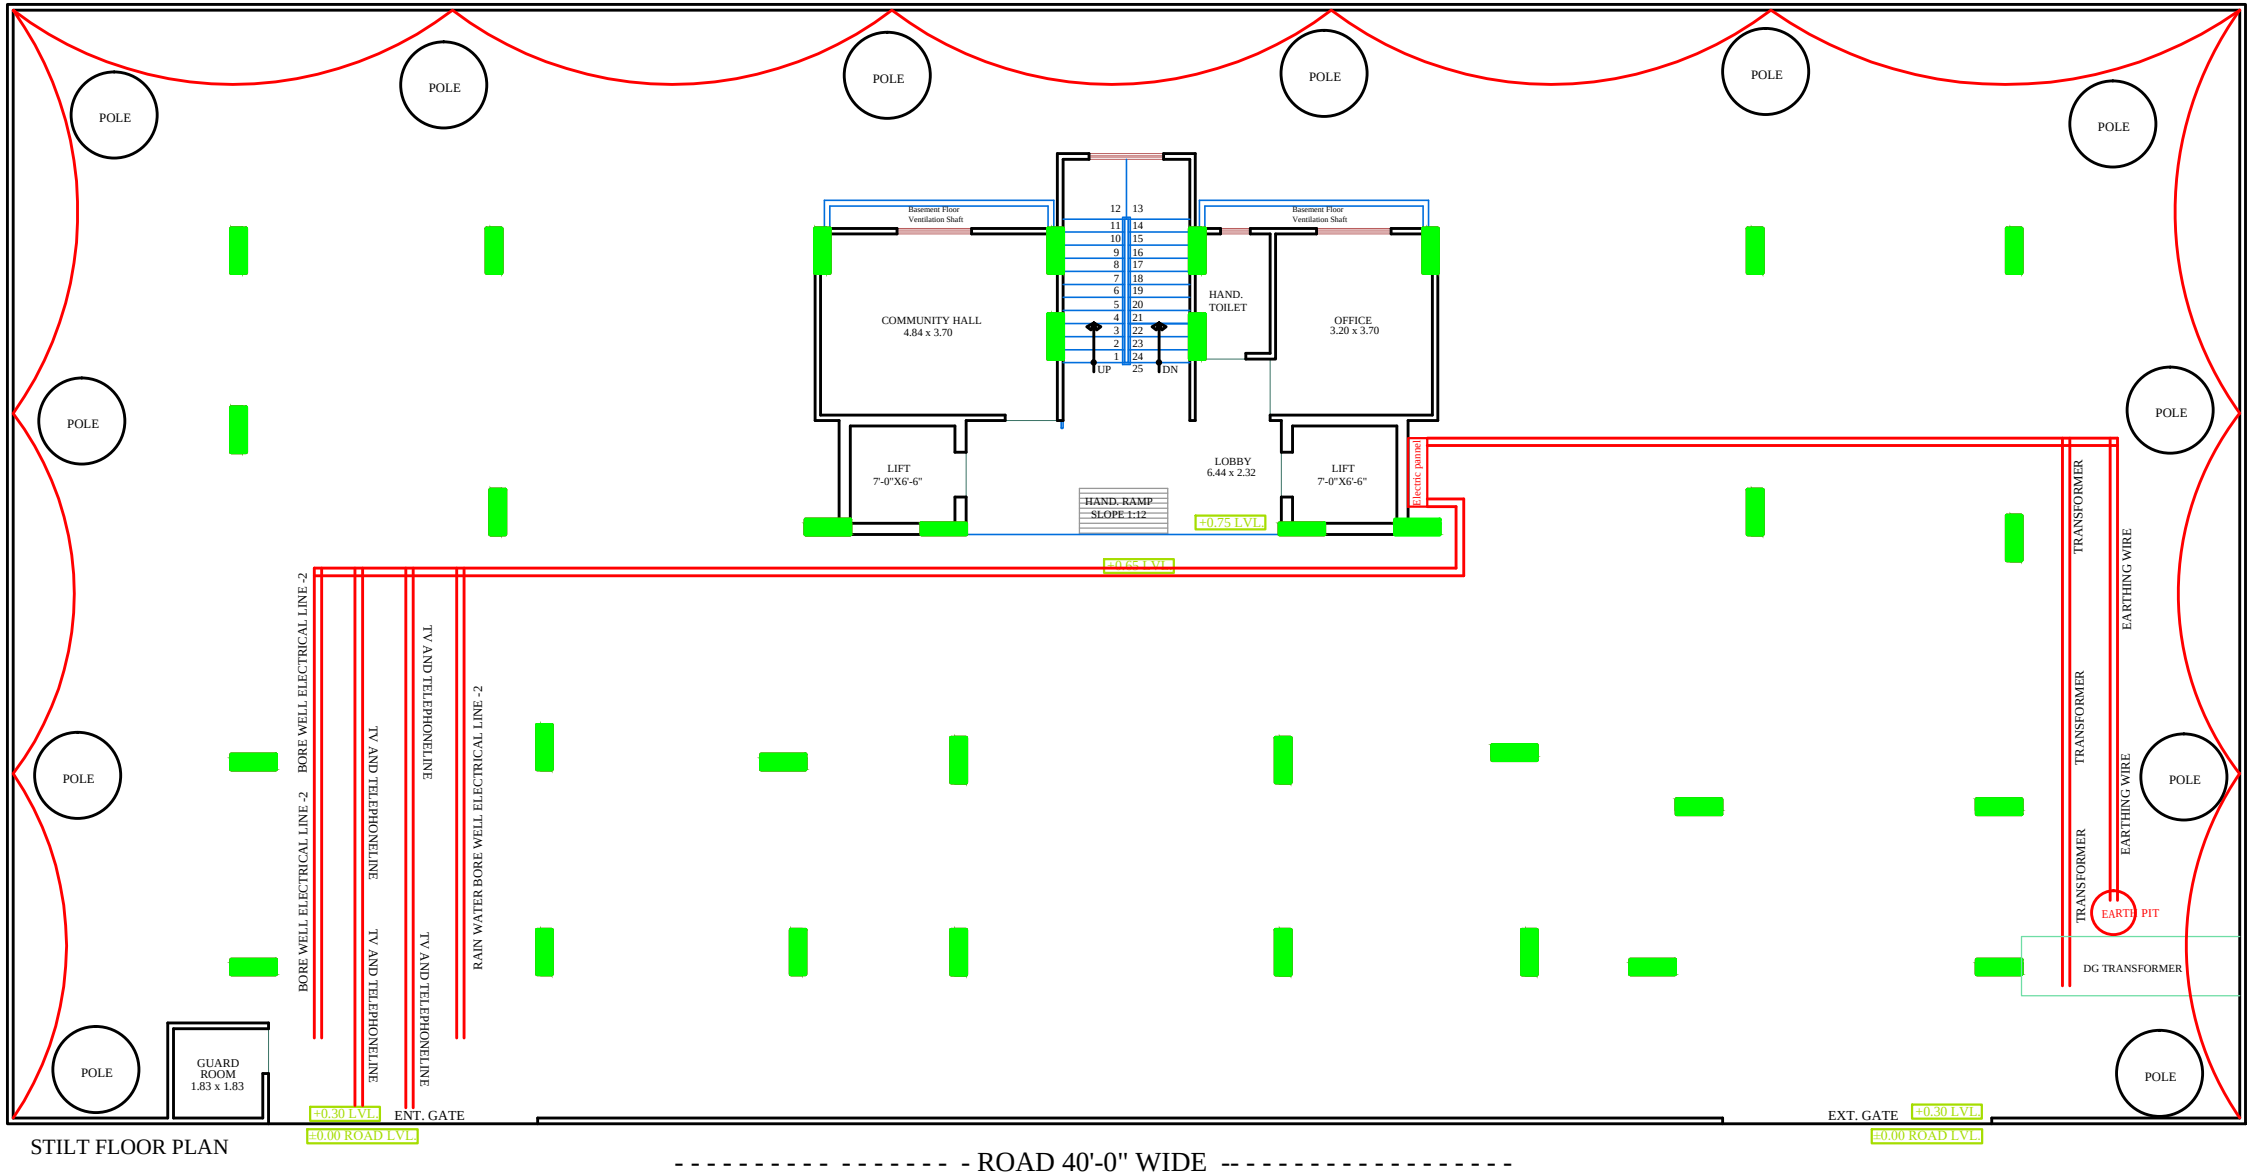

STILT (PARKING) FLOOR PLAN

PROJECT TITLE :- PROPOSED BUILDING AT PLOT NO. F-28, F-29 & F-30, 6-D ENGINEERS COLONY , JAIPUR	BUILDING NAME PARTH AANGAN	DRAWING TITLE :- SERVICE DRAWING SLD/DISTRIBUTION AFTER LT PANEL, EARTHING LAYOUT,EXTERNAL LIGHTING PLAN, TV & TELEPHONE RISER,LIGHTING ARRESTR, & PIT LOCATION COMMON AREA TRANSFORMER	SPACE CONSULTANT PLOT-A-173, JAGDAMBA NAGAR, HEERAPURA POWER HOWER, JAIPUR (RAJ) 302024	DRN. BY		DATE	
	DEVELOPER NAME PARTH SARTHI BUILD ESTATE (P)LTD.			APPD. BY		REVISION	
				SCALE	N.T.S		

For Parth Sarthi Build Estate (P) Ltd.

मेधा २०२१
Director

रामेश कुमावत
RAMESH KUMAWAT
M.E.P. CONSULTANT
B.E. CIVIL